


BUILDING FRONT ELEVATION


1/8" = 1'-0"

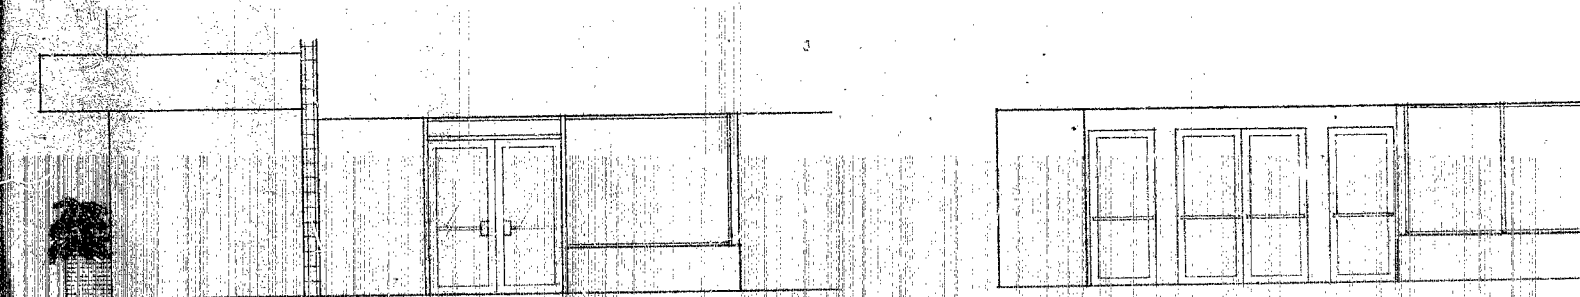

INTERIOR BANK ENTRANCE

3/16" = 1'-0"

BUILDING MAIN ENTRANCE INTERIOR ELEV. 1/8" = 1'-0"

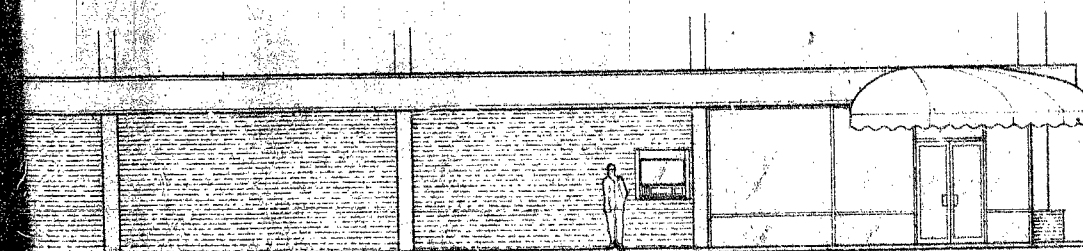

BUILDING LEFT SIDE ELEVATION

1/8" = 1'-0"

RECEIVED
APR 24 1960

BUILDING INSPECTION DIVISION

CITY OF MIAMI BEACH

APPROVED

DATE

DESIGNED BY

DRAWN BY


FLORIDA ARCHT. NO.

REVISIONS BY

DATE

OFFICE COPY

90121

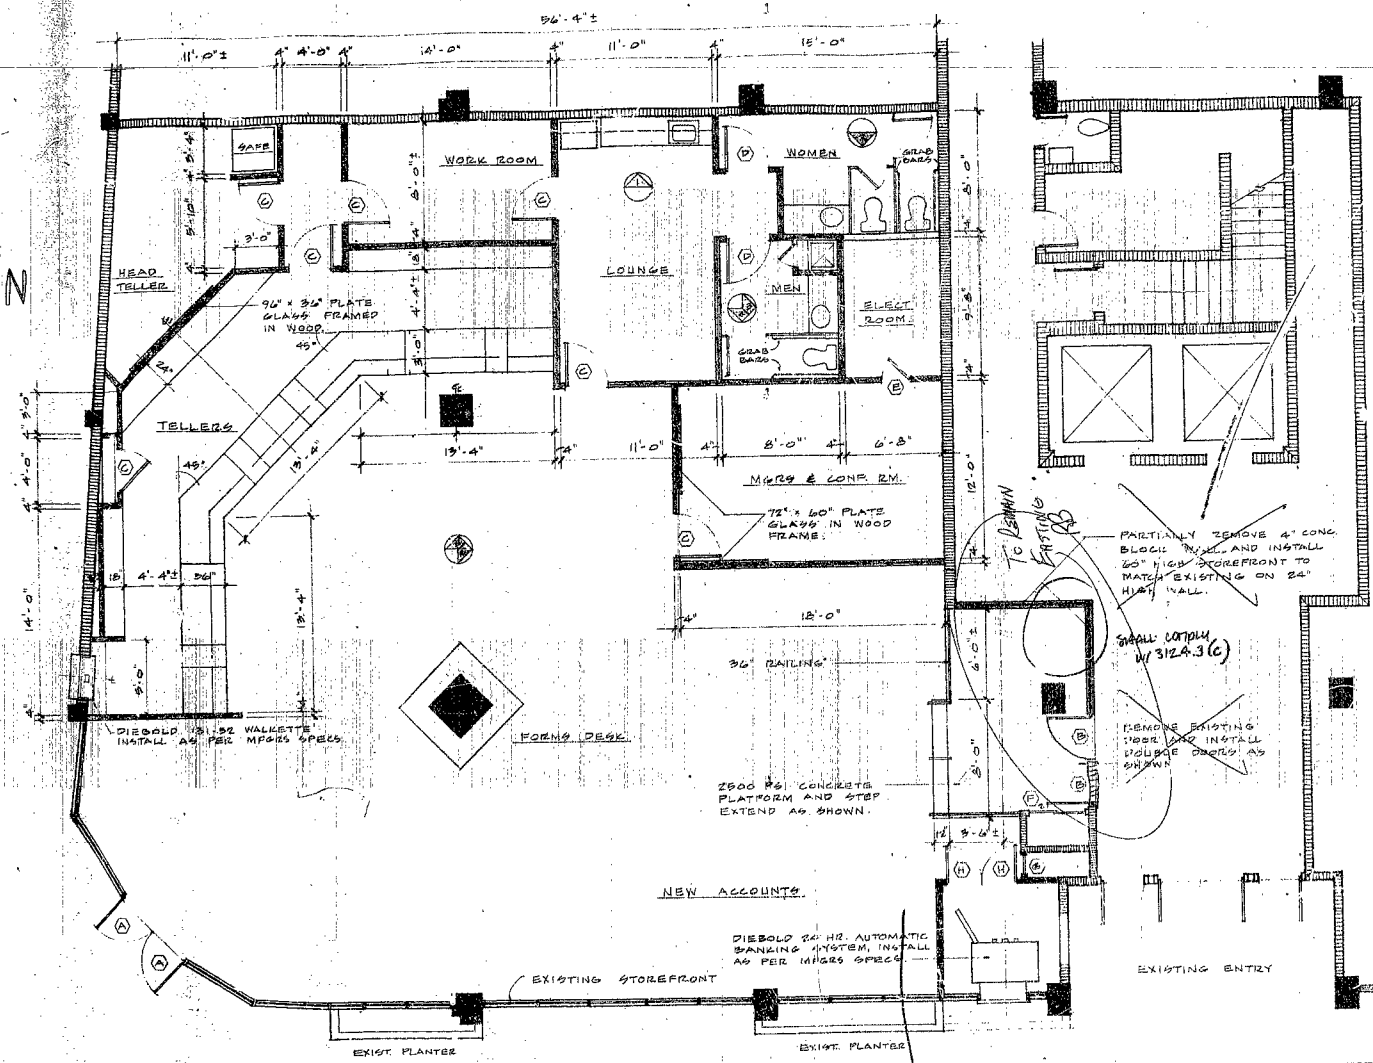

333 - 4th STREET

4th STREET

FLOOR PLAN (PROPOSED)

CITY OF MIAMI BEACH
APPROVED

DATE: 7/1/50
DRAWN BY: [Signature]
CHECKED BY: [Signature]
DESIGNED BY: [Signature]
PROJECT NO.: 7907-6

WALL LEGEND

EXISTING BLOCK WALL

EXISTING INT. PARTITION

NEW DRYWALL PARTITION

OFFICE COPY

DRYWALL: ONE LAYER 5/8" TYPE 'X' GYPSUM WALLBOARD ON VENEER BARS APPLIED AT RIGHT ANGLES TO EACH SIDE OF 3/8" METAL STUDS AT 16" ON CENTER WITH 1" TYPE 'G' DRYWALL SCREWS 8" O.C. TO ENDS AND 12" O.C. TO INTERMEDIATE STUDS. STAGGER JOINTS 18" O.C. EACH SIDE.

ACOUSTICAL CEILING: UNITED STATES GYPSUM ACOUSTIC GLAZIER SHADOWLINE 1 1/2" R12 CODE PANELS U.L. DESIGN P. 216. 24" x 24" x 5/8" AND 24" x 48" x 5/8" (AS INDICATED ON REFLECTED CEILING PLAN). LAMINATE BLACK PIRET WING EXPOSED AND SUSPENDED FROM BAR JOISTS OR OTHER EXISTING ROOF MEMBERS AS PER MANUFACTURER'S PRINTED DIRECTIONS.

LUMINOUS CEILING: (OPTIONAL FOR CONFERENCE ROOM) INTEGRATED CEILING, INC. LIGHTFRAME LUMINOUS CEILING NO. 5099. MODULES SIZE 24" x 24". FRAME FINISH TO BE WOOD VINYL LAMINATE. DIFFUSERS TO BE ALBA-LITE PATTERN NO. 29 OPAL GLASS. INSTALLATION OF LUMINOUS CEILING SYSTEM SHALL BE AS PER MANUFACTURER'S PRINTED DIRECTIONS AND SPECIFICATIONS.

REST ROOMS: TO BE EQUIPPED WITH 'BOBBICK' 6.9. RECESSED TONEL AND SOAP DISPENSER CABINETS CAT. NO. B-319 AND 6.4. RECESSED WASTE RECEPTACLES WITH 10 1/2 GALLON 'ZIGZAG' PLASTIC WASTE CONTAINERS CAT. NO. B-3653 AND TOILET COMPARTMENTS (PLASTIC LAMINATE) PROVIDE HANDICAP SEATS AS SHOWN ON FLOOR PLAN.

GLAZING AND STOREFRONT: ALL GLASS TO BE 1/2" CLEAR GLASS. NEW METAL STOREFRONT TO MATCH EXISTING BUILDING STOREFRONT.

CONTRACTOR TO VERIFY EXISTING SITE DIMENSIONS AND CONDITIONS BEFORE PROCEEDING ANY WORK. REPORT ANY DISCREPANCIES TO ARCHITECT.

TELLER COUNTERS AND OTHER BUILT-IN CABINETS TO BE MANUFACTURED IN ACCORDANCE WITH BANKS REQUIREMENTS AND SPECIFICATIONS.

DOOR SCHEDULE

MARK	SIZE	TYPE	GLASS	JAMB	REMARKS
(A)	8'-0" x 7'-0" x 1	FLOOR	GLASS	METAL	EXISTING
(B)	8'-0" x 7'-0" x 1		GLASS	METAL	STOREFRONT
(C)	8'-0" x 6'-8" x 1 1/2		GLASS	WOOD	
(D)	6'-8" x 6'-8" x 1 1/2				
(E)	6'-0" x 6'-8" x 1 1/2				
(F)	8'-0" x 6'-8" x 1 1/2	GLASS			EXISTING
(G)	1'-0" x 8'-0" x 1 1/2	FLOOR			
(H)	2'-0" x 8'-0" x 1 1/2				

DATE: 7/1/50

PROJECT NO.: 7907-6


FLORIDA

AMERICAN SAVINGS AND LOAN ASSOC.
431 ST. STREET BRANCH

RECEIVED
APR 24 1950
BUILDING DEPARTMENT

UNGE A-1

90121

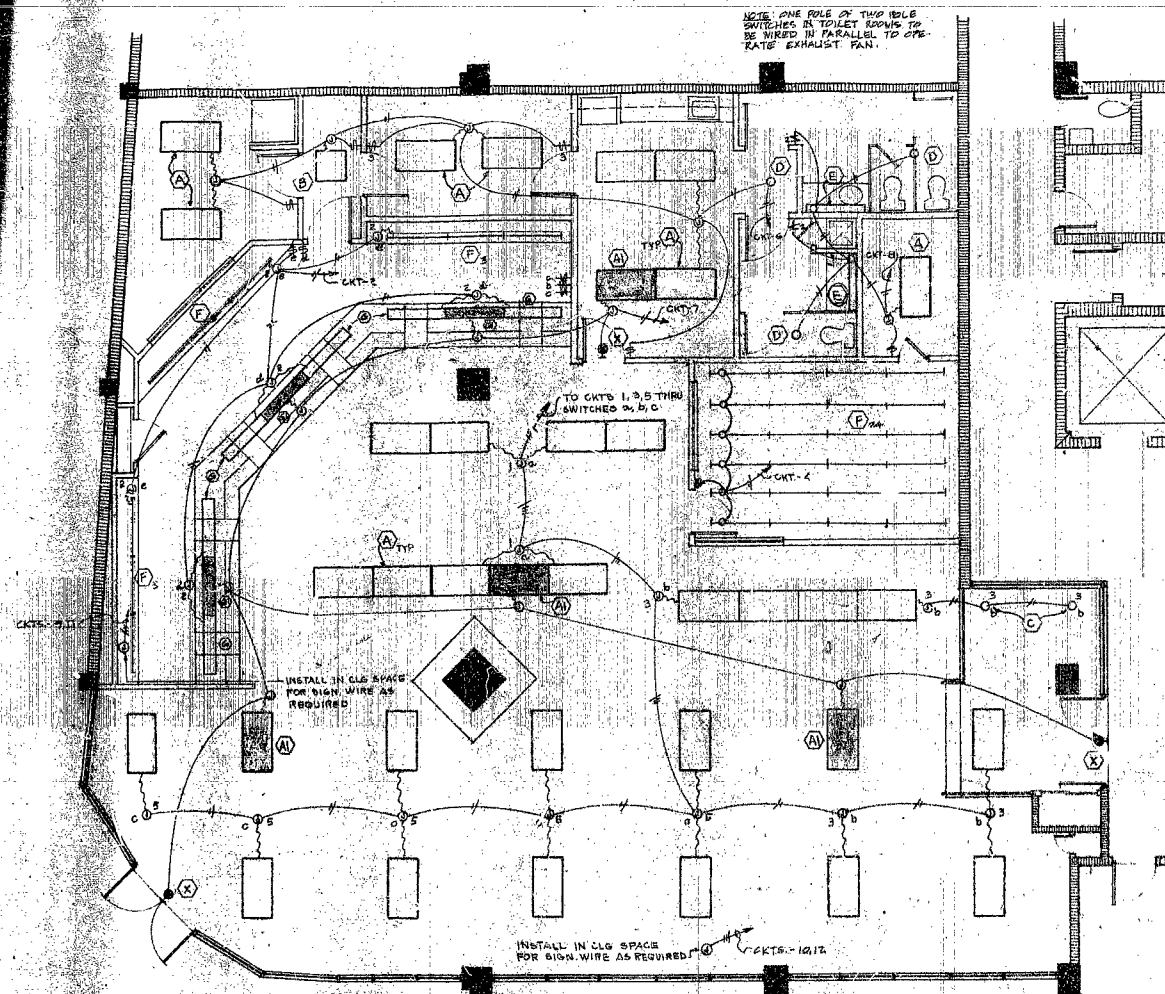

FLOOR PLAN - LIGHTING
SCALE: 1/4" = 1'-0"

CITY OF MIAMI BEACH
APPROVED
DESIGNED BY: [Signature]
DRAWN BY: [Signature]
CHECKED BY: [Signature]
ELECTRICAL BY: [Signature]
MECHANICAL BY: [Signature]
PLUMBING BY: [Signature]
FIRE PROTECTION BY: [Signature]

- A
 - A1
 - B
 - C
 - D
 - E
 - F
 - G
 - G1
 - X
- NOTE: ONE POLE OF TWO 100W SWITCHES IN TOILET ROOMS TO BE WIRED IN PARALLEL TO ONE RATE EXHAUST FAN.
- INSTALL IN CLO SPACE FOR SIGN WIRE AS REQUIRED.
- INSTALL IN CLO SPACE FOR SIGN WIRE AS REQUIRED.

RECEIVED
APR 24 1980
OFFICE COPY


EXISTING CNL									
DET. NO.	LOAD SERVICE	WIRE SIZE	WIRE TYPE	WIRE COLOR	WIRE GROUND	WIRE GROUND	WIRE GROUND	WIRE GROUND	WIRE GROUND
1	LIGHTING	1-20' HIC	12	100W	100W	12	12	12	12
2									
3									
4									
5									
6									
7									
8									
9	SIGN LYS								
10	SIGN LYS								
11	REFRIGERATOR								
12	FOOD WARMER								
13	RECEPTACLES								
14									
15									
16									
100									

AMERICAN SAVINGS AND LOAN ASSOC.
41ST STREET BRANCH
MIAMI BEACH, FLORIDA

PROJECT No. 7907-C

DESIGNED BY: [Signature]
DRAWN BY: [Signature]
CHECKED BY: [Signature]
ELECTRICAL BY: [Signature]
MECHANICAL BY: [Signature]
FIRE PROTECTION BY: [Signature]

90121

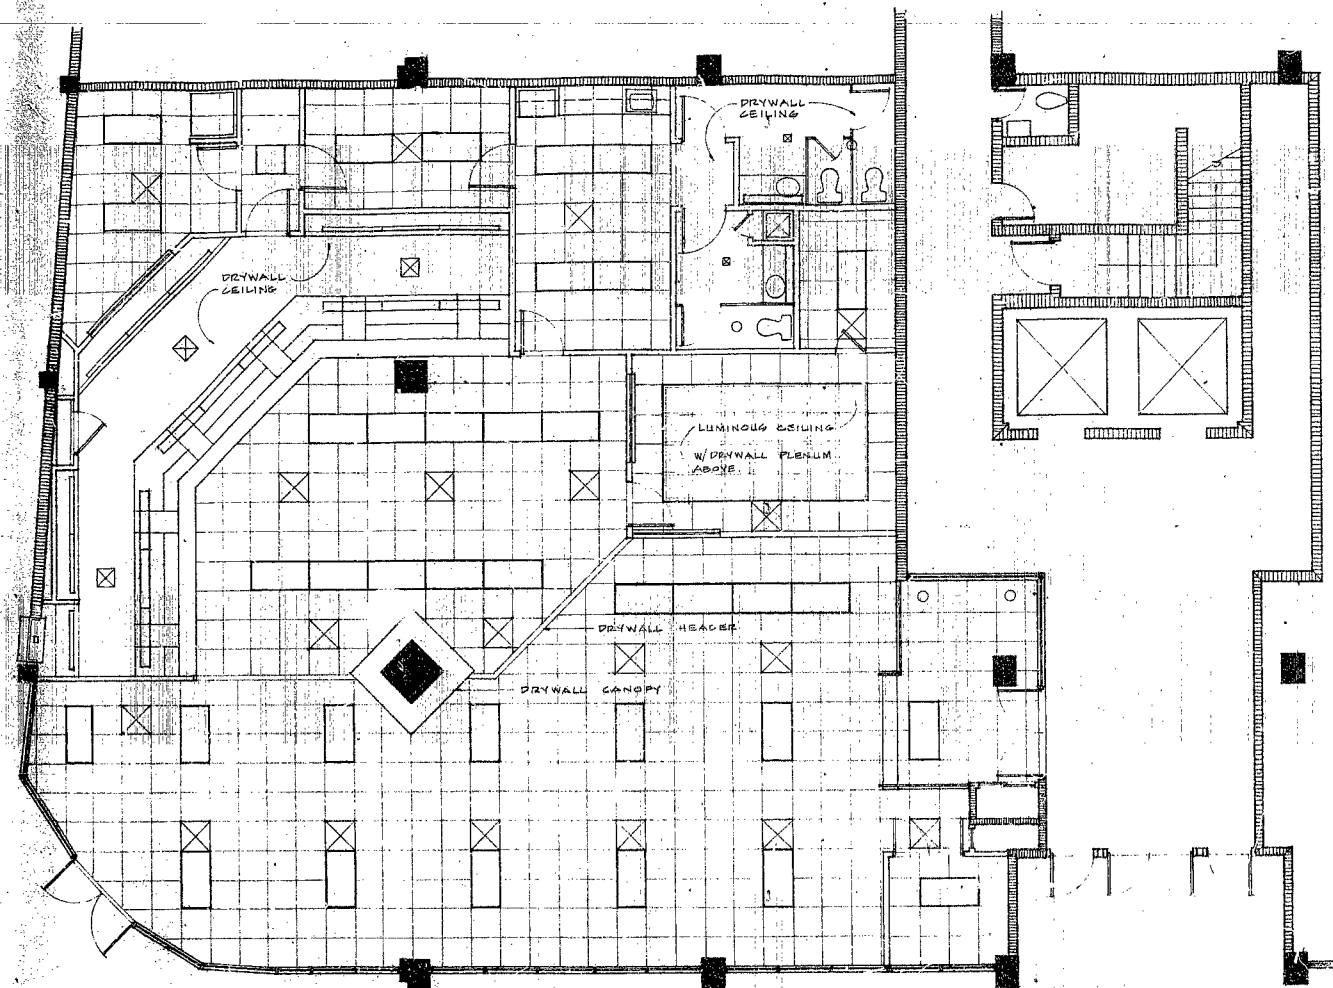

REFLECTED CEILING PLAN 1/8" = 1'-0"

RECEIVED
APR 24 1980
BUILDING DEPARTMENT DIVISION
CITY OF MIAMI BEACH
APPROVED
DESIGNED BY: [Signature]
DRAWN BY: [Signature]
CHECKED BY: [Signature]
DATE: 4-21-80
FILE PREPARED BY: [Signature]
PREPARED BY: [Signature]

OFFICE COPY

ROOM FINISH SCHEDULE						
AREA	FLOOR	BASE	WALLS	CEILING	CLS. HT.	CONTRACT
NEW ACC.	CARPETING	EXIST.	EXISTING	DRYW. ACROUST.	10'-0"	
LOBBY	"	WOOD	DRYWALL	"	8'-0"	
TELENG.	"	"	"	DRYWALL	8'-0"	
HEAD TOWER	"	"	"	DRYW. ACROUST.	8'-0"	
WORK ROOM	"	"	"	"	8'-0"	
LOUNGE	VINYL	VINYL	"	"	8'-0"	
REST ROOMS	"	"	"	DRYWALL	8'-0"	
MENS. OFF.	CARPETING	WOOD	"	LUMINOUS CEILING	8'-0"	




DATE: 4/21/80
BY: [Signature]

AMERICAN SAVINGS AND LOAN ASSOC.
4151 STREET BRANCH
MIAMI BEACH, FLORIDA

PROJECT No. 7207-C
DESIGNED BY: [Signature]
DRAWN BY: [Signature]
CHECKED BY: [Signature]
DATE: 4-21-80
FILE PREPARED BY: [Signature]
PREPARED BY: [Signature]

DWG. A-3
[Signature]

90121

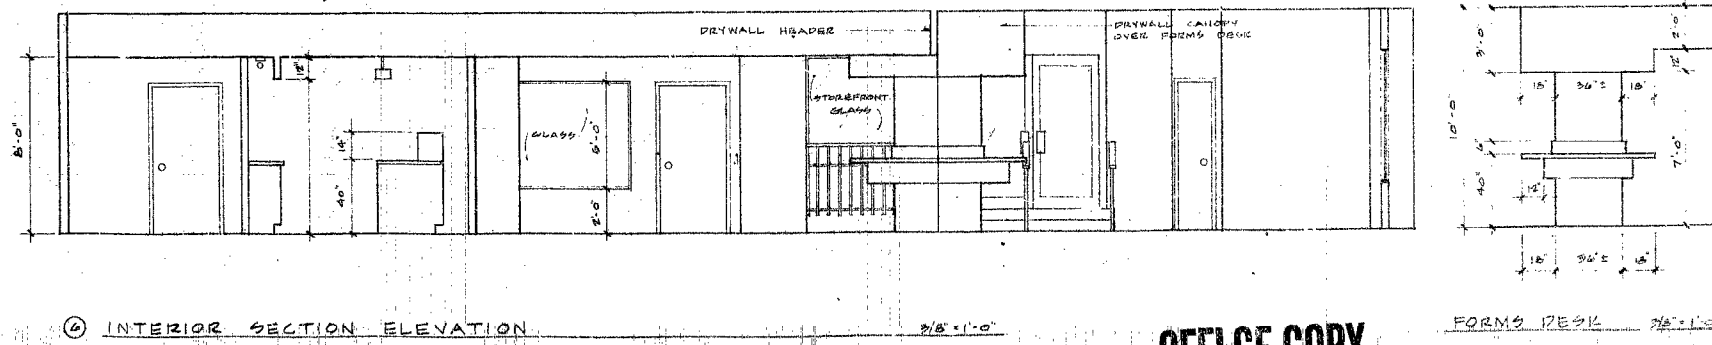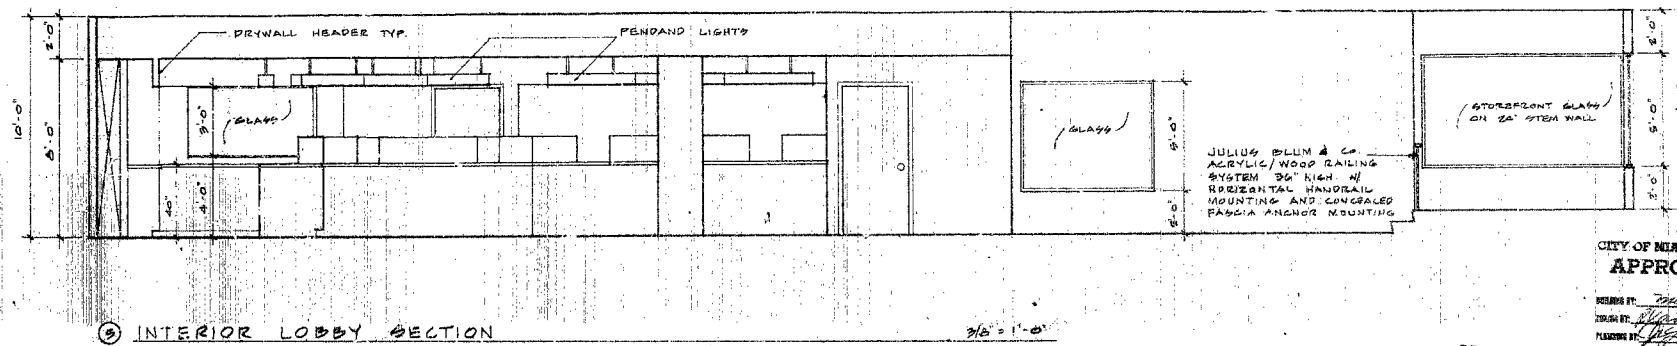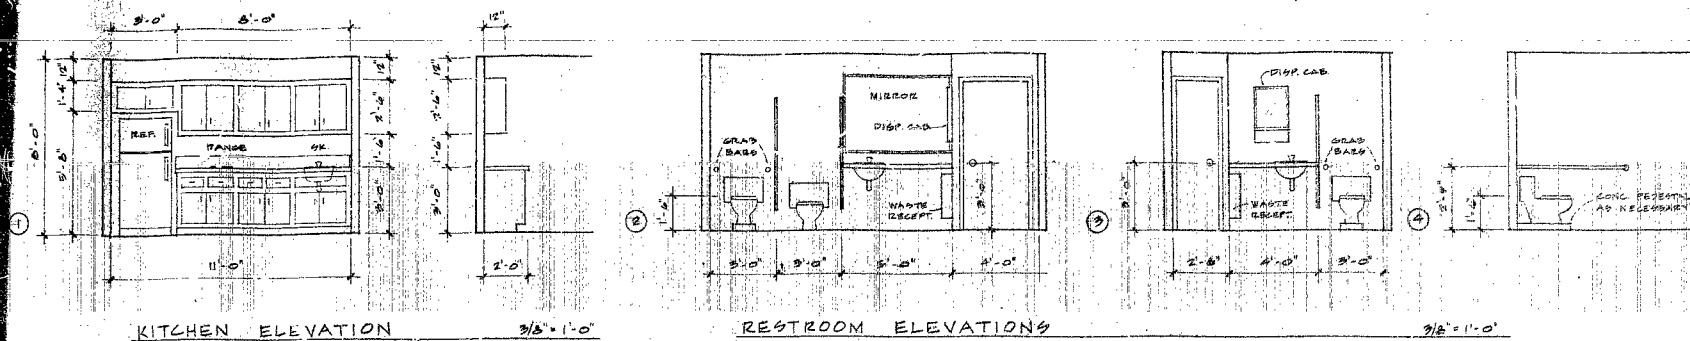

CITY OF MIAMI BEACH
APPROVED

DESIGNED BY: [Signature]
DRAWN BY: [Signature]
PLANNED BY: [Signature]
ELECTRICAL BY: [Signature]
MECHANICAL BY: [Signature]
TRF. ACTIVITY: [Signature]
FINANCING: [Signature]

RECEIVED
APR 21 1980
BUILDING INSPECTION DIVISION

OFFICE COPY

DATE: 4/16/80

PROJECT NO. 7307-C


PROJECT NAME: AMERICAN SAVINGS AND LOAN ASSOC. 1501 STREET BRANCH

DRW. A-1

NO. 1

DATE: 4/16/80

90121

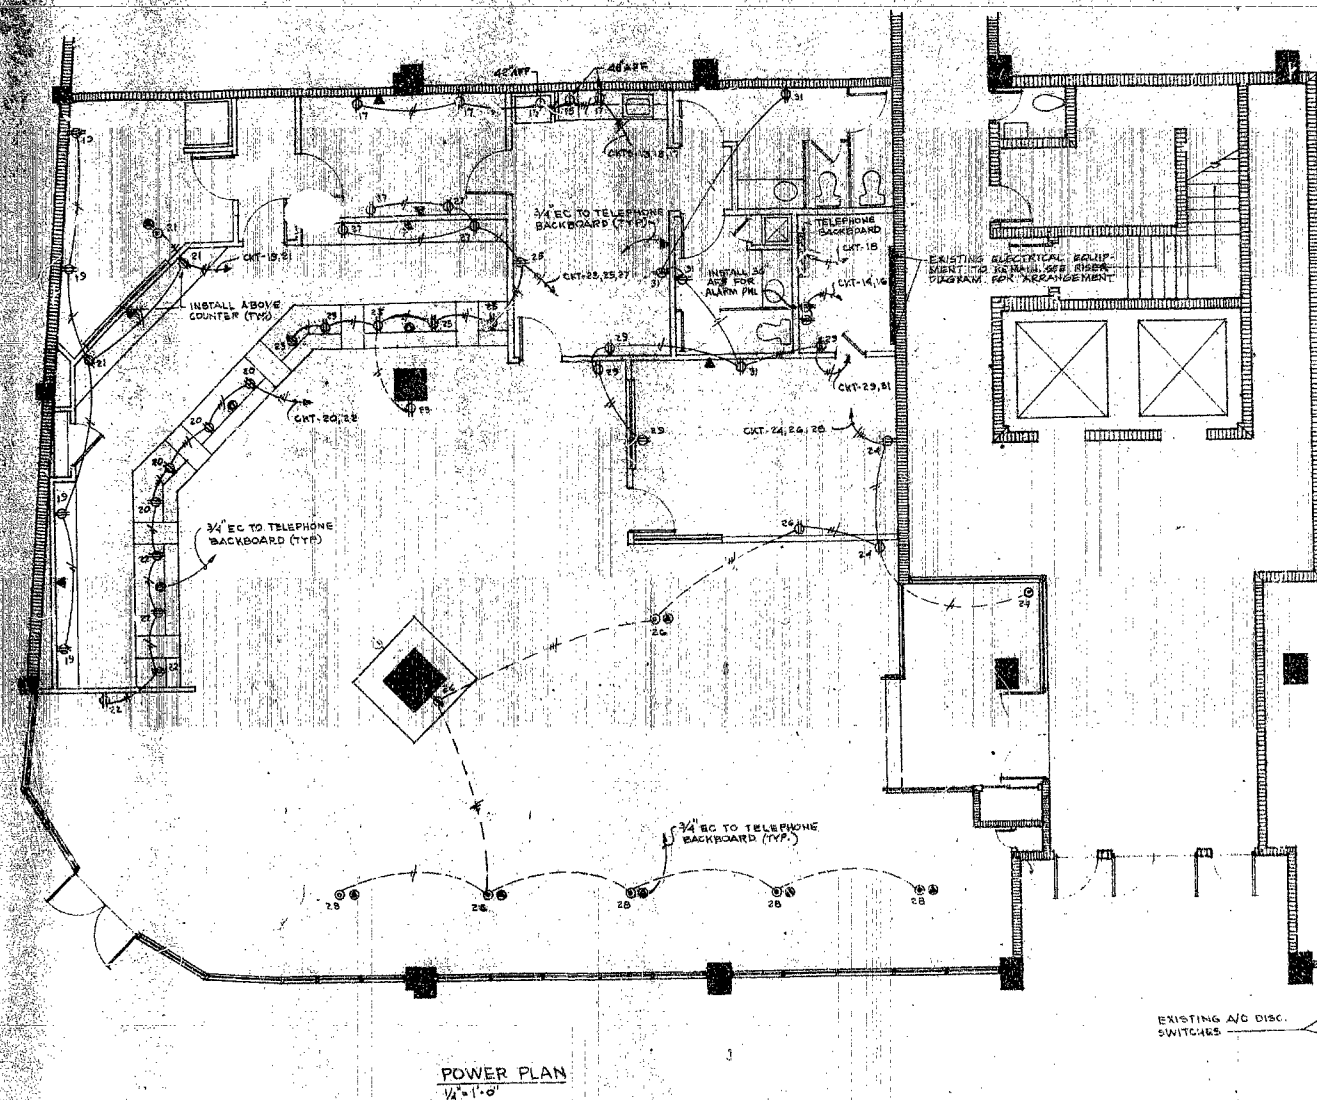


- [illegible]

[illegible]

2" EC TO MAIN TELEPHONE BOARD IN BUILDING COORDINATE W/ TRS. CO

4' x 4' x 3/4" PLYWOOD BACKBOARD FOR TELEPHONE


RECEIVED
APR 24 1968
BUILDING INSPECTION DIVISION
146-750-2400

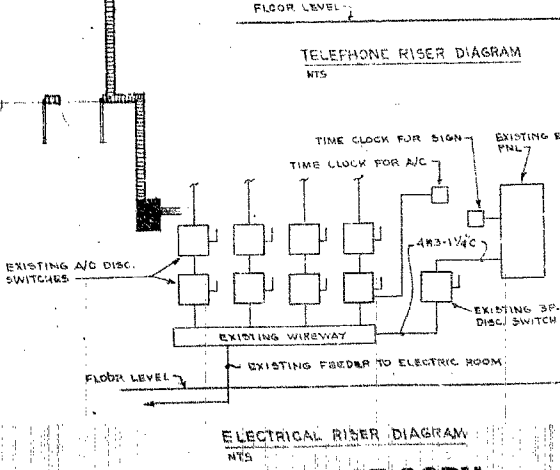

OFFICE COPY

AMERICAN SAVINGS AND LOAN ASSOC.
41st STREET BRANCH

Project 7, Bunkers, Arlington
Box 27, 230 West
Fort Belvoir, 61514
CND 443-2444

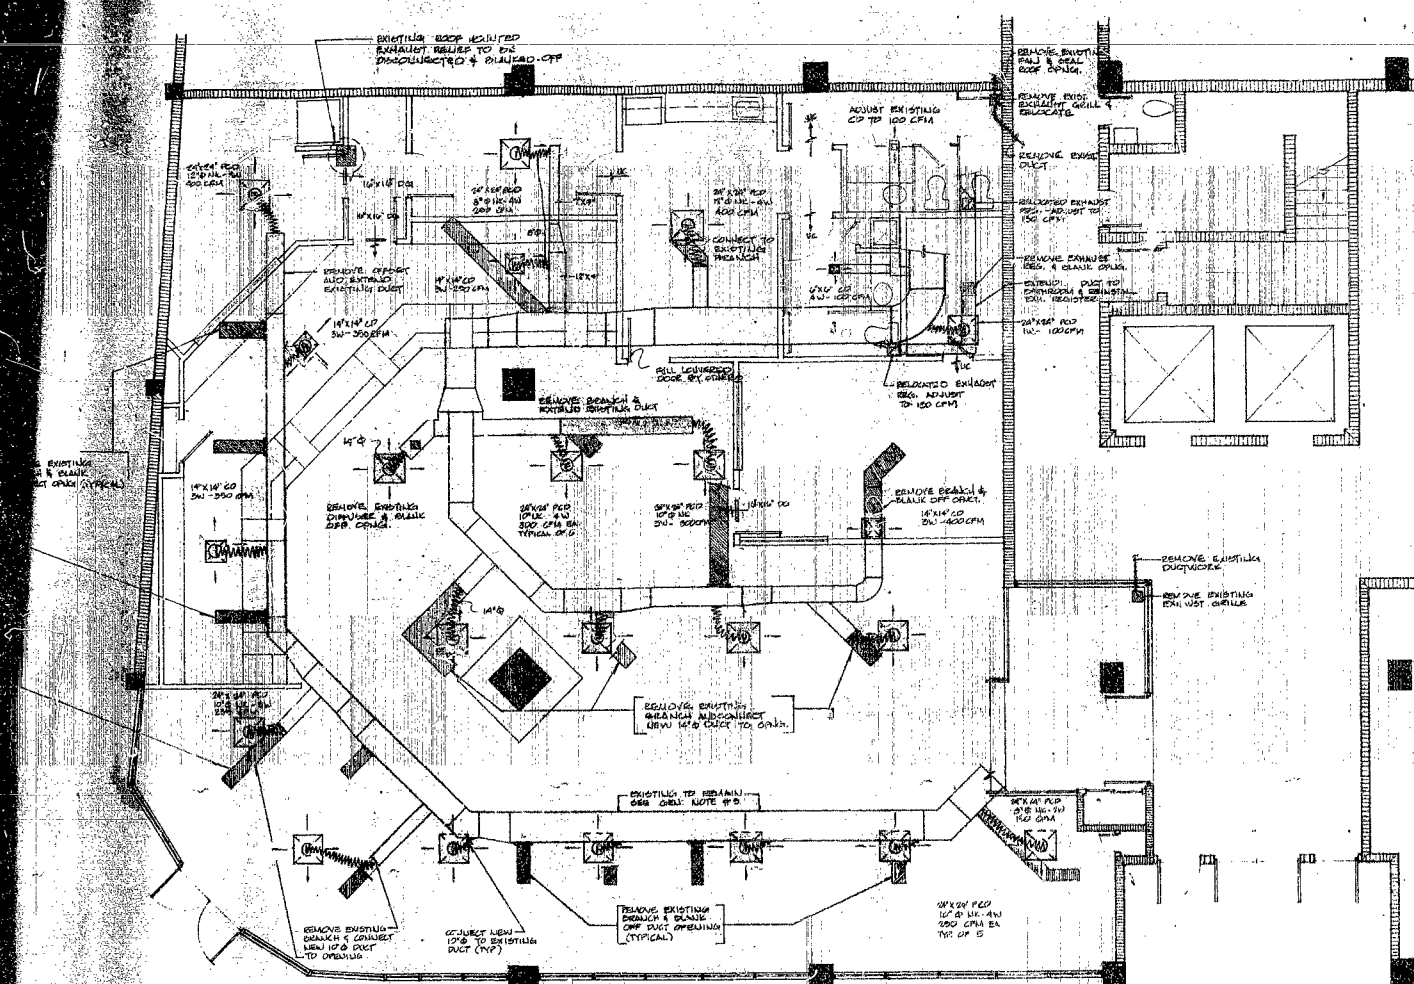

- LEGEND**
- PC-3 PROPOSED C.D. DUCTWORK
 - CD C.D. DUCTWORK
 - UD UNDERGROUND DUCT
 - ED EXISTING DUCT TO BE REMOVED
 - ND NEW DUCTWORK TO BE INSTALLED

- GENERAL NOTES:**
1. CONTRACTOR TO VERIFY LOCATIONS & DIMENSIONS PRIOR TO CONSTRUCTION.
 2. ALL NEW DUCTWORK SHALL MATCH EXISTING IN CONSTRUCTION & MATERIALS.
 3. CONTRACTOR SHALL EXPLORE THE POSSIBILITY OF REPAIRING EXISTING DUCTWORK OF 18" & 20" ABOVE WEIGHTS OF MAXIMUM FUNCTIONAL CEILING HEIGHT ALONG SHERIDAN STREET.
 4. CONTRACTOR TO COORDINATE WITH A COLOR OF DIFFUSERS TO MATCH CEILING TILES.
 5. CONTRACTOR TO CHECK, REPAIR/REPLACE & VERIFY OR REPLACE (IF NEEDED) ANY EXISTING MECHANICAL EQUIPMENT (CONDENSING UNITS, AIR HANDLING UNITS, EXHAUST FANS, VOLUME DAMPERS, ETC.).
 6. CONTRACTOR TO BALANCE SYSTEM FOR CFM. UNLESS OTHERWISE SPECIFIED, TOTAL OUTSIDE AIR INTAKE TO MINIMUM 100 CFM & ADJUST TO EXHAUST REGISTER & FAN TO VALUES SHOWN.
 7. CONTRACTOR TO RELOCATE OR REPLACE RETURN AIR GRILLS FOR BOTH AIR HANDLING UNITS TO ACCOMMODATE NEW CEILING LAYOUT.
 8. ALL NEW FLEXIBLE DUCT CONNECTIONS TO HAVE VOLUME DAMPERS AT TAKE-OFF COLLARS.

RECEIVED
APR 24 1980
BUILDING INSPECTION DIVISION


CITY OF MIAMI BEACH
APPROVED

DESIGNED BY: [Signature]
CHECKED BY: [Signature]
DRAWN BY: [Signature]
DATE: 4/15/80

OFFICE COPY

DATE	4/15/80
BY	[Signature]
AMERICAN SAVINGS AND LOAN ASSOC. 415 STREET BRANCH MIAMI BEACH, FLORIDA	
PROJECT NO.	7507-0
DWG.	ALG-1
NO.	6

90121

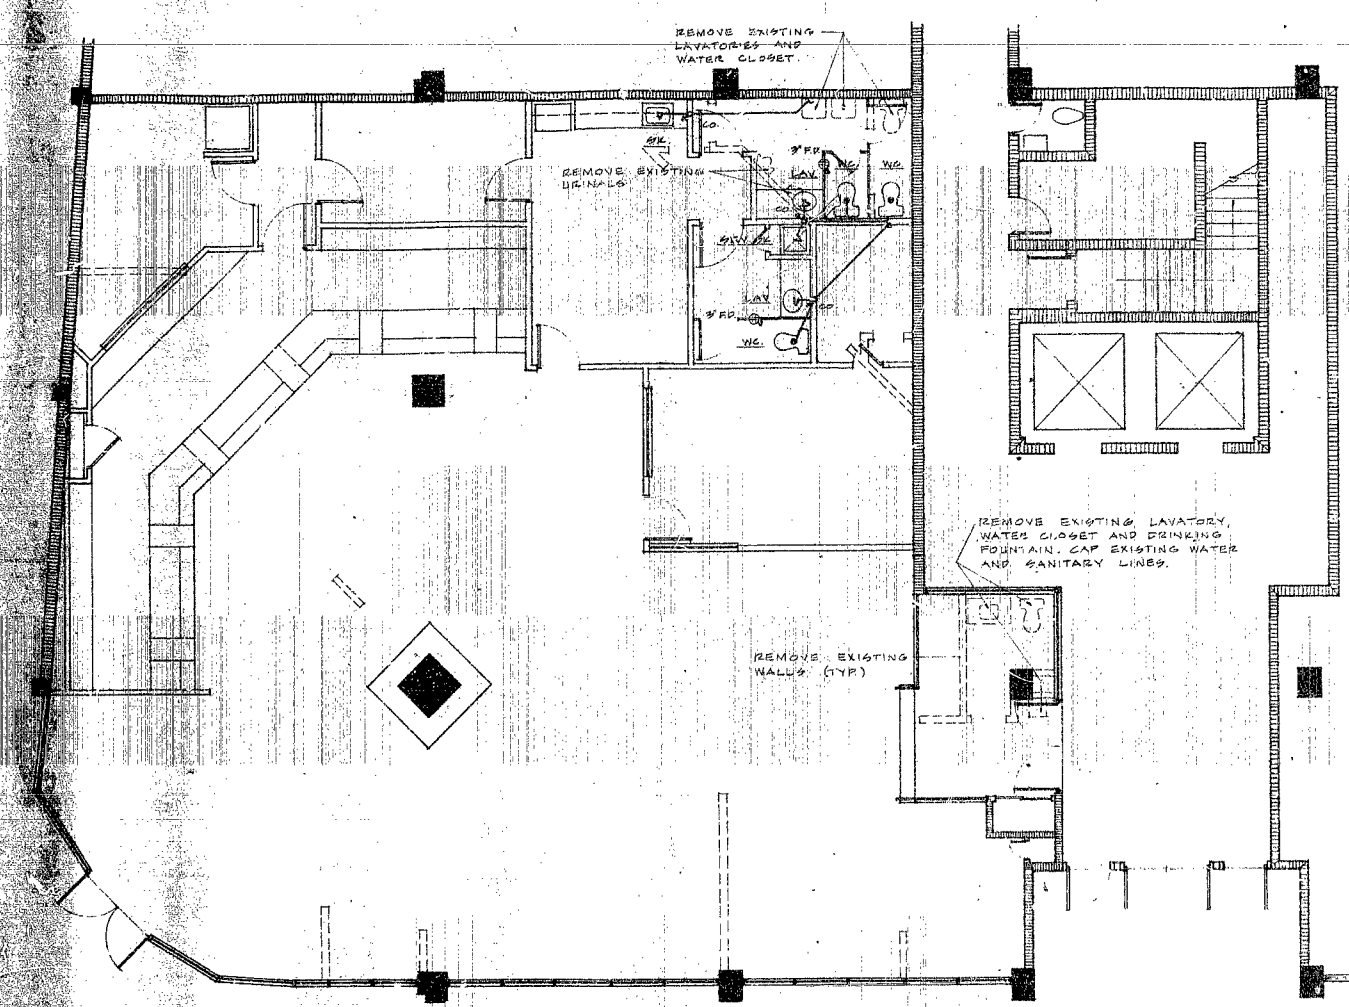

PLUMBING FLOOR PLAN 1/4" = 1'-0"

PLUMBING NOTES


SINK:
AMERICAN STANDARD EXPLORER
SINGLE BOWL SINK CATALOGUE No.
2297.223 WITH AQUARIAN II
FAUCET CATALOGUE No. 2297.044

LAVATORY:
AMERICAN STANDARD AQUALIN
LAVATORY CATALOGUE No. 0476.023
WHITE WIT 4" CENTERS AND
AQUARIAN CENTERSET LAVATORY
FAUCET CATALOGUE No. 279.100

WATER CLOSET:
AMERICAN STANDARD ELONGATED
CADET TOILET CATALOGUE No.
2109.096 WITH 3087.918 BOWL,
4047.090 TANK AND 5921.037 SEAT.

FLOOR DRAIN:
RICHMOND FLOOR DRAIN WITH 3 INCH
OUTLET AND 6 INCH NICKEL BRONZE
STRAINER CATALOGUE No. R-1464

OF MIAMI BEACH
MOVED
DESIGNED BY: [Signature]
DRAWN BY: [Signature]
CHECKED BY: [Signature]
REVISIONS BY: [Signature]
PROJECT NO. 7507-2

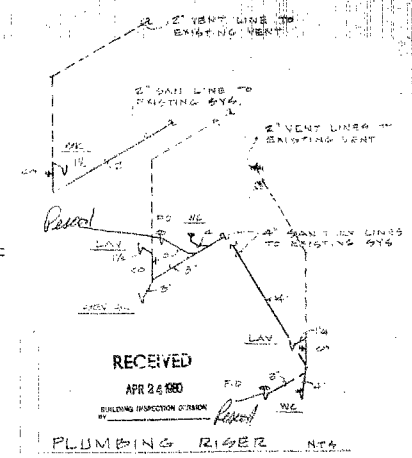

PLUMBING RISER NT4

OFFICE COPY


DATE	7/1/58
BY	[Signature]
CHECKED	[Signature]
PROJECT NO.	7507-2
AMERICAN SAVINGS AND LOAN ASSOC. 4341 STREET BRANCH	
DWG. NO. 7	

90121


90121

9291


9291

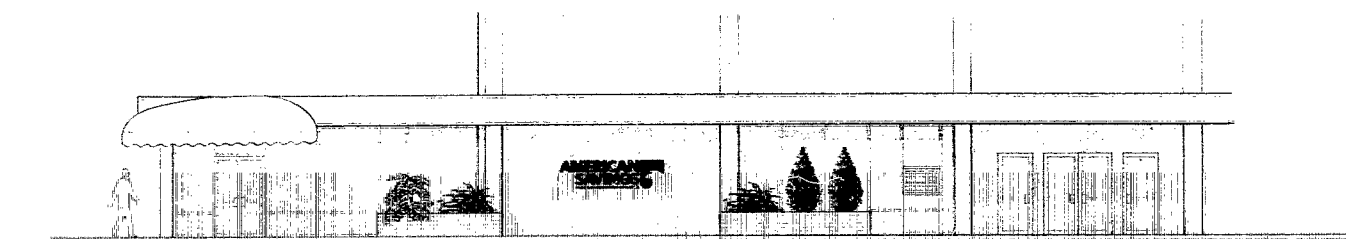


BUILDING FRONT ELEVATION

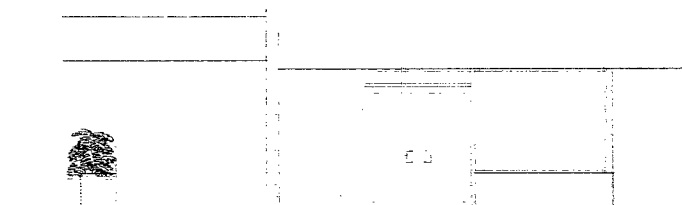

STREET BANK ENTRANCE

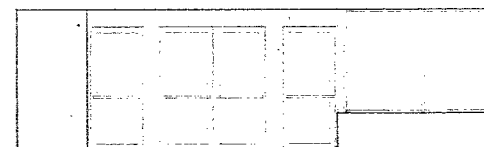

BUILDING VAN ENTRANCE

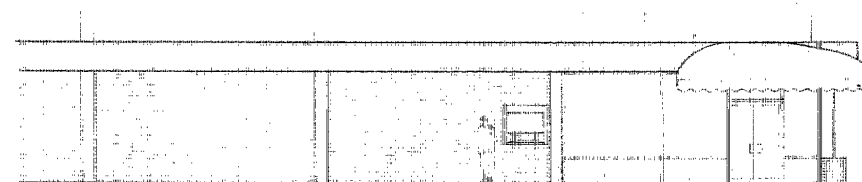

BUILDING LEFT SIDE ELEVATION

RECEIVED
APR 24 1988
BUILDING PERMIT DIVISION
CITY OF MIAMI BEACH
APPROVED
DATE: 4/26/88
DRAWN BY: [Signature]
CHECKED BY: [Signature]
DESIGNED BY: [Signature]
PROJECT NO. 90121

OFFICE COPY

DATE	4/26/88
DESIGNER	[Signature]
CHECKED	[Signature]
DATE	4/26/88


AMERICAN SAVINGS AND LOAN
41 W STREET BRANCH
MIAMI BEACH
FLORIDA


PROJECT NO.	90121
DATE	4/26/88

DATE	4/26/88
------	---------

DATE	4/26/88
------	---------

90121

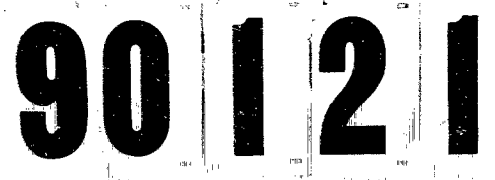

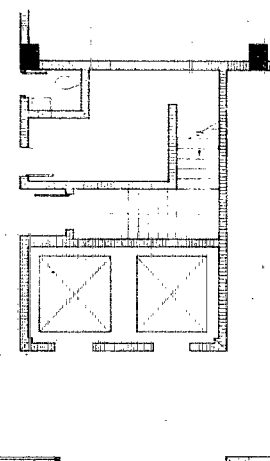

5. TRANSFORMER WITH TWO SHIELDS IF THE TWO SHIELD FACTOR RATIO IS 1:1 THEN THERE IS NO VOLTAGE LOSS IN SHIELDS.
6. RECTIFIER CIRCUIT, INSTEAD OF 4 DIODES, USING 2 DIODES AND 2 CAPACITORS. BUT THE POWER FACTOR WILL BE 2/3RD OF THE CONVENTIONAL CIRCUIT. NOT GOOD TO BE USED.
7. SIMILAR TO THE 6 BUT WITH DIODES IN BRIDGE MODE.

OFFICE COPY

[illegible]

CITY OF MIAMI HEADQUARTERS
APPROVED

ISSUING TO: John Smith
TRADING NO: 101
EXPIRATION DATE: 12/31/2001
RECEIVED BY: F. S. 1-
ISSUING OFFICE: 11/11/01
FIVE FINGERED: 11/11/01
FINGERPRINTS: 11/11/01

DATE	NO.	NAME	ADDRESS	CITY	STATE	ZIP	TELEPHONE
11/10/80	1	WILLIAM	11111	11111	11111	11111	11111

 
AMERICAN SAVINGS AND LOAN ASSOC.
41st STREET BRANCH
MIAMI BEACH
FLORIDA

Miss F. Sacher, Architect
401 E. 17th Street
Rm. 401 (entrance) N. 13116
(406) 443-2225



DWG. E-1
NO. **4**
OF 5




90 1 2 1

[illegible]

RECEIVED
APR 22 1960
U. S. DEPARTMENT OF JUSTICE
CITY OF MIAMI BEACH
APPROVED
DATE
MAILING BY *2nd class*
REMARKS BY *W. J. ...*
FURNISHING BY *...*
RECEIVED BY *...*
VOUCHER NO. *...*
GENERAL INVEST. *...*
FUND CATEGORY *...*
FUND NUMBER *...*

MEMBER'S NAME Member's Name, Address Full Name, Address City, State, Zip		DATE Date of Birth Date of Issue Date of Expiration	
MEMBER'S SIGNATURE Member's Signature Date		DATE Date of Birth Date of Issue Date of Expiration	

90 1 2

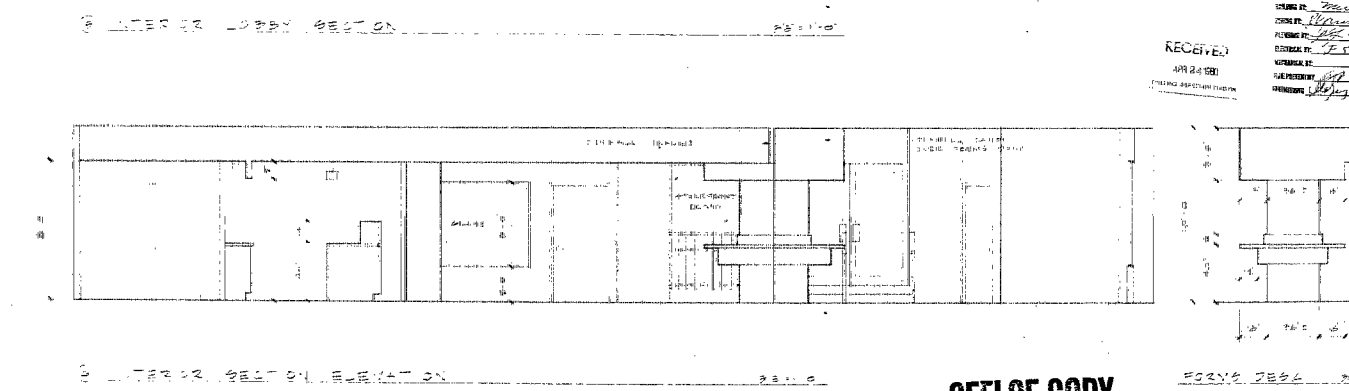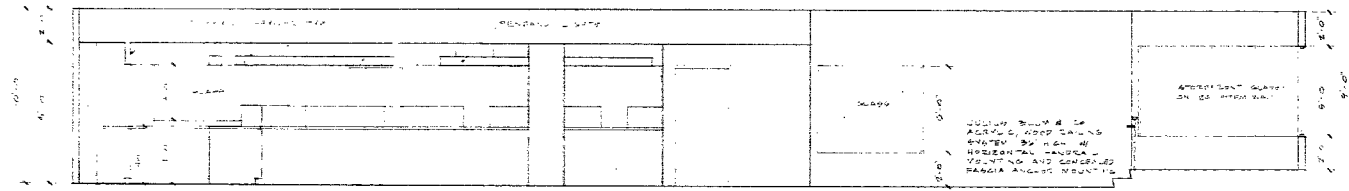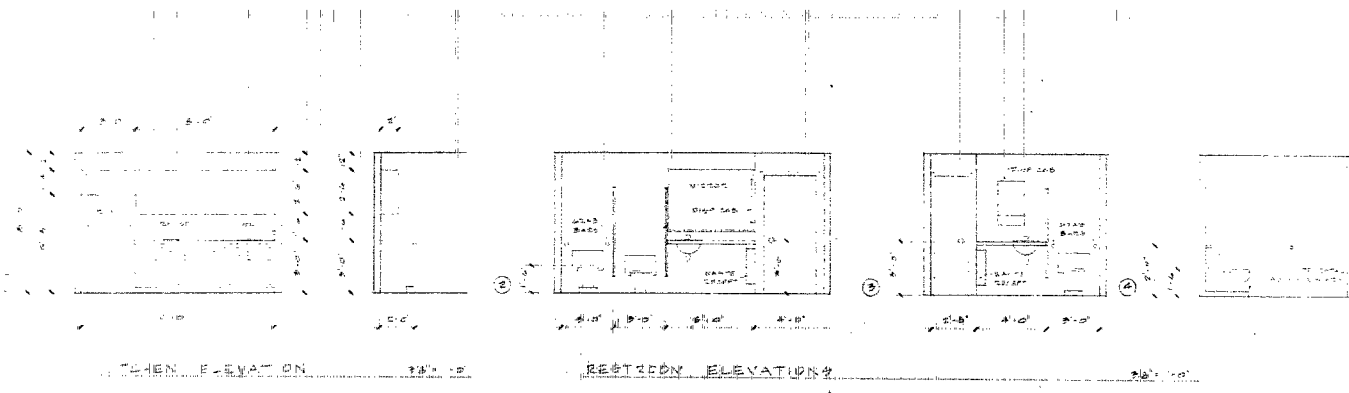


CITY OF MIAMI BEACH
APPROVED
DATE: 10/1/80
DESIGNED BY: [Signature]
CHECKED BY: [Signature]
PERMITTED BY: [Signature]
REVISIONS: [Signature]

FOR THE DESIGNER

OFFICE COPY

DATE	10/1/80
DESIGNED BY	[Signature]
CHECKED BY	[Signature]
PERMITTED BY	[Signature]
REVISIONS	[Signature]
AMERICAN SAVINGS AND LOAN ASSOC. 41st STREET BRANCH FLORIDA MIAMI BEACH	
PROJECT NO. 1507-C	
DWG. NO.	2
OF	2

90121

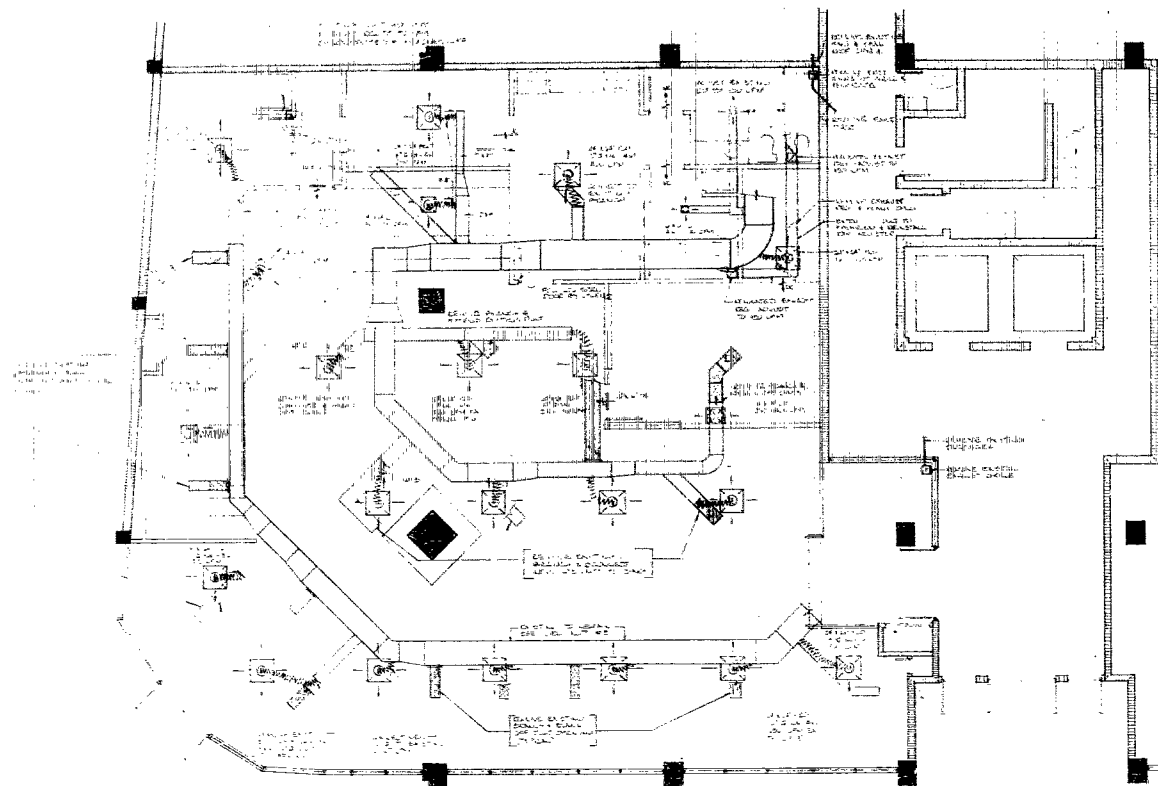

LEGEND

- 1. EXTERIOR WALLS
- 2. EXTERIOR DOORS
- 3. EXTERIOR WINDOWS
- 4. EXTERIOR STAIRS
- 5. EXTERIOR ELEVATOR
- 6. EXTERIOR RESTROOM
- 7. EXTERIOR OFFICE
- 8. EXTERIOR LOAN
- 9. EXTERIOR SAVINGS
- 10. EXTERIOR CASHIER
- 11. EXTERIOR RECEIVING AREA

GENERAL NOTES:

1. EXTERIOR WALLS SHALL BE CONCRETE BLOCK WITH 1/2" REINFORCING BARS AT 16" ON CENTER.
2. EXTERIOR DOORS SHALL BE 1/2" REINFORCING BARS AT 16" ON CENTER.
3. EXTERIOR WINDOWS SHALL BE 1/2" REINFORCING BARS AT 16" ON CENTER.
4. EXTERIOR STAIRS SHALL BE 1/2" REINFORCING BARS AT 16" ON CENTER.
5. EXTERIOR ELEVATOR SHALL BE 1/2" REINFORCING BARS AT 16" ON CENTER.
6. EXTERIOR RESTROOM SHALL BE 1/2" REINFORCING BARS AT 16" ON CENTER.
7. EXTERIOR OFFICE SHALL BE 1/2" REINFORCING BARS AT 16" ON CENTER.
8. EXTERIOR LOAN SHALL BE 1/2" REINFORCING BARS AT 16" ON CENTER.
9. EXTERIOR SAVINGS SHALL BE 1/2" REINFORCING BARS AT 16" ON CENTER.
10. EXTERIOR CASHIER SHALL BE 1/2" REINFORCING BARS AT 16" ON CENTER.
11. EXTERIOR RECEIVING AREA SHALL BE 1/2" REINFORCING BARS AT 16" ON CENTER.

RECEIVED

APR 24 1980

A. J. JONES - PROJECT MANAGER

CITY OF MIAMI BEACH

APPROVED

DESIGNED BY: [Signature]

DRAWN BY: [Signature]

CHECKED BY: [Signature]

APPROVED BY: [Signature]

DATE: [Signature]

OFFICE COPY

DATE	10/10/80
BY	[Signature]

AMERICAN SAVINGS AND LOAN ASSOC.	FLORIDA
41st STREET BRANCH	MIAMI BEACH

Project No.	77077
Sheet No.	1


EW

DWG:	A-01
------	------

NO:	6
-----	---

OF:	6
-----	---

90121

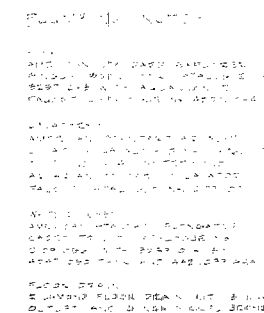


CITY OF MIAMI BEACH
... MOVED ...
ISSUED BY: [Signature]
EXACT BY: [Signature]
FEDERAL BY: [Signature]
ELECTRIC BY: SF 5/1/60
MECHANICAL BY:
PAID PREPARED BY: [Signature]
INSTRUMENT: [Signature] 578

RECEIVED
APR 24 1968

OFFICE COPY

AMERICAN SAVINGS AND LOAN ASSOC. 41st STREET BRANCH MIAMI BEACH, FLORIDA		DATE 11-22-62 11-22-62 11-22-62	
Michael F. Sinclair, Assistant First Vice President 1000 Biscayne Blvd., Suite 3333 Miami Beach, Florida 33139		PRESENT NA 7907-6	
OWO: 7		NO:	
OF:			

90 1 2 1

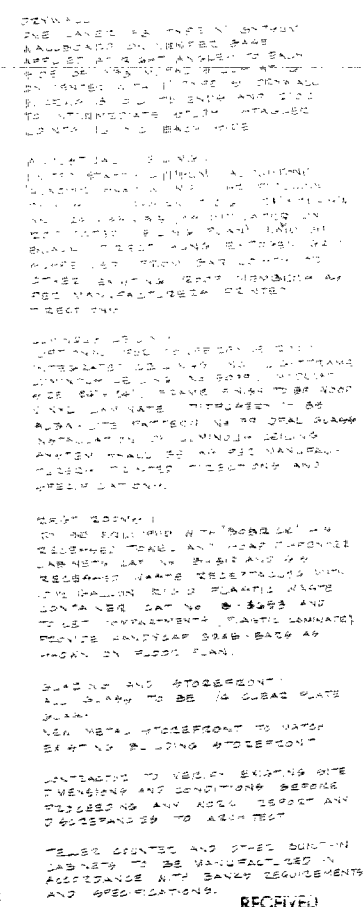

7002 40457016				
WAVE	TYPE	CODE	NAME	REMARKS
A	0-0-0-0-0-0	0-0-0-0	0-0-0-0	0-0-0-0-0-0
B	0-0-0-0-0-0	0-0-0-0	0-0-0-0	0-0-0-0-0-0
C	0-0-0-0-0-0	0-0-0-0	0-0-0-0	0-0-0-0-0-0
D	0-0-0-0-0-0	0-0-0-0	0-0-0-0	0-0-0-0-0-0
E	0-0-0-0-0-0	0-0-0-0	0-0-0-0	0-0-0-0-0-0
F	0-0-0-0-0-0	0-0-0-0	0-0-0-0	0-0-0-0-0-0
G	0-0-0-0-0-0	0-0-0-0	0-0-0-0	0-0-0-0-0-0
H	0-0-0-0-0-0	0-0-0-0	0-0-0-0	0-0-0-0-0-0
I	0-0-0-0-0-0	0-0-0-0	0-0-0-0	0-0-0-0-0-0
J	0-0-0-0-0-0	0-0-0-0	0-0-0-0	0-0-0-0-0-0
K	0-0-0-0-0-0	0-0-0-0	0-0-0-0	0-0-0-0-0-0
L	0-0-0-0-0-0	0-0-0-0	0-0-0-0	0-0-0-0-0-0
M	0-0-0-0-0-0	0-0-0-0	0-0-0-0	0-0-0-0-0-0
N	0-0-0-0-0-0	0-0-0-0	0-0-0-0	0-0-0-0-0-0
O	0-0-0-0-0-0	0-0-0-0	0-0-0-0	0-0-0-0-0-0
P	0-0-0-0-0-0	0-0-0-0	0-0-0-0	0-0-0-0-0-0
Q	0-0-0-0-0-0	0-0-0-0	0-0-0-0	0-0-0-0-0-0
R	0-0-0-0-0-0	0-0-0-0	0-0-0-0	0-0-0-0-0-0
S	0-0-0-0-0-0	0-0-0-0	0-0-0-0	0-0-0-0-0-0
T	0-0-0-0-0-0	0-0-0-0	0-0-0-0	0-0-0-0-0-0
U	0-0-0-0-0-0	0-0-0-0	0-0-0-0	0-0-0-0-0-0
V	0-0-0-0-0-0	0-0-0-0	0-0-0-0	0-0-0-0-0-0
W	0-0-0-0-0-0	0-0-0-0	0-0-0-0	0-0-0-0-0-0
X	0-0-0-0-0-0	0-0-0-0	0-0-0-0	0-0-0-0-0-0
Y	0-0-0-0-0-0	0-0-0-0	0-0-0-0	0-0-0-0-0-0
Z	0-0-0-0-0-0	0-0-0-0	0-0-0-0	0-0-0-0-0-0


PROJECT No. 7907-C Miami Building 9071		AMERICAN SAVINGS AND LOAN ASSOC. 41st STREET BRANCH MIAMI BEACH, FLORIDA	
Daniel F. Scammell, Assistant Vice President 1000 Biscayne Blvd. Miami, Florida	DATE 5/24/72 5/24/72 5/24/72		

FLOOR PLAN (PROPOSED)

CITY OF MIAMI BEACH
APPROVED


NEW ORLEANS
OFFICE COPY

90121

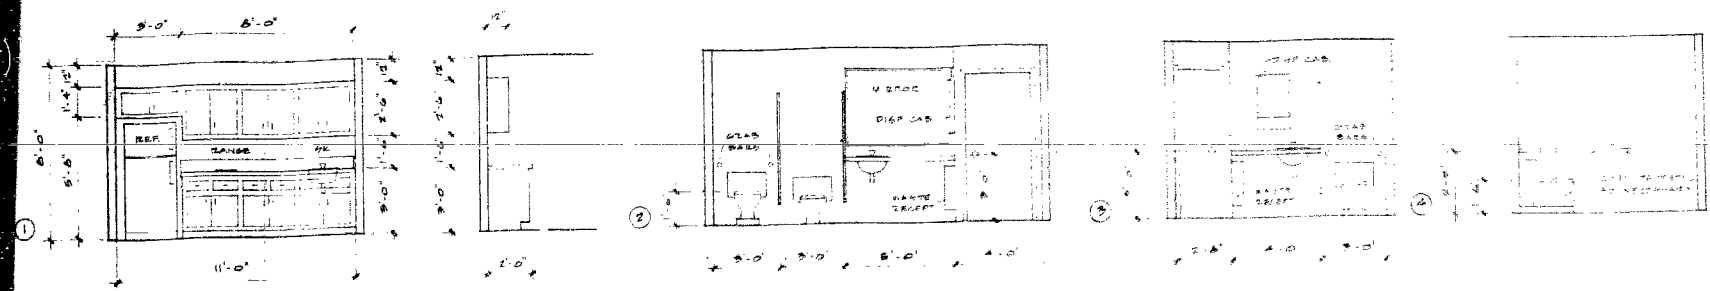


KITCHEN ELEVATION 9/8-1-0

RESTROOM ELEVATIONS 9/8-1-0

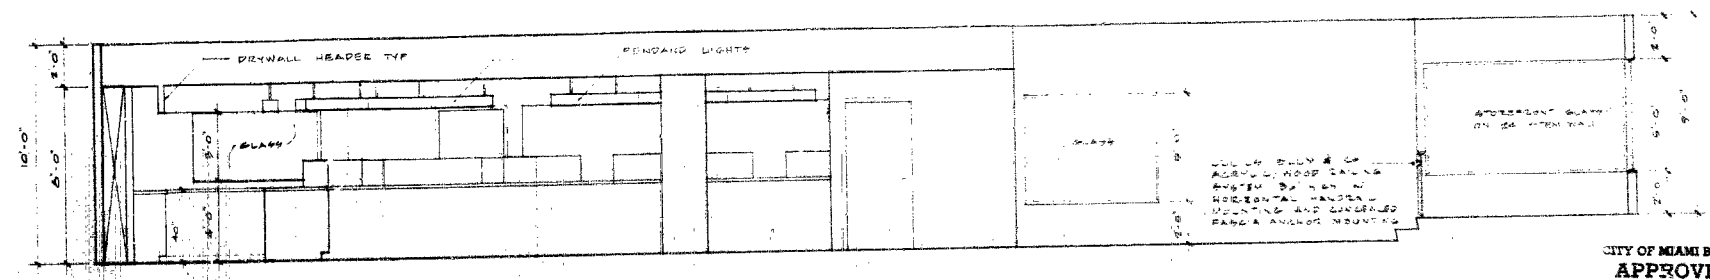


3 INTERIOR LOBBY SECTION 9/8-1-0

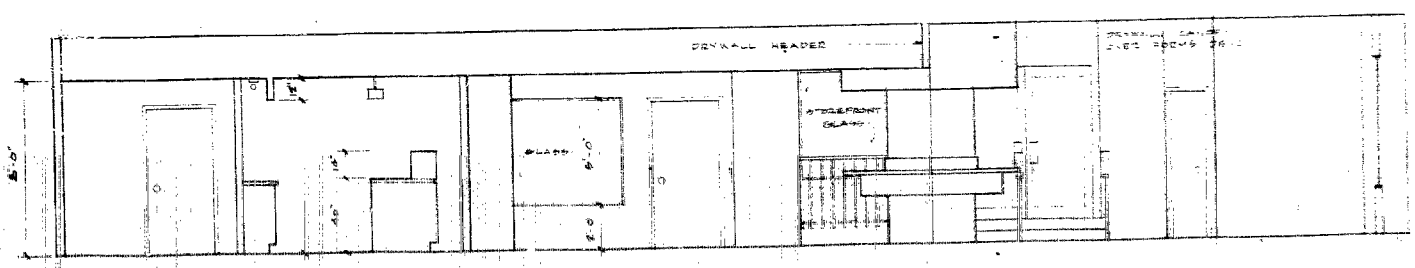

4 INTERIOR SECTION ELEVATION 9/8-1-0

CITY OF MIAMI BEACH
APPROVED
 DATE: 10/1/00
 DESIGNED BY: [Signature]
 DRAWN BY: [Signature]
 CHECKED BY: [Signature]
 APPROVED BY: [Signature]
 PROJECT NO. 1109-C

RECEIVED
 APR 24 1991
 LONG ISLAND AVENUE

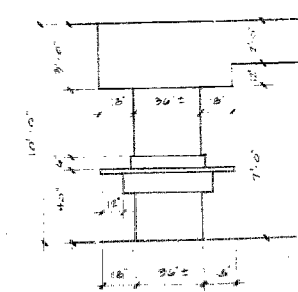


FORMS DESK 9/8-1-0

OFFICE COPY

DATE	10/1/00
DESIGNED BY	[Signature]
DRAWN BY	[Signature]
CHECKED BY	[Signature]
APPROVED BY	[Signature]
PROJECT NO.	1109-C
AMERICAN SAVINGS AND LOAN ASSOC. 4111 STREET BRANCH MIAMI BEACH, FLORIDA	

90121

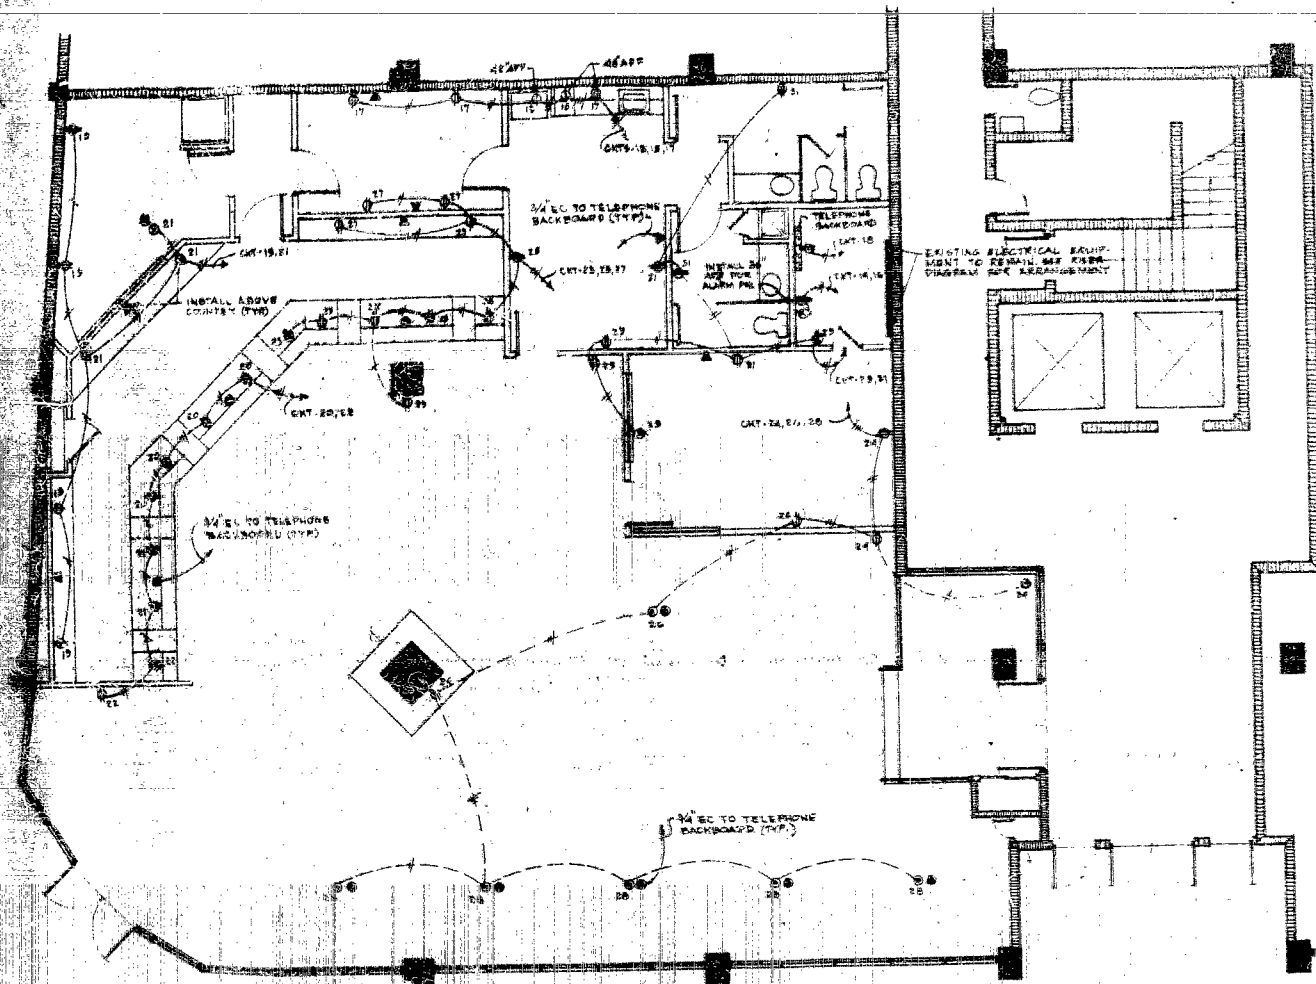


POWER PLAN
1/4"=1'-0"

2"=1' TO MAIN TELEPHONE BOARD IN BUILDING COORDINATE W/ TEL. CO.
4"=1' W/ PLYWOOD BACKBOARD FOR TELEPHONE

RECEIVED
APR 24 1960
ELECTRICAL DIVISION
100-1120 GROUND

TELEPHONE RISER DIAGRAM
NTS

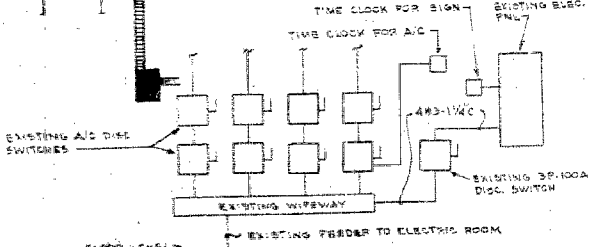


ELECTRICAL RISER DIAGRAM
NTS

OFFICE COPY

DATE	4/19/60
BY	W. J. [Signature]
CITY OF MIAMI BEACH	APPROVED
DESIGNED BY	W. J. [Signature]
PLANNED BY	W. J. [Signature]
ELECTRICAL BY	W. J. [Signature]
MECHANICAL BY	W. J. [Signature]
CIVIL BY	W. J. [Signature]
STRUCTURAL BY	W. J. [Signature]
PROJECT NO.	7707-C
AMERICAN SAVINGS AND LOAN ASSOC. 41st STREET BRANCH MIAMI BEACH, FLORIDA	

90121

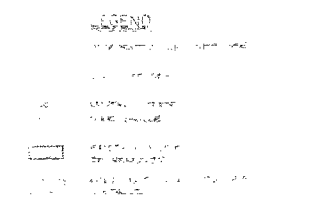

1. IDENTIFYING THE ISSUES ASSOCIATED WITH THE PROBLEM
2. ANALYZING THE ISSUES AND DEVELOPING A STRATEGY TO RESOLVE THE PROBLEM
3. IMPLEMENTING THE STRATEGY AND EVALUATING THE RESULTS OF THE STRATEGY
4. REVISITING THE PROBLEM AND DEVELOPING A STRATEGY TO RESOLVE THE PROBLEM
5. REVISITING THE PROBLEM AND DEVELOPING A STRATEGY TO RESOLVE THE PROBLEM
6. REVISITING THE PROBLEM AND DEVELOPING A STRATEGY TO RESOLVE THE PROBLEM
7. REVISITING THE PROBLEM AND DEVELOPING A STRATEGY TO RESOLVE THE PROBLEM
8. REVISITING THE PROBLEM AND DEVELOPING A STRATEGY TO RESOLVE THE PROBLEM
9. REVISITING THE PROBLEM AND DEVELOPING A STRATEGY TO RESOLVE THE PROBLEM
10. REVISITING THE PROBLEM AND DEVELOPING A STRATEGY TO RESOLVE THE PROBLEM

FIELDING INSPECTION UNIT

WORKING PT. 7:00 AM
ENDING PT. 5:00 PM
PLANNING ON 5/1/80
ELECTRONIC BY 5-1-80
SCHEDULED AT 5-1-80
PAGE NUMBER 5/1-80
REMARKS 5/1-80

OFFICE COPY

 
7909-C
 1909-2
 1909-3
 1909-4
 1909-100

DATE: _____

NO.: _____

OF: _____

90121



2008 2009
 2010 2011 2012 2824 28


RECEIVED BY: John J. [illegible]
 PROJECT NO: 100-100000
 RECEIVED BY: [illegible]
 ELECTRICAL BY: 5-31-80
 MECHANICAL BY: [illegible]
 THE PROJECT: [illegible]
 WORK ORDER: [illegible]




OFFICE COPY

[illegible]


90121

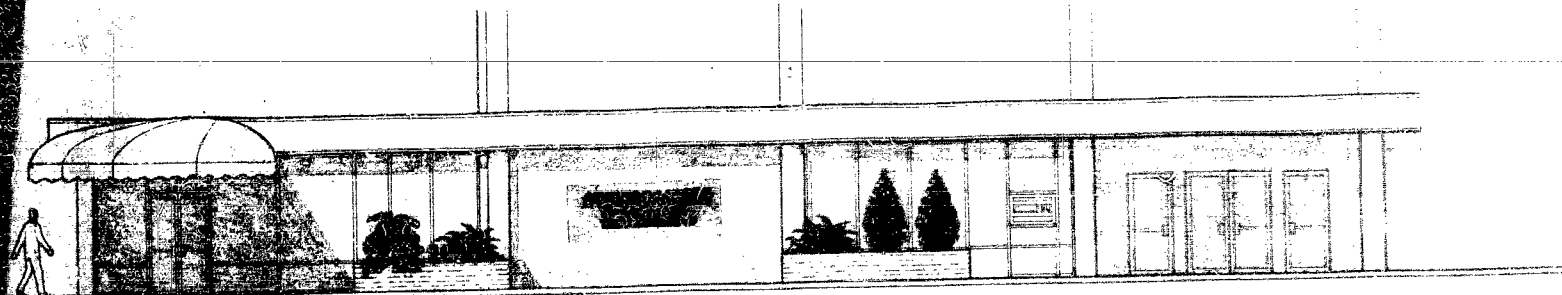


BUILDING FRONT ELEVATION

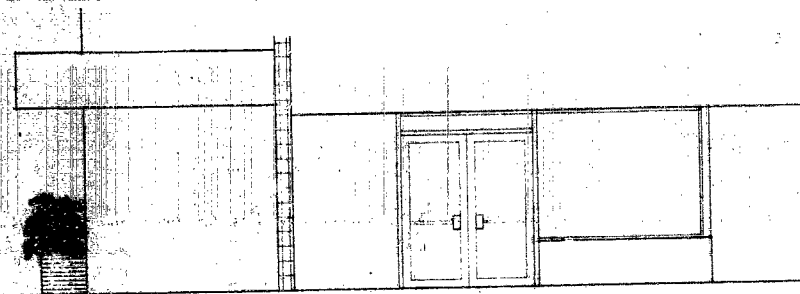

INTERIOR BANK ENTRANCE

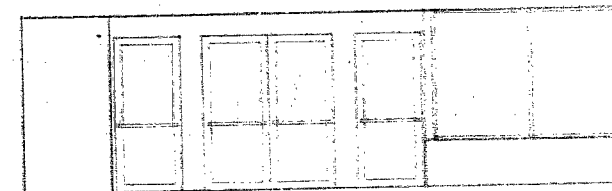

BUILDING MAIN ENTRANCE

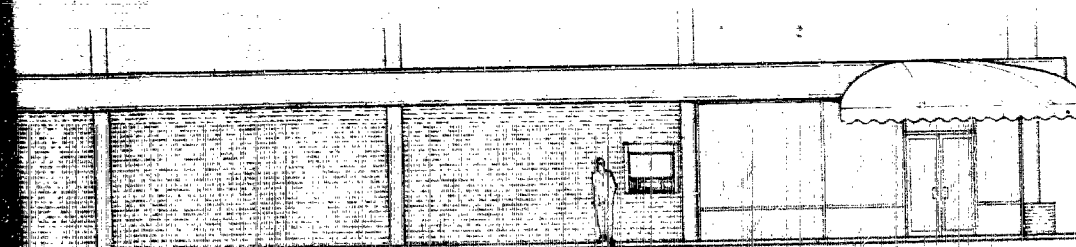

BUILDING LEFT SIDE ELEVATION

RECEIVED
APR 24 1977
MAYOR'S OFFICE OF MIAMI
CITY OF MIAMI BEACH
APPROVED
DATE: 4/20/77
DRAWN BY: [Signature]
CHECKED BY: [Signature]
PLANNED BY: [Signature]
ELECTRICAL BY: [Signature]
MECHANICAL BY: [Signature]
THE PLANNING
FIRM: [Signature]

OFFICE COPY

DATE	4/20/77
PROJECT NO.	7509-2
PROJECT NAME	AMERICAN SAVINGS AND LOAN 4150 STREET BEACH
LOCATION	MIAMI BEACH, FLORIDA
SCALE	1/4" = 1'-0"
BY	[Signature]
CHECKED	[Signature]
DATE	4/20/77

90121

January 17, 2007

City of Miami Beach
Building Department
Miami Beach, Florida

Project Name: Naya Sales Center
333 W 41st St. MBCH

Project Number: B0701152

In response to your Electrical Review Comments, SEi Companies offers the following:

Comment #1 "Show fire alarm devices for the space and the building lease space."

Response: Fire alarm devices here been added. Refer to Sheet E-301.

Comment #2: "Ok show emergency lighting for the exit corridor (in the rear)."

Response: Emergency lighting has been added. Refer to Sheet E-201.

Comment #3: "Ok cannot have electrical panel in rated corridor."

Response: Electrical panel is now located in a dedicated electrical room. Refer to Sheet E-201.

Comment #4: "Check for the early warning thru out proposed space and show fire alarm devices need to provide the candela rating for the strobes."

Response: Refer to Sheet E-201 general note #3. Candela ratings have been added to all fire alarm devices.

Please call with questions or comments.

Sincerely,



Sam Elhaj, PE
SEi Companies

SEi
COMPANIES

2424 WILCREST DRIVE

SUITE 200

HOUSTON

TEXAS


77042-2753

TELEPHONE: 713.785.1311

FAX: 713.785.2556

WWW.SEI-COMPANIES.COM

BOSTON • HOUSTON

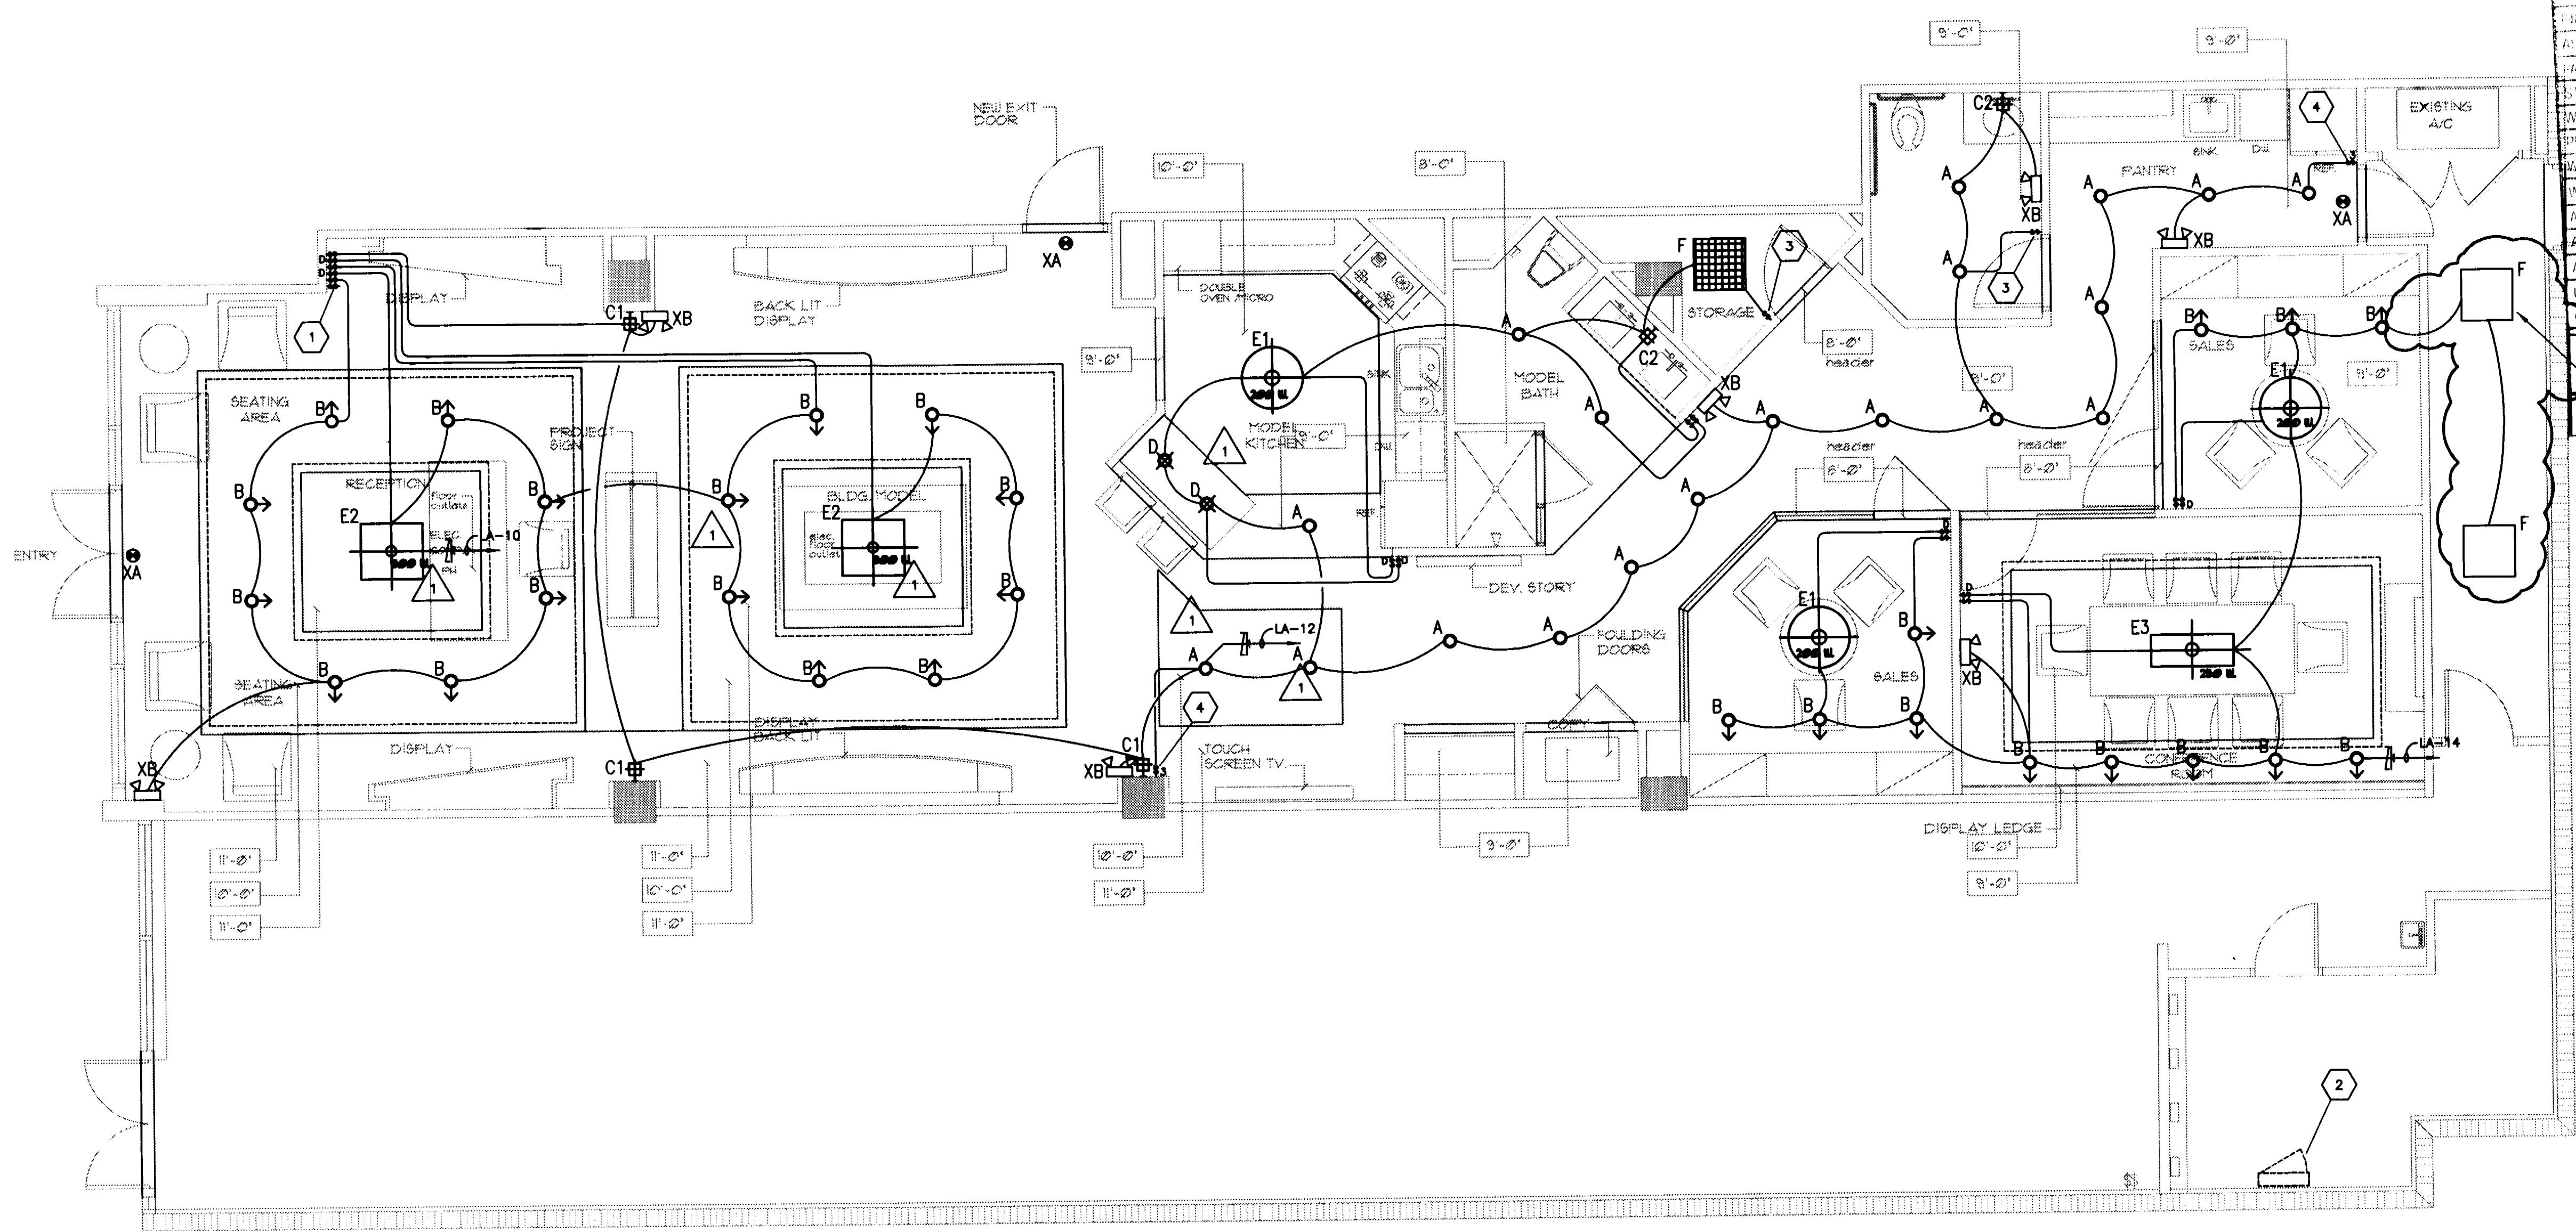

NOTICE: In addition to the requirement of this applicable permit, there may be additional restrictions applicable to this property that may be found in the Public Records of this County and other governmental entities. Permits required for management of the districts, state agencies, or federal agencies.

The City of Miami Beach assumes no responsibility for accuracy of or results from these plans which are approved subject to compliance with all Federal, State, and Local Laws, Rules, and Regulations.

Derm Number: 2007-0306-0952-2006
Contact Name: MS JANETTE SUAREZ
Contact Phone: (305)466-1810
Folio: 02-3222-001-0360
Project Name: CABI SALES CENTER
Date Received: 03/06/2007
Reviewer Name: MIGUEL DE ARMAS

GENERAL NOTES

1. ALL EMERGENCY LIGHT FIXTURES/EXIT SIGNS SHALL BE UNSWITCHED.
2. CIRCUIT EXIT SIGNS TO NEAREST EXISTING 120V EMERGENCY CIRCUIT.

KEYED NOTES

- 1 AUTOMATIC MASTER SWITCH SHALL TURN OFF ALL LIGHTING IN THIS ROOM.
- 2 EXISTING PANEL "LA".
- 3 PROVIDE INFRARED OCCUPANCY SENSOR WITHIN SWITCH. CATALOG # LIRW-277-WH BY LITHONIA OR EQUAL.
- 4 THREEWAY SWITCH TO CONTROL CORRIDOR LIGHTS.

**FULLERTON
DIAZ
ARCHITECTS INC.**
AA COOP
Architecture
Interior Design
Planning
John Fullerton
Julie Diaz
355 Altara Ave.
Coral Gables, FL 33146
Ph: (305) 442-4200
Fax: (305) 444-8962
jfd@architects.com

FULLERTON DIAZ ARCHITECTS INC.

CABI SALES CENTER - 331 W. 41ST STREET

MIAMI BEACH, FLORIDA

OFFICE COPY
CITY OF MIAMI BEACH
APPROVED FOR PERMIT BY
THE FOLLOWING:

BUILDING: _____
ZONING: _____
DRB/TPB: _____
CONCURRENCY: _____
PLUMBING: _____
ELECTRICAL: _____
MECHANICAL: _____
FIRE PREVENTION: _____
ENGINEERING: _____
PUBLIC WORKS: _____
STRUCTURAL: _____
ACCESSIBILITY: _____
ELEVATOR: _____

As per Florida Building Code Section 104.5 ³
 REVIEWED FOR CODE COMPLIANCE

Scale: AS SHOWN
Date: 05-10-08
Project Designer: FDA
Drawn By: FDA
Checked By: FDA
Job Number: 20528 - Cabl
Submittal: DEMOLITION PERMIT
File: _____

Drawing Title:
**LIGHTING
FLOOR PLAN**

Revisions		
No.	Description	Date:
1	ISSUE FOR PERMIT	11/15/06
2	CITY COMMENTS	12/05/06

[illegible]

E-201


 **LIGHTING FLOOR PLAN**
SCALE: 1/4" = 1'-0"

SEi
COMPANIES
2424 WILCREST DR, SUITE 200
HOUSTON, TEXAS 77042-2753
MAIN TELEPHONE: 713.785.1311
FAX: 713.785.2556
WWW.SEICOMPANIES.COM

1. NEW FIRE ALARM SYSTEM TO MATCH EXISTING. RE-USE EXISTING WHERE POSSIBLE.
2. RE-USE ALL THE EXISTING EXIT LIGHTS AND EMERGENCY FROG LIGHTS IF IT'S IN GOOD CONDITION. RELOCATE THEM IF NECESSARY.
3. IF AN EARLY WARNING SYSTEM EXISTS FOR THIS BUILDING, THEN PROVIDE REQUIRED SPEAKERS THROUGHOUT THE SPACE AND CONNECT TO EXISTING SYSTEM.

- 1 DUPLEX RECEPTACLE FOR REFRIGERATOR.
- 2 MICROWAVE.
- 3 OVEN CONTROLS.
- 4 HOOD.
- 5 DISHWASHER.
- 6 DUPLEX RECEPTACLE FOR DISPOSAL.
- 7 J-BOX RECESSED IN WALL BEHIND CABINET FOR UNDER CABINET LIGHTING.
- 8 COPIER.
- 9 PLASMA TV.
- 10 PROVIDE J-BOX AND BRANCH CIRCUITING AS INDICATED FOR BACKLIT DISPLAYS.
- 11 (2)-1" CONDUITS; ONE FOR POWER, AND ONE FOR TELECOM/DATA.
- 12 (1)-1" CONDUIT FOR POWER.
- 13 ELECTRIC WATER HEATER. EWH-1.
- 14 ROUTE CONDUITS IN WALL TO ABOVE CEILING.

- 15 COFFEE MAKER.
- 16 EXISTING PANEL "1A".
- 17 PROVIDE FLUSH FLOOR BOX. HUBBELL OR EQUAL B2422 STAMPED STEEL BOX, S3825 FOR DUBLEX RECEPTACLE & S3826 FOR DATA COVERS. COORDINATE FINISH COVER WITH INTERIOR DESIGN DRAWINGS.
- 18 PROVIDE FLUSH FLOOR BOX. HUBBELL OR EQUAL B2421 STAMPED STEEL BOX, S3825 FOR DUBLEX RECEPTACLE COVER WITH SB3083 CARPET FLANGES.
- 19 CAMERA CONTROLLER
- 20 SECURITY PANEL
- 21 ROUTE WIRE TO RECEIVER IN STORAGE ROOM.
- 22 ROUTE WIRE TO SECURITY PANEL IN A/C ROOM.

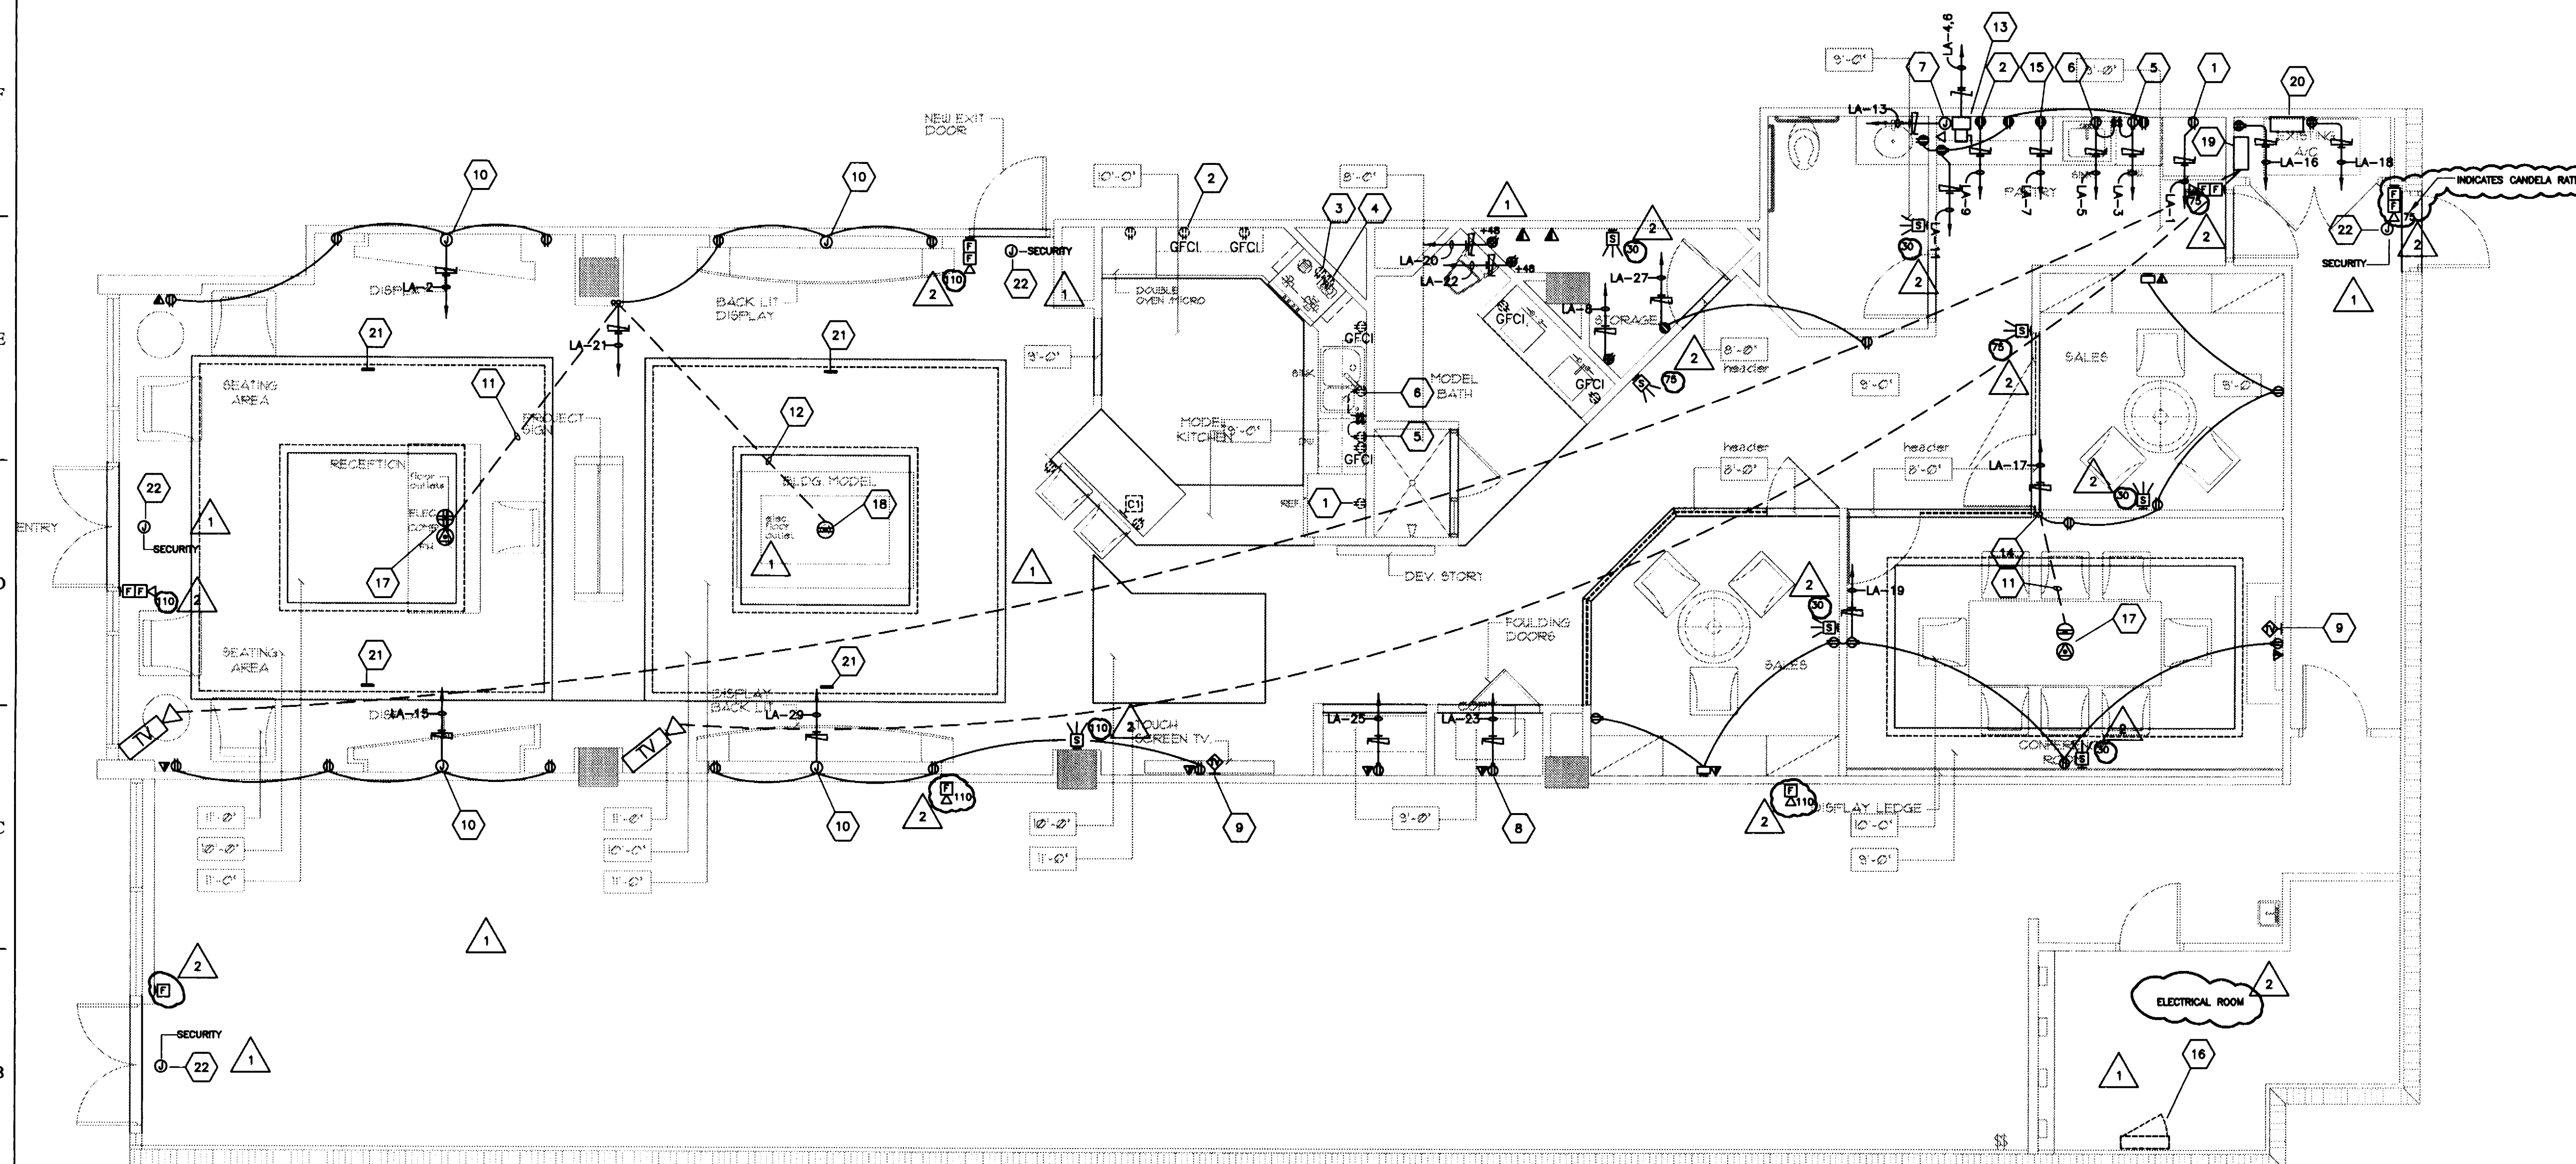

ELECTRICAL FLOOR PLAN

1/17/07

SEi
COMPANIES
2424 WILCREST DR, SUITE 200
HOUSTON, TEXAS 77042-2753
MAIN TELEPHONE: 713.785.1311
FAX: 713.785.2556
WWW.SEICOMPANIES.COM

**FULLERTON
DIAZ
ARCHITECTS INC.**
AA 000087
Architecture
Interior Design
Planning
John Fullerton
Julio Diaz
366 Altara Ave.
Coral Gables, FL 33146
Ph: (305) 442-4200
Fax: (305) 444-6962
fd@fdarchitects.com

FULLERTON DIAZ ARCHITECTS INC.

CABI SALES CENTER - 331 W. 41ST STREET

MIAMI BEACH, FLORIDA

Scale: AS SHOWN
Date: 06-10-06
Project Designer: FOA
Drawn By: FOA
Checked By: FOA
Job Number: 20026 - Cal
Submittal: DEMOLITION PERMIT
File:





Drawing Title:
**ELECTRICAL
FLOOR PLAN**

Revisions		
No.	Description	Date:
1	ISSUE FOR PERMIT	11/15/06
	CITY COMMENTS	12/05/06


[illegible]

Sheet Number

E-301

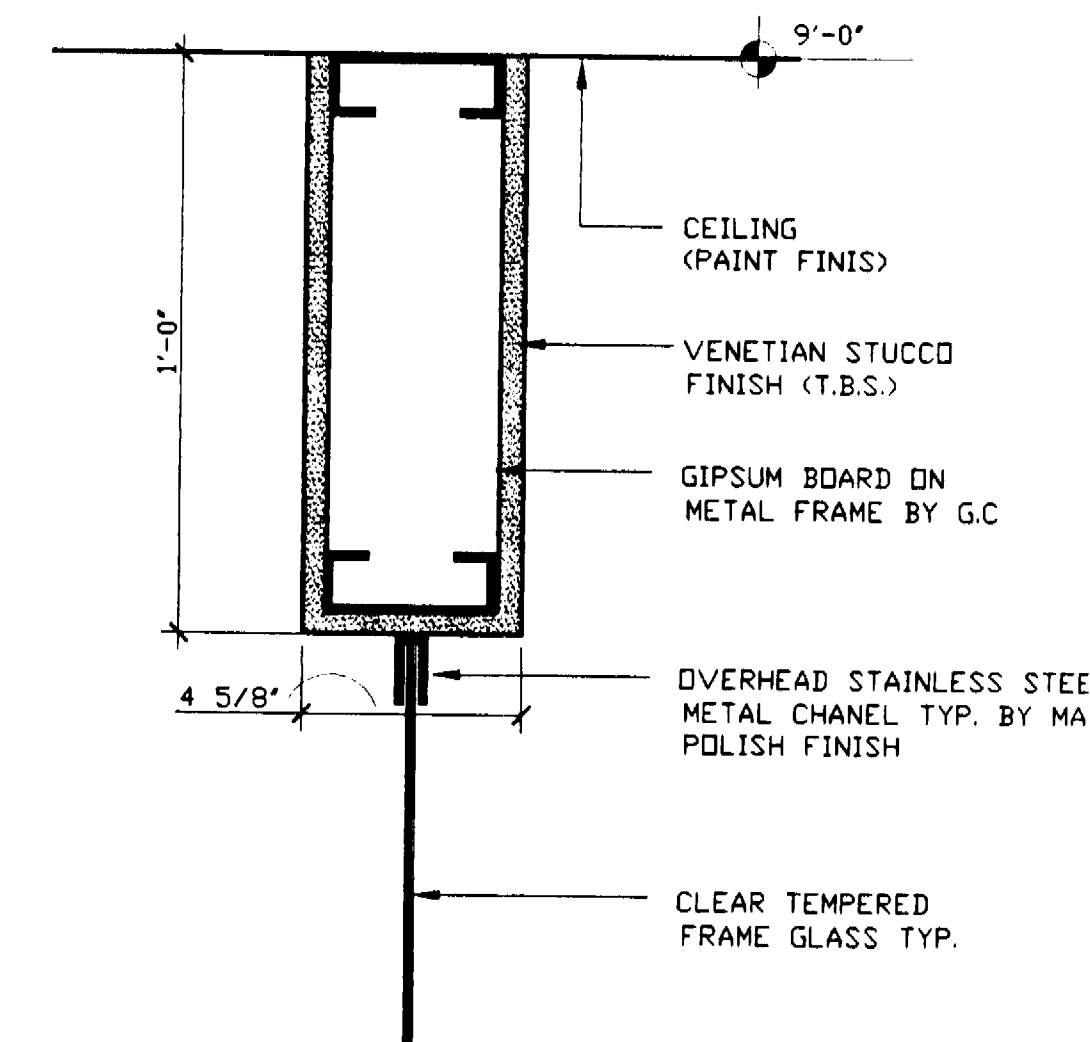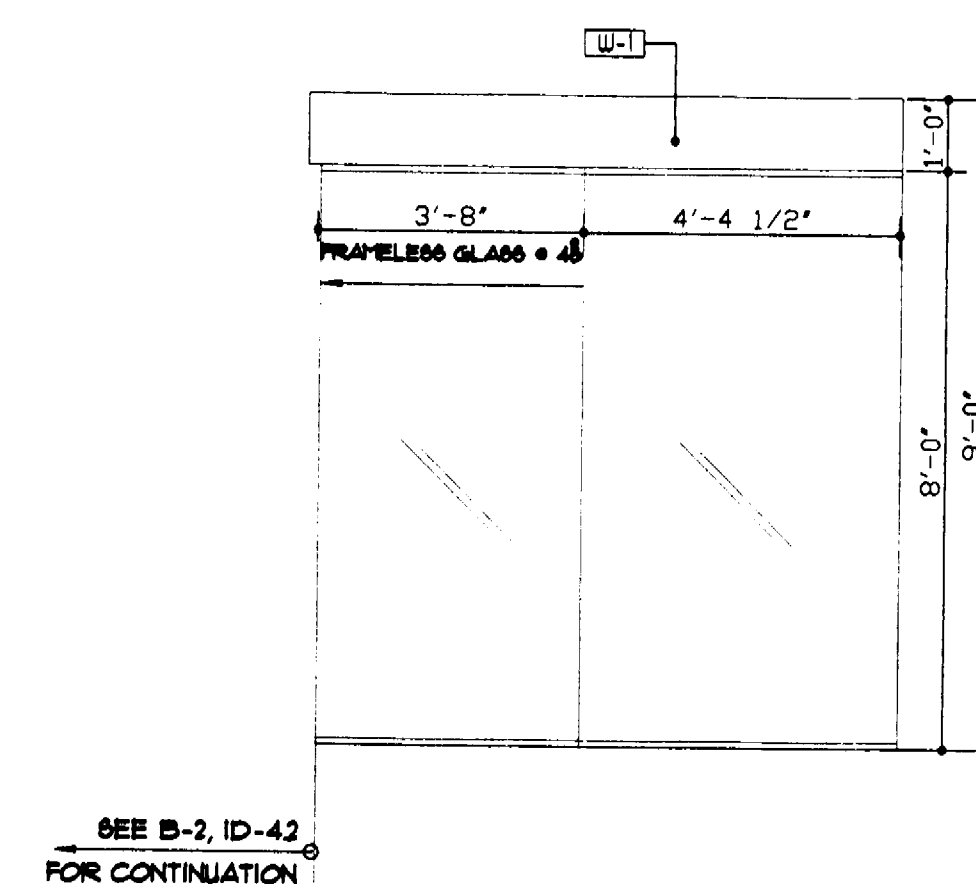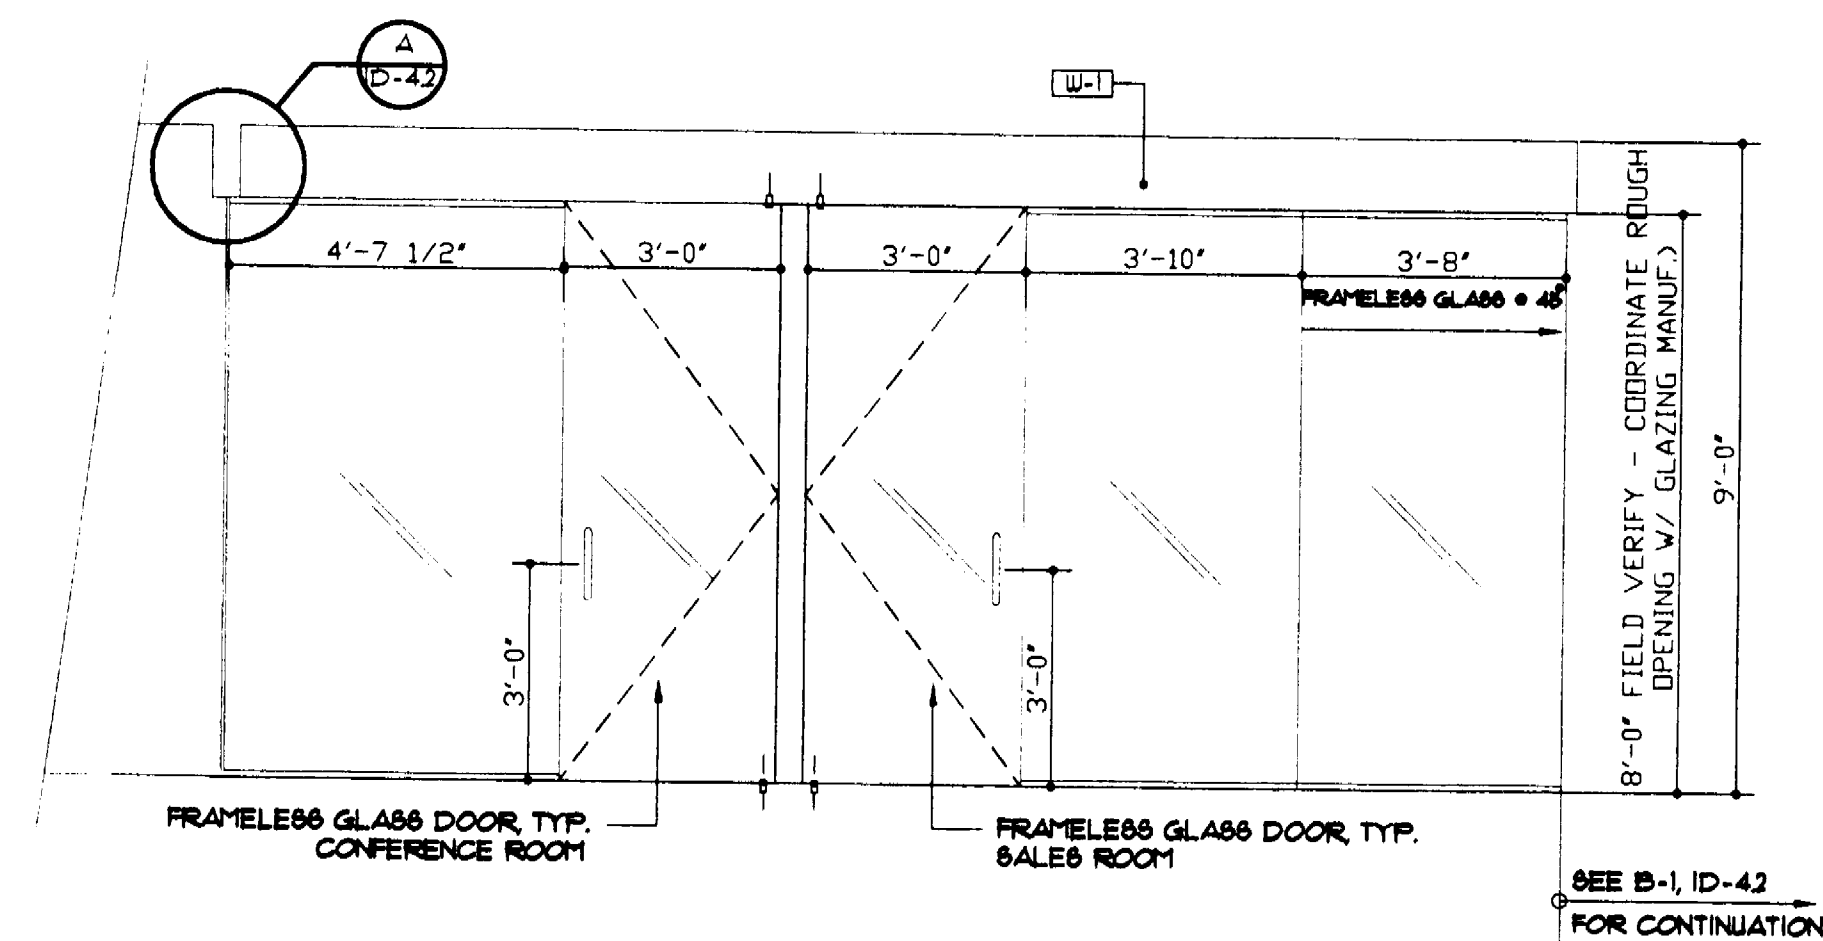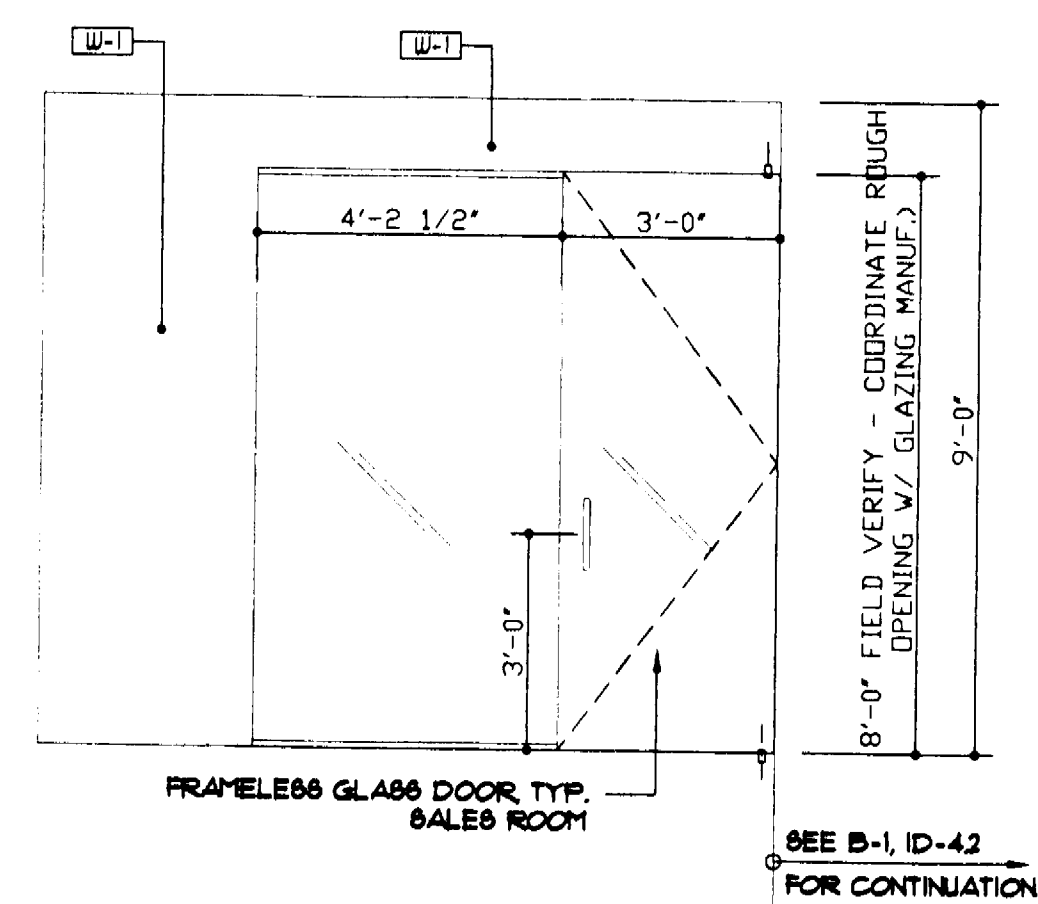

NOTES:

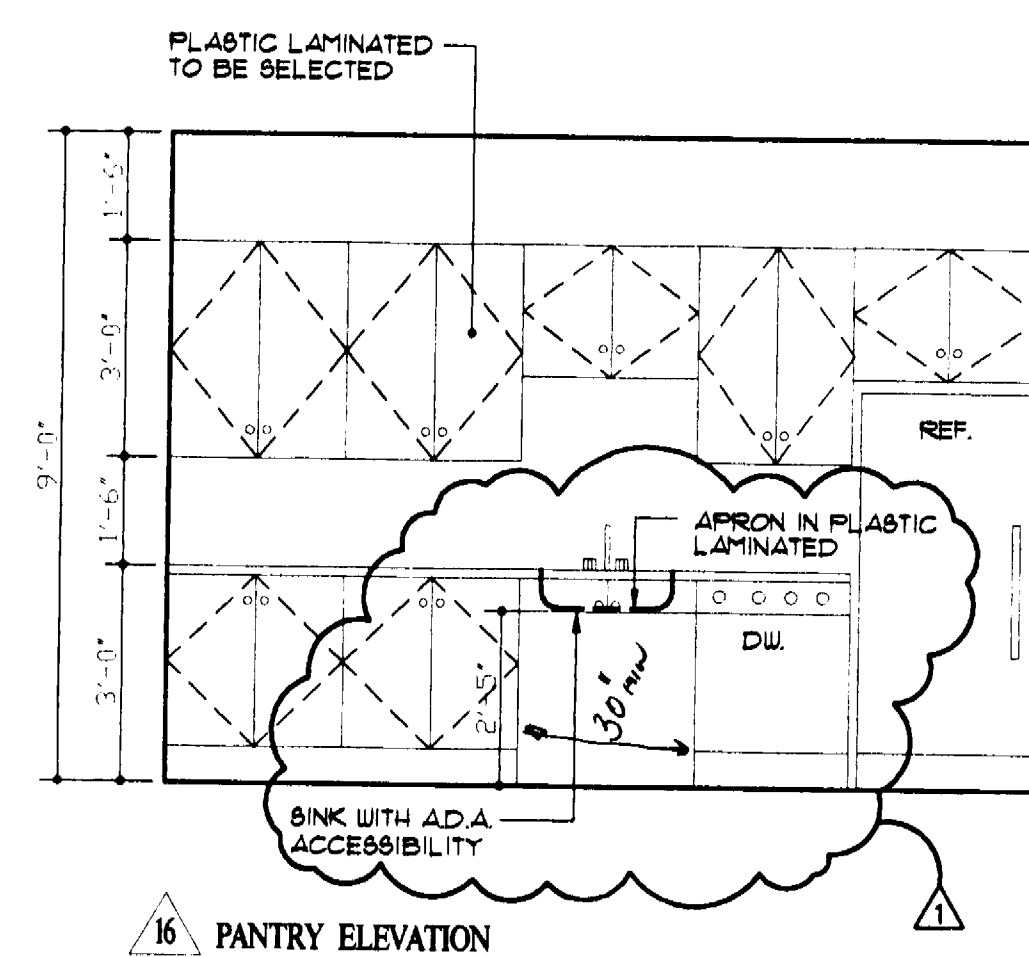

ELEVATIONS