


SEVENTY THIRD ST.

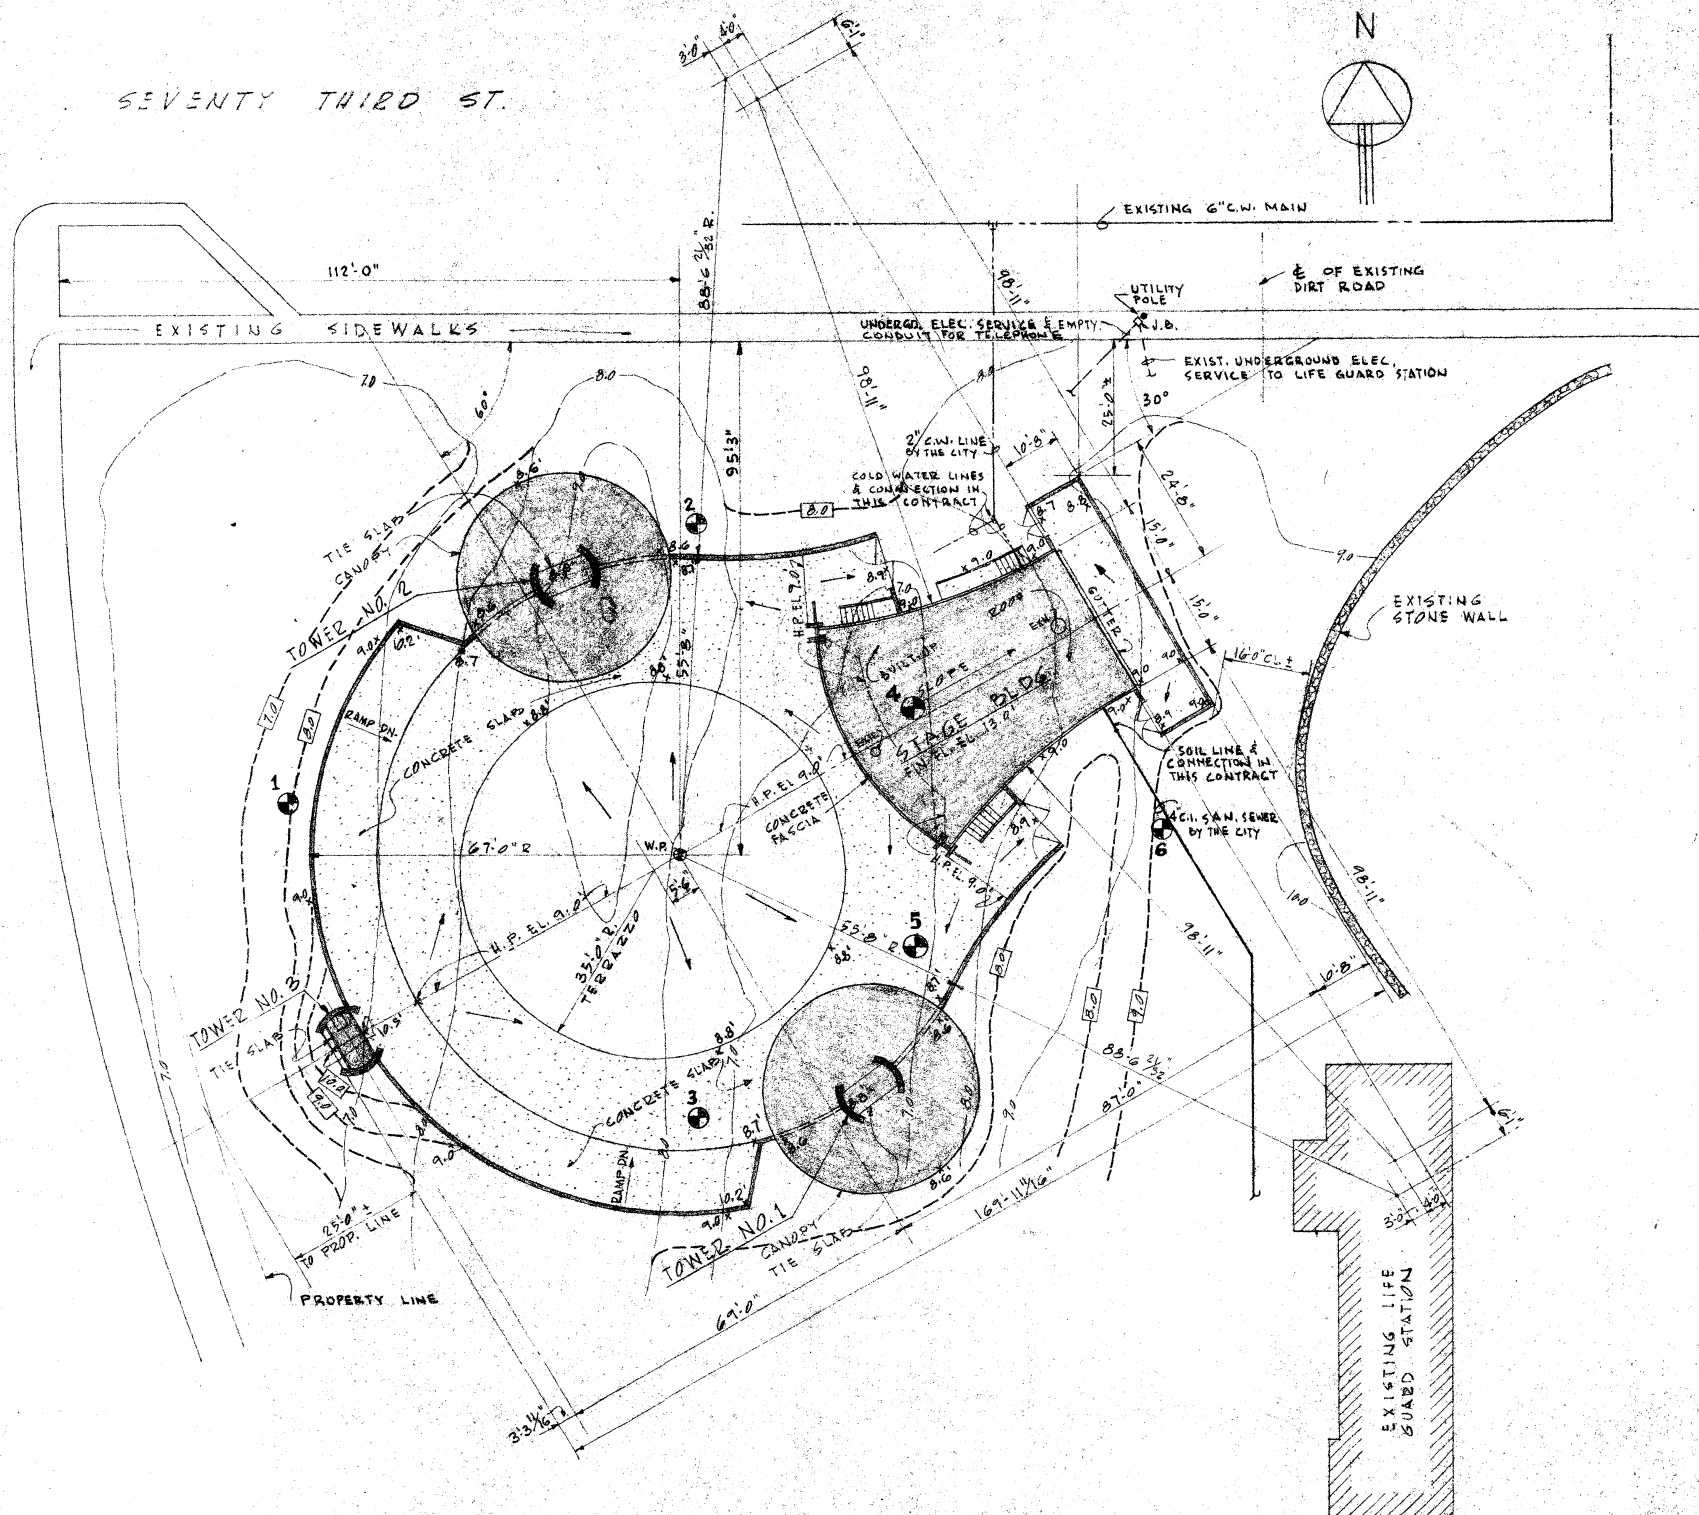

ROOF & PLOT PLAN

SCALE 1/16" = 1'-0"

NOTE: ELEVATION 9.0' = 0.0' REFERENCE ELEVATION
 EXISTING CONTOURS ——— 9.0
 NEW CONTOURS ——— 9.0
 NEW ELEVATIONS ——— 9.0
 TEST BORING LOCATION X 87'

INDEX TO SHEETS

NO.	TITLE
A-1	ROOF & PLOT PLAN, INDEX
A-2	FLOOR PLAN
A-3	ELEVATIONS
A-4	SECTIONS
A-5	WALL SECTIONS
A-6	FLOOR PLAN OF STAGE BLDG., DOOR & FINISH SCHEDULES
A-7	ARCHITECTURAL DETAILS #1
A-8	ARCHITECTURAL DETAILS #2
S-9	FOUNDATION PLAN, DETAILS & SCHEDULES
S-10	FLOOR FRAMING AND PILING DETAILS
S-11	ROOF FRAMING PLAN OF STAGE BUILDING
S-12	CANOPY FRAMING PLAN OF TOWERS 1 & 2
P-13	PLUMBING PLAN & RISER DIAGRAM
E-14	EXTERIOR ELECTRICAL & SOUND LAYOUT; LEGEND
E-15	STAGE ELECTRICAL LAYOUT, PANEL SCHEDULES & RISERS

DESCRIPTION OF SOIL MATERIAL	BORING TEST DATA					
	TEST HOLE NO. 1	TEST HOLE NO. 2	TEST HOLE NO. 3	TEST HOLE NO. 4	TEST HOLE NO. 5	TEST HOLE NO. 6
A	VEGETATION, PEAT SOIL & FINE GRAIN GRAY SAND	VEGETATION, PEAT SOIL & FINE GRAIN GRAY SAND	VEGETATION, PEAT SOIL & FINE GRAIN GRAY SAND	VEGETATION, PEAT SOIL & FINE GRAIN GRAY SAND	VEGETATION, PEAT SOIL & FINE GRAIN GRAY SAND	VEGETATION, PEAT SOIL & FINE GRAIN GRAY SAND
B	FINE GRAIN TAN SAND	FINE GRAIN TAN SAND	FINE GRAIN TAN SAND	FINE GRAIN TAN SAND	FINE GRAIN TAN SAND	FINE GRAIN TAN SAND
C	COURSE GRAIN TAN SAND WITH SHELL FRAGMENTS	COURSE GRAIN TAN SAND WITH SHELL FRAGMENTS	COURSE GRAIN TAN SAND WITH SHELL FRAGMENTS	COURSE GRAIN TAN SAND WITH SHELL FRAGMENTS	COURSE GRAIN TAN SAND WITH SHELL FRAGMENTS	COURSE GRAIN TAN SAND WITH SHELL FRAGMENTS
D	FINE GRAIN GRAY SAND WITH ROCK NODULES	FINE GRAIN GRAY SAND WITH ROCK NODULES	FINE GRAIN GRAY SAND WITH ROCK NODULES	FINE GRAIN GRAY SAND WITH ROCK NODULES	FINE GRAIN GRAY SAND WITH ROCK NODULES	FINE GRAIN GRAY SAND WITH ROCK NODULES
E	PEAT SOIL & VEGETATION	PEAT SOIL & VEGETATION	PEAT SOIL & VEGETATION	PEAT SOIL & VEGETATION	PEAT SOIL & VEGETATION	PEAT SOIL & VEGETATION
F	FINE TO MEDIUM GRAIN TAN SAND	FINE TO MEDIUM GRAIN TAN SAND	FINE TO MEDIUM GRAIN TAN SAND	FINE TO MEDIUM GRAIN TAN SAND	FINE TO MEDIUM GRAIN TAN SAND	FINE TO MEDIUM GRAIN TAN SAND
G	FINE TO MEDIUM GRAIN GRAY SAND WITH ROCK NODULES	FINE TO MEDIUM GRAIN GRAY SAND WITH ROCK NODULES	FINE TO MEDIUM GRAIN GRAY SAND WITH ROCK NODULES	FINE TO MEDIUM GRAIN GRAY SAND WITH ROCK NODULES	FINE TO MEDIUM GRAIN GRAY SAND WITH ROCK NODULES	FINE TO MEDIUM GRAIN GRAY SAND WITH ROCK NODULES
H	FINE GRAIN GRAY SAND	FINE GRAIN GRAY SAND	FINE GRAIN GRAY SAND	FINE GRAIN GRAY SAND	FINE GRAIN GRAY SAND	FINE GRAIN GRAY SAND
J	MEDIUM GRAIN TAN BEACH SAND	MEDIUM GRAIN TAN BEACH SAND	MEDIUM GRAIN TAN BEACH SAND	MEDIUM GRAIN TAN BEACH SAND	MEDIUM GRAIN TAN BEACH SAND	MEDIUM GRAIN TAN BEACH SAND
K	FINE GRAIN TAN SAND WITH SHELL FRAGMENTS	FINE GRAIN TAN SAND WITH SHELL FRAGMENTS	FINE GRAIN TAN SAND WITH SHELL FRAGMENTS	FINE GRAIN TAN SAND WITH SHELL FRAGMENTS	FINE GRAIN TAN SAND WITH SHELL FRAGMENTS	FINE GRAIN TAN SAND WITH SHELL FRAGMENTS
L	FINE GRAIN GRAY SAND WITH SHELL FRAGMENTS & ROCK NODULES	FINE GRAIN GRAY SAND WITH SHELL FRAGMENTS & ROCK NODULES	FINE GRAIN GRAY SAND WITH SHELL FRAGMENTS & ROCK NODULES	FINE GRAIN GRAY SAND WITH SHELL FRAGMENTS & ROCK NODULES	FINE GRAIN GRAY SAND WITH SHELL FRAGMENTS & ROCK NODULES	FINE GRAIN GRAY SAND WITH SHELL FRAGMENTS & ROCK NODULES
M	MEDIUM TO COURSE GRAIN GRAY SAND WITH SHELL FRAGMENTS	MEDIUM TO COURSE GRAIN GRAY SAND WITH SHELL FRAGMENTS	MEDIUM TO COURSE GRAIN GRAY SAND WITH SHELL FRAGMENTS	MEDIUM TO COURSE GRAIN GRAY SAND WITH SHELL FRAGMENTS	MEDIUM TO COURSE GRAIN GRAY SAND WITH SHELL FRAGMENTS	MEDIUM TO COURSE GRAIN GRAY SAND WITH SHELL FRAGMENTS
N	VERY DENSE FINE GRAIN GRAY SAND	VERY DENSE FINE GRAIN GRAY SAND	VERY DENSE FINE GRAIN GRAY SAND	VERY DENSE FINE GRAIN GRAY SAND	VERY DENSE FINE GRAIN GRAY SAND	VERY DENSE FINE GRAIN GRAY SAND

DENOTES GROUND WATER DEPTH BELOW GROUND ELEVATION

JUL 3 1961

norman m. giller & associates
 ARCHITECTS - ENGINEERS
 975 ARTHUR GODFREY ROAD MIAMI BEACH, FLA.

NORTH SHORE COMMUNITY CENTER
 FOR
 CITY OF MIAMI BEACH
 NORTH SHORE PARK, MIAMI BEACH, FLA.





ROOF & PLOT PLAN INDEX

COMM. NO. DATE AREA DRAWN I.S. SHEET NO.
 61105 6-23-1961

DATE NO. ISSUED TO
 PRINTING RECORD
 APPROVED TOTAL SHEETS 15

THESE PLANS ARE THE PROPERTY OF THE ARCHITECT AND CANNOT BE REPRODUCED IN PART OR IN WHOLE WITHOUT WRITTEN PERMISSION OF THE ARCHITECT

BG-61K


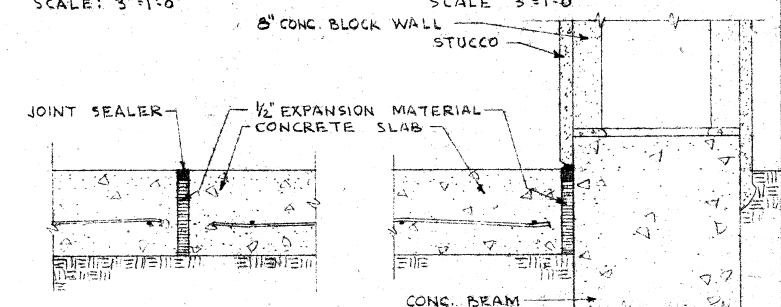
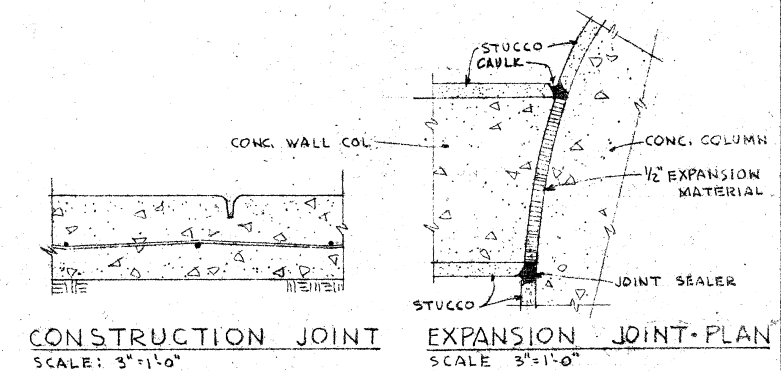
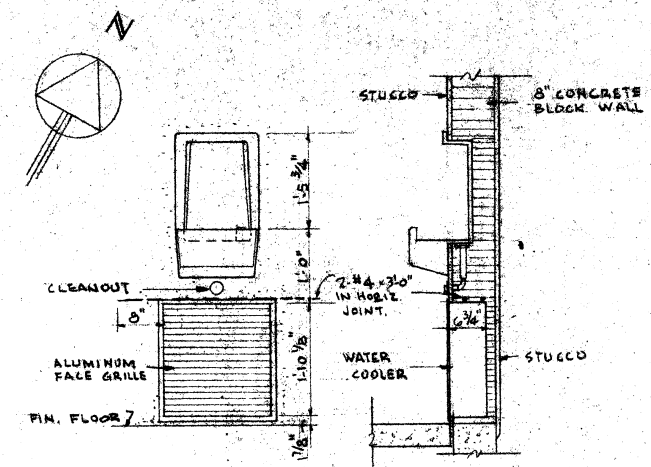
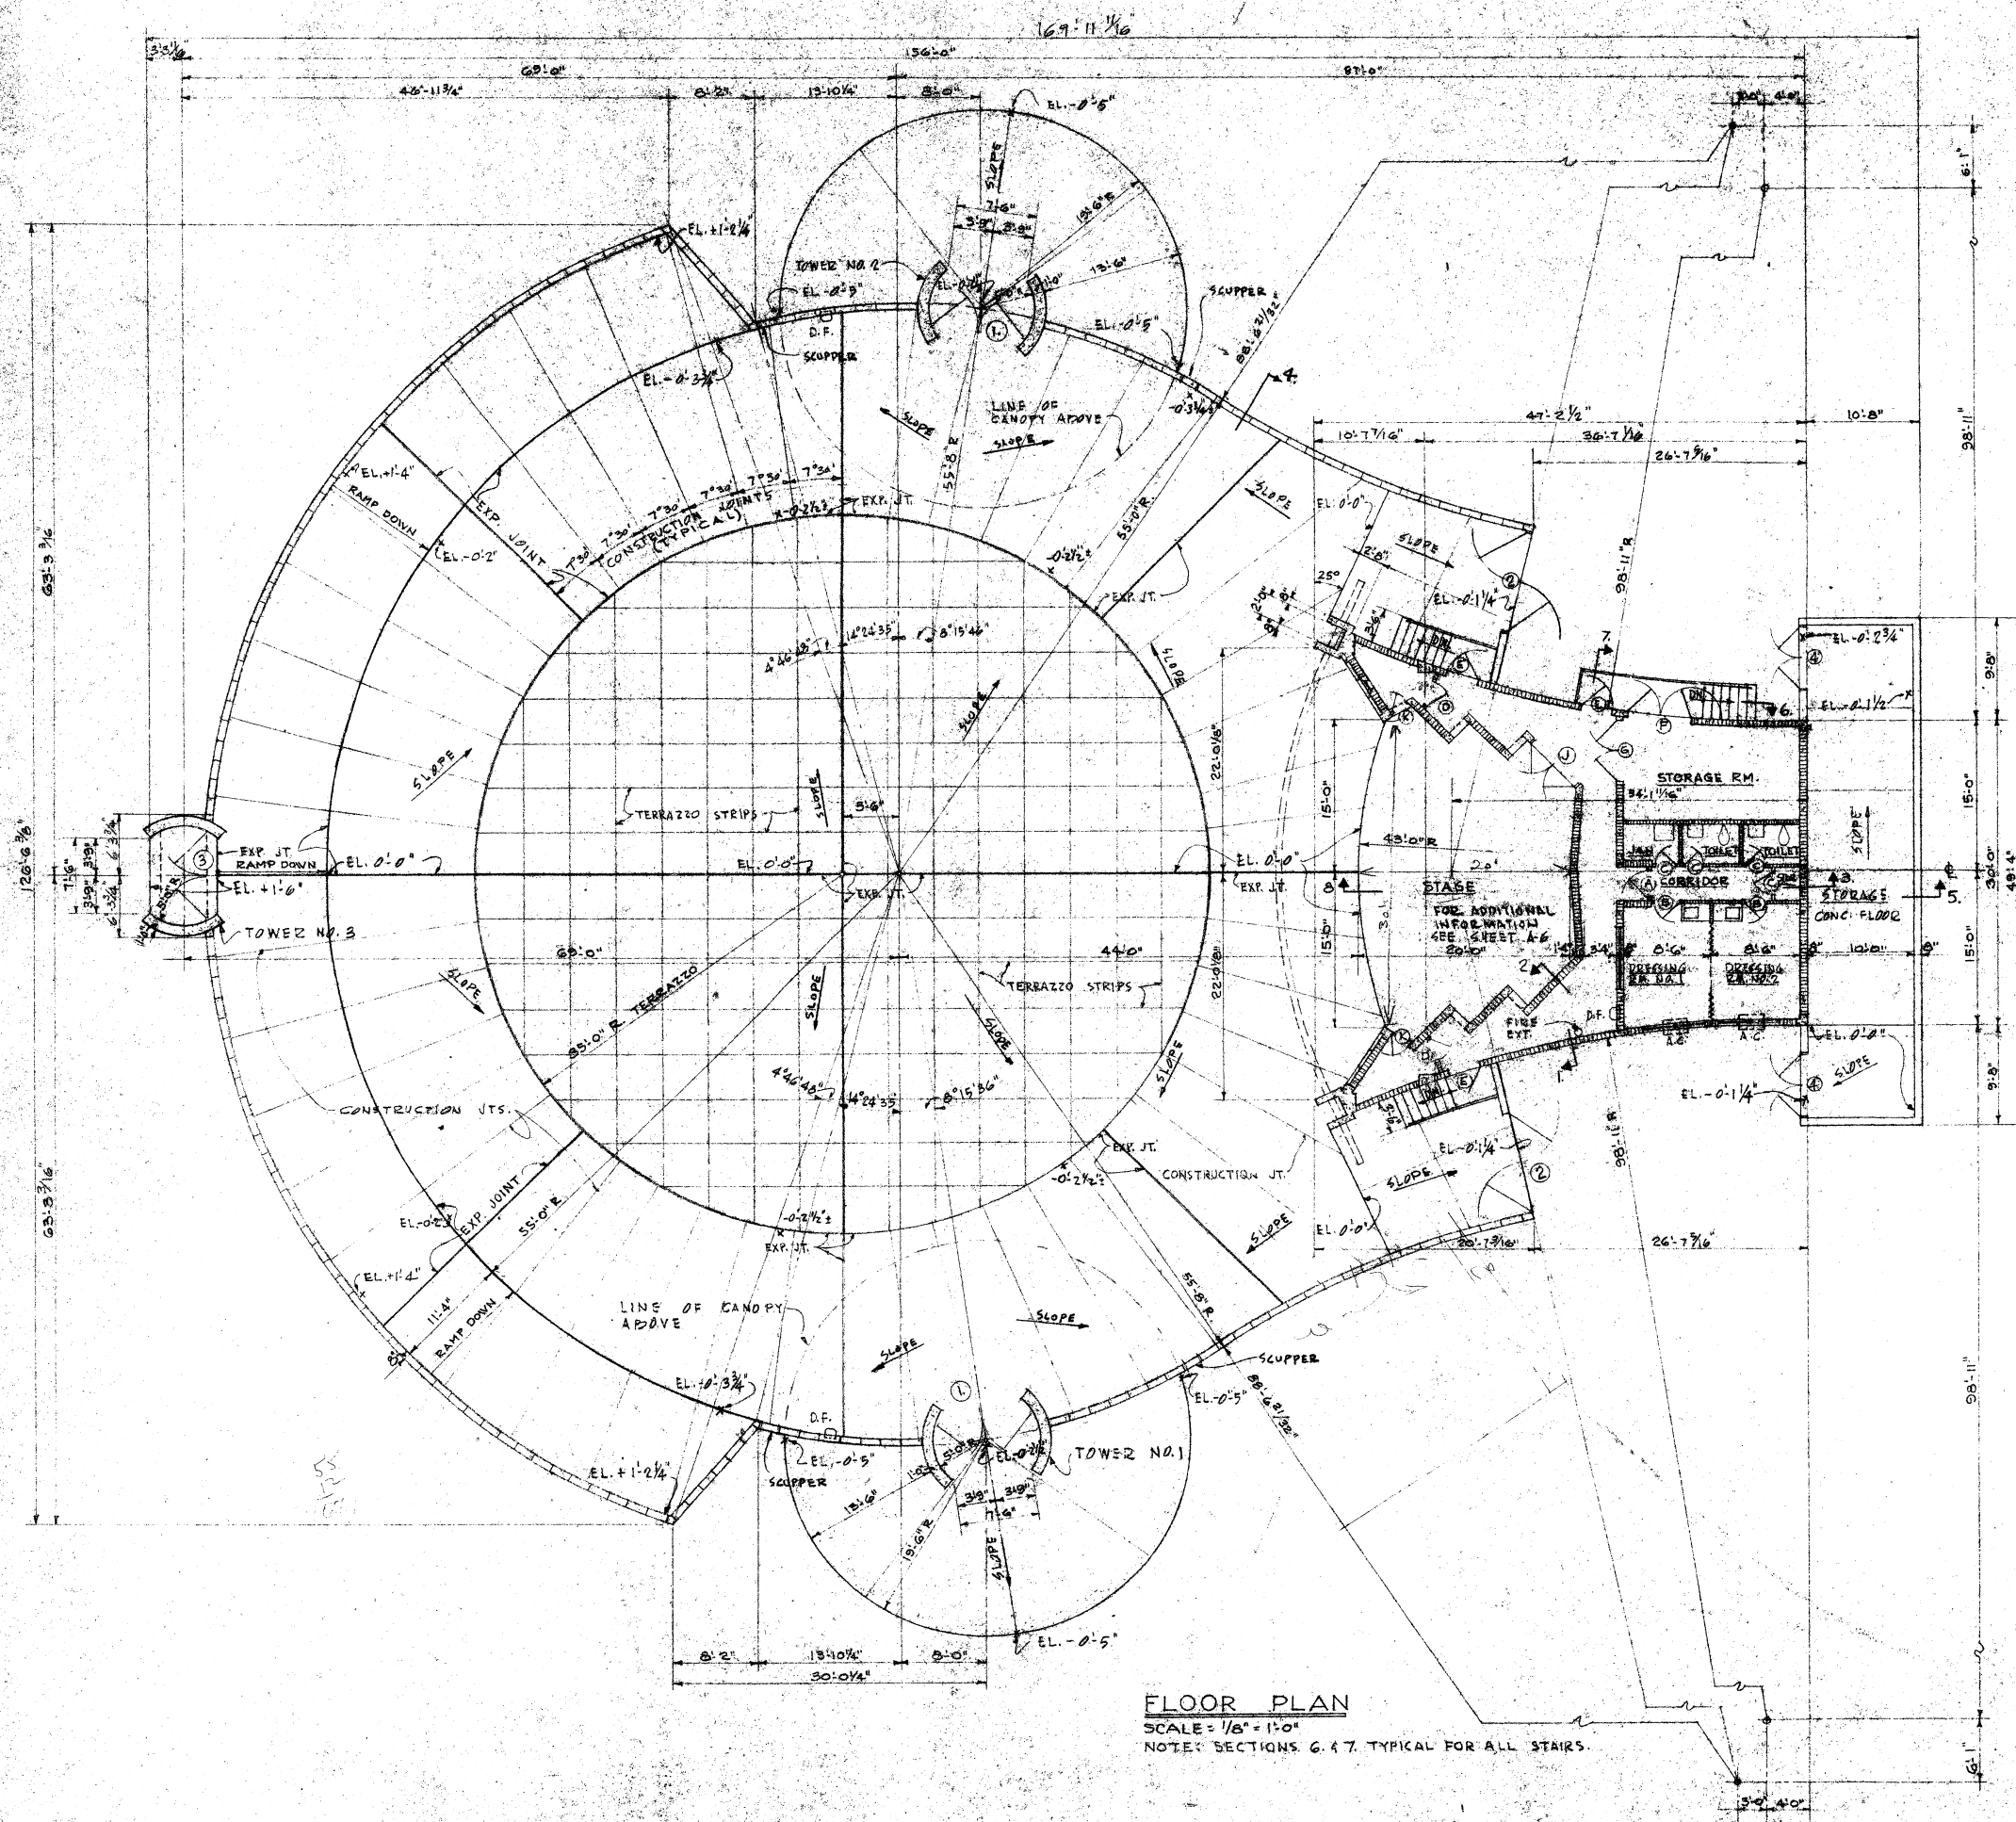


REFERENCES:

FOR DETAILS OF GATES NO. 1, 2, & 3 SEE SHEET A-7
FOR DETAILS OF GATE NO. 4 SEE SHEET A-4
FOR DOOR SCHEDULE & FINISH SCHEDULE
SEE SHEET NO. A-6

JUL 3 1961

[illegible]

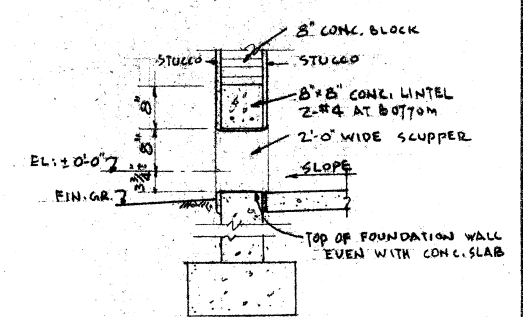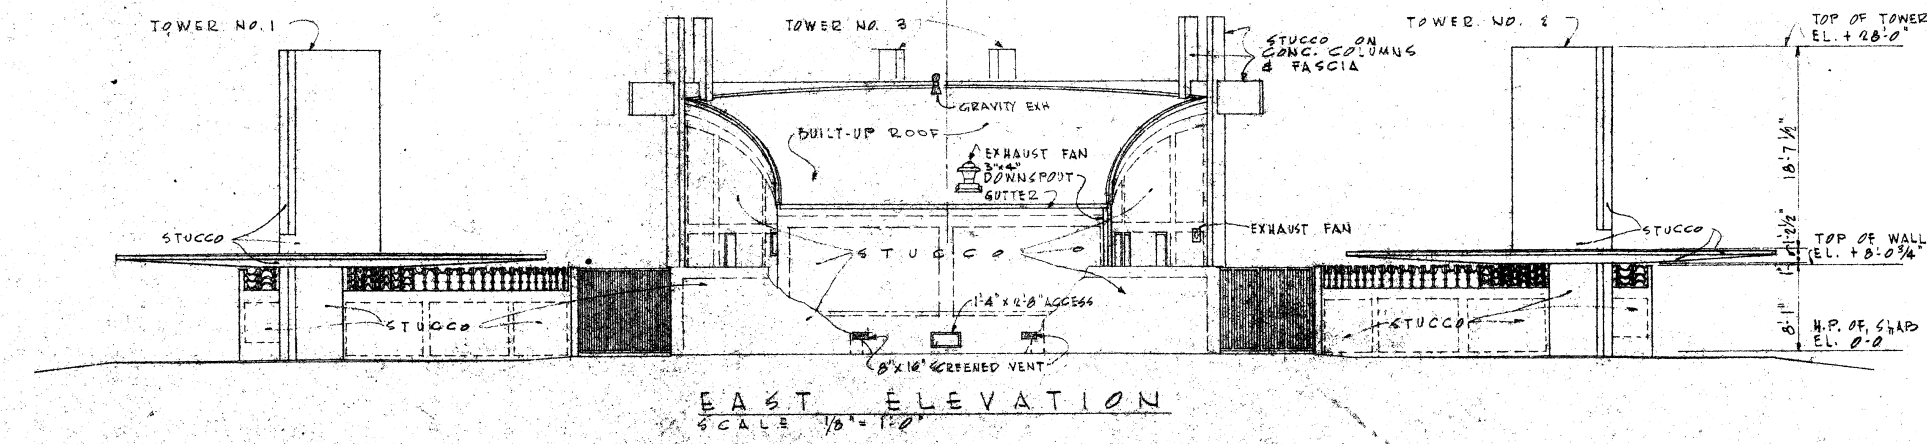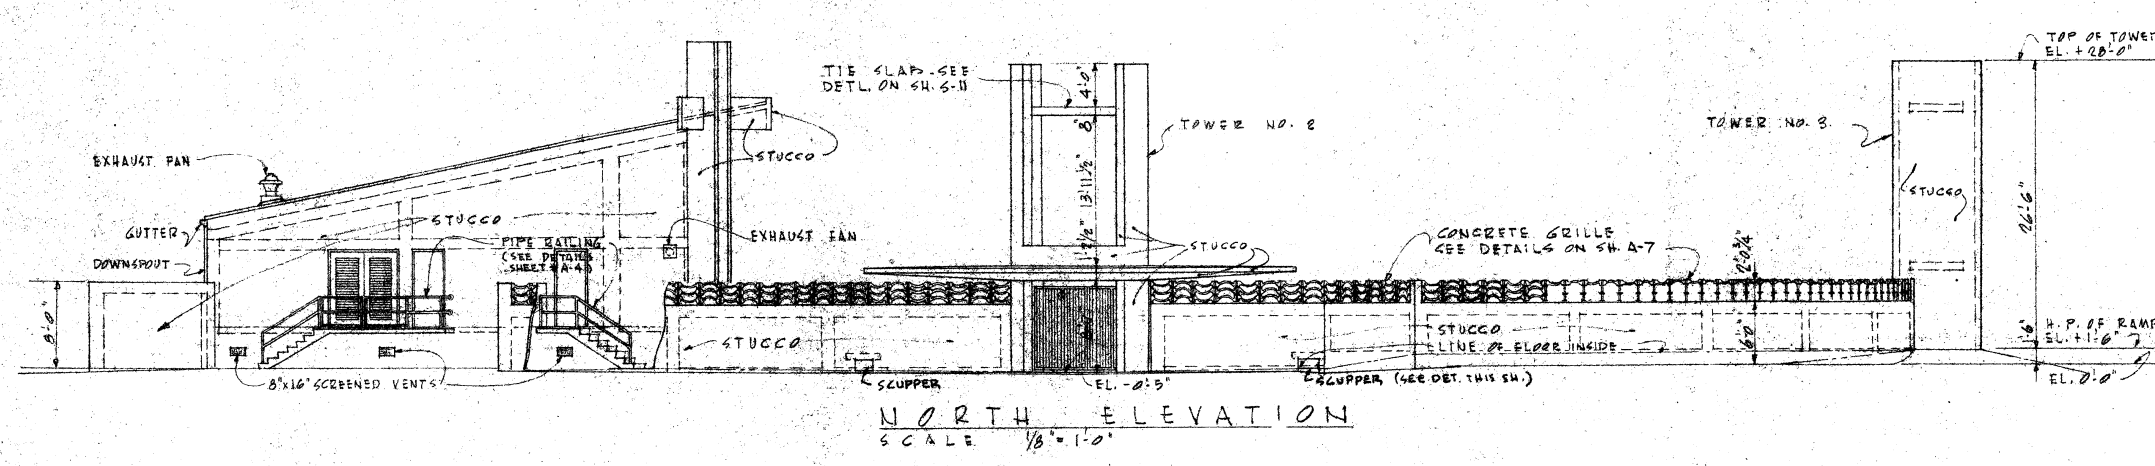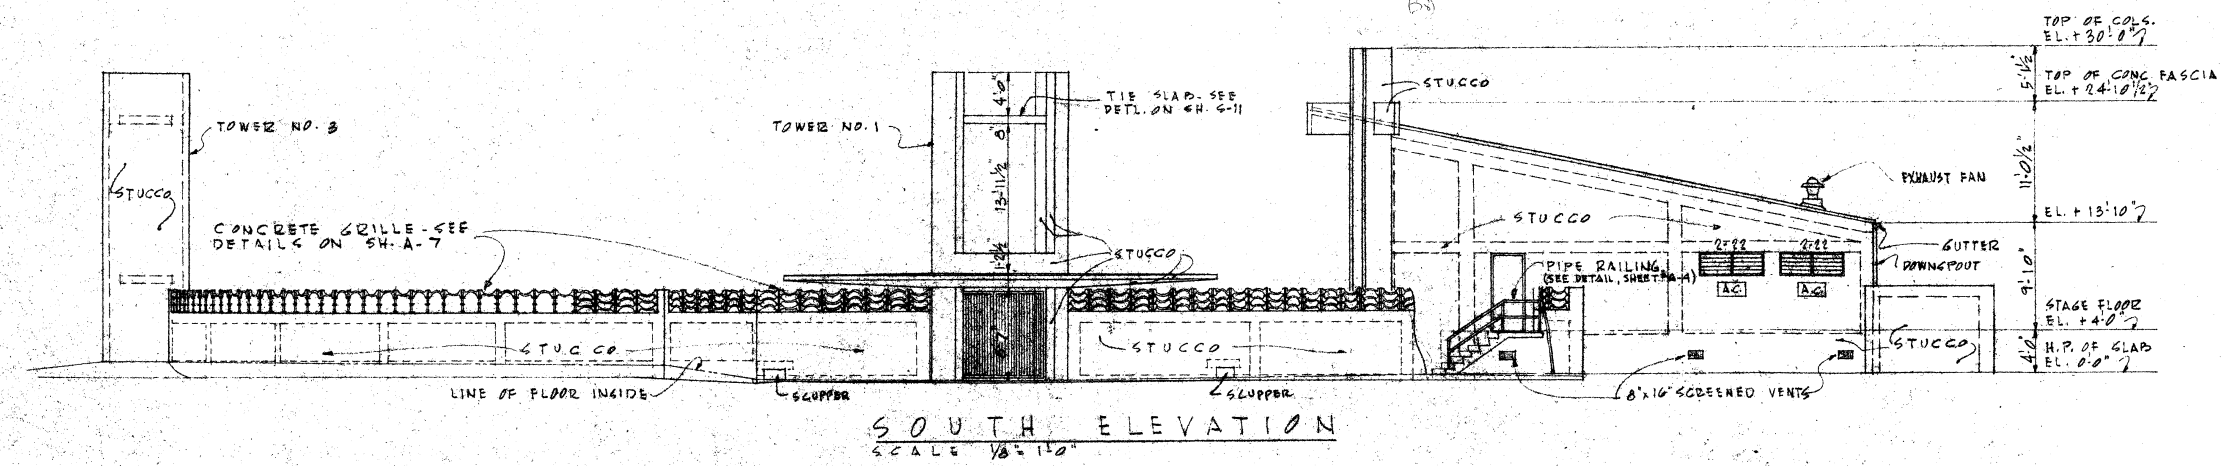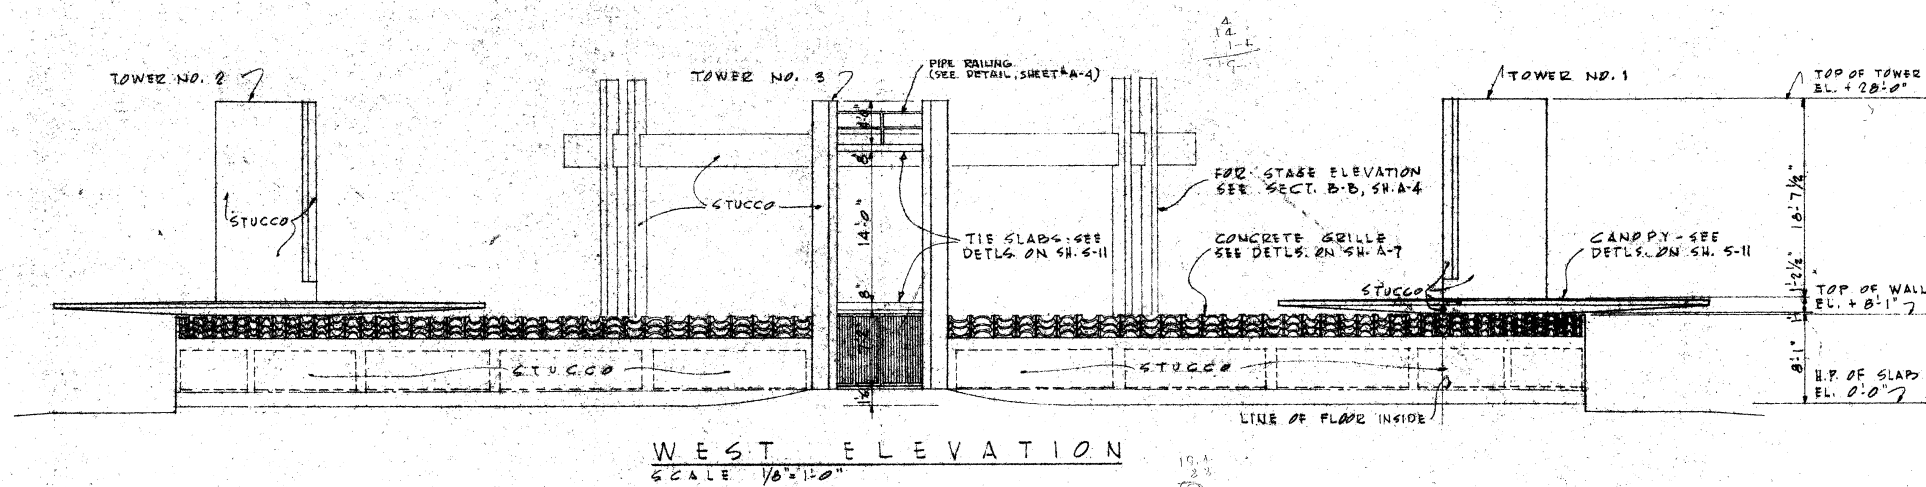


JUL 3 1961


NO.	DATE	DESCRIPTION	BY
1			
2			
3			
4			
5			
6			
7			
8			
9			
10			
11			
12			
13			
14			
15			

norman m. giller & associates ARCHITECTS - ENGINEERS 975 ARTHUR GODFREY ROAD MIAMI BEACH, FLA.			
ELEVATIONS		NORTH SHORE COMMUNITY CENTER MIAMI BEACH, FLORIDA.	
COMM. NO. 61105	DATE 6-23-1961	DRAWN I.E. CHECKED APPROVED	SHEET NO. A-3 TOTAL SHEETS 15
PRINTING RECORD			
THESE PLANS ARE THE PROPERTY OF THE ARCHITECT AND CANNOT BE REPRODUCED IN PART OR IN WHOLE WITHOUT WRITTEN PERMISSION OF THE ARCHITECT.			


BG-61K

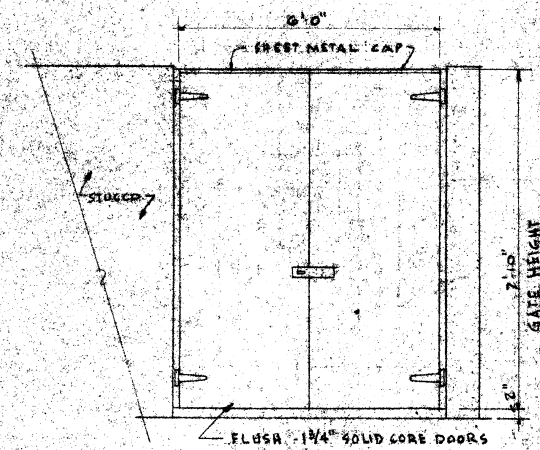


EXTERIOR ELEVATION GATE ④
SCALE: 1/2" = 1'-0"

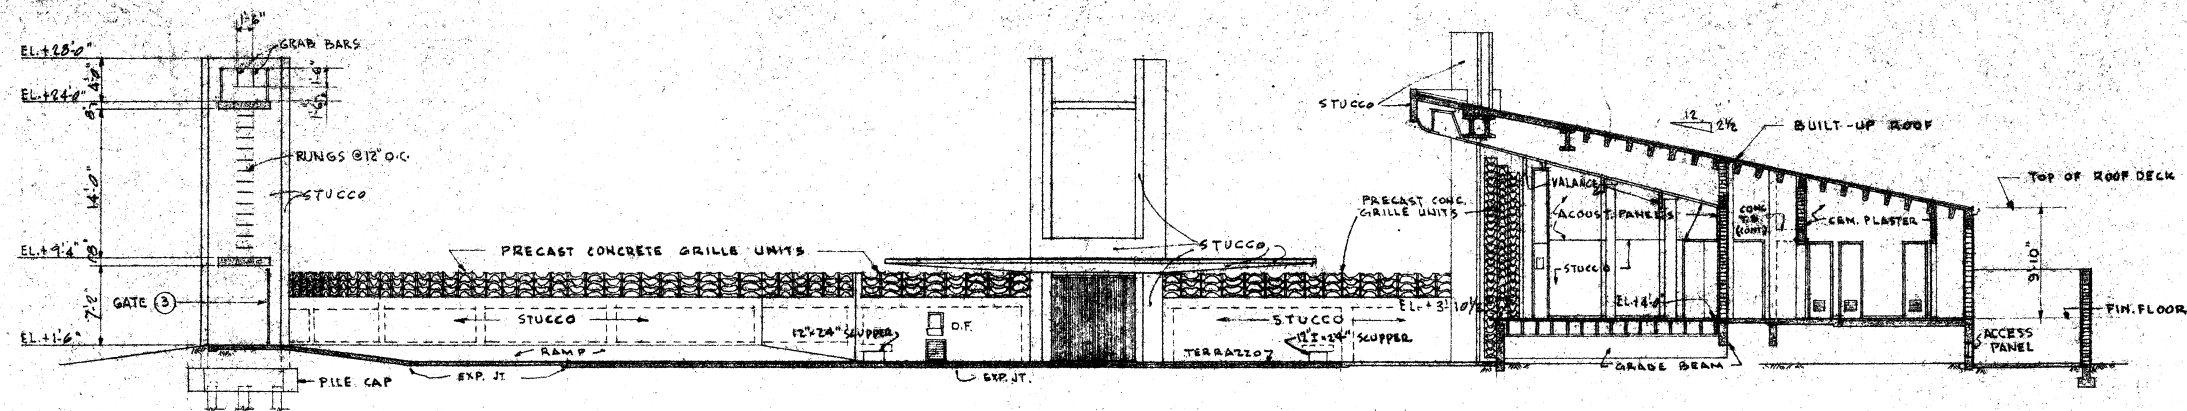


SECTION A-A
SCALE: 1/8" = 1'-0"

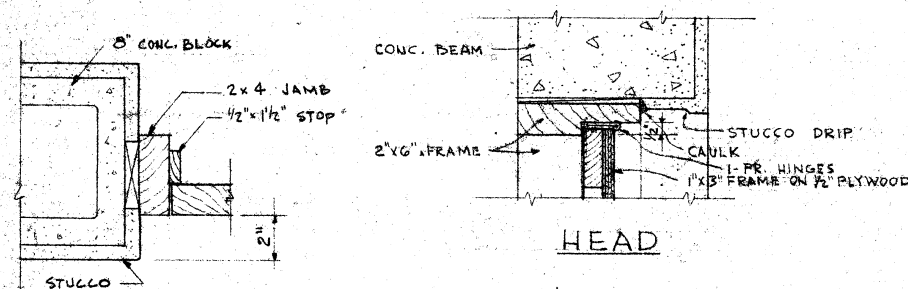


JAMB DETAIL GATE ④
SCALE: 3"=1'-0"

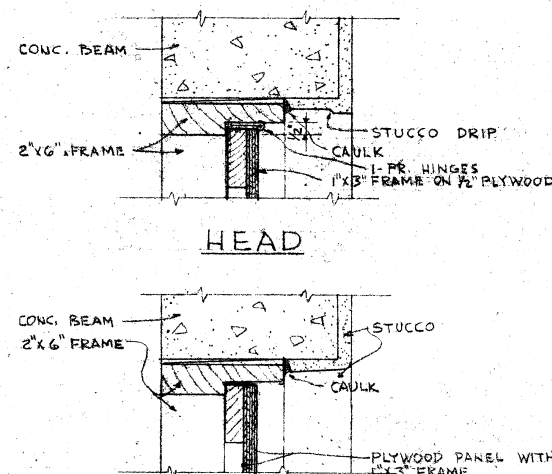


HEAD

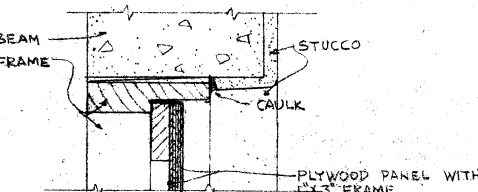


JAMB

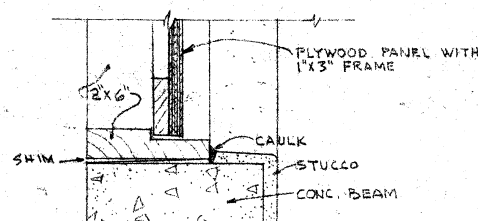


SILL
ACCESS PANEL DETAIL

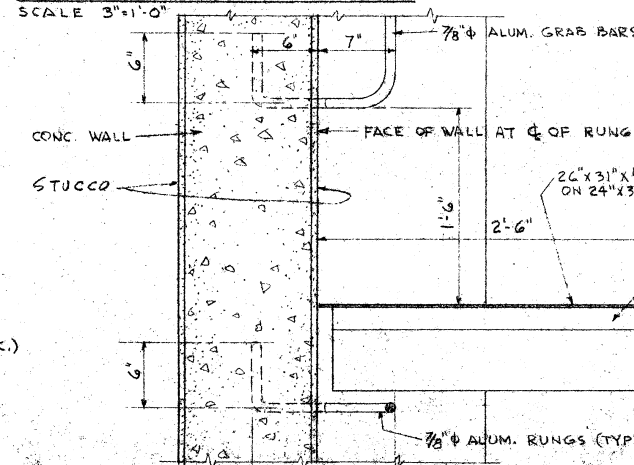


ACCESS PANEL DETAIL
SCALE 3"=1'-0"

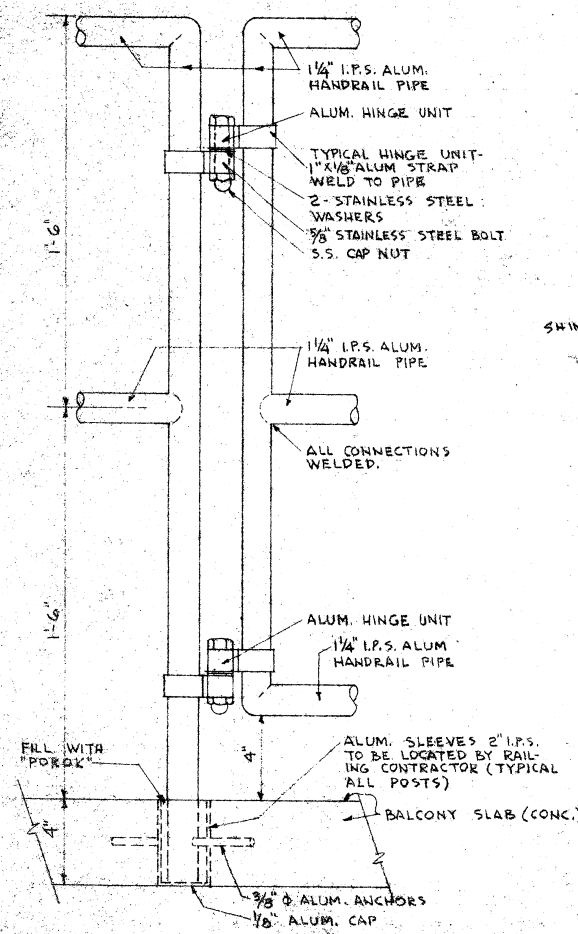


RAILING DETAIL
SCALE 3"=1'-0"

 


SECTION THRU ACCESS OVER GATE (3)
SCALE: $1\frac{1}{2}'' = 1'-0''$

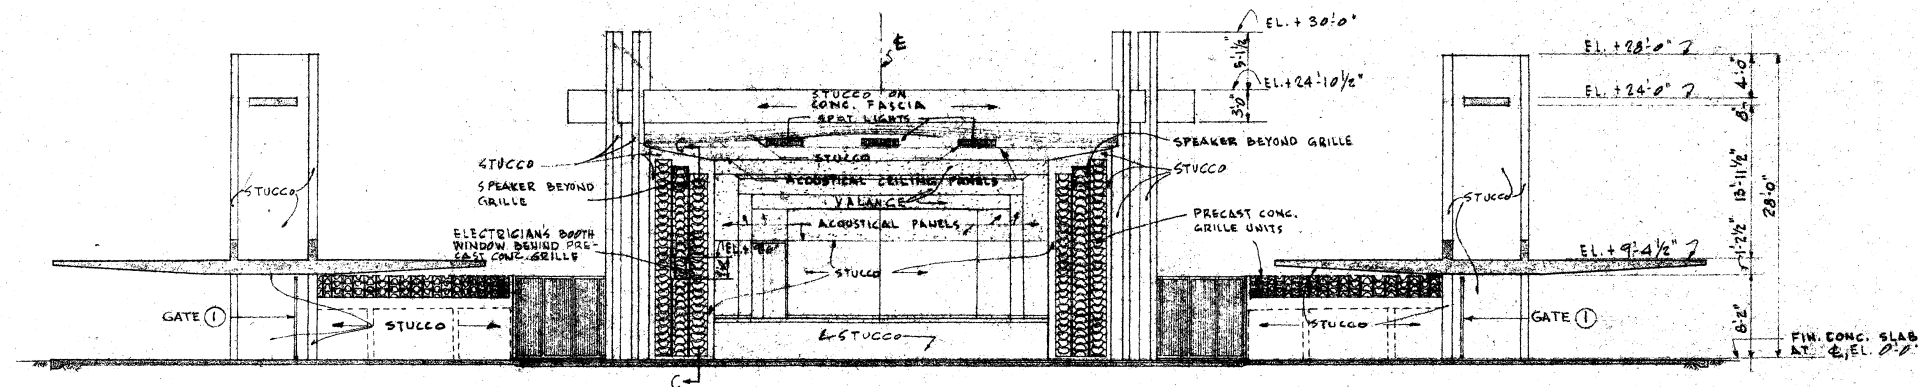


SECTION B-B
SCALE: $1/8" = 1'-0"$

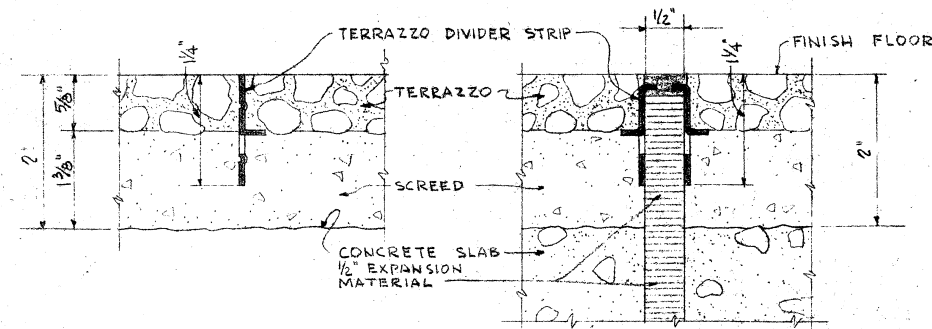


FULL SIZE TERRAZZO STRIPPING DETAILS

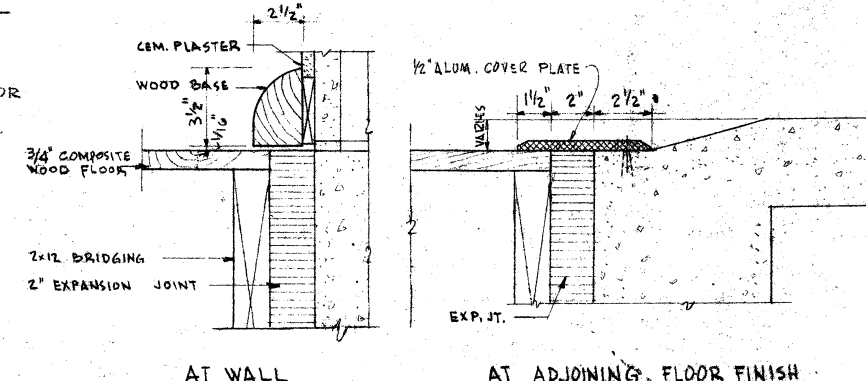

STAGE FLOOR DETAILS
SCALE: 3"=1'-0"

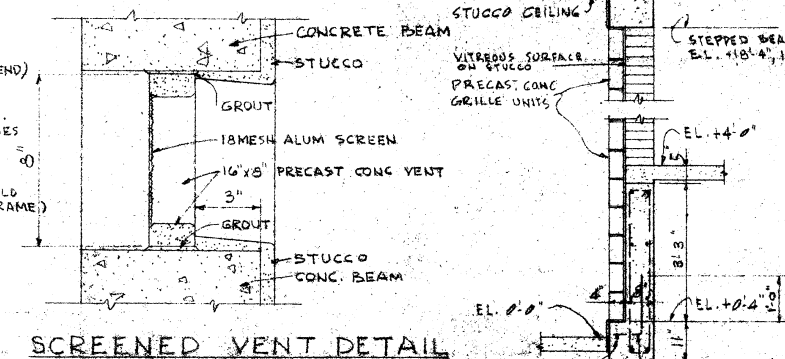

SCREENED VENT DETAIL
SCALE 3"=1'-0"





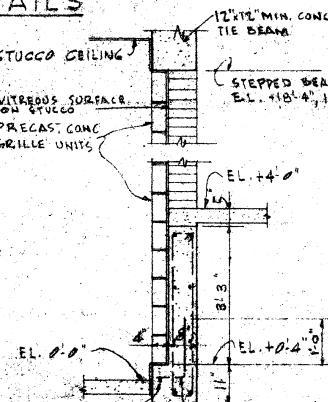


SECTION C-C
SCALE 1/2" = 1'-0"



[illegible]

JUL 3 1961

     BG-61K



STAIR SECTIONS
SCALE : $3/4" = 1'-0"$

  


REFERENCES:
FOR STRUCTURAL DETAILS SEE SHEETS
S-9, S-10 & S-11



JUL 3 1961

[illegible]


BG-6K

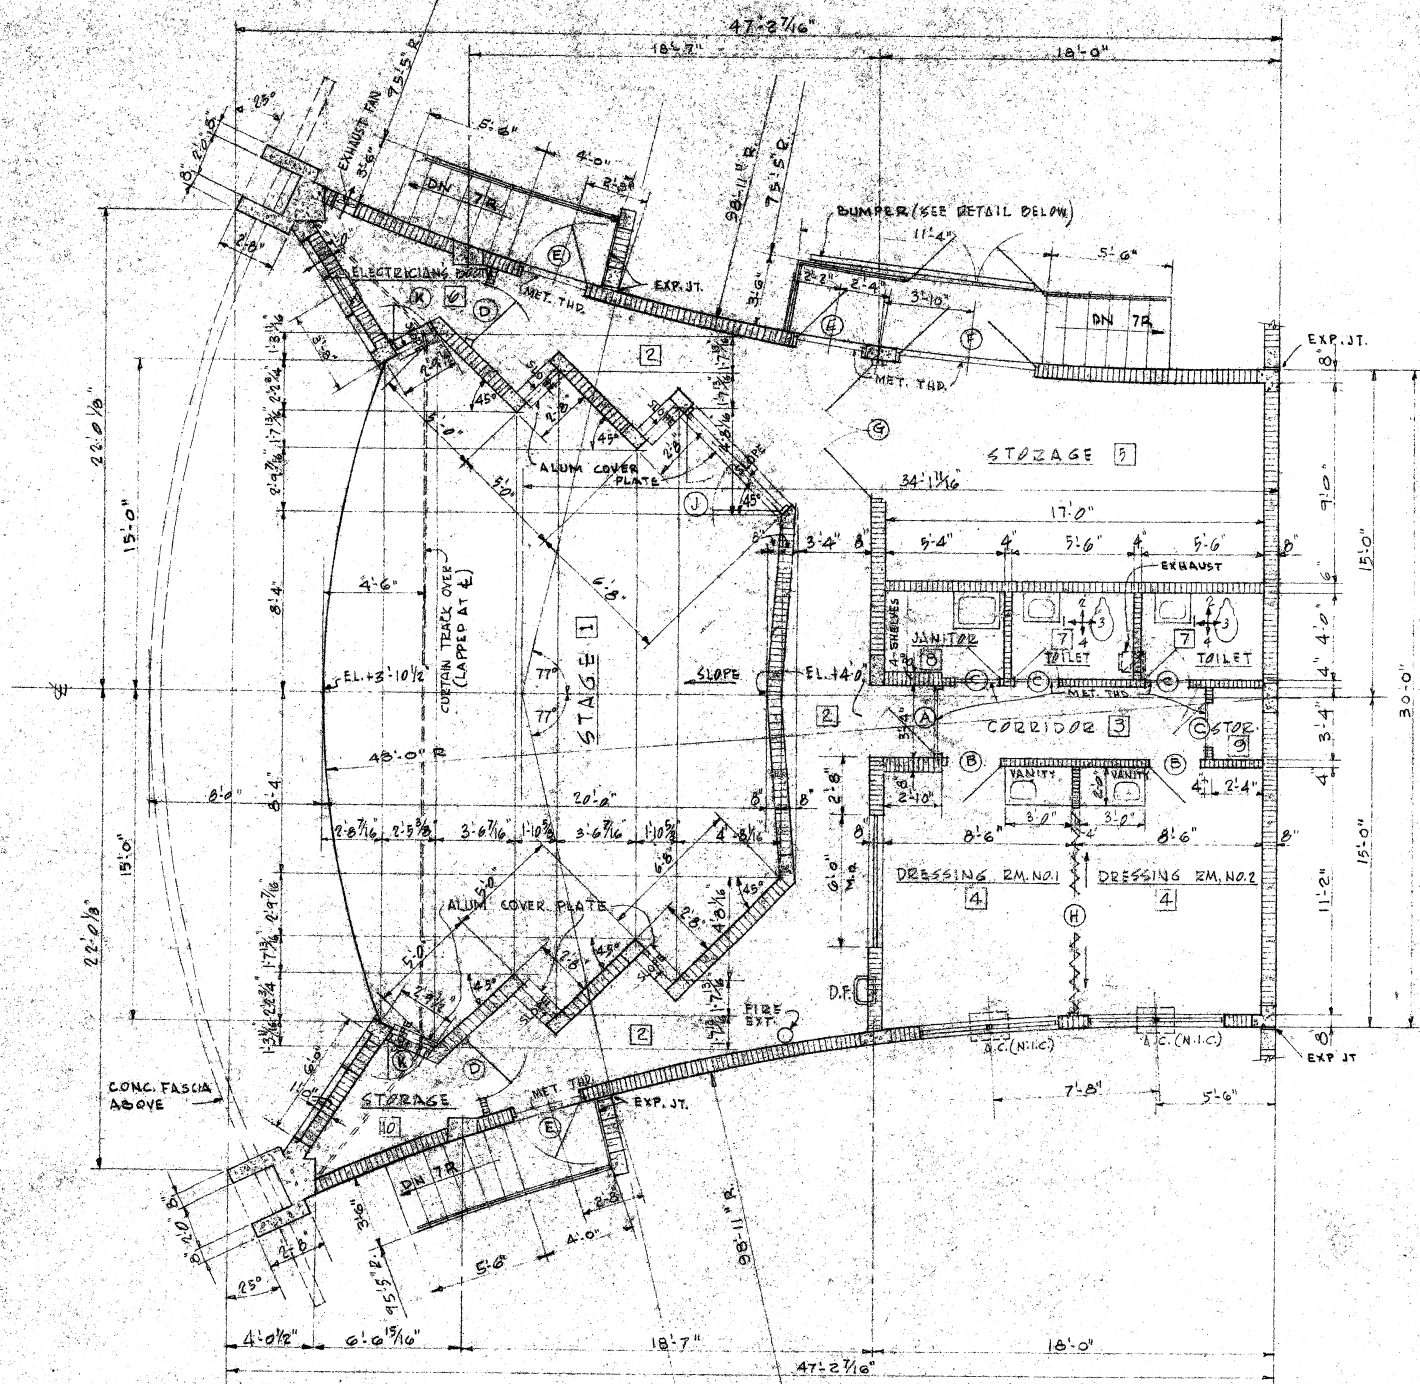


FLOOR PLAN OF STAGE BUILDING
SCALE 1/4" = 1'-0"

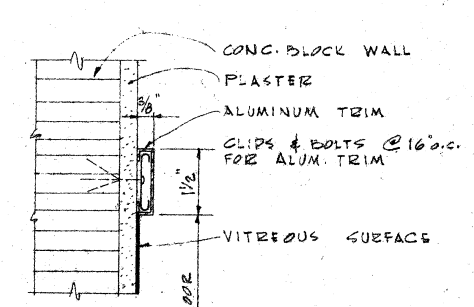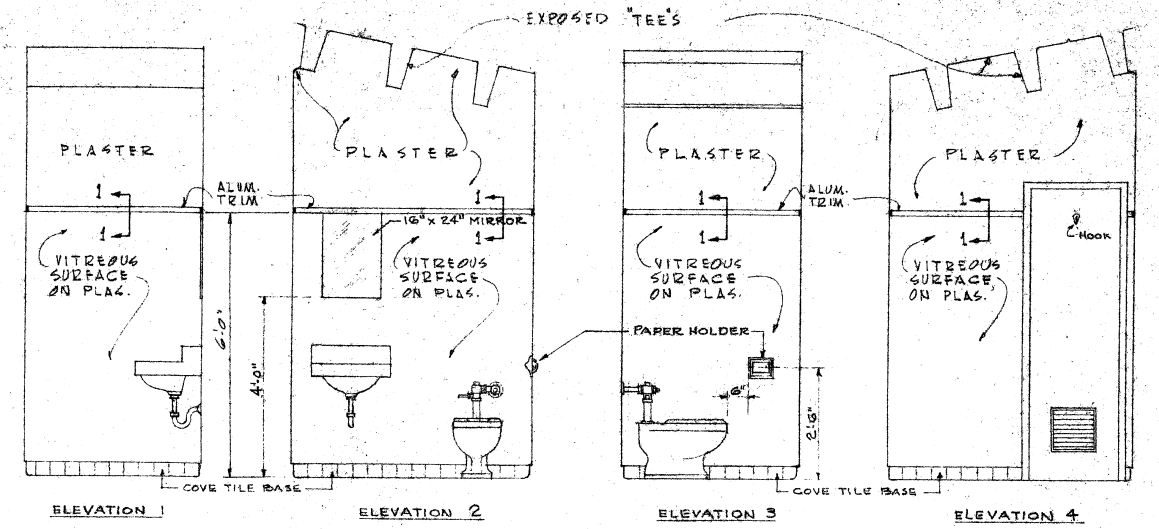

SECTION 1-1
SCALE 1/2" = 1'-0"


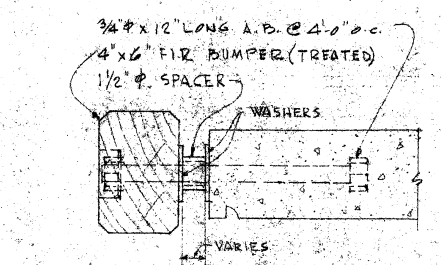


DETAIL OF BUMPER
SCALE 3/4" = 1'-0"

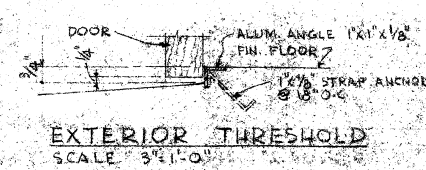


EXTERIOR THRESHOLD
SCALE 3/4" = 1'-0"

ELEVATION DOOR K
SCALE 1/2" = 1'-0"

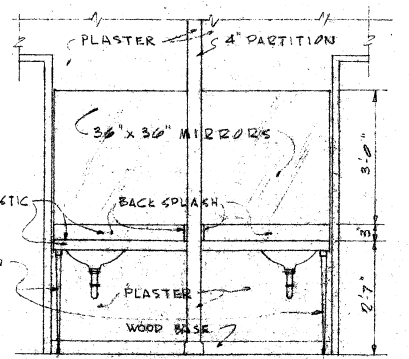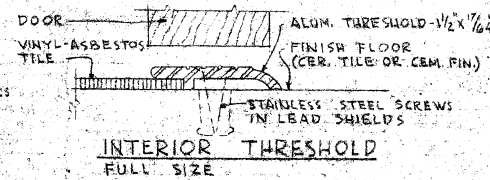

ELEVATION OF VANITIES
SCALE 1/8" = 1'-0"

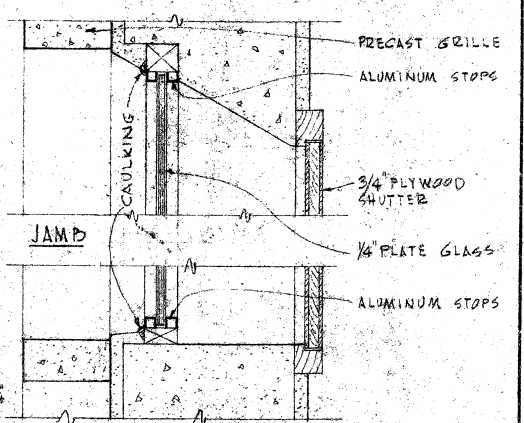

DETAIL OF WINDOW AT ELECTRICIAN'S BOOTH
SCALE 3/4" = 1'-0"

ROOM FINISH SCHEDULE					
ROOM	SPACE	FLOOR	BASE	WALLS	CEILING
1	STAGE	WOOD	WOOD	STUCCO & ACOUSTIC PNL	STUCCO & ACOUSTIC PNL
2	PASSAGE	CEMENT	---	STUCCO	EXPOSED
3	CORRIDOR	1/2" VINYL ASBESTOS TILE	WOOD	PLASTER	"
4	DRESSING ROOMS	"	"	"	"
5	STORAGE ROOM	CEMENT	"	"	"
6	ELECTRICIAN'S BOOTH	"	"	"	"
7	TOILET ROOMS	CERAMIC TILE	COVE TILE	"	"
8	JANITOR'S ROOM	CEMENT	WOOD	"	"
9	STORAGE CLOSET	"	"	"	"
10	STORAGE	"	"	"	"





DOOR SCHEDULE					
MARK	SIZE	TYPE	MATERIAL	FRAME	GLASS
A	3/0 x 9/8 x 3/4"	FLUSH	WOOD	WOOD	---
B	2/0 x 6/8 x 3/4"	"	"	"	---
C	2/0 x 6/8 x 3/4"	"	"	"	---
D	2/8 x 6/8 x 3/4"	"	"	"	---
E	3/0 x 7/8 x 3/4"	"	WOOD	ALUM	---
F	PR 3/0 x 7/8 x 3/4"	LOUVERED	WOOD	"	---
G	PR 3/0 x 7/8 x 3/4"	"	WOOD	"	---
H	PR 5/0 x 7/8 x 3/4"	FOLDING	WOOD	"	---
J	PR 3/0 x 7/8 x 3/4"	FLUSH	WOOD	"	---
K	1-10 x 7/8 x 1 1/4"	FLUSH	WOOD	"	---

REVISIONS					
NO.	DATE	DESCRIPTION	BY	DATE	DESCRIPTION
1	6-23-1961	ISSUED TO	---	---	---
2	---	PRINTING RECORD	---	---	---

norman m. giller & associates
ARCHITECTS - ENGINEERS
975 ARTHUR GODFREY ROAD, MIAMI BEACH, FLA.







FLOOR PLAN OF STAGE BLDG., NORTH SHORE COMMUNITY CENTER, MIAMI BEACH, FLORIDA.

COMM. NO. 61105 DATE 6-23-1961 SHEET NO. A-6 TOTAL SHEETS 15

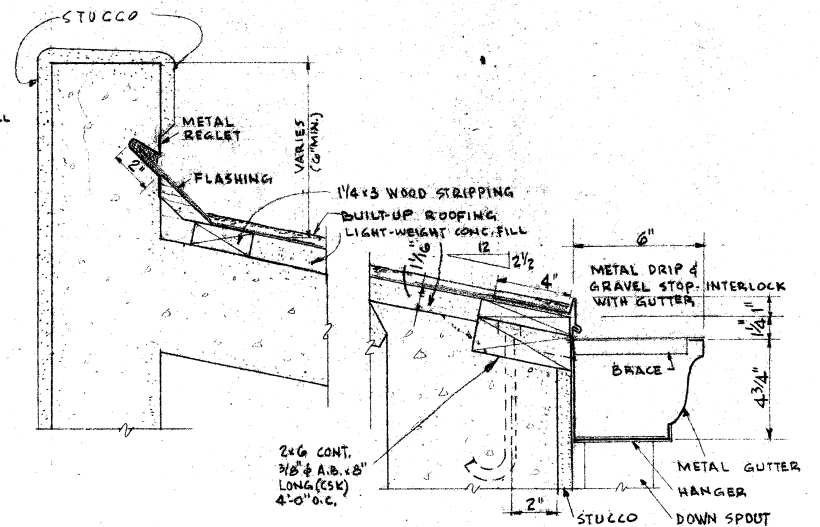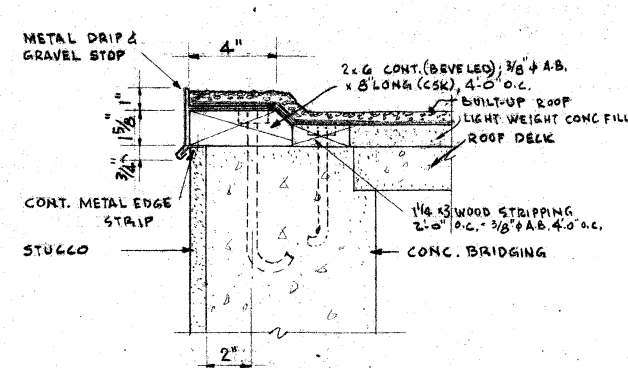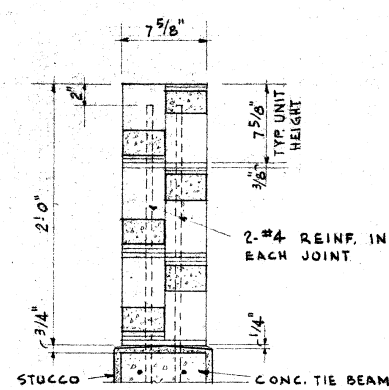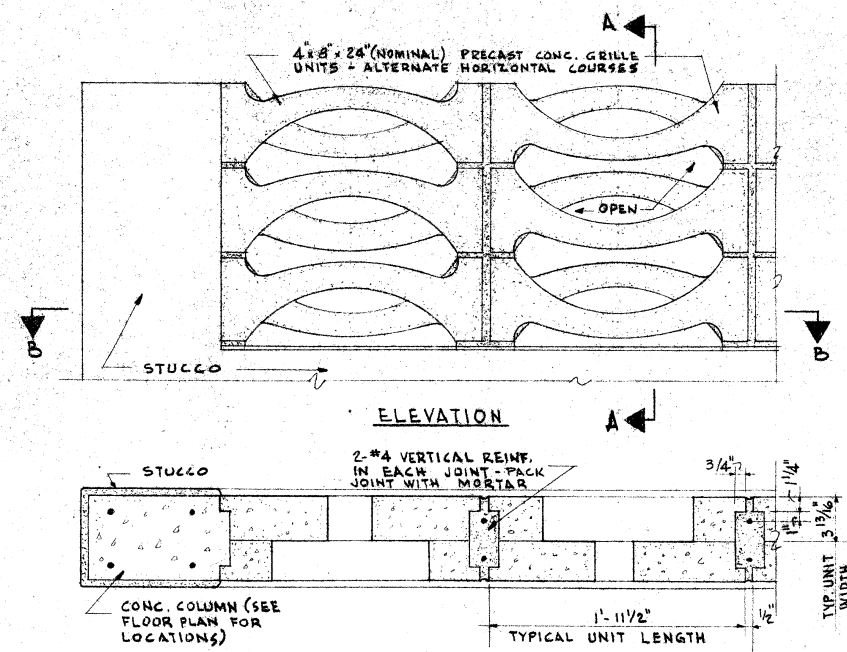


FLASHING DETAILS
SCALE: 3"=1'-0"

DETAILS OF GRILLE AT TOP OF SEATING ENCLOSURE WALL
SCALE: $1\frac{1}{2}" = 1'-0"$

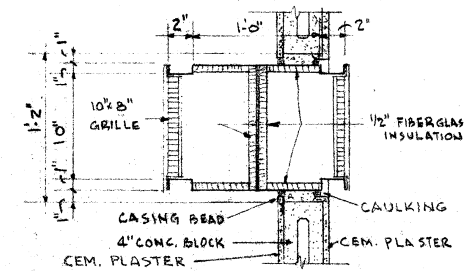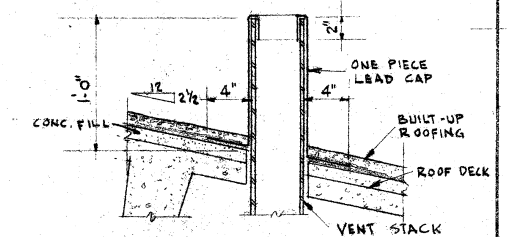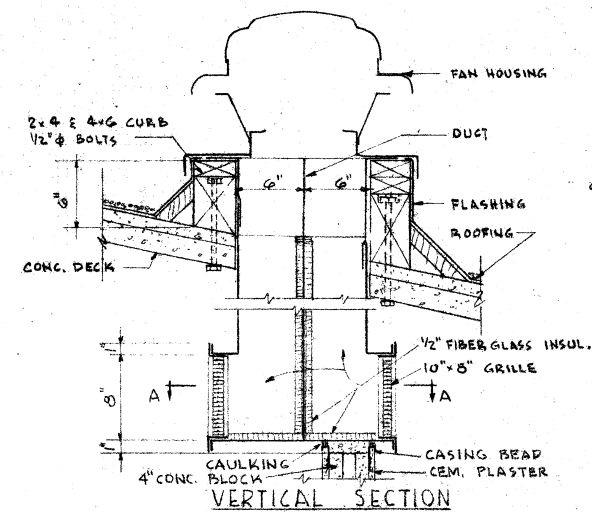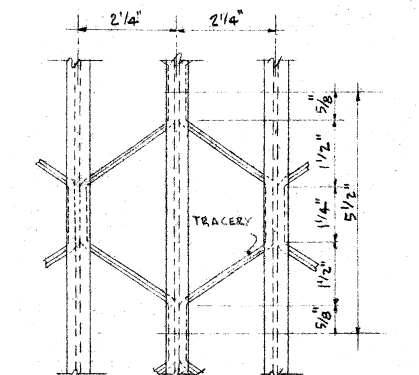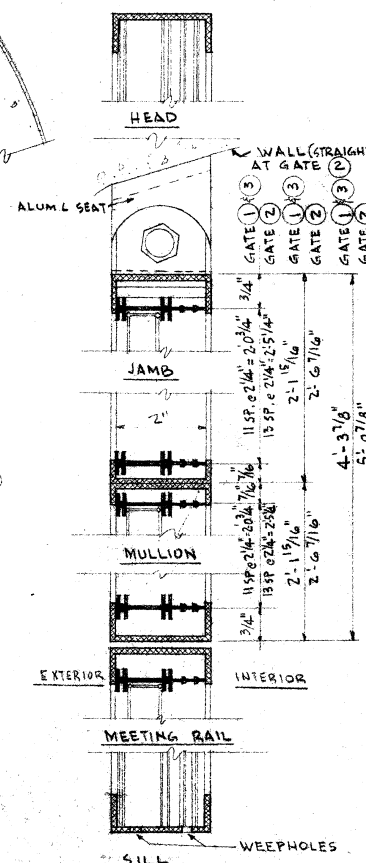
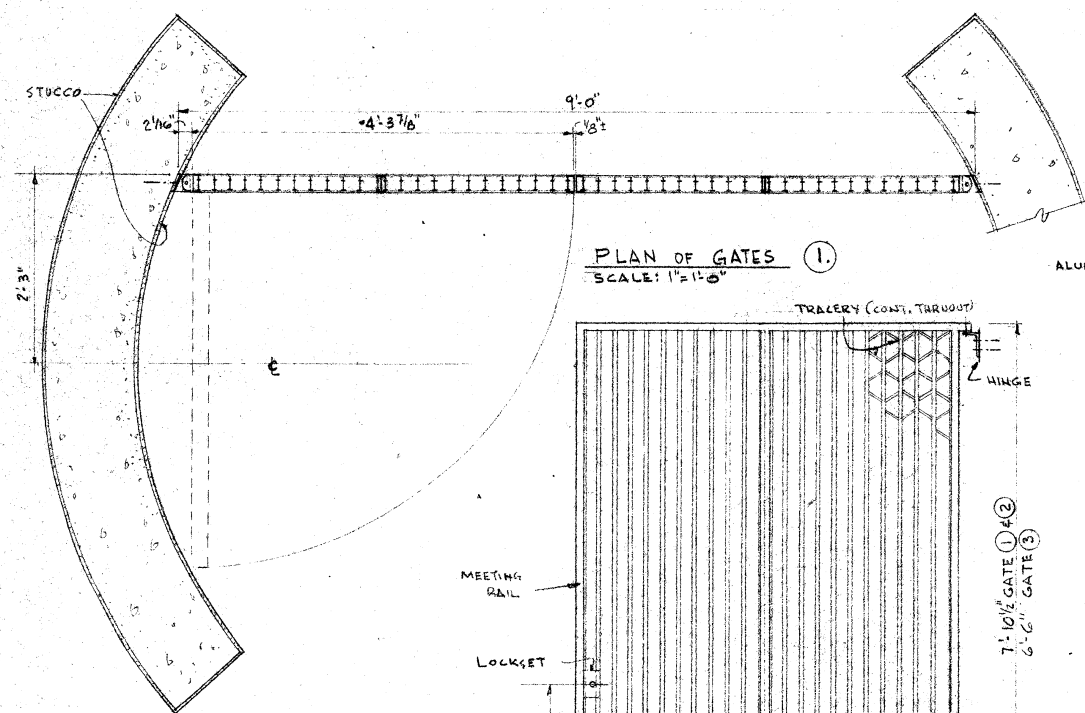


TOILET ROOMS EXHAUST FAN DUCT & CURB DETAILS
SCALE: 1/4" = 1'-0"

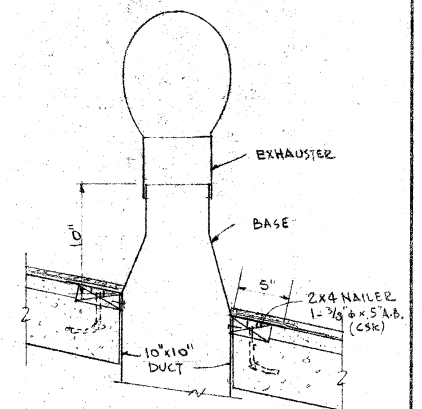

JUL 3 1961

[illegible]

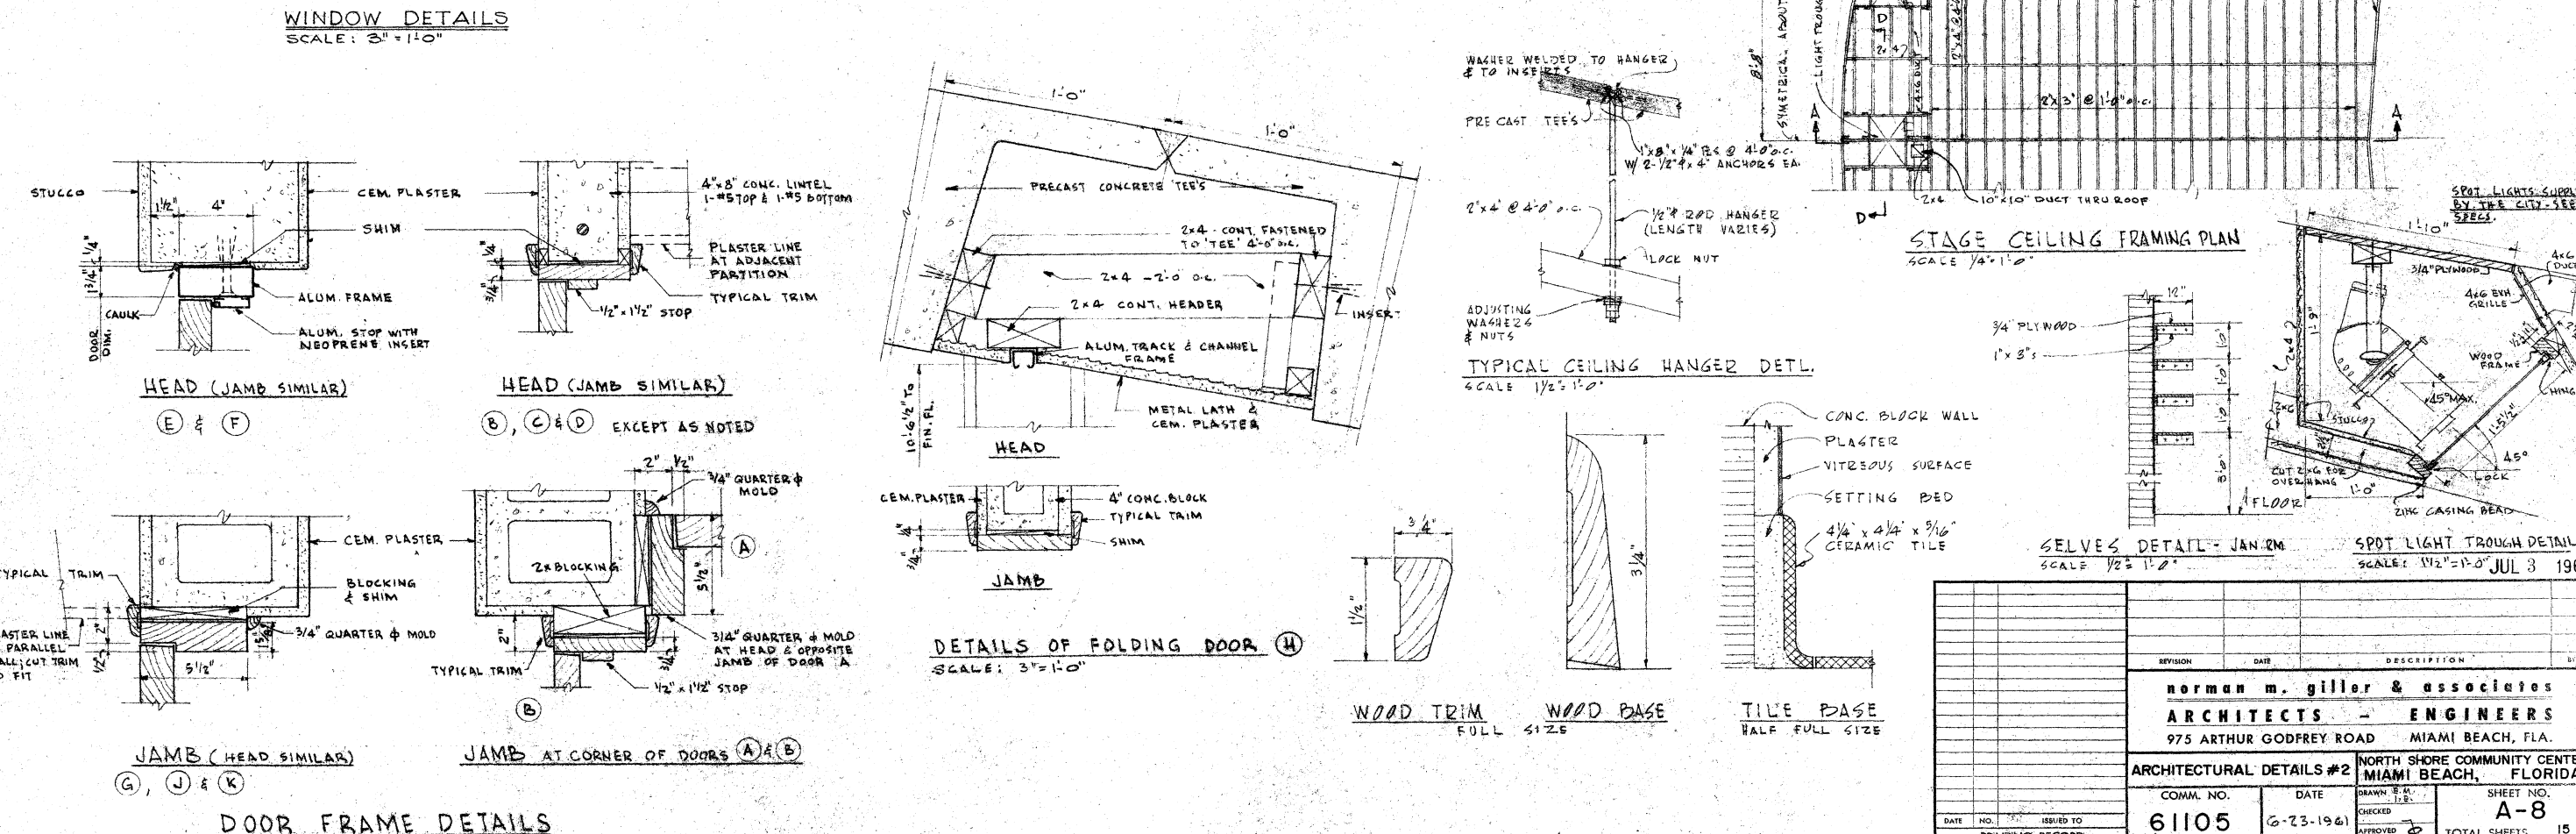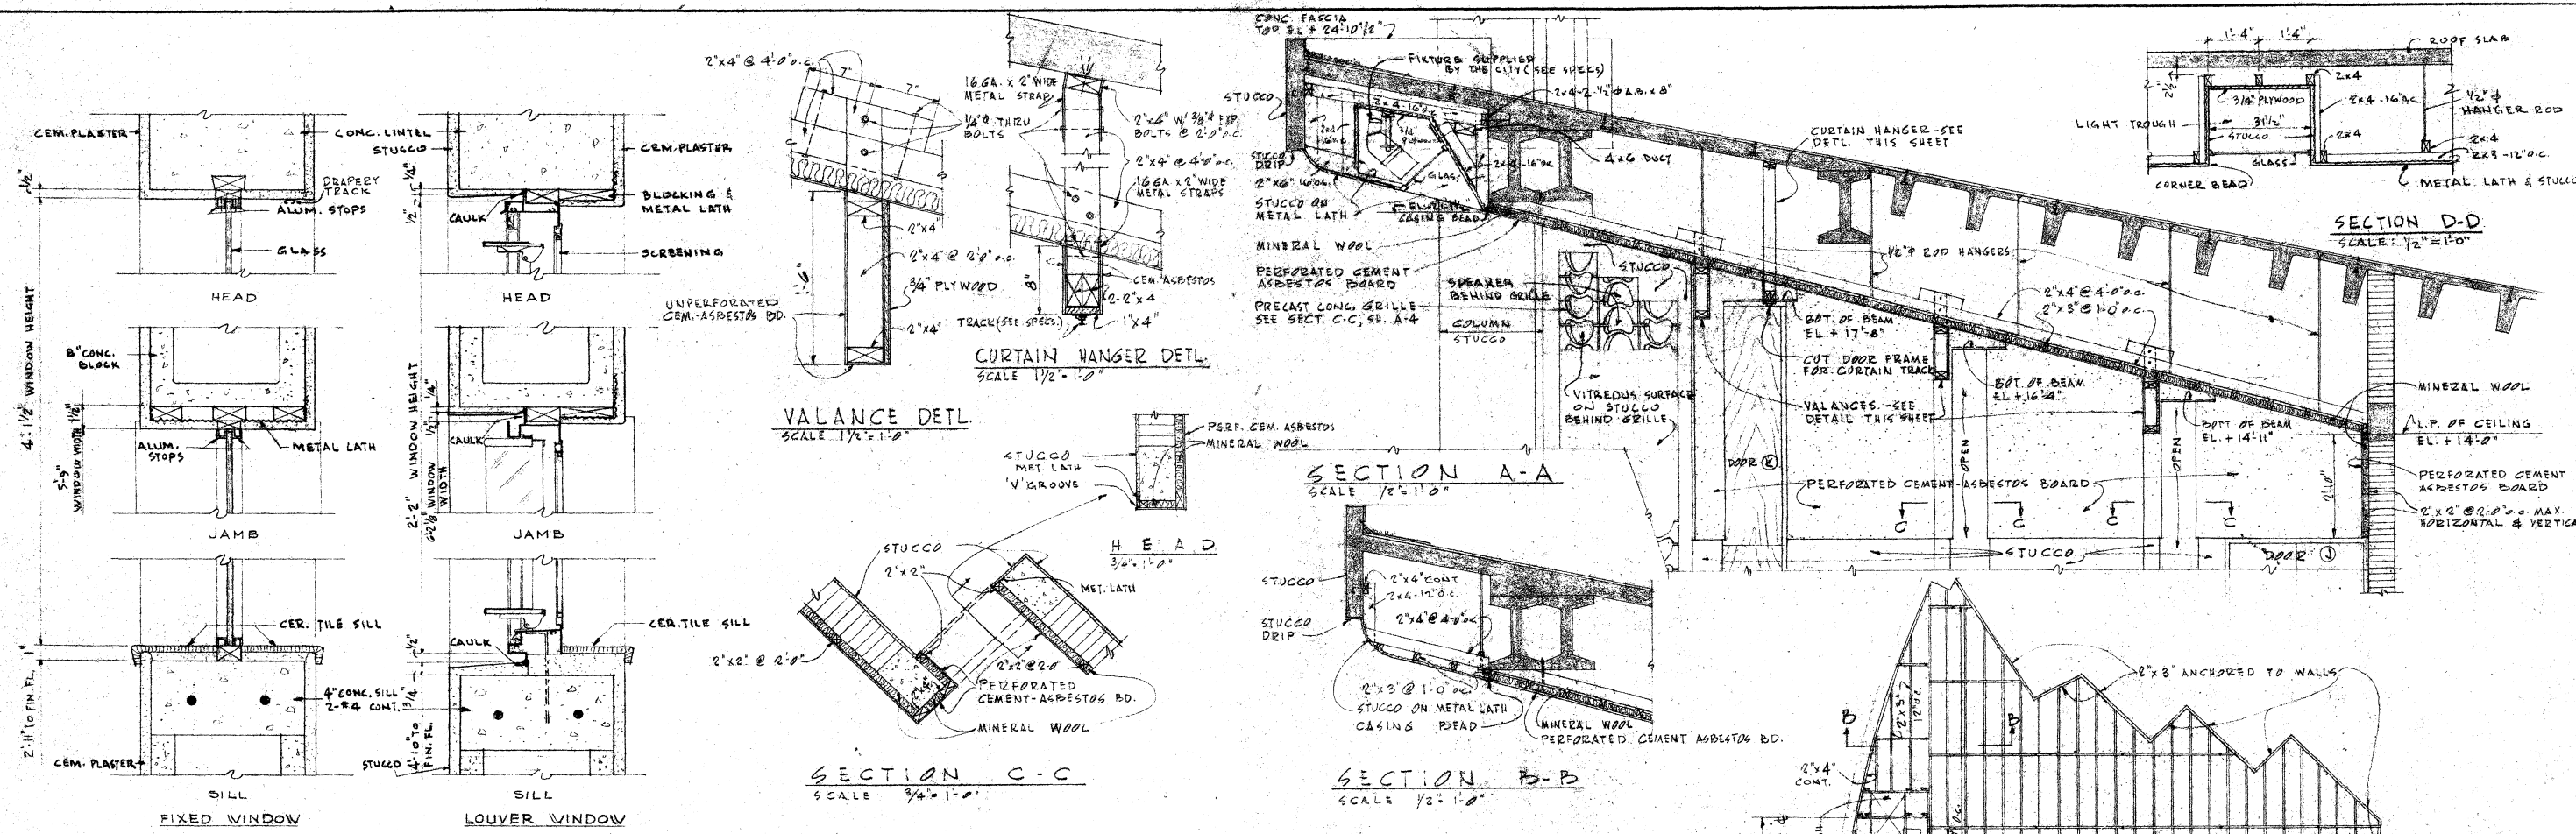


REVISION	DATE	DESCRIPTION	BY

norman m. giller & associates		ARCHITECTS - ENGINEERS	
975 ARTHUR GODFREY ROAD		MIAMI BEACH, FLA.	
ARCHITECTURAL DETAILS #2		NORTH SHORE COMMUNITY CENTER	
MIAMI BEACH, FLORIDA.			
COMM. NO.	DATE	DRAWN E.A.	SHEET NO.
61105	6-23-1961	CHECKED	A-8
APPROVED			TOTAL SHEETS 15

DATE: 6-23-1961
NO. 1
ISSUED TO: PRINTING RECORD
APPROVED:

THESE PLANS ARE THE PROPERTY OF THE ARCHITECT AND CANNOT BE REPRODUCED IN PART OR IN WHOLE WITHOUT WRITTEN PERMISSION OF THE ARCHITECT

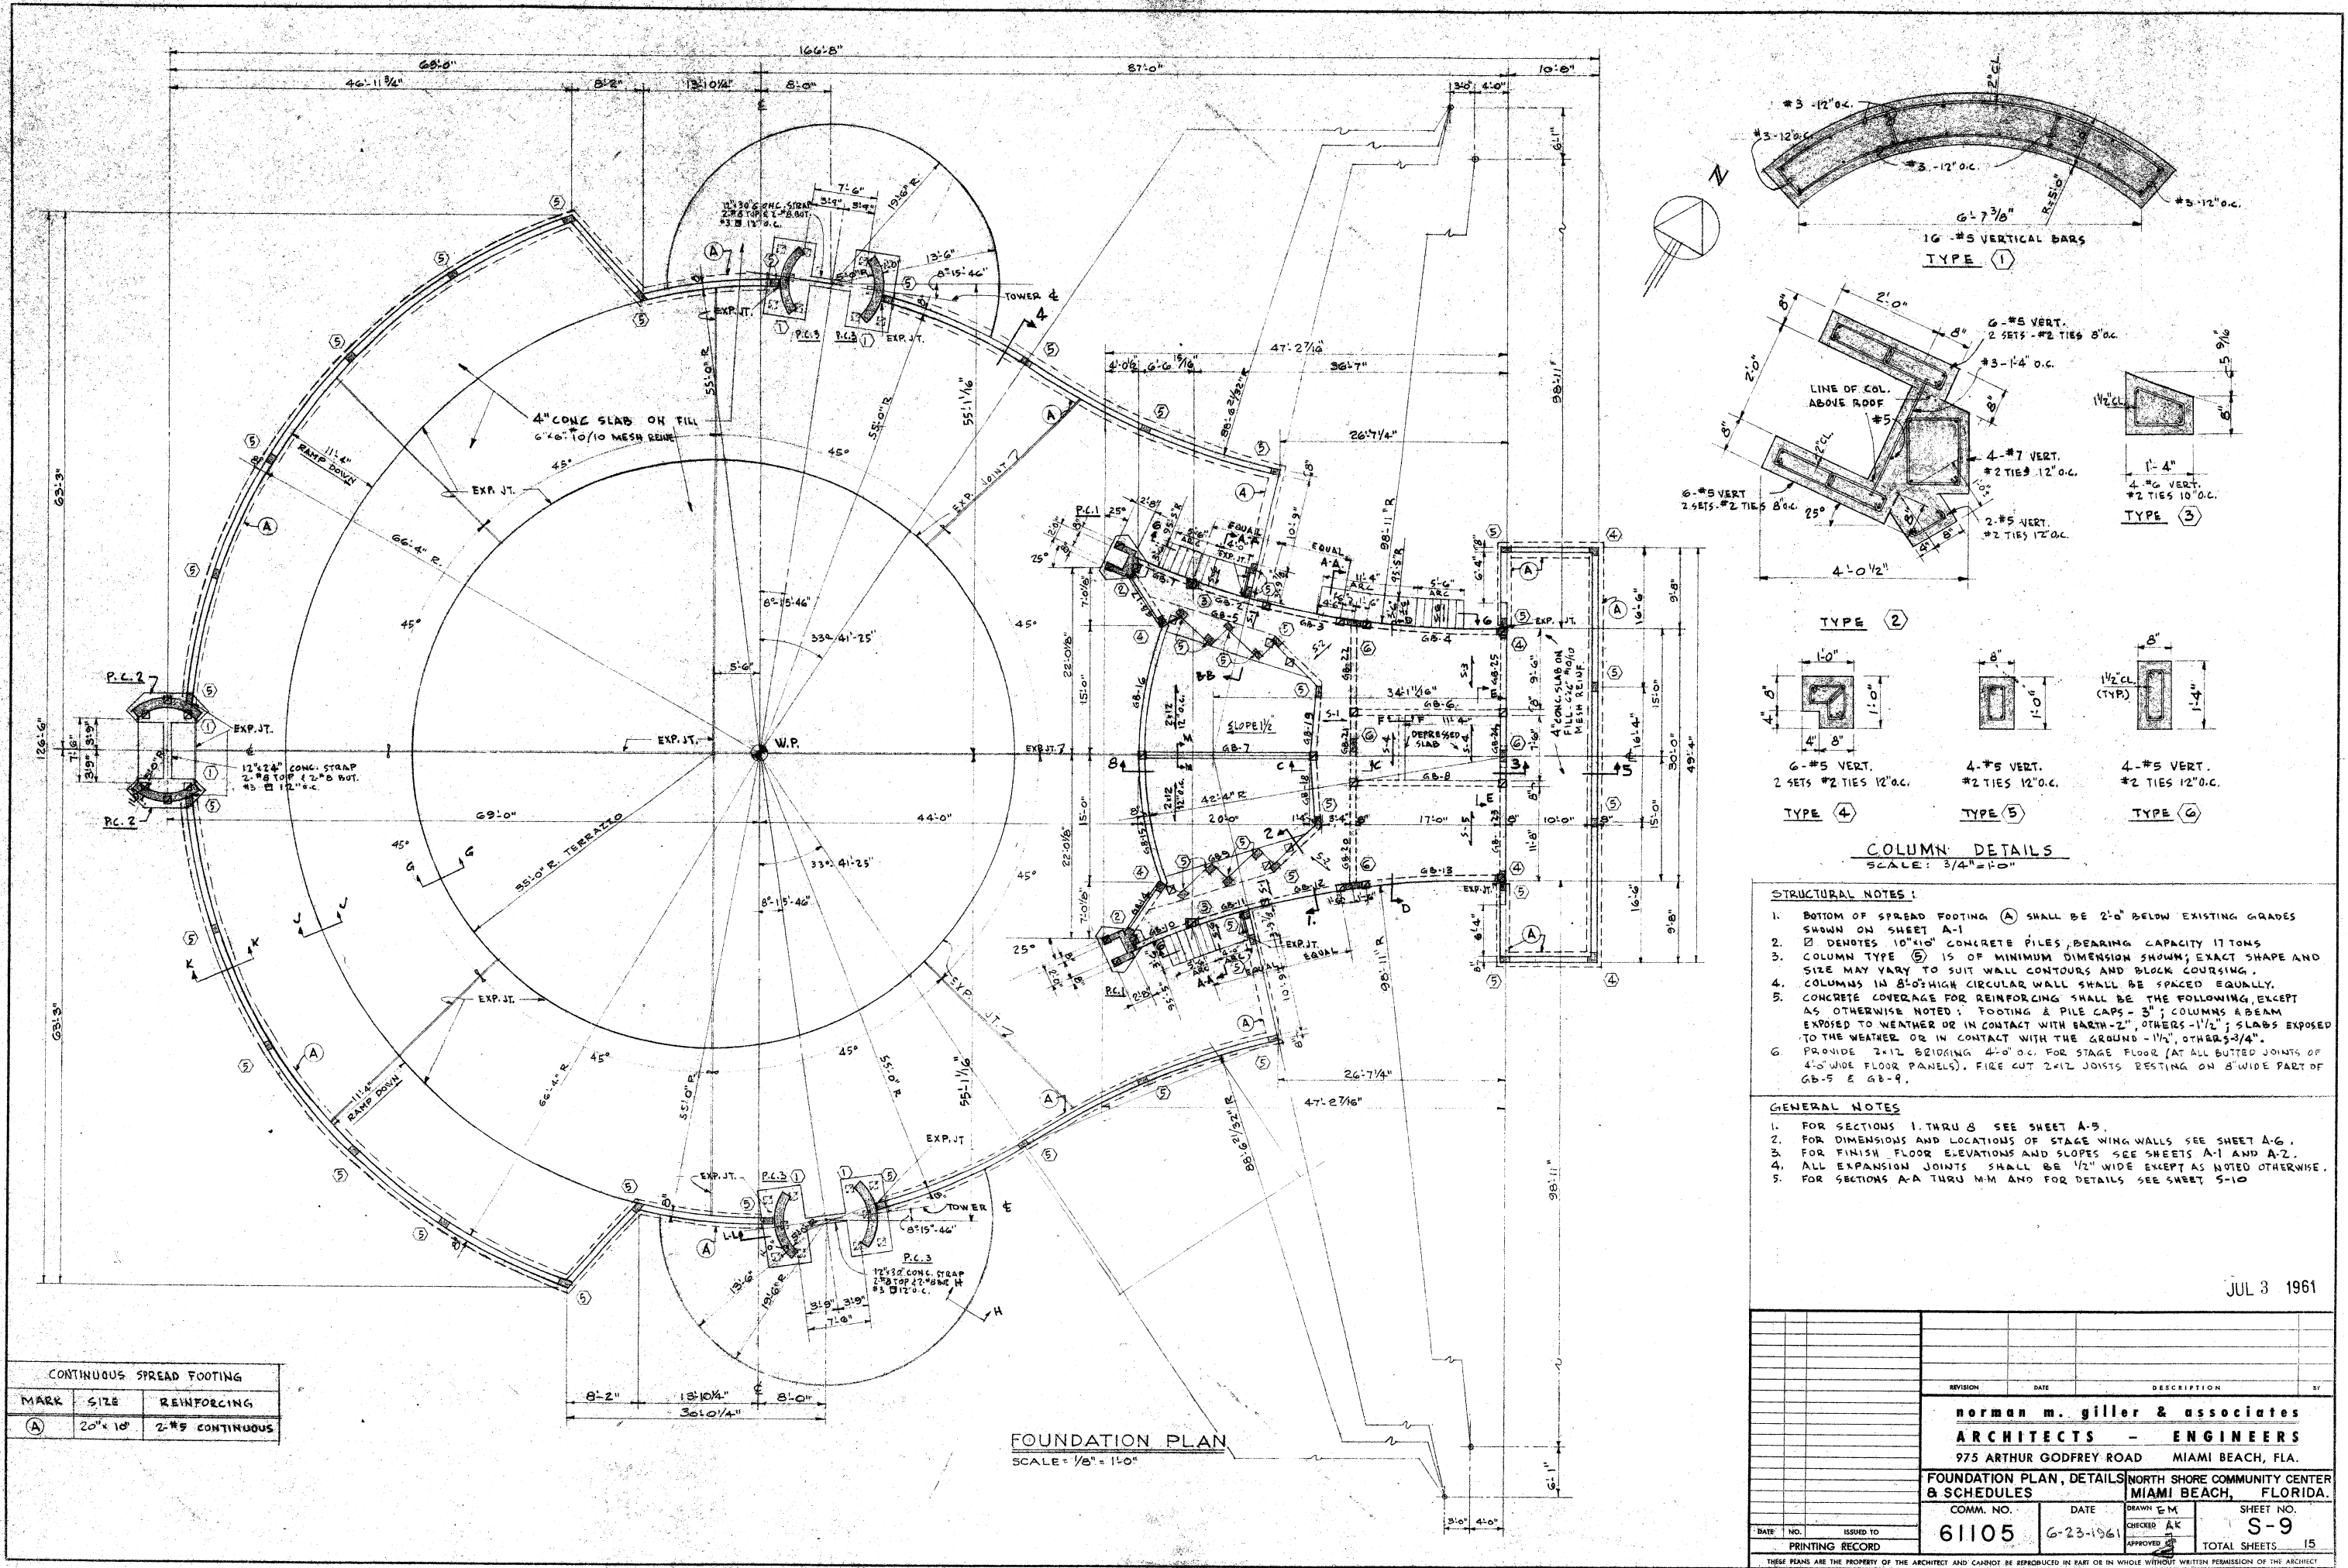

JUL 3 1961

REVISION	DATE	DESCRIPTION	BY

norman m. giller & associates
ARCHITECTS - ENGINEERS
975 ARTHUR GODFREY ROAD MIAMI BEACH, FLA.

FOUNDATION PLAN, DETAILS & SCHEDULES **NORTH SHORE COMMUNITY CENTER MIAMI BEACH, FLORIDA.**


COMM. NO.	DATE	DRAWN	CHECKED	APPROVED	SHEET NO.
61105	6-23-1961	E.M.	A.K.		S-9

PRINTING RECORD

BATE	NO.	ISSUED TO

TOTAL SHEETS 15


B6-61K

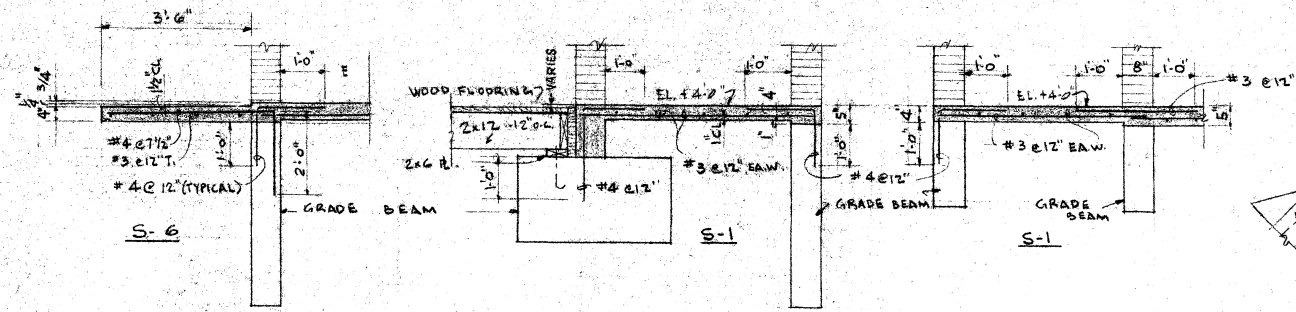


SECTION A-A

SECTION B-B

SECTION C-C

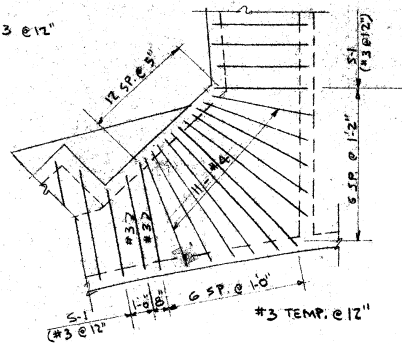

PLAN OF SLAB S-2
SCALE: 1/4" = 1'-0"
(SECTION SAME AS FOR S-1 EXCEPT FOR REINF. SIZE & SPACING)

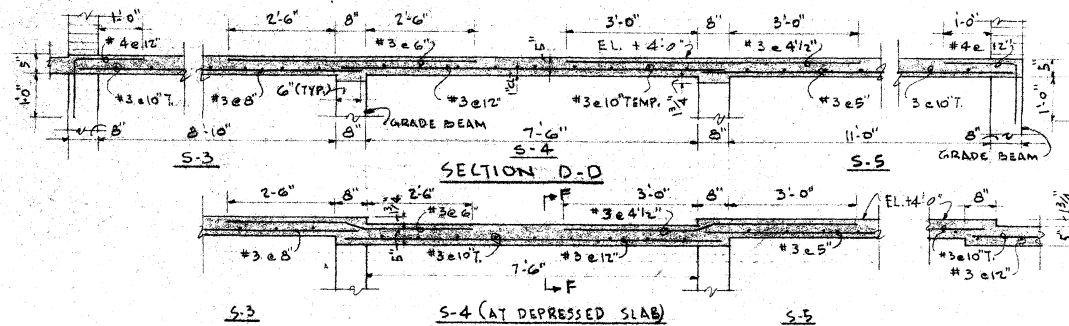


SECTION D-D

SECTION E-E

SECTION F-F


SLAB DETAILS
SCALE: 1/2" = 1'-0"

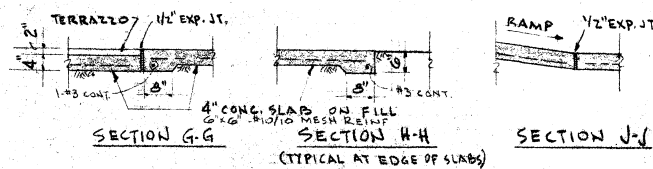


SECTION G-G

SECTION H-H


SECTION J-J

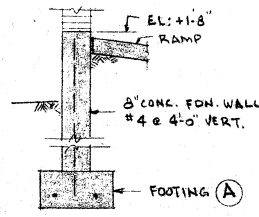


SECTION K-K

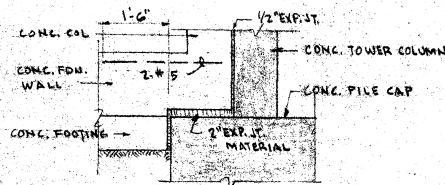

SECTION L-L

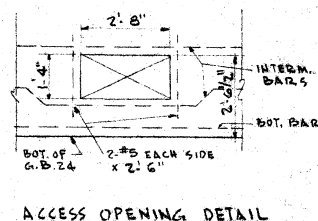


ACCESS OPENING DETAIL

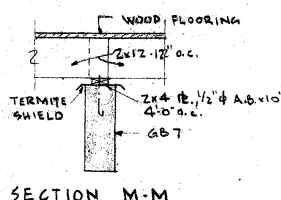


SECTION M-M


SECTIONS AND DETAILS
SCALE: 1/2" = 1'-0"

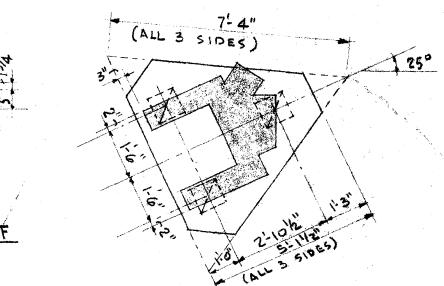


TOP VIEW

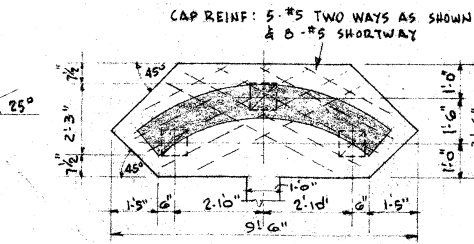


TOP VIEW

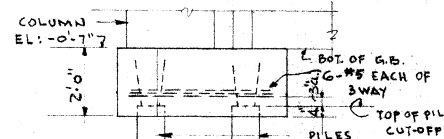


ELEVATION

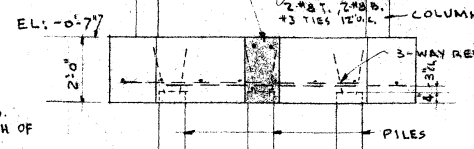

ELEVATION

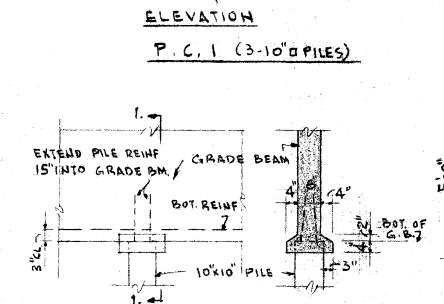

ELEVATION

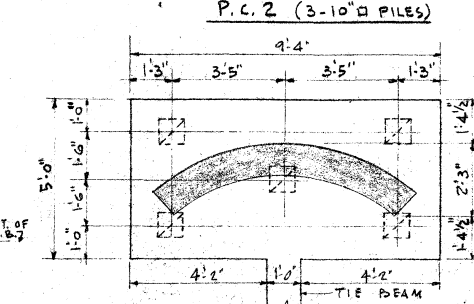


ELEVATION

TYPICAL SINGLE PILE DETAIL


NOTE: ALL PILE VERTICAL REINFORCING SHALL EXTEND 15" INTO PILE CAP OR GRADE BEAM.

PILE & PILE CAP DETAILS
SCALE: 3/8" = 1'-0"

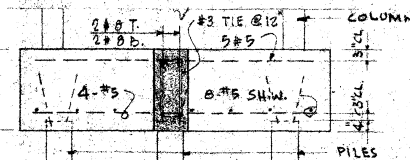

ELEVATION

P.C. 3 (5-10" PILES)

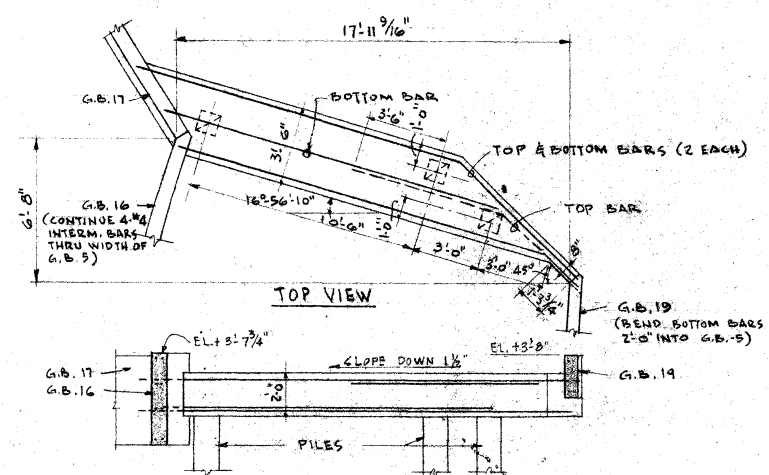

TOP VIEW

ELEVATION









DETAILS OF GRADE BEAM G.B.5 (G.B.9 SAME, REVERSED)
SCALE: 1/4" = 1'-0"


MARK	SIZE	ELEV. TOP OF BEAM	REINFORCING TOP	REINFORCING BOTTOM	STIRRUPS	REMARKS
G.B. 1	8"x50"	+3.7'	2-#5	2-#5	#3, 12" O.C. THRUOUT	2 SETS - 2 #4 INTERMEDIATE BARS
G.B. 2	8"x50"	+3.7'			#3, 12" O.C. THRUOUT	CONTINUE ALL BARS FROM G.B. 1
G.B. 3	8"x50"	+3.7'			#3, 12" O.C. THRUOUT	CONTINUE ALL BARS FROM G.B. 2
G.B. 4	8"x50"	+3.7'	2-#9	2-#7	#3, 12" O.C. THRUOUT	2 SETS - 2 #4 INTERMEDIATE BARS; EXTEND TOP BARS 2'-0" INTO G.B. 3
G.B. 5	8"x24"	+3.7'	2-#6	2-#8	#3, 12" O.C. THRUOUT	SEE DETAIL
G.B. 6	8"x24"	+3.7'	2-#10	2-#5	3-#3 EA. END @ 3'-6"	
G.B. 7	8"x24"	+3.7'	2-#11	2-#6	4-#3 EA. END @ 3'-6", 3'-6"	
G.B. 8	8"x24"	+3.7'	2-#10	2-#6	4-#3 EA. END @ 3'-6", 3'-6"	
G.B. 9	8"x24"	+3.7'	2-#10	2-#6	#3, 12" O.C. THRUOUT	SEE DETAIL
G.B. 10	8"x50"	+3.7'	2-#5	2-#5	#3, 12" O.C. THRUOUT	2 SETS - 2 #4 INTERMEDIATE BARS
G.B. 11	8"x50"	+3.7'			#3, 12" O.C. THRUOUT	CONTINUE ALL BARS FROM G.B. 10
G.B. 12	8"x50"	+3.7'			#3, 12" O.C. THRUOUT	CONTINUE ALL BARS FROM G.B. 11
G.B. 13	8"x50"	+3.7'	2-#9	2-#7	#3, 12" O.C. THRUOUT	2 SETS - 2 #4 INTERMEDIATE BARS; EXTEND TOP BARS 2'-0" INTO G.B. 12
G.B. 14	8"x24"	+3.7'	2-#5	2-#5	#3, 12" O.C. THRUOUT	2 SETS - 2 #4 INTERMEDIATE BARS SEE SECT. C-C ON SHEET A-4
G.B. 15	8"x50"	+3.7'	2-#5	2-#5	#3, 12" O.C. THRUOUT	2 SETS - 2 #4 INTERMEDIATE BARS
G.B. 16	8"x50"	+3.7'			#3, 12" O.C. THRUOUT	CONTINUE ALL BARS FROM G.B. 15
G.B. 17	8"x50"	+3.7'	2-#5	2-#5	#3, 12" O.C. THRUOUT	2 SETS - 2 #4 INTERMEDIATE BARS SEE SECT. C-C ON SHEET A-4
G.B. 18	8"x24"	+3.7'	2-#5	2-#5		
G.B. 19	8"x24"	+3.7'				CONTINUE ALL BARS FROM G.B. 18
G.B. 20	8"x24"	+3.7'	2-#5	2-#5		
G.B. 21	8"x24"	+3.7'				CONTINUE ALL BARS FROM G.B. 20
G.B. 22	8"x24"	+3.7'				CONTINUE ALL BARS FROM G.B. 21
G.B. 23	8"x50"	+3.7'	2-#5	2-#5	#3, 12" O.C. THRUOUT	2 SETS - 2 #4 INTERMEDIATE BARS
G.B. 24	8"x50"	+3.7'			#3, 12" O.C. THRUOUT	CONTINUE ALL BARS FROM G.B. 23
G.B. 25	8"x50"	+3.7'			#3, 12" O.C. THRUOUT	CONTINUE ALL BARS FROM G.B. 24

JUL 3 1961


DATE	NO.	ISSUED TO	PRINTING RECORD	REVISION	DATE	DESCRIPTION	BY
norman m. giller & associates ARCHITECTS - ENGINEERS 975 ARTHUR GODFREY ROAD MIAMI BEACH, FLA.							
FLOOR FRAMING AND PILING DETAILS				NORTH SHORE COMMUNITY CENTER MIAMI BEACH, FLORIDA.			
COMM. NO.		DATE		DRAWN		SHEET NO.	
61105		6-25-1961		EM		S-10	
APPROVED		CHECKED		TOTAL SHEETS		15	

  BG-61K

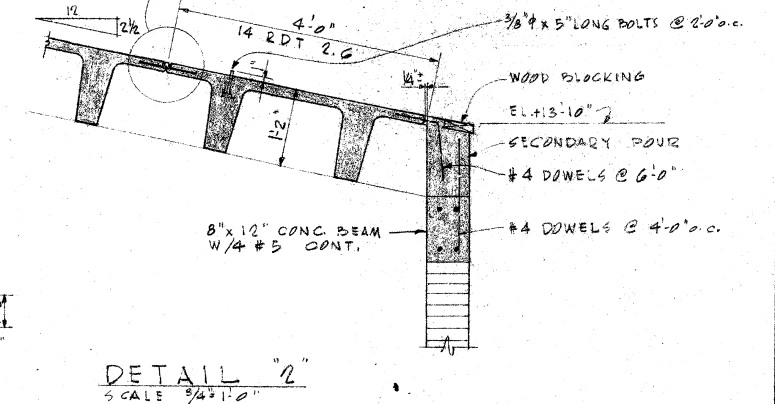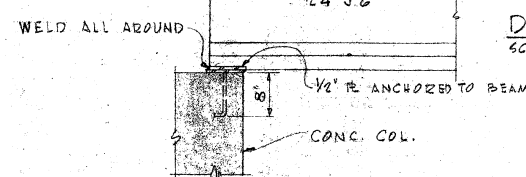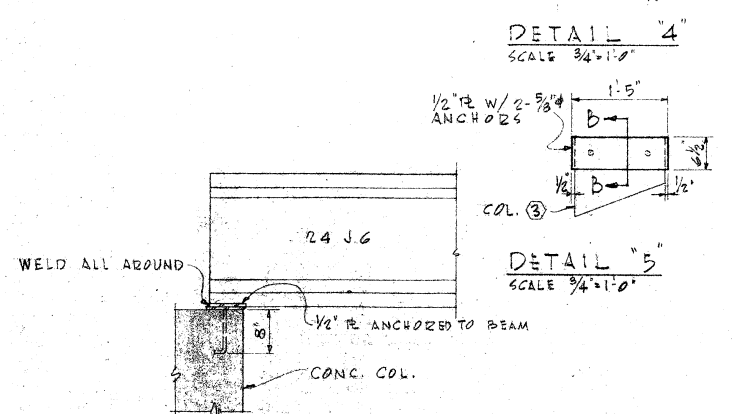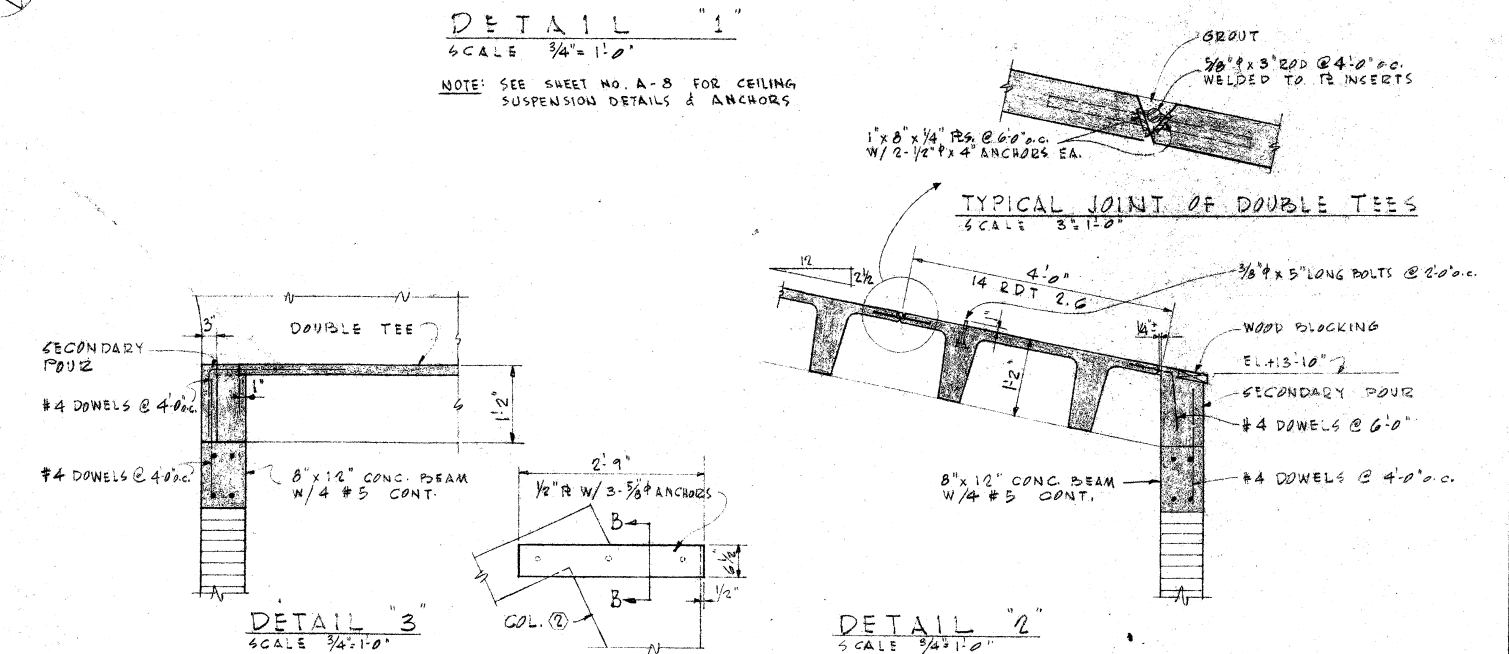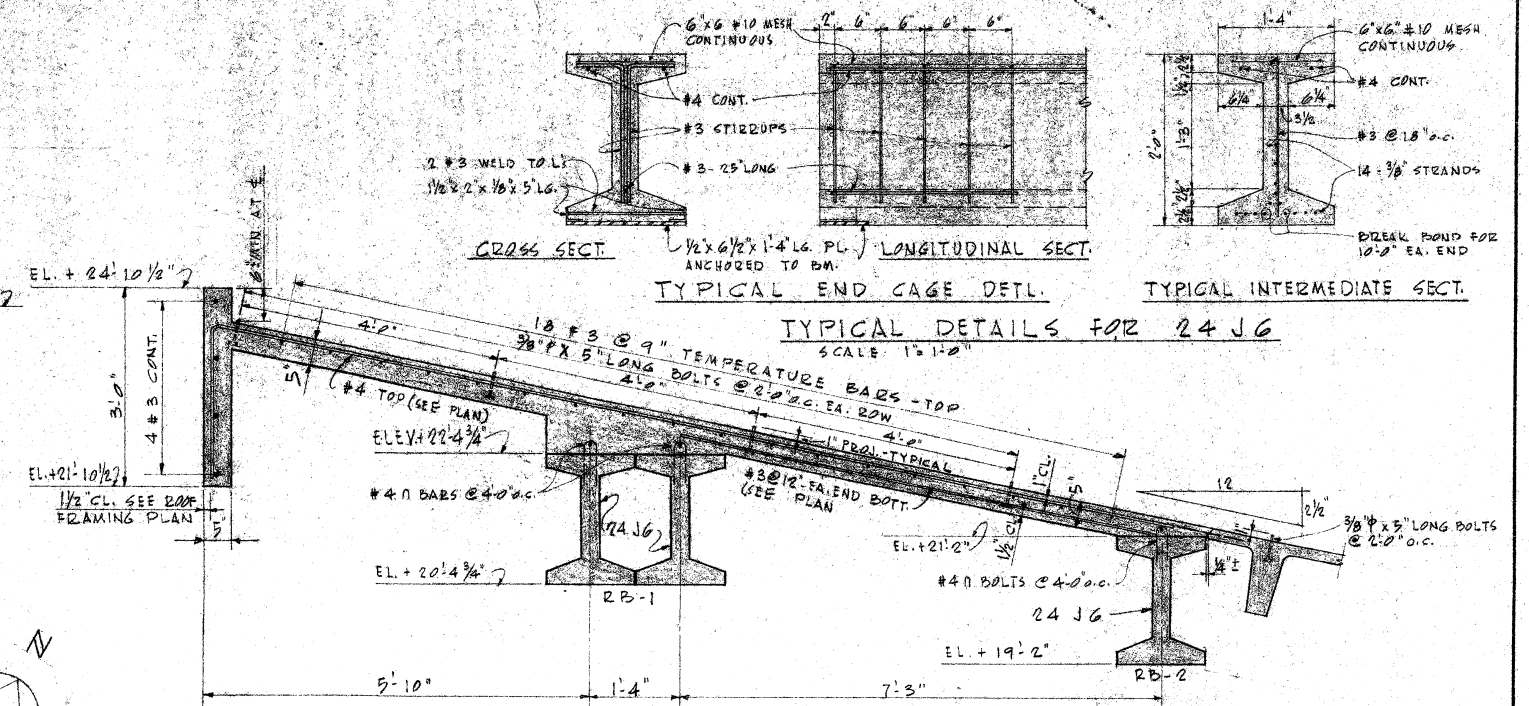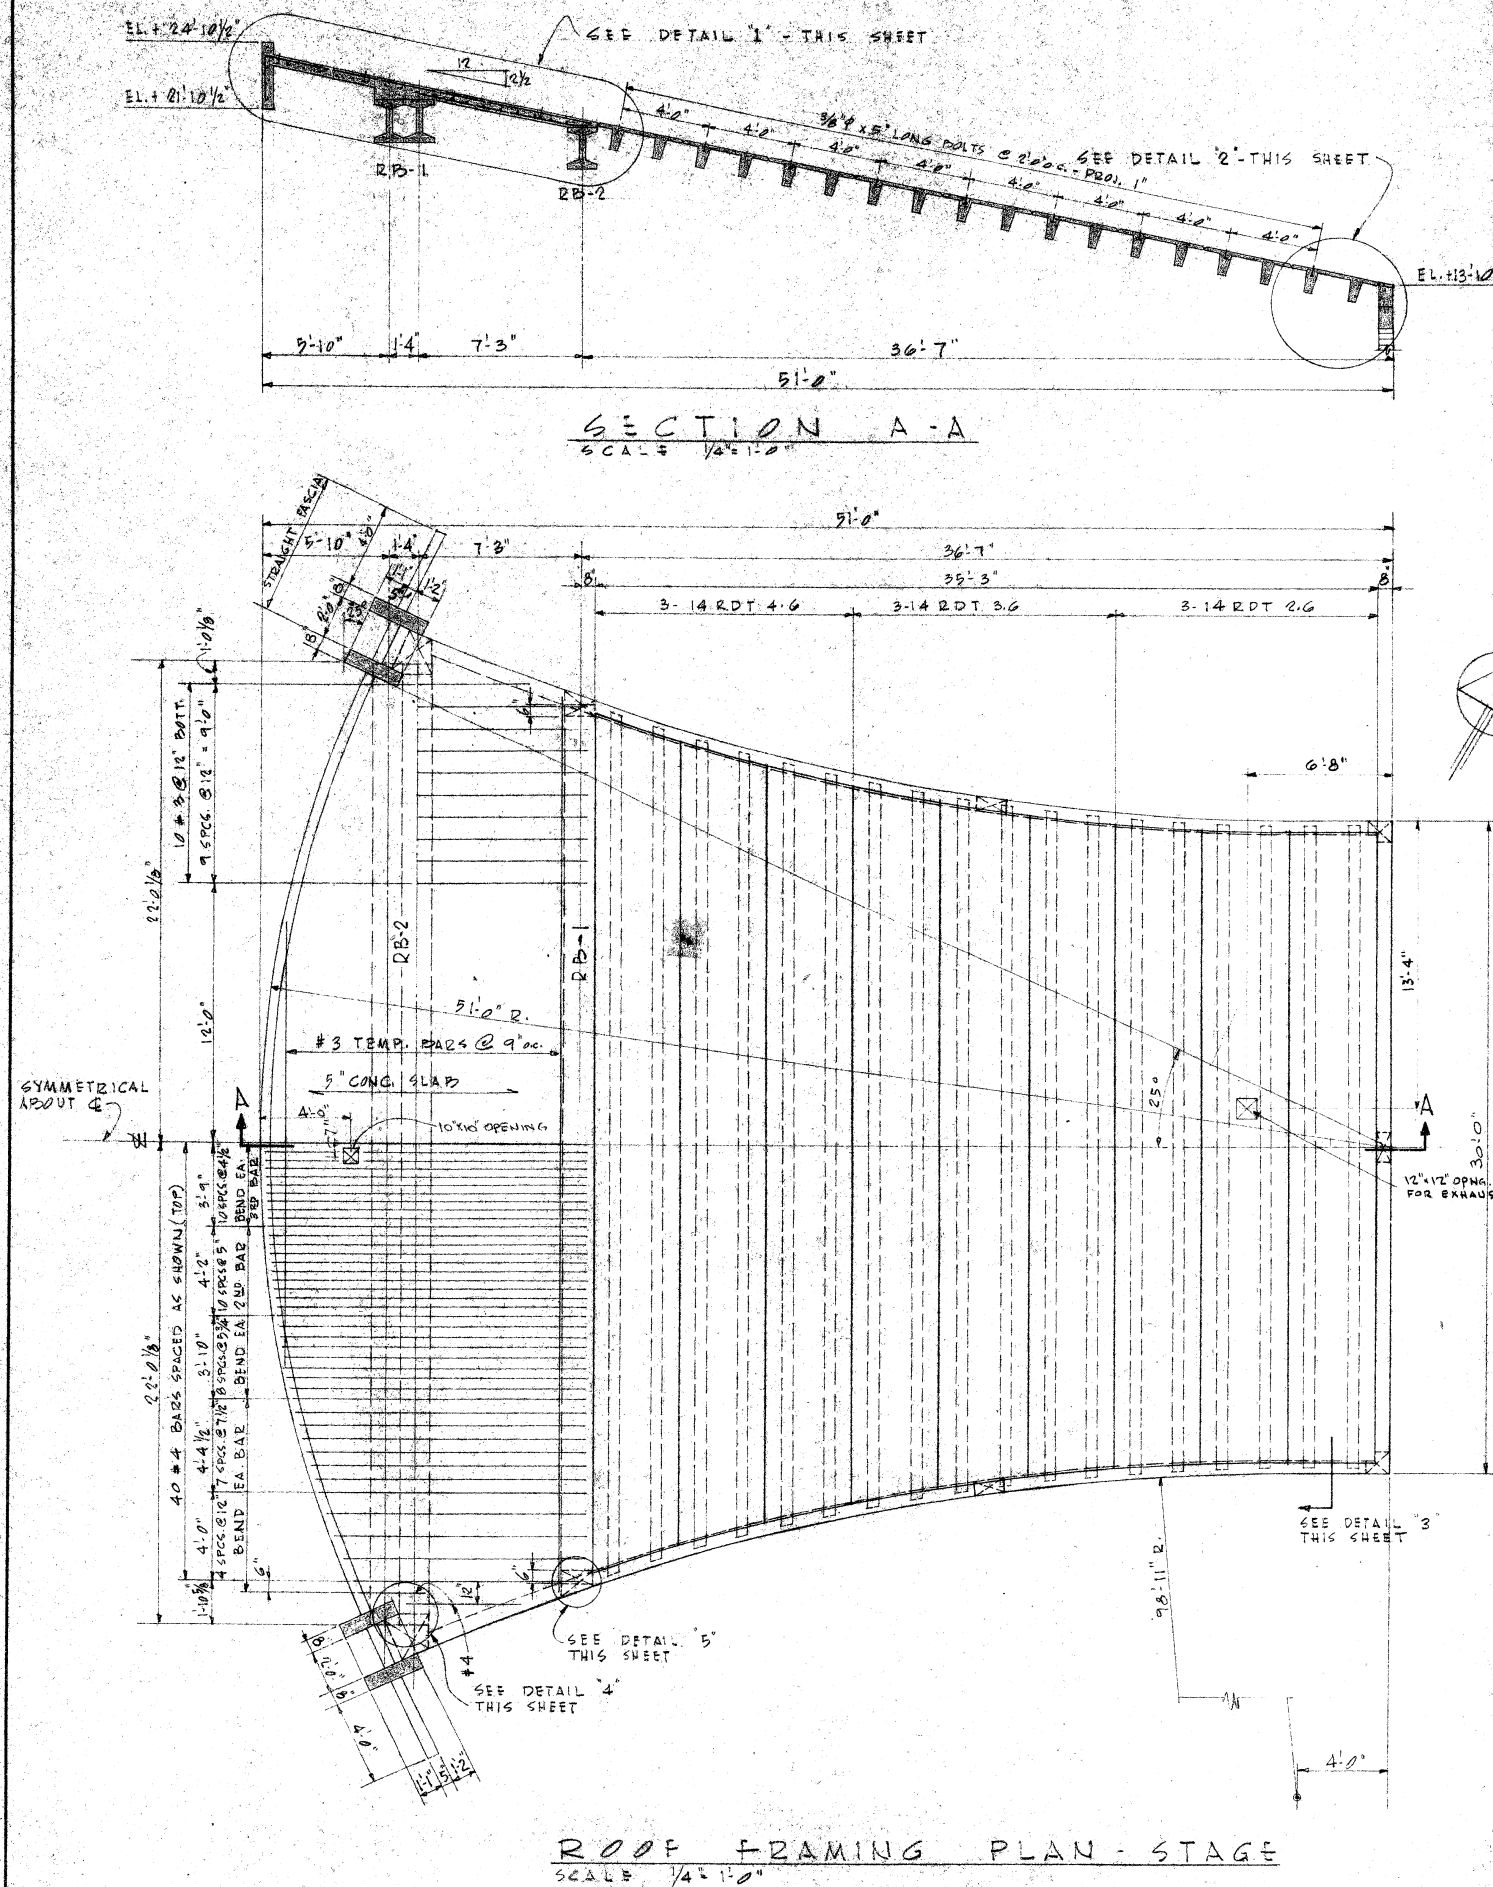
[illegible]

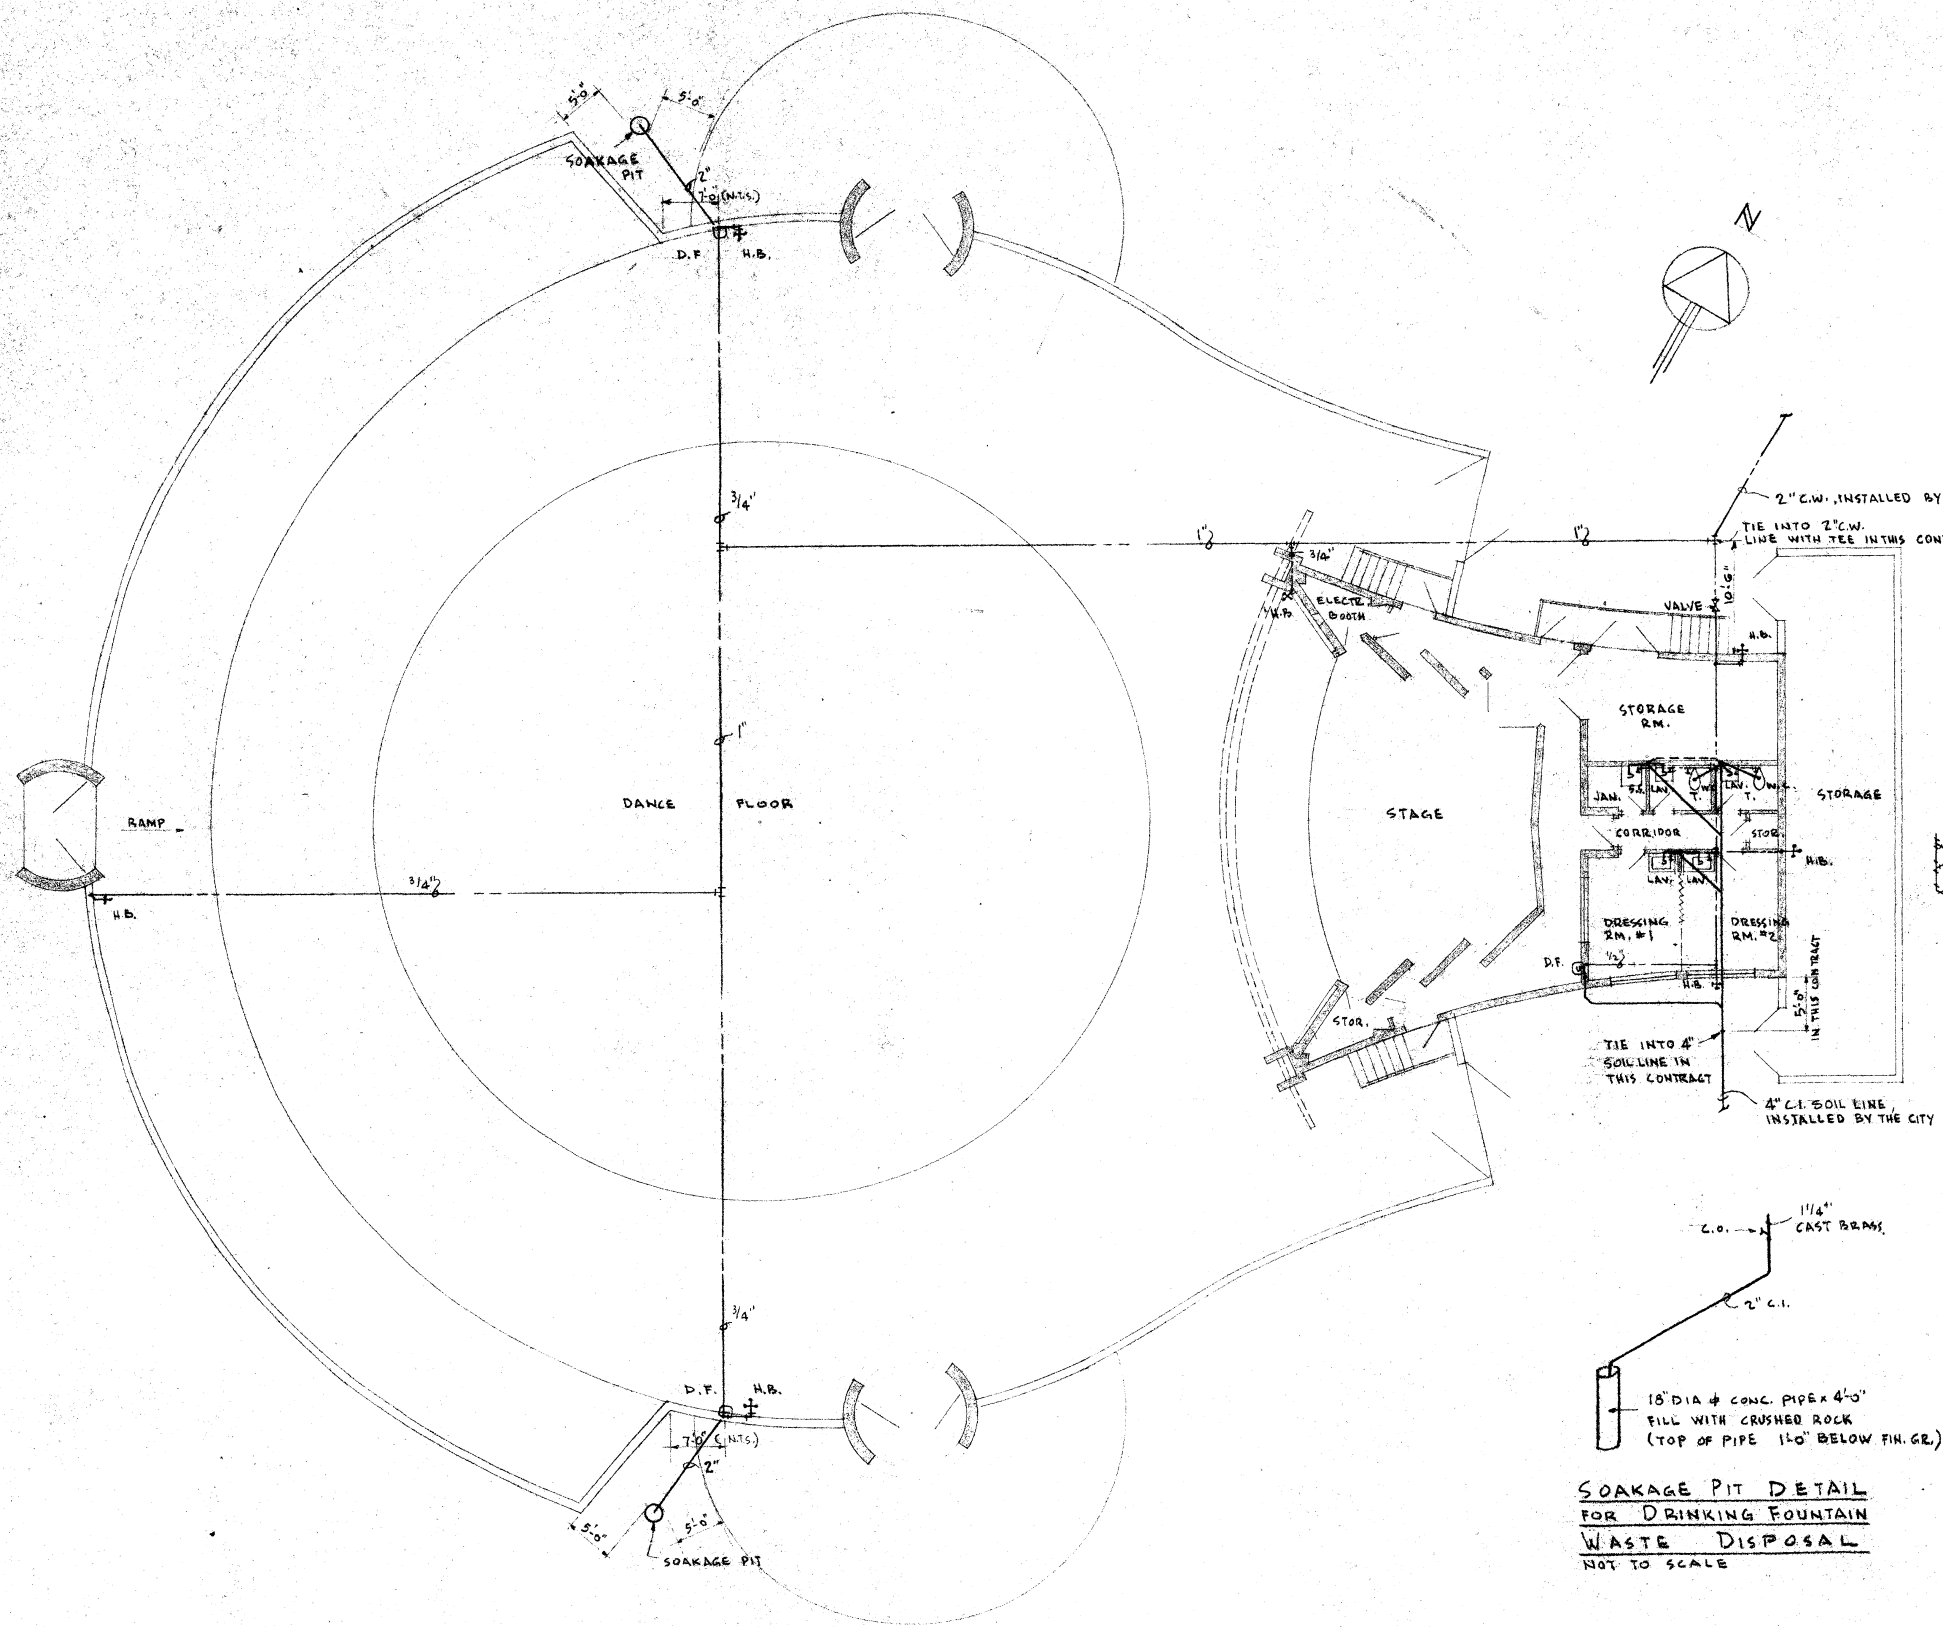


PLUMBING FLOOR PLAN
SCALE: 1/8" = 1'-0"

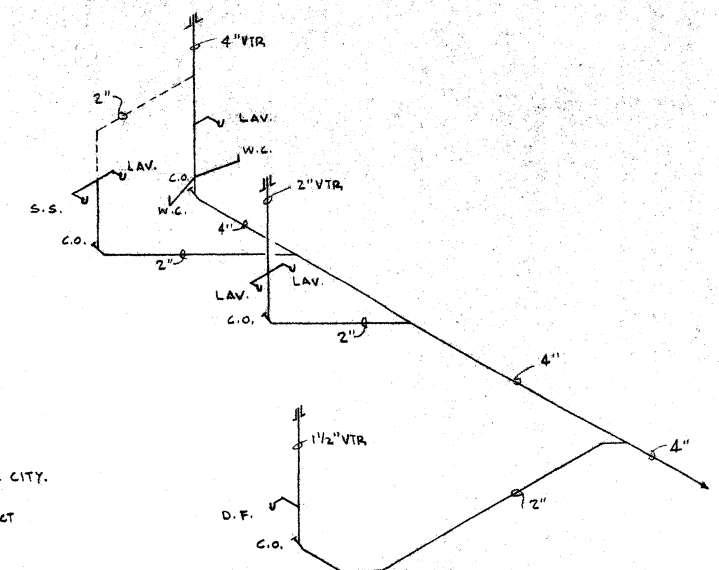

SOIL AND WASTE PIPING RISER DIAGRAM
NOT TO SCALE

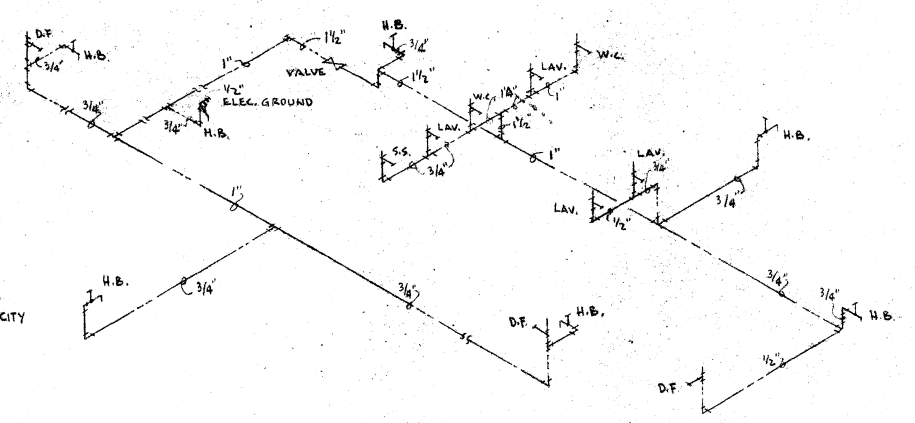

COLD WATER PIPING RISER DIAGRAM
NOT TO SCALE

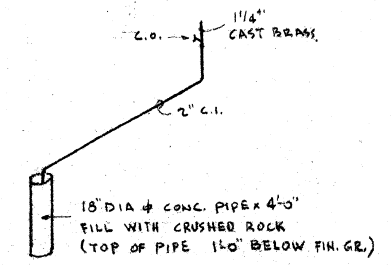


SOAKAGE PIT DETAIL
FOR DRINKING FOUNTAIN
WASTE DISPOSAL
NOT TO SCALE


JUL 3 1961

REVISION		DATE	DESCRIPTION
norman m. giller & associates ARCHITECTS - ENGINEERS 975 ARTHUR GODFREY ROAD MIAMI BEACH, FLA.			
PLUMBING PLAN & RISER DIAGRAM		NORTH SHORE COMMUNITY CENTER MIAMI BEACH, FLORIDA.	
COMM. NO.	DATE	DRAWN	SHEET NO.
61105	6-23-1961	EM	P-13
PRINTING RECORD		CHECKED	TOTAL SHEETS
		APPROVED	15


B.G.-G.K.

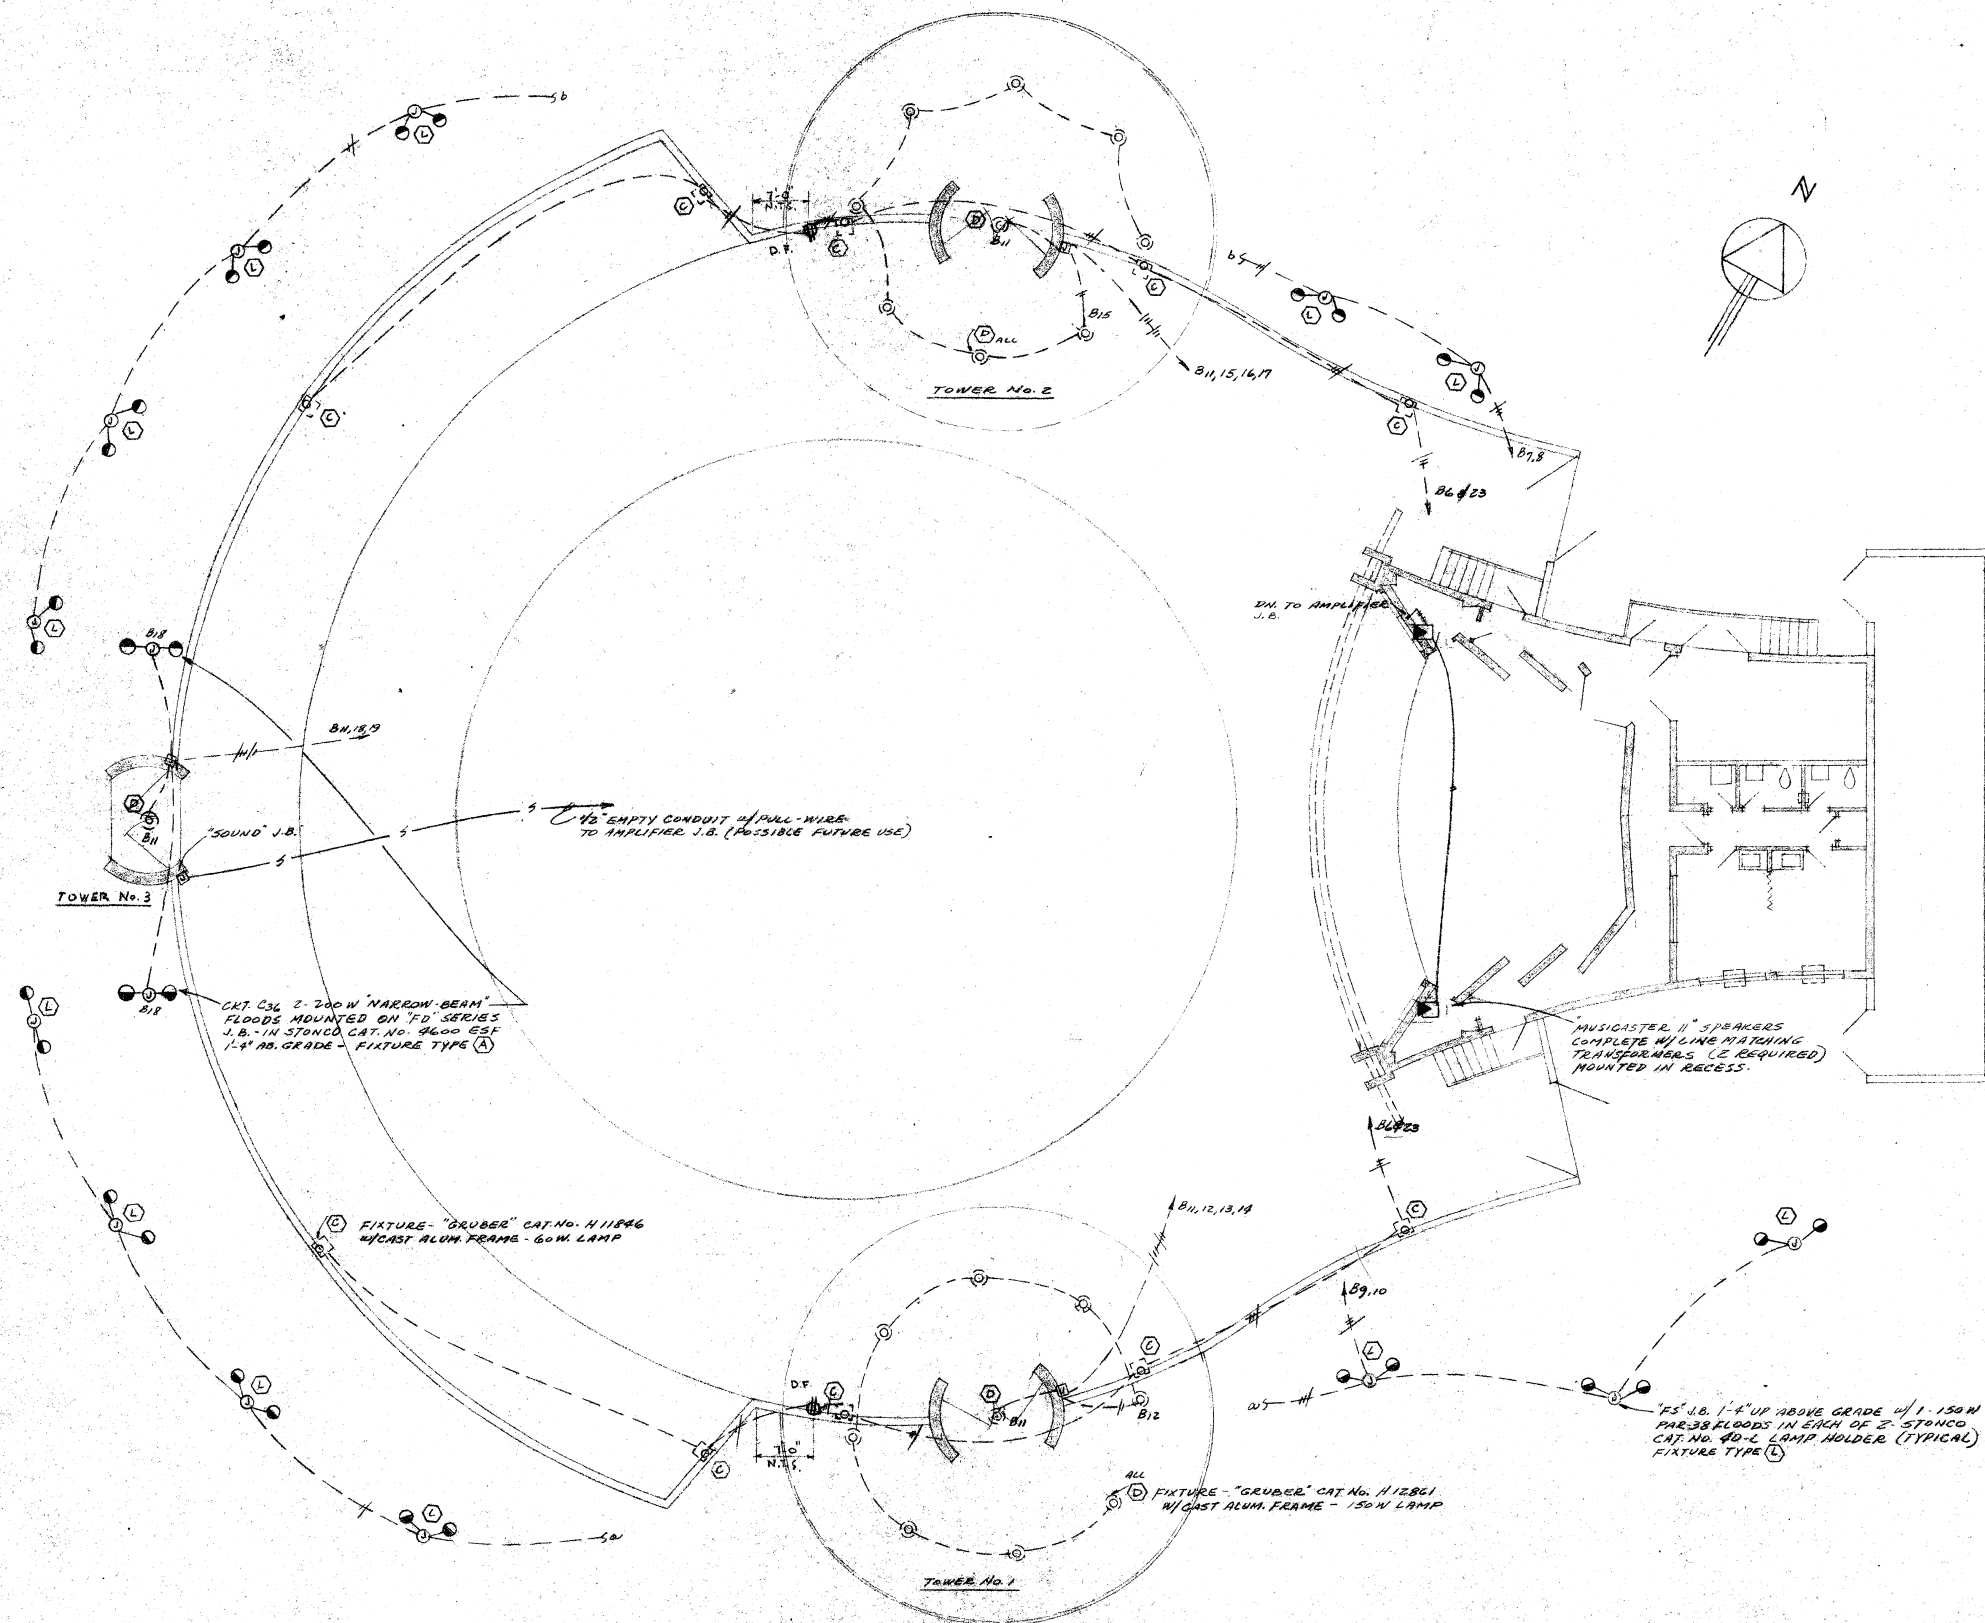

EXTERIOR ELECTRICAL & SOUND LAYOUT

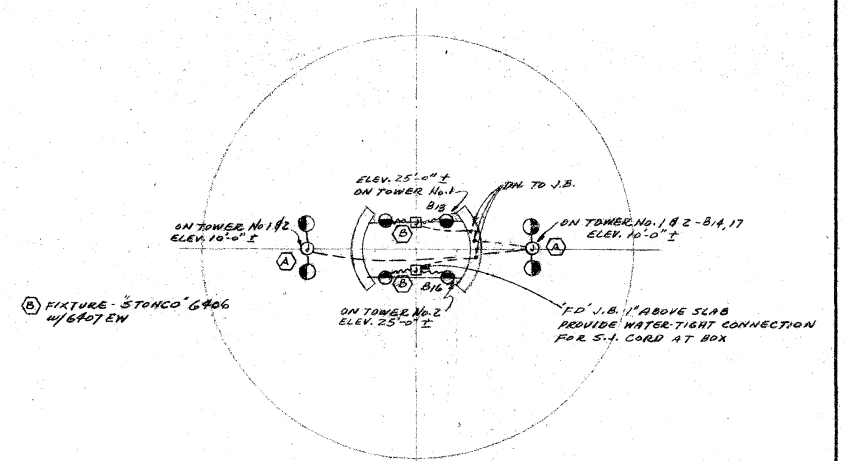

TOWER NO. 1 & NO. 2

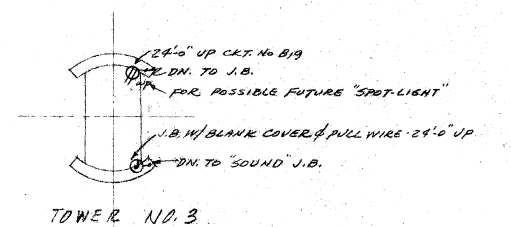

TOWER NO. 3

LEGEND

- ⊕ DUPLEX RECEPTACLE, 3 WIRE GROUNDING TYPE "SPECIFICATION" GRADE
- ⊞ JUNCTION BOX - CROUSE/HINDS TYPE RSM SERIES
- ⊙ MICROPHONE OUTLET - 10 AMP TWIST-LOCK RECEPTACLE - 3 WIRE
- ⊞ JUNCTION BOX
- ⊕ SWITCH - SINGLE POLE, "SPECIFICATION" GRADE
- ⊕ SWITCH - 3 WAY
- ⊕ POWER OUTLET - 20 AMP, GROUNDING TYPE - A.C. UNIT
- ⊕ LIGHTING FIXTURE, TYPE AS INDICATED
- ⊕ LIGHTING FIXTURE, BRACKET MOUNTED, TYPE AS INDICATED
- ⊕ SWITCH, SINGLE POLE, FAN CONTROL w/ THERMO OVERLOAD - 5'-0" UP
- ⊕ RECESSED LIGHTING FIXTURE, TYPE AS INDICATED
- ⊕ FLOOD LIGHT - MOUNTING & TYPE AS INDICATED
- CONDUIT "RUN" UNDERGROUND OR IN SLAB
- CONDUIT "RUN" IN WALL OR CEILING
- CONDUIT "RUN" TO PANEL, SLANT LINES INDICATE NO. OF CONDUCTORS
- ⊕ FIXTURE TYPE AS NOTED
- ⊕ FLUORESCENT FIXTURE, TYPE AS INDICATED

JUL 3 1961

REVISION		DATE		DESCRIPTION		BY
norman m. giller & associates ARCHITECTS - ENGINEERS 975 ARTHUR GODFREY ROAD MIAMI BEACH, FLA.						
EXTERIOR ELECTRICAL & SOUND LAYOUT; LEGEND				NORTH SHORE COMMUNITY CENTER MIAMI BEACH, FLORIDA		
COMM. NO.	DATE	DRAWN	CHECKED	APPROVED	SHEET NO.	
61105	6-23-1961	525	525		E-14	
PRINTING RECORD				TOTAL SHEETS 15		

36.61K

