

**LEGEND:**

- R/W LINE / PROPERTY LINE
- CENTER LINE
- EXISTING WATER MAIN LINE
- EXISTING SAN. SEW. MAIN LINE
- EXISTING WATER VALVE
- EXISTING LINE TO BE ABANDONED
- PROP. SAN. SEW. MANHOLE



**LIST OF QUANTITIES**

EXIST. 8" SAN SEWER MAIN TO BE ABANDONED = 436.0'  
 PROP. 8" SAN SEWER MAIN = 402.0'  
 TOTAL NUMBER OF PROP. SAN SEW MANHOLE = 4  
 TOTAL NUMBER OF PROP. 8" X 8" WTE = 1

**Sunshine**  
 Call 811 or www.sunshine11.com two full business days before digging to have utilities located and marked.  
 (Red color requires color reference only)

**OCEAN ENGINEERING**  
 CIVIL ENGINEERING CONSULTANTS  
 1000 N. MILITARY AVE., SUITE 100  
 WEST PALM BEACH, FL 33411  
 PHONE: 561-833-8800  
 FAX: 561-833-8801  
 WWW.OCEANENGINEERING.COM

<p>ENGINEER OF RECORD</p> <p>WALTER M. LUGO, P.E.          FLORIDA PE LIC. No. 61747</p>		<p><b>NORTH BEACH</b></p> <p><b>OUTSIDE CONCEPTUAL SEWER PLAN</b></p>		<table border="1"> <thead> <tr> <th>No.</th> <th>Date</th> <th>Revision Description</th> </tr> </thead> <tbody> <tr><td> </td><td> </td><td> </td></tr> <tr><td> </td><td> </td><td> </td></tr> <tr><td> </td><td> </td><td> </td></tr> <tr><td> </td><td> </td><td> </td></tr> </tbody> </table>	No.	Date	Revision Description												
No.	Date	Revision Description																	
<p>Date: Apr 22, 2019</p> <p>Scale: AS SHOWN</p> <p>Designed By:</p> <p>Drawn By:</p> <p>Checked By:</p> <p>CAD File:</p> <p>Project No.: 2019-0321-12</p> <p>Dwg. No.:</p> <p>Sheet: C-100</p>		<p>Call 811 or www.sunshine11.com two full business days before digging to have utilities located and marked.          (Red color requires color reference only)</p>																	

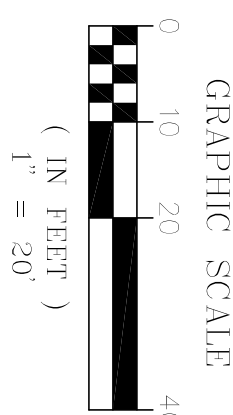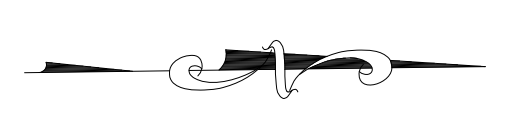

**LEGEND:**

- R/W LINE / PROPERTY LINE
- CENTER LINE
- EXISTING WATER MAIN LINE
- EXISTING SAN. SEW. MAIN LINE
- EXISTING WATER VALVE
- EXISTING LINE TO BE ABANDONED
- PROP. SAN. MANHOLE

**LIST OF QUANTITIES**


EXIST. 6" CI WATER MAIN TO BE ABANDONED = 177.0'  
 PROP. 6" WATER MAIN = 215.0'  
 TOTAL NUMBER OF PROP. 6" CAP = 3

**Sunshine**  
 Call 811 or www.unearth1.com two full business days before digging to have utilities located and marked.  
*Check owner response code before digging*

**OCEAN ENGINEERING**  
 CIVIL ENGINEERING CONSULTANTS  
 10000 W. UNIVERSITY BLVD., SUITE 100  
 WEST PALM BEACH, FLORIDA 33411  
 PHONE: 561-833-8800  
 FAX: 561-833-8801  
 WWW.OCEANENGINEERING.COM

No.	Date	Revision Description

ENGINEER OF RECORD  
  
 WALTER M. LUGO, P.E.  
 FLORIDA PE LIC. No. 61747




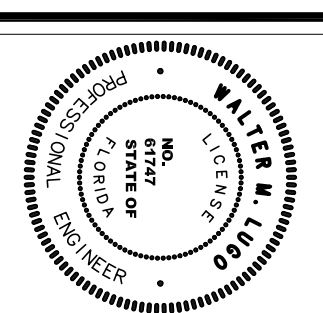


**NORTH BEACH**  
**OUTSIDE CONCEPTUAL WATER PLAN**

Date: Apr 22, 2019  
 Scale: AS SHOWN  
 Designed By:  
 Drawn By:  
 Checked By:  
 CAD File:  
 Project No.: 2019-0321-12  
 Dwg. No.:  
 Sheet: C101




- LEGEND:**
- R/W LINE / PROPERTY LINE
  - - - CENTER LINE
  - WTR EXISTING WATER MAIN LINE
  - S.S. EXISTING SAN. SEW. MAIN LINE

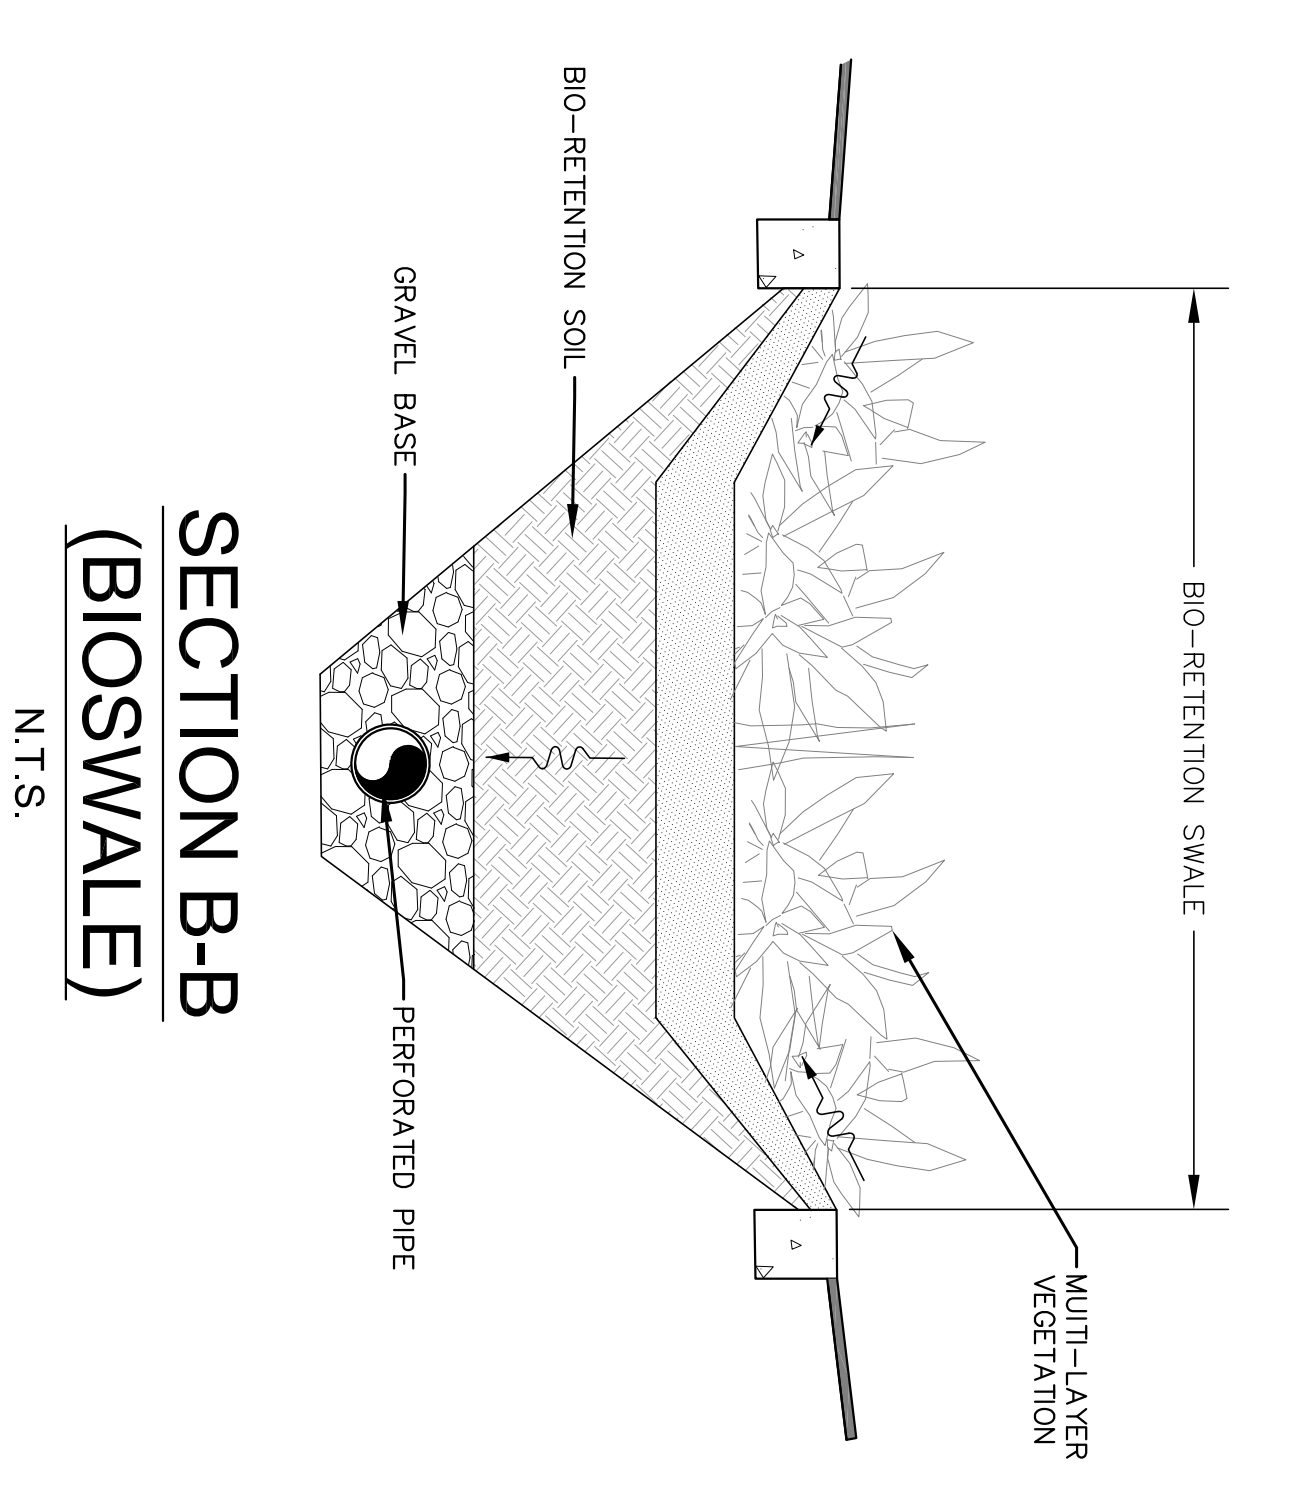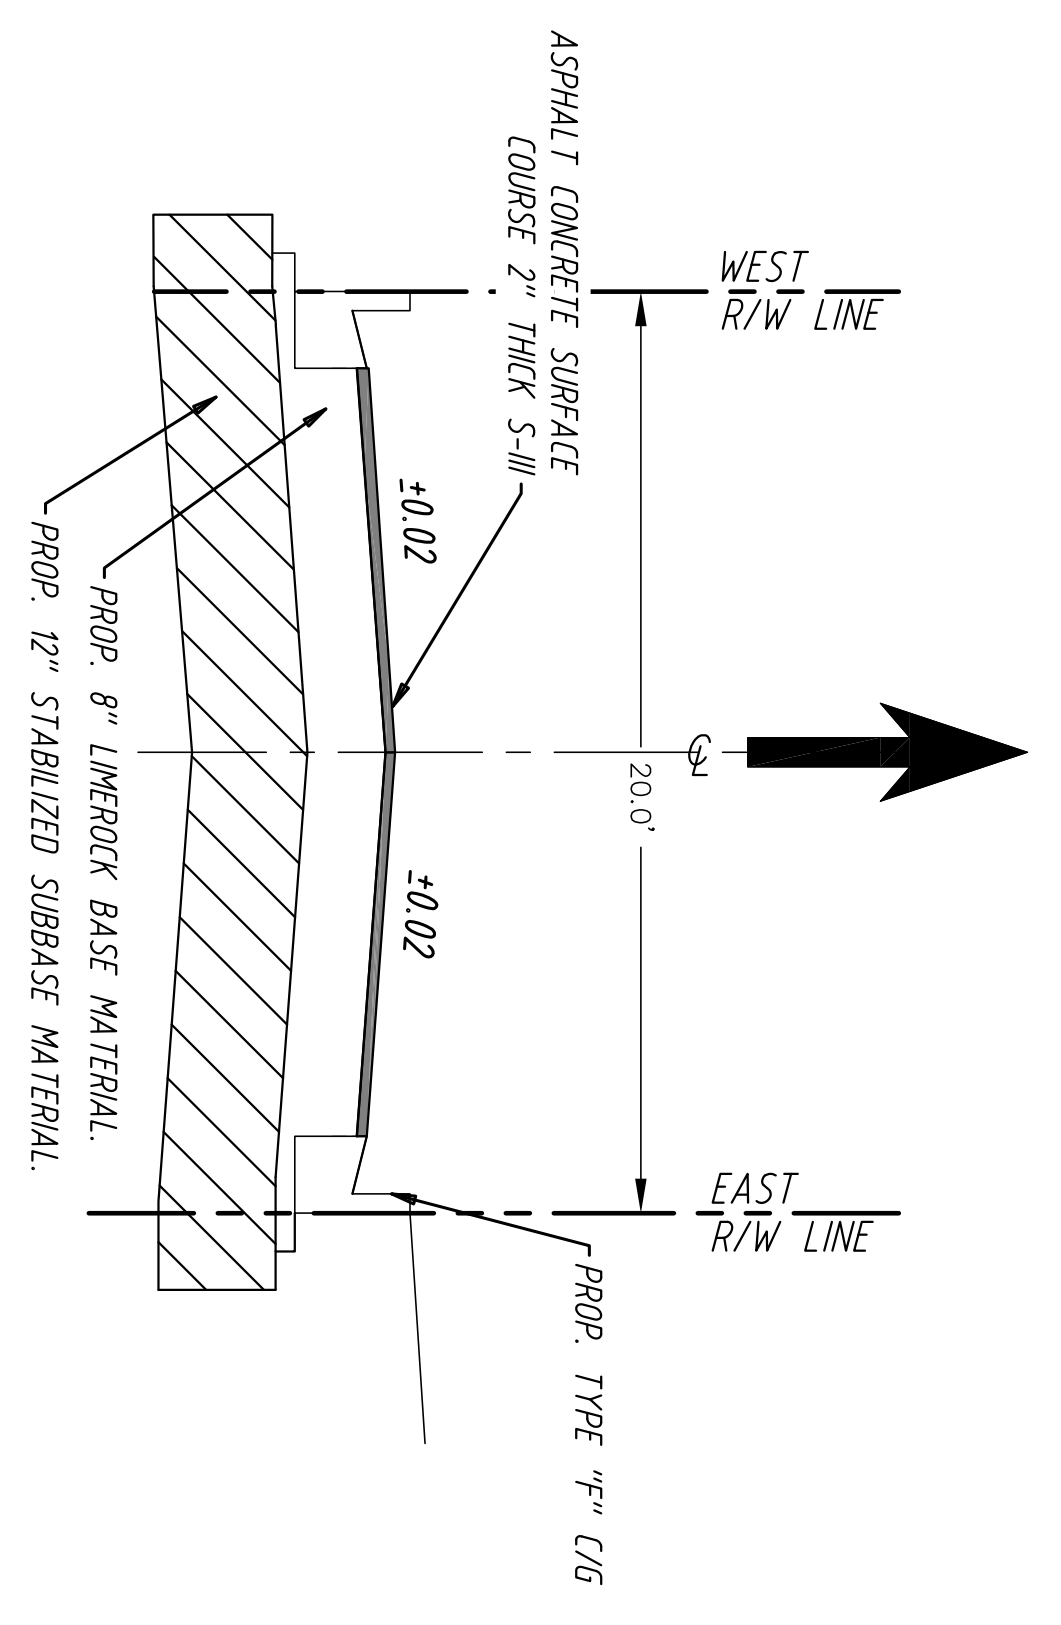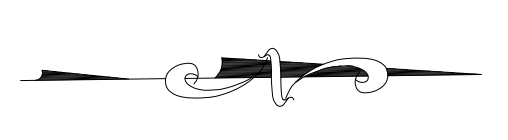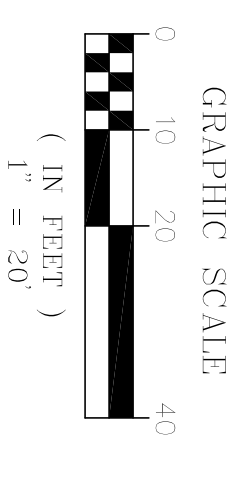

No.	Date	Revision Description

**NORTH BEACH**  
**CONCEPTUAL PAVING GRADING AND DRAINAGE PLAN**

ENGINEER OF RECORD  
  
WALTER M. LUGO, P.E.  
FLORIDA PE LIC. No. 61747

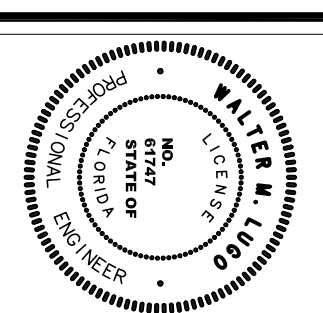

Date: Apr 22, 2019  
Scale: AS SHOWN  
Designed By:  
Drawn By:  
Checked By:  
CAD File:  
Project No.: 2019-0321-12  
Dwg. No.:  
Sheet: C200

**Sunshine**  
Call 811 or www.sunshine11.com two full business days before digging to have utilities located and marked.  
Check owner response code before digging.

