

PERMIT
SET

SIGNED BY:
ADAM M. ALABEIA
Florida Registered Engineer
No. 0045130

Revisions

11	CITY OF MIAMI BEACH PERMIT COMMENTS	08/26/2016
10	UNDERGROUND UTILITIES & COLUMN RELOCATION	05/30/2016
9	REVISIONS	9/11/2015
8	REVISIONS	07/13/2015
7	REVISIONS	11/26/2014
6	REVISIONS	11/26/2014
5	REVISIONS	11/26/2014
4	REVISIONS	11/26/2014
3	REVISIONS	11/26/2014
2	REVISIONS	11/26/2014
1	REVISIONS	11/26/2014
NO	REVISIONS	11/26/2014


Sheet Information	
Date	Issued: September 4, 2014
Job Number	01457-A
Drawn	DOA
Checked	JAC
Approved	AJA

4TH FLOOR
FRAMING PLAN

Sheet

S04-04

Copyright © 2013 Perkins+Will

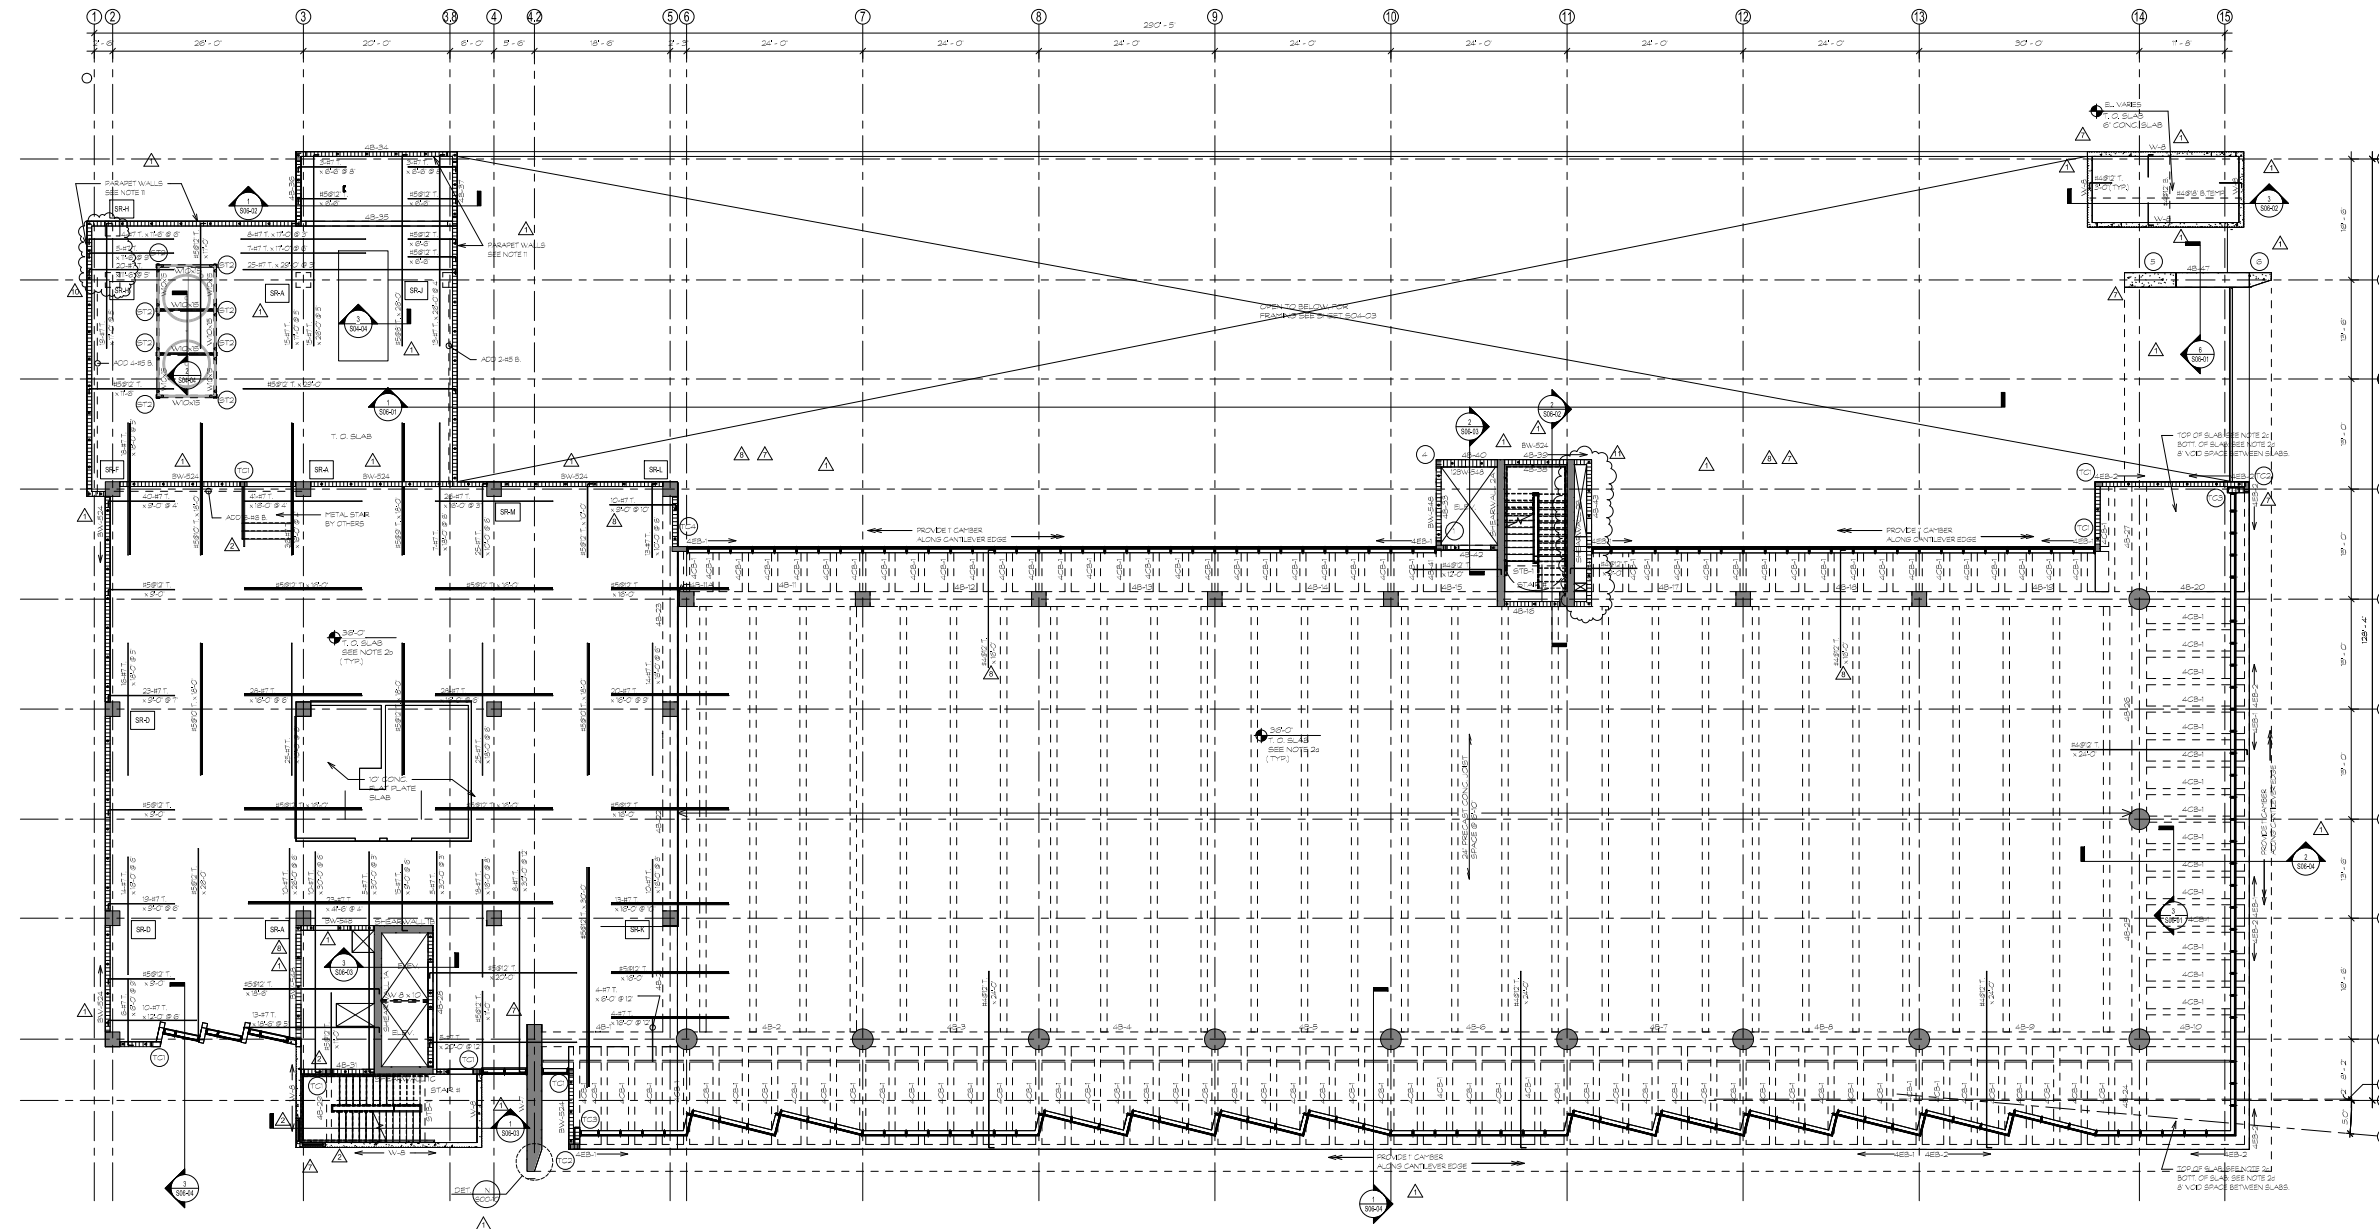


4TH FLOOR FRAMING PLAN

1/8" = 1'-0"


PLAN NOTES

1. TOP OF SLAB ELEVATION = 280.0' (+/-) 0.1' NVD. TYPICAL, UNLESS OTHERWISE NOTED AS THIS.
2. 1/2" VERTICAL.
3. 4" CONCRETE SLAB REINFORCED WITH #4 @ 12" O.C. PERPENDICULAR TO JOINT AND #3 @ 12" O.C. PARALLEL TO JOINTS. PRECAST/PRESTRESSED CONCRETE JOINTS AND SPINDLES ARE SHOWN ON PLANS. JOINT MANUFACTURER TO DESIGN JOINT FOR ADDITIONAL LOAD DUE TO BLOCK WALL. TYPICAL UNLESS OTHERWISE NOTED.
4. 10" CONCRETE SLAB PLATE BOTTOM REINFORCING SHALL COMPLY WITH EACH WAY REINFORCING BAR SHOWN ON PLANS. AS SOLID LINES ARE TOP BARS AND BARS SHOWN AS CHAINED LINES ARE BOTTOM BARS. BOTTOM BARS UNLESS SPECIFICALLY SHOWN OTHERWISE, PLACE REINFORCING PARALLEL TO V-S DIRECTION IN COUNTERSLOPE.
5. 4" CONCRETE SLAB WITH #4 @ 12" O.C. EACH WAY BOTTOM.
6. 4" CONCRETE SLAB WITH #4 @ 12" O.C. EACH WAY BOTTOM.
7. COORDINATE ALL SLAB OPENINGS, SLURS AND DEPRESSIONS WITH ARCHITECTURAL AND OTHER TRADE DRAWINGS.
8. FOR GENERAL STRUCTURAL NOTES, REFER TO SHEET S04-01.
9. FOR COLUMN SCHEDULE, REFER TO SHEET S04-02.
10. FOR BEAM SCHEDULE, REFER TO SHEET S04-03.
11. FOR CONCRETE WALL SCHEDULE, REFER TO SHEET S04-04.
12. FOR UNITS, SCHEDULE, REFER TO SHEET S04-01.
13. 8" CONCRETE SLAB REINFORCED WITH #4 @ 12" O.C. EACH WAY. UNLESS OTHERWISE NOTED, COORDINATE ALL SLAB OPENINGS, SLURS AND DEPRESSIONS WITH ARCHITECTURAL AND OTHER TRADE DRAWINGS. TYPICAL UNLESS OTHERWISE NOTED.

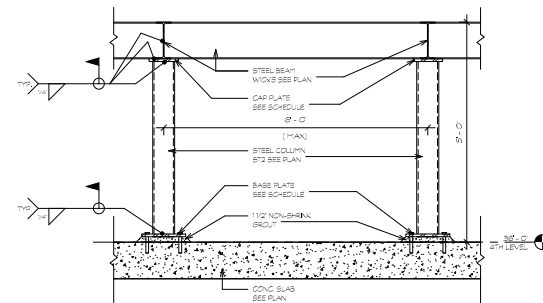

SECTION

3/4" = 1'-0"

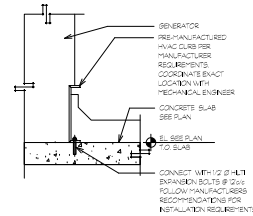

SECTION

3/4" = 1'-0"

PERMIT
SET

SIGNED BY:
AIDA M. ALBAISA
Florida Registered Engineer
No. 0045130

Revisions

11	CITY OF MIAMI BEACH PERMIT COMMENTS	08/26/2016
7	VE CHANGES	07/31/2015
2	QA/QC REVISIONS	11/26/2014
1	REVISED PERMIT COMMENTS	11/26/2014
NO	ISSUE	DATE


Sheet Information

Date	Issued: September 4, 2014
Job Number	01457-A
Drawn	DD
Checked	J.C.
Approved	A.A.

ROOF LEVEL
FRAMING PLAN


Sheet
S04-05

Copyright © 2013 Perkins+Will

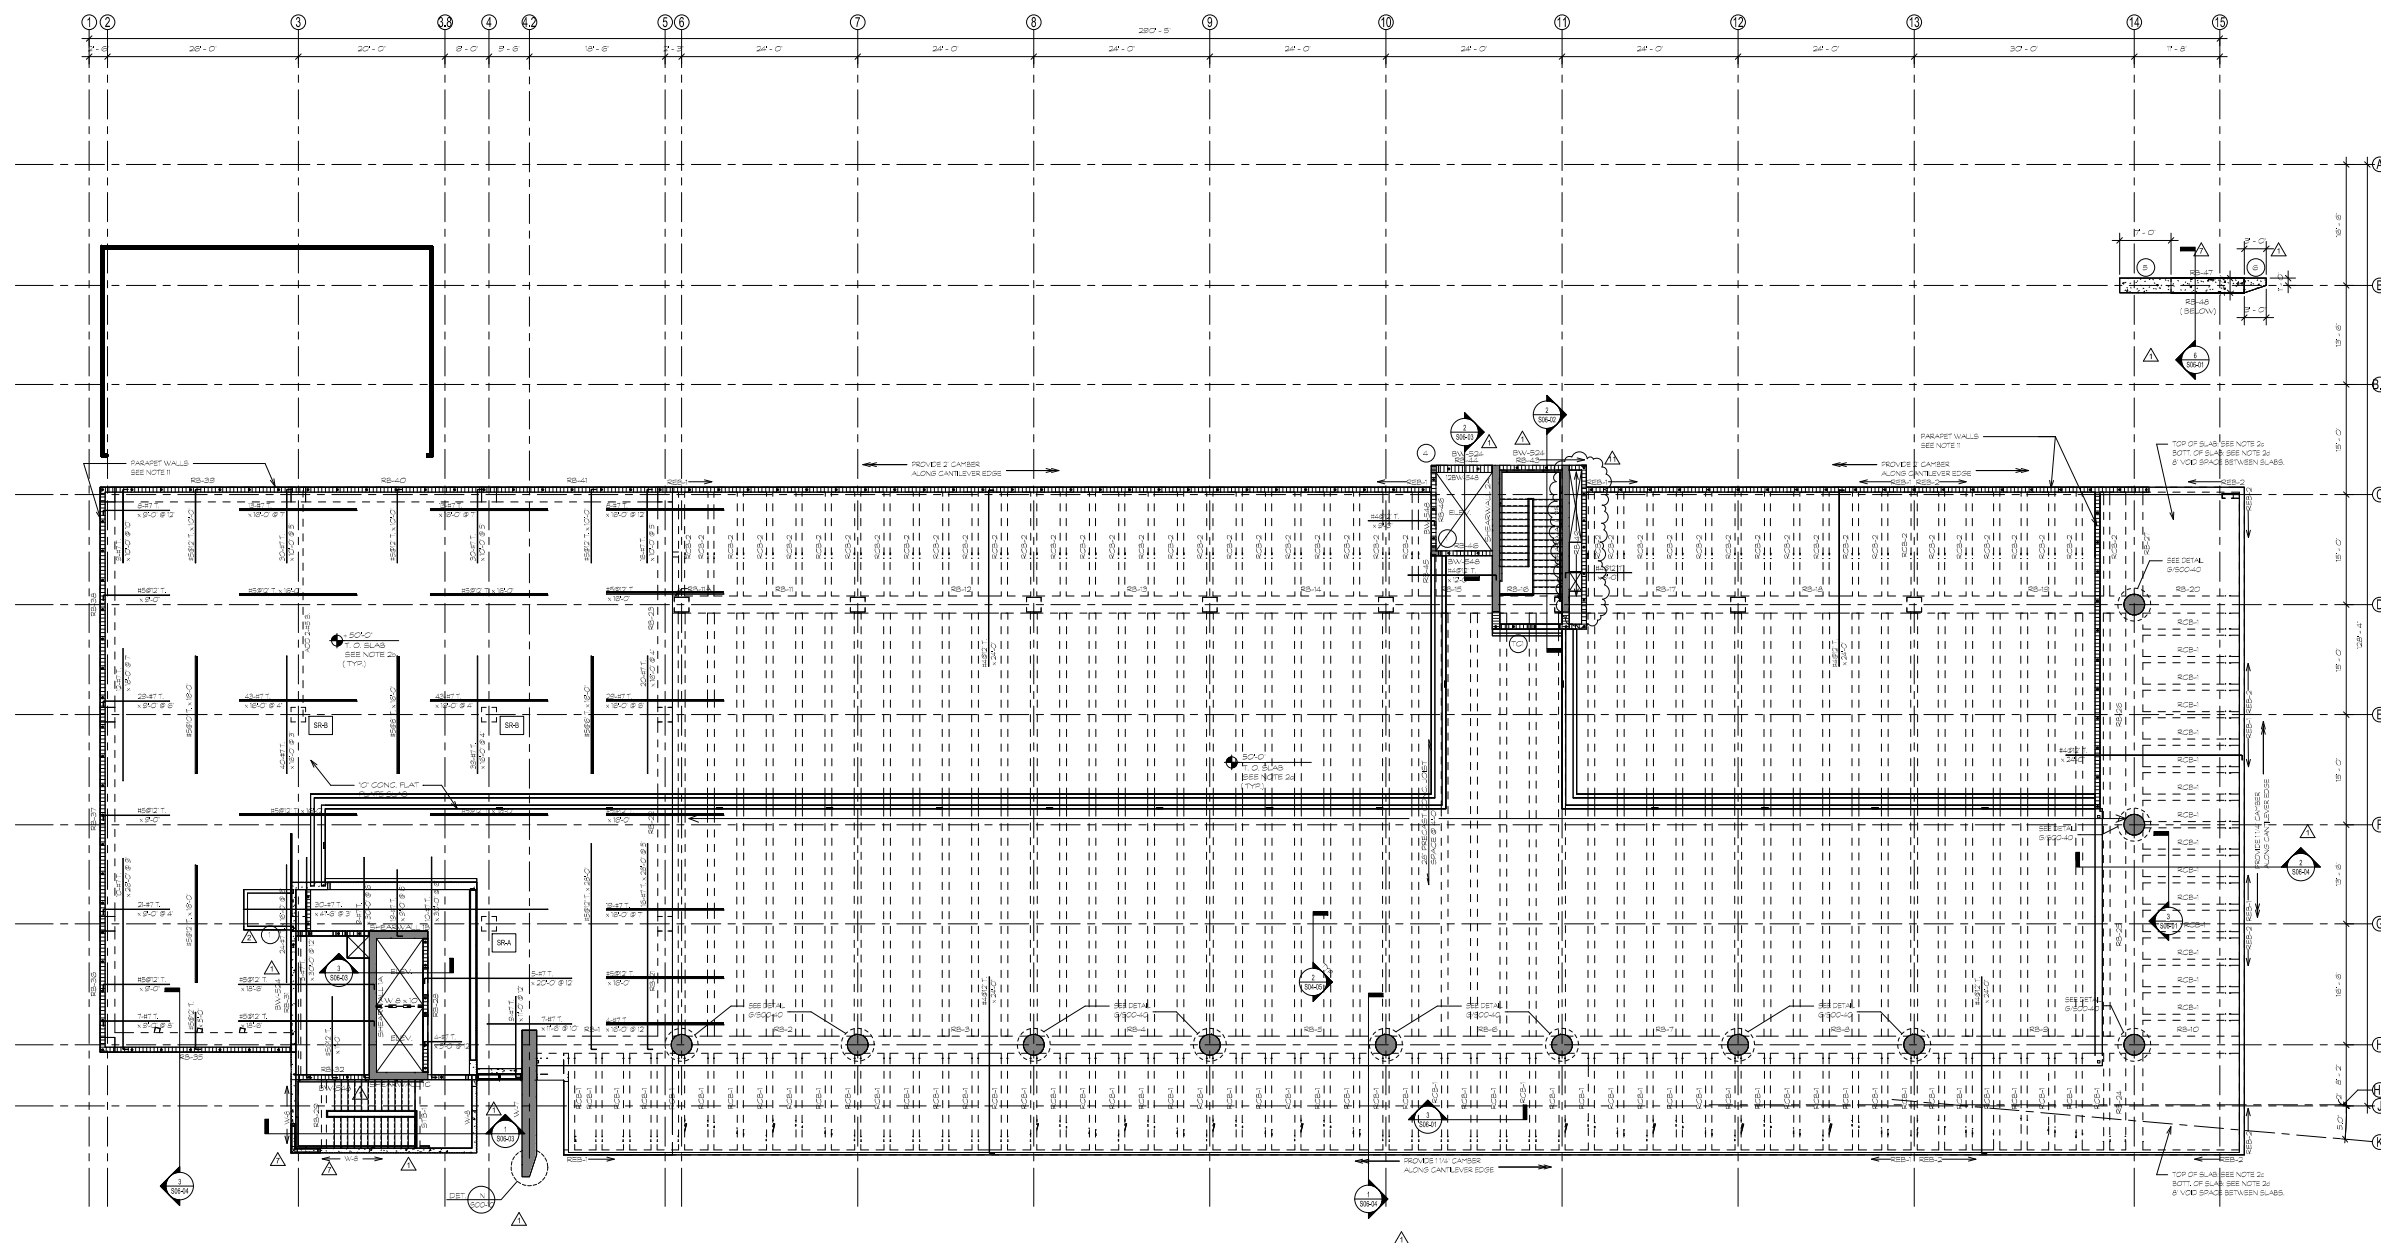

N  1 ROOF LEVEL FRAMING PLAN
1/8" = 1'-0"

1. TOP OF SLAB ELEVATION SHOWN AT (5/17) PERIODICAL INSPECTION UNLESS OTHERWISE NOTED. SEE NOTE 1.
2. SLAB NOTES
4. 8 IN. CONCRETE SLAB REINFORCED WITH 8 # 2 @ 12" O.C. PERPENDICULAR TO JOINTS AND 8 # 3 @ 24" O.C. JOINTS. REBAR PRESTRESSED CONCRETE (PCC) SHALL BE 4" MIN. THICK. REBAR SHALL BE 1/2" DIA. MIN. PERMANENTLY PLACED TO BE EXPOSED TO JOINTS FOR ADDITIONAL LOAD DUE TO BLOCK WALL THICKNESS UNLESS OTHERWISE NOTED.
10. CONCRETE FLAT SLAB BOTTOM THAT REINFORCING SHALL BE 4" MIN. THICK. EACH WAY REINFORCING SHALL BE 4" MIN. AS SOLID SLABS ARE TOP BARS AND BARS SHOWN AS DASHED LINES ARE BOTTOM BARS. BARS SHALL BE 1/2" DIA. MIN. PERMANENTLY PLACED REINFORCEMENT PARALLEL TO JOINTS DIRECTION IN BOTH DIRECTIONS.
6. CONCRETE SLAB MIN. SHEET EACH WAY BOTTOM.
3. CONCRETE SLAB MIN. SHEET EACH WAY BOTTOM.
3. COORDINATE ALL SLAB CHANGES, LINES AND DEPRESSIONS WITH ARCHITECTURAL AND OTHER TRADE DRAWINGS.
4. FOR GENERAL STRUCTURAL NOTES, REFER TO SHEET S-001.
5. FOR COLUMN SCHEDULE, REFER TO SHEET S-002.
6. FOR BEAM SCHEDULE, REFER TO SHEET S-003.
7. FOR CONCRETE SLAB SCHEDULE, REFER TO SHEET S-003.
8. FOR JOINTS SCHEDULE, REFER TO SHEET S-001.
9. WALL/RETAINING WALL NOTES
1. RETAINING WALL REINFORCED WITH 8 # 2 @ 12" O.C. IN SLAB. SEE PLANING POLARIZATION LINE AND POLAR COORDINATE LINE AND LOCATION WITH ARCHITECTURAL AND TRADE DRAWINGS UNLESS OTHERWISE NOTED.
10. WALL/RETAINING WALL NOTES
1. RETAINING WALL REINFORCED WITH 8 # 2 @ 12" O.C. IN SLAB. SEE PLANING POLARIZATION LINE AND POLAR COORDINATE LINE AND LOCATION WITH ARCHITECTURAL AND TRADE DRAWINGS UNLESS OTHERWISE NOTED.
11. RETAINING WALL REINFORCED WITH 8 # 2 @ 12" O.C. IN SLAB. SEE PLANING POLARIZATION LINE AND POLAR COORDINATE LINE AND LOCATION WITH ARCHITECTURAL AND TRADE DRAWINGS UNLESS OTHERWISE NOTED.
12. DETECTS SHEAR STIFF REINFORCING IN CONCRETE SLAB FOR PUNCHING SHEAR SEE DETAIL A ON SHEET S-003.

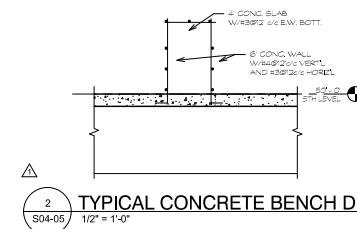

2 TYPICAL CONCRETE BENCH DETAIL
S04-05 1/2" = 1'-0"

PERMIT
SET

SIGNED BY:
APRIL M. ALBERA
Florida Registered Engineer
No. 0045130

Revisions

11	CITY OF MIAMI BEACH	09/26/2019
7	PERMIT COMMENTS	
7	REV CHANGES	07/31/2019
7	REVISED PERMIT	11/06/2019
NO	COMMENTS	
NO	DATE	

Sheet Information


Date	Issued: September 4, 2014
Job Number	01457-A
Drawn	DDA
Checked	JJC
Approved	AJA

Title

HIGH ROOF
FRAMING PLAN

Sheet

S04-06

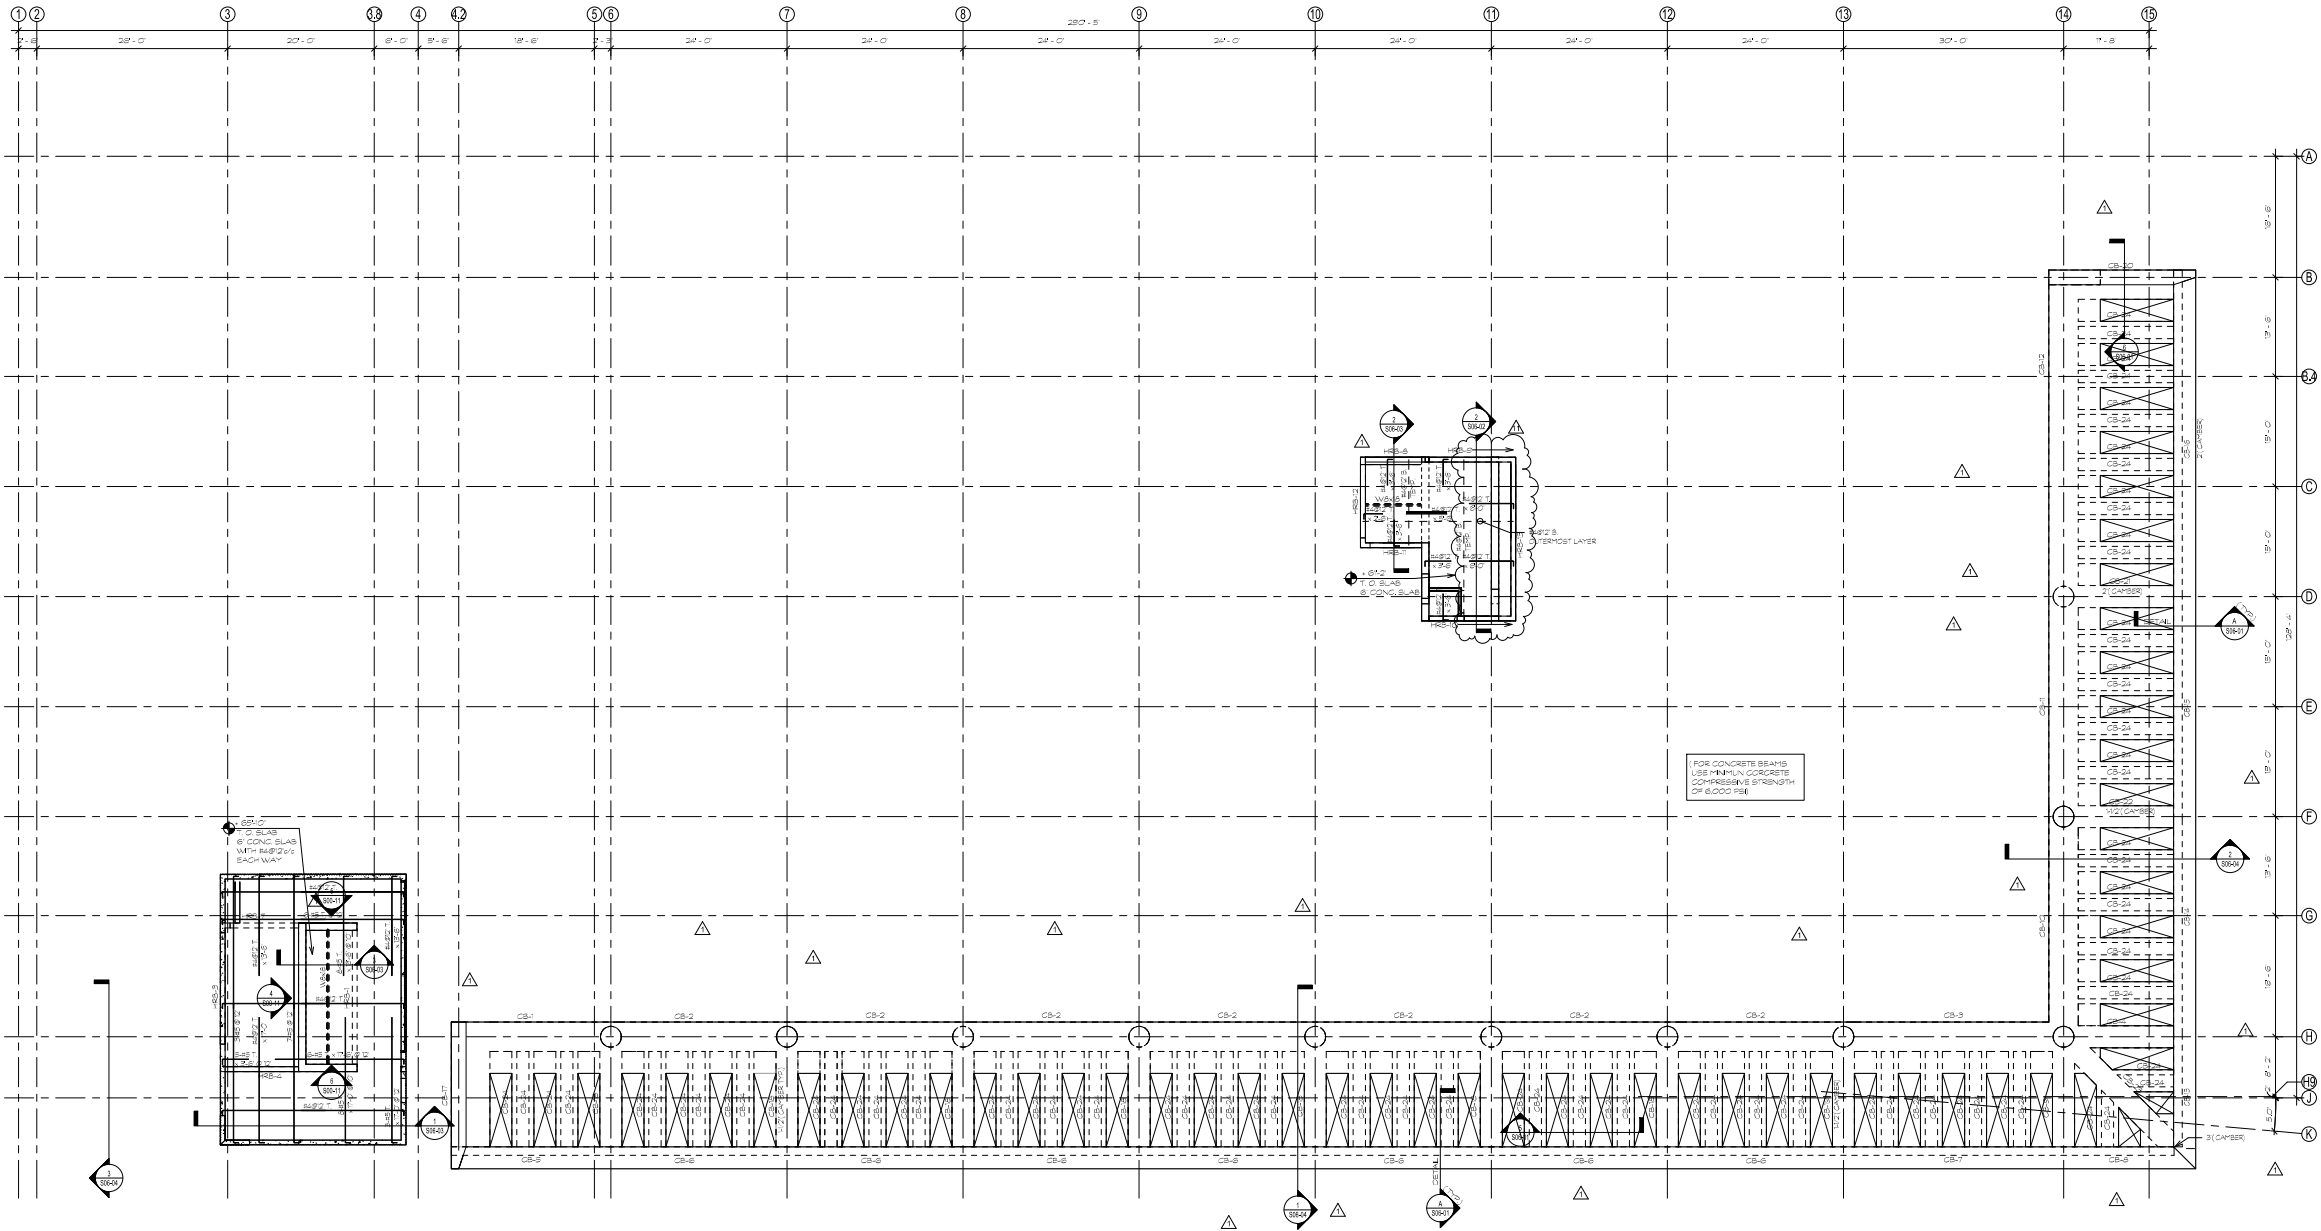

1 HIGH ROOF FRAMING PLAN
1/8" = 1'-0"

Crescent Heights
ton Road Miami Beach,
Florida, 33139

MILLER LEGG
6747 N Andrews Way
Ft. Lauderdale, FL 33309
1954.436.7000
1954.436.8664

LANDSCAPE
NO MILLER DESIGN STUDIO
12345 NE 6th Avenue Suite A
North Miami, FL 33161
1 305.895.0082
1 305.895.0083

DDA ENGINEERS, P.A.
4930 SW 74th Street
Miami, FL 33155
1 305.666.0711
1 305.666.5258

BR+A
2600 Douglas Road, Suite 301
Coral Gables, FL 33134
1 305.529.1515
1 305.529.1112

DESMAN ASSOCIATES
110 E. Broward Boulevard, Suite 1710
Fort Lauderdale, FL 33301
1 954.315.3824
1 954.315.3899

Revisions

11	CITY OF MIAMI BEACH PERMIT COMMENTS	08/26/2016
7	VE CHANGES	07/31/2015
1	REVISED PERMIT COMMENTS	11/26/2014
NO	ISSUE	DATE





Sheet Information

Date	Issued: September 4, 2014
Job Number	01457-A
Drawn	Author
Checked	Checker
Approved	Approver

Title

SECTIONS

Sheet
S06-01

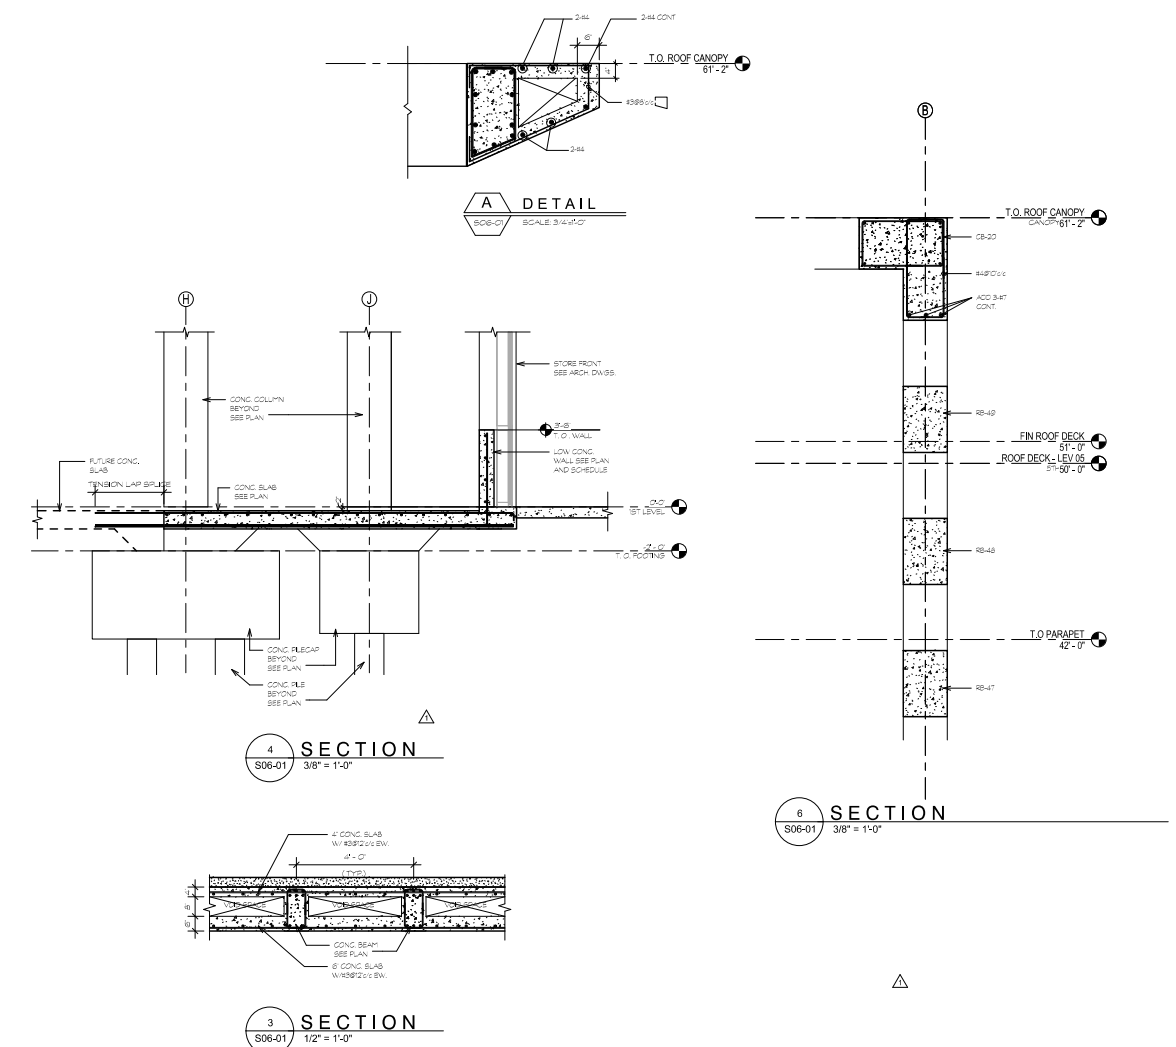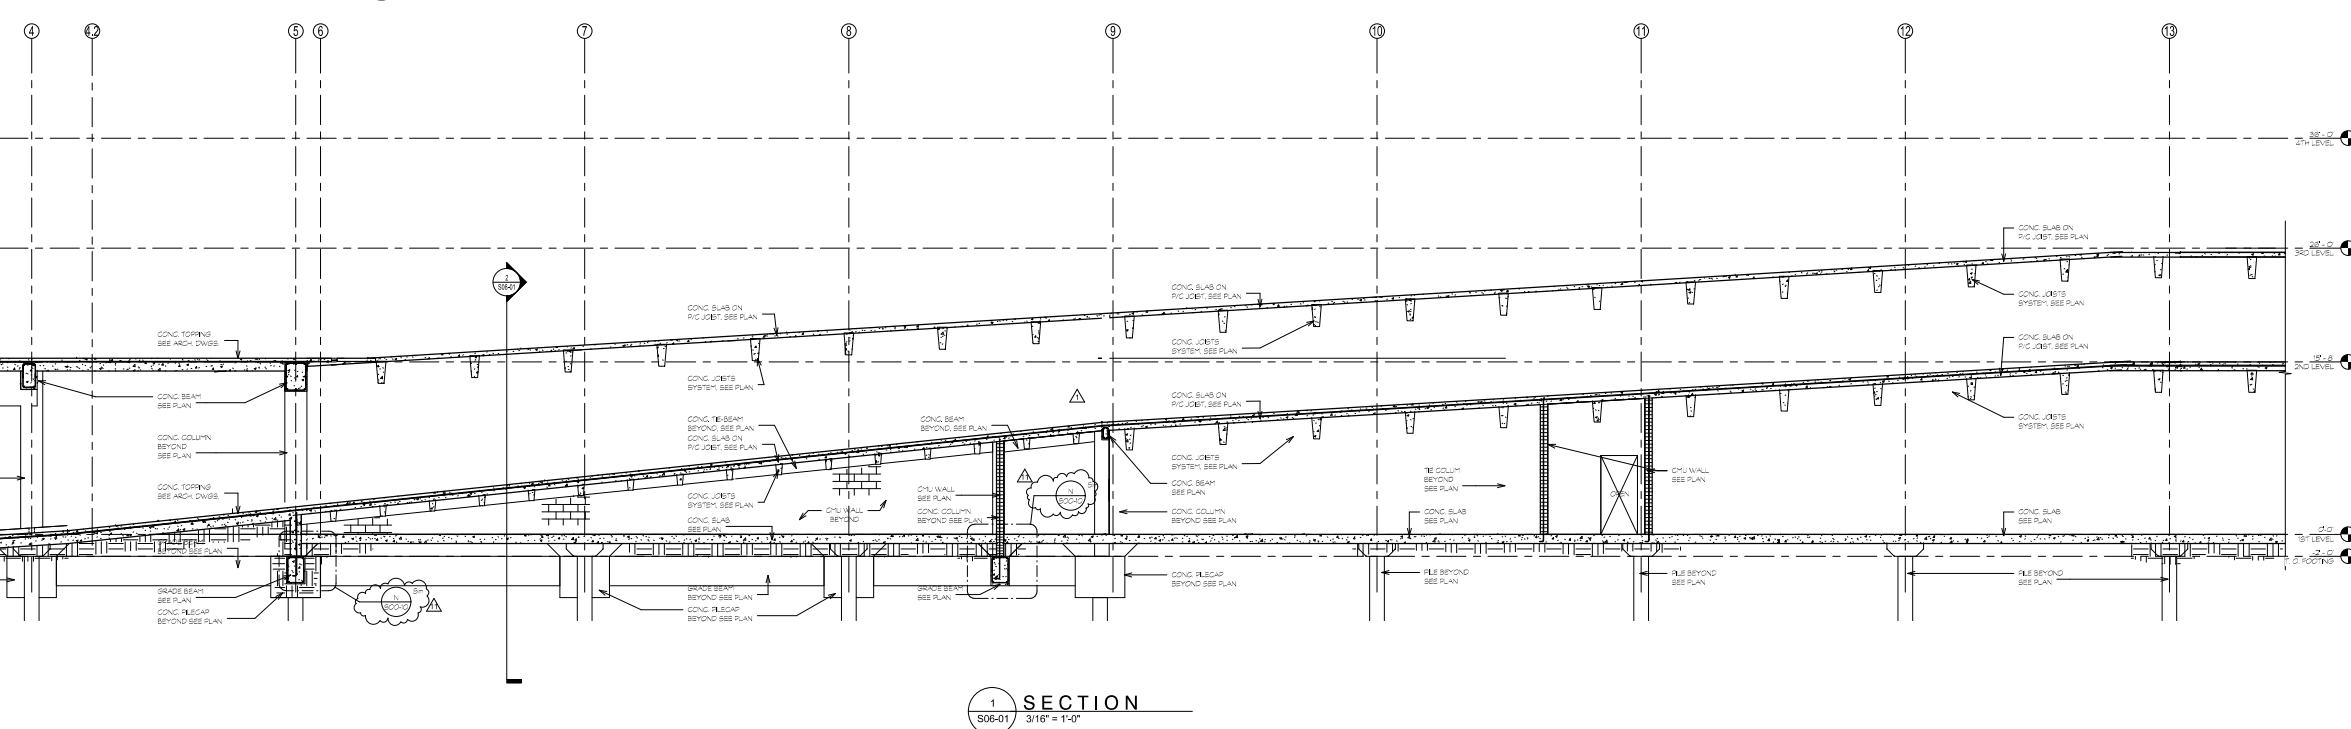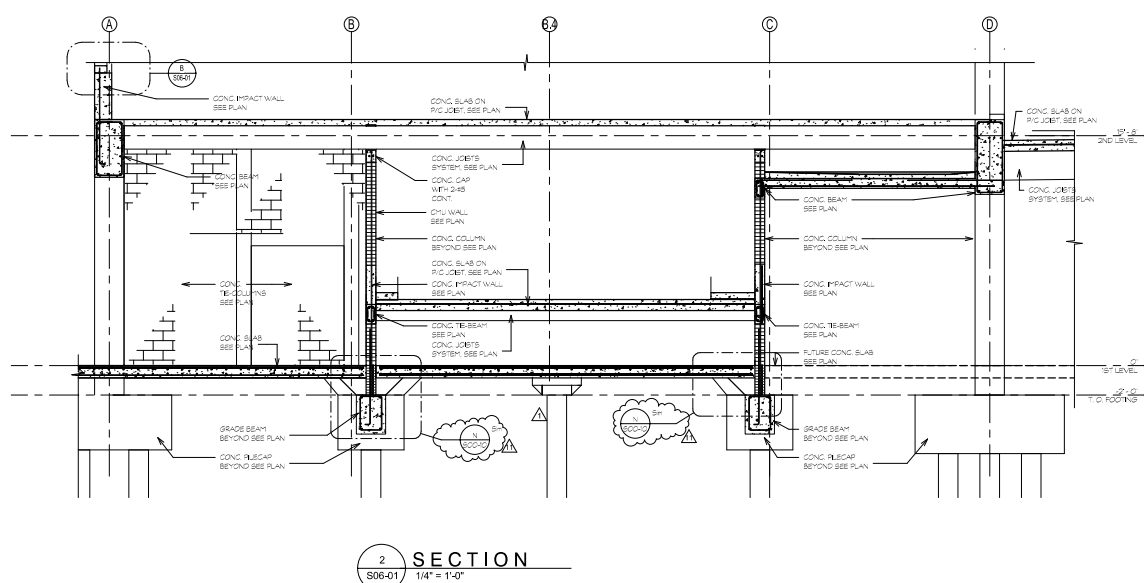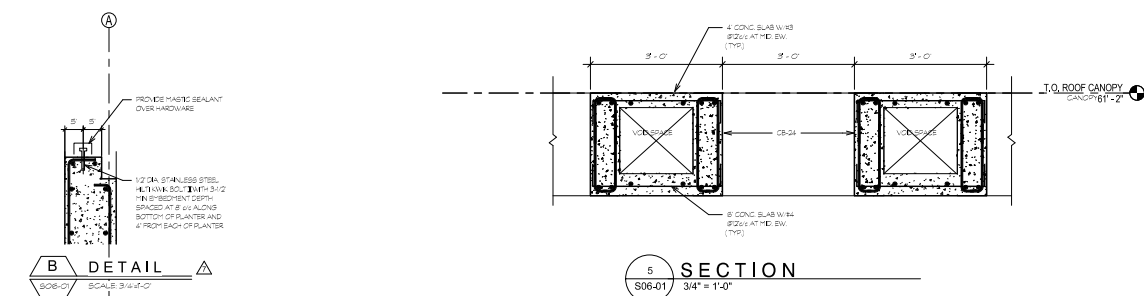

C:\Users\dd034\Documents\Revit Files\2014\5-A-709-ALTON\709-ALTON_STR_d0034.rvt

Crescent Heights

709 Alton Road Miami Beach,
Florida, 33139

CIVIL

MILLER LEGG

6747 N Andrews Way
Ft. Lauderdale, FL 33309
1954/436,7000
1954/436,8664

INDICATORS

SAVINO MILLER DESIGN STUDIO
12345 NE 6th Avenue Suite A
North Miami, FL 33161
1 305.895.0082
1 305.895.8082

STRUCTURE

DDA ENGINEERS, P.A.

4930 SW 74th Street
Miami, FL 33155
1305.866.0711
1305.866.5259

MEFVP

BR+A
2600 Douglas Road, Suite 301
Coral Gables, FL 33134
t 305.529.1515
f 305.529.1112

PARKING CONSULTANTS

DESMAN ASSOCIATES
110 E. Broward Boulevard, Suite 1710
Fort Lauderdale, FL 33301
1 954.315.9924
1 954.315.9899

Revised:
October 17, 2014

Revisions

7	VE CHANGES	07/31/2015
NO.	ISSUE	DATE

Sheet Information

Date	October 17, 2014
Job Number	01457-A
Drawn	Author
Checked	Checker
Approved	Approver


Title

SECTIONS

Sheet

S06-02

Copyright © 2013 Perkins+Will

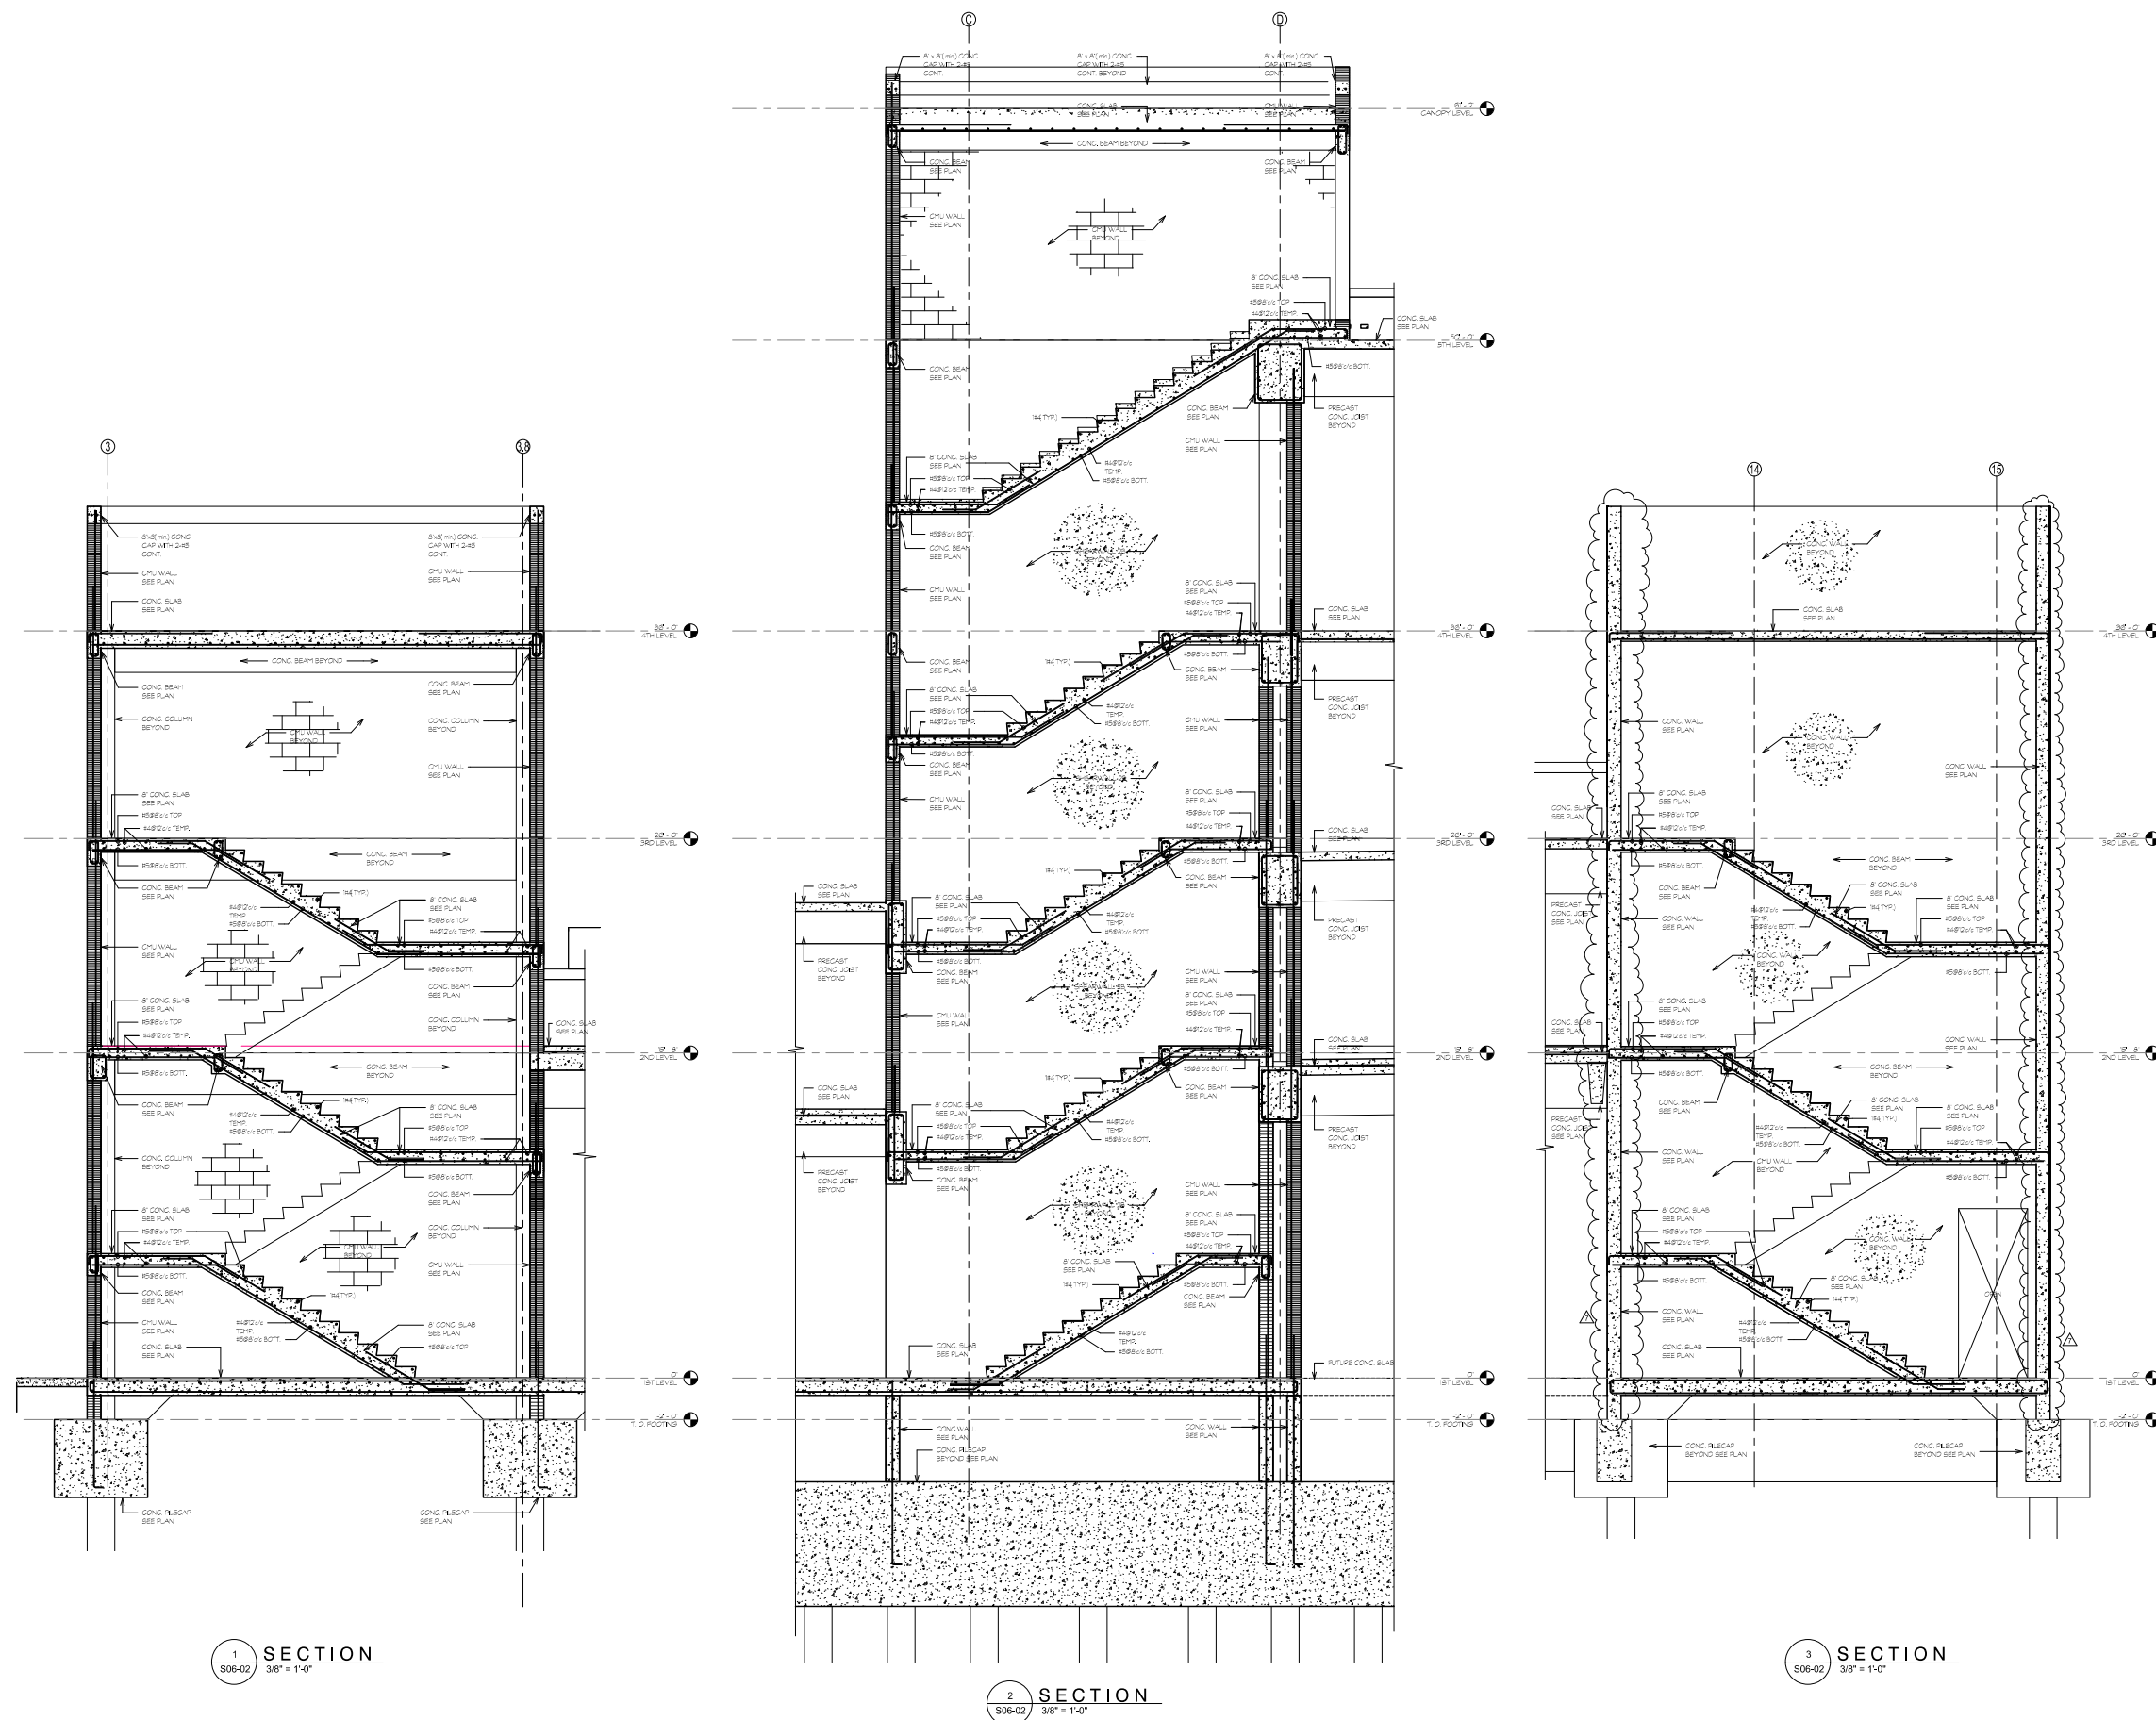

Crescent Heights
 n Road Miami Beach,
 Florida, 33139

MILLER LEGG
5747 N Andrews Way
Ft. Lauderdale, FL 33309
1954/436,7000
1954/418,8888

LANDSCAPE
SAVINO MILLER DESIGN STUDIO
12345 NE 8th Avenue Suite A
North Miami, FL 33161
1 305.895.9082
1 305.895.9083

STRUCTURE
DDA ENGINEERS, P.A.
4930 SW 74th Street
Miami, FL 33156
1 305.866.0711
1 305.866.5252

BR+A
2600 Douglas Road, Suite 301
Coral Gables, FL 33134
1-305-529-1515
1-305-529-1111

DESMAN ASSOCIATES
110 E. Broward Boulevard, Suite 1710
Fort Lauderdale, FL 33301
1 954.315.3924
1 954.315.3899

Revised:
October 17, 2014

Revisions

7	VE CHANGES	07/31/2015
2	QA/QC REVISIONS	11/26/14
1	REVISED PERMITS COMMENTS	11/26/14
NO	ISSUE	DATE

Sheet Information


Date	October 17, 2014
Job Number	01457-A
Drawn	Author
Checked	Checker
Approved	Approver

Title


SECTIONS

Sheet
S06-03


Copyright © 2013 Perkins+Will

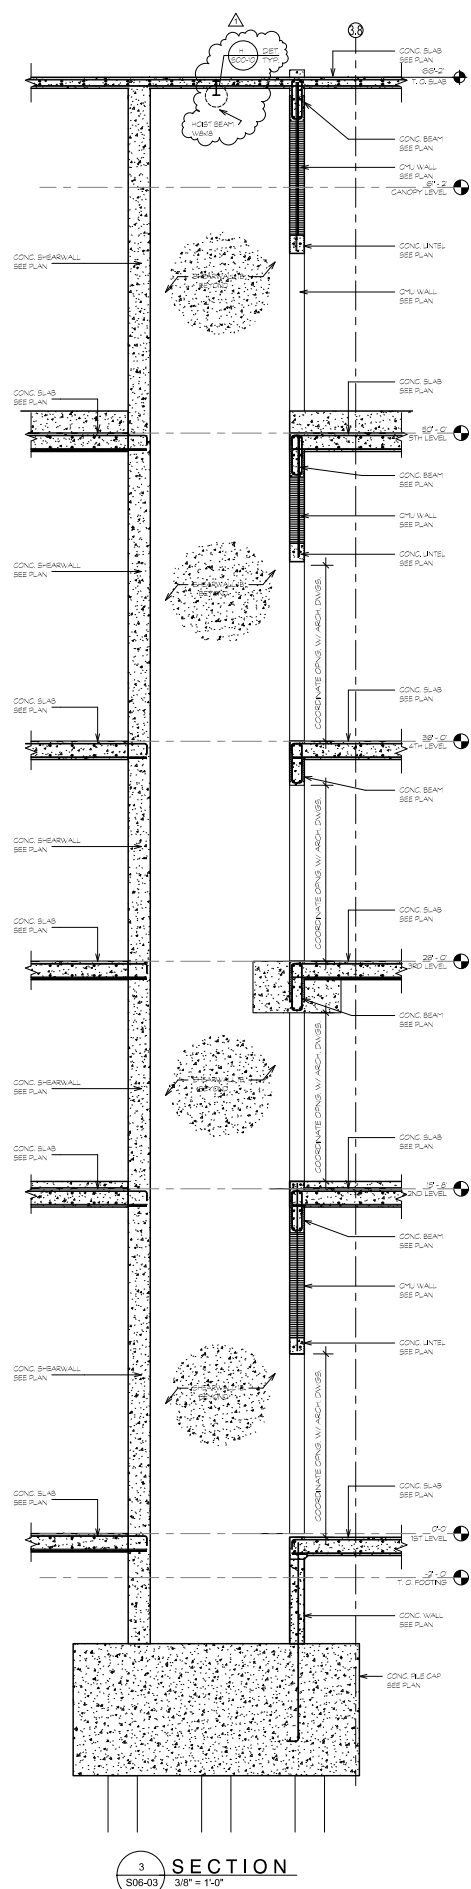

3 SECTION
S06-03 3/8" = 1'-0"

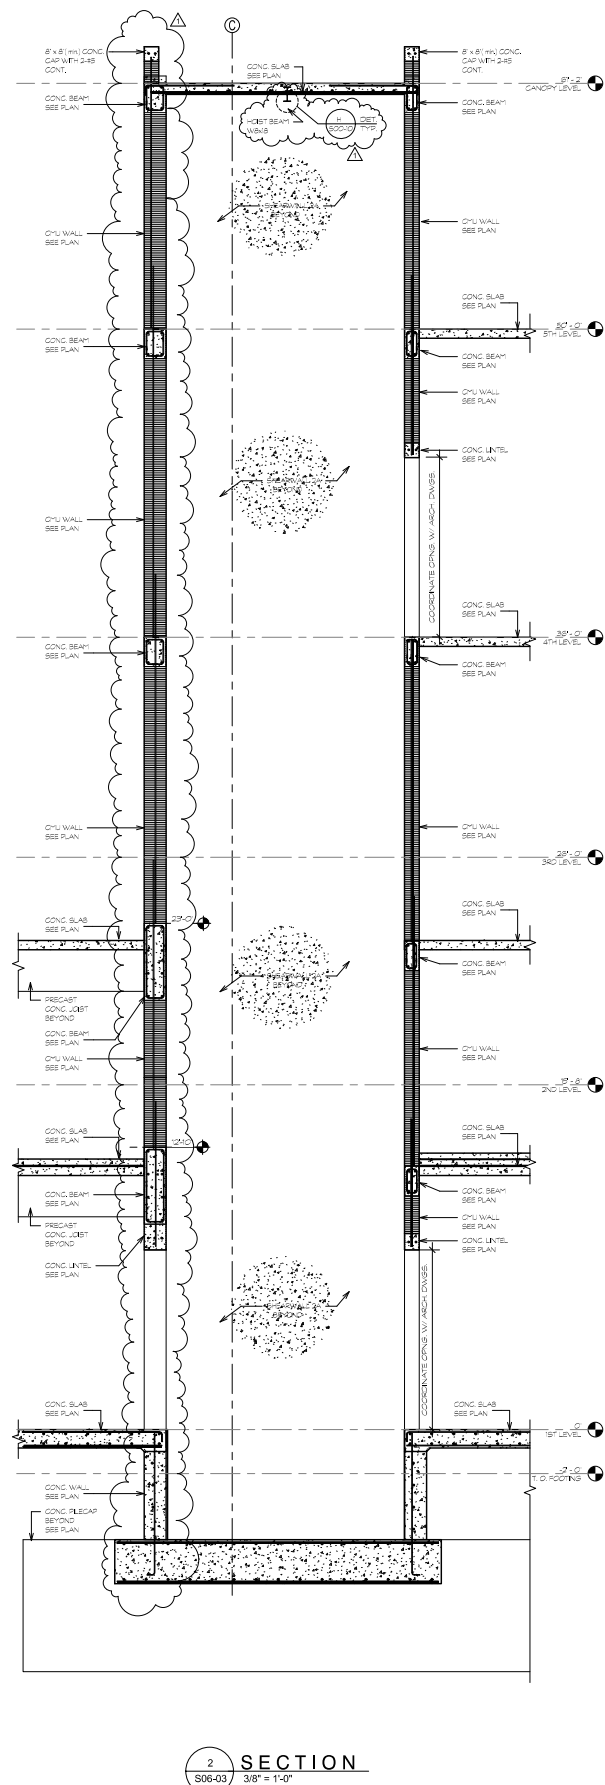

2 SECTION
S06-03 3/8" = 1'-0"

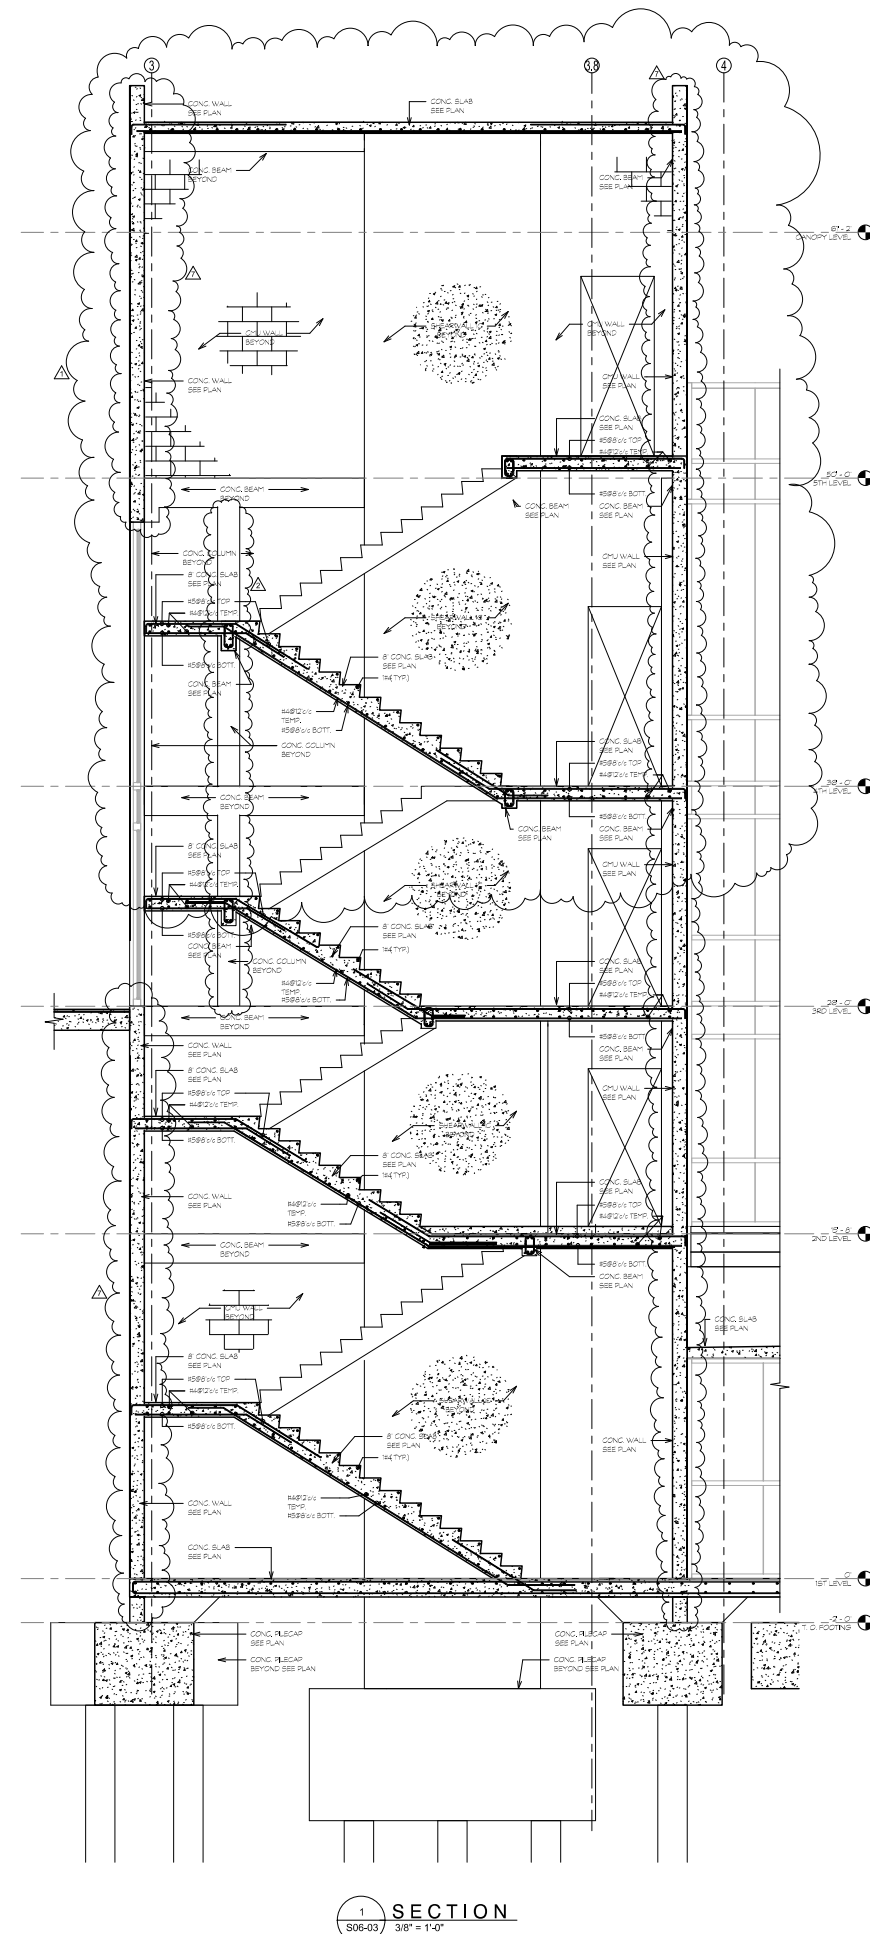

SECTION

PRICING
SET

Revised:
October 17, 2014


Revisions

7	VE CHANGES	07/31/2015
1	REVISED PERMIT COMMENTS	11/20/14
NO.	ISSUE	DATE
Sheet Information		
Date	October 17, 2014	
Job Number	01457-A	
Drawn	Author	
Checked	Checker	
Approved	Approver	
Title		


SECTIONS

Sheet

S06-04

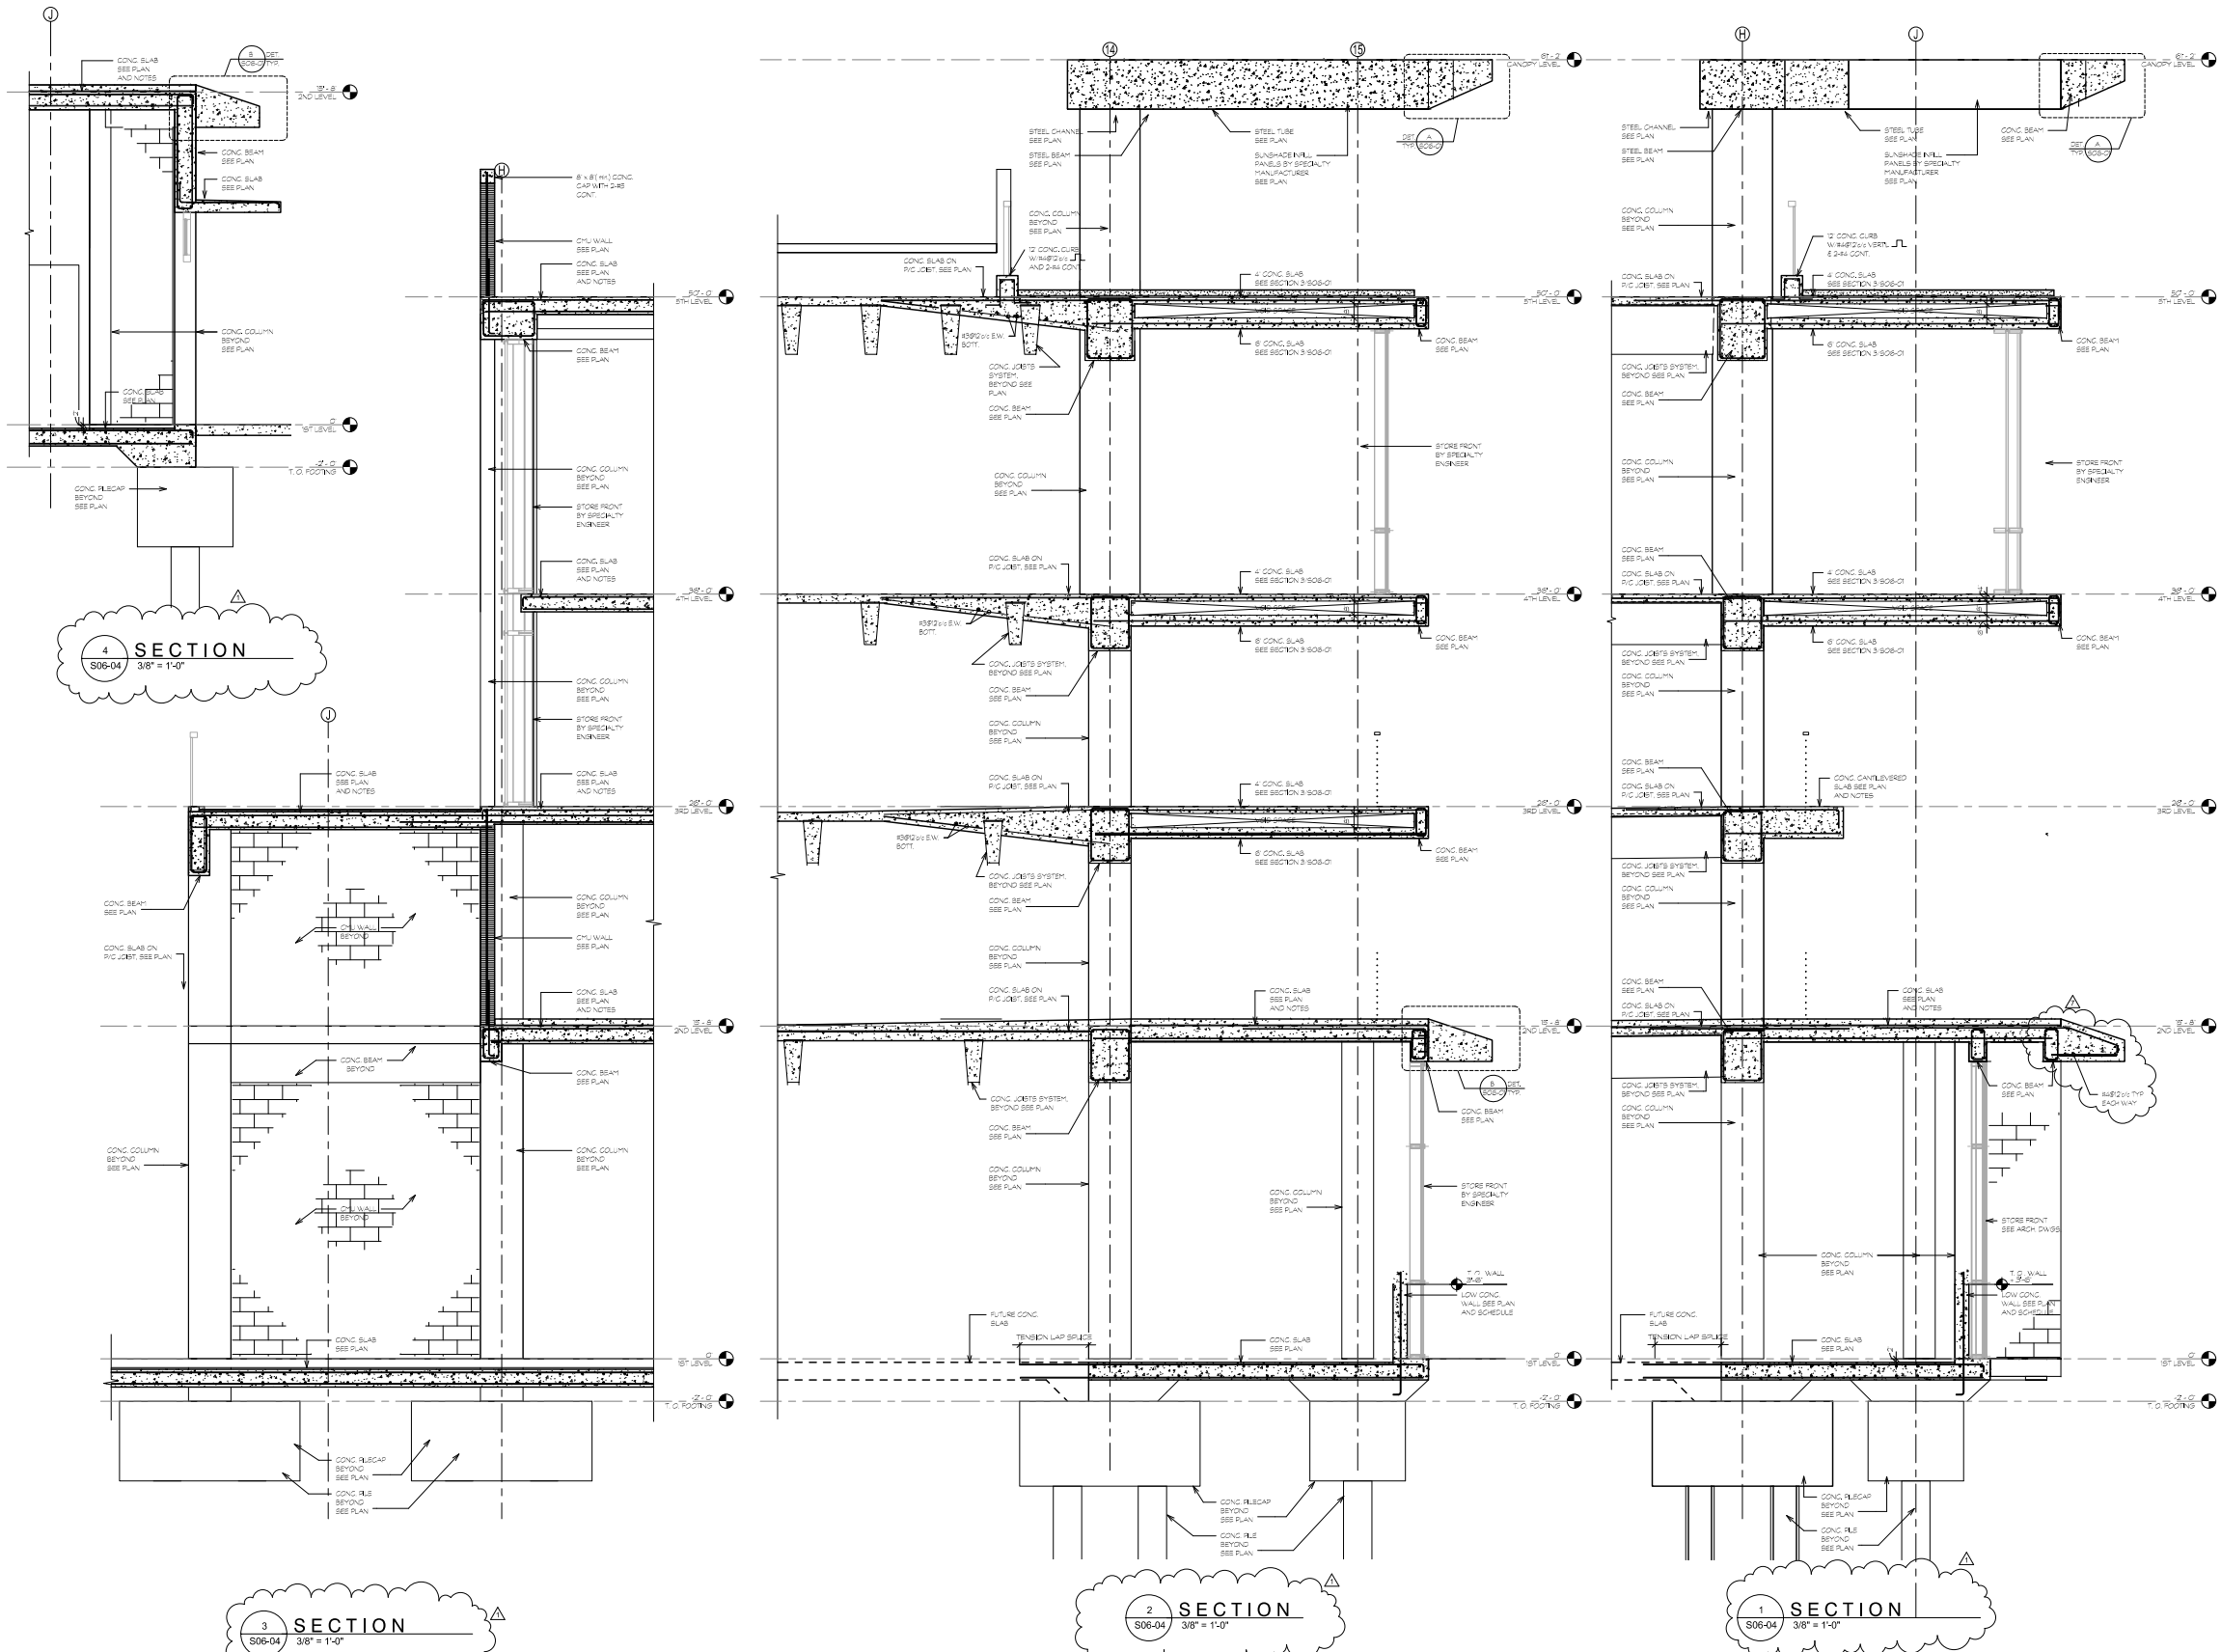

NEW SHEET

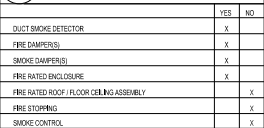

PERMIT
SET

Revisions

11	CITY OF MIAMI BEACH PERMIT COMMENTS	08/26/2014
10	CONCRETE & GENERAL REVISIONS	11/12/2013
9	REVISIONS	08/14/2013
8	REVISIONS	08/14/2013
7	REVISIONS	11/09/14
6	REVISIONS	11/09/14
5	REVISIONS	11/09/14
4	REVISIONS	11/09/14
3	REVISIONS	11/09/14
2	REVISIONS	11/09/14
1	REVISIONS	11/09/14
0	REVISIONS	11/09/14

NO.	ISSUE	DATE
Sheet Information		
Date	Issued: September 4, 2014	
Job Number	810405.000	
Drawn	Author	
Checked	Checker	
Approved	Approver	
Title		

MECHANICAL
LEVEL 1 PLAN

Sheet

M-101

Copyright © 2013 Perkins+Will

1 MECHANICAL LEVEL 1 PLAN
1/8" = 1'-0"



Crescent Heights

709 Alton Road Miami Beach,
Florida, 33139

MILLER LEGG
5747 N Andrews Way
Ft. Lauderdale, FL 33309
1 954.436.7000
1 954.436.8864

LANDSCAPE
SAVINO MILLER DESIGN STUDIO
12345 NE 6th Avenue Suite A
North Miami, FL 33161
1 305.895.0082
1 305.895.0083

STRUCTURE
DDA ENGINEERS, P.A.
4930 SW 74th Street
Miami, FL 33155
1/305.666.0711
1/305.666.5259

MEPPP
BR+A
2500 Douglas Road, Suite 301
Coral Gables, FL 33134
1-305.529.1515
1-305.529.1112

DESMAN ASSOCIATES
110 E. Broward Boulevard, Suite 1710
Fort Lauderdale, FL 33301
1954.315.3924
1954.315.3899

**PERMIT
SET**

Revisions


7	VE CHANGES	08/14/15
1	REVISED PERMIT COMMENTS	11/28/14
NO	ISSUE	DATE

Sheet Information

Date	09/02/14
Job Number	810408,000
Drawn	Author
Checked	Checker
Approved	Approver

MECHANICAL
LEVEL 2 PLANSheet
M-102

Copyright © 2013 Perkins+Will

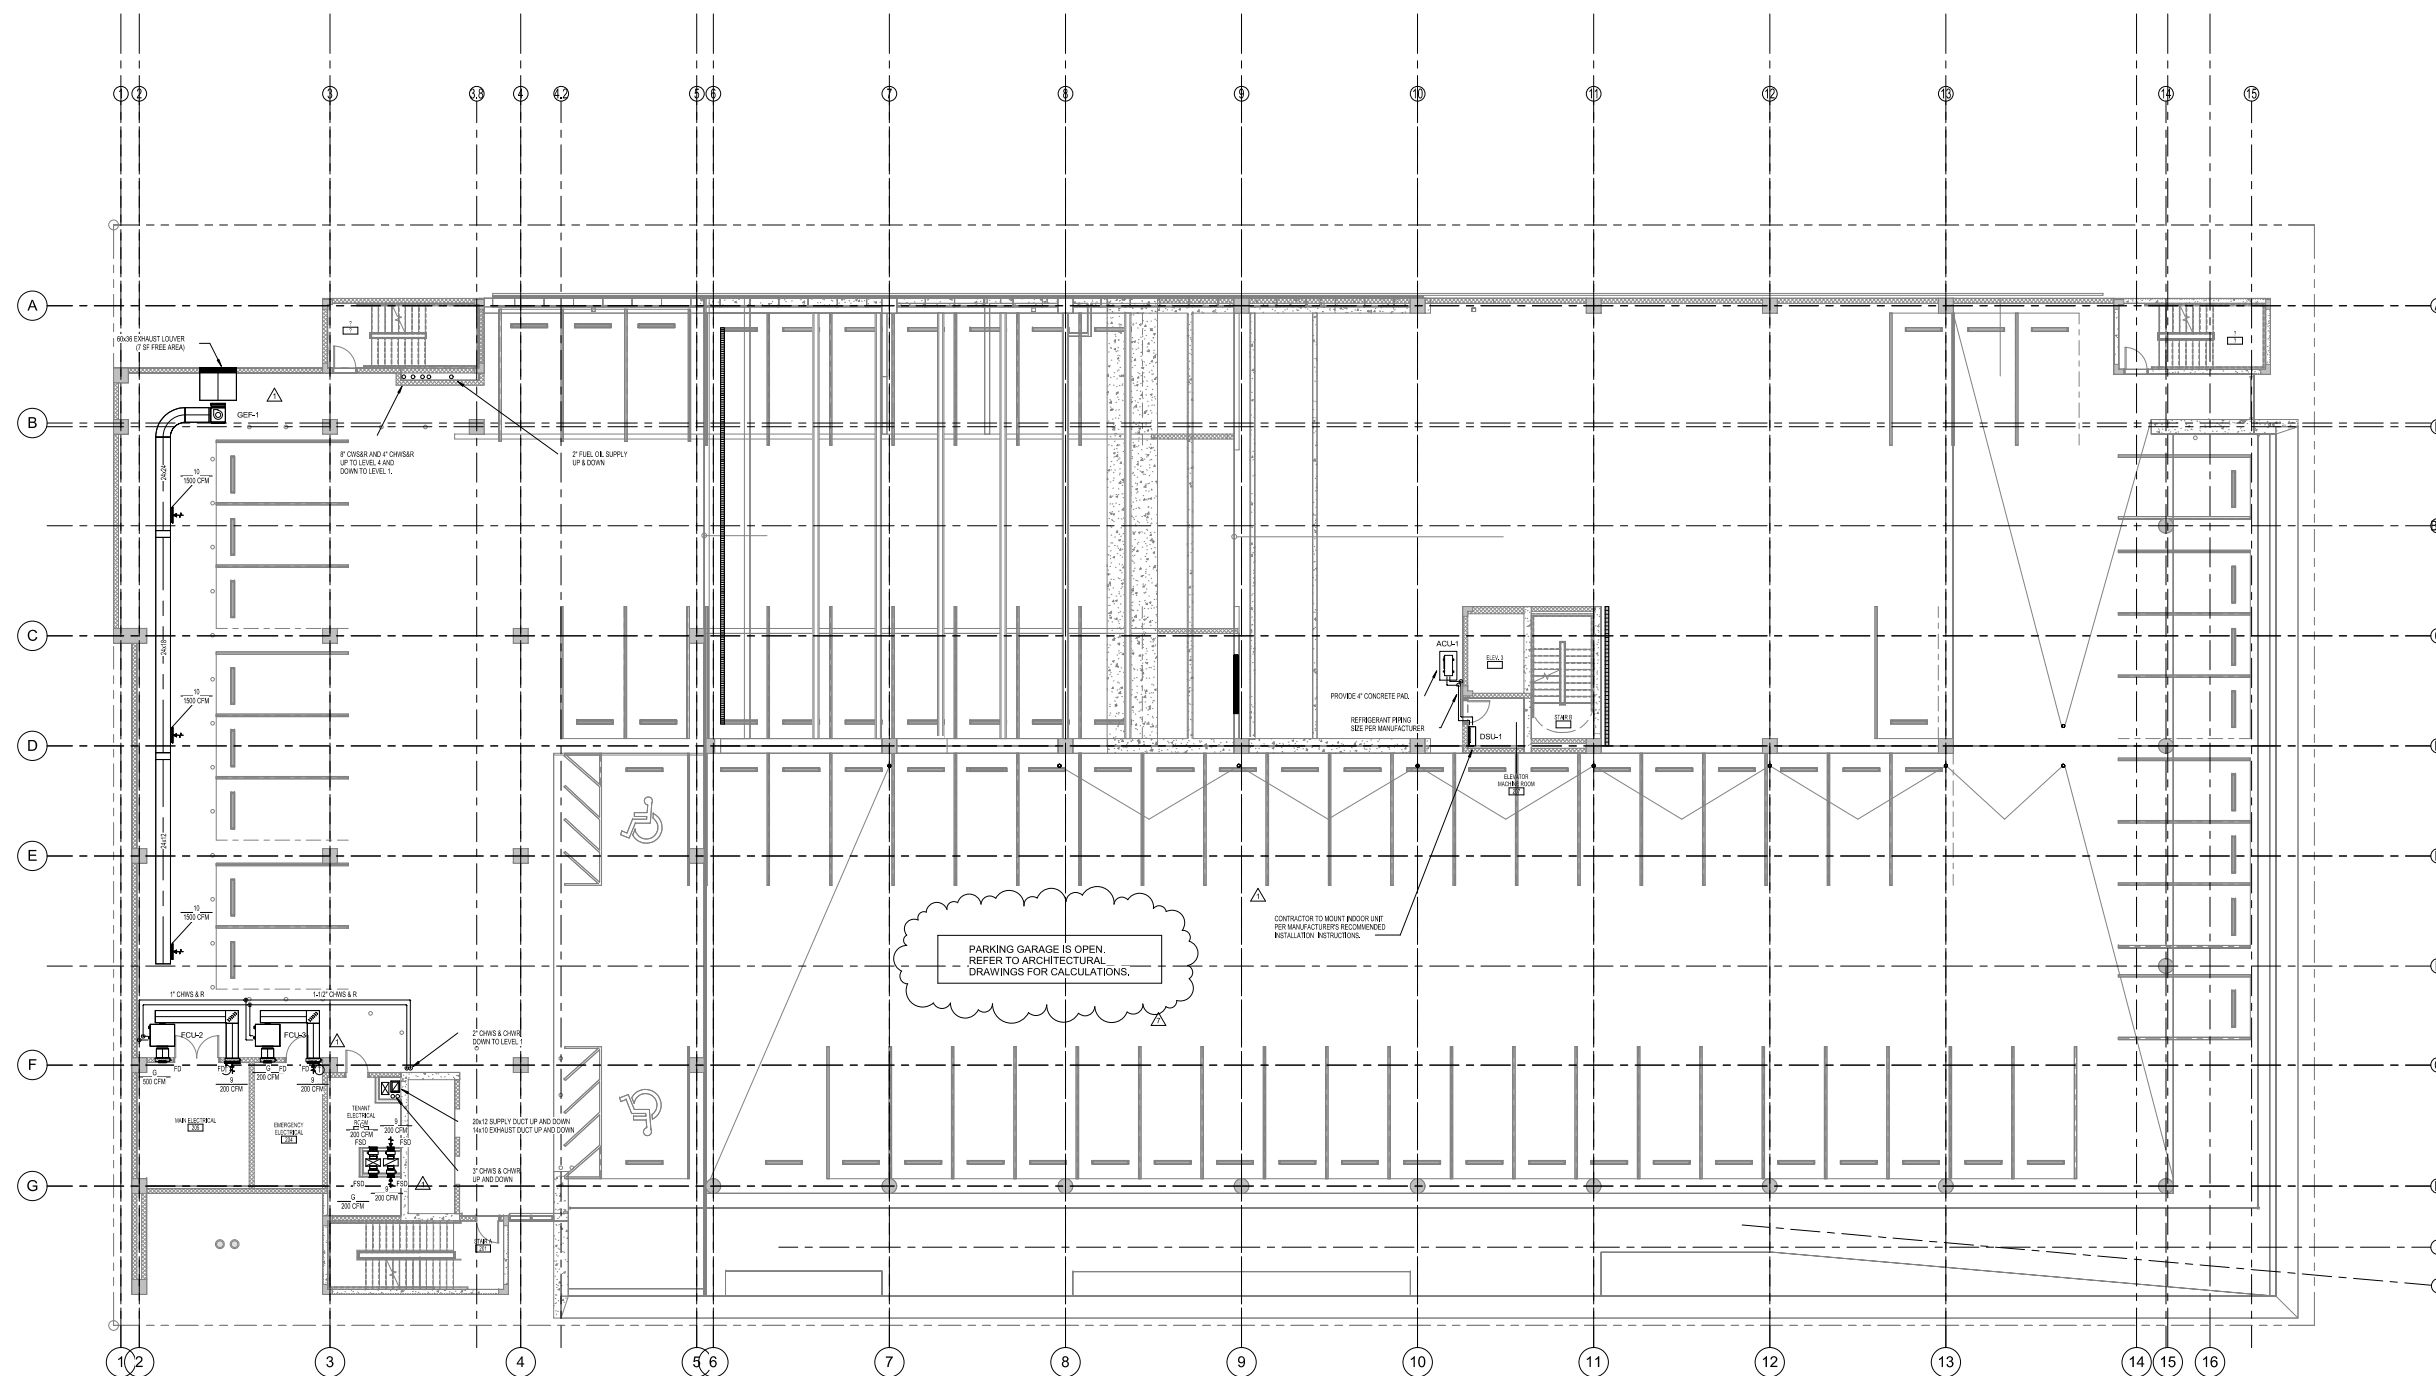

1 MECHANICAL LEVEL 2 PLAN
1/8" = 1'-0"



PERMIT
SET

Revisions

11	CITY OF MIAMI BEACH	08/05/20
10	PERMIT COMMENTS	11/12/15
9	CONTRACT GENERAL	11/12/15
8	REVISIONS	11/12/15
7	REV CHANGES	08/14/15
6	REVISED PERMIT	11/09/14
5	COMMENTS	
4	ISSUE	DATE

Sheet Information

Date	08/02/14
Job Number	810469.000
Drawn	Author
Checked	Checker
Approved	Approver


Title

MECHANICAL
LEVEL 3 PLAN

Sheet

M-103

Copyright © 2013 Perkins+Will

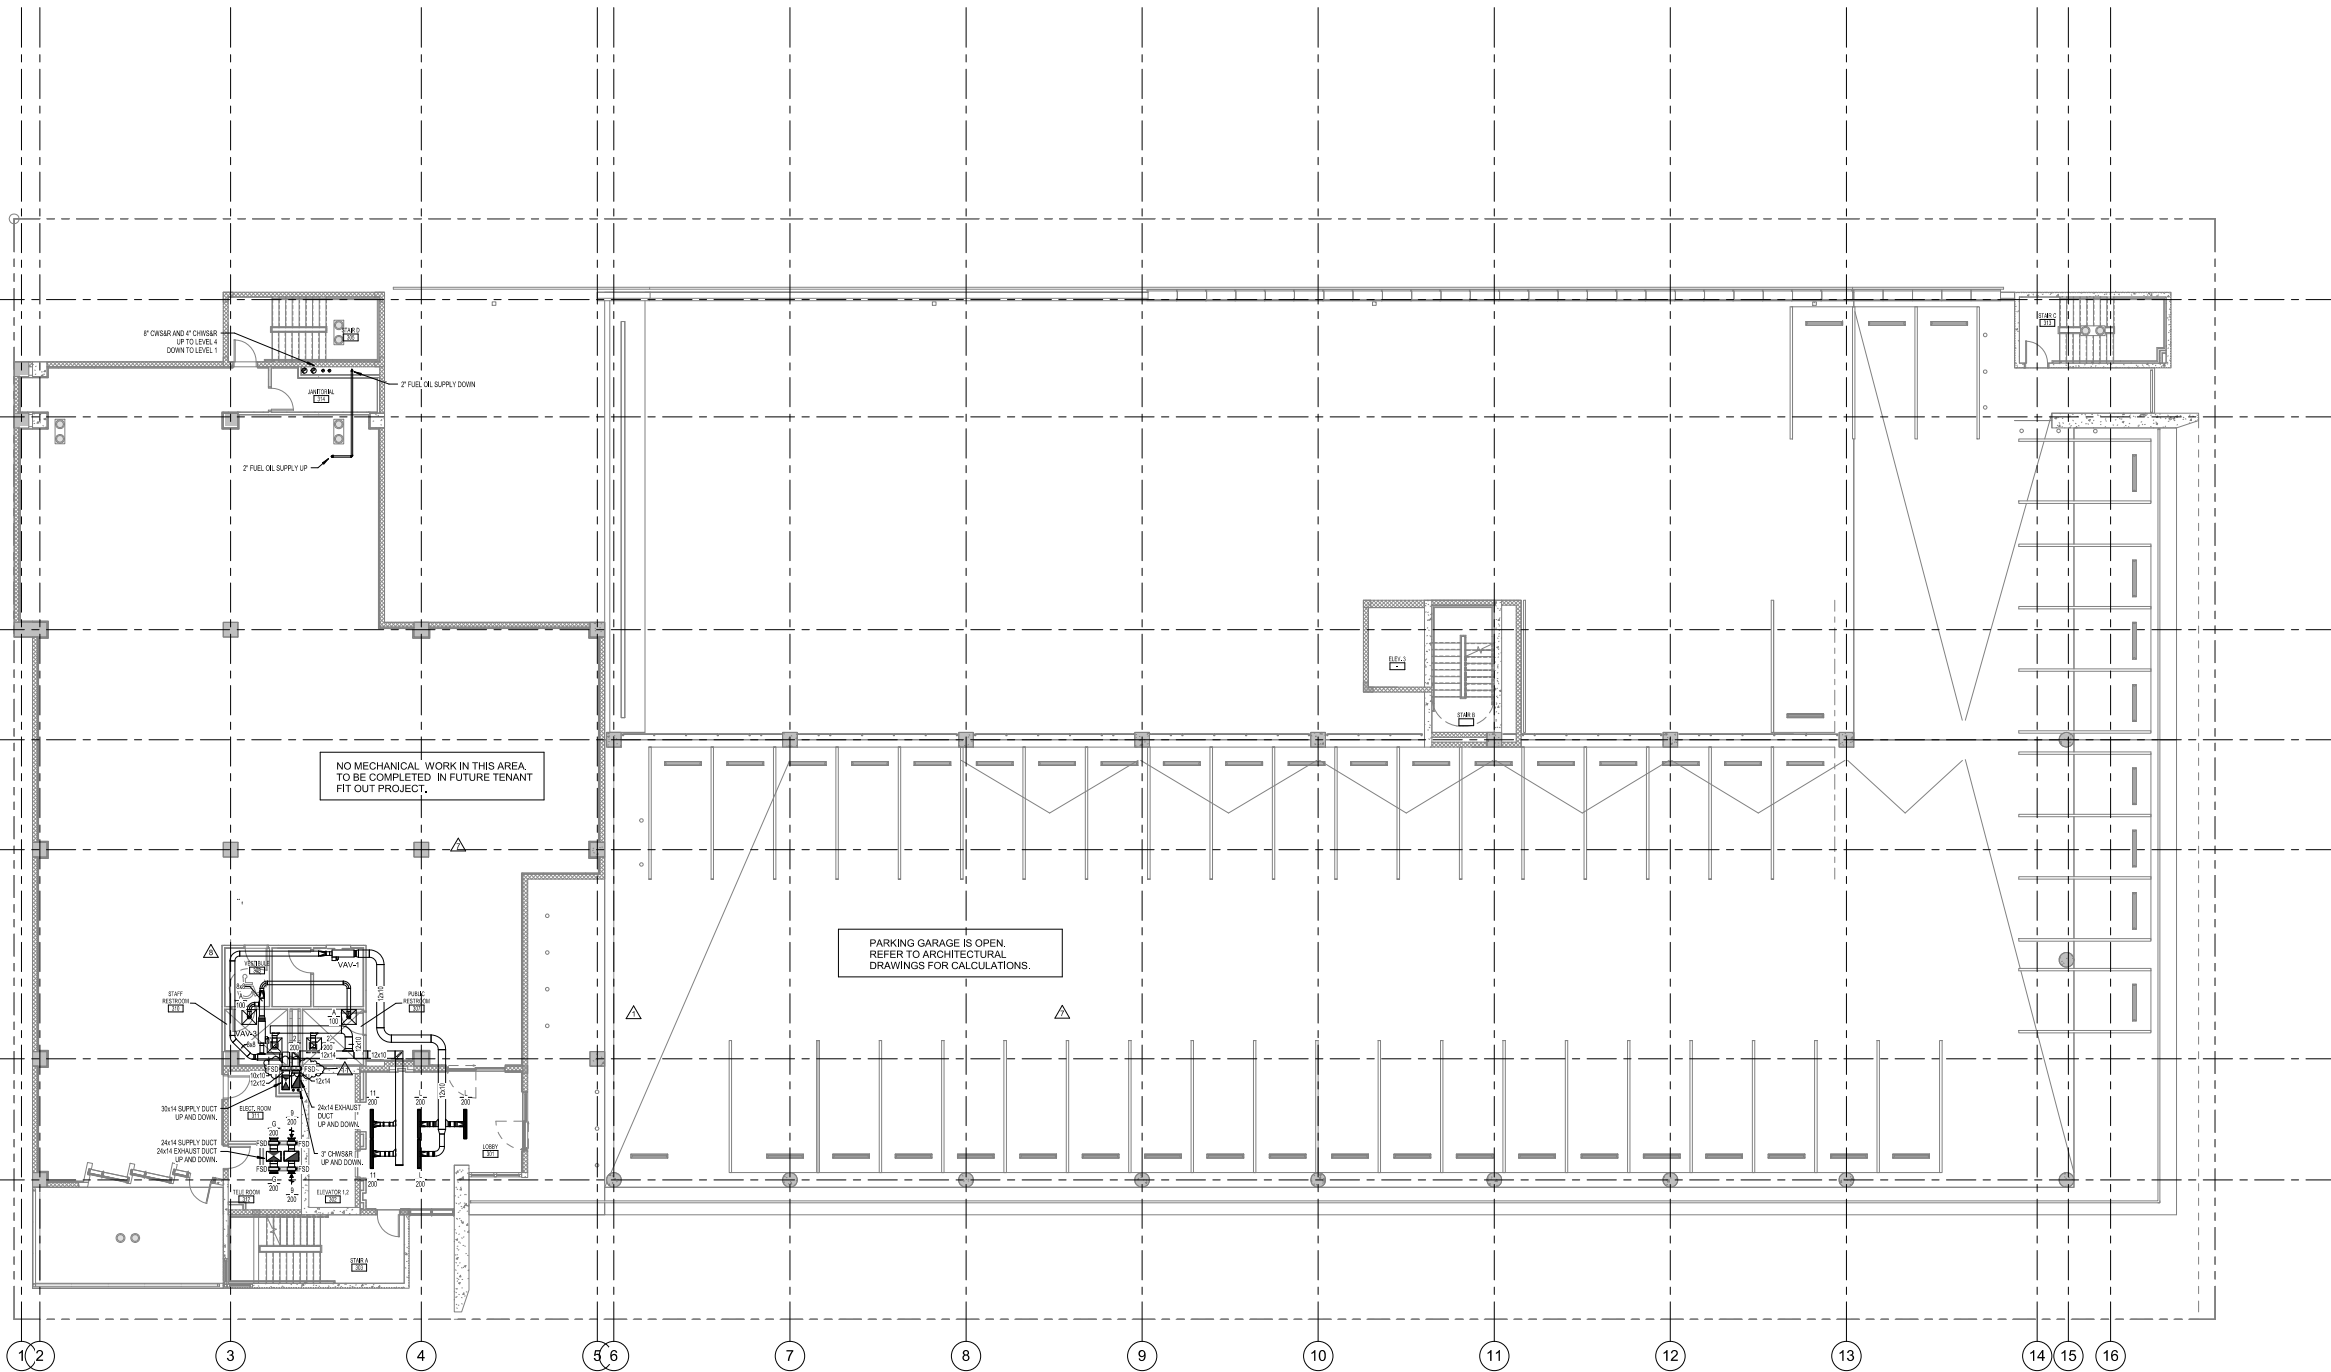

1 MECHANICAL LEVEL 3 PLAN
1/8" = 1'-0"



PERMIT
SET

Revisions

16	CS AND TAYLOR COORDINATION	3/3/17
11	CITY OF MIAMI BEACH PERMIT COMMENTS	08/09/20
8	CONCRETE & GENERAL REVISIONS	11/12/20
7	REVISIONS	08/14/20
5	REVISIONS	08/14/20
3	REVISIONS	07/08/15
1	REVISIONS	11/09/14
NO	ISSUE	DATE

Sheet Information

Date	Issued: September 4, 2014
Job Number	810469.000
Drawn	Author
Checked	Checker
Approved	Approver


Title

MECHANICAL
LEVEL 4 PLAN

Sheet

M-104

Copyright © 2013 Perkins+Will

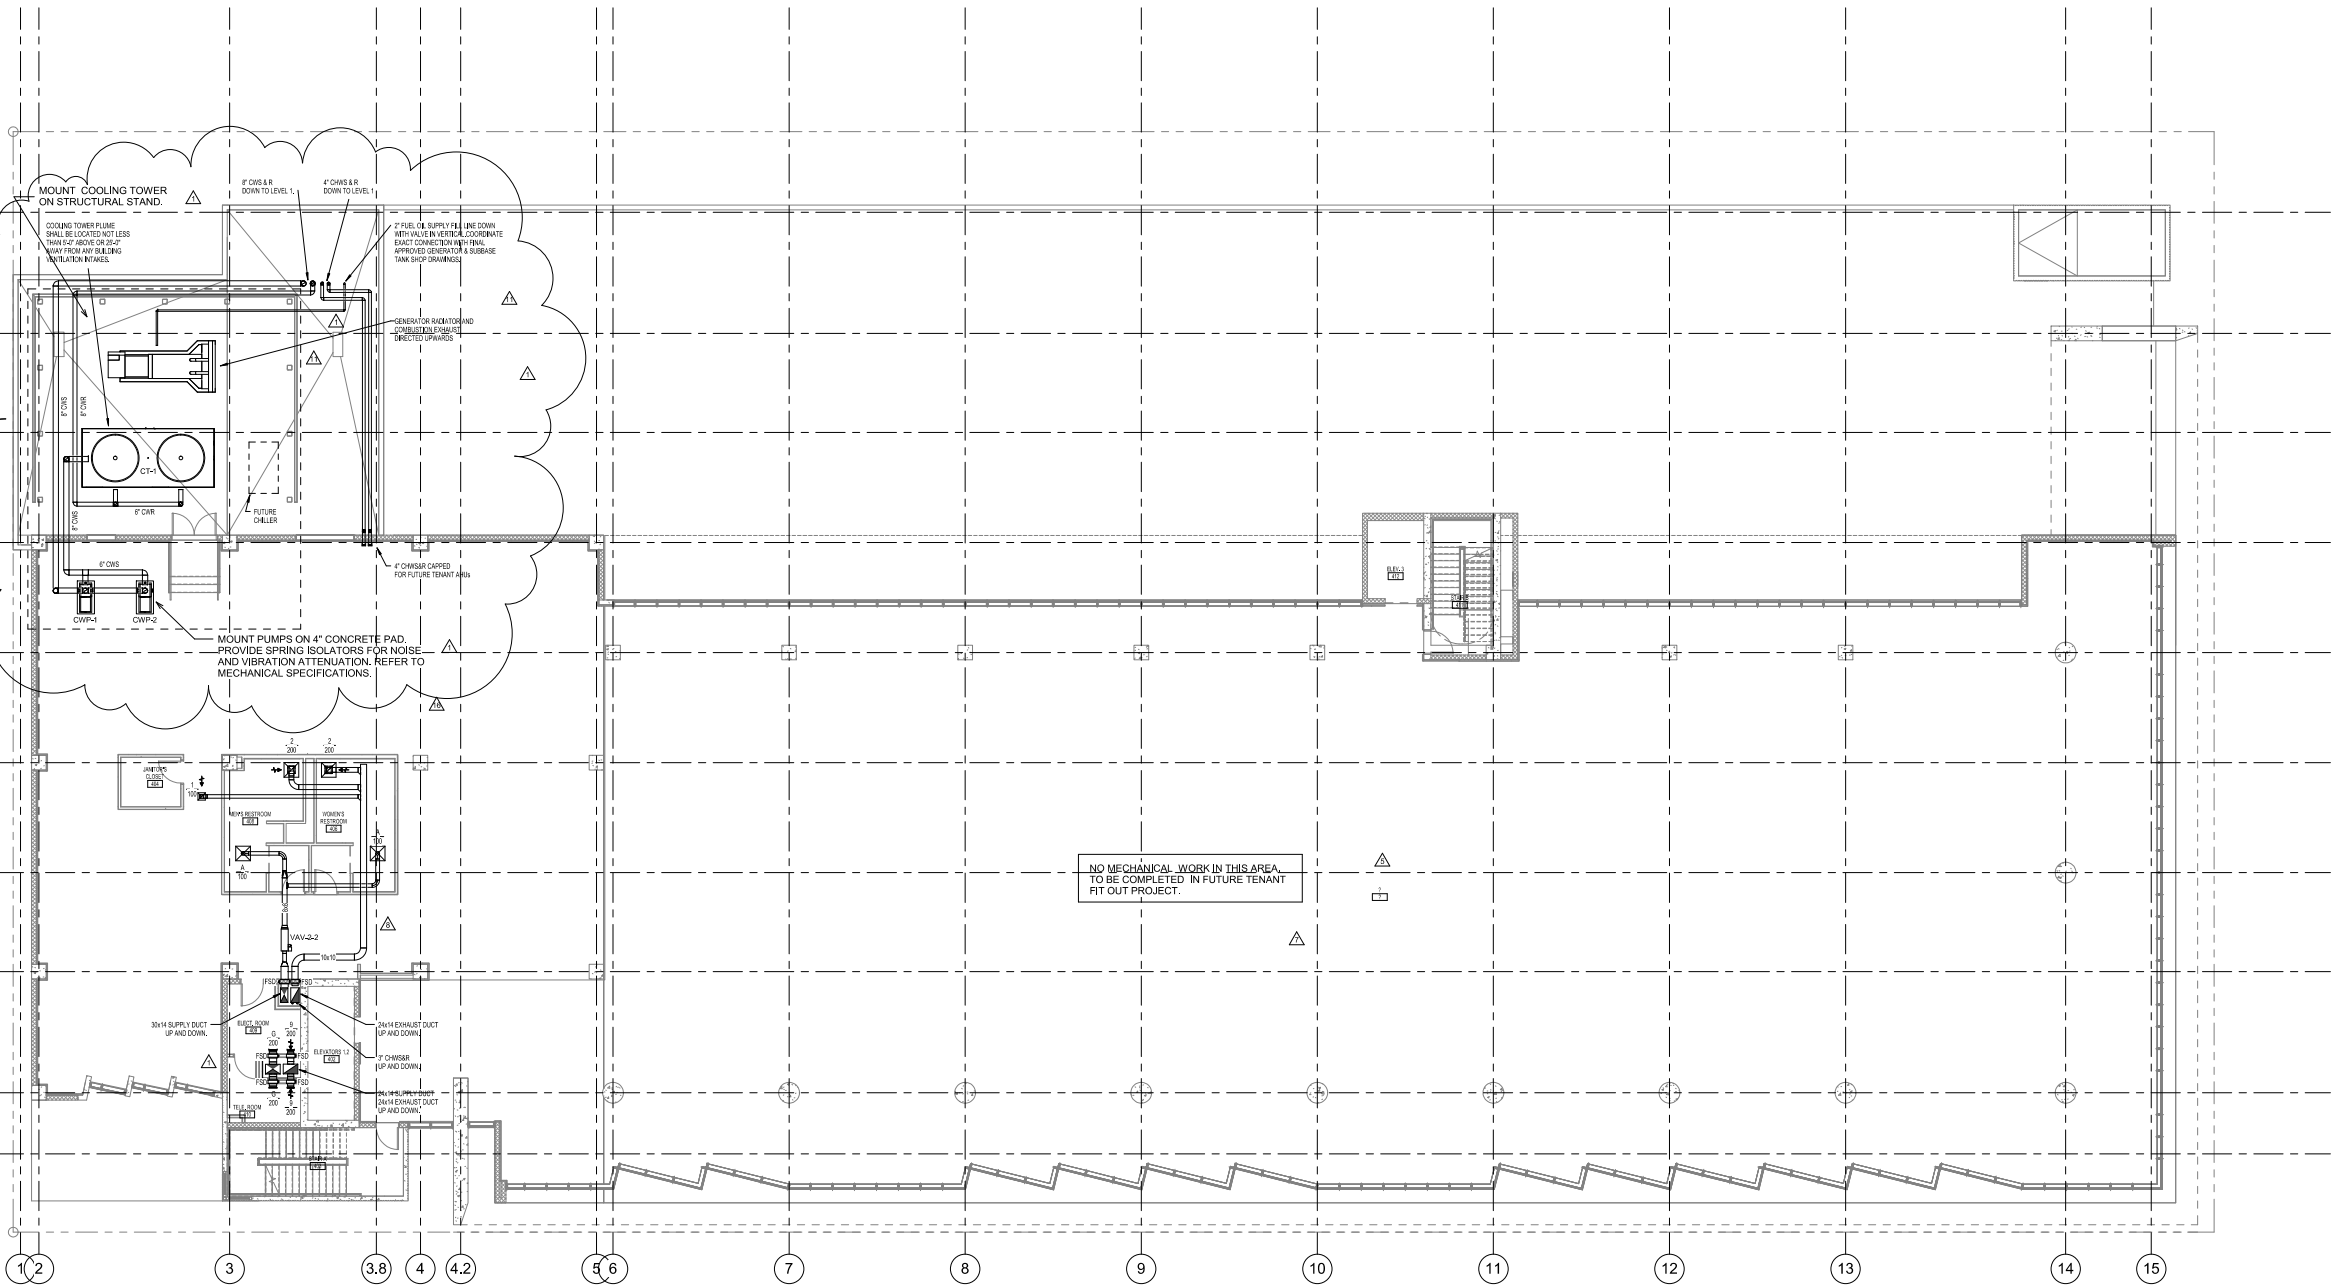

1 MECHANICAL LEVEL 4 PLAN
1/8" = 1'-0"

MOUNT ALL ROOF TOP EQUIPMENT PER
FBC HIGH VELOCITY WIND REQUIREMENTS.
REFER TO ARCHITECTURAL AND STRUCTURAL
DRAWINGS FOR ADDITIONAL INFORMATION
AND DETAILS.

Crescent Heights

709 Alton Road Miami Beach,
Florida, 33139

MILLER LEGG
5747 N Andrews Way
Ft. Lauderdale, FL 33309
1 954.436.7000
1 954.436.8664

LANDSCAPE
SAVINO MILLER DESIGN STUDIO
12345 NE 8th Avenue Suite A
North Miami, FL 33181
1 305.895.0082
1 305.895.0083

STRUCTURE
DDA ENGINEERS, P.A.
4930 SW 74th Street
Miami, FL 33155
1 305.666.0711
1 305.666.5259
MEPP

MEPPP
BR+A
2500 Douglas Road, Suite 301
Coral Gables, FL 33134
1 305.529.1515
1 305.529.1112

DESMAN ASSOCIATES
110 E. Broward Boulevard, Suite 1710
Fort Lauderdale, FL 33301
1954.315.3924
1954.315.3899

**PERMIT
SET**

Revisions

7	VE CHANGES	08/14/15
2	QA/QC REVISIONS	11/26/14
NO	ISSUE	DATE

Sheet Information


Date	09/02/15
Job Number	810408,000
Drawn	Author
Checked	Checker
Approved	Approver

**MECHANICAL
LEVEL 5 PLAN**

Sheet


M-105

Copyright © 2013 Perkins+Will

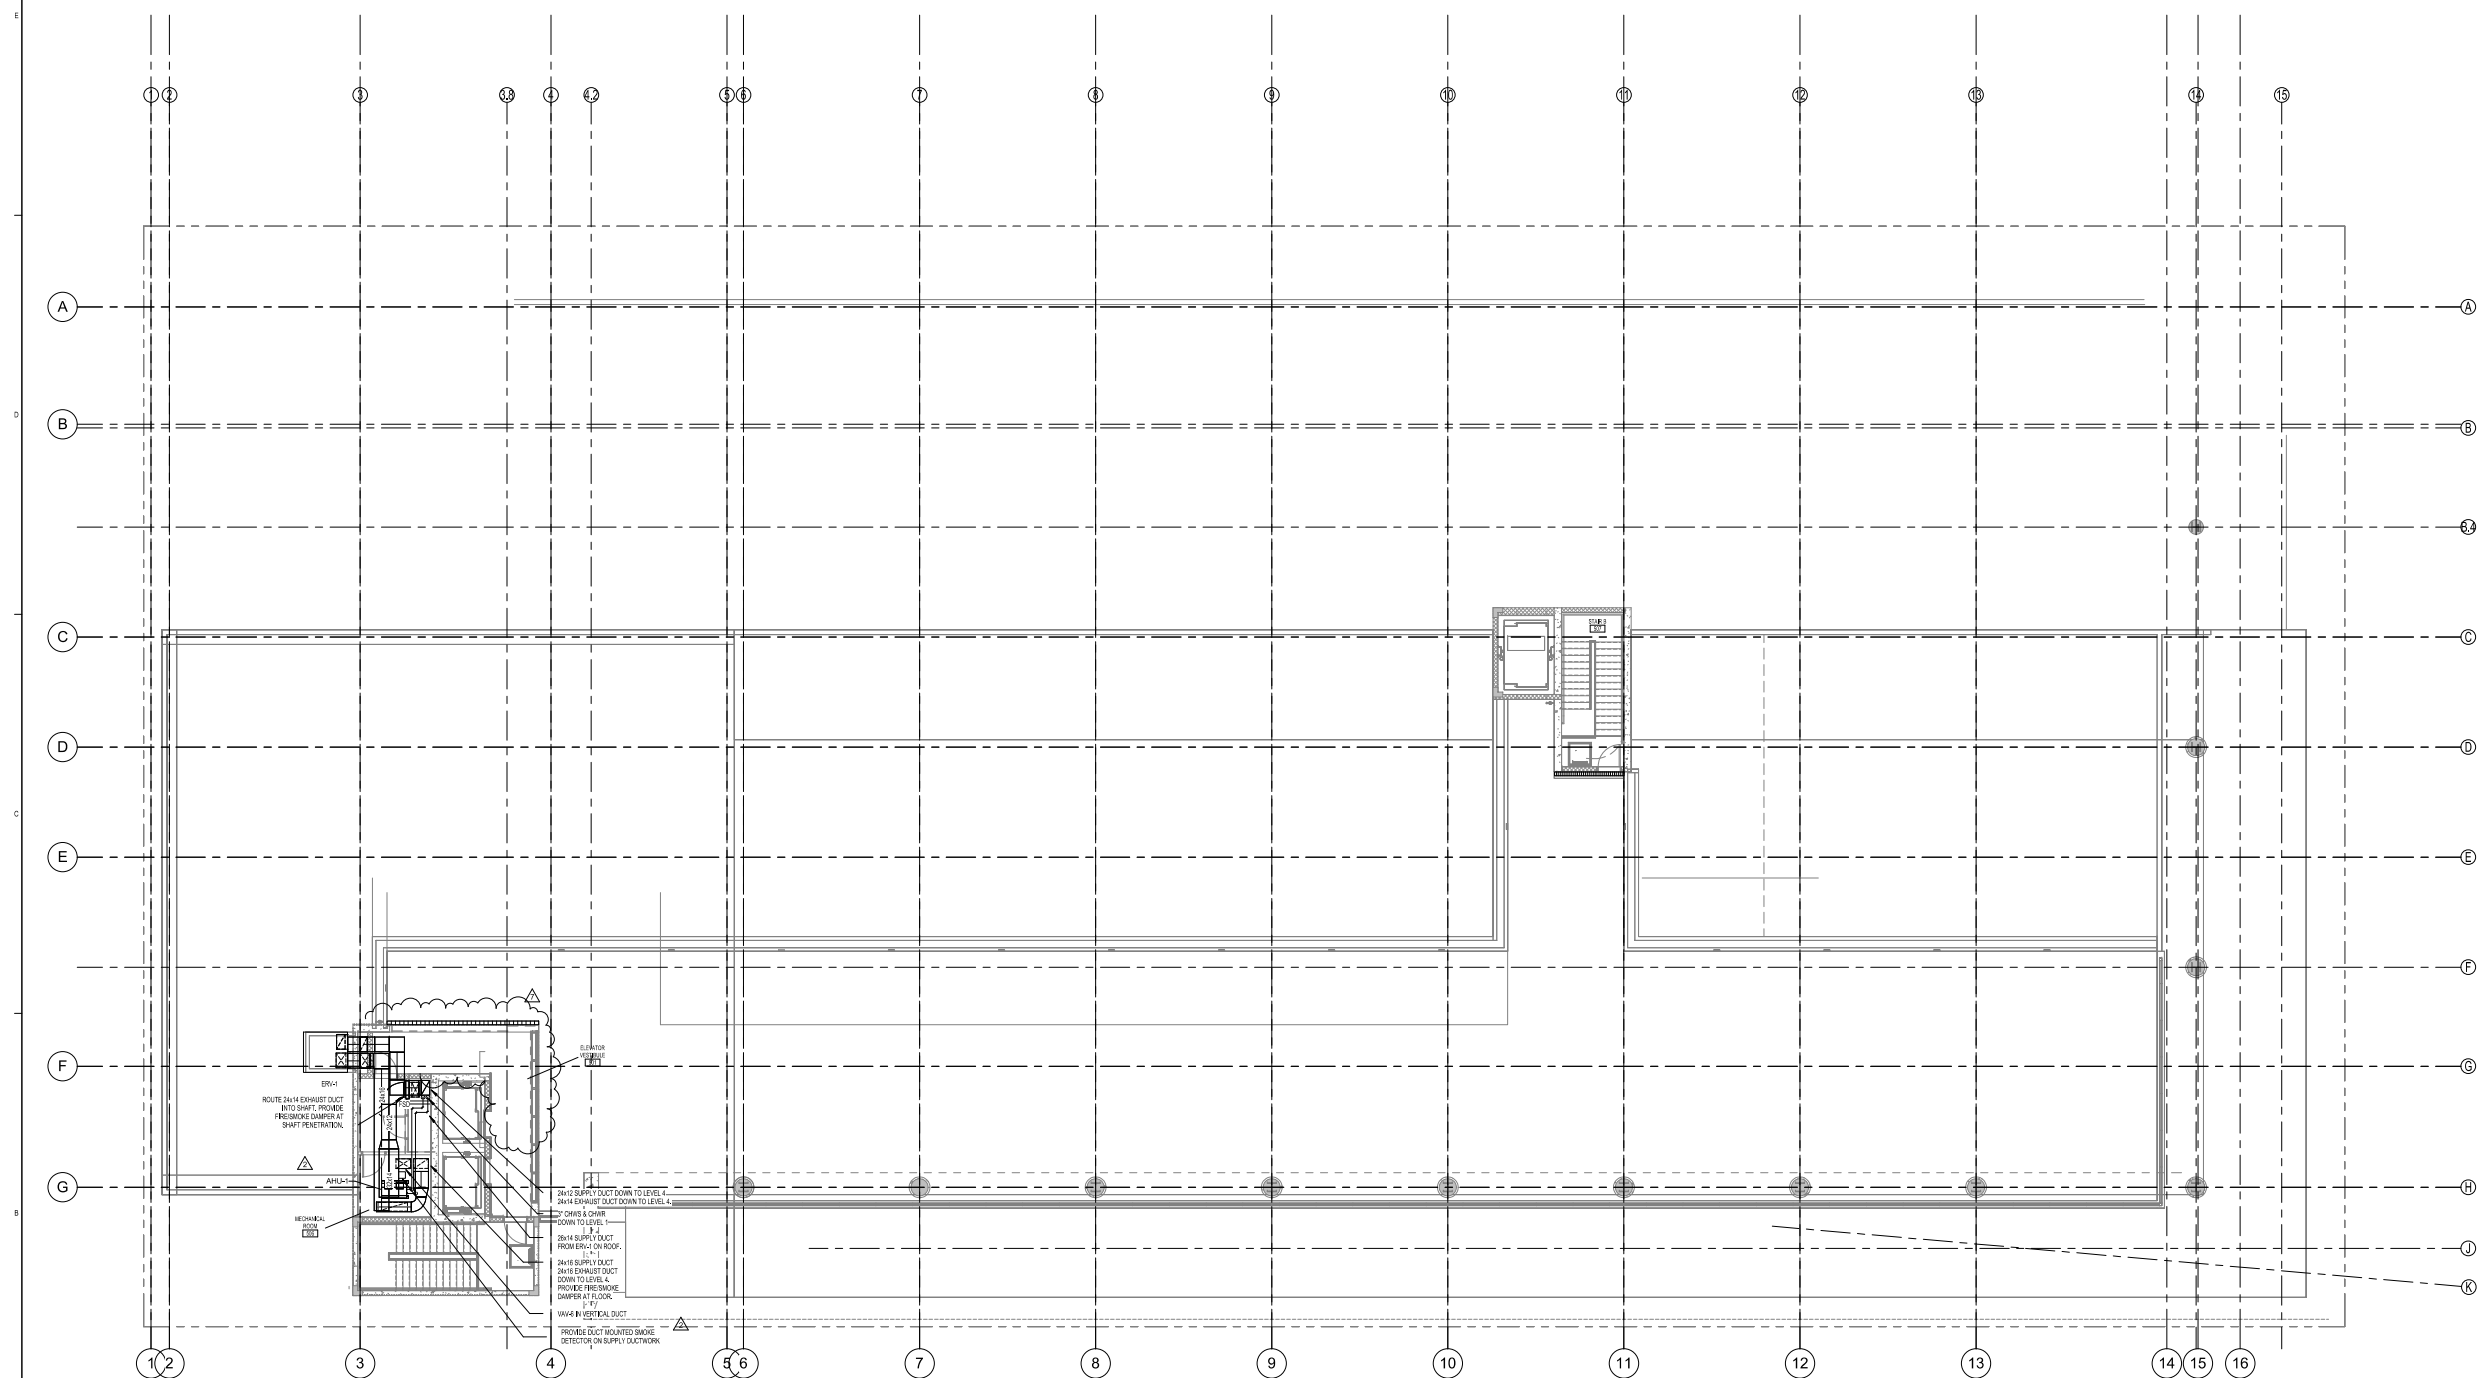

1 MECHANICAL LEVEL 5 PLAN
1/8" = 1'-0"



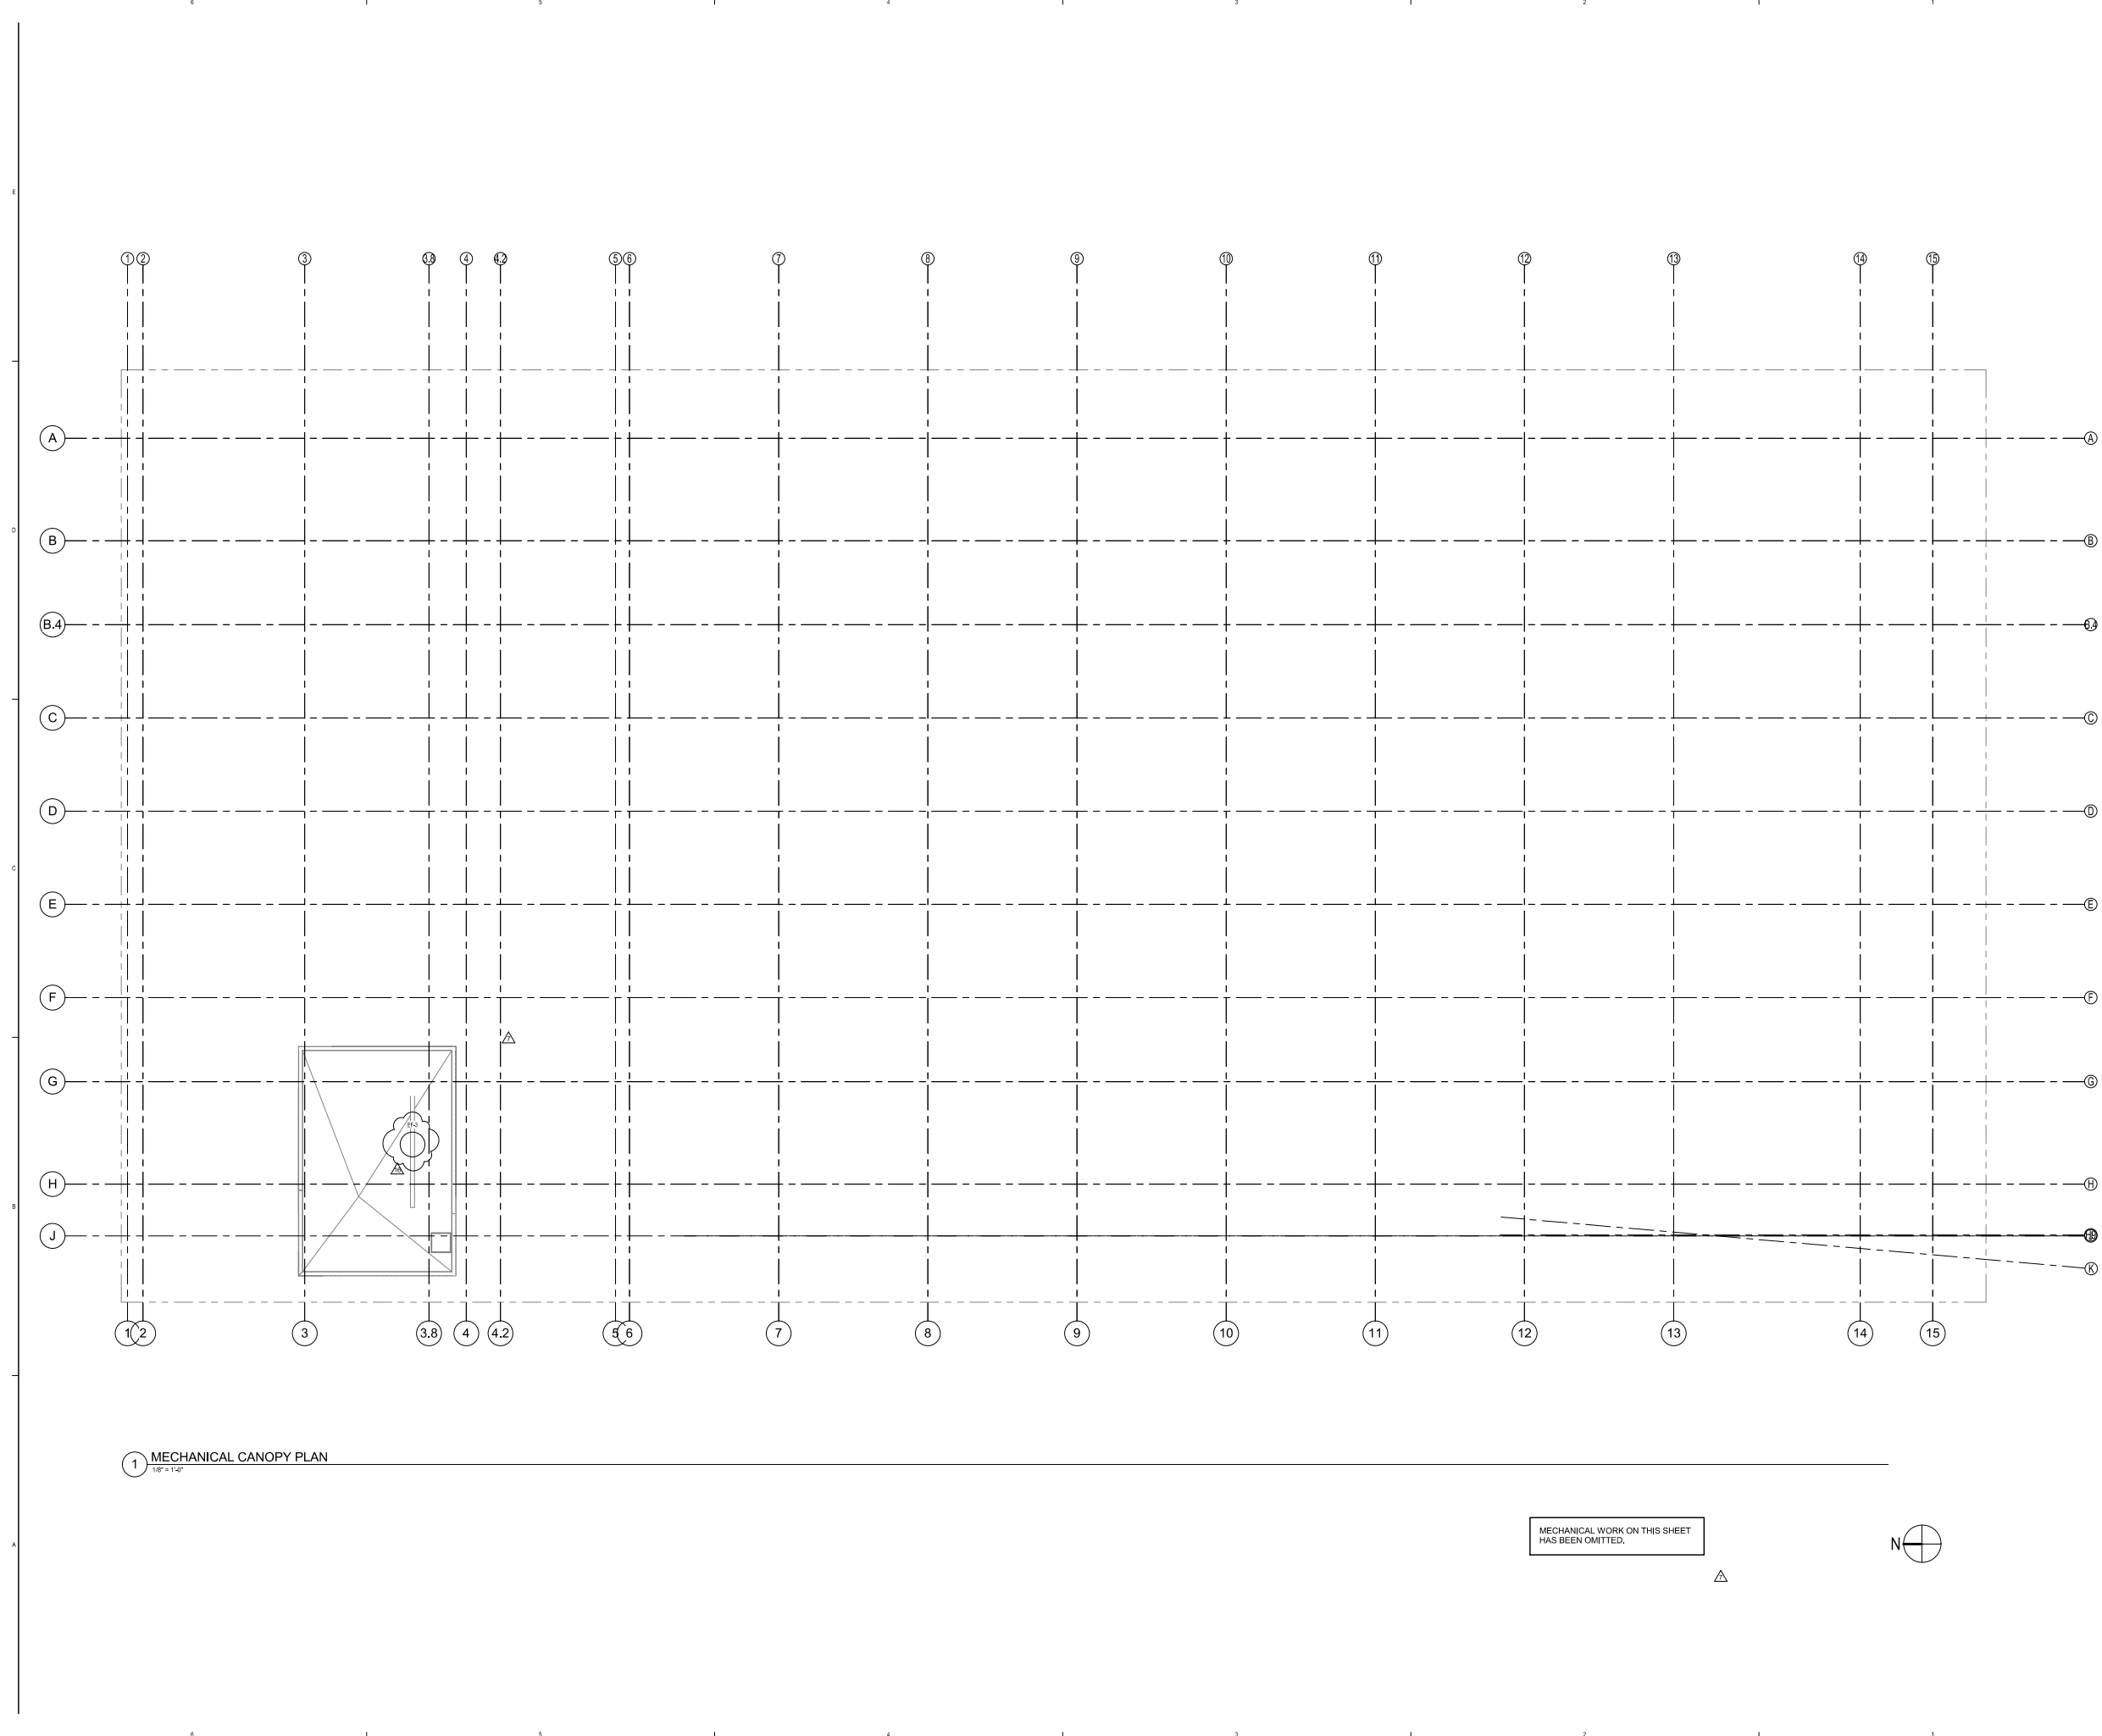

1 MECHANICAL CANOPY PLAN
1/8" = 1'-0"

MECHANICAL WORK ON THIS SHEET
HAS BEEN OMITTED.



PERKINS
+ WILL

805 Douglas Rd.
Suite 300
Coral Gables, FL 33134
1.305.565.1333
1.305.565.1334
www.perkinswill.com

709 Alton
Road

Crescent
Heights

709 Alton Road Miami Beach,
Florida, 33139

CHA
MILLER LEGG
5747 N. Andrews Way
FL, Lauderhill, FL 33308
1.954.435.7000
1.954.435.8664

SAVINO MILLER DESIGN STUDIO
12345 NE 9th Avenue Suite A
North Miami, FL 33181
1.305.865.9082
1.305.865.9083

STRUCTURE
DDA ENGINEERS, P.A.
4938 SW 7th Street
Miami, FL 33155
1.305.865.0711
1.305.865.5299

MEPP
BRVA
2600 Douglas Road, Suite 300
Coral Gables, FL 33134
1.305.528.1515
1.305.528.1112

PARKING CONSULTANTS
DESMAN ASSOCIATES
110 E. Broward Boulevard, Suite 1710
Fort Lauderdale, FL 33301
1.954.315.3024
1.954.315.3888

PERMIT
SET

Revisions

16	CS AND TJ FIELD	03/03/17
7	COORDINATION	06/14/20
7	VE CHANGES	15
NO	ISSUE	DATE

Sheet Information

Date Issued: September 4, 2014
Job Number 810409.000
Drawn Author
Checked Checker
Approved Approver


Title

MECHANICAL
CANOPY PLAN


Sheet

M-106


Copyright © 2013 Perkins+Will

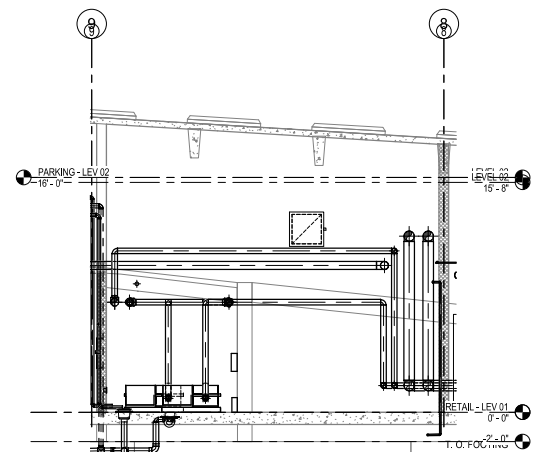


5 SECTION - CHILLER ROOM WEST - LEVEL 1
1/4" = 1'-0"

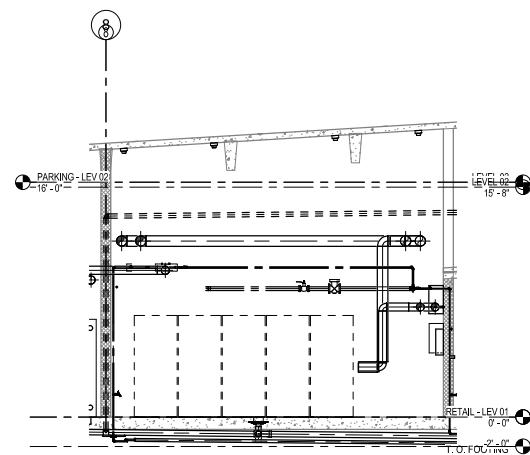


4 SECTION - CHILLER ROOM EAST - LEVEL 1
1/4" = 1'-0"

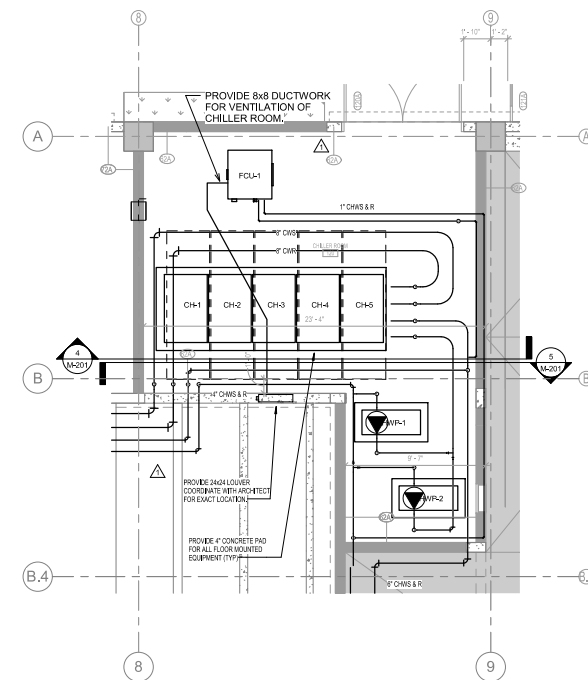


1 ENLARGED CHILLER ROOM PLAN - LEVEL 1
1/4" = 1'-0"

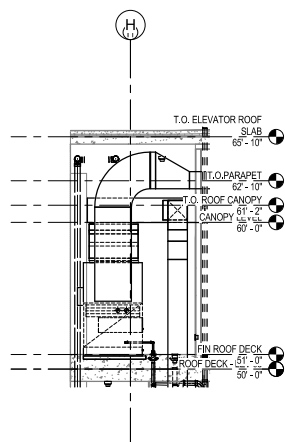

6 SECTION - MECHANICAL ROOM NORTH - LEVEL 5
1/4" = 1'-0"

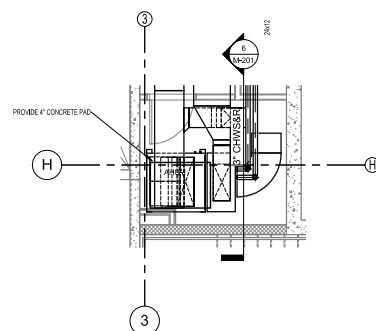

3 ENLARGED MECHANICAL ROOM PLAN - LEVEL 5
1/4" = 1'-0"

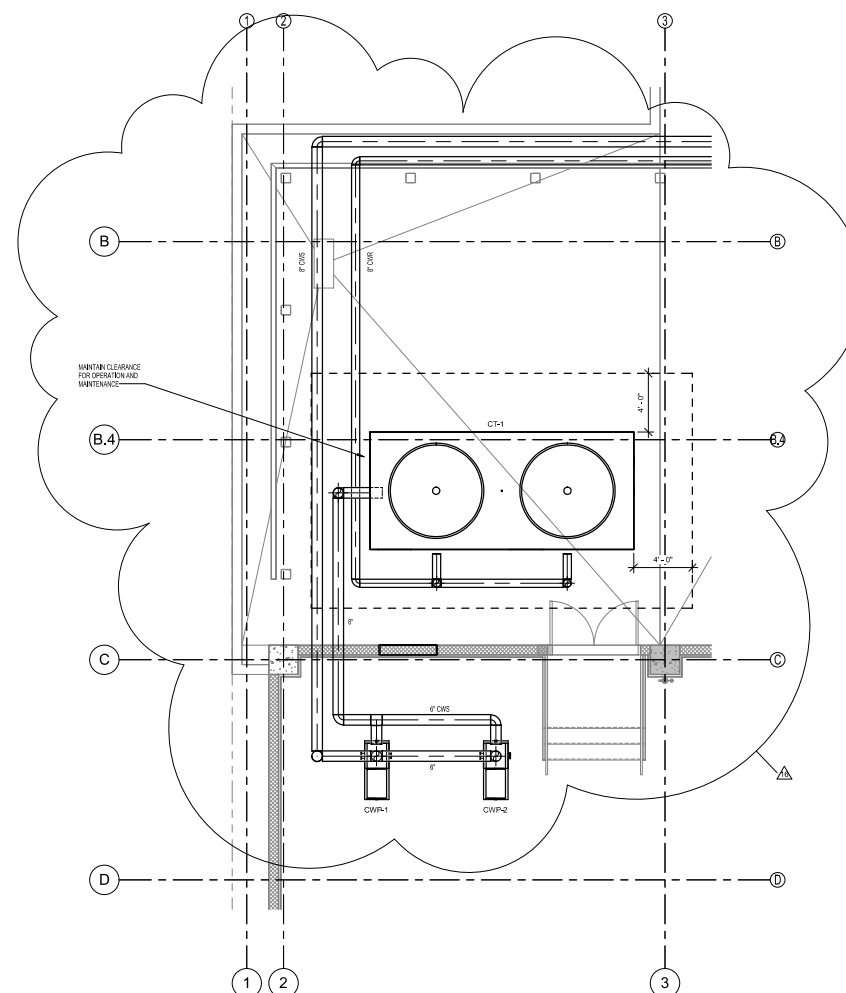

2 ENLARGED COOLING TOWER PLAN - LEVEL 4
1/4" = 1'-0"

PERKINS
+ WILL

805 Douglas Rd.
Suite 300
Coral Gables, FL 33134
t 305.569.1333
f 305.569.1334
www.perkinswill.com

**709 Alton
Road**

Crescent Heights

709 Alton Road Miami Beach,
Florida, 33139

MILLER LEGG
5747 N Andrews Way
Ft. Lauderdale, FL 33309
1 954.436.7000
1 954.436.8664

LANDSCAPE
SAVINO MILLER DESIGN STUDIO
12345 NE 8th Avenue Suite A
North Miami, FL 33181
1 305.895.9082
1 305.895.9083

STRUCTURE
DDA ENGINEERS, P.A.
4930 SW 74th Street
Miami, FL 33155
1 305.666.0711
1 305.666.5259

MEYER
BR+A
2500 Douglas Road, Suite 301
Coral Gables, FL 33134
1 305.529.1515
1 305.529.1112

DESMAN ASSOCIATES
110 E. Broward Boulevard, Suite 1710
Fort Lauderdale, FL 33301
1 954.315.3924
1 954.315.3889

**PERMIT
SET**

Revisions


16	CS AND TJ FIELD COORDINATION	03/03/17
1	REVISED PERMIT COMMENTS	11/28/14
NO.	ISSUE	DATE

Sheet Information

Date	Issued: September 4, 2014
Job Number	810408.000
Drawn	Author
Checked	Checker
Approved	Approver

MECHANICAL
ENLARGED PLANSSheet
M-201

Copyright © 2013 Perkins+Will

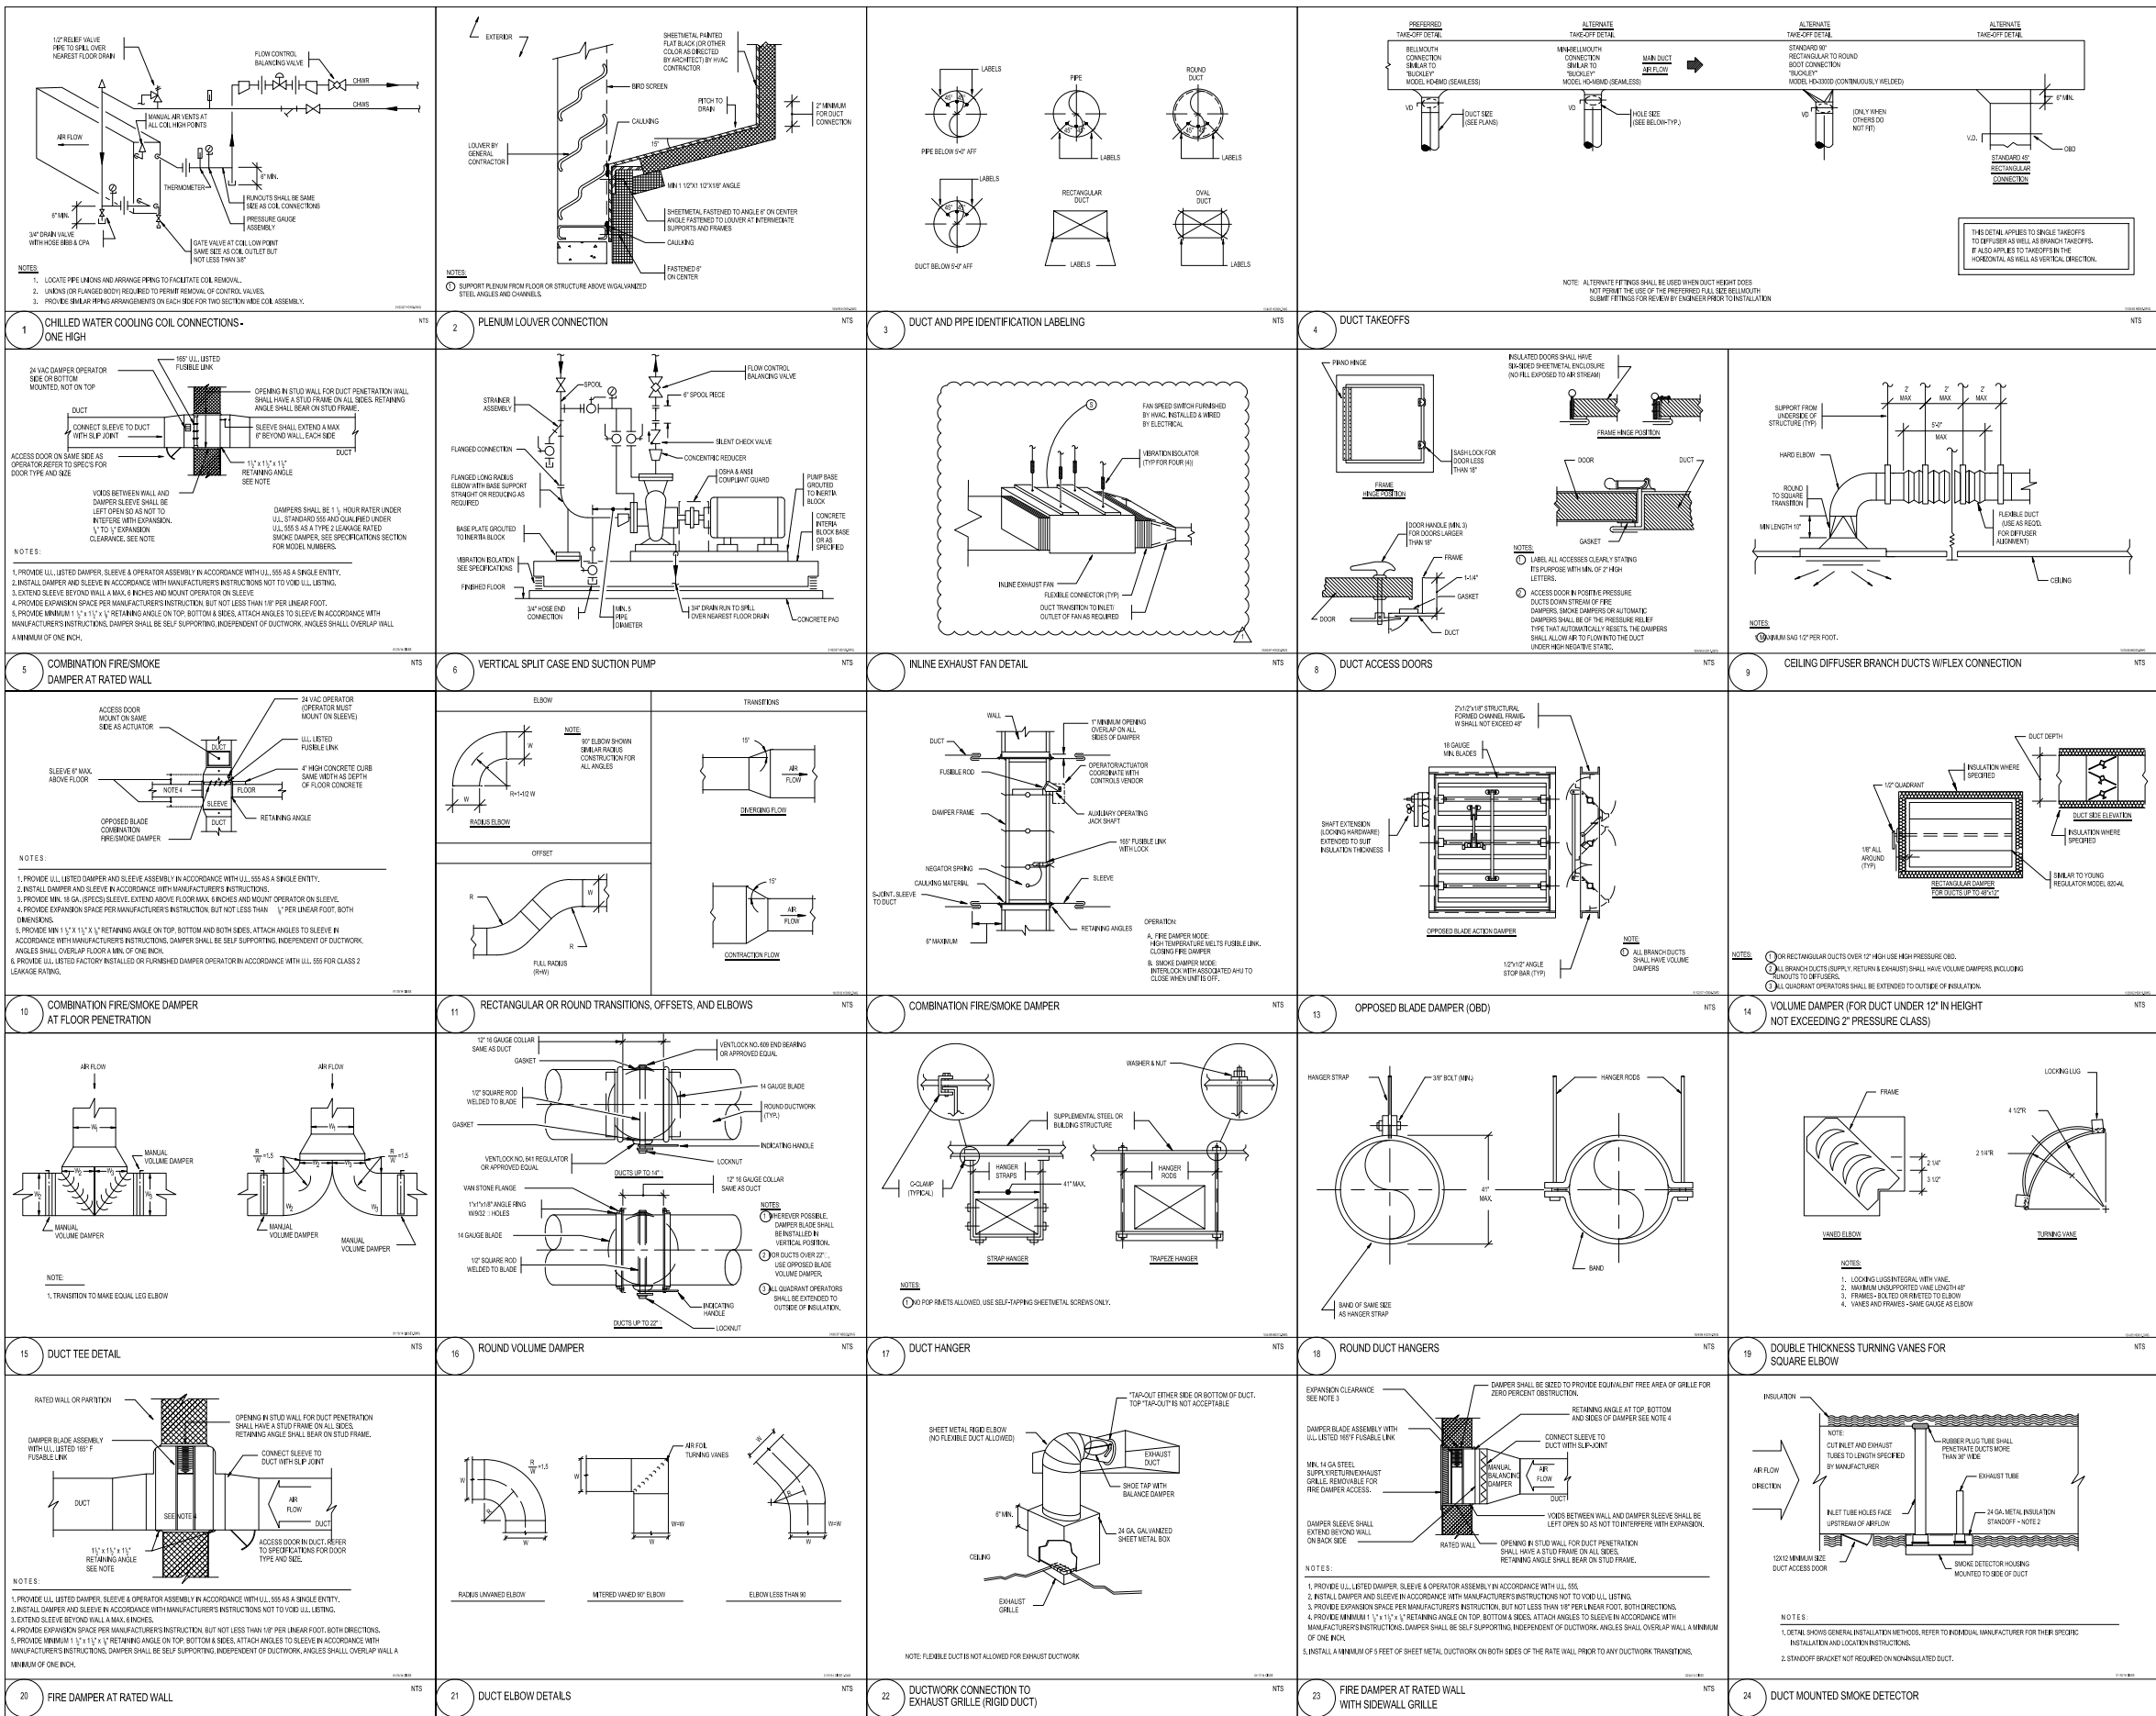

PERKINS
+ WILL

709 Alton
Road

Crescent
Heights

709 Alton Road Miami Beach,
Florida, 33139

CHL
MILLER LEGG
5747 N Andrews Way
Fort Lauderdale, FL 33351
1 305.566.5862
1 305.566.5863

DESIGNER
SAVINO MILLER DESIGN STUDIO
12041 NE 8th Avenue Suite A
North Miami, FL 33161
1 305.566.5862
1 305.566.5863

STRUCTURE
DDA ENGINEERS, P.A.
4900 SW 7th Street
Miami, FL 33155
1 305.566.6711
1 305.566.6239

MECH
BRVA
2800 Douglas Road, Suite 301
Coral Gables, FL 33134
1 305.520.5555
1 305.520.1112

FAIRING CONSULTANTS
DESIGN ASSOCIATES
110 E. Broward Boulevard, Suite 1710
Fort Lauderdale, FL 33301
1 561.315.3264
1 561.315.3399

PERMIT
SET


Revisions

NO	ISSUE	DATE
Sheet Information		
Date	09/02/14	
Job Number	810408,000	
Drawn	Author	
Checked	Checker	
Approved	Approver	
Title		

MECHANICAL
DETAILS

Sheet
M-301



Copyright © 2013 Perkins+Will

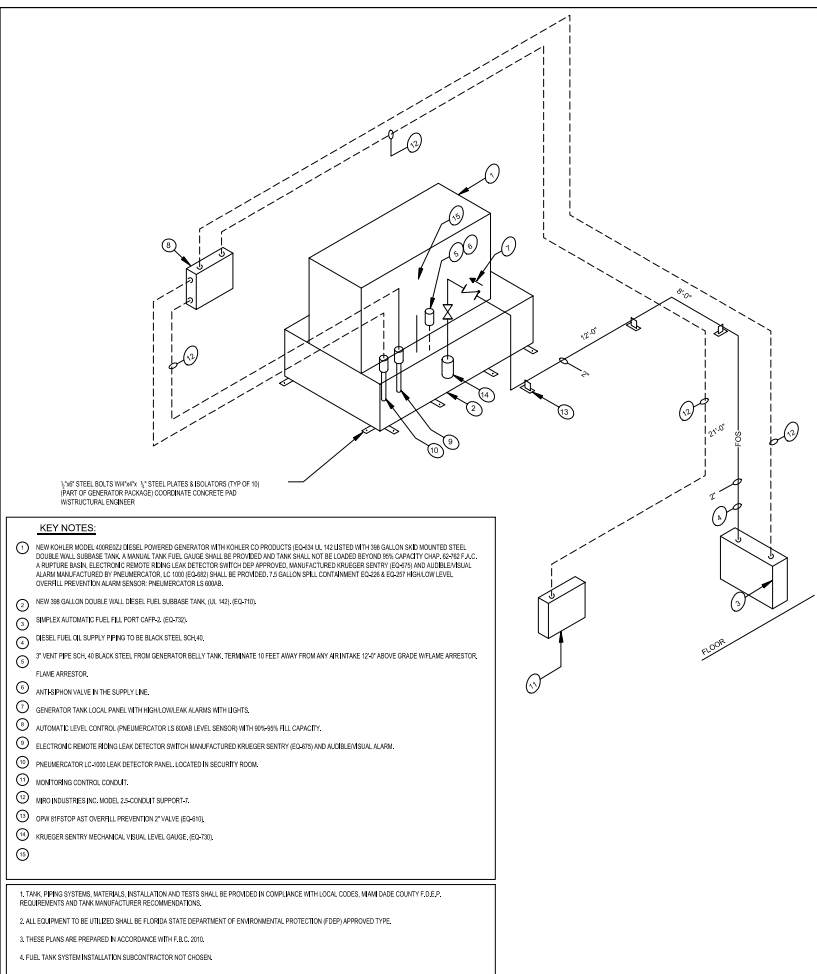

1504315,3899


Revisions

Sheet Information	
Date	09/02/14
Job Number	810408.000
Drawn	Author
Checked	Checker
Approved	Approver
Title	

  Sheet
M-401

FIXTURE CONNECTION SCHEDULE						
TYPE	SOIL / WASTE	VENT	CW	HW	REMARKS	
3" FLOOR DRAIN	3"	1½"	—	—	PROVIDE ½" CW FROM TRAP PRIMER	
4" FLOOR DRAIN	4"	2"	—	—	PROVIDE ½" CW FROM TRAP PRIMER	
6" FLOOR DRAIN	6"	3"	—	—	PROVIDE ½" CW FROM TRAP PRIMER	
4" ANTI-SPLASH STANDPIPE	4"	2"	—	—	PROVIDE ½" CW FROM TRAP PRIMER	
DRINKING FOUNTAIN	1½"	1½"	½"	—		
3/4" HOSE BIBB	—	—	¾"	—		
KITCHEN SINK	2"	1½"	½"	½"	1.5 GPM AT 60 PSI MAXIMUM	
LAVATORY (PRIVATE)	1½"	1½"	½"	½"	1.5 GPM AT 60 PSI MAXIMUM	
LAVATORY (PUBLIC)	1½"	1½"	½"	½"	0.5 GPM AT 60 PSI MAXIMUM (0.25 GALLON METERING CYCLE)	
MOP SINK	3"	2"	¾"	¾"		
WALL HYDRANT	—	—	¾"	—		
PANTRY SINK	2"	1½"	½"	½"	2.2 GPM AT 60 PSI MAXIMUM	
URINAL (3/4" FLUSHOMETER VALVE)	3"	2"	¾"	—	0.5 GALLONS PER FLUSHING CYCLE MAXIMUM	
WATER CLOSET (FLUSHOMETER VALVE)	4"	2"	1½"	—	1.28 GALLONS PER FLUSHING CYCLE MAXIMUM (OR EQUIVALENT DUAL FLUSH)	

NOTE: PLUMBING FIXTURE CONNECTION SCHEDULE IS SHOWN FOR CONVENIENCE ONLY. PLUMBING CONTRACTOR TO CONFIRM FINAL PLUMBING FIXTURE CONNECTION SIZES WITH PLUMBING FIXTURE MANUFACTURER'S REQUIREMENTS. ALL FIXTURES SHALL COMPLY WITH WASH-WASTE WATER-USE EFFICIENCY REQUIREMENTS.

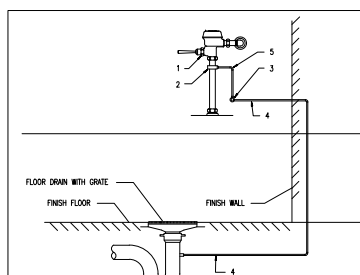

****Note:** System pressure is the sum of the minimum suction pressure (40 psi) + pressure boost (40 psi) = 80 PSI

-
- RING GENERAL NOTES

1. THE WORK THAT IS TO BE DONE UNDER THIS CONTRACT INCLUDES THE

-
- Diagram illustrating the components and installation of a reduced pressure back-flow preventer with air gap:
- REDUCED PRESSURE BACK-FLOW PREVENTER WITH AIR GAP:** The main device being installed.
 - BALL VALVE (TYPICAL):** A valve used for isolation.
 - 0 TO 100 PSI 5/8" DIAMETER PRESSURE GAUGE WITH GAUGE COCK (TYP):** A gauge to monitor system pressure.
 - SPRING LOADED, RUBBER SEATED CHECK VALVE INSTALLED PER MANUFACTURER'S WRITTEN INSTRUCTIONS:** A check valve to prevent backflow.
 - ALLOW SPACE FOR STRAINER REMOVAL:** A designated area for accessing the strainer.
 - PIPE AIR GAP FUNNEL DRAIN DISCHARGE TO NEAREST FLOOR DRAIN UNLESS NOTED OTHERWISE ON PLANS:** A drain pipe that extends above the flood level and discharges to the floor drain.
 - PREVENT AIR GAP FITTING AND DRAIN PIPING A MINIMUM OF ONE SIZE LARGER THAN OR PIPE SIZE SERVING BACKFLOW PREVENTER UNLESS NOTED OTHERWISE:** A requirement for the drain piping size.
 - STRAINER W/ BLOW-OFF/ MOUNT LEAD FREE # 177775 (TYPICAL):** A strainer with a blow-off feature to catch debris.
 - IN:** The inlet connection to the system.
 - OUT:** The outlet connection to the system.
 - TO SYSTEM:** The direction of flow to the system.

NOTES:

1. SEE FLOOR PLAN FOR SIZE OF R.P.B.P. AND PIPE.
2. PROVIDE BALL SUPPORTS FOR R.P.B.P. IF LOCATED BELOW CEILING.
3. PROVIDE AN ADDITIONAL BALL VALVE ON INLET AND OUTLET OF BACKFLOW PREVENTER AS PER DETAIL.
4. INSTALL PER MANUFACTURER'S WRITTEN INSTRUCTIONS AND PER LOCAL REGULATIONS WITH CLEARANCE TO ALL OTHERS' OBSTRUCTIONS.
5. CONTRACTOR SHALL CERTIFY AND TAG ALL BACKFLOW PREVENTERS PER FBC AND LOCAL AMENDMENTS AND SHALL PROVIDE A COPY OF THE CERTIFICATION REPORT TO ARCHITECT.
6. PROVIDE THREADED BALL VALVE WITH GHS CONNECTION SIZED FOR STRAINER BLOW OFF OR OWNER FOR SERVICING OF THE R.P.B.P.
7. ALL THREADED CONNECTIONS SHALL BE PROVIDED WITH TEFLON TAPE. PIPE DOPE IS NOT PERMITTED OR ACCEPTABLE.

TRAP PRIMER FROM FIXTURE	NTS
--------------------------	-----

PLUMBING AS-BUILTS NOTE

PLUMBING CONTRACTOR IS REQUIRED TO SUBMIT PLUMBING AS BUILT PLANS UPON COMPLETION OF THE PROJECT. COMPLETION IS DEFINED AS THE OWNER RECEIVING A "COT" AND PLUMBING INSPECTION HAS FINALIZED AND APPROVED THE INSTALLATION.

AS BUILTS SHALL BE SUBMITTED IN ELECTRONIC FASHION IN THEIR AUTOCAD FORMAT OR SCANNED FILES IN PDF FORMAT.

AS BUILTS SHALL BE LEGIBLE AND NEAT. AS BUILTS WILL BE RETAINED BY ARCHITECT AND ENGINEER FOR RECORDS OF CHANGES TO THE SYSTEM. AS BUILTS WILL BE SUBMITTED TO RECORD THROUGH ARCHITECT AND ENGINEER.

WATER HAMMER ARRESTOR SCHEDULE

FIXTURE UNITS	1-11	12-32	33-60	31-113	114-154	155-330
P&I UNITS	A	B	C	D	E	F
P&I SIZE	50"	14"	1"	1/4"	1/8"	2"

NOTE: SEE DISCS ON 30' LENGTH WATER PRESSURE UP TO 35 PSIG. WHEN WATER PRESSURE IN LINE EXCEEDS 35 PSIG, SELECT NEXT LARGER SIZE P&I—PLUMBING & IRGAINING INSTITUTE

DOMESTIC WATER PIPING SCHEDULE		
SIZE	CW FITTURE UNITS UP TO	HW FITTURE UNITS UP TO
3/8"	1.7	1.5
1/2"	5.4	4.0
1"	11	9.3
1 1/2"	30.4	25
2"	64	53
2 1/2"	165	142
3"	320	280
4"	520	458
6"	1130	980
8"	3675	3265

NOTE: DOMESTIC WATER PIPING SCHEDULE IS SHOWN FOR CONVENIENCE ONLY.

SHEET #	DESCRIPTION
P-001	SCHEDULES, DETAILS, NOTES & LEGENDS- PLUMBING
P-002	PLUMBING DETAILS
P-100	UNDERGROUND PLAN - PLUMBING
P-101	LEVEL 1 - SUPPLY
P-102	LEVEL 2 - SUPPLY
P-103	LEVEL 3 - SUPPLY
P-104	LEVEL 4 - SUPPLY
P-201	LEVEL 1 - WASTE & STORM
P-202	LEVEL 2 - WASTE & STORM
P-203	LEVEL 3 - WASTE & STORM
P-204	LEVEL 4 - WASTE & STORM
P-205	LEVEL 5 - WASTE & STORM
P-206	LEVEL 6 CANNOPY - WASTE & STORM
P-401A	ISOMETRIC RISER DIAGRAMS
P-401B	ISOMETRIC RISER DIAGRAMS
P-402A	ISOMETRIC RISER DIAGRAMS
P-402B	ISOMETRIC RISER DIAGRAMS
P-403	ISOMETRIC RISER DIAGRAMS
P-404A	ISOMETRIC RISER DIAGRAMS
P-404B	ISOMETRIC RISER DIAGRAMS

WATER HAMMER ARRESTOR SCHEDULE						
FIXTURE UNITS	1-11	12-32	33-60	31-113	114-154	155-330
PDI UNITS	A	B	C	D	E	F
PIPE SIZE	½"	¾"	1"	1½"	1½"	2"

NOTE: SIZING BASED ON 50 FT LENGTH AND WATER PRESSURE UP TO 65 PSIG. WHEN WATER PRESSURE IN LINE EXCEEDS 65 PSIG, SELECT NEXT LARGER SIZE. PDI-PLUMBING & DRAINAGE INSTITUTE

4. All water closets, urinals, and lavatories shall be white in color.

5. All stainless steel fixtures shall be provided with Everclean Antimicrobial Surface.

6. Installation of fixtures shall be fully coordinated with grab bars.

7. Provide Symmons Thermostatic water temperature limiting device #214-CC, ASSE 1017/1070, CSA B125.1, lead free, stainless steel, 1/2 gpm MIN, 2 gpm MAX on all faucets in public areas. Set temperature to 110°F.

details.

CSAIL

MILLER LEGG
5747 N Andrews Way
Ft. Lauderdale, FL 33309
1954.436.7000
1954.436.8664

LANDSCAPE
SAVINO MILLER DESIGN STUDIO
12345 NE 6th Avenue Suite A
North Miami, FL 33161
1 305.806.9082
1 305.806.9083

STRUCTURE

DDA ENGINEERS, P.A.
4930 SW 74th Street
Miami, FL 33155
1 305.866.0711
1 305.866.5259

NEPP

BR+A
2620 Douglas Road, Suite 301
Coral Gables, FL 33134
1 305.529.1515
1 305.529.1112

PARKING CONSULTANTS

DESMAN ASSOCIATES
10 E. Broward Boulevard, Suite 1710
Fort Lauderdale, FL 33301
1954.315.3924
1954.315.3899

Revisions


11	CITY OF MIAMI BEACH PERMIT COMMENTS	08/26/2016
7	VE CHANGES	08/14/16
1	Revised Permit Comment	11/26/14
NO	ISSUE	DATE

Date	Tue: September 4, 2014
Job Number	810408.000
Drawn	DAU
Checked	WBS
Approved	WBS

**SCHEDULES,
DETAILS, NOTES &
LEGENDS -
PLUMBING**


Sheet

P-001

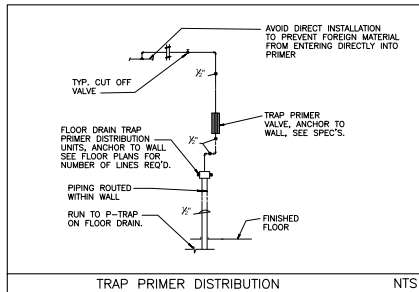


TRAP PRIMER DISTRIBUTION

NTS

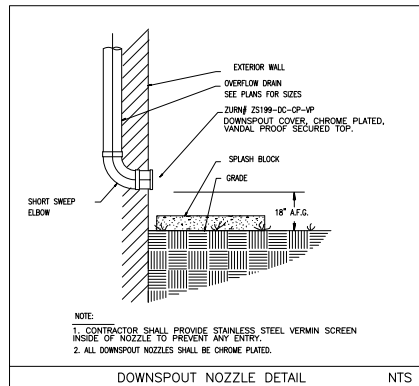


DOWNSPOUT NOZZLE DETAIL

NTS

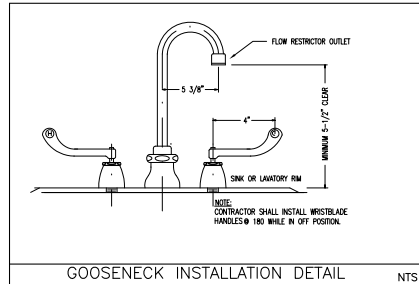


GOOSENECK INSTALLATION DETAIL

NTS

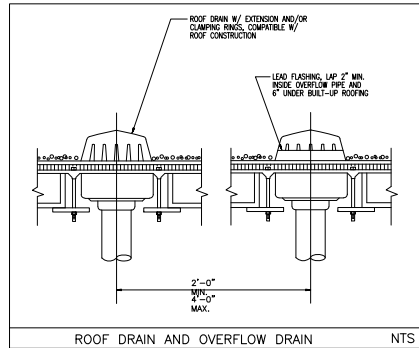


ROOF DRAIN AND OVERFLOW DRAIN

NTS

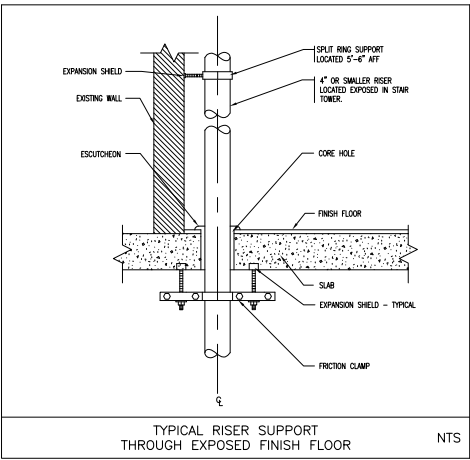


TYPICAL RISER SUPPORT THROUGH EXPOSED FINISH FLOOR

NTS

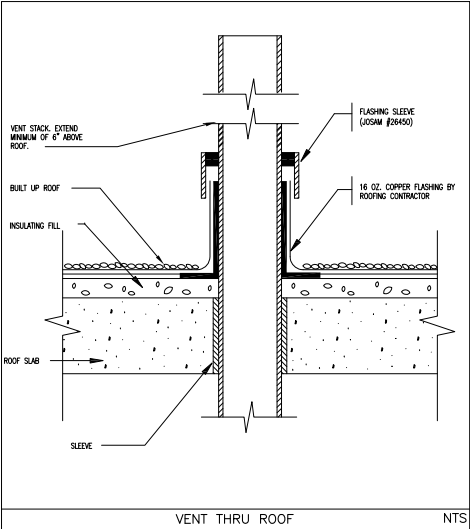


VENT THRU ROOF

NTS

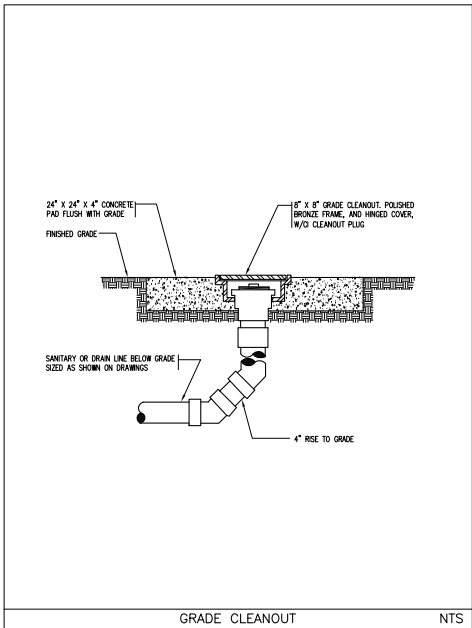


GRADE CLEANOUT

NTS

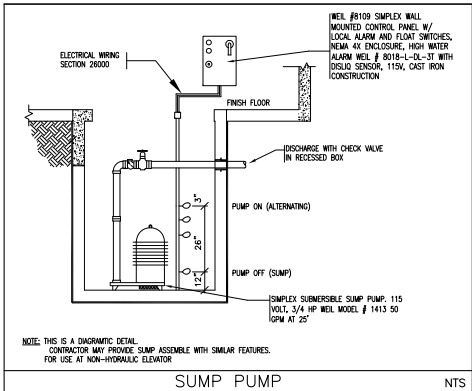


SUMP PUMP

NTS

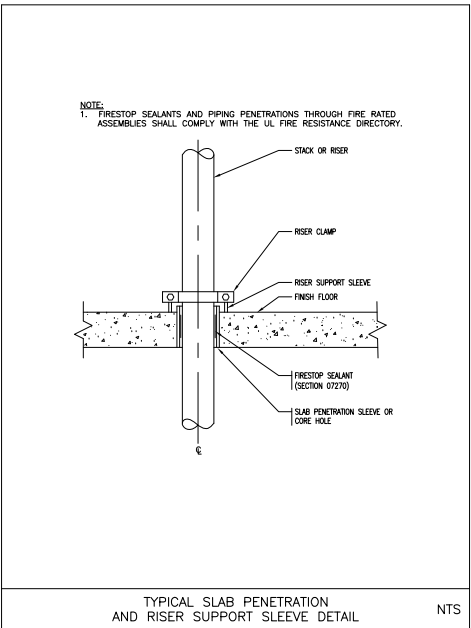


TYPICAL SLAB PENETRATION AND RISER SUPPORT SLEEVE DETAIL

NTS

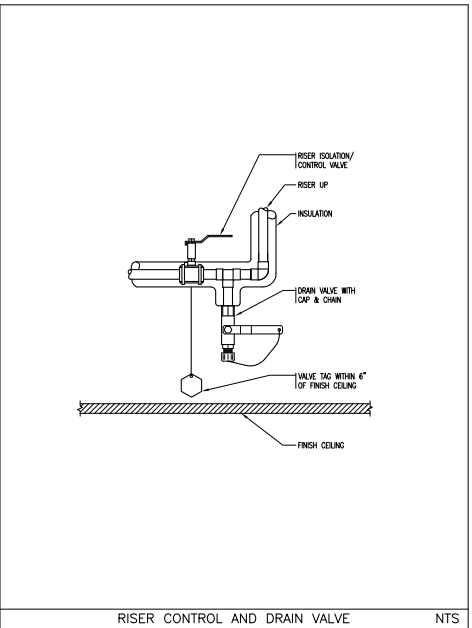


RISER CONTROL AND DRAIN VALVE

NTS

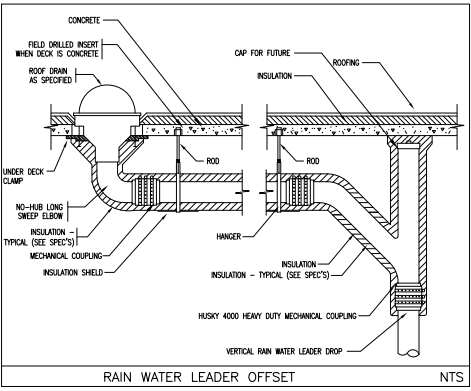


RAIN WATER LEADER OFFSET

NTS

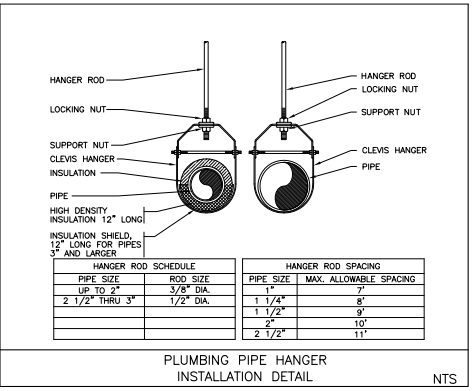

PLUMBING PIPE HANGER INSTALLATION DETAIL

NTS

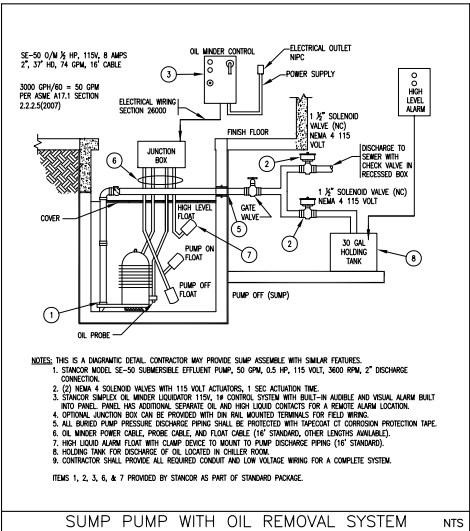


SUMP PUMP WITH OIL REMOVAL SYSTEM

NTS


CONDENSATE TRAP SCHEDULE									
TOTAL HEIGHT OF TRAP = 1/2" (X) + PIPE DIAMETER									
FOR DRAIN THRU UNITS					FOR BLOW THRU UNITS				
1/2" DIA. (PREFERRED) X 1/2" DIA. (MIN.)					1/2" DIA. (PREFERRED) X 1/2" DIA. (MIN.)				
PIPE SIZE	TONnage	FEET (INCHES)	AV. NEGATIVE STATE PRESS. (INCHES)	MAX. STATE PRESS. (INCHES)	PIPE SIZE	TONnage	FEET (INCHES)	AV. NEGATIVE STATE PRESS. (INCHES)	MAX. STATE PRESS. (INCHES)
1/2"					1/2"				
3/4"					3/4"				
1"					1"				
1 1/4"					1 1/4"				
1 1/2"					1 1/2"				
2"					2"				
2 1/2"					2 1/2"				

NOTE: ELEVATE A/C UNIT SUFFICIENT DISTANCE ABOVE FLOOR OR ROOF TO ALLOW FOR INSTALLATION OF TRAP WITH ACCURATE DIMENSIONS TO WITHSTAND SYSTEM OPERATING PRESSURE. COORDINATE WITH DETAIL FOR A/C UNIT MOUNTING.

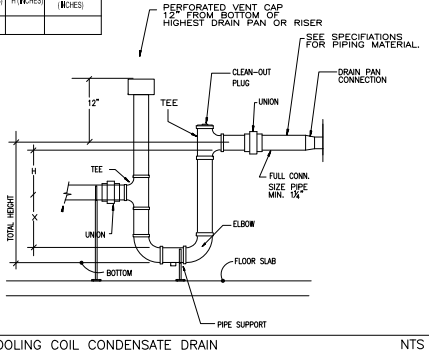


COOLING COIL CONDENSATE DRAIN

NTS

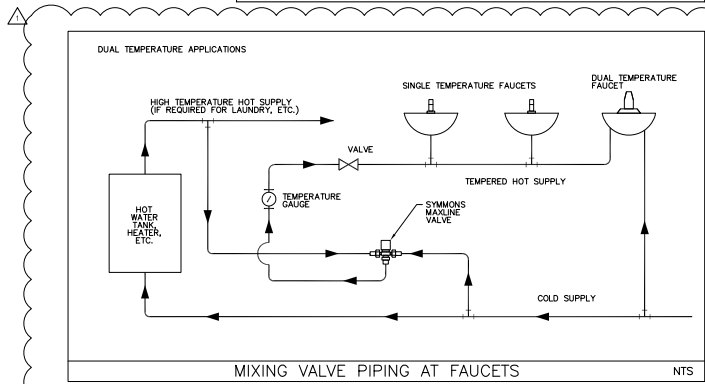


MIXING VALVE PIPING AT FAUCETS

NTS

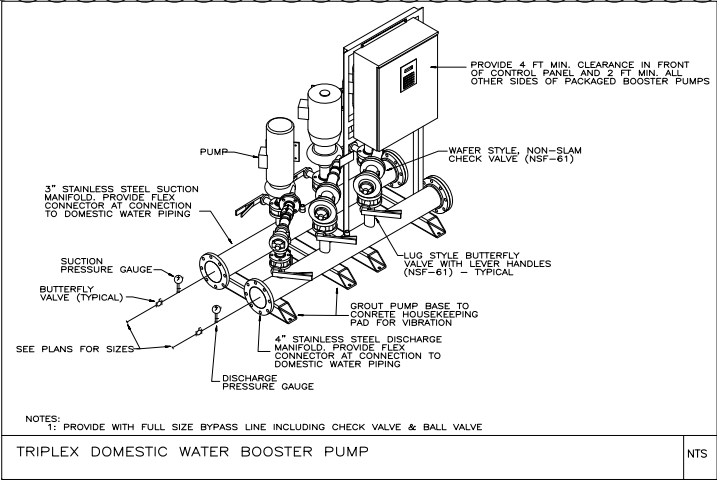

TRIPLEX DOMESTIC WATER BOOSTER PUMP

NTS

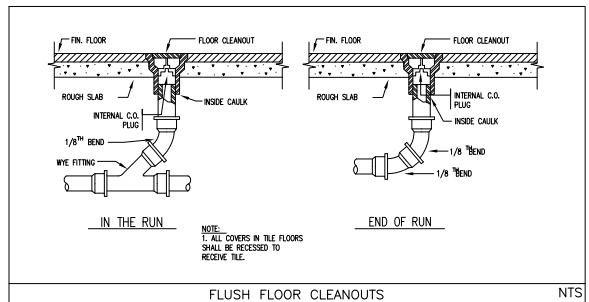

FLUSH FLOOR CLEANOUTS

NTS

PERKINS + WILL

800 Douglass Rd
Suite 100
Coral Gables, FL 33134
305.466.1333
305.466.1334
www.perkinswill.com

709 Alton Road

Crescent Heights

709 Alton Road Miami Beach, Florida, 33139

C.E.

MILLER LEGG
5747 N Andrews Way
Fort Lauderdale, FL 33309
1.954.436.7300
1.954.436.6884

LANDSCAPE

SAVINO MILLER DESIGN STUDIO
12345 NE 8th Avenue Suite A
North Miami, FL 33181
1.305.466.6982
1.305.466.6983

STRUCTURE

DOA ENGINEERS, P.A.
4830 SW 74th Street
Miami, FL 33155
1.305.466.6911
1.305.466.6239

MEPP

BR+A
2000 Douglas Road, Suite 301
Coral Gables, FL 33134
1.305.426.1915
1.305.426.1112

PAVING CONSULTANTS

DESMASSO ASSOCIATES
110 S. Broward Boulevard, Suite 1710
Fort Lauderdale, FL 33301
1.954.411.0384
1.954.411.0389

PERMIT SET

Revisions

NO.	REVISION	DATE
1	ISSUED FOR PERMIT	11/26/14
2	REVISED PERMIT	11/26/14

Sheet Information
Date: 11/26/14
Job Number: 870409-000
Drawn: CAU
Checked: WBS
Approved: WBS

PLUMBING DETAILS

Sheet
P-002

Copyright © 2013 Perkins + Will

PERMIT
SET

Revisions

NO.	PERMIT COMMENTS & FIELD COORDINATION	DATE
16	ISSUED FOR FIELD COORDINATION	09/21/17
15	CITY OF MIAMI BEACH PERMIT COMMENTS	09/20/17
14	UNDERGROUND UTILITIES AND COLUMN RELOCATION	09/20/17
13	REVISIONS	09/14/17
12	REVISIONS	09/14/17
11	REVISIONS	09/14/17
10	REVISIONS	09/14/17
9	REVISIONS	09/14/17
8	REVISIONS	09/14/17
7	REVISIONS	09/14/17
6	REVISIONS	09/14/17
5	REVISIONS	09/14/17
4	REVISIONS	09/14/17
3	REVISIONS	09/14/17
2	REVISIONS	09/14/17
1	REVISIONS	09/14/17


Sheet Information

Date	Issued: September 4, 2014
Job Number	810469.000
Drawn	SEC
Checked	DAP
Approved	DAP
Title	

UNDERGROUND
PLAN - PLUMBING

Sheet

P-100

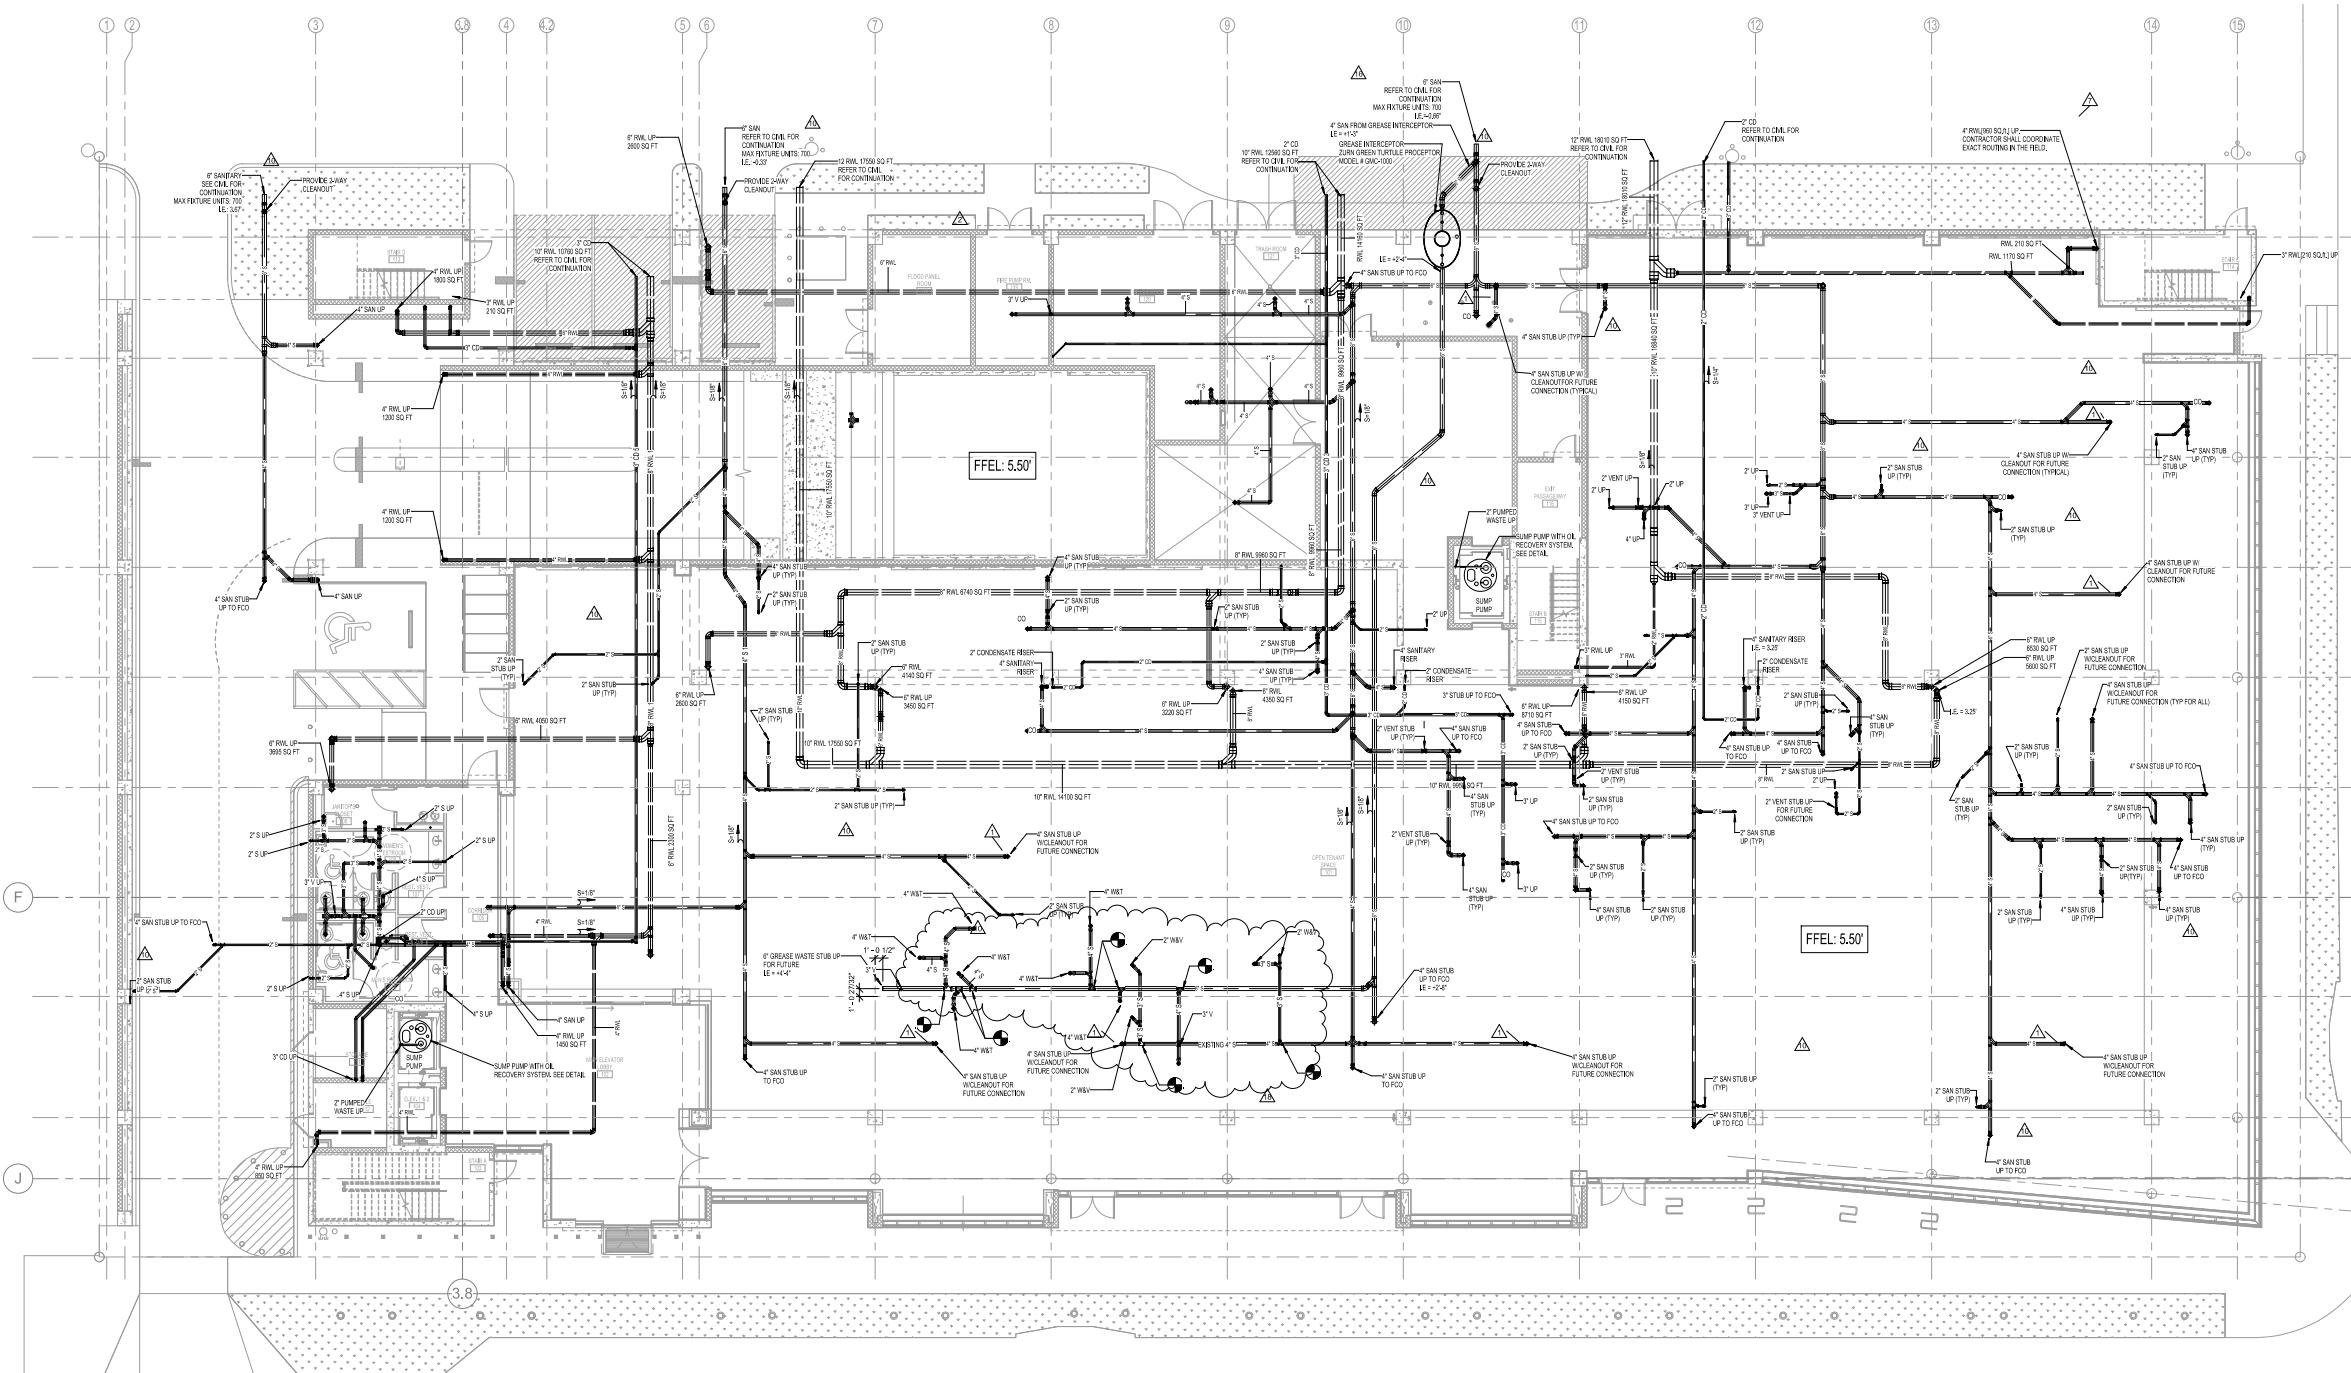

1 UNDERGROUND - WASTE & STORM
1/8" = 1'-0"

REFER TO 1ST FLOOR BAPTIST
OCEANIA TENANT FIT OUT
PROJECT FOR FIRST FLOOR STUB
UP CONTINUATION.

Crescent Heights

709 Alton Road Miami Beach,
Florida, 33139

310

MILLER LEGG
5747 N Andrews Way
Ft. Lauderdale, FL 33309
1954, 436, 7000
1954, 436, 8864

LANDSCAPE

O MILLER DESIGN STUDIO
12345 NE 6th Avenue Suite A
North Miami, FL 33151
1 305.895.0082
1 305.895.0083

STRUCTURE

DDA ENGINEERS, P.A.
4930 SW 74th Street
Miami, FL 33155

MEPP

BR+A

2600 Douglas Road, Suite 301
Coral Gables, FL 33134
1 305.529.1515
1 305.529.1112

PARKING CONSULTANTS

DESMAN ASSOCIATES
110 E. Broward Boulevard, Suite 1710
Fort Lauderdale, FL 33301
1954.315.3924
1954.315.3899

**PERMIT
SET**

Revisions

8	ZONING & GENERAL REVISIONS	11/12/15
7	VE CHANGES	08/14/15
3	CITY OF MIAMI BEACH REVISIONS	11/26/14
1	REVISED PERMIT COMMENTS	11/26/14
NO	ISSUE	DATE

Sheet Information


Date	09/02/14
Job Number	810408,000
Drawn	SEC
Checked	DAP
Approved	Approved
	Title

Level 1 - Supply

Sheet

P-101

Copyright © 2013 Perkins+Will

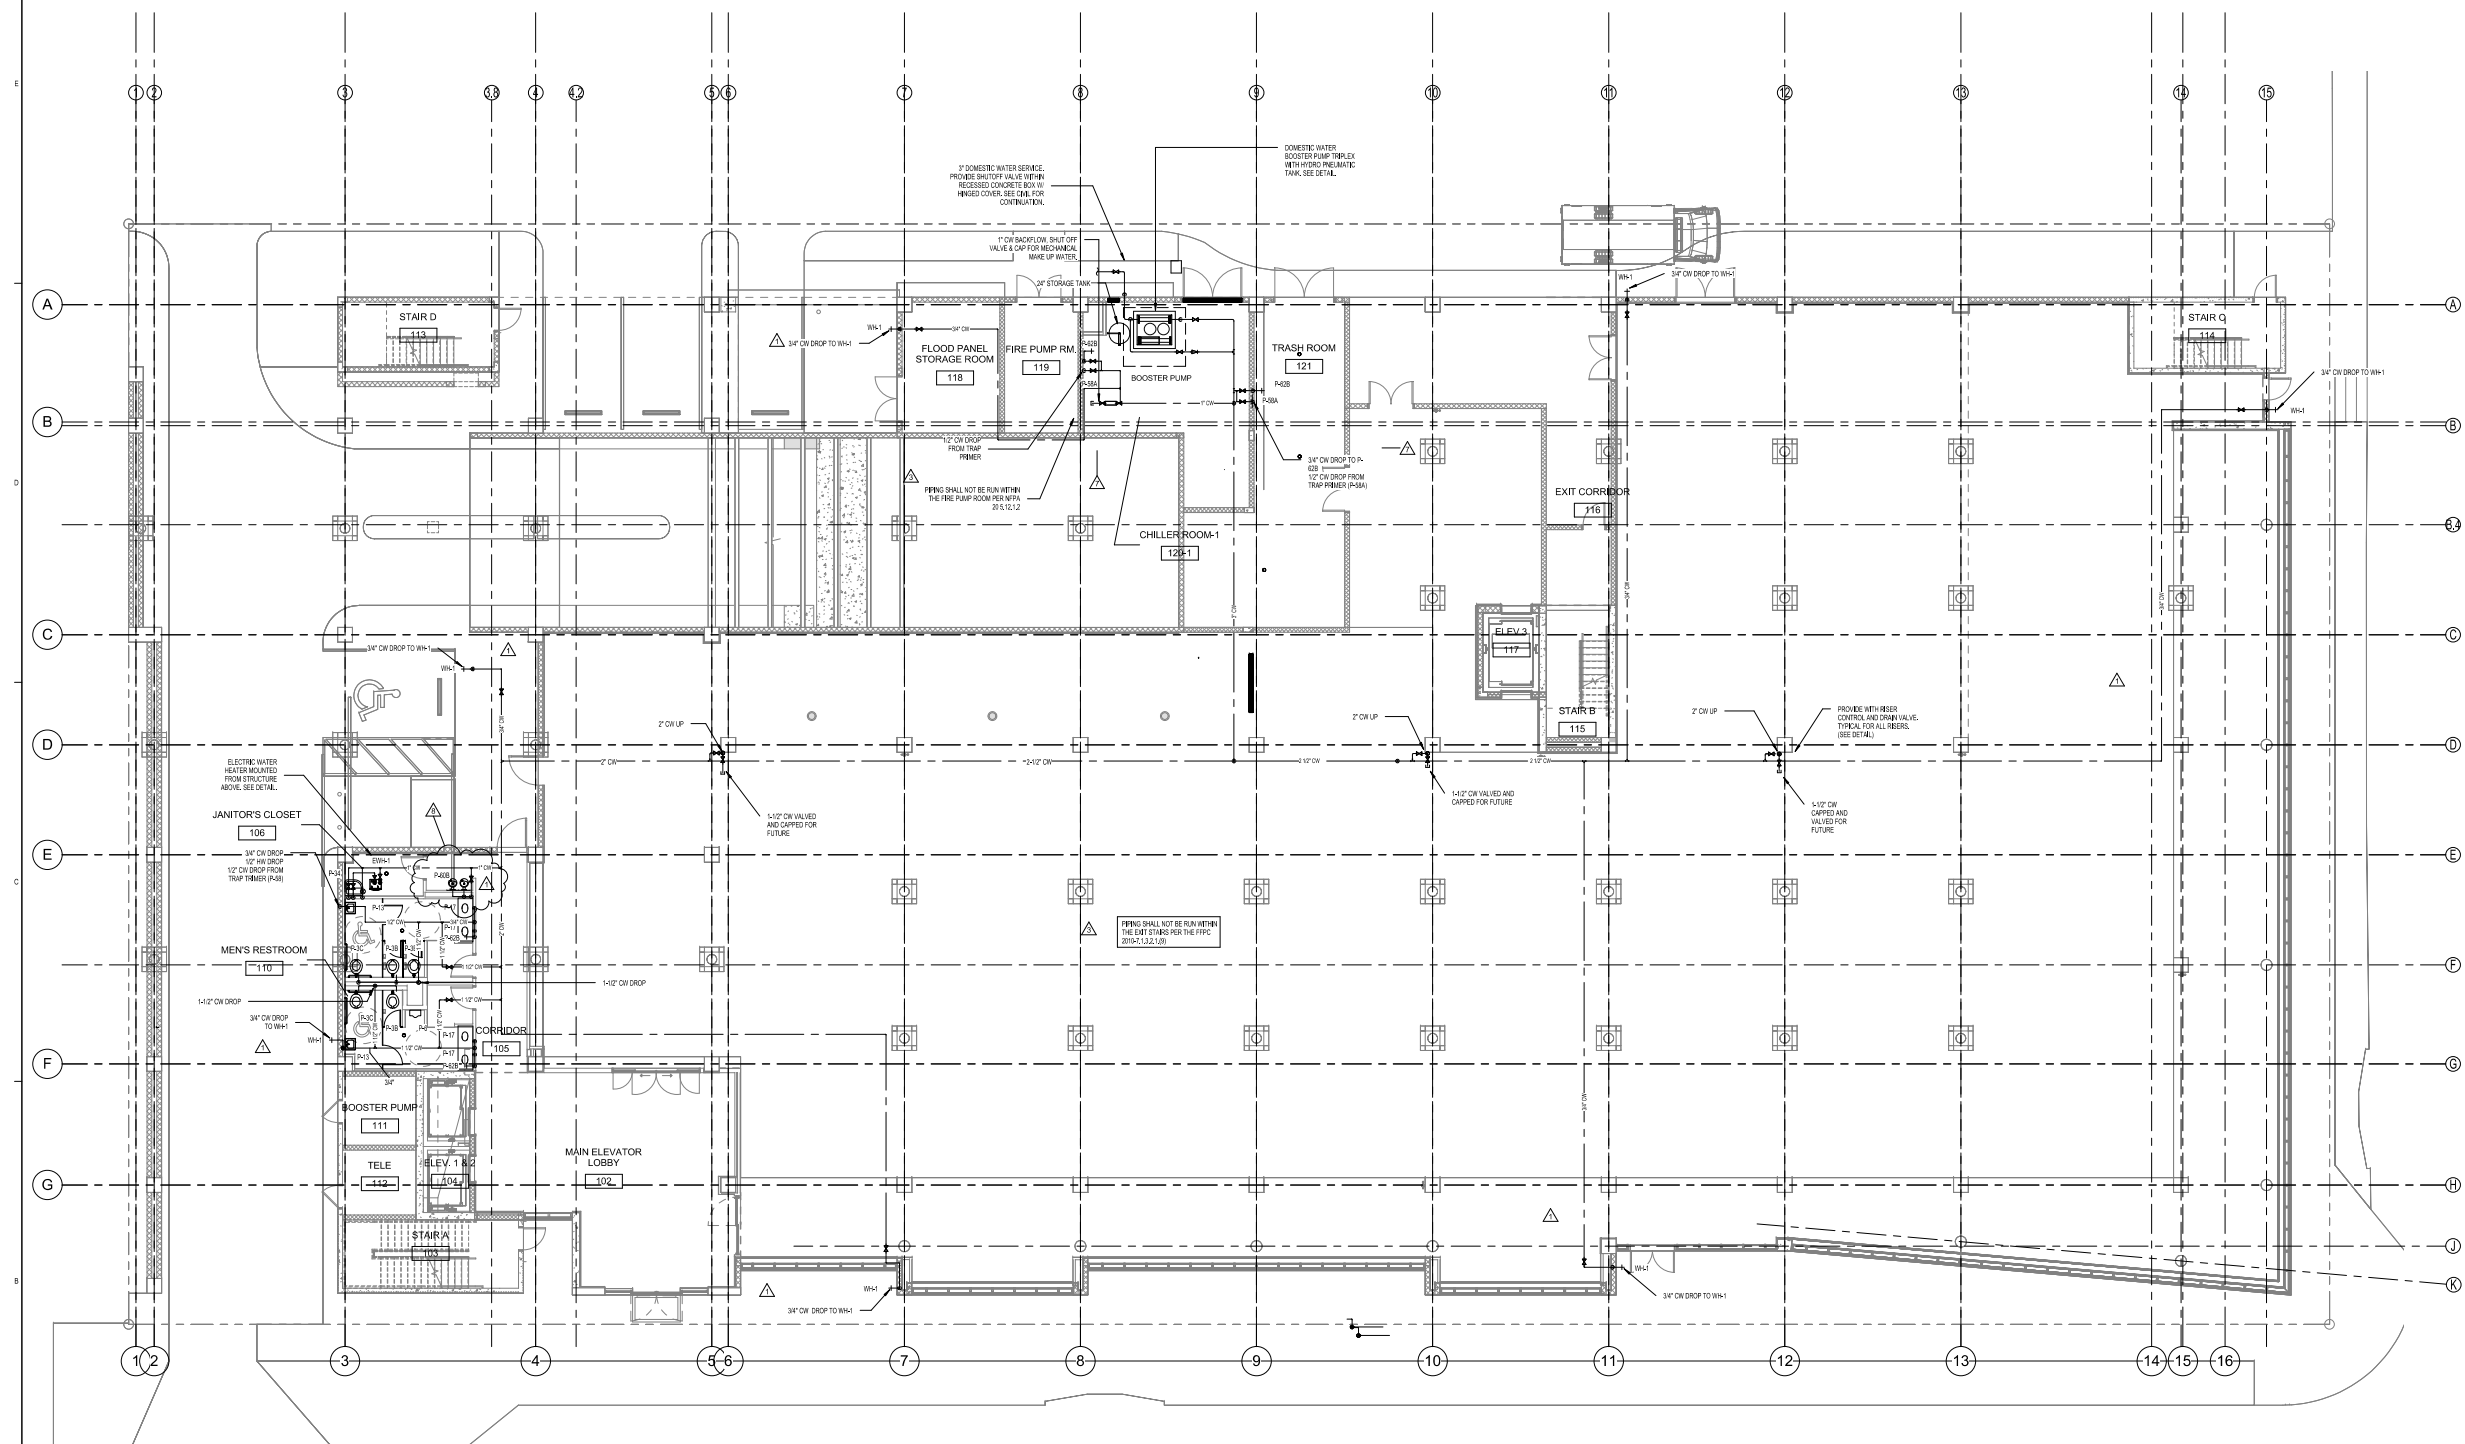

1 LEVEL 01 - Supply
1/8" = 1'-0"