
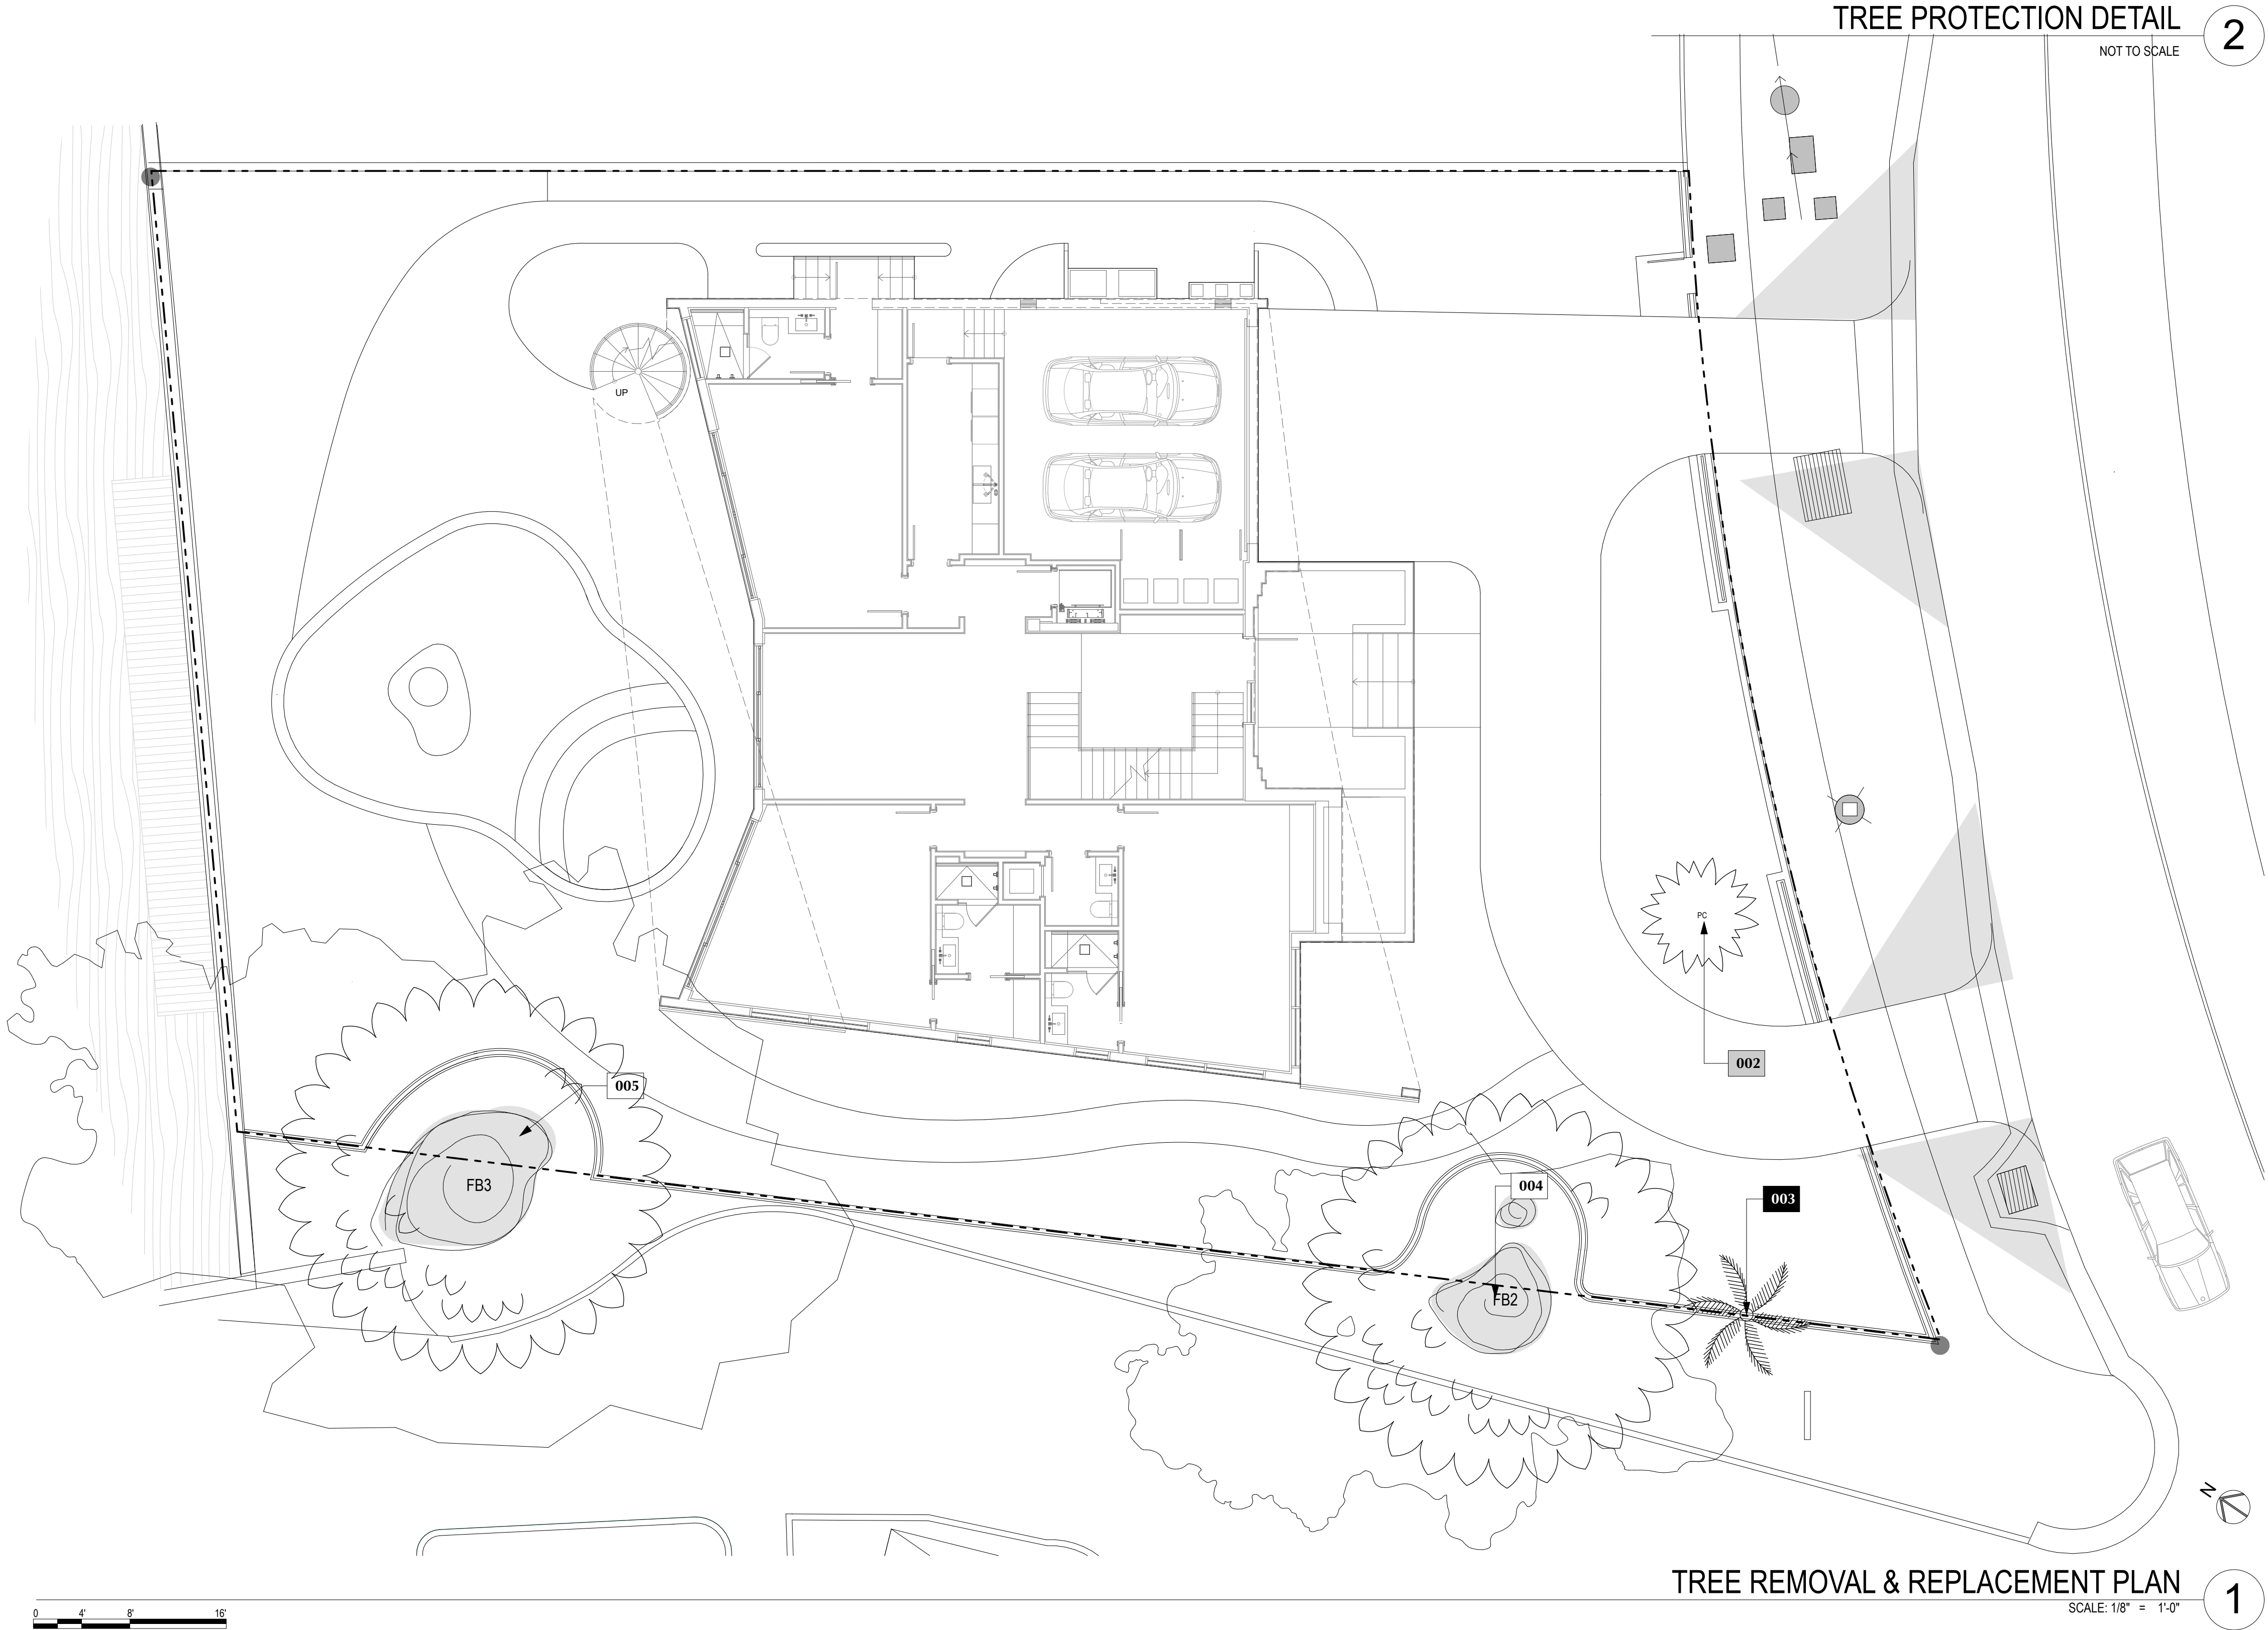


TREE REPLACEMENT CHART			
Category	Qty	Canopy Credit (ea.)	Canopy Credit Tree Name(s)
Category 1 Trees XL =		450	0
Category 1 Trees =	9	300	2,700 6 Gumbo Limbo, 1 Pitch Apple, 2 Bay Rum
Category 2 Trees =	8	150	1,200 7 Pigeon Plum, 1 Frangipani
Category 3 Trees =	8	100	800 1 Wax Myrtle, 1 Crape Myrtle, 5 Simpson Stopper, 1 Red Stopper
Category 4 Palms =	0	50	0
TOTALS	25		4,700
TREE SPECIES DIVERSITY (5 Species Provided)			
Required No. of Trees	Required minimum No. of Species		
01 - 20	2		
21 - 50	4		
51 or greater	6		


LEGEND			
EXISTING TREE TO REMAIN		000	
EXISTING TREE TO RELOCATE		000	
EXISTING TREE TO REMOVE		000	
RELOCATED TREE NEW LOCATION		000	

TREE / PALM DISPOSITION SCHEDULE													
TREE NUM	COMMON NAME	BOTANICAL NAME	HEIGHT FEET	WIDTH FEET	DBH INCHES	HEALTH CONDITION %	REMAIN	RELOCATE	REMOVE	SPECIMEN	CANOPY AREA (SF)	CALCULATED CANOPY (SF)	OBSERV.
002	Canary Island Date	<i>Phoenix canariensis</i>	15	8	18	75	X		X		50		RELOCATE
003	Royal Palm	<i>Roystonea elata</i>	50	20	18	45		X		X	314	314	Dead trunk
004	Banyan Tree	<i>Ficus aurea</i>	40	40	60	80	X		X		1257		Native sp.
005	Banyan Tree	<i>Ficus aurea</i>	35	60	72	80	X		X		2827		Native sp.
Total Canopy to be Mitigated:												314	

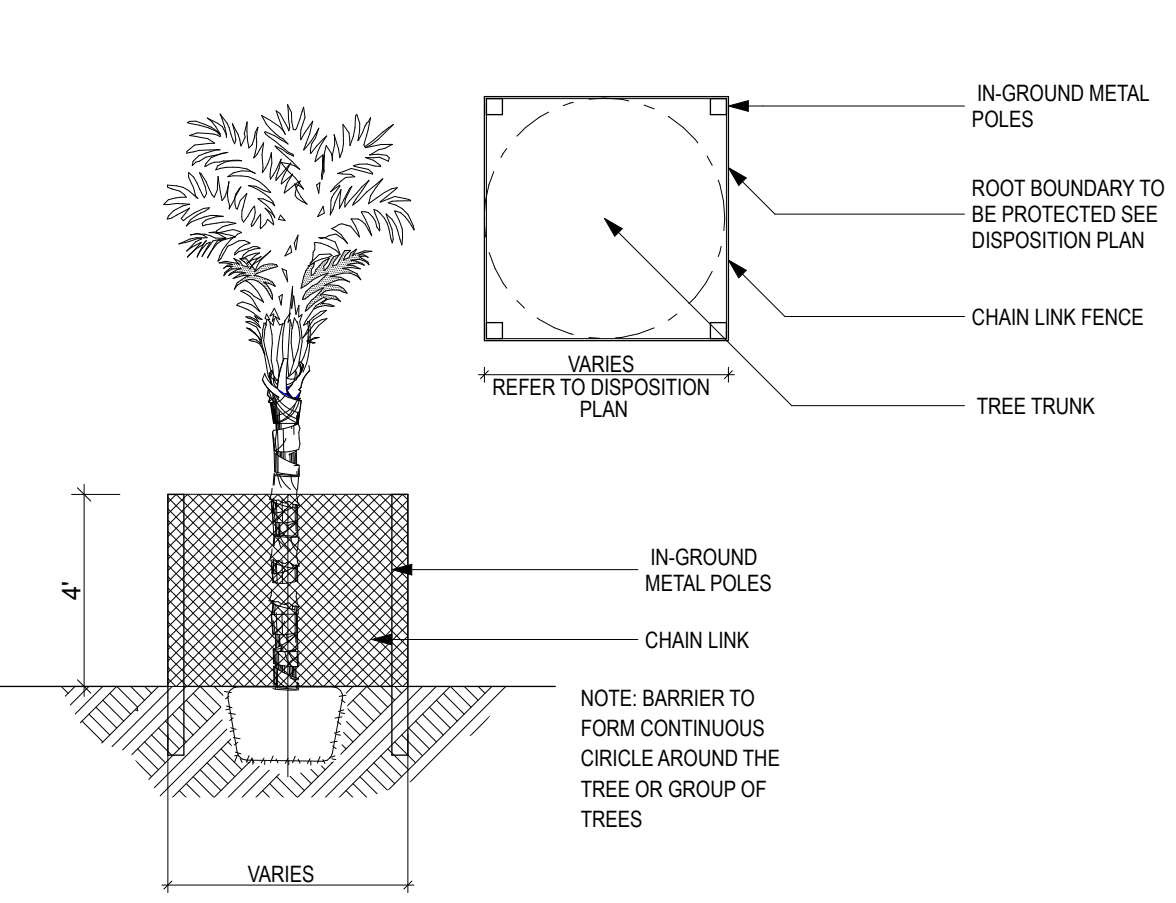

TREE REMOVAL & REPLACEMENT PLAN
SCALE: 1/8" = 1'-0"

2

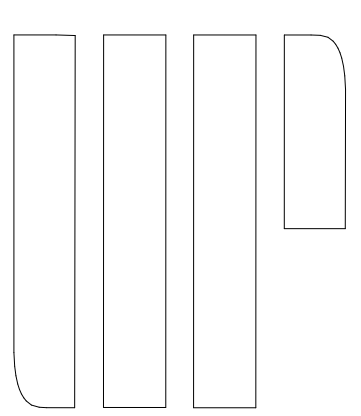

420 LINCOLN ROAD S 600 | MIAMI BEACH, FL 33139
T: 786.246.4857 | F: 786.768.2537 |
WWW.URBANROBOT.NET
URBAN ROBOT LLC

2000 NORTH BAY ROAD
Miami Beach, FL

SEAL


URBAN ROBOT LLC
A-26002760 ID:2601534 LC:26000510

REVISIONS		
ID	Date	Description

#Pin
PROJECT NO.
12/6/19
ML / RU / JV
DRAWN / CHECKED


TREE PROTECTION &
REPLACEMENT PLAN

L002

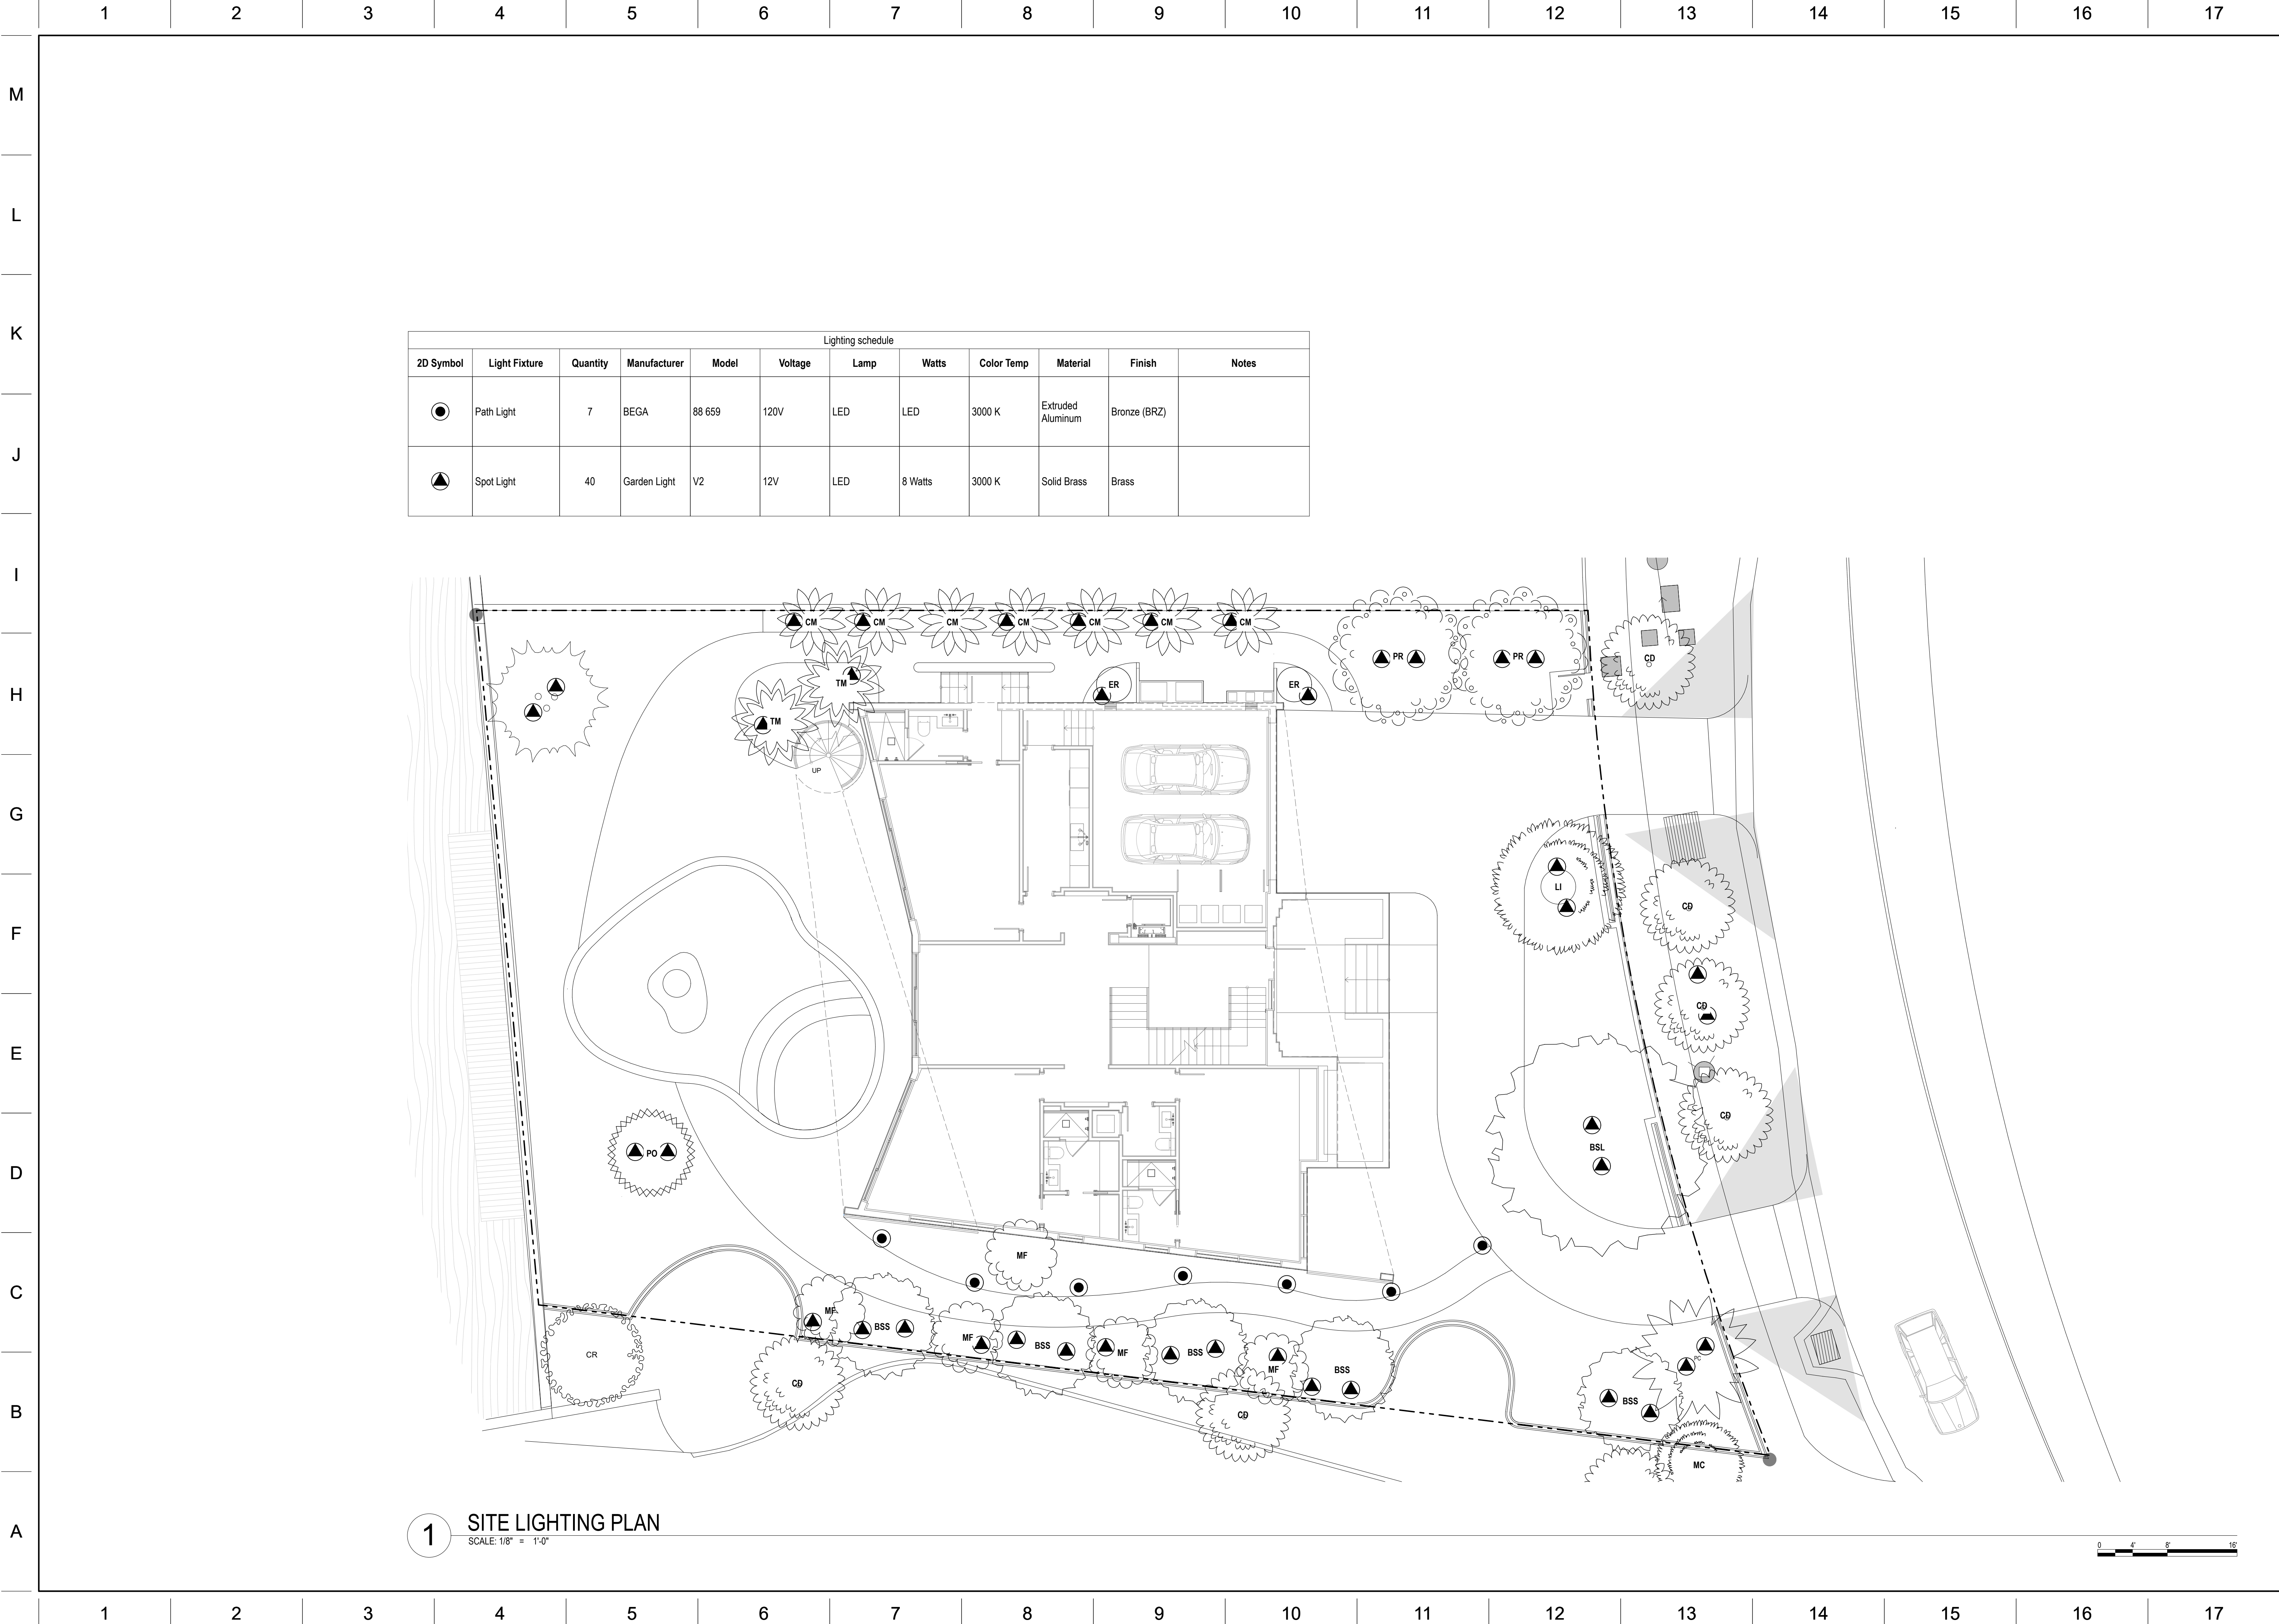

Lighting schedule											
2D Symbol	Light Fixture	Quantity	Manufacturer	Model	Voltage	Lamp	Watts	Color Temp	Material	Finish	Notes
	Path Light	7	BEGA	88 659	120V	LED	LED	3000 K	Extruded Aluminum	Bronze (BRZ)	
	Spot Light	40	Garden Light	V2	12V	LED	8 Watts	3000 K	Solid Brass	Brass	

1 SITE LIGHTING PLAN
SCALE: 1/8" = 1'-0"

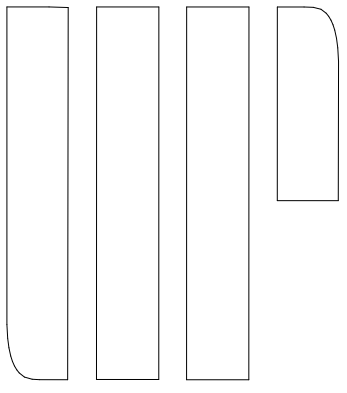

420 LINCOLN ROAD S 600 | MIAMI BEACH, FL 33139
T 786.246.4857 | F 786.768.2537 |
WWW.URBANROBOT.NET

URBAN ROBOT LLC

2000 NORTH BAY ROAD

Miami Beach, FL

SEAL

URBAN ROBOT LLC
A-20002780-020001534-LC28000510

REVISIONS

ID	Date	Description

#Pin

PROJECT NO.

12/6/19

ML / RU / JV

DRAWN / CHECKED

SITE LIGHTING PLAN

L300