



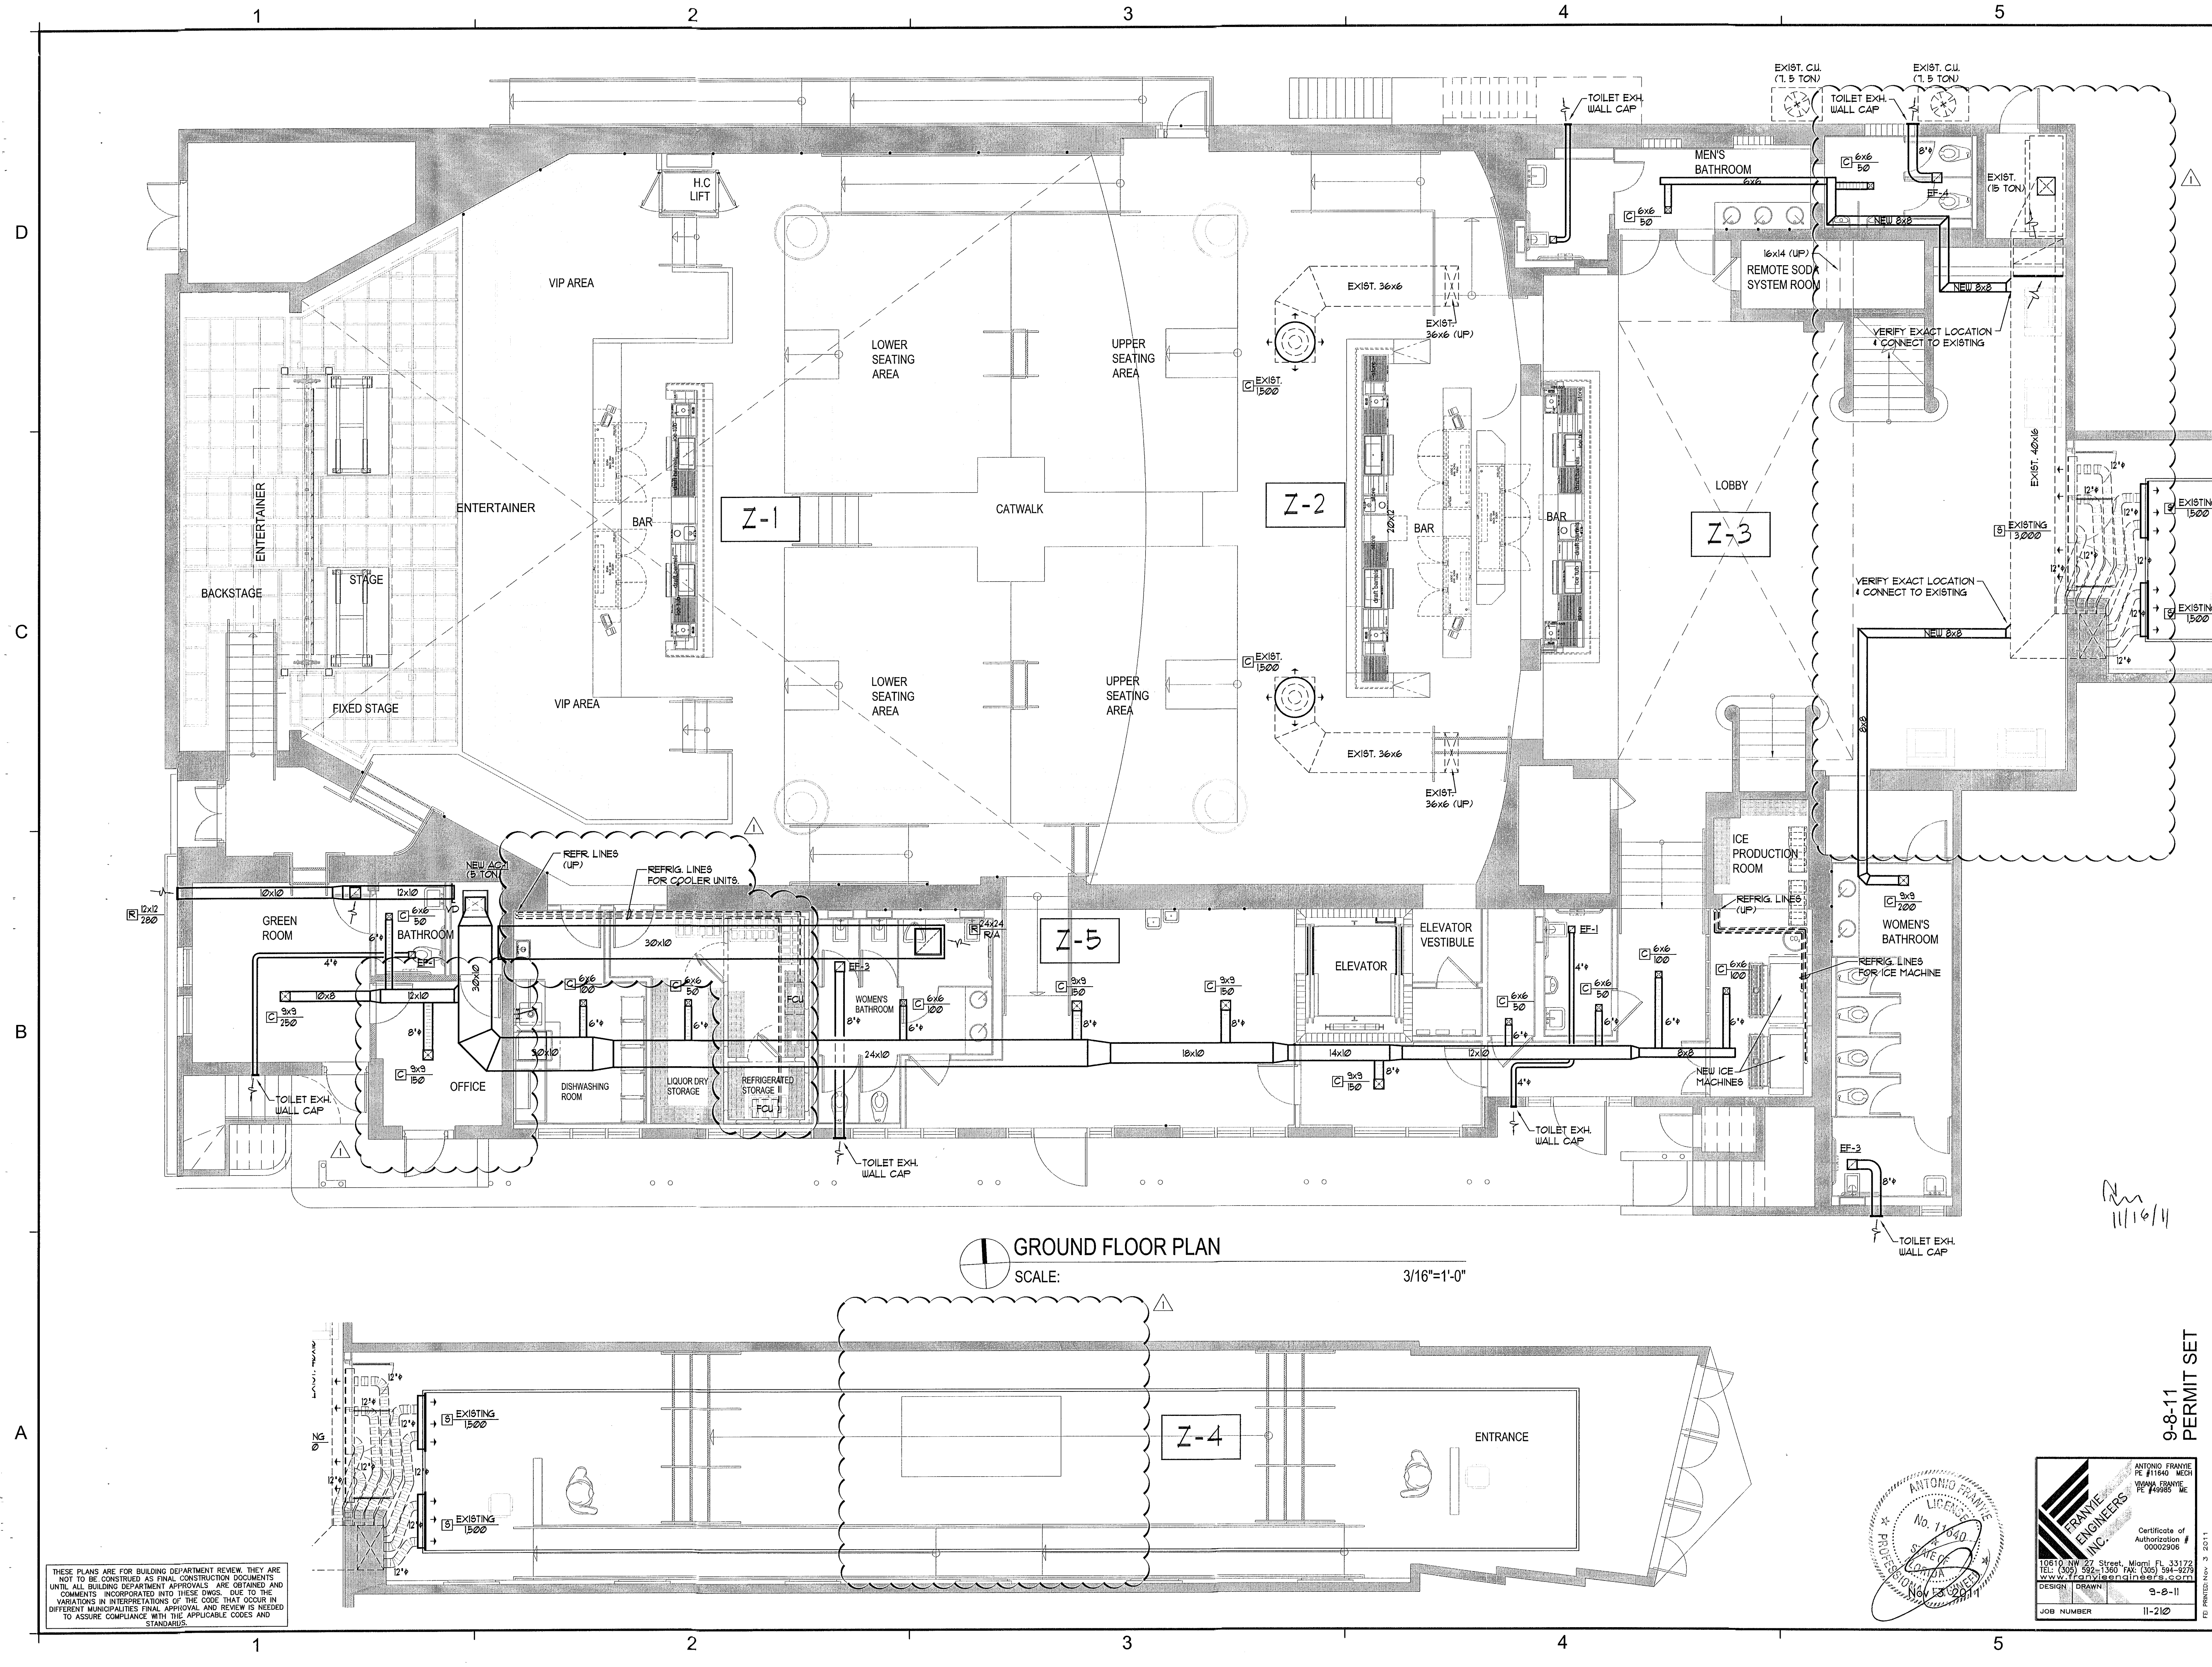

GROUND FLOOR PLAN
SCALE: 3/16"=1'-0"

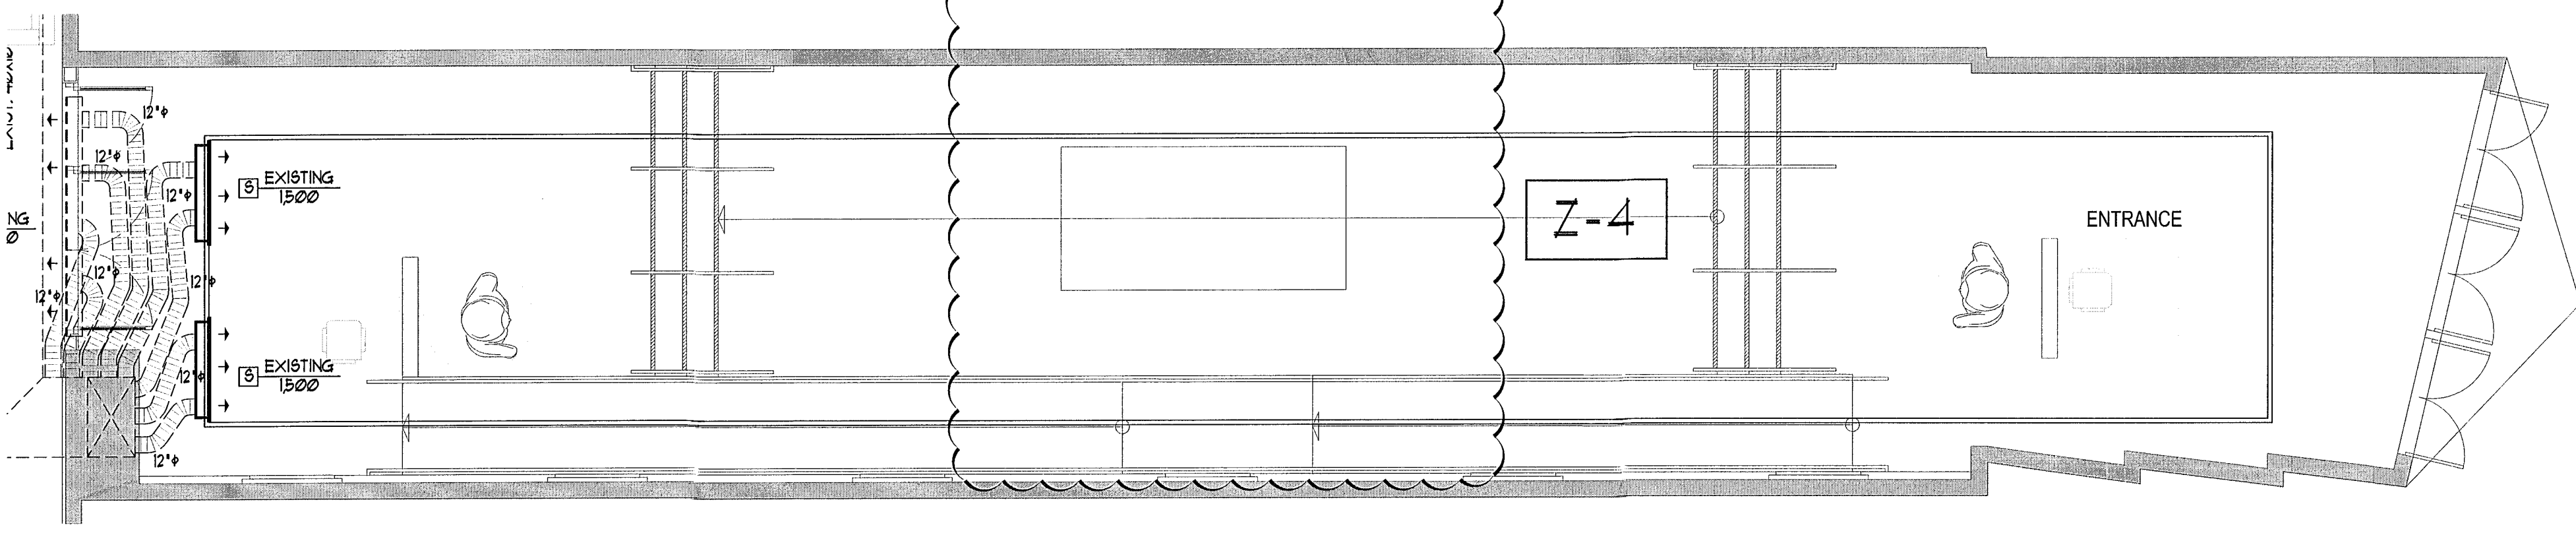

THESE PLANS ARE FOR BUILDING DEPARTMENT REVIEW. THEY ARE NOT TO BE CONSIDERED AS FINAL CONSTRUCTION DOCUMENTS UNTIL ALL BUILDING DEPARTMENT APPROVALS ARE OBTAINED AND COMMENTS INCORPORATED INTO THESE DWGS. DUE TO THE VARIATIONS IN INTERPRETATIONS OF THE CODE THAT OCCUR IN DIFFERENT MUNICIPALITIES, FINAL APPROVAL AND REVIEW IS NEEDED TO ASSURE COMPLIANCE WITH THE APPLICABLE CODES AND STANDARDS.

REVISIONS / SUBMISSIONS

11-2-II	BD/COORD.	AAF

1151

ALL DRAWINGS AND WRITTEN MATERIAL APPEARING HEREIN CONSTITUTE THE ORIGINAL AND UNPUBLISHED WORK OF KOB KARP AND MAY NOT BE COPIED, REPRODUCED, USED, OR DISCLOSED WITHOUT THE EXPRESS WRITTEN CONSENT OF KOB KARP ARCHITECTURE & INTERIOR DESIGN, INC. AIA, INC. 2011.

BAMBOO GROUP INC.

550 WASHINGTON AVENUE
MIAMI BEACH, FLORIDA

GROUND FLOOR PLAN

Lic. # AR0012578

ARCHITECTURE
INTERIOR DESIGN
PLANNING

AIA ASID NCARB
2915 Biscayne Boulevard
Suite 200
Miami, Florida 33137
P: 305.573.1818
F: 305.573.3746
WWW.KOBKARP.COM

9-8-11 PERMIT SET

ANTONIO FRAMIE
PE #11640 MECH
VIRGINIA FRAMIE
PE #00055 ME


ANTONIO FRAMIE
PE #11640 MECH
VIRGINIA FRAMIE
PE #00055 ME

10610 NW 27 Street, Miami, FL 33172
TEL: (305) 590-1360 FAX: (305) 594-2078
WWW.FRANIEENGINEERS.COM


DESIGN DRAWN 9-8-11
JOB NUMBER 11-212

DATE 09-08-11

M-100

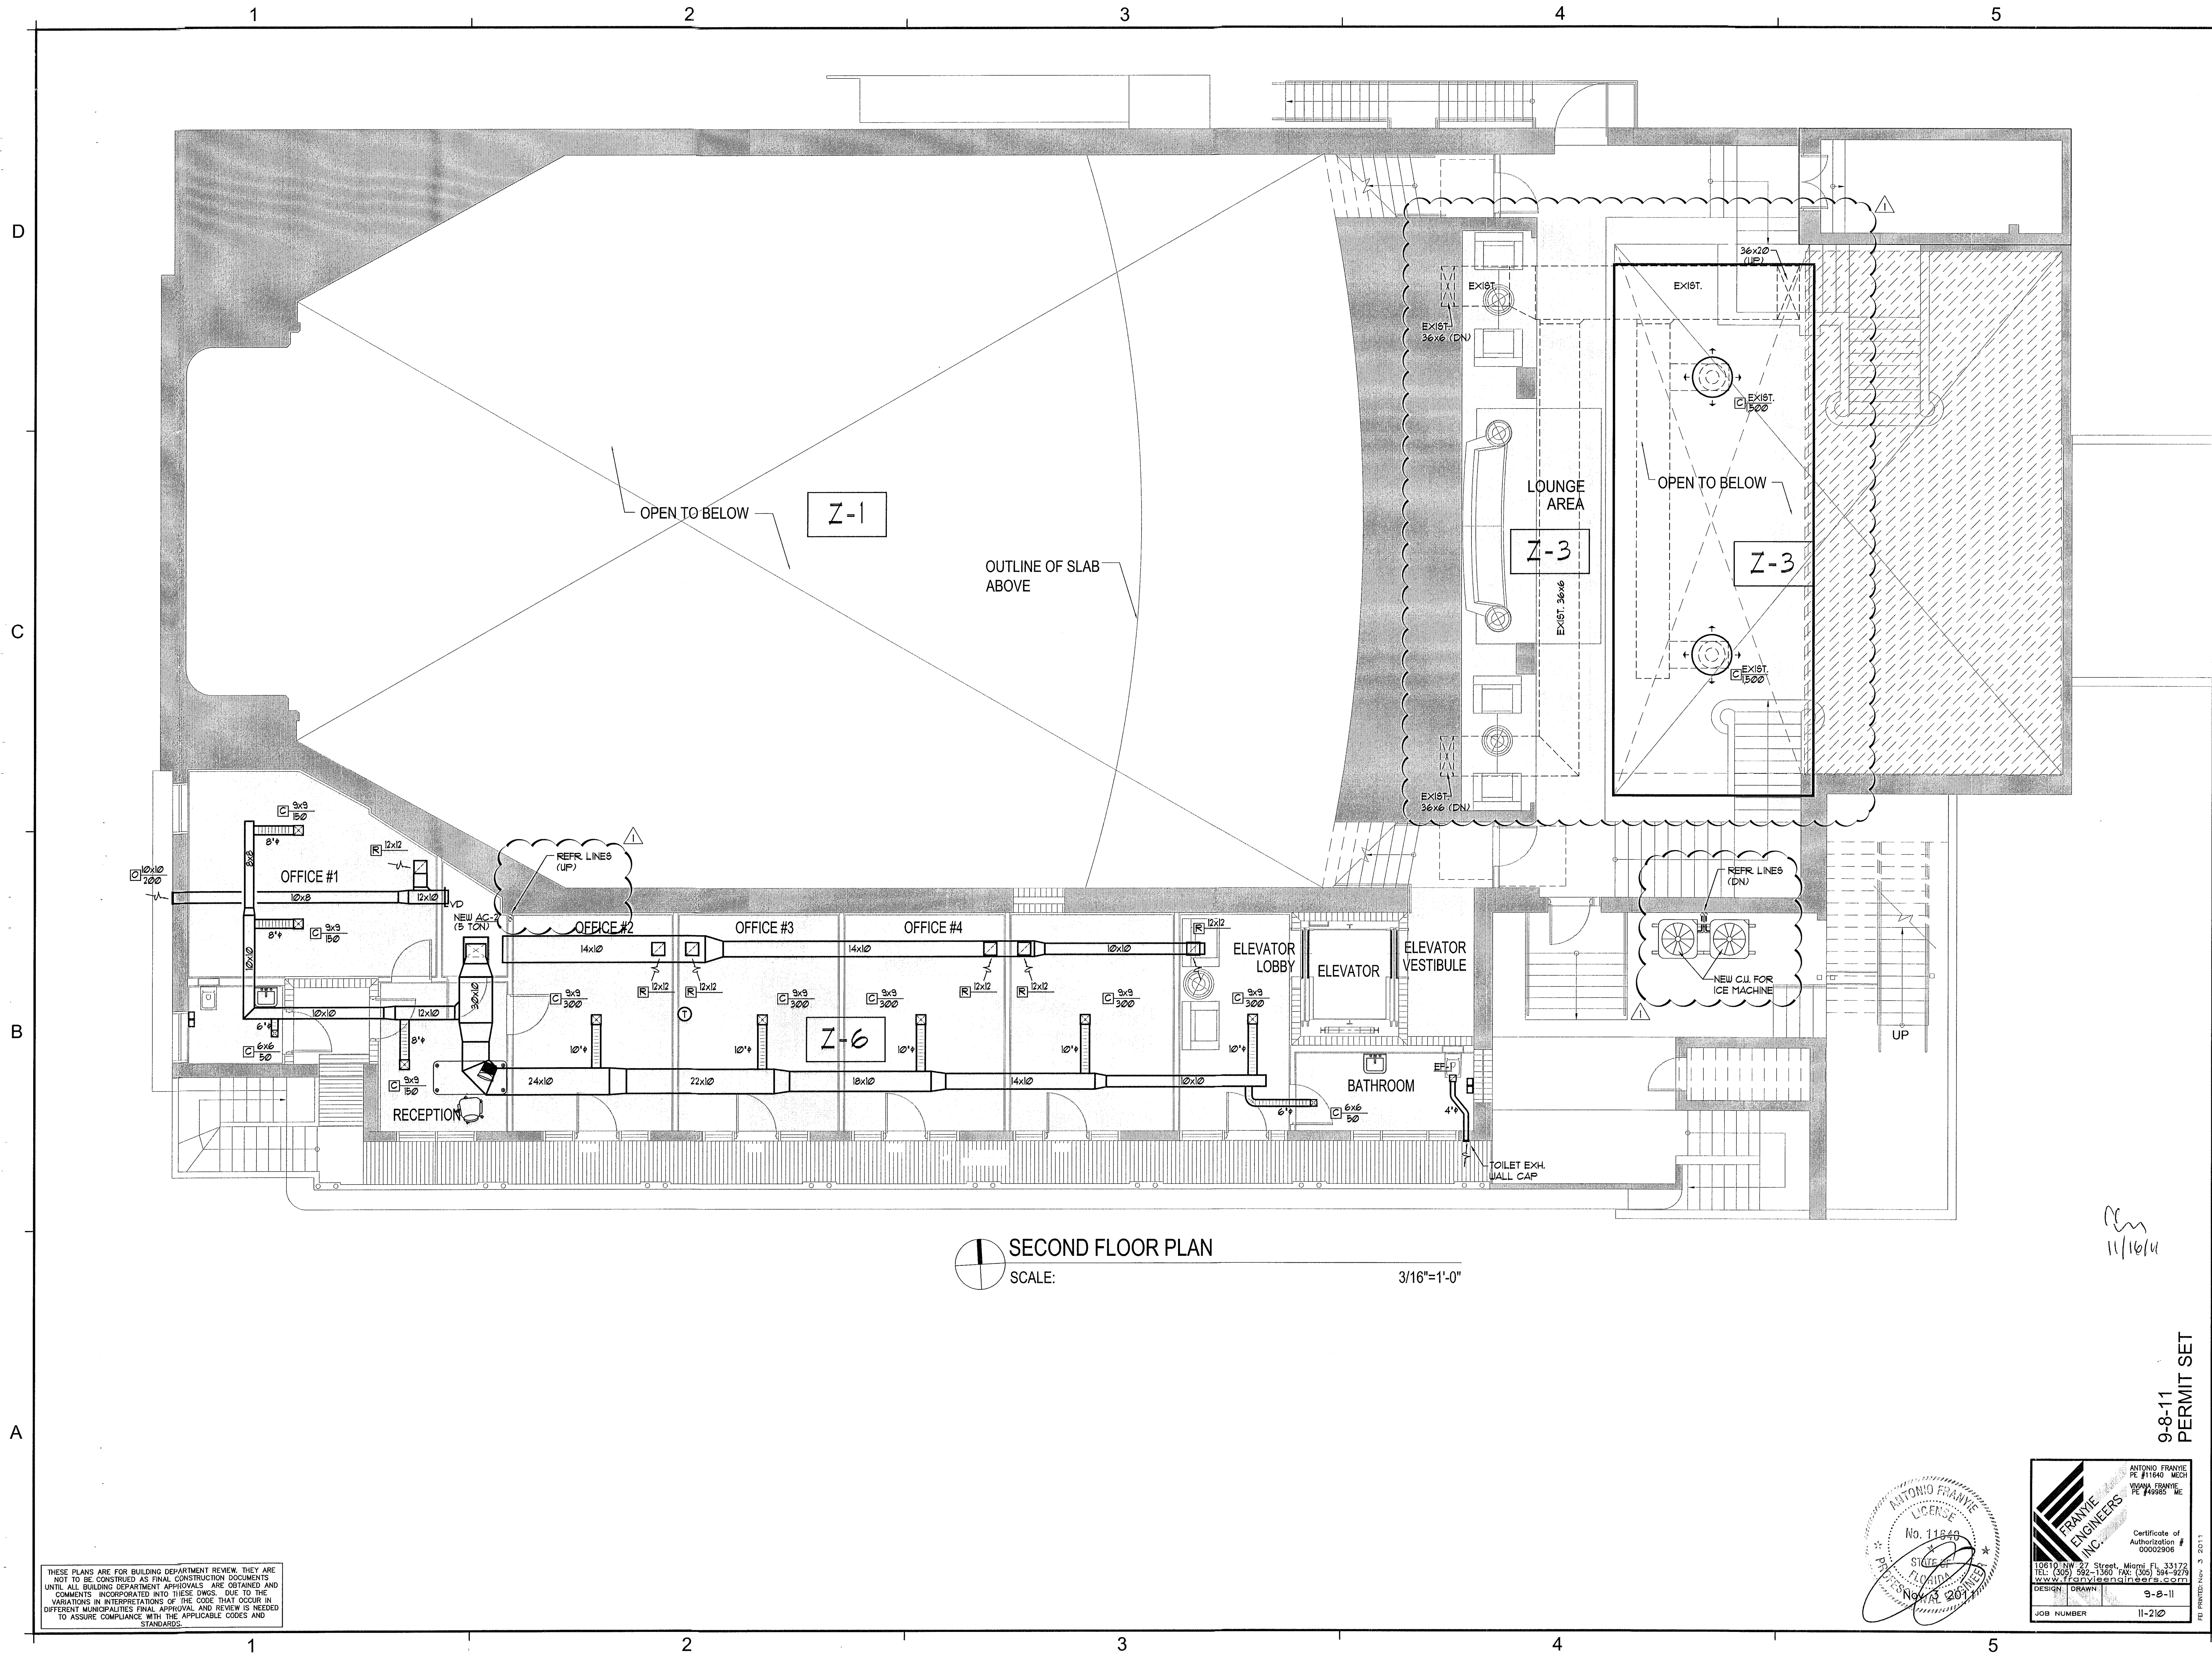

THESE PLANS ARE FOR BUILDING DEPARTMENT REVIEW. THEY ARE NOT TO BE CONSTRUED AS FINAL CONSTRUCTION DOCUMENTS UNTIL ALL BUILDING DEPARTMENT APPROVALS ARE OBTAINED AND COMMENTS INCORPORATED INTO THESE DWGS. DUE TO THE VARIATIONS IN INTERPRETATIONS OF THE CODE THAT OCCUR IN DIFFERENT MUNICIPALITIES FINAL APPROVAL AND REVIEW IS NEEDED TO ASSURE COMPLIANCE WITH THE APPLICABLE CODES AND STANDARDS.

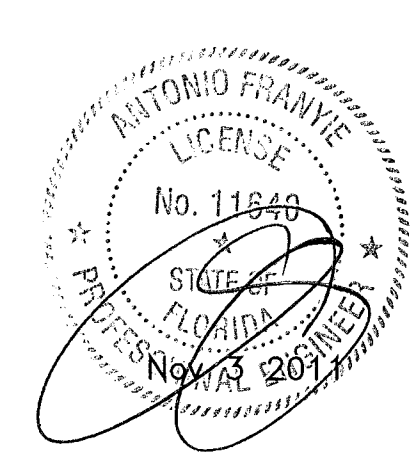

ANTONIO FRANKE
PE #11840, MECH
VIRGINIA FRANKE
PE #49985, ME
10610 NW 27 Street, Miami, FL 33172
TEL: (305) 592-1350 FAX: (305) 594-9279
www.frankeengineers.com
DESIGN: DRAWN: 9-8-11
JOB NUMBER: 11-210
FD PRINTED Nov. 3 2011

9-8-11
PERMIT SET

REVISIONS / SUBMISSIONS	
11-2-11 BD/COORD.	AAF


1151

ALL DRAWINGS AND WRITTEN MATERIAL APPEARING HEREIN CONSTITUTE THE ORIGINAL AND UNPUBLISHED WORK OF KOB KARP AIA, AND MAY NOT BE DUPLICATED, USED, OR DISCLOSED WITHOUT THE EXPRESS WRITTEN CONSENT OF KOB KARP ARCHITECTURE & INTERIOR DESIGN, INC. AIA, © 2011.

BAMBOO GROUP INC.
550 WASHINGTON AVENUE
MIAMI BEACH, FLORIDA



SECOND FLOOR PLAN

ARCHITECTURE
INTERIOR DESIGN
PLANNING
AIA ASID NCARB
Suite 200
2915 Biscayne Boulevard
Miami Beach, FL 33137
Tel: 305.573.8811
F: 305.573.3766
WWW.KOBKARP.COM

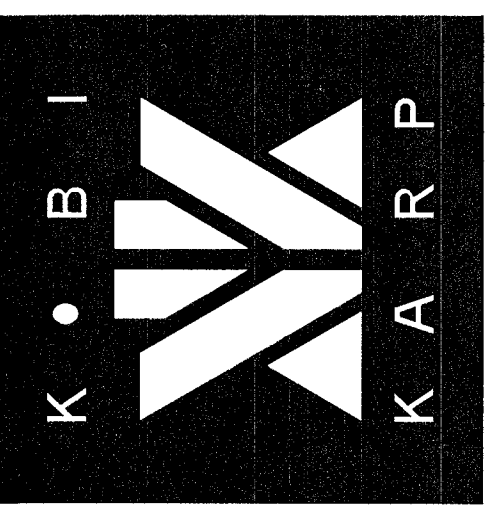

DRAWN BY: MD,JO
CHECKED BY: JG
DATE: 09-08-11

M-101

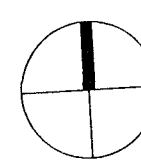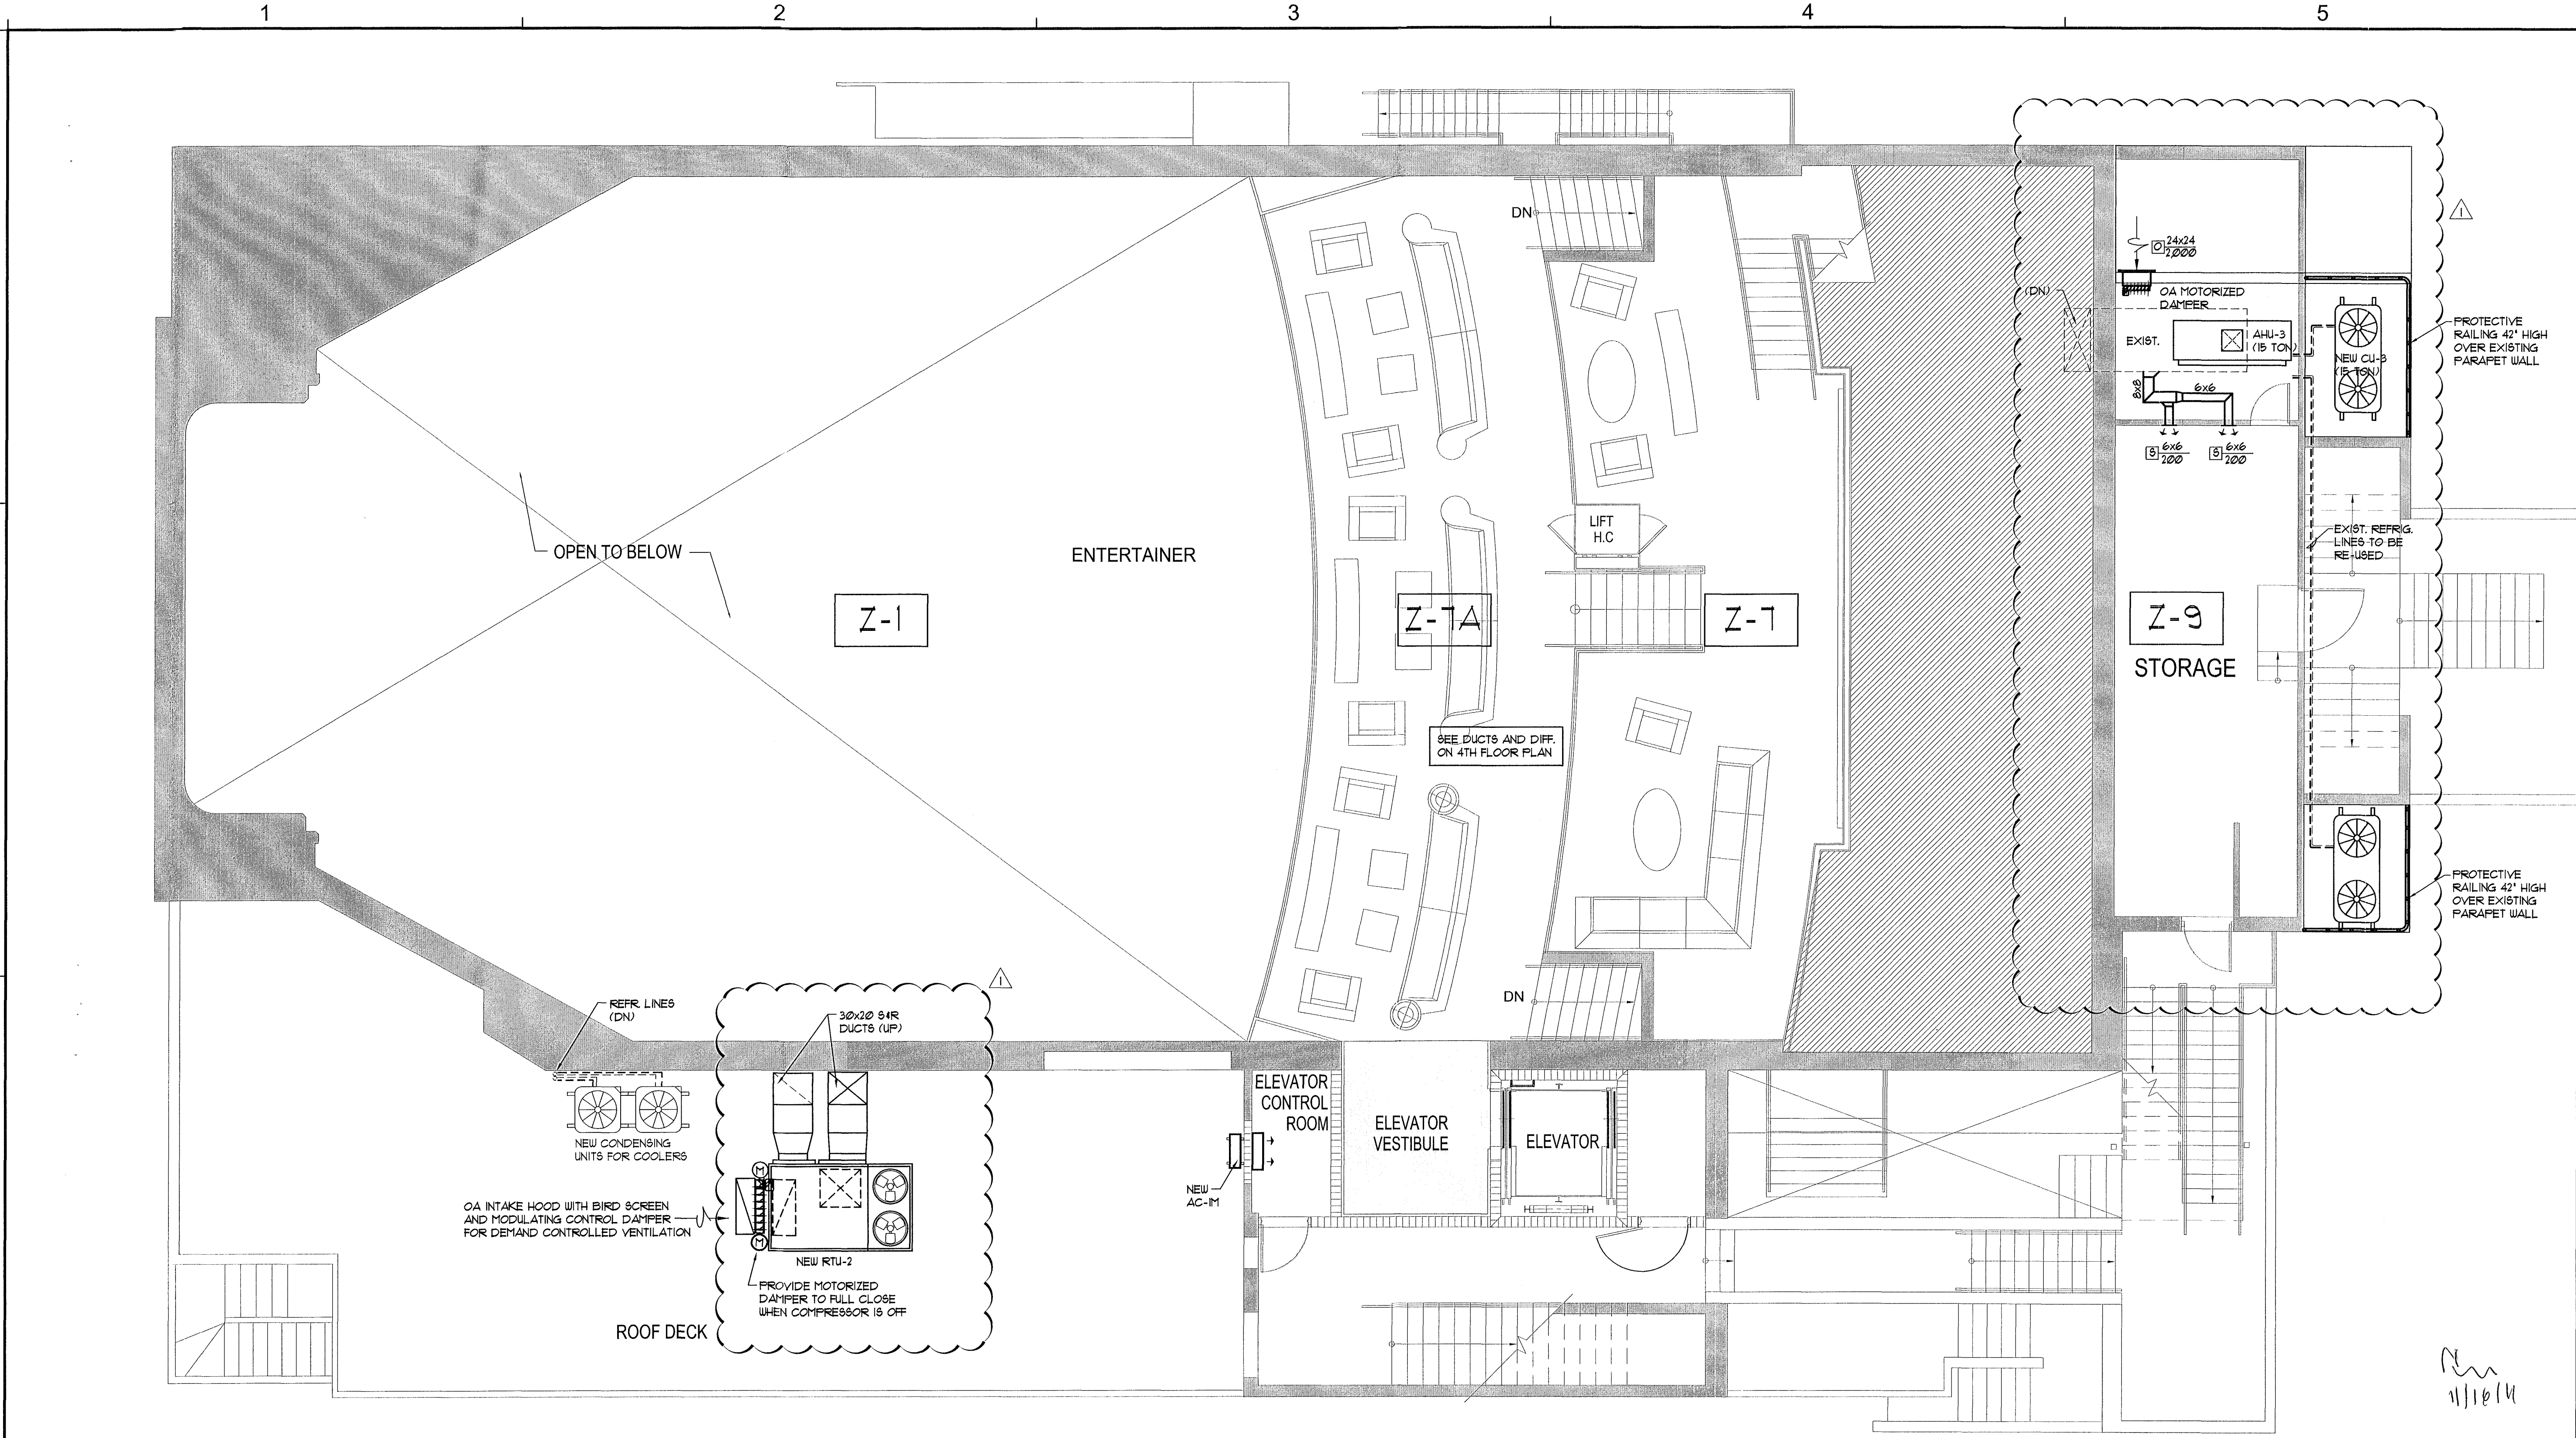

THIRD FLOOR PLAN

SCALE:

3/16"=1'-0"

THESE PLANS ARE FOR BUILDING DEPARTMENT REVIEW. THEY ARE NOT TO BE CONSTRUED AS FINAL CONSTRUCTION DOCUMENTS UNTIL ALL BUILDING DEPARTMENT APPROVALS ARE OBTAINED AND COMMENTS INCORPORATED INTO THESE DWGS. DUE TO THE VARIATIONS IN INTERPRETATIONS OF THE CODE THAT OCCUR IN DIFFERENT MUNICIPALITIES FINAL APPROVAL AND REVIEW IS NEEDED TO ASSURE COMPLIANCE WITH THE APPLICABLE CODES AND STANDARDS.


REVISIONS / SUBMISSIONS		
II-2-II	BD/COORD	AAF

1151

ALL DRAWINGS AND WRITTEN MATERIAL APPEARING HEREIN CONSTITUTE THE ORIGINAL AND UNPUBLISHED WORK OF KOB GROUP INC. AND MAY NOT BE REPRODUCED, COPIED, OR DISCLOSED WITHOUT THE EXPRESS WRITTEN CONSENT OF KOB GROUP ARCHITECTURE & INTERIOR DESIGN, INC. (KOB GROUP INC.)

BAMBOO GROUP INC.
550 WASHINGTON AVENUE
MIAMI BEACH, FLORIDA

THIRD FLOOR PLAN

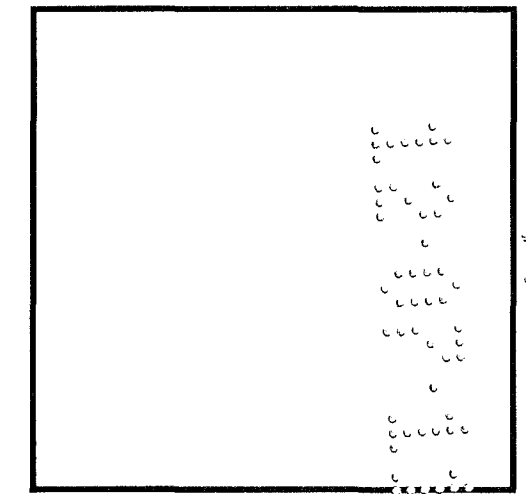


ARCHITECTURE
INTERIOR DESIGN
PLANNING

AIA ASID NCARB
2015 Biscayne Boulevard
Suite 200
Miami, Florida 33137
P: 305.573.3766
WWW.KOBKARP.COM

ARCHITECTURE
INTERIOR DESIGN
PLANNING

AIA ASID NCARB
2015 Biscayne Boulevard
Suite 200
Miami, Florida 33137
P: 305.573.3766
WWW.KOBKARP.COM

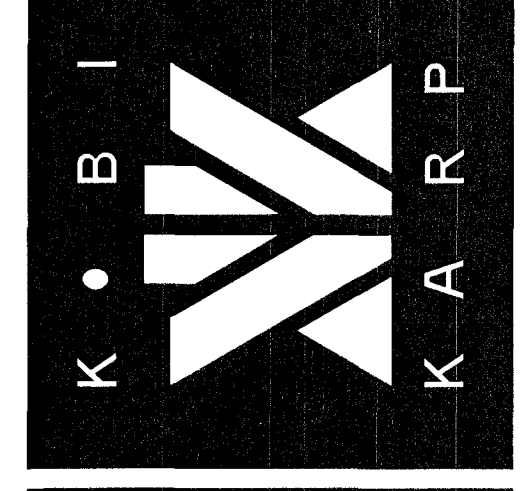

DRAWN BY:	MD,JO
CHECKED BY:	JG
DATE:	09-08-11
M-102	

9-8-11 PERMIT SET


ANTONIO FRAYNE
PE #11640 MECH
WANDA FRAYNE
PE #10805 ME



FRAYNE
ENGINEERS
INC.

Certificate of
Authorization
00002906

10010 NW 27 Street, Miami, FL 33172
TEL: (305) 592-1360 FAX: (305) 594-3273
WWW.FRAYNEENGINEERS.COM

DESIGN: DRAWN: 9-8-11
JOB NUMBER: 11-210

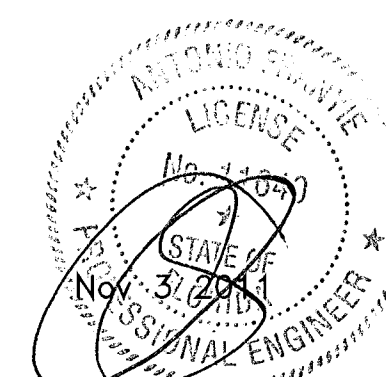


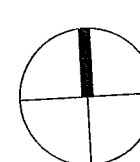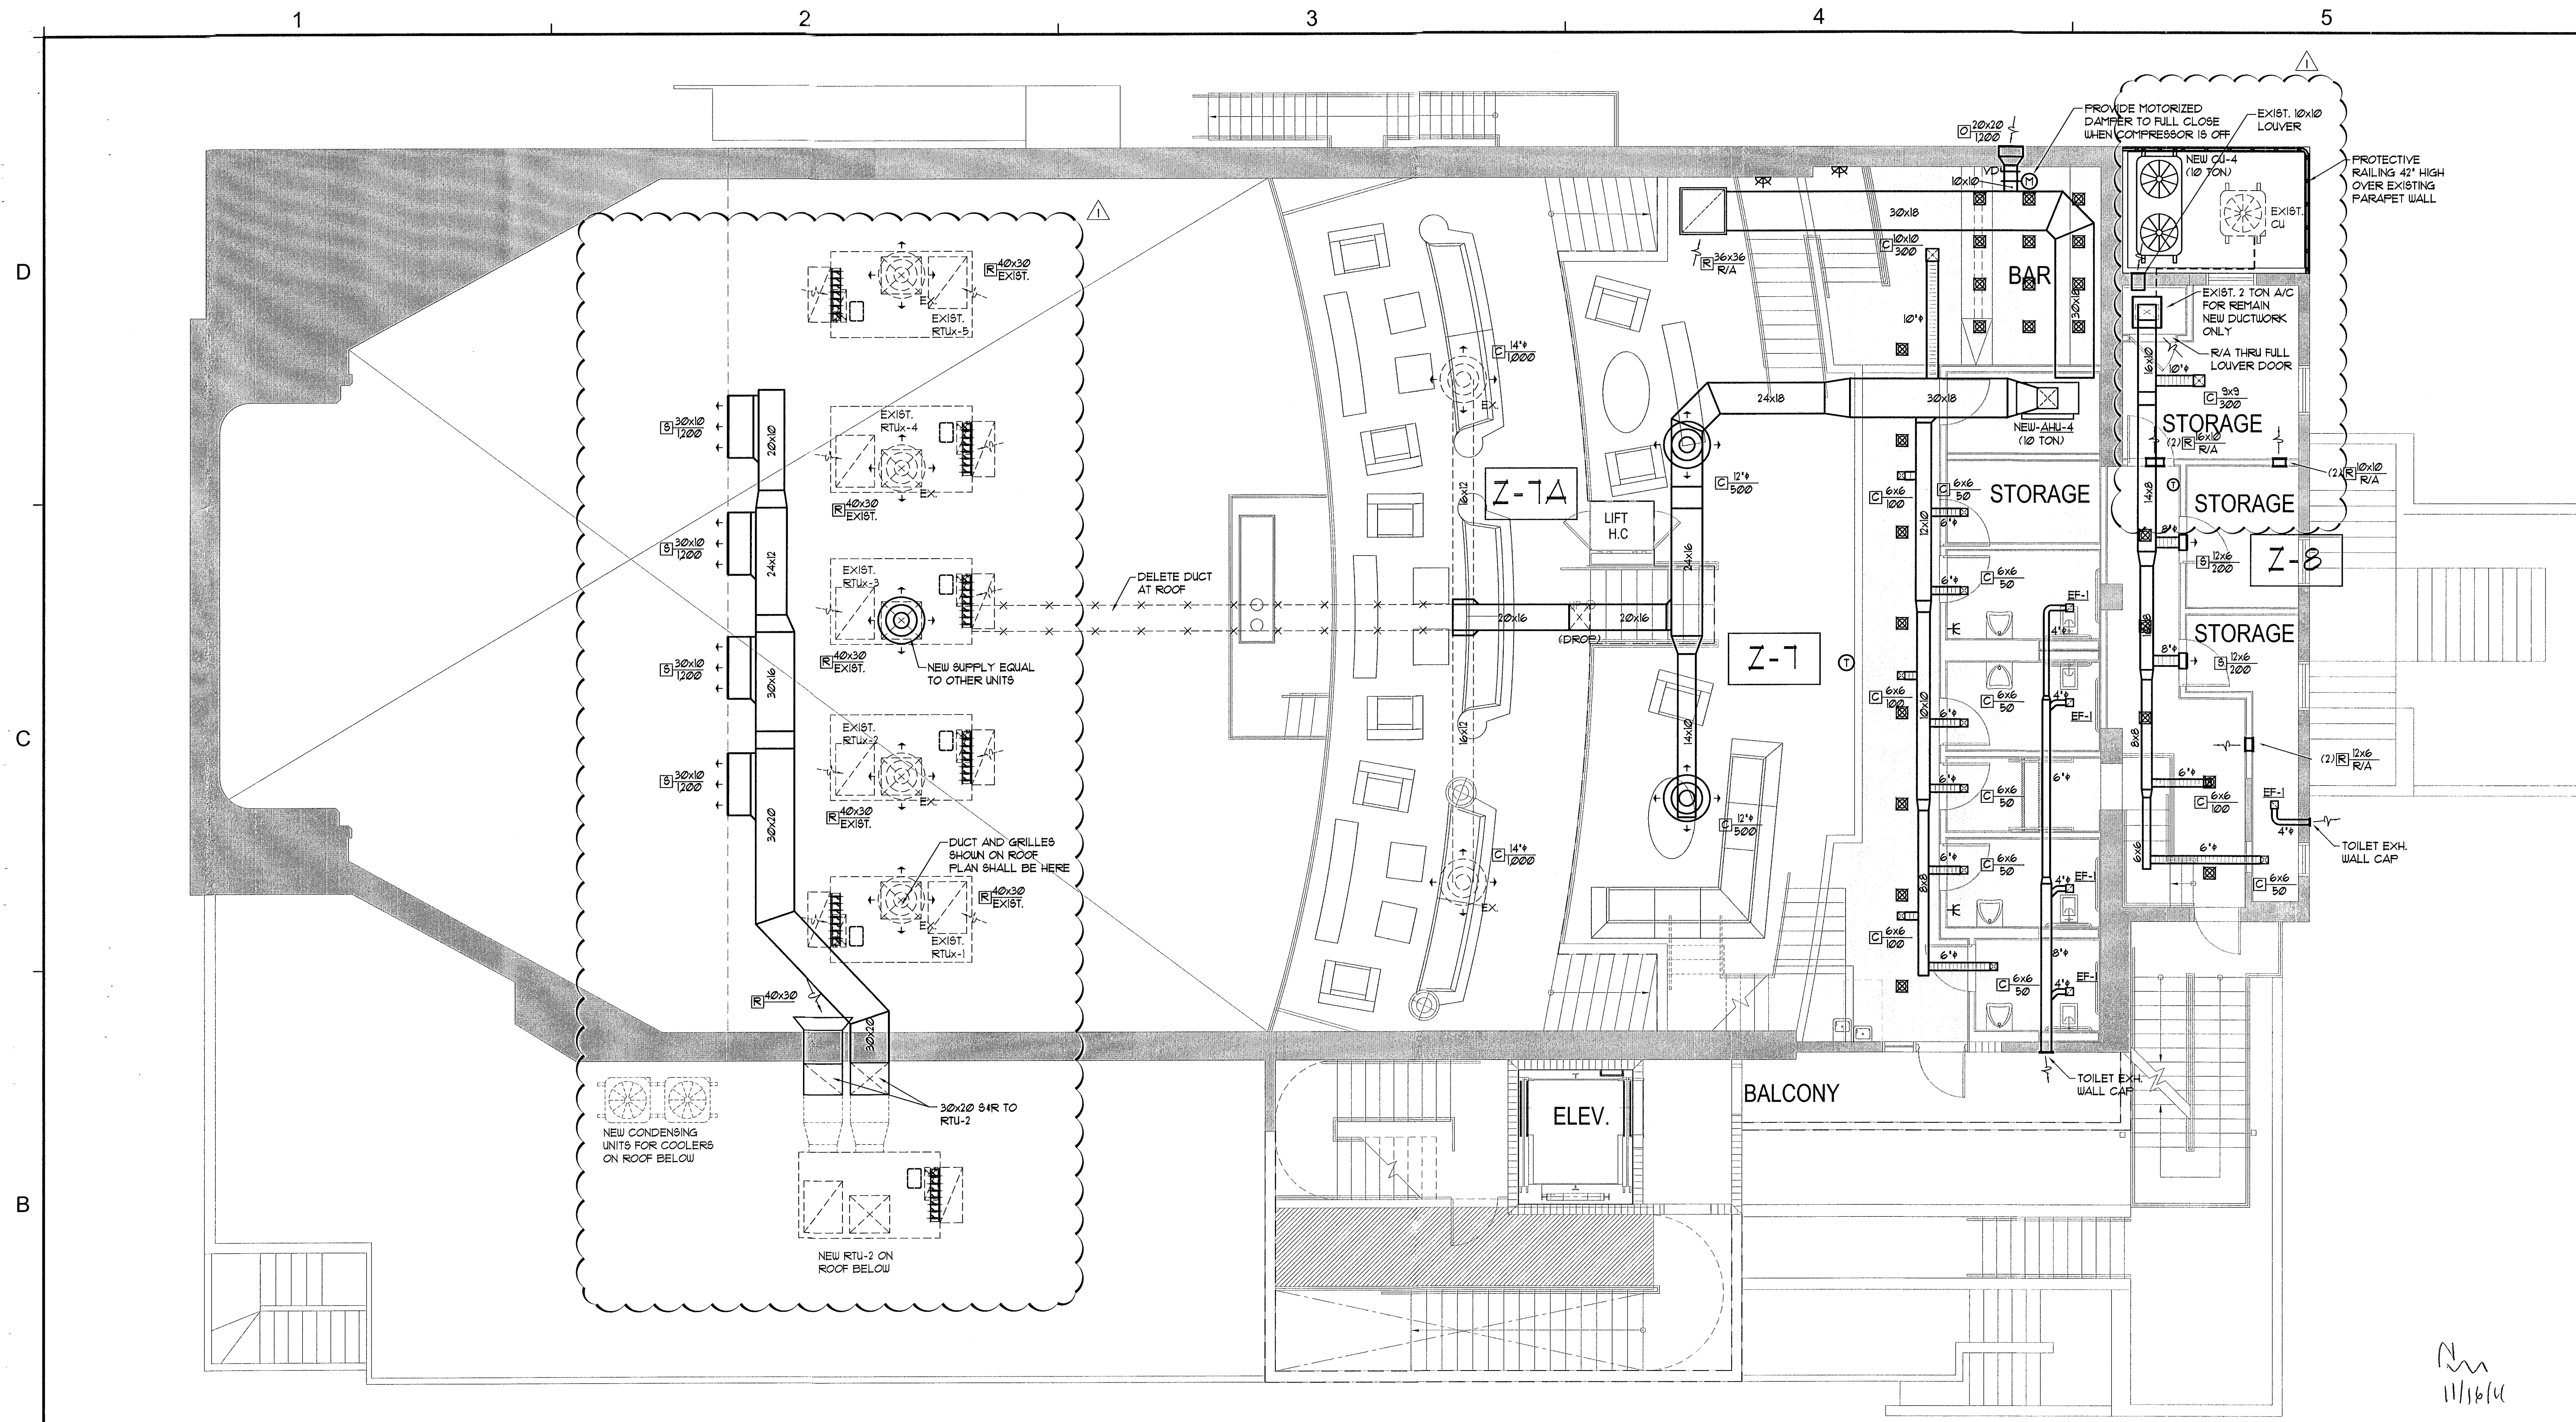

FOURTH FLOOR PLAN

SCALE: 3/16"=1'-0"

THESE PLANS ARE FOR BUILDING DEPARTMENT REVIEW. THEY ARE NOT TO BE CONSTRUED AS FINAL CONSTRUCTION DOCUMENTS. UNTIL ALL BUILDING DEPARTMENT APPROVALS ARE OBTAINED AND COMMENTS INCORPORATED INTO THESE DWGS. DUE TO THE VARIATIONS IN INTERPRETATIONS OF THE CODE THAT OCCUR IN DIFFERENT MUNICIPALITIES FINAL APPROVAL AND REVIEW IS NEEDED TO ASSURE COMPLIANCE WITH THE APPLICABLE CODES AND STANDARDS.

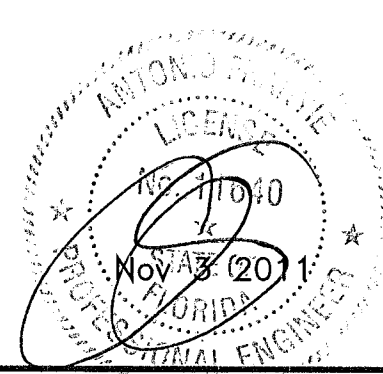

ANTONIO FRANKE
PE #111640 MECH
WYMAN FRANKE
PE #45989 ME

Certificate of
Authorization #
00002906

10610 NW 27 Street, Miami FL 33172
TEL: (305) 556-1360 FAX: (305) 594-9276
www.frankeengineers.com

DESIGN DRAWN 9-8-11
JOB NUMBER 11-210

FED. PRINTED Nov. 3, 2011

9-8-11
PERMIT SET

REVISIONS / SUBMISSIONS		
11-2-11	BD/COORD.	AAF

1151

ALL DRAWINGS AND WRITTEN MATERIAL APPEARING HEREIN CONSTITUTE THE ORIGINAL AND UNPUBLISHED WORK OF KOB KARP AIA, AND MAY NOT BE DUPLICATED, USED, OR DISCLOSED WITHOUT THE EXPRESS WRITTEN CONSENT OF KOB KARP ARCHITECTURE & INTERIOR DESIGN, INC. AIA, © 2011.


BAMBOO GROUP INC.
550 WASHINGTON AVENUE
MIAMI BEACH, FLORIDA

FOURTH FLOOR PLAN

Lic. # AR002576


ARCHITECTURE
INTERIOR DESIGN
PLANNING

AIA ASID NCARB
2915 Biscayne Boulevard
Suite 200
Miami, Florida 33137
P: 305.573.3795
F: 305.573.3796
WWW.KOBKARP.COM

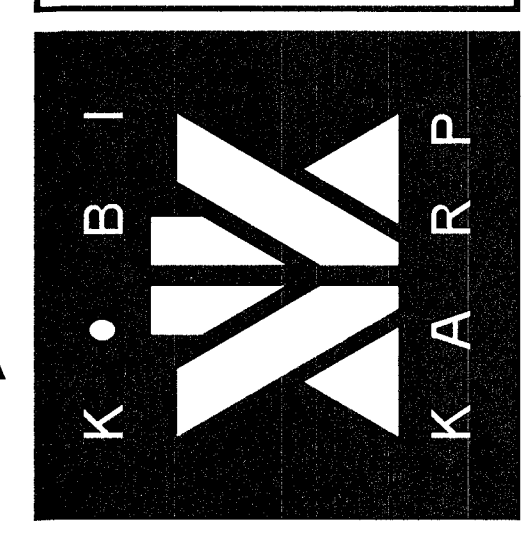

DRAWN BY: MDJO
CHECKED BY: JG
DATE: 09-08-11

M-103

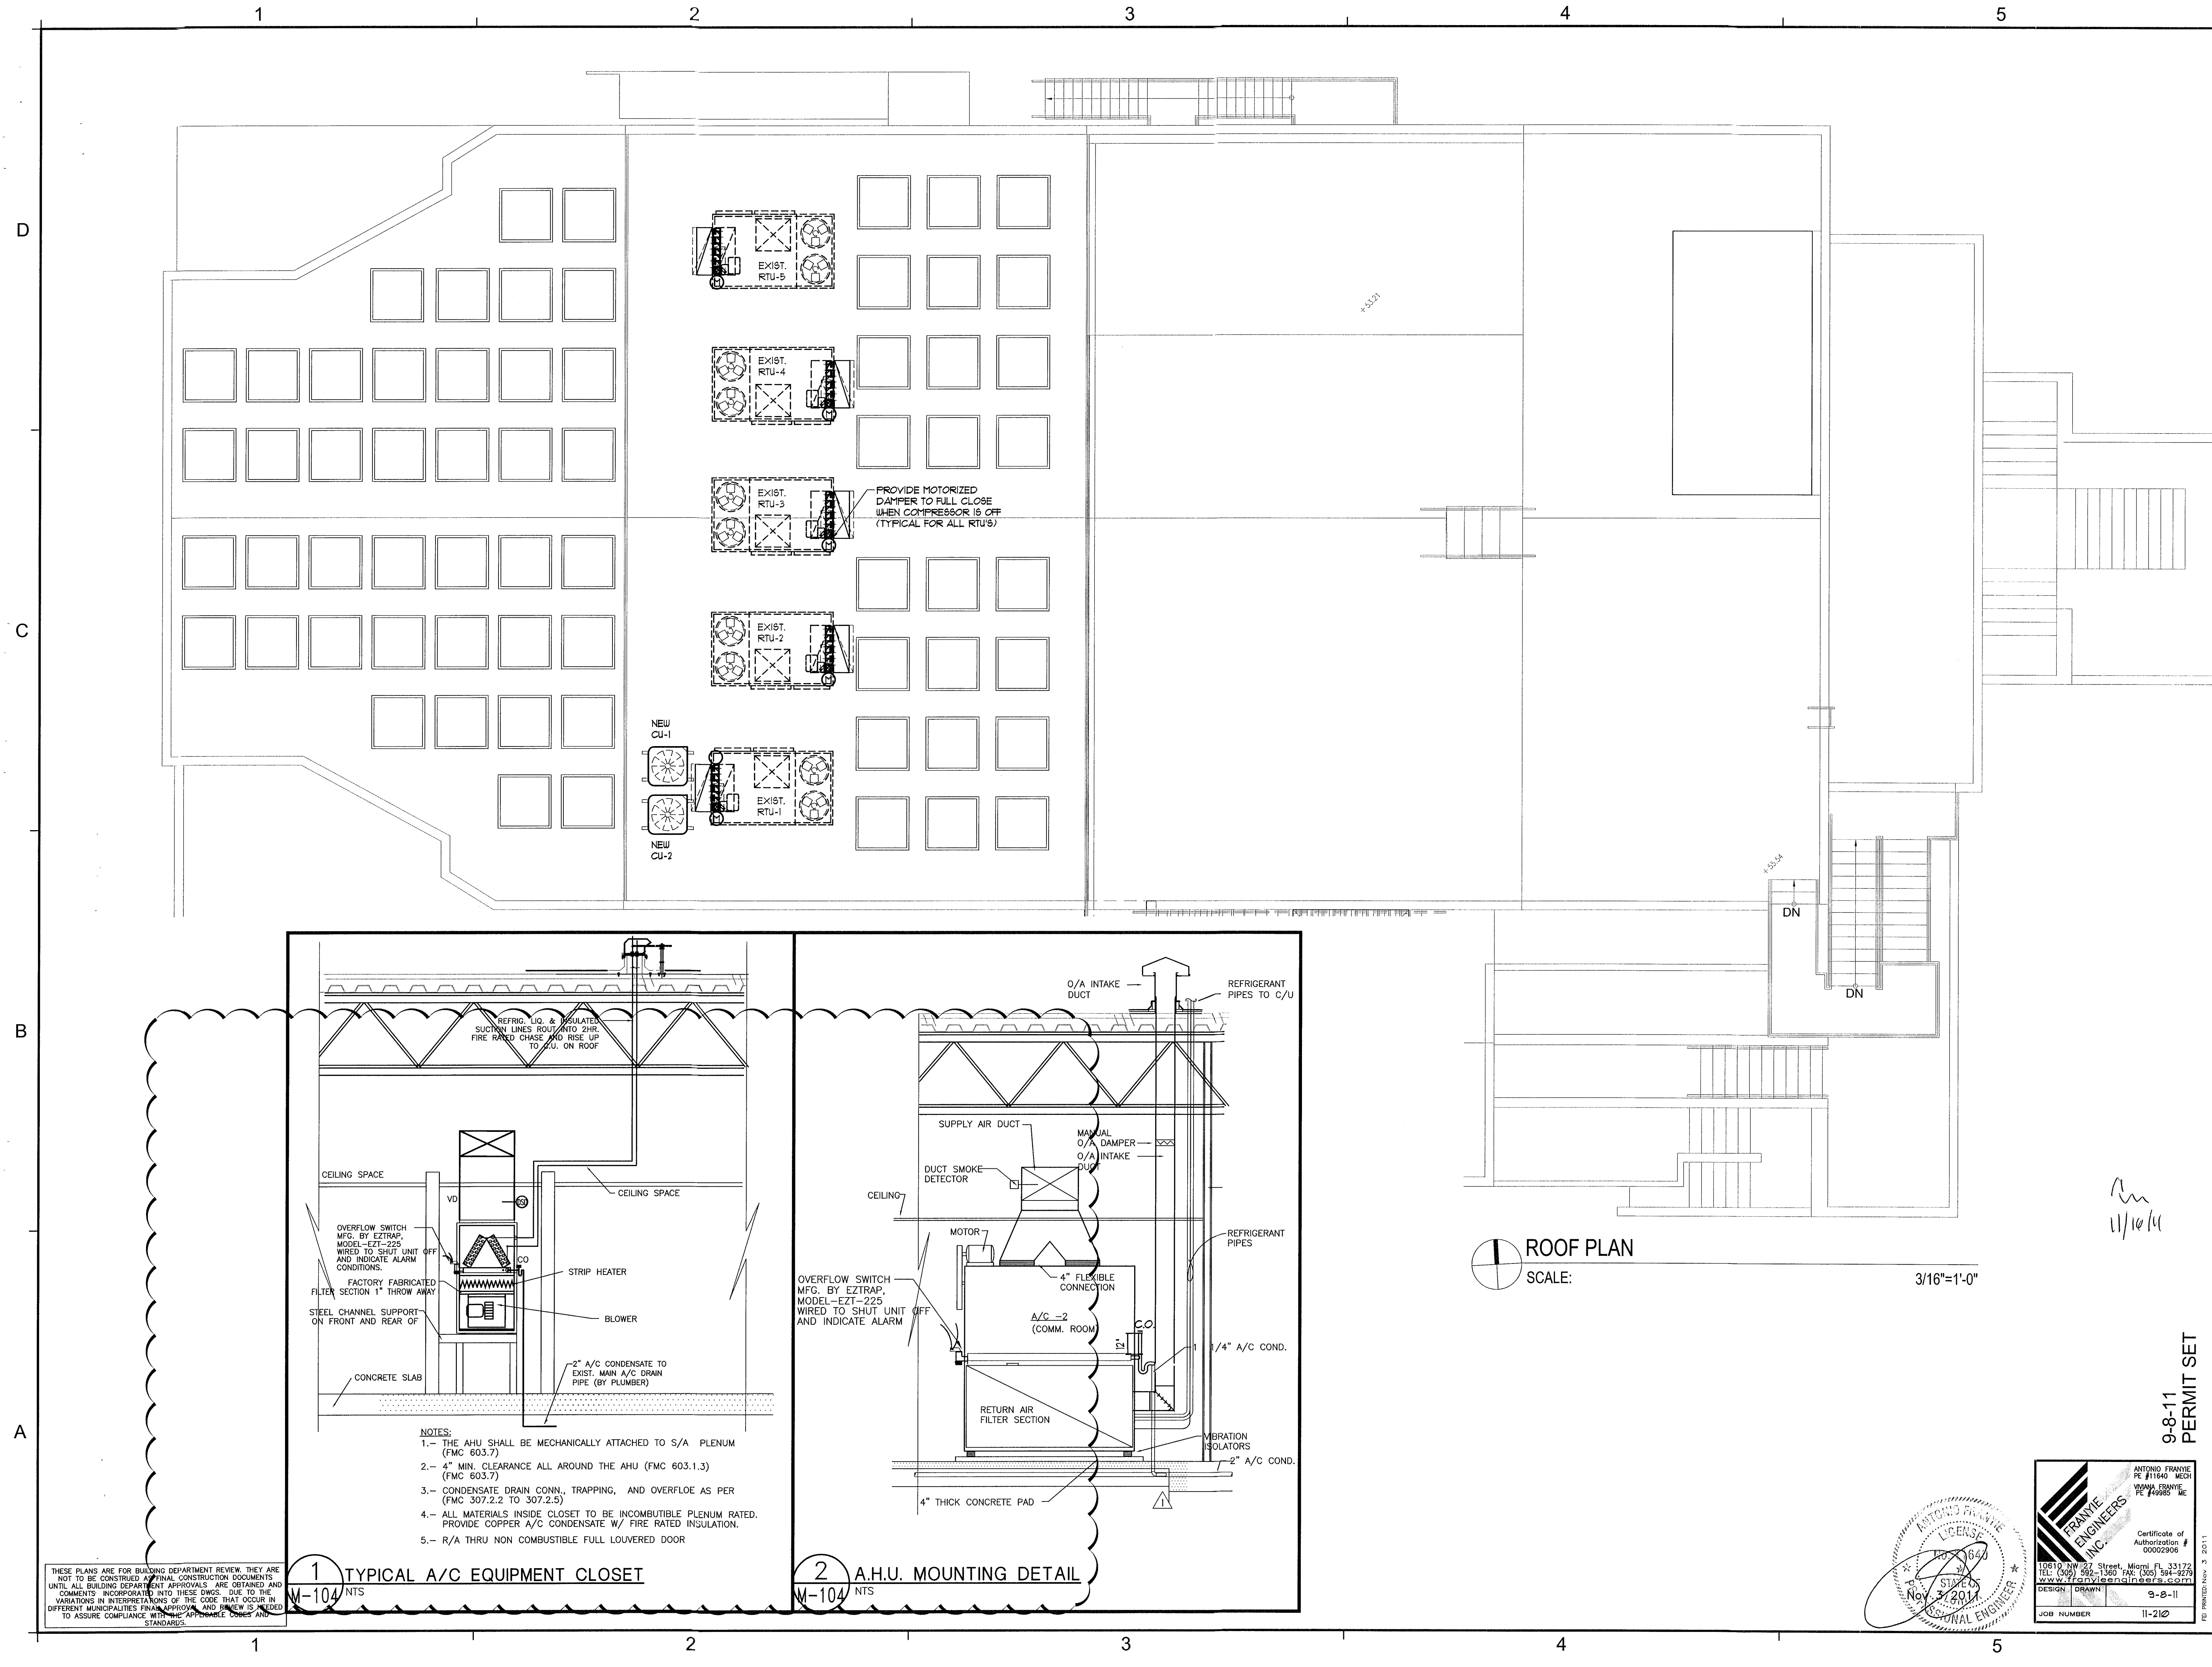


REVISIONS / SUBMISSIONS	
11-2-11	AAF
BD/COORD.	

1151

ALL DRAWINGS AND WRITTEN MATERIAL APPEARING HEREIN CONSTITUTE THE ORIGINAL AND UNPUBLISHED WORK OF KOB KARP ARCHITECTURE & INTERIOR DESIGN, INC. AIA (A) 2011.

BAMBOO GROUP INC.
550 WASHINGTON AVENUE
MIAMI BEACH, FLORIDA


ROOF FLOOR PLAN

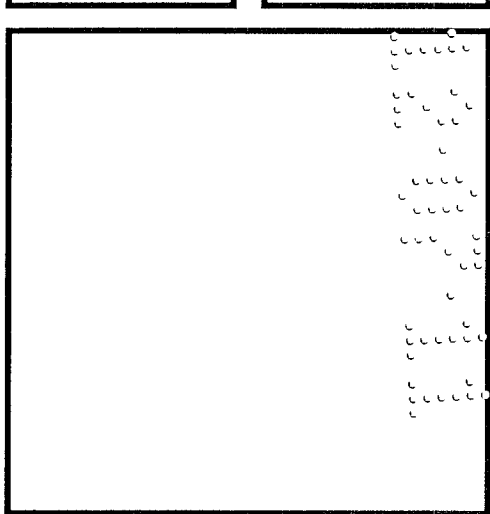

Lic. # AR0012578


ARCHITECTURE
INTERIOR DESIGN
PLANNING

AIA ASID NCARB
2915 Biscayne Boulevard
Suite 200
Miami, Florida 33137
C: 305.573.1818
F: 305.573.3766
WWW.KOBKARP.COM

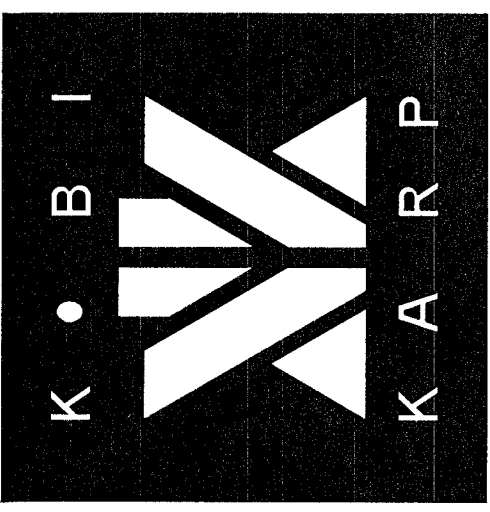

DRAWN BY: MDJO
CHECKED BY: JG
DATE: 09-08-11

M-104

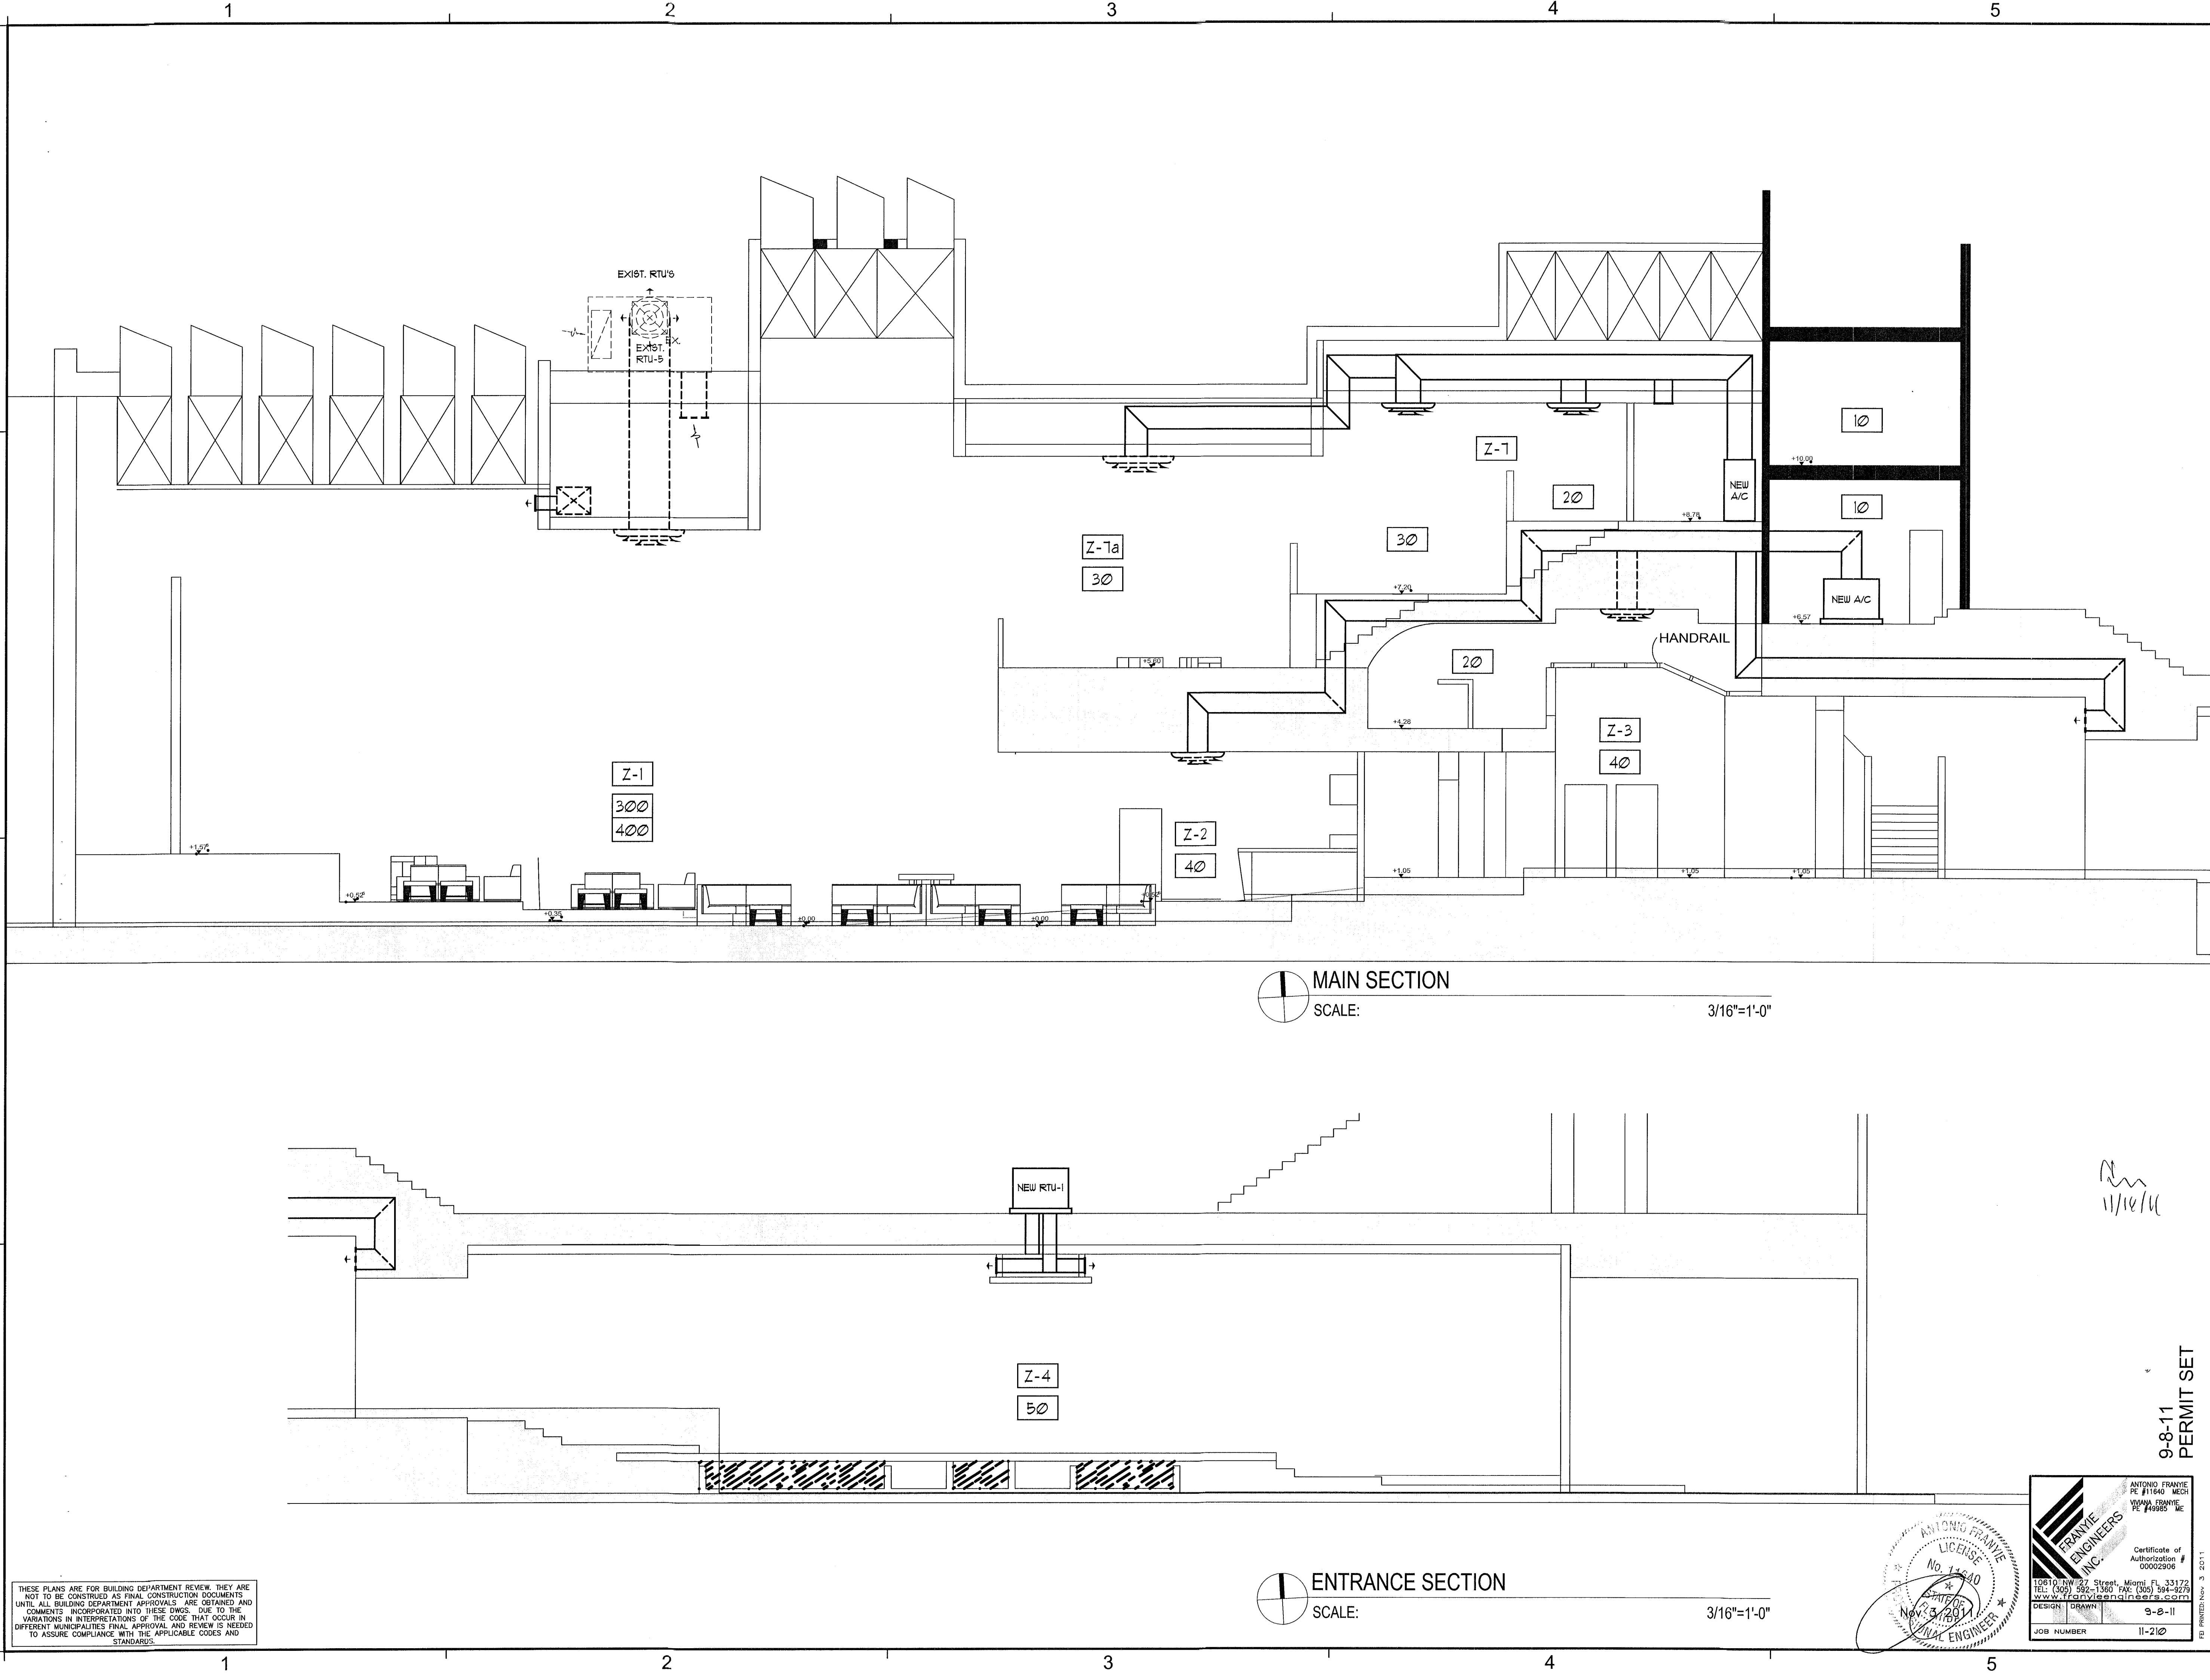

THESE PLANS ARE FOR BUILDING DEPARTMENT REVIEW. THEY ARE NOT TO BE CONSTRUED AS FINAL CONSTRUCTION DOCUMENTS. UNTIL ALL BUILDING DEPARTMENT APPROVALS ARE OBTAINED AND COMMENTS INCORPORATED INTO THESE DWGS. DUE TO THE VARIATIONS IN INTERPRETATIONS OF THE CODE THAT OCCUR IN DIFFERENT MUNICIPALITIES FINAL APPROVAL AND REVIEW IS NEEDED TO ASSURE COMPLIANCE WITH THE APPLICABLE CODES AND STANDARDS.

ANTONIO FRANKIE
No. 13440
Nov 8, 2011
Professional Engineer

FRANKIE
ENGINEERS
INC.
10810 NW 27 Street, Miami, FL 33172
TEL: (305) 592-1360 FAX: (305) 594-2975
www.frankieengineers.com
DESIGN DRAWN 9-8-11
JOB NUMBER 11-210

Certificate of
Authorization
00002306
ANTONIO FRANKIE
PE #11540 MECH
VIVIANA FRANKIE
PE #9985 ME


FD PRINTED NOV. 3 2011

REVISIONS / SUBMISSIONS

1151
ALL DRAWINGS AND WRITTEN MATERIAL APPEARING HEREIN CONSTITUTE THE ORIGINAL AND UNPUBLISHED WORK OF FIRM KOBKARP AND MAY NOT BE DUPLICATED, USED, OR DISCLOSED WITHOUT THE EXPRESS WRITTEN CONSENT OF FIRM KOBKARP ARCHITECTURE & INTERIOR DESIGN, INC. AIA (S) 2011

BAMBOO GROUP INC.
550 WASHINGTON AVENUE
MIAMI BEACH, FLORIDA


SECTIONS

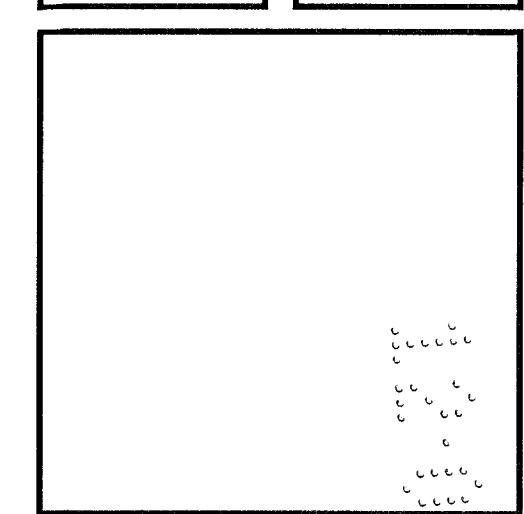

Lic. # AR0012578


ARCHITECTURE
INTERIOR DESIGN
PLANNING

AIA ASID NCARB
2915 Biscayne Boulevard
Suite 200
Miami, Florida 33137
TEL: 305.573.3718
F: 305.573.3785
WWW.KOBKARP.COM

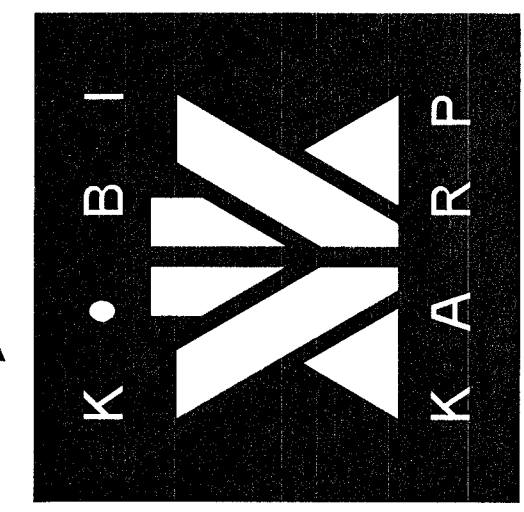

DRAWN BY: MDJO
CHECKED BY: JG
DATE: 09-08-11

M-200

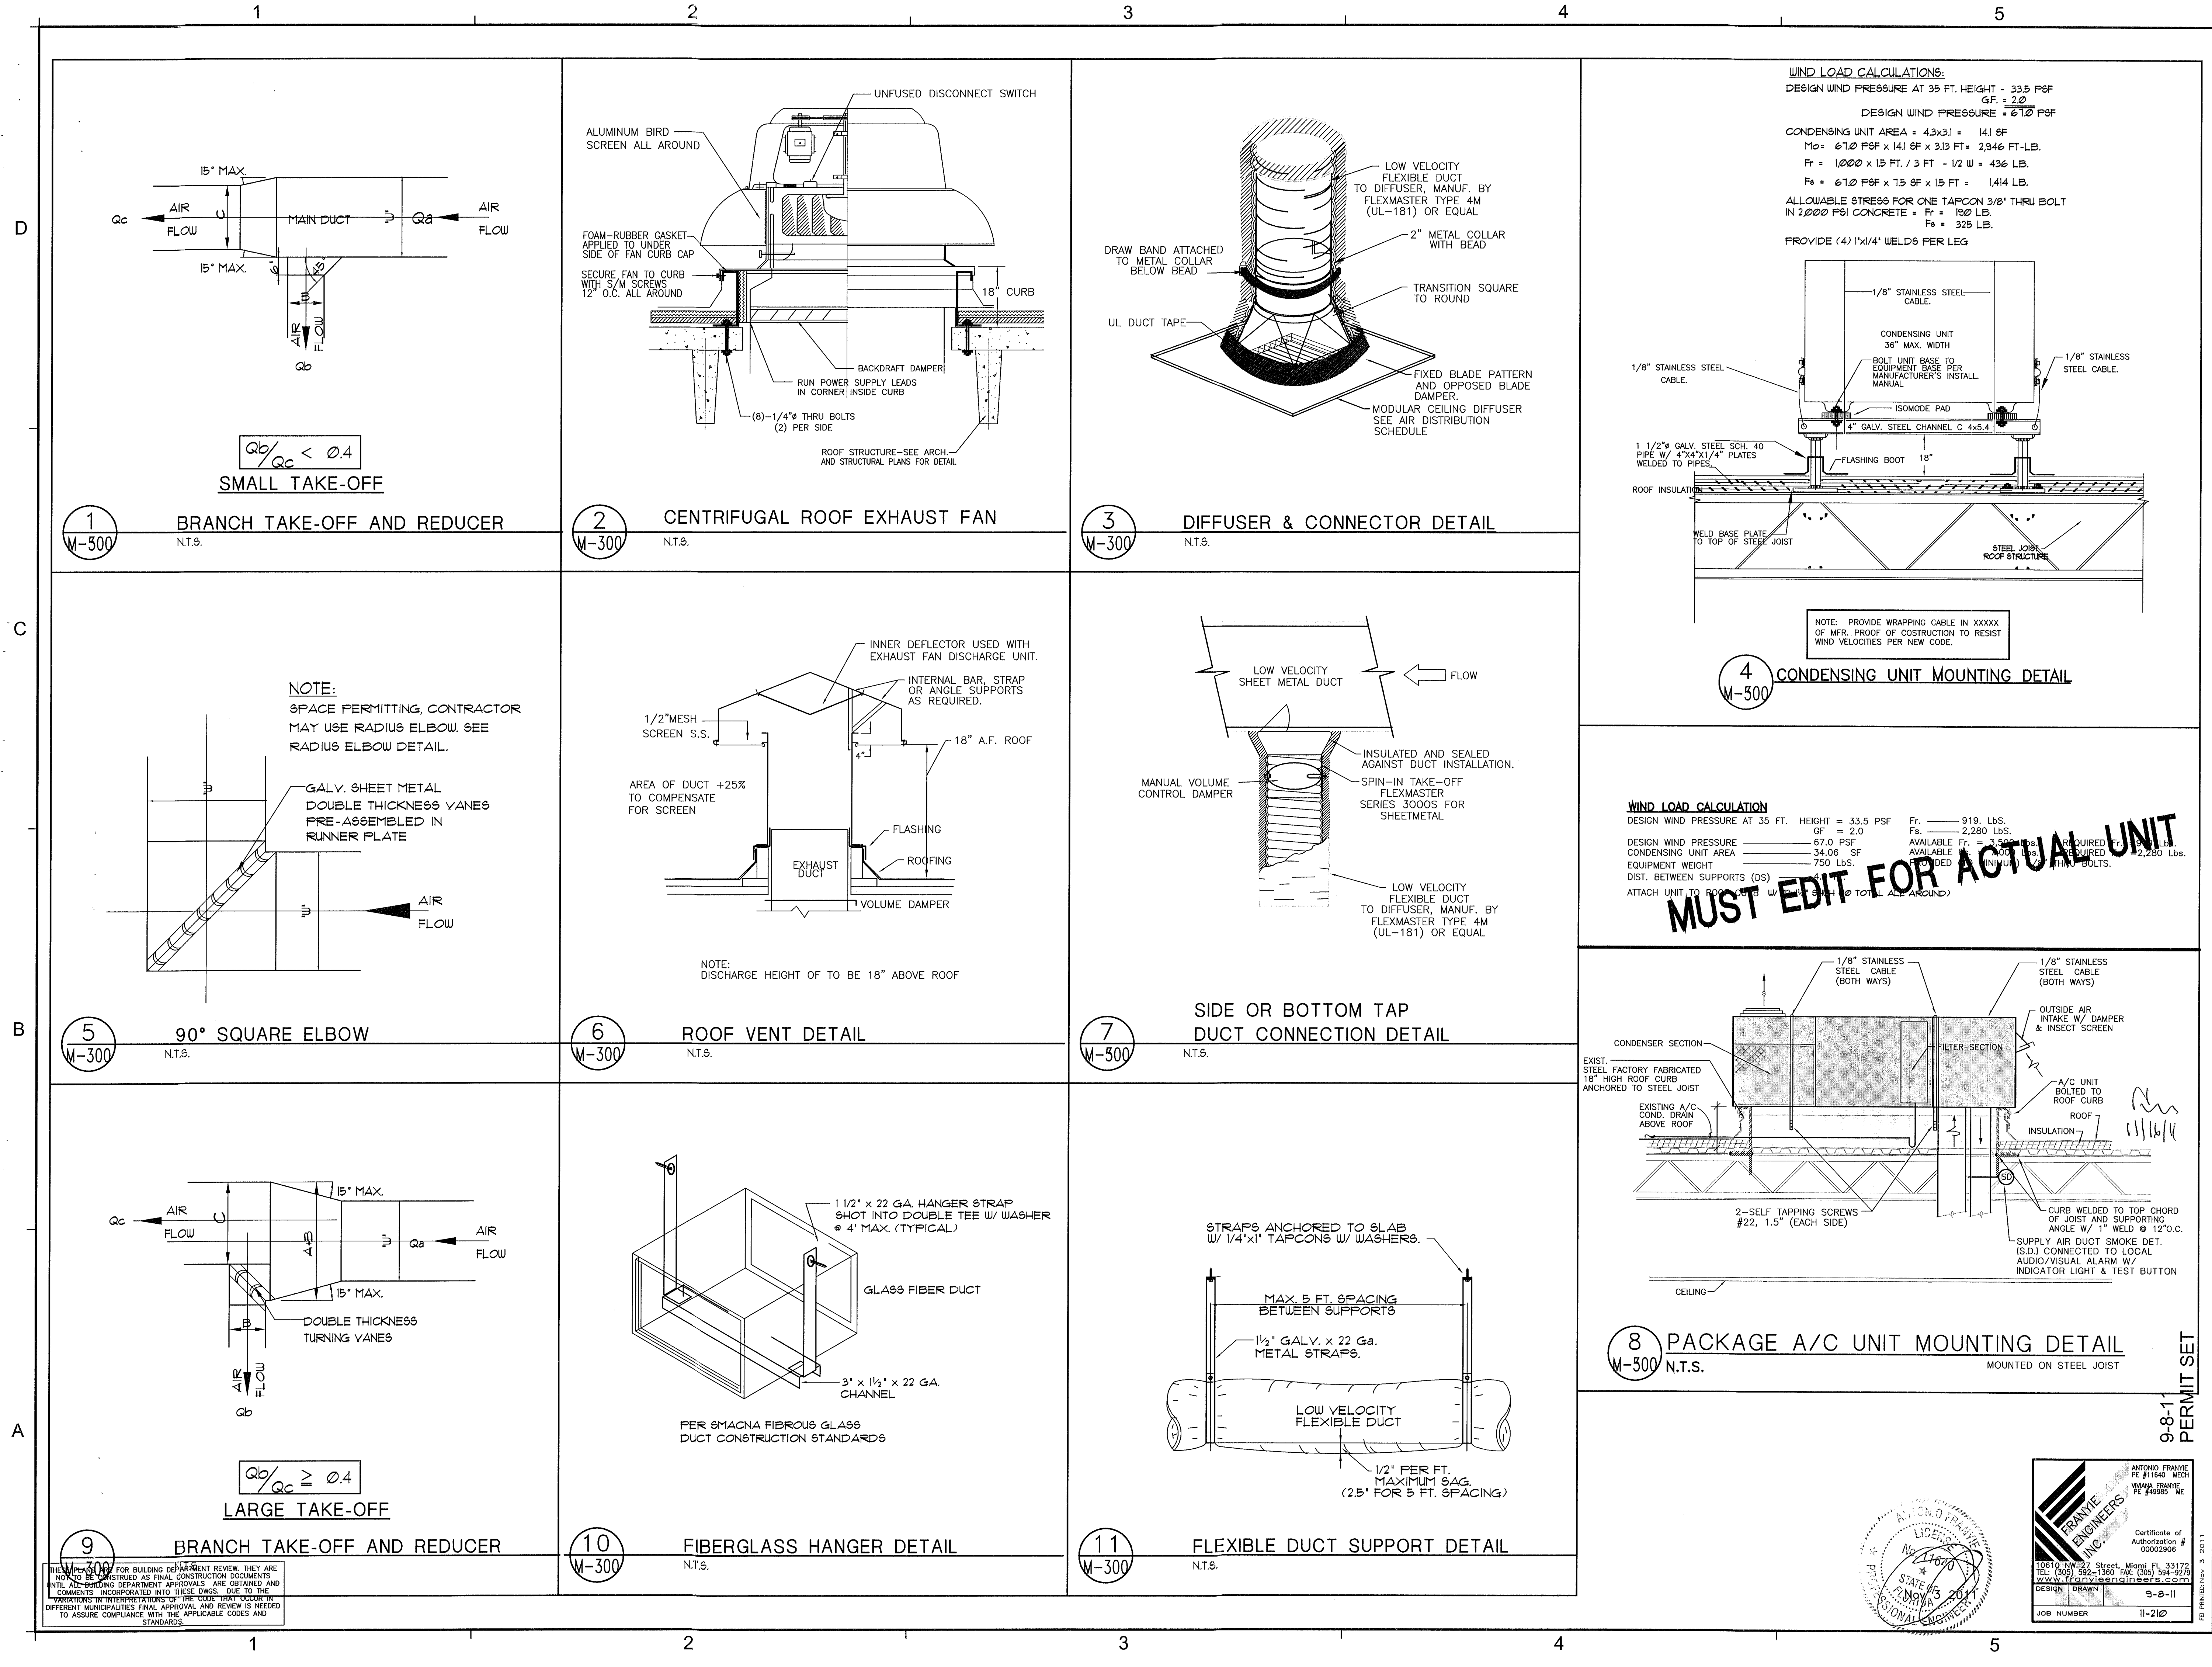

REVISIONS / SUBMISSIONS

1151

ALL DRAWINGS AND WRITTEN MATERIAL APPEARING HEREIN CONSTITUTE THE ORIGINAL AND UNPUBLISHED WORK OF KOB KARP AIA, AND MAY NOT BE REPRODUCED, USED, OR DISCLOSED WITHOUT THE EXPRESS WRITTEN CONSENT OF KOB KARP ARCHITECTURE & INTERIOR DESIGN, INC. AIA (c) 2011.

BAMBOO GROUP INC.
550 WASHINGTON AVENUE
MIAMI BEACH, FLORIDA

HVAC DETAILS

Lic. # AR0012578

ARCHITECTURE
INTERIOR DESIGN
PLANNING

AIA ASID NCARB
Suite 200
Miami, Florida 33137
Tel: 305.573.3766
F: 305.573.3766
WWW.KOBKARP.COM

KOB KARP

DRAWN BY: MD,JO
CHECKED BY: JG
DATE: 09-08-11

M-300

HVAC NOTES

1.0 GENERAL

1.1 PROVIDE (FURNISH AND INSTALL) ALL NECESSARY MATERIALS AND LABOR FOR A COMPLETELY OPERATIONAL HEATING, VENTILATING AND AIR CONDITIONING (HVAC) SYSTEM AS SHOWN ON THESE CONTRACT DOCUMENTS.

1.2 INSTALL IN ACCORDANCE WITH THE SOUTH FLORIDA CODE, ASHRAE, SMACNA, NFPA AND LOCAL ORDINANCES.

1.3 SCOPE OF WORK - PROVIDE THE FOLLOWING COMPLETE SYSTEMS:

A. AIR CONDITIONING SUPPLY AND RETURN DUCT SYSTEM.

B. EXHAUST SYSTEM FOR TOILET ROOMS.

C. EXHAUST SYSTEMS FOR WAREHOUSE.

D. AIR CONDITIONING UNITS AND CONTROLS.

E. INDEPENDENT TEST AND BALANCE.

1.4 NOT USED.

1.5 PAY FOR ALL FEES, INSPECTIONS AND CONNECTION CHARGES REQUIRED.

1.6 VERIFY AT JOB SITE ALL SPACE CONDITIONS AVAILABLE FOR THE INSTALLATION OF MATERIALS AND EQUIPMENT PRIOR TO THE INSTALLATION OF EQUIPMENT AND FABRICATION OF DUCTS AND PIPING SYSTEMS. COORDINATE SPACE REQUIREMENTS FOR SERVICE AND MAINTENANCE AND COORDINATE INTERFERENCE WITH OTHER TRADES.

1.7 NATURE OF DESIGN DRAWINGS: DESIGN DRAWINGS ARE DIAGRAMMATIC AND DO NOT INTEND TO SHOW EVERY FITTING, ELBOW, TRANSITION, ETC. THAT WILL BE NECESSARY FOR A COMPLETE AND OPERATIONAL SYSTEMS. CONSULT ALL INFORMATION FROM 1.5 ABOVE.

1.8 COORDINATION DRAWINGS: PREPARE 1/4" SCALE (MIN.) COORDINATION DRAWINGS SHOWING DUCTWORK, PIPING AND ALL MAJOR SYSTEM COMPONENTS FOR A/E APPROVAL BEFORE PROCEEDING WITH THE INSTALLATION. IMPLEMENT ALL INFORMATION FROM 1.5 ABOVE.

1.9 SUBMIT SHOP DRAWINGS FOR A/E APPROVAL BEFORE PROCEEDING WITH THE THE PURCHASE OR INSTALLATION OF EQUIPMENT AND MATERIALS. ALL SHOP DRAWINGS MUST BE SUBMITTED AND APPROVED BY THE ARCHITECT AND INDEXED PACKAGE NO LATER THAN 30 DAYS FROM THE ADJUDICATION OF THE PROJECT.

1.10 GUARANTEE ALL WORK FREE OF DEFECTS IN MATERIALS AND WORKMANSHIP FOR A PERIOD OF ONE YEAR FROM THE DATE OF PROJECT ACCEPTANCE.

2.0 MATERIALS

2.1 DUCTWORK

2.1.1 GENERAL: ALL DUCT SIZES SHOWN ARE CLEAR INSIDE DIMENSIONS.

2.1.2 DUCTWORK MATERIALS:

A. GENERAL OFFICE AREAS:

FIVE POUNDS DENSITY 1.5" THICK GLASS FIBER (R-6) DESIGNED, CONSTRUCTED AND INSTALLED IN ACCORDANCE WITH SMACNA'S FIBROGLASS GLASS DUCT CONSTRUCTION STANDARDS. DUCT JOINTS SHALL BE SEALED AND TAPED.

B. TOILET ROOM EXHAUST AND FRESH AIR INTAKES:

GALVANIZED SHEET METAL CONSTRUCTED AND INSTALLED ACCORDING TO LATEST EDITION OF SMACNA'S LOW PRESSURE CONSTRUCTION STD. (0.5" W.G.).

2.1.3 PROVIDE DOUBLE THICKNESS TURNING VANES AT ALL SQUARE ELBOWS, WHERE THE ELBOWS ARE RECTANGULAR. INSTALL SINGLE THICKNESS VANES.

1. ALTERNATE A: PROVIDE 3-PIECE ELBOWS IN LIEU OF TURNING VANES FOR GLASS FIBER DUCTS ONLY.

2. ALTERNATE B: PROVIDE FULL RADIOS ELBOWS IN LIEU OF TURNING VANES.

2.1.4 PROVIDE VOLUME EXTRACTORS BEHIND EACH SUPPLY OUTLET AND AT EACH DUCT BRANCH.

D. CORRIDORS SUPPLY AIR RISER & ALL VERTICAL RISERS

1. DUCT IN SHAFT:

CONSTRUCT OF GALVANIZED SHEET METAL IN ACCORDANCE WITH SMACNA PRESSURE RATING OF 3" W.G. INSULATE WITH 1" GLASSFIBER THERMAL BLANKET WITH APPROVED RJ REINFORCE ALUMINUM JACKED. SEAL AIR TIGHT ALL JOINT WITH APPROVED HIGH VELOCITY MASTIC.

2. EXTERIOR DUCT:

CONSTRUCT OF GALVANIZED SHEET METAL IN ACCORDANCE WITH SMACNA PRESSURE RATING OF 3" W.G. INSULATE WITH 2" GLASSFIBER (MIN. R-8) THERMAL AND ACOUSTICAL LINING WITH ANTI-BACTERIAL COATING. CONSTRUCT ALL JOINTS WEATHERPROOF (AIR AND WATER TIGHT) WITH HIGH PRESSURE LONG-LIFE MASTIC APPROVED FOR EXTERIOR USE.

3. MAIN SUPPLY AIR DUCTS IN VAV SYSTEMS

1. LIEU OF VAV BOXES:

CONSTRUCT OF GALVANIZED SHEET METAL IN ACCORDANCE WITH SMACNA PRESSURE RATING OF 3" W.G. INSULATE WITH 1" GLASSFIBER THERMAL BLANKET WITH APPROVED RJ REINFORCE ALUMINUM JACKED. SEAL AIR TIGHT ALL JOINT WITH APPROVED HIGH VELOCITY MASTIC.

2. DOWNSTREAM OF VAV BOXES:

FIVE POUND DENSITY 1.5" THICK GLASS FIBER (R-6) DESIGNED, CONSTRUCTED AND INSTALLED IN ACCORDANCE WITH SMACNA'S LOW PRESSURE DUCT MANUAL. ALL DUCT JOINTS SHALL BE SEALED AND TAPED.

2.2 NOT USED.

2.3 NOT USED.

2.4 AIR DISTRIBUTION PRODUCTS:

2.4.1 PROVIDE EXTRUDED ALL ALUMINUM AIR DISTRIBUTION PRODUCTS.

2.4.2 PROVIDE SUPPLY AND RETURN GRILLES AND DIFFUSERS AS INDICATED ON THE DRAWINGS AND SCHEDULES.

2.4.3 PROVIDE FINISHES AND TYPES OF MOUNT IN COORDINATION WITH THE CEILING TYPES AS SHOWN ON ARCHITECTURAL DRAWINGS.

2.4.4 PROVIDE OPPOSED BLADE KEY OPERATED DAMPERS BEHIND ALL AIR SUPPLY OUTLETS.

2.5 PROVIDE A MINIMUM 5 YEAR WARRANTY FOR ALL AIR CONDITIONING COMPRESSORS STARTING FROM THE DATE OF PROJECT ACCEPTANCE.

2.6 CONTROLS:

2.6.1 GENERAL: PROVIDE THE NECESSARY AUTOMATIC CONTROLS FOR PROPER OPERATION OF ALL EQUIPMENT SPECIFIED HEREIN. FURNISH MAGNETIC STARTERS AND INTERLOCK WIRING INDICATED FOR EACH PIECE OF EQUIPMENT.

2.6.2 OFFICE AREA DX EQUIPMENT:

PROVIDE AIR CONDITIONING UNITS WITH MATCHING LOW VOLTAGE HEAT/COOL THERMOSTATS WITH ON-OFF AUTO SUB-BASE SWITCH AS FURNISHED BY THE EQUIPMENT MANUFACTURER.

2.7 STARTERS:

PROVIDE MAGNETIC STARTER FOR ALL MECHANICAL EQUIPMENT IN THIS SECTION AS DESCRIBED ON THE EQUIPMENT SCHEDULES. ALL STARTERS MUST HAVE HAND-OFF-AUTO POSITION SWITCH ON THE COVER AND RED/GREEN PILOT LIGHTS. PROVIDE THE NECESSARY AUXILIARY OPEN AND CLOSED CONTACTS FOR THE INTENDED OPERATION AND INTERLOCKS.

2.8 NOT USED.

2.9 IDENTIFICATION:

2.9.1 LABEL ALL EQUIPMENT WITH ENGRAVED BLACK PLASTIC PLAQUES 12"x4" HIGH WITH WITH 1/2" LETTERS. USE THE SAME NOMENCLATURE AS IN THESE DOCUMENTS.

3.0 EXECUTION

3.1 INSTALL ALL EQUIPMENT AND MATERIALS IN STRICT ACCORDANCE WITH THE MANUFACTURER'S MANUALS AND RECOMMENDATIONS, PAYING SPECIAL ATTENTION TO REQUIRED CLEARANCES FOR INSTALLATION, OPERATION & SERVICE.

3.2 THERMOSTAT LOCATION:

THERMOSTAT LOCATION IS CRITICAL TO PROPER EQUIPMENT OPERATION. INSTALL THERMOSTAT AT LOCATIONS SHOWN ON PLANS. RELOCATE ONLY WHEN APPROVED BY A/E IN WRITING.

3.3 WHERE R/A IS PROPOSED BY WAY OF DOOR UNDERCUTS, PROVIDE A MINIMUM 1" CLEAR SPACE BETWEEN THE BOTTOM OF THE DOOR AND THE FLOOR FINISH CARPET OR TILE.

3.4 EQUIPMENT MUST OPERATE FREE OF OBJECTIONABLE NOISE AND VIBRATION. REPAIR, RELOCATE OR REPLACE ALL SOURCES OF NOISE AND VIBRATION FOUND TO BE OBJECTIONABLE, TO THE SATISFACTION OF THE A/E.

3.5 BALANCE ALL SYSTEMS TO PROVIDE AIR AND WATER QUANTITIES AND CAPACITIES TO MATCH SPECIFIED FLOWS & CAPACITIES. CALIBRATE FLOWS TO NEW EQUIPMENT PER MANUFACTURER'S REQUIREMENTS. SUBMIT FINAL TEST AND BALANCE REPORT TO A/E FOR ACCEPTANCE.

3.6 STRICTLY FOLLOW ALL MANUFACTURER'S INSTALLATION MANUALS AND INSTRUCTIONS IN THE INSTALLATION OF ALL EQUIPMENT. OBTAIN, FROM EACH MANUFACTURER, PROPER CERTIFICATION FOR THE ADEQUACY OF THE INSTALLATION OF ALL PIECES OF EQUIPMENT BEFORE PLACING SYSTEM IN OPERATION.

3.7 PROVIDE MAINTENANCE AND OPERATION MANUAL.

3.8 PROVIDE AS-BUILT REPRODUCIBLE DRAWINGS.

3.9 PROVIDE INSTRUCTION TO OWNER'S DESIGNATED PERSONNEL.

NOTES:

1. INSULATE ROOF SLAB WITH R-19 MINIMUM INSULATION VALUE FOR ALL R/A CEILING PLUMB AREAS.

NFPA 90A (SECTION 4-4)

1. DUCT SMOKE DETECTOR SHALL BE INSTALLED DOWNSTREAM OF THE FILTERS AND AHEAD OF ANY BRANCH CONNECTION IN AIR SUPPLY SYSTEM HAVING A CAPACITY GREATER THAN 2000 CFM.

2. AT EACH STORY PRIOR TO THE CONNECTION TO COMMON RETURN AND PRIOR TO ANY REGRILLATION OR FRESH AIR INLET CONNECTION IN AIR RETURN SYSTEM HAVING CAPACITY GREATER THAN 15,000 CFM AND SERVING MORE THAN ONE STORY.

THESE PLANS ARE FOR BUILDING DEPARTMENT REVIEW. THEY ARE NOT TO BE CONSIDERED AS FINAL CONSTRUCTION DOCUMENTS UNTIL ALL BUILDING DEPARTMENT APPROVALS ARE OBTAINED AND INCORPORATED INTO THESE DWS. DUE TO THE VARIATIONS IN INTERPRETATIONS OF THE CODE THAT OCCUR IN DIFFERENT MUNICIPALITIES FINAL APPROVAL AND REVIEW IS NEEDED TO ASSURE COMPLIANCE WITH THE APPLICABLE CODES AND STANDARDS.

		2		3	
		EXISTING		NEW	
DESIGNATION		2 TON (EXIST.)		AC-1 & AC-2	
AREA SERVED		Z-8		Z-5 & Z-6	
MANUFACTURER		CARRIER		CARRIER	
FAN COIL MODEL No.		FA4NC024		FA4NC060	
CONDENSING UNIT MODEL No.		24ABR360		24ABR360	
		2 TON		5 TON	
				</	

4

OUTSIDE AIR CALCULATIONS

ASHRAE SIA 62.1 - 2007(1)

ZONE-1 EXIST. RTU-1, 2, 3, 4 & 5 PLUS NEW RTU-2

BAR LOWER SEATING

AREA = 3,600 SF		
400 PERSONS * 20 CFM/PR	8,000 CFM O/A	INSTALL MODULATING DAMPER IN O/A INTAKE CONNECTED TO CO2 DETECTOR
O/A PROVIDED *	8,000 CFM O/A	

REMARKS

ZONE-2 NEW AC-3

BAR

AREA = 1,350 SF		
50 PERSONS * 20 CFM/PR	1,000 CFM O/A	INSTALL MODULATING DAMPER IN O/A INTAKE CONNECTED TO CO2 DETECTOR
O/A PROVIDED *	1,000 CFM O/A	

REMARKS

ZONE-3 NEW AC-3

LOBBY

AREA = 2,250 SF		
50 PERSONS * 20 CFM/PR	1,000 CFM O/A	INSTALL MODULATING DAMPER IN O/A INTAKE CONNECTED TO CO2 DETECTOR
O/A PROVIDED *	1,000 CFM O/A	

REMARKS

ZONE-4 NEW RTU-1

ENTRANCE

AREA = 1,810 SF		
50 PERSONS * 20 CFM/PR	1,000 CFM O/A	INSTALL MODULATING DAMPER IN O/A INTAKE CONNECTED TO CO2 DETECTOR
O/A PROVIDED *	1,000 CFM O/A	

REMARKS

ZONE-5 NEW AC-2

BACK OF THE HOUSE

AREA = 3,600 SF		
14 PERSONS * 20 CFM/PR	280 CFM O/A	INSTALL MODULATING DAMPER IN O/A INTAKE CONNECTED TO CO2 DETECTOR
O/A PROVIDED *	280 CFM O/A	

REMARKS

ZONE-6 NEW AC-3

OFFICES 2, 3 & 4

AREA = 1,750 SF		
10 PERSONS * 20 CFM/PR	200 CFM O/A	INSTALL MODULATING DAMPER IN O/A INTAKE CONNECTED TO CO2 DETECTOR
O/A PROVIDED *	200 CFM O/A	

REMARKS

ZONE-7 NEW AC-4

VIP AREA

AREA = 1,300 SF		
30 PERSONS * 20 CFM/PR	600 CFM O/A	INSTALL MODULATING DAMPER IN O/A INTAKE CONNECTED TO CO2 DETECTOR
O/A PROVIDED *	600 CFM O/A	

REMARKS

ZONE-1A NEW AC-4

VIP AREA

AREA = 810 SF		
30 PERSONS * 20 CFM/PR	600 CFM O/A	INSTALL MODULATING DAMPER IN O/A INTAKE CONNECTED TO CO2 DETECTOR
O/A PROVIDED *	600 CFM O/A	

REMARKS

ZONE-8 EXIST. 2 TON SPLIT

STORAGE

AREA = 500 SF * 0.05 CFM/SF	25 CFM O/A	INSTALL MODULATING DAMPER IN O/A INTAKE CONNECTED TO CO2 DETECTOR
2 PERSONS * 20 CFM/PR	40 CFM O/A	
O/A PROVIDED *	40 CFM O/A	

REMARKS

ZONE-9 NEW AC-3

STORAGE

AREA = 361 SF * 0.05 CFM/SF	18 CFM O/A	INSTALL MODULATING DAMPER IN O/A INTAKE CONNECTED TO CO2 DETECTOR
1 PERSONS * 20 CFM/PR	20 CFM O/A	
O/A PROVIDED *	20 CFM O/A	

REMARKS


VENTILATION EQUIPMENT SCHEDULE				
DESIGNATION	EF-1	EF-2	EF-3	EF-4
QUANTITY (VERIFY)	SEE PLAN	SEE PLAN	SEE PLAN	SEE PLAN
USE	EXHAUST	EXHAUST	EXHAUST	EXHAUST
LOCATION	CLG.	CLG.	CLG.	CLG.
AREA SERVED	RESTROOM	ELECT. RM	RESTROOM	RESTROOM
MANUFACTURER	GREENHECK	GREENHECK	GREENHECK	GREENHECK
MODEL NO.	SP-350	CSP-A200	SFA-330	SFA-250
FAN	BELT DRIVE	BELT DRIVE	DIRECT	DIRECT
TYPE	CENTRIFUGE	CENTRIFUGE	CENTRIFUGE	CENTRIFUGE
AIR FLOW (C.F.M.)	50	200	300	200
EXTERNAL STATIC PRESSURE (" H ₂ O)	0.15	0.25	0.15	0.15
FAN SPEED (R.P.M.)	625	900	1000	1000
FAN SOUND RATINGS, SONES	1.9	0.9	4.5	2.5
MOTOR				
TYPE	-	-	-	-
HORSEPOWER	3/8 WATTS	48.2 WATTS	1/8 WATTS	81 WATTS
FULL LOAD AMPS		0.43		
ELECTRICAL SERVICE AVAILABLE	15/160	15/160	15/160	15/160
STARTER TYPE	LITE SWITCH	LITE SWITCH	LITE SWITCH	LITE SWITCH
STARTER FURNISHED BY	ELECT. CONT.	(3) ELECT. CONT.	ELECT. CONT.	ELECT. CONT.
GENERAL DATA				
LOCATION	CLG.	INLINE	CLG.	CLG.
MASONRY OPENING REQUIRED, SEE NOTE 1	SEE PLAN	SEE PLAN	-	-
OPERATING WEIGHT	9	5	12	10
ACCESSORIES				
FACTORY ROOF CURB, (SEE NOTE 2)	N/A	N/A	N/A	N/A
SERVICE SWITCH	YES	YES	YES	YES
BACKDRAFT DAMPER	YES	YES	YES	YES
WALL BOX	N/A	N/A	N/A	N/A
WALL COLLAR	N/A	N/A	N/A	N/A
OSHA MOTOR SIDE GUARD	N/A	N/A	N/A	N/A
BIRD SCREEN	YES	YES	YES	YES
WEATHER HOOD	N/A	N/A	N/A	N/A
DAMPER GUARD	N/A	N/A	N/A	N/A
REAR GUARD	N/A	N/A	N/A	N/A
ROOF-JACK	YES	YES	WALL CAP	WALL CAP
ROOF-CAP	N/A	N/A	N/A	N/A
VIBRATION ISOLATORS				
TYPE	N/A	N/A	N/A	N/A
MINIMUM STATIC DEFLECTION (INCH.)	N/A	N/A	N/A	N/A
AUTOMATIC CONTROLS				
TYPE	N/A	N/A	N/A	N/A
DESCRIPTION	N/A	N/A	N/A	N/A
1. ROOF AND/OR MASONRY OPENING SHOWN ARE FOR REFERENCE ONLY. PROVIDE ROOF OPENINGS PER APPROVED EQUIPMENT SHOP DRAWINGS.				
2. PROVIDE FAN AND CURB FACTORY HIGH WIND RESISTANCE (50 MPH - 61 PSF) CERTIFICATION.				
3. INTERCONNECTED WITH THERMOSTAT.				

5

VENTILATION EQUIPMENT SCHEDULE

DESIGNATION	EF-1	EF-2	EF-3	EF-4
QUANTITY (VERIFY)	SEE PLAN	SEE PLAN	SEE PLAN	SEE PLAN
USE	EXHAUST	EXHAUST	EXHAUST	EXHAUST
LOCATION	CLG.	CLG.	CLG.	CLG.
AREA SERVED	RESTROOM	ELECT. RM	RESTROOM	RESTROOM
MANUFACTURER	GREENHECK	GREENHECK	GREENHECK	GREENHECK
MODEL NO.	SP-350	CSP-A200	SFA-330	SFA-250
FAN TYPE	BELT DRIVE	BELT DRIVE	DIRECT	DIRECT
AIR FLOW (C.F.M.)	50	100	300	100
EXTERNAL STATIC PRESSURE (" H ₂ O)	0.15	0.25	0.15	0.15
FAN SPEED (R.P.M.)	675	900	1000	1000
FAN SOUND RATINGS, SONES	1.9	0.9	4.5	2.5
MOTOR				
TYPE	-	-	-	-
HORSEPOWER	3/8 WATTS	48.7 WATTS	1/8 WATTS	81 WATTS
FULL LOAD AMPS		0.43		
ELECTRICAL SERVICE AVAILABLE	15/1/60	15/1/60	15/1/60	15/1/60
STARTER TYPE	LITE SWITCH	LITE SWITCH	LITE SWITCH	LITE SWITCH
STARTER FURNISHED BY	ELECT. CONT.	(3) ELECT. CONT.	ELECT. CONT.	ELECT. CONT.
GENERAL DATA				
LOCATION	CLG.	INLINE	CLG.	CLG.
MASONRY OPENING REQUIRED, SEE NOTE 1	SEE PLAN	SEE PLAN	-	-
OPERATING WEIGHT	9	5	12	10
ACCESSORIES				
FACTORY ROOF CURB (SEE NOTE 2)	N/A	N/A	N/A	N/A
SERVICE SWITCH	YES	YES	YES	YES
BACKDRAFT DAMPER	YES	YES	YES	YES
WALL BOX	N/A	N/A	N/A	N/A
WALL COLLAR	N/A	N/A	N/A	N/A
OSHA MOTOR SIDE GUARD	N/A	N/A	N/A	N/A
BIRD SCREEN	YES	YES	YES	YES
WEATHER HOOD	N/A	N/A	N/A	N/A
DAMPER GUARD	N/A	N/A	N/A	N/A
REAR GUARD	N/A	N/A	N/A	N/A
ROOF-JACK	YES	YES	WALL CAP	WALL CAP
ROOF-CAP	N/A	N/A	N/A	N/A
VIBRATION ISOLATORS				
TYPE	N/A	N/A	N/A	N/A
MINIMUM STATIC DEFLECTION (INCH.)	N/A	N/A	N/A	N/A
AUTOMATIC CONTROLS				
TYPE	N/A	N/A	N/A	N/A
DESCRIPTION	N/A	N/A	N/A	N/A

1. ROOF AND/OR MASONRY OPENING SHOWN ARE FOR REFERENCE ONLY. PROVIDE ROOF OPENINGS PER APPROVED EQUIPMENT SHOP DRAWINGS.
2. PROVIDE FAN AND CURB FACTORY HIGH WIND RESISTANCE (50 MPH - 61 PSF) CERTIFICATION.
3. INTERCONNECTED WITH THERMOSTAT.

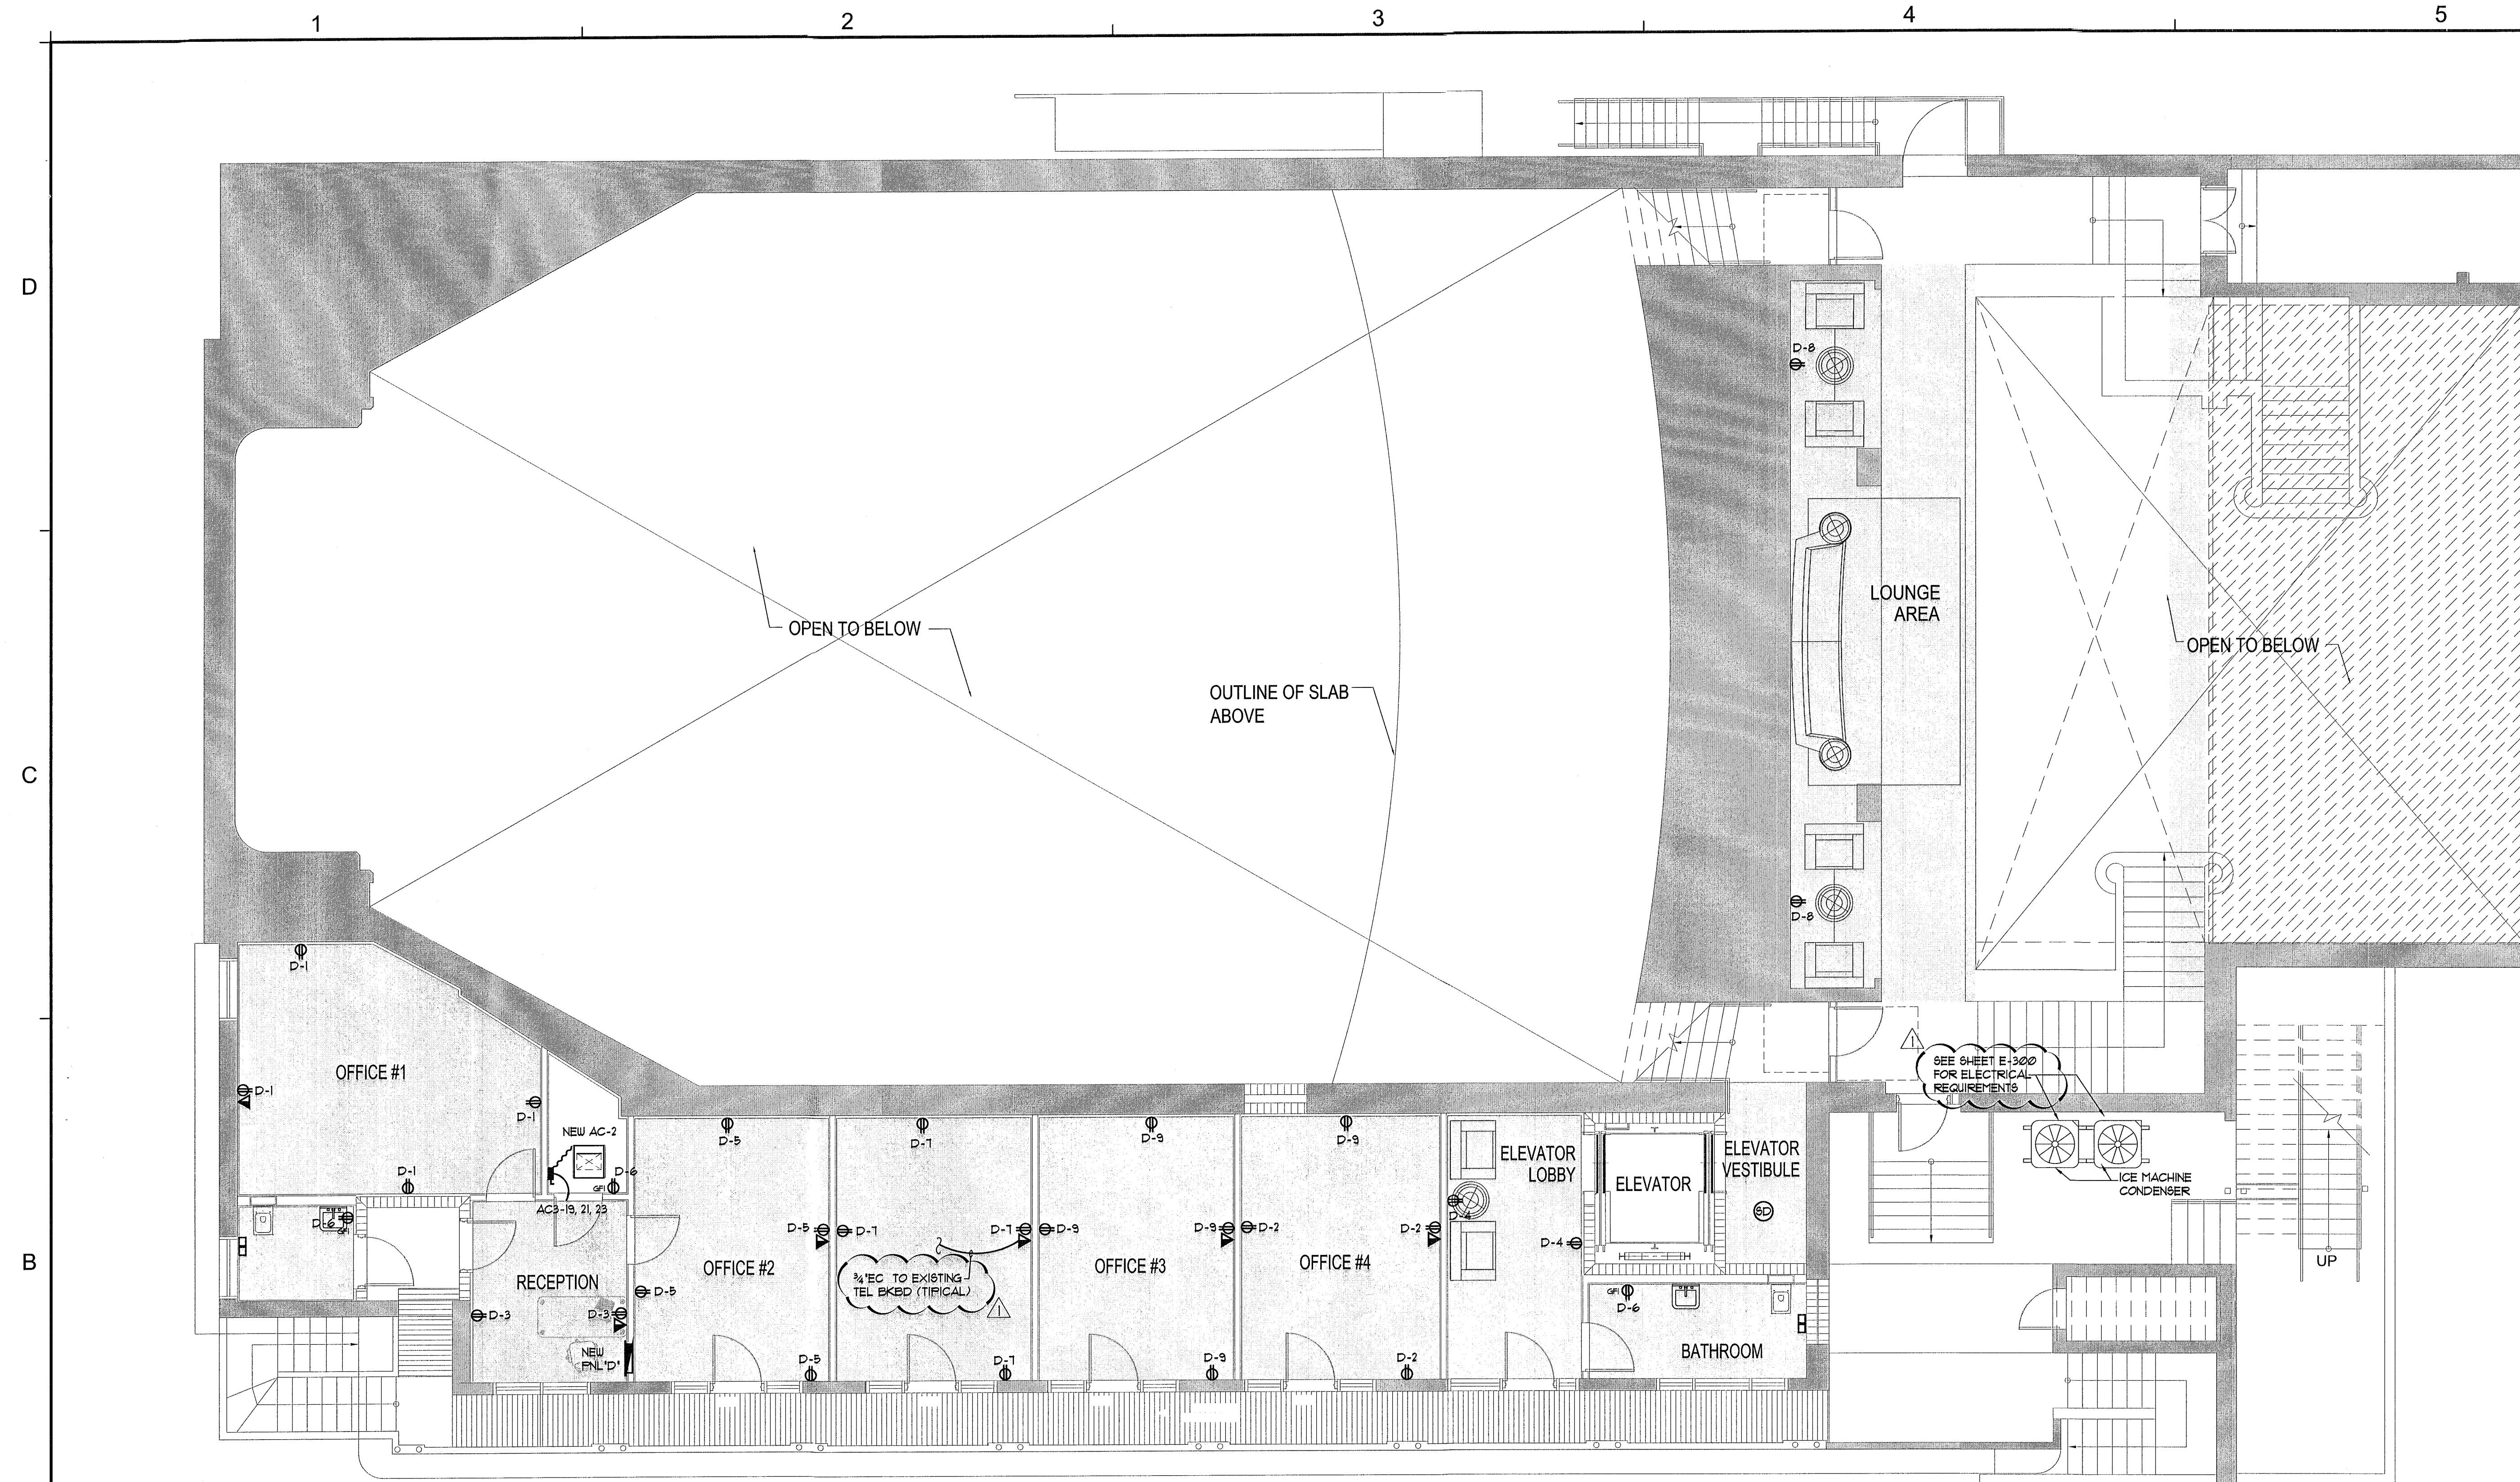

 SECOND FLOOR POWER PLAN

SCALE: 3/16"=1'-0"


[illegible]

1151

ALL DRAWINGS AND WRITTEN MATERIAL APPEARING HEREIN CONSTITUTE THE ORIGINAL AND UNPUBLISHED WORK OF KOBİ KARP A.Ş. AND MAY NOT BE DUPLICATED, USED, OR DISCLOSED WITHOUT THE EXPRESS WRITTEN CONSENT OF KOBİ KARP ARCHITECTURE & INTERIOR DESIGN, INC. A.Ş. (c) 2011

BAMBOO GROUP INC.
550 WASHINGTON AVENUE
MIAMI BEACH, FLORIDA

SECOND FLOOR PLAN

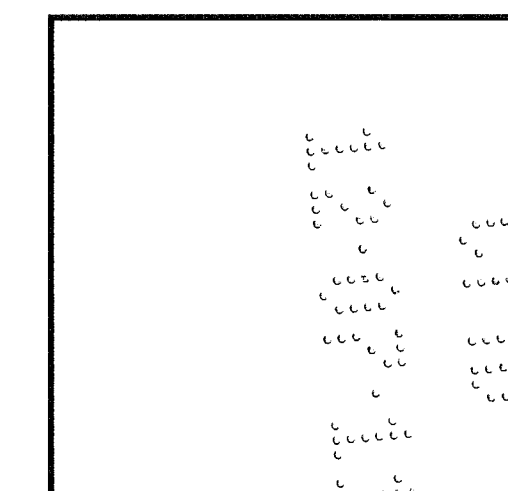


ic: # AR0012578

ARCHITECTURE
INTERIOR DESIGN
PLANNING

AIA ASID NCARB

2915 Biscayne Boulevard
Suite 200
Miami, Florida 33137
O: 305.573.1818
F: 305.573.3766

WWW.KOBIKARP.COM

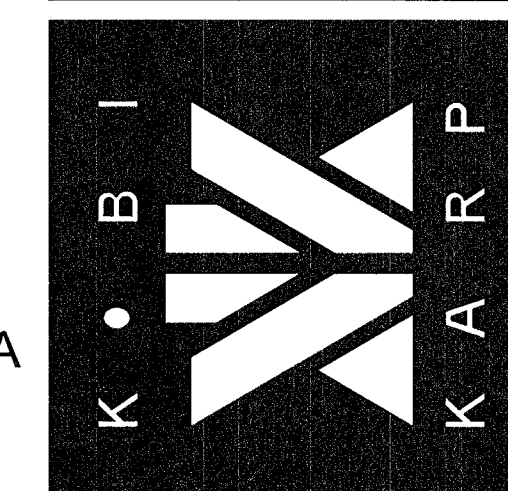


DRAWN BY:	MD,JO
CHECKED BY:	JG
DATE:	09-08-11

E-101

THESE PLANS ARE FOR BUILDING DEPARTMENT REVIEW. THEY ARE NOT TO BE CONSTRUED AS FINAL CONSTRUCTION DOCUMENTS UNTIL ALL BUILDING DEPARTMENT APPROVALS ARE OBTAINED AND COMMENTS INCORPORATED INTO THESE DWGS. DUE TO THE VARIATIONS IN INTERPRETATIONS OF THE CODE THAT OCCUR IN DIFFERENT MUNICIPALITIES FINAL APPROVAL AND REVIEW IS NEEDED TO ASSURE COMPLIANCE WITH THE APPLICABLE CODES AND STANDARDS.


Electrical Plans Examined

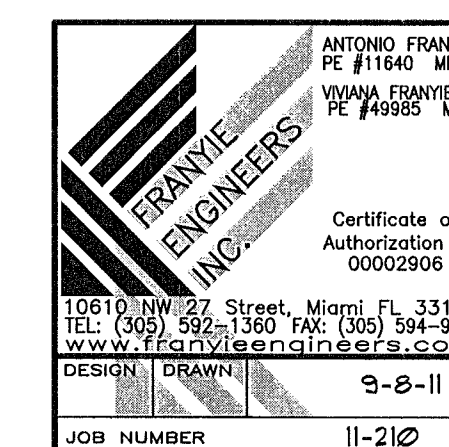

9-8-11
PERMIT SET

P:\PROJECTS\2011\KOBK KARP\11-210 Perms Theater\Perms Theater\11-210-102-102-102-NEW.dwg, E-102, 11/3/2011, 4:25:10 PM, 11

THESE PLANS ARE FOR BUILDING DEPARTMENT REVIEW. THEY ARE NOT TO BE CONSTRUED AS FINAL CONSTRUCTION DOCUMENTS UNTIL ALL BUILDING DEPARTMENT APPROVALS ARE OBTAINED AND COMMENTS INCORPORATED INTO THESE DWGS. DUE TO THE VARIATIONS IN INTERPRETATIONS OF THE CODE THAT OCCUR IN DIFFERENT MUNICIPALITIES FINAL APPROVAL AND REVIEW IS NEEDED TO ASSURE COMPLIANCE WITH THE APPLICABLE CODES AND STANDARDS.

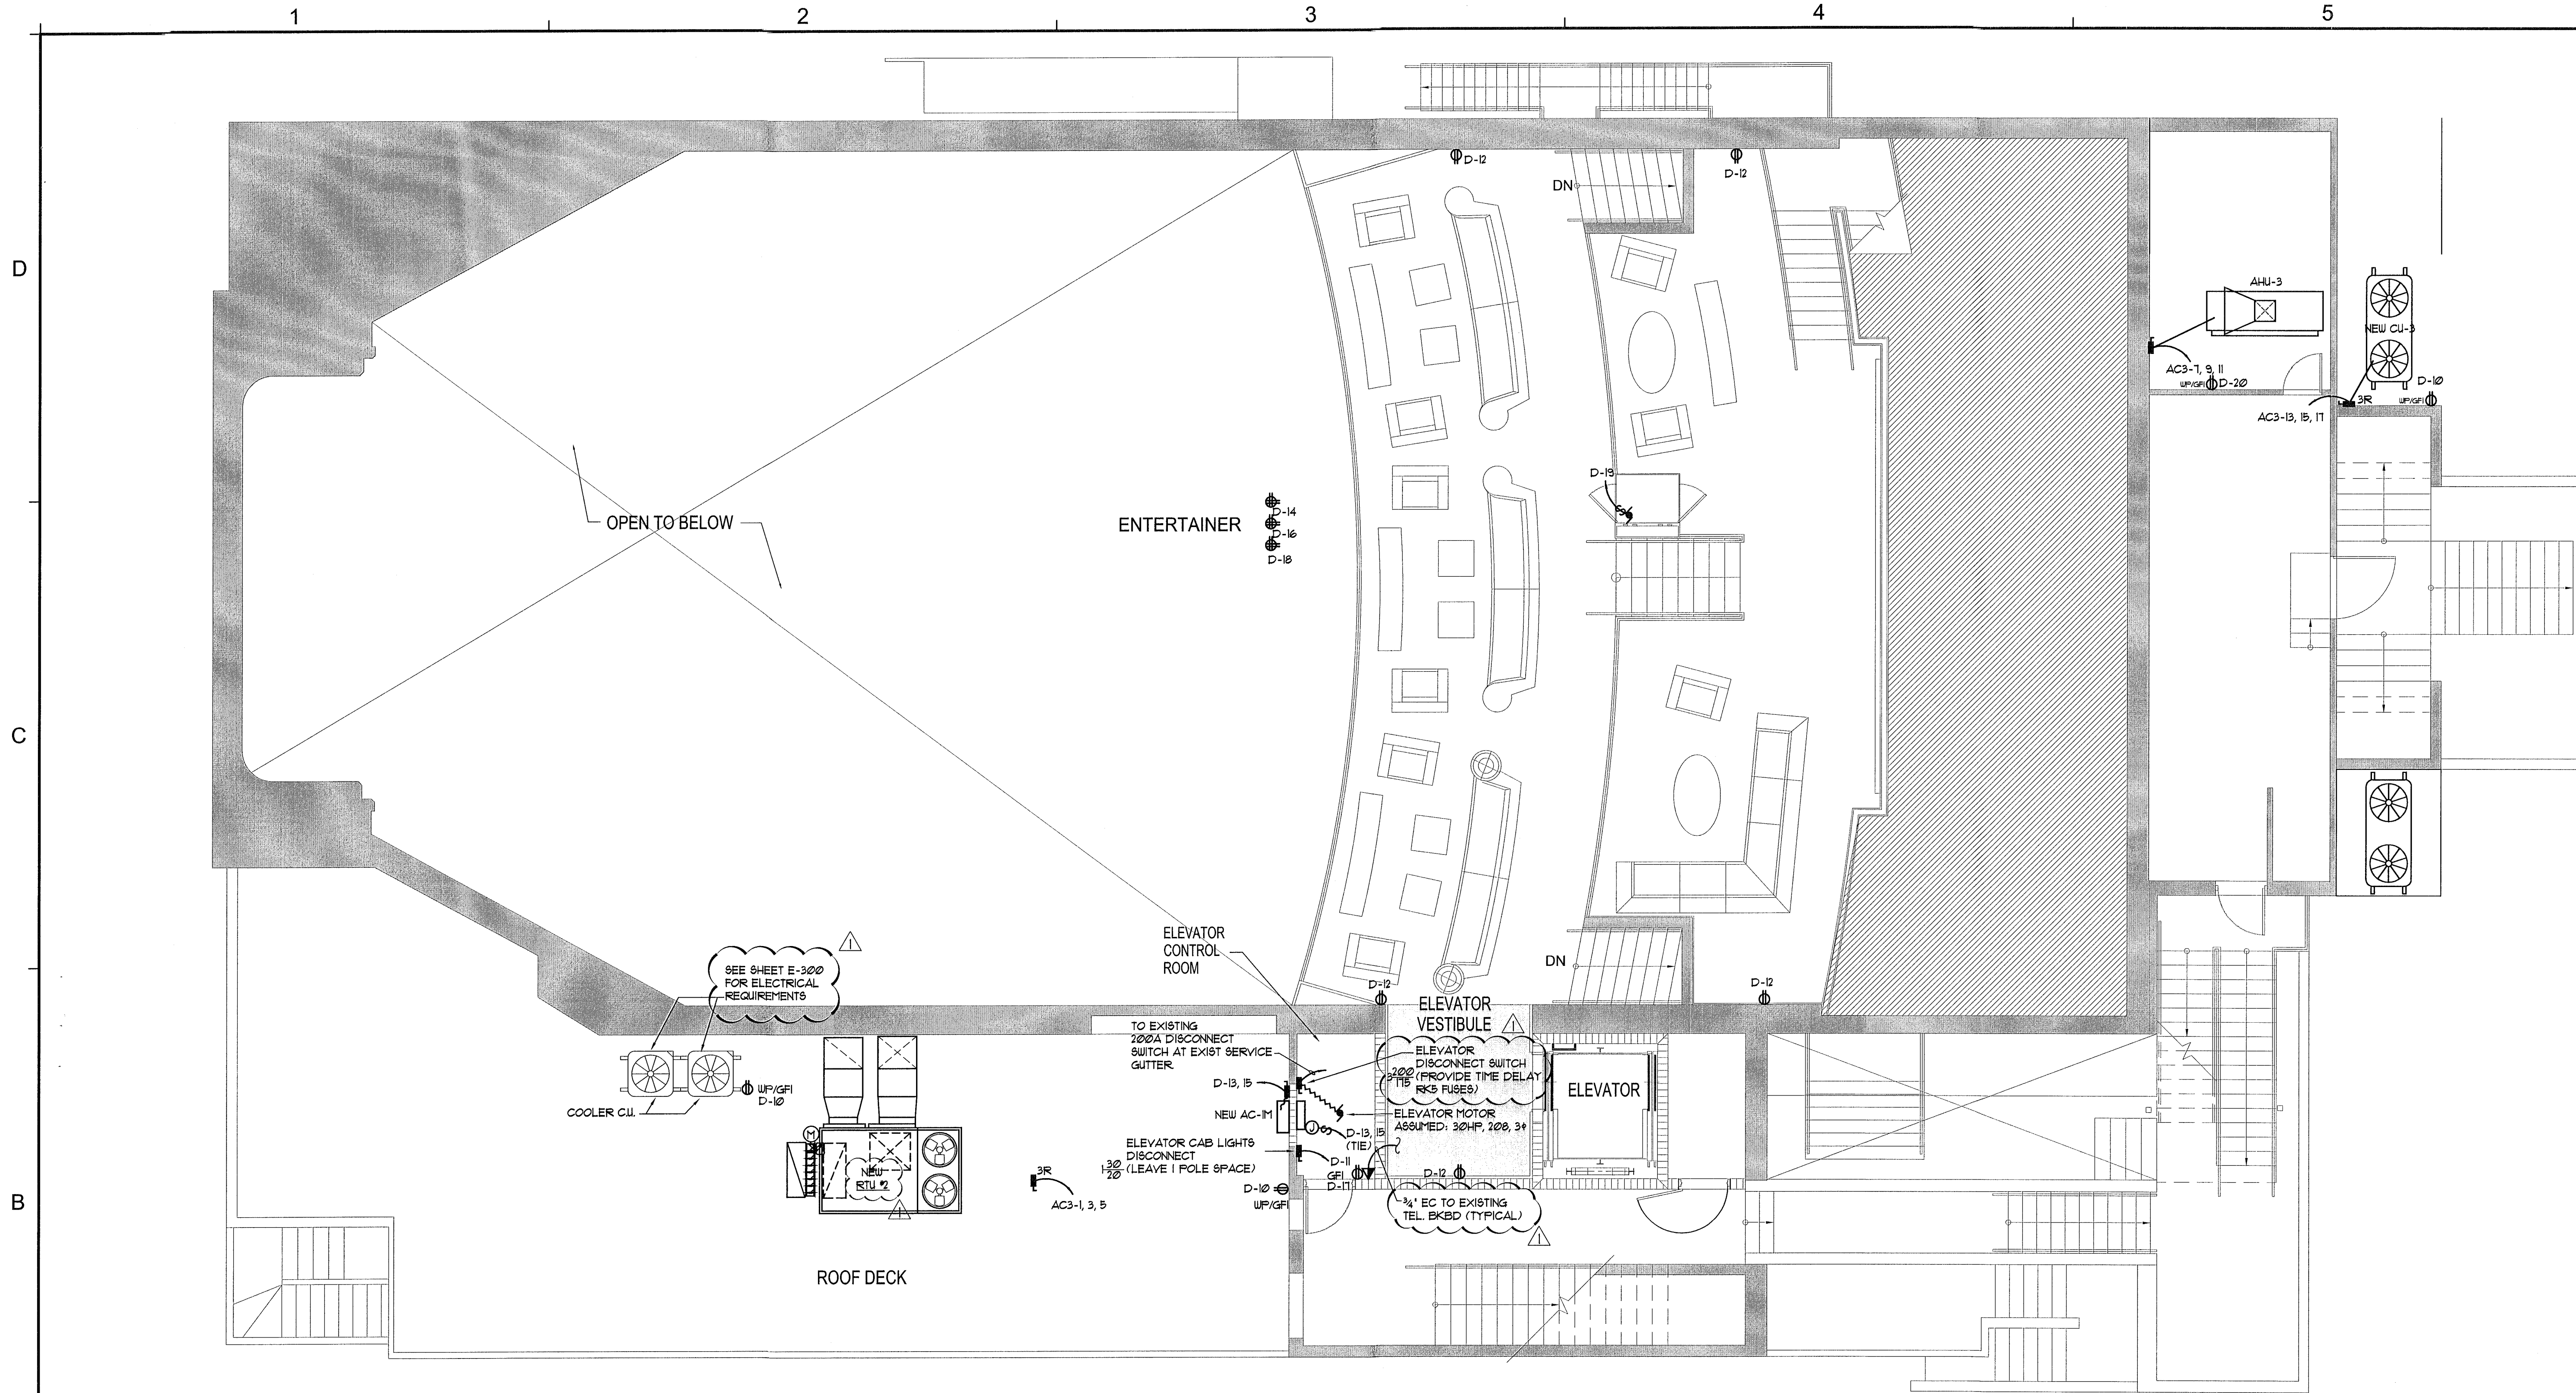

THIRD FLOOR POWER PLAN
SCALE: 3/16"=1'-0"

Electrical Plans Examiner



9-8-11
PERMIT SET


REVISIONS / SUBMISSIONS		
II-2-II	COORDINATION	AAF

1151

ALL DRAWINGS AND WRITTEN MATERIAL APPROVING HEREIN CONSTITUTE THE ORIGINAL AND UNPUBLISHED WORK OF KOBK KARP ARCHITECTURE & INTERIOR DESIGN, INC. NO PART OF THIS DOCUMENT MAY BE REPRODUCED OR TRANSMITTED IN ANY FORM OR BY ANY MEANS, WITHOUT THE EXPRESS WRITTEN CONSENT OF KOBK KARP ARCHITECTURE & INTERIOR DESIGN, INC. (K&I).


BAMBOO GROUP INC.
550 WASHINGTON AVENUE
MIAMI BEACH, FLORIDA

THIRD FLOOR PLAN

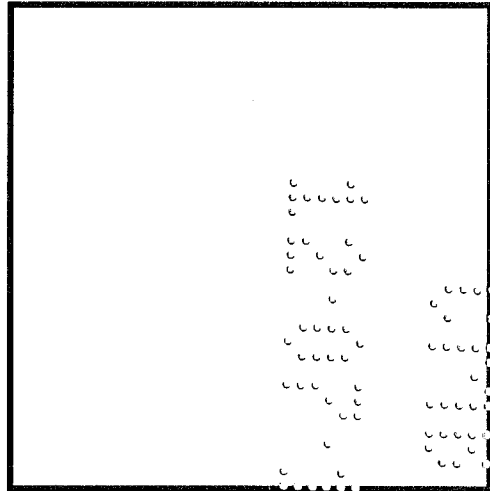

Lic. # AR0012578



ARCHITECTURE
INTERIOR DESIGN
PLANNING
AIA ASID NCARB
2915 Biscayne Boulevard
Suite 300
Miami, Florida 33137
C: 305.573.1818
F: 305.573.3786
WWW.KOBKARP.COM

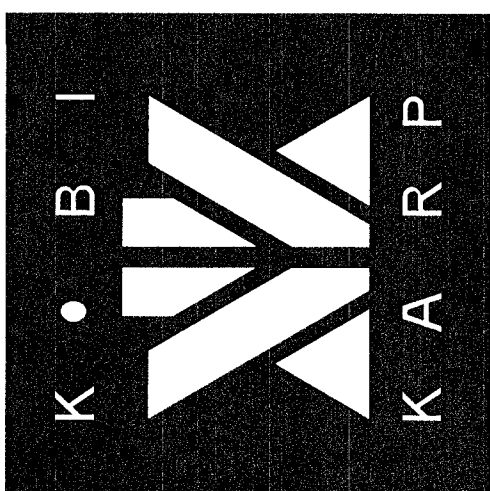

DRAWN BY: MD,JO
CHECKED BY: JG
DATE: 09-08-11

E-102

P:\PROJECTS\2011\KOB KARP\11-10 Pwr Plan\11-10-103-REV.dwg E-103, 11/3/2011 4:25:15 PM, 11

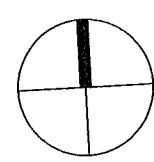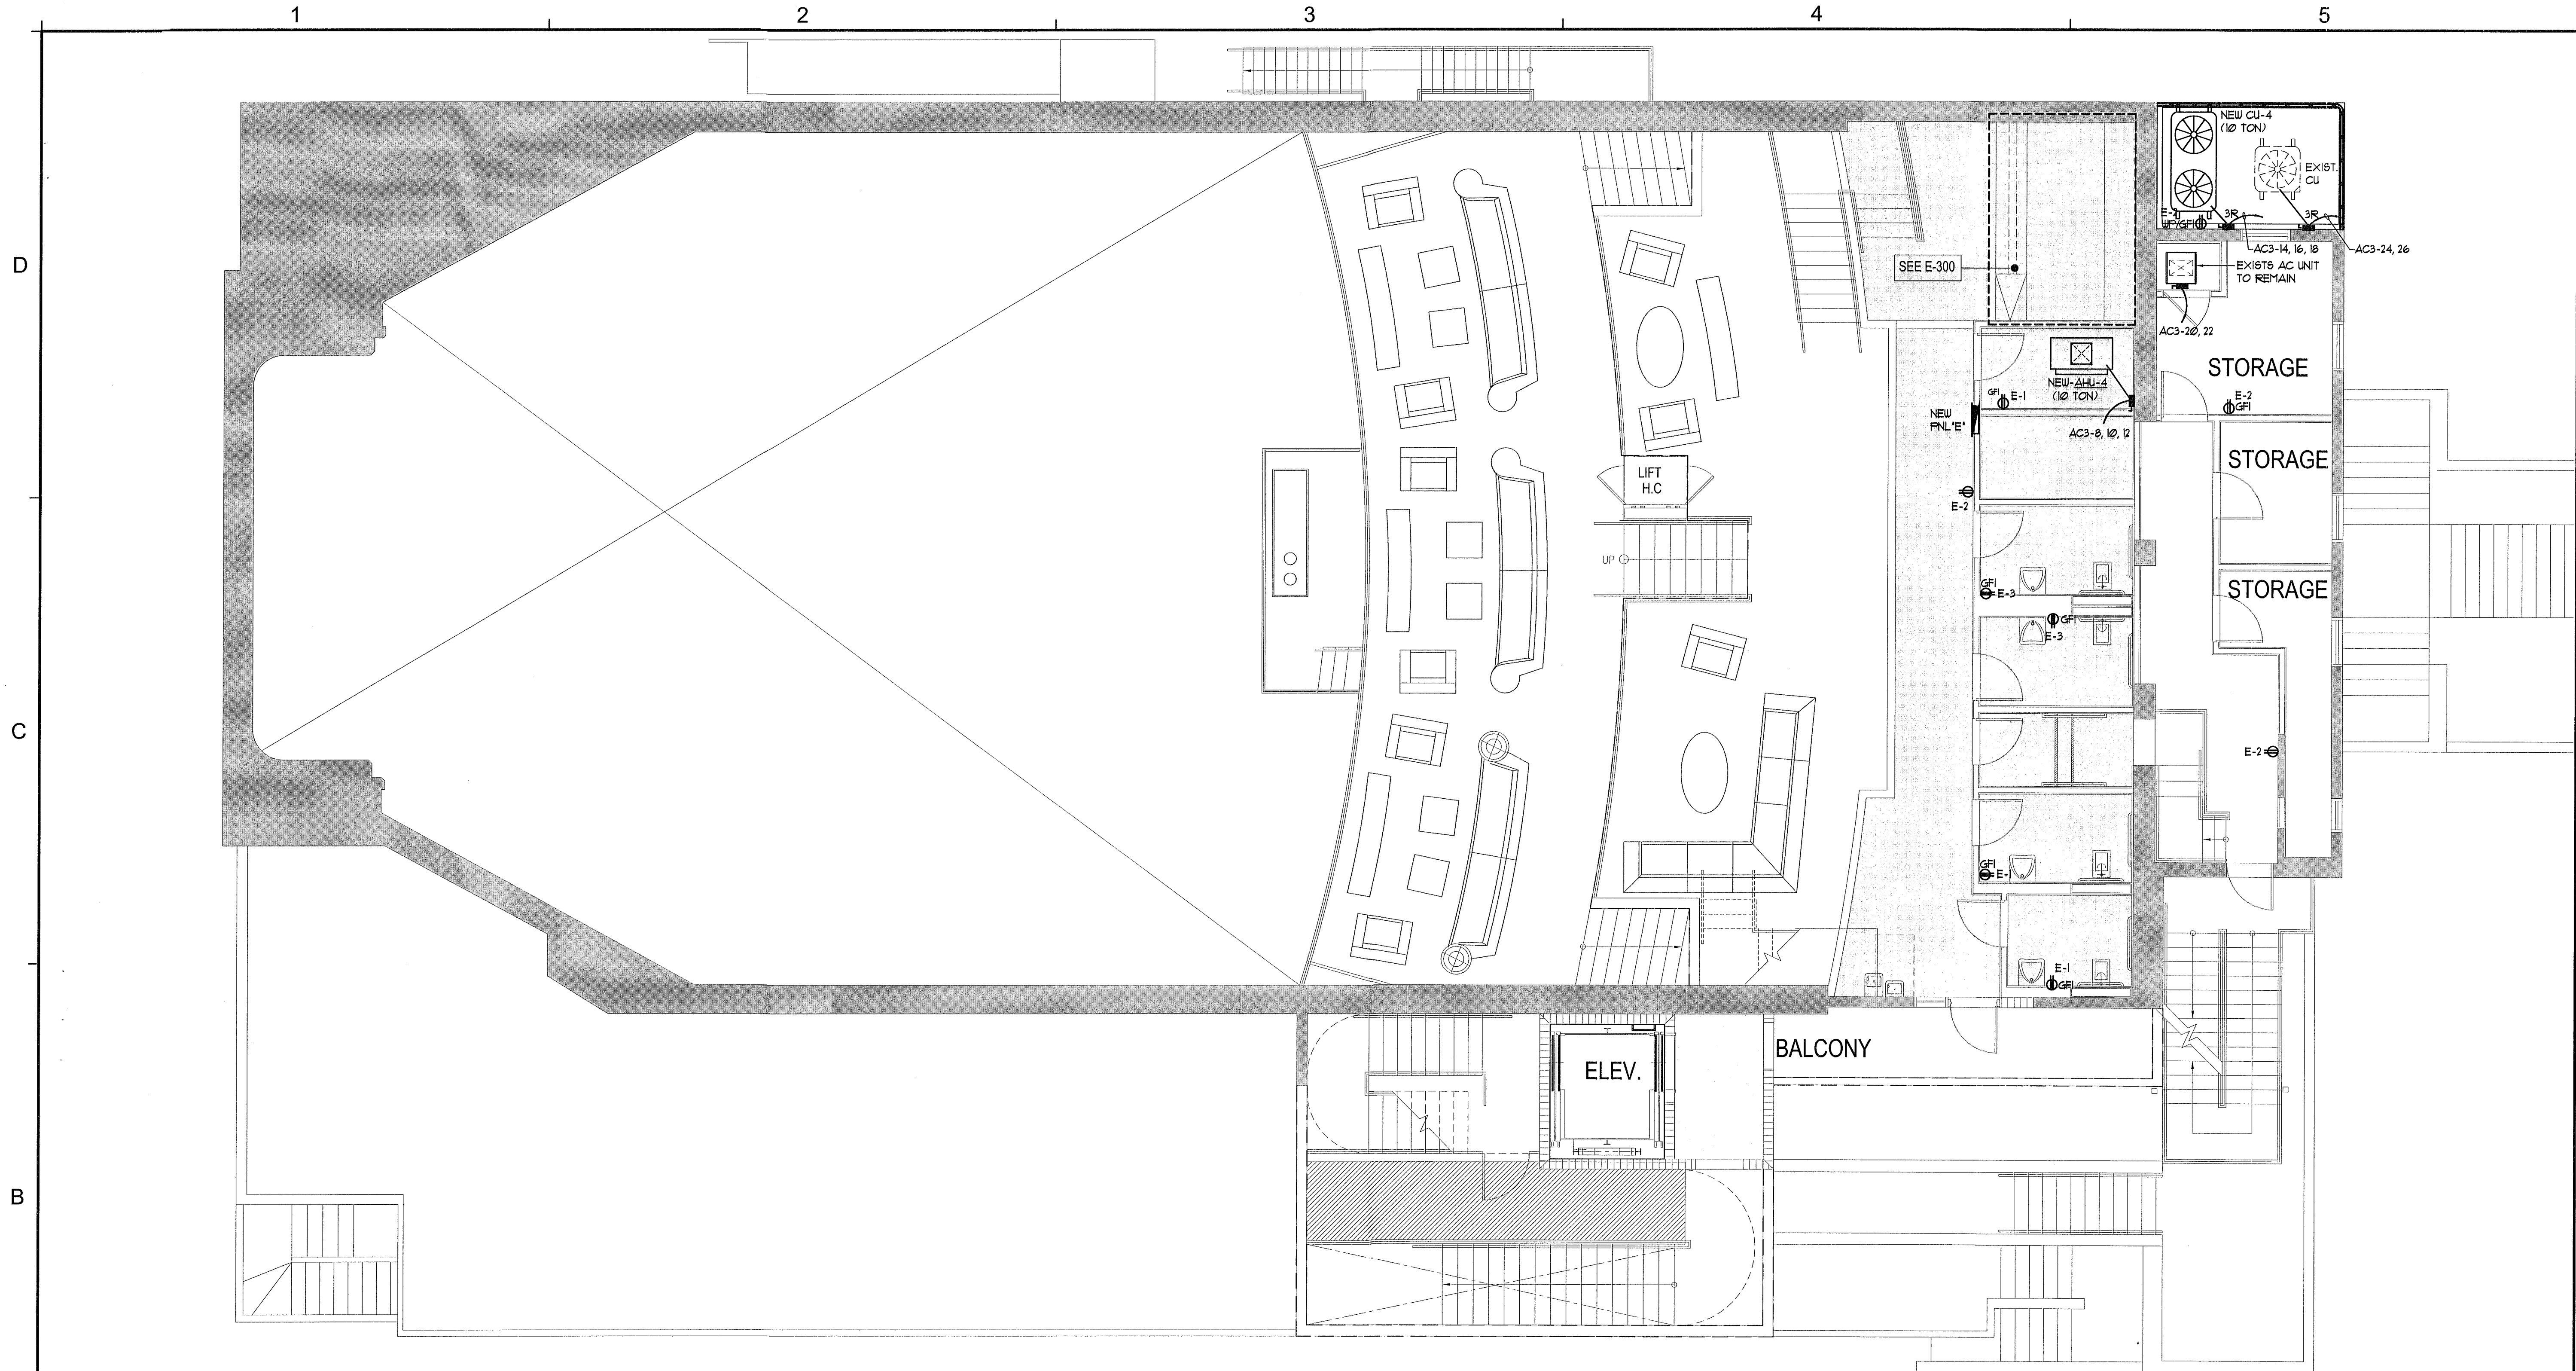

FOURTH FLOOR POWER PLAN



SCALE:

3/16"=1'-0"

THESE PLANS ARE FOR BUILDING DEPARTMENT REVIEW. THEY ARE NOT TO BE CONSTRUED AS FINAL CONSTRUCTION DOCUMENTS UNTIL ALL BUILDING DEPARTMENT APPROVALS ARE OBTAINED AND COMMENTS INCORPORATED INTO THESE DWGS. DUE TO THE VARIATIONS IN INTERPRETATIONS OF THE CODE THAT OCCUR IN DIFFERENT MUNICIPALITIES FINAL APPROVAL AND REVIEW IS NEEDED TO ASSURE COMPLIANCE WITH THE APPLICABLE CODES AND STANDARDS.

Electrical Plans Examiner

[Signature]

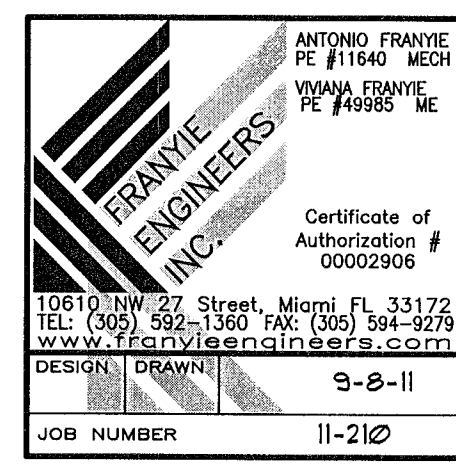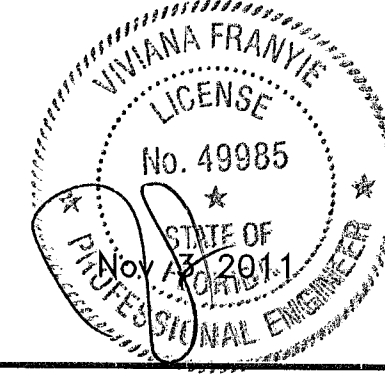

9-8-11 PERMIT SET

REVISIONS / SUBMISSIONS

1151

ALL DRAWINGS AND WRITTEN MATERIAL APPEARING HEREIN CONSTITUTE THE ORIGINAL AND UNPUBLISHED WORK OF KOB KARP AIA, AND MAY NOT BE DUPLICATED, USED, OR DISCLOSED WITHOUT THE EXPRESS WRITTEN CONSENT OF KOB KARP ARCHITECTURE & INTERIOR DESIGN, INC. AIA (S) 2011

BAMBOO GROUP INC.
550 WASHINGTON AVENUE
MIAMI BEACH, FLORIDA

FOURTH FLOOR PLAN

ARCHITECTURE
INTERIOR DESIGN
PLANNING

AIA ASID NCARB


2915 Biscayne Boulevard
Miami, Florida 33137
O: 305.573.8116
F: 305.573.9766
WWW.KOBKARP.COM

Lic. #AR0012578

ARCHITECTURE
INTERIOR DESIGN
PLANNING


AIA ASID NCARB

2915 Biscayne Boulevard
Miami, Florida 33137
O: 305.573.8116
F: 305.573.9766
WWW.KOBKARP.COM

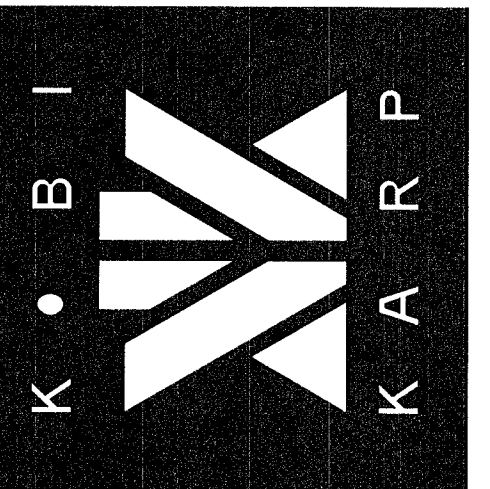

DRAWN BY:	MD,JO
CHECKED BY:	JG
DATE:	09-08-11
E-103	


P:\PROJECTS\2011\KOB KARP\11-210 Perms\Thermal\Perms_E-104_11-210.dwg, E-104, 11/29/2011, 4:25:20 PM, 09, 11

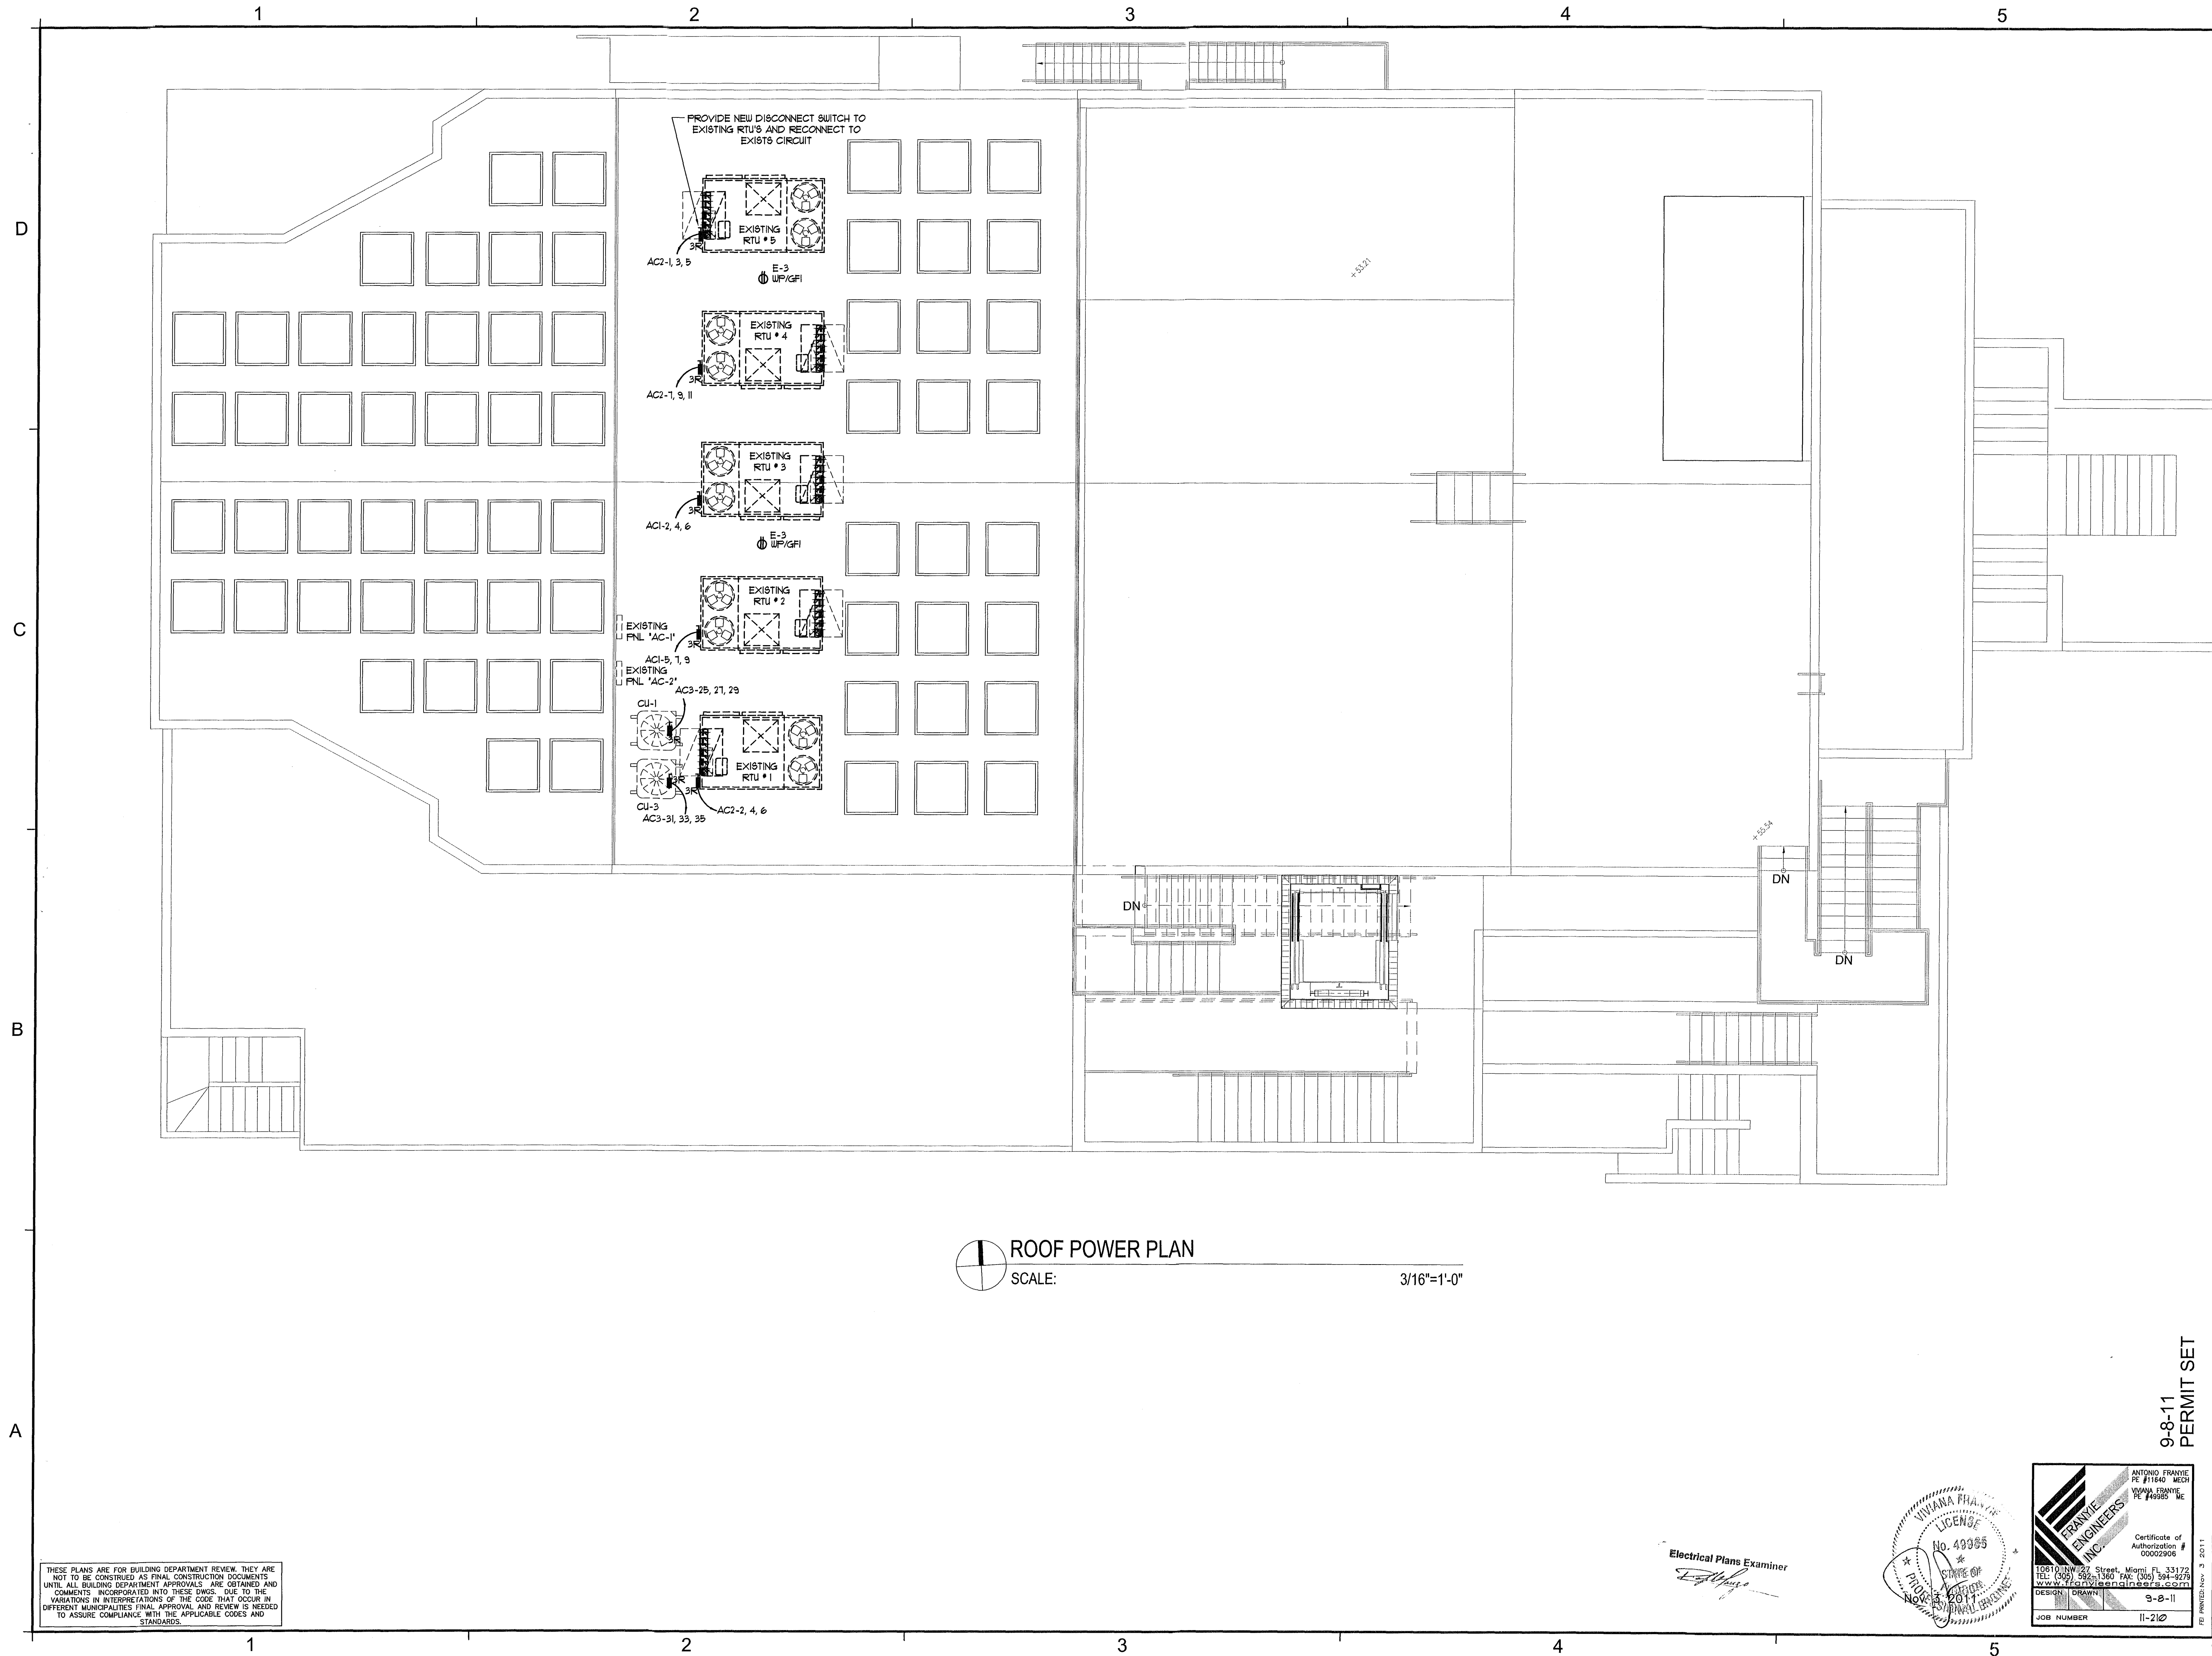

ROOF POWER PLAN
SCALE: 3/16"=1'-0"

THESE PLANS ARE FOR BUILDING DEPARTMENT REVIEW. THEY ARE NOT TO BE CONSTRUED AS FINAL CONSTRUCTION DOCUMENTS UNTIL ALL BUILDING DEPARTMENT APPROVALS ARE OBTAINED AND COMMENTS INCORPORATED INTO THESE DWGS. DUE TO THE VARIATIONS IN INTERPRETATIONS OF THE CODE THAT OCCUR IN DIFFERENT MUNICIPALITIES FINAL APPROVAL AND REVIEW IS NEEDED TO ASSURE COMPLIANCE WITH THE APPLICABLE CODES AND STANDARDS.

Electrical Plans Examiner
[Signature]

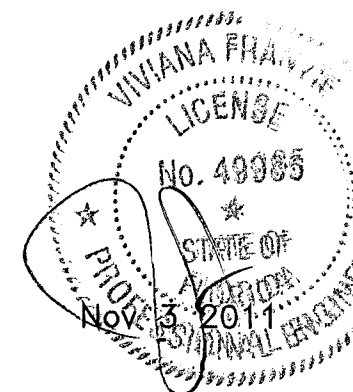

9-8-11
PERMIT SET

REVISIONS / SUBMISSIONS

1151


ALL DRAWINGS AND WRITTEN MATERIAL APPEARING HEREIN CONSTITUTE THE ORIGINAL AND UNPUBLISHED WORK OF KOB KARP INC. AND MAY NOT BE REPRODUCED, COPIED, OR DISCLOSED WITHOUT THE EXPRESS WRITTEN CONSENT OF KOB KARP ARCHITECTURE & INTERIOR DESIGN, INC. (K.A.R.P.)

BAMBOO GROUP INC.
550 WASHINGTON AVENUE
MIAMI BEACH, FLORIDA

ROOF FLOOR PLAN

Lic. # AR0012578


ARCHITECTURE
INTERIOR DESIGN
PLANNING
AIA ASID NCARB
2015 Biscayne Boulevard
Suite 200
Miami, Florida 33137
P: 305.573.3378
F: 305.573.3798
WWW.KOBKARP.COM

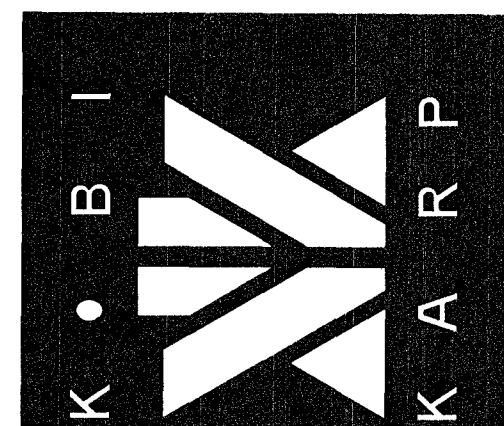

DRAWN BY: MDJO
CHECKED BY: JG
DATE: 09-08-11

E-104

P:\PROJECTS\2011\KOB KARP\11-210 Permit\Perms\EDOC-201-202-203-LIGHTING.dwg, E-200, 11/16/2011, 5:11:25 PM, Rev. 11

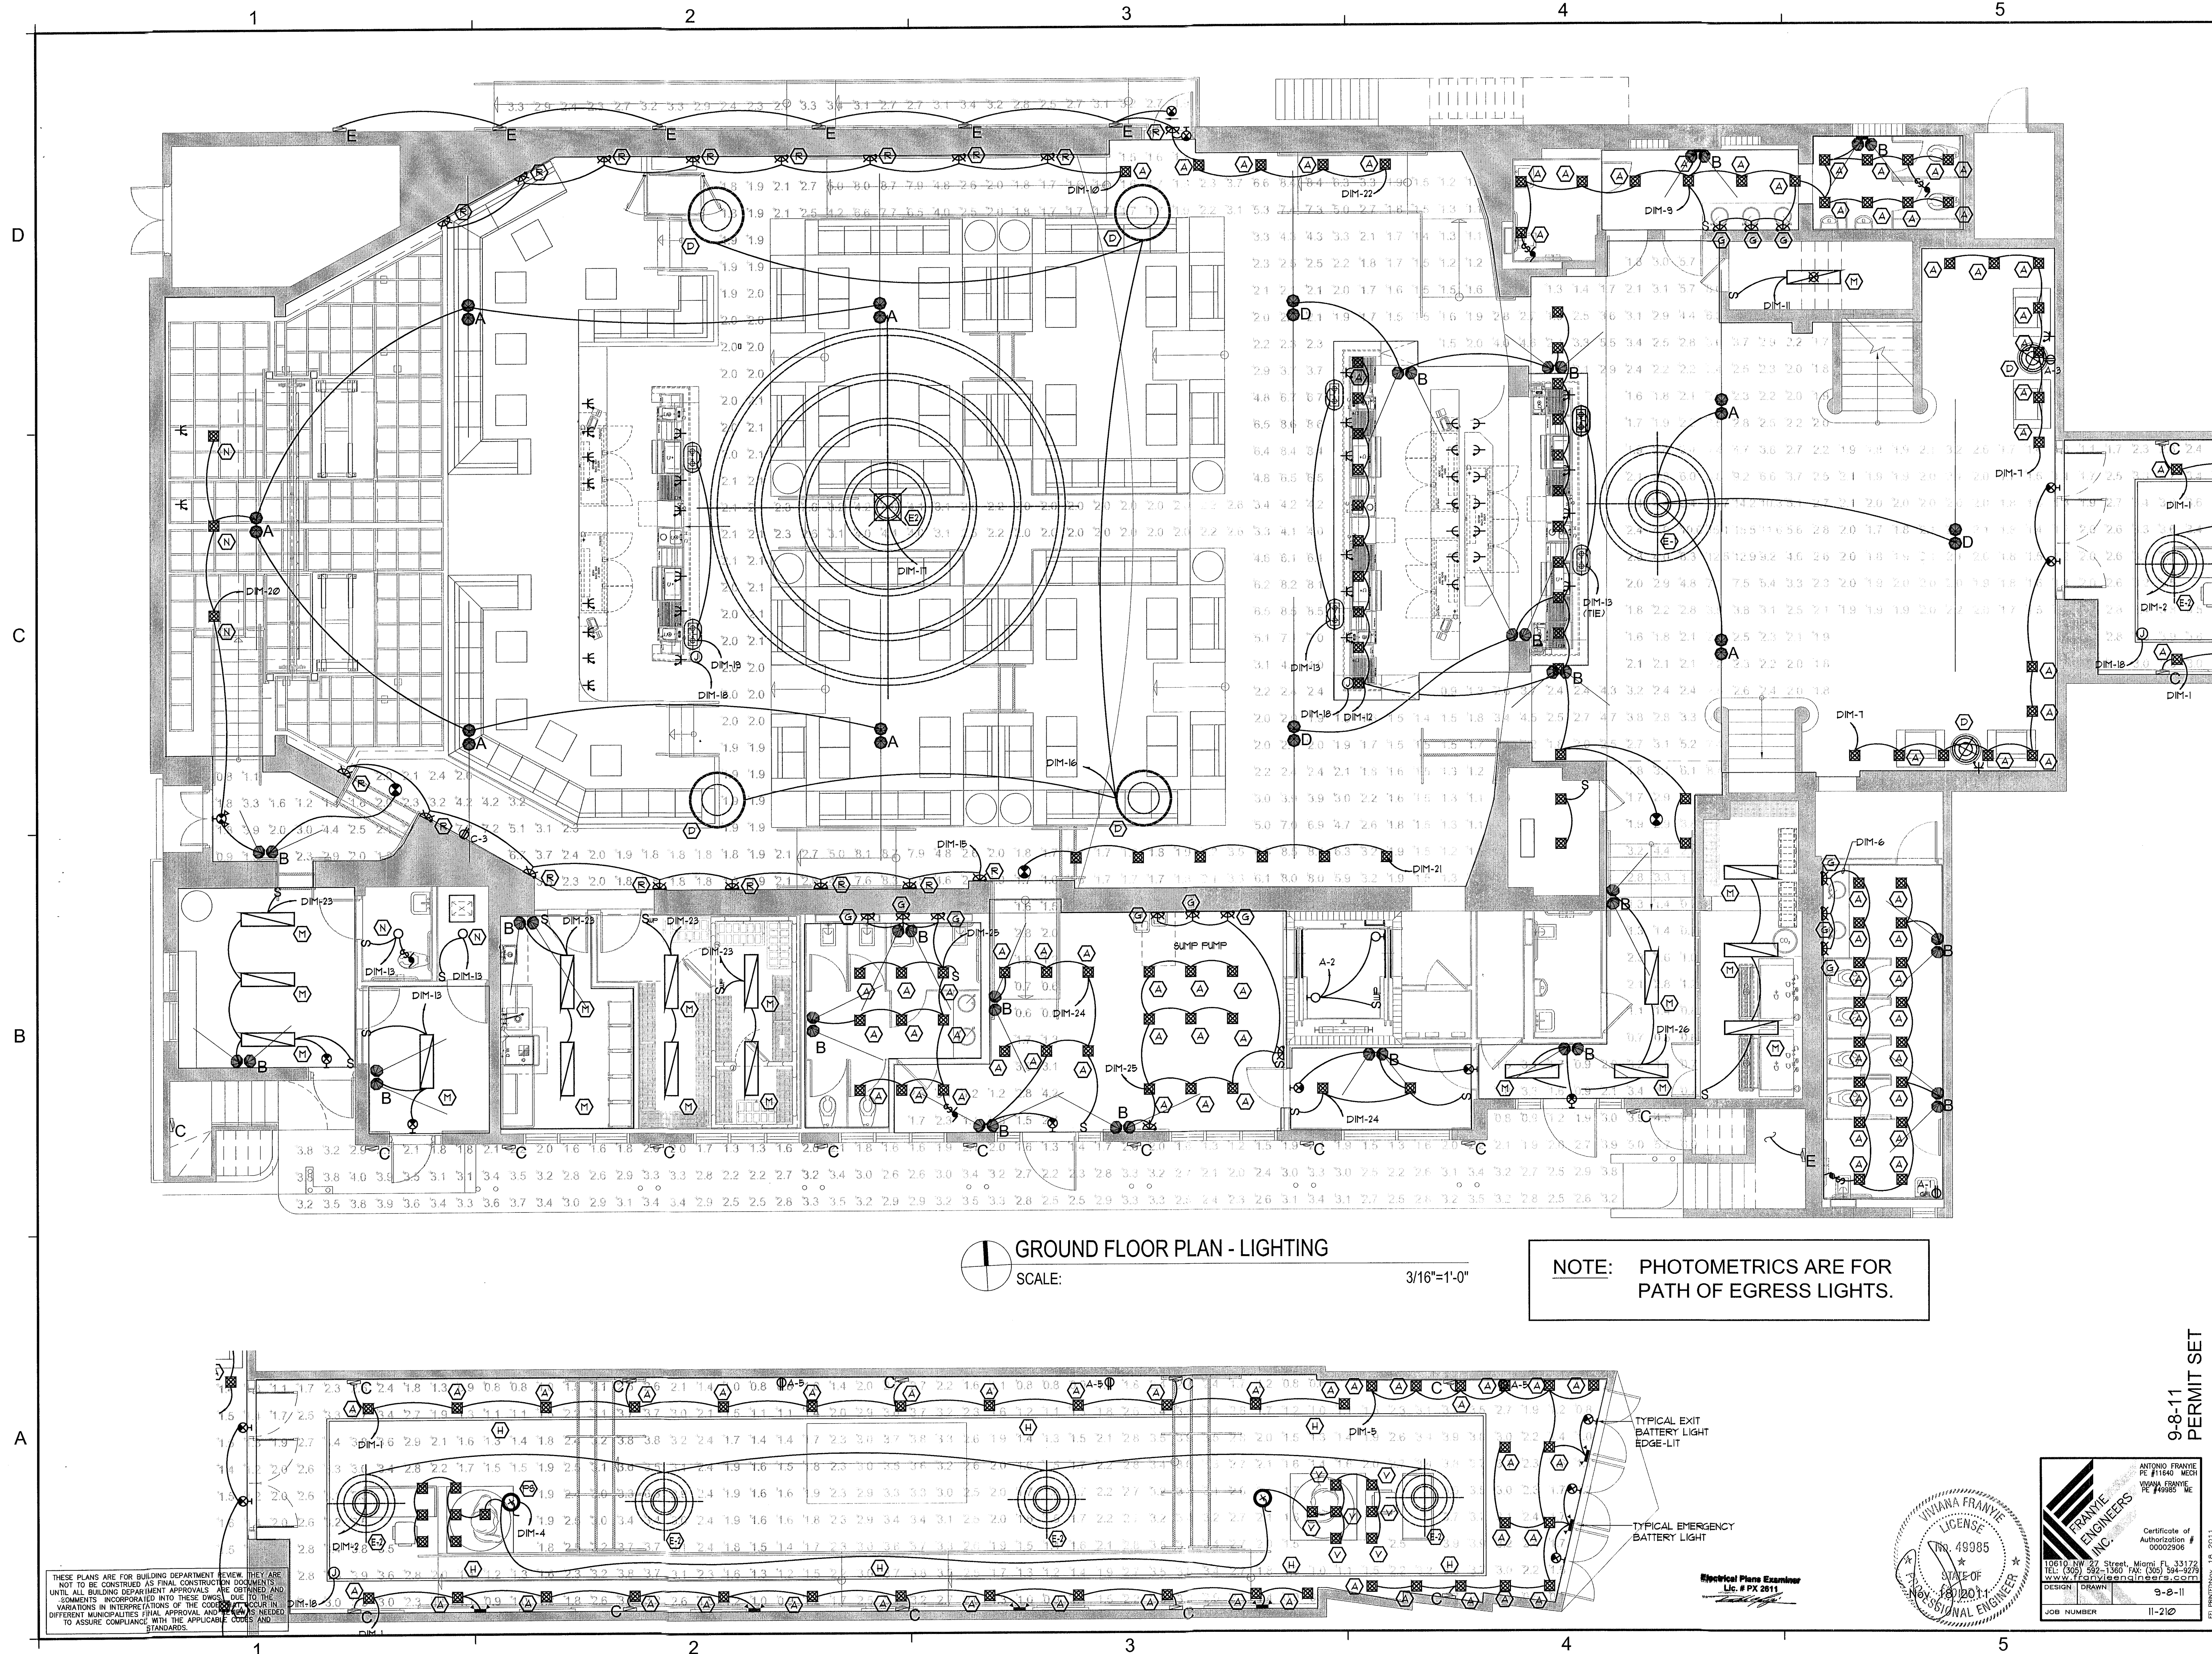

GROUND FLOOR PLAN - LIGHTING
SCALE: 3/16"=1'-0"

NOTE: PHOTOMETRICS ARE FOR PATH OF EGRESS LIGHTS.

THESE PLANS ARE FOR BUILDING DEPARTMENT REVIEW. THEY ARE NOT TO BE CONSTRUED AS FINAL CONSTRUCTION DOCUMENTS. COMMENTS INCORPORATED INTO THESE DWGS. DUE TO THE VARIATIONS IN INTERPRETATIONS OF THE CODES AND LOCAL ORDINANCES, DIFFERENT MUNICIPALITIES FINAL APPROVAL AND ANY NECESSARY TO ASSURE COMPLIANCE WITH THE APPLICABLE CODES AND STANDARDS.



9-8-11 PERMIT SET

REVISIONS / SUBMISSIONS	
11-2-11	COORDINATION AAF
11-18-11	COORDINATION AAF
11-18-11	BD COMMENT AAF

1151

ALL DRAWINGS AND WRITTEN MATERIAL APPEARING HEREIN CONSTITUTE THE ORIGINAL AND UNPUBLISHED WORK OF KOB KARP INC. AND MAY NOT BE REPRODUCED, COPIED, OR DISCLOSED WITHOUT THE EXPRESS WRITTEN CONSENT OF KOB KARP ARCHITECTURE & INTERIOR DESIGN, INC. AIA, INC. 2011.

BAMBOO GROUP INC.
550 WASHINGTON AVENUE
MIAMI BEACH, FLORIDA

GROUND FLOOR PLAN

ARCHITECTURE
INTERIOR DESIGN
PLANNING

AIA ASID NCARB
2915 Biscayne Boulevard
Miami, Florida 33137
O: 305.573.1818
F: 305.573.3786
WWW.KOBKARP.COM

Lic. # A10012578


KOB KARP

DRAWN BY: MDJO
CHECKED BY: JG
DATE: 09-08-11

E-200

P:\PROJECTS\2011\KOB KARP\11-210 Plans\Drawings\9-8-11\9-8-11-210 LIGHTING.dwg, E-201, 10/18/2011 5:11:30 PM, bty, 1:1

THESE PLANS ARE FOR BUILDING DEPARTMENT REVIEW. THEY ARE NOT TO BE CONSTRUED AS FINAL CONSTRUCTION DOCUMENTS UNTIL ALL BUILDING DEPARTMENT APPROVALS ARE OBTAINED AND COMMENTS INCORPORATED INTO THESE DWGS. DUE TO THE VARIATIONS IN INTERPRETATIONS OF THE CODE THAT OCCUR IN DIFFERENT MUNICIPALITIES FINAL APPROVAL AND REVIEW IS NEEDED TO ASSURE COMPLIANCE WITH THE APPLICABLE CODES AND STANDARDS.

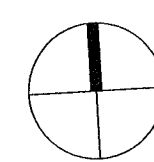

SECOND FLOOR PLAN - LIGHTING


SCALE:

3/16"=1'-0"

NOTE: PHOTOMETRICS ARE FOR PATH OF EGRESS LIGHTS.

9-8-11 PERMIT SET

MECHANICAL PLANS EXAMINER
Lic. # PX 2011

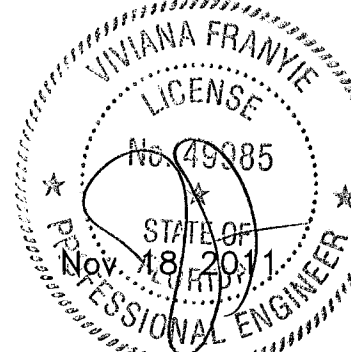

DRAWN BY: MD,JO
CHECKED BY: JG
DATE: 09-08-11

E-201

REVISIONS / SUBMISSIONS

II-2-II	COORDINATION	AAF
I-18-II	BD COMMENT	AAF


1151

ALL DRAWINGS AND WRITTEN MATERIAL APPEARING HEREIN CONSTITUTE THE ORIGINAL AND UNPUBLISHED WORK OF KOB KARP AND MAY NOT BE REPRODUCED, USED, OR DISCLOSED WITHOUT THE EXPRESS WRITTEN CONSENT OF KOB KARP ARCHITECTURE & INTERIOR DESIGN, INC. AIA, INC., 2011.

BAMBOO GROUP INC.
550 WASHINGTON AVENUE
MIAMI BEACH, FLORIDA


SECOND FLOOR PLAN

ARCHITECTURE
INTERIOR DESIGN
PLANNING
AIA ASID NCARB
2915 Biscayne Boulevard
Miami, Florida 33137
O: 305.573.1818
F: 305.573.3785
WWW.KOBKARP.COM

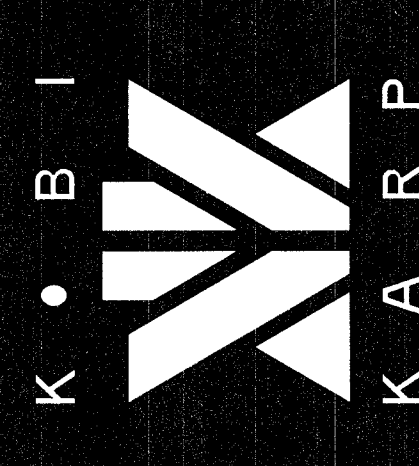

P:\PROJECTS\2011\KOB KARP\11-210 P&E\Theater\9-8-11\2011-202-203-LIGHTING.dwg, E-203, 11/3/2011, 4:25:46 PM, DWG, 11

THESE PLANS ARE FOR BUILDING DEPARTMENT REVIEW. THEY ARE NOT TO BE CONSTRUED AS FINAL CONSTRUCTION DOCUMENTS UNTIL ALL BUILDING DEPARTMENT APPROVALS ARE OBTAINED AND COMMENTS INCORPORATED INTO THESE DWGS. DUE TO THE VARIATIONS IN INTERPRETATIONS OF THE CODE THAT OCCUR IN DIFFERENT MUNICIPALITIES FINAL APPROVAL AND REVIEW IS NEEDED TO ASSURE COMPLIANCE WITH THE APPLICABLE CODES AND STANDARDS.

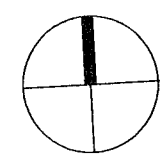

FOURTH FLOOR PLAN

SCALE:

3/16"=1'-0"

Electrical Plans Examiner



9-8-11
PERMIT SET

DRAWN BY: MD,JO
CHECKED BY: JG
DATE: 09-08-11

E-203

REVISIONS / SUBMISSIONS		
II-2-II	COORDINATION	AAF

1151

ALL DRAWINGS AND WRITTEN MATERIAL APPEARING HEREIN CONSTITUTE THE ORIGINAL AND UNPUBLISHED WORK OF KOB KARP AIA AND MAY NOT BE DUPLICATED, USED, OR DISCLOSED WITHOUT THE EXPRESS WRITTEN CONSENT OF KOB KARP ARCHITECTURE & INTERIOR DESIGN, INC. AIA (S) 2011.

BAMBOO GROUP INC.
550 WASHINGTON AVENUE
MIAMI BEACH, FLORIDA

FOURTH FLOOR PLAN

ARCHITECTURE
INTERIOR DESIGN
PLANNING
AIA ASID NCARB
2915 Biscayne Boulevard
Miami, Florida 33137
O: 305.573.8118
F: 305.573.3766
WWW.KOBKARP.COM

