 


31 LA GORCE RESIDENCE

FINAL SUBMITTAL . APRIL 6, 2020

DRAWING INDEX

A-1	INDEX	A-19	DEMOLITION PLAN	A-35.1	SECTION - TRANSVERSE
A-2	SURVEY	A-20	DEMOLITION ELEVATIONS	A-35.2	POOL CABANA ELEVATIONS
A-3	ZONING DATA SHEET	A-20.1	PROPOSED AXONOMETRICS	A-35.3	FENCE DETAIL
A-4	SETBACK DIAGRAM - GROUND LEVEL	A-21	PROPOSED DIAGRAMS - UNIT SIZE - GROUND LEVEL	A-35.4	TRASH DETAIL
A-5	SETBACK DIAGRAM - SECOND LEVEL	A-22	PROPOSED DIAGRAMS - UNIT SIZE - SECOND LEVEL	A-36	RENDERING
A-6	VARIANCE DIAGRAM	A-23	PROPOSED DIAGRAMS - UNIT SIZE - ROOF LEVEL	A-37	RENDERING
A-7	SITE LOCATION	A-24	PROPOSED DIAGRAMS - LOT COVERAGE	A-37.1	RENDERING
A-8	CONTEXT LOCATION PLAN	A-25	PROPOSED DIAGRAMS - OPEN SPACE	A-37.2	RENDERING
A-9	SITE LOCATION - EAST/WEST	A-26	PROPOSED SITE PLAN	A-37.3	RENDERING
A-10	SITE LOCATION - NORTH/SOUTH	A-27	GROUND FLOOR PLAN	A-37.4	RENDERING
A-11	SITE PHOTOS - EXISTING LANDSCAPE	A-28	SECOND FLOOR PLAN		
A-12	SITE PHOTOS - EXISTING LANDSCAPE	A-29	ROOF FLOOR PLAN	TM-1	TREE MITIGATION PLAN
A-13	SITE PHOTOS - EXISTING STRUCTURE	A-30	MATERIALS AND TEXTURES	LP-1-R	LANDSCAPE PLAN - RENDERED
A-14	SITE PHOTOS - EXISTING STRUCTURE DETAILS	A-31	SOUTH ELEVATION	LP-1	LANDSCAPE PLAN
A-15	EXISTING ELEVATION - SOUTH	A-32	EAST ELEVATION	LP-2	PLANT LIST AND DETAILS
A-16	EXISTING ELEVATION - WEST	A-33	NORTH ELEVATION	L-1	HARDSCAPE PLAN
A-17	EXISTING CONDITIONS SITE PLAN	A-34	WEST ELEVATION	LL-1	LIGHTING
A-18	EXISTING CONDITIONS ELEVATIONS	A-35	SECTION - LONGITUDINAL	LL-2	LIGHTING FIXTURE SCHEDULE
				SK-1	TOPOGRAPHIC CROSS SECTIONS
				SK-2	TOPOGRAPHIC CROSS SECTIONS




SINGLE FAMILY RESIDENTIAL - ZONING DATA SHEET


ITEM #	Zoning Information				
1	Address:		31 La Gorce Circle, Miami Beach, FL		
2	Folio number(s):		02-3210-003-0320		
3	Board and file numbers :		DRB20-0533		
4	Year built:		1936 Zoning District: RS-2 SINGLE-FAMILY RESIDENTIAL DISTRICT		
5	Based Flood Elevation:		Zone AE +8.00 NGVD		Grade value in NGVD: +4.97 NGVD
6	Adjusted grade (Flood+Grade/2):		+6.48 NGVD		Free board: Min. 1'-0" Provided 2'-0"
7	Lot Area:		25,897 SF		
8	Lot width:		114'-11"		Lot Depth: 202'-8"
9	Max Lot Coverage SF and %:		7,769 SF		Proposed Lot Coverage SF and %: 6,419 SF (24.7%)
10	Existing Lot Coverage SF and %:		4,574 SF (18%)		Lot coverage deducted (garage-storage) SF: 453 SF
11	Front Yard Open Space SF and %:				Rear Yard Open Space SF and %:
12	Max Unit Size SF and %:		12,948 SF (50%)		Proposed Unit Size SF and %: 9,894 SF (38%)
13	Existing First Floor Unit Size:		N/A		Proposed First Floor Unit Size: 5,474 SF
14	Existing Second Floor Unit Size		N/A		Proposed Second Floor volumetric Unit Size SF and % (Note: to exceed 70% of the first floor of the main home require DRB Approval)
15					Proposed Second Floor Unit Size SF and % :
16					Proposed Roof Deck Area SF and % (Note: Maximum is 25% of the enclosed floor area immediately below): 4,192 SF (76%)
					228 SF (5% OF LEVEL BELOW)
		Required	Existing	Proposed	Deficiencies
17	Height:	28'-0" Flat / 31'-0" Sloped		26'-0"	
18	Setbacks:				
19	Front - One Story Structure:				
	East - Brevity Lane	20'-0"		NA	
	West - La Gorce Circle (Accessory Structure)	20'-0"		20'-0"	
20	Front - Two Story Structure:				
	East - Brevity Lane	30'-0"		22'-8"	Variance request for one-story portion of structure.
	West - La Gorce Circle	30'-0"		NA	
21	Side - Facing Street				
	South - La Gorce Circle	15'-0" (10% or 15'-whichever is greater)		22'-3"	
22	Side - Interior				
	North	11'-6" (10% or 10'-whichever is greater)		26'-8"	
	North (Accessory Structure)	11'-6" (10% or 10'-whichever is greater)		12'-8"	
25	Sum of Side yards:				
	North and South Sides	28'-9" (25% of lot width)		48'-11"	
26	Located within a Local Historic District?		no		
27	Designated as an individual Historic Single Family Residence Site?		no		
28	Determined to be Architecturally Significant?		yes		
Notes:					
If not applicable write N/A					
All other data information should be presented like the above format					

31 LA GORCE RESIDENCE
31 LA GORCE CIRCLE, MIAMI BEACH, FLORIDA



 No copies, transmissions, reproductions or electronic manipulation of any portion of these drawings in whole or in part are to be made without the express written permission of Touzet Studio Design & Architecture. All designs indicated in these drawings are property of Touzet Studio Design & Architecture. All copyrights reserved (c) 2020.



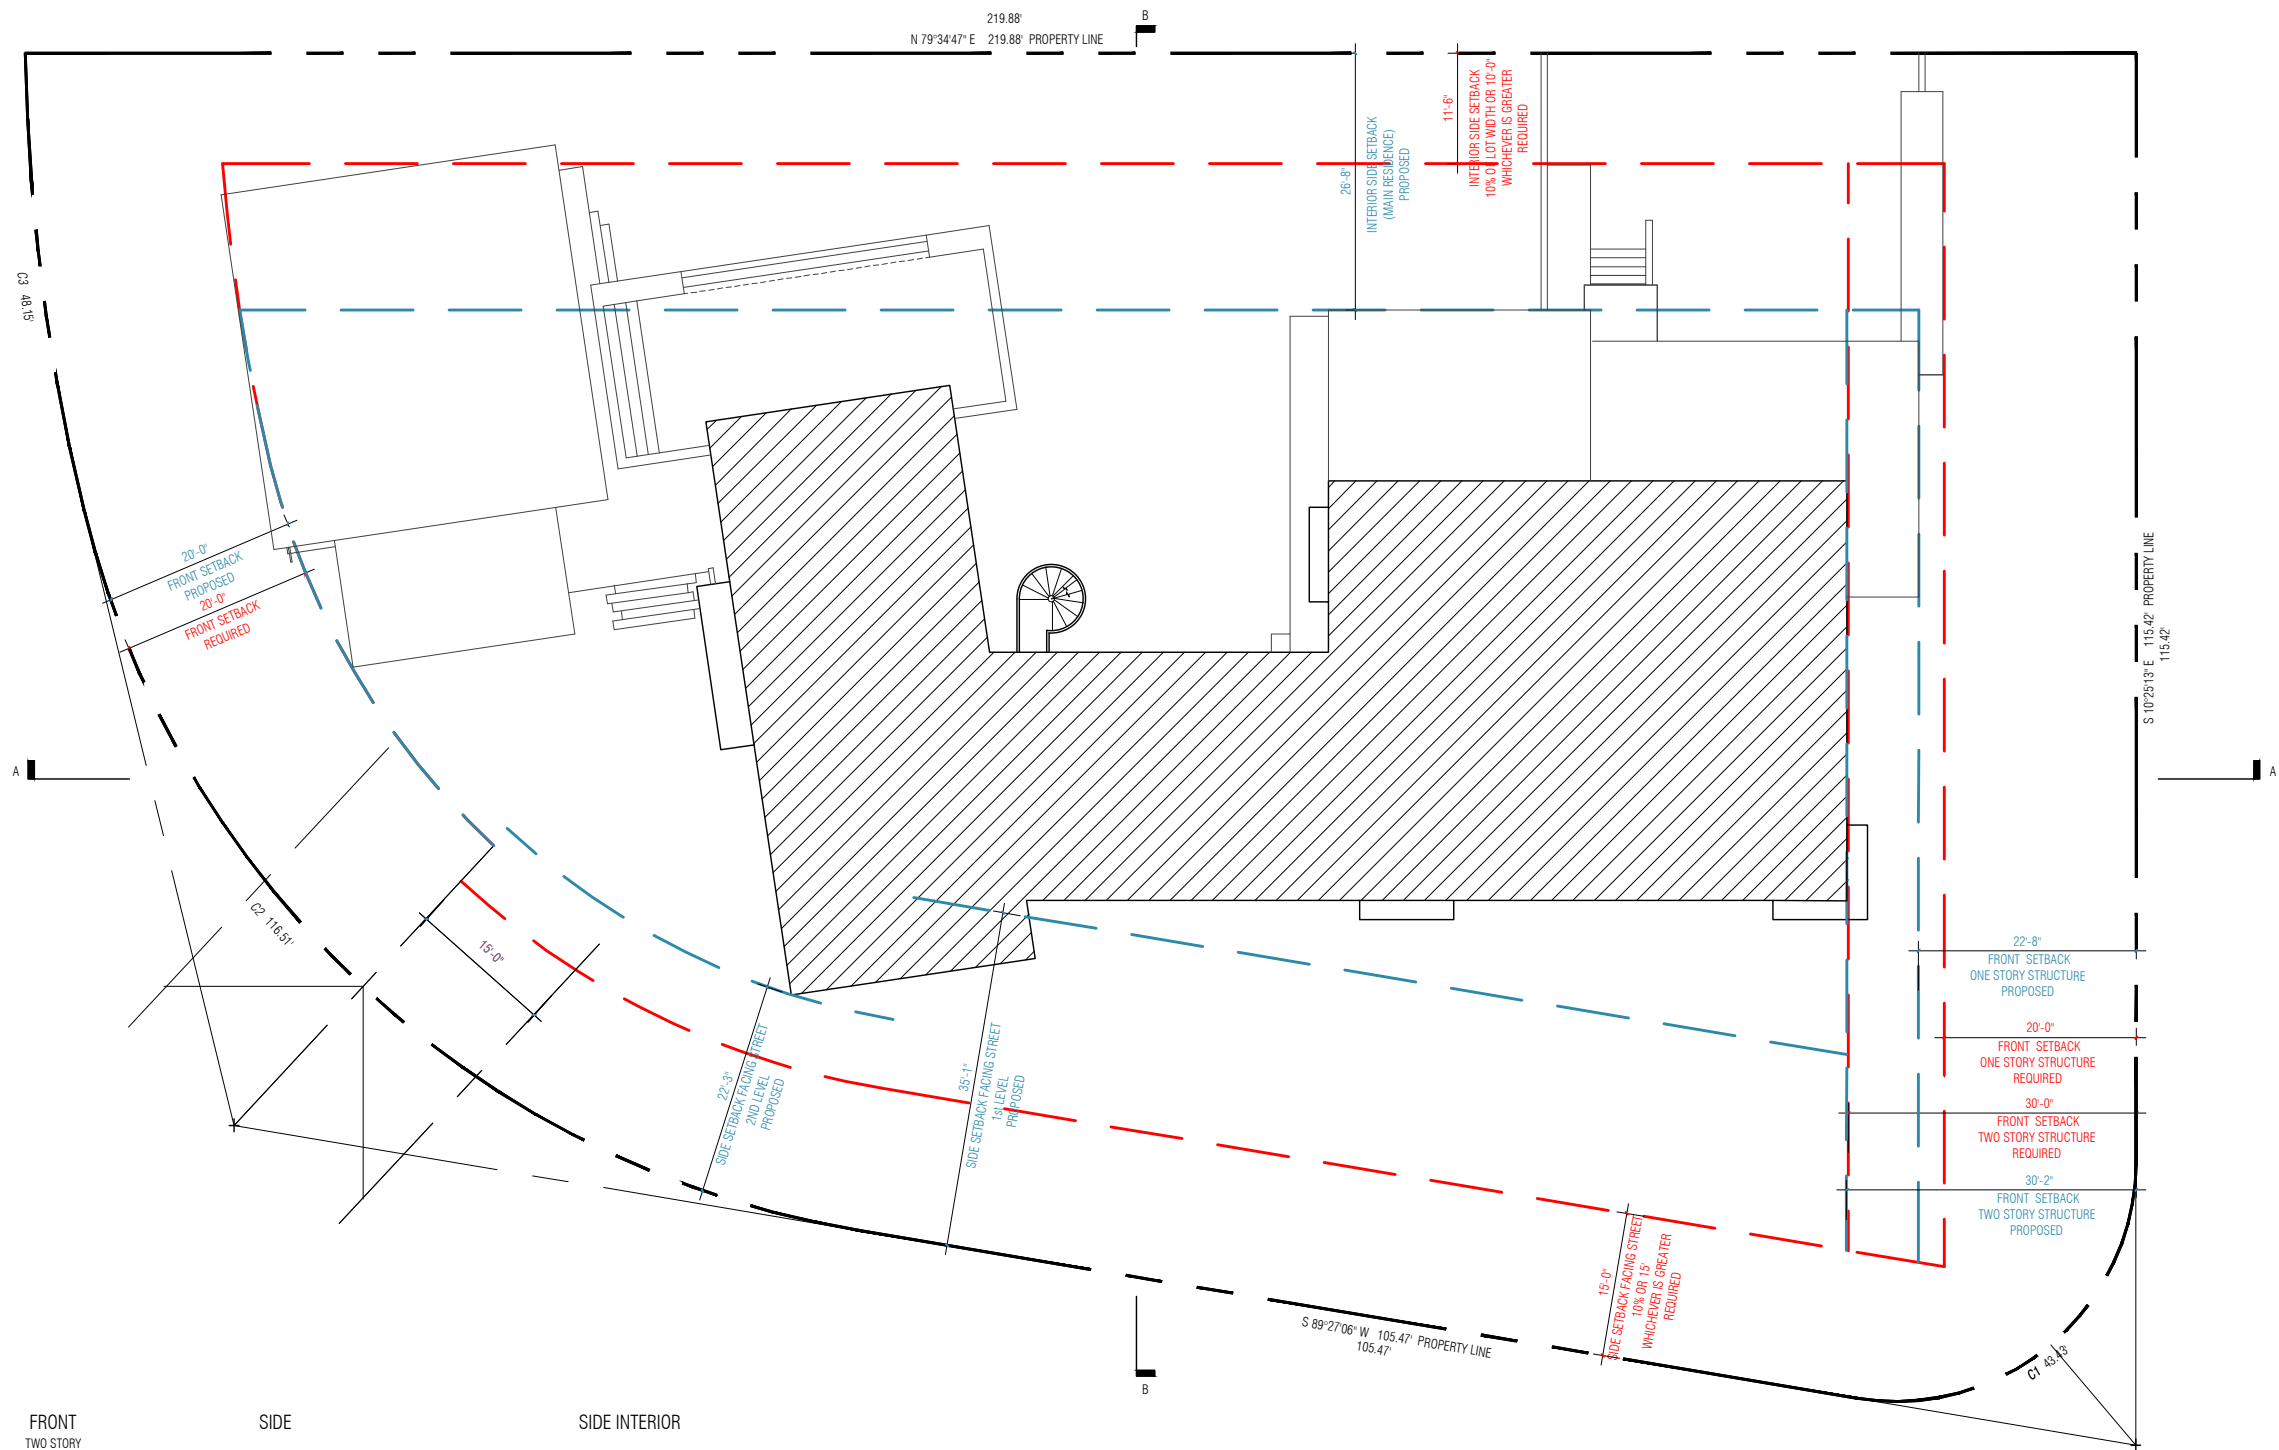

SETBACKS

	REQUIRED	FRONT	FRONT ONE STORY	FRONT TWO STORY	SIDE		SIDE INTERIOR	
		20'-0"	20'-0"	30'-0"	15'-0" *10% OF LOT WIDTH OR 15'-0" WHICHEVER IS GREATER		11'-6" *10% OF LOT WIDTH OR 10'-0" WHICHEVER IS GREATER	
	PROPOSED	FRONT	FRONT ONE STORY	FRONT TWO STORY	SIDE FIRST LEVEL	SIDE SECOND LEVEL	SIDE INTERIOR ACCESSORY BUILDING	SIDE INTERIOR MAIN RESIDENCE
		22'-8"	22'-8"	30'-2"	35'-1"	22'-3"	12'-8"	26'-8"

31 LA GORCE RESIDENCE
31 LA GORCE CIRCLE, MIAMI BEACH, FLORIDA

TOUZET
STUDIO
DESIGN & ARCHITECTURE

No copies, transmissions, reproductions or electronic manipulation of any portion of these drawings in whole or in part are to be made without the express written permission of Touzet Studio Design & Architecture. All designs indicated in these drawings are property of Touzet Studio Design & Architecture. All copyrights reserved (c) 2020.




SETBACK DIAGRAM - SECOND LEVEL

SCALE: 1:20




A-5

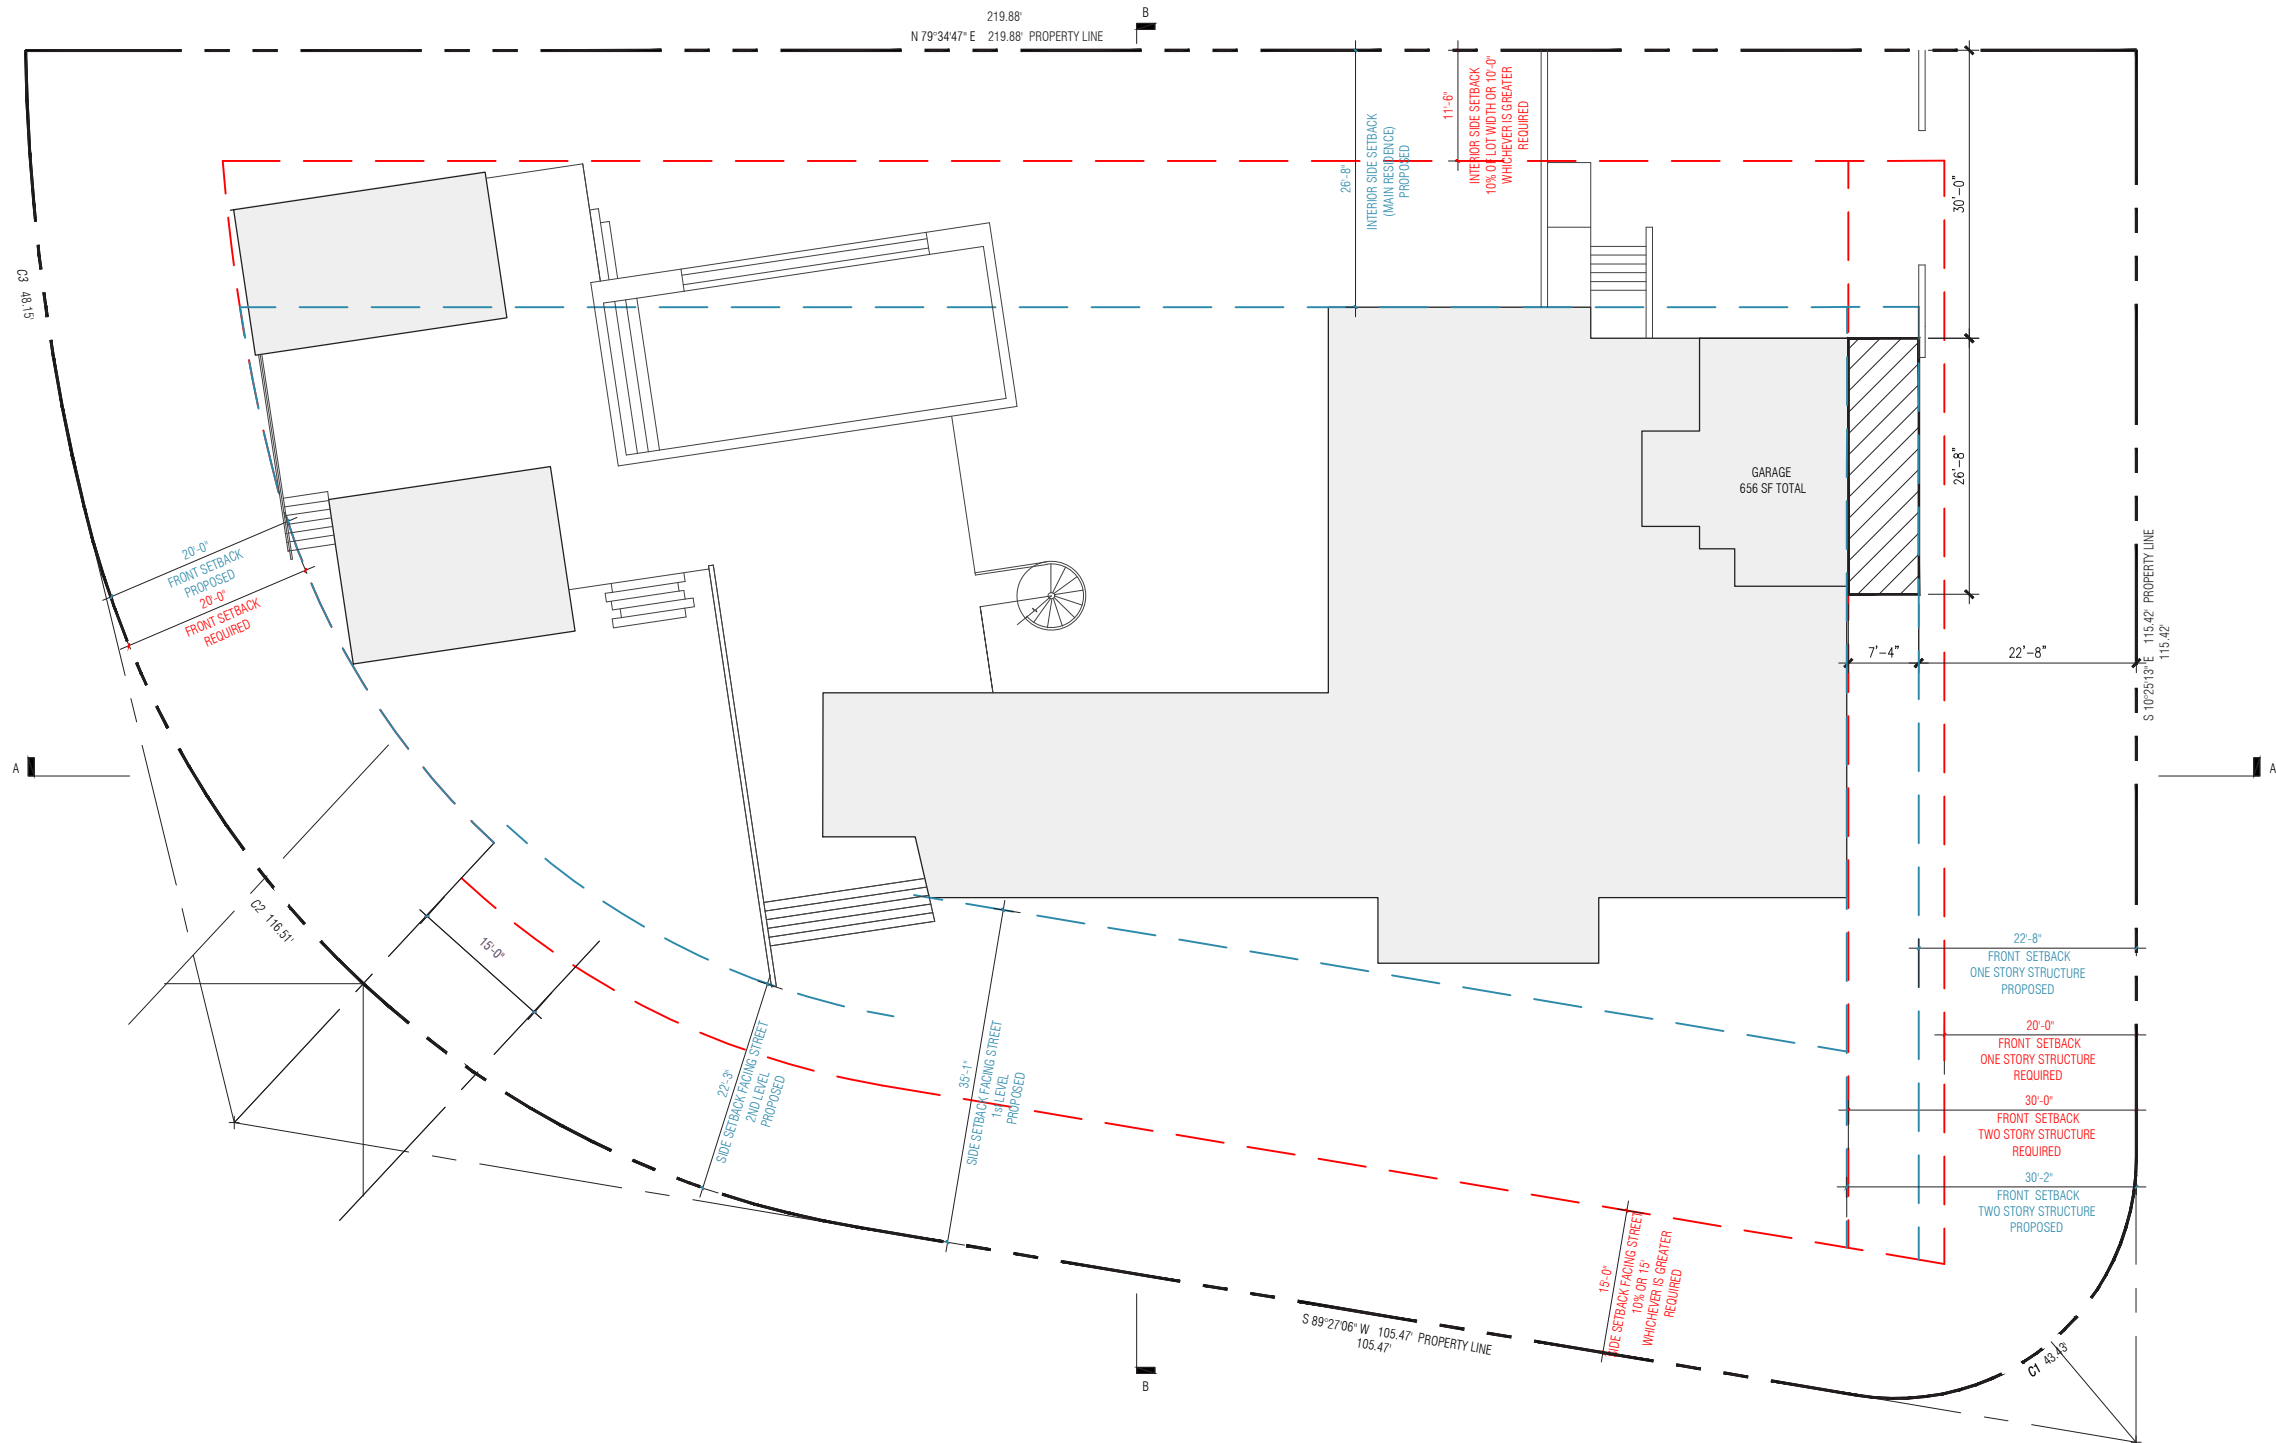

31 LA GORCE RESIDENCE 31 LA GORCE CIRCLE, MIAMI BEACH, FLORIDA

TOUZET
STUDIO
DESIGN &
ARCHITECTURE


No copies, transmissions, reproductions or electronic manipulation of any portion of these drawings in whole or in part are to be made without the express written permission of Touzet Studio Design & Architecture. All designs indicated in these drawings are property of Touzet Studio Design & Architecture. All copyrights reserved (c) 2020.

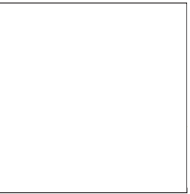

VARIANCE DIAGRAM SCALE: 1:20



A-6

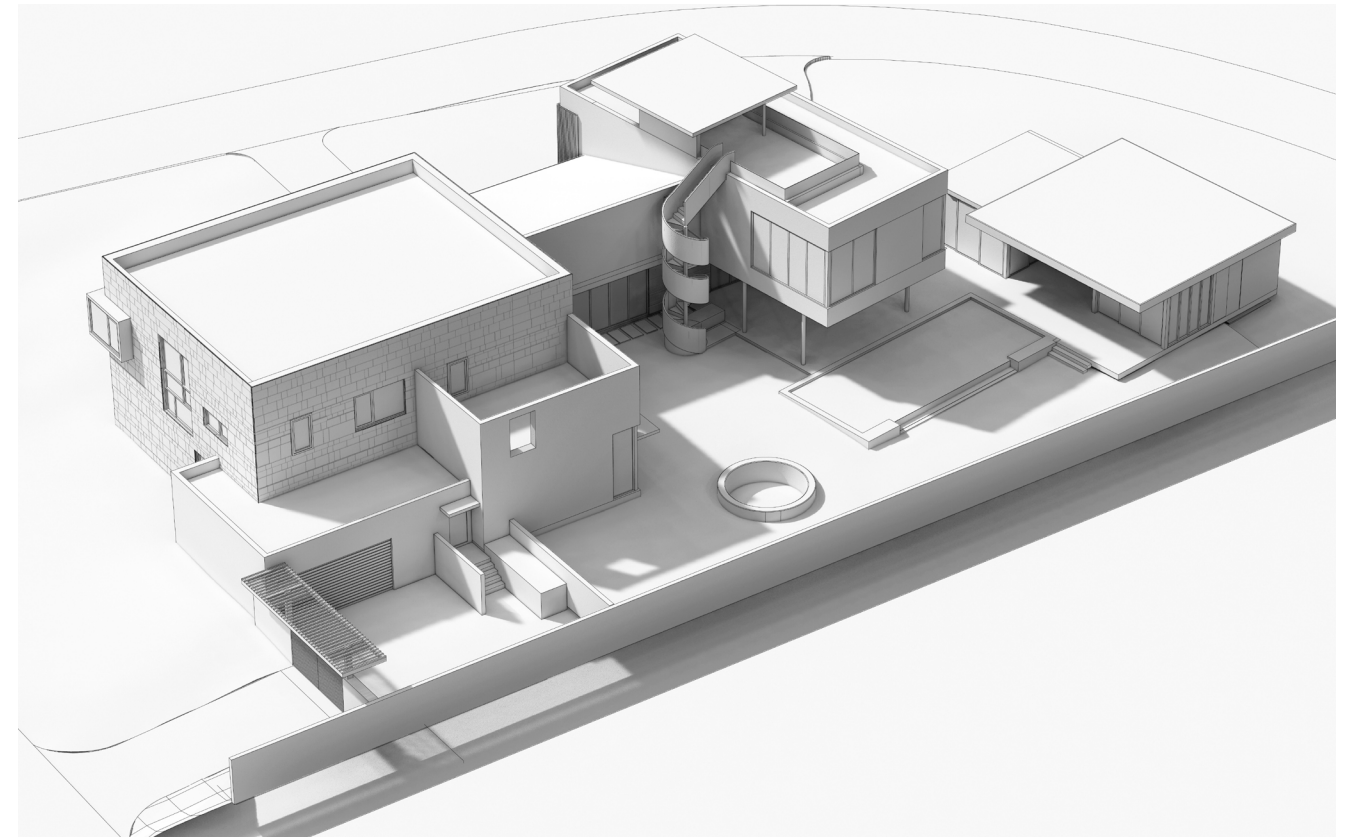


31 LA GORCE RESIDENCE

31 LA GORCE CIRCLE, MIAMI BEACH, FLORIDA




No copies, transmissions, reproductions or electronic manipulation of any portion of these drawings in whole or in part are to be made without the express written permission of Touzet Studio Design & Architecture. All designs indicated in these drawings are property of Touzet Studio Design & Architecture. All copyrights reserved (c) 2020.

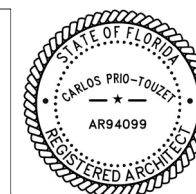

PROPOSED AXONOMETRICS

A-20.1

MIAMI BEACH . DRB FINAL SUBMITTAL . 6 APRIL 2020

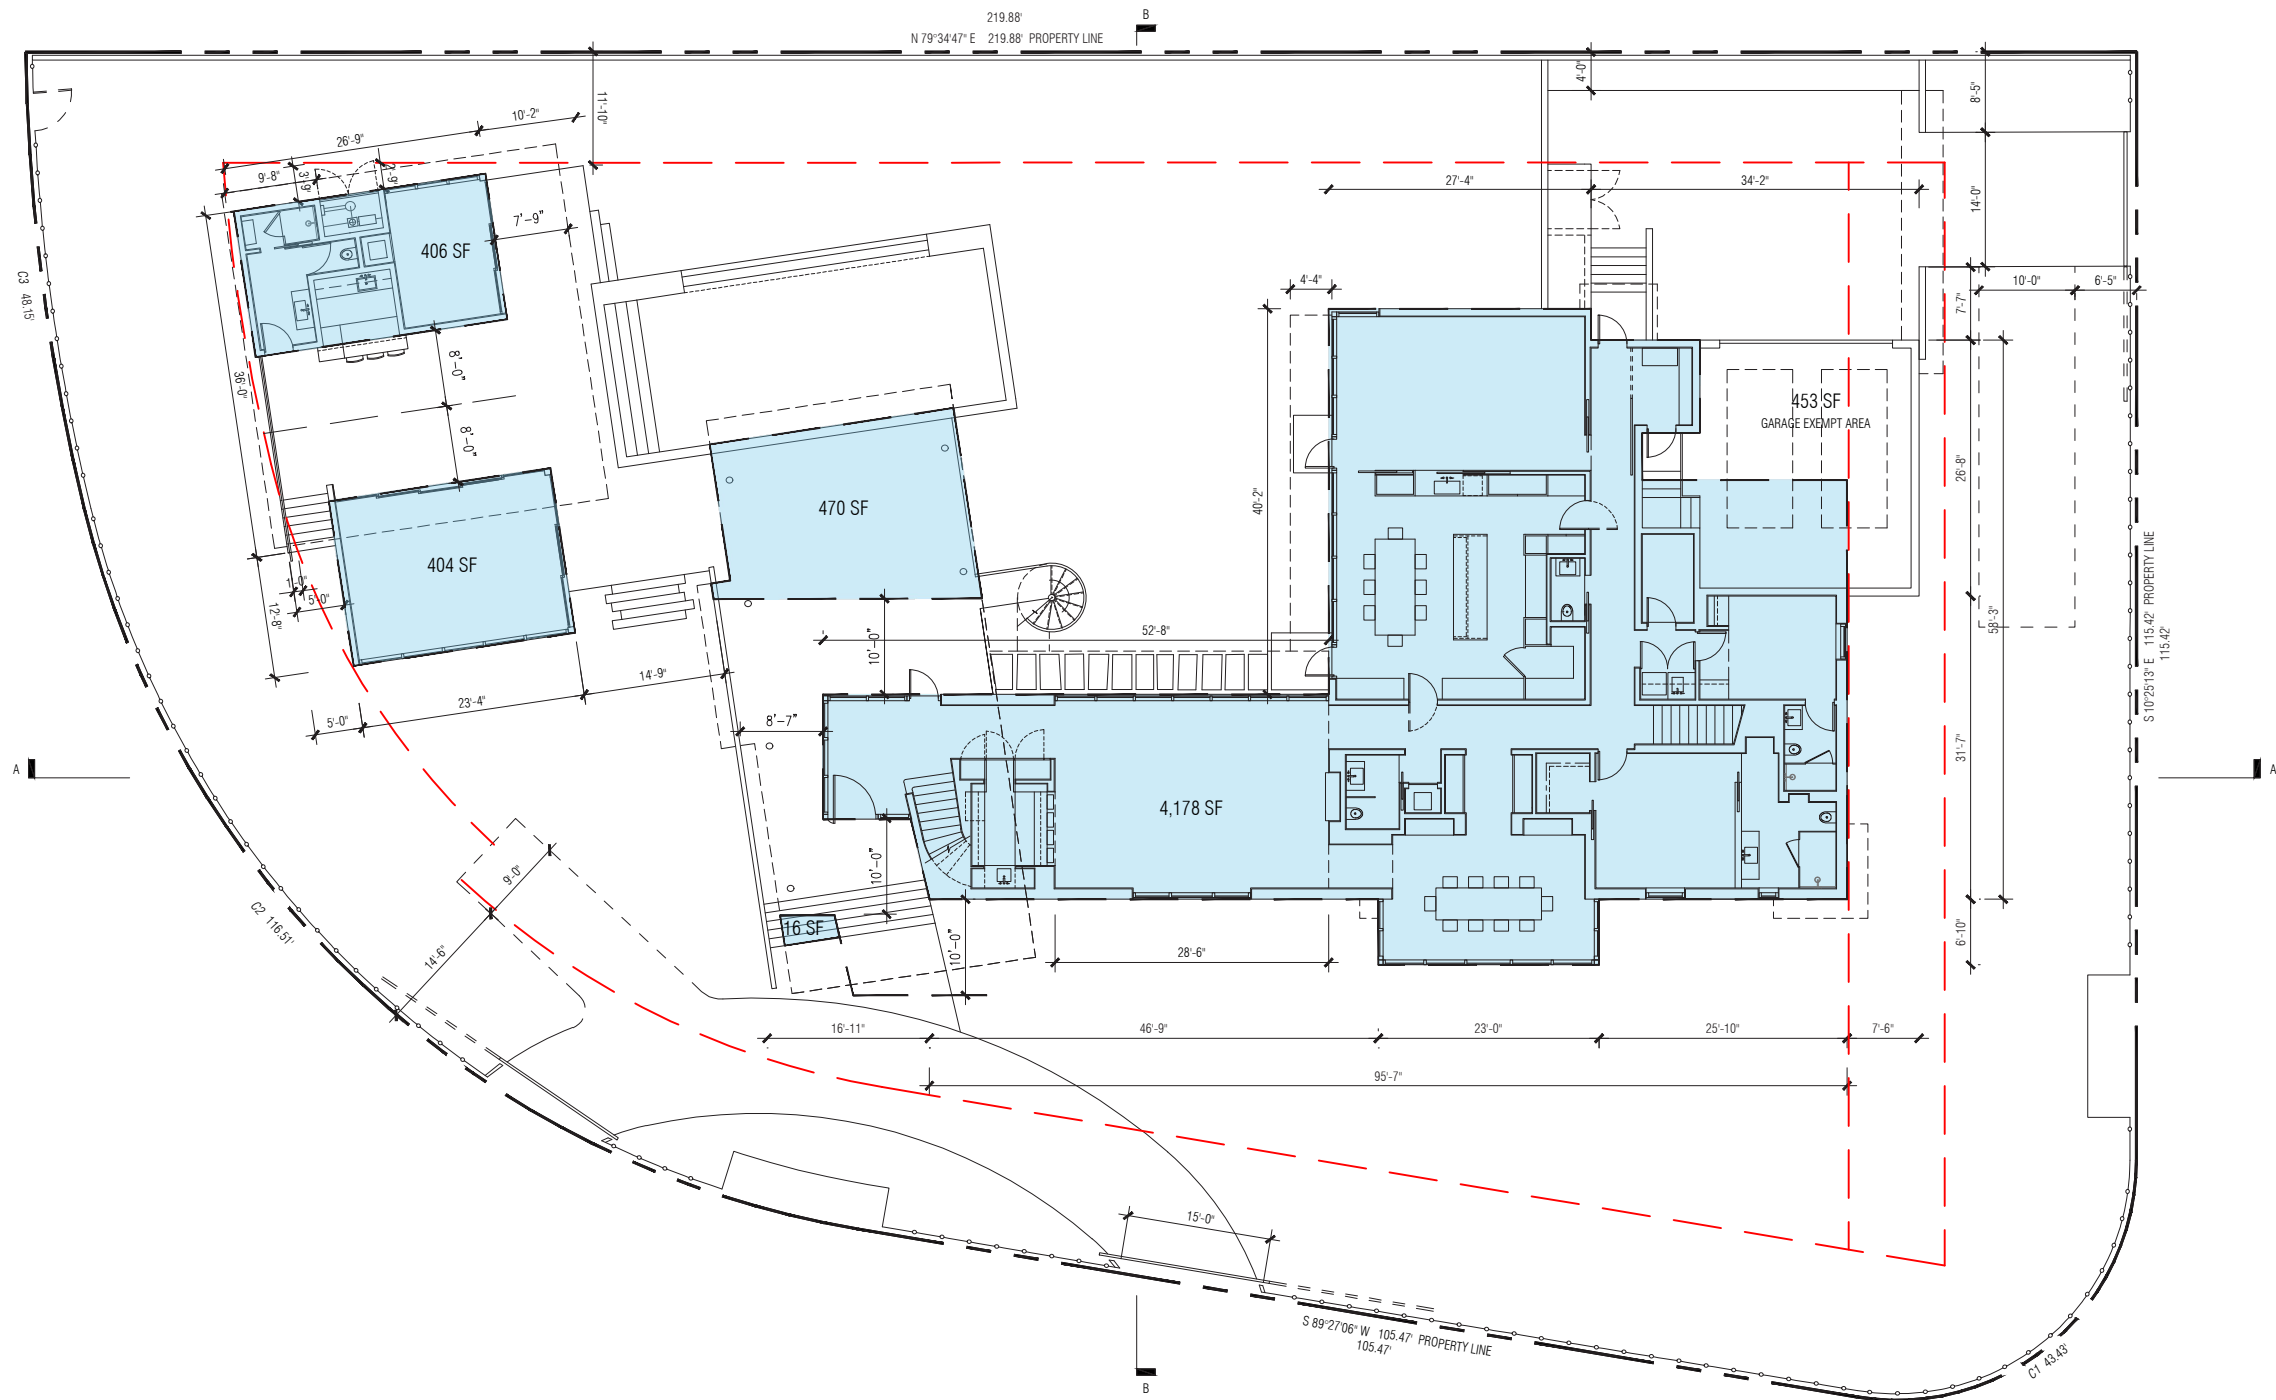

UNIT SIZE


GROUND LEVEL	GROUND LEVEL ACCESSORY BUILDING	GROUND LEVEL GARAGE EXEMPT AREA	SECOND LEVEL	ROOF DECK	TOTAL UNIT SIZE
5,474 SF (INCL. ACCESSORY BUILDING)	810 SF 3% OF LOT AREA	453 SF	4,192 SF 76% OF GROUND LEVEL	228 SF 5% OF SECOND LEVEL	9,894 SF (38%)

31 LA GORCE RESIDENCE

31 LA GORCE CIRCLE, MIAMI BEACH, FLORIDA



No copies, transmissions, reproductions or electronic manipulation of any portion of these drawings in whole or in part are to be made without the express written permission of Touzet Studio Design & Architecture. All designs indicated in these drawings are property of Touzet Studio Design & Architecture. All copyrights reserved (c) 2020.

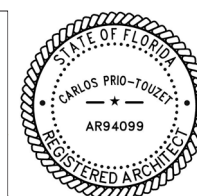


PROPOSED DIAGRAMS - UNIT SIZE - GROUND LEVEL

SCALE: 1:20



A-21

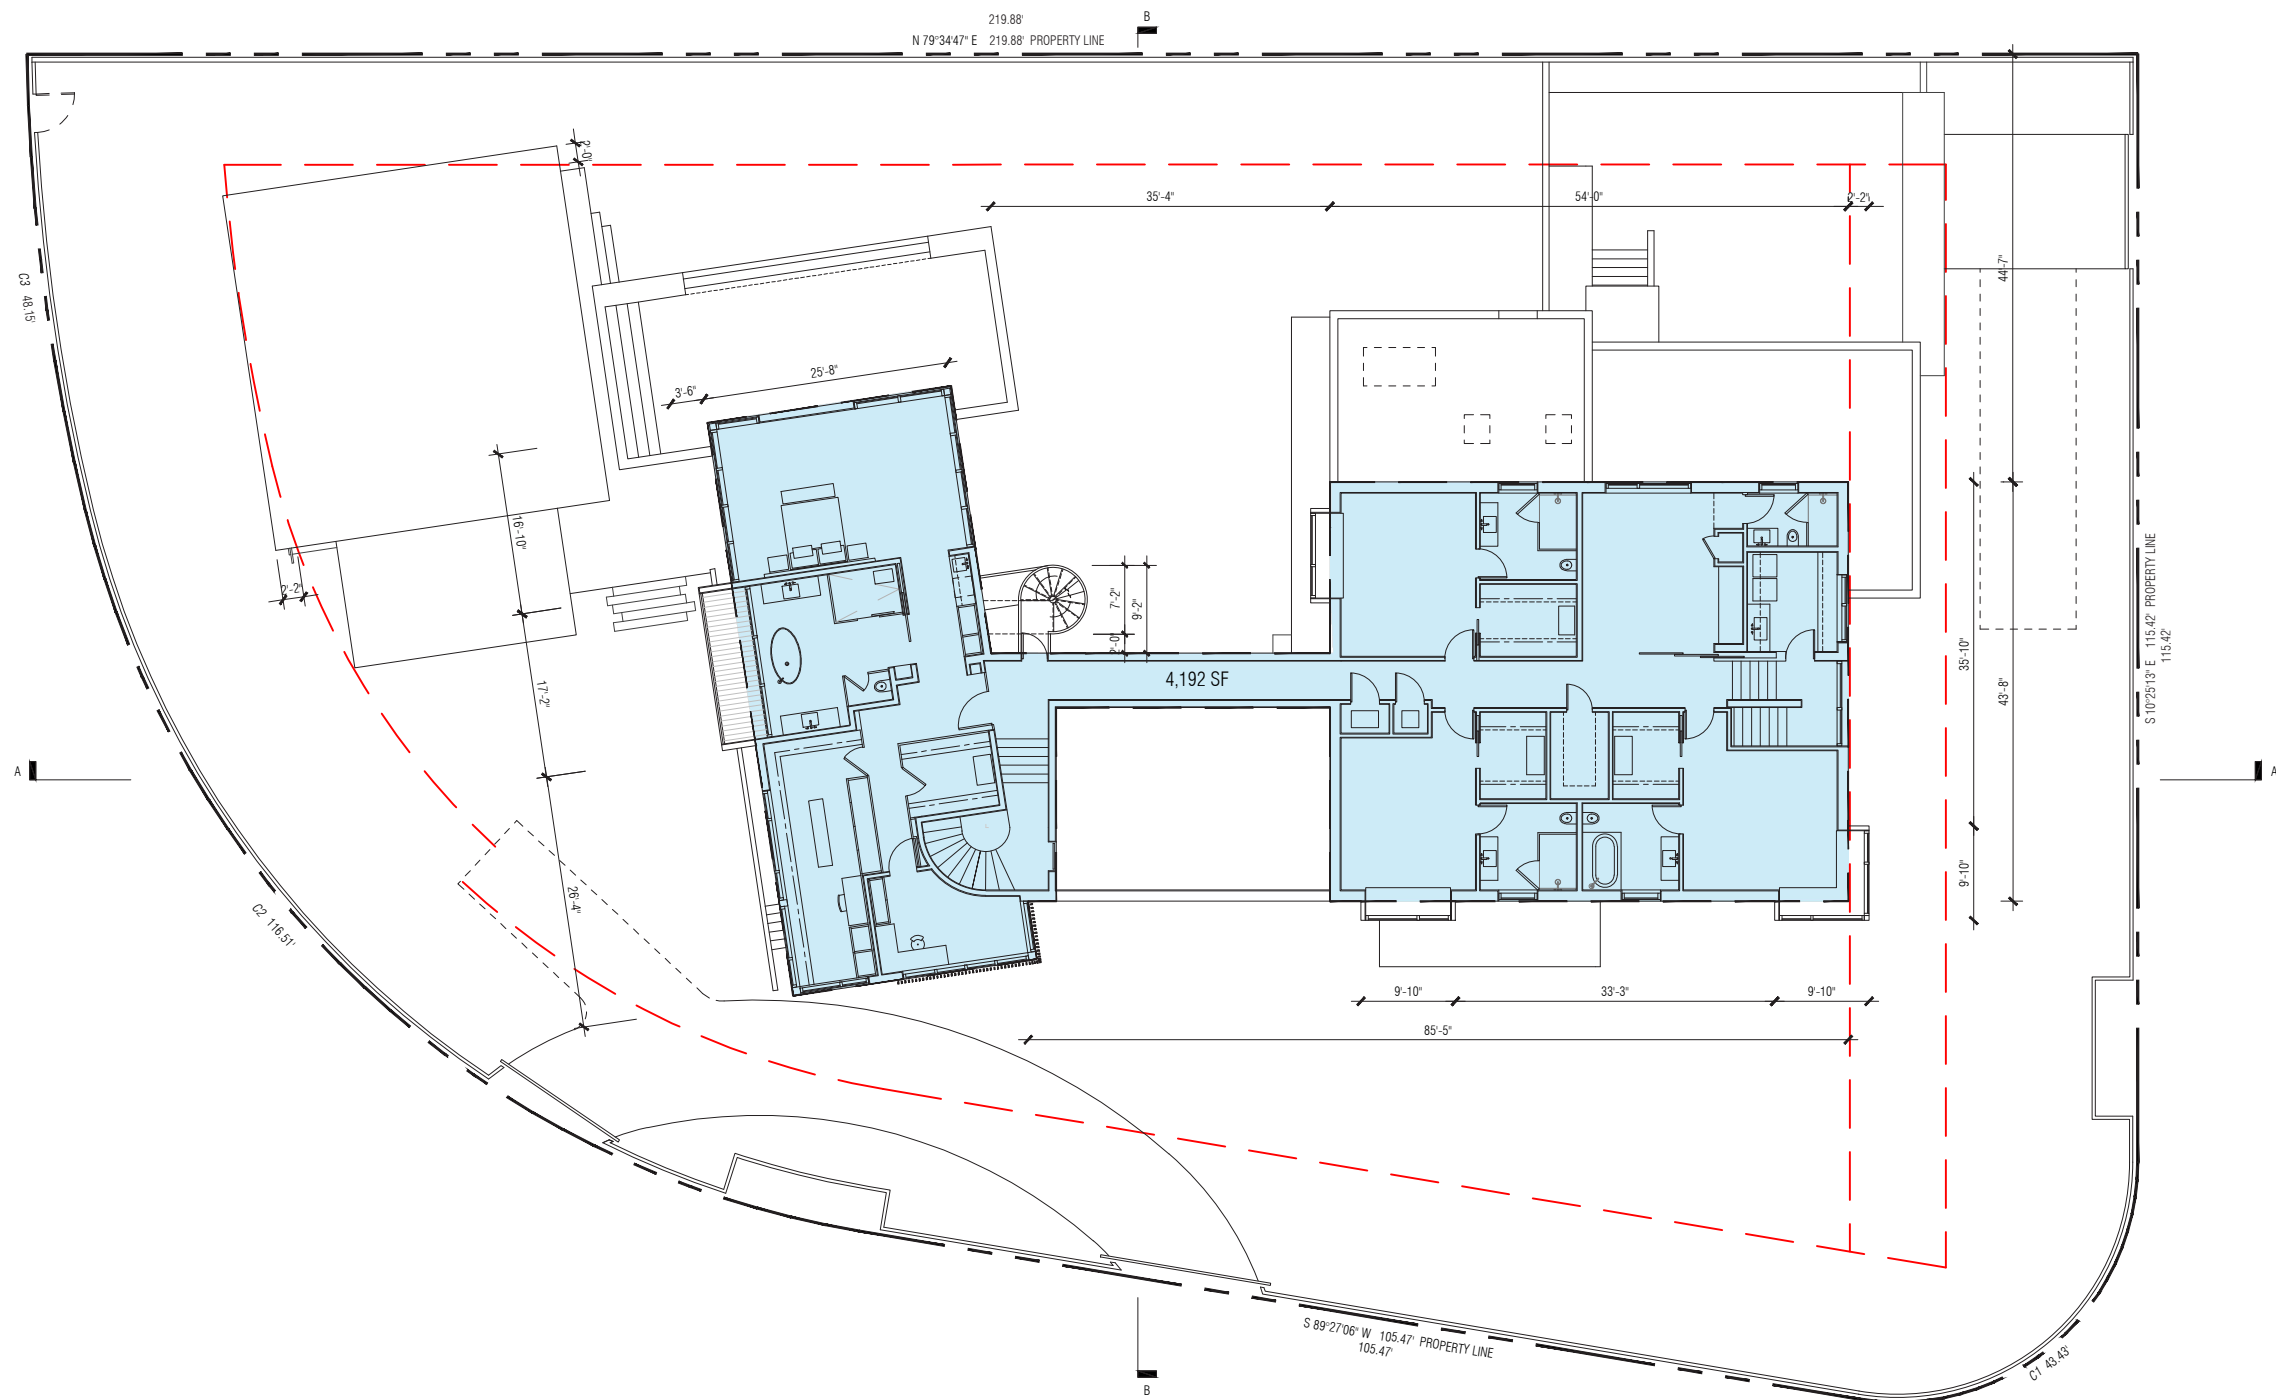

UNIT SIZE


	GROUND LEVEL	GROUND LEVEL ACCESSORY BUILDING	GROUND LEVEL GARAGE EXEMPT AREA	SECOND LEVEL	ROOF DECK	TOTAL UNIT SIZE
	5,474 SF (INCL. ACCESSORY BUILDING)	810 SF 3% OF LOT AREA	453 SF	4,192 SF 76% OF GROUND LEVEL	228 SF 5% OF SECOND LEVEL	9,894 SF (38%)

31 LA GORCE RESIDENCE

31 LA GORCE CIRCLE, MIAMI BEACH, FLORIDA



No copies, transmissions, reproductions or electronic manipulation of any portion of these drawings in whole or in part are to be made without the express written permission of Touzet Studio Design & Architecture. All designs indicated in these drawings are property of Touzet Studio Design & Architecture. All copyrights reserved (c) 2020.

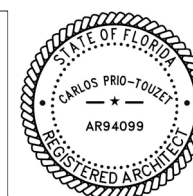


PROPOSED DIAGRAMS - UNIT SIZE - SECOND LEVEL

SCALE: 1:20



A-22

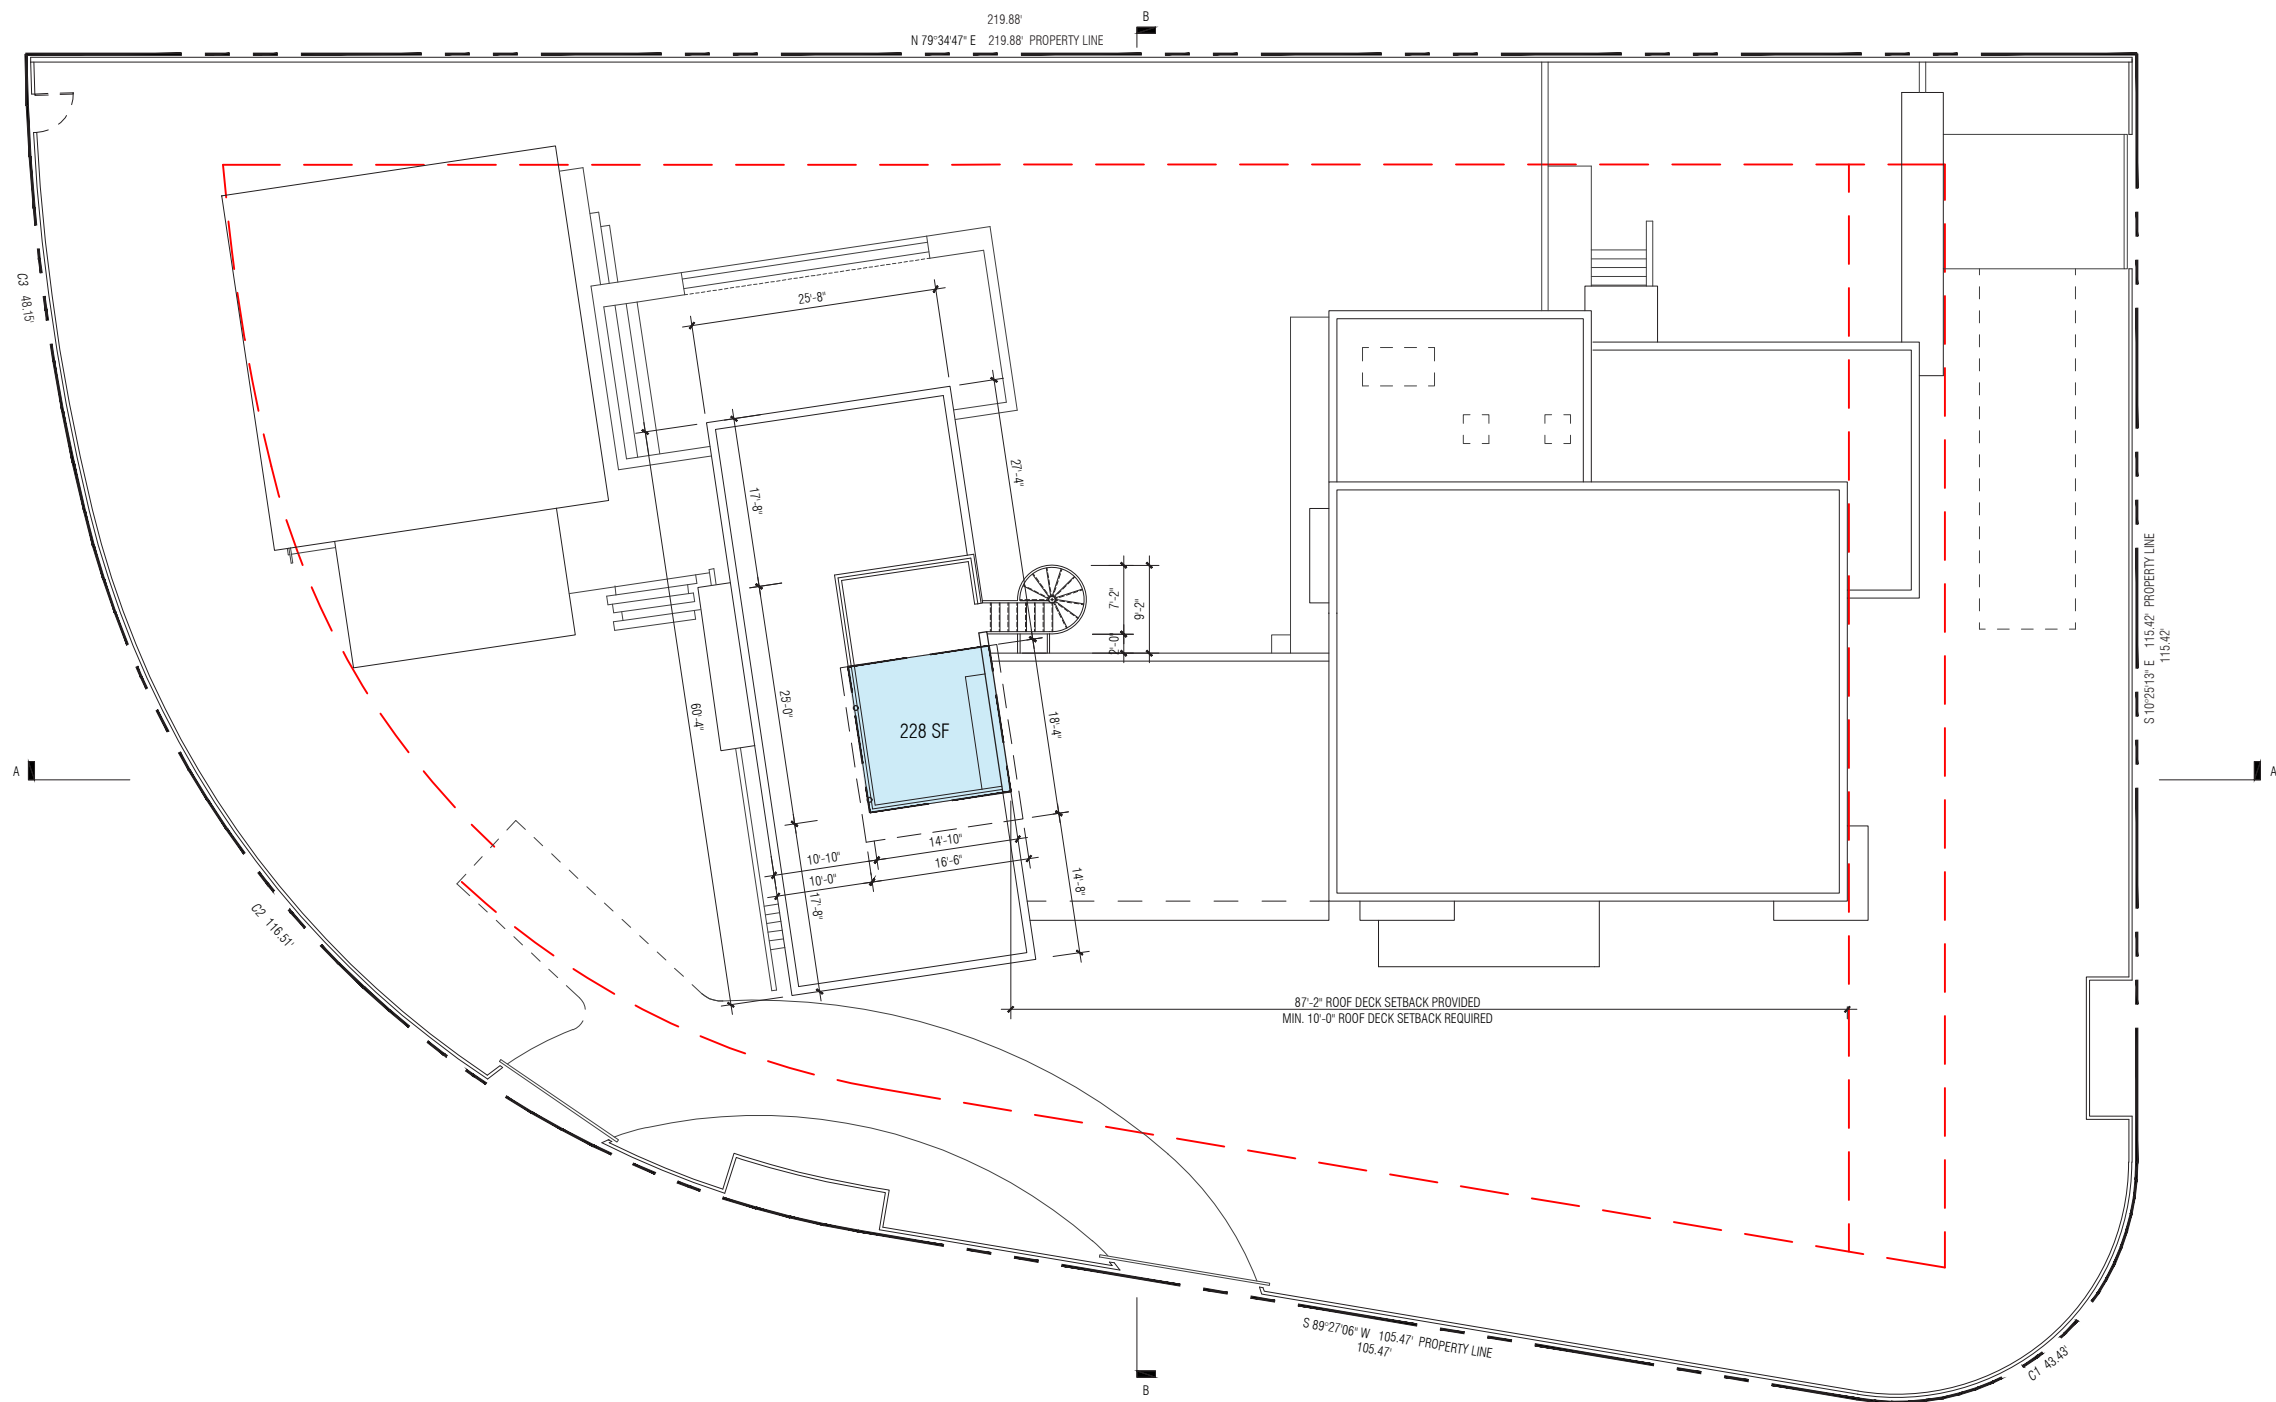

UNIT SIZE



GROUND LEVEL

GROUND LEVEL
ACCESSORY BUILDING

GROUND LEVEL
GARAGE EXEMPT AREA

SECOND LEVEL

ROOF DECK

TOTAL UNIT SIZE

5,474 SF
(INCL. ACCESSORY BUILDING)

810 SF
3% OF LOT AREA

453 SF

4,192 SF
76% OF GROUND LEVEL

228 SF
5% OF SECOND LEVEL

9,894 SF (38%)

31 LA GORCE RESIDENCE

31 LA GORCE CIRCLE, MIAMI BEACH, FLORIDA



No copies, transmissions, reproductions or electronic manipulation of any portion of these drawings in whole or in part are to be made without the express written permission of Touzet Studio Design & Architecture. All designs indicated in these drawings are property of Touzet Studio Design & Architecture. All copyrights reserved (c) 2020.




PROPOSED DIAGRAMS - UNIT SIZE - ROOF LEVEL

SCALE: 1:20



A-23

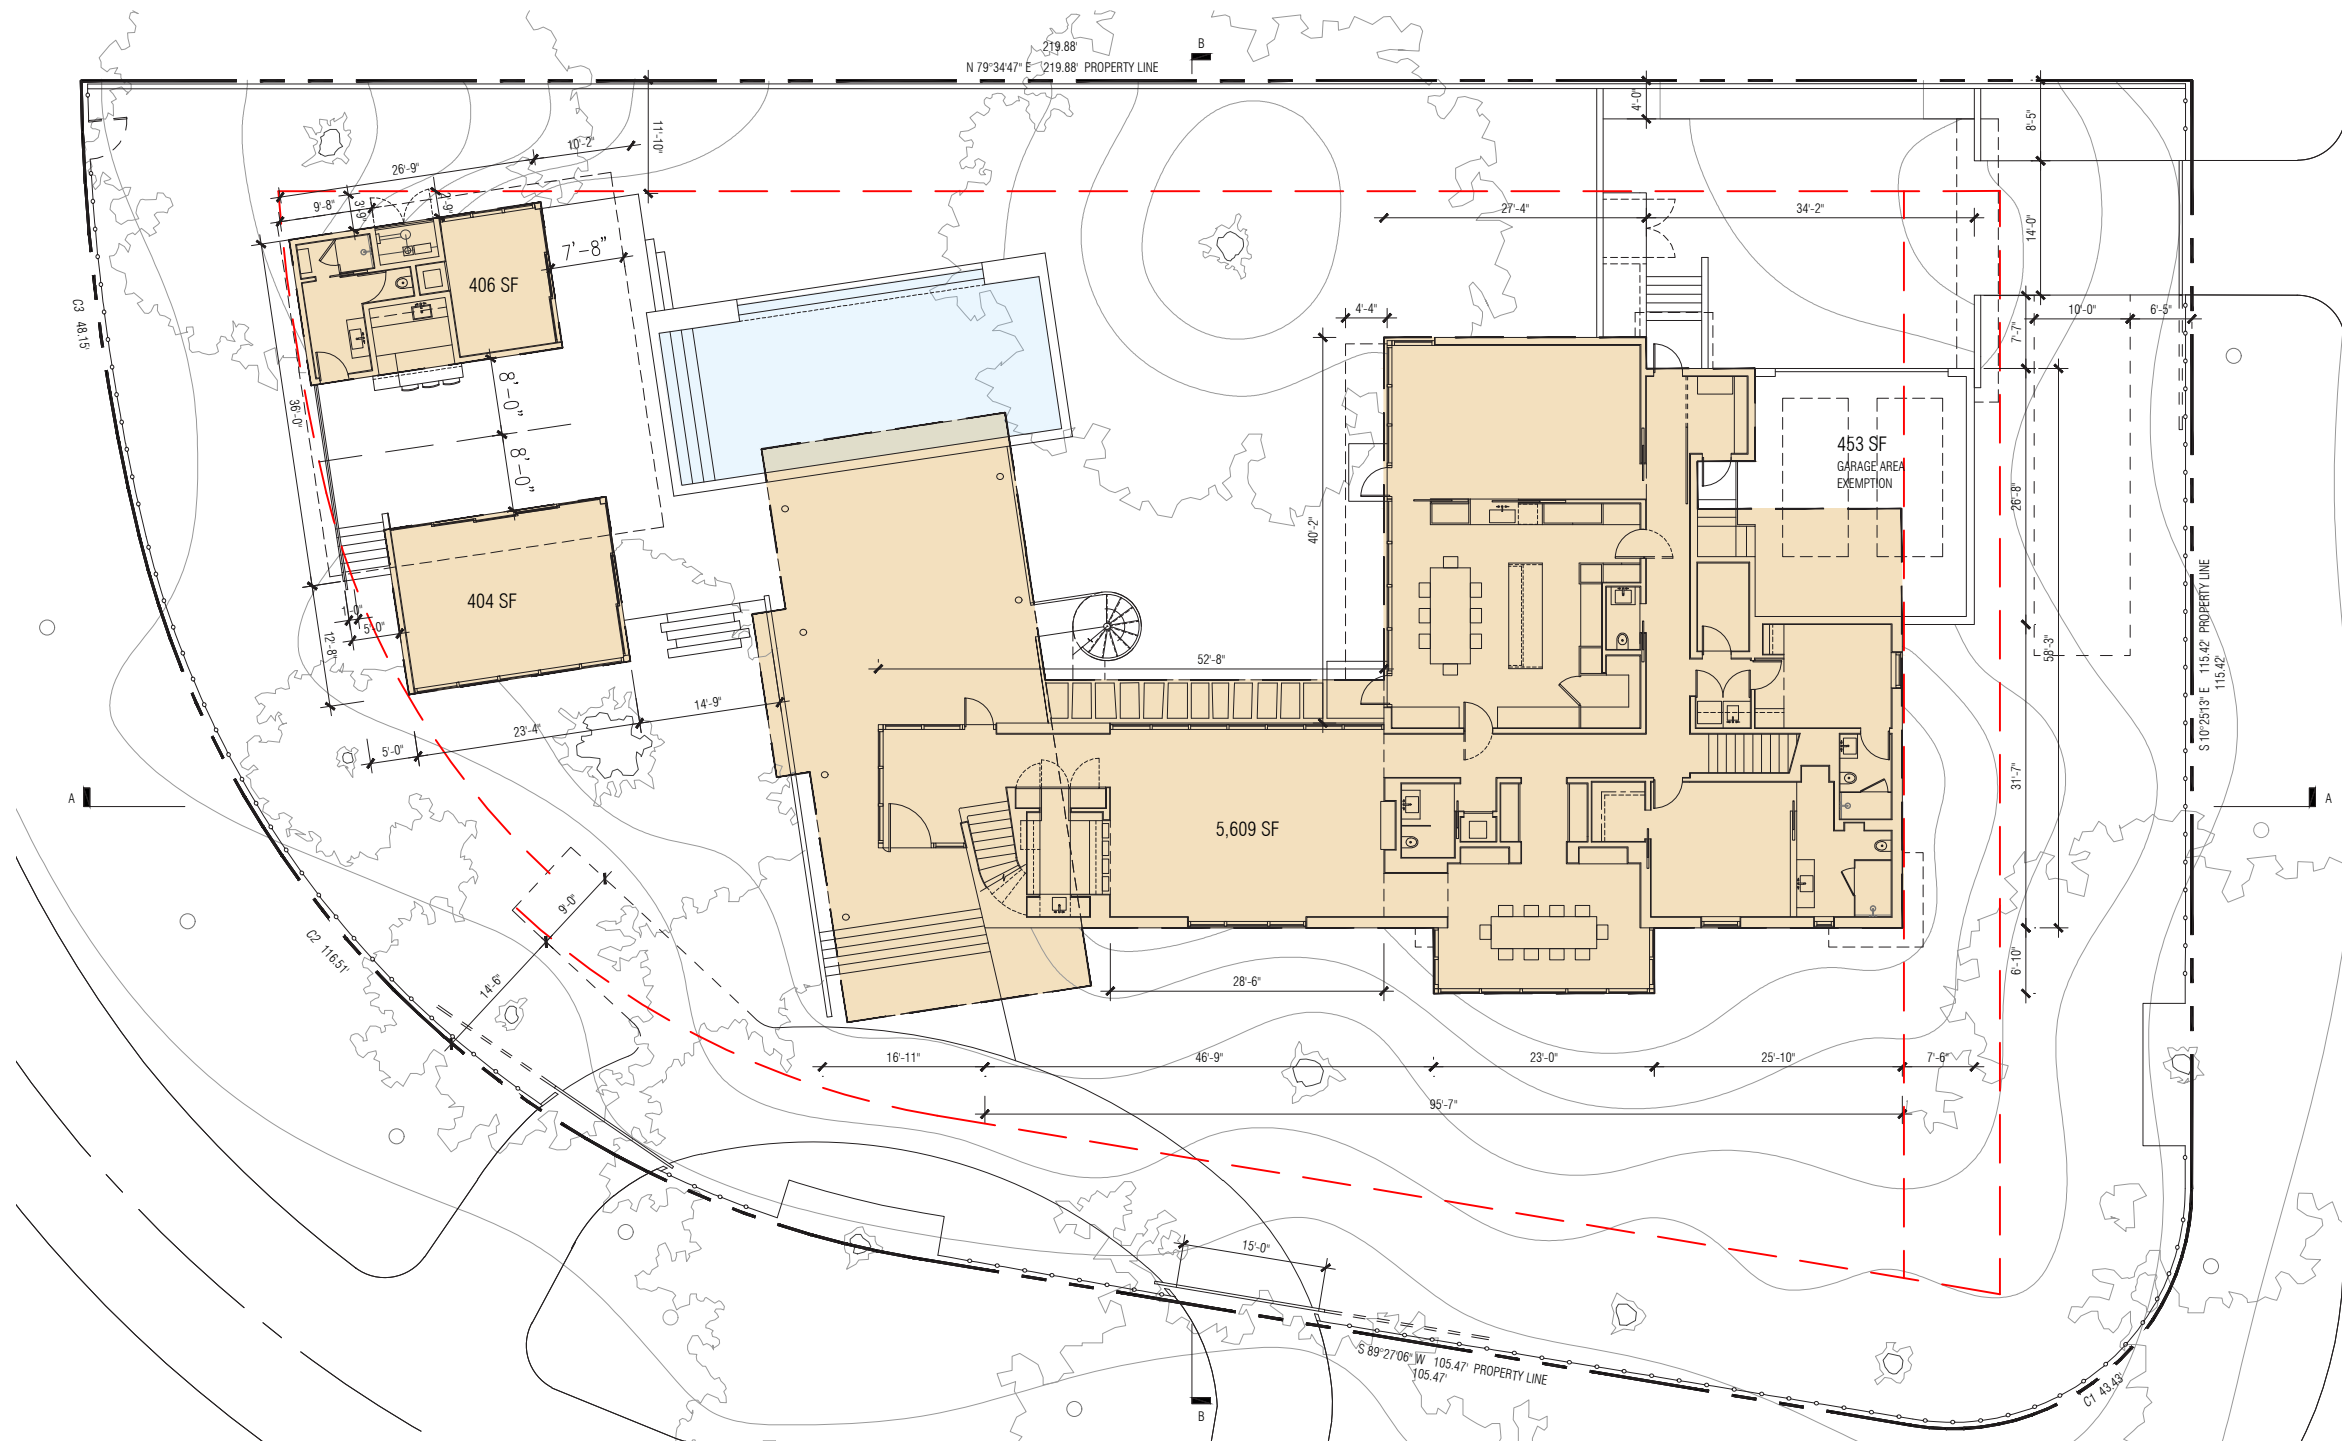


LOT COVERAGE			
 RS-2	LOT AREA	MAX LOT COVERAGE ALLOWED	LOT COVERAGE PROVIDED
	25,897 SF	7,769 SF - 30%	6,419 SF - 24.7% PROVIDED

31 LA GORCE RESIDENCE

31 LA GORCE CIRCLE, MIAMI BEACH, FLORIDA



No copies, transmissions, reproductions or electronic manipulation of any portion of these drawings in whole or in part are to be made without the express written permission of Touzet Studio Design & Architecture. All designs indicated in these drawings are property of Touzet Studio Design & Architecture. All copyrights reserved (c) 2020.

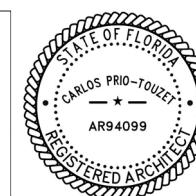


PROPOSED DIAGRAMS - LOT COVERAGE

SCALE: 1:20



A-24

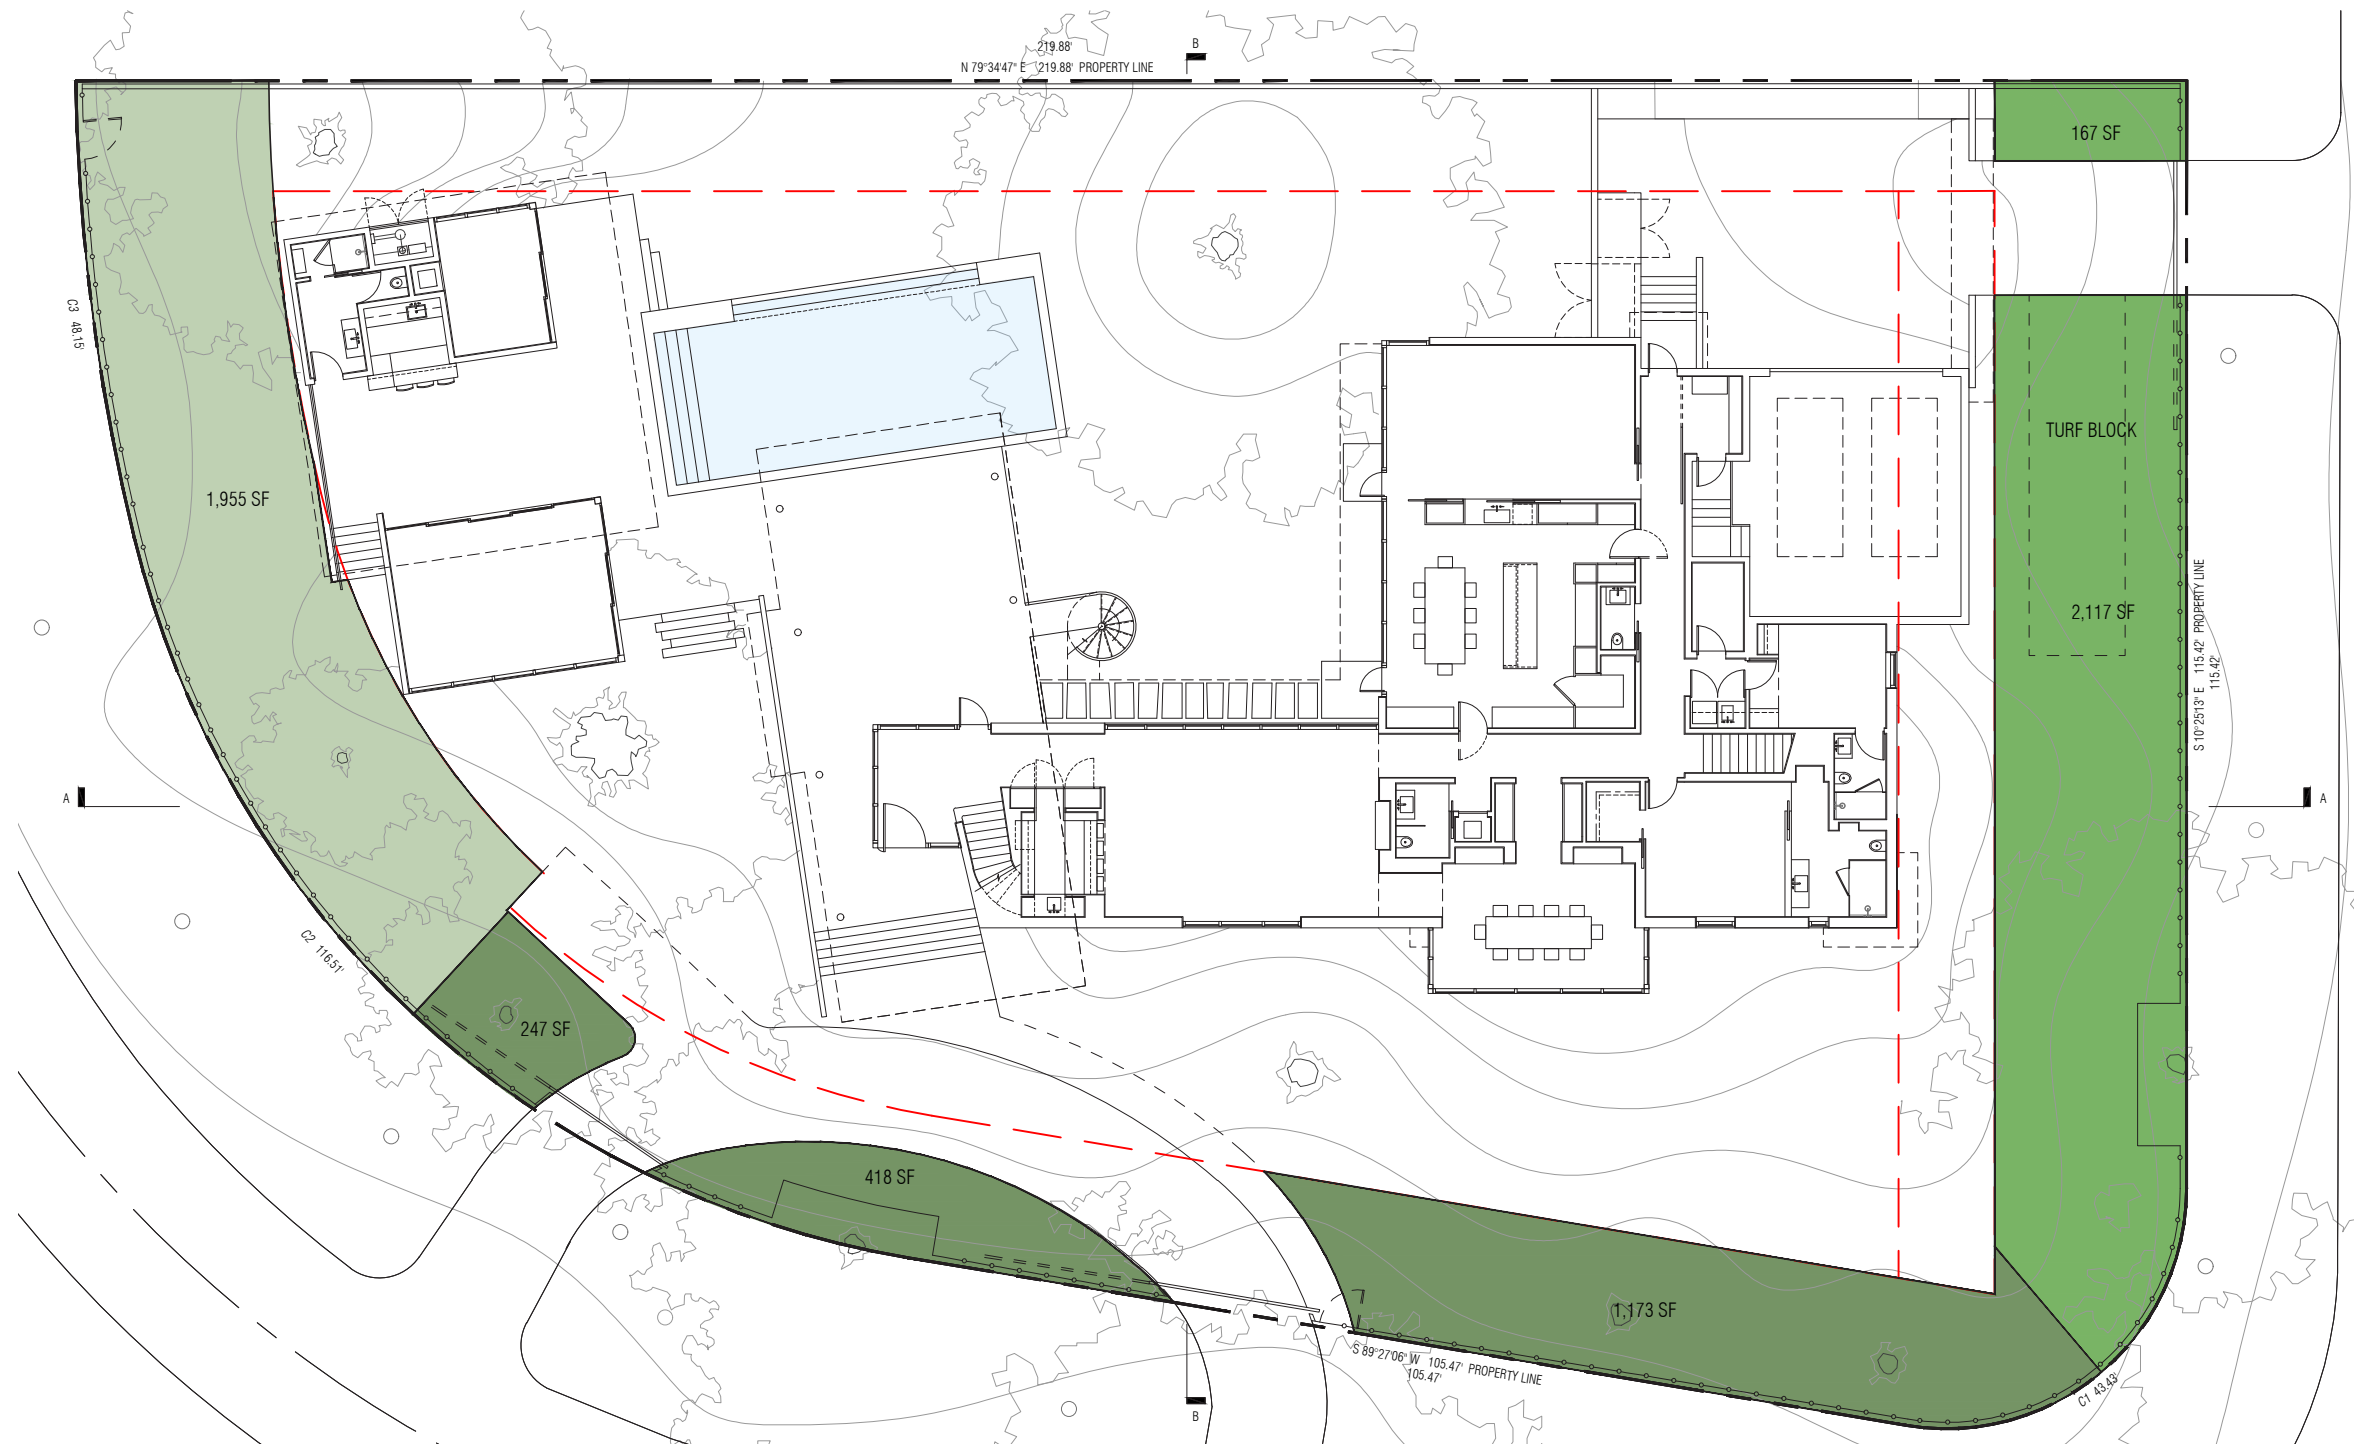

OPEN SPACE			
RS-2	YARD AREA	OPEN SPACE REQUIRED	OPEN SPACE PROVIDED
FRONT (WEST)	1,955 SF	1,369 SF - 70%	1,955 SF - 100% PROVIDED
FRONT (EAST)	2,564 SF	1,795 SF - 70%	2,284 SF - 89% PROVIDED
SIDE STREET	2,602 SF	1,821 SF - 70%	1,838 SF - 71% PROVIDED

31 LA GORCE RESIDENCE
31 LA GORCE CIRCLE, MIAMI BEACH, FLORIDA



No copies, transmissions, reproductions or electronic manipulation of any portion of these drawings in whole or in part are to be made without the express written permission of Touzet Studio Design & Architecture. All designs indicated in these drawings are property of Touzet Studio Design & Architecture. All copyrights reserved (c) 2020.




PROPOSED DIAGRAMS - OPEN SPACE
SCALE: 1:20




31 LA GORCE RESIDENCE
31 LA GORCE CIRCLE, MIAMI BEACH, FLORIDA



No copies, transmissions, reproductions or electronic manipulation of any portion of these drawings in whole or in part are to be made without the express written permission of Touzet Studio Design & Architecture. All designs indicated in these drawings are property of Touzet Studio Design & Architecture. All copyrights reserved (c) 2020.

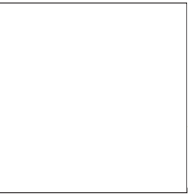

PROPOSED SITE PLAN
SCALE: 1:20

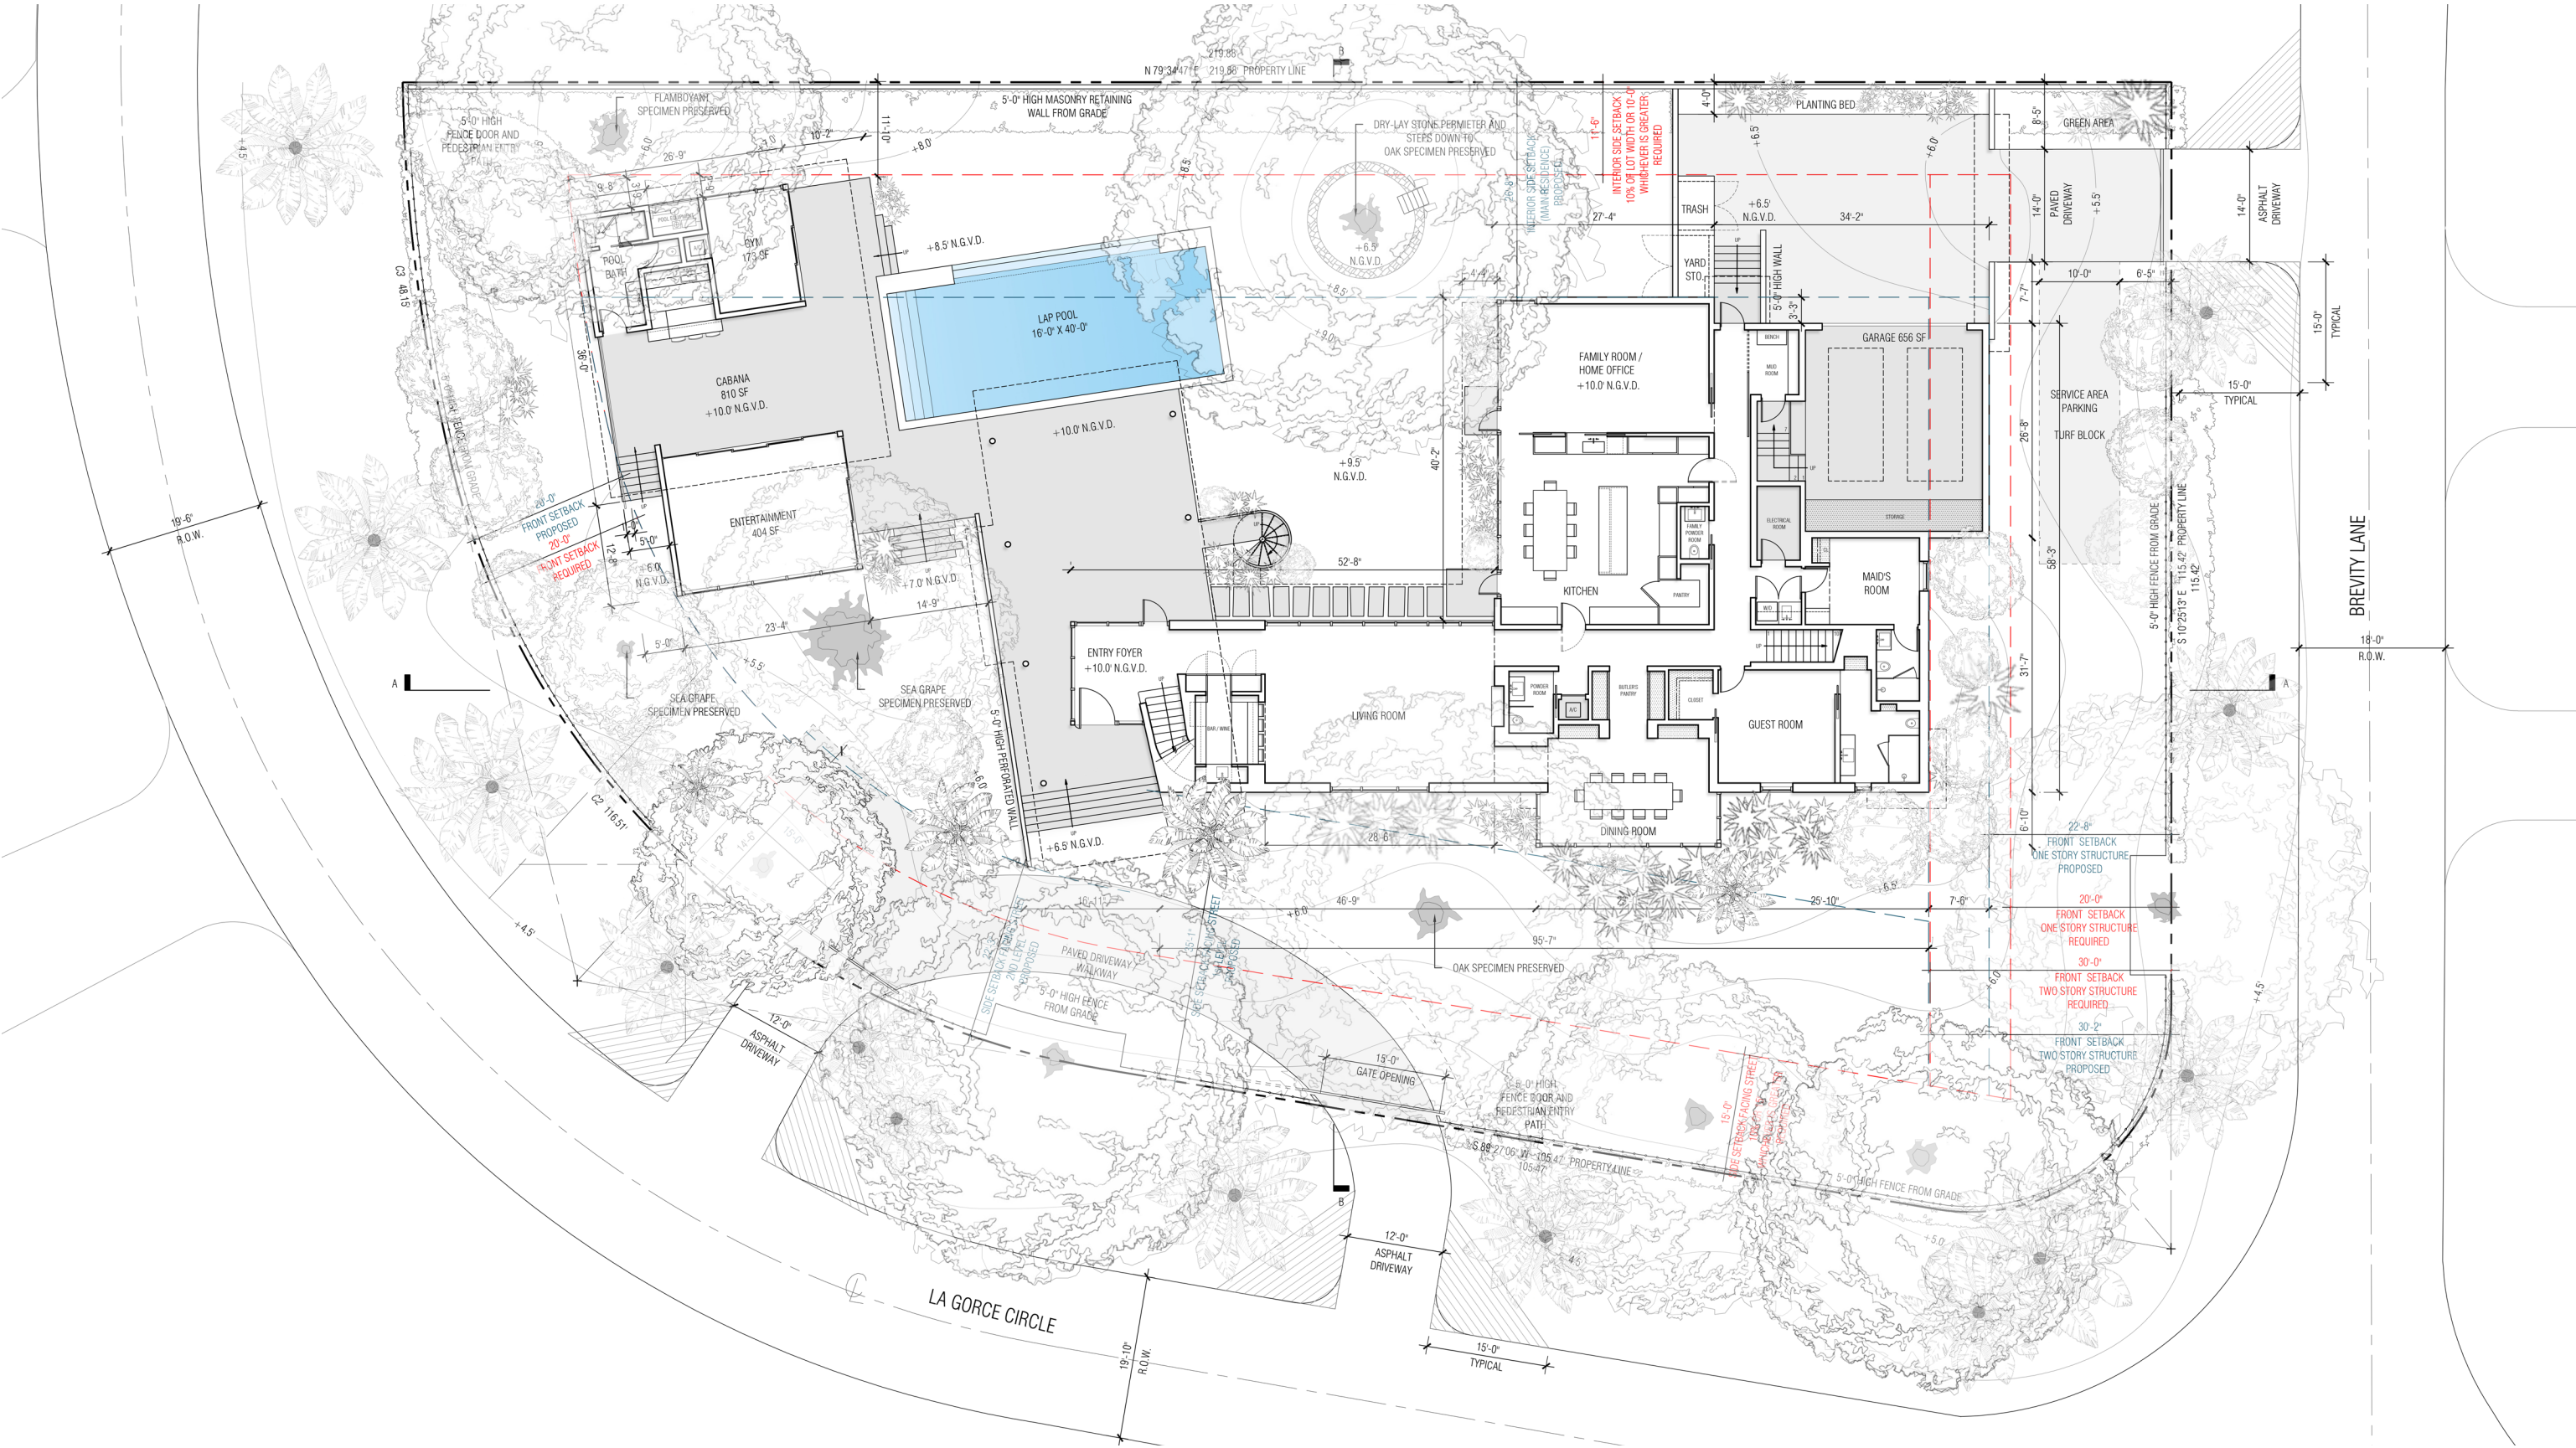


31 LA GORCE RESIDENCE

31 LA GORCE CIRCLE, MIAMI BEACH, FLORIDA



No copies, transmissions, reproductions or electronic manipulation of any portion of these drawings in whole or in part are to be made without the express written permission of Touzet Studio Design & Architecture. All designs indicated in these drawings are property of Touzet Studio Design & Architecture. All copyrights reserved (c) 2020.

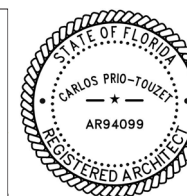


0' 5' 10' 25' 50' N


GROUND FLOOR PLAN

SCALE: 1/16" = 1'-0"


A-27

MIAMI BEACH . DRB FINAL SUBMITTAL . 6 APRIL 2020

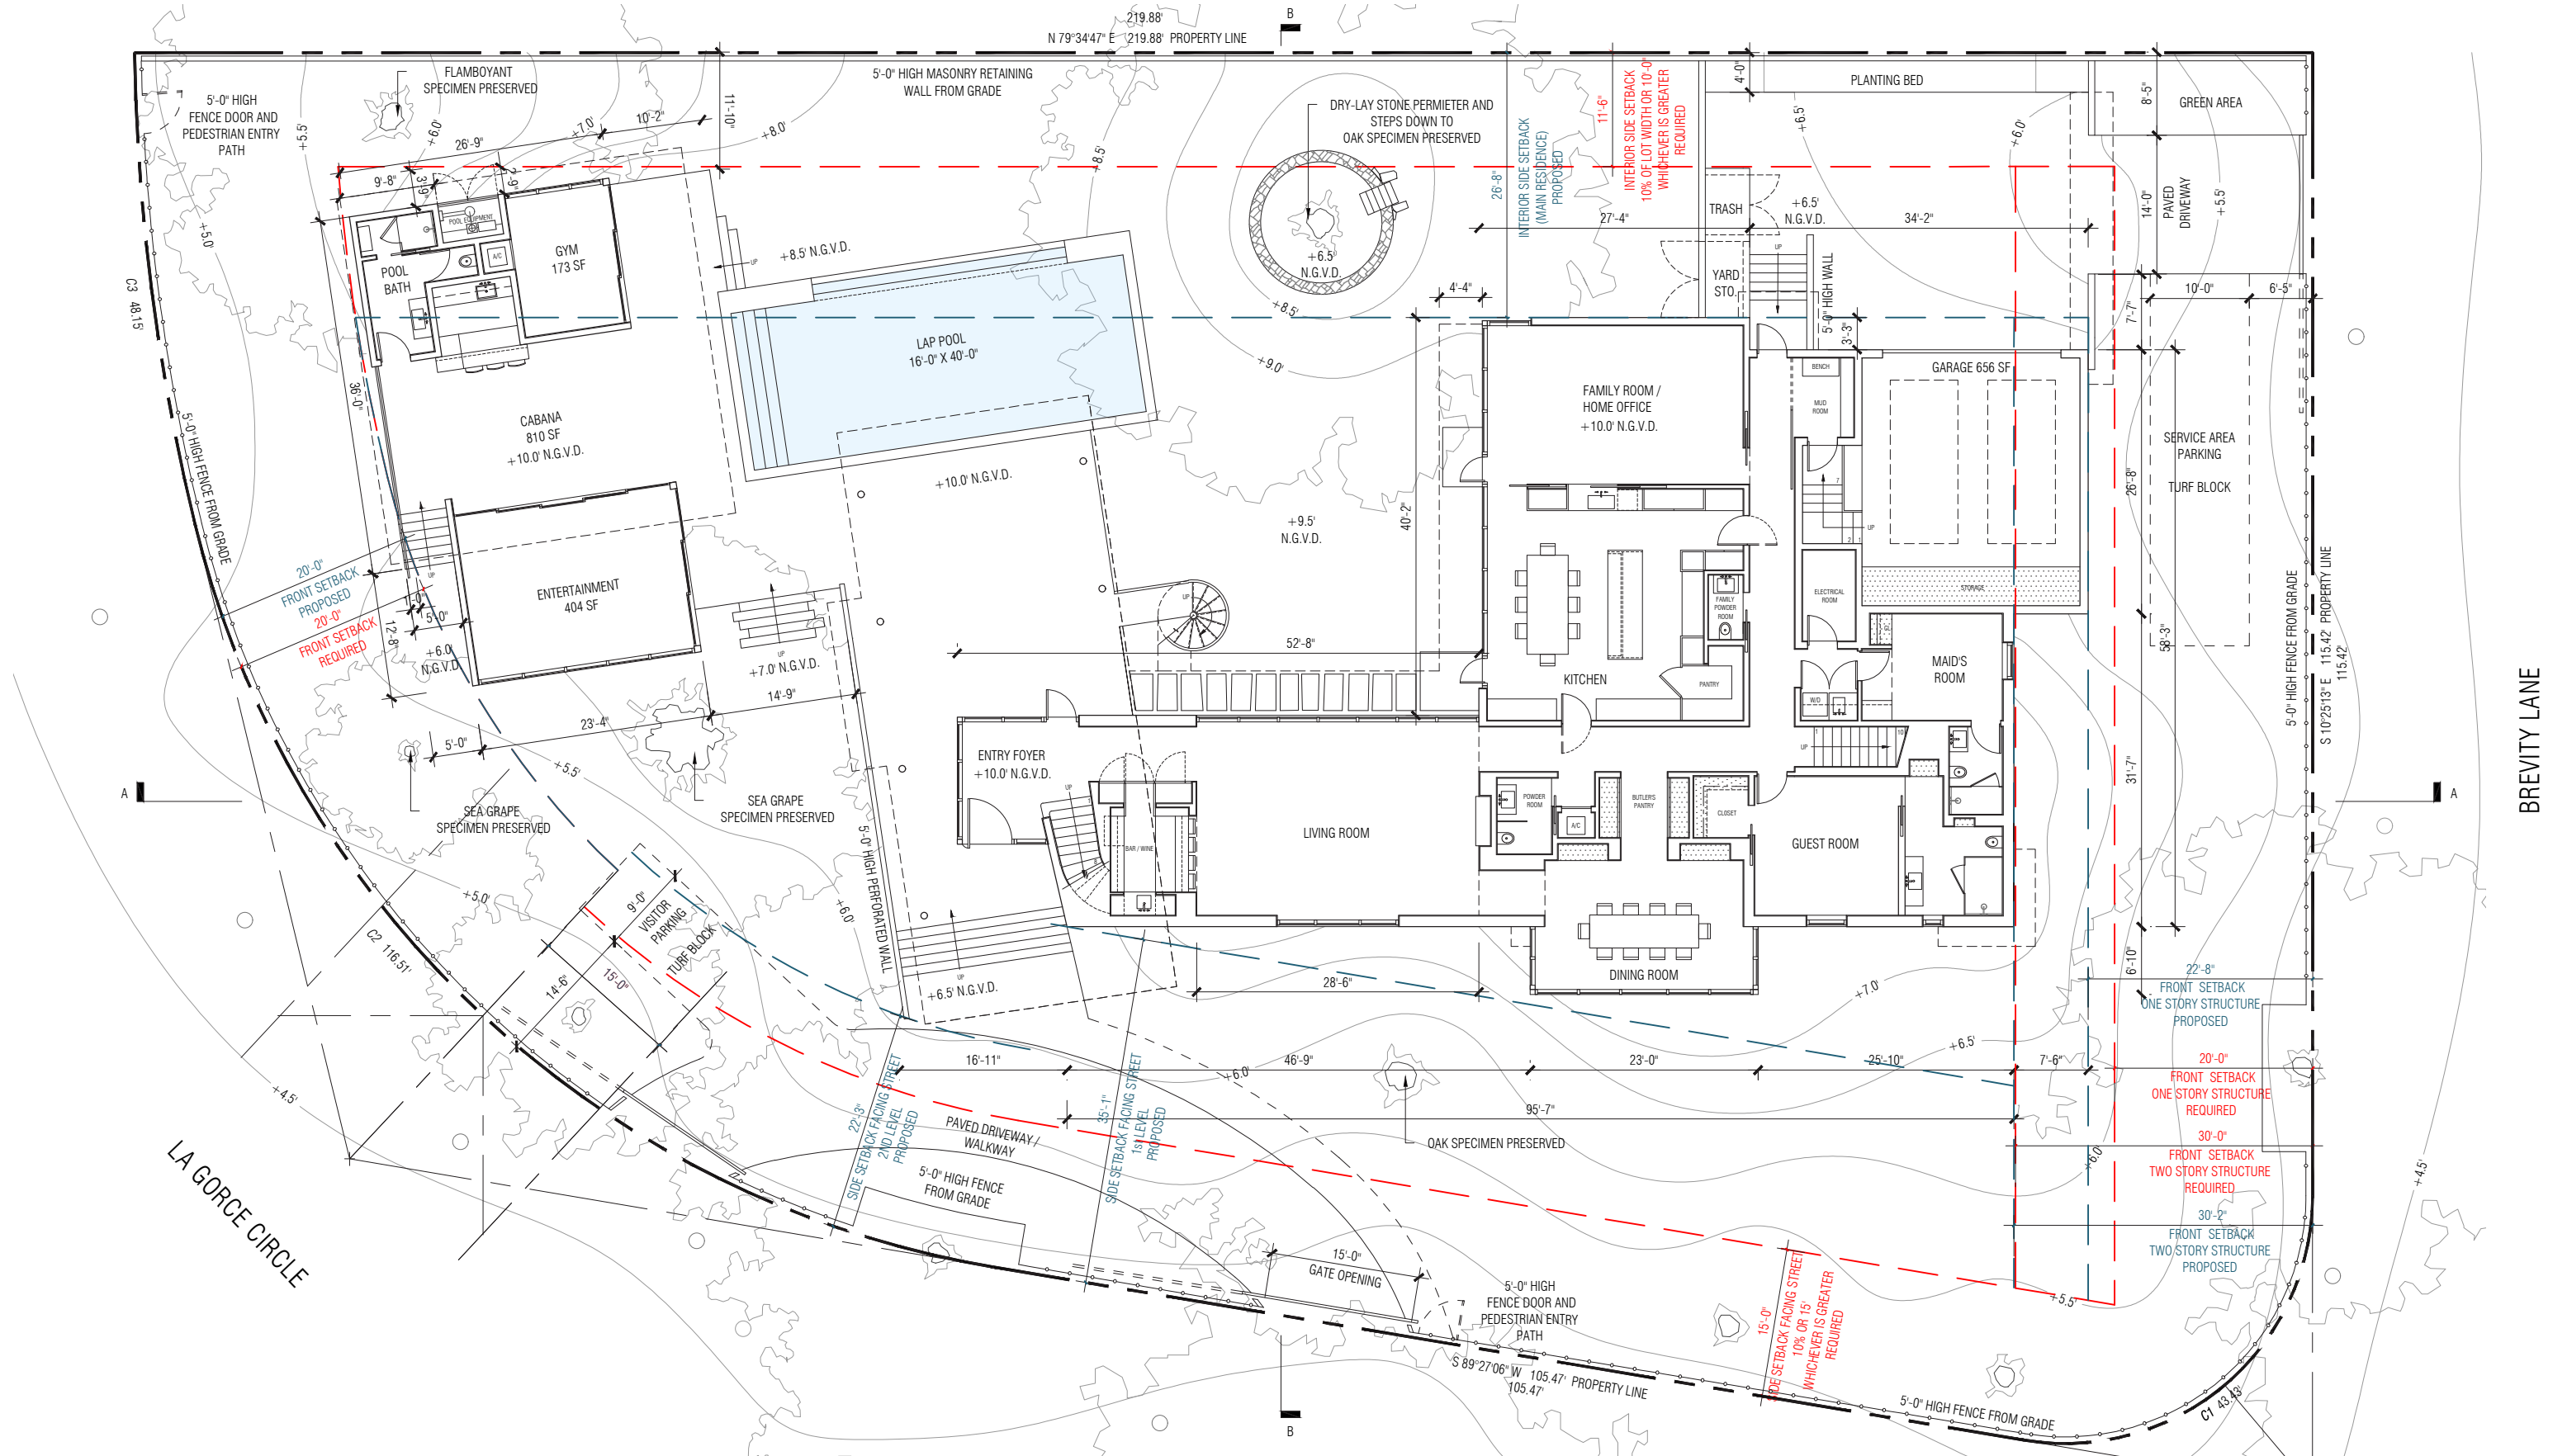

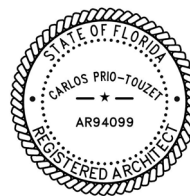

-28

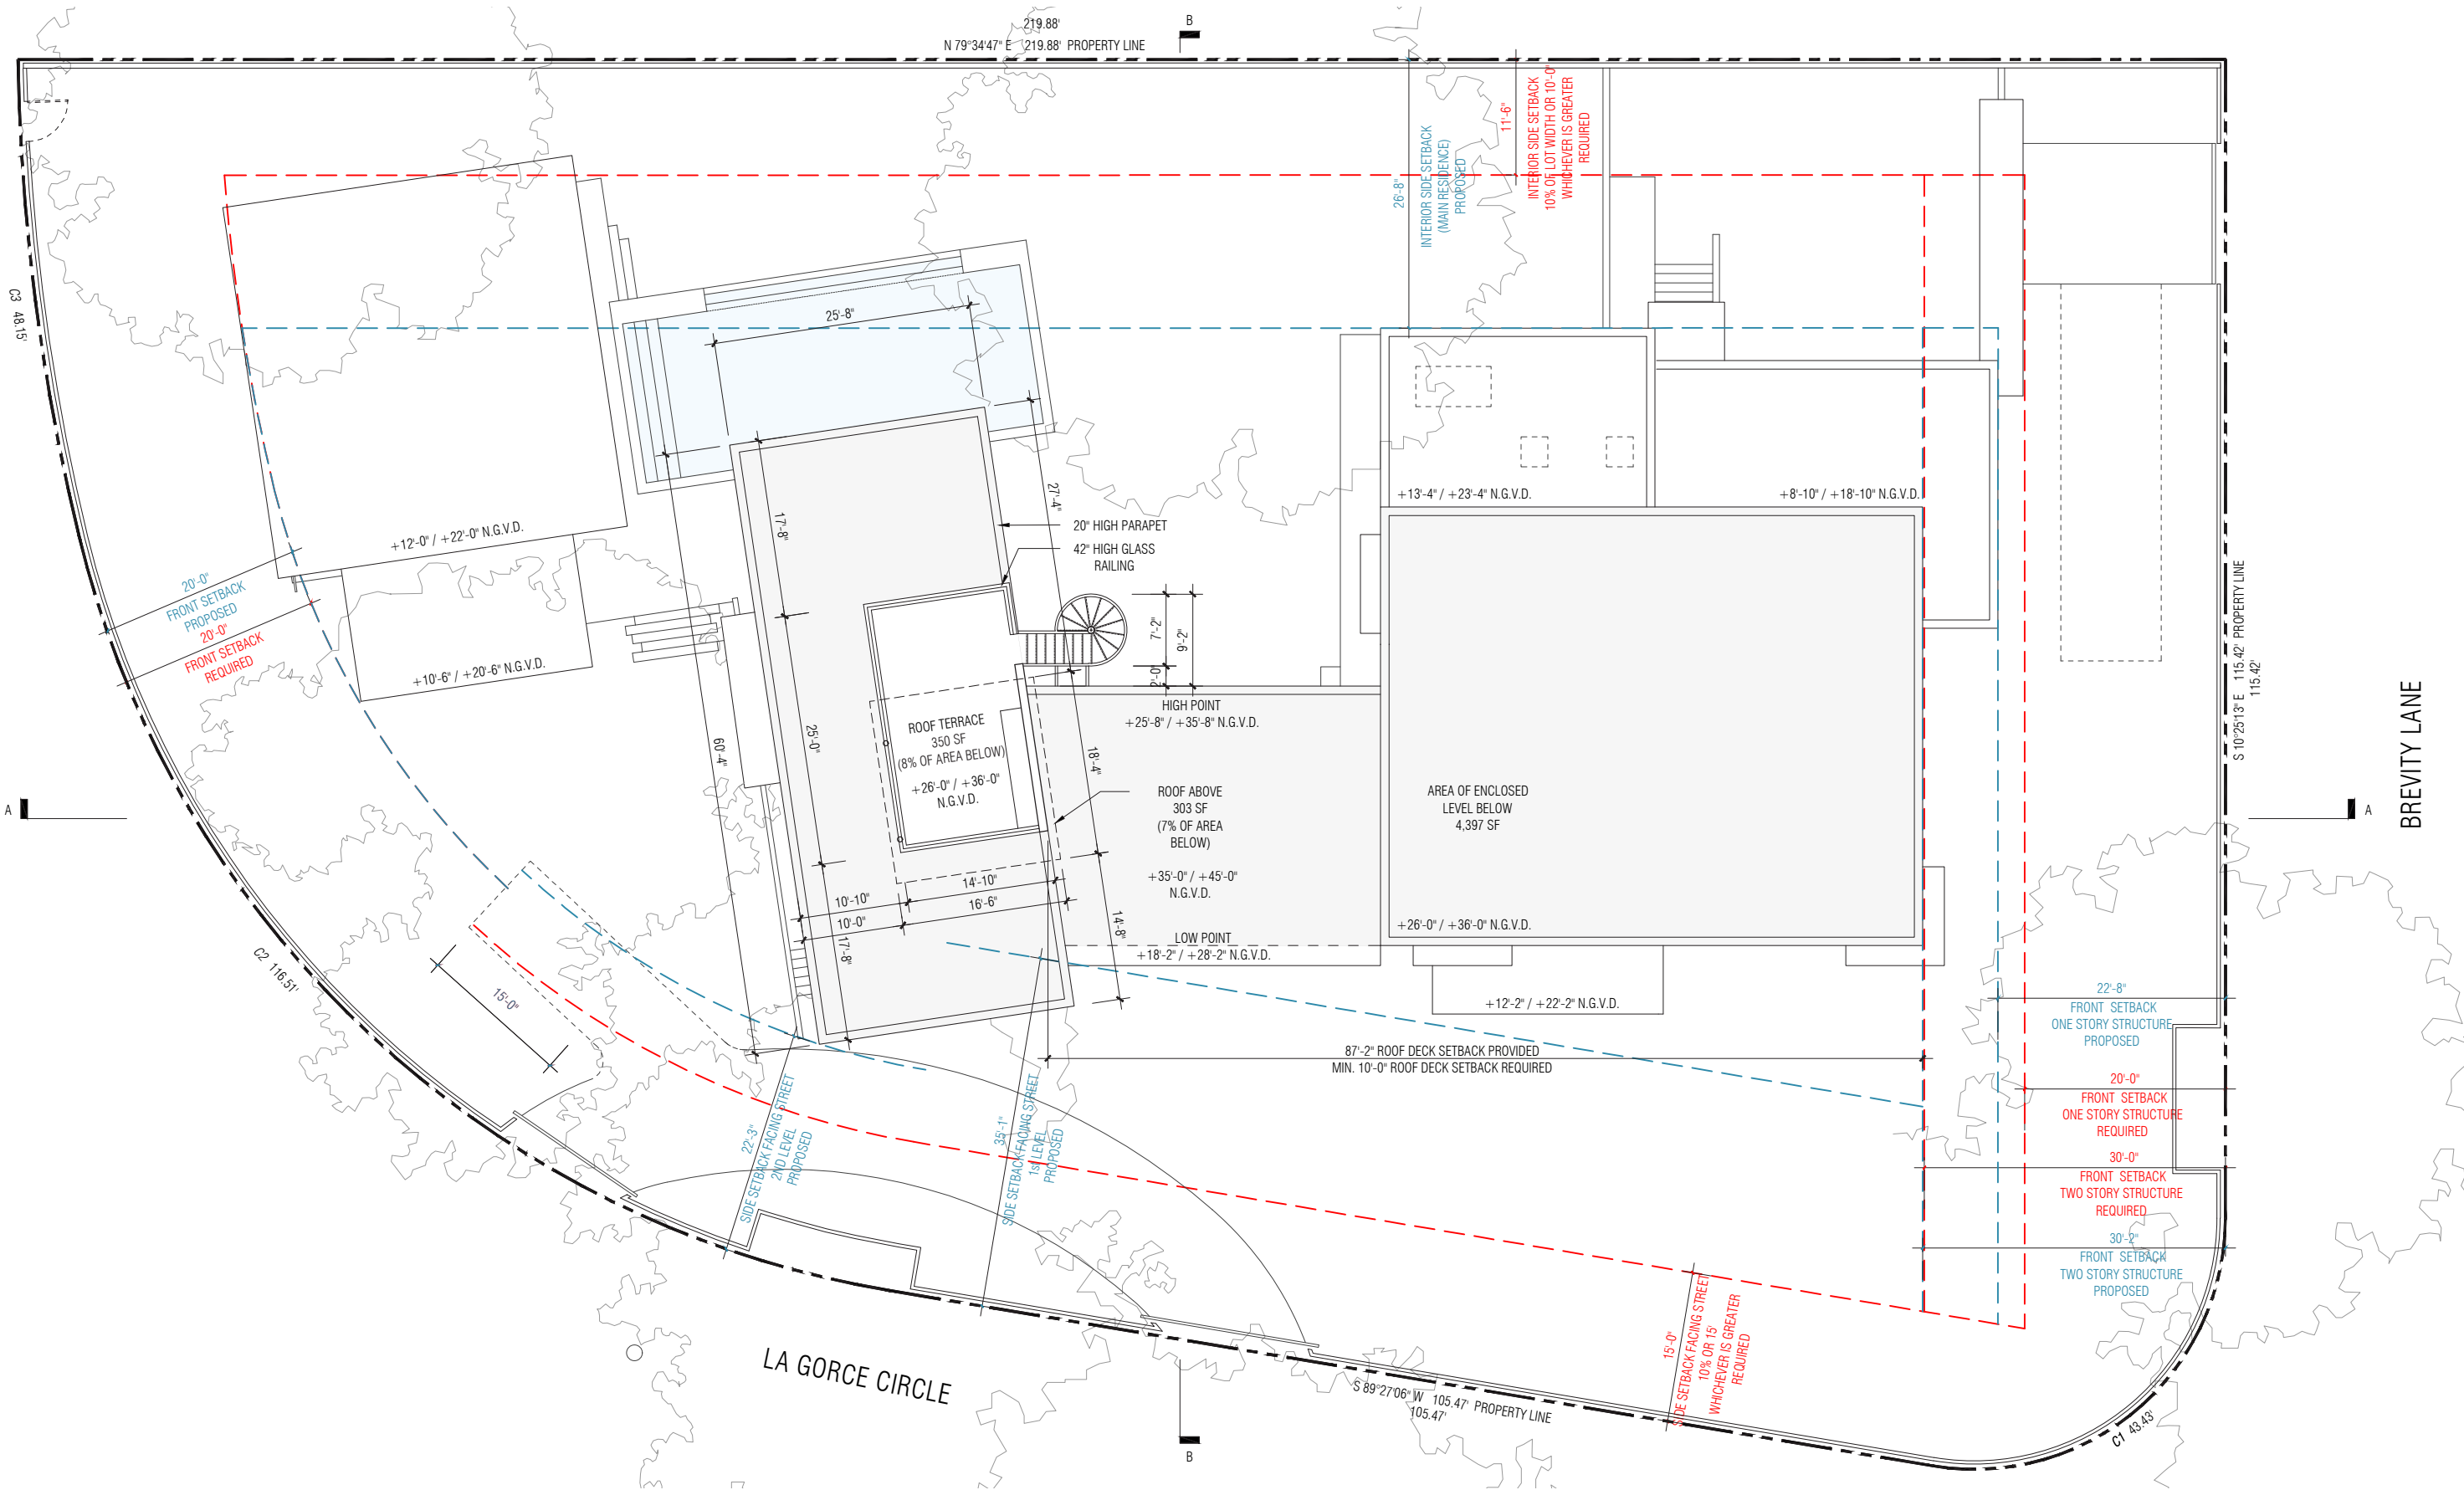


31 LA GORCE RESIDENCE
31 LA GORCE CIRCLE, MIAMI BEACH, FLORIDA




No copies, transmissions, reproductions or electronic manipulation of any portion of these drawings in whole or in part are to be made without the express written permission of Touzet Studio Design & Architecture. All designs indicated in these drawings are property of Touzet Studio Design & Architecture. All copyrights reserved (c) 2020.



0' 5' 10' 25' 50' N

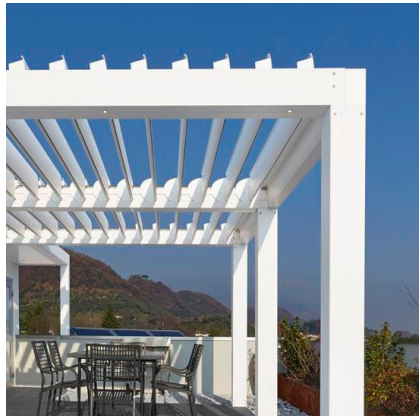


AL-01

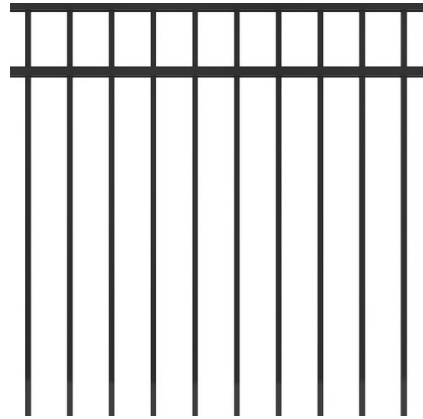

AL-02



C-01

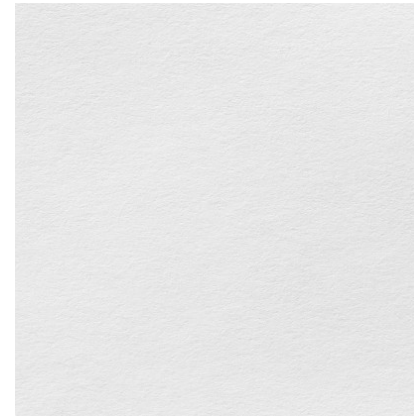

CBS-01



GL-01



GL-02




MTL-01



S-01



ST-01

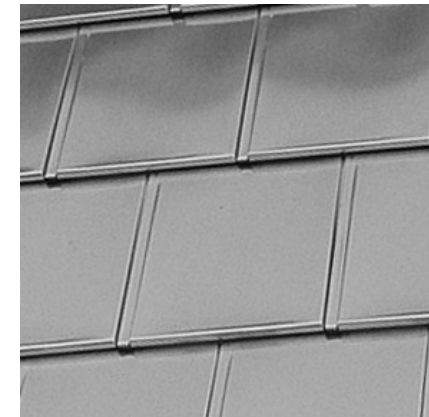

TL-01


 
- AL-01 ALUMINUM MEMBERS AND STRUCTURAL ELEMENTS TO BE FINISHED IN WHITE KYNAR, OR SIMILAR FINISH
- AL-02 BLACK POWDER COAT FINISH, OR SIMILAR FINISH, ON ALUMINUM EXTRUSIONS DECORATIVE FENCE
- C-01 SEALED, LIGHT-COLOR, CAST-IN-PLACE ARCHITECTURAL CONCRETE ELEMENTS / STRUCTURE
- CBS-01 WHITE PAINTED STUCCO ON REINFORCED CONCRETE MASONRY WALL
- GL-01 LIGHT TINT, LAMINATED GLASS ON ALUMINUM FRAMING SYSTEM - MEDIUM BRONZE FINISH
- GL-02 CLEAR, LAMINATED GLASS RAILING SYSTEM
- MTL-01 BREAK METAL OVER STEEL STRUCTURAL ELEMENTS - MEDIUM BRONZE FINISH
- S-01 VERTICAL BAGUETTE RAIN SCREEN - MATERIAL TBD
- ST-01 HONED SAN CROIX / SIMENA LIMESTONE IN COURSED, RANDOM ASHLAR PATTERN
- TL-01 PAC CLAD DIAMOND TILE - MUSKET GRAY

31 LA GORCE RESIDENCE

31 LA GORCE CIRCLE, MIAMI BEACH, FLORIDA



No copies, transmissions, reproductions or electronic manipulation of any portion of these drawings in whole or in part are to be made without the express written permission of Touzet Studio Design & Architecture. All designs indicated in these drawings are property of Touzet Studio Design & Architecture. All copyrights reserved (c) 2020.

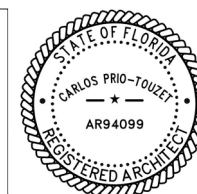


MATERIALS AND TEXTURES



MATERIAL LEGEND

- AL-01 ALUMINUM MEMBERS AND STRUCTURAL ELEMENTS TO BE FINISHED IN WHITE KYNAR, OR SIMILAR FINISH
- AL-02 BLACK POWDER COAT FINISH, OR SIMILAR FINISH, ON ALUMINUM EXTRUSIONS DECORATIVE FENCE
- C-01 SEALED, LIGHT-COLOR, CAST-IN-PLACE ARCHITECTURAL CONCRETE ELEMENTS / STRUCTURE
- CBS-01 WHITE PAINTED STUCCO ON REINFORCED CONCRETE MASONRY WALL
- GL-01 LIGHT TINT, LAMINATED GLASS ON ALUMINUM FRAMING SYSTEM - MEDIUM BRONZE FINISH
- GL-02 CLEAR, LAMINATED GLASS RAILING SYSTEM
- MTL-01 BREAK METAL OVER STEEL STRUCTURAL ELEMENTS - MEDIUM BRONZE FINISH
- S-01 VERTICAL BAGUETTE RAIN SCREEN - MATERIAL TBD
- ST-01 HONED SAN CROIX / SIMENA LIMESTONE IN COURSED, RANDOM ASHLAR PATTERN
- TL-01 PAC CLAD DIAMOND TILE - MUSKET GRAY

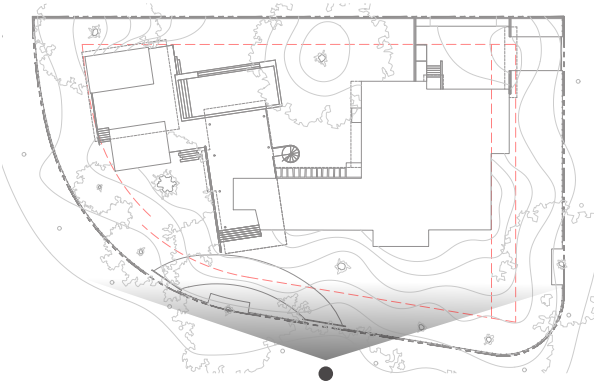

31 LA GORCE RESIDENCE

31 LA GORCE CIRCLE, MIAMI BEACH, FLORIDA



No copies, transmissions, reproductions or electronic manipulation of any portion of these drawings in whole or in part are to be made without the express written permission of Touzet Studio Design & Architecture. All designs indicated in these drawings are property of Touzet Studio Design & Architecture. All copyrights reserved (c) 2020.




SOUTH ELEVATION
SCALE: 1/16" = 1'-0"





MATERIAL LEGEND

- AL-01 ALUMINUM MEMBERS AND STRUCTURAL ELEMENTS TO BE FINISHED IN WHITE KYNAR, OR SIMILAR FINISH
- AL-02 BLACK POWDER COAT FINISH, OR SIMILAR FINISH, ON ALUMINUM EXTRUSIONS DECORATIVE FENCE
- C-01 SEALED, LIGHT-COLOR, CAST-IN-PLACE ARCHITECTURAL CONCRETE ELEMENTS / STRUCTURE
- CBS-01 WHITE PAINTED STUCCO ON REINFORCED CONCRETE MASONRY WALL
- GL-01 LIGHT TINT, LAMINATED GLASS ON ALUMINUM FRAMING SYSTEM - MEDIUM BRONZE FINISH
- GL-02 CLEAR, LAMINATED GLASS RAILING SYSTEM
- MTL-01 BREAK METAL OVER STEEL STRUCTURAL ELEMENTS - MEDIUM BRONZE FINISH
- S-01 VERTICAL BAGUETTE RAIN SCREEN - MATERIAL TBD
- ST-01 HONED SAN CROIX / SIMENA LIMESTONE IN COURSED, RANDOM ASHLAR PATTERN
- TL-01 PAC CLAD DIAMOND TILE - MUSKET GRAY

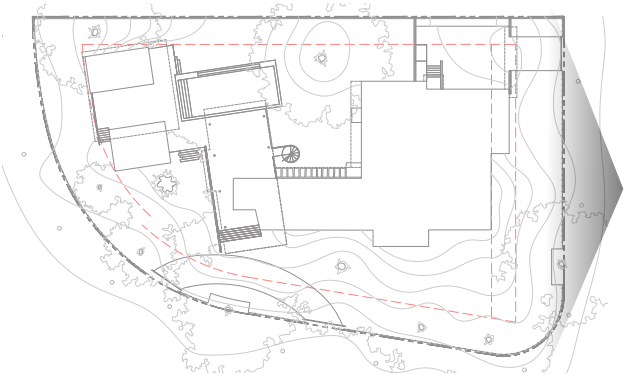

31 LA GORCE RESIDENCE

31 LA GORCE CIRCLE, MIAMI BEACH, FLORIDA



No copies, transmissions, reproductions or electronic manipulation of any portion of these drawings in whole or in part are to be made without the express written permission of Touzet Studio Design & Architecture. All designs indicated in these drawings are property of Touzet Studio Design & Architecture. All copyrights reserved (c) 2020.



0' 5' 10' 25' 50'

EAST ELEVATION

SCALE: 1/16" = 1'-0"




MATERIAL LEGEND

- AL-01 ALUMINUM MEMBERS AND STRUCTURAL ELEMENTS TO BE FINISHED IN WHITE KYNAR, OR SIMILAR FINISH
- AL-02 BLACK POWDER COAT FINISH, OR SIMILAR FINISH, ON ALUMINUM EXTRUSIONS DECORATIVE FENCE
- C-01 SEALED, LIGHT-COLOR, CAST-IN-PLACE ARCHITECTURAL CONCRETE ELEMENTS / STRUCTURE
- CBS-01 WHITE PAINTED STUCCO ON REINFORCED CONCRETE MASONRY WALL
- GL-01 LIGHT TINT, LAMINATED GLASS ON ALUMINUM FRAMING SYSTEM - MEDIUM BRONZE FINISH
- GL-02 CLEAR, LAMINATED GLASS RAILING SYSTEM
- MTL-01 BREAK METAL OVER STEEL STRUCTURAL ELEMENTS - MEDIUM BRONZE FINISH
- S-01 VERTICAL BAGUETTE RAIN SCREEN - MATERIAL TBD
- ST-01 HONED SAN CROIX / SIMENA LIMESTONE IN COURSED, RANDOM ASHLAR PATTERN
- TL-01 PAC CLAD DIAMOND TILE - MUSKET GRAY


31 LA GORCE RESIDENCE
31 LA GORCE CIRCLE, MIAMI BEACH, FLORIDA



No copies, transmissions, reproductions or electronic manipulation of any portion of these drawings in whole or in part are to be made without the express written permission of Touzet Studio Design & Architecture. All designs indicated in these drawings are property of Touzet Studio Design & Architecture. All copyrights reserved (c) 2020.

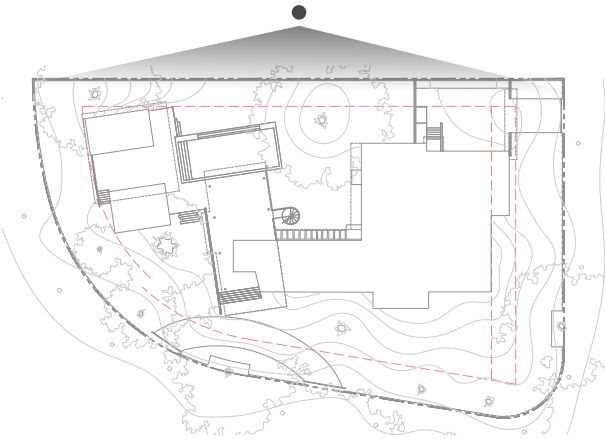


NORTH ELEVATION
SCALE: 1/16" = 1'-0"

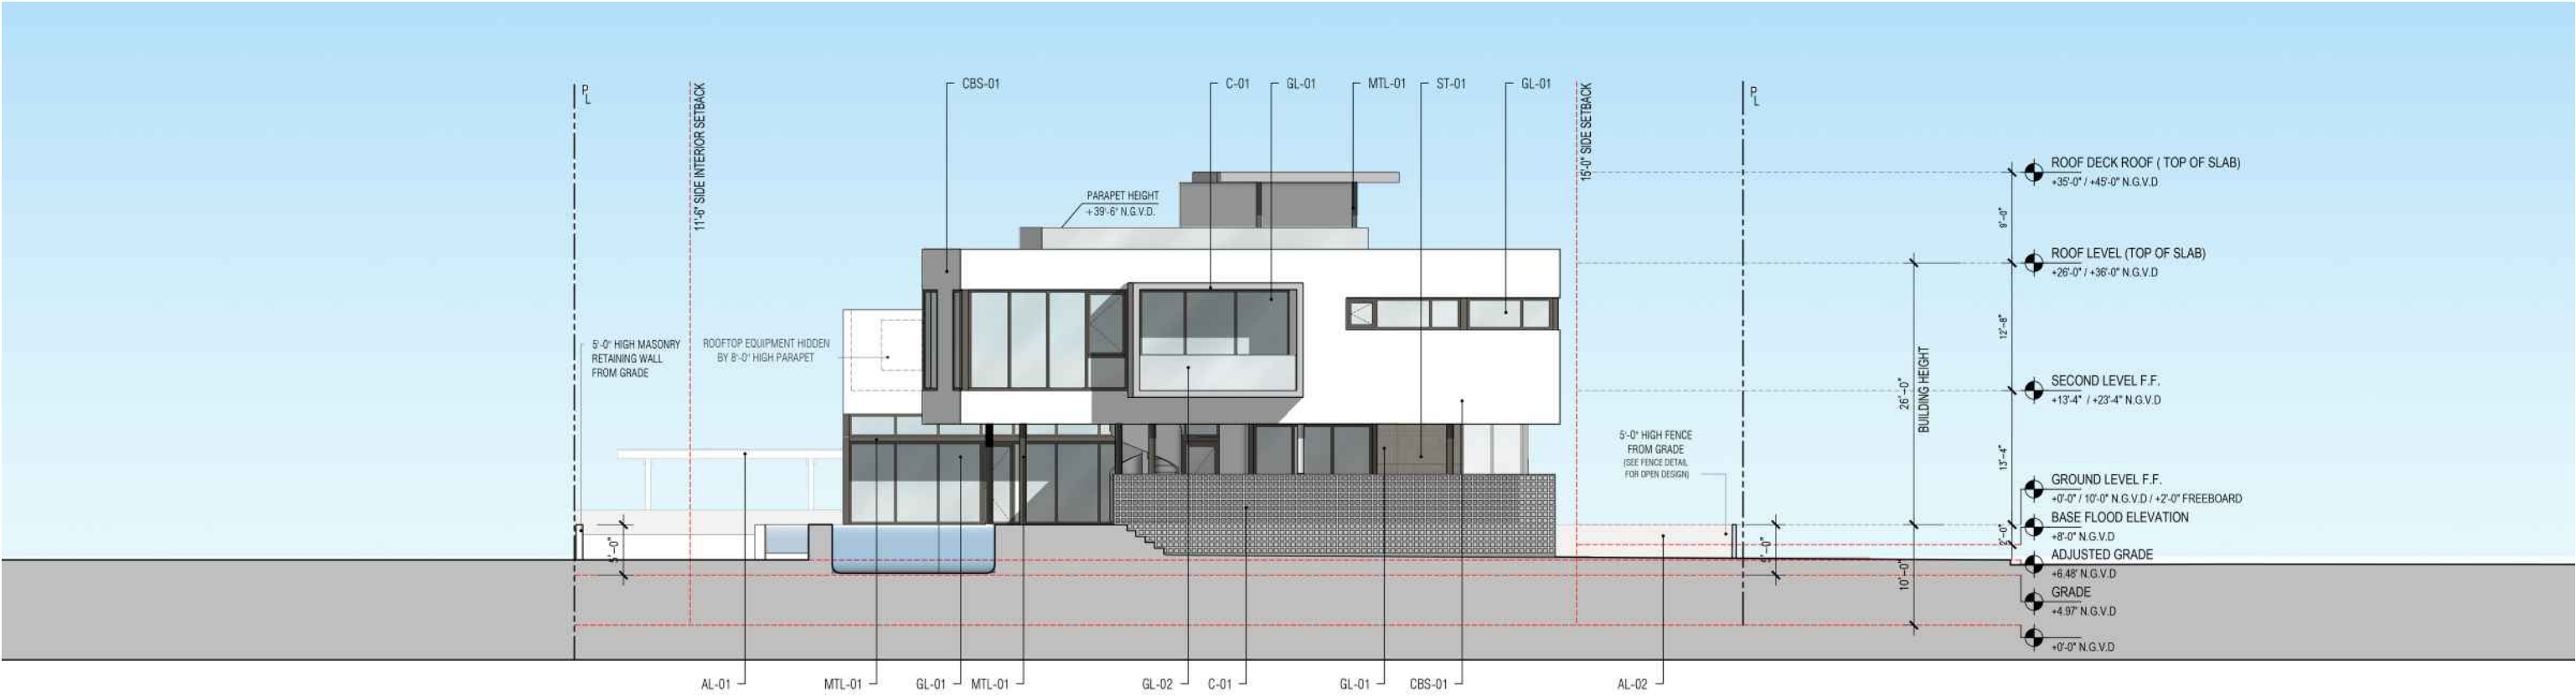

MATERIAL LEGEND

- AL-01 ALUMINUM MEMBERS AND STRUCTURAL ELEMENTS TO BE FINISHED IN WHITE KYNAR, OR SIMILAR FINISH
- AL-02 BLACK POWDER COAT FINISH, OR SIMILAR FINISH, ON ALUMINUM EXTRUSIONS DECORATIVE FENCE
- C-01 SEALED, LIGHT-COLOR, CAST-IN-PLACE ARCHITECTURAL CONCRETE ELEMENTS / STRUCTURE
- CBS-01 WHITE PAINTED STUCCO ON REINFORCED CONCRETE MASONRY WALL
- GL-01 LIGHT TINT, LAMINATED GLASS ON ALUMINUM FRAMING SYSTEM - MEDIUM BRONZE FINISH
- GL-02 CLEAR, LAMINATED GLASS RAILING SYSTEM
- MTL-01 BREAK METAL OVER STEEL STRUCTURAL ELEMENTS - MEDIUM BRONZE FINISH
- S-01 VERTICAL BAGUETTE RAIN SCREEN - MATERIAL TBD
- ST-01 HONED SAN CROIX / SIMENA LIMESTONE IN COURSED, RANDOM ASHLAR PATTERN
- TL-01 PAC CLAD DIAMOND TILE - MUSKET GRAY

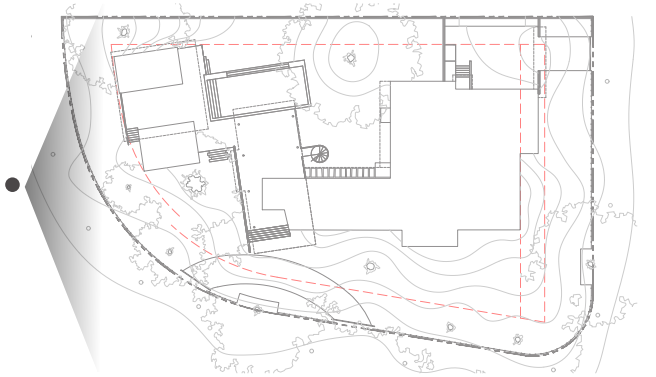

31 LA GORCE RESIDENCE

31 LA GORCE CIRCLE, MIAMI BEACH, FLORIDA




No copies, transmissions, reproductions or electronic manipulation of any portion of these drawings in whole or in part are to be made without the express written permission of Touzet Studio Design & Architecture. All designs indicated in these drawings are property of Touzet Studio Design & Architecture. All copyrights reserved (c) 2020.



0' 5' 10' 25' 50'


WEST ELEVATION

SCALE: 1/16" = 1'-0"

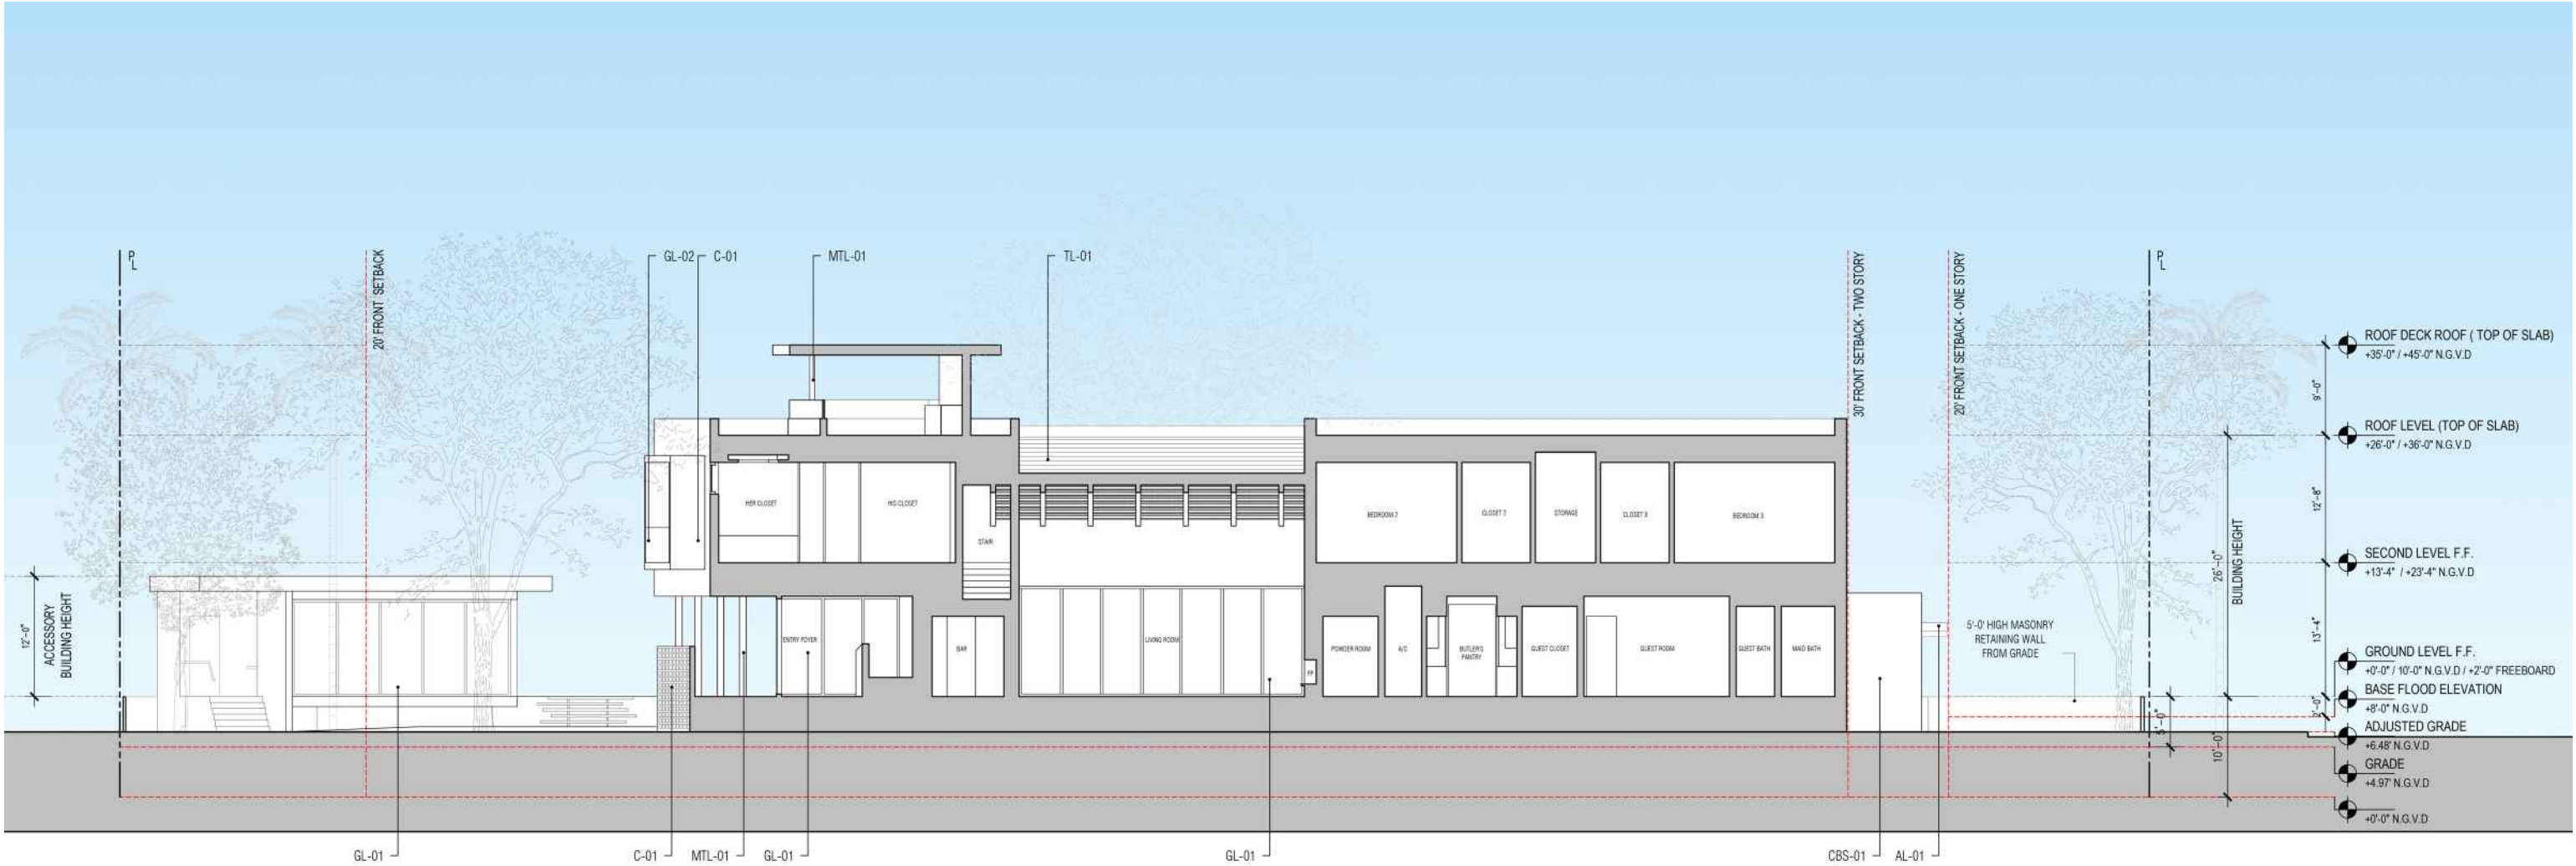

MATERIAL LEGEND


- AL-01 ALUMINUM MEMBERS AND STRUCTURAL ELEMENTS TO BE FINISHED IN WHITE KYNAR, OR SIMILAR FINISH
- AL-02 BLACK POWDER COAT FINISH, OR SIMILAR FINISH, ON ALUMINUM EXTRUSIONS DECORATIVE FENCE
- C-01 SEALED, LIGHT-COLOR, CAST-IN-PLACE ARCHITECTURAL CONCRETE ELEMENTS / STRUCTURE
- CBS-01 WHITE PAINTED STUCCO ON REINFORCED CONCRETE MASONRY WALL
- GL-01 LIGHT TINT, LAMINATED GLASS ON ALUMINUM FRAMING SYSTEM - MEDIUM BRONZE FINISH
- GL-02 CLEAR, LAMINATED GLASS RAILING SYSTEM
- MTL-01 BREAK METAL OVER STEEL STRUCTURAL ELEMENTS - MEDIUM BRONZE FINISH
- S-01 VERTICAL BAGUETTE RAIN SCREEN - MATERIAL TBD
- ST-01 HONED SAN CROIX / SIMENA LIMESTONE IN COURSED, RANDOM ASHLAR PATTERN
- TL-01 PAC CLAD DIAMOND TILE - MUSKET GRAY

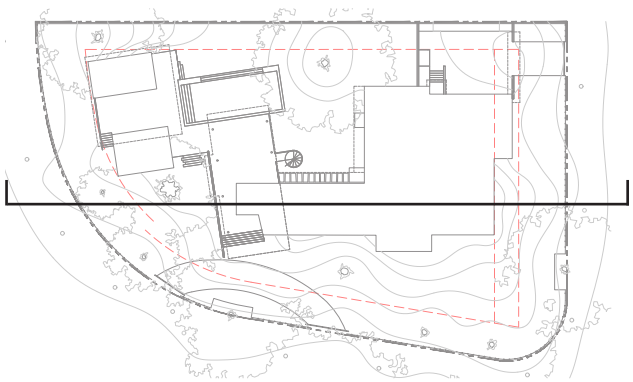

31 LA GORCE RESIDENCE
31 LA GORCE CIRCLE, MIAMI BEACH, FLORIDA


TOUZET
STUDIO
DESIGN & ARCHITECTURE

No copies, transmissions, reproductions or electronic manipulation of any portion of these drawings in whole or in part are to be made without the express written permission of Touzet Studio Design & Architecture. All designs indicated in these drawings are property of Touzet Studio Design & Architecture. All copyrights reserved (c) 2020.

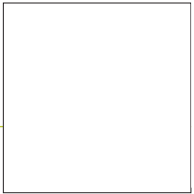

SECTION - LONGITUDINAL
SCALE: 1/16" = 1'-0"

0' 5' 10' 25' 50'

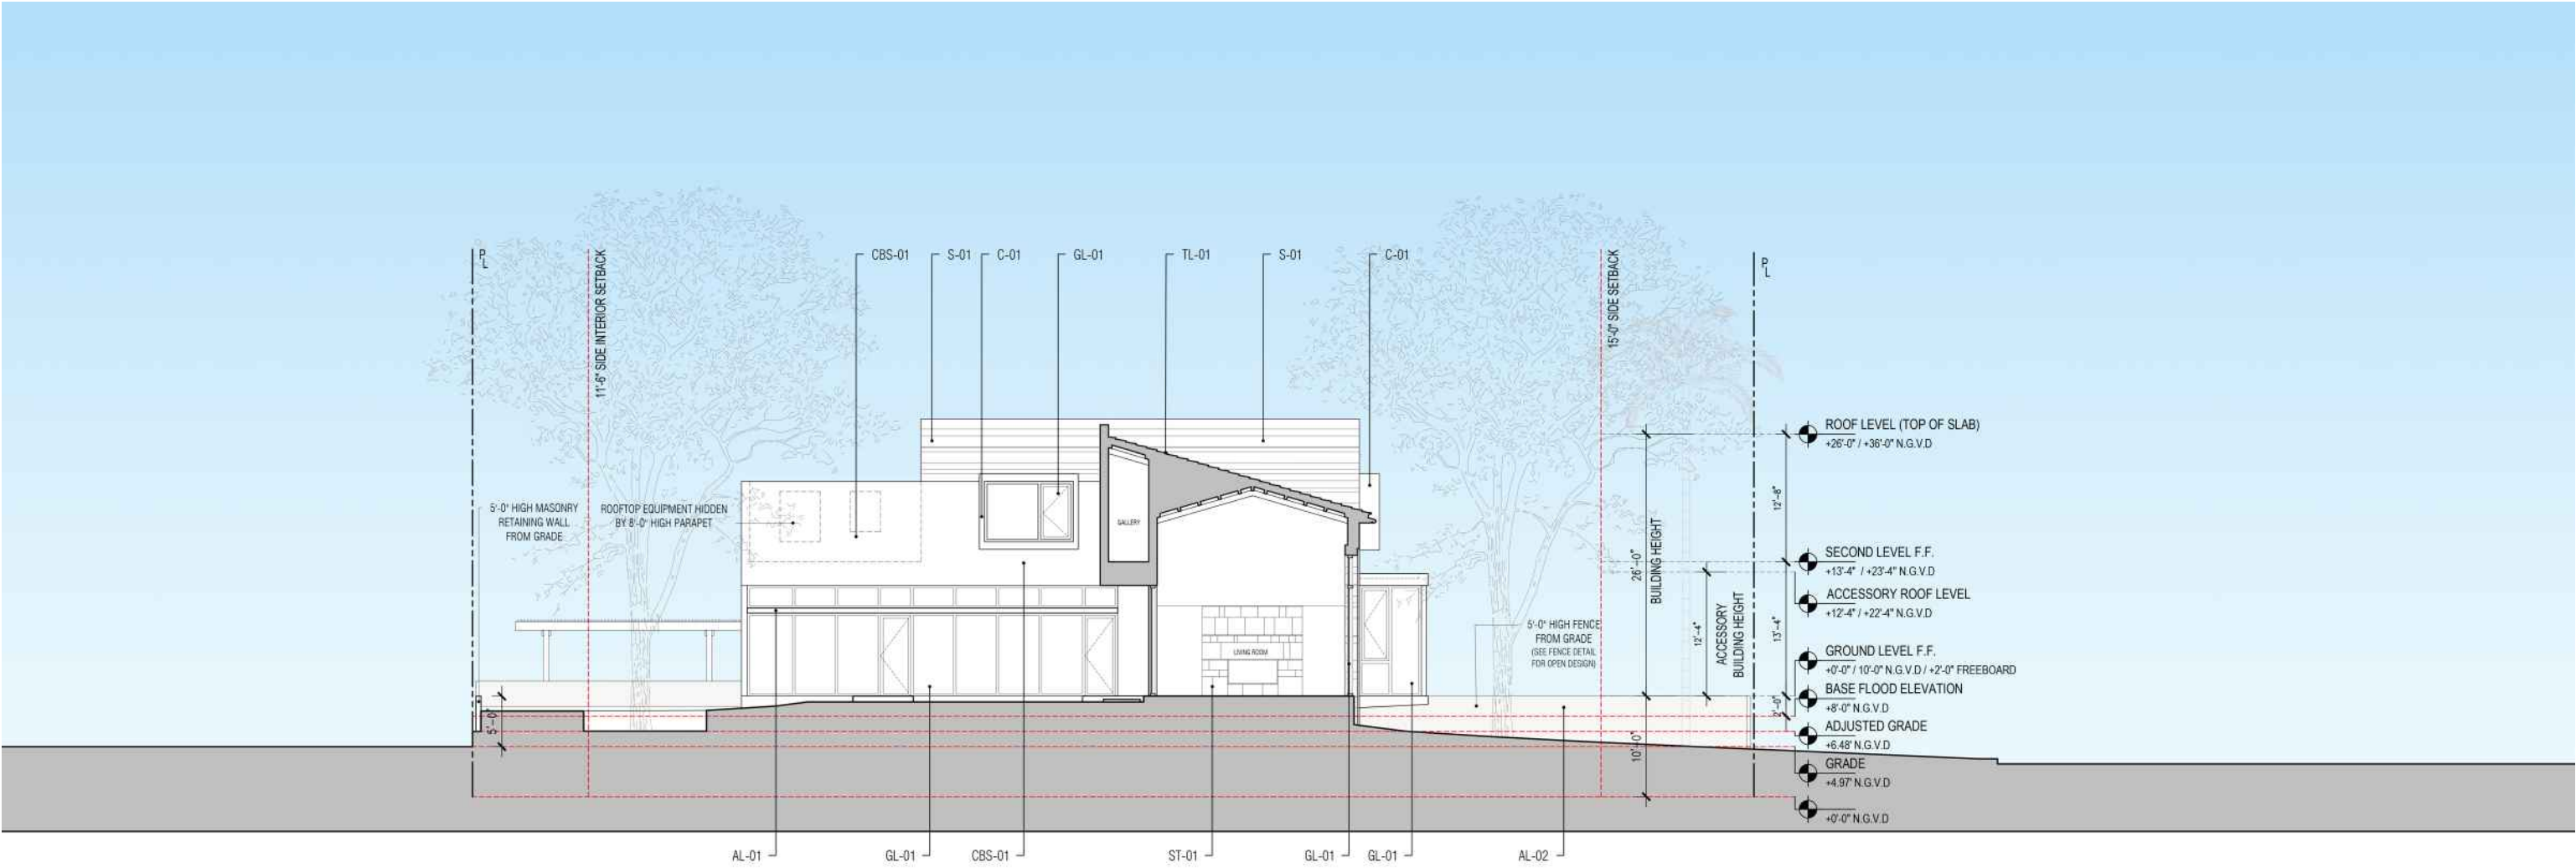

MATERIAL LEGEND


- AL-01 ALUMINUM MEMBERS AND STRUCTURAL ELEMENTS TO BE FINISHED IN WHITE KYNAR, OR SIMILAR FINISH
- AL-02 BLACK POWDER COAT FINISH, OR SIMILAR FINISH, ON ALUMINUM EXTRUSIONS DECORATIVE FENCE
- C-01 SEALED, LIGHT-COLOR, CAST-IN-PLACE ARCHITECTURAL CONCRETE ELEMENTS / STRUCTURE
- CBS-01 WHITE PAINTED STUCCO ON REINFORCED CONCRETE MASONRY WALL
- GL-01 LIGHT TINT, LAMINATED GLASS ON ALUMINUM FRAMING SYSTEM - MEDIUM BRONZE FINISH
- GL-02 CLEAR, LAMINATED GLASS RAILING SYSTEM
- MTL-01 BREAK METAL OVER STEEL STRUCTURAL ELEMENTS - MEDIUM BRONZE FINISH
- S-01 VERTICAL BAGUETTE RAIN SCREEN - MATERIAL TBD
- ST-01 HONED SAN CROIX / SIMENA LIMESTONE IN COURSED, RANDOM ASHLAR PATTERN
- TL-01 PAC CLAD DIAMOND TILE - MUSKET GRAY

31 LA GORCE RESIDENCE

31 LA GORCE CIRCLE, MIAMI BEACH, FLORIDA




No copies, transmissions, reproductions or electronic manipulation of any portion of these drawings in whole or in part are to be made without the express written permission of Touzet Studio Design & Architecture. All designs indicated in these drawings are property of Touzet Studio Design & Architecture. All copyrights reserved (c) 2020.

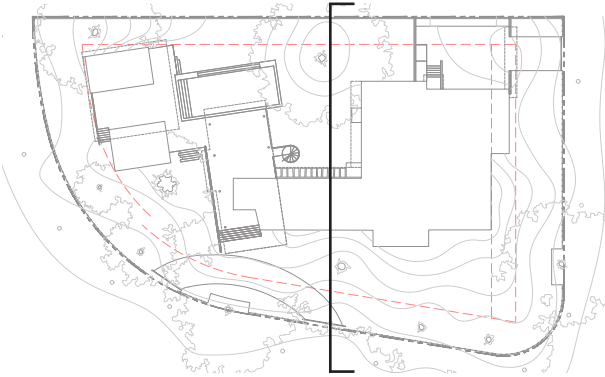


SECTION - TRANSVERSE

SCALE: 1/16" = 1'-0"




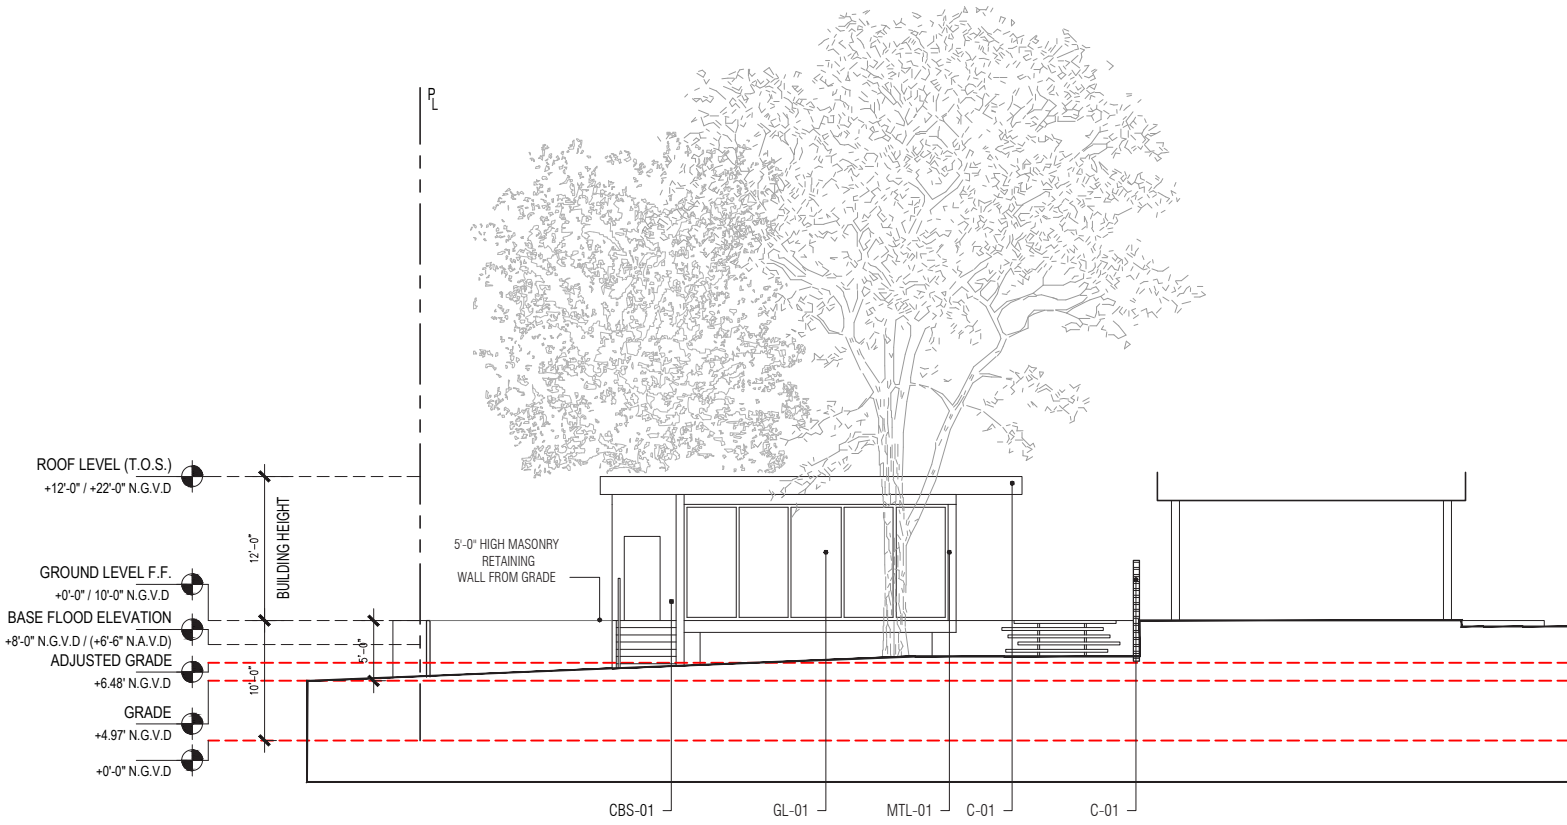


SOUTH ELEVATION

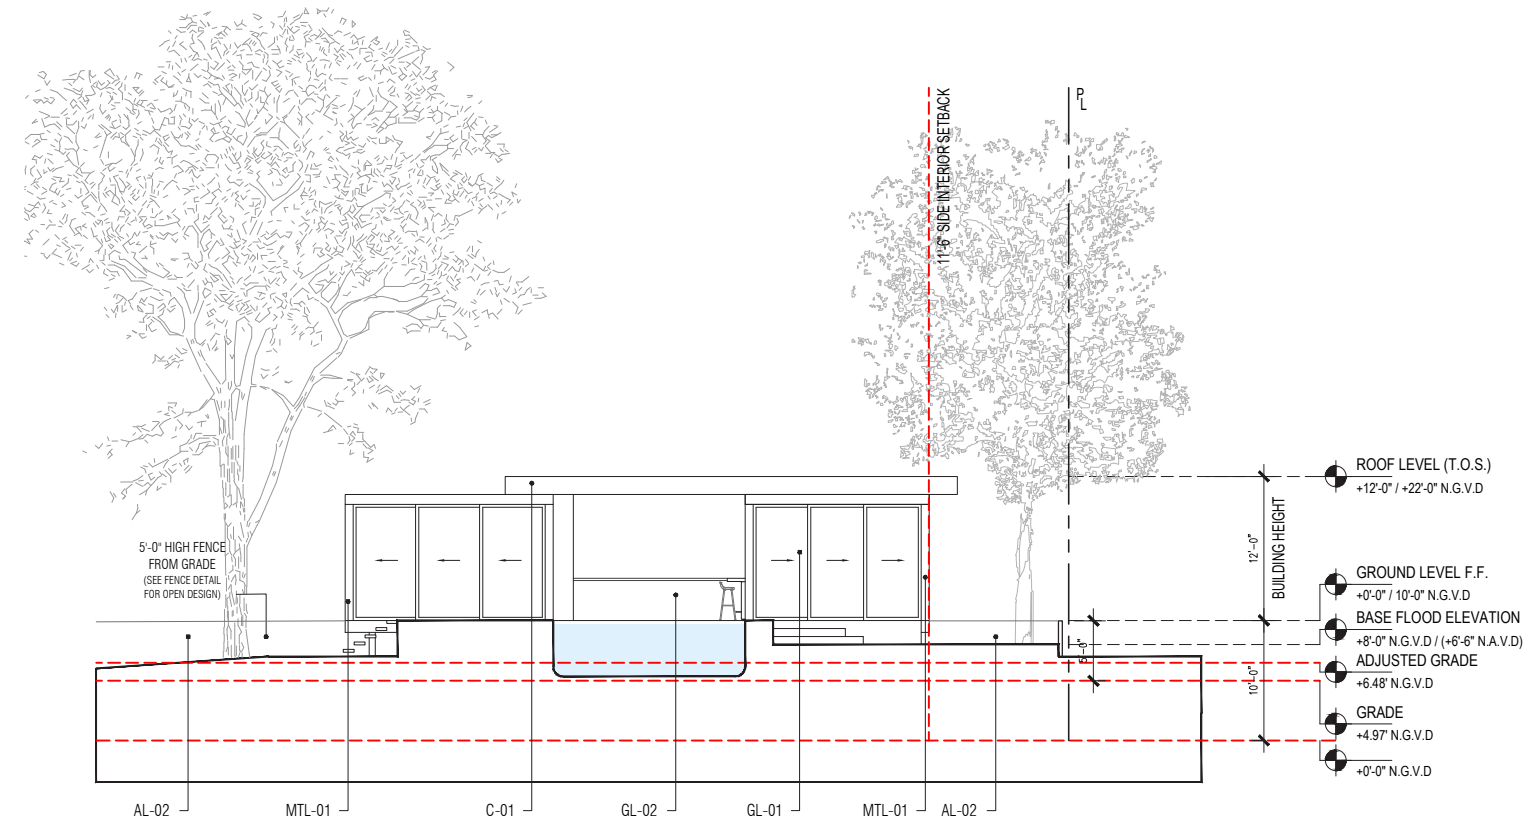

EAST ELEVATION

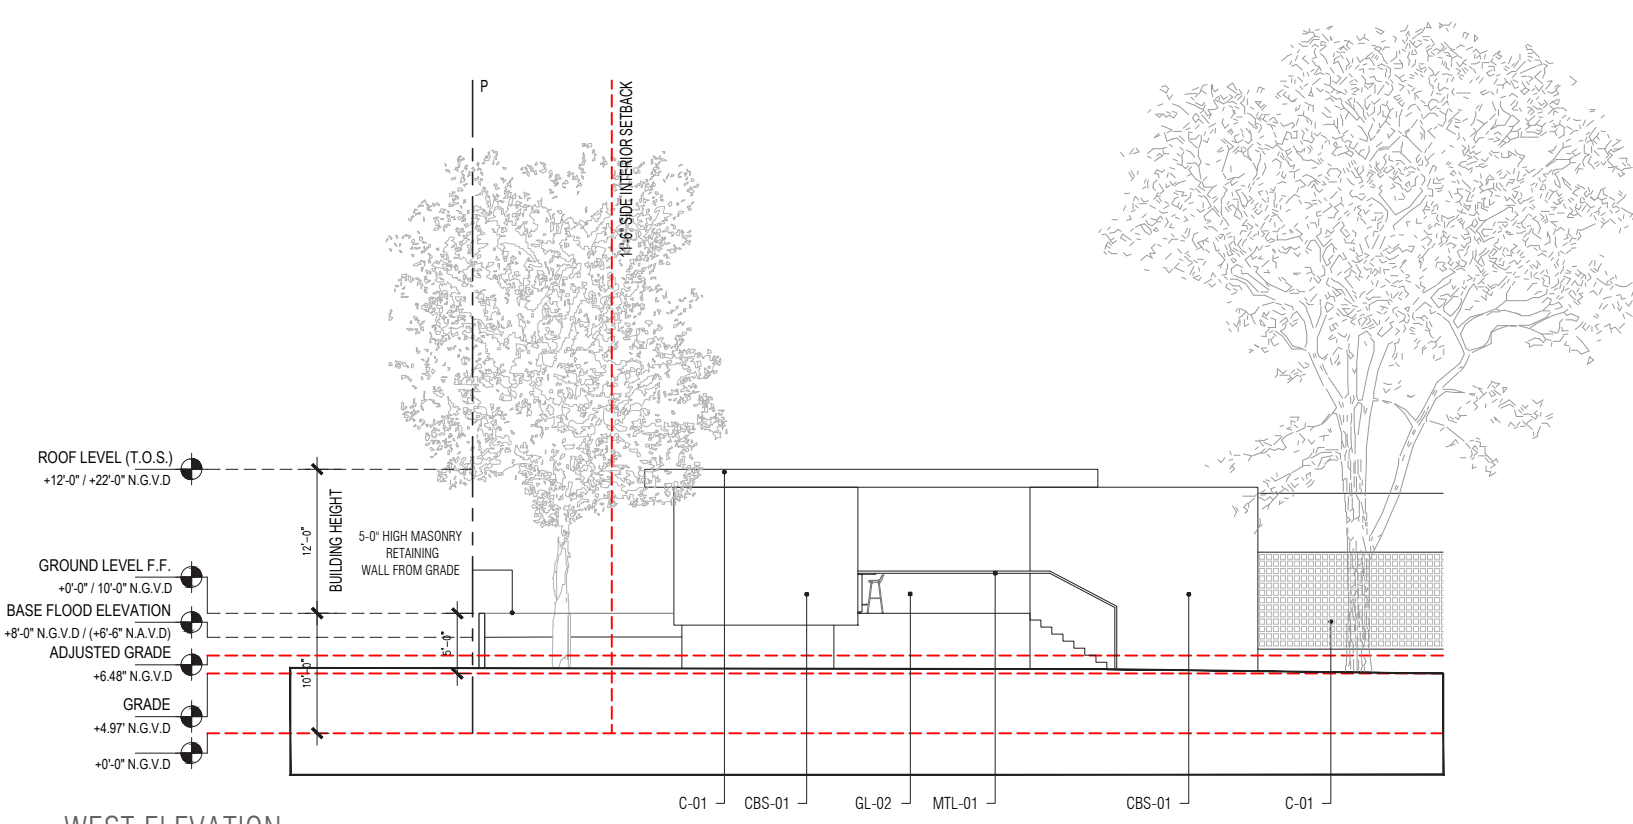

WEST ELEVATION

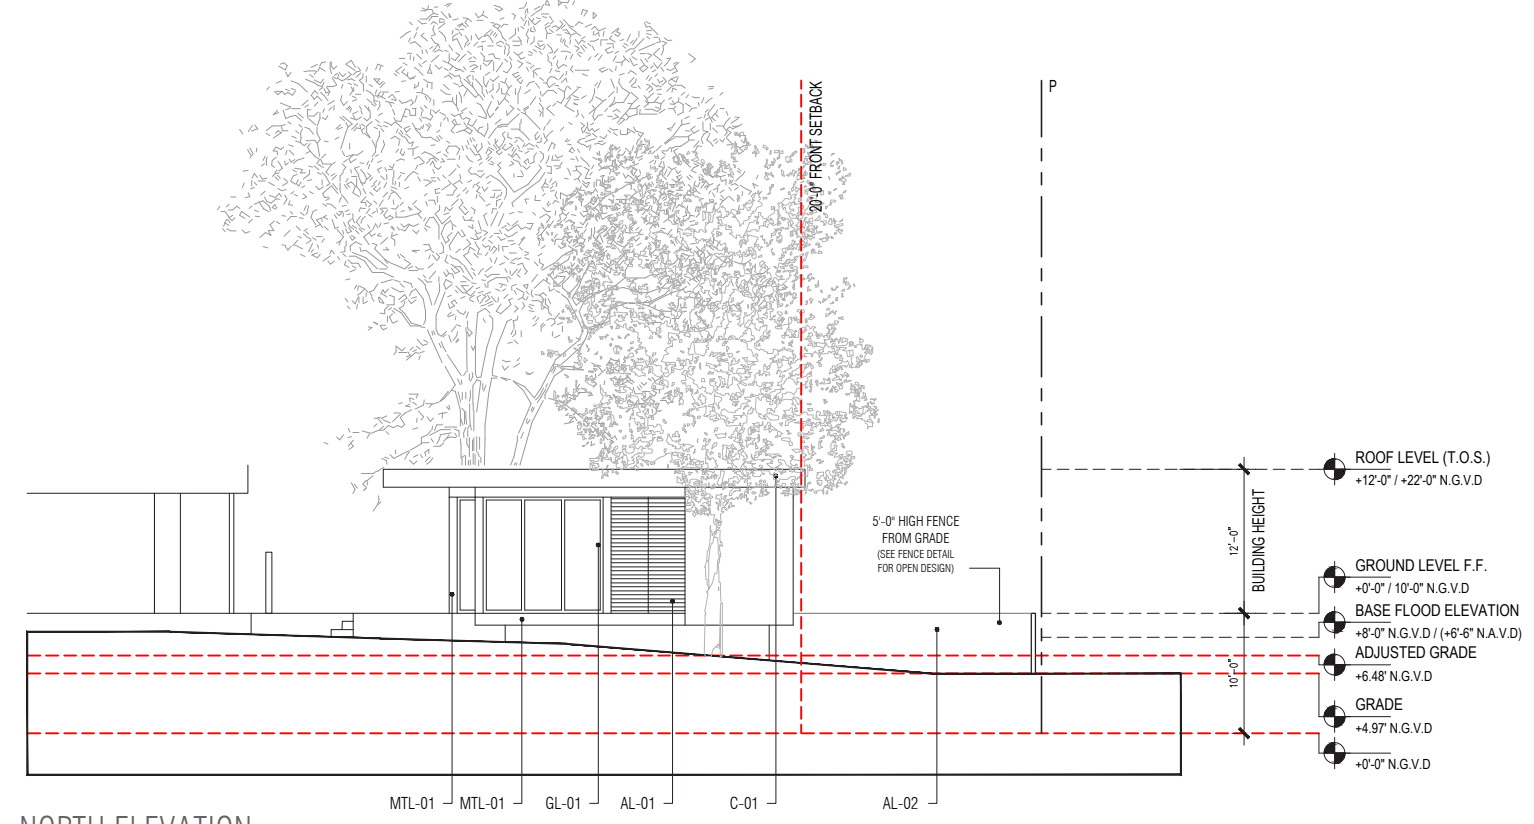


NORTH ELEVATION

31 LA GORCE RESIDENCE


31 LA GORCE CIRCLE, MIAMI BEACH, FLORIDA

TOUZET STUDIO
No copies, transmissions, reproductions or electronic manipulation of any portion of these drawings in whole or in part are to be made without the express written permission of Touzet Studio Design & Architecture. All designs indicated in these drawings are property of Touzet Studio Design & Architecture. All copyrights reserved (c) 2020.

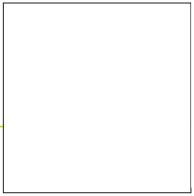

POOL CABANA ELEVATIONS


SCALE: 1/8" = 1'-0"

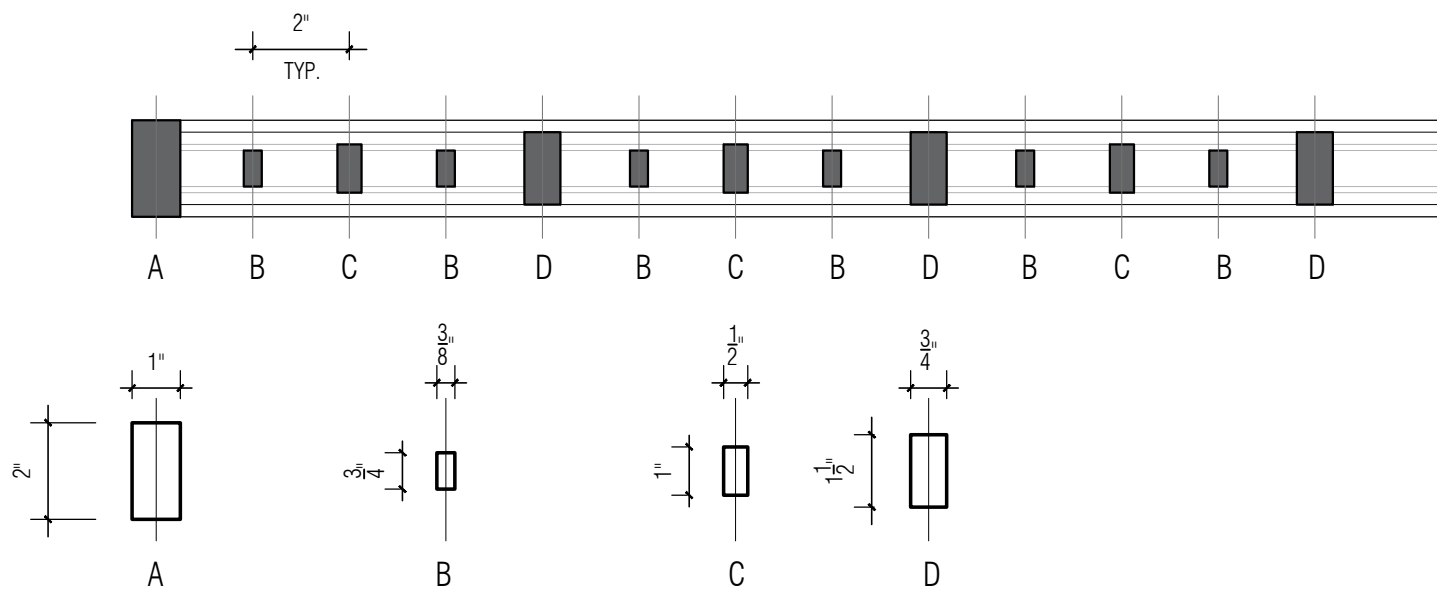

PLAN
SCALE: 3" = 1'-0"

MATERIAL LEGEND

AL-02 BLACK POWDER COAT FINISH, OR SIMILAR FINISH, ON ALUMINUM EXTRUSIONS DECORATIVE FENCE

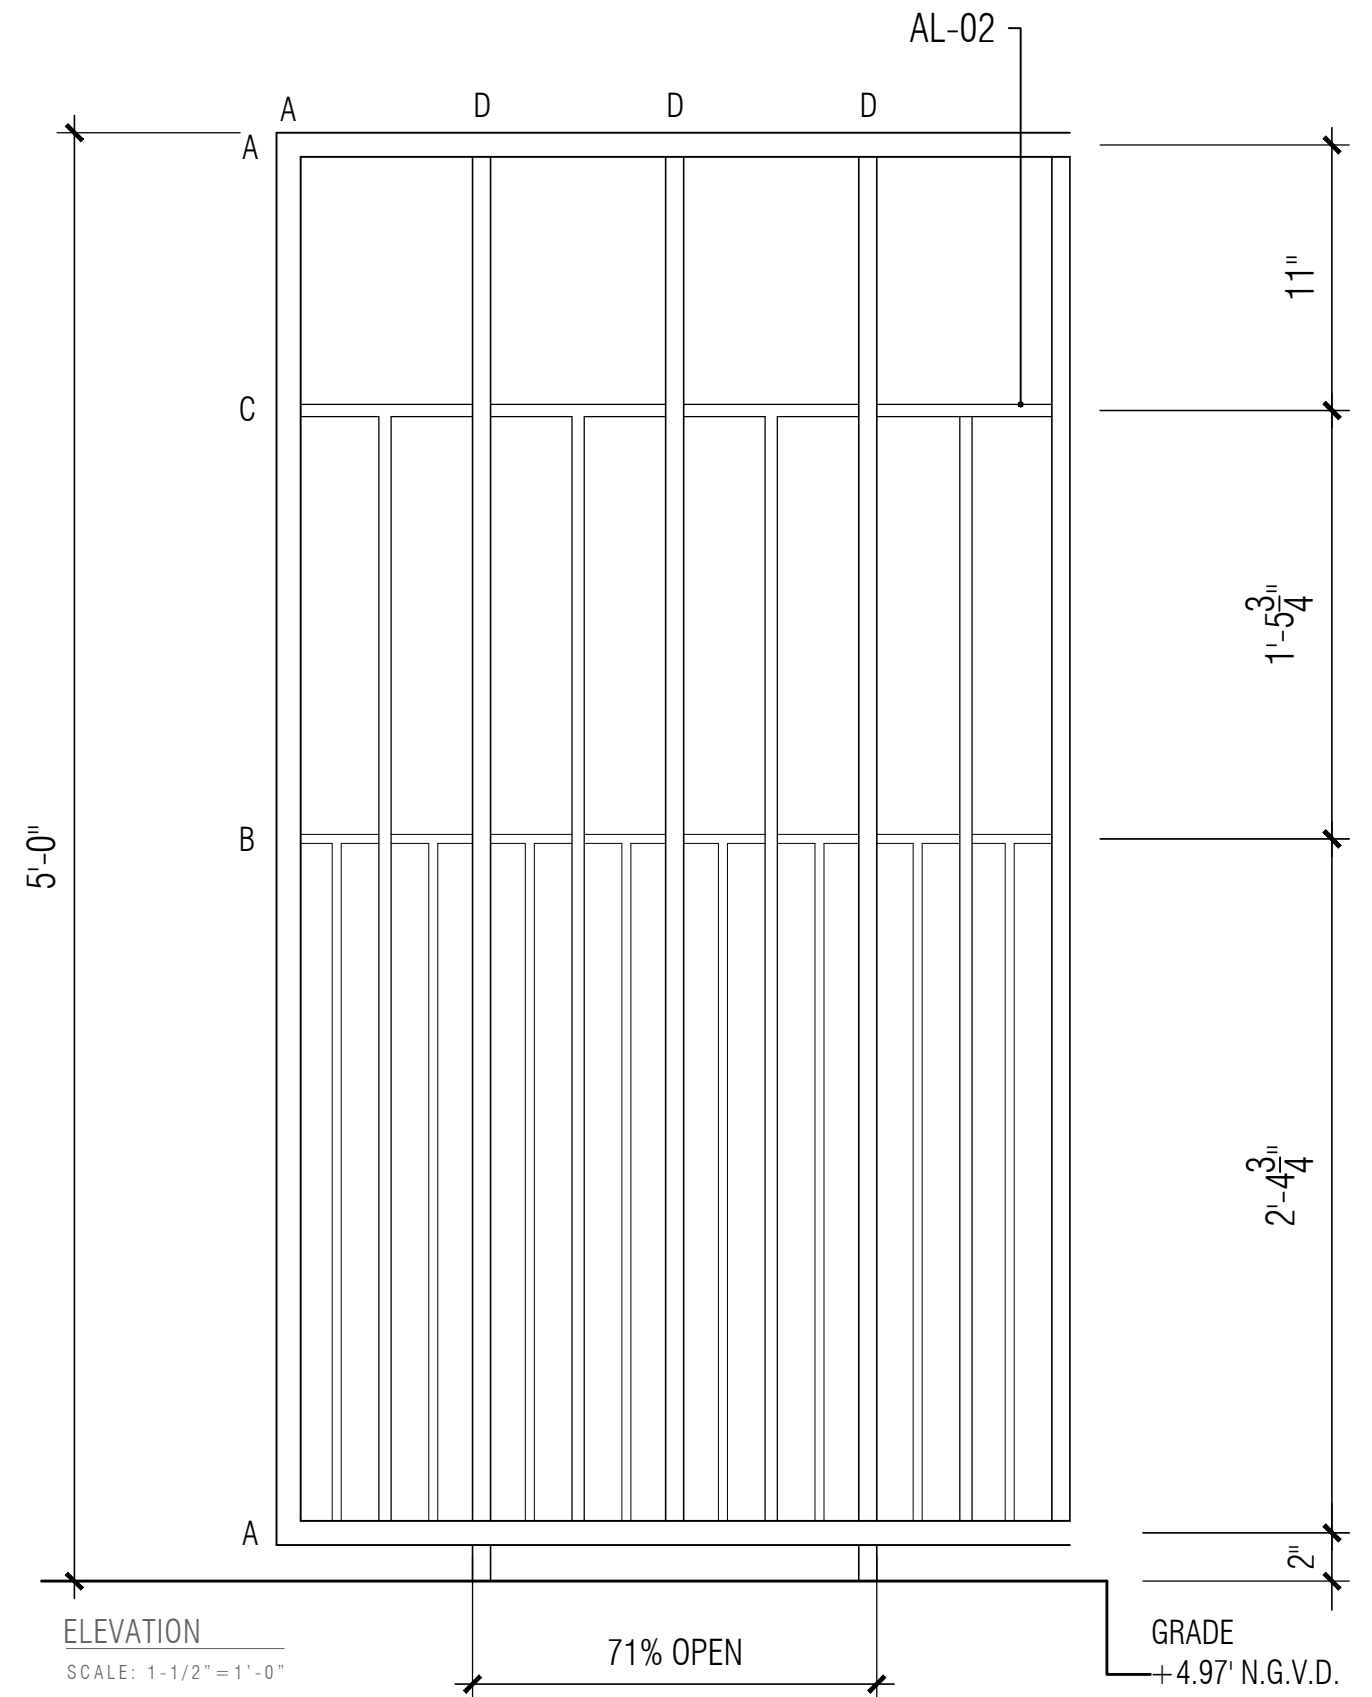


ELEVATION
SCALE: 1-1/2" = 1'-0"

31 LA GORCE RESIDENCE
31 LA GORCE CIRCLE, MIAMI BEACH, FLORIDA




No copies, transmissions, reproductions or electronic manipulation of any portion of these drawings in whole or in part are to be made without the express written permission of Touzet Studio Design & Architecture. All designs indicated in these drawings are property of Touzet Studio Design & Architecture. All copyrights reserved (c) 2020.

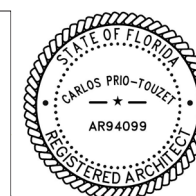


FENCE DETAIL
SCALE: N/A

A-35.3

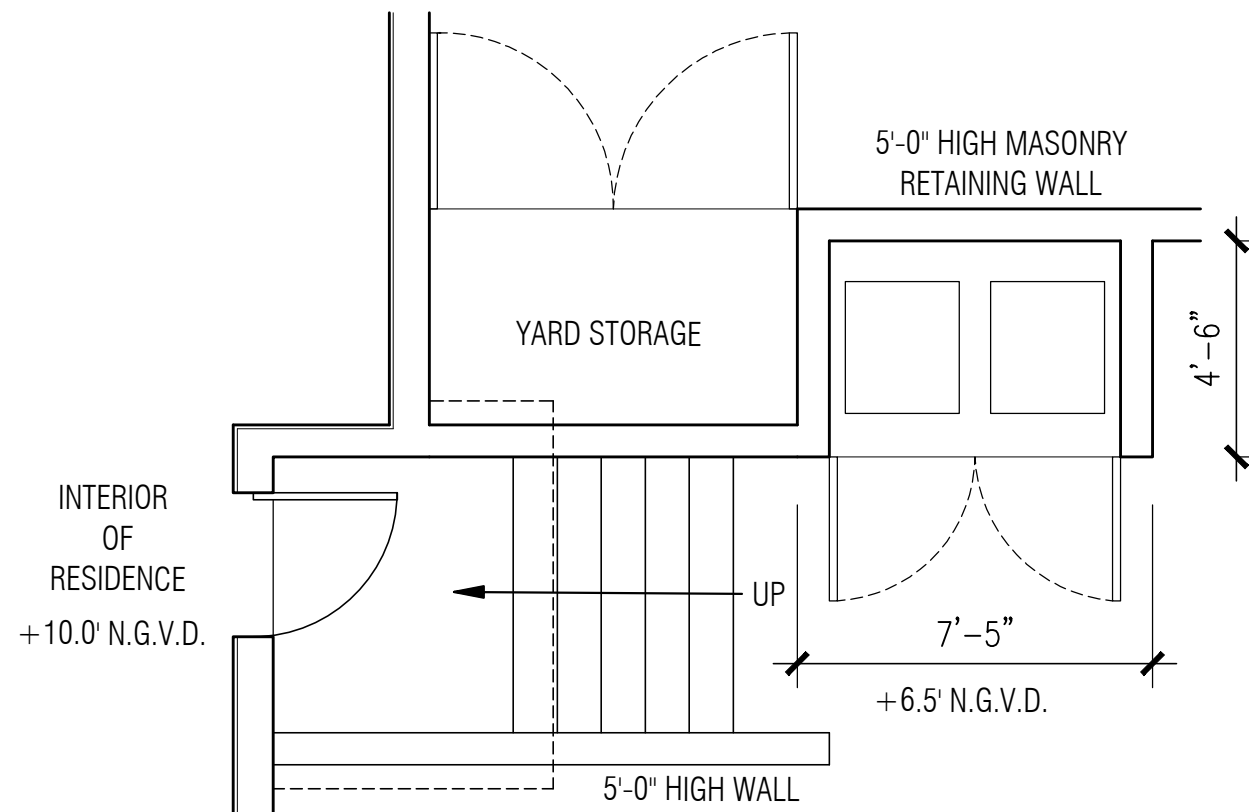

PLAN

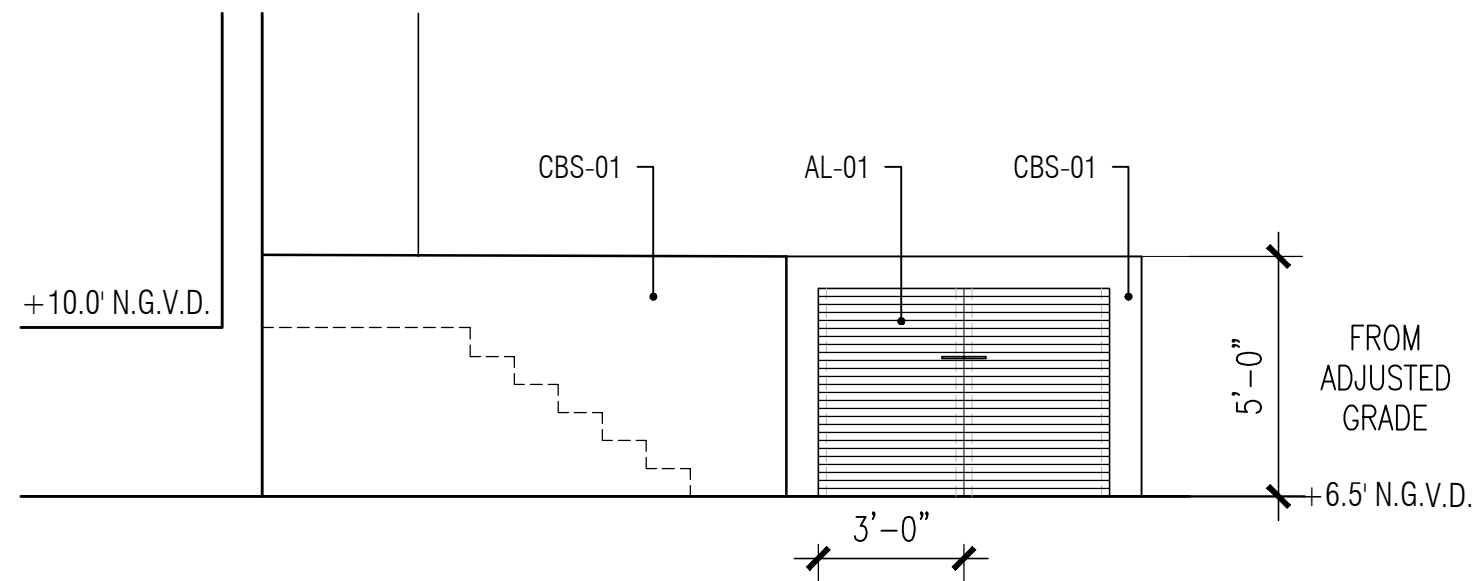

ELEVATION

MATERIAL LEGEND

AL-01 ALUMINUM MEMBERS AND STRUCTURAL ELEMENTS TO BE FINISHED IN WHITE KYNAR, OR SIMILAR FINISH


 
CBS-01 WHITE PAINTED STUCCO ON REINFORCED CONCRETE MASONRY WALL

31 LA GORCE RESIDENCE

31 LA GORCE CIRCLE, MIAMI BEACH, FLORIDA



No copies, transmissions, reproductions or electronic manipulation of any portion of these drawings in whole or in part are to be made without the express written permission of Touzet Studio Design & Architecture. All designs indicated in these drawings are property of Touzet Studio Design & Architecture. All copyrights reserved (c) 2020.

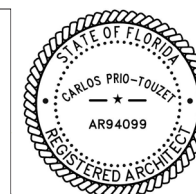

TRASH DETAIL
SCALE: 1/4" = 1'-0"

 
A-35.4



31 LA GORCE RESIDENCE
 31 LA GORCE CIRCLE, MIAMI BEACH, FLORIDA

TOUZET
 STUDIO

No copies, transmissions, reproductions or electronic manipulation of any portion of these drawings in whole or in part are to be made without the express written permission of Touzet Studio Design & Architecture. All designs indicated in these drawings are property of Touzet Studio Design & Architecture. All copyrights reserved (c) 2020.




VIEW FROM LA GORCE CIRCLE



31 LA GORCE RESIDENCE
 31 LA GORCE CIRCLE, MIAMI BEACH, FLORIDA

 TOUZET
STUDIO
 No copies, transmissions, reproductions or electronic manipulation of any portion of these drawings in whole or in part are to be made without the express written permission of Touzet Studio Design & Architecture. All designs indicated in these drawings are property of Touzet Studio Design & Architecture. All copyrights reserved (c) 2020.




VIEW FROM GARDEN



31 LA GORCE RESIDENCE
 31 LA GORCE CIRCLE, MIAMI BEACH, FLORIDA

TOUZET
STUDIO
 ARCHITECTURE

 No copies, transmissions, reproductions or electronic manipulation of any portion of these drawings in whole or in part are to be made without the express written permission of Touzet Studio Design & Architecture. All designs indicated in these drawings are property of Touzet Studio Design & Architecture. All copyrights reserved (c) 2020.




VIEW FROM POOL CABANA



31 LA GORCE RESIDENCE
 31 LA GORCE CIRCLE, MIAMI BEACH, FLORIDA

 TOUZET
STUDIO
 No copies, transmissions, reproductions or electronic manipulation of any portion of these drawings in whole or in part are to be made without the express written permission of Touzet Studio Design & Architecture. All designs indicated in these drawings are property of Touzet Studio Design & Architecture. All copyrights reserved (c) 2020.




VIEW FROM FAMILY ROOM



31 LA GORCE RESIDENCE
 31 LA GORCE CIRCLE, MIAMI BEACH, FLORIDA

 TOUZET
STUDIO
 No copies, transmissions, reproductions or electronic manipulation of any portion of these drawings in whole or in part are to be made without the express written permission of Touzet Studio Design & Architecture. All designs indicated in these drawings are property of Touzet Studio Design & Architecture. All copyrights reserved (c) 2020.




VIEW FROM BREVITY LANE



31 LA GORCE RESIDENCE
 31 LA GORCE CIRCLE, MIAMI BEACH, FLORIDA

TOUZET
STUDIO
 ARCHITECTURE

 No copies, transmissions, reproductions or electronic manipulation of any portion of these drawings in whole or in part are to be made without the express written permission of Touzet Studio Design & Architecture. All designs indicated in these drawings are property of Touzet Studio Design & Architecture. All copyrights reserved (c) 2020.



VIEW FROM LA GORCE CIRCLE