


FLOOD VENT CALCULATIONS:

TOTAL GARAGE AREA = 481 SQ. FT.
FLOOD VENT REQUIRED = 481 SQ. INCHES
ENGINEERED FLOOD VENTS = BLOCK WALL
"SMART VENTS" = 200 SQ. INCHES EA.
200 SQ. IN. x 3 VENTS = 600 SQ. INCHES
CALCULATIONS ARE BASED ON "SMART VENT" MODEL
S40-S40, CERTIFICATION: FL 5602-R2

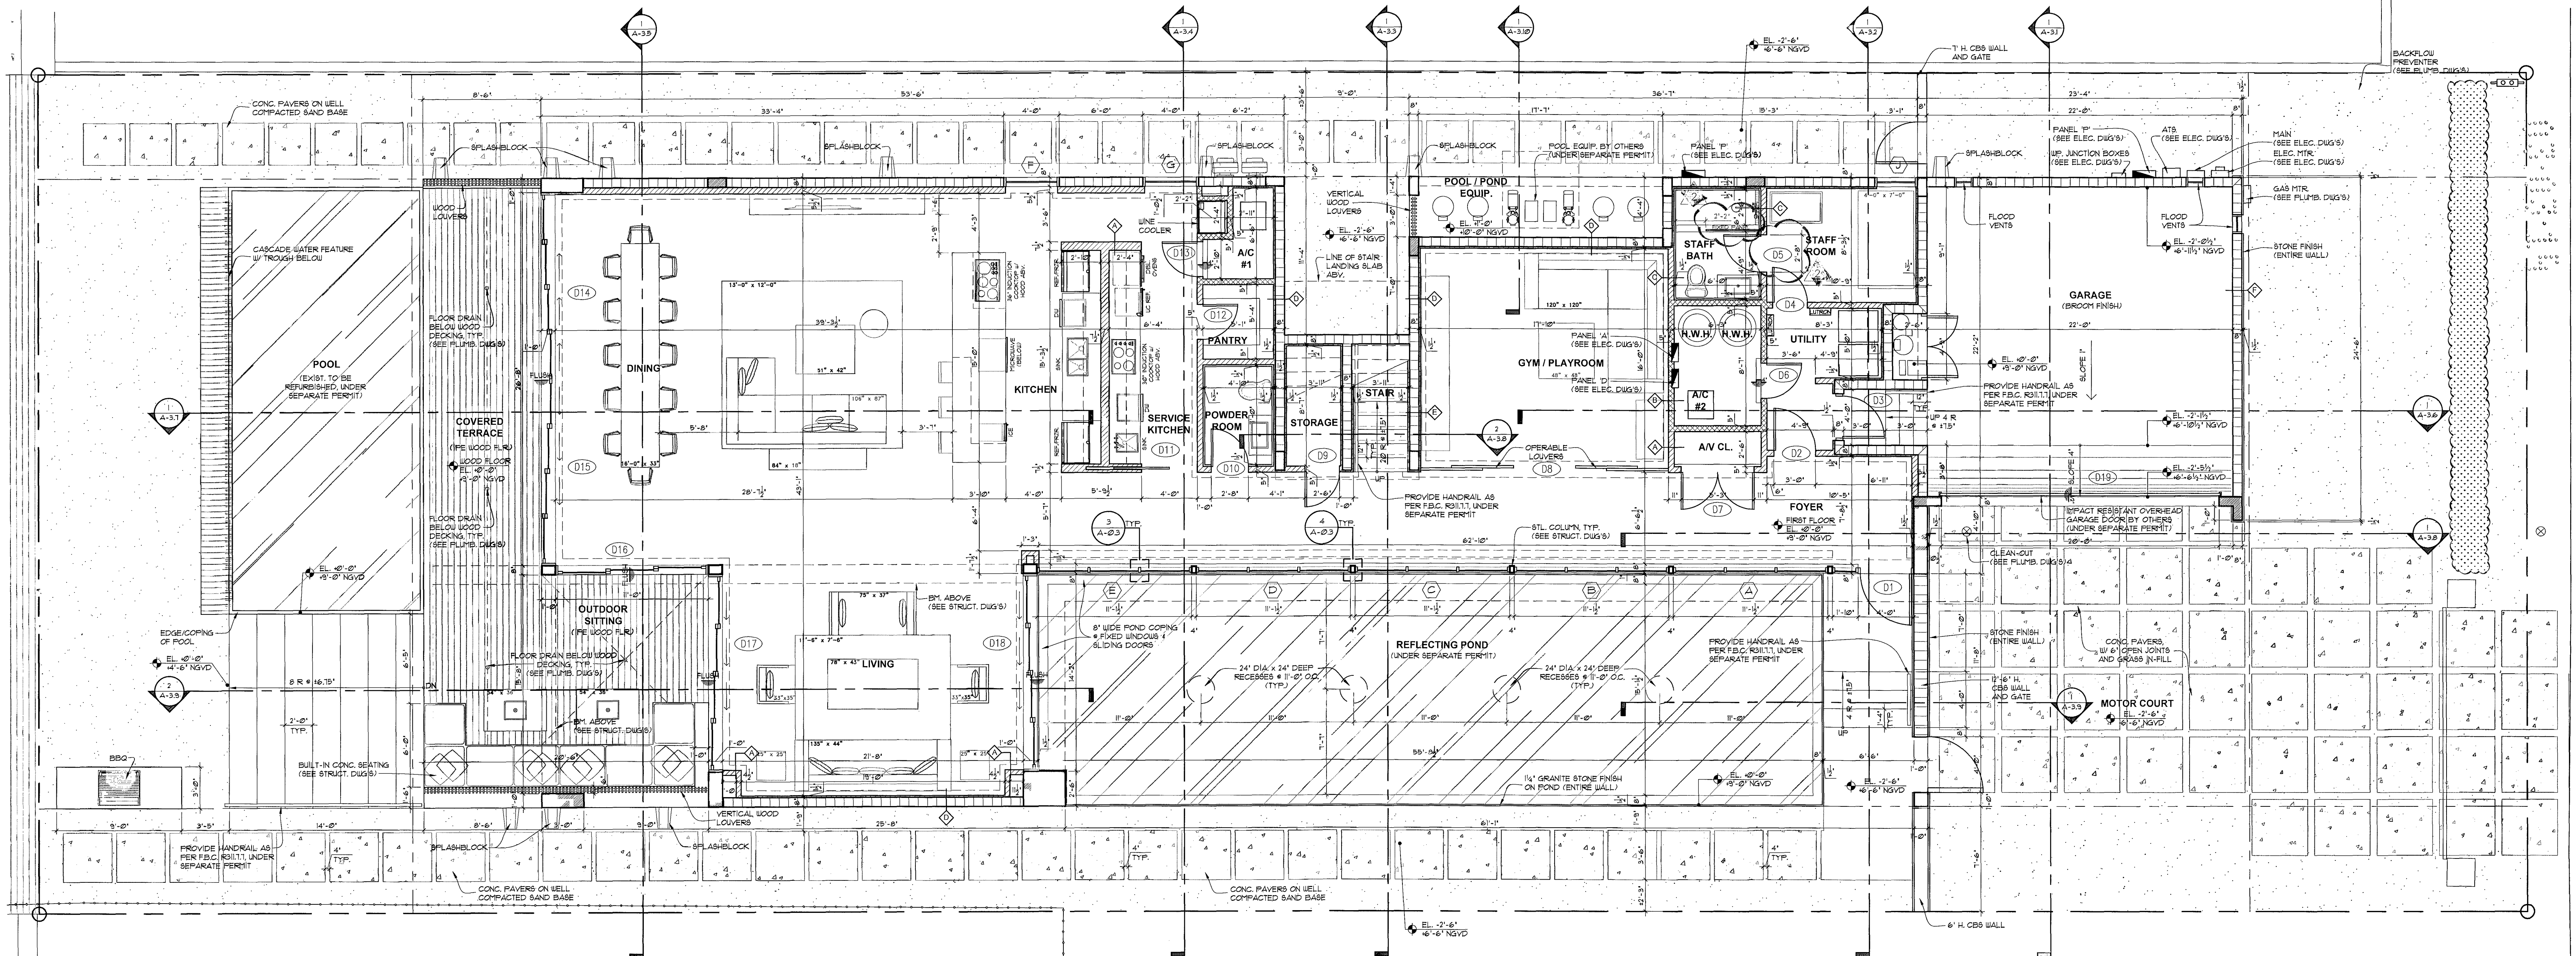

WALL LEGEND	
	CONC. COLUMN
	CONC. BLOCK WALL
	INTERIOR PARTITION
	SOUND INSULATED INTERIOR PARTITION

1 FIRST FLOOR PLAN
A-U SCALE 3/16" = 1'-0"

choeff +levy p.a.
architecture interior design

8425 biscayne blvd, suite 201
miami, florida 33138

www.choefflevy.com
AR0009679 - AR0094779

Phone: 305.434.8338
Fax: 305.892.5292

DILIDO RESIDENCE

808 WEST DILIDO DR. MIAMI BEACH, FL 33139

comm no.
1241

date:
09-30-13

revised:

sheet no.

A-1.1

02-07-2014
B.D. REV.

[Signature]
FEB 07 2014


FLOOD VENT CALCULATIONS:

TOTAL GARAGE AREA = 481 SQ. FT.

FLOOD VENT REQUIRED = 481 SQ. INCHES

ENGINEERED FLOOD VENTS = BLOCK WALL
"SMART VENTS" = 200 SQ. INCHES EA.
200 SQ. IN. X 3 VENTS = 600 SQ. INCHES

CALCULATIONS ARE BASED ON "SMART VENT" MODEL
B4P-310, CERTIFICATION R. #827-92

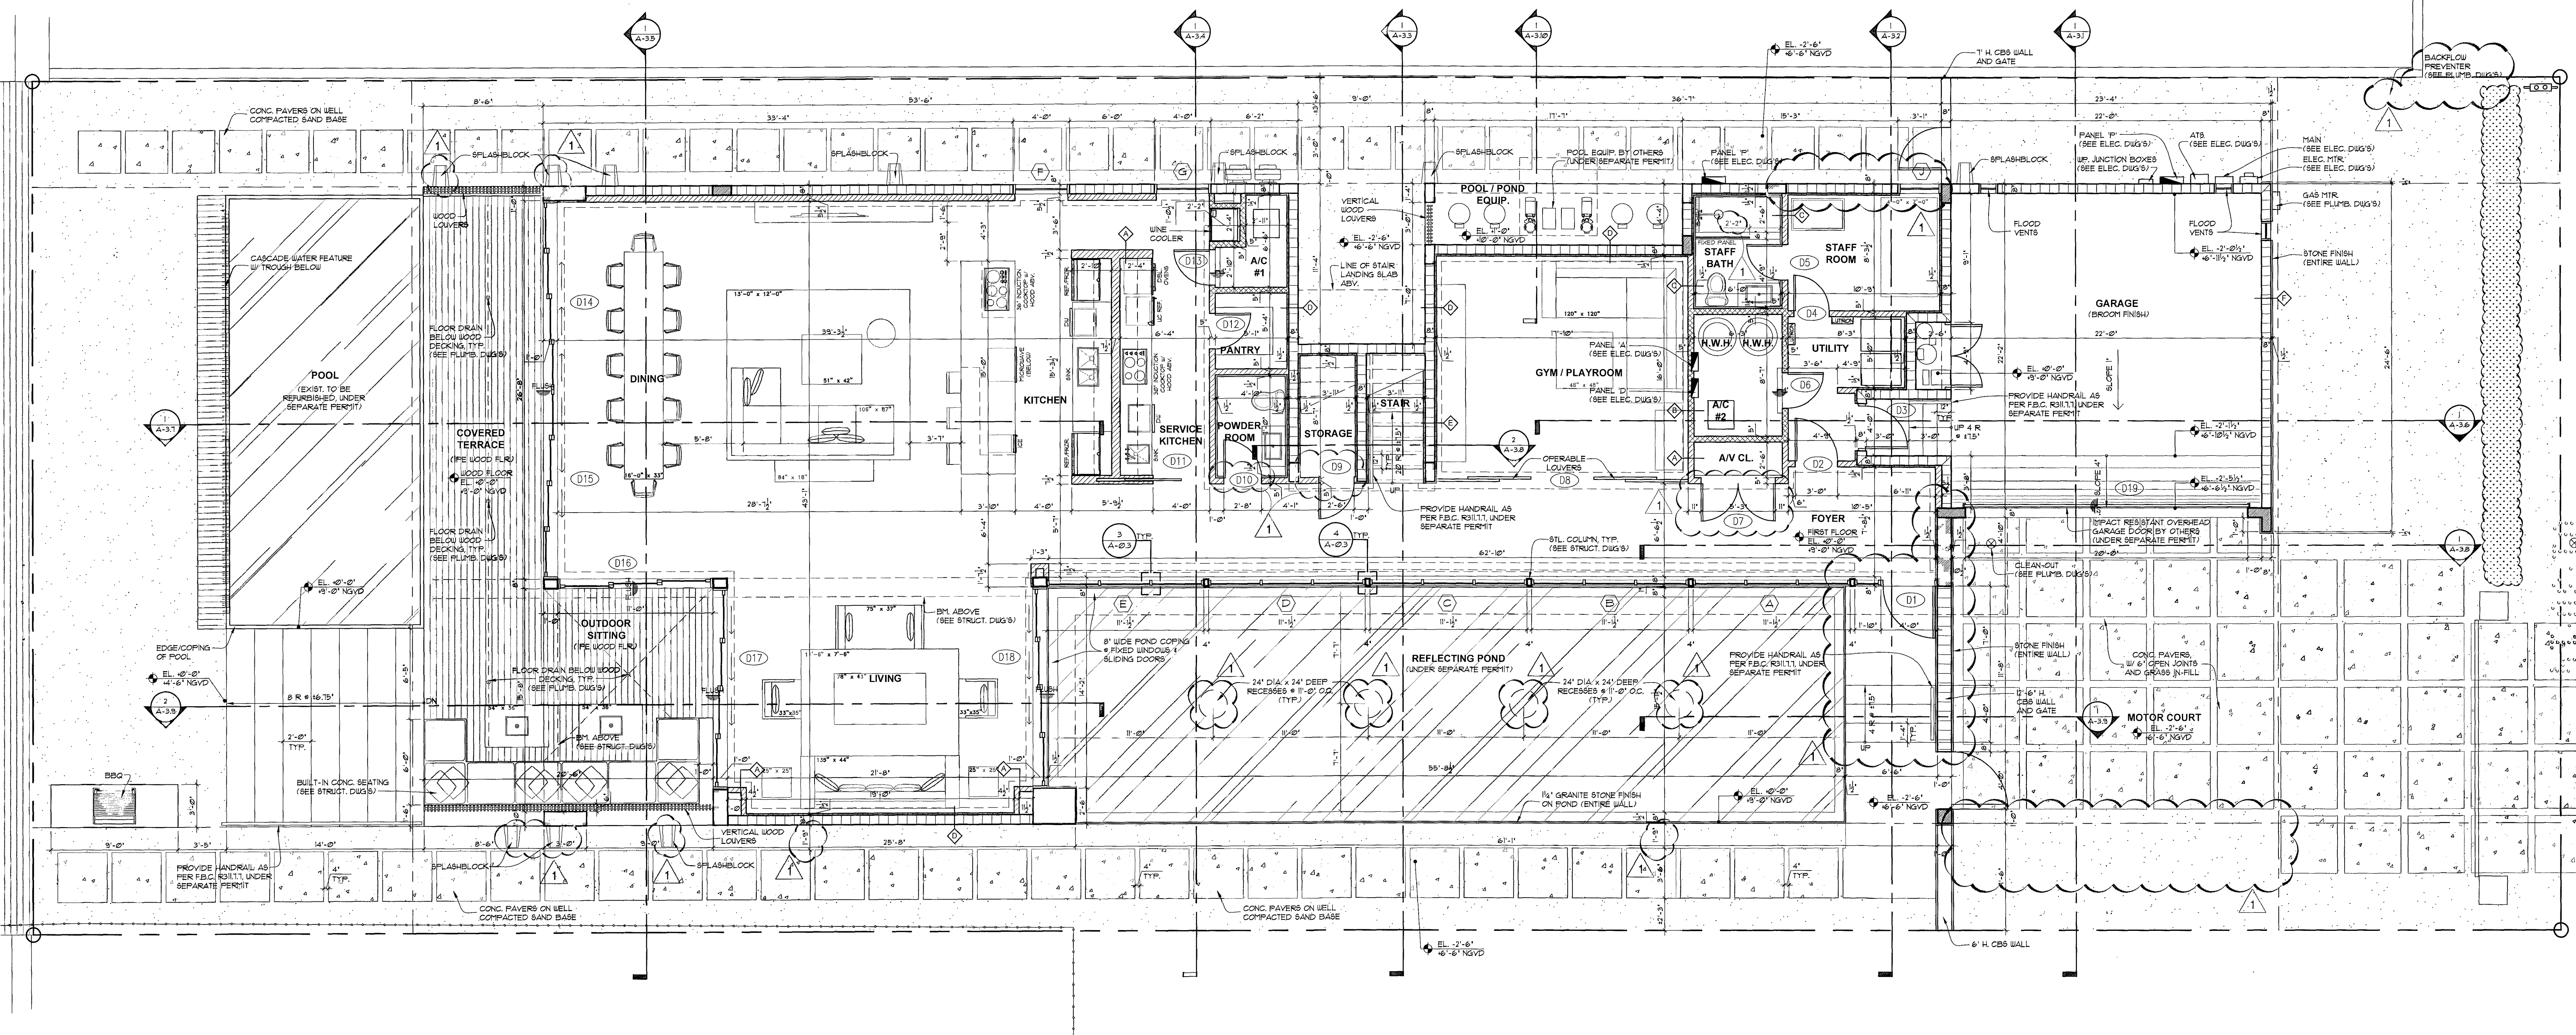

WALL LEGEND	
	CONC. COLUMN
	CONC. BLOCK WALL
	INTERIOR PARTITION
	SOUND INSULATED INTERIOR PARTITION

1 FIRST FLOOR PLAN
A-11 SCALE 3/16" = 1'-0"

choeff + levy p.a.
architecture interior design

8425 biscayne blvd, suite 201
miami, florida 33138
www.choefflevy.com
AR0009679 AR0094779
Phone: 305.434.8338
Fax: 305.892.5292

DILIDO RESIDENCE
808 WEST DILIDO DR. MIAMI BEACH, FL 33139

comm no.
1241


date:
09-30-13

revised:
01-06-2014
OWNER REV.

sheet no.
A-1.1

[Signature]
JAN 20 2014

FLOOD VENT CALCULATIONS:
 TOTAL GARAGE AREA = 481 SQ. FT.
 FLOOD VENT REQUIRED = 481 SQ. INCHES
 ENGINEERED FLOOD VENTS = BLOCK WALL
 'SMART VENTS' = 200 SQ. INCHES EA
 200 SQ. IN. x 3 VENTS = 600 SQ. INCHES
 CALCULATIONS ARE BASED ON 'SMART VENT' MODEL
 B40-310, CERTIFICATION: FL 5602-R2

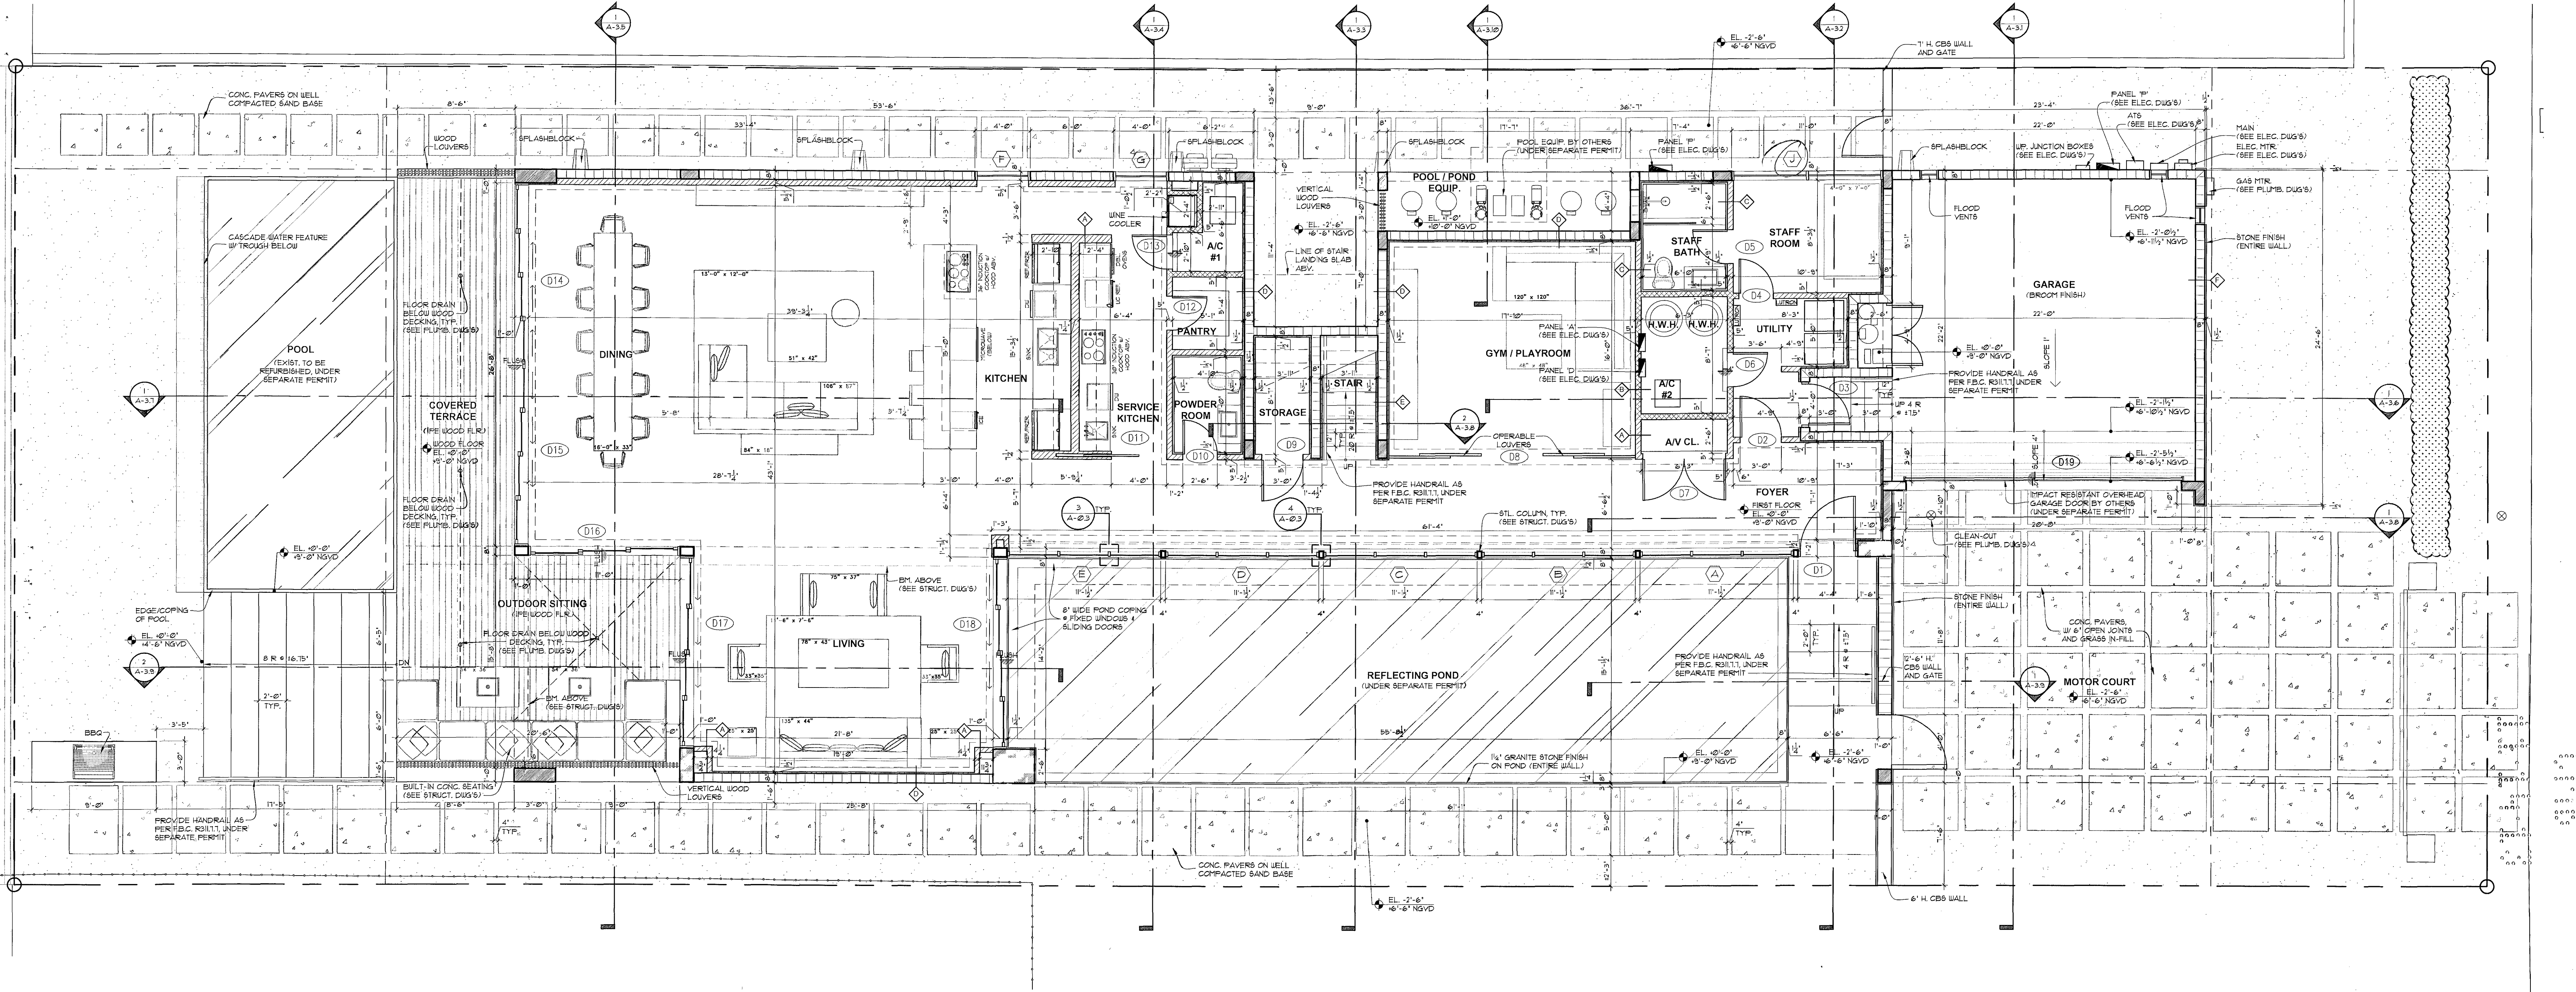

WALL LEGEND

[Symbol]	CONC. COLUMN
[Symbol]	CONC. BLOCK WALL
[Symbol]	INTERIOR PARTITION
[Symbol]	SOUND INSULATED INTERIOR PARTITION

1 FIRST FLOOR PLAN
 A-1.1 SCALE 3/16" = 1'-0"

choeff + levy p.a.
 architecture interior design

8425 biscayne blvd, suite 201
 miami, florida 33138
 www.choefflevy.com
 AR0009679 AR0094779
 Phone: 305.434.8338
 Fax: 305.892.5292

DILIDO RESIDENCE
 808 WEST DILIDO DR. MIAMI BEACH, FL 33139


comm no.
1241

date:
 09-30-13

revised:

sheet no.
A-1.1

[Handwritten signature]
 NOV 08 2013

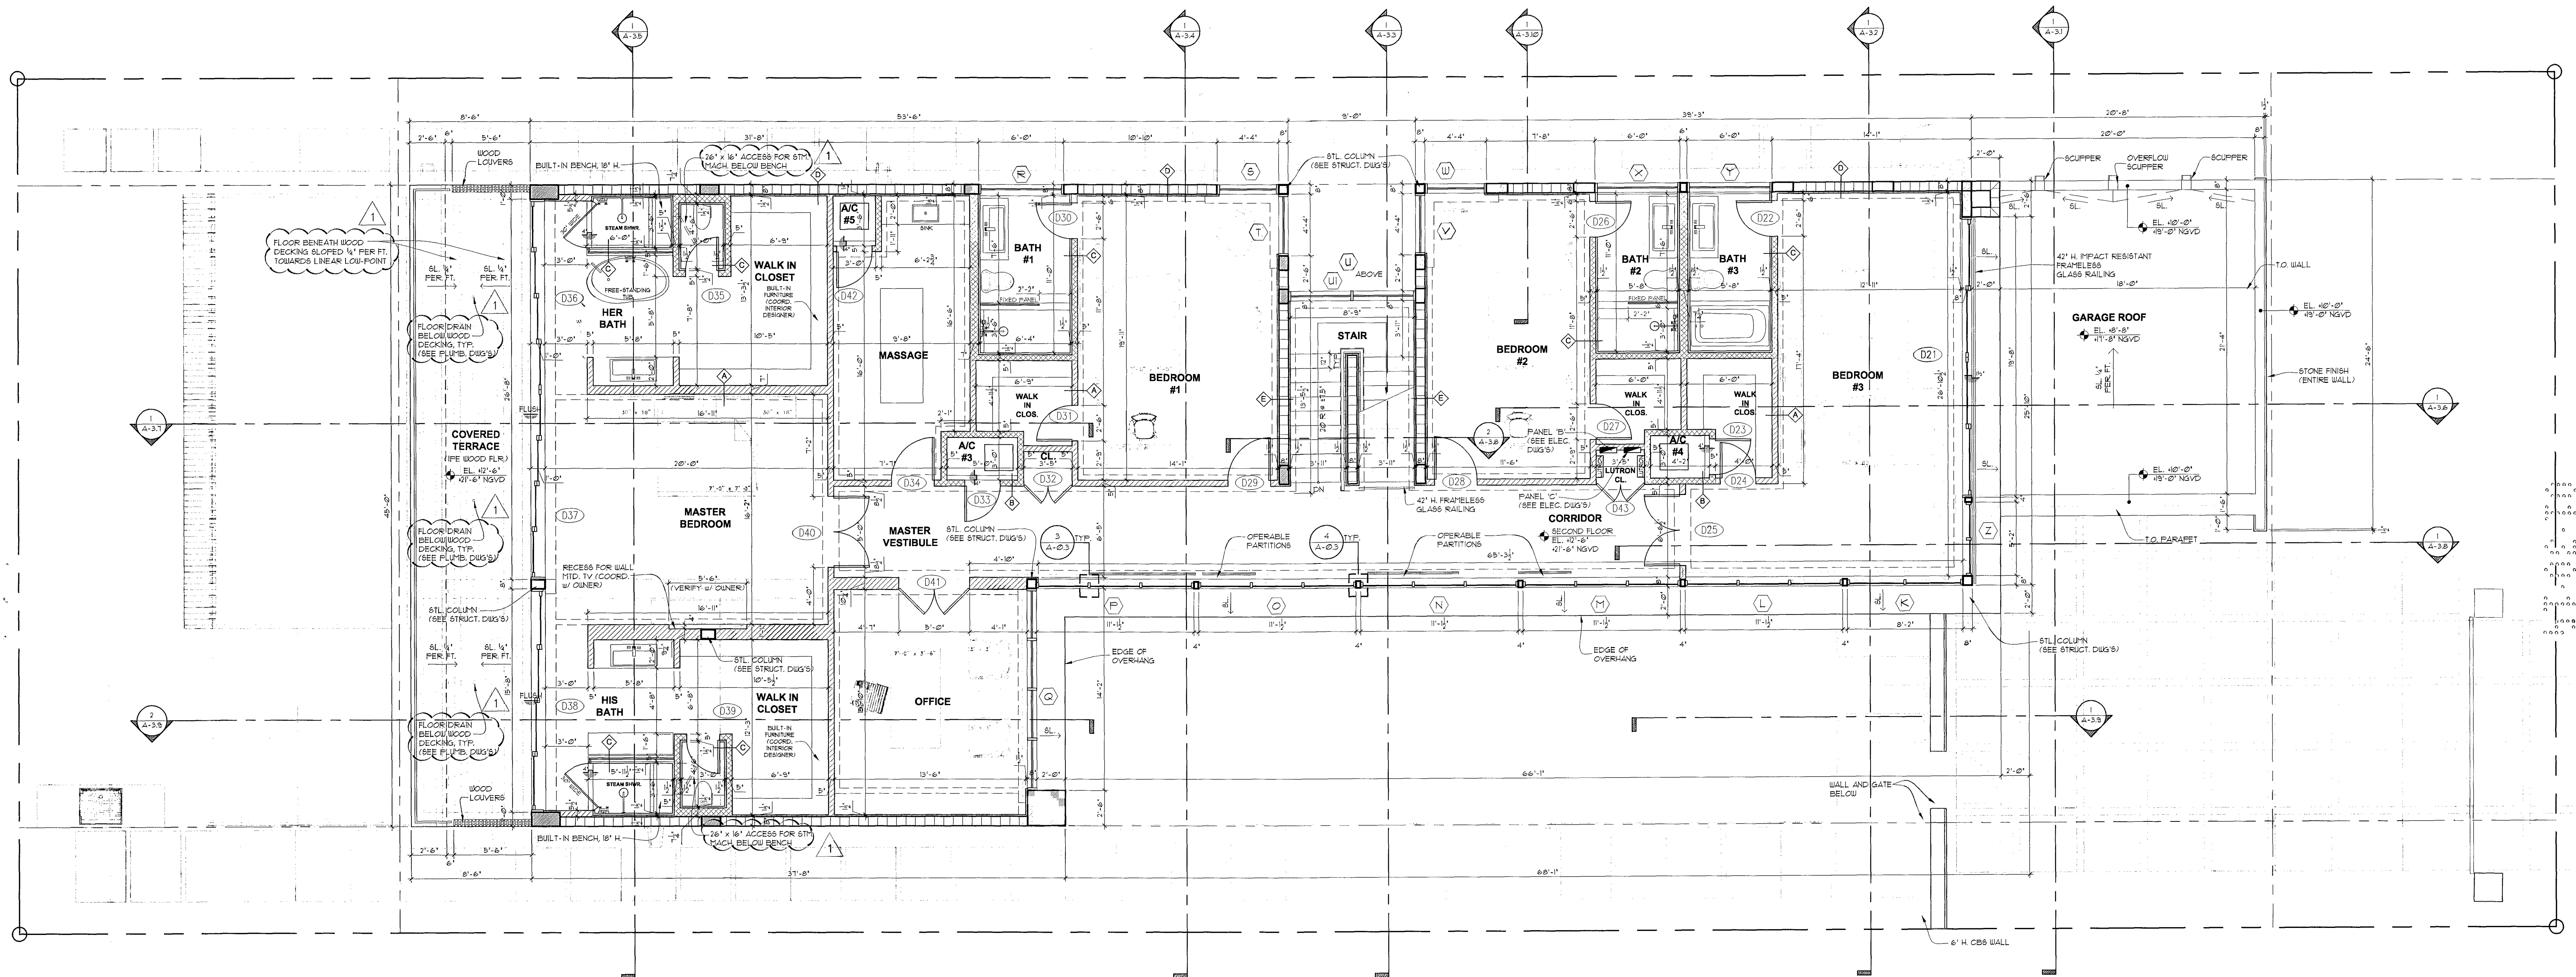

WALL LEGEND	
	CONC. COLUMN
	CONC. BLOCK WALL
	INTERIOR PARTITION
	SOUND INSULATED INTERIOR PARTITION

1 SECOND FLOOR PLAN
A-12 SCALE 3/16" = 1'-0"

choefflevy p.a.
architectural interior design

8425 biscayne blvd, suite 201
miami, florida 33138

www.choefflevy.com
AR0009679 - AR0094779

Phone: 305.434.8338
Fax: 305.892.5292

DILIDO RESIDENCE

808 WEST DILIDO DR. MIAMI BEACH, FL 33139

comm no.
1241

date:
09-30-13

revised:
01-06-2014
OWNER REV.

sheet no.
A-1.2

[Handwritten signature]
10/20/2014

DILIDO RESIDENCE

808 WEST DILIDO DR. MIAMI BEACH, FL 33139

comm no.
1241



date:
09-30-13

revised:



sheet no.
A-1.2

WALL LEGEND	
	CONC. COLUMN
	CONC. BLOCK WALL
	INTERIOR PARTITION
	SOUND INSULATED INTERIOR PARTITION

 
1 SECOND FLOOR PLAN
SCALE 3/16" = 1'-0"

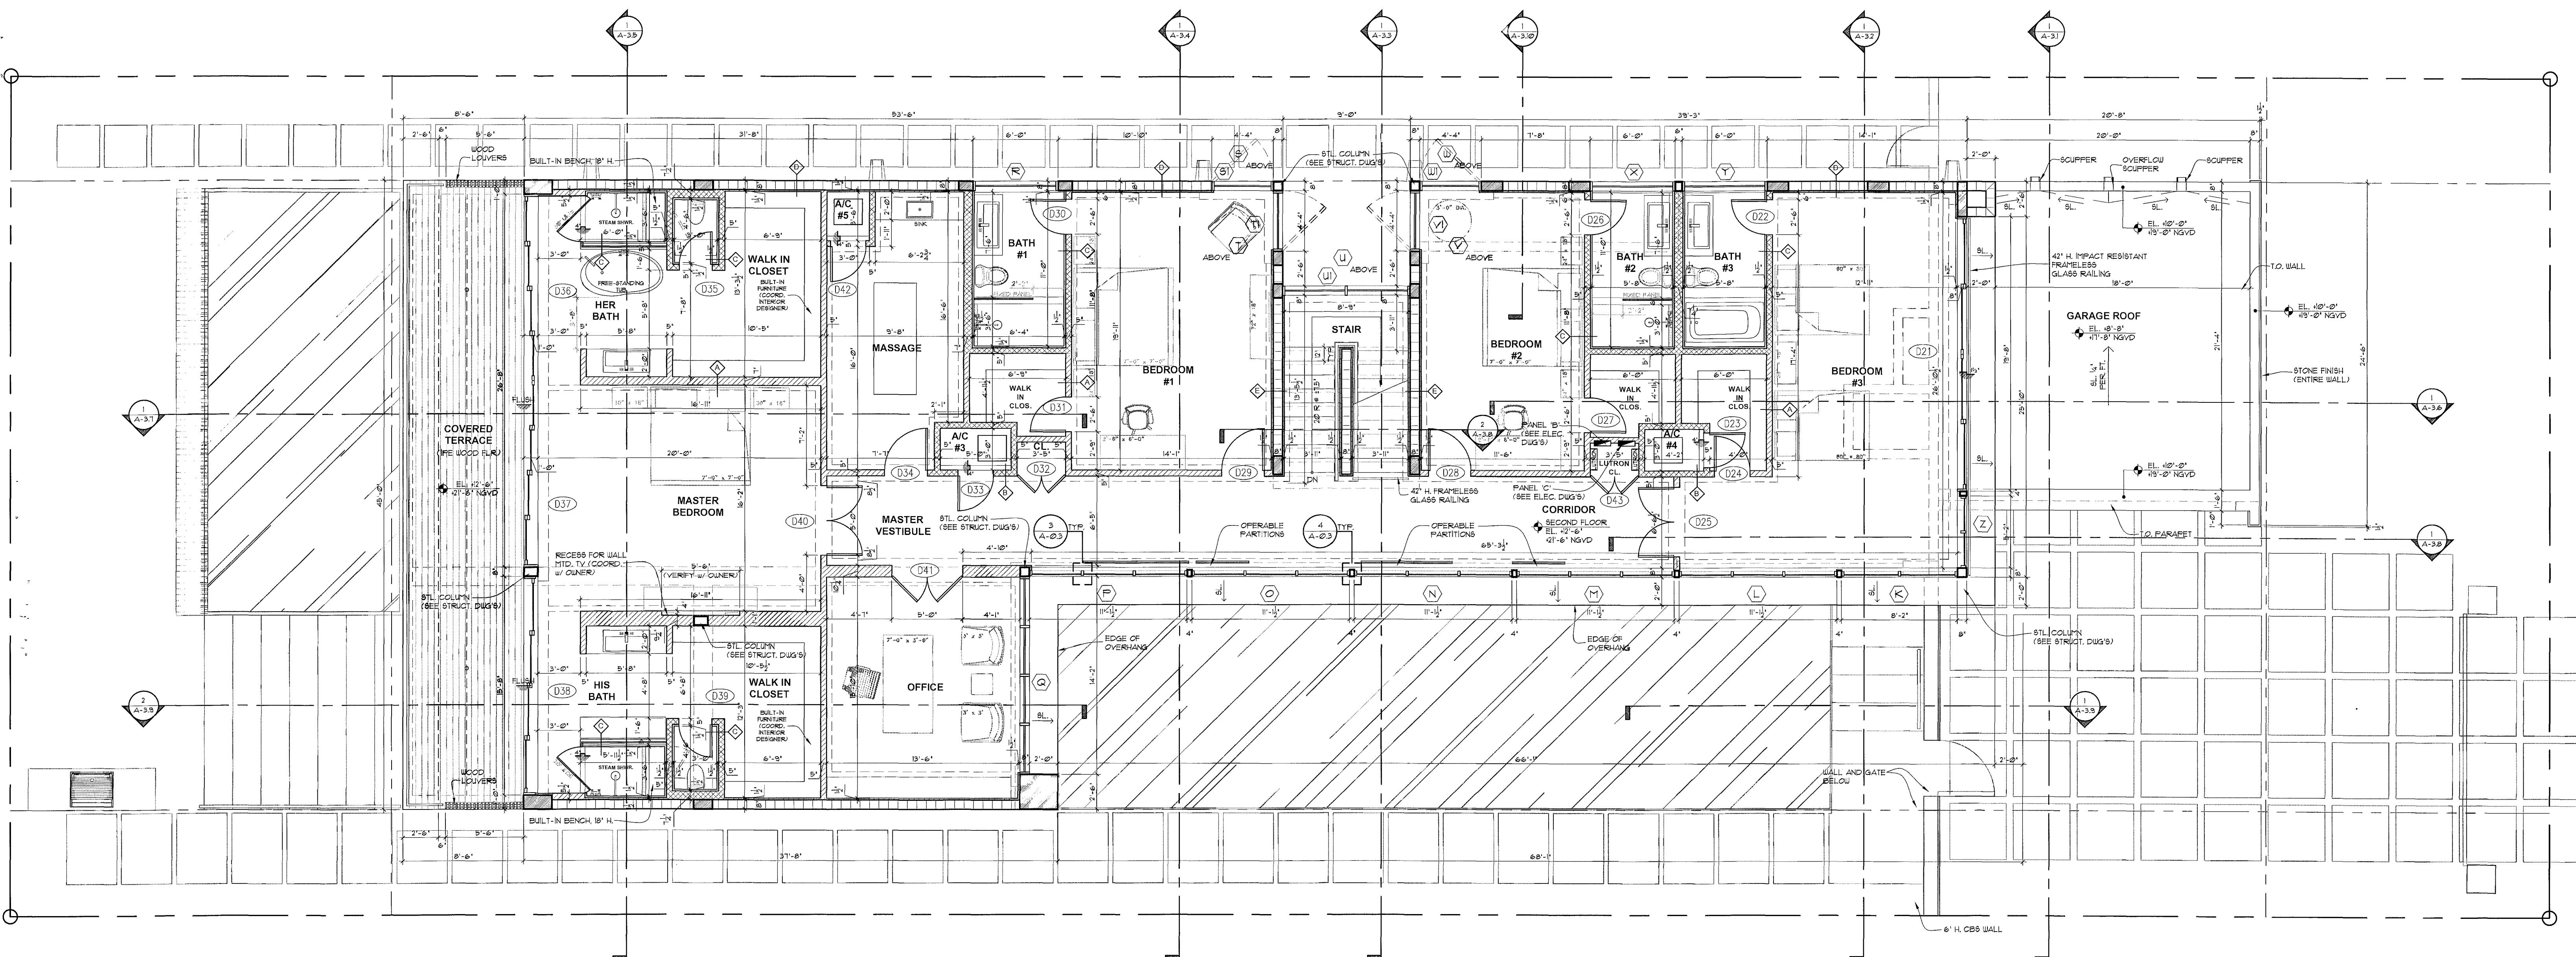

[Signature]
NOV 05 2013

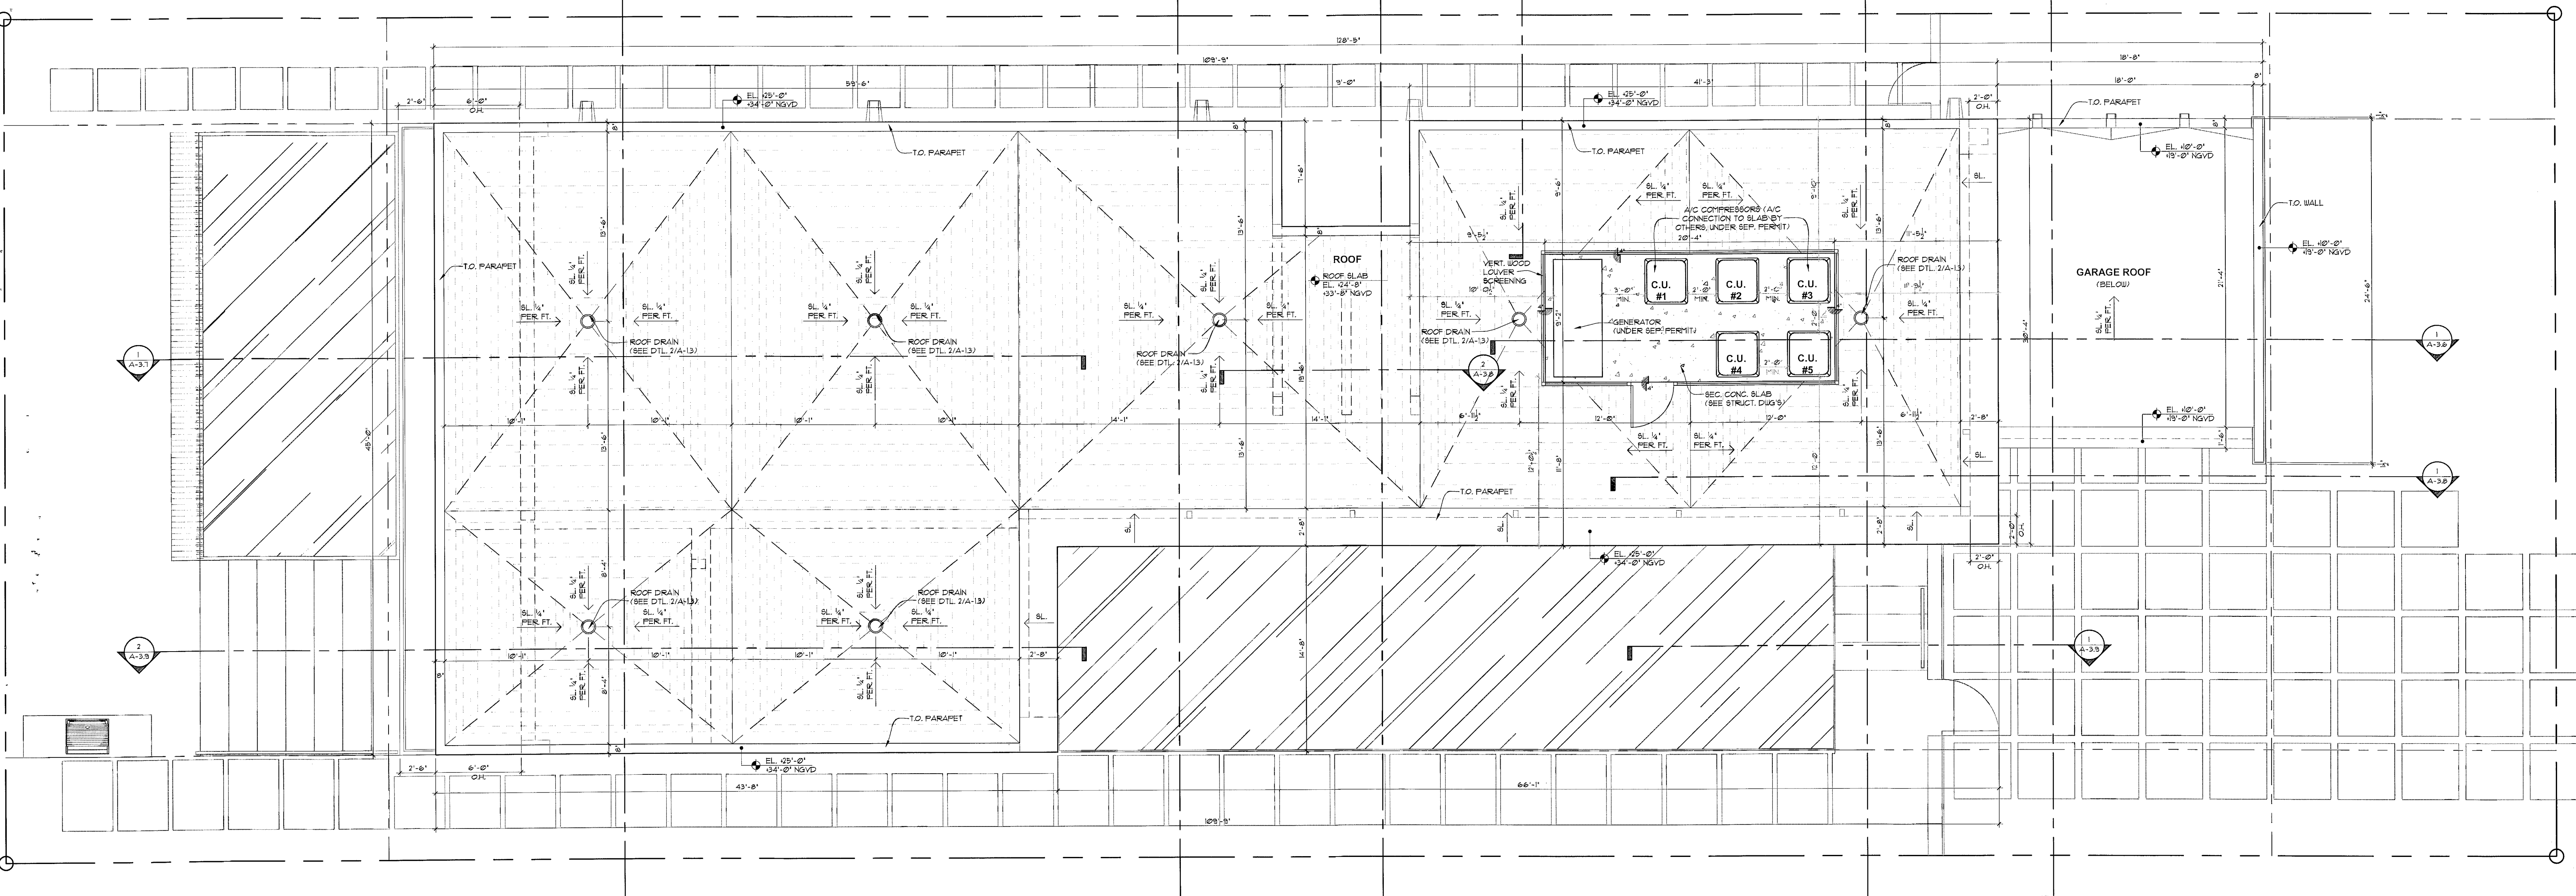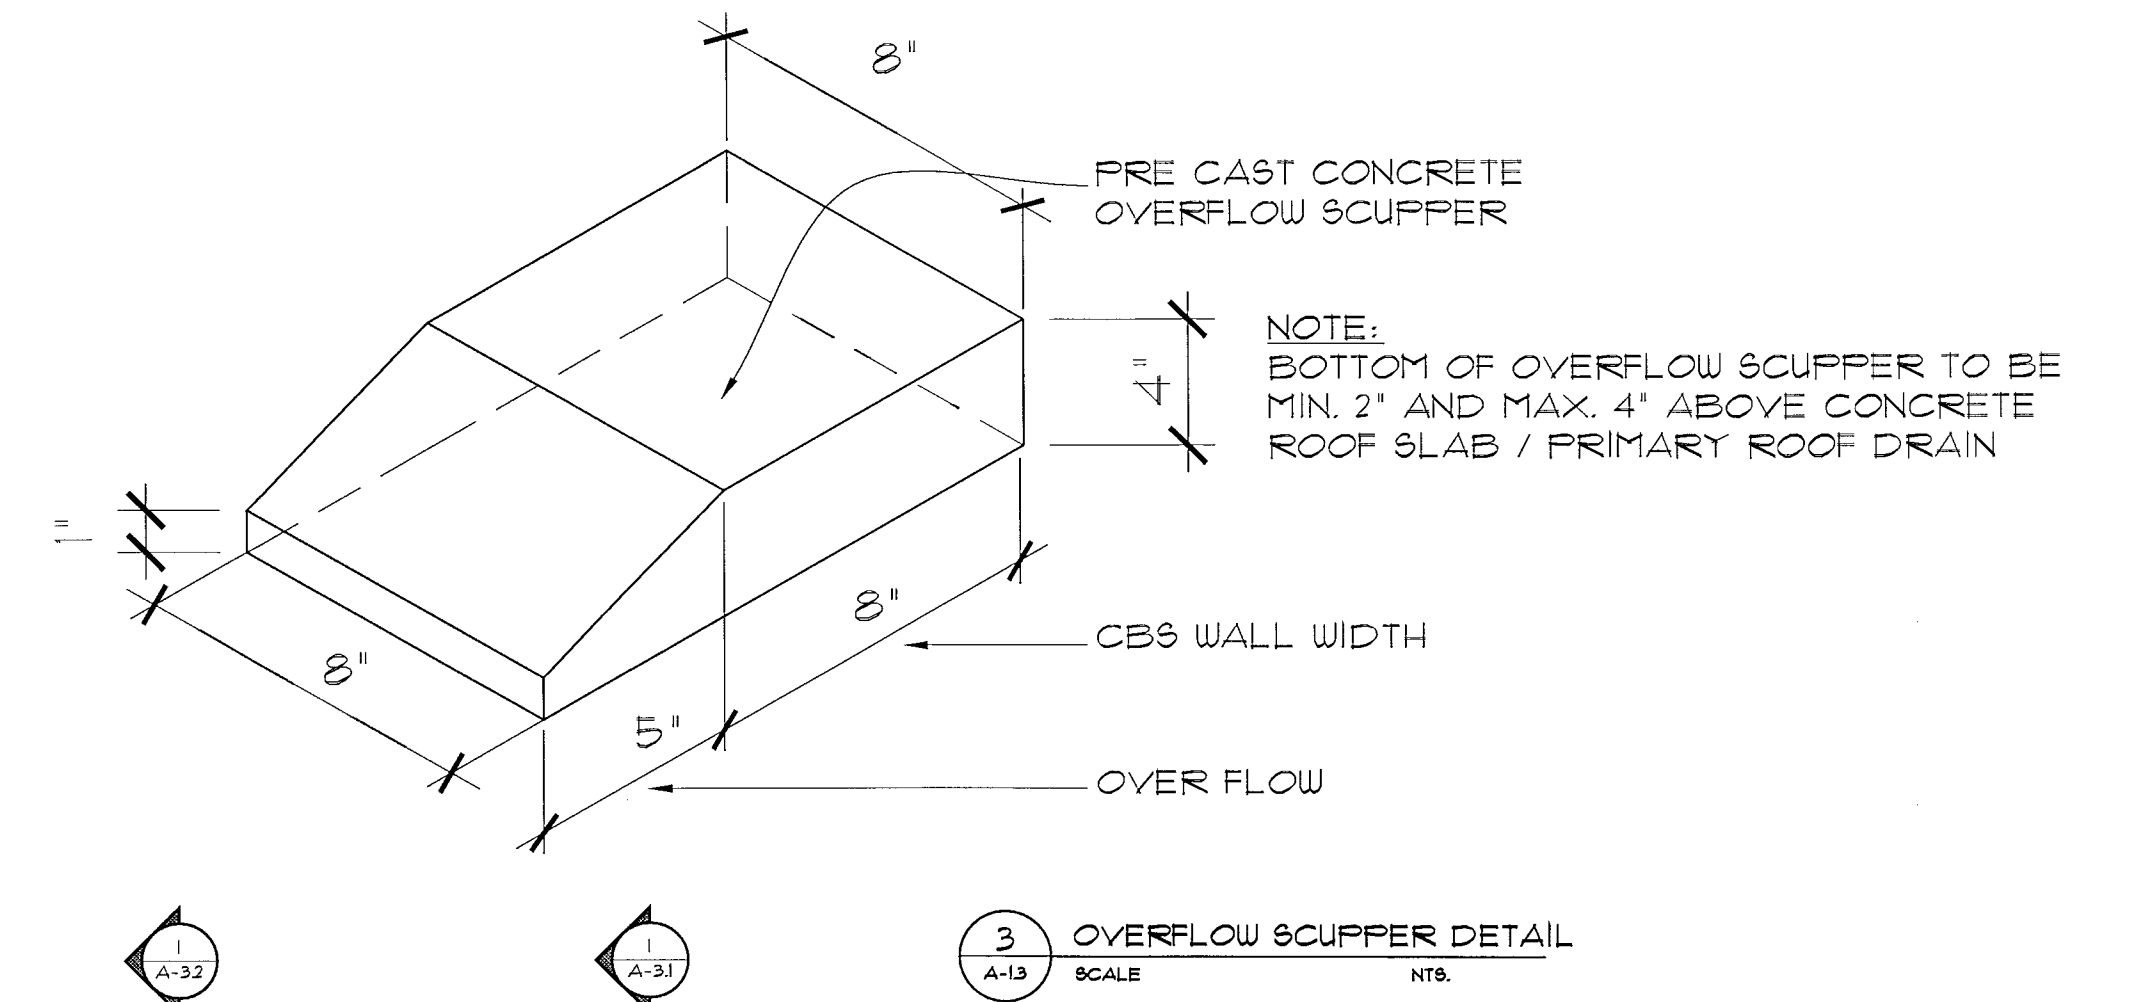

NOV 06 2013

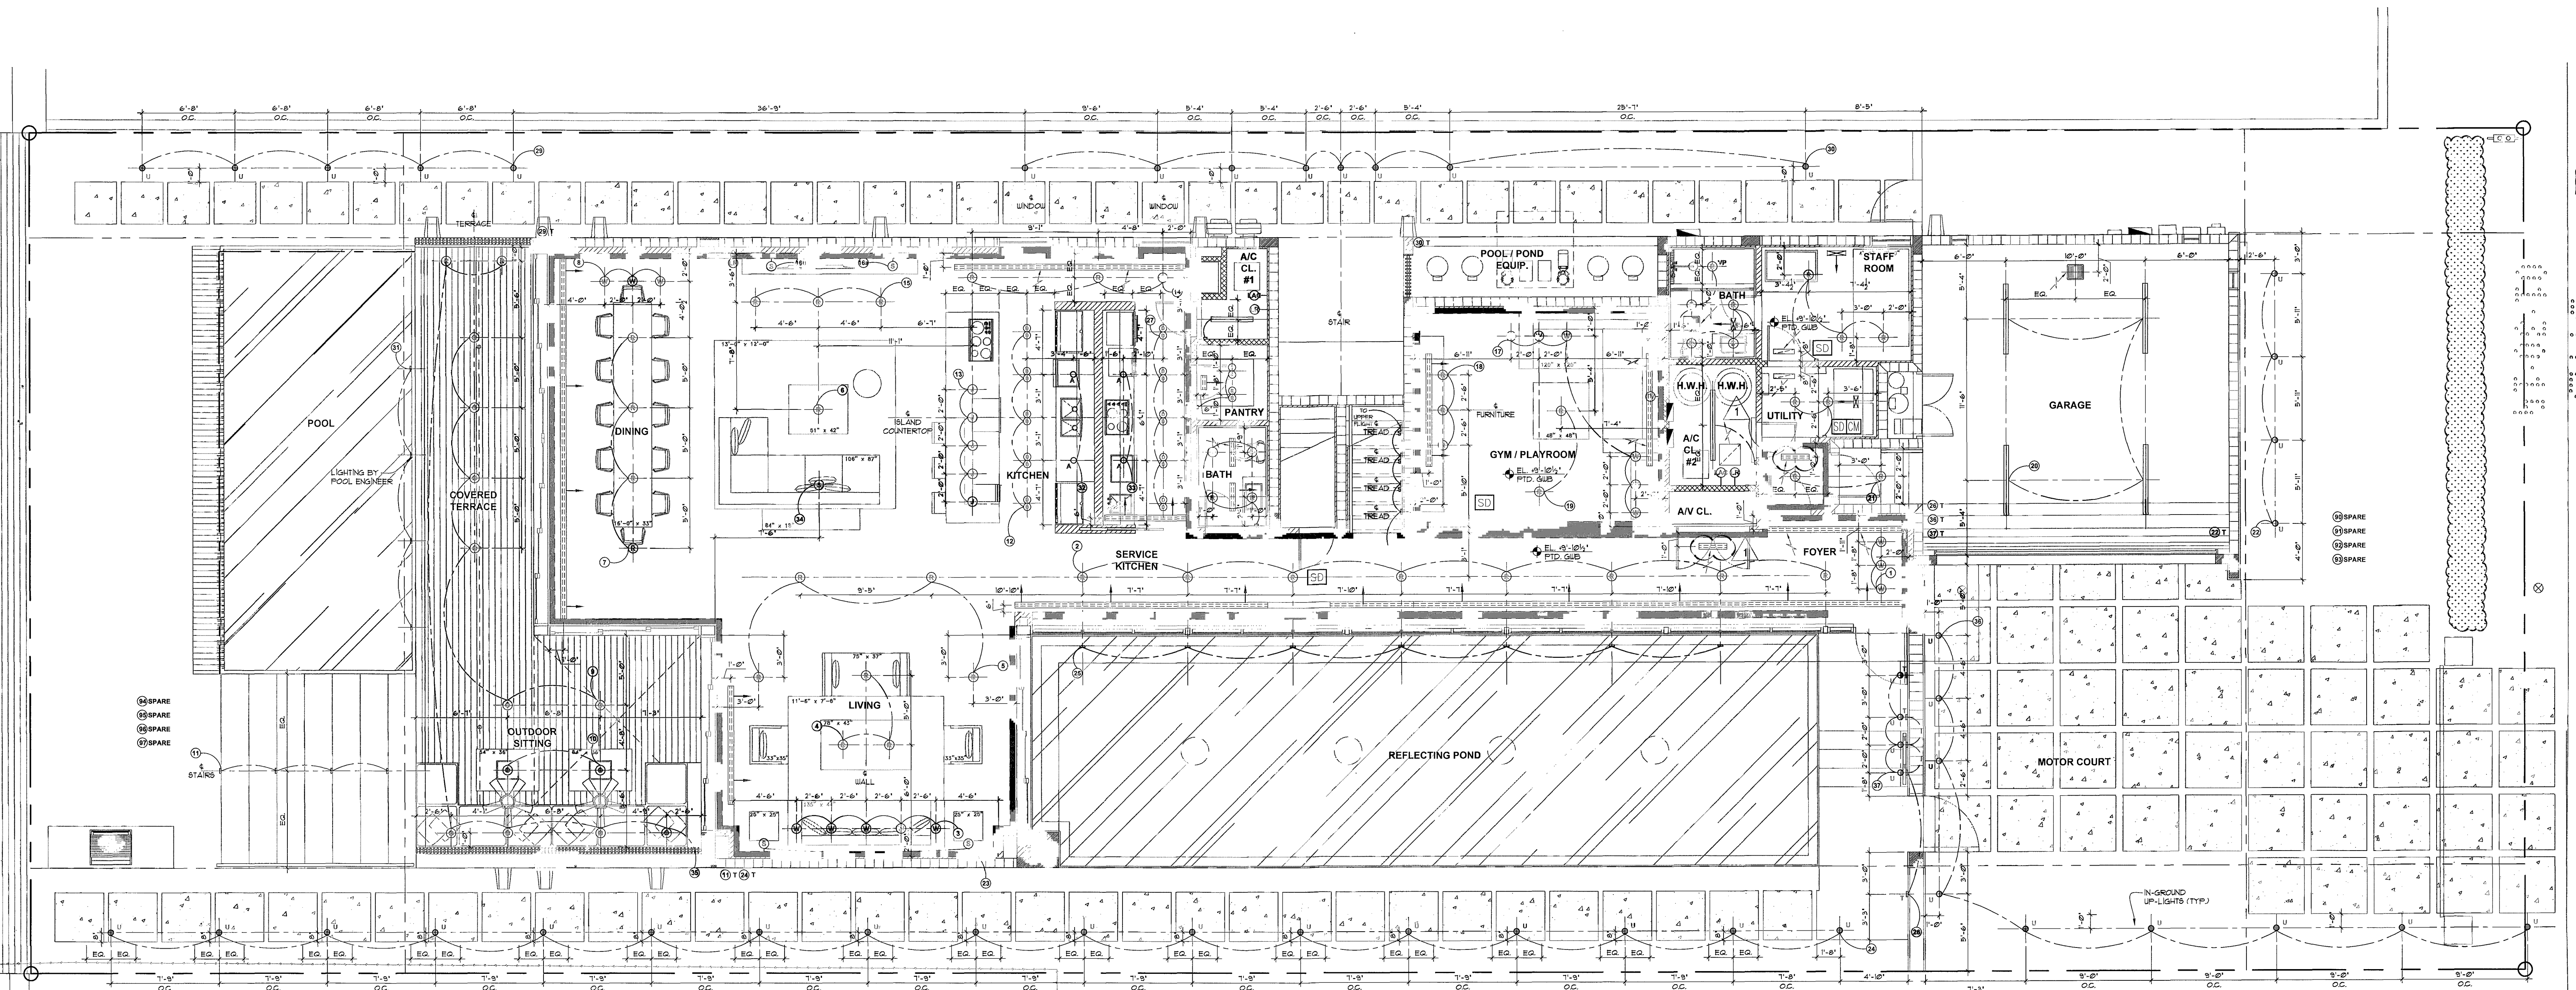

- SD SMOKE DETECTOR
- SD/CM COMBINATION SMOKE / CARBON MONOXIDE DETECTOR

FIXTURE LOCATION NOTE:
 FINAL LIGHTING LOCATIONS & FIXTURES
 SHALL BE COORDINATED WITH THE LIGHTING
 CONSULTANT PRIOR TO INSTALLATION.

**FIRST FLOOR
 LIGHTING PLAN**
 SCALE 3/16" = 1'-0"
 N

choeff + levy p.a.
 architecture interior design

8425 biscayne blvd, suite 201
 miami, florida 33138
 www.choefflevy.com
 AR0009679 AR0094779
 Phone: 305.434.8338
 Fax: 305.892.5292

DILIDO RESIDENCE
 808 WEST DILIDO DR. MIAMI BEACH, FL 33139


comm no.
1241


date:
 09-30-13

revised:
 01-06-2014
 OWNER REV.


sheet no.
A-1.4

[Signature]
 JAN 20 2014

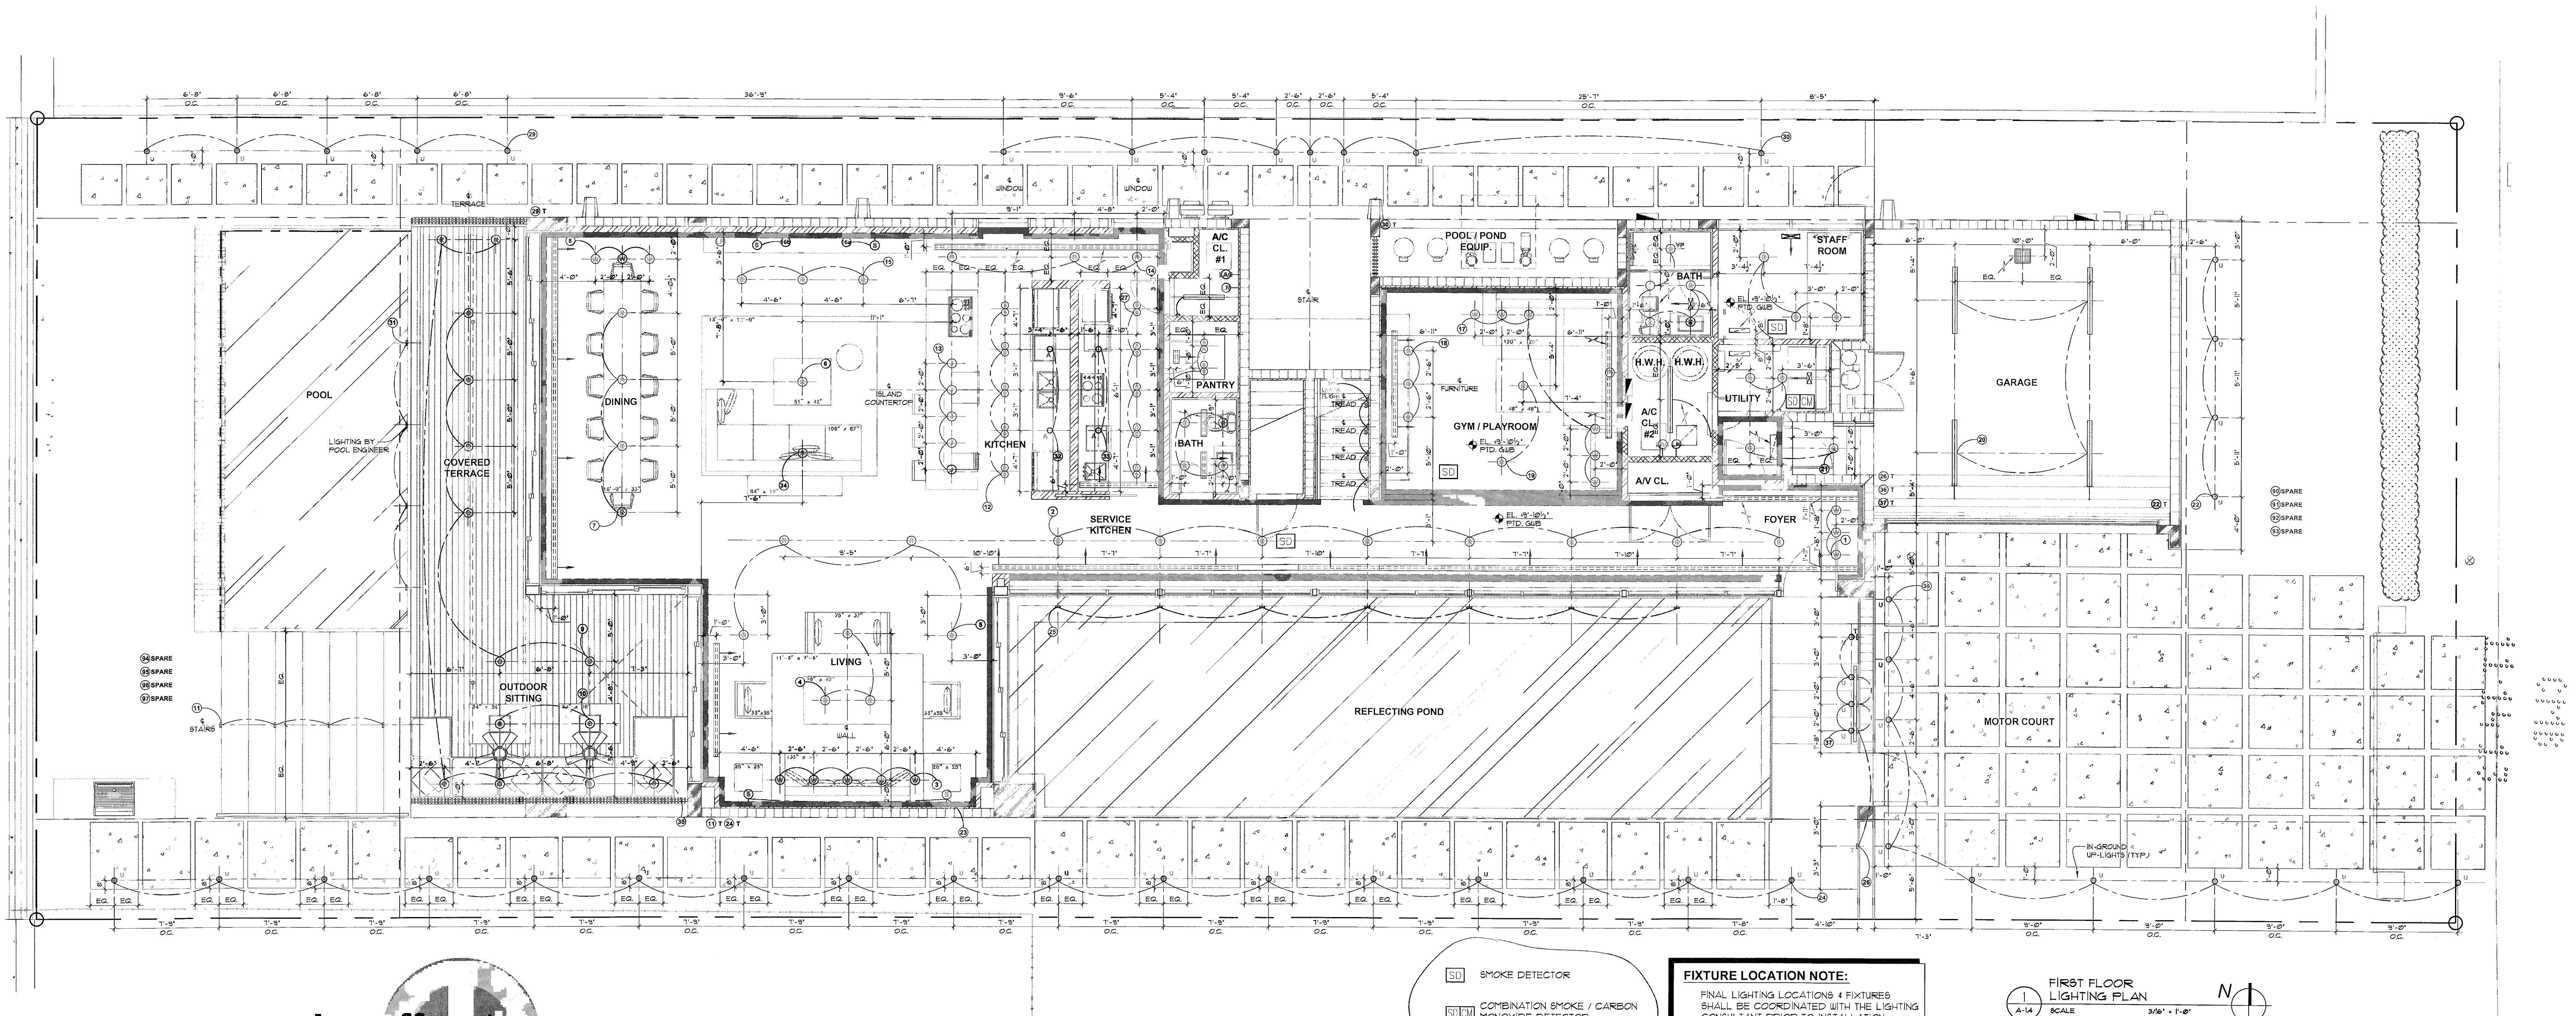

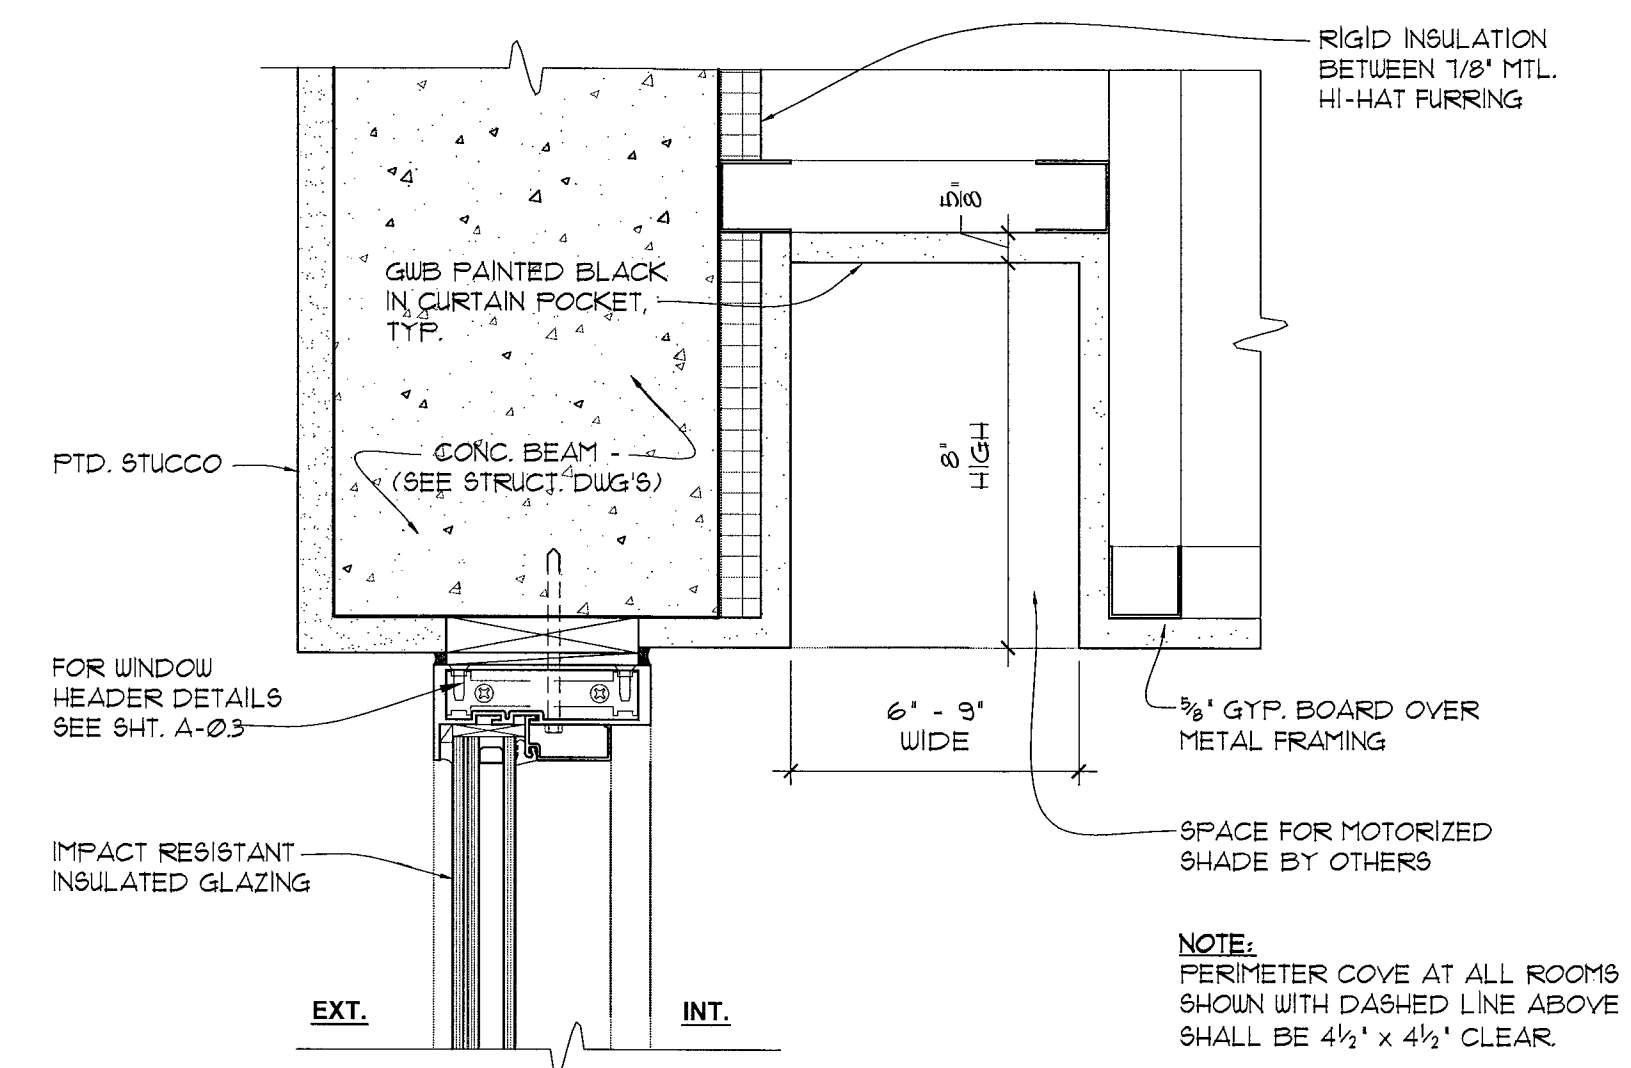

1
A-1.5
TYP. SHADE POCKET / PERIMETER COVE
DETAIL
SCALE: 3\"/>

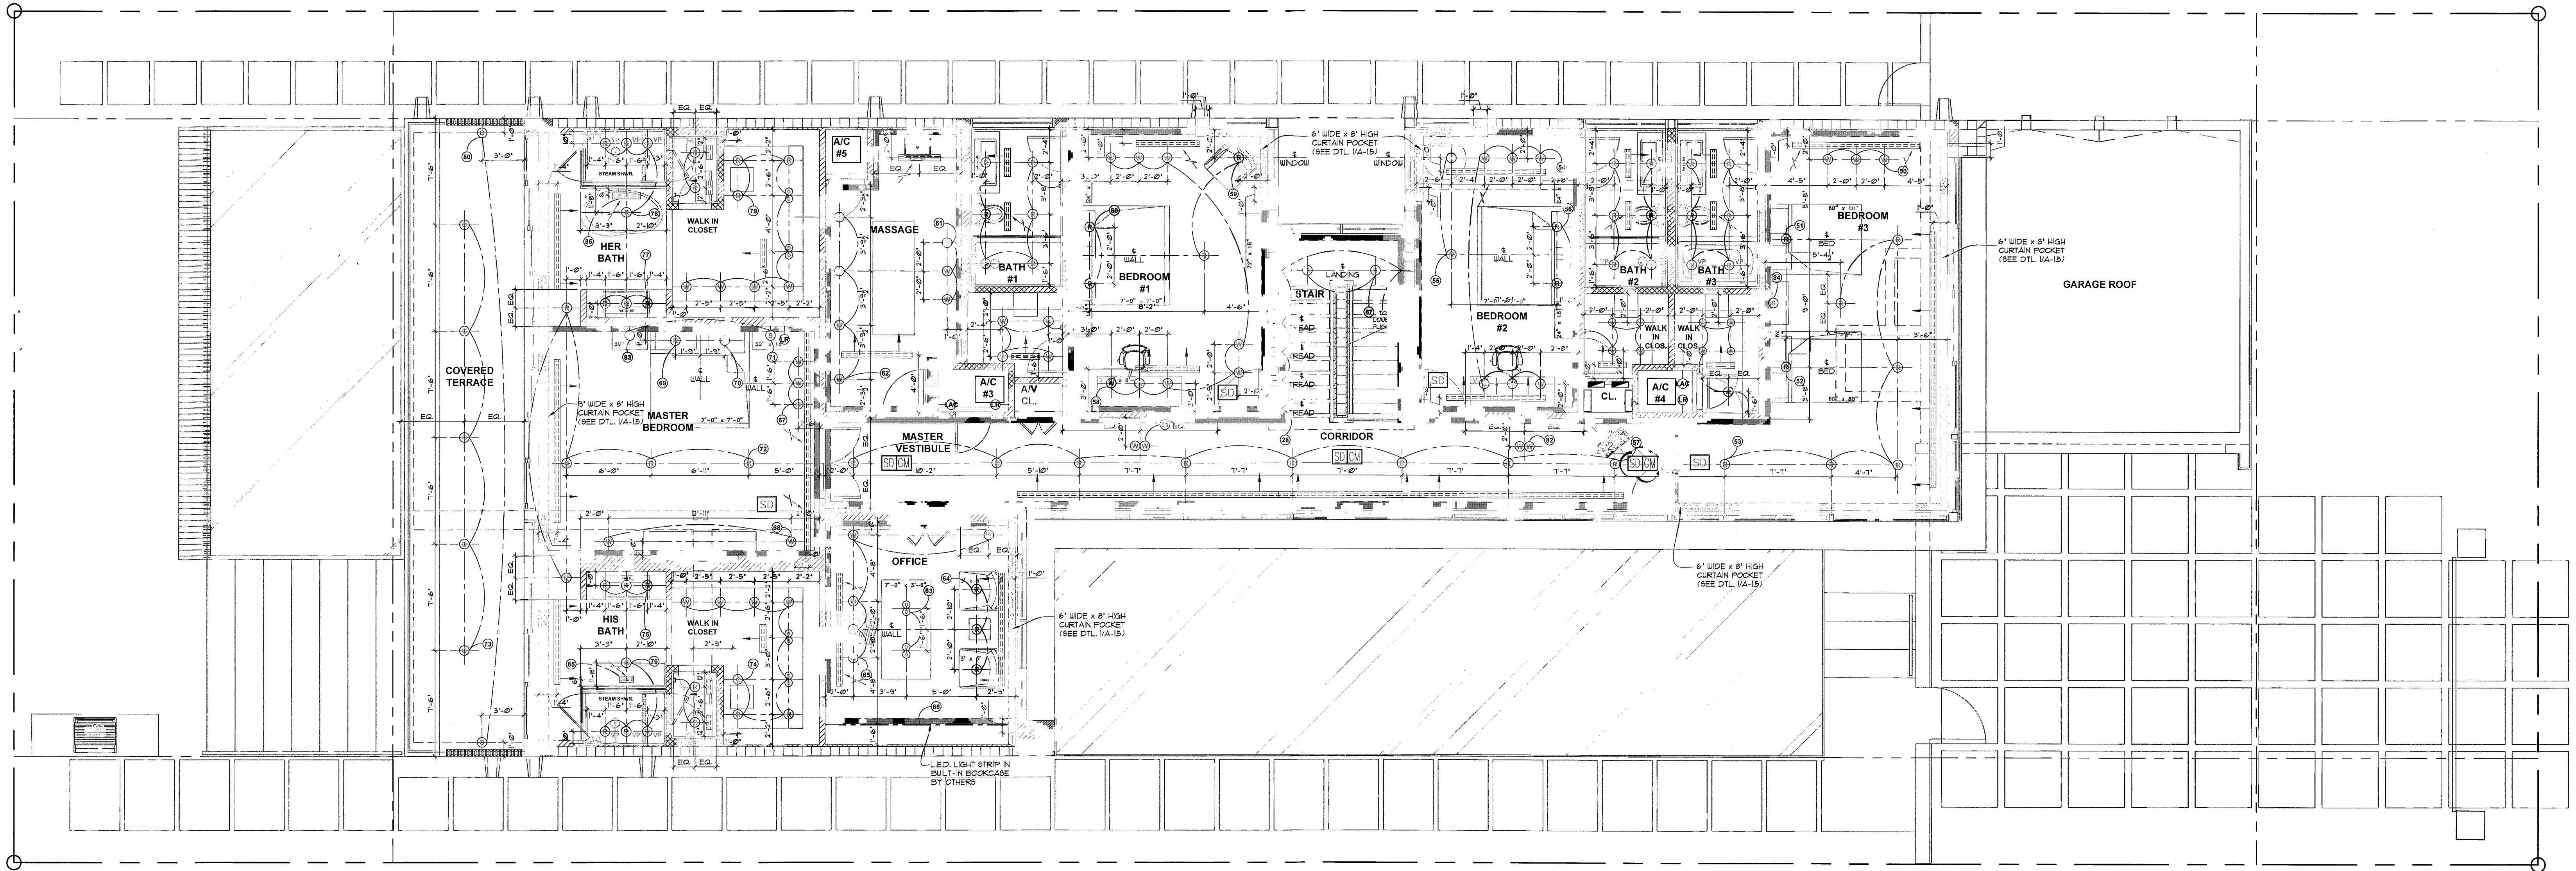

- SD SMOKE DETECTOR
- SDCM COMBINATION SMOKE / CARBON MONOXIDE DETECTOR

FIXTURE LOCATION NOTE:
FINAL LIGHTING LOCATIONS & FIXTURES SHALL BE COORDINATED WITH THE LIGHTING CONSULTANT PRIOR TO INSTALLATION.

SECOND FLOOR
LIGHTING PLAN
SCALE 3/16\"/>

choeff + levy p.a.
architecture interior design

8425 biscayne blvd, suite 201
miami, florida 33138
www.choefflevy.com
AR0009679 AR0094779
Phone: 305.434.8338
Fax: 305.892.5292


DILIDO RESIDENCE
808 WEST DILIDO DR. MIAMI BEACH, FL 33139

comm no.
1241
date:
09-30-13


FEB 07 2014
[Signature]

revised:
02-07-2014
B.D. REV.

sheet no.
A-1.5

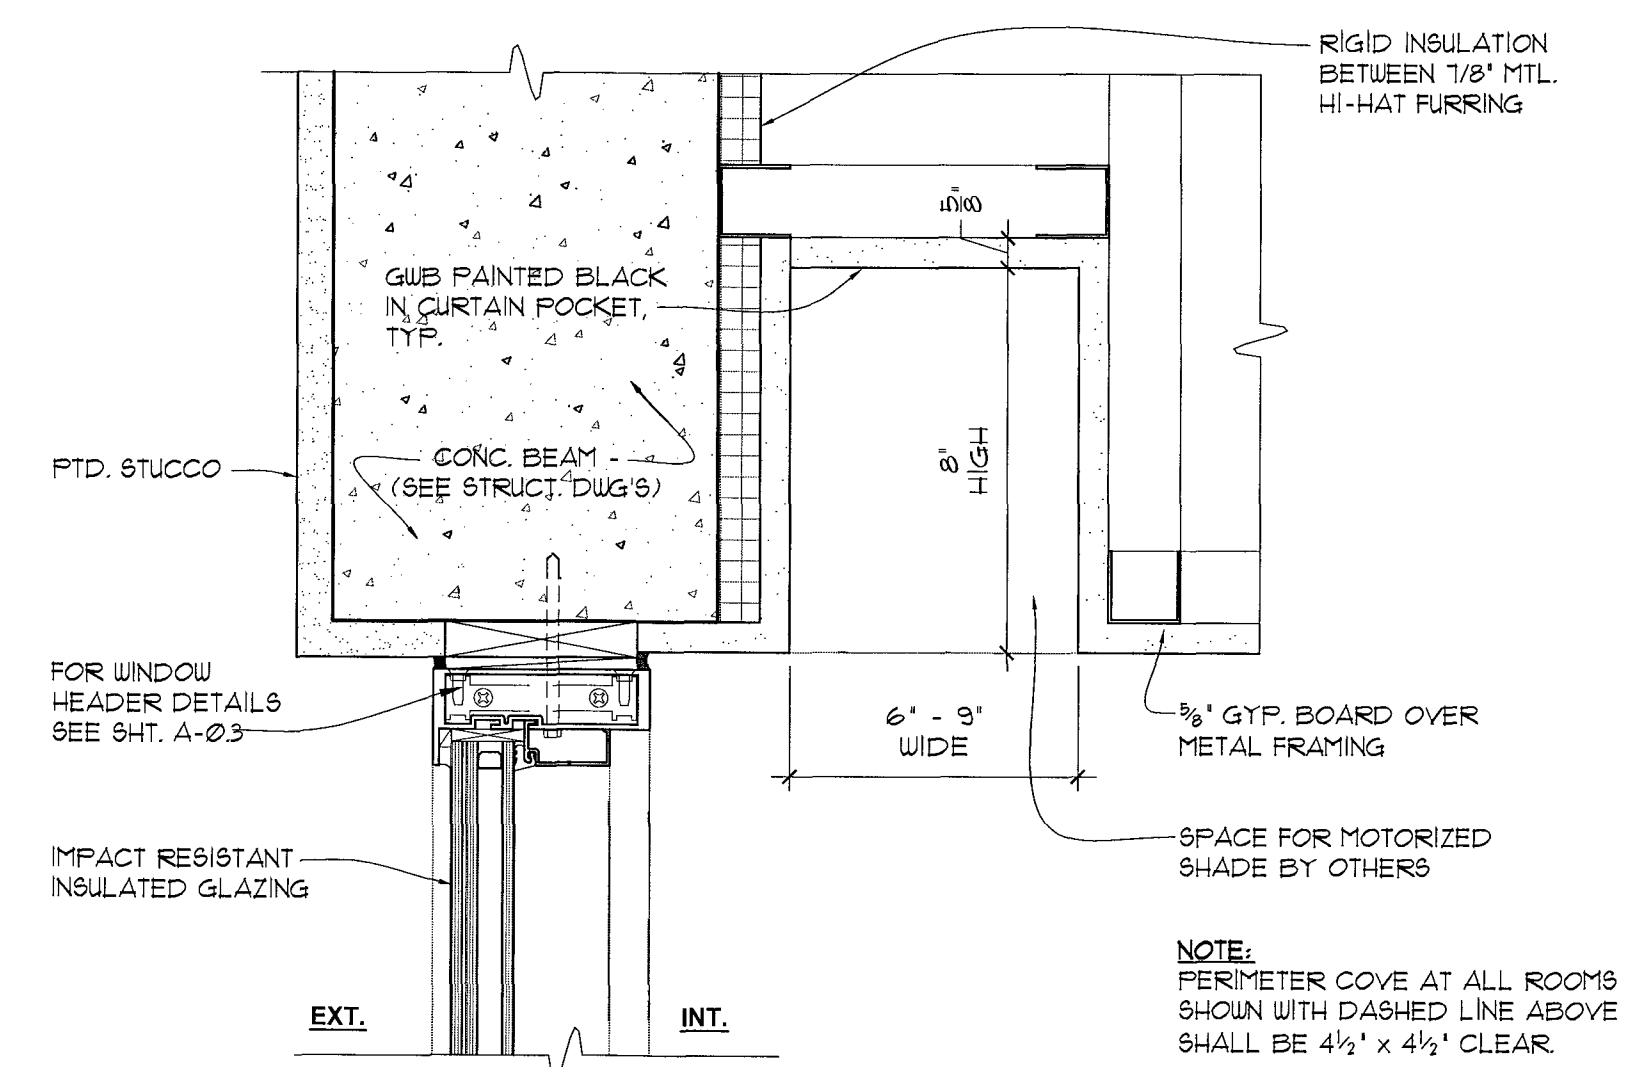

TYP. SHADE POCKET / PERIMTER COVE
DETAIL
SCALE: 3/8" = 1'-0"

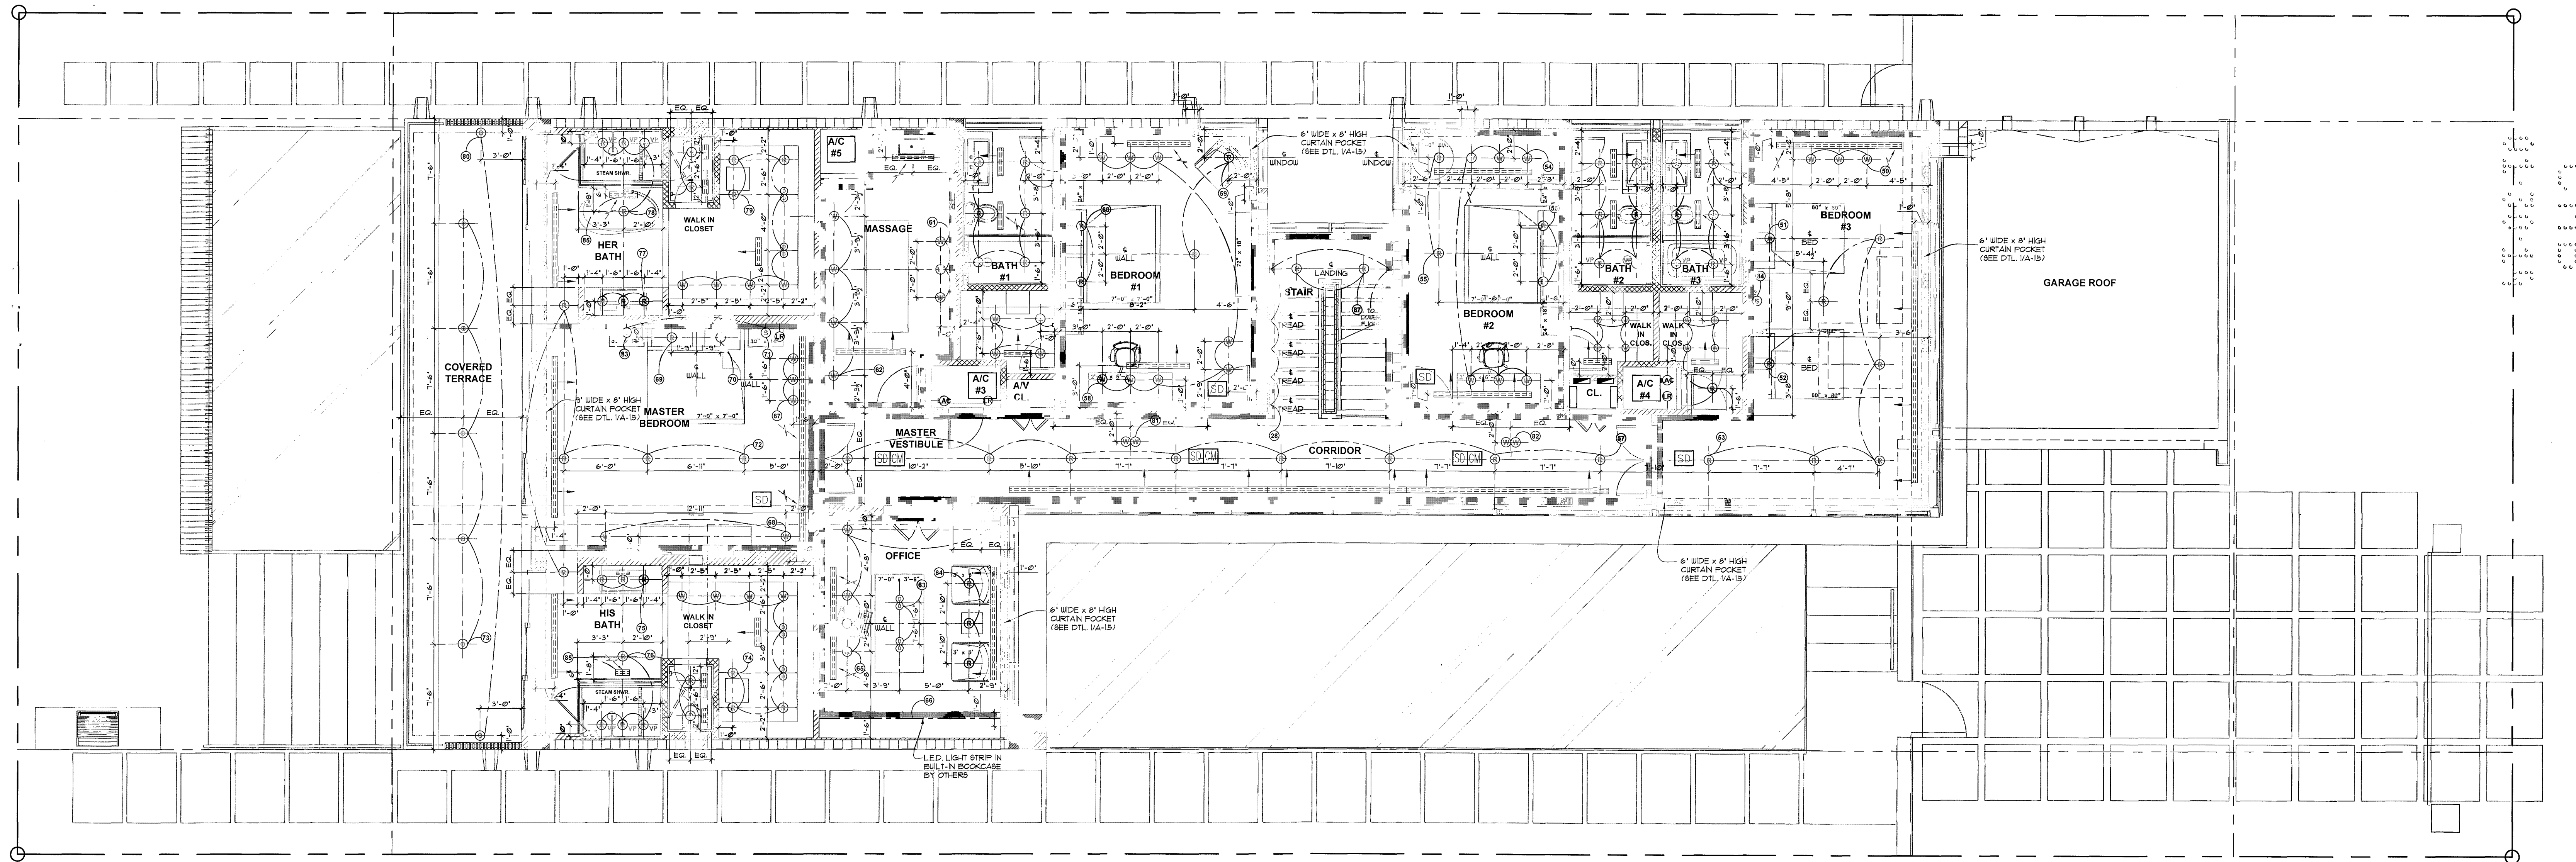

- 1 SD SMOKE DETECTOR
- SD COMBINATION SMOKE / CARBON MONOXIDE DETECTOR

FIXTURE LOCATION NOTE:
FINAL LIGHTING LOCATIONS & FIXTURES SHALL BE COORDINATED WITH THE LIGHTING CONSULTANT PRIOR TO INSTALLATION.

SECOND FLOOR LIGHTING PLAN
SCALE 3/16" = 1'-0"

choeff + levy p.a.
architecture interior design

8425 biscayne blvd, suite 201
miami, florida 33138

www.choefflevy.com
AR0009679 AR0094779

Phone: 305.434.8338
Fax: 305.892.5292

DILIDO RESIDENCE

808 WEST DILIDO DR. MIAMI BEACH, FL 33139


comm no.
1241

date:
09-30-13


revised:

sheet no:
A-1.5





[Handwritten signature]
JAN 20 2014

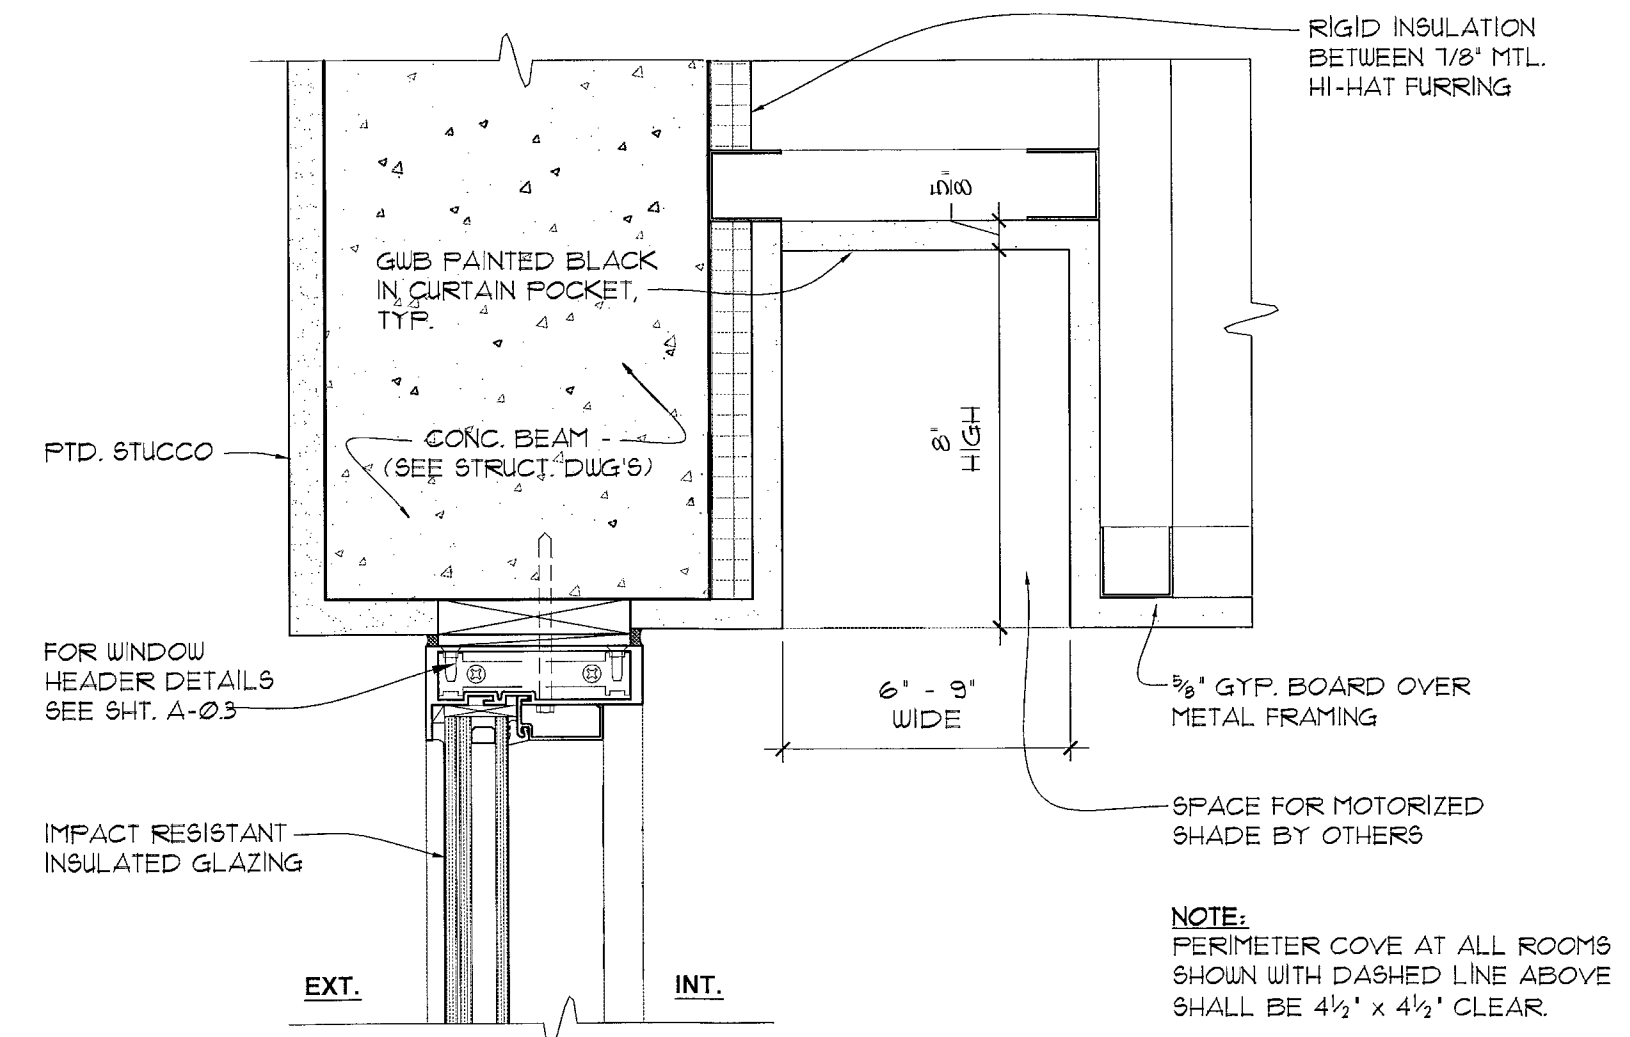

1
A-1.5
TYP. SHADE POCKET / PERIMETER COVE
DETAIL
SCALE: 3"=1'-0"

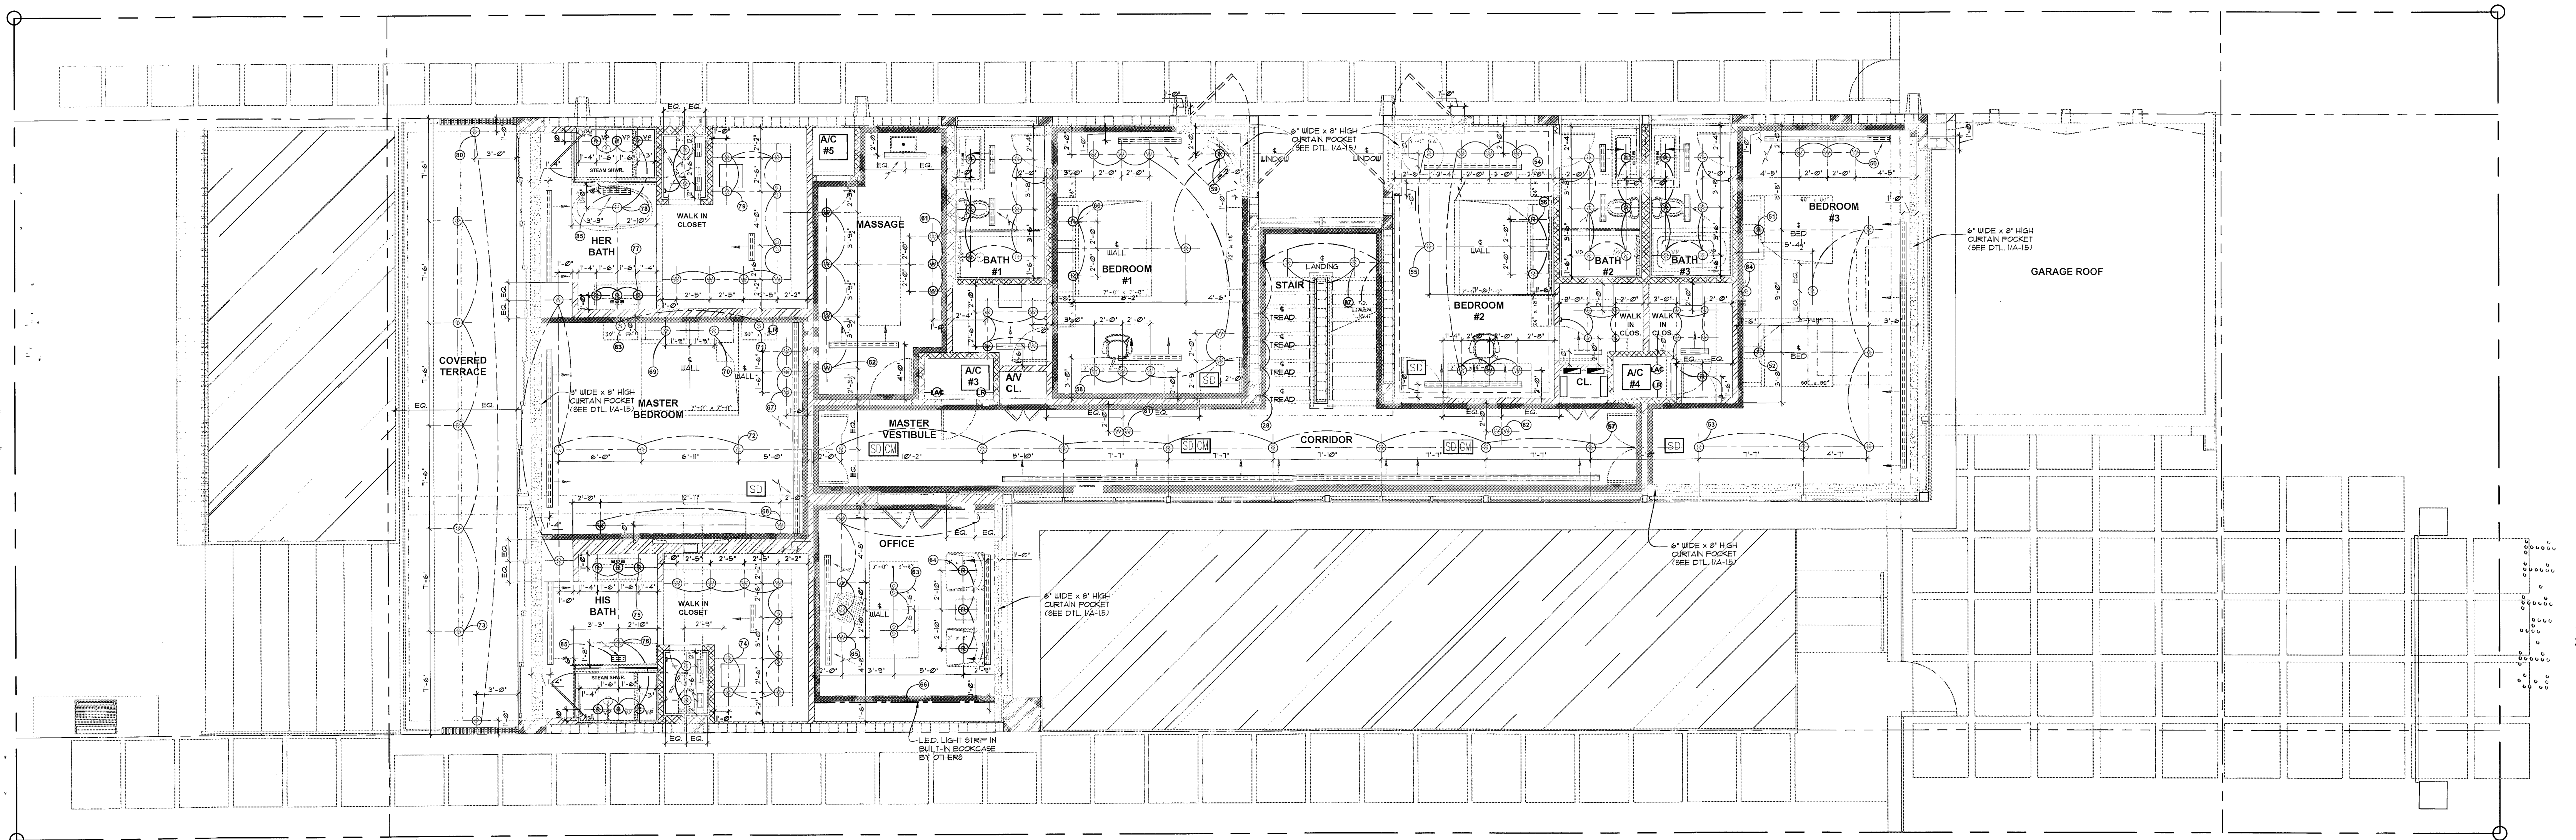

[Handwritten signature]
NOV 06 2013

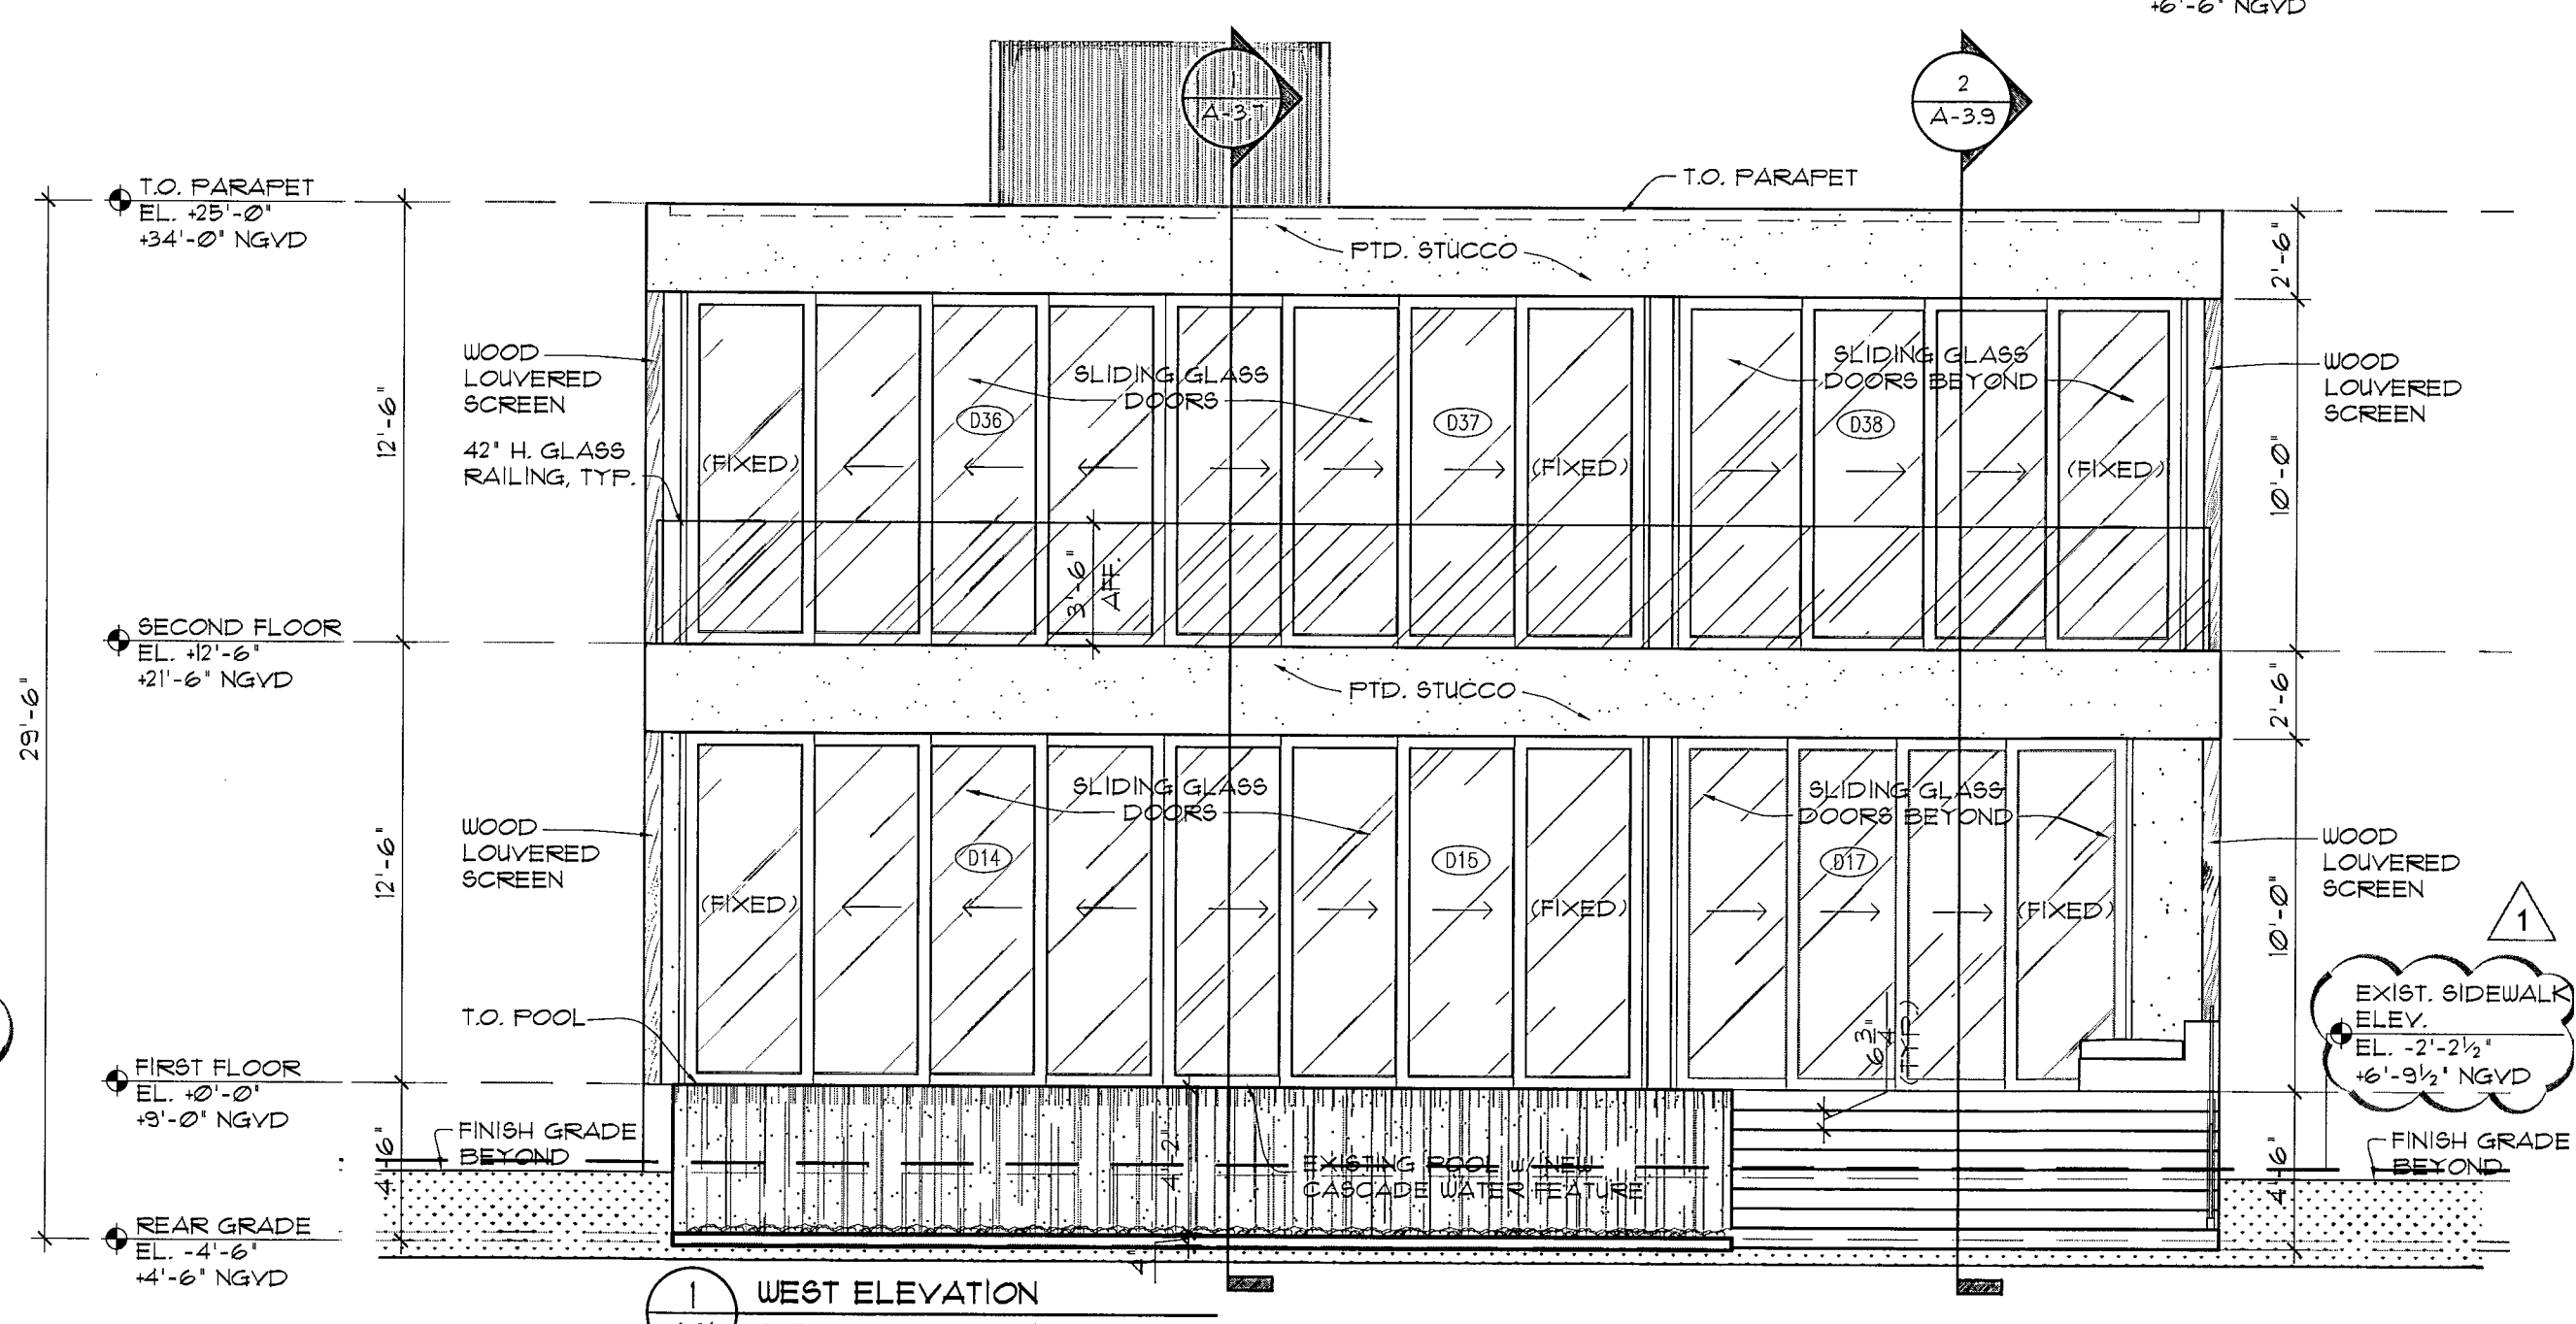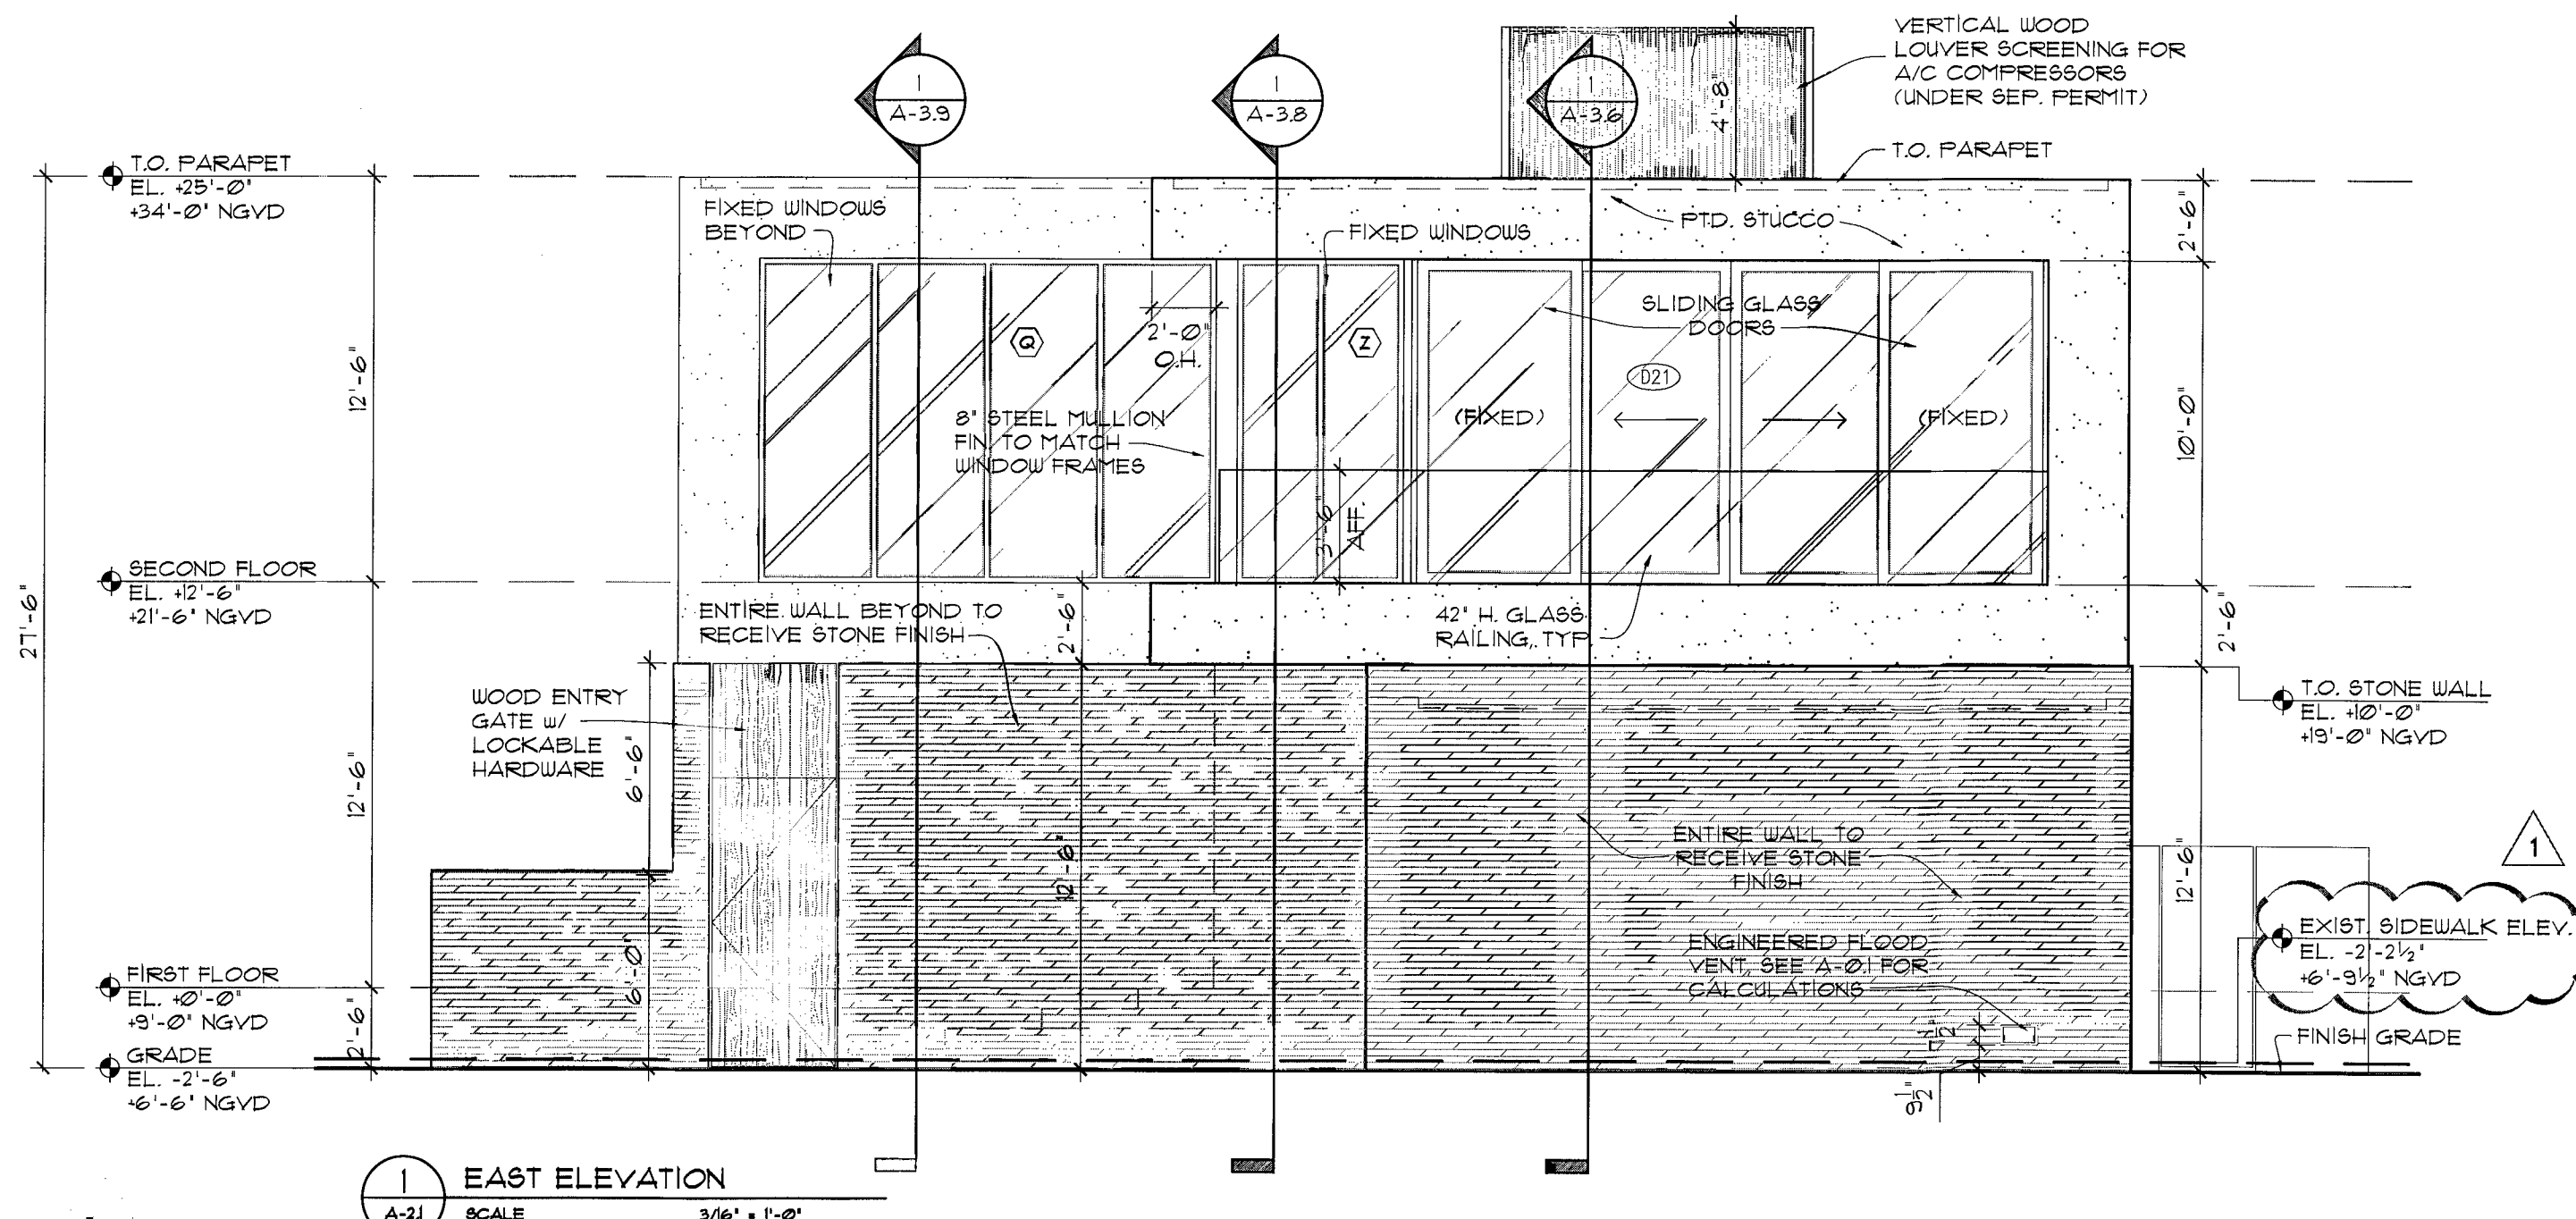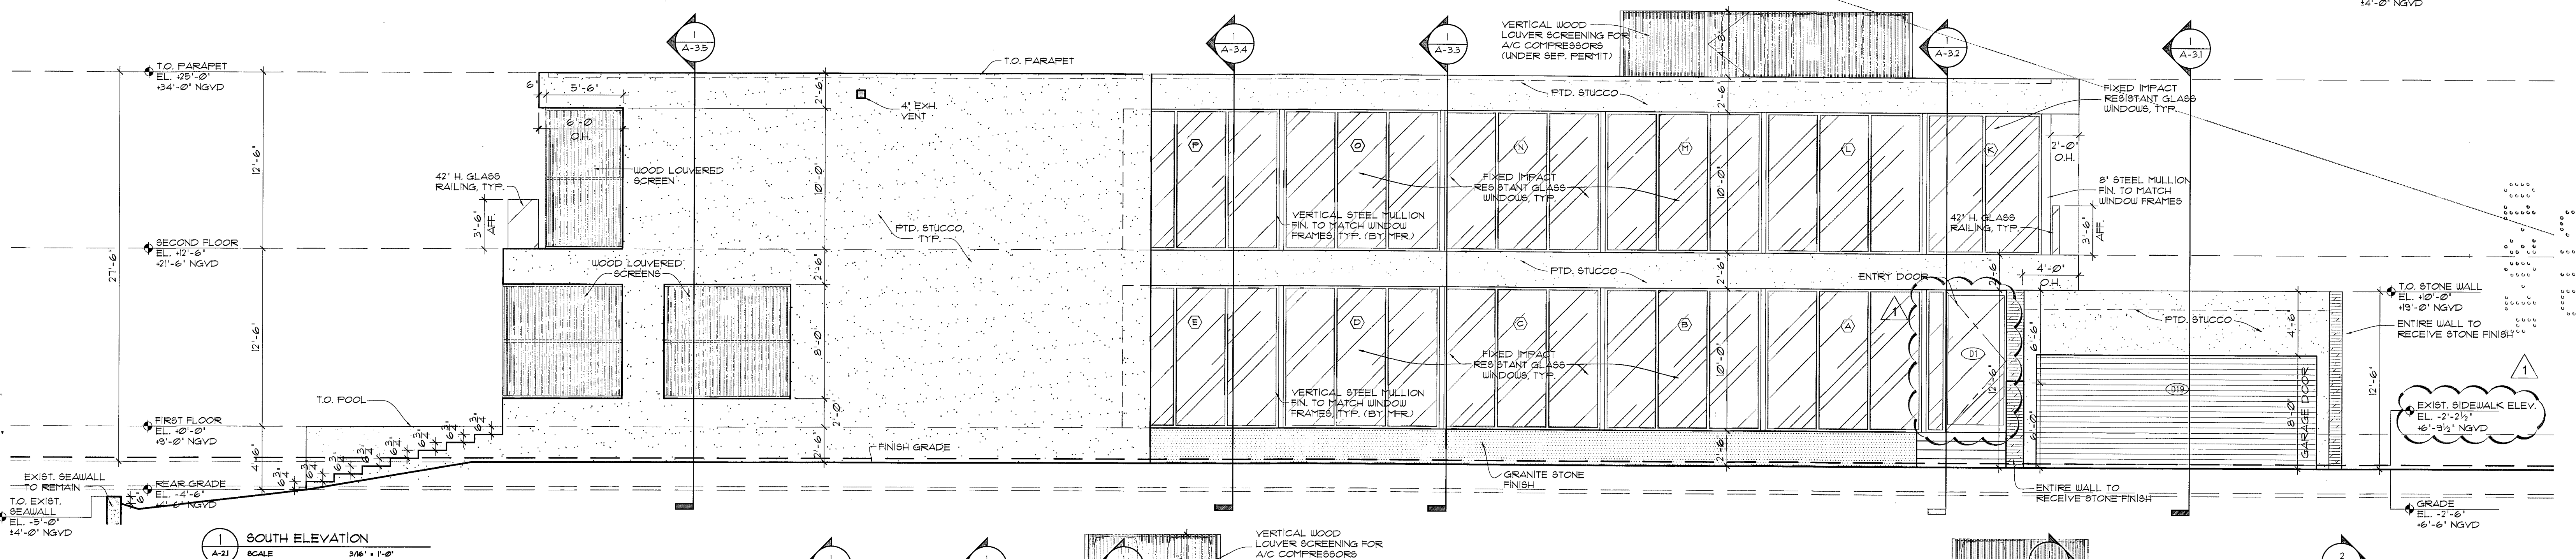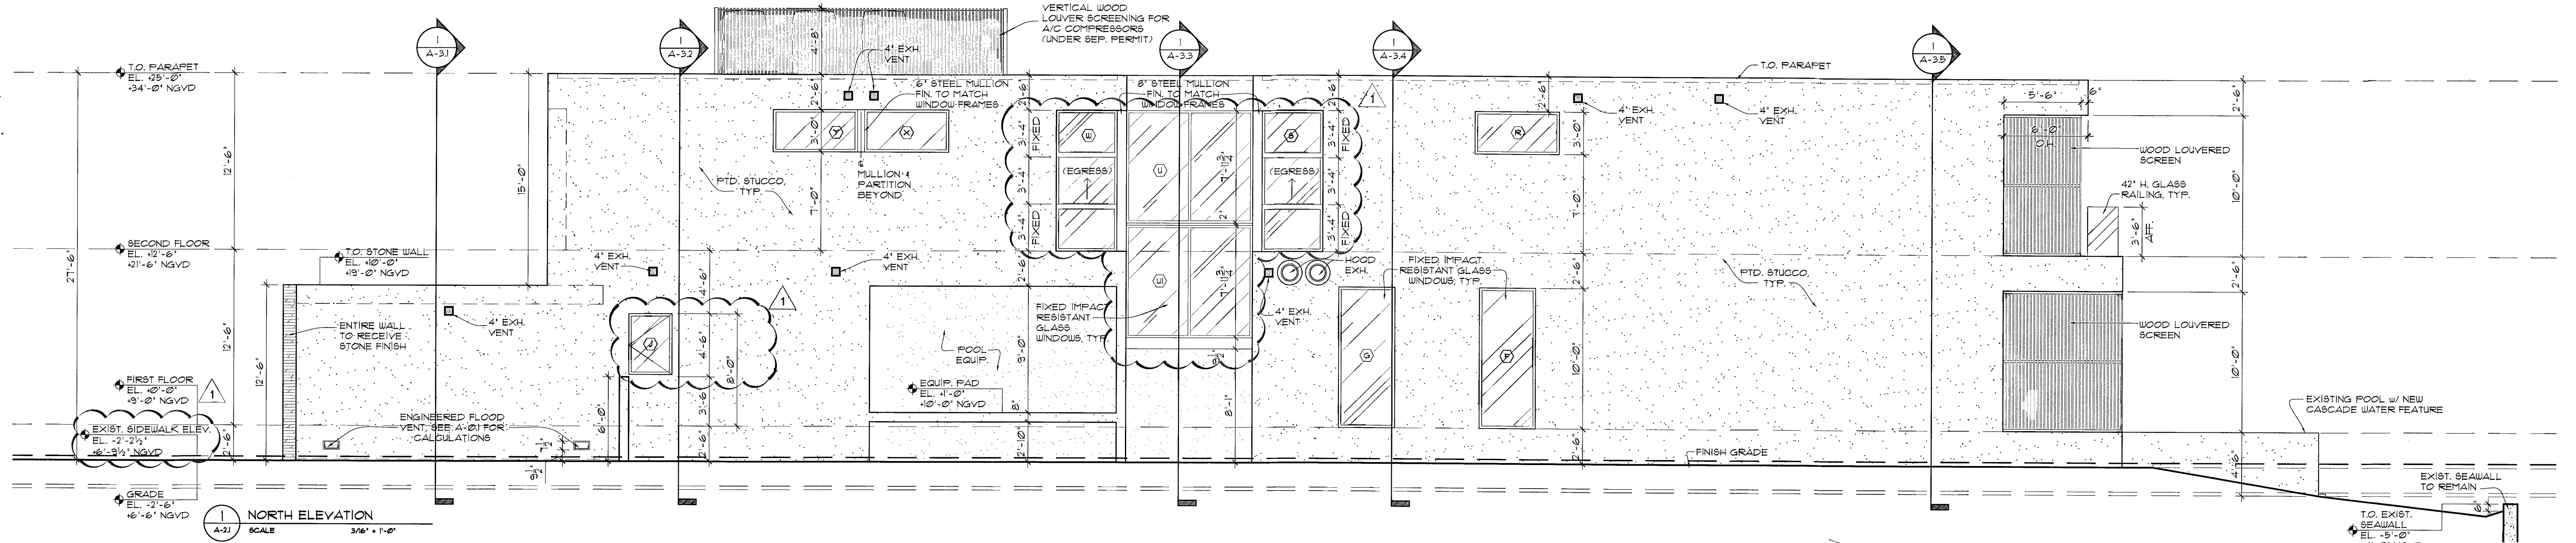

choeff + levy p.a.
architecture interior design

8425 biscayne blvd, suite 201
miami, florida 33138

www.choefflevy.com
AR0009679 AR0094779

Phone: 305.434.8338
Fax: 305.892.5292

DILIDO RESIDENCE

808 WEST DILIDO DR. MIAMI BEACH, FL 33139





comm no.
1241

date:
09-30-13

revised:
01-06-2014
OWNER REV.

sheet no.
A-2.1

JAN 20 2014

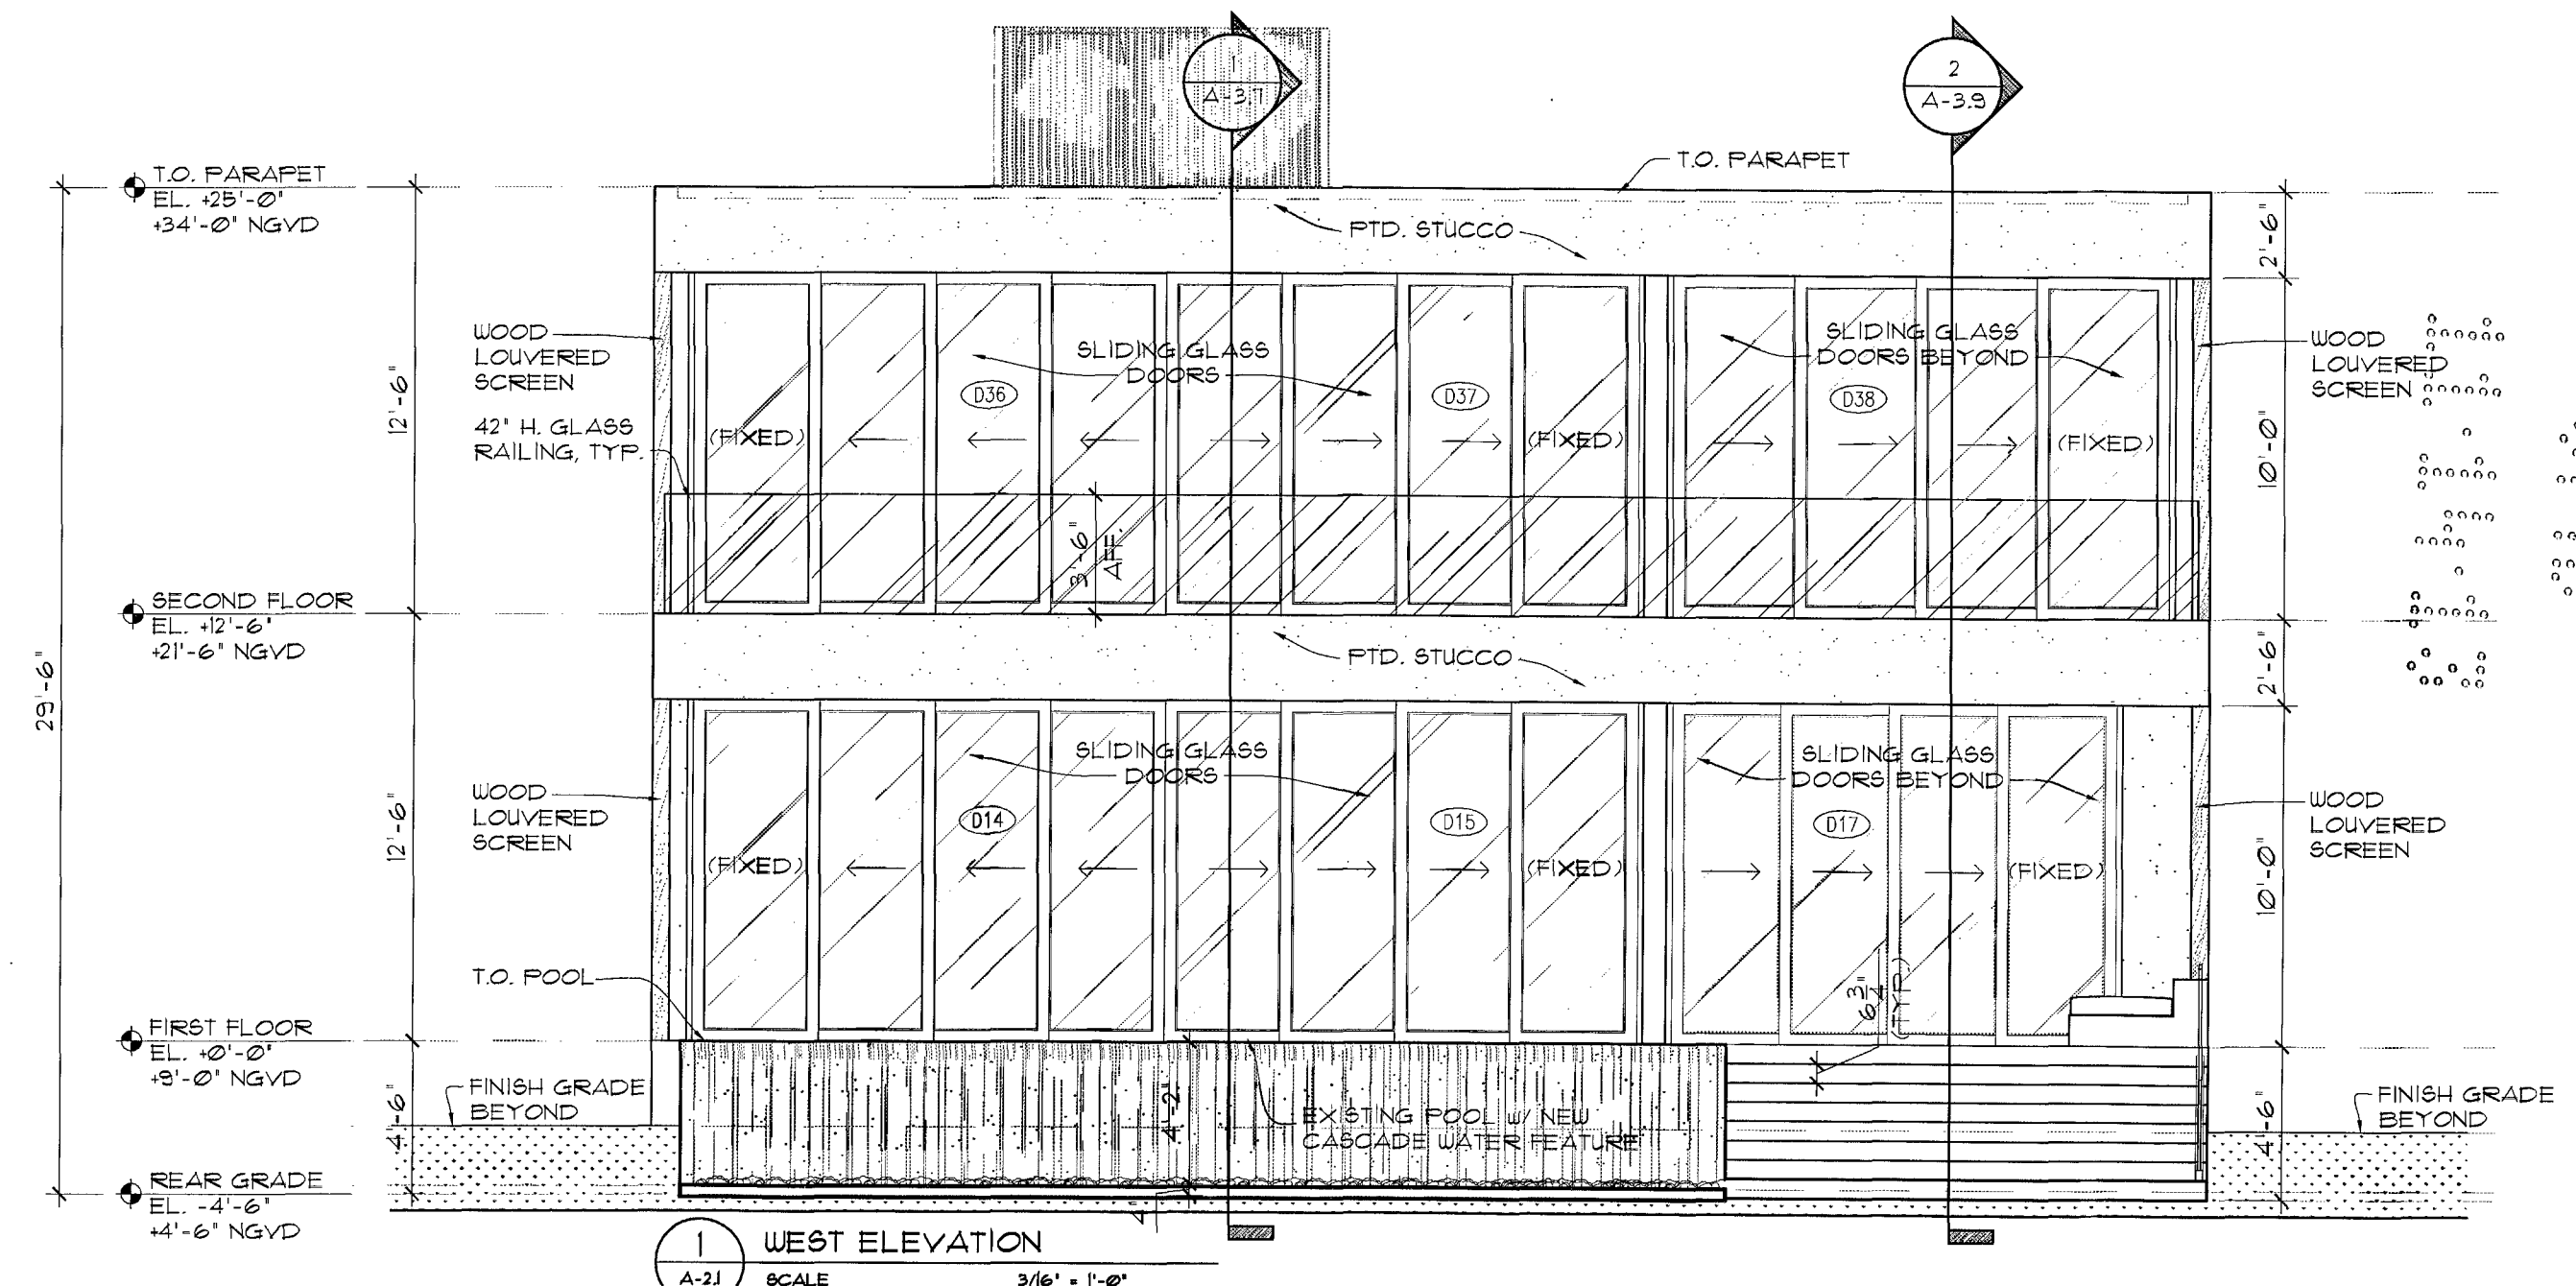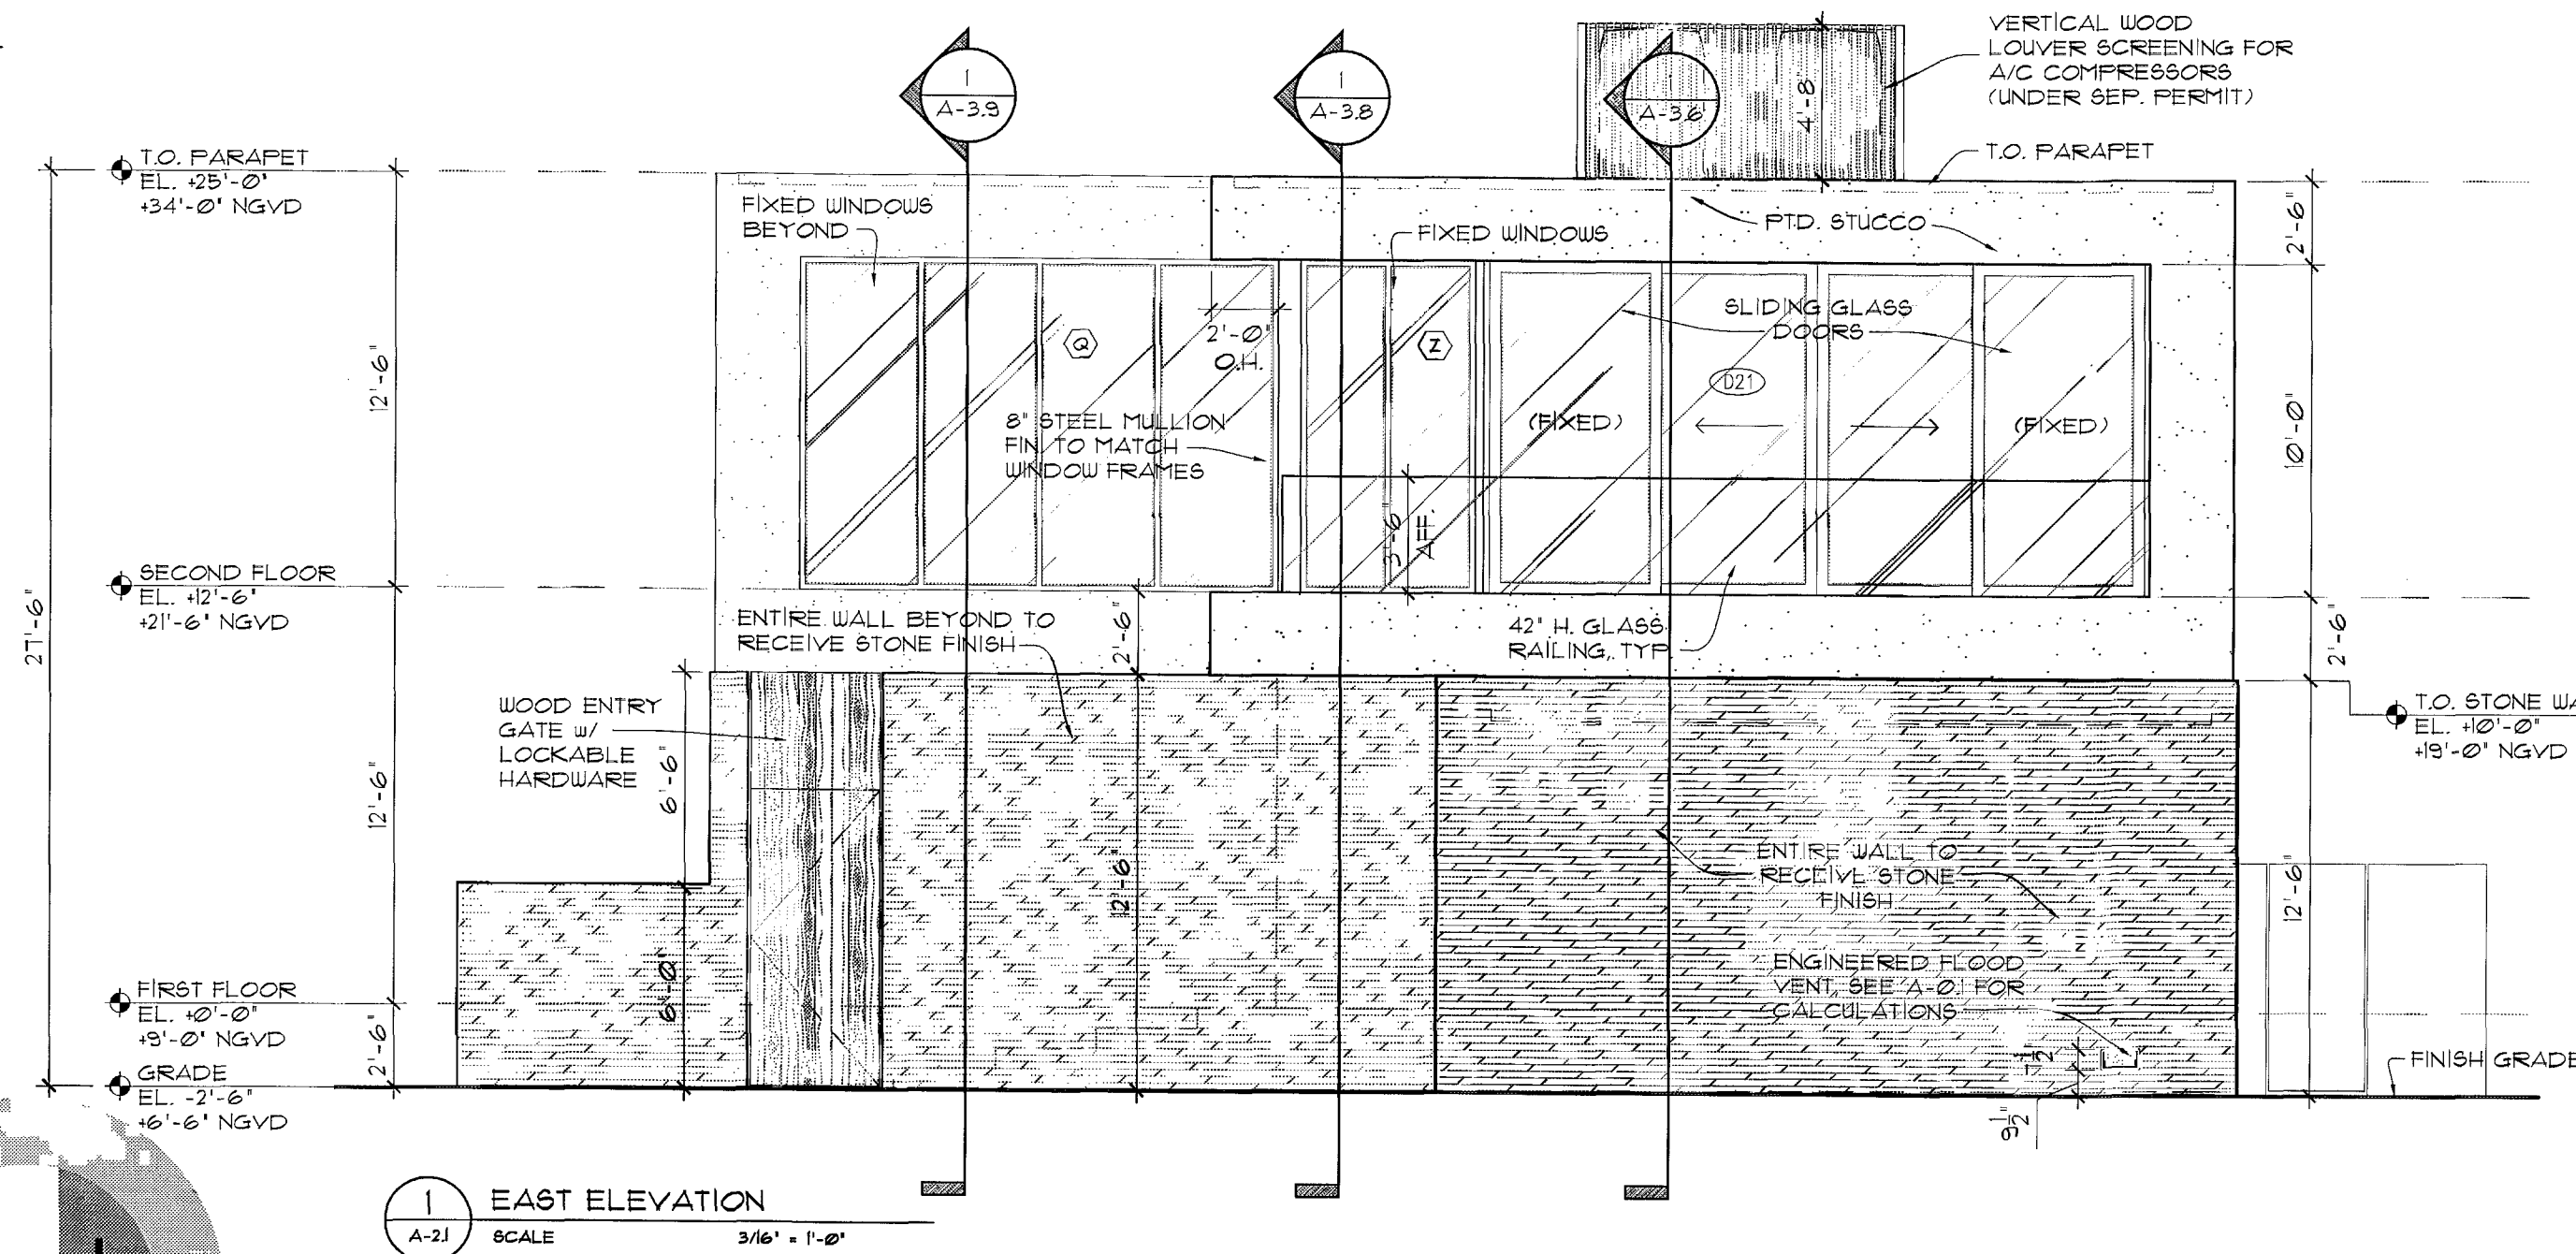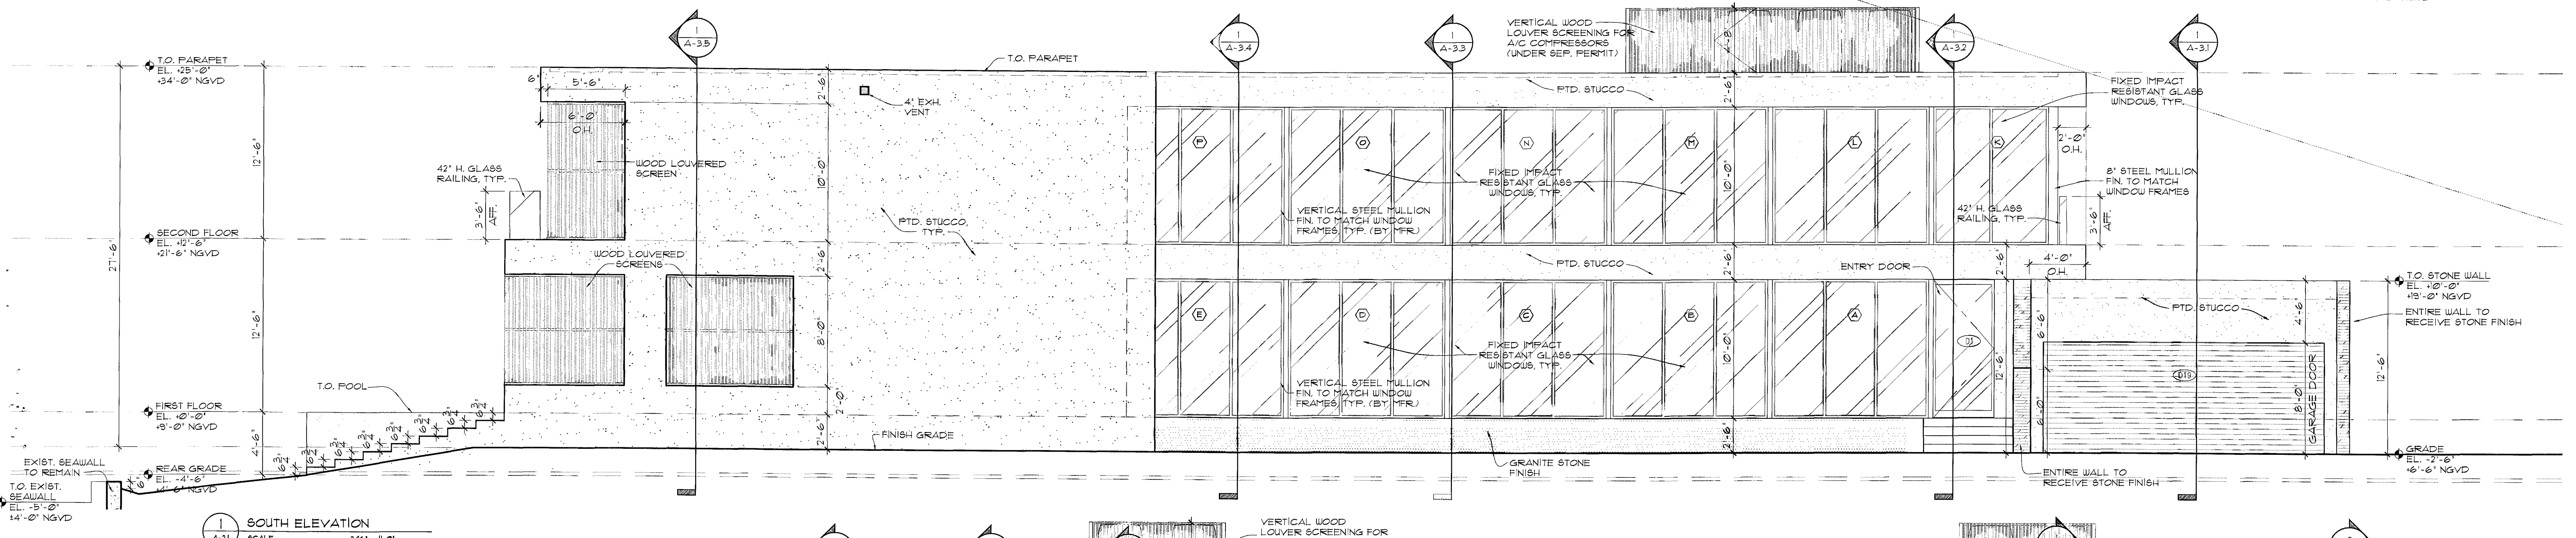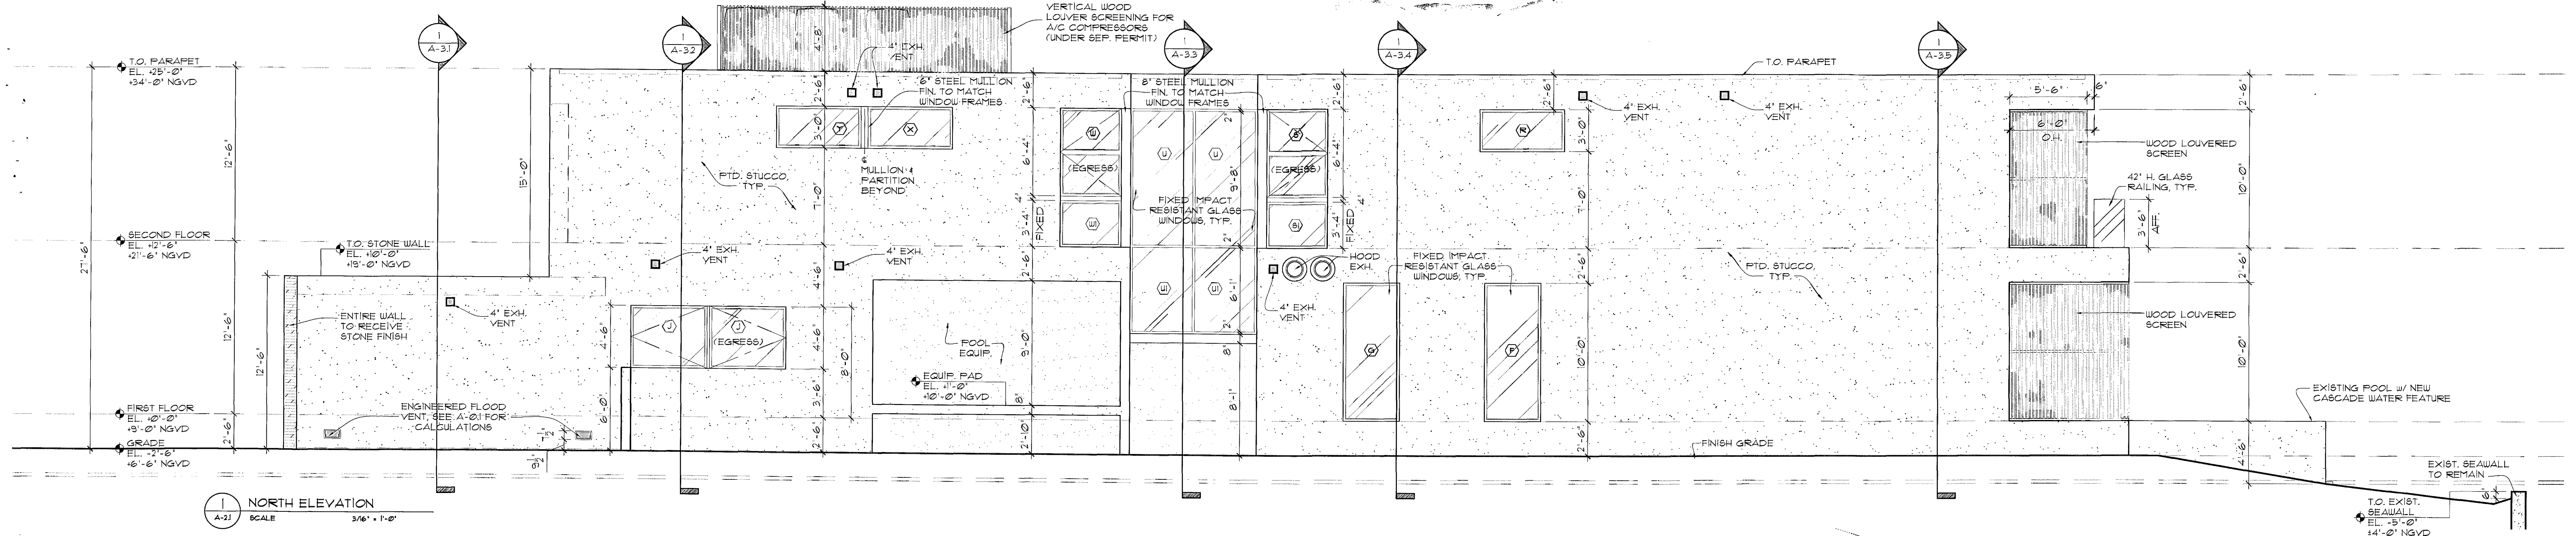

choeff + levy p.a.
architecture interior design

8425 biscayne blvd, suite 201
miami, florida 33138

www.choefflevy.com
AR0009679 AR0094779

Phone: 305.434.8338
Fax: 305.892.5292

DILIDO RESIDENCE
808 WEST DILIDO DR. MIAMI BEACH, FL 33139


comm no.
1241

date:
09-30-13

revised:

sheet no.
A-2.1

[Signature]
NOV 6 2013

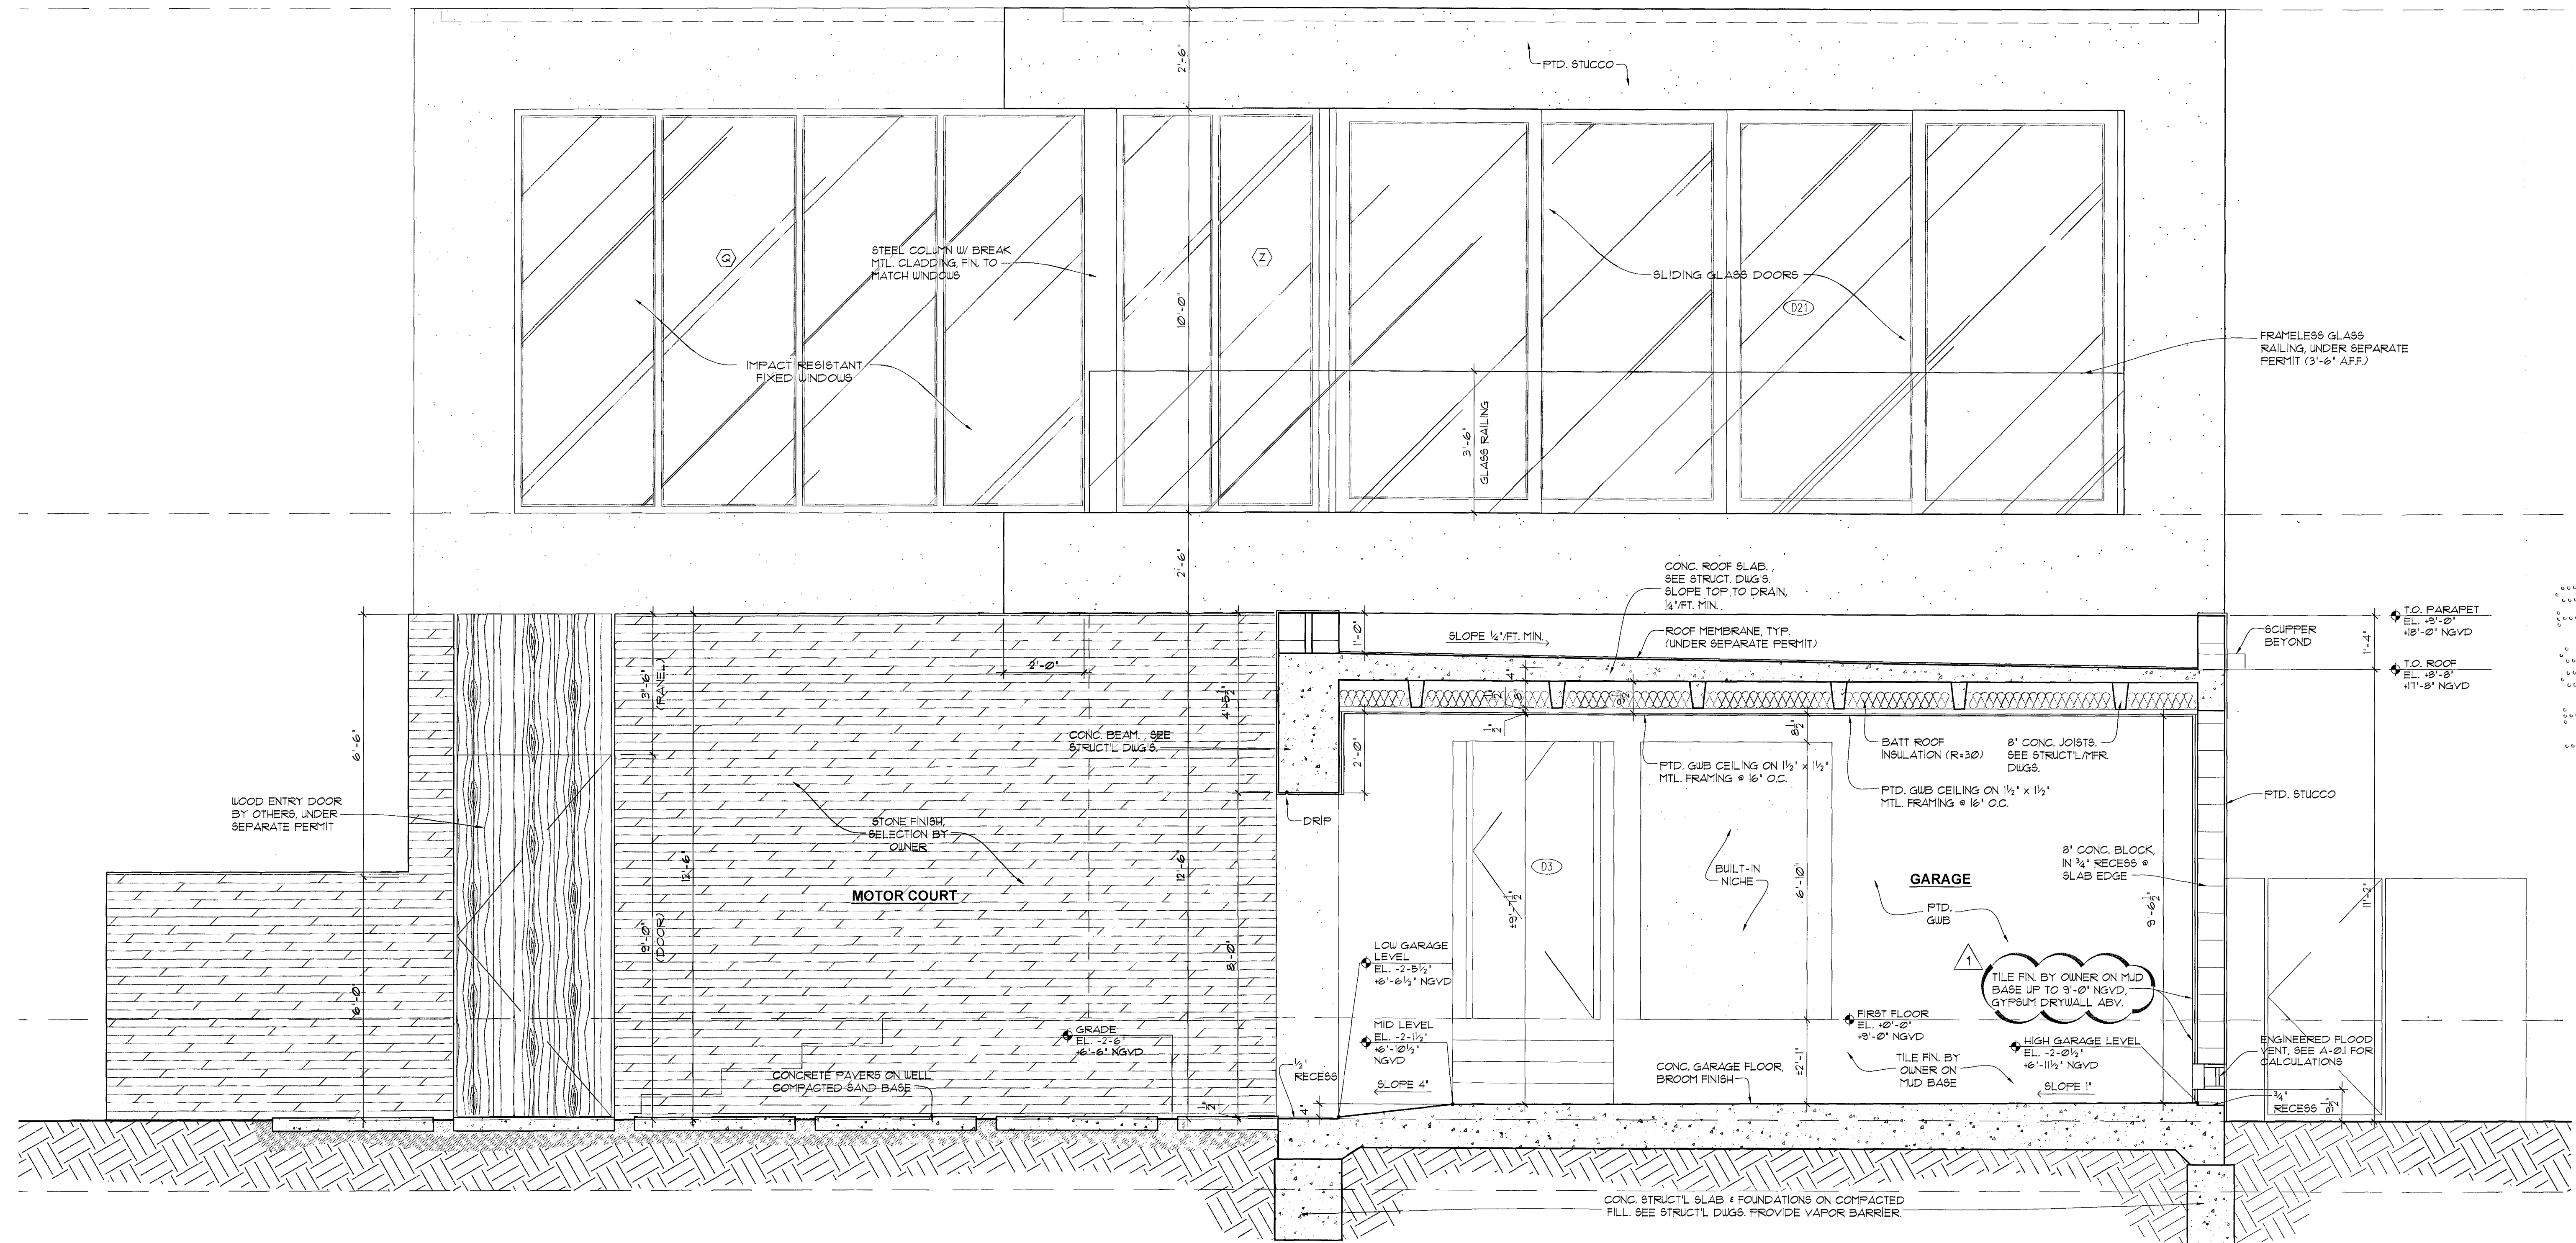

SECTION
A-3.1
SCALE 1/2" = 1'-0"

choeff + levy p.a.
architecture interior design

8425 biscayne blvd, suite 201
miami, florida 33138

www.choefflevy.com
AR0009679 AR0094779

Phone: 305.434.8338
Fax: 305.892.5292

DILIDO RESIDENCE

808 WEST DILIDO DR. MIAMI BEACH, FL 33139


comm no.
1241

date:
09-30-13

revised:
01-06-2014
OWNER/B.D. REV.


sheet no.
A-3.1

[Signature]
JAN 20 2014

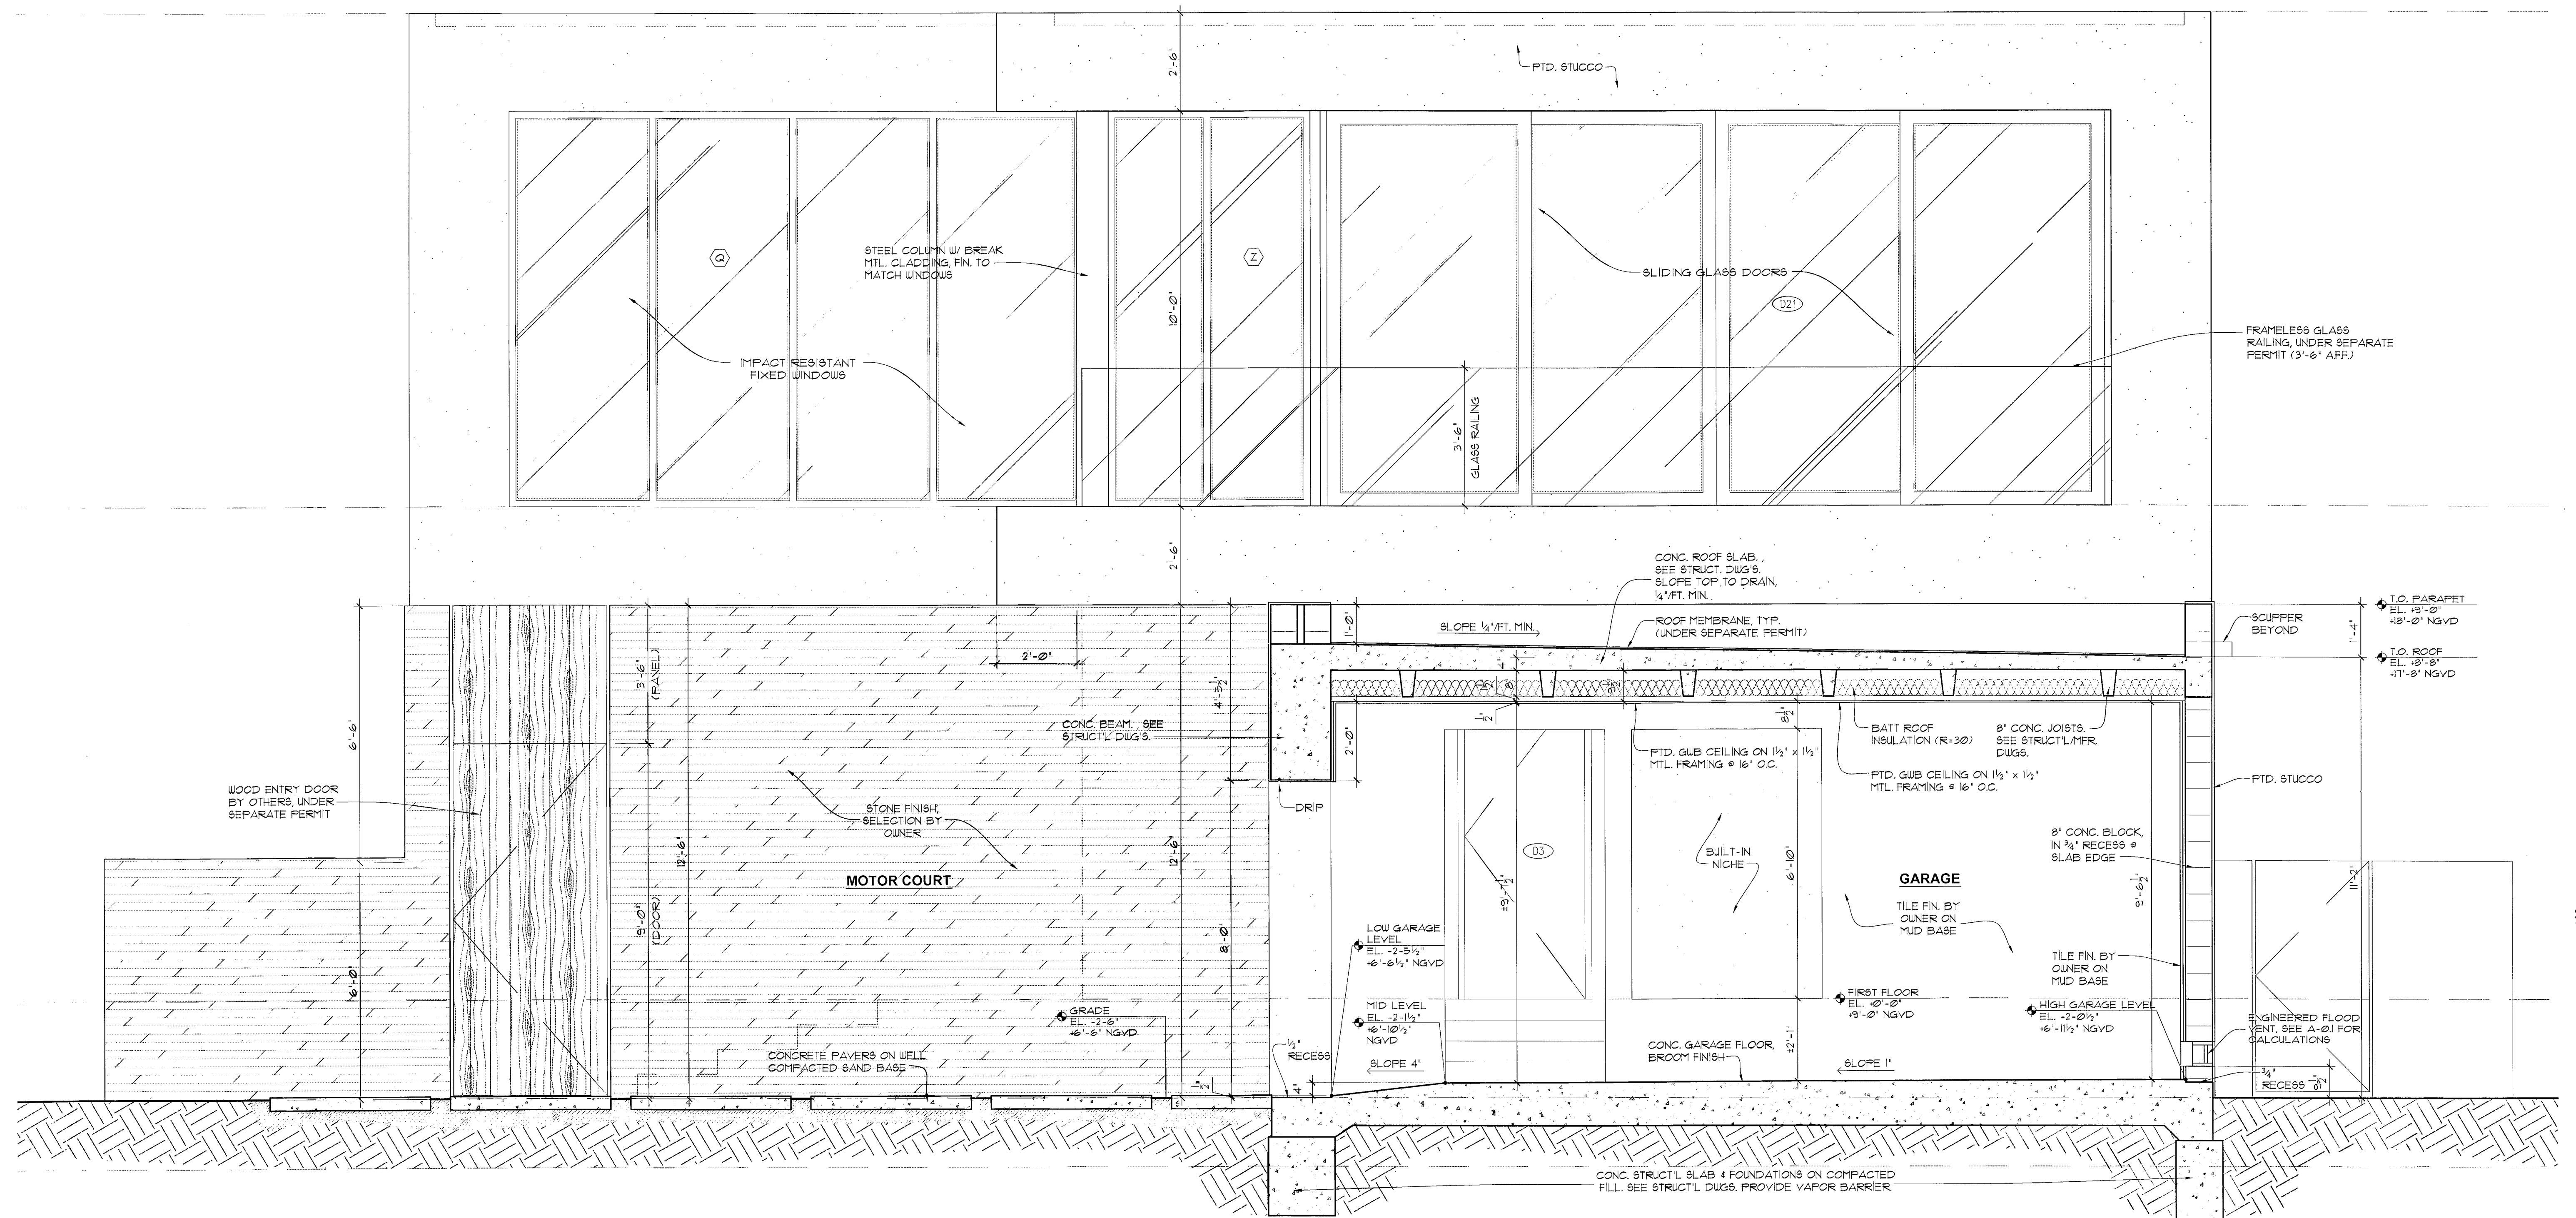

SECTION
A-31 SCALE 1/2" = 1'-0"

[Signature]
NOV 06 2013

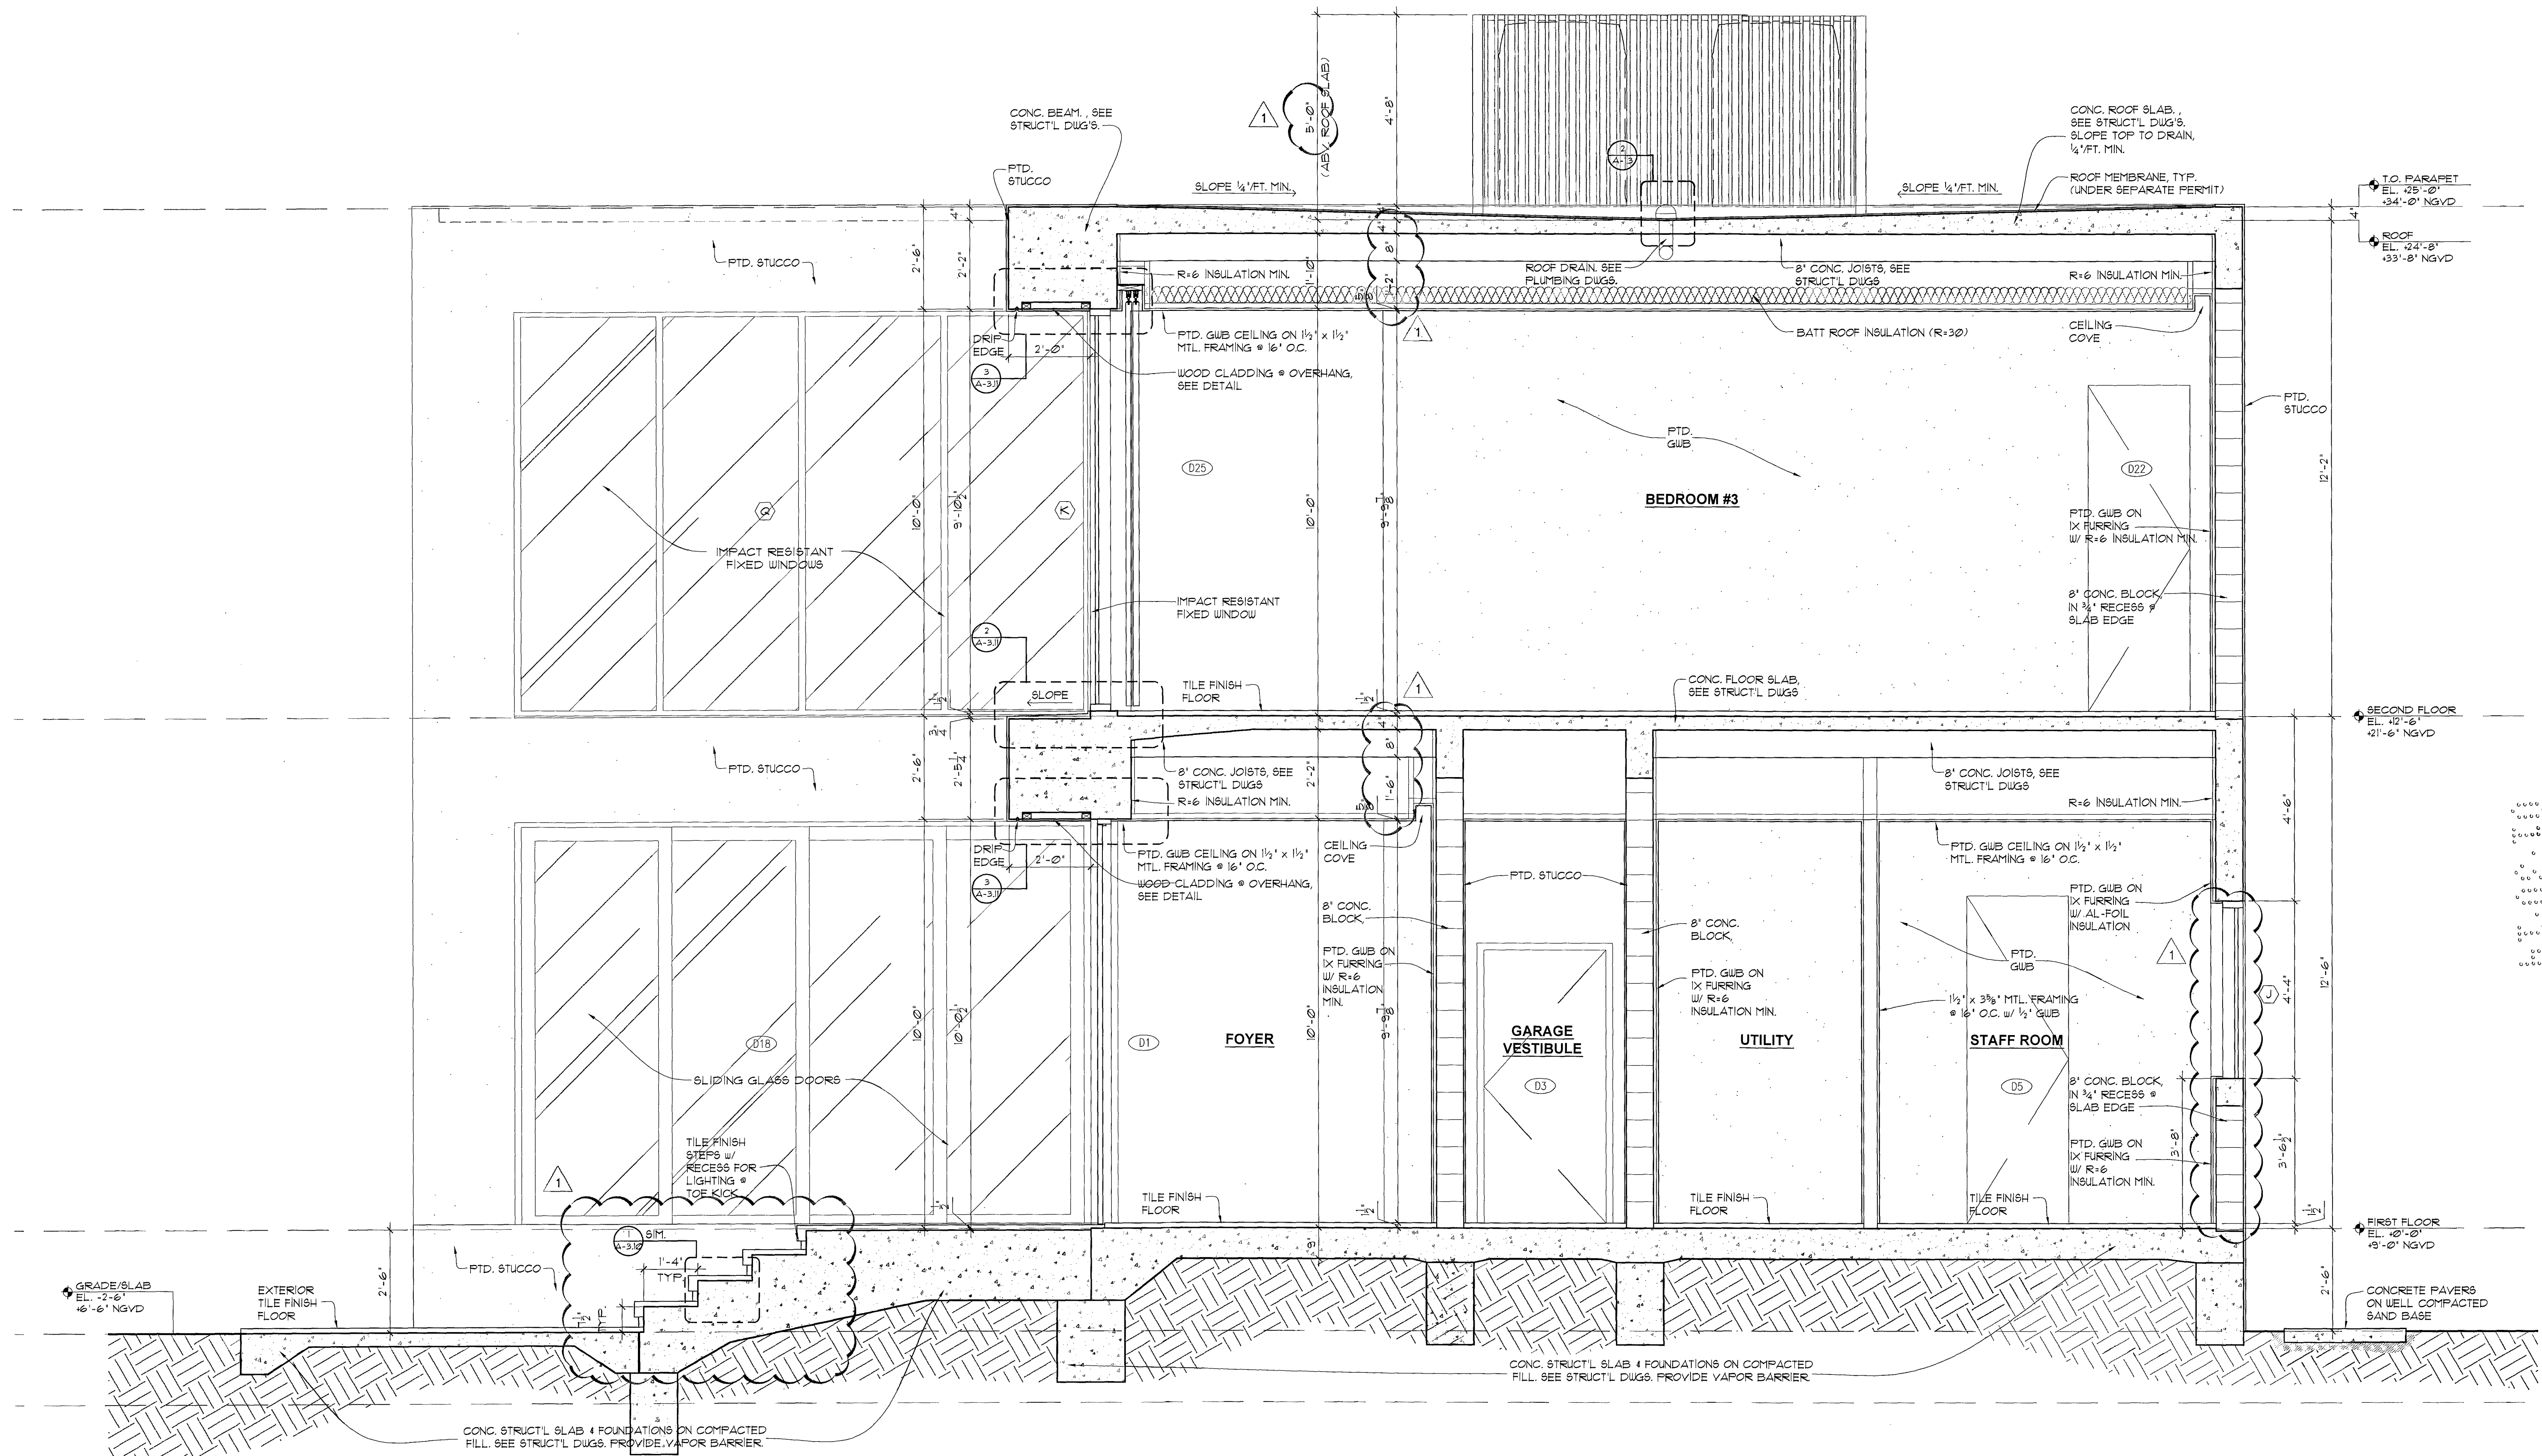

SECTION
A-A
SCALE 1/2" = 1'-0"

choeff + levy p.a.
architecture interior design

8425 biscayne blvd, suite 201
miami, florida 33138

www.choefflevy.com
AR0009679 AR0094779

Phone: 305.434.8338
Fax: 305.892.5292

DILIDO RESIDENCE

808 WEST DILIDO DR. MIAMI BEACH, FL 33139


comm no.
1241

date:
09-30-13

revised:
01-06-2014
OWNER/B.D. REV.

sheet no.
A-3.2

[Signature]
JAN 20 2014

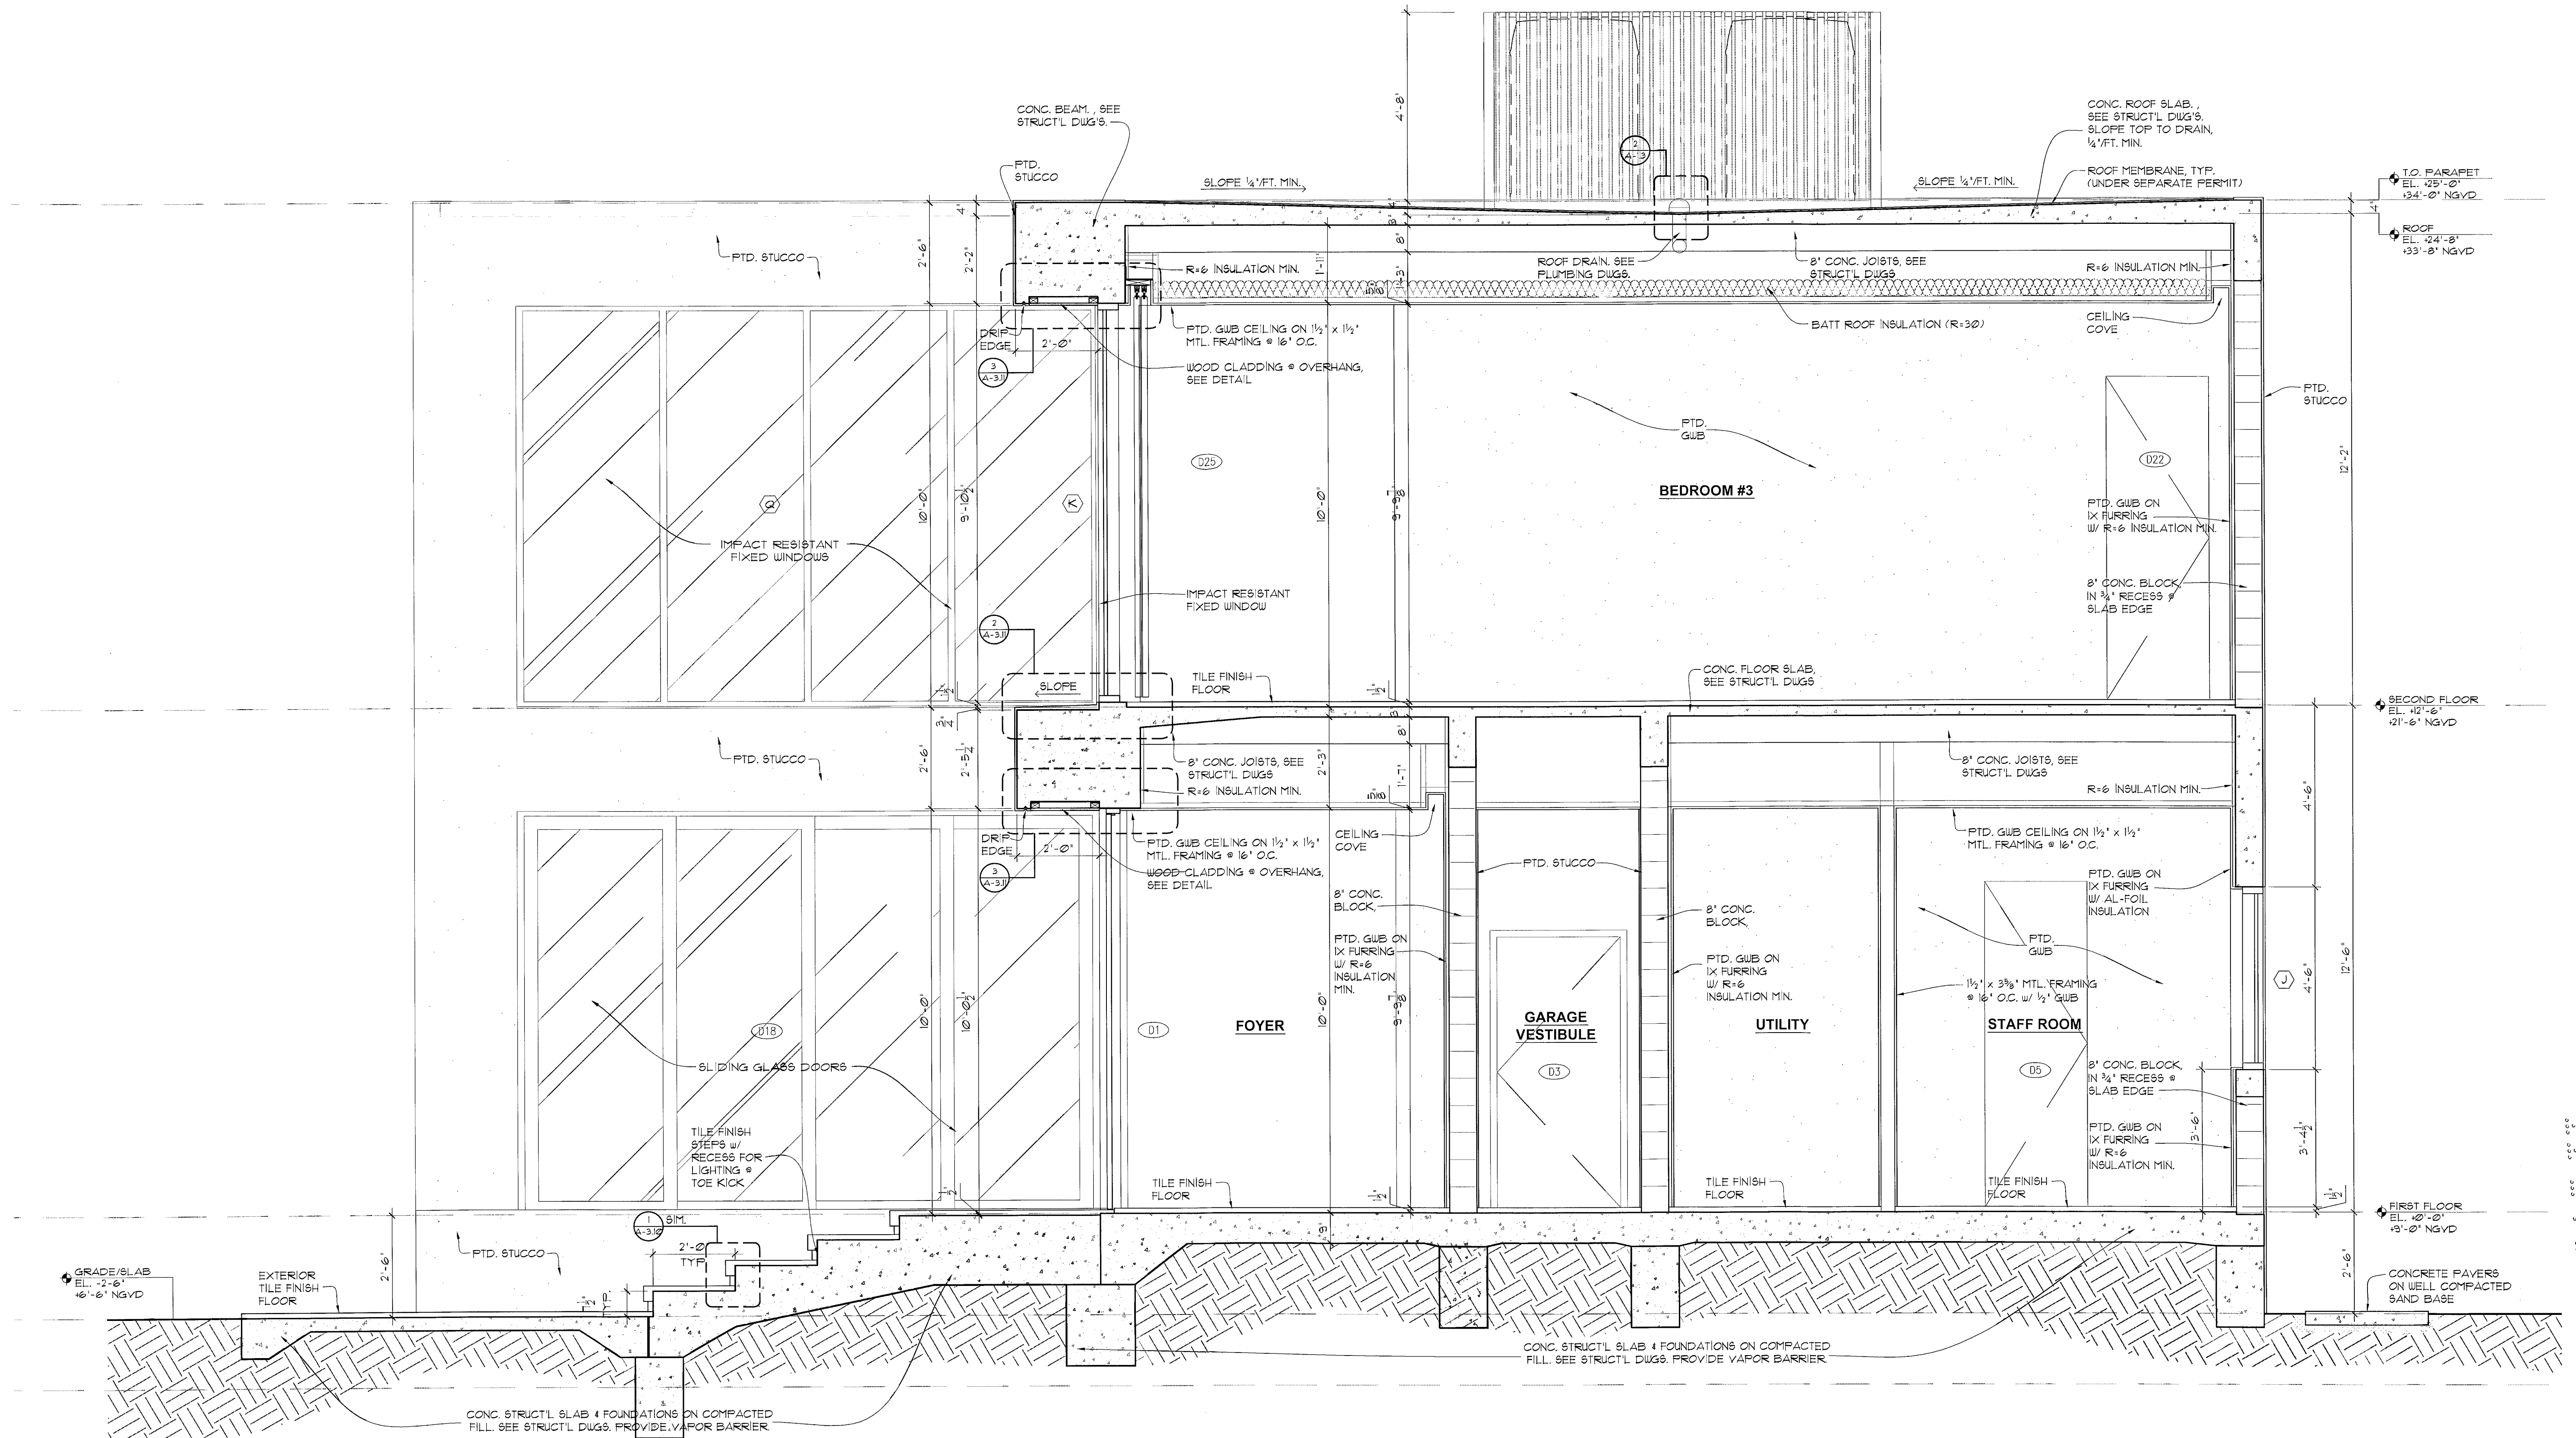

SECTION
A-32 SCALE 1/2" = 1'-0"

choeff + levy p.a.
architecture interior design

8425 biscayne blvd, suite 201
miami, florida 33138

www.choefflevy.com
AR0009679 AR0094779

Phone: 305.434.8338
Fax: 305.892.5292

DILIDO RESIDENCE

808 WEST DILIDO DR. MIAMI BEACH, FL 33139


comm no.
1241

date:
09-30-13

revised:

sheet no.
A-3.2

[Handwritten signature]
NOV 06 2013

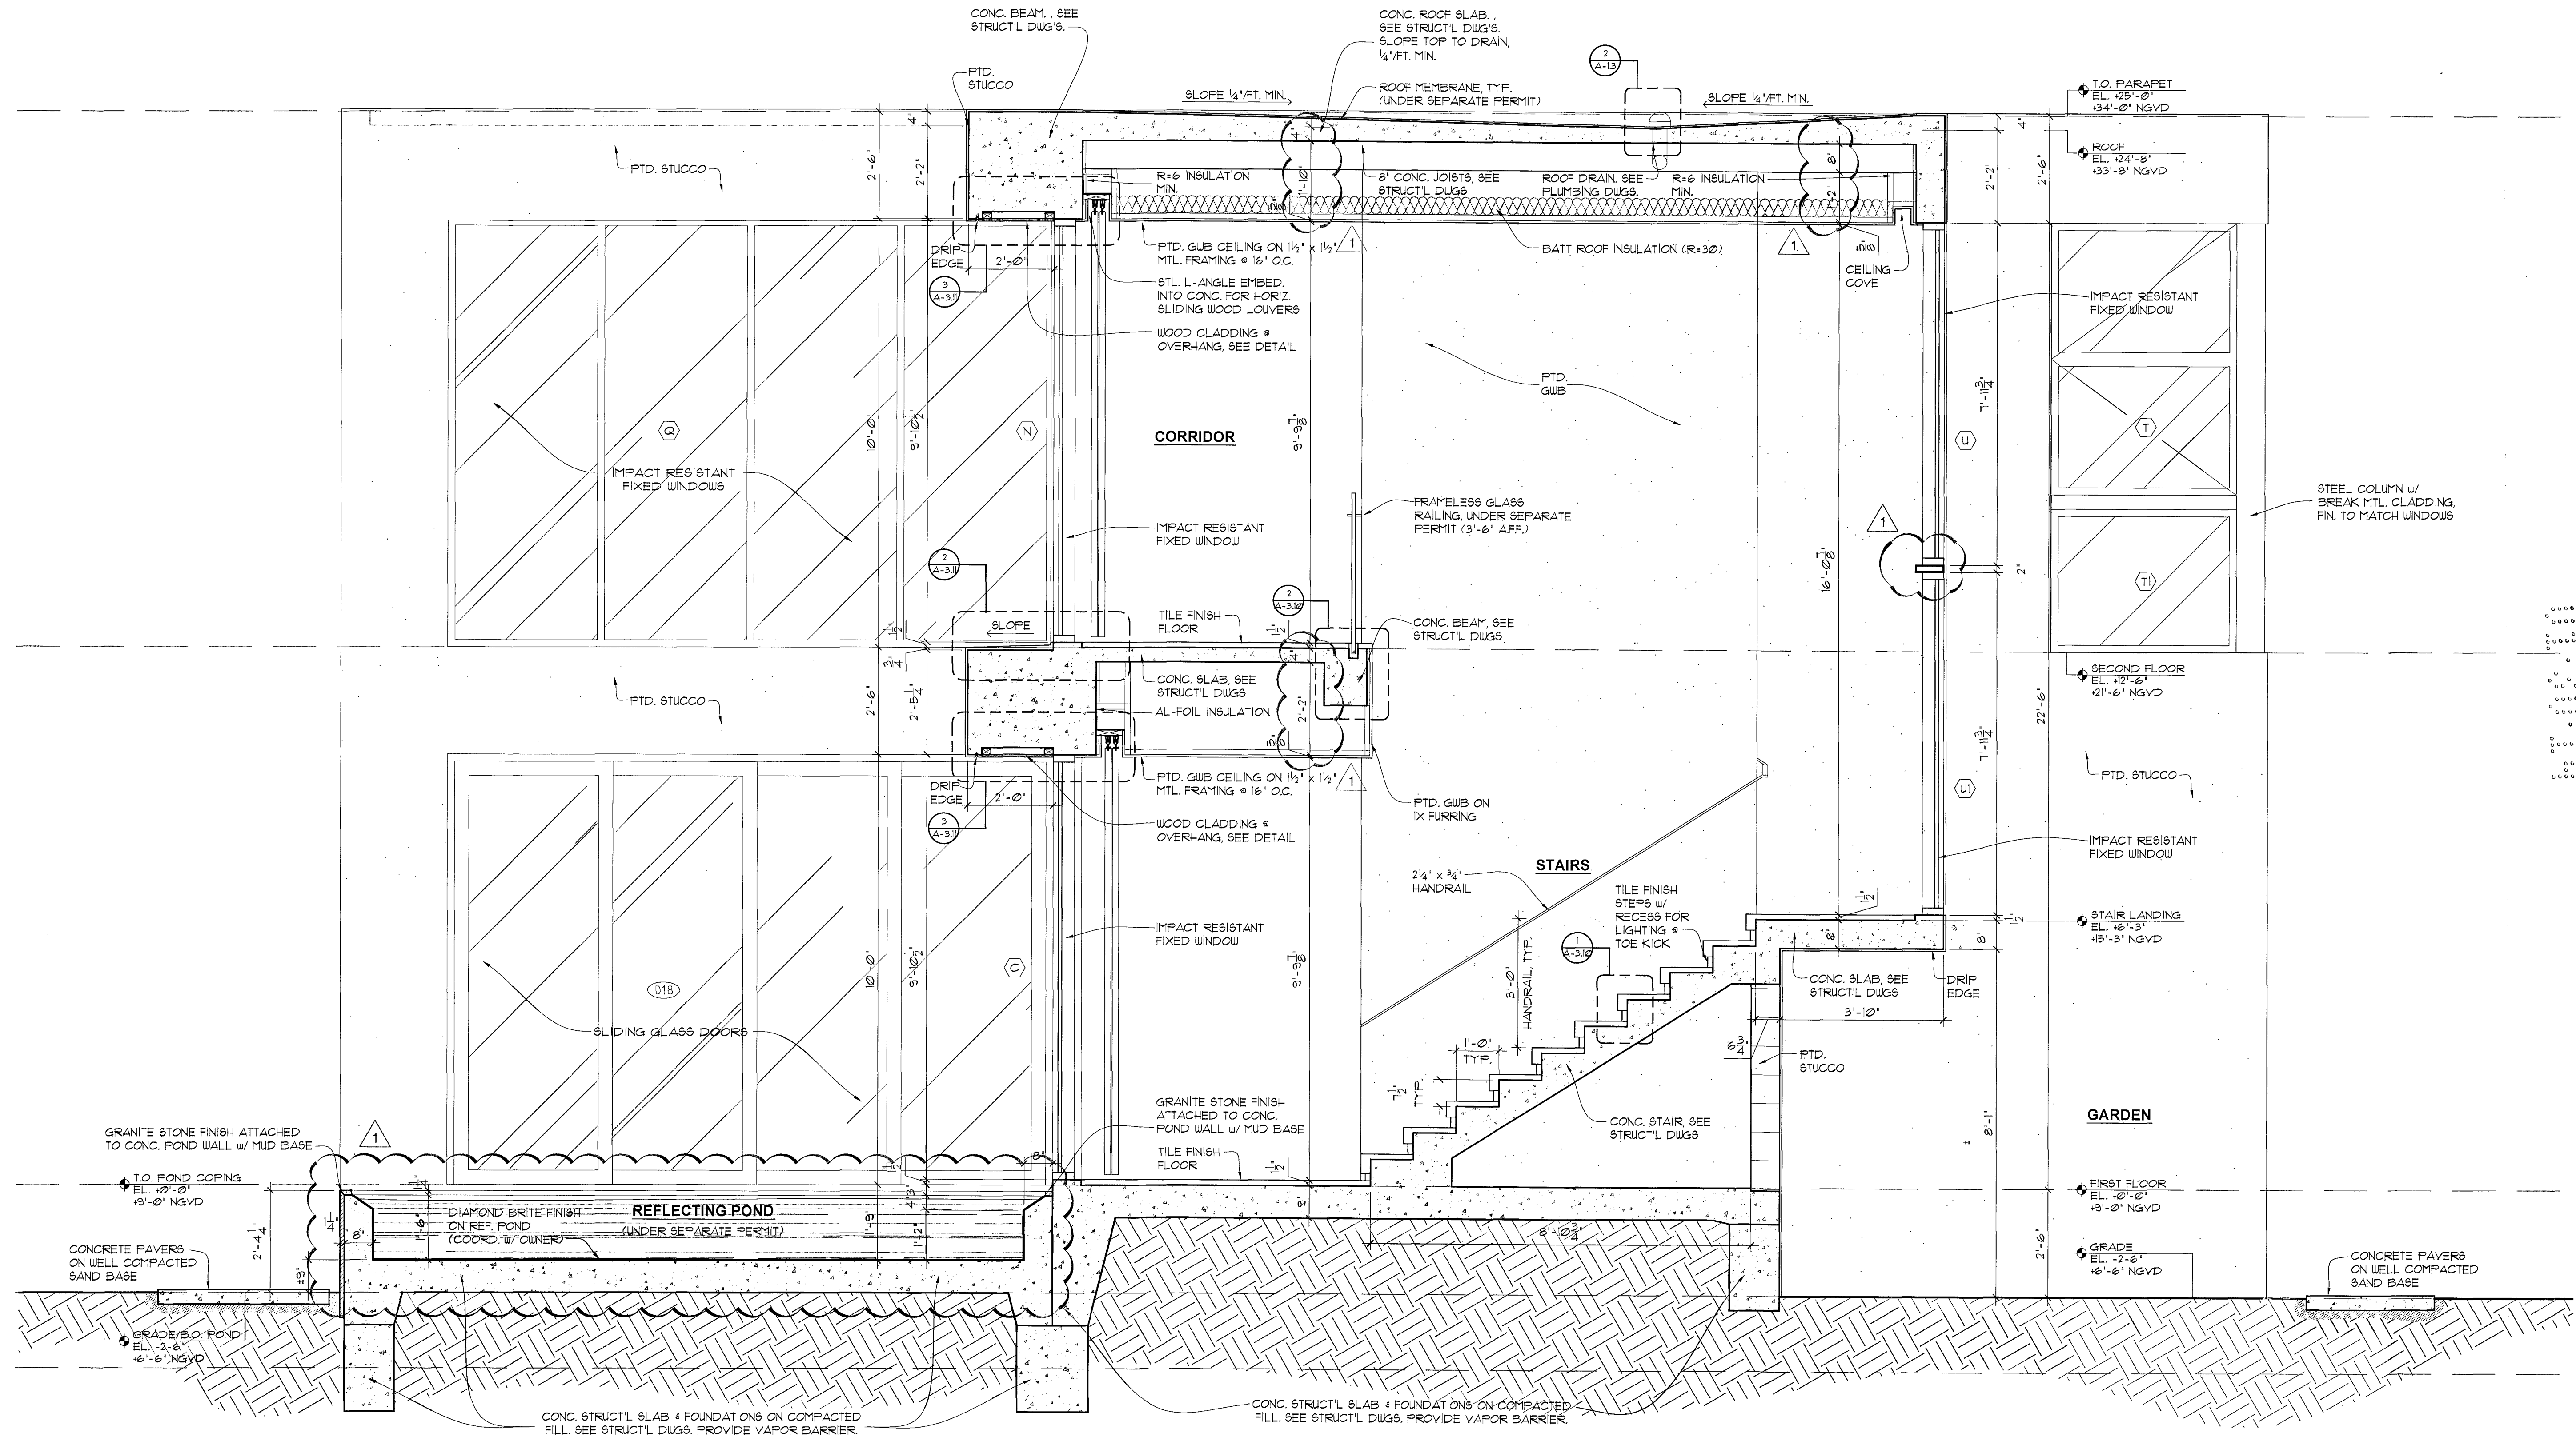

SECTION
A-3.3 SCALE 1/2" = 1'-0"

choeff + levy p.a.
architecture interior design

8425 biscayne blvd, suite 201
miami, florida 33138

www.choefflevy.com
AR0009679 AR0094779

Phone: 305.434.8338
Fax: 305.892.5292

DILIDO RESIDENCE

808 WEST DILIDO DR. MIAMI BEACH, FL 33139


comm no.
1241

date:
09-30-13


revised:
01-06-2014
OWNER/B.D. REV.

sheet no.
A-3.3

[Signature]
JAN 20 2014

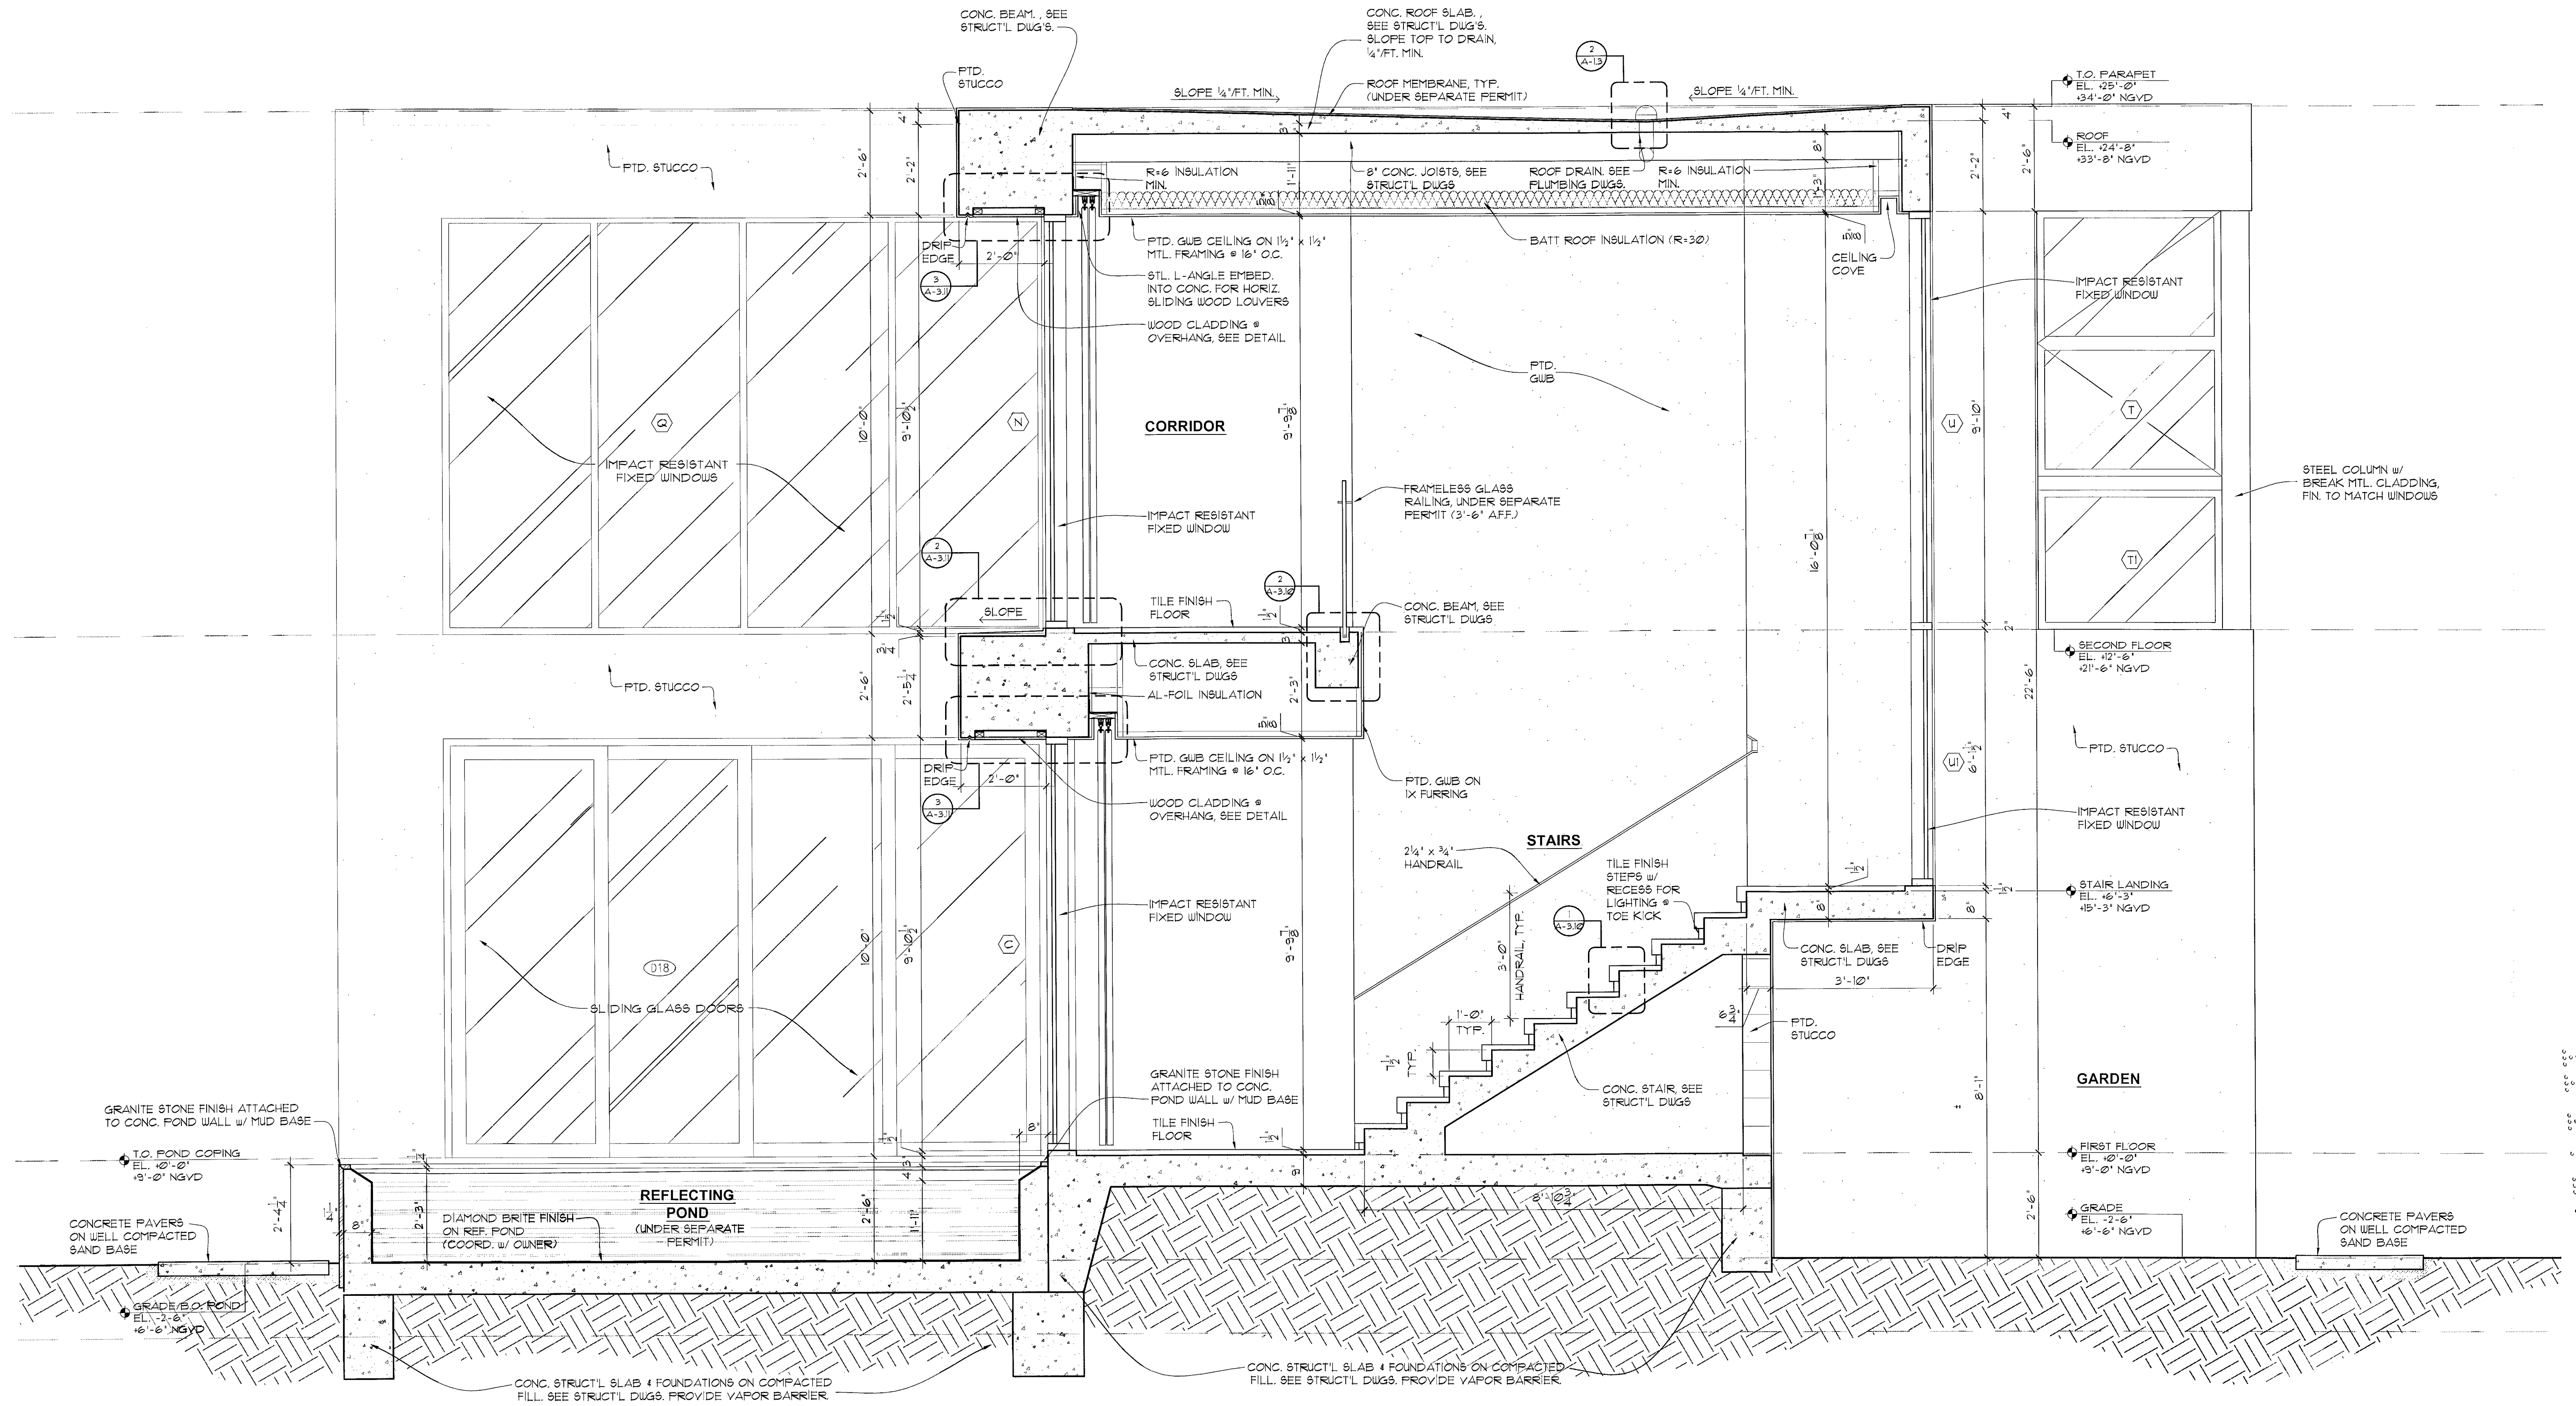

1 SECTION
A-3.3 SCALE 1/2" = 1'-0"

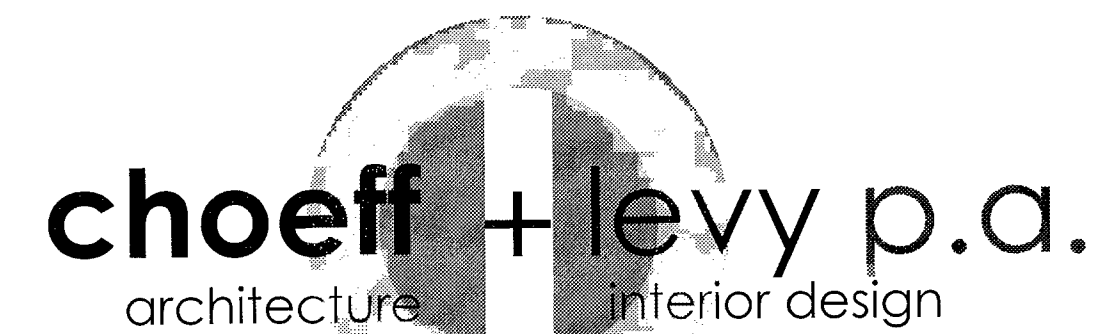

8425 biscayne blvd, suite 201
miami, florida 33138

www.choefflevy.com
AR0009679 AR0094779

Phone: 305.434.8338
Fax: 305.892.5292

DILIDO RESIDENCE
808 WEST DILIDO DR. MIAMI BEACH, FL 33139


comm no.
1241

date:
09-30-13

revised:

sheet no.
A-3.3

[Signature]
NOV 06 2013

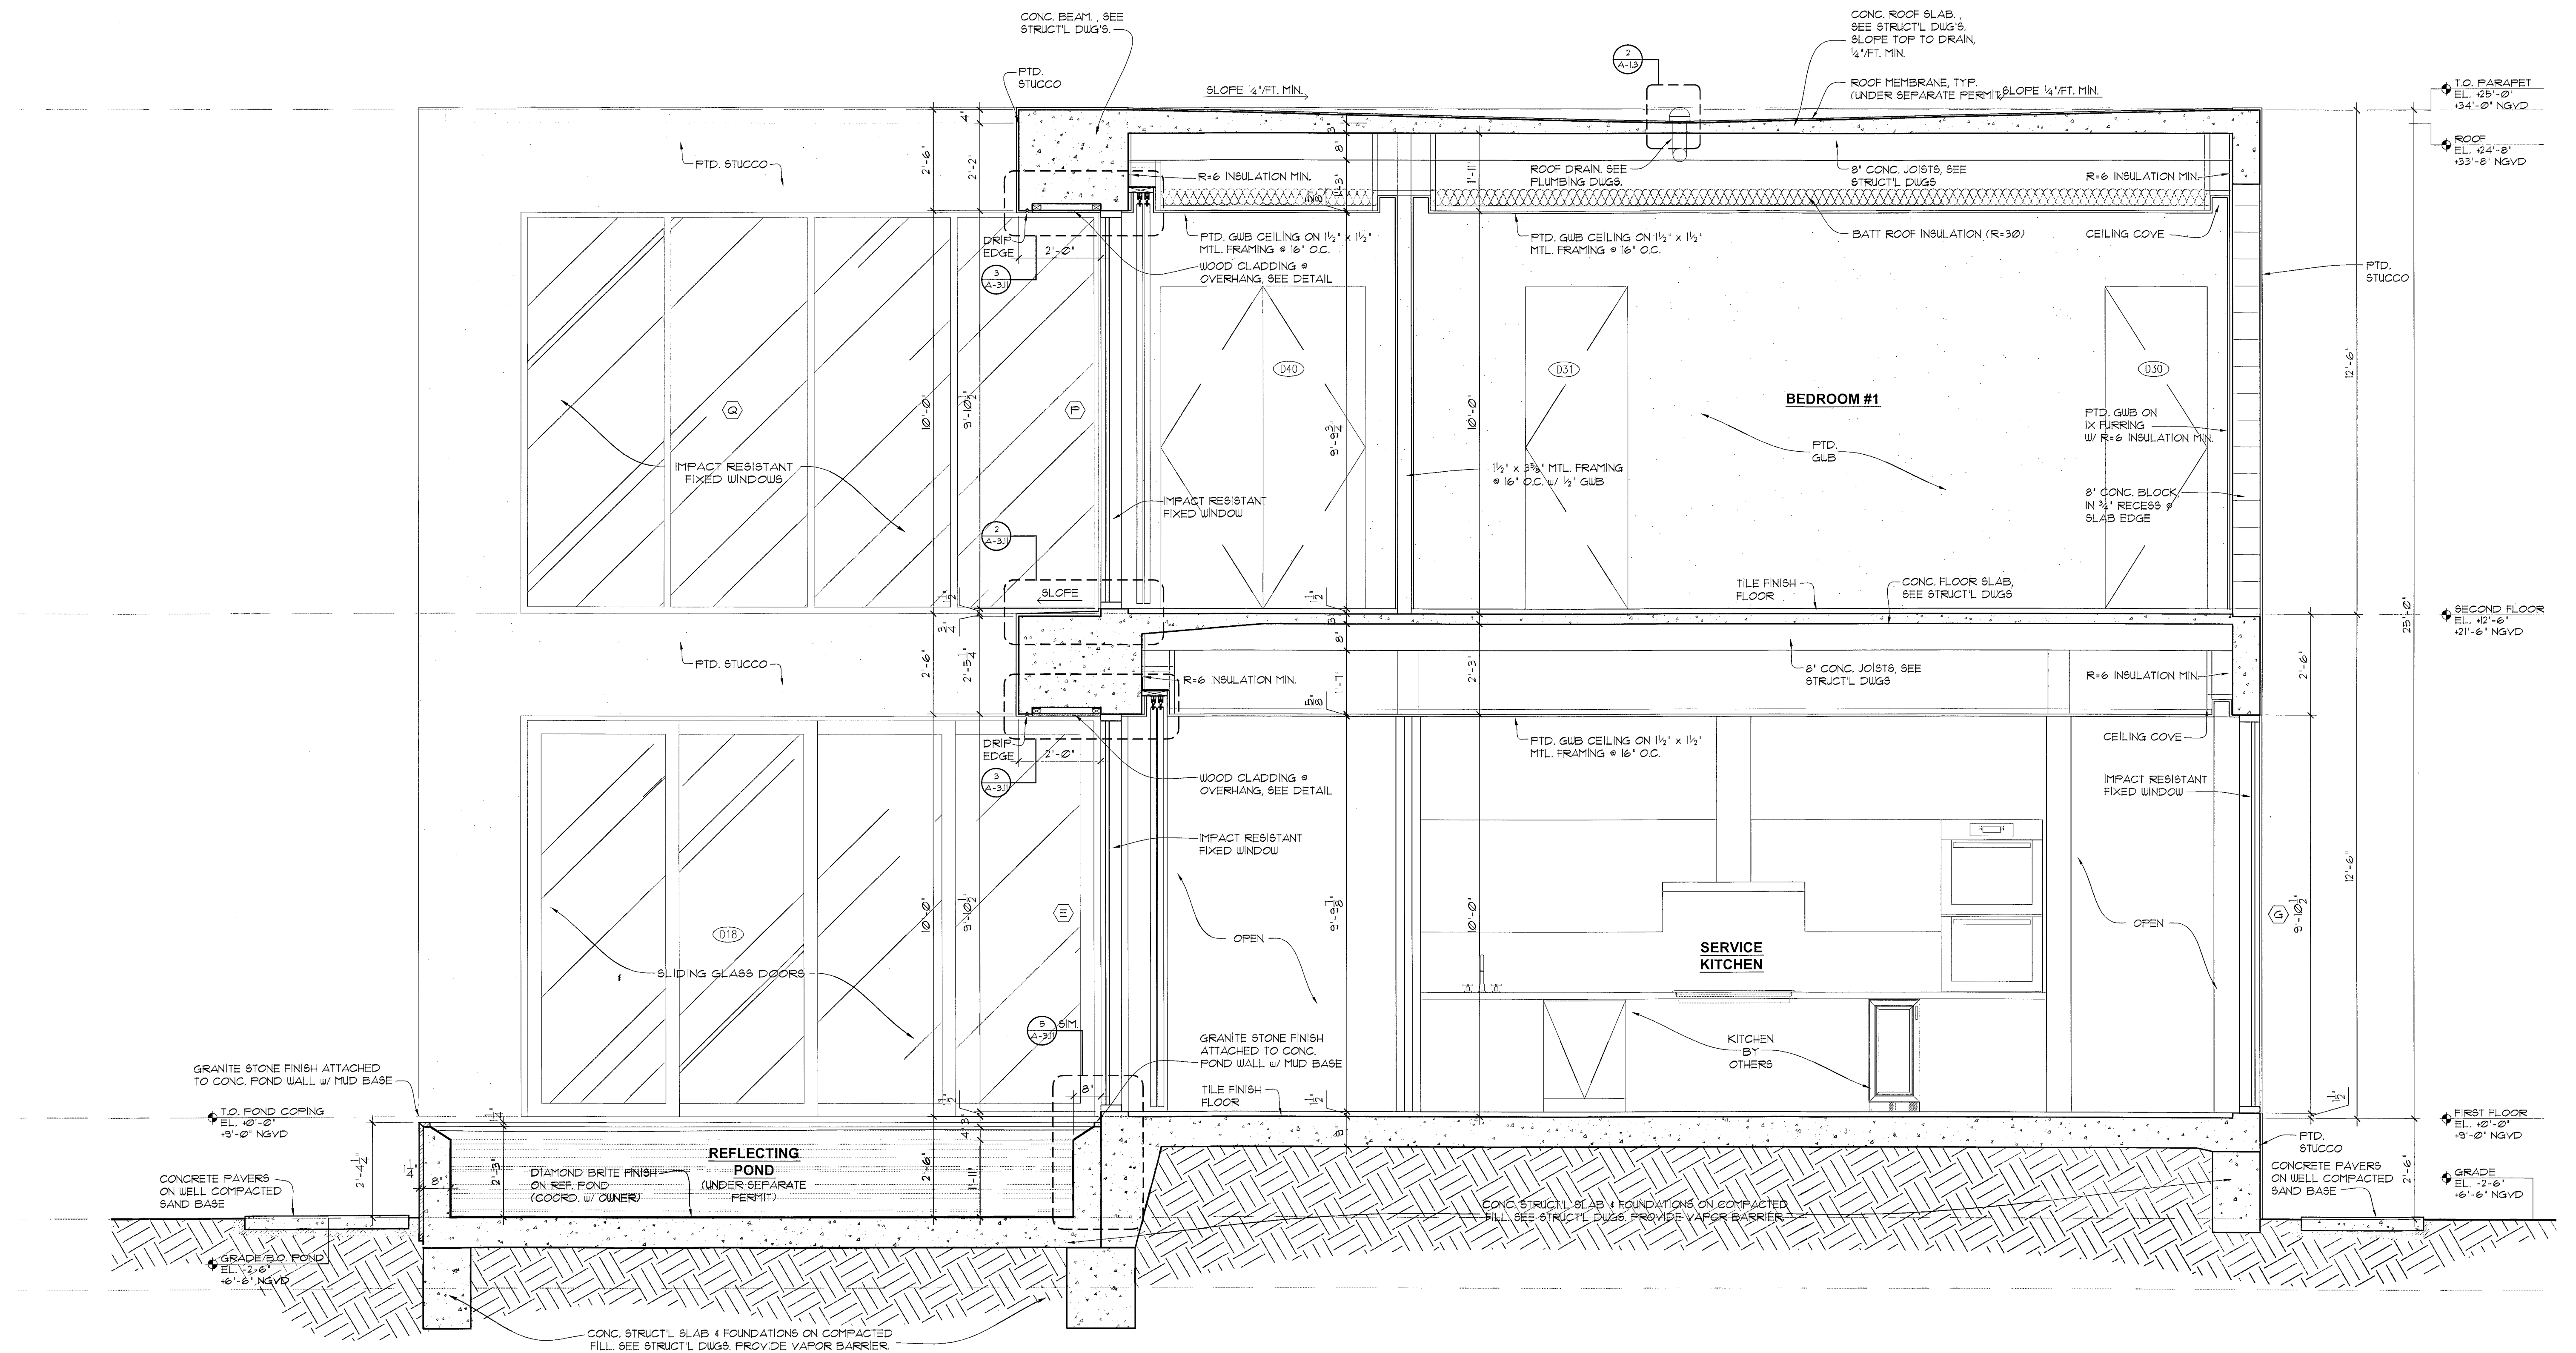

SECTION
A-A SCALE 1/2" = 1'-0"

choeff + levy p.a.
architecture interior design

8425 biscayne blvd, suite 201
miami, florida 33138

www.choefflevy.com
AR0009679 AR0094779

Phone: 305.434.8338
Fax: 305.892.5292

DILIDO RESIDENCE
808 WEST DILIDO DR. MIAMI BEACH, FL 33139


comm no.
1241

date:
09-30-13

revised:

sheet no.
A-3.4

[Signature]
NOV 06 2013

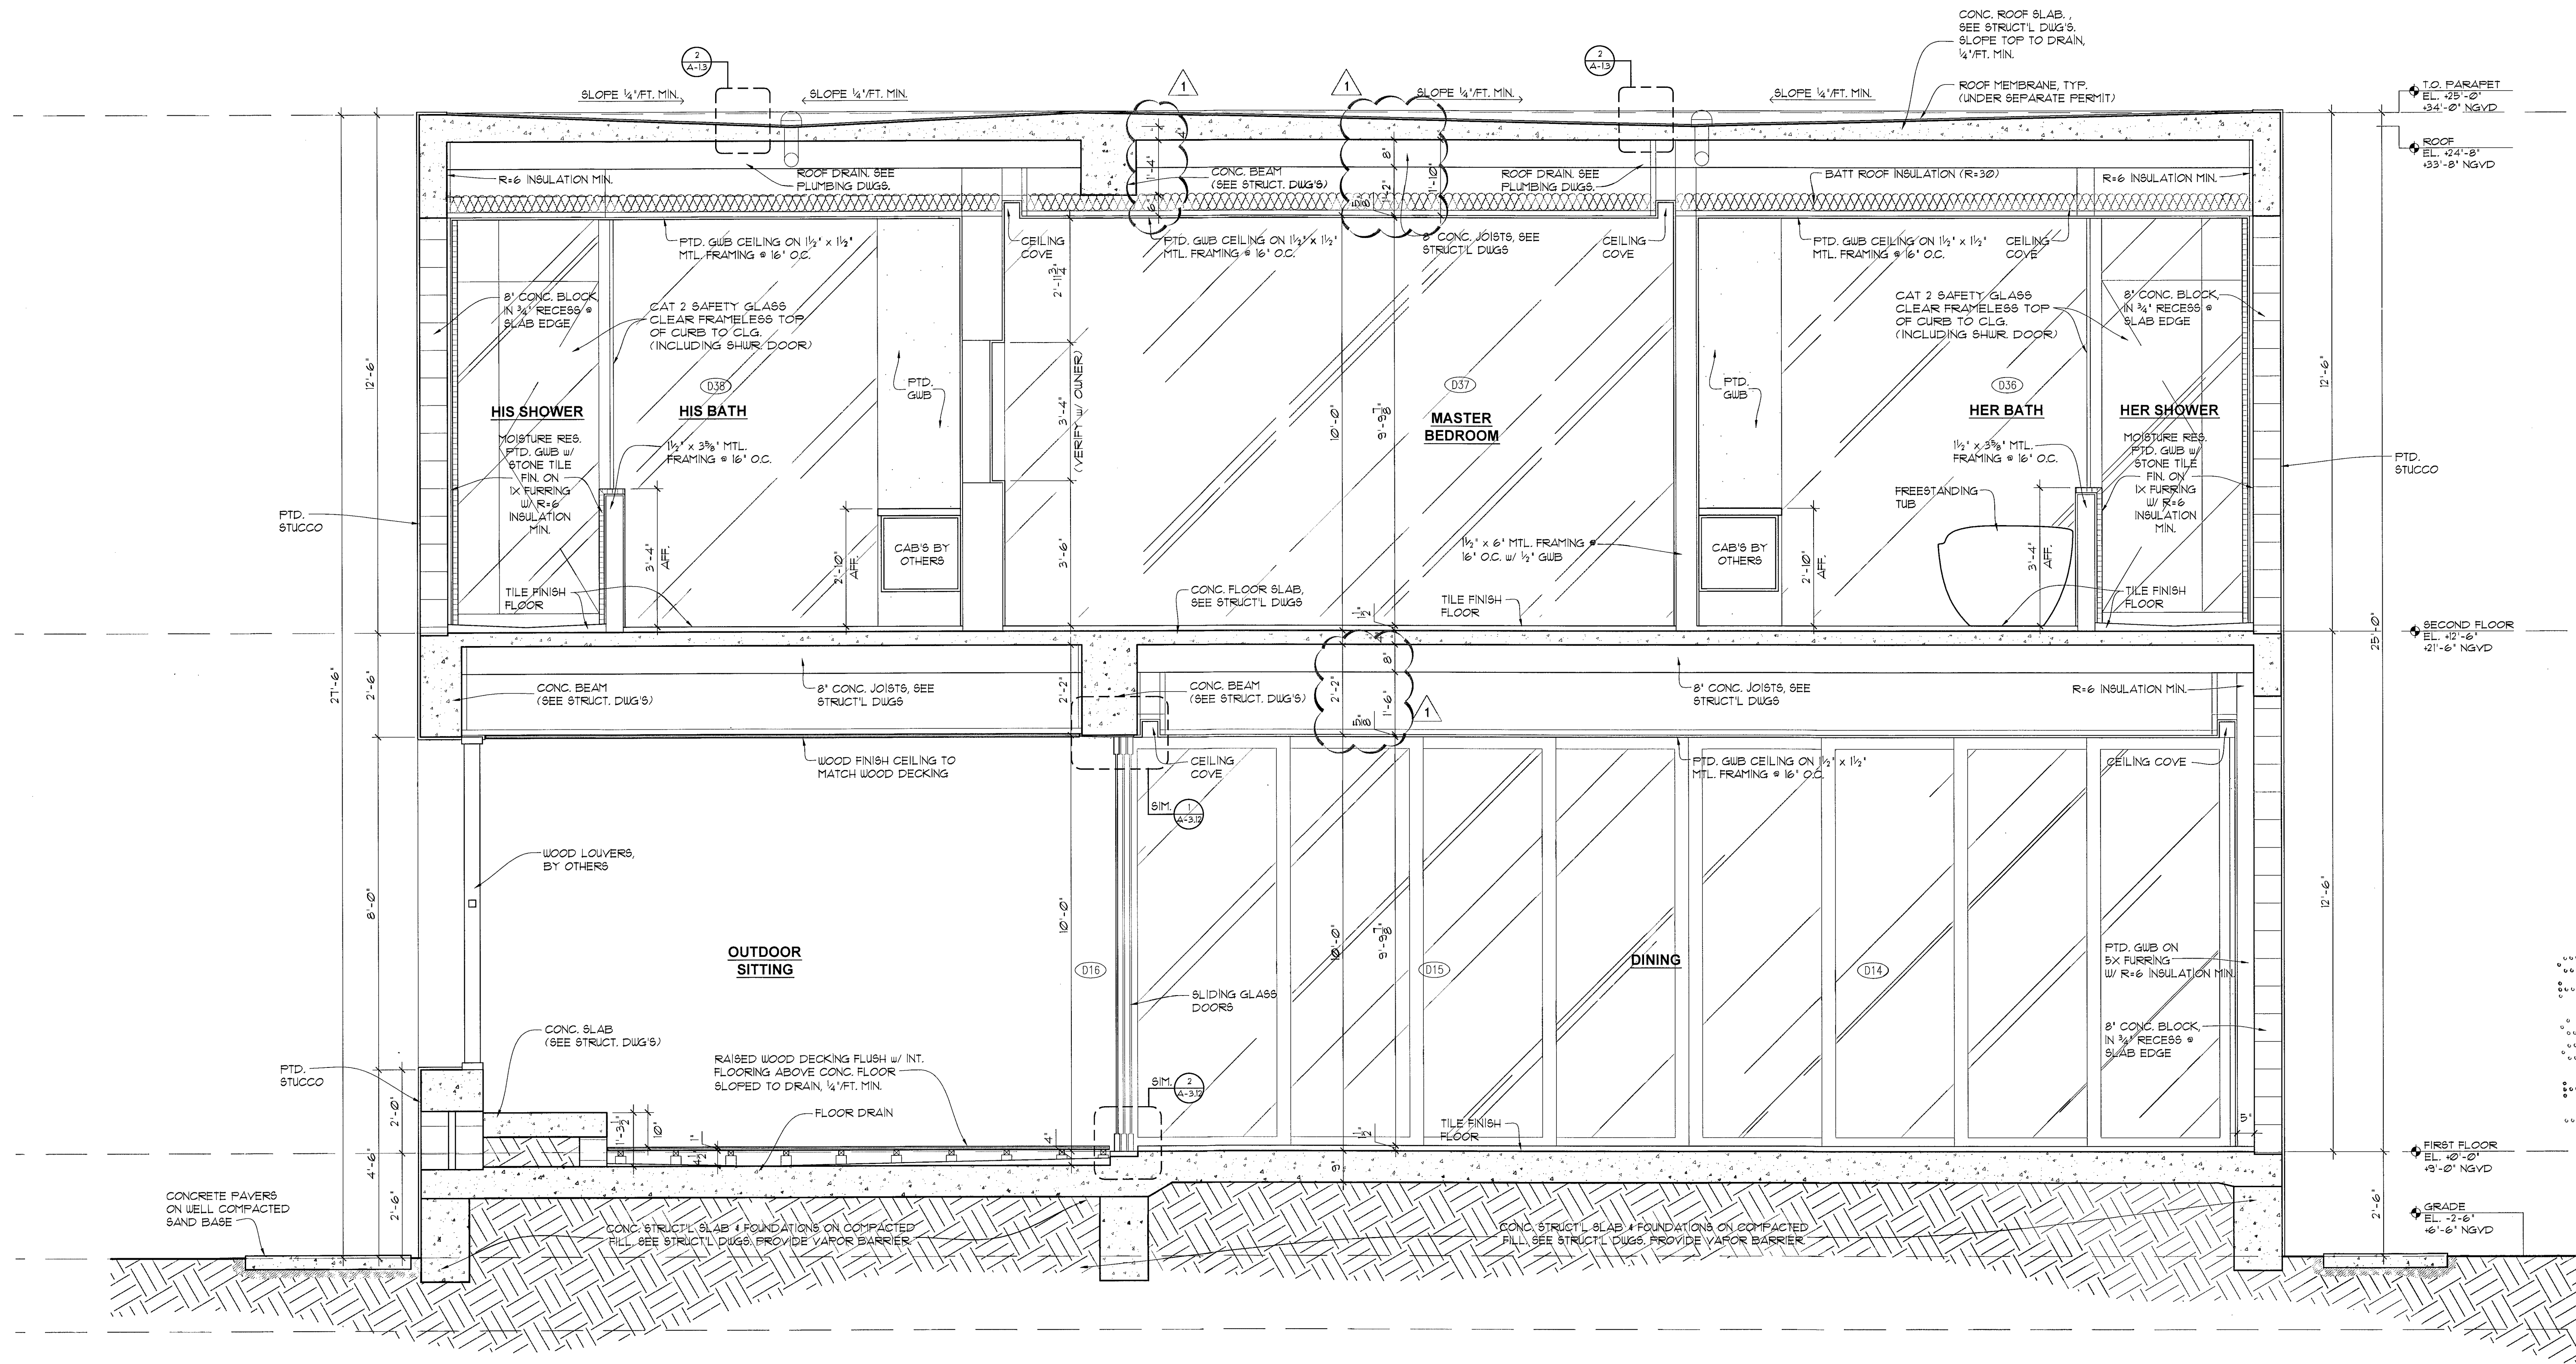

1 SECTION
A-33 SCALE 1/2" = 1'-0"

choeff + levy p.a.
architecture interior design

8425 biscayne blvd, suite 201
miami, florida 33138

www.choefflevy.com
AR0009679 AR0094779

Phone: 305.434.8338
Fax: 305.892.5292

DILIDO RESIDENCE

808 WEST DILIDO DR. MIAMI BEACH, FL 33139


comm no.
1241

date:
09-30-13

revised:
01-06-2014
OWNER/B.D. REV.

sheet no.
A-3.5

[Signature]
JAN 20 2014

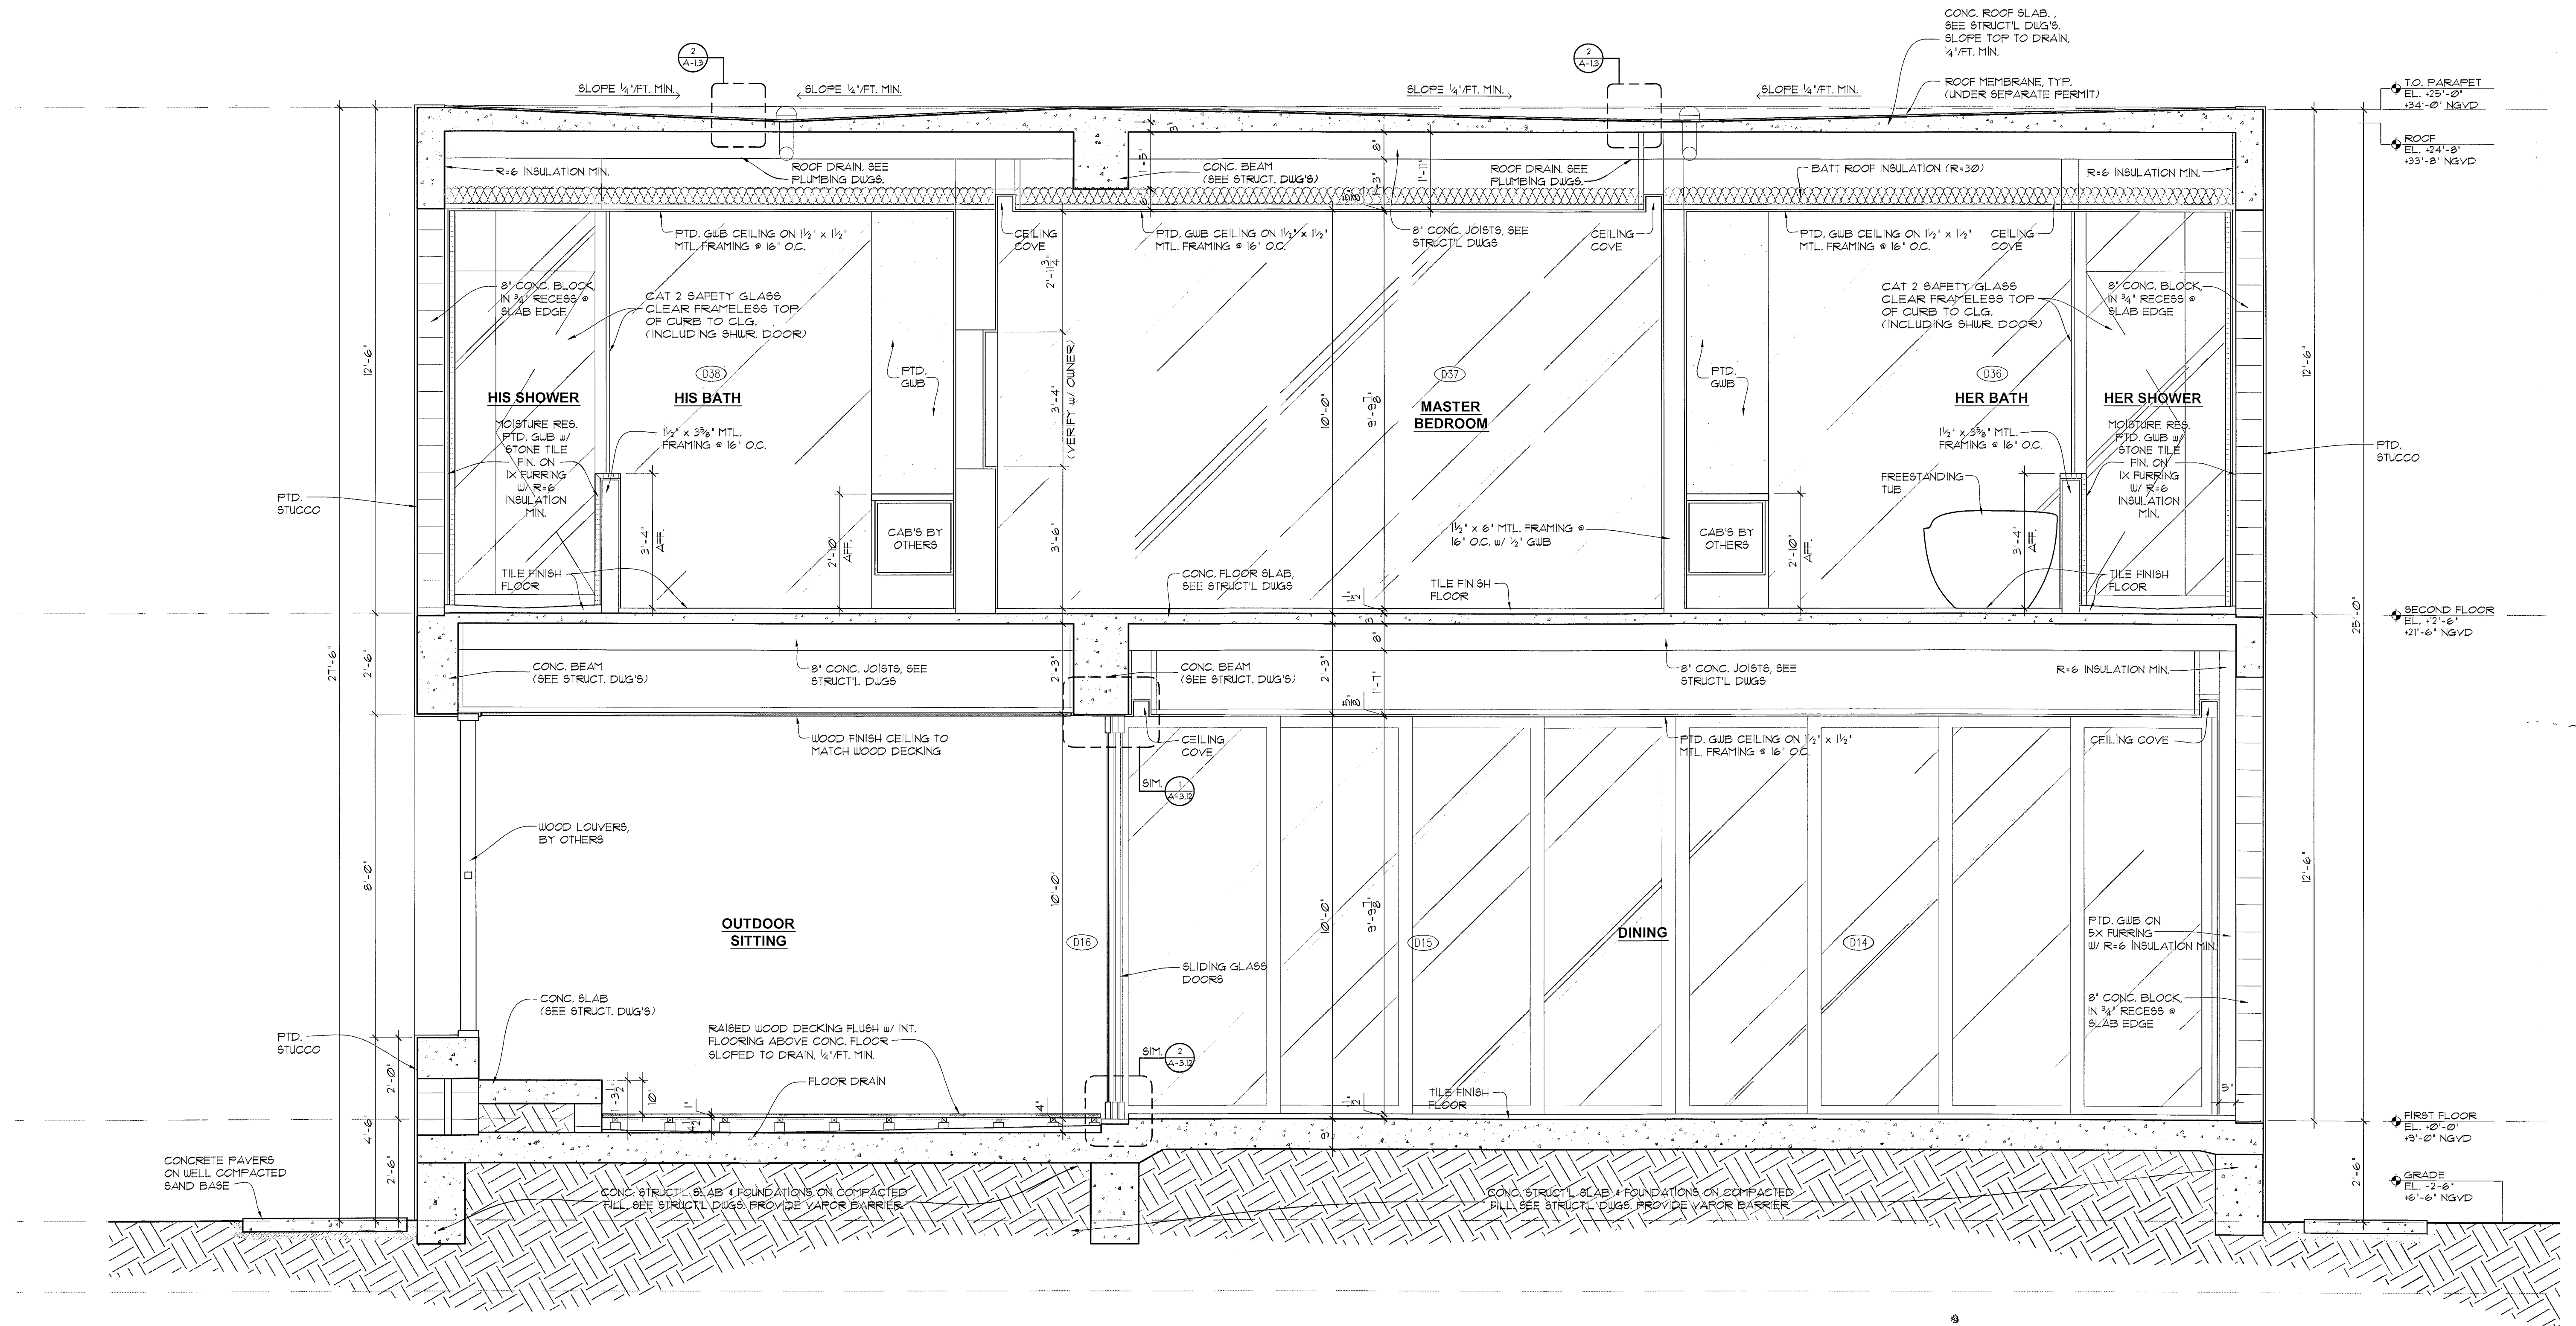

9

SECTION
A-35 SCALE 1/2" = 1'-0"

choeff + levy p.a.
architecture interior design

8425 biscayne blvd, suite 201
miami, florida 33138

www.choefflevy.com
AR0009679 AR0094779

Phone: 305.434.8338
Fax: 305.892.5292

DILIDO RESIDENCE

808 WEST DILIDO DR. MIAMI BEACH, FL 33139


comm no.
1241

date:
09-30-13

revised:

sheet no.
A-3.5

[Signature]
06 2013

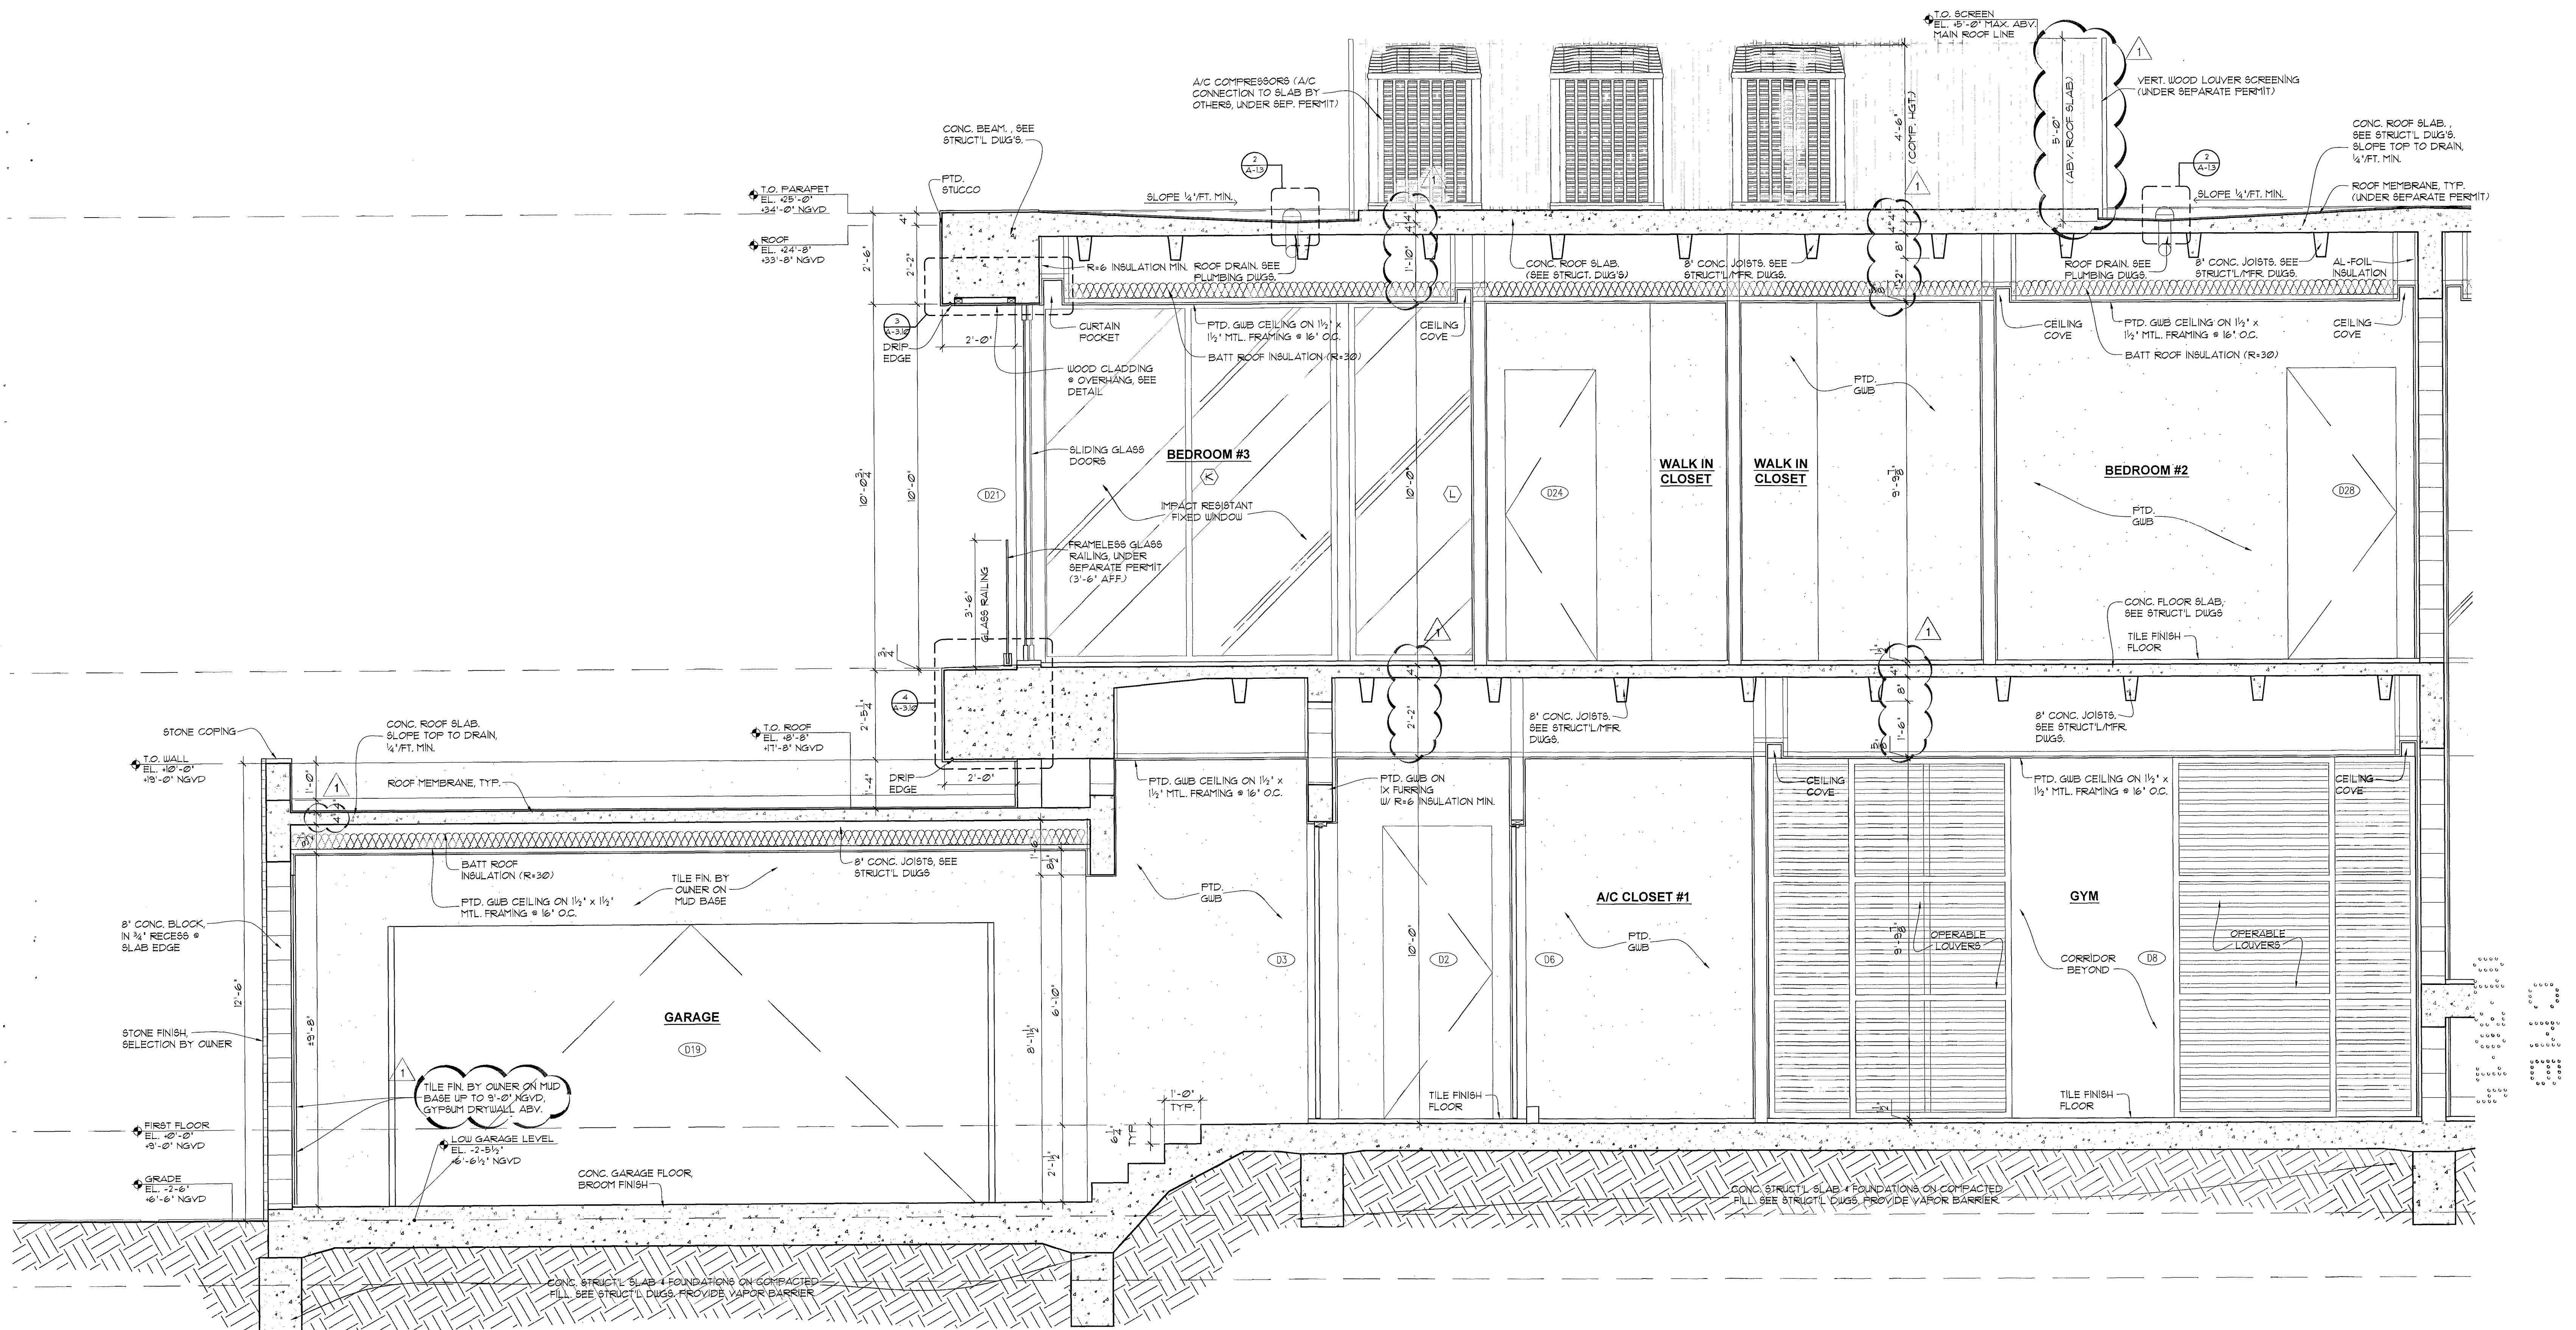

SECTION
A-3A
SCALE 1/2" = 1'-0"

choeff + levy p.a.
architecture interior design

8425 biscayne blvd, suite 201
miami, florida 33138

www.choefflevy.com
AR0009679 AR0094779

Phone: 305.434.8338
Fax: 305.892.5292

DILIDO RESIDENCE

808 WEST DILIDO DR. MIAMI BEACH, FL 33139


comm no.
1241

date:
09-30-13

revised:
01-06-2014
OWNER/B.D. REV.

sheet no.
A-3.6

[Signature]
JAN 20 2014

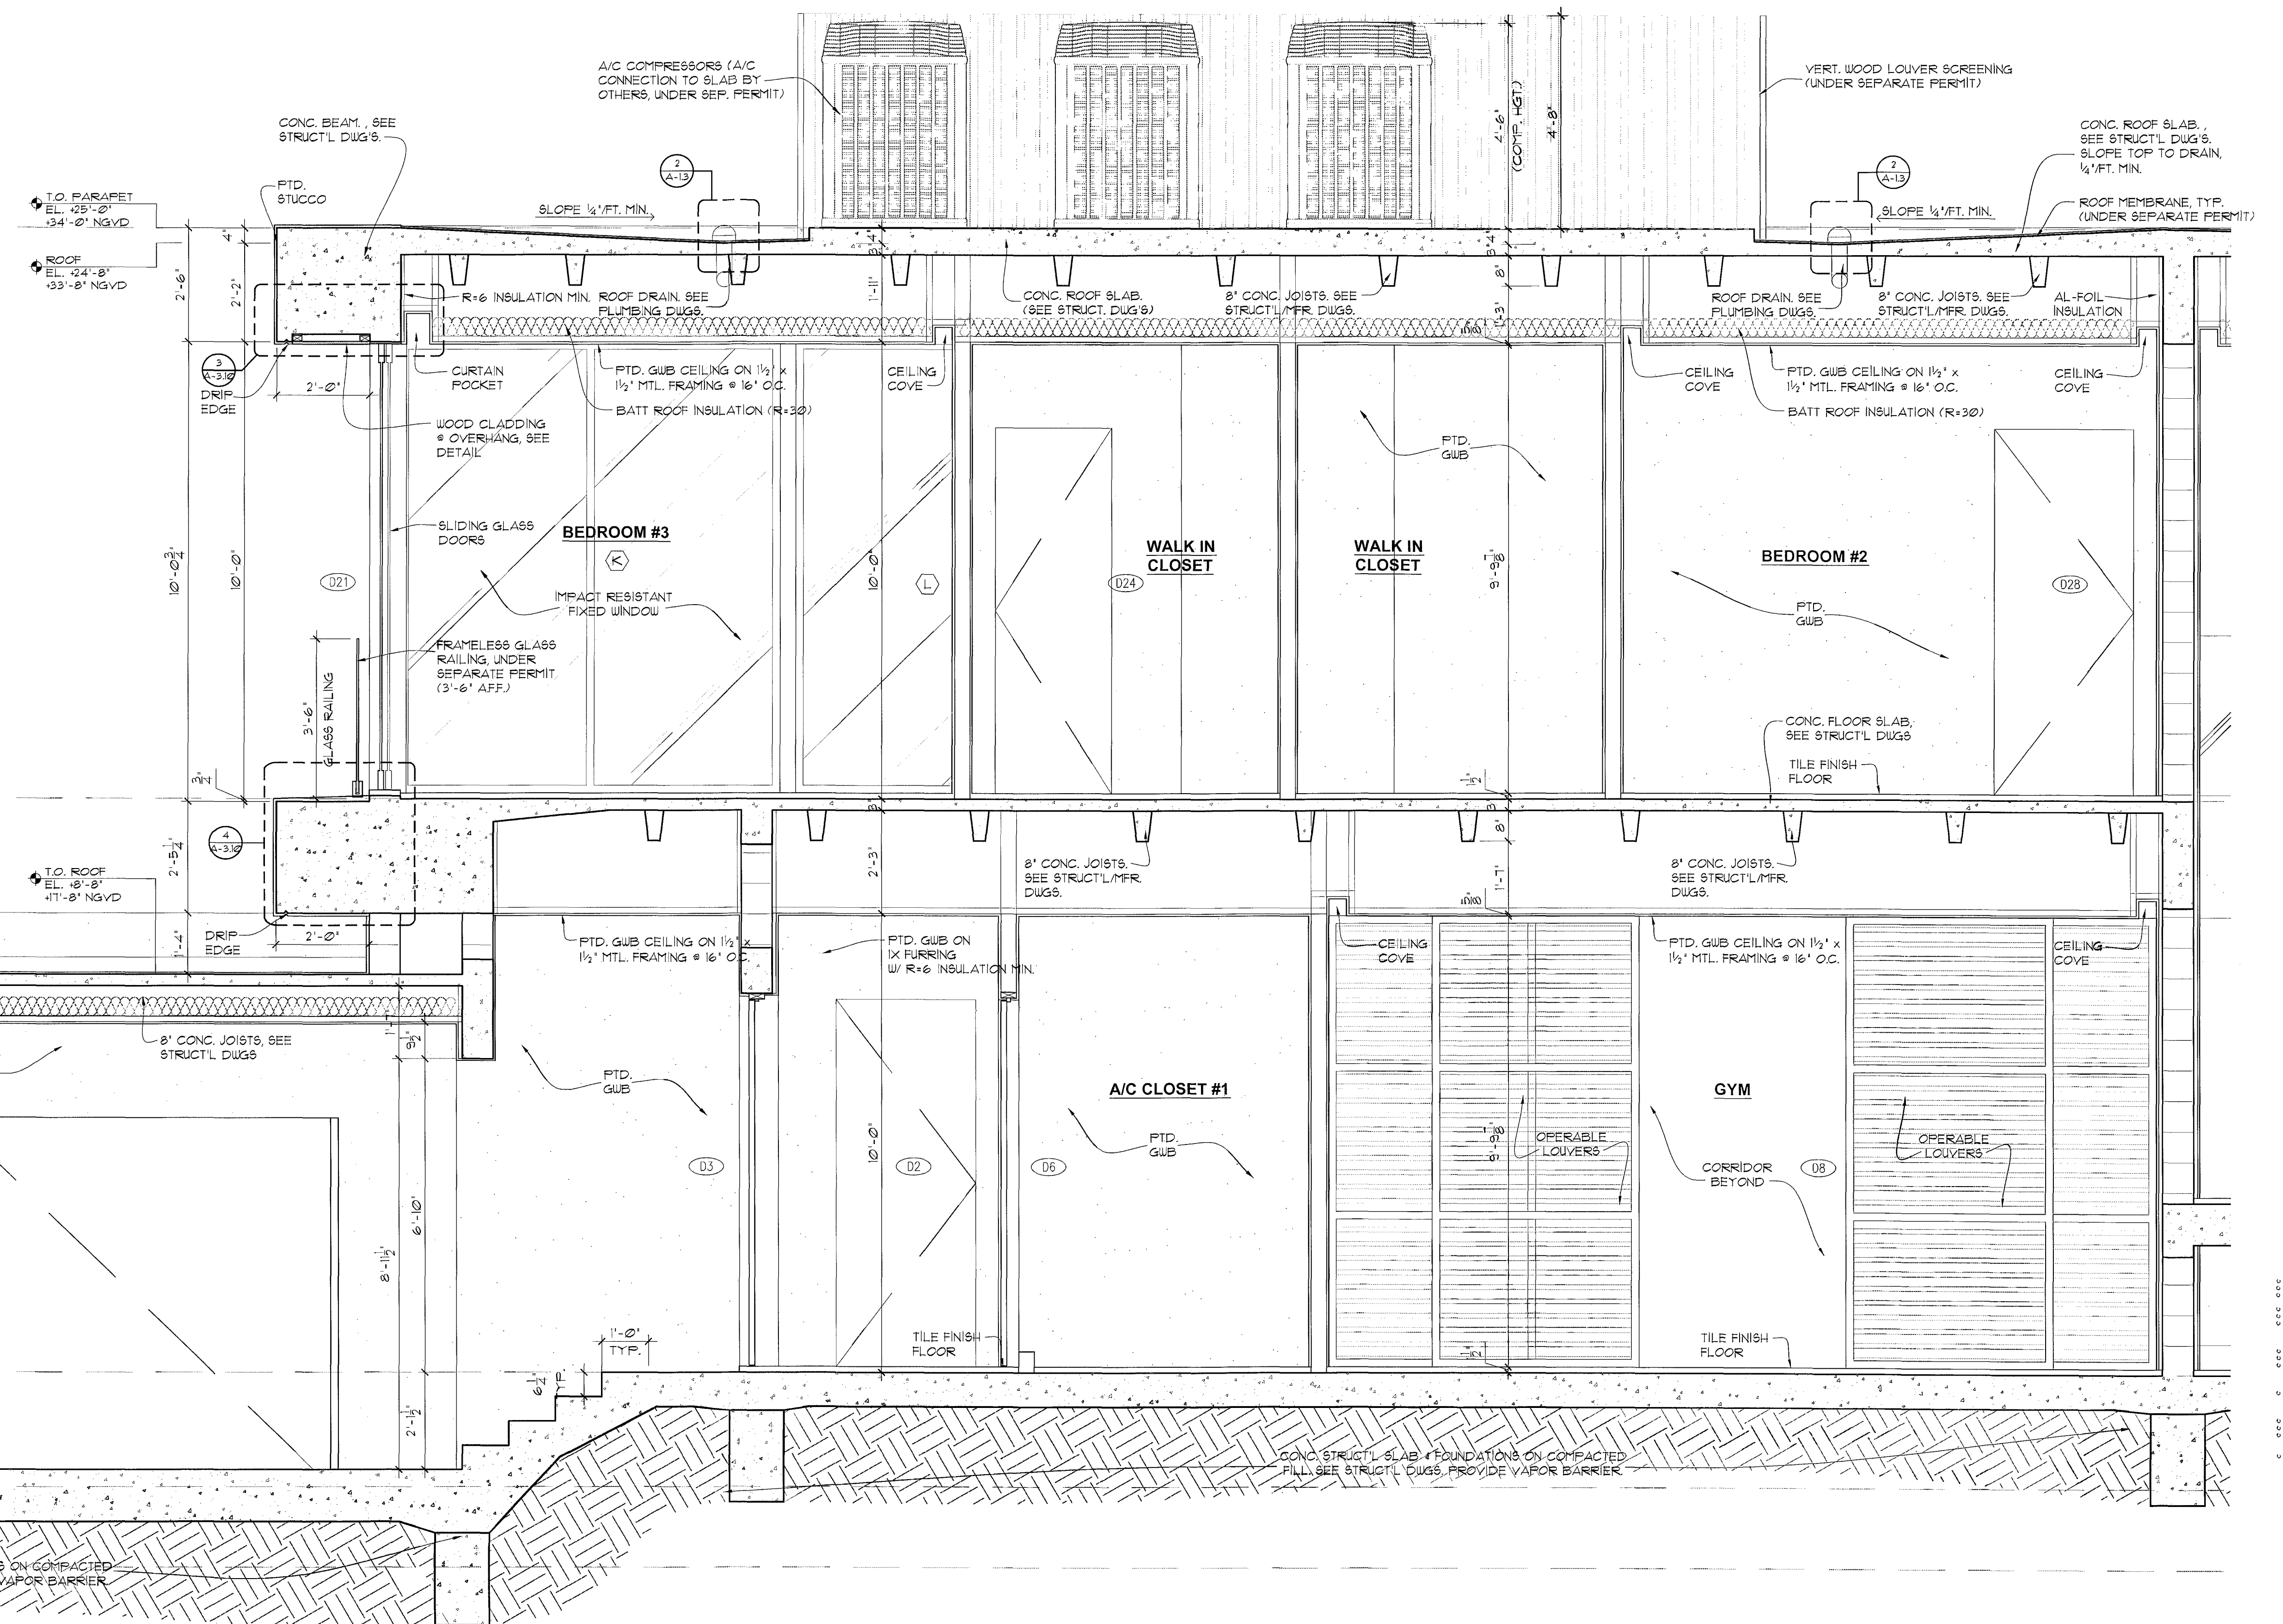

SECTION
A-36 SCALE 1/2" = 1'-0"

choeff + levy p.a.
architecture interior design

8425 biscayne blvd, suite 201
miami, florida 33138

www.choefflevy.com
AR0009679 AR0094779

Phone: 305.434.8338
Fax: 305.892.5292

DILIDO RESIDENCE

808 WEST DILIDO DR. MIAMI BEACH, FL 33139

comm no.
1241

date:
09-30-13

revised:

sheet no.

A-3.6

[Signature]
NOV 06 2013