



420 LINCOLN ROAD 6TH FLOOR | MIAMI BEACH, FL 33139
T.786.246.4857 | INFO@URBANROBOT.NET
HTTP://WWW.URBANROBOT.NET
URBAN ROBOT ASSOCIATES

29

INDIAN CREEK

2901 - 2911 INDIAN CREEK DRIVE :: MIAMI BEACH, FL 33139

SHEET INDEX:

ID	Name	
A-01	COVER	A-32 REAR YARD PAVED AREA DIAGRAM
A-02	SITE	A-33 POOL DECK AREA DIAGRAM
A-03	SURVEY-NOT TO SCALE	A-34 GROUND FLOOR
A-04	HISTORIC SITE	A-35 SECOND FLOOR
A-05	HISTORIC SITE	A-36 TYPICAL FLOOR 3, 5, 7
A-06	INDIAN CREEK DRIVE STREET ELEVATION	A-37 TYPICAL FLOOR 4, 6
A-07	INDIAN CREEK DRIVE STREET ELEVATION	A-38 ROOF PLAN
A-08	29TH STREET	A-39 SECTION 01
A-09	29TH STREET ELEVATION	A-40 SECTION 02
A-10	29TH STREET ELEVATION	A-41 SOUTH ELEVATION
A-11	EXISTING BUILDINGS	A-42 NORTH ELEVATION
A-12	ARCHITECTURAL FEATURES (EXISTING BUILDING)	A-43 EAST ELEVATION
A-13	ARCHITECTURAL FEATURES (EXISTING BUILDING)	A-44 WEST ELEVATION
A-14	ARCHITECTURAL FEATURES (EXISTING BUILDING)	A-45 NEW BUILDING WEST ELEVATION
A-15	DEMOLITION GROUND FLOOR PLAN	A-46 ALTERNATE PARKING - GROUND FLOOR
A-16	DEMOLITION ROOF PLAN	A-47 ALTERNATE PARKING - SECOND LEVEL
A-17	DEMOLITION NORTH ELEVATION	A-48 MECHANICAL LIFTS SPECIFICATIONS
A-18	DEMOLITION SOUTH ELEVATION	A-49 RAILING DESIGN
A-19	DEMOLITION WEST ELEVATION	A-50 RAILING DETAIL AND INSPIRATION
A-20	DEMOLITION EAST ELEVATION	A-51 RENDERING
A-21	EXISTING BUILDINGS ELEVATIONS	A-52 RENDERING
A-22	PROPOSED ELEVATION OF CONTRIBUTING STRUCTURE	L-002 TREE REMOVAL & REPLACEMENT PLAN
A-23	PROPOSED ELEVATION CROSS SECTIONS	L-200 SITE PLANTING PLAN
A-24	HISTORIC BUILDINGS RELOCATION	L-201 UPPER DECK PLANTING PLAN
A-25	EXCERPTS FROM BUOYANT CITY	L-300 SITE LIGHTING PLAN
A-26	SITE DATA	L-301 UPPER DECK LIGHTING PLAN
A-27	CONTEXT ELEVATIONS	
A-28	FAR ANALYSIS	
A-29	GSF ANALYSIS	
A-30	SETBACK DIAGRAM PEDESTAL	
A-31	SETBACK DIAGRAM TOWER	

SCOPE OF WORK :


PROPOSAL FOR NEW CONSTRUCTION OF MULTI-FAMILY RESIDENTIAL PROJECT WITHIN EXISTING CONTRIBUTING STRUCTURES

PLANNING BOARD

FINAL SUBMITTAL: JANUARY 18, 2021

COVER

A-01

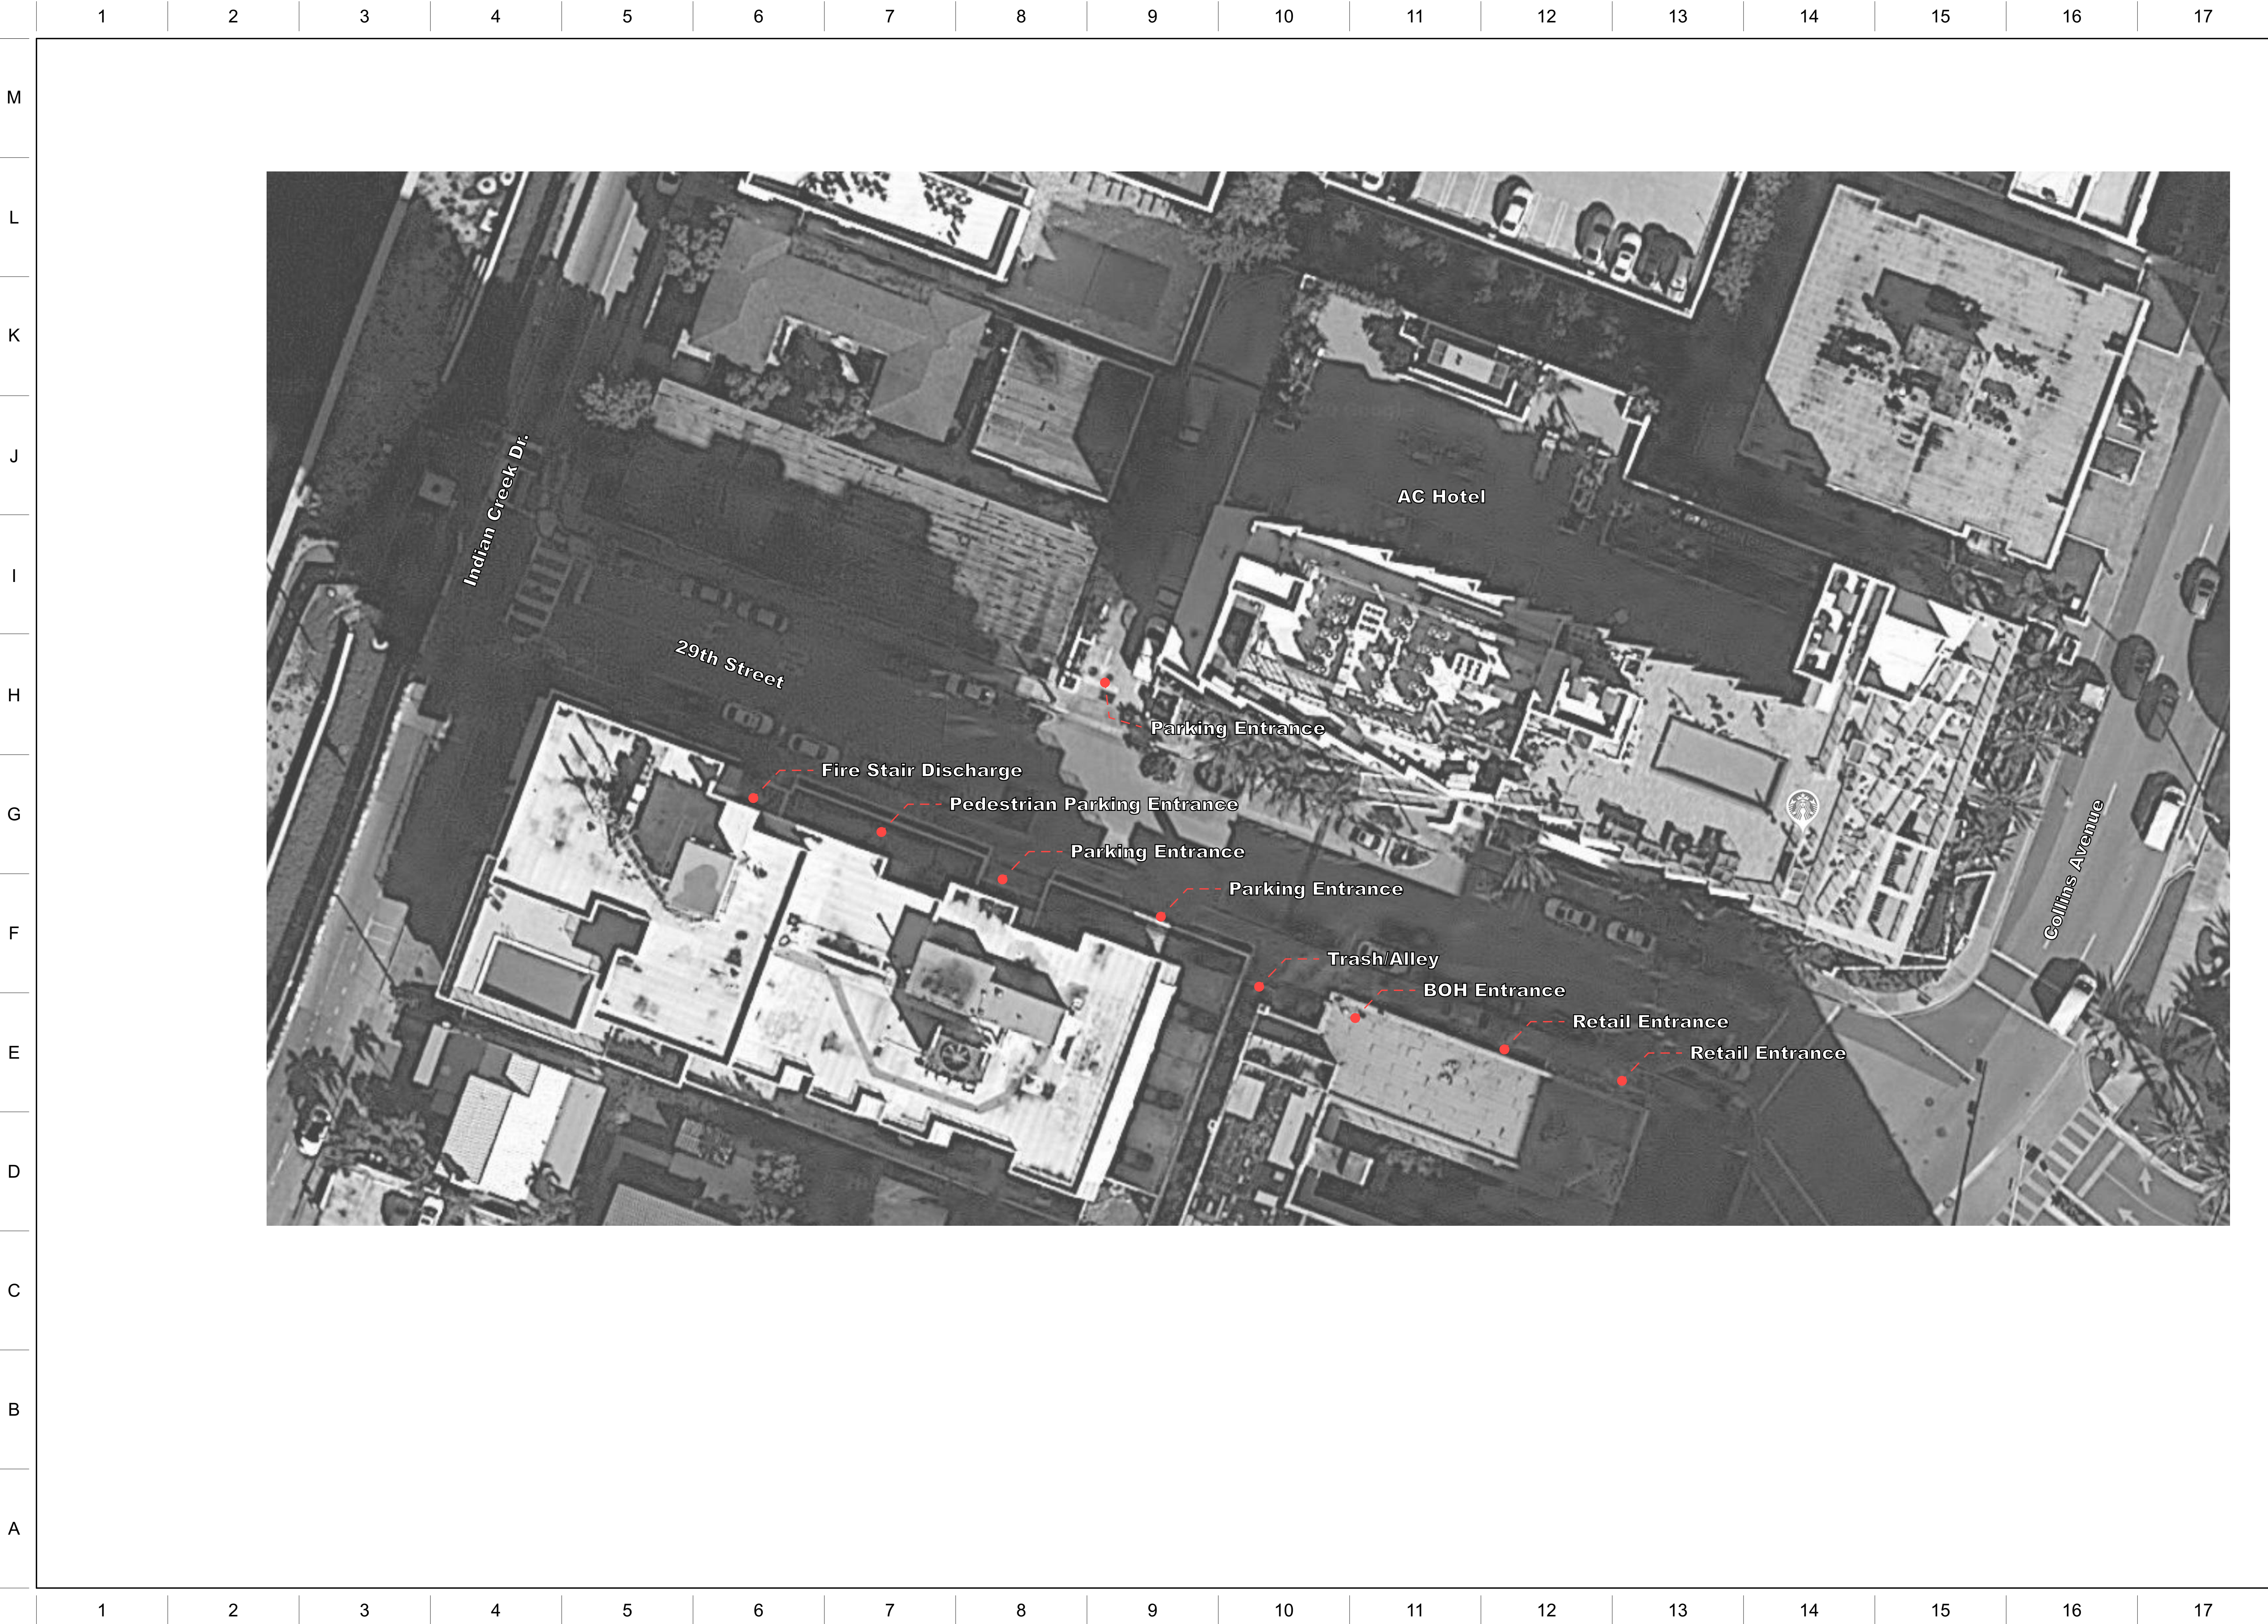

ARCHITECT:

URBAN ROBOT LLC
420 LINCOLN ROAD, S. 406
MIAMI BEACH, FL 33139
(786) 246-4857
(786) 768-2537, F

STRUCTURAL ENGINEER:

M.E.P. ENGINEERS:

CIVIL ENGINEERS:

GENERAL CONTRACTOR:

29 INDIAN CREEK
2911 INDIAN CREEK DRIVE :: MIAMI BEACH, FL 33139


SEAL

URBAN ROBOT LLC
AA26002760 RB26001534 LC26000510
REVISIONS

2002
PROJECT NO.
1/18/21
DATE
SV / JJ / AB
DRAWN / CHECKED

29TH STREET

A-08

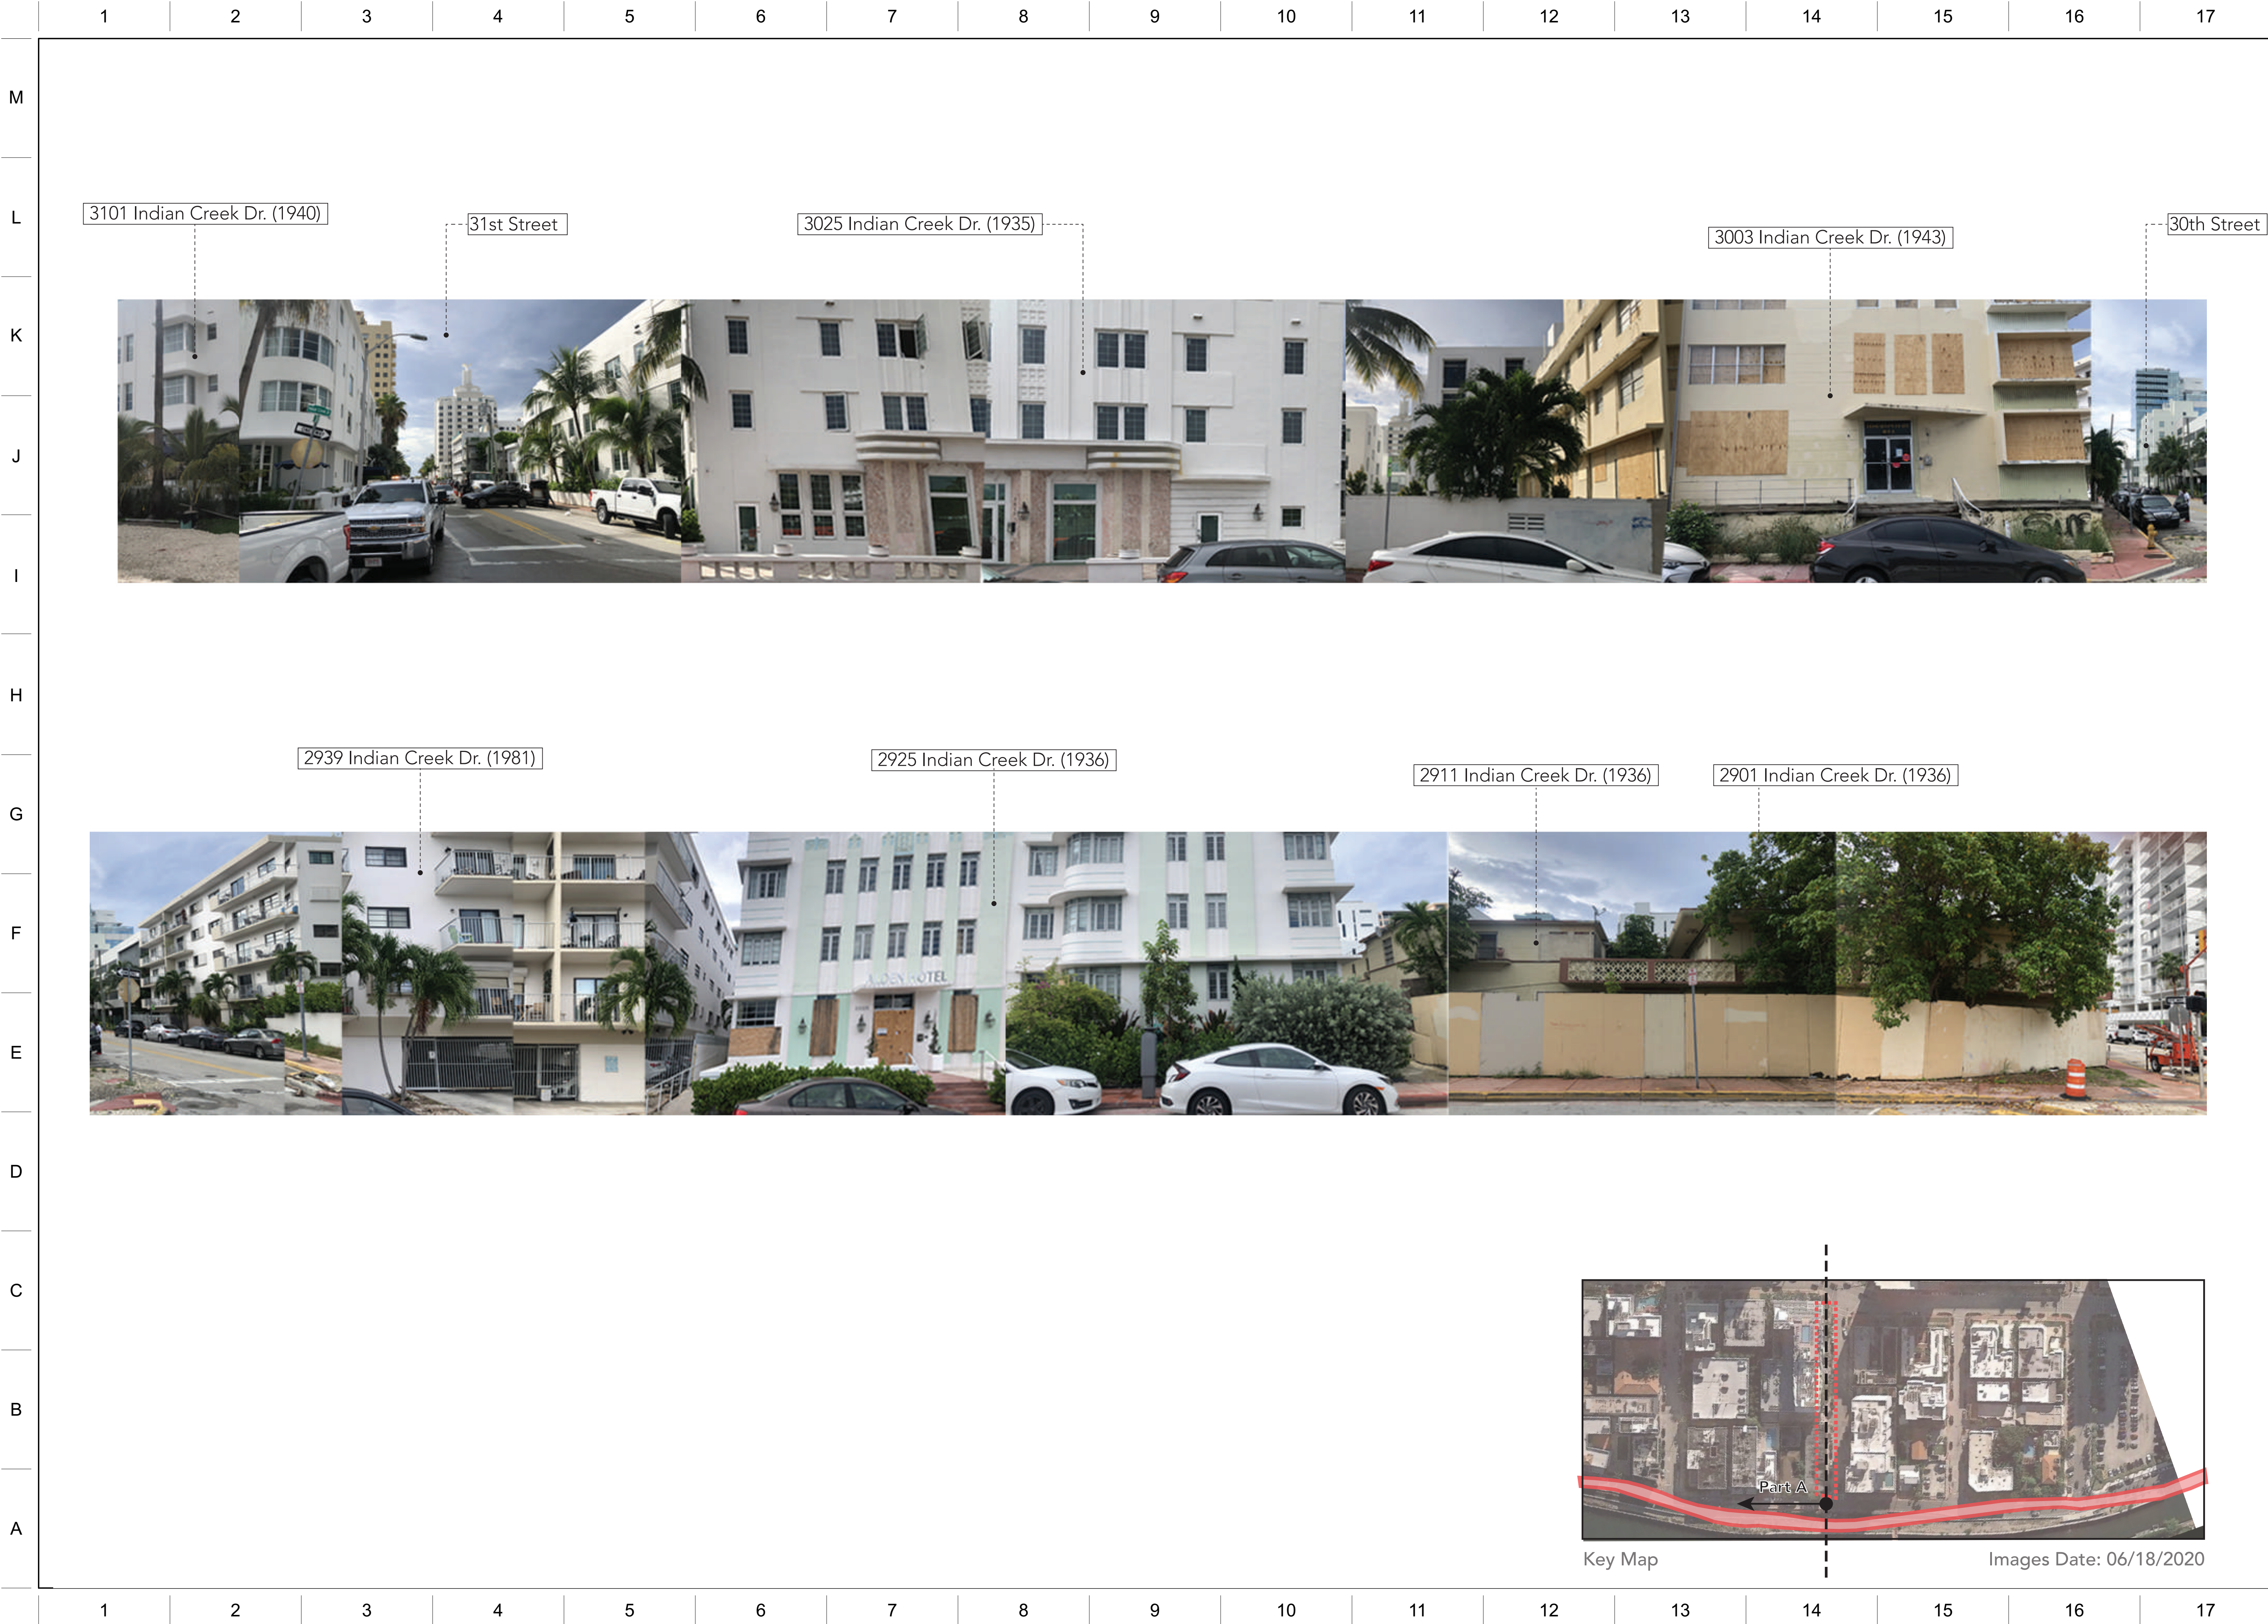

URBAN ROBOT LLC
420 LINCOLN ROAD, S. 406
MIAMI BEACH, FL 33139
(786) 246-4857
(786) 768-2537, F

M.E.P. ENGINEERS:

GENERAL CONTRACTOR:

29 INDIAN CREEK

2911 INDIAN CREEK DRIVE :: MIAMI BEACH, FL 33139

URBAN ROBOT LLC
AA26002760 IB26001534 LC26000510

2002
PROJECT NO. _____

1/18/21
DATE

SV / JJ / AB

DRAWN / CHECKED

**29TH STREET
ELEVATION**

A-10



Key Map

Images Date: 06/18/2020

M

L

K

J

1

H

G

F



E

D

C

B

A

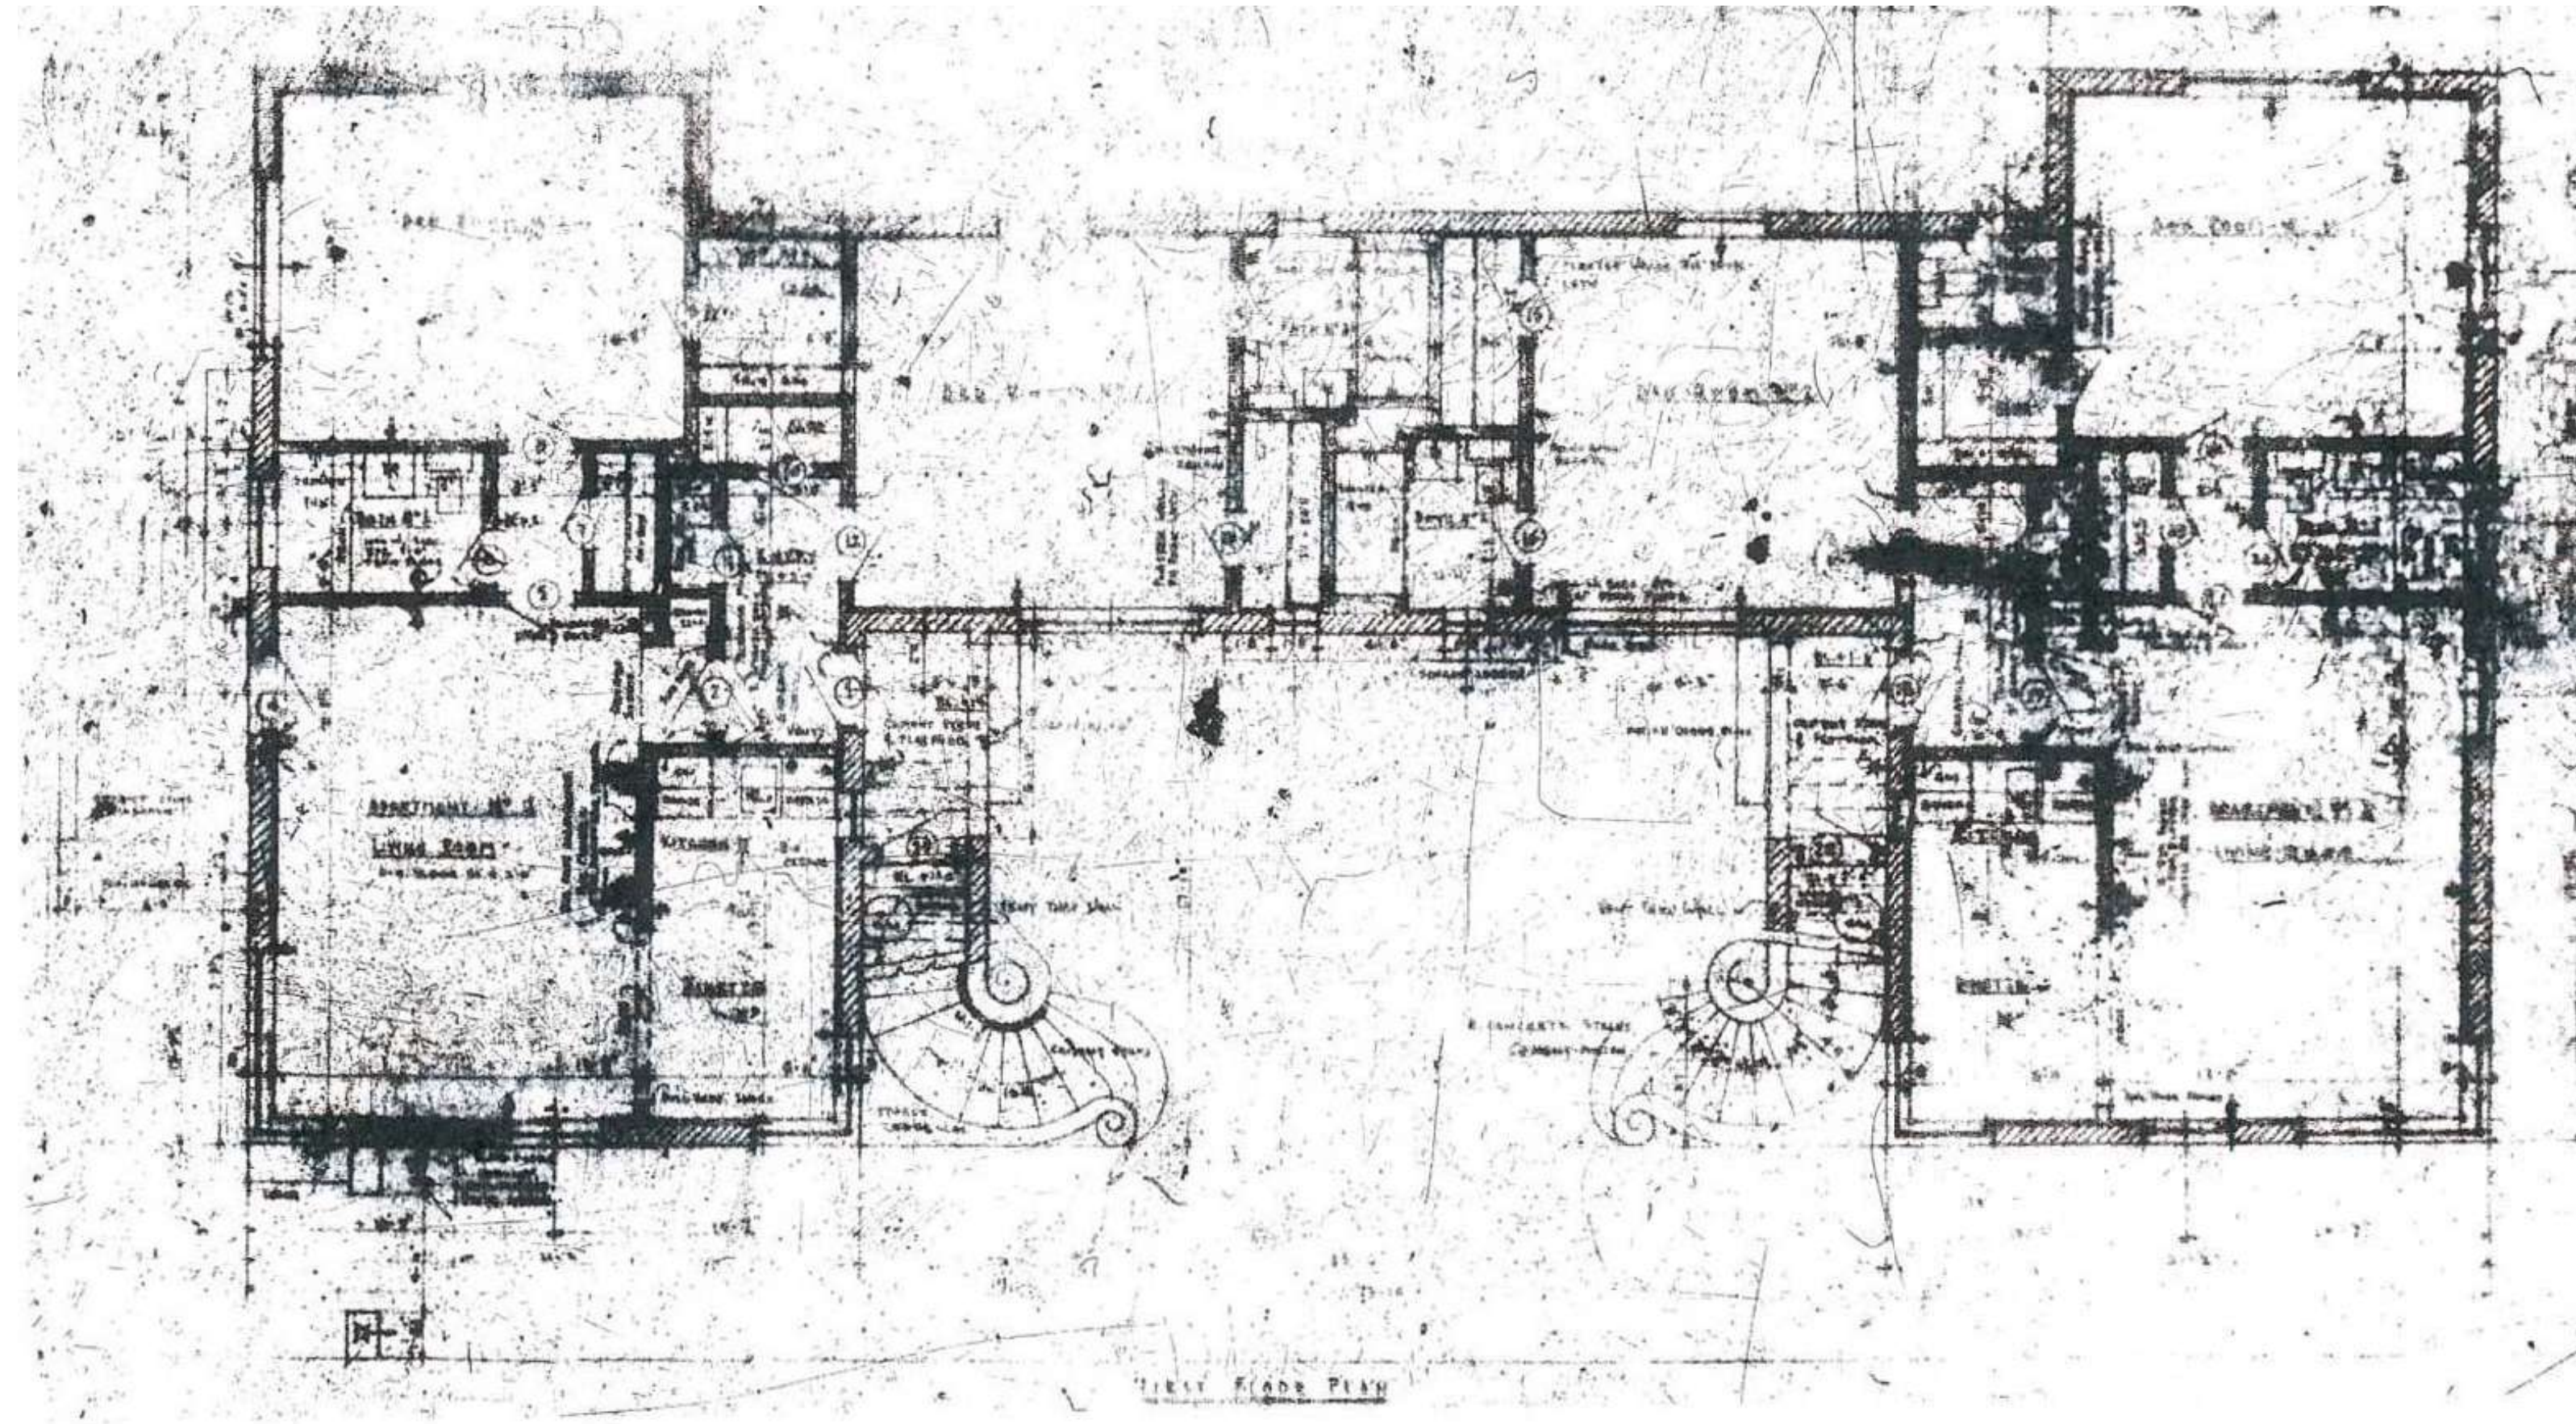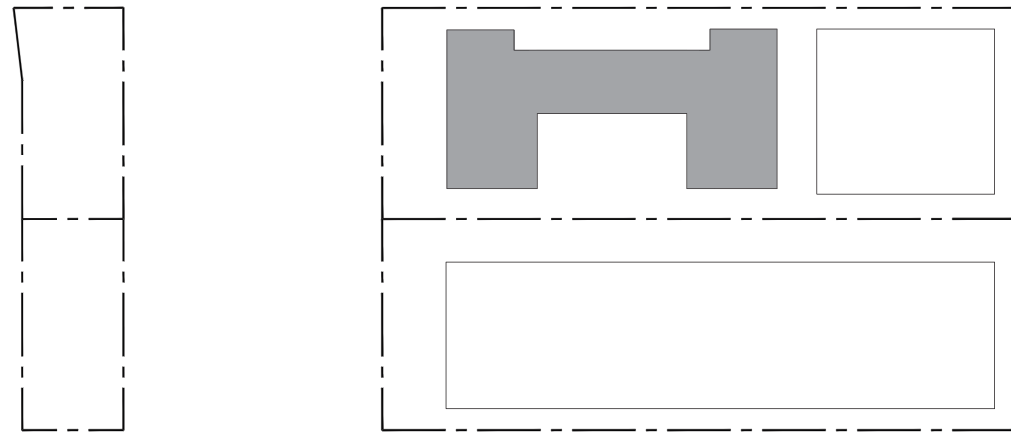

ARCHITECT:

URBAN ROBOT LLC
420 LINCOLN ROAD, S. 406
MIAMI BEACH, FL 33139
(786) 246-4857
(786) 768-2537, F

STRUCTURAL ENGINEER:

M.E.P. ENGINEERS:

CIVIL ENGINEERS:

GENERAL CONTRACTOR:

29 INDIAN CREEK

2911 INDIAN CREEK DRIVE :: MIAMI BEACH, FL 33139

SEAL

URBAN ROBOT LLC
A-100000700 ID00001501 LG00000510

REVISIONS

2002
PROJECT NO.1/18/21
DATESV / JJ / AB
DRAWN / CHECKED

ARCHITECTURAL FEATURES (EXISTING BUILDING)

M

L

K

J

I

H

G

F


E

D


C

B

A

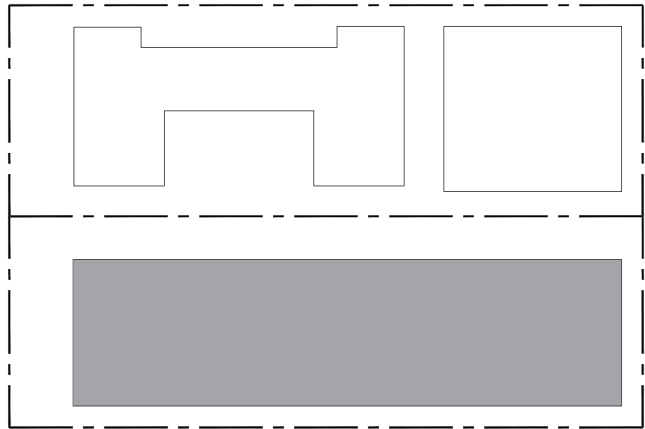

Key Plan

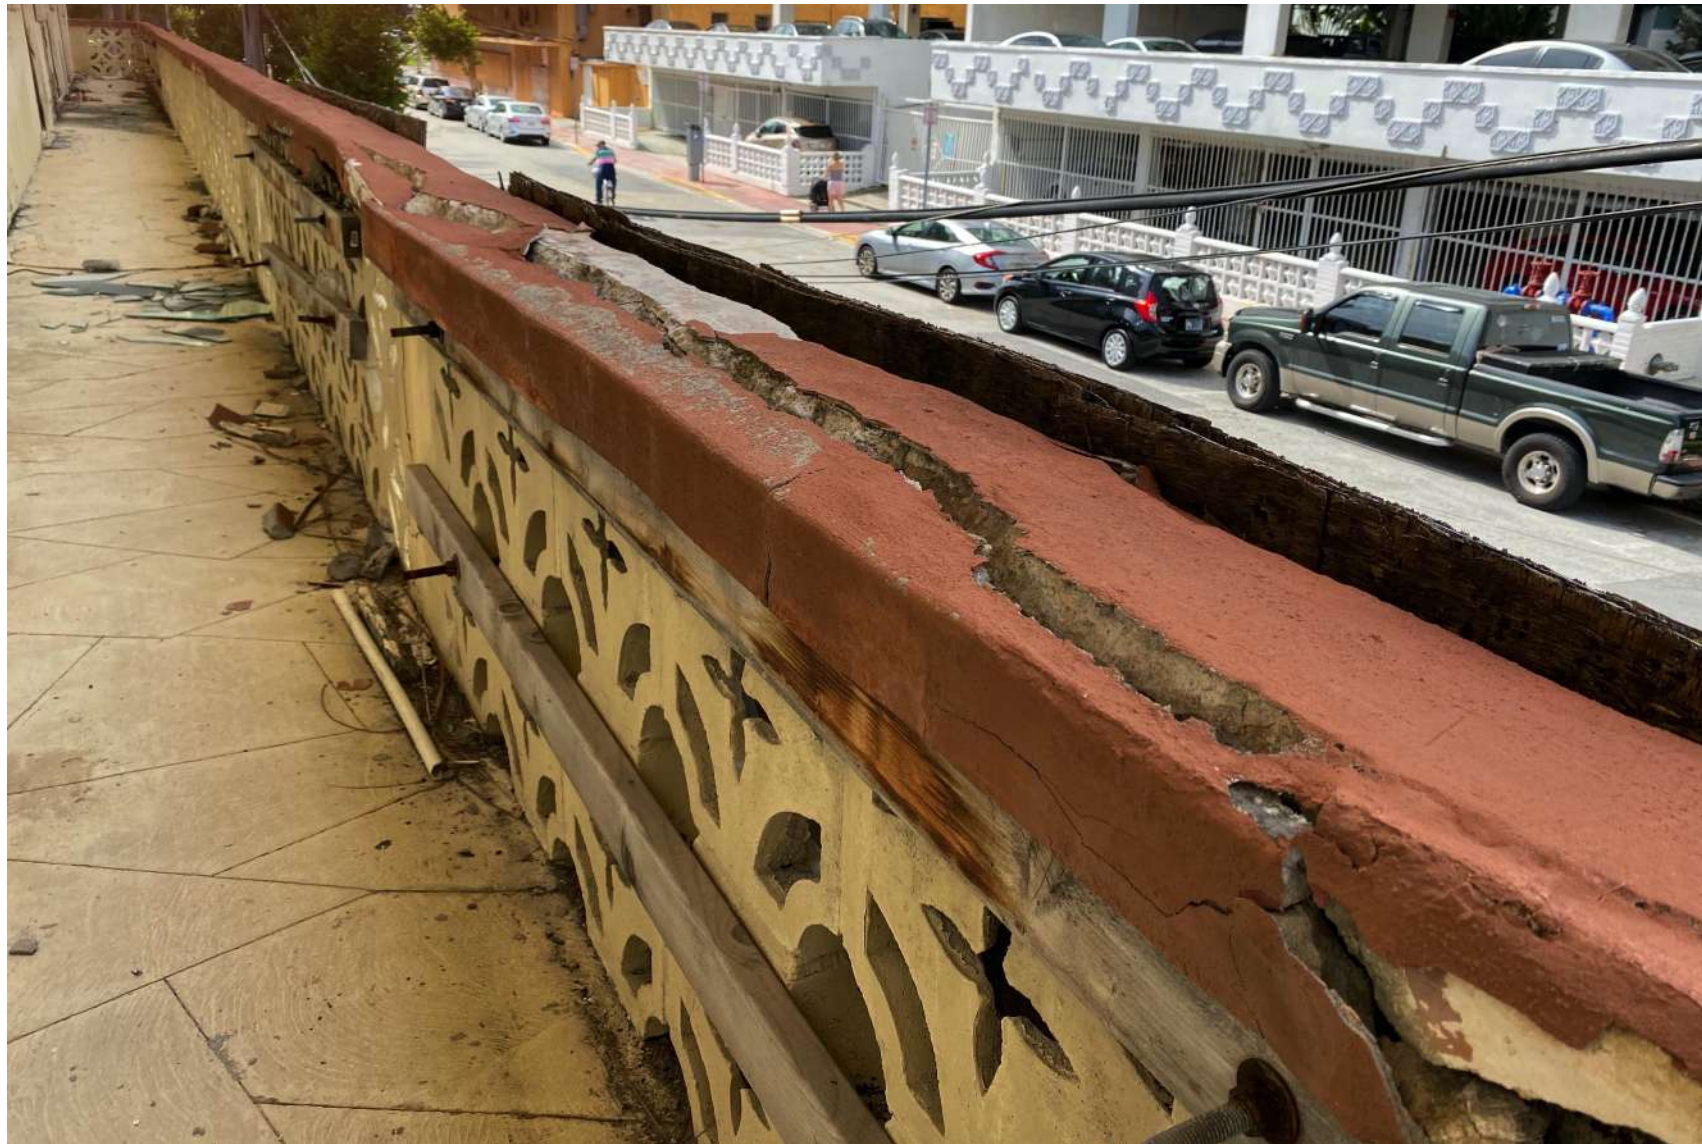

ARCHITECT:

URBAN ROBOT LLC
420 LINCOLN ROAD, S. 406
MIAMI BEACH, FL 33139
(786) 246-4857
(786) 768-2537, F

STRUCTURAL ENGINEER:

M.E.P. ENGINEERS:

CIVIL ENGINEERS:

GENERAL CONTRACTOR:

29 INDIAN CREEK
2911 INDIAN CREEK DRIVE :: MIAMI BEACH, FL 33139

SEAL

URBAN ROBOT LLC
A208002760 R26001534 LC26000510

REVISIONS

2002
PROJECT NO.

1/18/21
DATE

SV / JJ / AB
DRAWN / CHECKED

ARCHITECTURAL
FEATURES
(EXISTING
BUILDING)