

21048

Owner 6060 Realty Corp.

Lot 31-34 Block 2

Subdivision 2nd Ocean Front

General Contractor Construction Specialties of Fla. Inc.

Architect Francis Pisani

Zoning Regulations: RM-125 Use H

Building Size: MF-6 Front 190+

Certificate of Occupancy No.

Type of Construction I

Area

Depth 85+

Foundation Piling

Permit No. B8900200

Cost \$5,000,000.00

Address 6060 Indian Creek Drive

Bond No.

Engineer Weitz & Tseng Assoc.

Lot Size 18,793 ft

Height 173+

Use

Concrete Deck
Roof & Membrain

Stories 17
10 Apts.
60 Hotel Rooms
Date 5-4-89

PLUMBING Contractor

Sewer Connection

Date

Temporary Water Closet

Water Closets

Lavatories

Bath Tubs

Showers

Urinals

Sinks

Dish Washing Machine

Laundry Trays

Laundry Washing Machines

Drinking Fountains

Floor Drains

Grease Traps

Safe Wastes

AIR CONDITIONING Contractor

SEPTIC TANK Contractor

OIL BURNER Contractor

SPRINKLER Contractor

Swimming Pool Traps

Steam or Hot Water Boilers

ROUGH APPROVAL

FINAL APPROVAL

GAS Contractor

Gas Ranges

Gas Water Heaters

Gas Space Heaters

Gas Refrigerators

Gas Steam Tables

Gas Broilers

Down Spouts

Wells

Date

Gas Frylators

Gas Pressing Machine

Gas Vents for Stove

GAS Rough APPROVAL

GAS FINAL APPROVAL

ELECTRICAL Contractor

OUTLETS

Switches

Lights

Receptacles

HEATERS

Water

Space

FIXTURES

Ranges

Irons

Refrigerators

Fans

Motors

Appliances

Electrical Contractor

Date

Temporary Service

Neon Transformers

Sign Outlets

Meter Change

Centers of Distributions

Service

Violations

Date

FINAL APPROVAL

By

Date

Building Permits: #B8900200 - 4-7-89 - David Jones Builders Inc. - New Hotel, apt. (foundatiin only) - \$5,000,000.00 *OK*
#B8900280 - 5-4-89 - David Jones Builders Inc. - New apt./hotel (See Permit
#B8900200-Comm.) - \$5,000,000.00 *OK*

Plumbing Permits:

CUMULATIVE COST OF CONSTRUCTION OF PERMITS ISSUED

DATE	PROCESS	DESCRIPTION	WORK	CUMULATIVE	APPRAISED BLDG.			BUILDING
ISSUED	NO.	OF WORK	COST	WORK COST	VALUE BEFORE REMODEL	%	COMMENTS	PERMIT NO.
4-7-89		NEW HOTEL, APT. (Foundation only)	\$5,000,000.00					88900000
5-4-89		NEW APT./HOTEL (SEE P#88900200 COMM.)	\$5,000,000.00					88900280
10-12-89		REPAIR EXISTING SEAWALL + REPLACE EXIST DOCK	\$25,000.00					88900015


BUILDING PERMITS: #B8900015 - 10-12-89 - Denmar Marine Contractors - Repair existing seawall and
replace existing dock - \$25,000.00 *CH*

PERMIT NUMBER

B9300096


ADDRESS


5

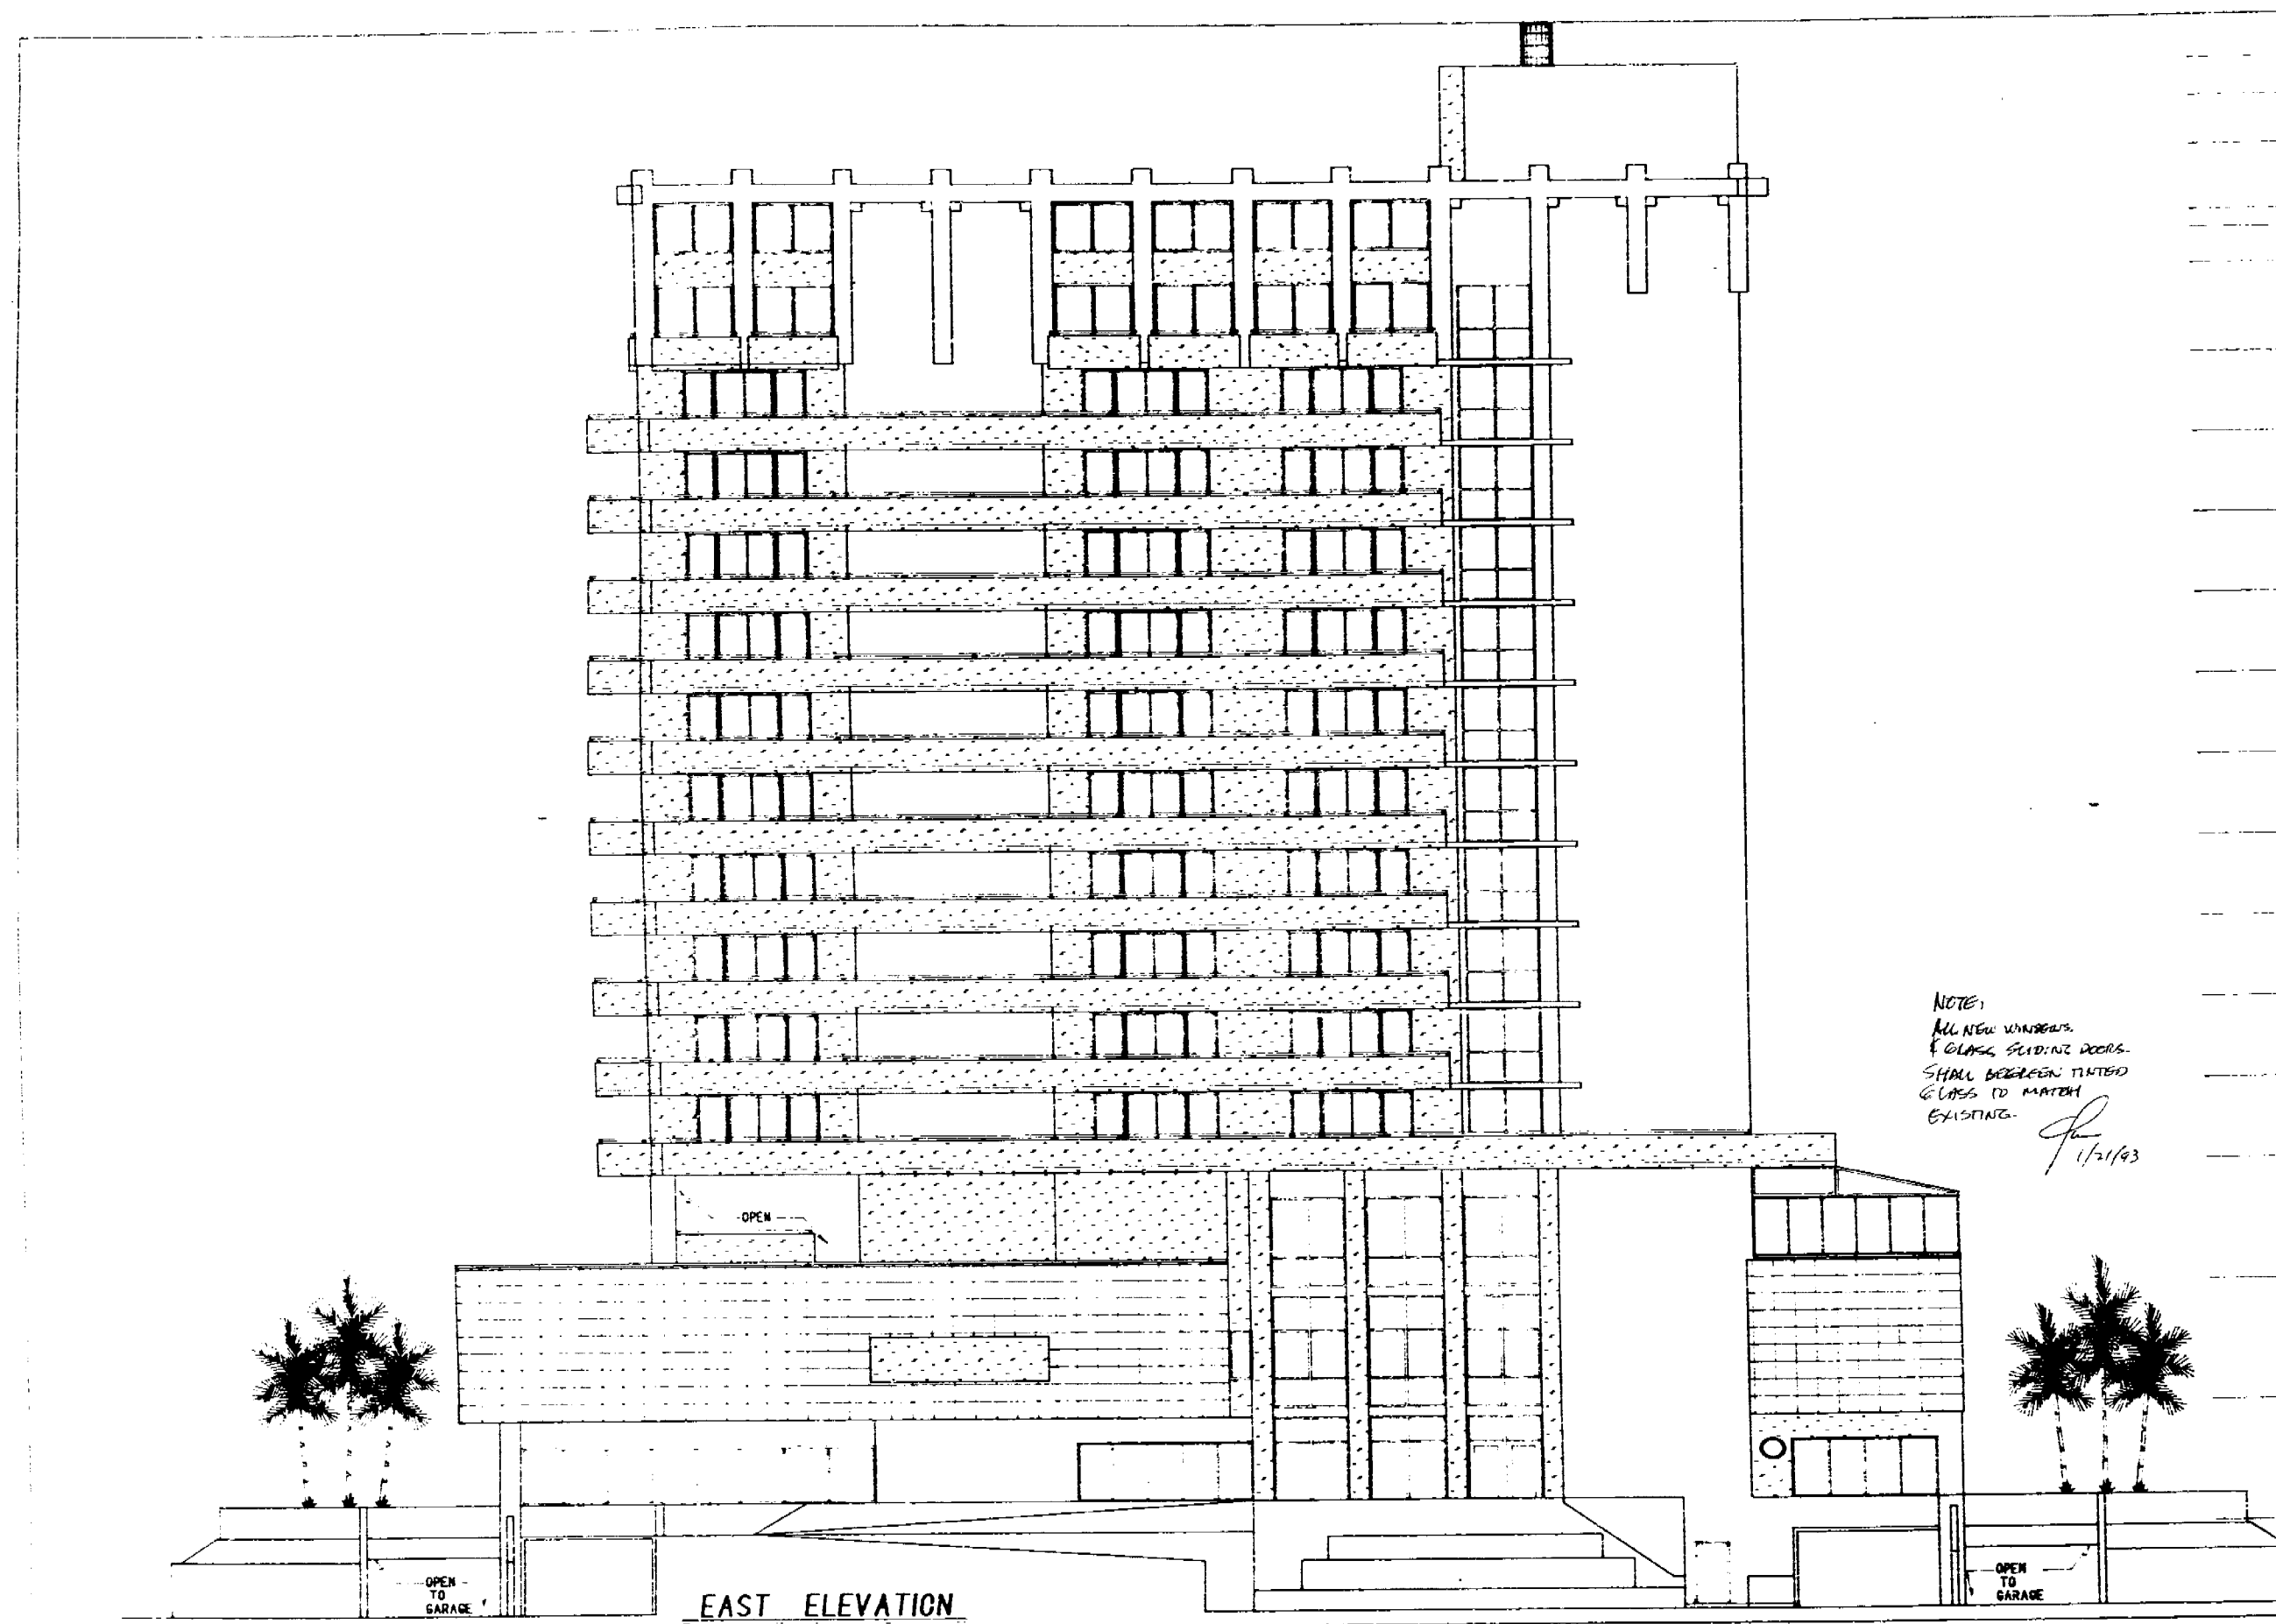

NOTE:
ALL NEW WINDOWS
& GLASS SLIDING DOORS.
SHALL BE GREEN TINTED
GLASS TO MATCH
EXISTING.

- [illegible]

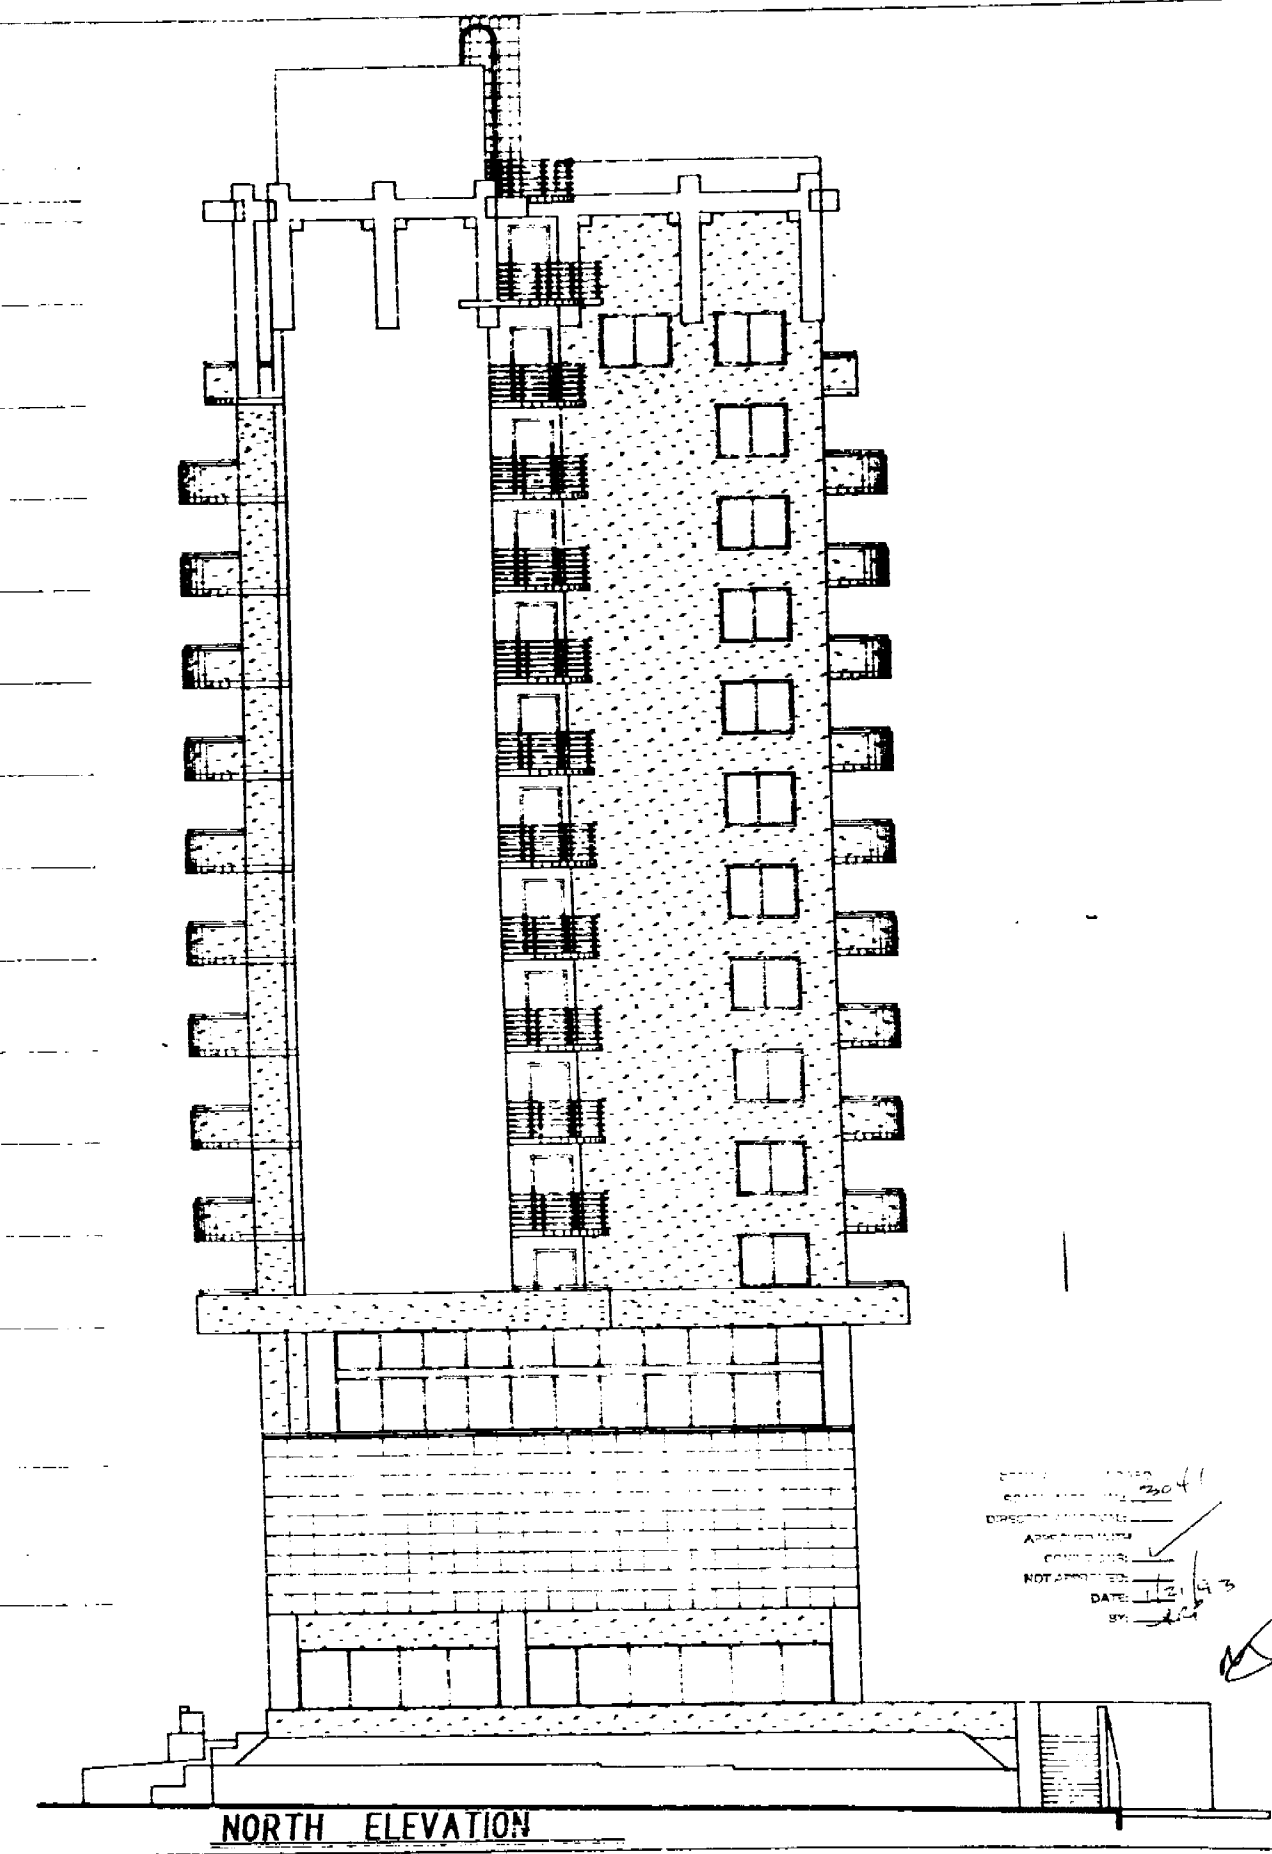[illegible]

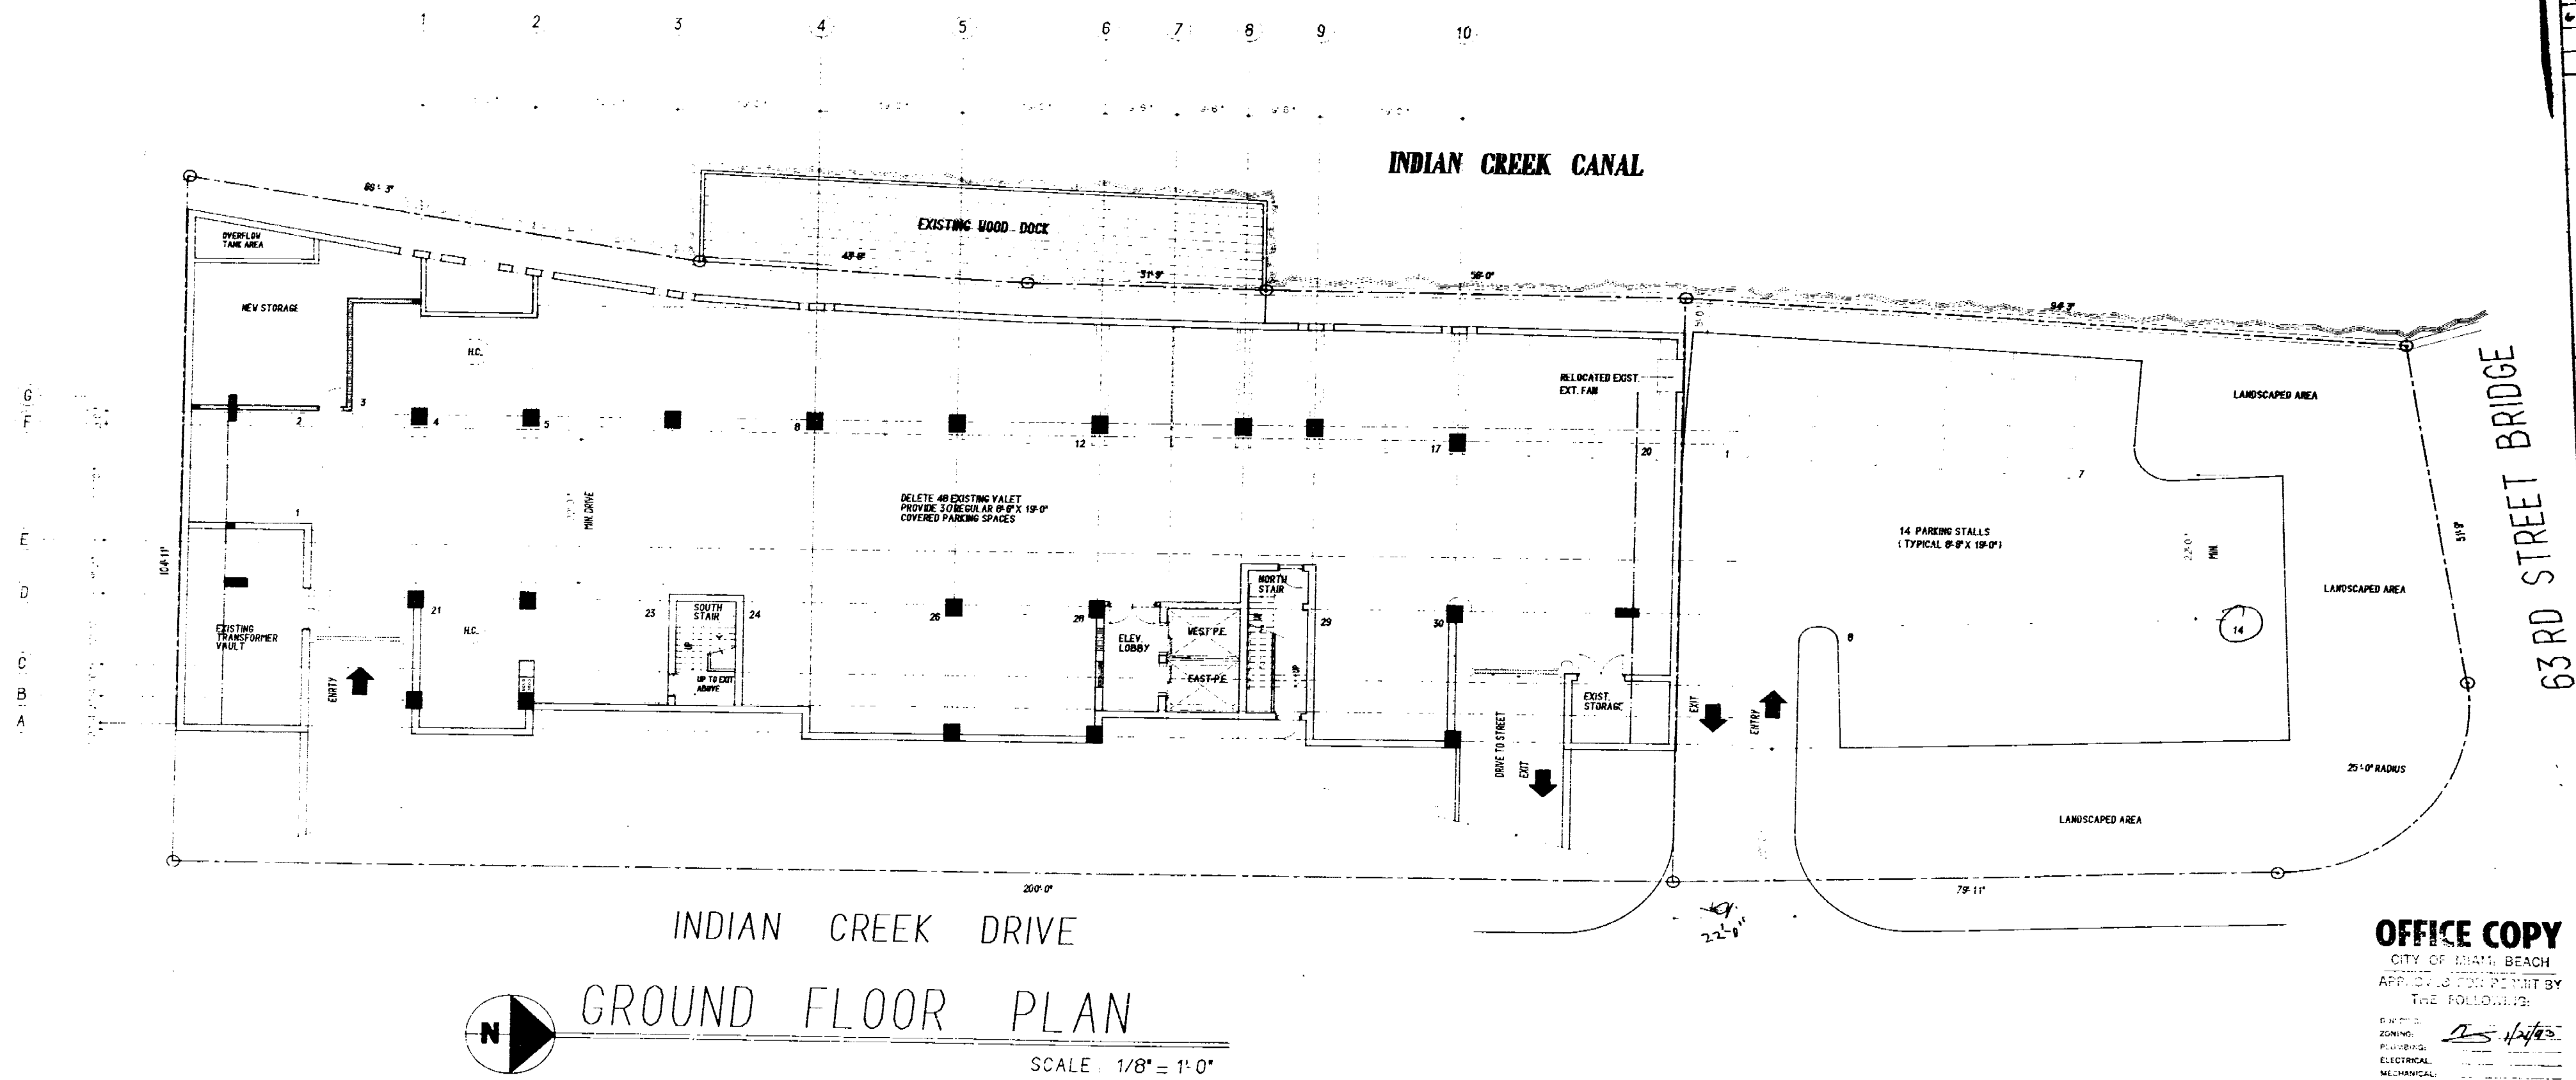

REVISIONS	
DATE	ITEM
5/1/02	REV. PARKING
6/10/02	REV. CIV.


PROJECT:
6060 INDIAN CREEK REALTY
6060 INDIAN CREEK DRIVE
MIAMI BEACH, FLORIDA

ARCHITECT:
MOSE COSCHER, ARCHITECT
780 - 5th STREET
MIAMI BEACH, FLORIDA 33140

CONSULTANTS	AREA
STRUCTURAL	STRUCTURAL
ELECTRICAL	ELECTRICAL
MECHANICAL	MECHANICAL
PLUMBING	PLUMBING
INTERIOR	INTERIOR
PAINT	PAINT


OFFICE COPY
CITY OF MIAMI BEACH
APPROVED FOR PERMIT BY
THE FOLLOWING:

SEAL
PAGE # 2
OF

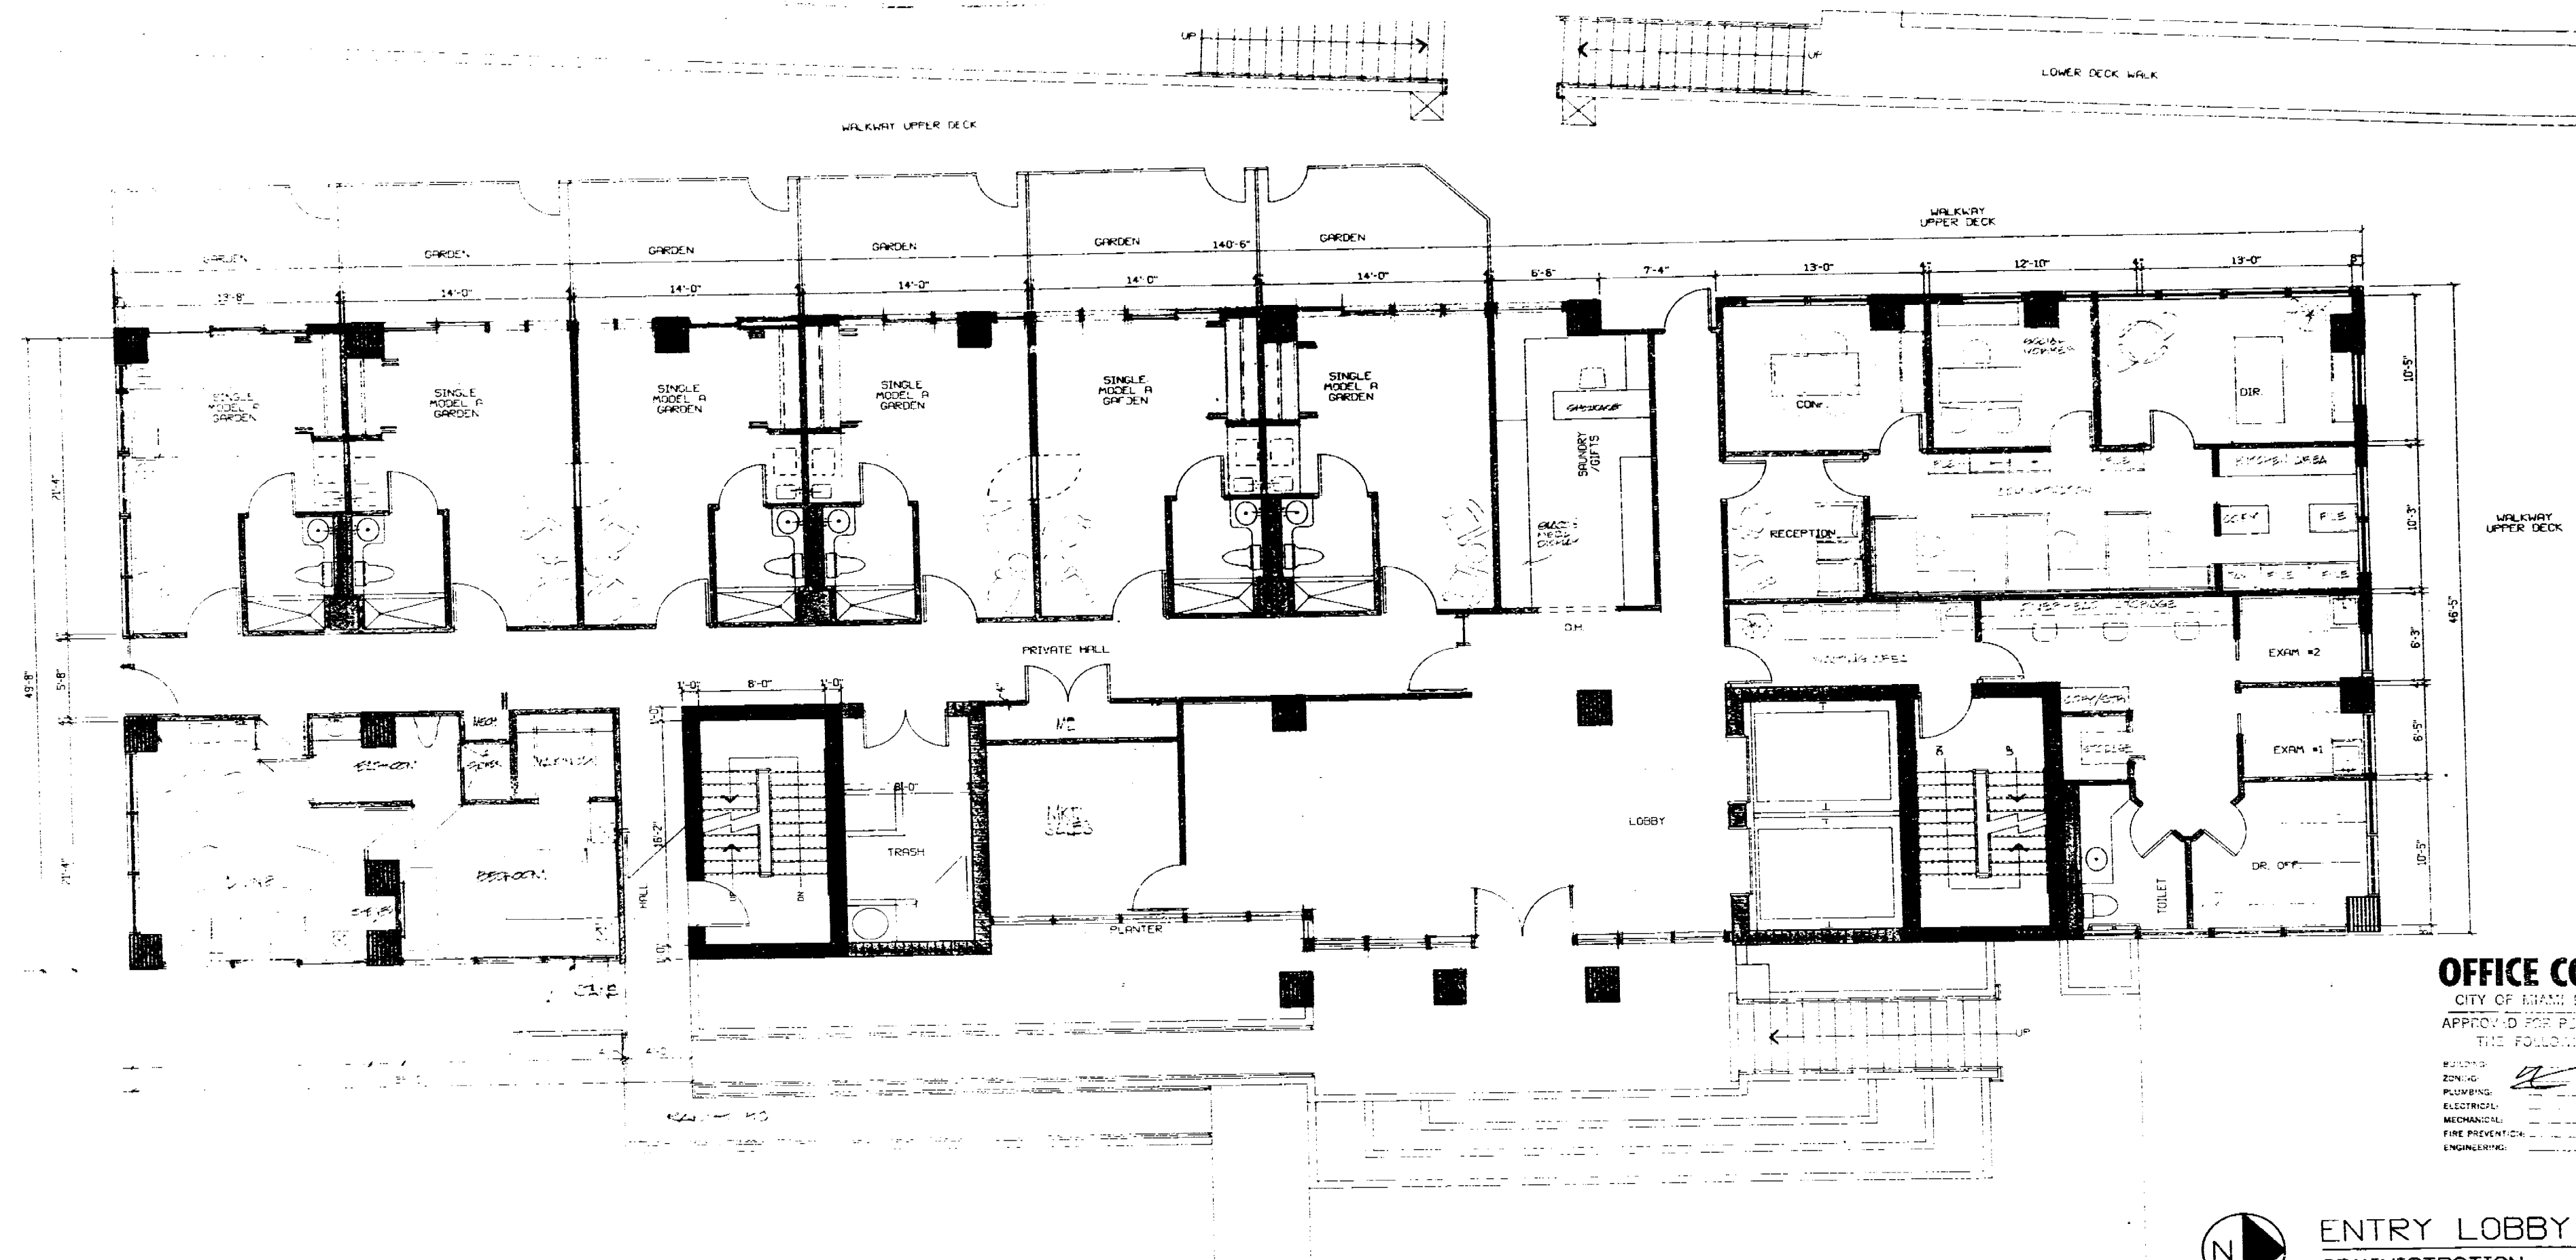

OFFICE COPY
 CITY OF MIAMI BEACH
 APPROVED FOR PERMIT BY
 THE FOLLOWING:

PLUMBING
 ELECTRICAL
 MECHANICAL
 FIRE PREVENTION
 ENGINEERING

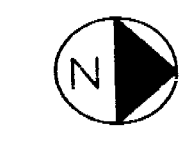

ENTRY LOBBY
 ADMINISTRATION
 17 RESIDENTS
 7 MODEL "A" UNITS


REVISIONS
 DATE: 1/2/71

PROJECT:
 6060 INDIAN CREEK REALTY
 6060 INDIAN CREEK DRIVE
 MIAMI BEACH, FLORIDA

ARCHITECT:
 MOSHE COSCHER, ARCHITECT
 700 - 5TH STREET
 MIAMI BEACH, FLORIDA 33140

CONSULTANTS:
 ELECTRICAL: FRED BOUTER, P.E.
 PLUMBING: STEVEN LEE, P.E.
 MECHANICAL: FRED BOUTER, P.E.
 FIRE PREVENTION: FRED BOUTER, P.E.

DATE: 1/2/71
SCALE: 1/8" = 1'-0"

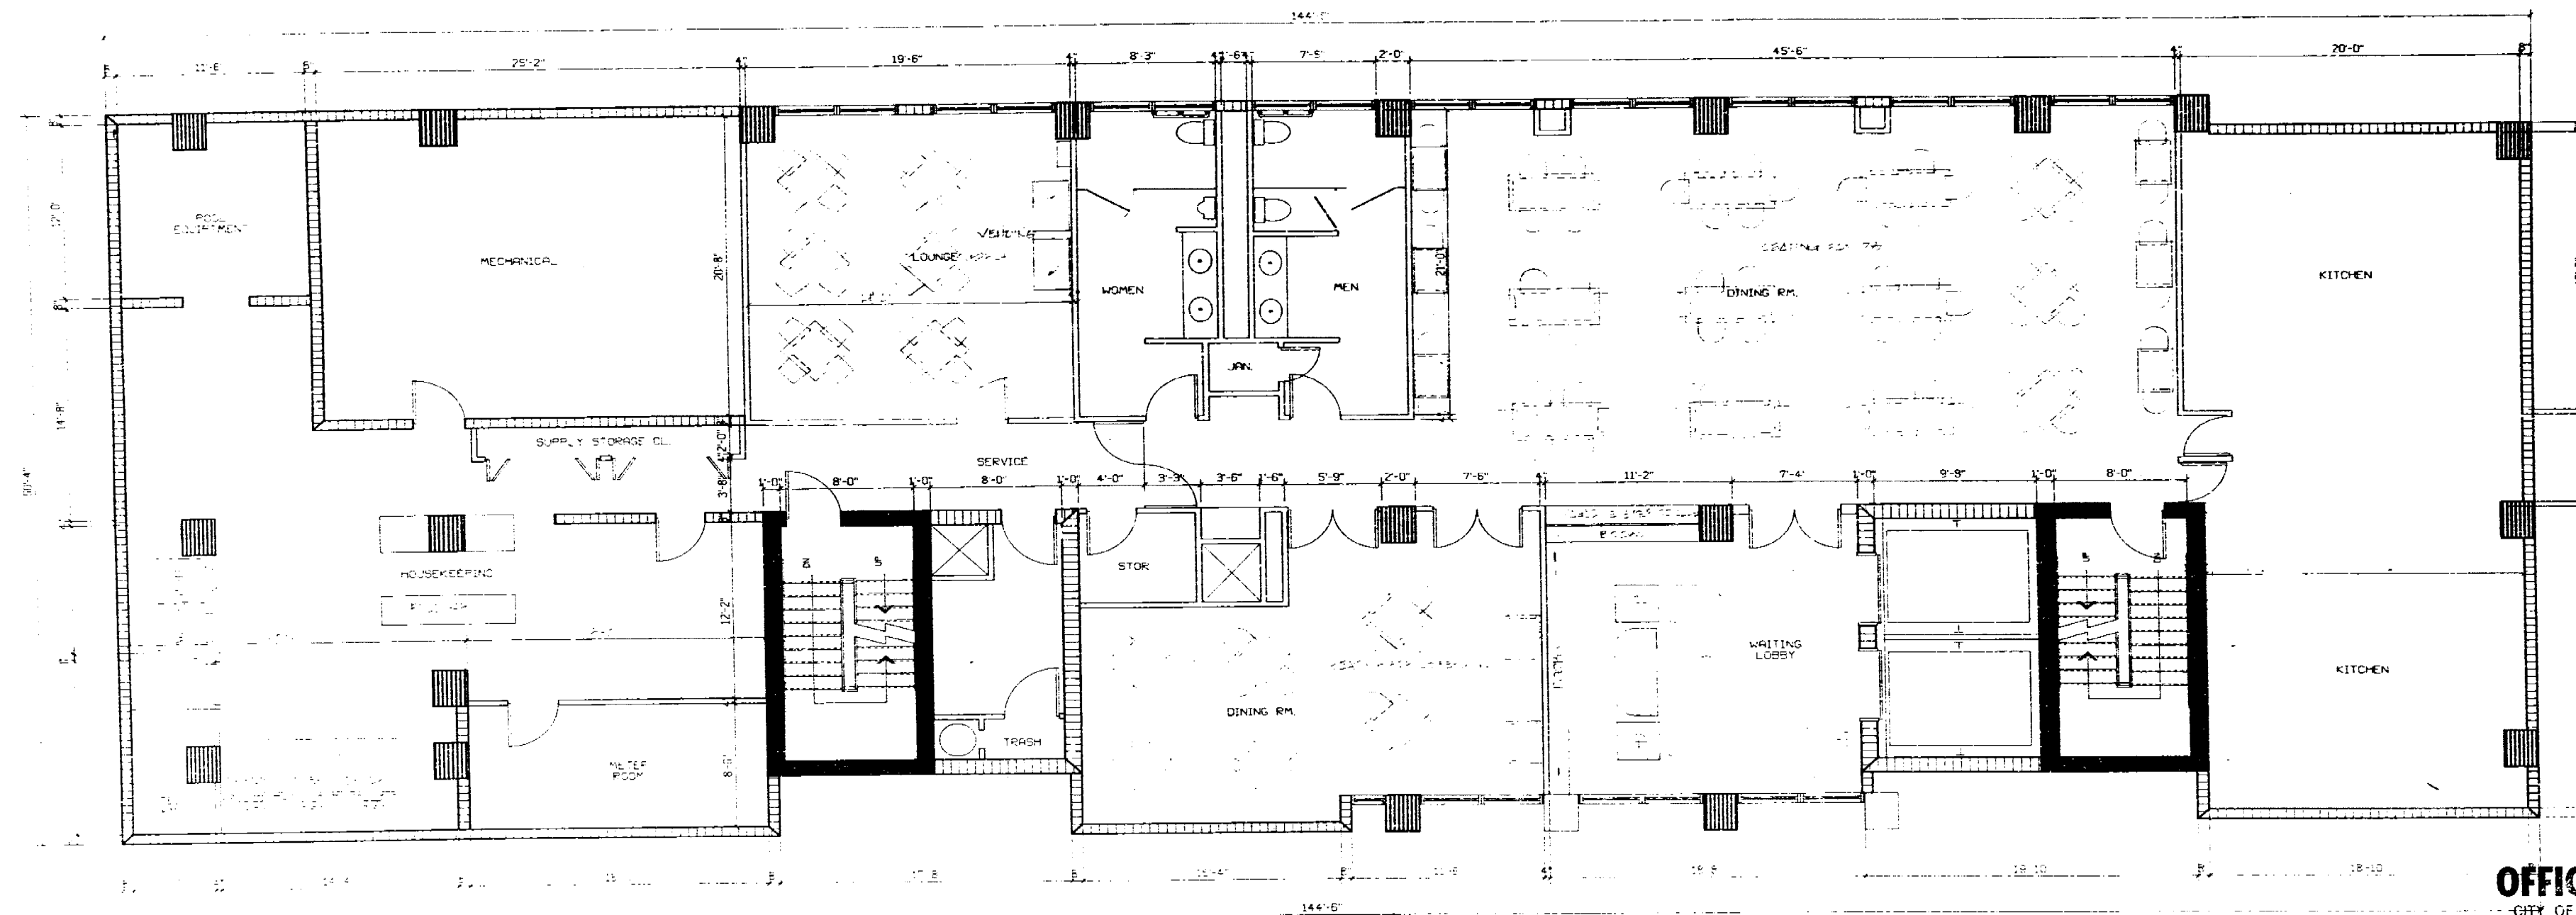

OFFICE COPY

CITY OF MIAMI BEACH
APPROVED FOR PERMIT BY
THE FOLLOWING:

☒ BUILDING
☒ ZONING
☒ PLUMBING
☒ ELECTRICAL
☒ MECHANICAL
☒ FIRE PREVENTION



DINING / KITCHEN
HOUSEKEEPING / STAFF

REVISIONS
DATE: REV:

PROJECT
6060 INDIAN CREEK REALTY
6060 INDIAN CREEK DRIVE
MIAMI BEACH, FLORIDA


ARCHITECT
MOSHE COSCHER, ARCHITECT
700 - 5th STREET
MIAMI BEACH, FLORIDA 33140

CONSULTANTS
FL REG #
STRUCTURAL: EUGENE SANTANA, P.E.
ELECTRICAL: STEVEN BELL, P.E.
MECHANICAL: MICHAEL BELL, P.E.
PLUMBING: WILLIAM GILBERT, J.S.A.
INTERIOR: ELEANOR COSCHER, L.S.D.
FIRE PREVENTION: FRED BLOSTEN, P.E.

[Signature]
 SEAL
 PAGE # 1
 OF 1

5

6

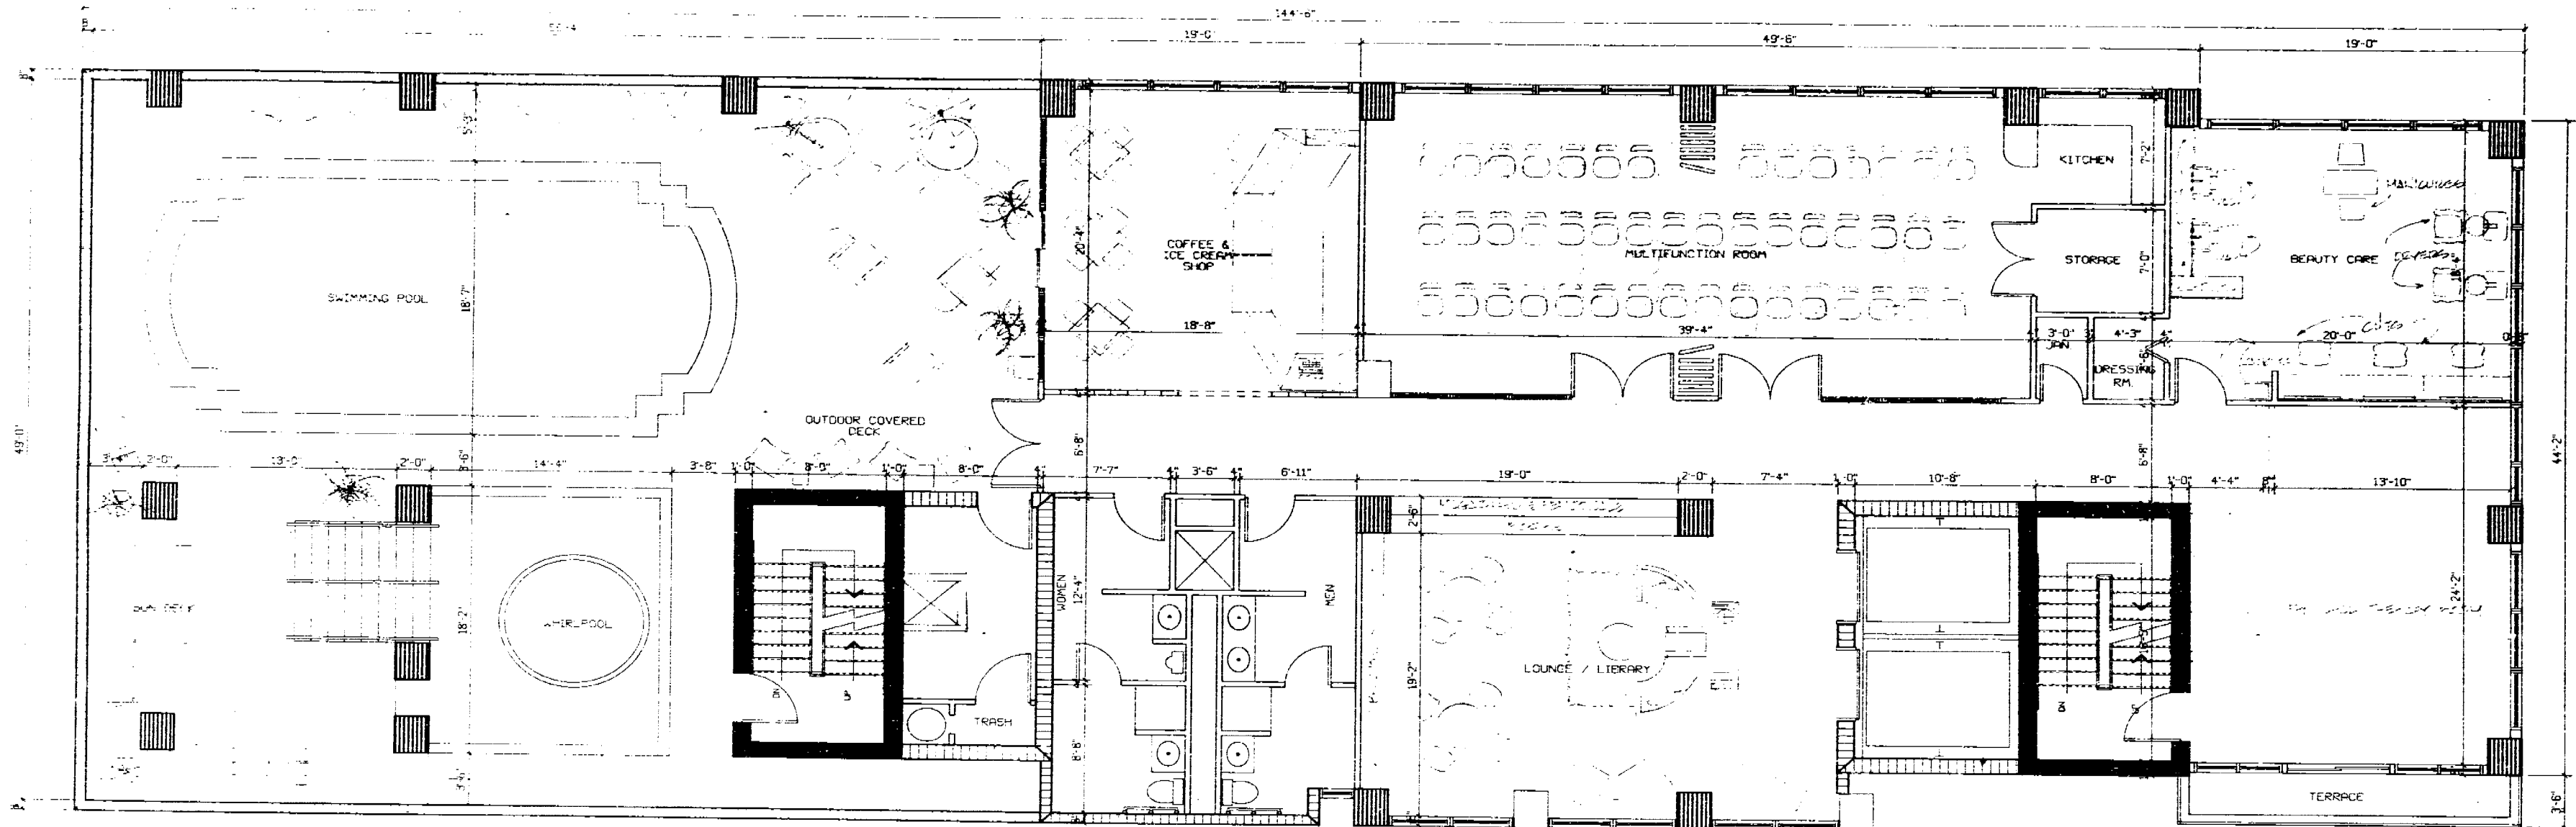

OFFICE COPY
CITY OF MIAMI BEACH
APPROVED FOR PERMIT BY
THE FOLLOWING:

SEAL
DATE



RECREATIONAL LEVEL
POOL / MULTIFUNCTION

REVISIONS
DATE ITEM

PROJECT:
6060 INDIAN CREEK REALTY
6060 INDIAN CREEK DRIVE
MIAMI BEACH, FLORIDA


ARCHITECT
MOSHE COSCHER, ARCHITECT
700 - 5th STREET
MIAMI BEACH, FLORIDA 33140

CONSULTANTS
ELECTRICAL: EDWARD SANTANA, P.E.
MECHANICAL: STEPHEN L. LEE, P.E.
PLUMBING: W. THOMAS ZEPPE, P.E.
LANDSCAPING: WILFRED L. JAMES, P.E.
INTERIOR: MOSHE COSCHER, AIA
PAINTING: FRED BUSTENIEVE, P.E.

SEAL
PAGE 8
OF

5

6

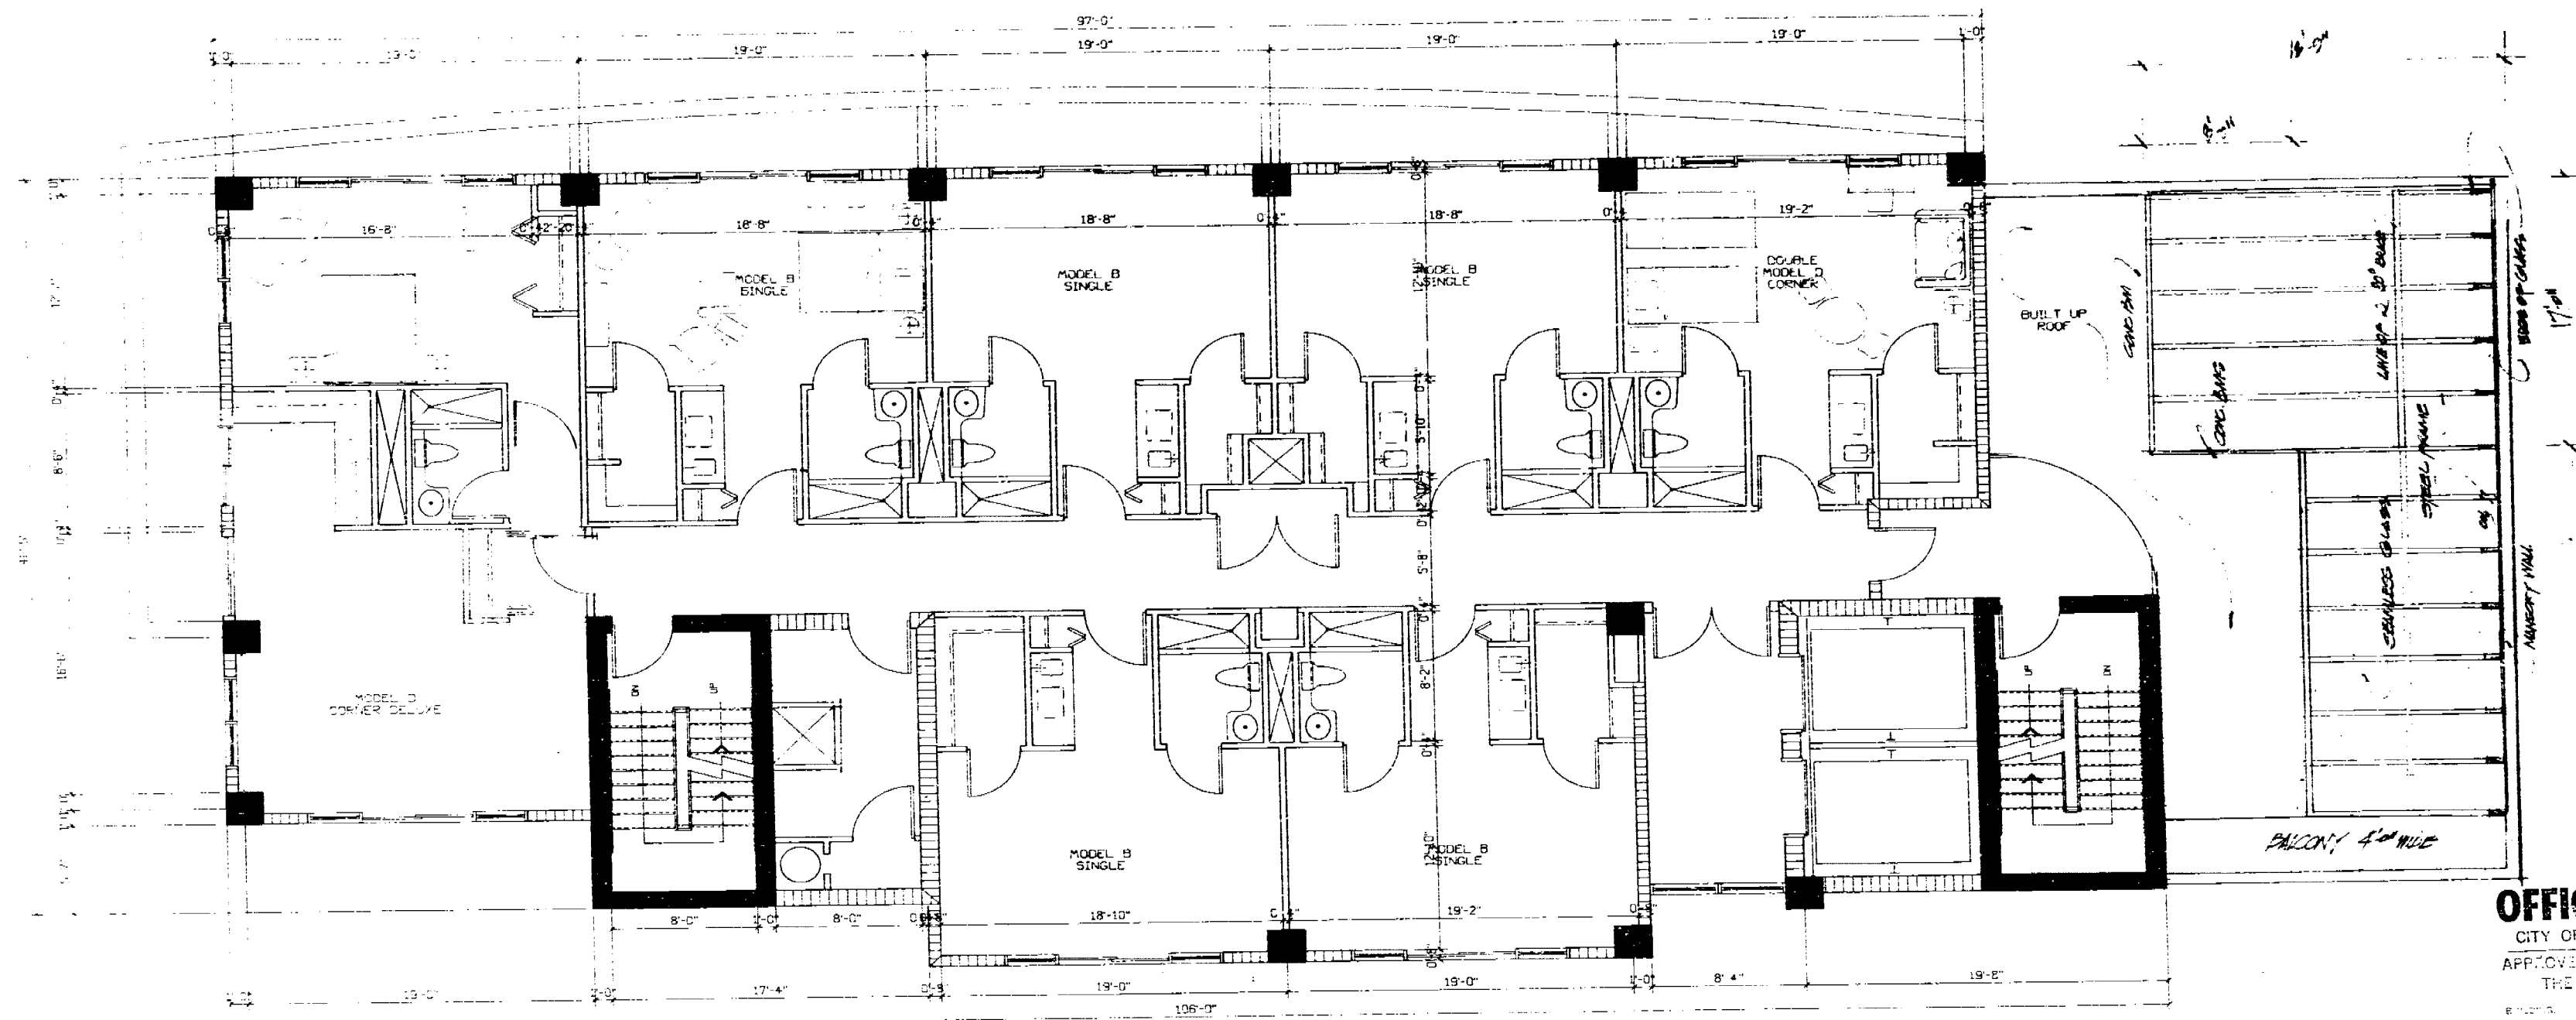

10 TYPICAL FLOORS

100 RESIDENTS
 5 MODEL "B" UNITS TYP.
 1 MODEL "C" UNIT TYP.
 2 MODEL "D" UNITS TYP.
 8 UNITS = 10 RESIDENTS

OFFICE COPY
 CITY OF MIAMI BEACH
 APPROVED FOR PERMIT BY
 THE FOLLOWING:


CONSULTANT	FLR. #	DATE
STRUCTURAL	100	10/1/00
ELECTRICAL	100	10/1/00
Mechanical	100	10/1/00
Plumbing	100	10/1/00
Fire Prevention	100	10/1/00
Engineering	100	10/1/00

REVISIONS

DATE	ITEM

PROJECT:
 6060 INDIAN CREEK REALTY
 6060 INDIAN CREEK DRIVE
 MIAMI BEACH, FLORIDA


ARCHITECT:
 MOSHE COSCHER, ARCHITECT
 700 - 5th STREET
 MIAMI BEACH, FLORIDA 33140

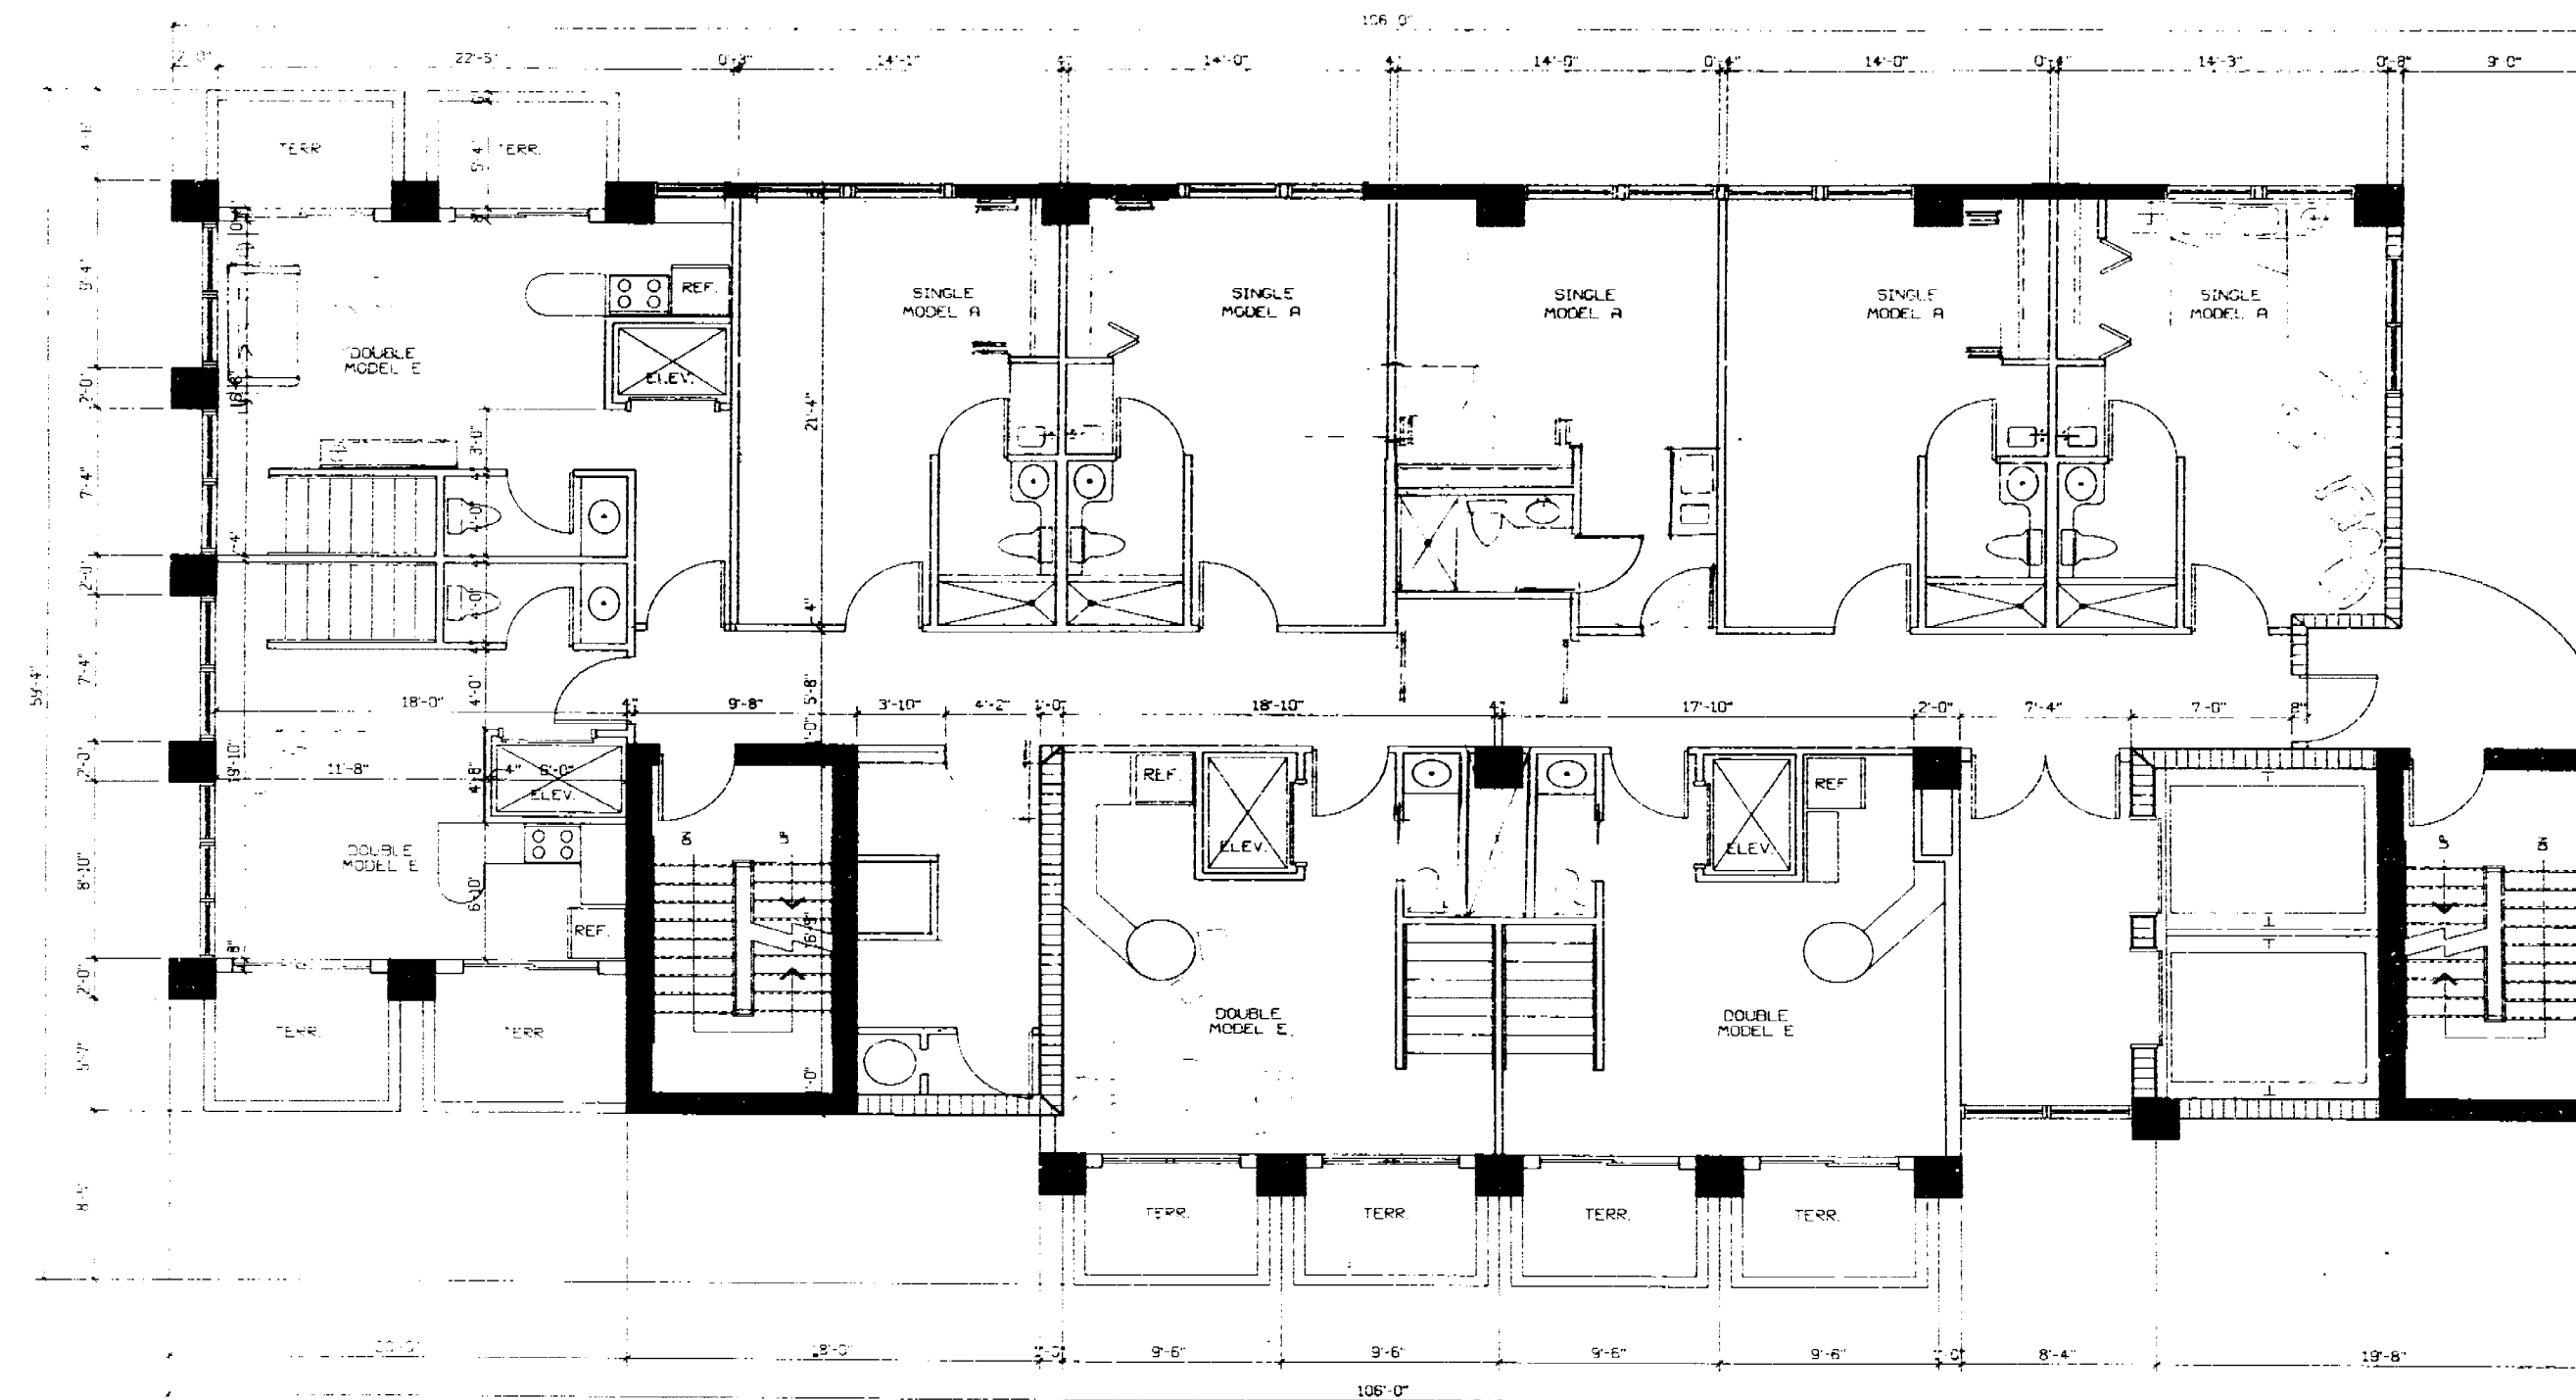

PENTHOUSE FLOOR
 13 RESIDENTS
 5 MODEL "A"
 4 MODEL "E"

OFFICE COPY
 CITY OF MIAMI BEACH
 APPROVED FOR PERMIT BY
 THE FOLLOWING:


CIVIL: _____
 ZONING: _____
 PLUMBING: _____
 ELECTRICAL: _____
 MECHANICAL: _____
 FIRE PREVENTION: _____
 ENGINEERING: _____

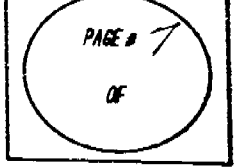REVISIONS	
DATE	ITEM
PROJECT:	
8080 INDIAN CREEK REALTY	
8080 INDIAN CREEK DRIVE	
MIAMI BEACH, FLORIDA	
ARCHITECT:	
MOSHE COSSICHER, ARCHITECT	
700 - 5th STREET	
MIAMI BEACH, FLORIDA 33140	
CONSULTANTS	FLORIDA #
STRUCTURAL	EDWARD J. JACOBI, P.E.
ELECTRICAL	STEVEN HELLER, P.E.
MECHANICAL	WILLIAM J. ZEMKE, P.E.
LANDSCAPING	WILLIAM J. LEAHY, A.S.L.A.
INTERIOR	ELENA COSSICHER, A.S.D.
PAVING	FRED B. LESTER, P.E.
 SEAL  SEAL	



000000
 ZONE:
 PLUMBING:
 ELECTRICAL:
 MECHANICAL:
 FIRE PREVENTION:
 ENGINEERING:

5

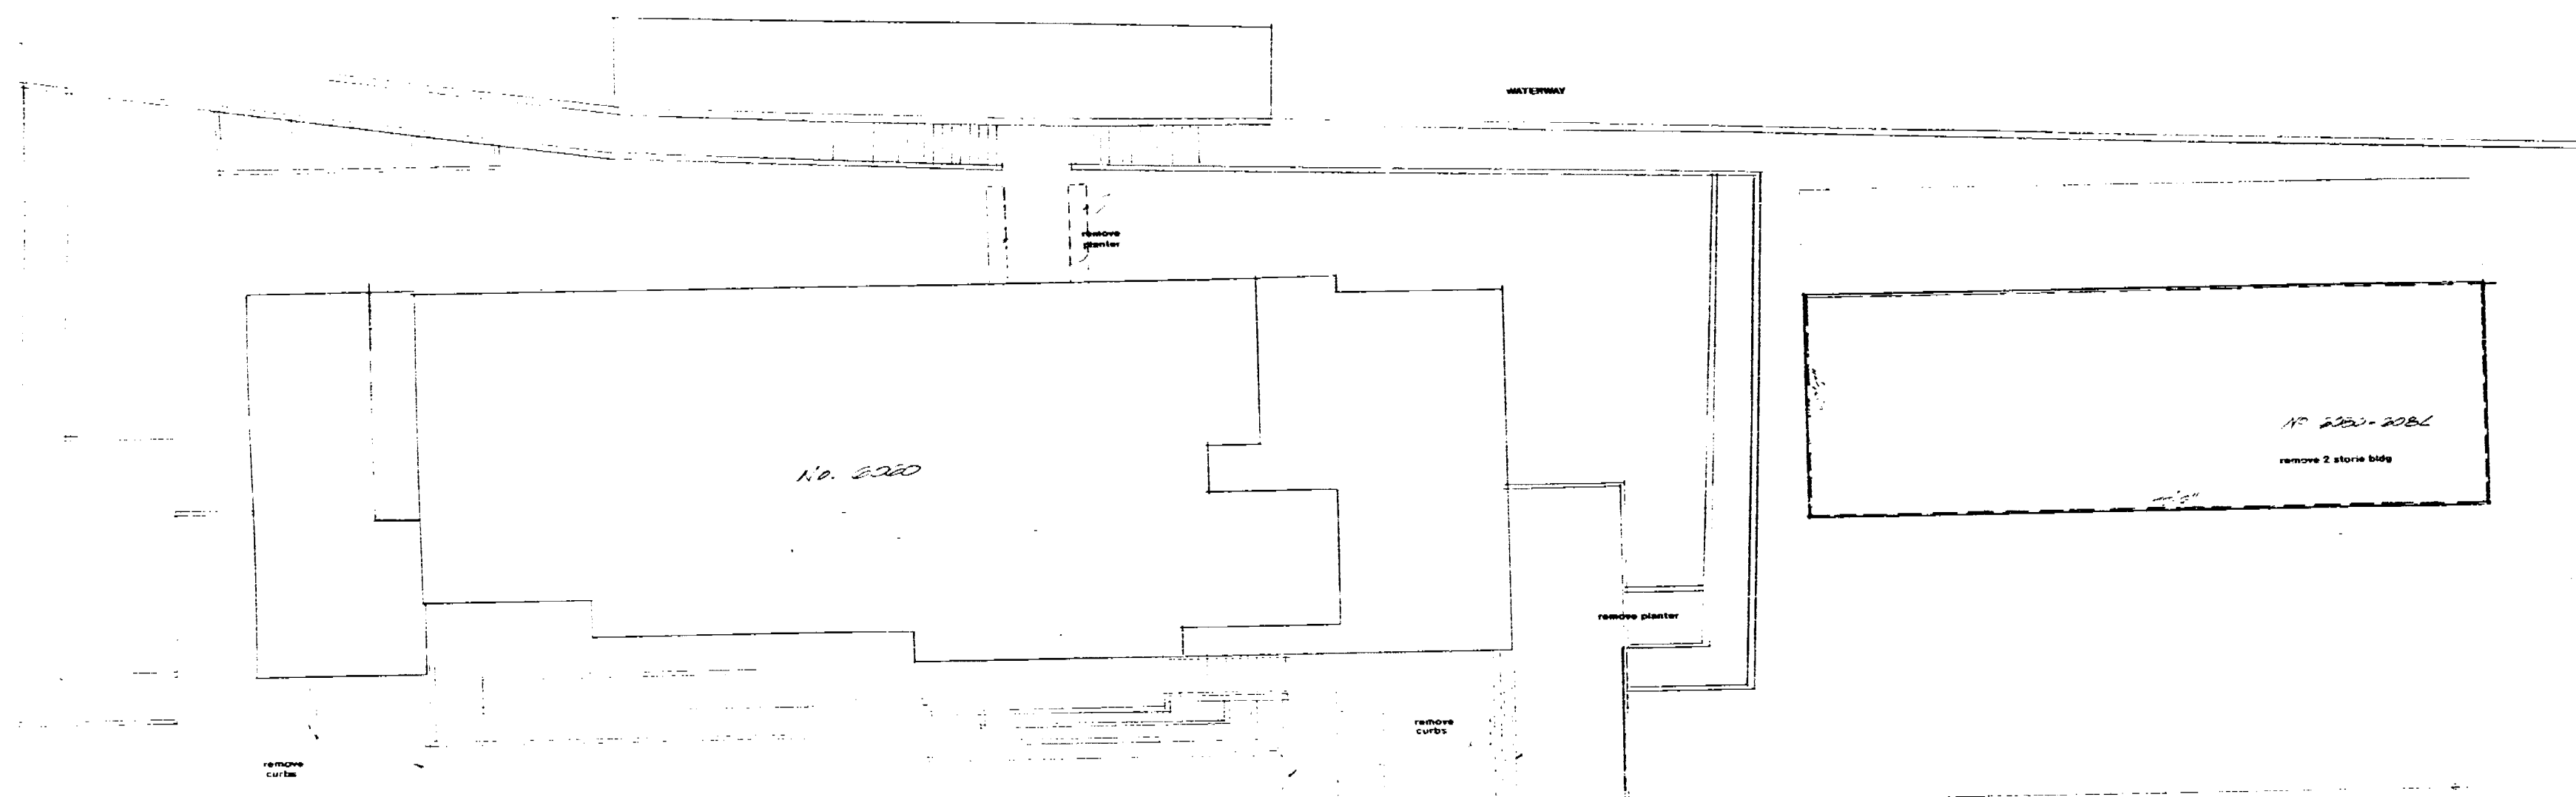


OFFICE COPY

CITY OF MIAMI BEACH
 APPROVED FOR PERMIT BY
 THE FOLLOWING:


DESIGNED BY: *[Signature]*
 CHECKED BY: *[Signature]*
 ENGINEER: *[Signature]*
 ARCHITECT: *[Signature]*
 FIRE PREVENTION: *[Signature]*
 ELECTRICAL: *[Signature]*
 MECHANICAL: *[Signature]*
 PLUMBING: *[Signature]*
 ROOFING: *[Signature]*
 CONCRETE: *[Signature]*
 EXCAVATING: *[Signature]*

SITE PLAN 1/8" = 1'-0"

Demolition plans for:
6080 Indian Creek Dr. Miami Beach

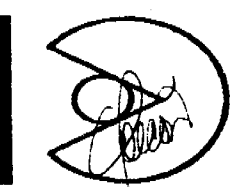

morhe corleher & assoc.
 architects, designers & planners
 700 FIFTY FIRST ST MIAMI BEACH, FL 33140
 ph. (305) 861-7936 Fax (305) 866-1801

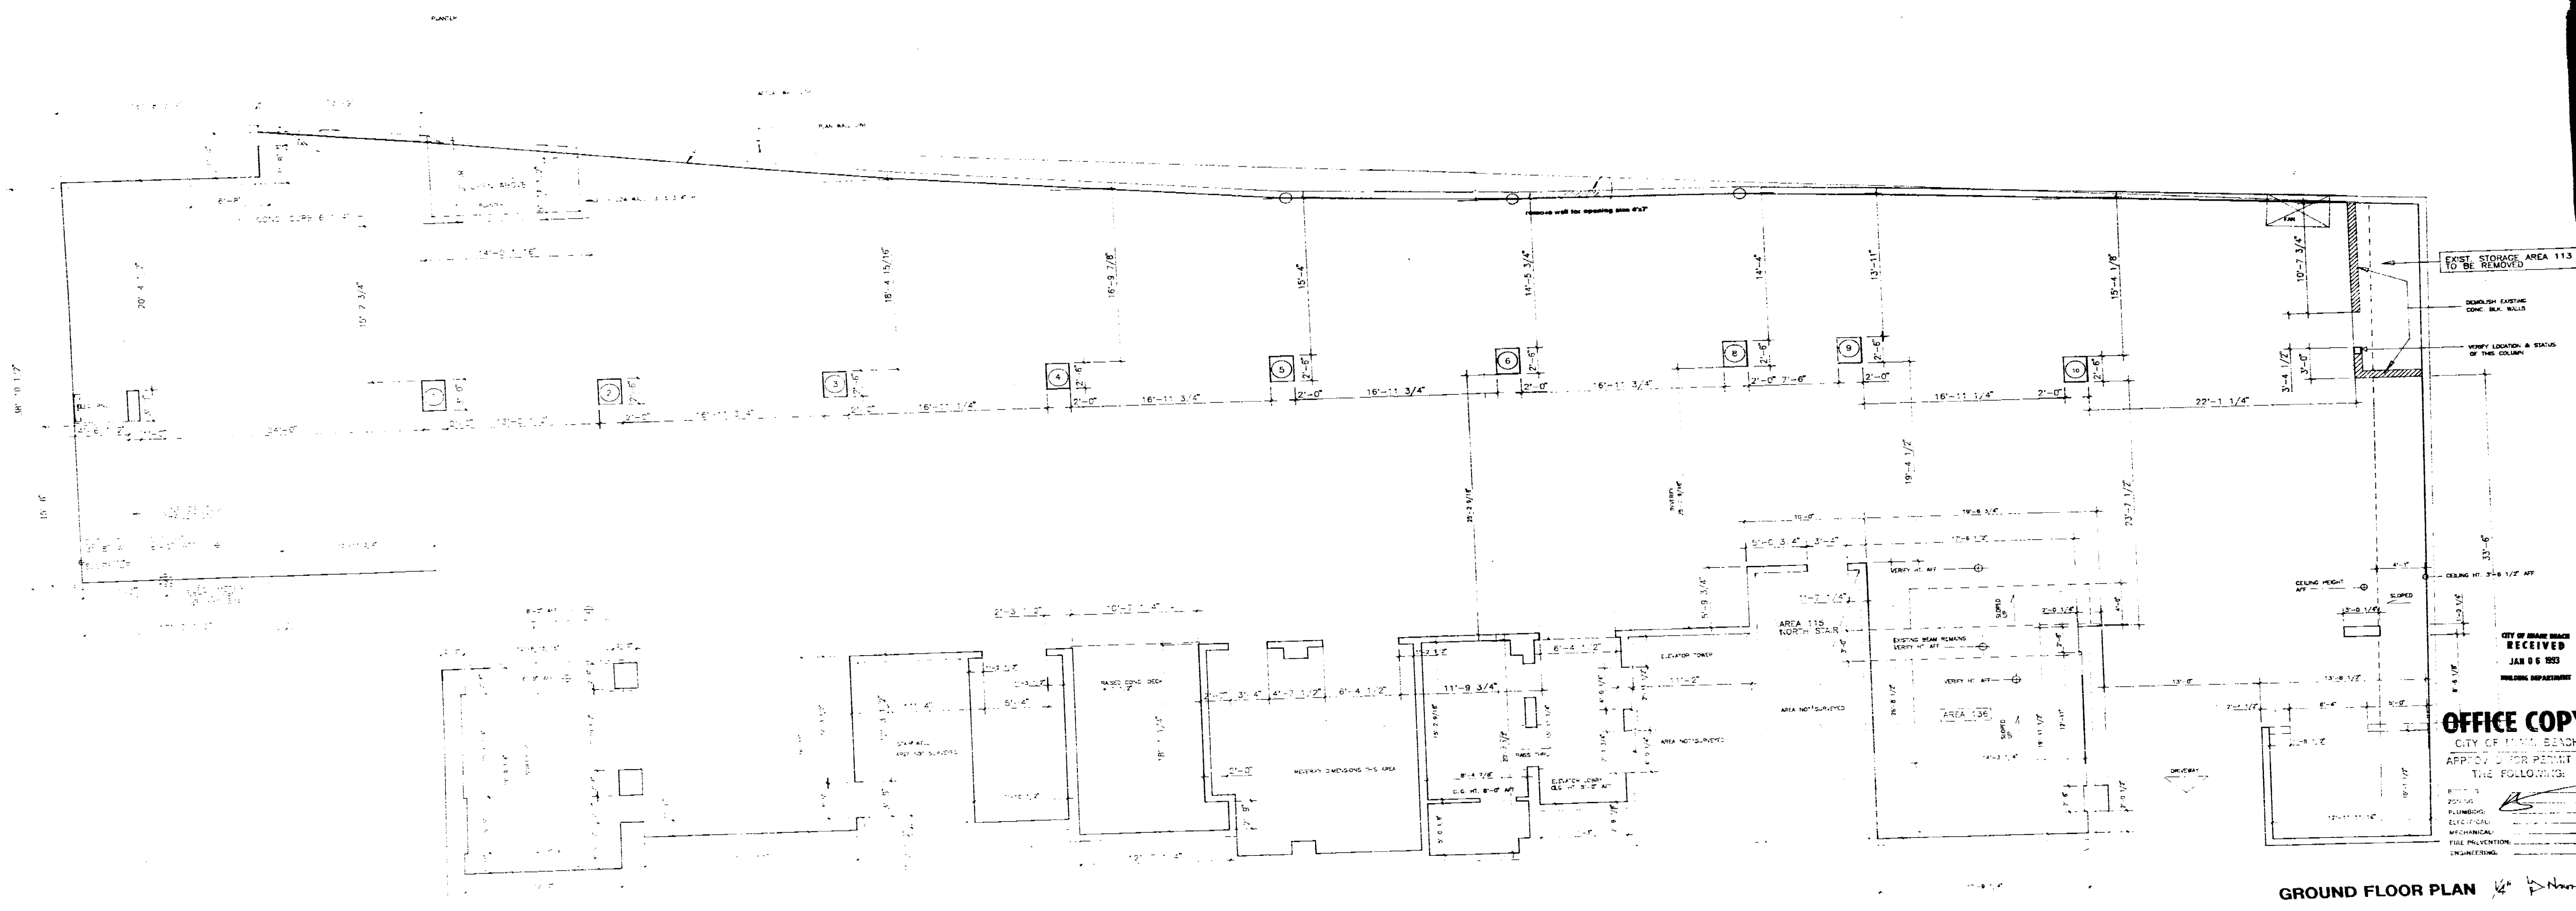


mark corcher & assoc.
architects, designers & planners
 700 FIFTY FIRST ST MIAMI BEACH, FL 33140
 ph. (305) 861-7936 Fax (305) 868-1901



Demolition plans for:
 8060 Indian Creek Dr. Miami Beach

Drawn by	
Reviewed by	
Job number	
Sheet number	11

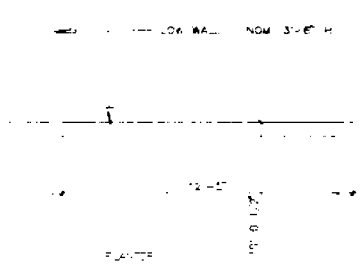

OFFICE COPY
CITY OF MIAMI BEACH
APPROVED FOR PERMIT BY
THE FOLLOWING:

APPROVED _____
ENGINEER _____
PLUMBING _____
ELECTRIC _____
MECHANICAL _____
FIRE PREVENTION _____
ENGINEER _____

**OFFICE OF MIAMI BEACH
RECEIVED
JAN 06 1953
BUILDING DEPARTMENT**


Drawn by _____

revision _____

ink number _____

date _____

spout number: 16

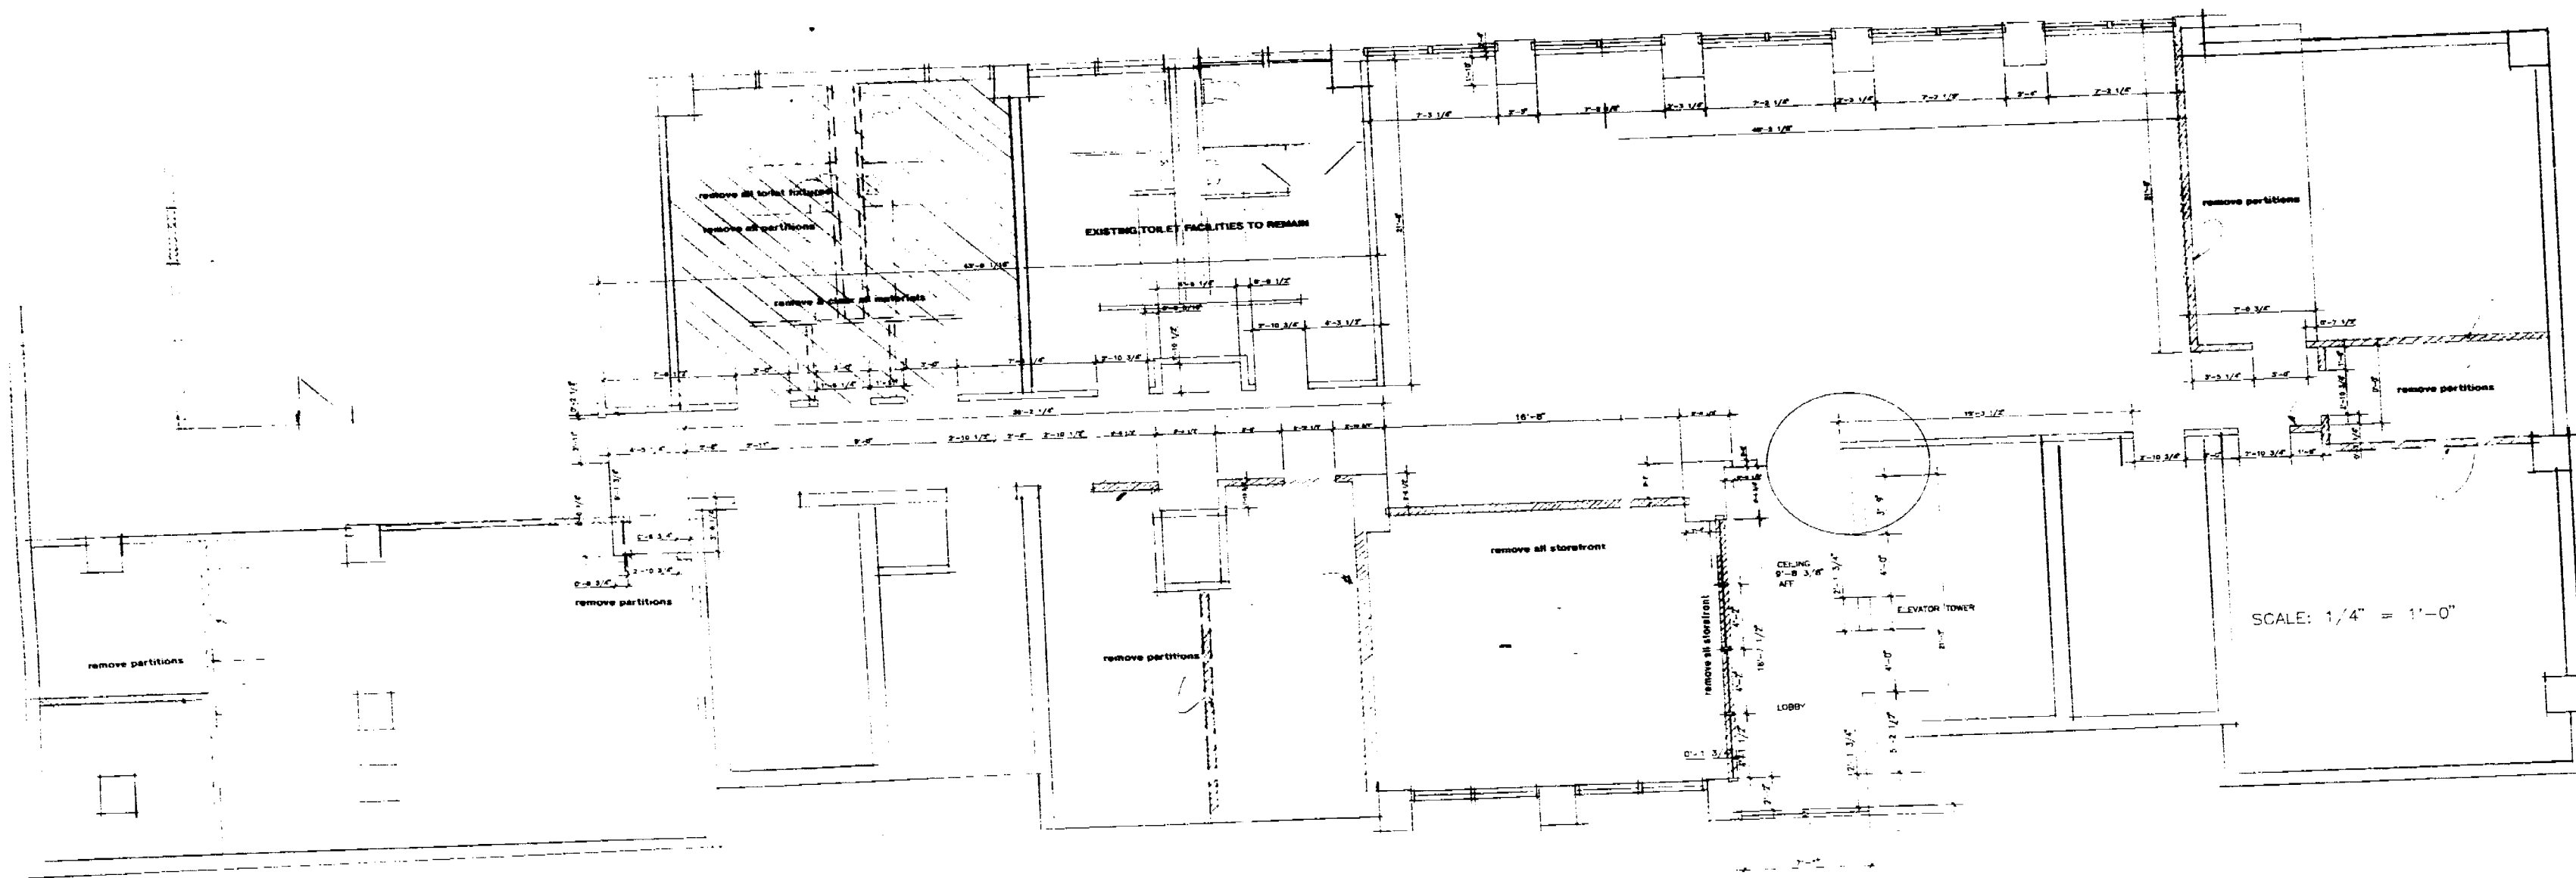

SECOND FLOOR

OFFICE COPY

CITY OF MIAMI BEACH
APPROVED FOR PERMIT
THE FOLLOWING:


ELECTRICAL _____
 MECHANICAL _____
 FIRE PREVENTION _____
 ENGINEER _____
 RECEIVED
 JAN 04 1993
 BUILDING DEPARTMENT

Demolition plans for:
 6060 Indian Creek Dr. Miami Beach



moshe cosicher & assoc.
 architects, designers & planners
 700 FIFTY FIRST ST MIAMI BEACH, FL 33140
 tel. (305) 8617936 Fax (305) 8661801

prepared by: _____
 checked by: _____
 date: _____

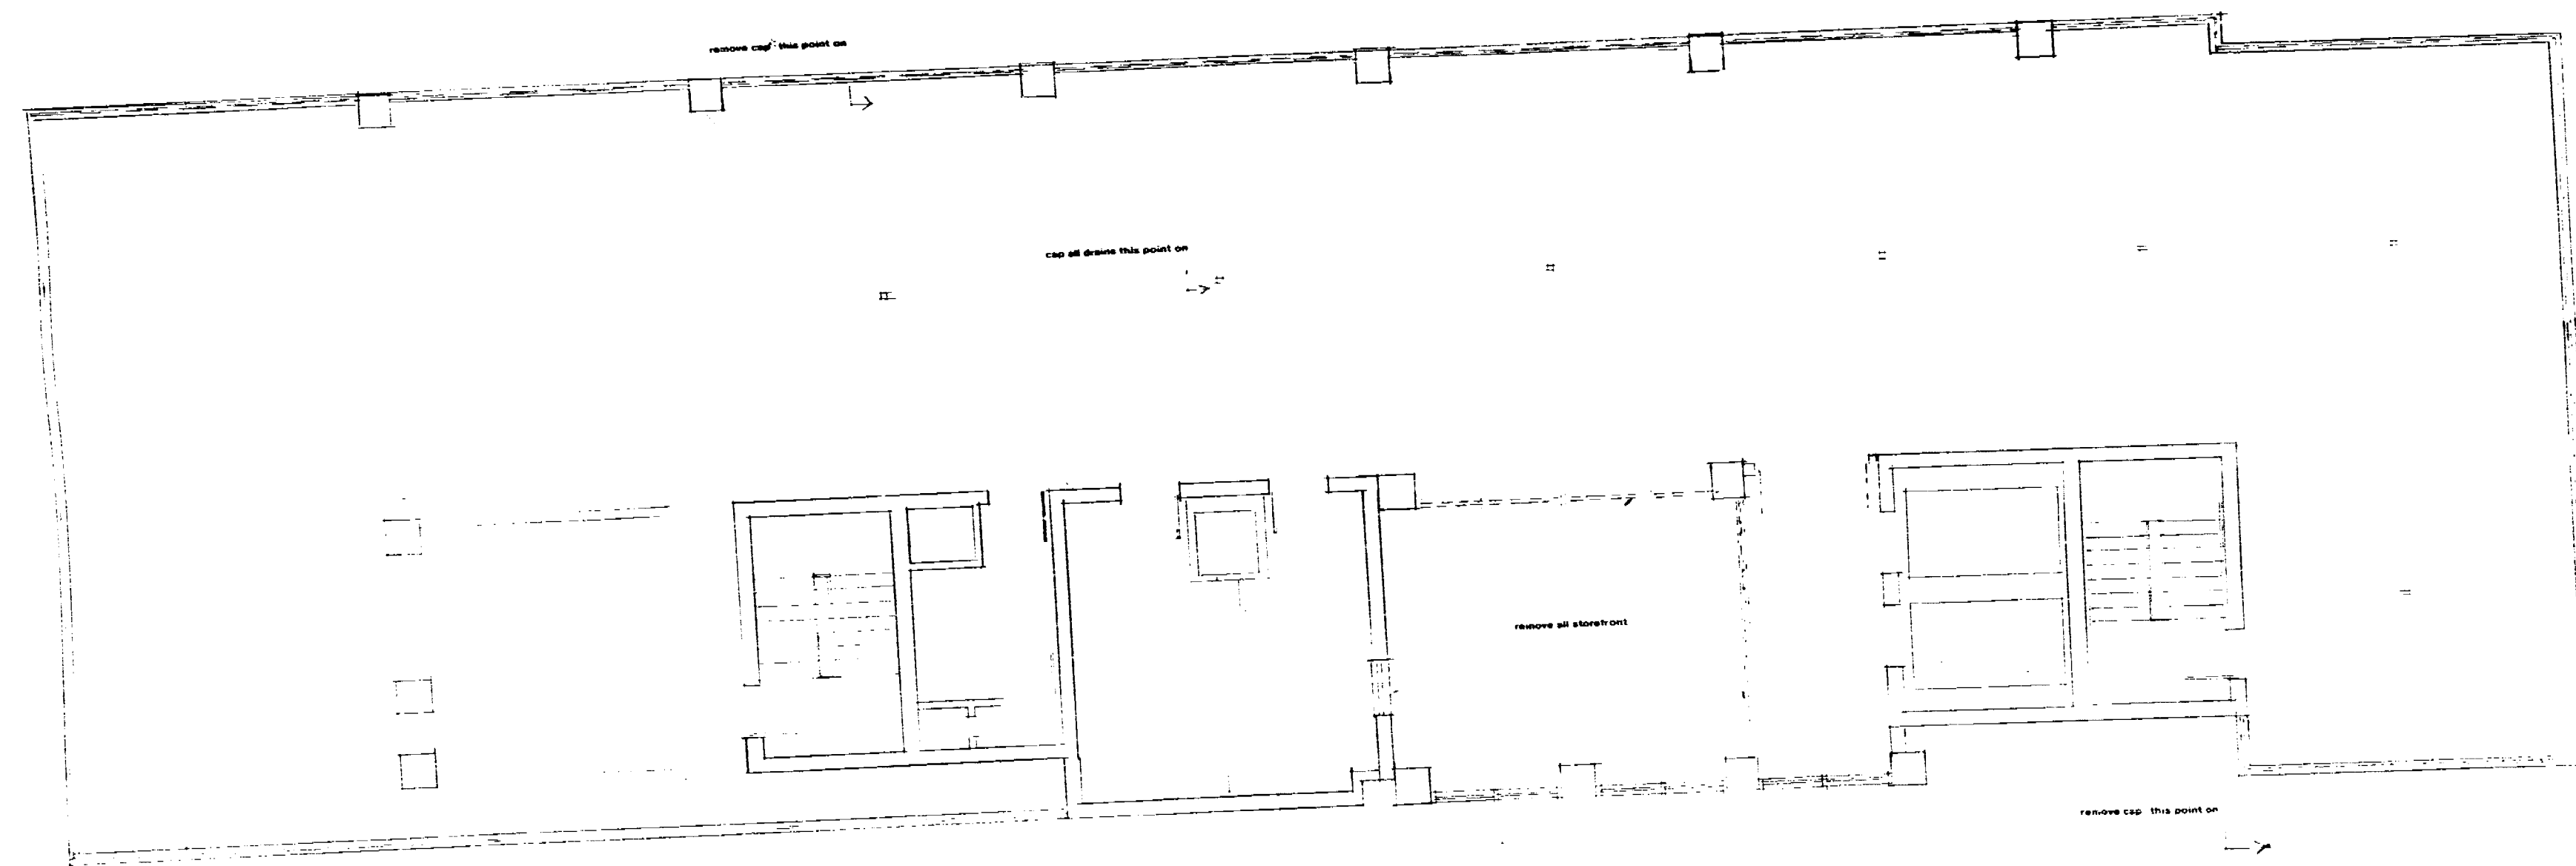

4 TH FLOOR POOL & RECREATION LEVEL


OFFICE COPY
CITY OF MIAMI BEACH
APPROVED FOR PERMIT BY
THE FOLLOWING:
DEPT. OF
ZONING
PLANNING
ELECTRICAL
MECHANICAL
FIRE PREVENTION
ENGINEERING

moshe cosicher & assoc.
architects, designers & planners
700 FIFTY FIRST ST. MIAMI BEACH, FL 33135
PH: (305) 661-1001 FAX: (305) 661-1001



Demolition plans for:
6000 Indian Creek Dr. Miami Beach

Project No.	
Revision	
Date	
Scale	1/4"

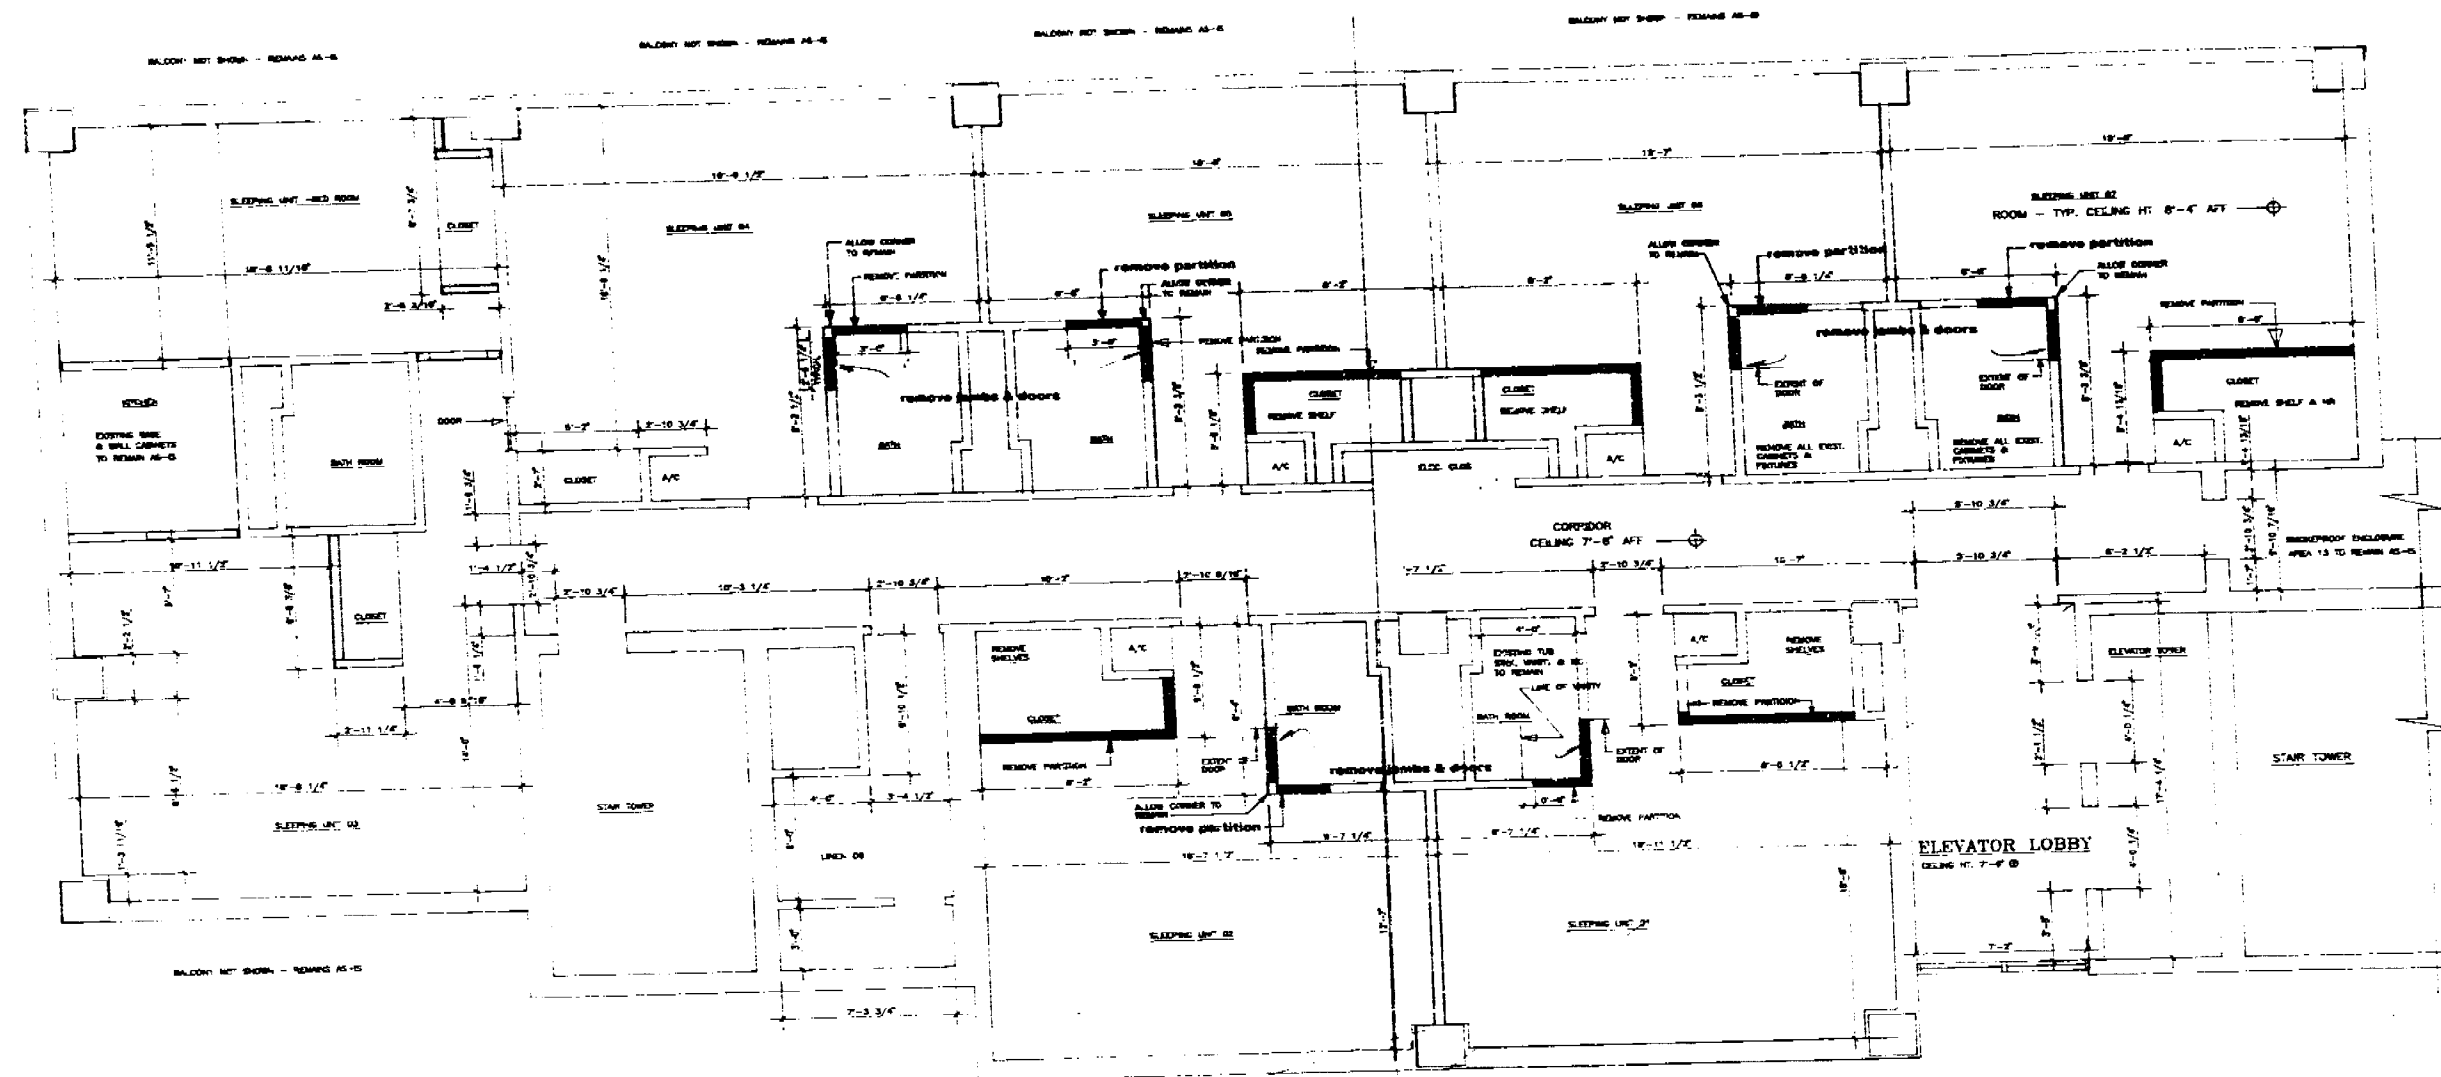


10 TYPICAL APARTMENT FLOOR PLANS (floors 5 thru 14) 1/4"

OFFICE COPY
 CITY OF MIAMI BEACH
 APP. OF D. FOR PERMIT BY
 THE FOLLOWING:
 BUILDING DEPARTMENT
 RECEIVED
 JAN 18 1993
 PLUMBING
 ELECTRICAL
 MECHANICAL
 FIRE PREVENTION
 ENGINEERING

Demolition plans for:
 6060 Indian Creek Dr. Miami Beach




moshe cosicher & assoc.
 architects, designers & planners
 700 FIFTY FIRST ST MIAMI BEACH, FL 33136
 ph. (305) 667-7900 Fax (305) 666-1901

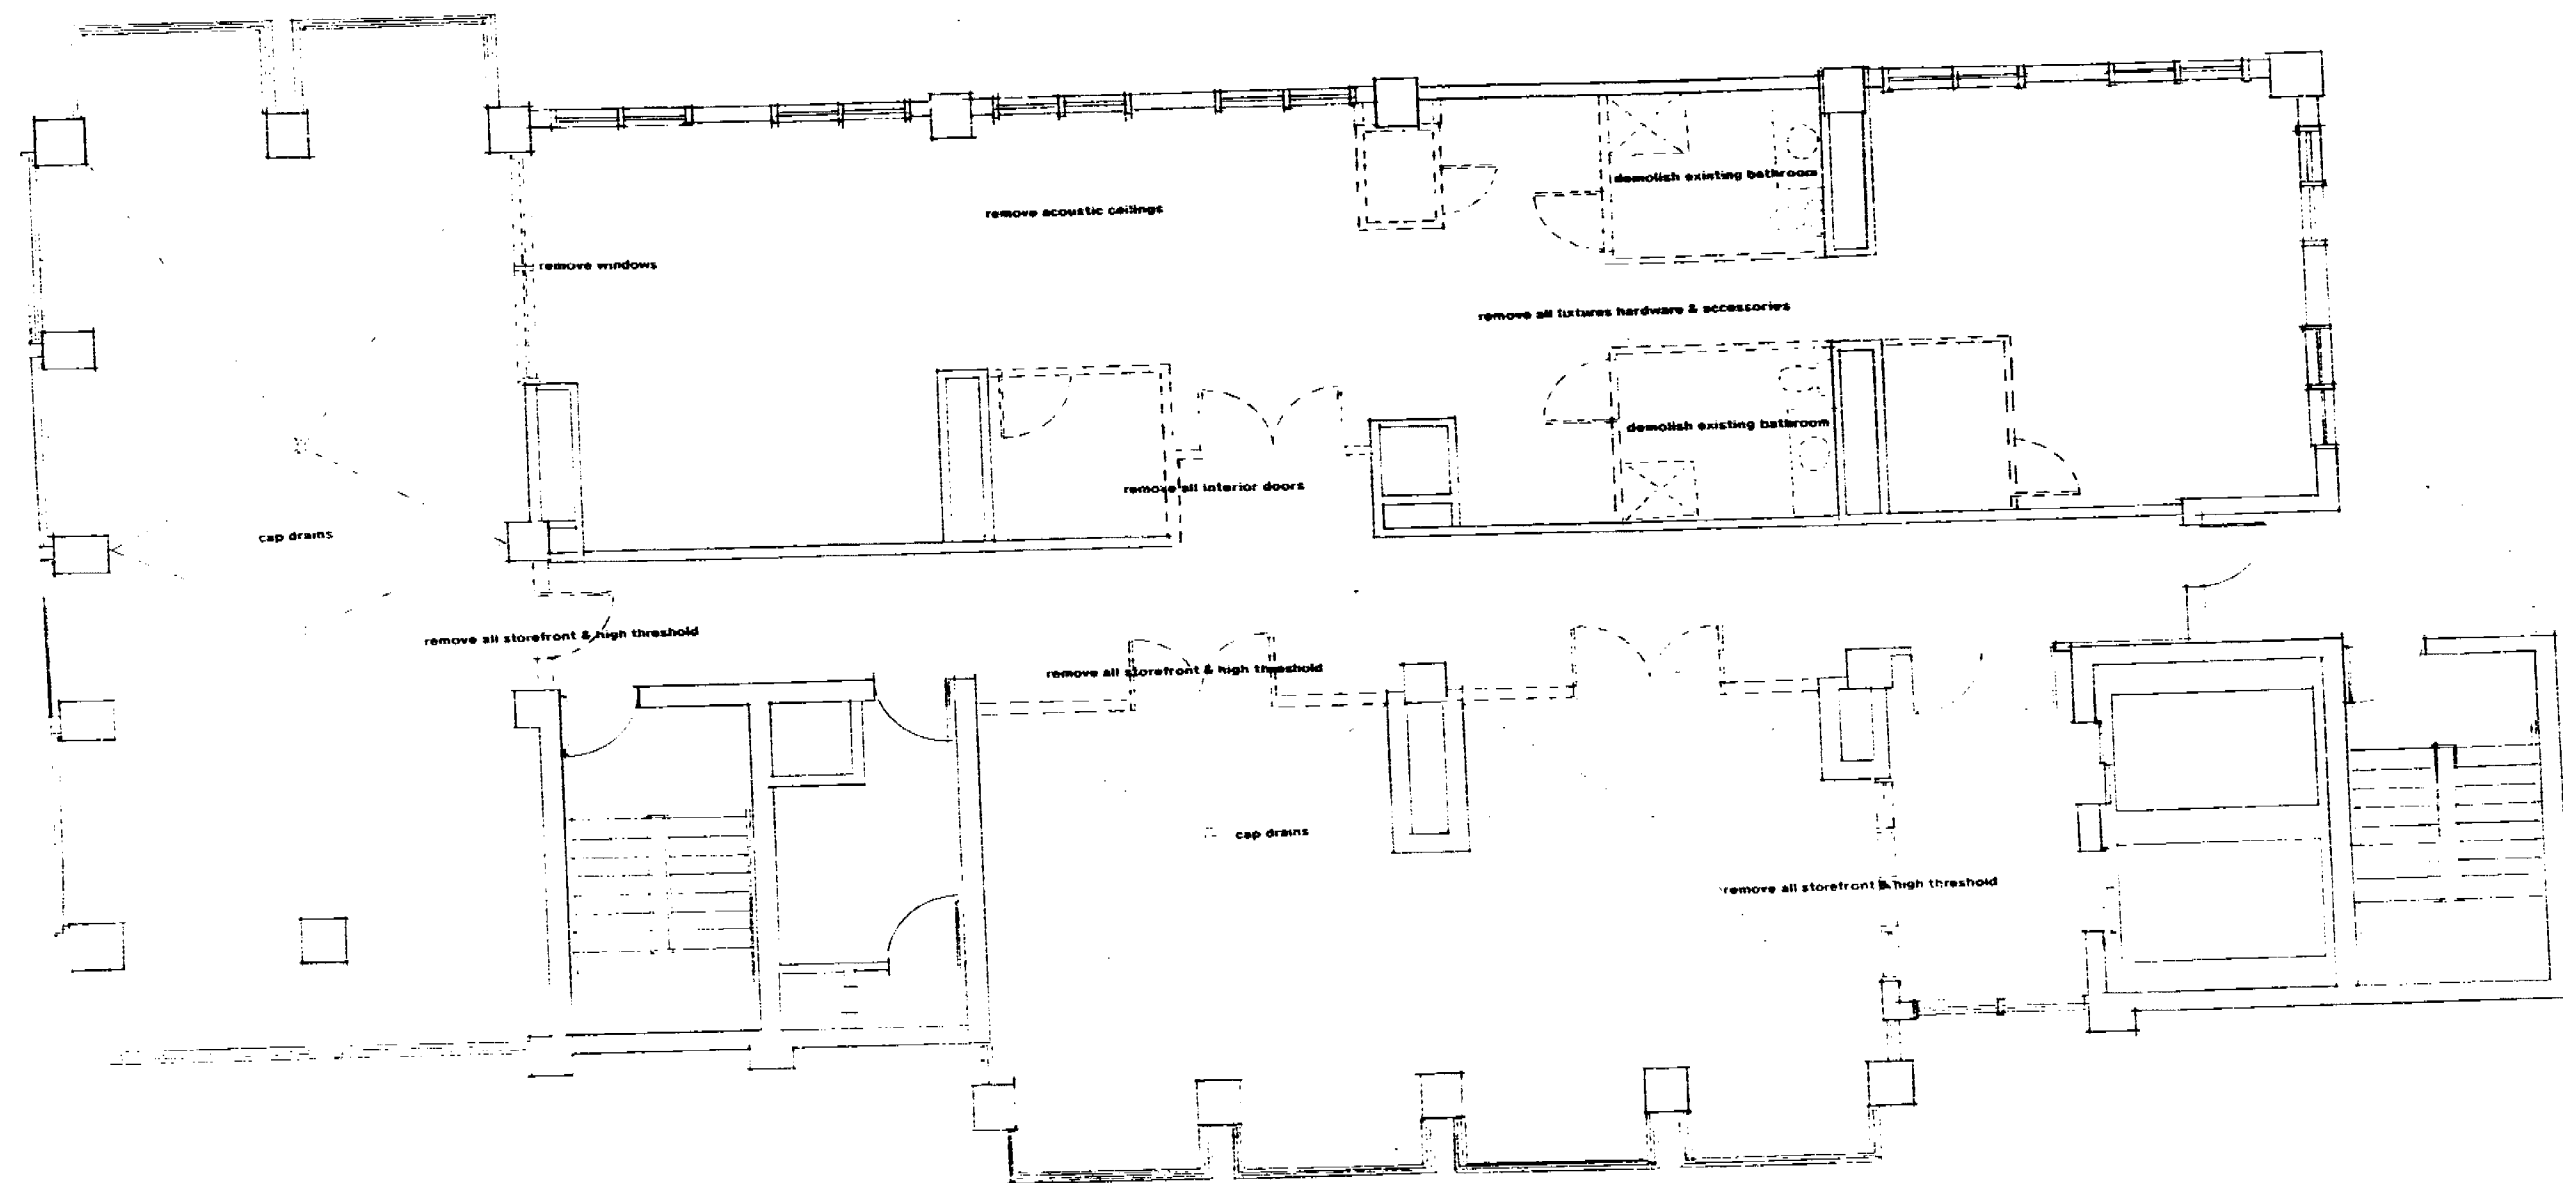

OFFICE COPY
 CITY OF MIAMI BEACH
 APPROVED FOR FILING BY
 THE PLANNING DEPARTMENT
 CITY OF MIAMI BEACH
 RECEIVED
 JAN 06 1993
 PLANNING DEPARTMENT
 ENGINEERING
 FIRE PREVENTION
 MECHANICAL
 ELECTRICAL
 PLUMBING
 BUILDING


PENTHOUSE LEVEL (15th floor) 20

mohe colcher & assoc.
architects, designers & planners
 700 FIFTY FIRST ST MIAMI BEACH, FL 33140
 ph. (305) 8677936 Fax (305) 8661801

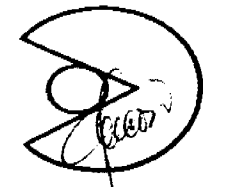

Demolition plans for:
 6060 Indian Creek Dr. Miami Beach

Drawn by	
Checked by	
Scale	
Sheet number	10

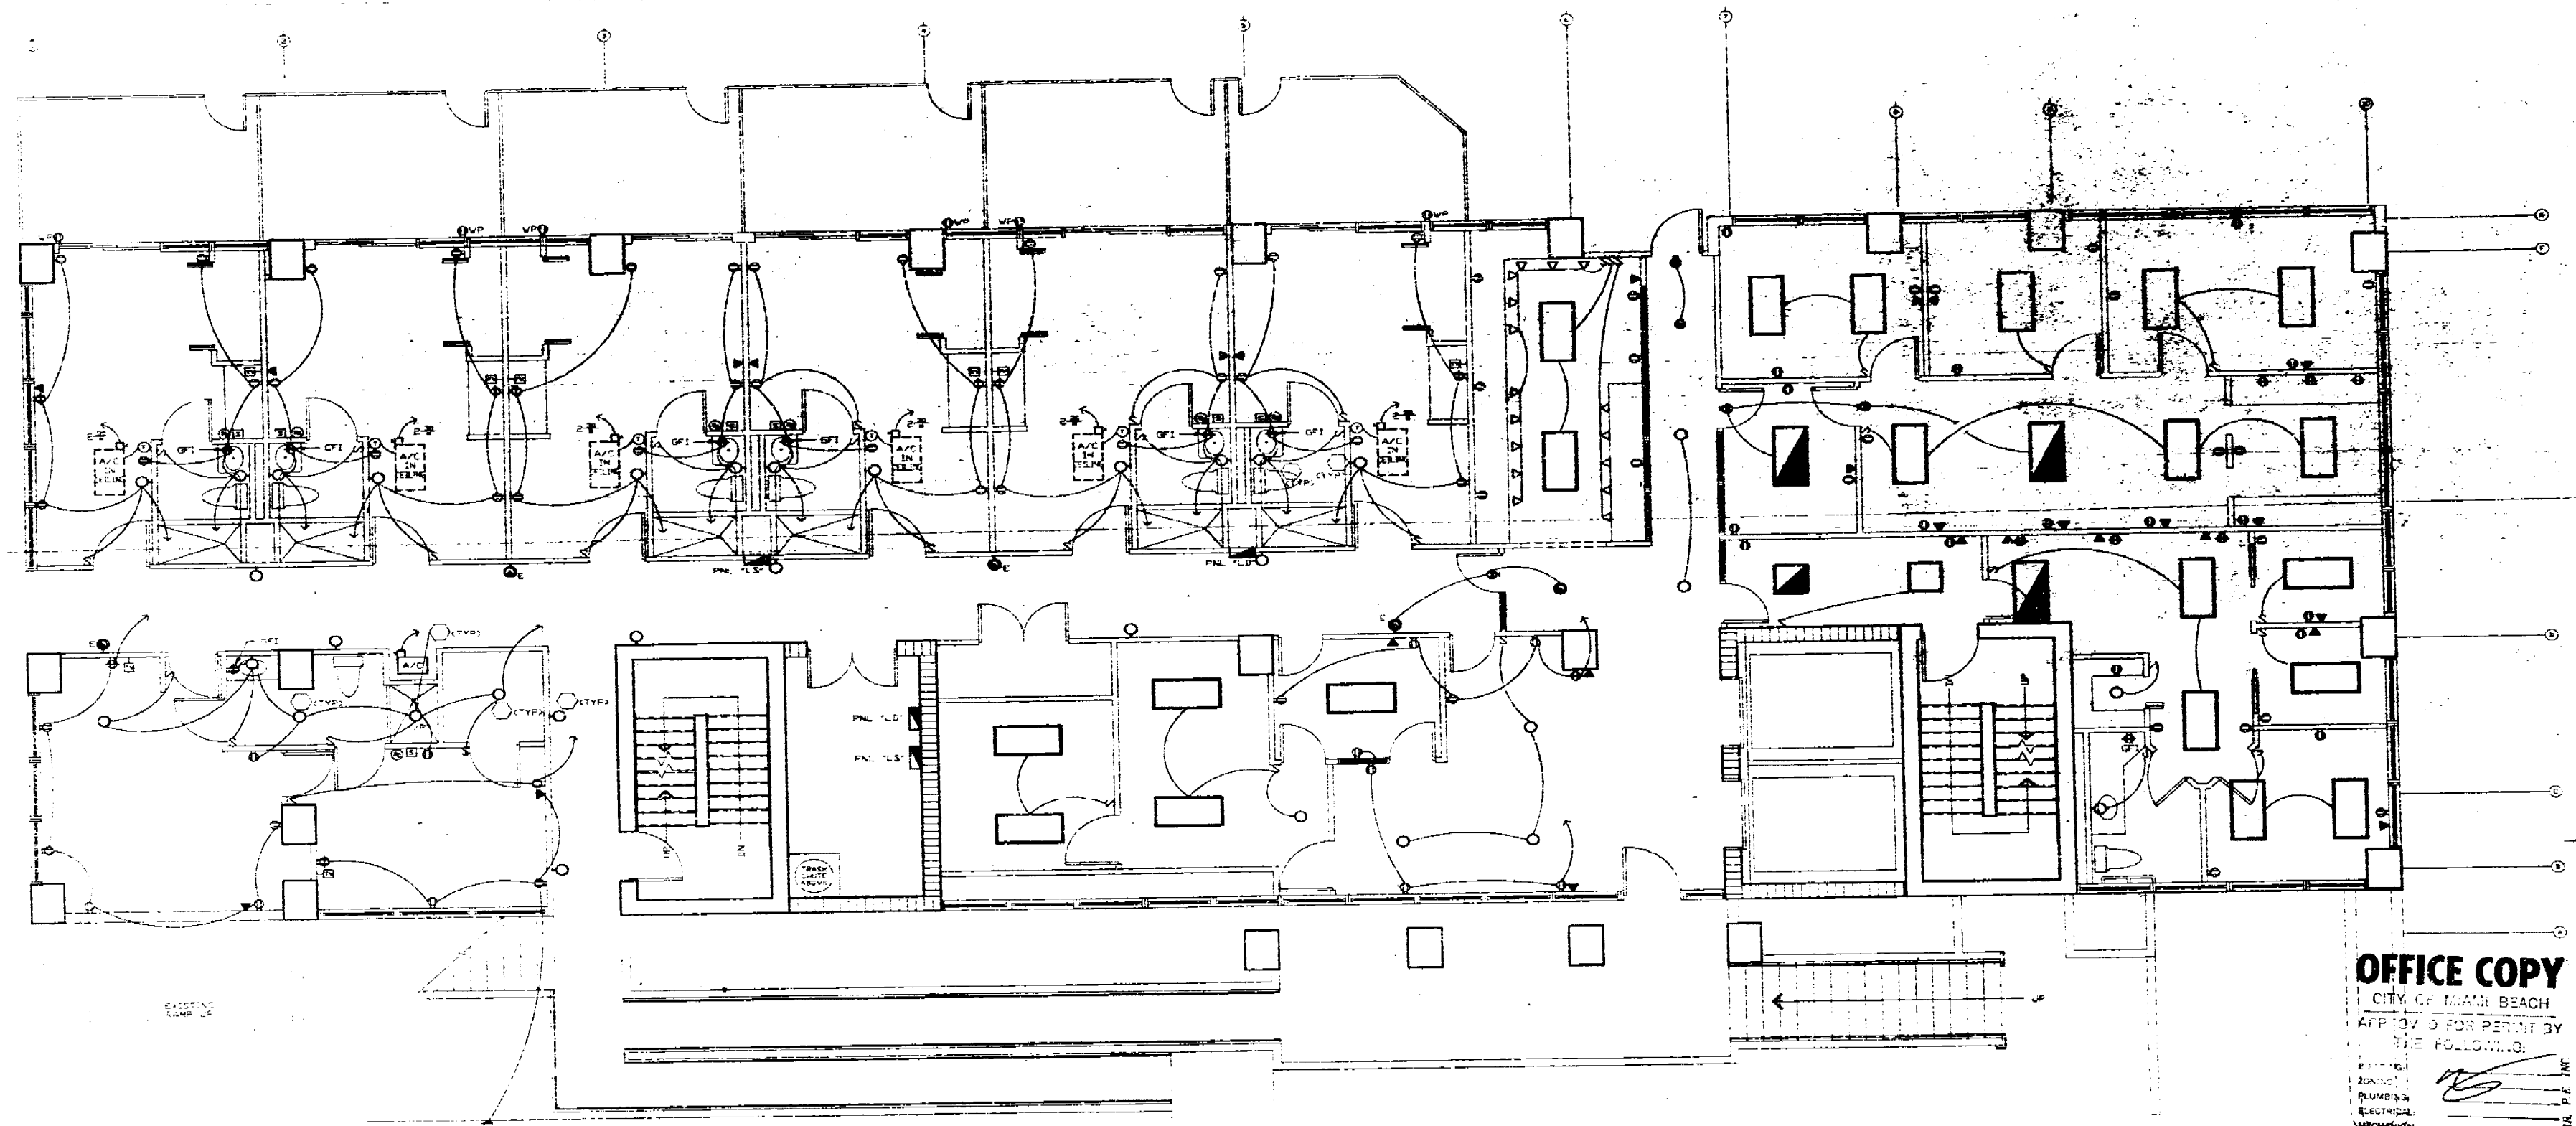


ENTRY LOBBY FLOOR PLAN - ELECTRICAL
 ADMINISTRATION

OFFICE COPY


CITY OF MIAMI BEACH
 APPROVED FOR PERMIT BY
 THE FOLLOWING:

ELECTRICAL
 PLUMBING
 MECHANICAL
 FIRE PREVENTION
 ENGINEERING

CITY OF MIAMI BEACH
RECEIVED
 JAN 06 1953
 BUILDING DEPARTMENT

REVISIONS	
DATE	ITEM

PROJECT	6800 MIAMI CREEK DRIVE MIAMI BEACH, FLORIDA
ARCHITECT	MOISE OSWALD, ARCHITECT 700 51st STREET MIAMI BEACH, FLORIDA 33140
DESIGN	ELECTRICAL
DATE	JAN 1 1953
SEAL	17

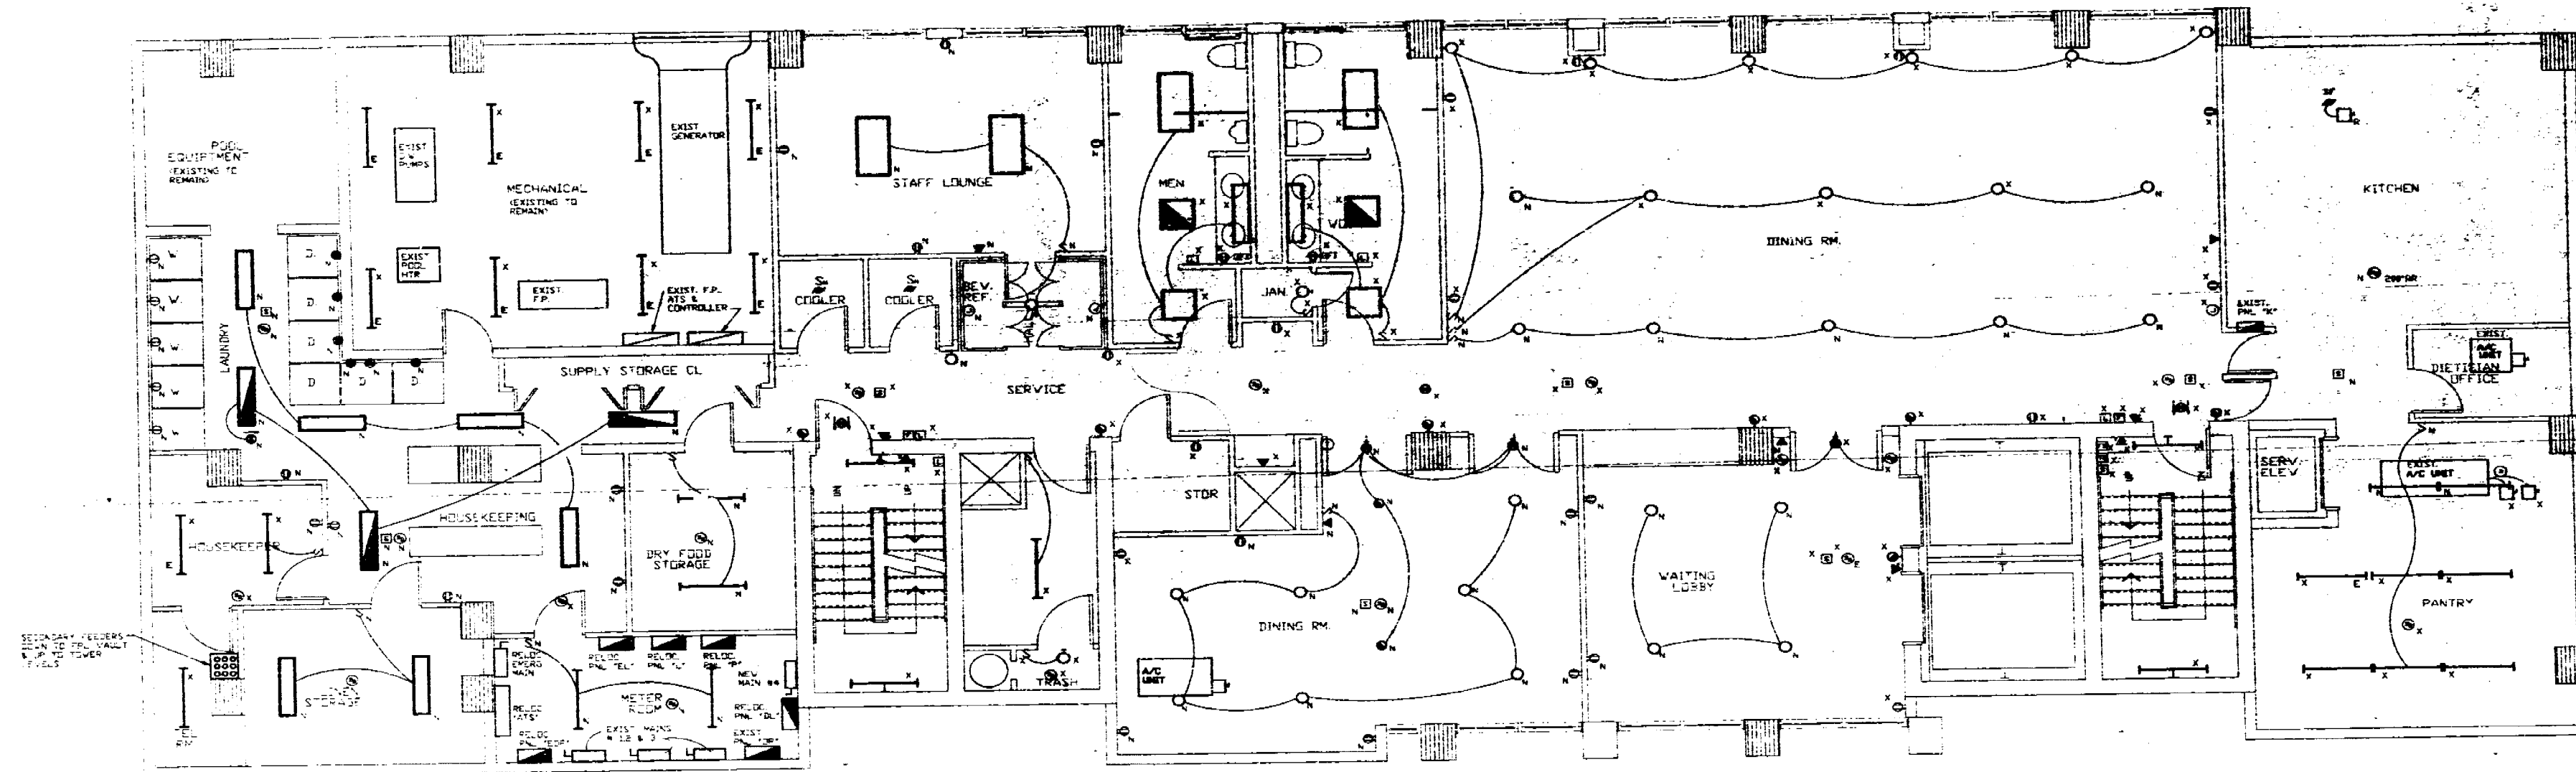

LEGEND
 X - EXISTING TO REMAIN
 O - EXISTING TO BE REMOVED
 N - NEW

DINING/KITCHEN LEVEL - ELECTRICAL
 SCALE: 1/4" = 1'-0"

OFFICE COPY
 CITY OF MIAMI BEACH
 APPROVED FOR PERMIT BY
 THE FOLLOWING:

 ELECTRICAL
 MECHANICAL
 FIRE PREVENTION
 ENGINEERING

CITY OF MIAMI BEACH
RECEIVED
 JAN 06 1963
 BUILDING DEPARTMENT

STEVEN PELLER, P.E. INC.
 CONSULTING ENGINEERS
 1001 N.W. 10th St., Suite 100
 MIAMI, FL 33136


REVISIONS	
DATE	ITEM
1-1-63	1-1-63

PROJECT:
 6060 INDIAN CREEK REALTY
 6060 INDIAN CREEK DRIVE
 MIAMI BEACH, FLORIDA

ARCHITECT
 MOSHE COSCHER, ARCHITECT
 700 - 5th STREET
 MIAMI BEACH, FLORIDA 33140

CONTRACT	FL 3634
SUBMITTAL	REVISIONS
SECTION	SECTION
ELECTRICAL	ELECTRICAL
MECHANICAL	MECHANICAL
INTERIOR	INTERIOR
PAINT	PAINT

SEAL
 PAGE 18
 OF

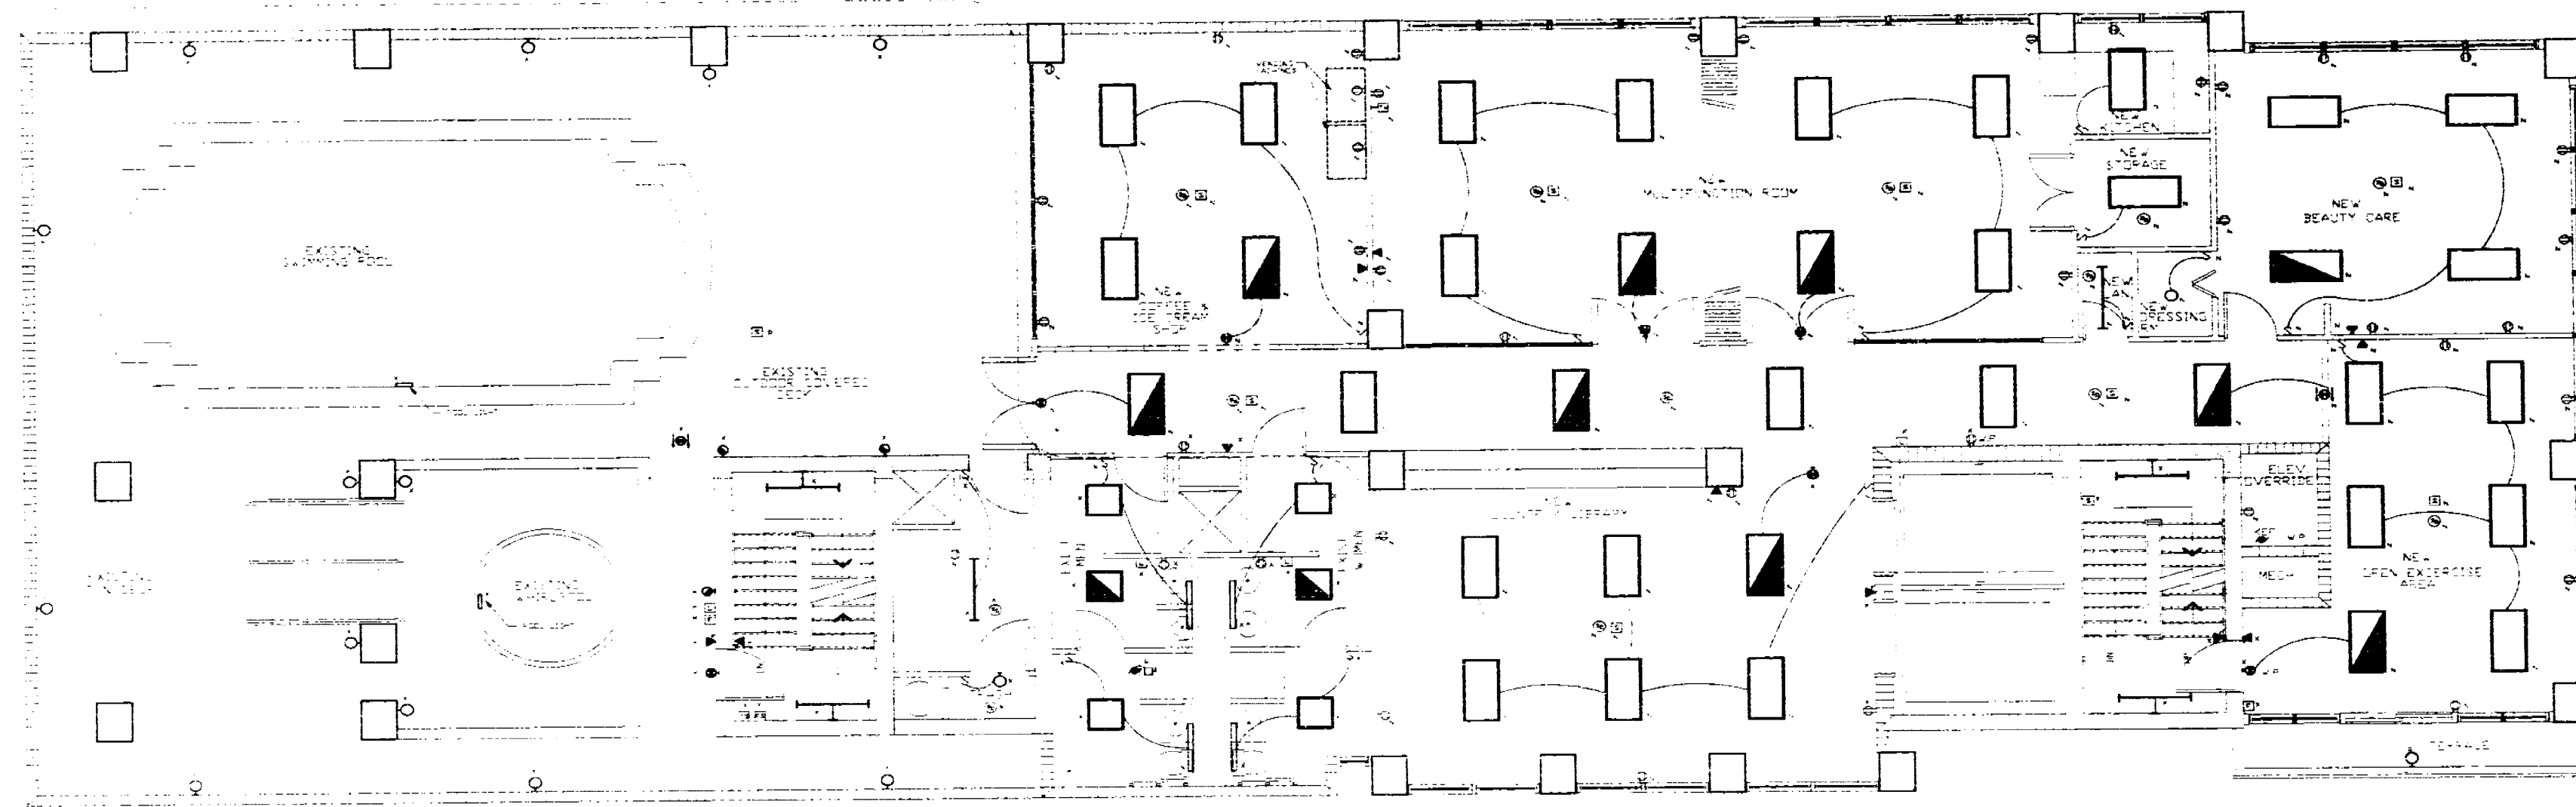

RECREATIONAL LEVEL - ELECTRICAL PLAN
 POOL / MULTIFUNCTION
 SCALE: 1/4" = 1'-0"

SEE EXISTING ELECTRICAL PLAN

OFFICE COPY

CITY OF MIAMI BEACH
 APPROVED FOR PERMIT BY
 THE FOLLOWING:

SUBMITTAL:
 ZONING:
 PLUMBING:
 ELECTRICAL:
 MECHANICAL:
 FIRE PREVENTION:
 ENGINEERING:

CITY OF MIAMI BEACH
RECEIVED
 JAN 06 1993
 BUILDING DEPARTMENT

STAFF: JEFFREY J. JAC
 PROJECT: MIAMI BEACH
 2000 MIAMI BEACH DRIVE
 MIAMI BEACH, FL 33140


REVISIONS		
DATE	ITEM	BY
5/1/93	REV. 1	STAFF

PROJECT:
 6060 INDIAN CREEK REALTY
 6060 INDIAN CREEK DRIVE
 MIAMI BEACH, FLORIDA

MOSHE COSCHER, ARCHITECT
 700 - 5th STREET
 MIAMI BEACH, FLORIDA 33140

CONSULTANTS	FLORIDA
STRUCTURAL	ENGINEERING
ELECTRICAL	ENGINEERING
CIVIL	ENGINEERING
MECHANICAL	ENGINEERING
INTERIOR	DESIGN
LANDSCAPE	ARCHITECTURE
PLUMBING	ENGINEERING
PAINTING	CONSTRUCTION

SEAL
 PAGE 1/3
 OF

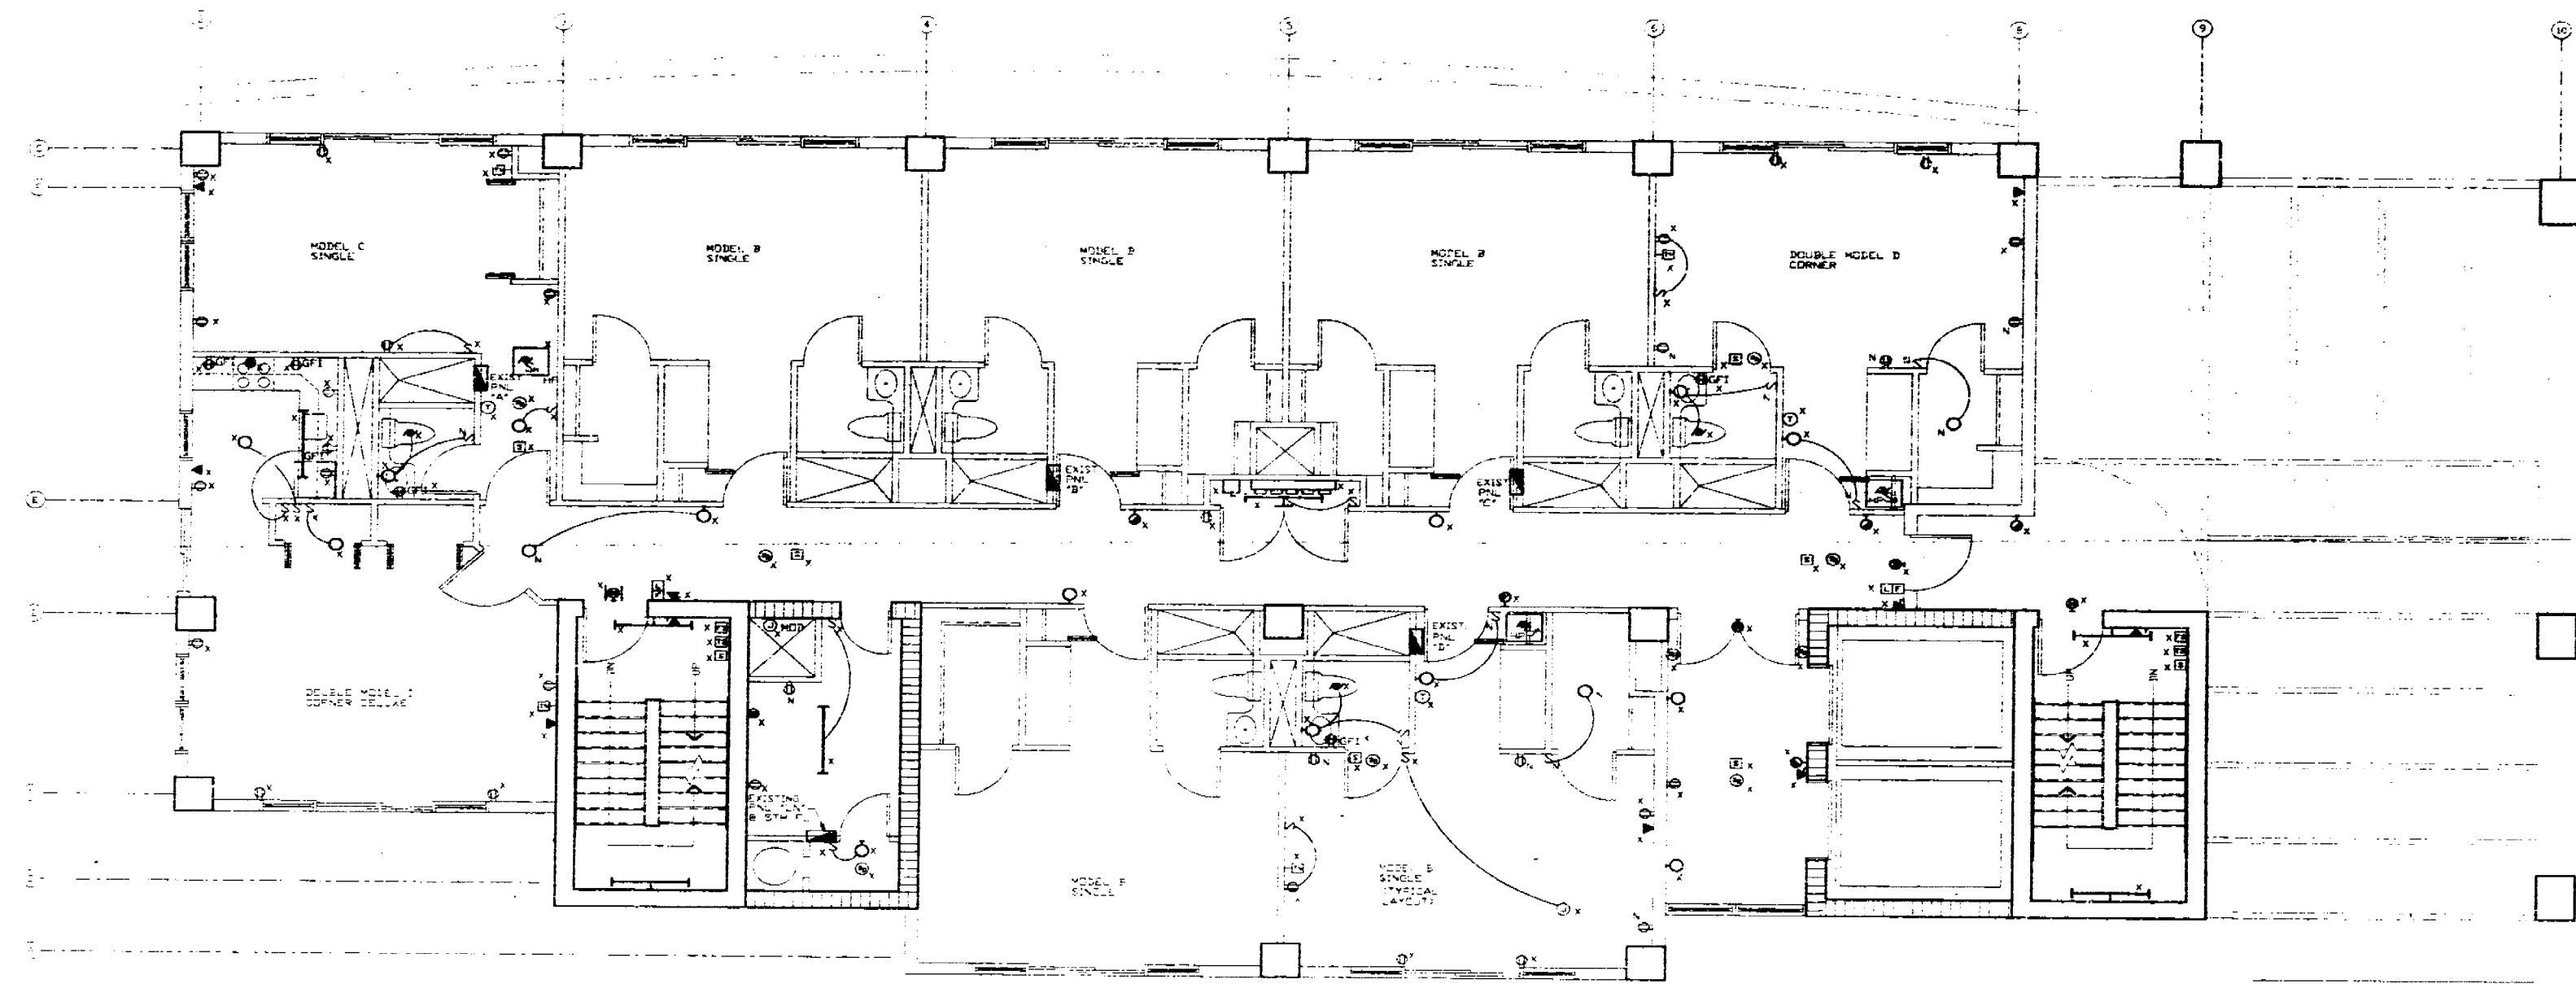

LEGEND
 X = EXISTING TO REMAIN CONNECTED TO
 Y = EXISTING TO EXISTING DAY

TYPICAL FLOOR - ELECTRICAL
 SCALE: 1/4" = 1'-0"

OFFICE COPY
 CITY OF MIAMI BEACH
 APPROVED FOR PERMIT BY
 THE FOLLOWING:

CITY OF MIAMI BEACH
 RECEIVED
 JAN 9 6 1994
 BUILDING DEPARTMENT


STEVEN MILLER, P.E., INC.
 CONSULTING ENGINEERS
 3000 N.W. 107th Ave., Suite 100
 Miami, FL 33177
 (305) 551-1100

CONSULTING ENGINEER
 STRUCTURAL: EDWARD SHROOF
 ELECTRICAL: STEVEN MILLER
 MECHANICAL: STEVEN MILLER
 CIVIL: STEVEN MILLER
 LANDSCAPING: WILLIAM DEWASA

ARCHITECT
 MOSHE COSCHER, ARCHITECT
 700 S.W. 11th Street
 MIAMI BEACH, FLORIDA 33140

PROJECT:
 6800 INDIAN CREEK REALTY
 6800 INDIAN CREEK DRIVE
 MIAMI BEACH, FLORIDA

SHEET 20

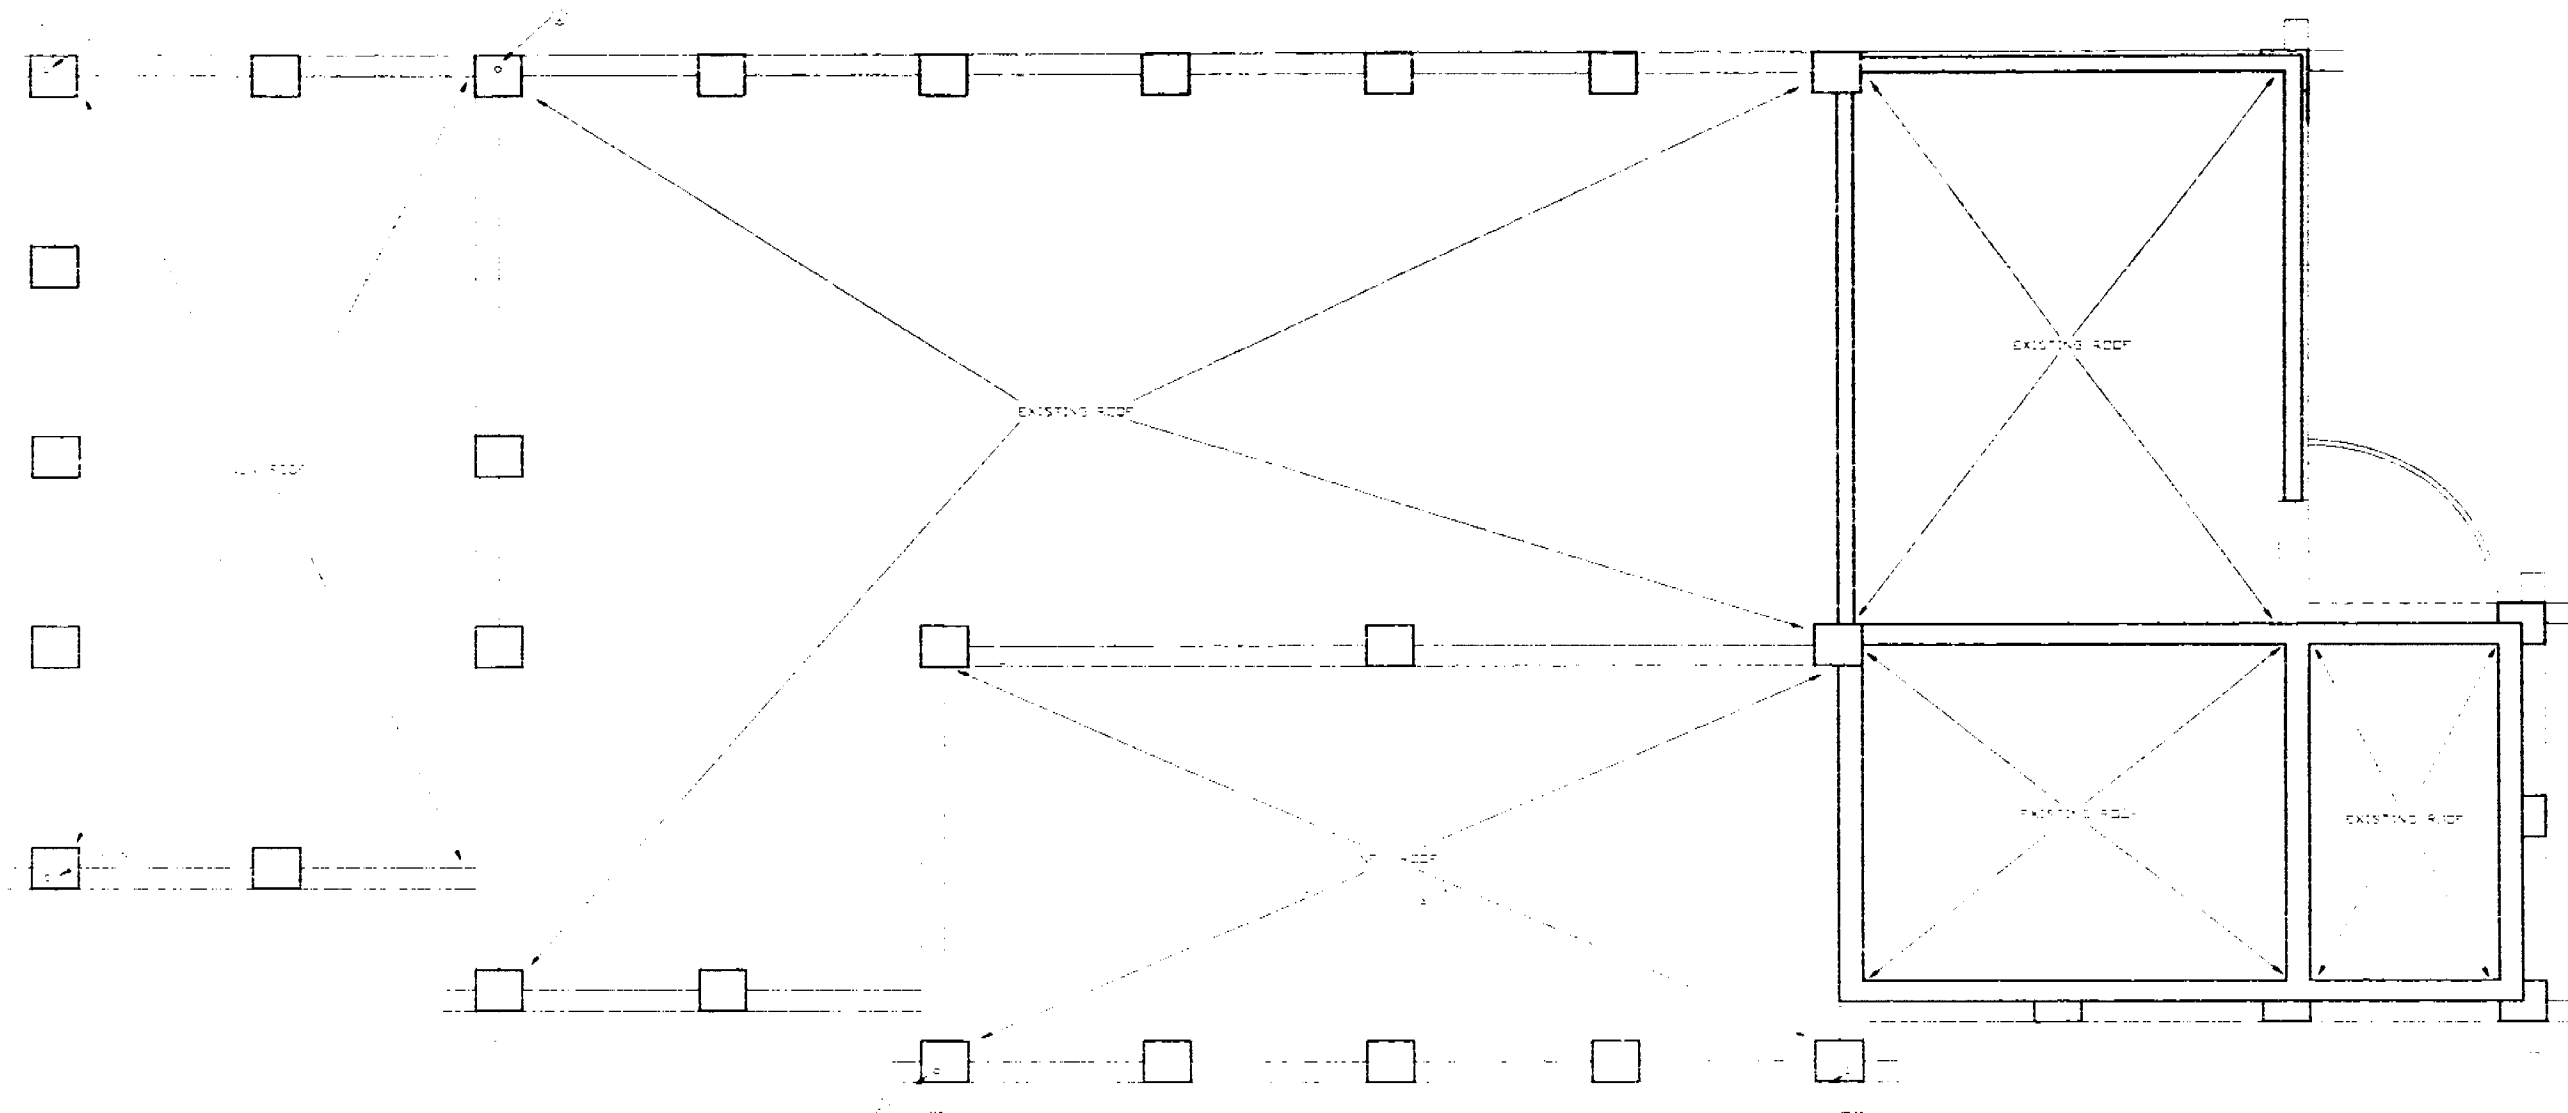

N
 ROOF LEVEL - ELECTRICAL
 SCALE: 1/4" = 1'


OFFICE COPY
 CITY OF MIAMI BEACH
 APPROVED FOR PERMIT BY
 THE FOLLOWING:
 ELECTRICAL
 MECHANICAL
 FIRE PREVENTION
 ENGINEERING

CITY OF MIAMI BEACH
 RECEIVED
 JAN 06 1983
 BUILDING DEPARTMENT

STEVEN FELDER, P.E.
 PROFESSIONAL ENGINEER
 STATE OF FLORIDA
 LICENSE NO. 10000

REVISIONS	
DATE	BY
PROJECT: 6800 N.W. CREEK BLVD 6800 N.W. CREEK DRIVE MIAMI BEACH, FLORIDA	
ARCHITECT: MOSHE COSCHER, ARCHITECT 700 51st STREET MIAMI BEACH, FLORIDA 33140	
CONSULTING ENGINEER:	FLORIDA
STRUCTURAL ENGINEER:	FLORIDA
ELECTRICAL ENGINEER:	FLORIDA
CIVIL ENGINEER:	FLORIDA
LANDSCAPING ENGINEER:	FLORIDA
MECHANICAL ENGINEER:	FLORIDA
FIRE PREVENTION ENGINEER:	FLORIDA

1. LATEST EDITION OF THE NATIONAL FIRE PROTECTION ASSOCIATION (NFPA) 720-1993, SECTION 10.1.1, SHALL BE USED FOR THE PURPOSES OF THIS SPECIFICATION.

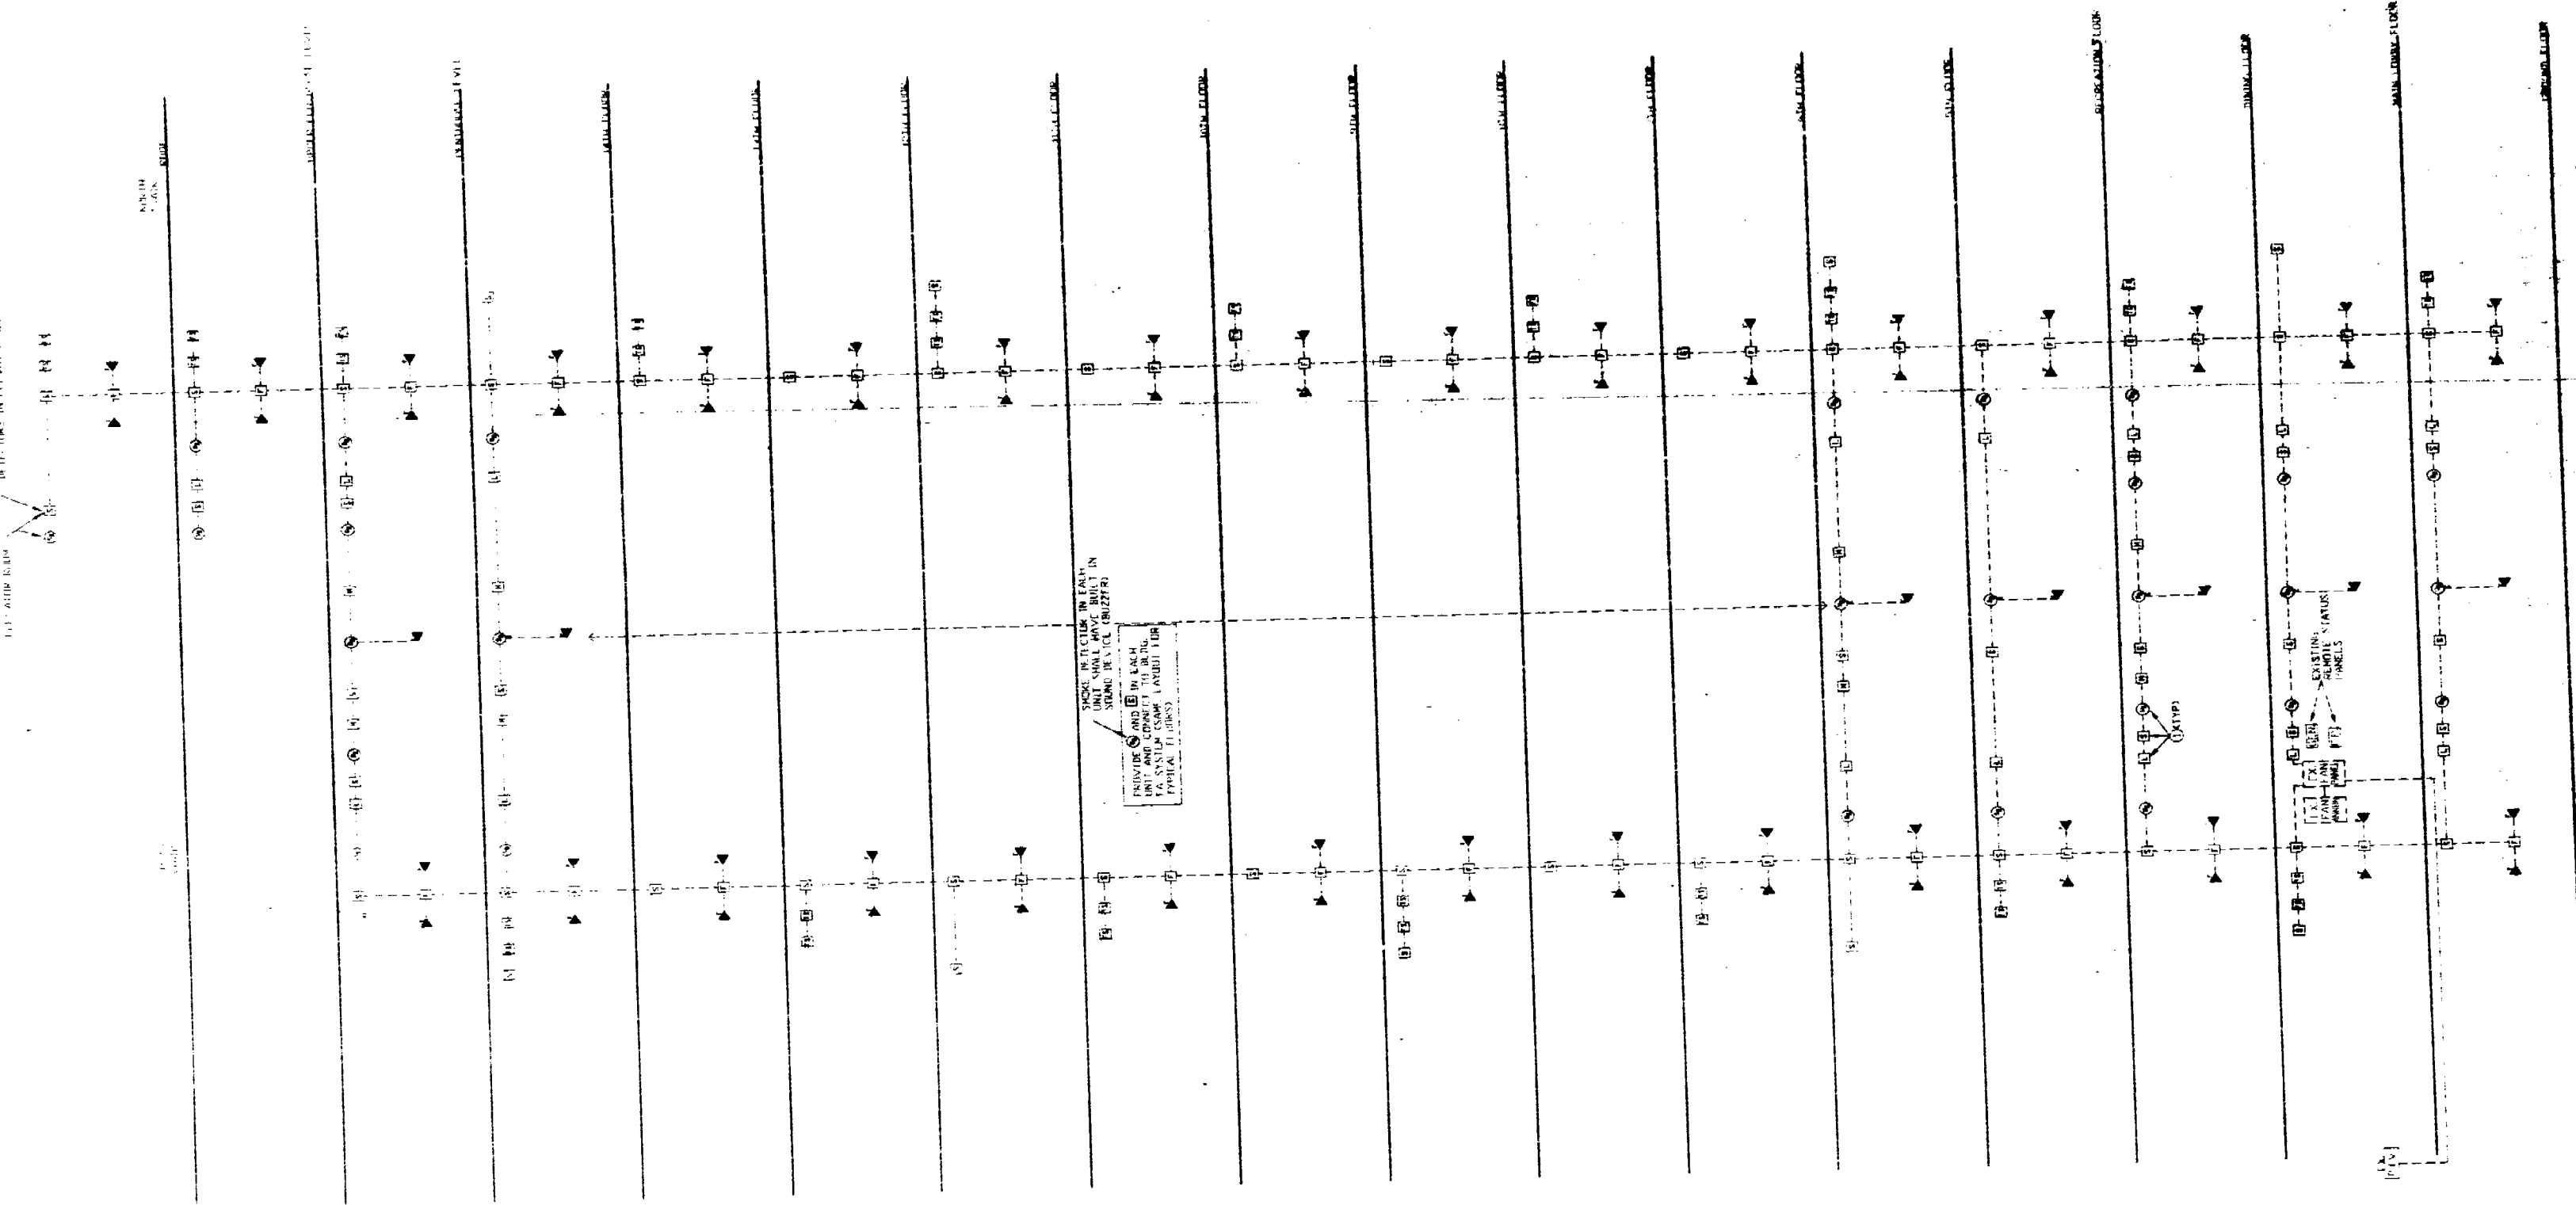

NOTES:
1. FOR EXACT LOCATION OF DEVICES, REFER TO THE PROJECT'S SITE PLAN AND ELEVATION DRAWINGS.
2. ALL DEVICES SHALL BE INSTALLED IN ACCORDANCE WITH THE NFPA 720-1993, SECTION 10.1.1.
3. THE FIRE ALARM SYSTEM SHALL BE DESIGNED TO PROVIDE A SILENT ALARM TO THE FIRE DEPARTMENT.
4. THE FIRE ALARM SYSTEM SHALL BE DESIGNED TO PROVIDE A SILENT ALARM TO THE FIRE DEPARTMENT.

FIRE ALARM RISER DIAGRAM

OFFICE COPY
CITY OF MIAMI BEACH
APPROVED FOR PERMIT BY:
THE FOLLOWING:
BUILDING DEPARTMENT
FIRE DEPARTMENT
ELECTRICITY DEPARTMENT
PLUMBING DEPARTMENT
MECHANICAL DEPARTMENT
LANDSCAPING DEPARTMENT
ENGINEERING DEPARTMENT


CITY OF MIAMI BEACH
RECEIVED
JAN 16 1993
BUILDING DEPARTMENT

STEVEN PELLER, P.E., INC.
CONSULTING ENGINEER
1111 N. MIAMI AVE., SUITE 100
MIAMI, FL 33136
TEL: 305-371-1111
FAX: 305-371-1112

REVISIONS	
DATE	ITEM

PROJECT:	6800 INDIAN CREEK REalty
6800 INDIAN CREEK DRIVE	MIAMI BEACH, FLORIDA
ARCHITECT:	MOSE COSCHER, ARCHITECT
700 51st STREET	MIAMI BEACH, FLORIDA 33140
CONTRACT NO.	2296
DESIGNER:	STEVEN PELLER, P.E.
ELECTRICAL:	STEVEN PELLER, P.E.
CIVIL:	STEVEN PELLER, P.E.
MECHANICAL:	STEVEN PELLER, P.E.
LANDSCAPING:	STEVEN PELLER, P.E.
ENGINEERING:	STEVEN PELLER, P.E.

1111 N. MIAMI AVE., SUITE 100
MIAMI, FL 33136
TEL: 305-371-1111
FAX: 305-371-1112

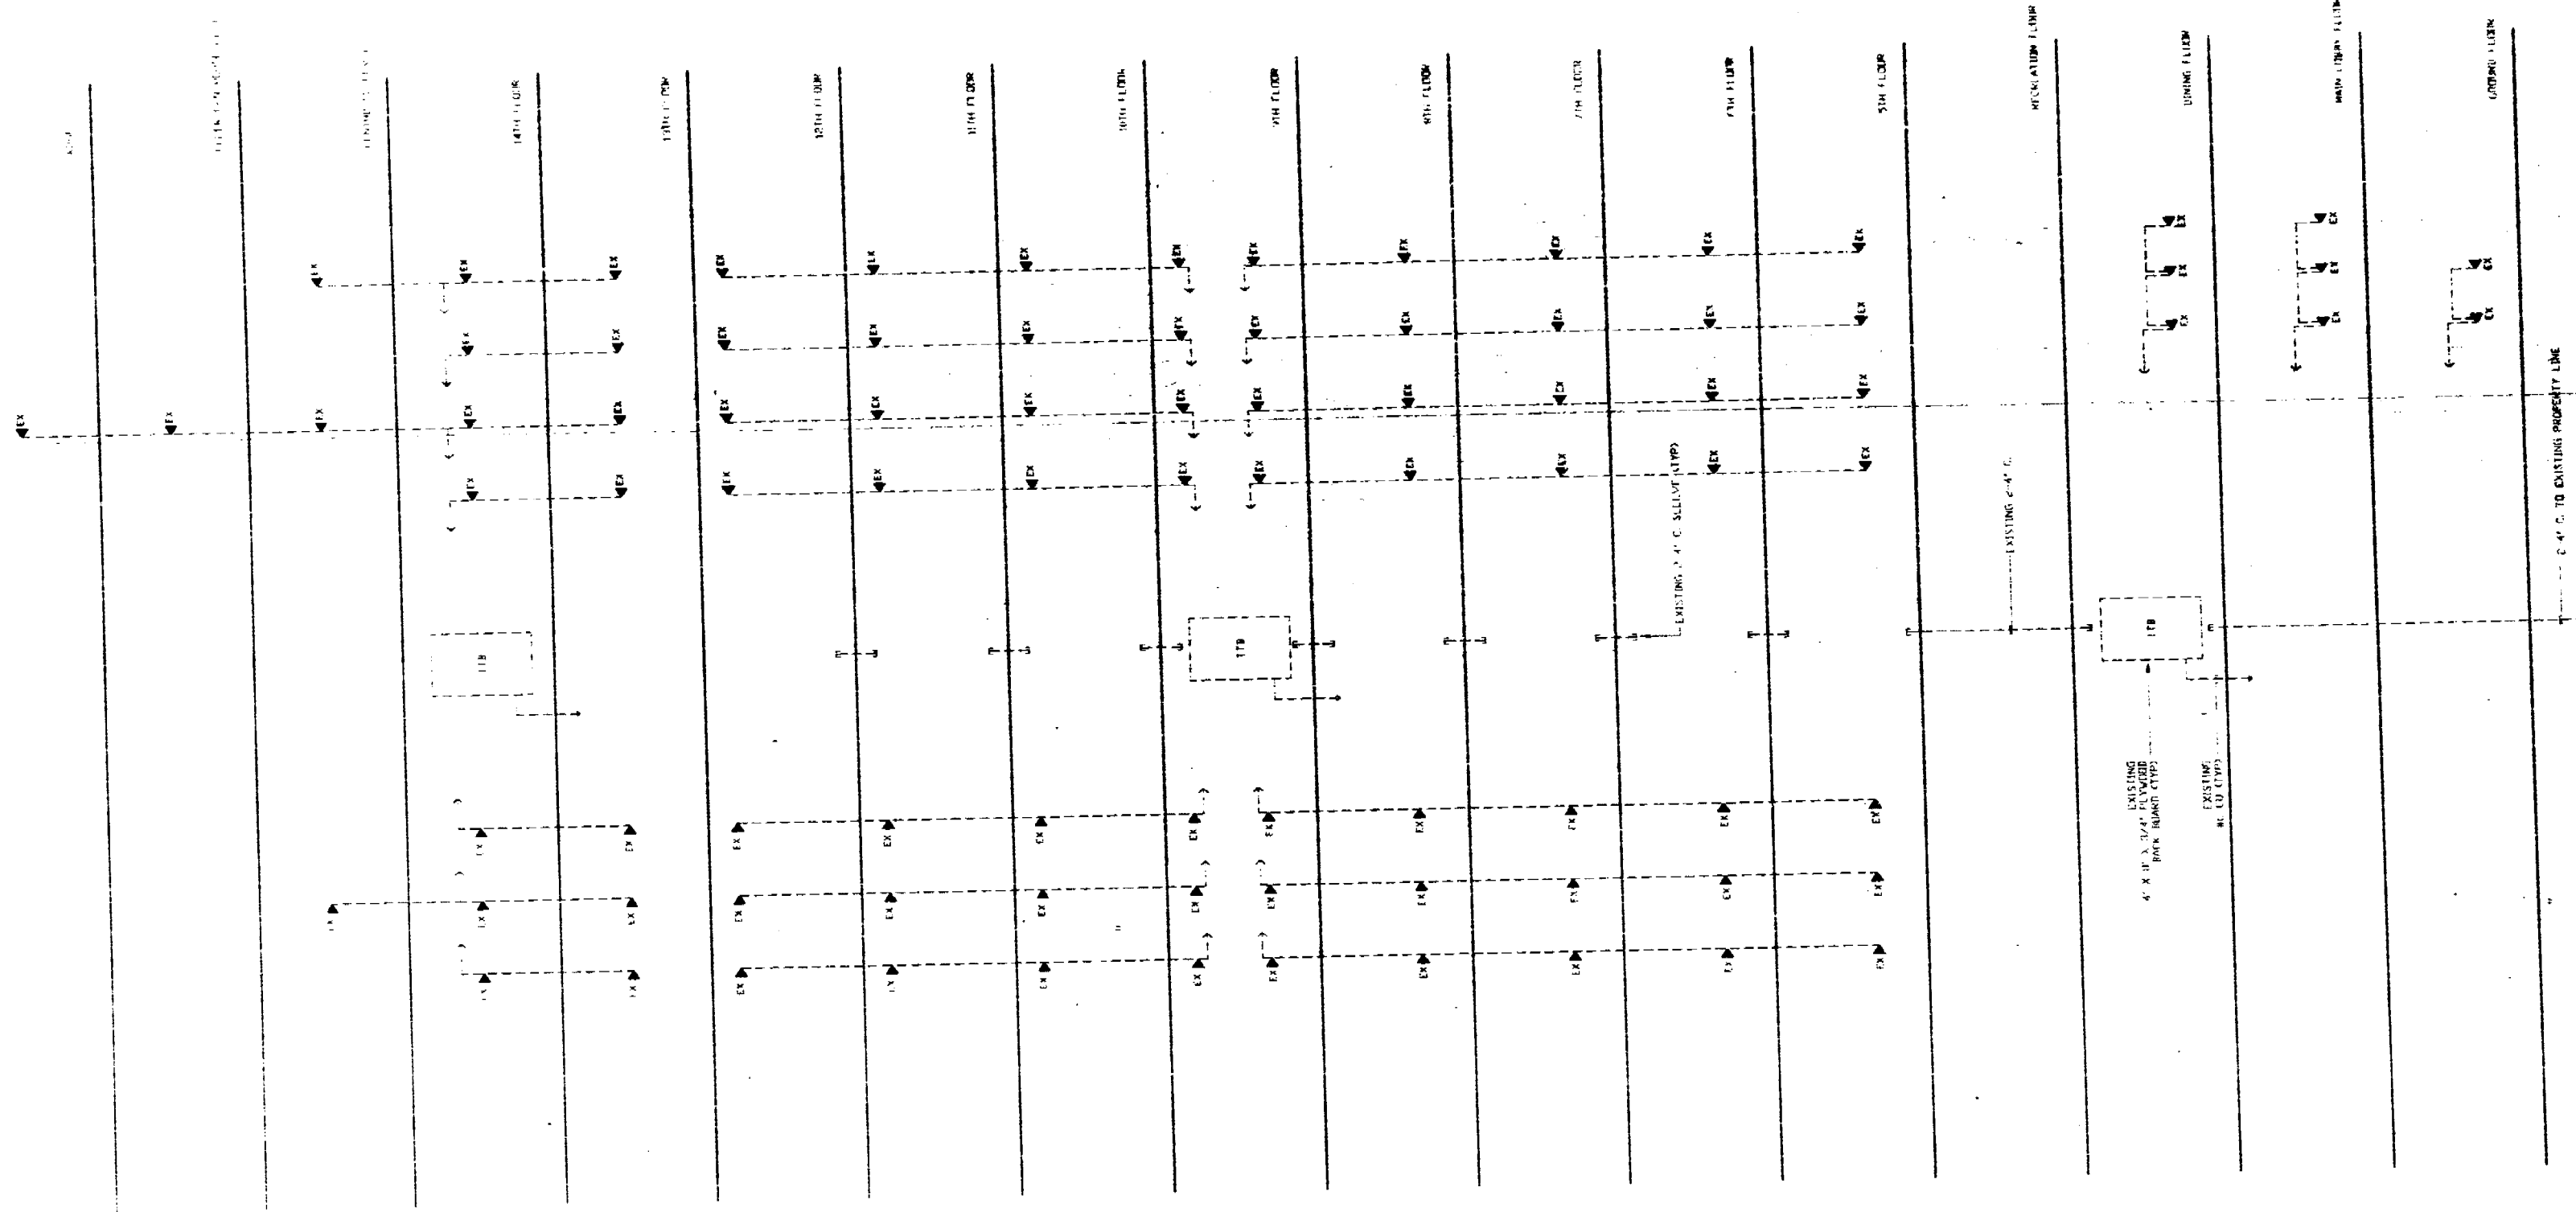

NOTES:
1. RISES TO BE PROVIDED IN CONFORMANCE WITH THE TELEPHONE COMPANY'S REQUIREMENTS.

LEGEND:
R. = RISE
C. = CROSS-OVER
X. = EXISTING RISER

TELEPHONE RISER DIAGRAM

OFFICE COPY


CITY OF MIAMI BEACH
APPROVED FOR PERMIT BY
THE FOLLOWING:

RECEIVED
CITY OF MIAMI BEACH
JAN 06 1993
ENGINEERING DEPARTMENT

STEVEN FELIX, P.E.
CONSULTING ENGINEER
REGISTERED PROFESSIONAL ENGINEER
NO. 12345
STATE OF FLORIDA

REVISIONS	
DATE	ITEM

PROJECT:	6000 INDIAN CREEK REALTY 6000 INDIAN CREEK DRIVE MIAMI BEACH, FLORIDA
ARCHITECT:	WISSE COSCHER, ARCHITECT 700 5th STREET MIAMI BEACH, FLORIDA 33140
DESIGNER:	D. B. JONES
STRUCTURAL:	STEVEN FELIX, P.E.
ELECTRICAL:	STEVEN FELIX, P.E.
MECHANICAL:	STEVEN FELIX, P.E.
LANDSCAPE:	WILLIAM CLARKSON
PAINTING:	JOHN B. JONES

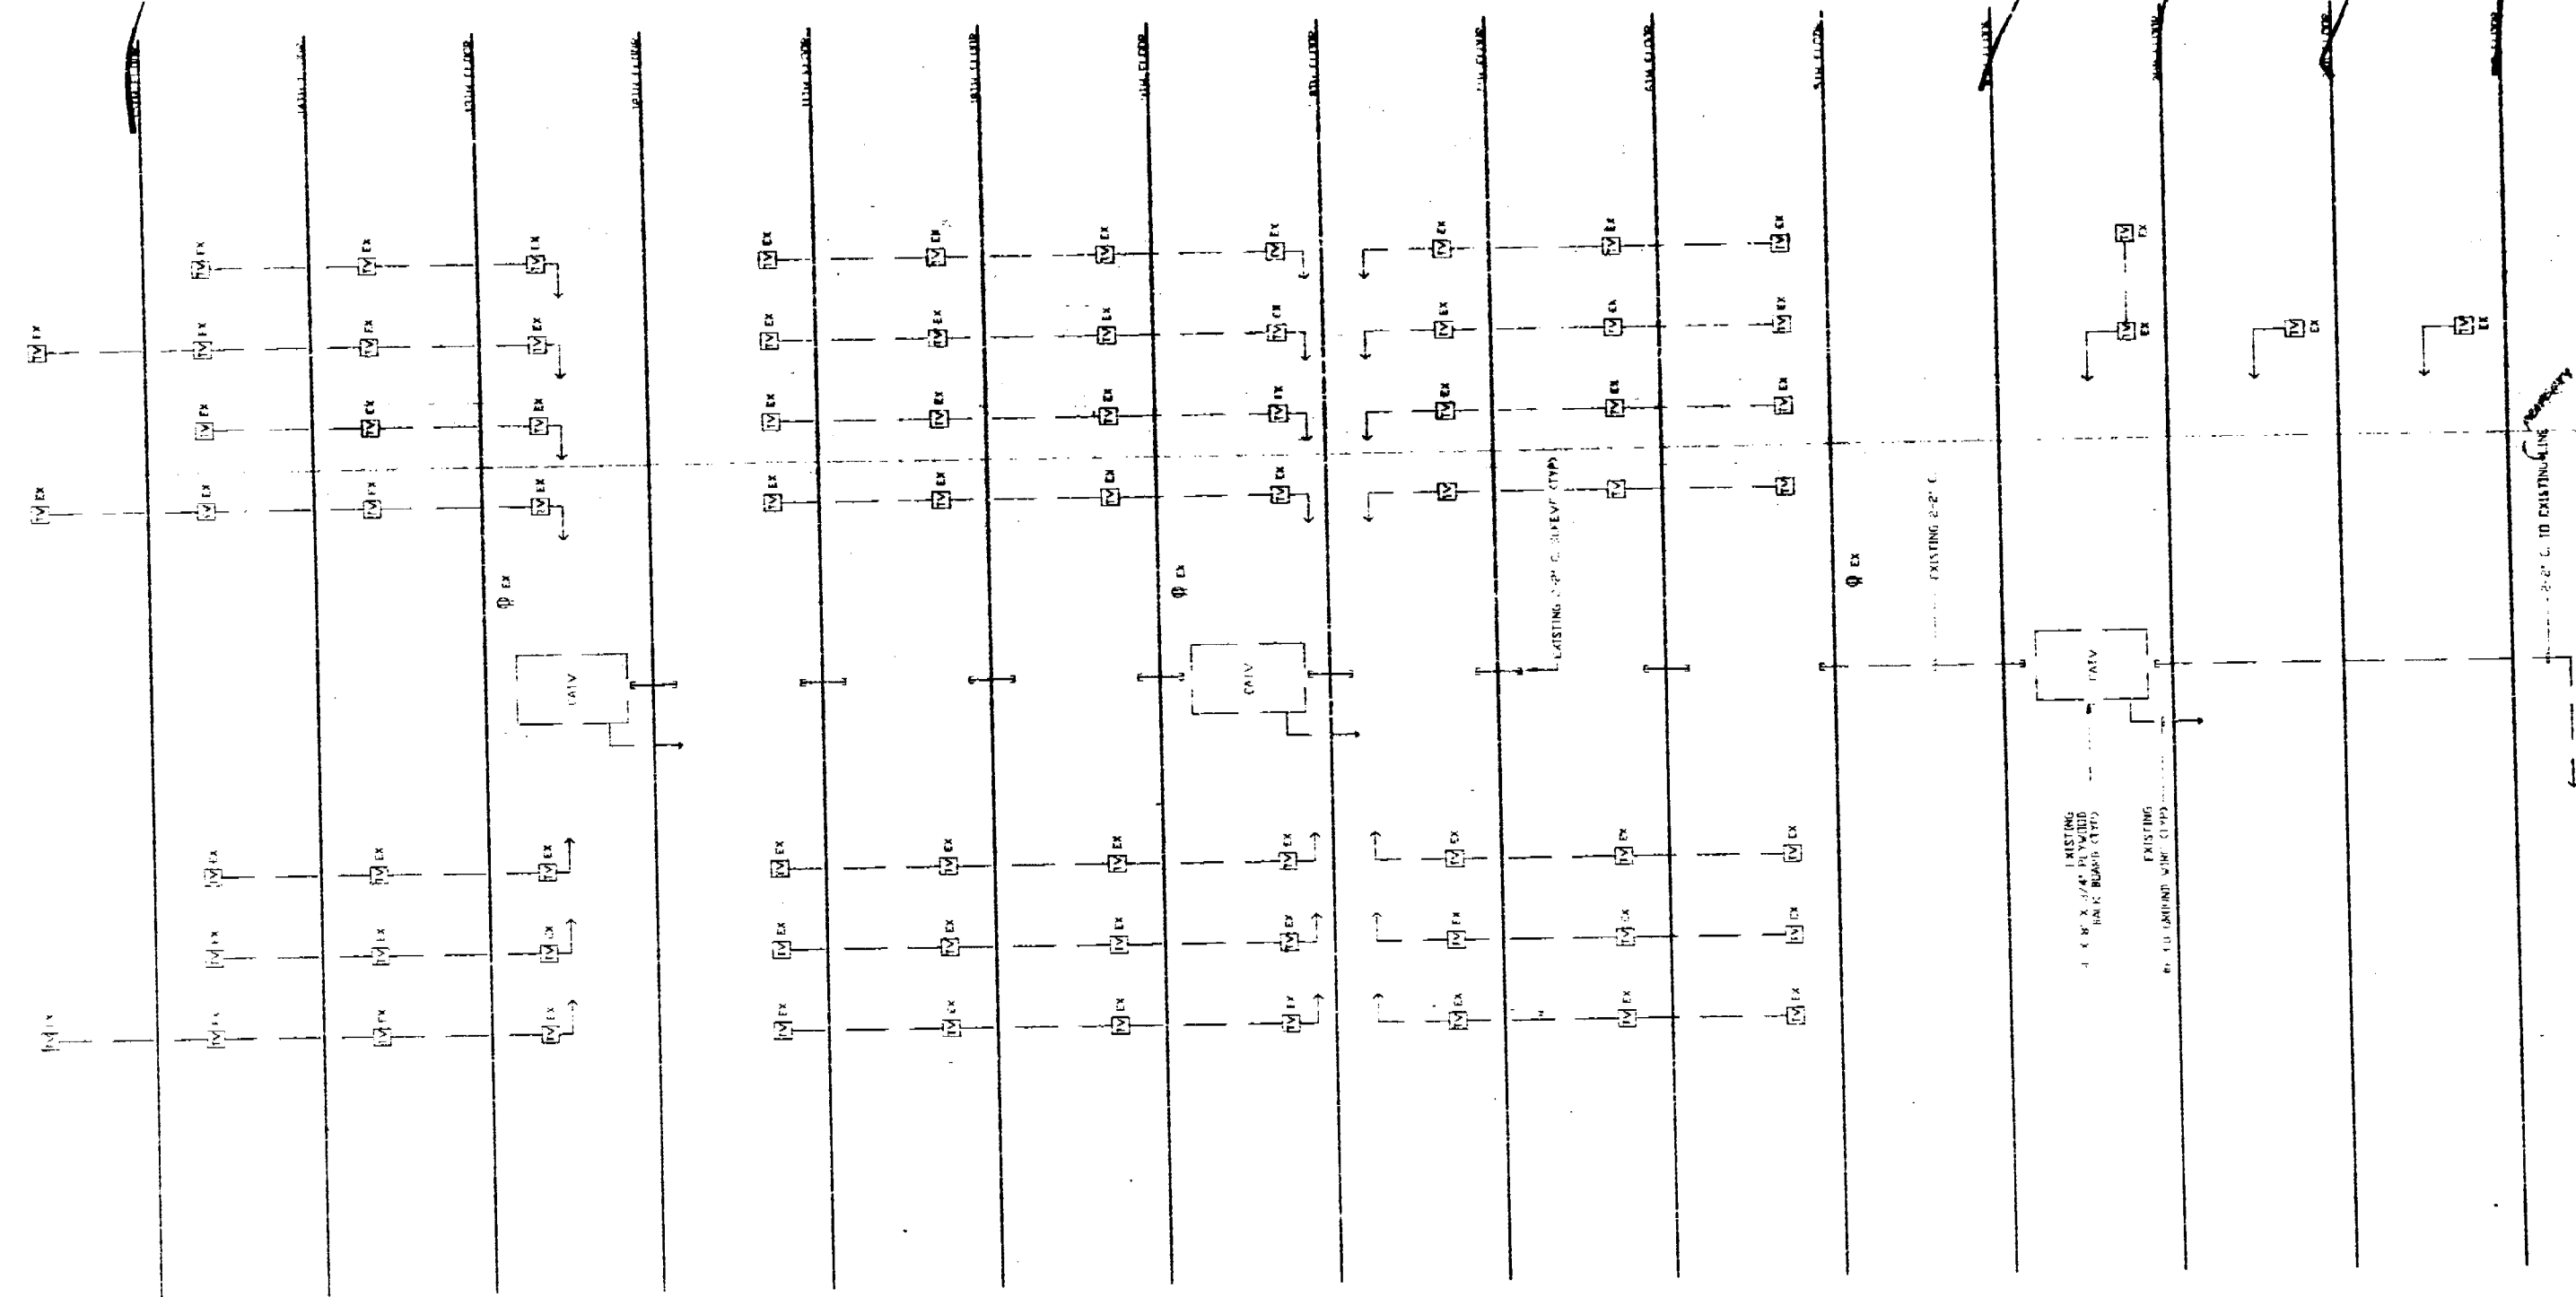

CATV RISER DIAGRAM

LEGEND:
 EX - EXISTING
 N - NEW
 --- - EXISTING FLOOR


NOTES:
 1. CONTRACTOR SHALL COORDINATE WITH THE BUILDING OWNER FOR THE LOCATION OF THE RISER SYSTEM.
 2. THE RISER SYSTEM SHALL BE INSTALLED IN THE BUILDING.
 3. THE RISER SYSTEM SHALL BE INSTALLED IN THE BUILDING.
 4. THE RISER SYSTEM SHALL BE INSTALLED IN THE BUILDING.

OFFICE COPY
 CITY OF MIAMI BEACH
 APPROVED FOR PERMIT BY
 THE FOLLOWING:

RECEIVED
 JAN 6 6 1993
 BUILDING DEPARTMENT

REVISIONS	
DATE	ITEM

PROJECT:	6000 MIAMI CREEK REALTY 6000 MIAMI CREEK DRIVE MIAMI BEACH, FLORIDA
ARCHITECT:	MOSHE COOKER, ARCHITECT 700 S.W. 1ST STREET MIAMI BEACH, FLORIDA 33140
DATE:	01/01/2004
DESIGNER:	STRUCTURAL: JEROME SWINARDE ELECT/MECH: JEROME SWINARDE CIVIL: JEROME SWINARDE LANDSCAPE: JEROME SWINARDE NAME: JEROME SWINARDE

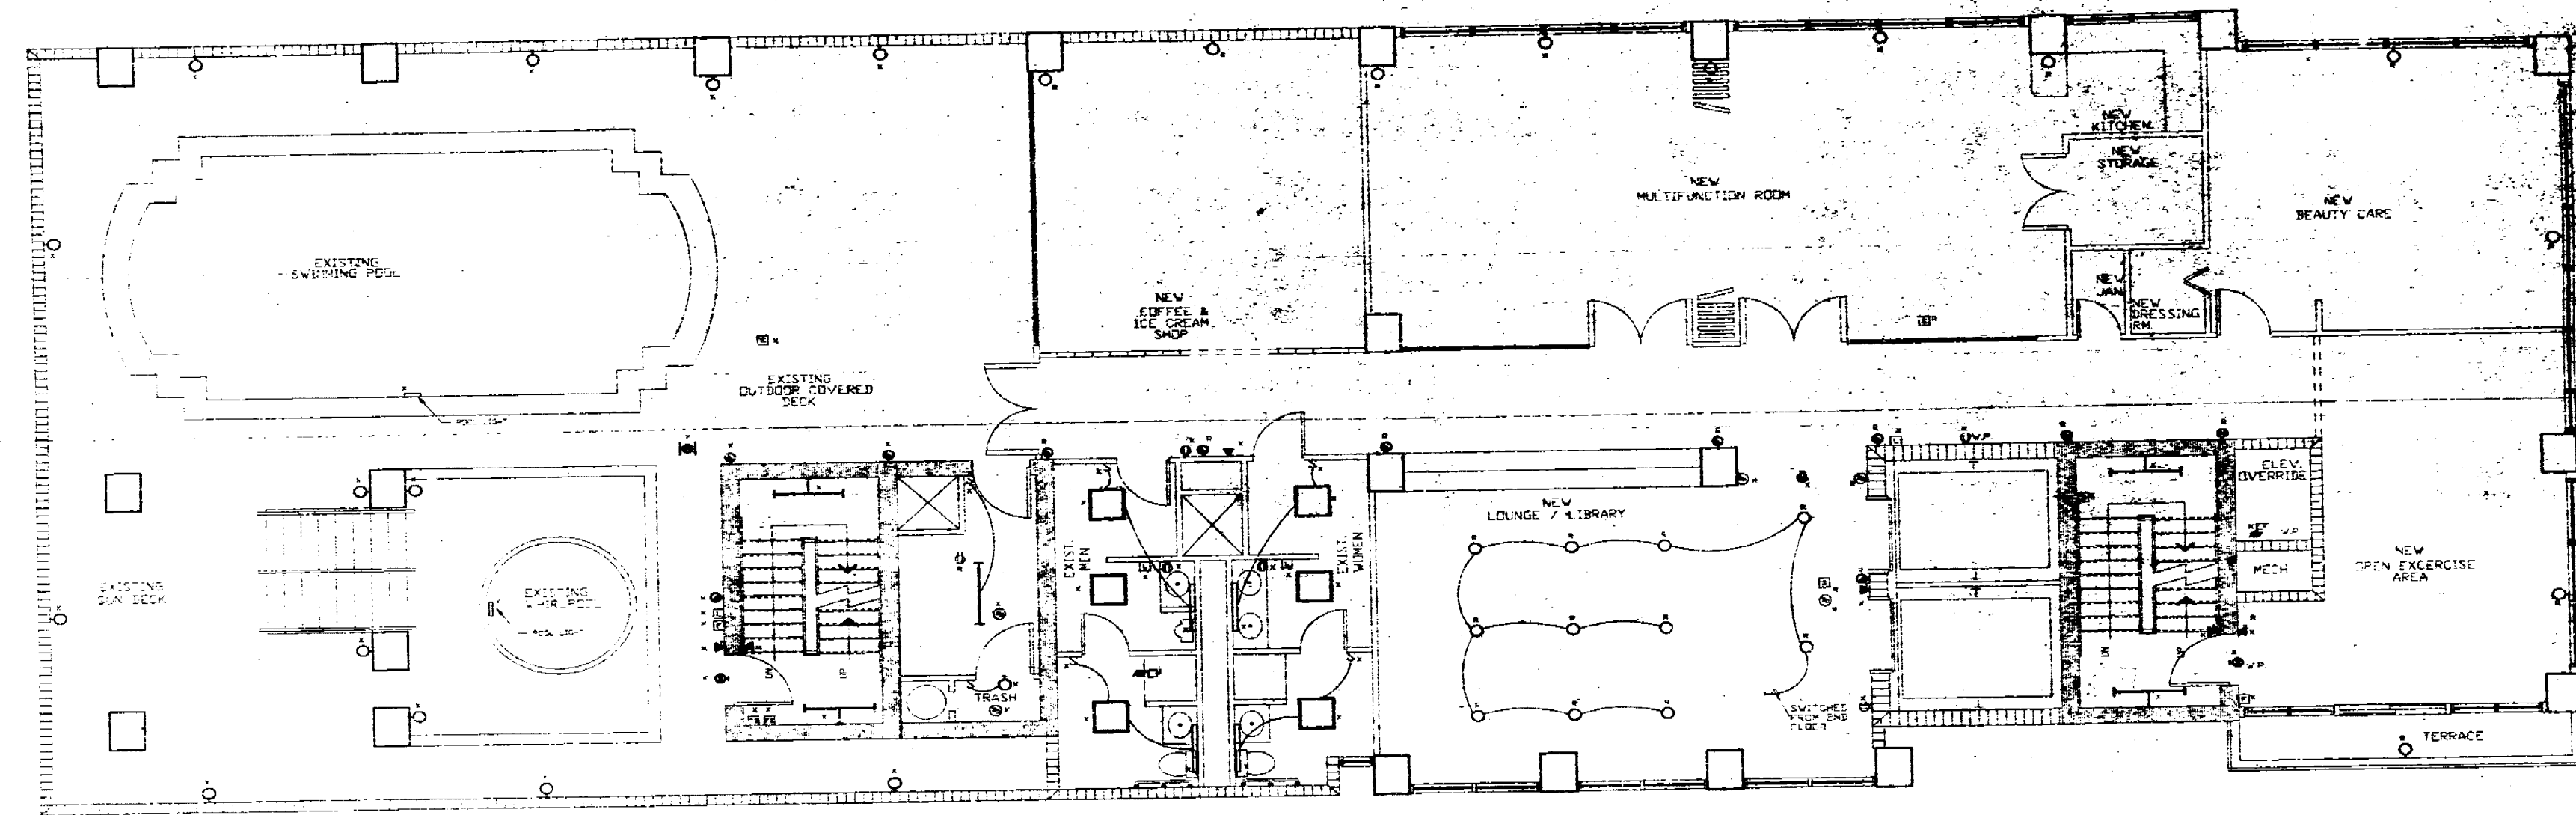

RECREATIONAL LEVEL - ELECTRICAL DEMOLITION PLAN POOL / MULTIFUNCTION SCALE: 1/4" = 1'-0"

OFFICE COPY
CITY OF MIAMI BEACH
APPROVED FOR PERMIT BY
THE FOLLOWING:

BUILDING
ZONING
PLUMBING
ELECTRICAL
MECHANICAL
FIRE PREVENTION
ENGINEERING

CITY OF MIAMI BEACH
RECEIVED
JAN 06 1993

DE 4
of
22


REVISIONS

DATE	REV

PROJECT:
6800 INDIAN CREEK BLVD
6800 INDIAN CREEK DRIVE
MIAMI BEACH, FLORIDA

ARCHITECT
MOSE COSCHER, ARCHITECT
700 5th STREET
MIAMI BEACH, FLORIDA 33140

CONTRACT NO.
STRUCTURAL
ELECTRICAL
MECHANICAL
FIRE PREVENTION
ENGINEERING

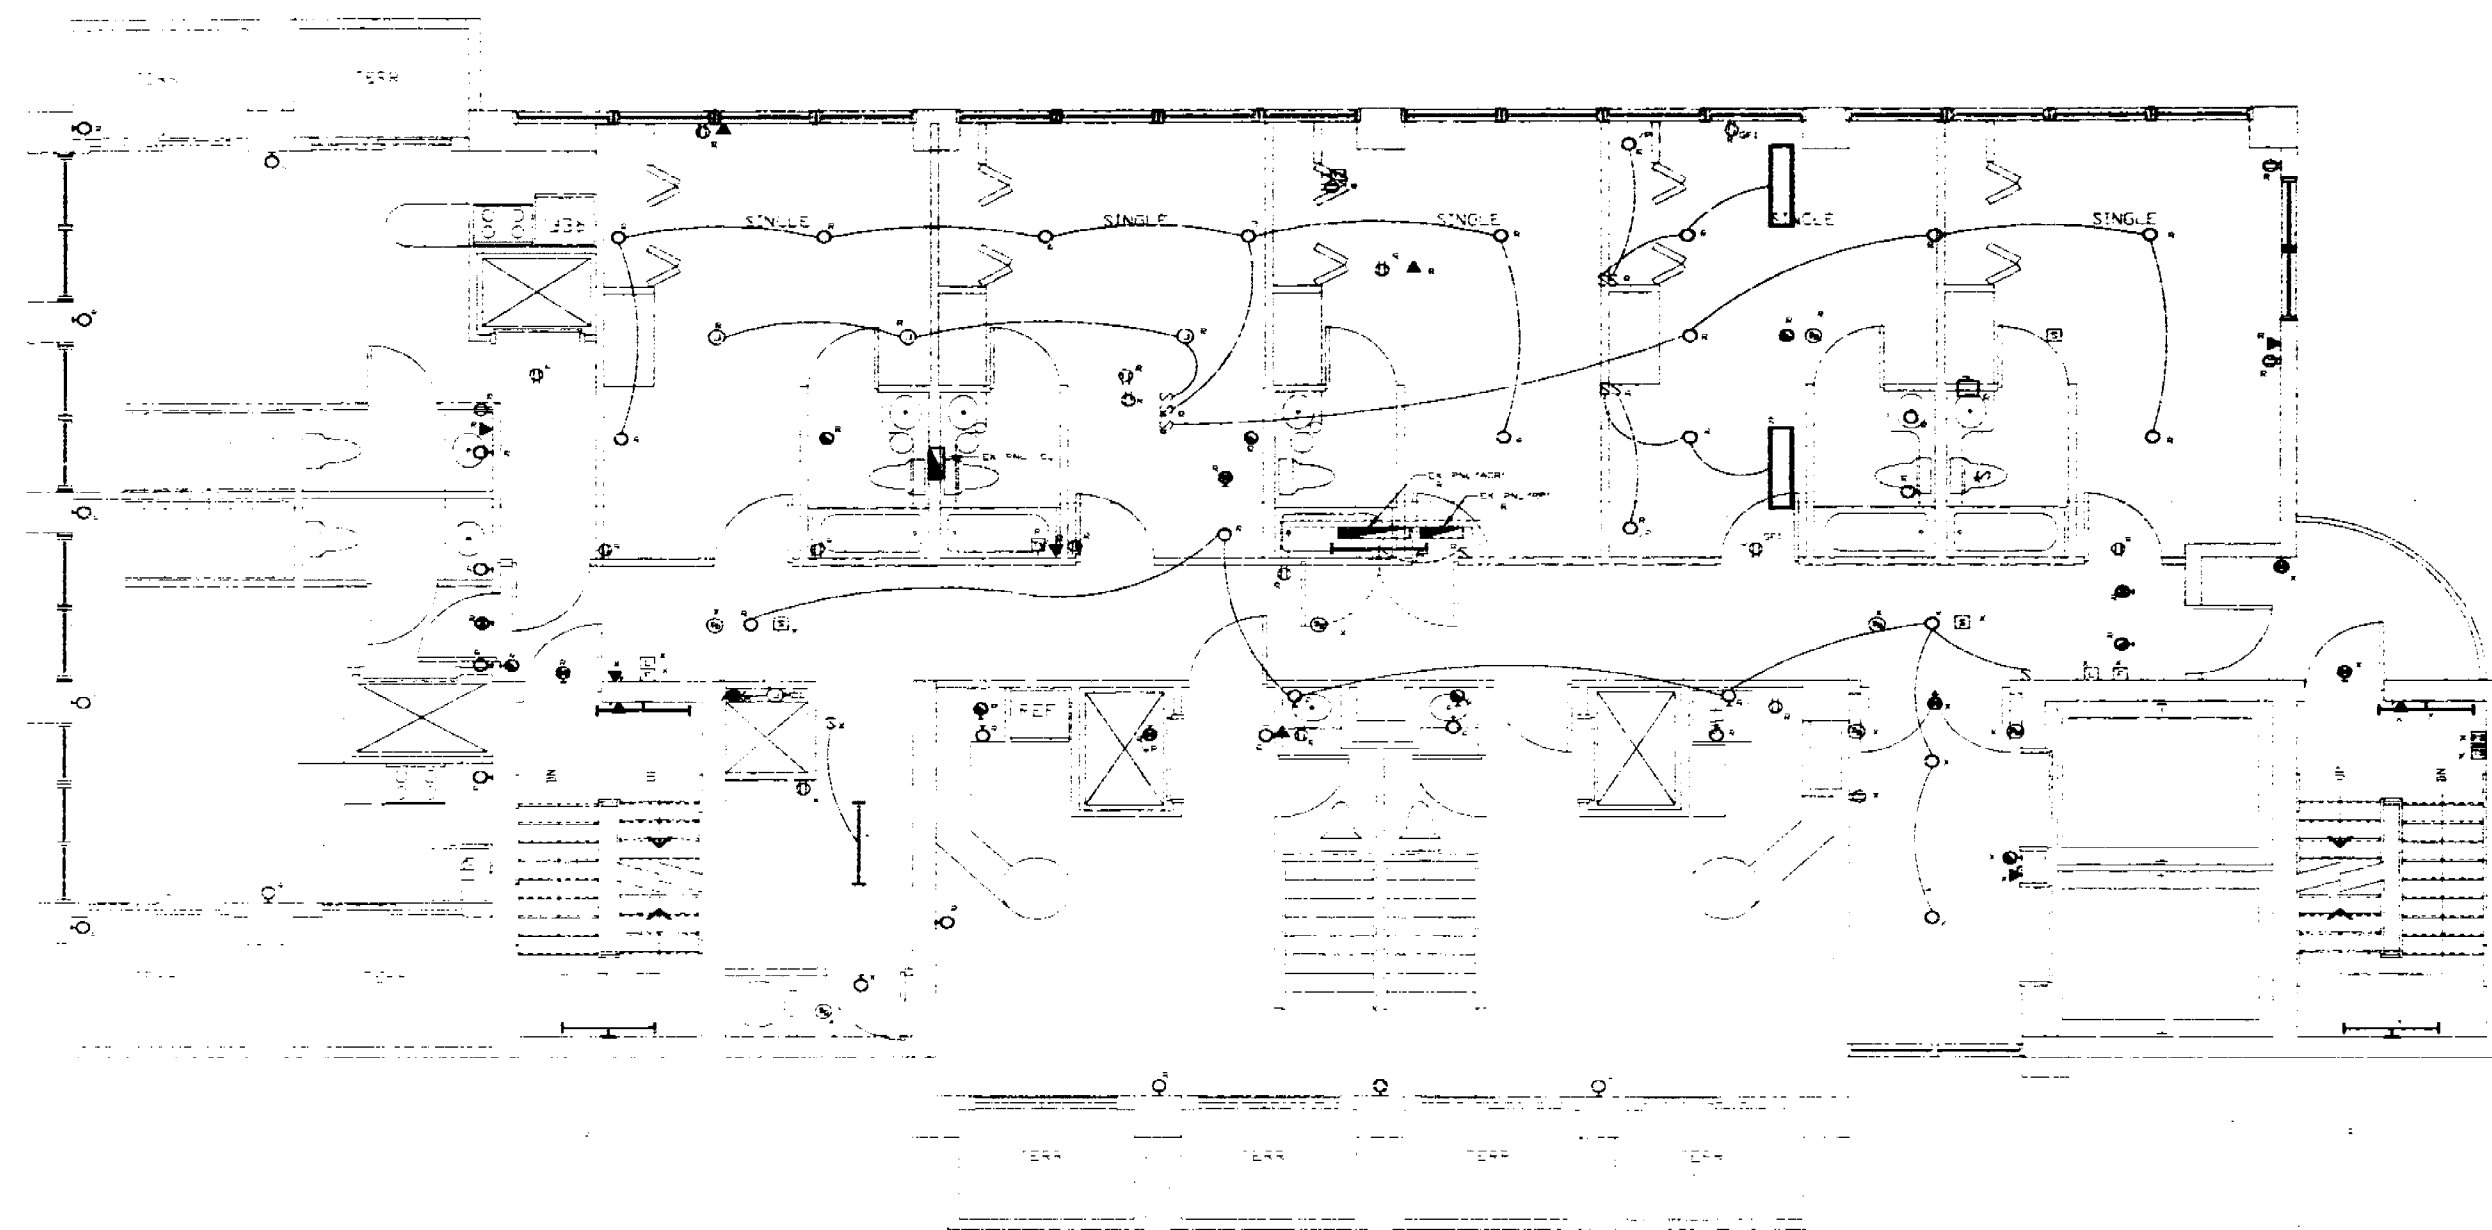


LOWER PENTHOUSE LEVEL - ELECTRICAL DEMOLITION PLAN
 SCALE: 1/4" = 1'

OFFICE COPY
 CITY OF MIAMI BEACH
 APP. 0713 FOR PERMIT BY
 THE FOLLOWING:

CITY OF MIAMI BEACH
 RECEIVED
 JAN 06 1993
 BUILDING DEPARTMENT

STEVEN KELLER, P.E., INC.
 1111 S.W. 15TH AVENUE
 MIAMI, FL 33135

REVISIONS	
DATE	BY
PROJECT: 6880 INDIAN CREEK REALTY 6880 INDIAN CREEK DRIVE MIAMI BEACH, FLORIDA	
ARCHITECT: MOSE COSCHER, ARCHITECT 700 51st STREET MIAMI BEACH, FLORIDA 33140	
DESIGNED BY: STEVEN KELLER, P.E.	CHECKED BY: STEVEN KELLER, P.E.
DRAWN BY: STEVEN KELLER, P.E.	IN CHARGE: STEVEN KELLER, P.E.
DATE: 01/05/93	SCALE: 1/4" = 1'

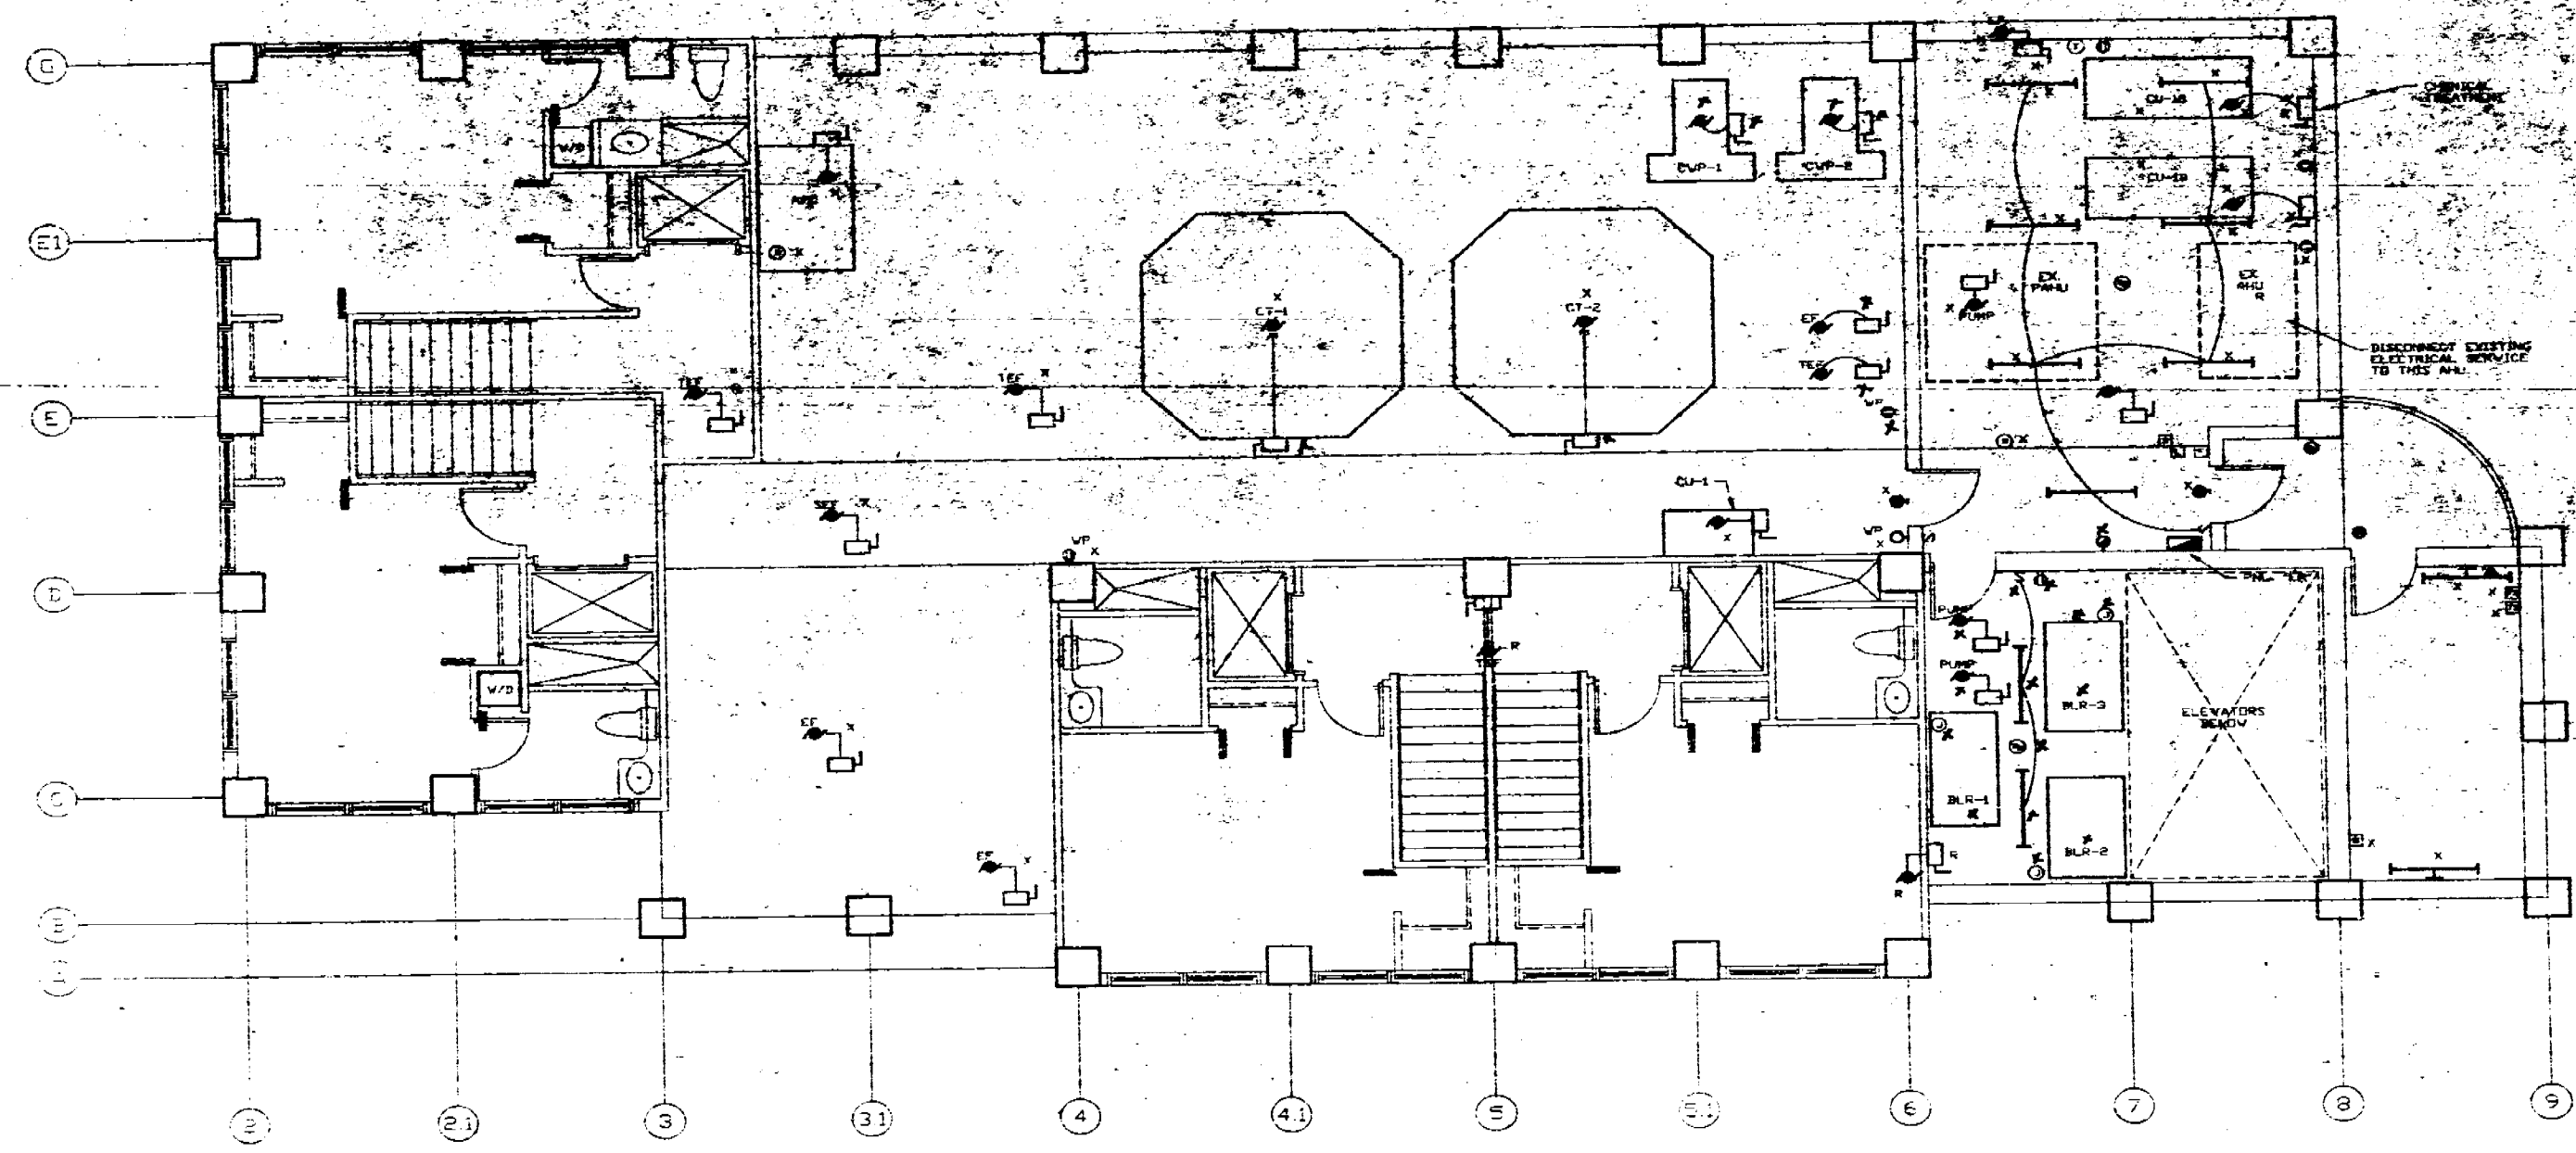

UPPER LEVEL - DEMOLITION ELECTRICAL PLAN
 PENTHOUSE FLOOR SCALE: 1/4" = 1'

OFFICE COPY
 CITY OF MIAMI BEACH
 APPROVED FOR PERMIT BY
 THE FOLLOWING:

CITY OF MIAMI BEACH
 RECEIVED
 JAN 06 1993
 PERMITTING DEPARTMENT

REVISIONS	
DATE	ITEM

PROJECT: 700 5th STREET
 SHEET: 34
 DATE: 1/1/93
 DRAWN BY: [Signature]
 CHECKED BY: [Signature]
 DESIGNED BY: [Signature]
 IN CHARGE: [Signature]

