


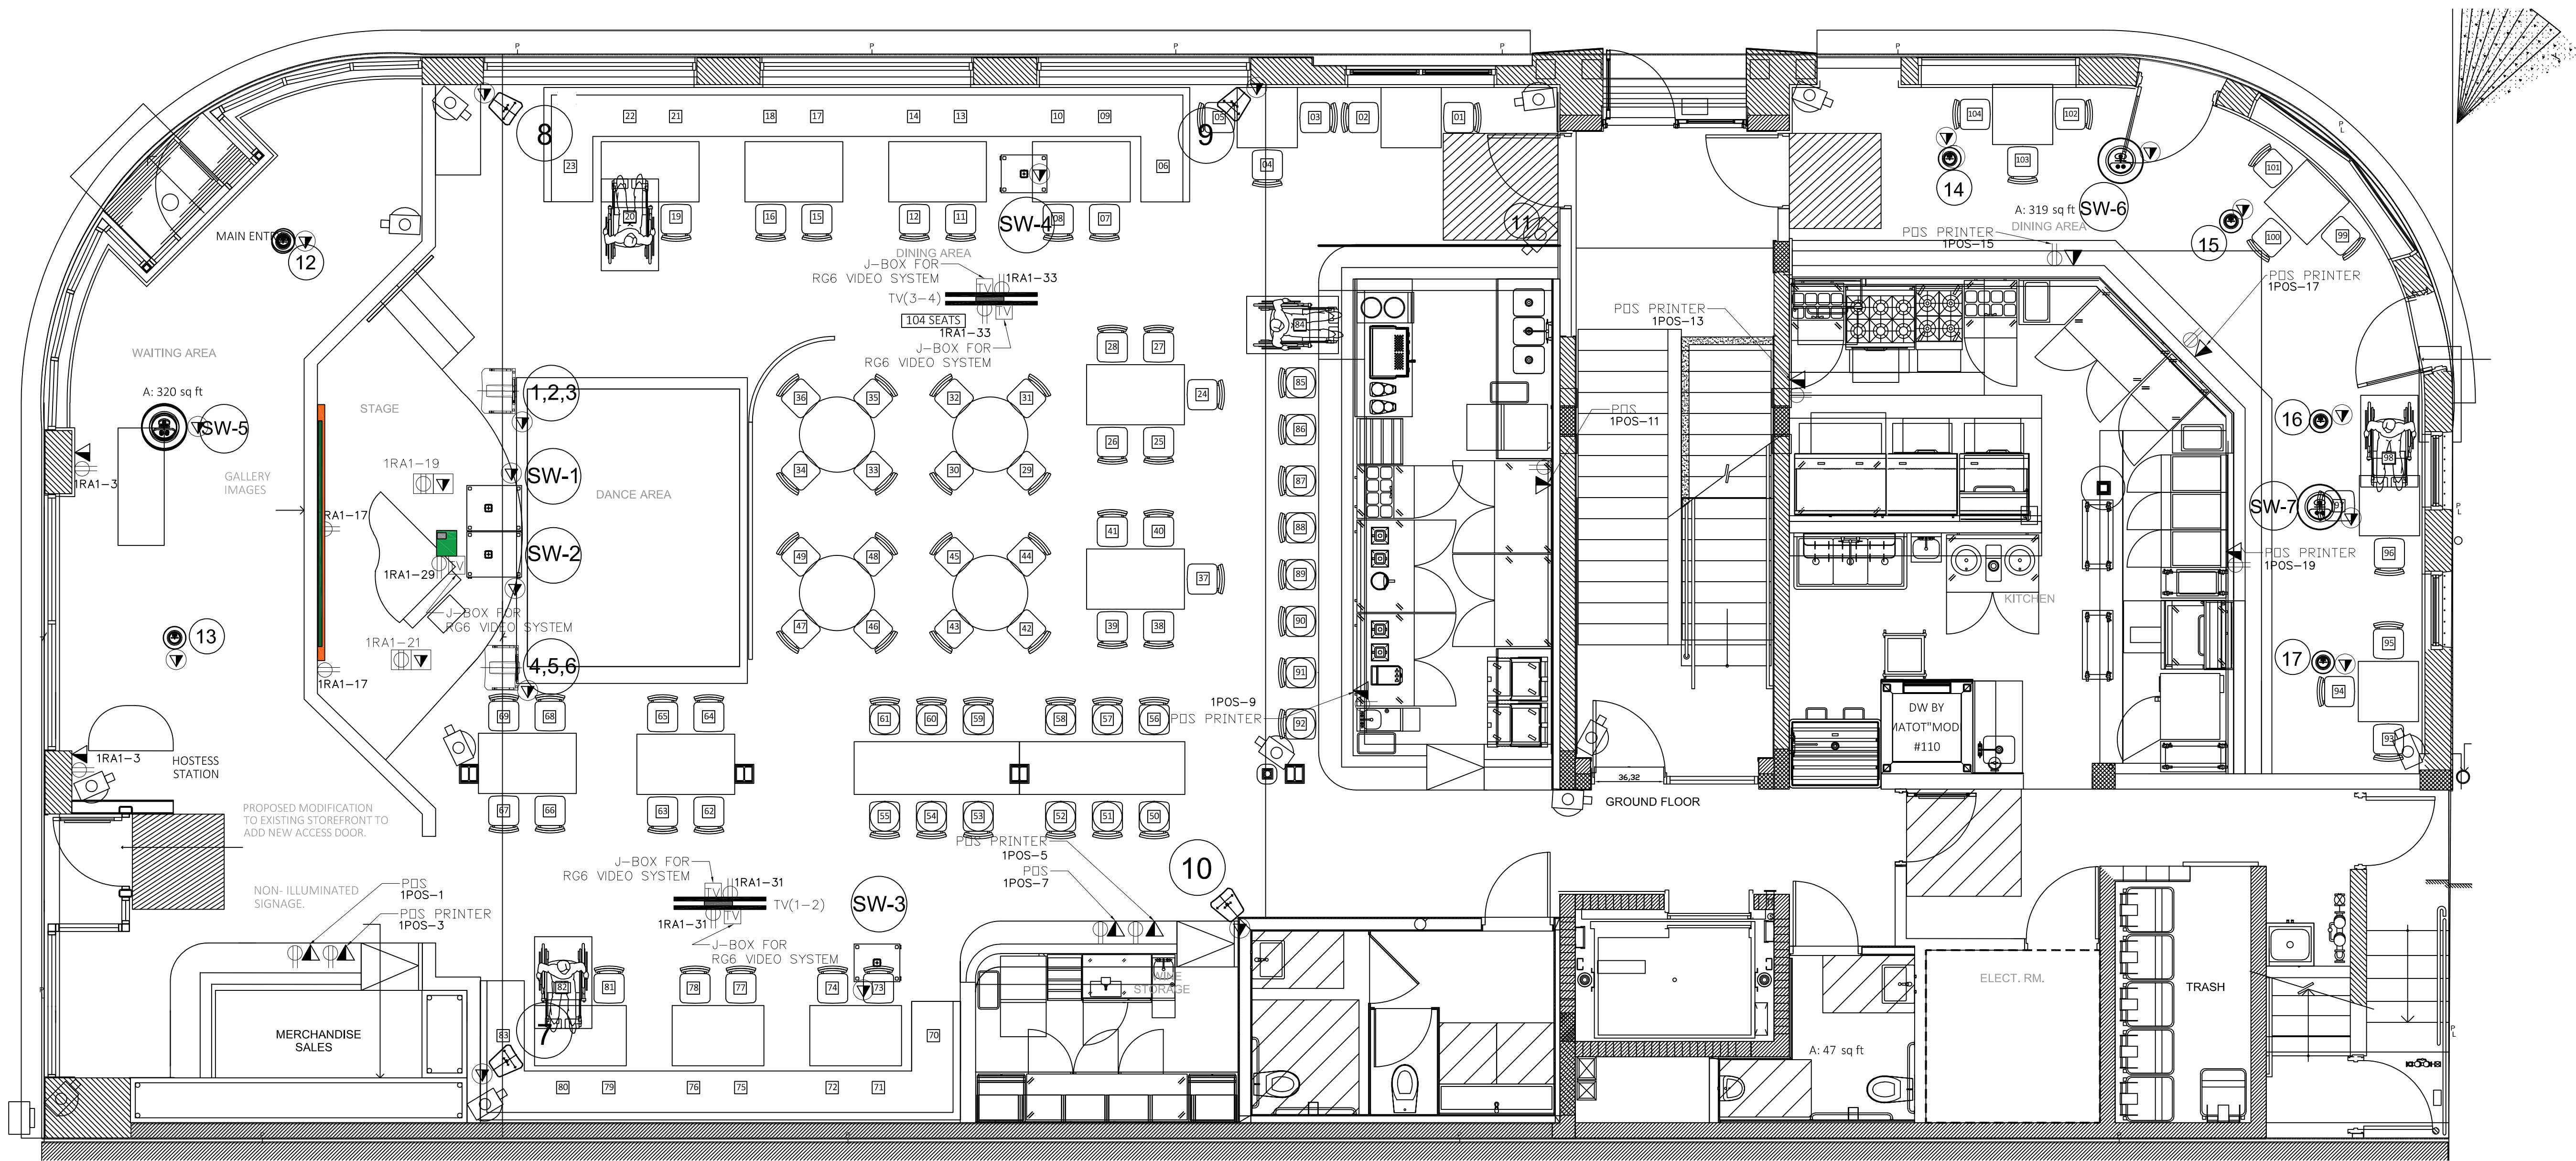

E VIDEO & SOUND AND POS / PRINTERS (WALL AND CEILING MOUNTED) GROUND FLOOR PLAN
SCALE: 1/4" = 1'-0"

NOTES:
SEE SOUND / SPEAKERS REQUIREMENTS NOTE AT SOUND/SPEAKERS DRAWINGS.

SECURITY SYSTEM SYMBOLS	
SYMBOLS	
	CCTV
	DATA
	ELECTRICAL RECEPTACLE (normal 110V)
	ELECTRICAL RECEPTACLE DEDICATE
	CHAUVET Rogue rfx-40
	CHAUVET Intimidator spot 360

SPEAKER SYSTEM SYMBOLS		
TYPE OF SPEAKER	MODEL	COVERAGE
	QSC KLA-12	90°
	QSC KS-212C	180°
	QSC KS-112	360°
	QSC E-112	85°
	QSC CP-8	90°
	QSC AD-P.SUB	360°
	QSC AD-P.SAT	360°
CABLE & DATA OUTLET (4"x 4"x 2 1/2" OUTLET BOX) FOR HEIGHT MOUNTED REFER TO SOUND TECHNIC DRAWINGS.		
VIDEO SYSTEM SYMBOLS		
	TENSIONED CURTAIN ELITE SCREEN TE 135 HW2	
	PROJECTOR LASER OPTOMA ZH 406ST	
	TV LG 55"	
	J-BOX FOR RG6 VIDEO SYSTEM	
	RECEPTACLE 110v	



OWNER:
LINCOLN DREXEL LTD
AND LINCOLN DREXEL II,
LTD
4300 SW 73 AVE, #106
MIAMI BEACH, FL 33140

ARCHITECT:
FORM GROUP, INC
4300 SW 73 AVE, #106
MIAMI, FL, 33155

PH: 305-443-4244

INTERIOR DESIGNER:

KITCHEN CONSULTANT:
LACE FOOD SERVICE
10490 NW 26TH STREET,
MIRAMAR, FL, 33172

PH: 305-513-5223

MEP ENGINEER:
LAUREDO ENGINEERING
COMPANY
MARCELO E. LAUREDO
STATE OF FLORIDA #12964
JULIO R. LOPES
STATE OF FLORIDA #12964
E-MAIL: me@laedo77.com


STRUCTURAL ENGINEER:

INTERIOR TENANT BUILT-OUT FOR:

**ANDRÉS
CARNE DE RES**

LINCOLN DREXEL BUILDING
1655 DREXEL AVENUE
MIAMI BEACH, FL 33139

REVISIONS:
1 09/30/21 B.D.C

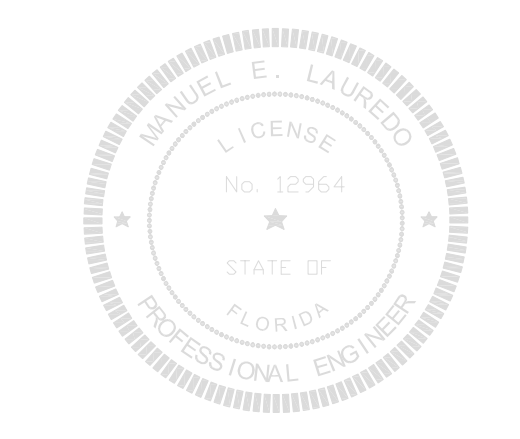


FORM GROUP, INC.
4300 SW 73 AVE, SUITE 106, MIAMI, FL 33155
TEL: 305.443.4244 FX: 305.443.3338
ARCHITECT OF RECORD: OMAR MORALES, AIA
AIA#014851

PROJECT NO. 19-1007
DATE: 3-8-20
SCALE: AS SHOWN


TITLE:
VIDEO & SOUND
GROUND FLOOR PLAN
DRAWING NO.:
E-101.2

THIS ARCHITECTURAL DRAWING IS THE PROPERTY OF FORM GROUP, INC. NO PART THEREOF SHALL BE COPIED, REPRODUCED OR USED IN WHOLE OR IN PART WITHOUT THE WRITTEN CONSENT OF THE ARCHITECT.

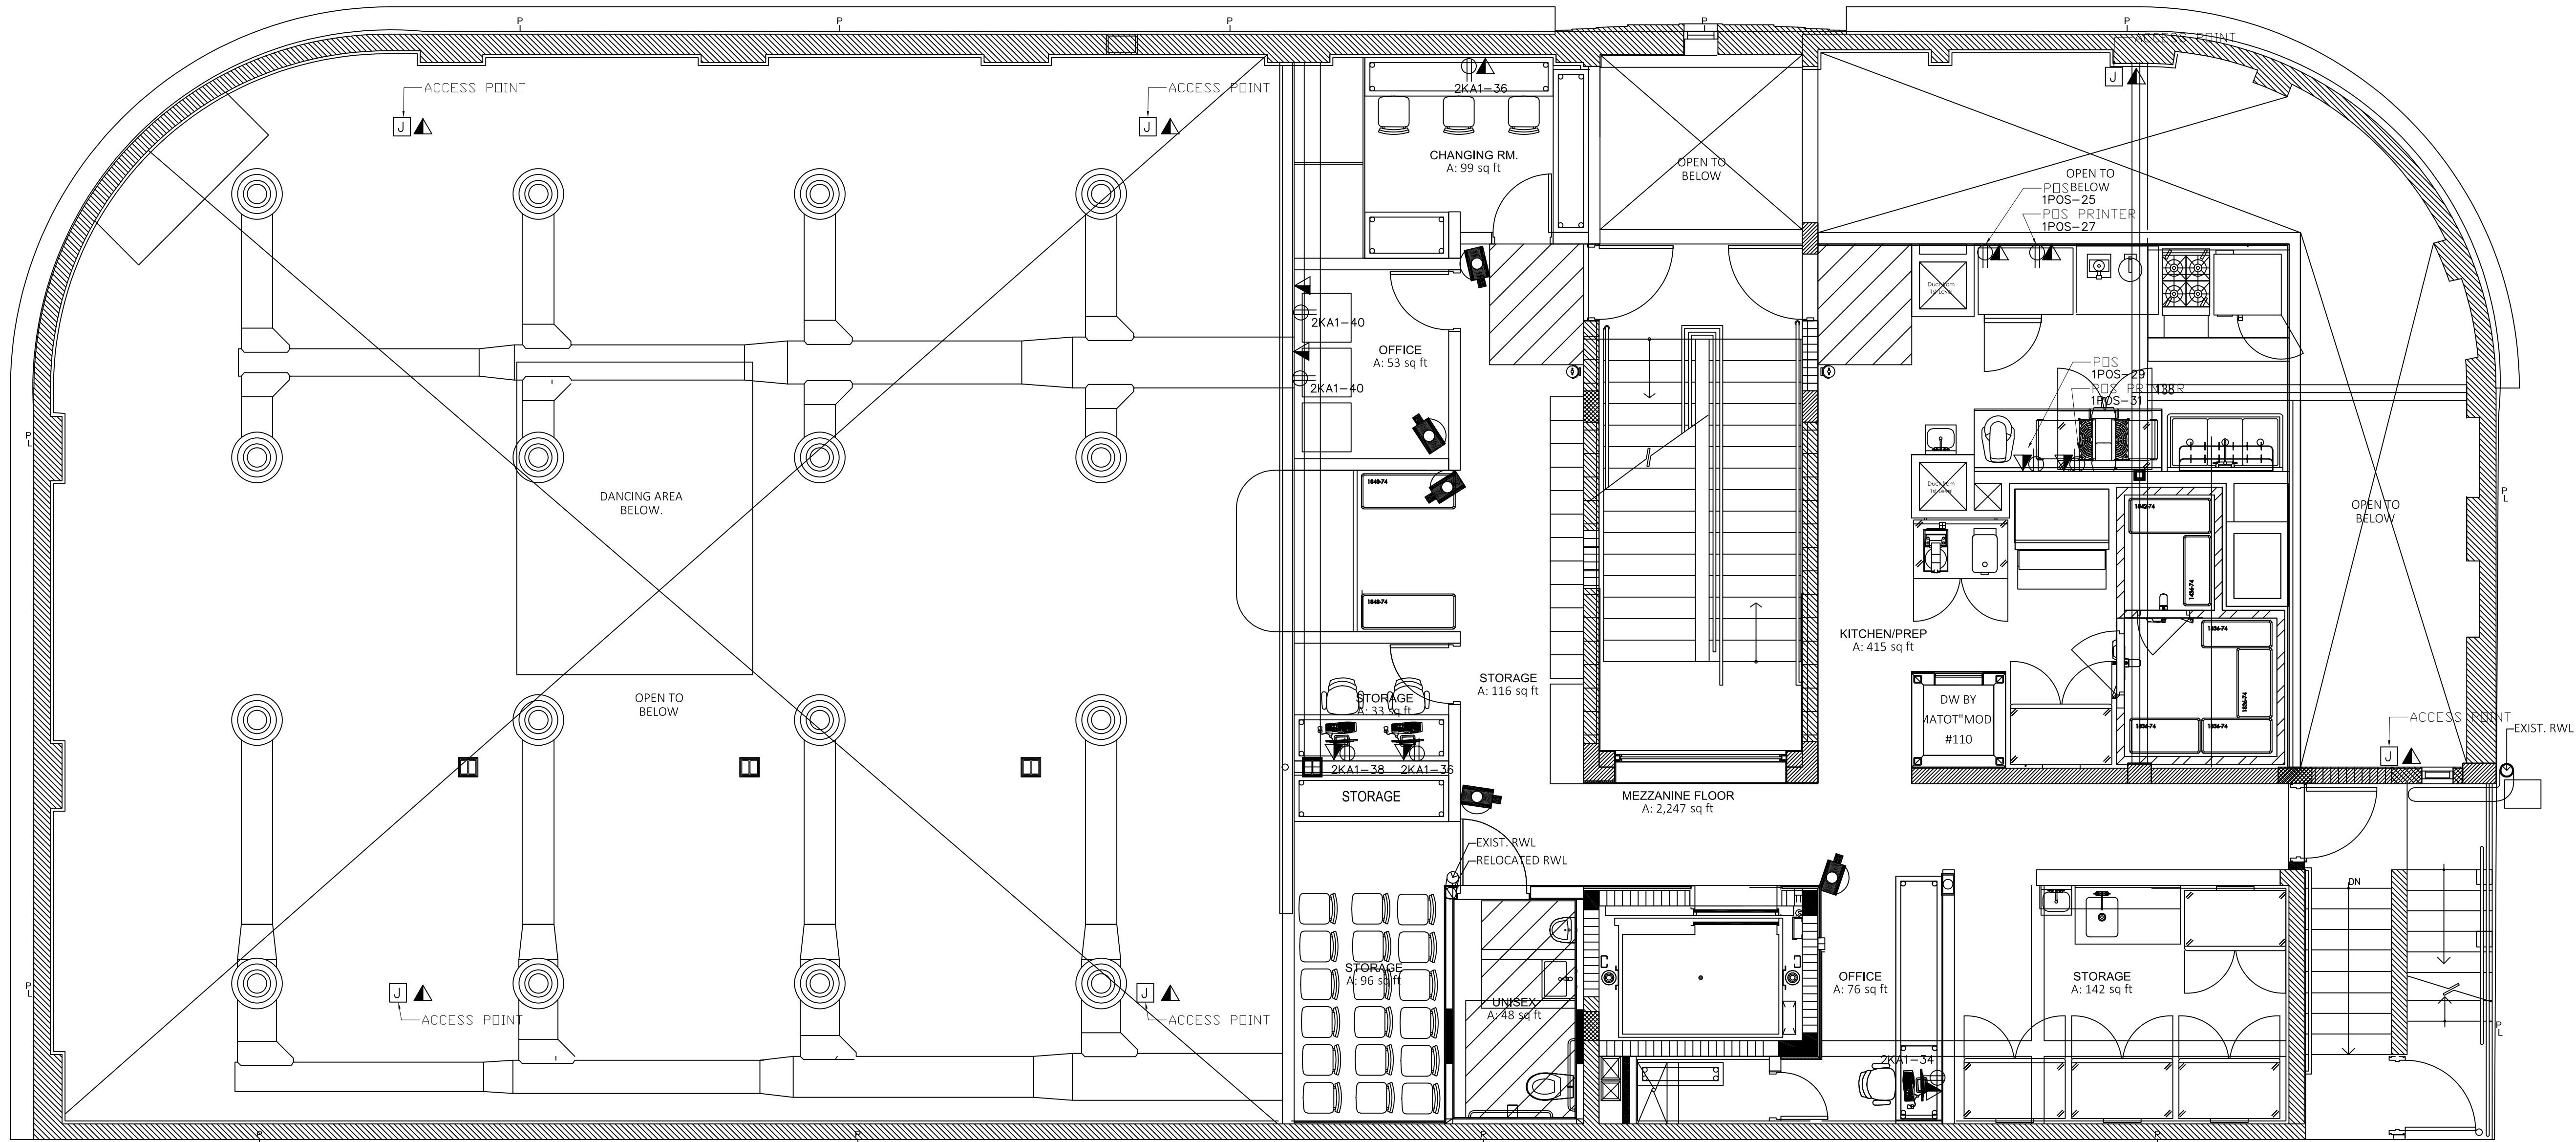

E VIDEO & SOUND AND POS / PRINTERS (WALL AND CEILING MOUNTED) MEZZANINE FLOOR PLAN

SCALE: 1/4" = 1'-0"

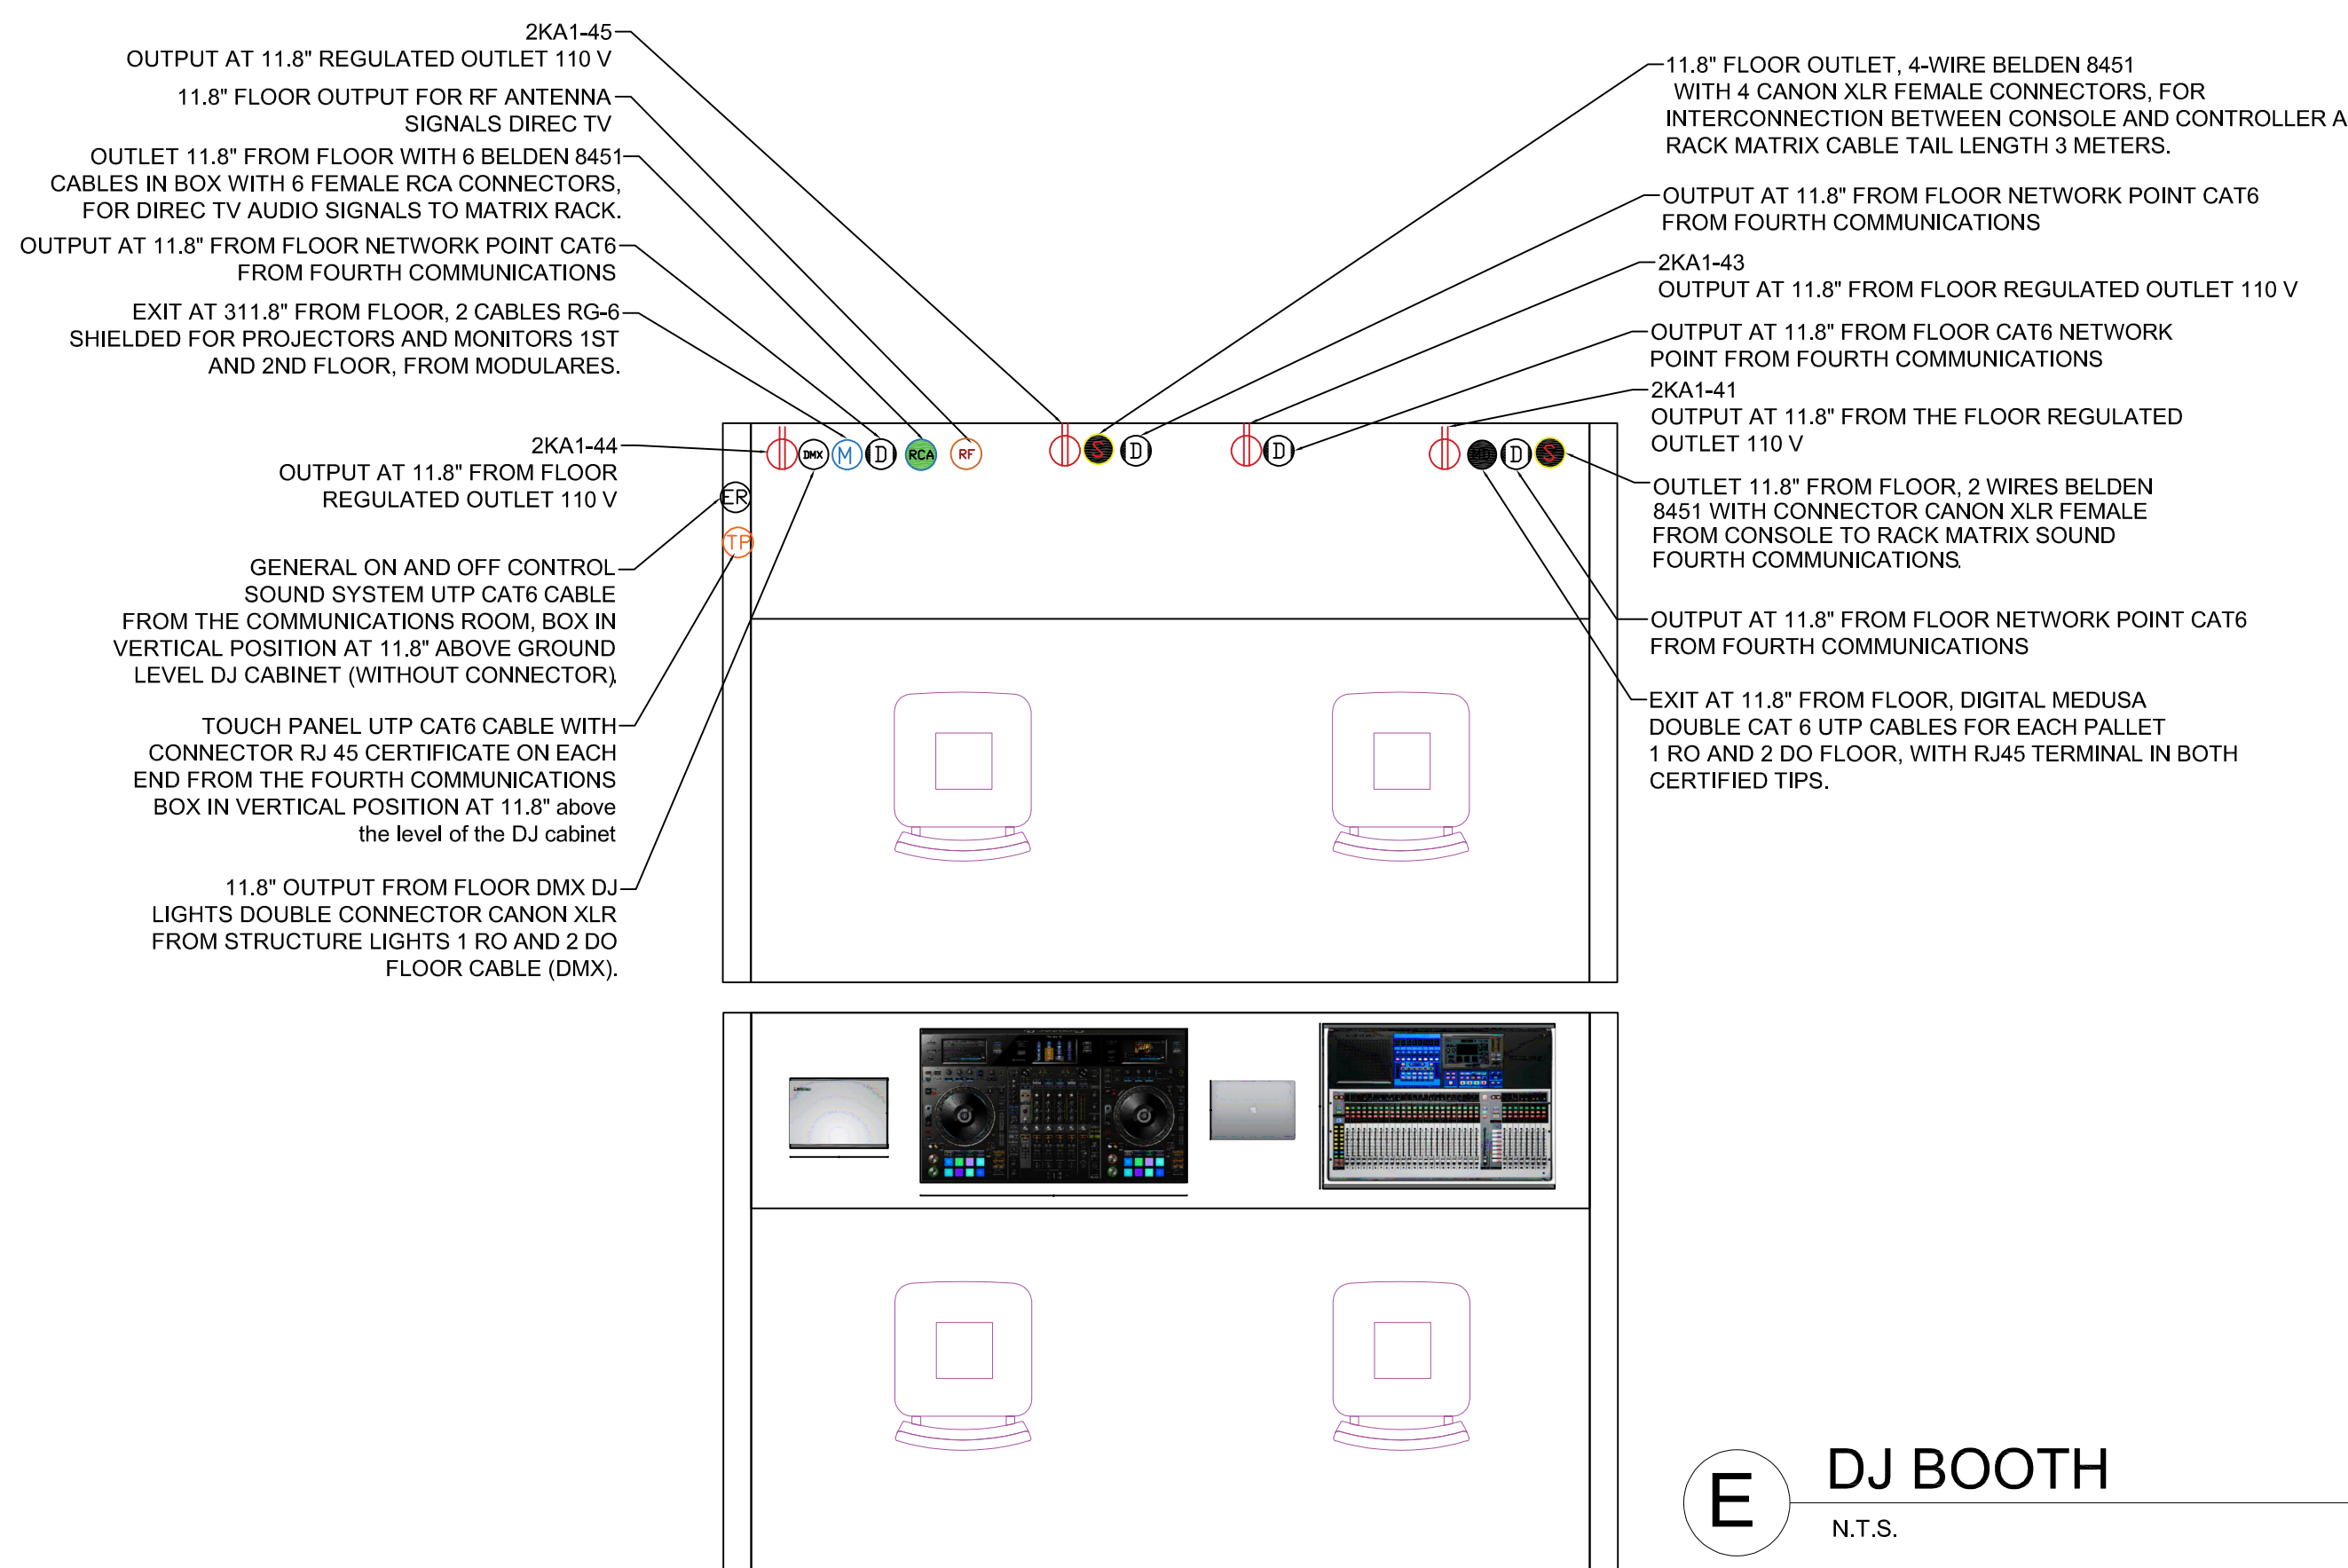

VIDEO SYSTEM SYMBOLS

	TENSIONED CURTAIN ELITE SCREEN TE 135 HW2
	PROJECTOR LASER OPTOMA ZH 406ST
	TV LG 55"
	J-BX FOR RGB VIDEO SYSTEM
	RECEPTACLE 110v

SECURITY SYSTEM SYMBOLS

SYMBOLS	
	CCTV
	DATA
	ELECTRICAL RECEPTACLE (normal 110V)
	ELECTRICAL RECEPTACLE DEDICATE
	CHAUVET Rogue rfx-b
	CHAUVET Intimidator spot 360

SPEAKER SYSTEM SYMBOLS

TYPE OF SPEAKER	MODEL	COVERAGE
	QSC KLA-12	90°
	QSC KS-212C	180°
	QSC KS-112	360°
	QSC E-112	85°
	QSC CP-8	90°
	QSC AD-P-SUB	360°
	QSC AD-P-SAT	360°

CABLE & DATA OUTLET (4"x 4"x 2 1/2" OUTLET BOX) FOR HEIGHT MOUNTED REFER TO SOUND TECHNIC DRAWINGS.

E DJ BOOTH
N.T.S.



OWNER:
LINCOLN DREXEL LTD
AND LINCOLN DREXEL II,
LTD
3921 ALTON ROAD #463
MIAMI BEACH, FL 33140

ARCHITECT:
FORM GROUP INC
4300 SW 73 AVE, #106
MIAMI, FL, 33155

PH: 305-443-4244

INTERIOR DESIGNER:

KITCHEN CONSULTANT:
LACE FOOD SERVICE
10490 NW 26TH STREET,
MIRAMAR, FL, 33172

PH: 305-513-5223

MEP ENGINEER:
LAUREDO ENGINEERING
COMPANY
MECHANICAL & ELECTRICAL ENGINEERING
STATE OF FLORIDA #E 0005502
MIAMI, FL 33139 TEL: 305-443-4244
FAX: 305-443-4245
E-MAIL: ml@laoet77.com

STRUCTURAL ENGINEER:


INTERIOR TENANT BUILT-OUT FOR:

**ANDRÉS
CARNE DE RES**

LINCOLN DREXEL BUILDING
1855 DREXEL AVENUE
MIAMI BEACH, FL 33139

REVISIONS:

1. 09/30/21 B.D.C

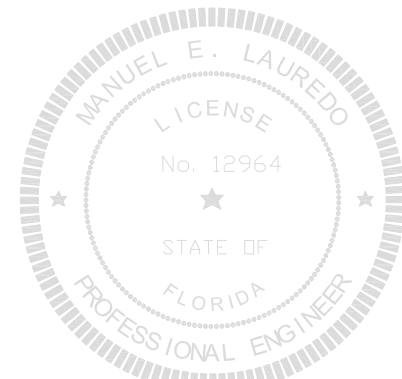


FORMGROUP
architecture .planning

FORM GROUP, INC.
4300 SW 73 AVE, SUITE 106, MIAMI, FL 33155
TEL: 305-443-4244 FAX: 305-443-3338
ARCHITECT OF RECORD: OMAR MORALES, AIA
AA0014891

THIS ARCHITECTURE, ENGINEERING, AND DESIGN ARE THE PROPERTY OF FORM GROUP, INC.
NO PART THEREOF SHALL BE COPIED, REPRODUCED OR USED IN WHOLE OR IN PART
WITHOUT THE WRITTEN CONSENT OF THE ARCHITECT

PROJECT NO.
19-1007
DATE:
3-6-20
SCALE:
AS SHOWN
TITLE:
VIDEO & SOUND
MEZZANINE FLOOR PLAN
DRAWING NO.:
E-102.2

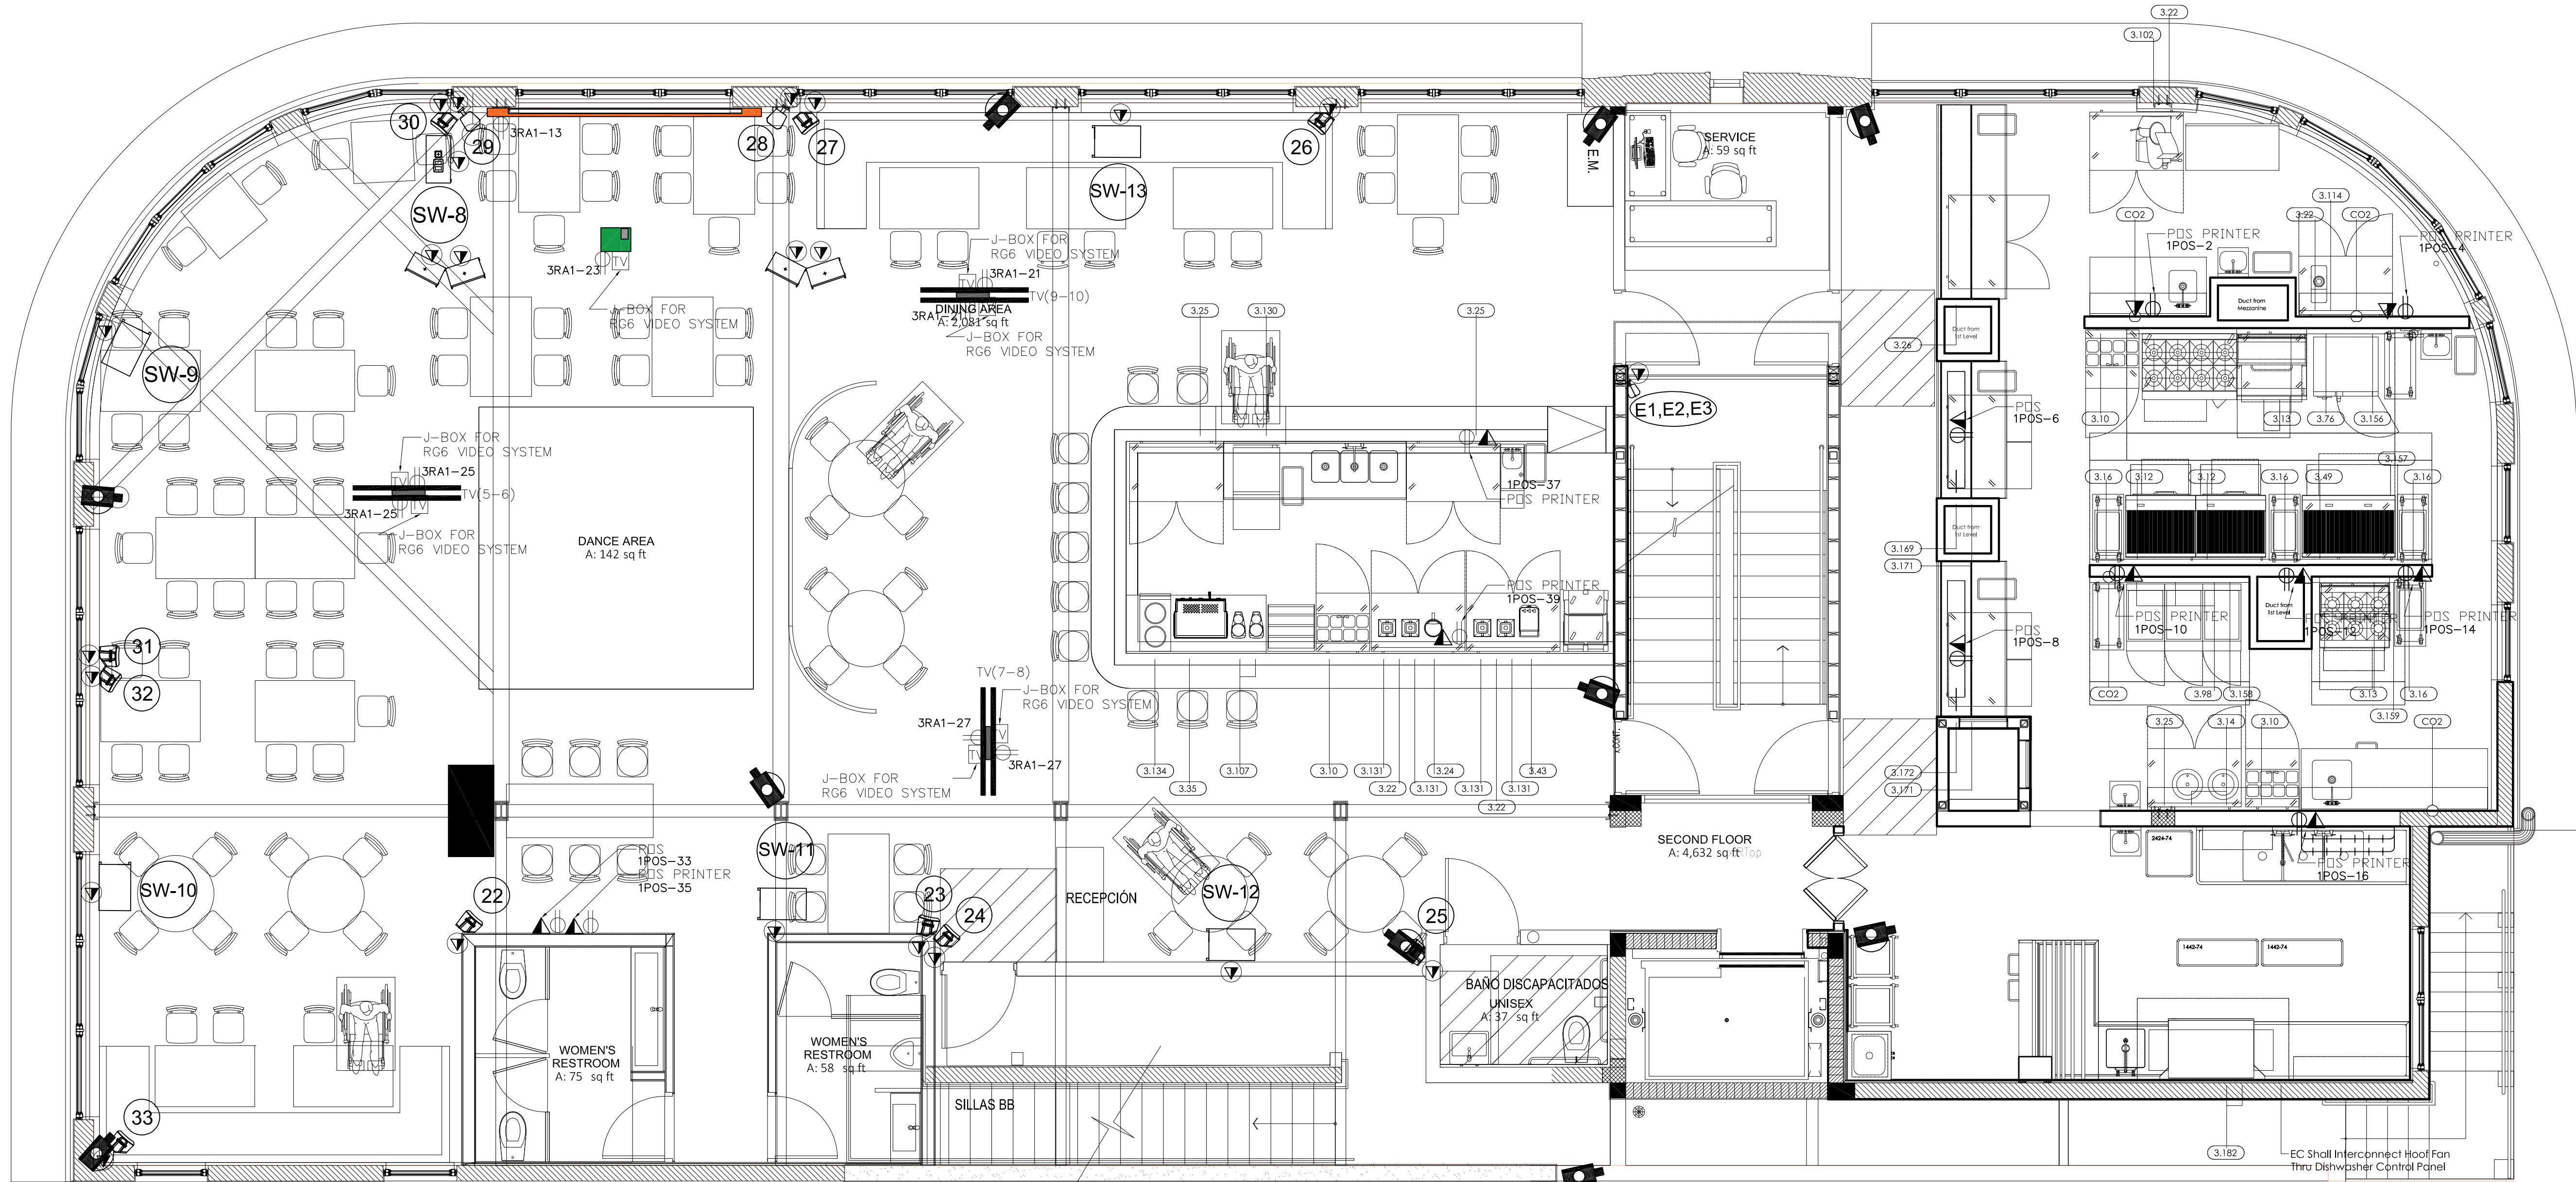

NOTES:
- SEE SOUND/ SPEAKERS REQUIREMENTS NOTE AT SOUND/SPEAKERS DRAWINGS.

E VIDEO & SOUND AND POS / PRINTERS (WALL AND CEILING MOUNTED) POWER SECOND FLOOR PLAN

SCALE: 1/4" = 1'-0"

VIDEO SYSTEM SYMBOLS

	TENSIONED CURTAIN ELITE SCREEN TE 135 HW2
	PROJECTOR LASER OPTOMA ZH 406ST
	TV LG 55"
	J-BOX FOR RG6 VIDEO SYSTEM
	RECEPTACLE 110v

SECURITY SYSTEM SYMBOLS

SYMBOLS	
	CCTV
	DATA
	ELECTRICAL RECEPTACLE (normal 110V)
	ELECTRICAL RECEPTACLE DEDICATE

	CHAUVET Rogue rfx-b
	CHAUVET Intimidator spot 360

SPEAKER SYSTEM SYMBOLS

TYPE OF SPEAKER	MODEL	COVERAGE
 ACTIVE Line Array	QSC KLA-12	 90°
 ACTIVE Cardioid Subwoofer	QSC KS-212C	 180°
 ACTIVE Subwoofer	QSC KS-112	 360°
 PASSIVE Full Range	QSC E-112	 85°
 ACTIVE Full Range	QSC CP-8	 90°
 PASSIVE Pendant Subwoofer	QSC AD-P.SUB	 360°
 PASSIVE Pendant Full Range	QSC AD-P.SAT	 360°
 CABLE & DATA OUTLET (4"x4"x2 1/2" OUTLET BOX) FOR HEIGHT MOUNTED REFER TO SOUND TECHNIC DRAWINGS.		



OWNER:
LINCOLN DREXEL LTD
AND LINCOLN DREXEL II,
LTD
3921 ALTON ROAD #463
MIAMI BEACH, FL 33140

ARCHITECT:
FORM GROUP INC
4300 SW 73 AVE, #106
MIAMI, FL, 33155

PH: 305-443-4244

INTERIOR DESIGNER:

KITCHEN CONSULTANT:
LAKE FOOD SERVICE
10490 NW 26TH STREET,
MIRAMAR, FL, 33172

PH: 305-513-5223

MEP ENGINEER:
LAUREDO ENGINEERING
COMPANY
MECHANICAL & ELECTRICAL ENGINEERING
STATE OF FLORIDA #E 0005502
MIAMI, FL 33139
TEL: 305-443-4244
E-MAIL: ml@laoe77.com

STRUCTURAL ENGINEER:


INTERIOR TENANT BUILT-OUT FOR:

**ANDRÉS
CARNE DE RES**

LINCOLN DREXEL BUILDING
1855 DREXEL AVENUE
MIAMI BEACH, FL 33139

REVISIONS:

1. 09/30/21 B.D.C

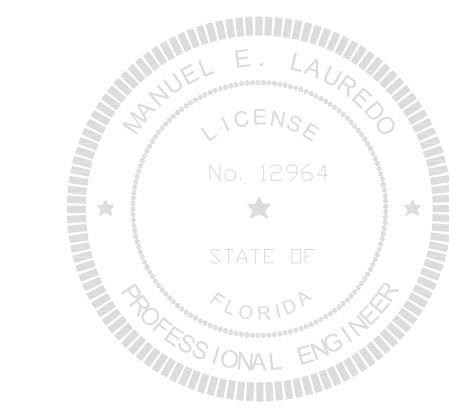


FORMGROUP
architecture .planning

FORM GROUP, INC.
4300 SW 73 AVE, SUITE 106, MIAMI, FL 33155
TEL: 305-443-4244 FAX: 305-443-3338
ARCHITECT OF RECORD: OMAR MORALES, AIA
AA0014891

PROJECT NO.
19-1007
DATE:
3-5-20
SCALE:
AS SHOWN

TITLE:
VIDEO & SOUND
SECOND FLOOR PLAN
DRAWING NO.:
E-103.2

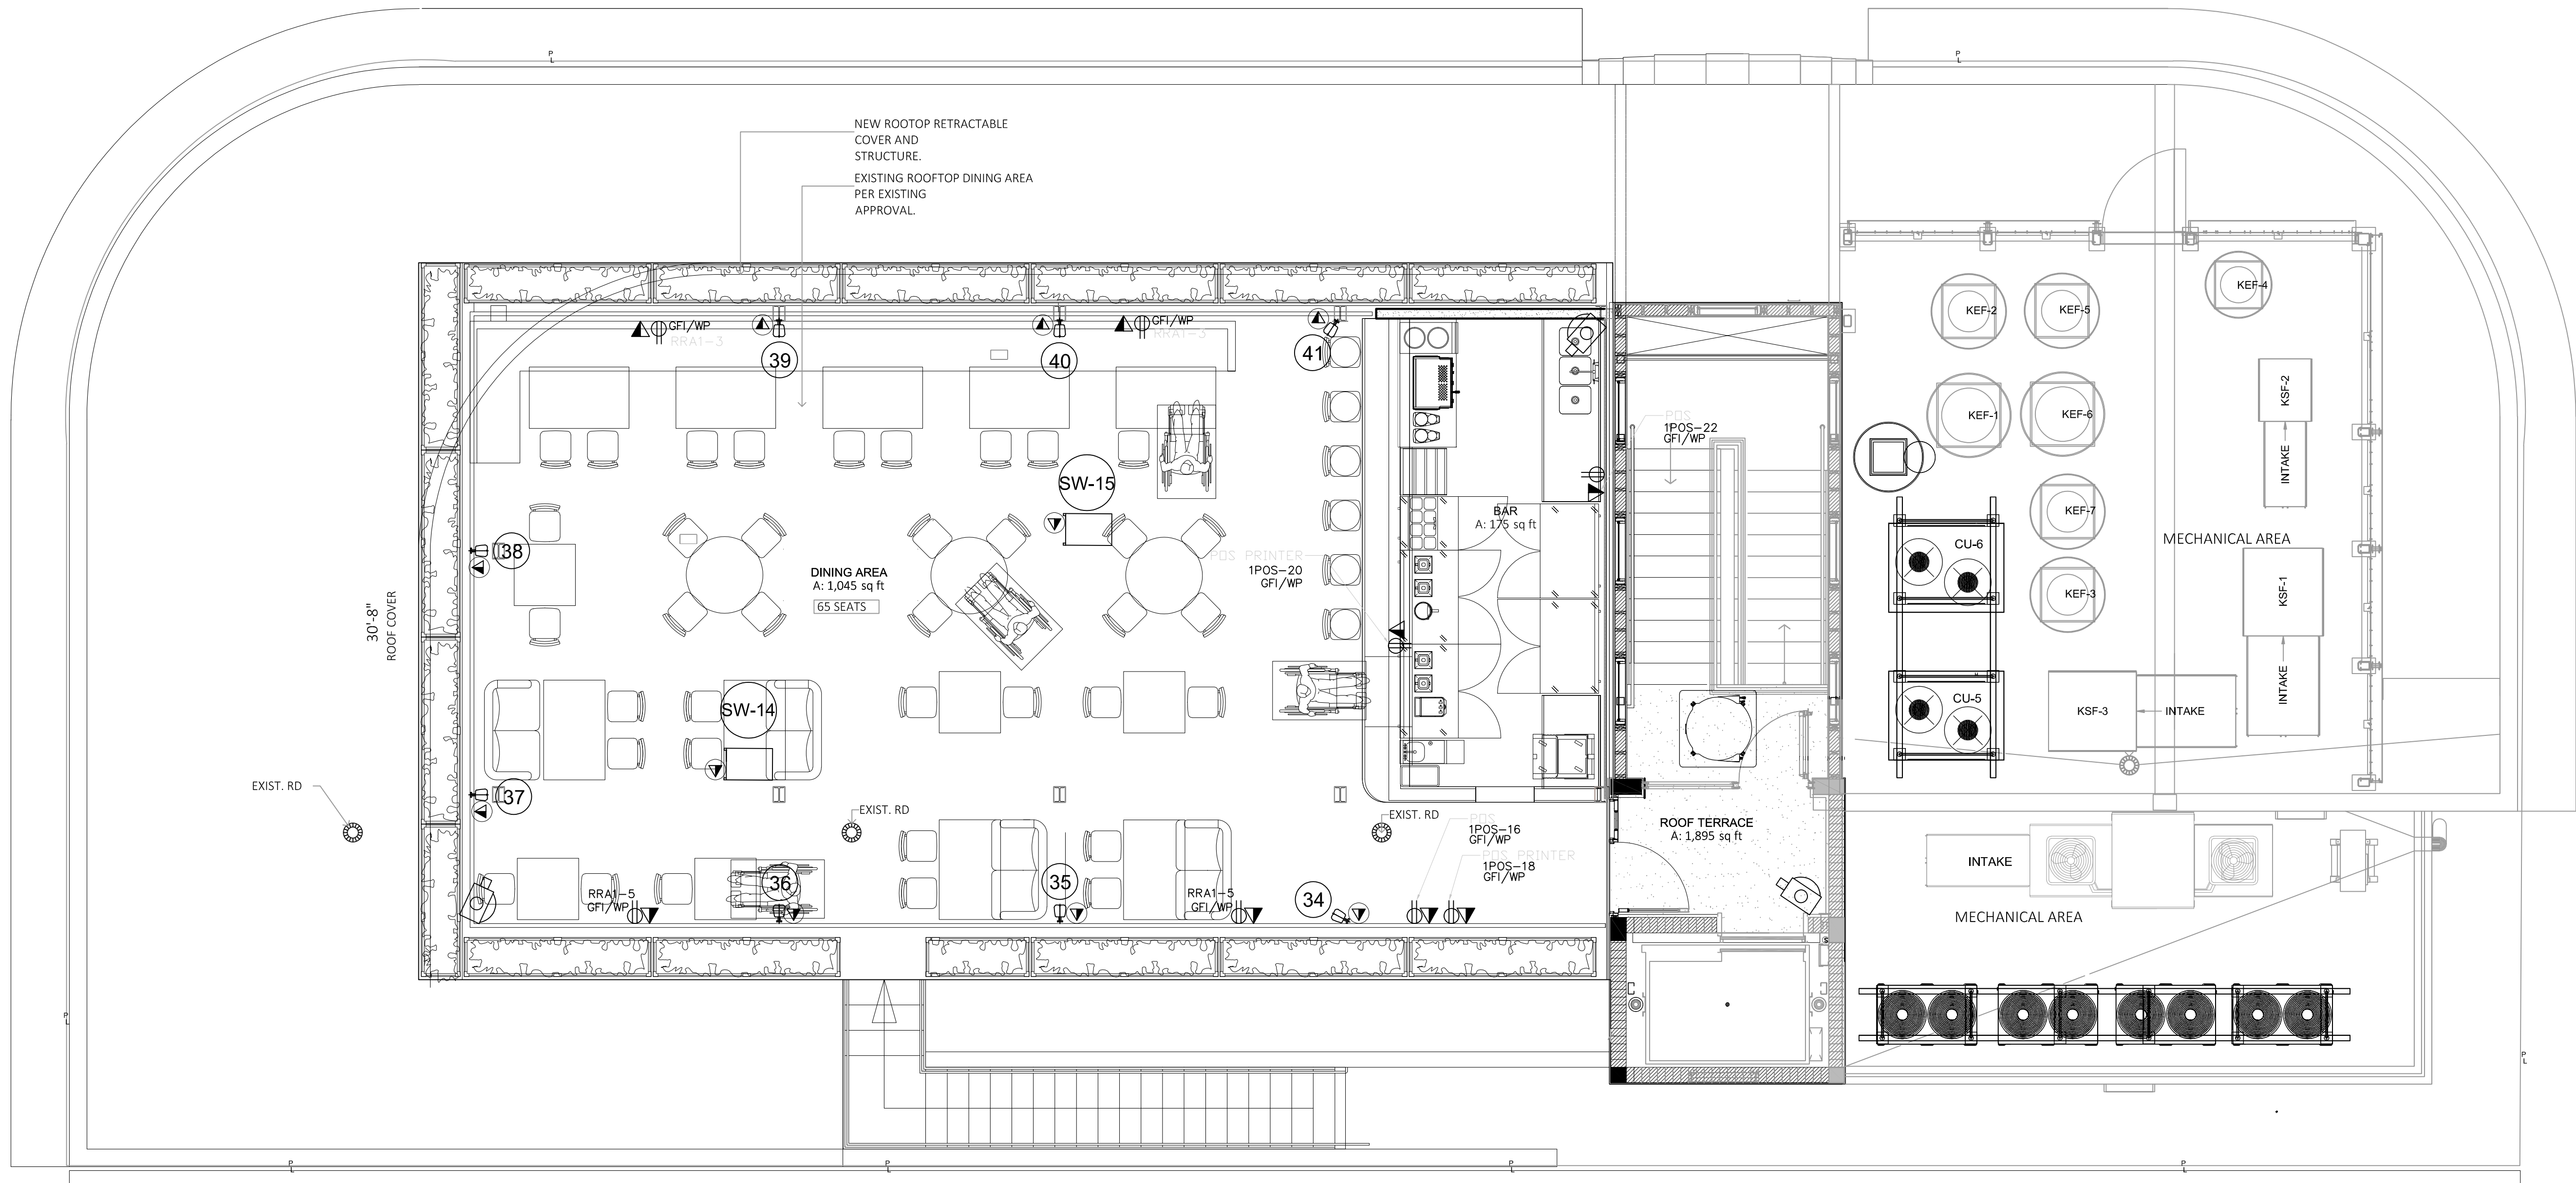

NOTES:
- SEE SOUND/ SPEAKERS REQUIREMENTS NOTE AT SOUND/SPEAKERS DRAWINGS.

E VIDEO & SOUND AND POS / PRINTERS (WALL AND CEILING MOUNTED) ROOF PLAN
SCALE: 1/4" = 1'-0"

VIDEO SYSTEM SYMBOLS	
	TENSIONED CURTAIN ELITE SCREEN TE 135 HW2
	PROJECTOR LASER OPTOMA ZH 406ST
	TV LG 55"
	J-BOX FOR RG6 VIDEO SYSTEM
	RECEPTACLE 110v

SECURITY SYSTEM SYMBOLS	
SYMBOLS	
	CCTV
	DATA
	ELECTRICAL RECEPTACLE (normal 110V)
	ELECTRICAL RECEPTACLE DEDICATE

	CHAUVET Rogue Hfx-b
	CHAUVET Intimidator spot 360

TYPE OF SPEAKER	MODEL	COVERAGE
 ACTIVE Line Array	QSC KLA-12	 90°
 ACTIVE Cardoid Subwoofer	QSC KS-212C	 180°
 ACTIVE Subwoofer	QSC KS-112	 360°
 PASSIVE Full Range	QSC E-112	 85°
 ACTIVE Full Range	QSC CP-8	 90°
 PASSIVE Pendant Subwoofer	QSC AD-P.SUB	 360°
 PASSIVE Pendant Full Range	QSC AD-P.SAT	 360°
	CABLE & DATA OUTLET (4"x 4"x 2 1/2" OUTLET BOX) FOR HEIGHT MOUNTED REFER TO SOUND TECHNIC DRAWINGS.	



OWNER:
LINCOLN DREXEL, LTD
AND LINCOLN DREXEL II,
LTD
3921 ALTON ROAD #463
MIAMI BEACH, FL 33140

ARCHITECT:
FORM GROUP INC
4300 SW 73 AVE, #106
MIAMI, FL, 33155
PH: 305-443-4244

INTERIOR DESIGNER:

KITCHEN CONSULTANT:
LACE FOOD SERVICE
10490 NW 26TH STREET,
MIRAMAR, FL, 33172
PH: 305-513-5223

MEP ENGINEER:
LAUREDO ENGINEERING
COMPANY
MECHANICAL & ELECTRICAL ENGINEERING
STATE OF FLORIDA #E 12964
10001 N. W. 11TH AVENUE, SUITE 100
MIAMI, FL 33150
TEL: 305-443-4244
FAX: 305-443-3338
E-MAIL: mla@lae77.com


STRUCTURAL ENGINEER:

INTERIOR TENANT BUILT-OUT FOR:

**ANDRÉS
CARNE DE RES**

LINCOLN DREXEL BUILDING
1655 DREXEL AVENUE
MIAMI BEACH, FL 33139

REVISIONS:
1. 09/30/21 B.D.C

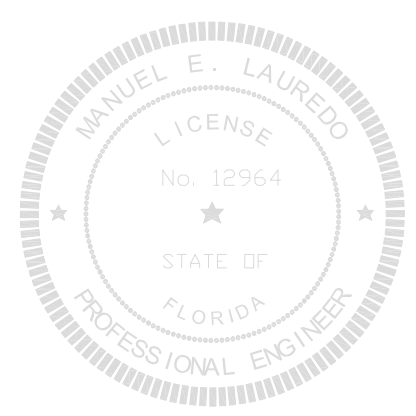

FORMGROUP
architecture .planning

FORM GROUP, INC.
4300 SW 73 AVE, SUITE 106, MIAMI, FL 33155
TEL: 305-443-4244 FAX: 305-443-3338
ARCHITECT OF RECORD: OMAR MORALES, AIA
AA2014851

THIS ARCHITECTURE, ENGINEERING, OR DESIGN AND THE PROPERTY OF FORM GROUP, INC. NO PART THEREOF SHALL BE COPIED, REPRODUCED OR USED IN WHOLE OR IN PART WITHOUT THE WRITTEN CONSENT OF THE ARCHITECT.

PROJECT NO.
19-1007

TITLE
VIDEO & SOUND
ROOF PLAN

DATE:
3-5-20

SCALE:
AS SHOWN

DRAWING NO.
E-104.2