

FINAL PLANNING BOARD

L001	COVER SHEET
L002	TREE DISPOSITION PLAN
L003	EXISTING TREE SCHEDULE
L004	LANDSCAPE LEGEND AND MITIGATION
L100	SITE HARDSCAPE PLAN
L200	SITE PLANTING PLAN
L201	2ND LEVEL PLANTING PLAN
L202	PLANTING DETAILS
L300	SITE LIGHTING PLAN

NOTE: ARBORIST REPORT SUBMITTED AS A SEPARATE FILE



7500 NE 4th Court  
Suite 102  
Miami, FL 33138  
T: (305) 573-2728

PROJECT NUMBER  
2314

PROJECT NAME  
WHOLE FOODS  
AND  
WELLS FARGO  
1901 ALTON ROAD  
MIAMI BEACH, FL 33141

OWNER  
CRESCENT HEIGHTS

FACADE ARCHITECT  
OPPENHEIM ARCHITECTURE  
AND DESIGN

DRAWING

COVER  
SHEET

JUSTINE VELEZ, FLORIDA LIC# LA6667391  
ALL DRAWINGS AND WRITTEN MATERIAL APPEARING  
HEREIN CONSTITUTE THE ORIGINAL AND UNPUBLISHED  
WORK OF STUDIO MCG ARCHITECTURE AND  
MAY NOT BE DUPLICATED, USED OR DISCLOSED  
WITHOUT THE EXPRESS WRITTEN CONSENT OF  
STUDIO MCG ARCHITECTURE & PLANNING, INC. (c) 2020

SCALE: 1/32" = 1'- 0"

DRAWN: AJ

CHECK: JV/DS

DATE: 10/02/23

SHEET NUMBER  
L001


KEY









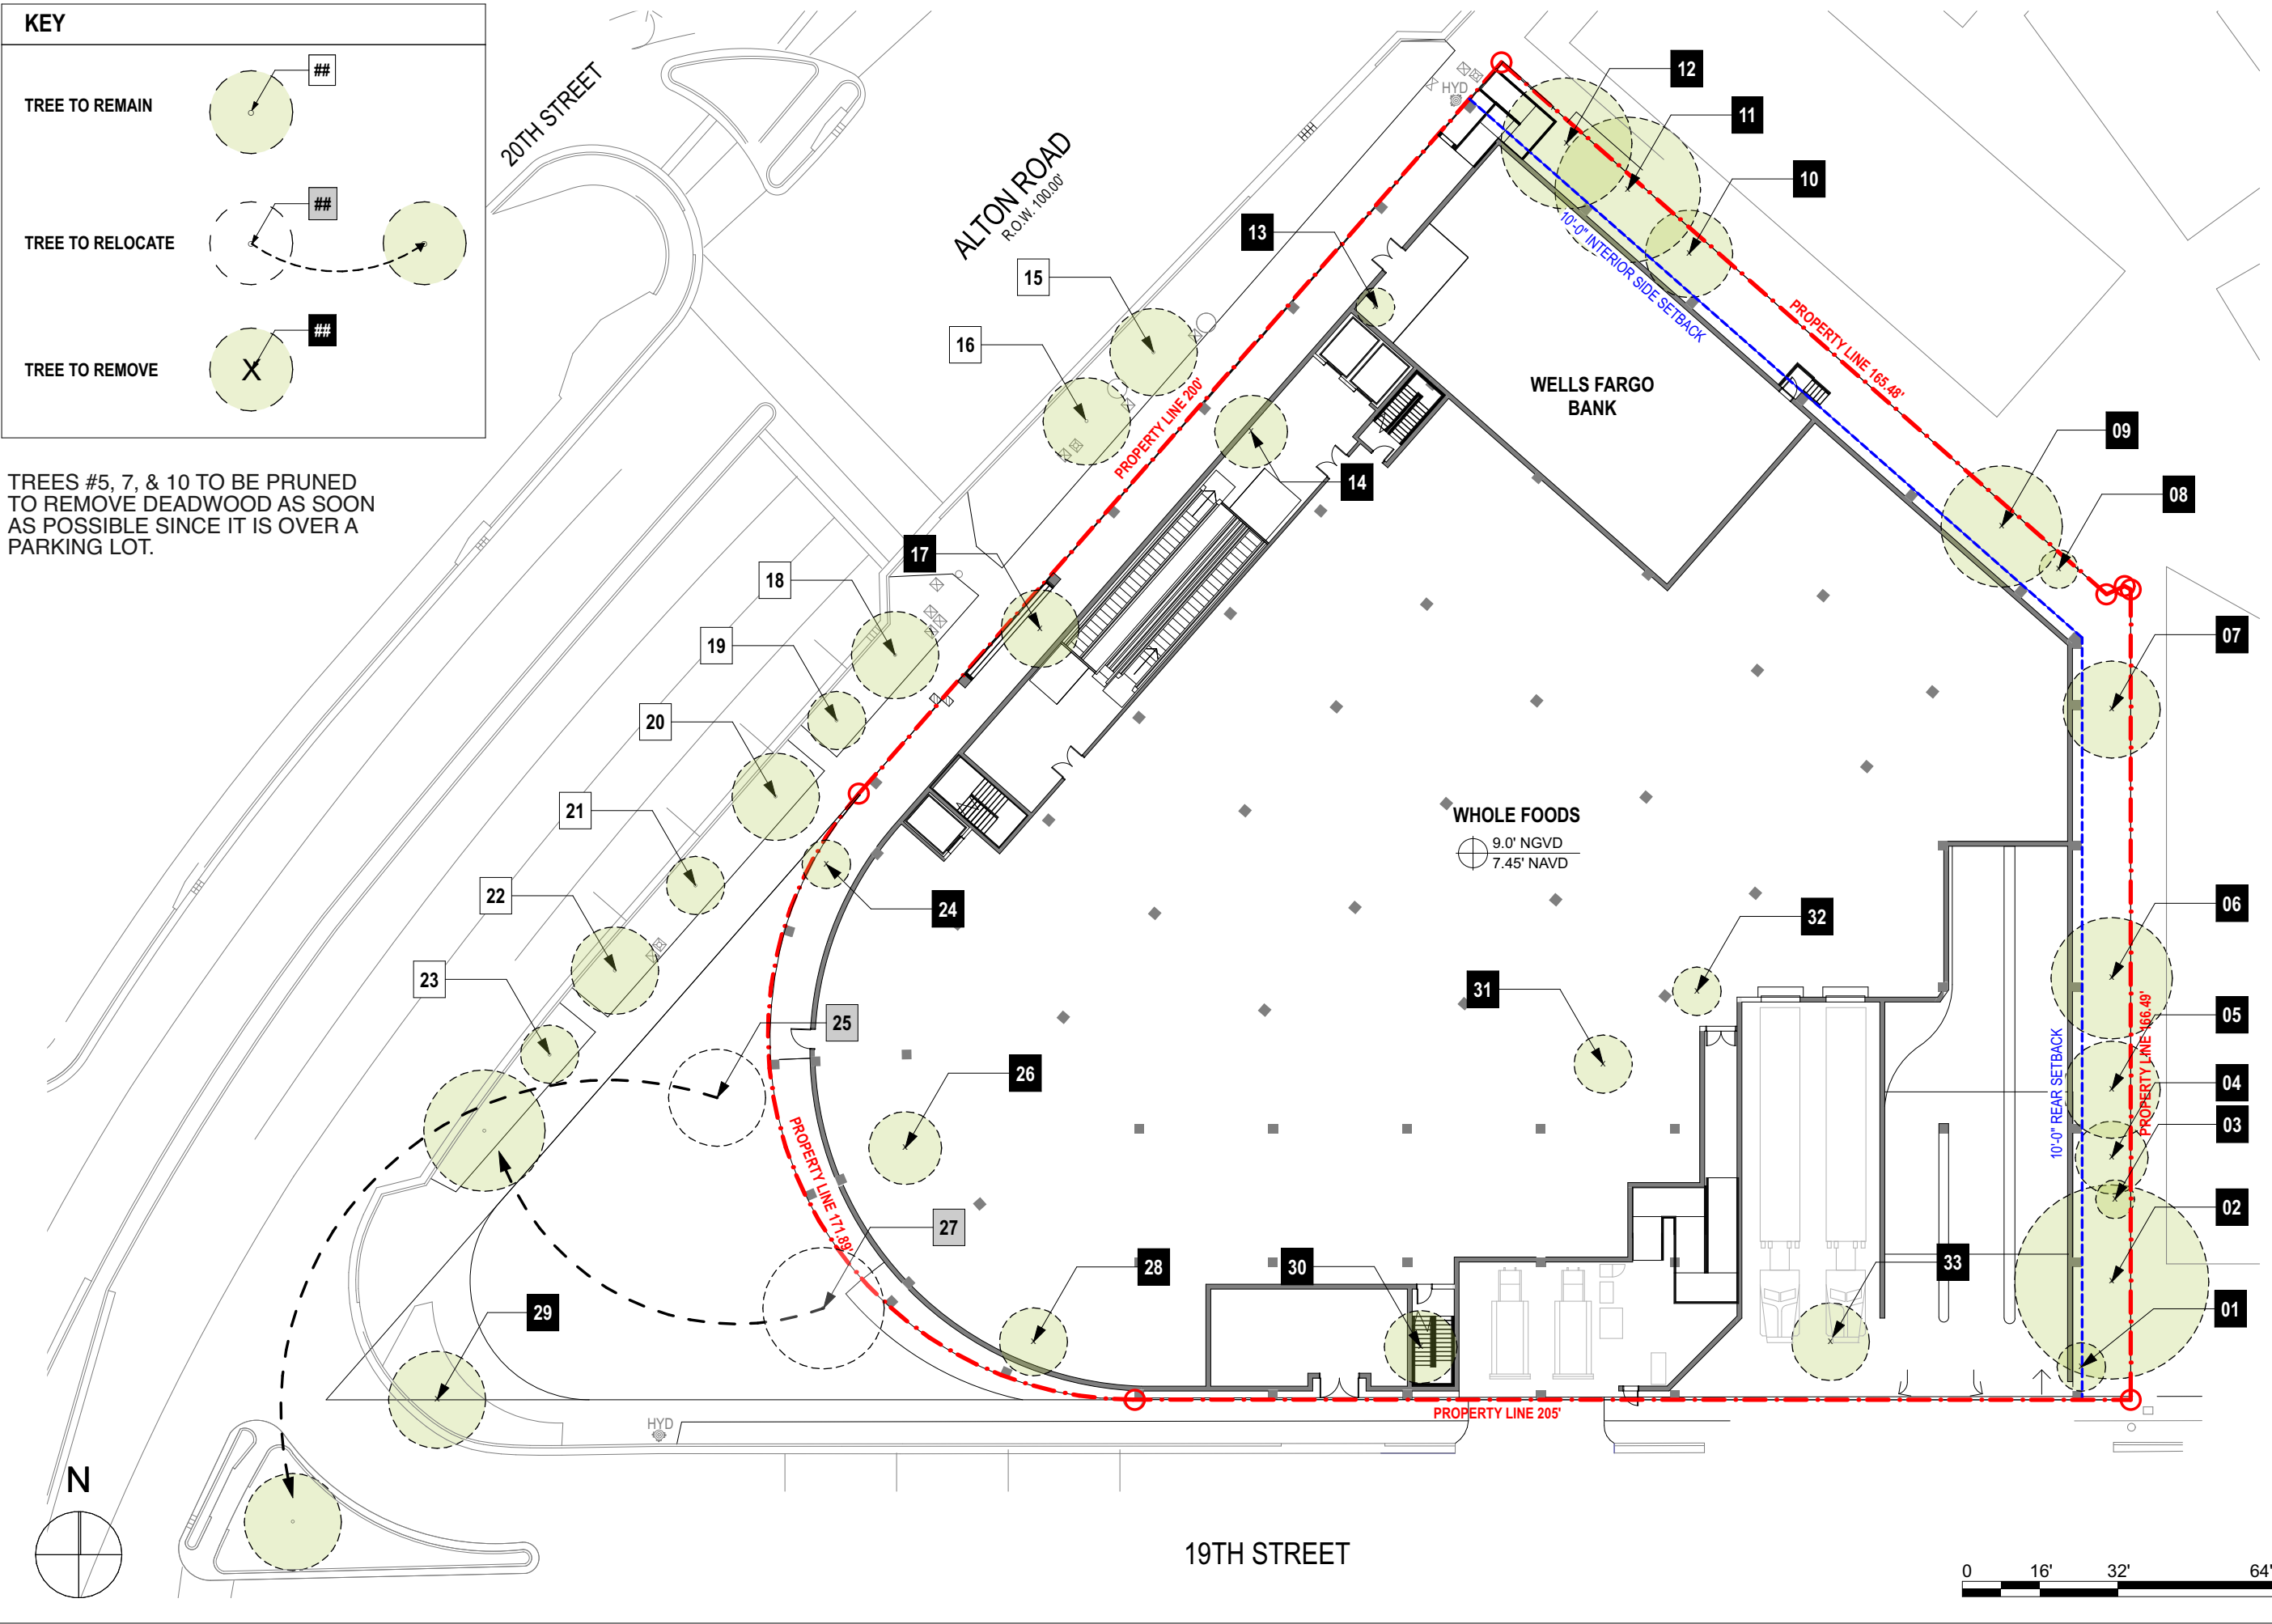


 









TREE TO REMAIN


TREE TO RELOCATE

TREE TO REMOVE

TREES #5, 7, & 10 TO BE PRUNED TO REMOVE DEADWOOD AS SOON AS POSSIBLE SINCE IT IS OVER A PARKING LOT.




Existing Tree Schedule									
Symbol	ID	Botanical Name	Common Name	DBH	Height	Spread	Native	Status	Remarks
	01	Washingtonia robusta	Mexican Fan Palm	14"	50'	10'	N	REMOVE	
	02	Acacia auriculiformis	Earleaf acacia	30"	45'	40'	N	REMOVE	Prohibited Tree*
	03	Washingtonia robusta	Mexican Fan Palm	8"	8'	8'	N	REMOVE	
	04	Acacia auriculiformis	Earleaf acacia	10.5"	30	15	N	REMOVE	Prohibited Tree*
	05	Acacia auriculiformis	Earleaf acacia	17"	33	20	N	REMOVE	LARGE DEADWOOD; PRUNE TO REMOVE DEADWOOD ASAP Prohibited Tree*
	06	Acacia auriculiformis	Earleaf acacia	12"	30'	25'	N	REMOVE	Prohibited Tree*
	07	Acacia auriculiformis	Earleaf acacia	18.5"	40'	20'	N	REMOVE	LARGE DEADWOOD; PRUNE TO REMOVE DEADWOOD ASAP Prohibited Tree*
	08	Tabebuia heterophylla	Pink Trumpet Tree	6"	20'	8'	N	REMOVE	
	09	Acacia auriculiformis	Earleaf acacia	19.5"	40'	25'	N	REMOVE	Prohibited Tree*
	10	Acacia auriculiformis	Earleaf acacia	24"	40'	18'	N	REMOVE	LARGE DEADWOOD; PRUNE TO REMOVE DEADWOOD ASAP Prohibited Tree*
	11	Acacia auriculiformis	Earleaf acacia	24"	40'	30'	N	REMOVE	Prohibited Tree*
	12	Acacia auriculiformis	Earleaf acacia	12"	40'	27'	N	REMOVE	Prohibited Tree*
	13	Washingtonia robusta	Mexican Fan Palm	16"	40'	8'	N	REMOVE	
	14	Roystonea regia	Royal Palm	14"	50'	15'	Y	REMOVE	
	15	Conocarpus erectus 'sericeus'	Silver Buttonwood	8"	15'	18'	Y	REMAIN	
	16	Conocarpus erectus 'sericeus'	Silver Buttonwood	8"	15'	18'	Y	REMAIN	
	17	Roystonea regia	Royal Palm	16"	45'	16'	Y	REMOVE	
	18	Quercus virginiana	Live Oak	6"	20'	18'	Y	REMAIN	
	19	Phoenix sylvestris	Silvester Date Palm	12"	25'	12'	N	REMAIN	
	20	Quercus virginiana	Live Oak	9"	20'	18'	Y	REMAIN	
	21	Phoenix sylvestris	Silvester Date Palm	12"	25'	12'	N	REMAIN	

Existing Tree Schedule									
Symbol	ID	Botanical Name	Common Name	DBH	Height	Spread	Native	Status	Remarks
	22	Quercus virginiana	Live Oak	6"	18'	18'	Y	REMAIN	
	23	Phoenix sylvestris	Silvester Date Palm	14"	25'	12'	N	REMAIN	
	24	Roystonea regia	Royal Palm	14"				REMOVE	
	25	Phoenix dactylifera	Date Palm	18"	28'	20'	N	RELOCATE	
	26	Sabal palmetto	Sabal Palm	13"	25'	15'	Y	REMOVE	
	27	Quercus virginiana	Live Oak	12"	30'	25'	Y	RELOCATE	
	28	Roystonea regia	Royal Palm	12.5"	40'	14'	Y	REMOVE	
	29	Veitchia arecina	Montgomery Palm 'double'	7"	25	20		REMOVE	
	30	Roystonea regia	Royal Palm	14"	50'	15'	Y	REMOVE	
	31	Waashingtonia robusta	Mexican Fan Palm	14"	40'	12'	N	REMOVE	
	32	Syagrus romanzoffiana	Queen Palm	8"	25'	10'	N	REMOVE	
	33	Roystonea regia	Royal Palm	17"	50'	16'	Y	REMOVE	

TREE/ PALM PROTECTION FENCES SHALL BE CONSTRUCTED PRIOR TO ANY CONSTRUCTION ACTIVITY INCLUDING GRUBBING FOR ALL TREES/PALMS THAT ARE 'TO REMAIN, BE PROTECTED OR BE RELOCATED'

NO ACTIVITY OR DISTURBANCE SHOULD OCCUR WITHIN THE FENCED AREAS, INCLUDING VEHICLE USE, STORAGE OF MATERIALS, DUMPING OF LIQUIDS OR MATERIALS, GRADE CHANGES, GRUBBING, AND MECHANICAL TRENCHING FOR IRRIGATION, ELECTRICAL, LIGHTING, ETC.

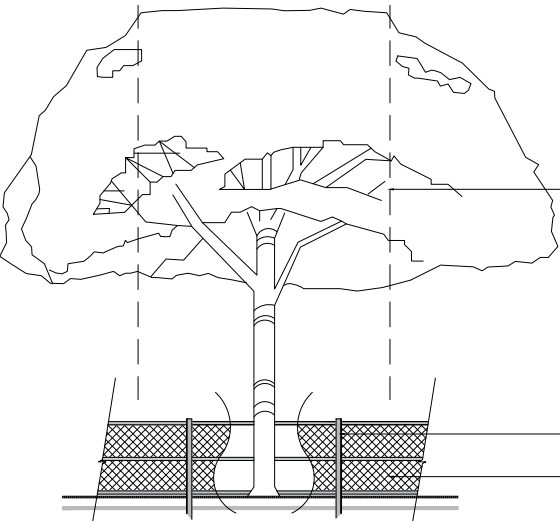

IN NO CASE SHALL THE FENCE BE INSTALLED LESS THAN TEN FEET FROM THE TRUNK

TREE + PALM PROTECTION BARRIERS TO EXTEND BEYOND THE 'DRIPLINE' OR TO THE 'CRITICAL ROOT ZONE AREA' OF ALL TREES/PALMS TO BE PROTECTED. EXTEND WHERE NECESSARY TO PROTECT TREE CANOPY ROOTS

BARRIERS SHALL BE A MINIMUM OF FOUR FEET HIGH, AND SHALL BE CONSTRUCTED OF CONTINUOUS CHAIN LINK FENCE WITH METAL POSTS AT EIGHT-FOOT SPACING OR 2"x4" POSTS WITH THREE EQUALLY SPACED 2"x4" RAILS. POSTS MAY BE SHIFTED TO AVOID ROOTS.

PROTECTION DETAIL NOTE:  
CONTRACTOR TO INSTALL 'TREE/PALM PROTECTION FENCE BARRIERS' AROUND ALL EXISTING TREES OR PALMS AT THE START OF THE PROJECT. BARRIERS TO REMAIN IN PLACE THROUGHOUT THE DURATION OF THE PROJECT AND SHOULD NOT BE REMOVED OR DROPPED FOR ANY REASON WITHOUT AUTHORIZATION FROM THE CITY OF MIAMI BEACH URBAN FORESTER + PLANNING + ZONING DEPARTMENT

C.M.B. TREE / PALM PROTEC. DETAIL

NOTE:

TREES #5, 7, & 10 TO BE PRUNED TO REMOVE DEADWOOD AS SOON AS POSSIBLE SINCE THEY ARE OVER A PARKING LOT.

EXISTING  
TREE  
SCHEDULE

CITY OF MIAMI BEACH  
LANDSCAPE LEGEND

INFORMATION REQUIRED TO BE PERMANENTLY AFFIXED TO PLANS

Zoning District CD-1 Lot Area 55,377 Acres 1.27

OPEN SPACE

- A. Square feet of required Open Space as indicated on site plan:  
Lot Area = 55,377 s.f.x 5.98 % = 3,312 s.f.
- B. Square feet of parking lot open space required as indicated on site plan:  
Number of parking spaces x 10 s.f. parking space =
- C. Total square feet of landscaped open space required: A+B=

LAWN AREA CALCULATION

- A. Square feet of landscaped open space required
- B. Maximum lawn area (sod) permitted= 3,312 % x 20% s.f.

TREES

- A. Number of trees required per lot or net lot acre, less existing number of trees meeting minimum requirements=  
22 trees x 1.27 net lot acres - number of existing trees=
- B. % Natives required: Number of trees provided x 30% =
- C. % Low maintenance / drought and salt tolerant required:  
Number of trees provided x 50%=
- D. Street Trees (maximum average spacing of 20' o.c.)  
576.96 linear feet along street divided by 20'=
- E. Street tree species allowed directly beneath power lines:  
(maximum average spacing of 20' o.c.):  
linear feet along street divided by 20'=

SHRUBS

- A. Number of shrubs required: Sum of lot and street trees required x 12=
- B. % Native shrubs required: Number of shrubs provided x 50%=

LARGE SHRUBS OR SMALL TREES

- A. Number of large shrubs or small trees required: Number of required shrubs x 10%=
- B. % Native large shrubs or small trees required: Number of large shrubs or small trees provided x 50%=

NOTE:  
Street Trees will comply with Florida Fancy requirements. All other planting materials shall meet or exceed Florida Grade # 1 as specified in Grades and Standards for Nursery Plants and Part II, Palms and Trees, current edition

TOTAL TREES AND PALMS TO BE REMOVED

TREES

183" DBH  
1 Tabebuia heterophylla  
9 Acacia auriculiformis (prohibited tree)

REQUIRED MITIGATION

60 SMALL TREES (2" DBH x 6' SPREAD x 12' HEIGHT) OR,  
30 LARGE TREES (4" DBH x 8' SPREAD x 16' HEIGHT) OR,  
\$150,000 CONTRIBUTION TO TREE TRUST FUND

PALMS

4 Washingtonia robusta  
6 Roystonea regia  
1 Veitchia arecina  
1 Syagrus romanzoffiana  
1 Sabal Palm

Sec. 46-61. (c) The removal of a palm shall be replaced with one canopy tree at 12 feet overall height with a two-inch DBH.

REQUIRED MITIGATION

13 SMALL TREES (2" DBH x 12' HEIGHT) OR,  
6.5 LARGE TREES (4" DBH x 16' HEIGHT) OR,  
\$32,500 CONTRIBUTION TO TREE TRUST FUND

PROPOSED TREES. SEE PLANTING PLANS

SMALL TREES: 28  
6 Eugenia foetida \*  
5 Gymnanthes lucida \*  
3 Ilex vomitoria \*  
5 Myrcianthes fragrans \*  
6 Pimenta racemosa \*  
3 Annona glabra \*

LARGE TREES: 27  
10 Conocarpus erectus \*  
5 Conocarpus erectus sericeus \*  
12 Taxodium distichum \*

\* = Native trees

REQUIRED MITIGATION

73 SMALL TREES

TOTAL PROPOSED

28 SMALL TREES + 27 LARGE TREES  
(82 SMALL TREES EQUIVALENT)

EXCEEDING BY 9 SMALL TREES OR 4.5 LARGE TREES EQUIVALENT



7500 NE 4th Court  
Suite 102  
Miami, FL 33138  
T: (305) 573-2728

PROJECT NUMBER

2314

PROJECT NAME

WHOLE FOODS  
AND  
WELLS FARGO

1901 ALTON ROAD  
MIAMI BEACH, FL 33141

OWNER

CRESCENT HEIGHTS

FACADE ARCHITECT

OPPENHEIM ARCHITECTURE  
AND DESIGN

DRAWING

LANDSCAPE  
LEGEND  
AND  
MITIGATION

JUSTINE VELEZ, FLORIDA LIC# LA6667391

ALL DRAWINGS AND WRITTEN MATERIAL APPEARING  
HEREIN CONSTITUTE THE ORIGINAL AND UNPUBLISHED  
WORK OF STUDIO MCG ARCHITECTURE AND  
MAY NOT BE DUPLICATED, USED OR DISCLOSED  
WITHOUT THE EXPRESS WRITTEN CONSENT OF  
STUDIO MCG ARCHITECTURE & PLANNING, INC. (c) 2020

SCALE: 1/32" = 1'- 0"

DRAWN: AJ

CHECK: JW/DS


DATE: 10/02/23

SHEET NUMBER


L004


 
 

 
 


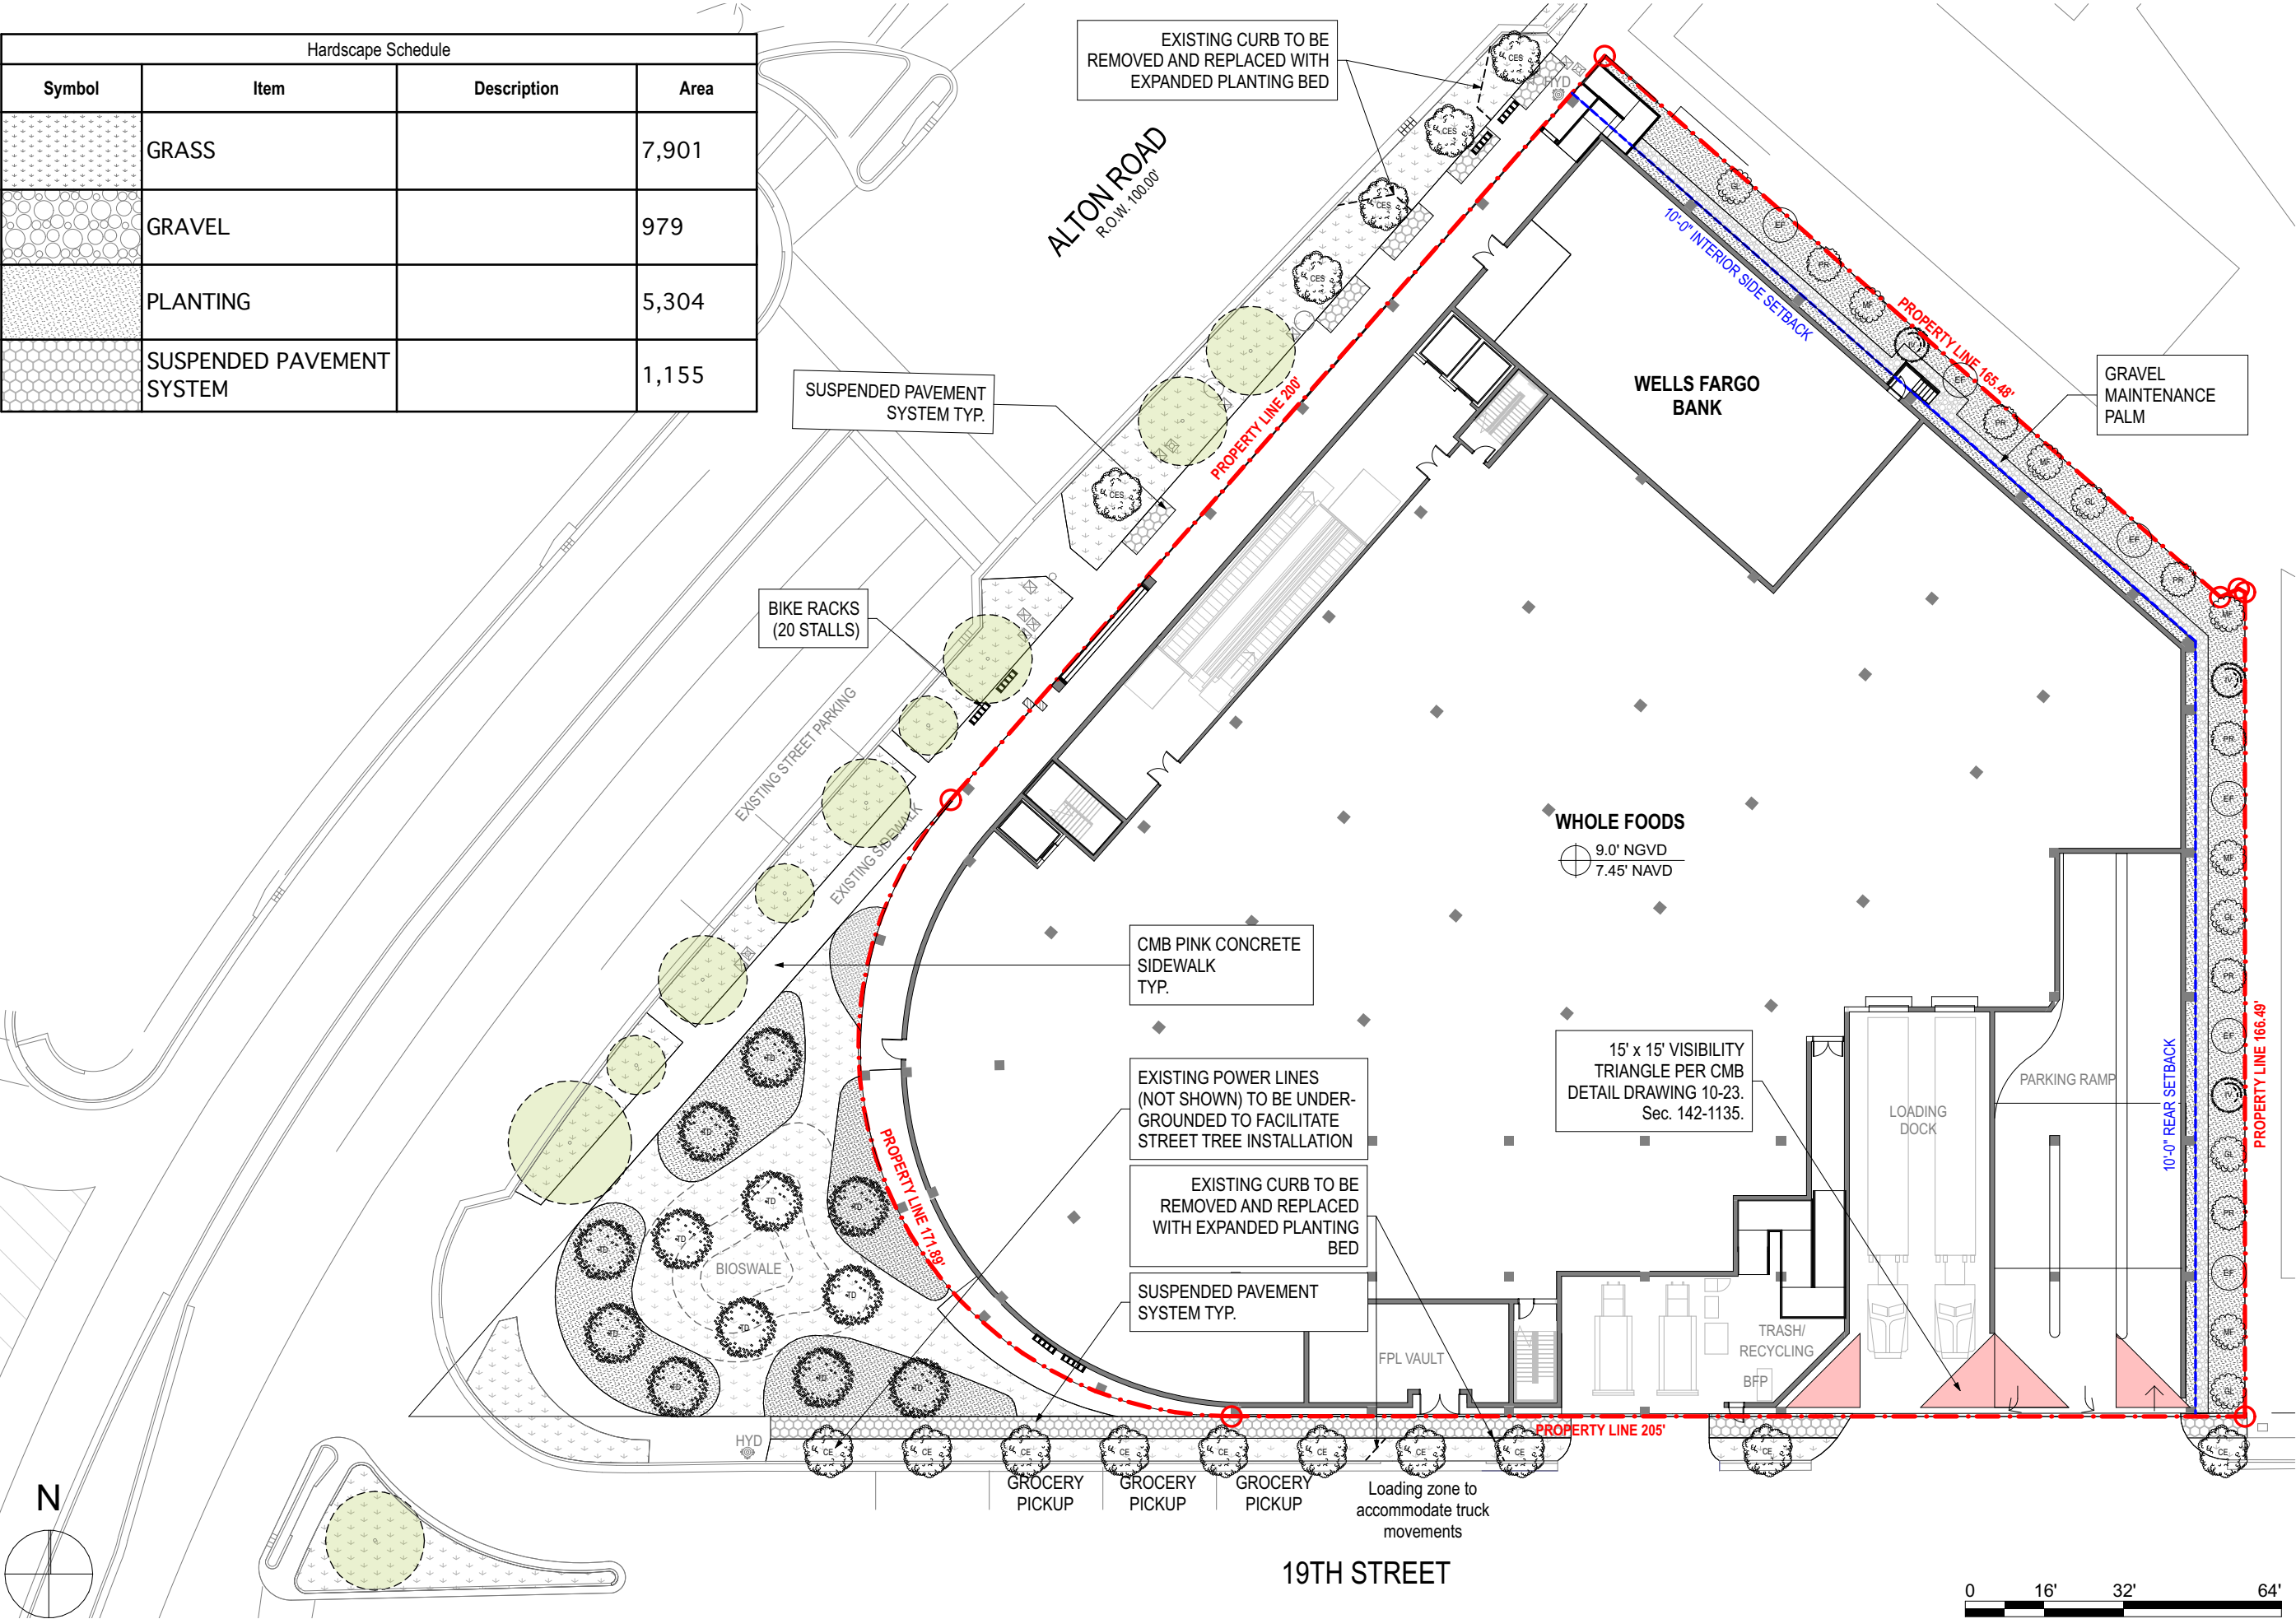

Hardscape Schedule			
Symbol	Item	Description	Area
	GRASS		7,901
	GRAVEL		979
	PLANTING		5,304
	SUSPENDED PAVEMENT SYSTEM		1,155

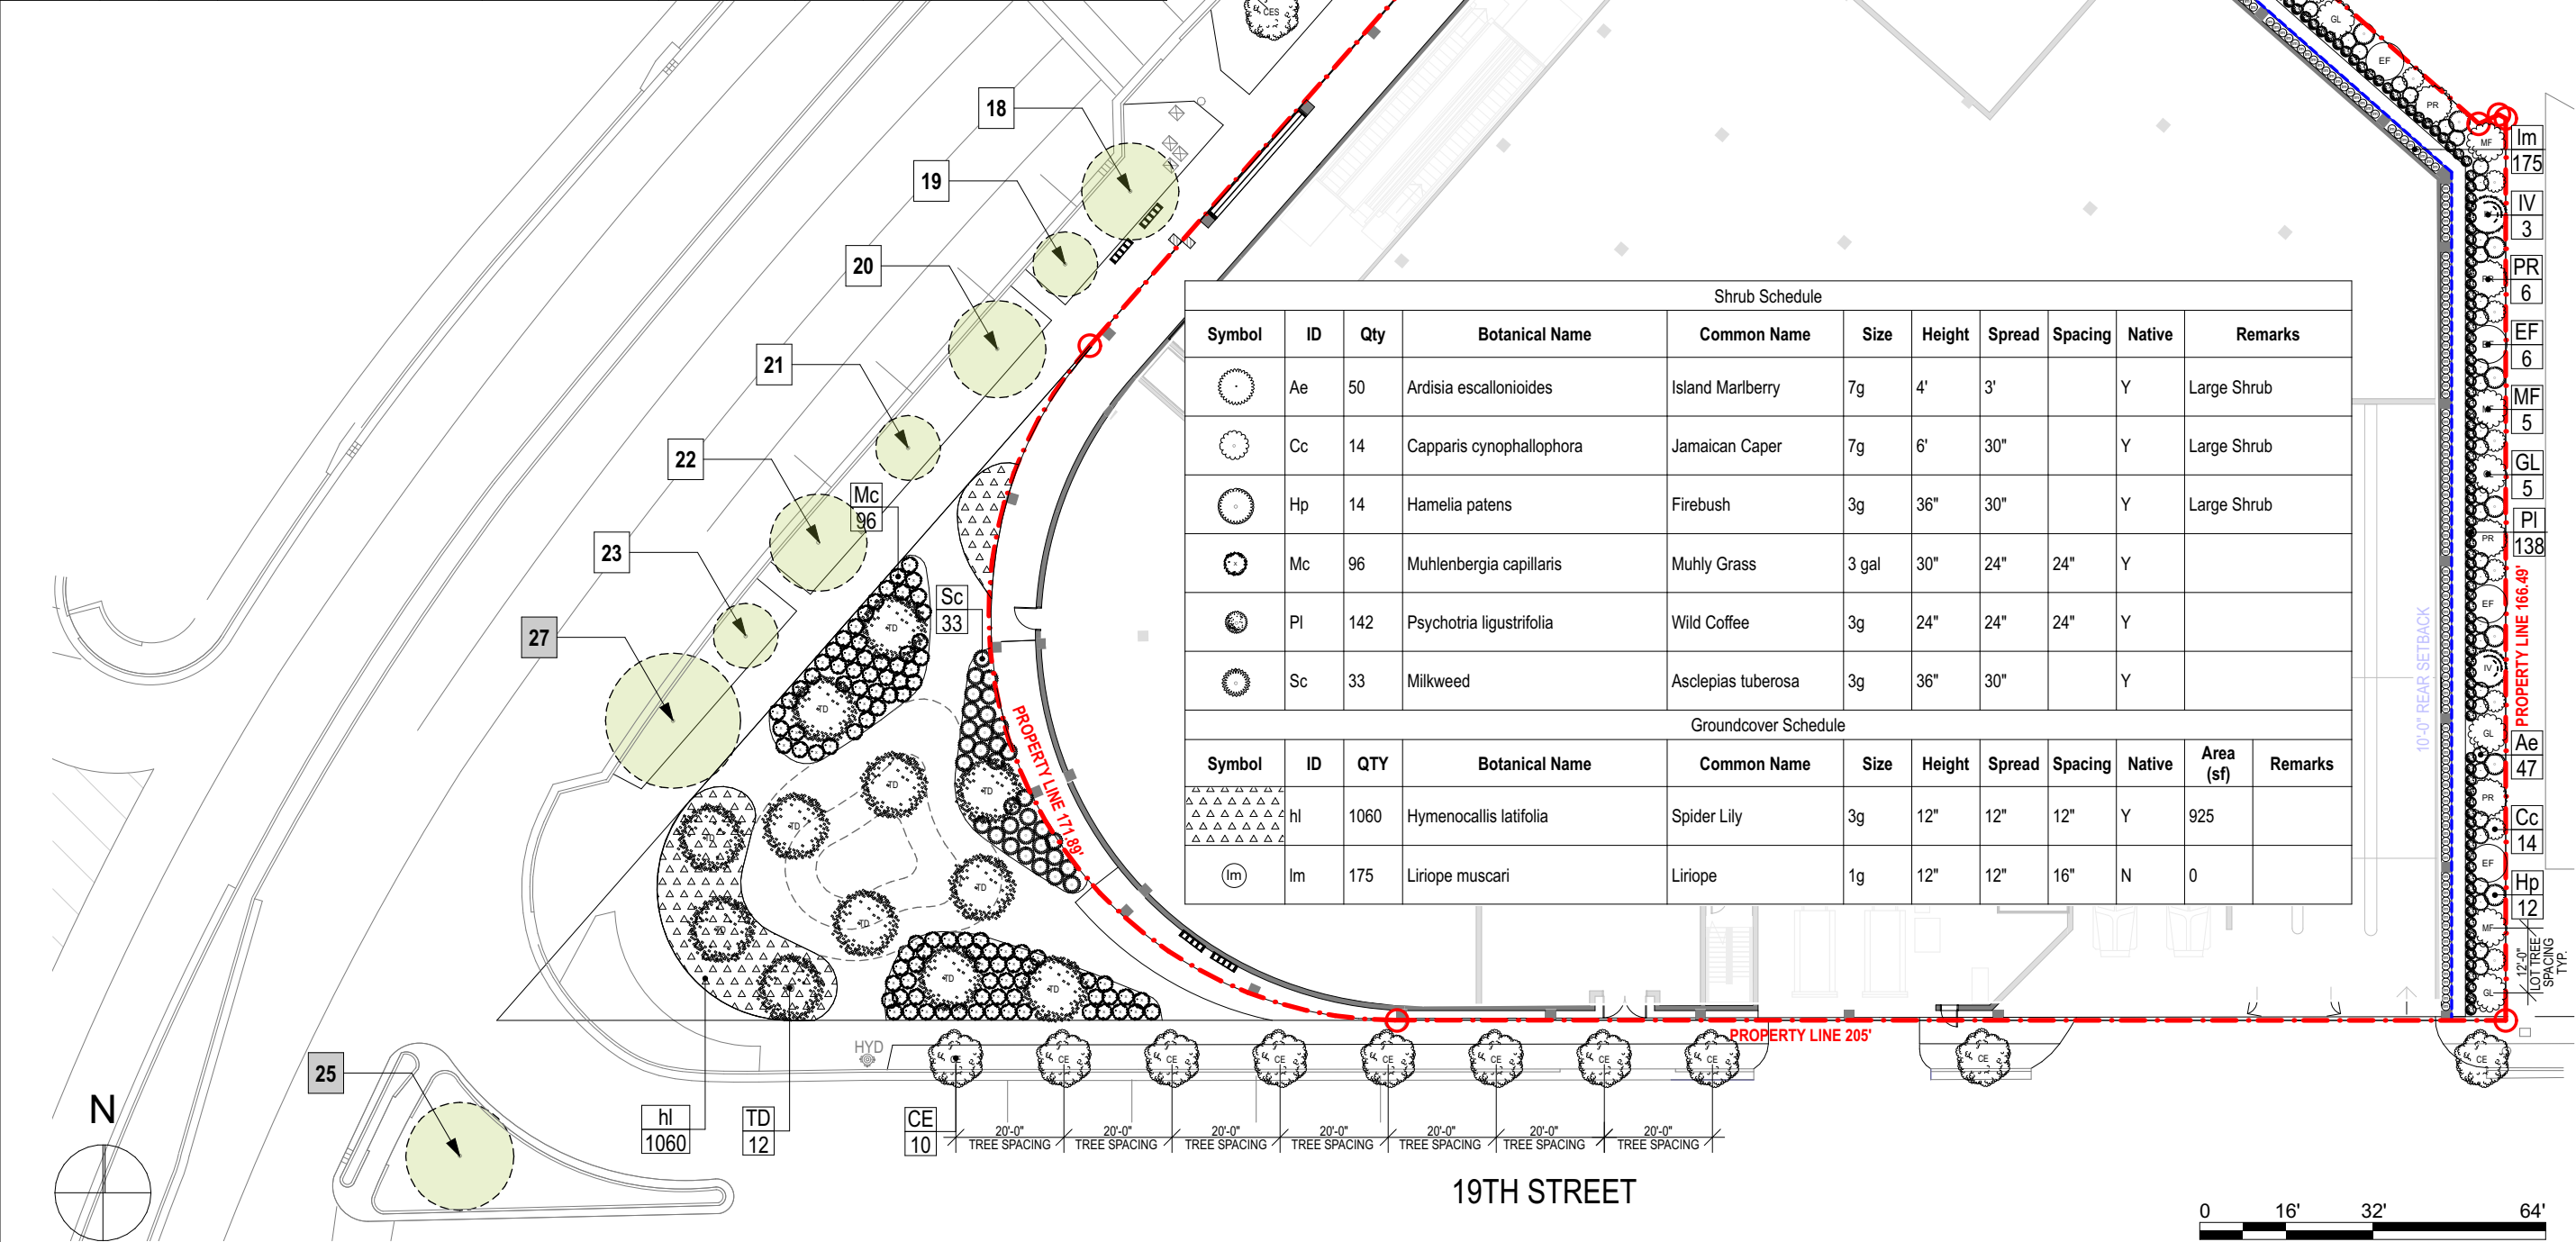

Tree Schedule									
Symbol	ID	Qty	Botanical Name	Common Name	DBH	Height	Spread	Native	Remarks
	CE	10	Conocarpus erectus	Green Buttonwood	4"	16' min	10'	Y	Florida Fancy - Street Tree - Standard Trunk
	CES	5	Conocarpus erectus 'serica'	Silver Buttonwood	4"	16' min	10'	Y	Florida Fancy - Street Tree - Standard Trunk
	EF	6	Eugenia foetida	Spanish Stopper	2"	12' min	7'	Y	Lot Tree
	GL	5	Gymnanthes lucida	Crabwood	2"	12' min	7'	Y	Lot Tree
	IV	3	Ilex vomitoria	Yaupon Holly	2"	12' min	7'	Y	Lot Tree
	MF	5	Myrcianthes fragrans	Simpson's Stopper	2"	12' min	7'	Y	Lot Tree
	PR	6	Pimenta racemosa	Bay Rum	2"	12' min	7'	Y	Lot Tree
	TD	12	Taxodium distichum	Bald Cypress	4"	16' min	10'	Y	Florida Fancy - Street Tree - Standard Trunk



Shrub Schedule											
Symbol	ID	Qty	Botanical Name	Common Name	Size	Height	Spread	Spacing	Native	Remarks	
	Ae	50	Ardisia escallonioides	Island Marberry	7g	4'	3'		Y	Large Shrub	
	Cc	14	Capparis cynophallophora	Jamaican Caper	7g	6'	30"		Y	Large Shrub	
	Hp	14	Hamelia patens	Firebush	3g	36"	30"		Y	Large Shrub	
	Mc	96	Muhlenbergia capillaris	Muhly Grass	3 gal	30"	24"	24"	Y		
	Pl	142	Psychotria ligustrifolia	Wild Coffee	3g	24"	24"	24"	Y		
	Sc	33	Milkweed	Asclepias tuberosa	3g	36"	30"		Y		
Groundcover Schedule											
Symbol	ID	QTY	Botanical Name	Common Name	Size	Height	Spread	Spacing	Native	Area (sf)	Remarks
	hl	1060	Hymenocallis latifolia	Spider Lily	3g	12"	12"	12"	Y	925	
	Im	175	Liriope muscari	Liriope	1g	12"	12"	16"	N	0	

STUDIO  
MCG  
ARCHITECTURE

7500 NE 4th Court  
Suite 102  
Miami, FL 33138  
T: (305) 573-2728

PROJECT NUMBER  
2314

PROJECT NAME  
WHOLE FOODS  
AND  
WELLS FARGO  
1901 ALTON ROAD  
MIAMI BEACH, FL 33141

OWNER  
CRESCENT HEIGHTS

FACADE ARCHITECT  
OPPENHEIM ARCHITECTURE  
AND DESIGN

DRAWING  
SITE  
PLANTING  
PLAN

JUSTINE VELEZ FLORIDA LIC# LA6667391  
ALL DRAWINGS AND WRITTEN MATERIAL APPEARING  
HEREIN CONSTITUTE THE ORIGINAL AND UNPUBLISHED  
WORK OF STUDIO MCG ARCHITECTURE AND  
MAY NOT BE DUPLICATED, USED OR DISCLOSED  
WITHOUT THE EXPRESS WRITTEN CONSENT OF  
STUDIO MCG ARCHITECTURE & PLANNING, INC. (c) 2020

SCALE: 1/32" = 1'-0"

DRAWN: AJ



CHECK: JV/DS

DATE: 10/02/23

SHEET NUMBER  
L200



2nd Level Tree Schedule									
Symbol	ID	Qty	Botanical Name	Common Name	DBH	Height	Spread	Native	Remarks
	AG	3	Annona glabra	Pond Apple Tree	2.5"	12'	6'	Y	Lot Tree
	ML	7	Polyalthia longifolia 'Upright'	Mast Tree		10'	4'	N	
	RM	24	Ravenala madagascariensis	Traveller Tree		15'	12'	N	
2nd Level Shrub Schedule									
Symbol	ID	Qty	Botanical Name	Common Name	Size	Height	Spread	Native	Remarks
	Am	13	Alocasia macrorrhiza	Black Stem Elephant Ear	7g			N	
	Ap	54	Alpinia purpurata 'Pink'	Pink Ginger	15g	5'		N	
	Cf	38	Cordyline fruticosa 'Pink Diamond'	Pink Diamond Cordyline	7 gal	30"	30"	N	
	Fl	26	Ficus lyrata	Fiddle Leaf Fig	7g			N	
	Hc	50	Heliconia caribaea x bihai 'Jacquinii'	Heliconia caribaea x bihai 'Jacquinii'	8"			N	
	Lc	43	Leea coccinea 'Rubra'	West Indian Holly	7g	36"	30"	N	Shrub
	Md	91	Monstera deliciosa	Swiss Cheese Vine	7g	4'	3'	N	
	Pg	195	Philodendron gloriosum	Philodendron gloriosum	3g	2'	2'	N	
	Re	12	Rhapis excelsa	Lady Palm		6'		N	Shade Grown

 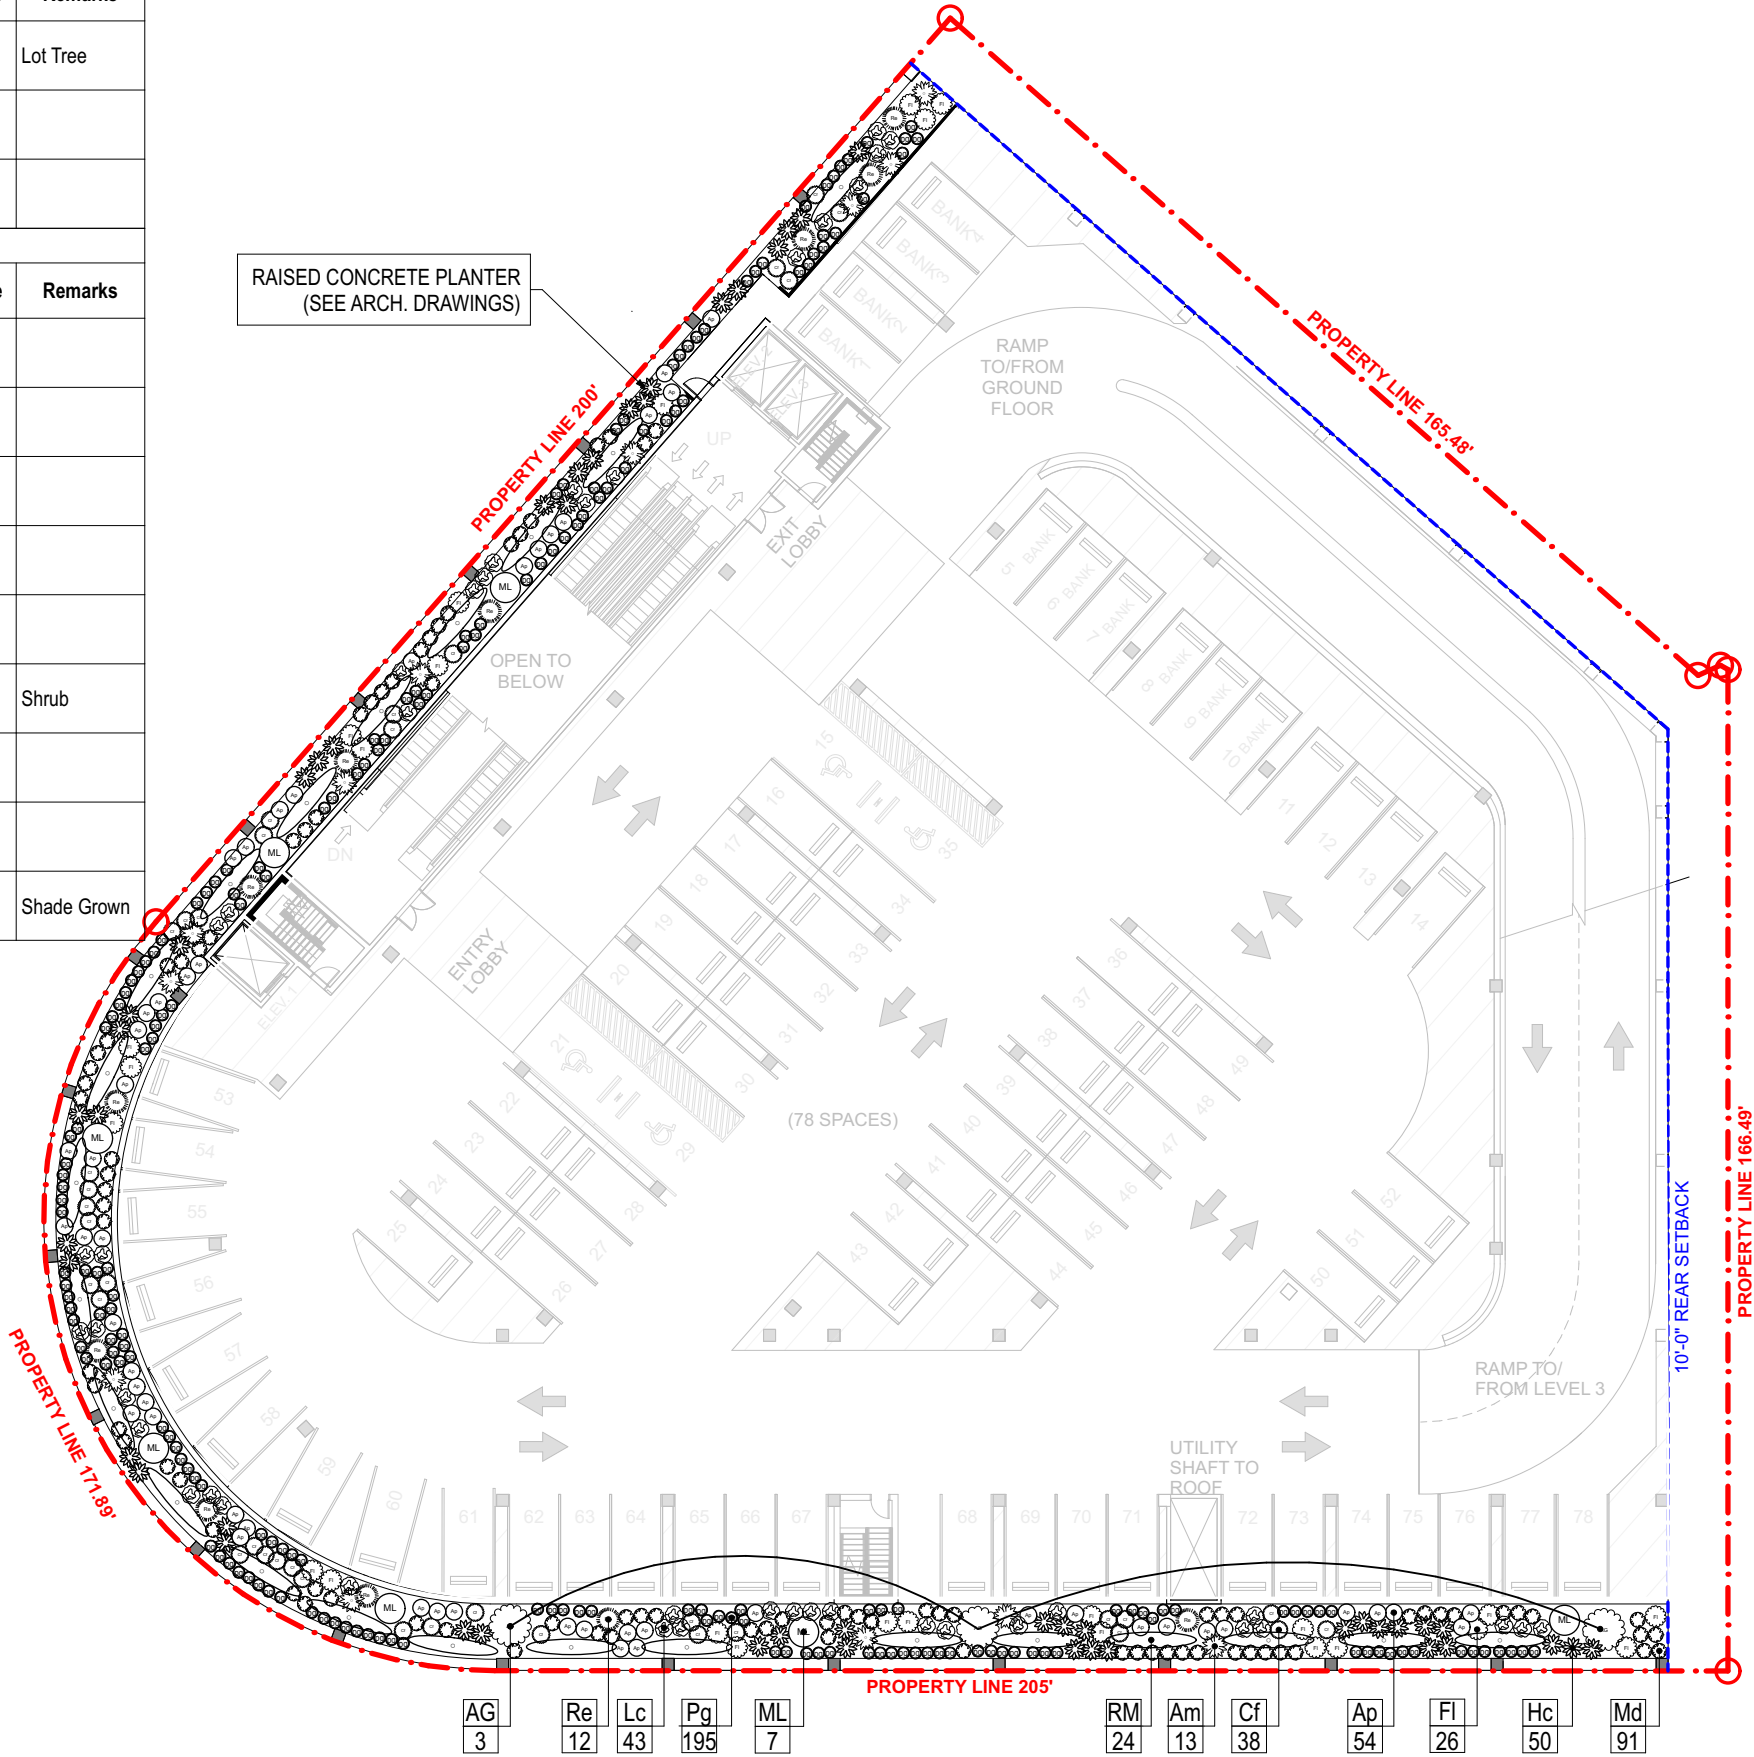

7500 NE 4th Court  
Suite 102  
Miami, FL 33138  
T: (305) 573-2728

PROJECT NUMBER  
2314

PROJECT NAME  
WHOLE FOODS  
AND  
WELLS FARGO  
1901 ALTON ROAD  
MIAMI BEACH, FL 33141

OWNER  
CRESCENT HEIGHTS

FACADE ARCHITECT  
OPPENHEIM ARCHITECTURE  
AND DESIGN

DRAWING

## 2ND LEVEL PLANTING PLAN

JUSTINE VELEZ FLORIDA LIC# LA6667391

ALL DRAWINGS AND WRITTEN MATERIAL APPEARING  
HEREIN CONSTITUTE THE ORIGINAL AND UNPUBLISHED  
WORK OF STUDIO MCG ARCHITECTURE AND  
MAY NOT BE DUPLICATED, USED OR DISCLOSED  
WITHOUT THE EXPRESS WRITTEN CONSENT OF  
STUDIO MCG ARCHITECTURE & PLANNING, INC. (c) 2020


SCALE: 1/32" = 1'- 0"

DRAWN: AJ


CHECK: JV/DS

DATE: 10/02/23


SHEET NUMBER  
L201

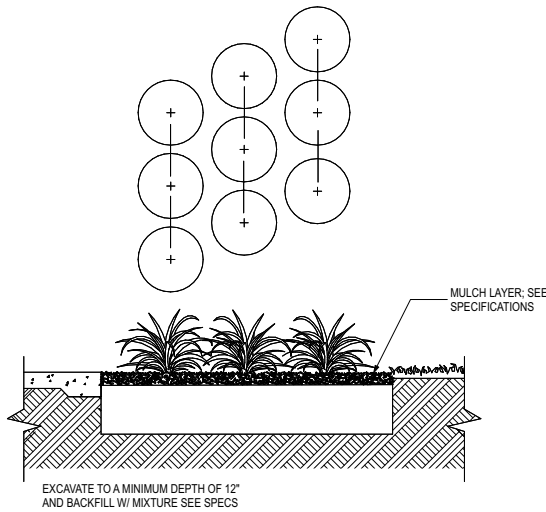


5  
L202  
GROUNDCOVER SPACING DETAIL  
NOT TO SCALE

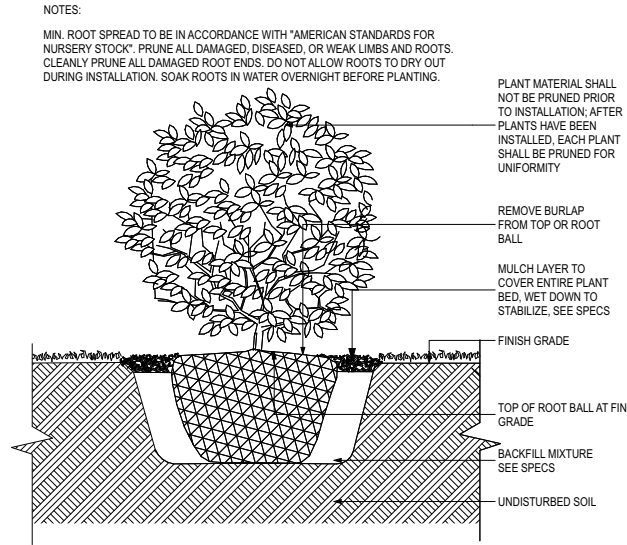


4  
L202  
SHRUB DETAIL  
NOT TO SCALE

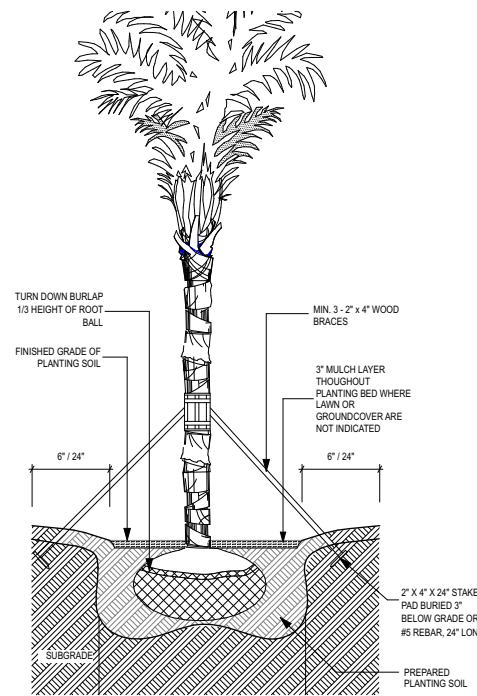

3  
L202  
PALM PLANTING DETAIL  
NOT TO SCALE

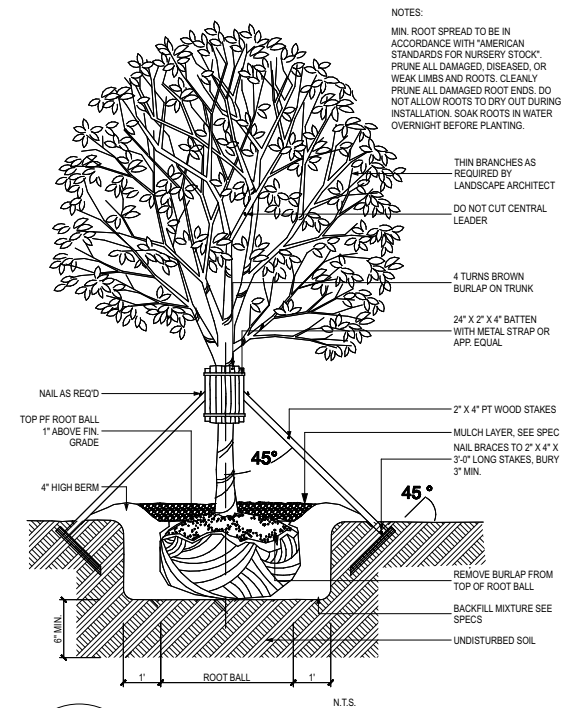


2  
L202  
LARGE TREE STAKE DETAIL  
NOT TO SCALE

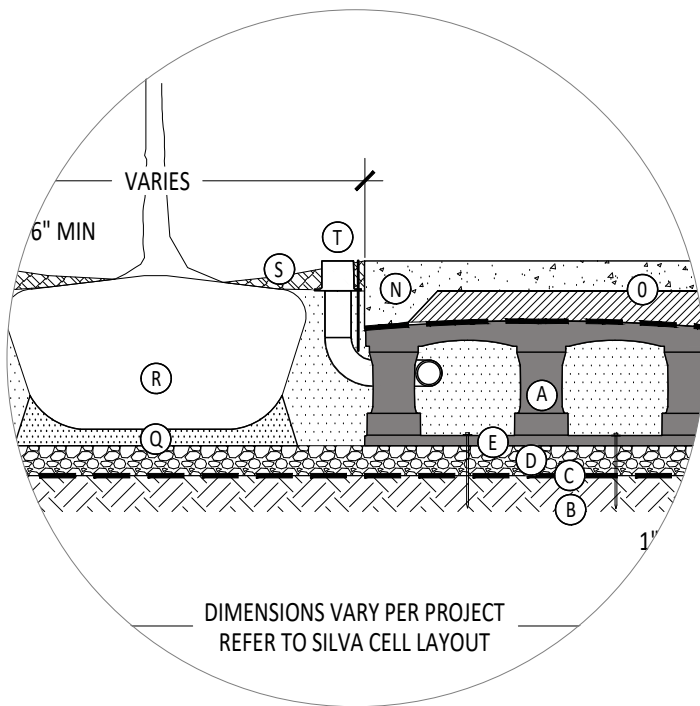



1A  
L202  
TYPICAL SILVA CELL DETAIL  
NOT TO SCALE

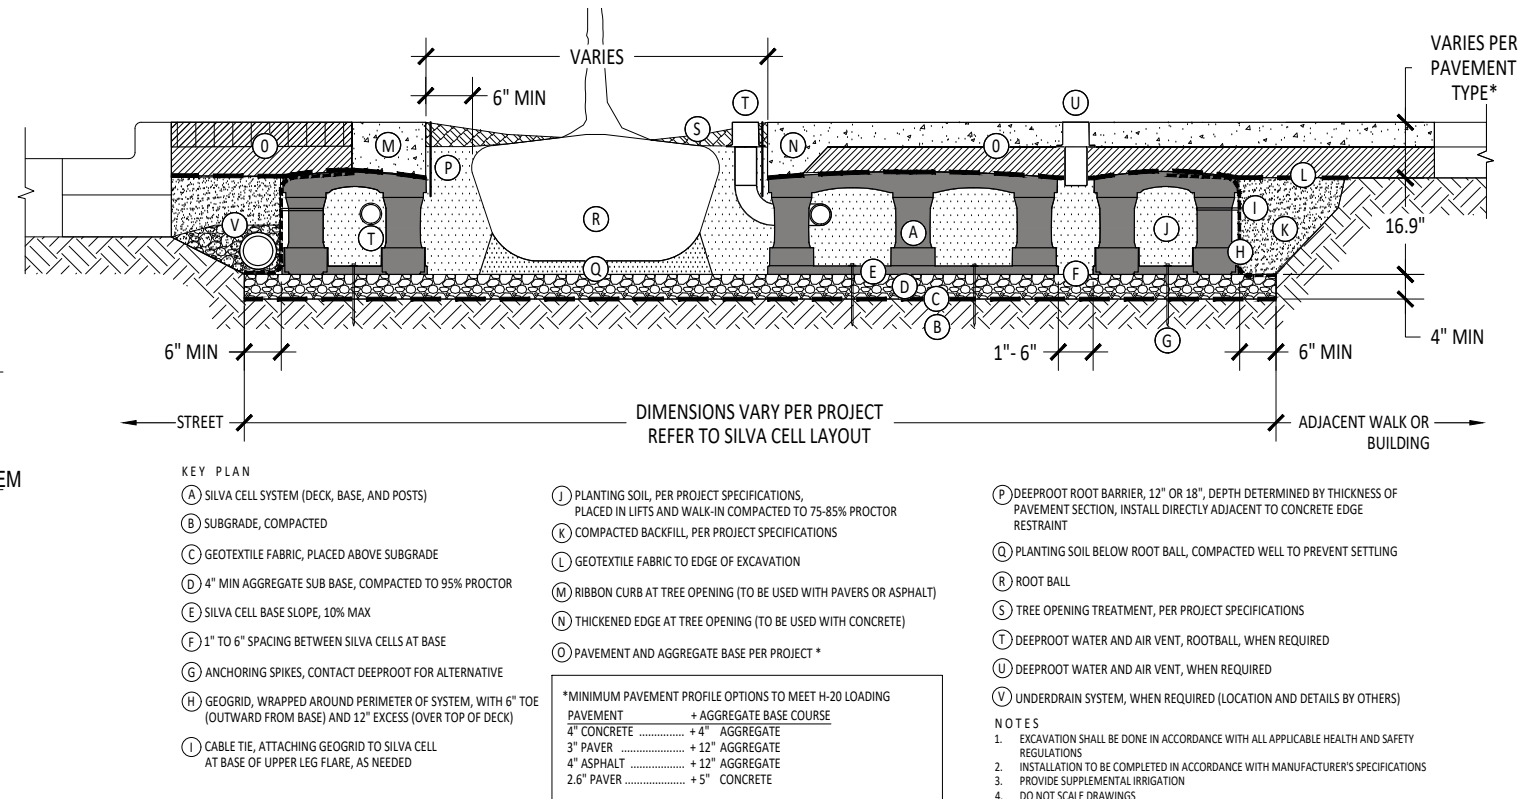ALTON RD 6.75' NGVD 5.20' NAVD	19TH STREET 5.75' NGVD 4.20' NAVD
TOP OF SUSPENDED PAVEMENT SYSTEM 6.08' NGVD 4.53' NAVD	5.08' NGVD 3.53' NAVD
BOTTOM OF SUSPENDED PAVEMENT SYSTEM 4.68' NGVD 3.13' NAVD	3.68' NGVD 2.13' NAVD



1  
L202  
TYPICAL SILVA CELL DETAIL  
NOT TO SCALE



LIGHTING LEGEND				
IMAGE	SYMBOL	MANUFACTURER	MODEL	QUANTITY
		Louis Poulsen	Albertslund Maxi Post	13

