


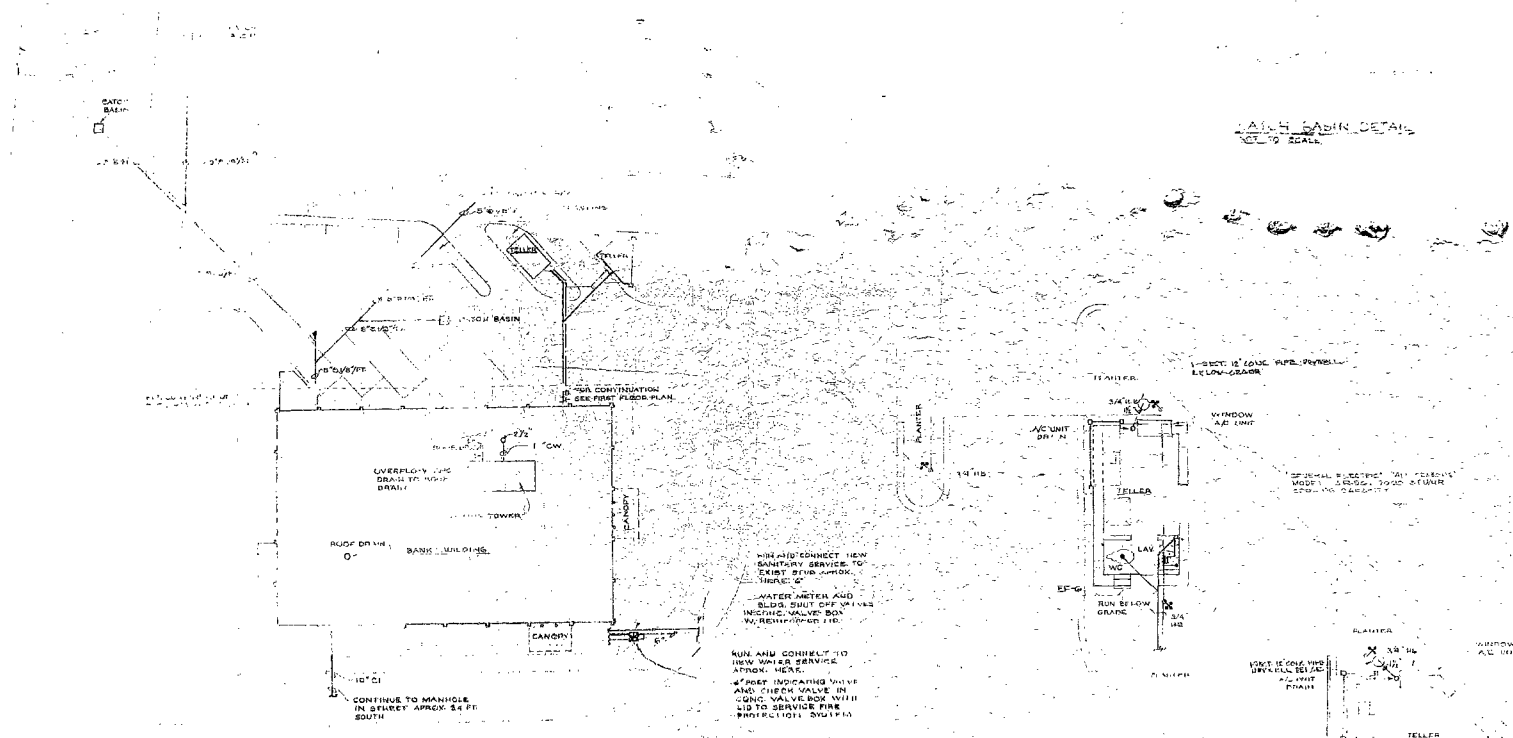




P.C.A. FLOOR DRAIN SAFEWASTE DETAIL
NO. 10 SCALE

PLOT PLAN
SCALE: 1/8" = 1'-0"

WASH BASIN DETAIL
1/4" = 1'-0" SCALE


JEFFERSON NATIONAL BANK
MIAMI BEACH, FLORIDA
CHARLES GILLER & ASSOCIATES
ARCHITECTS & ENGINEERS
4100 NO. MIAMI AVE.
MIAMI, FLA.

702
70243

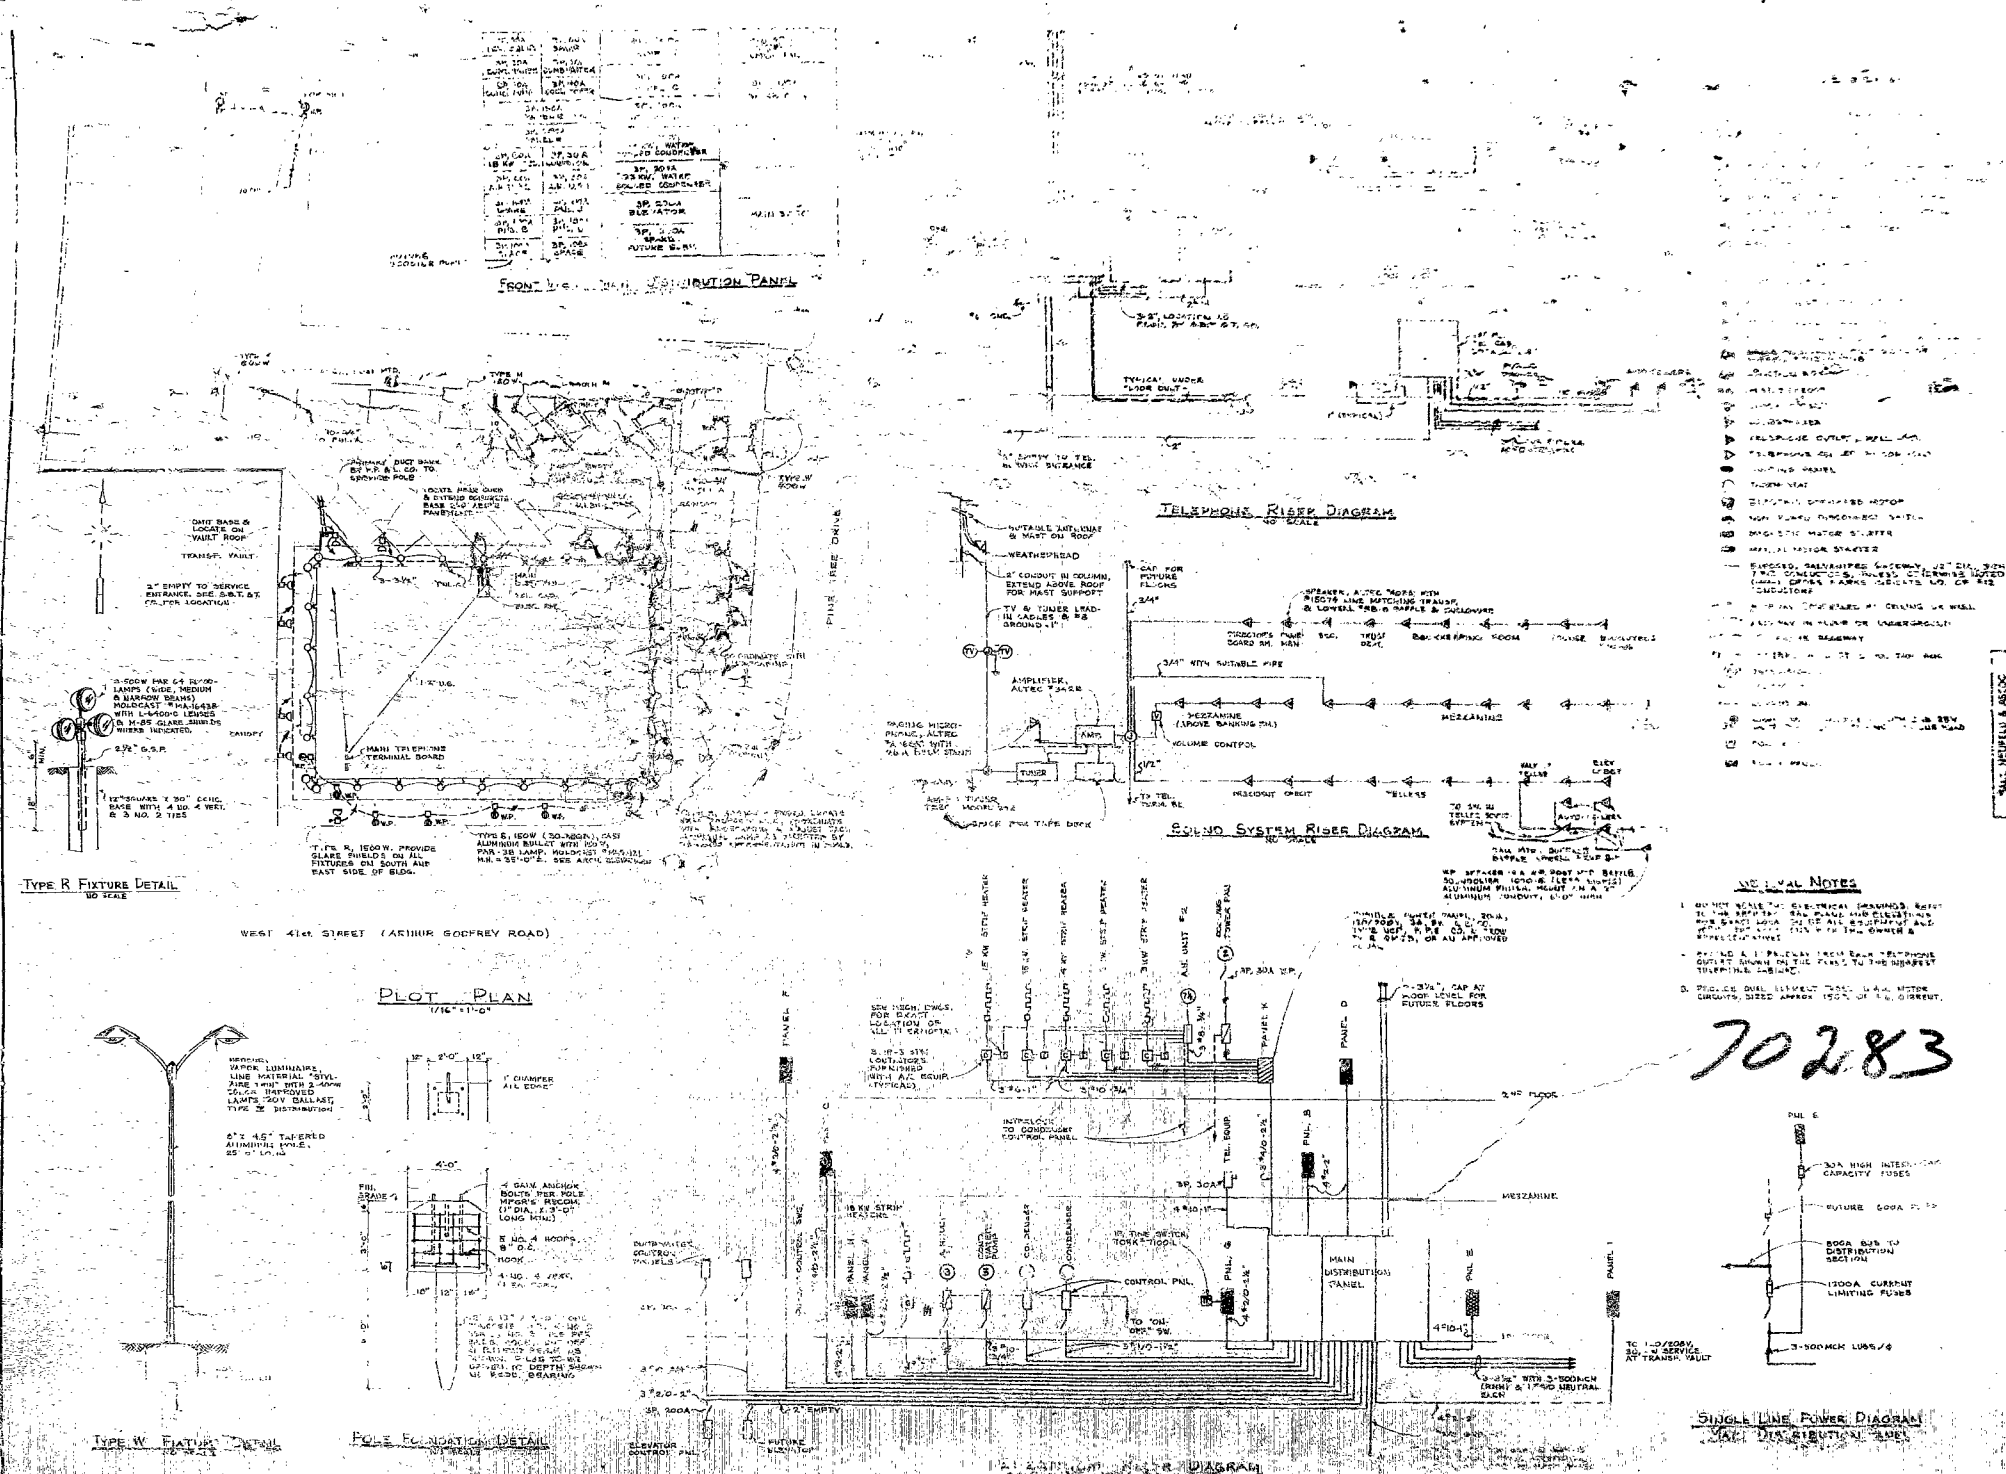


CHARLES J. JILBERT & ASSOCIATES
ARCHITECTS
JEFFERSON NATIONAL BANK
MIAMI BEACH
FLORIDA


70283

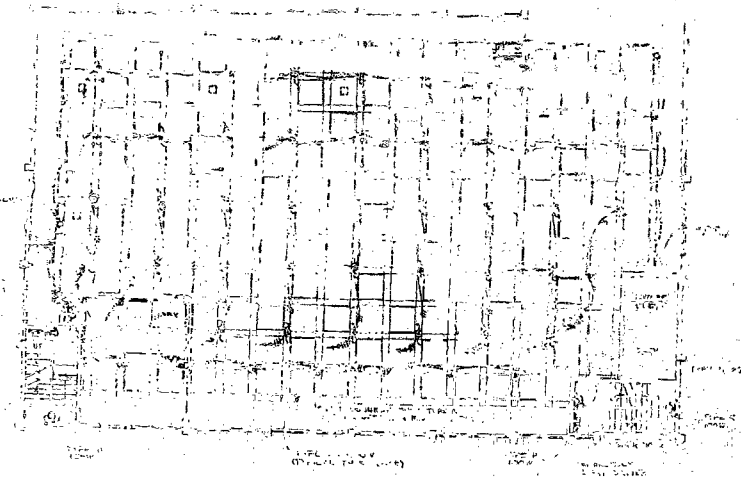



1st FLOOR PLAN

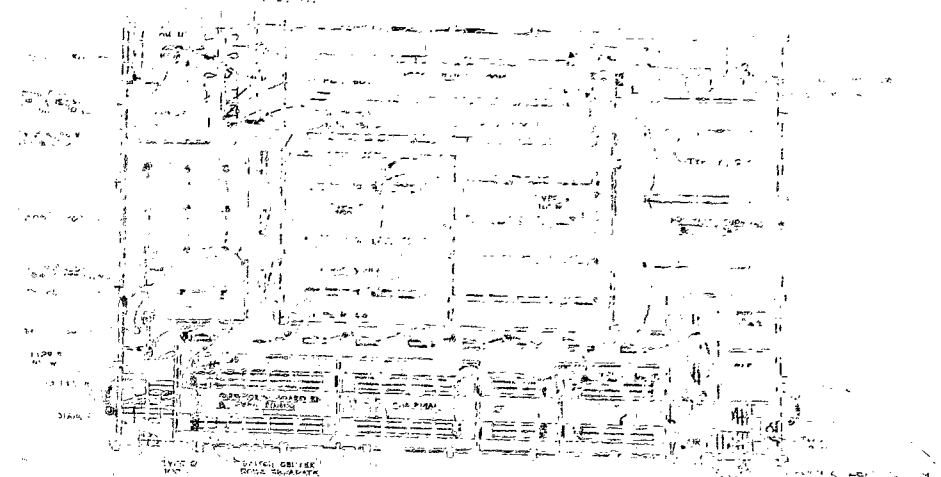



2nd FLOOR PLAN

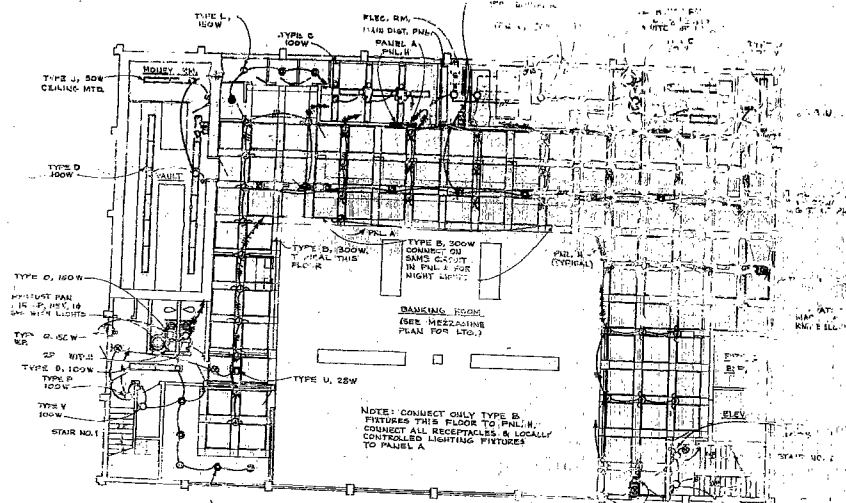

1st FLOOR LIGHTING PLAN

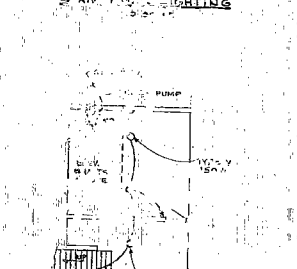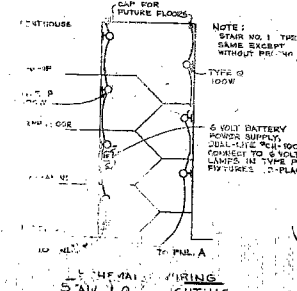


2nd FLOOR LIGHTING PLAN

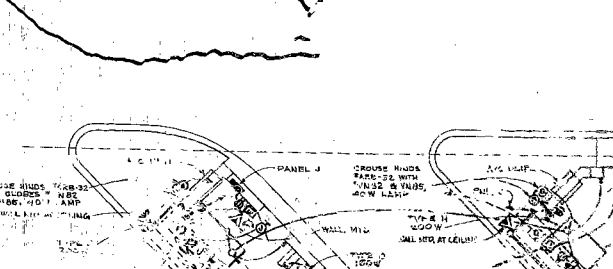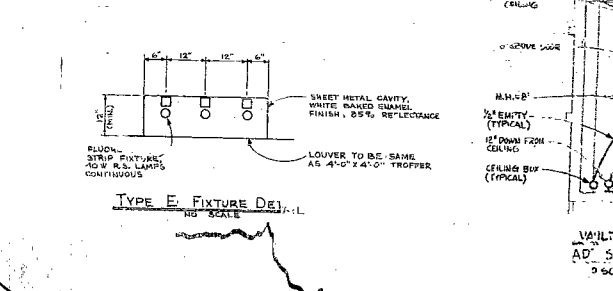


2nd FLOOR LIGHTING PLAN


JEFFERSON NATIONAL UNIVERSITY
 CHARLES GILBERT A. SUTHERLAND
 ARCHITECTS & ENGINEERS
 100 N. 1st St.
 PHILADELPHIA, PA.

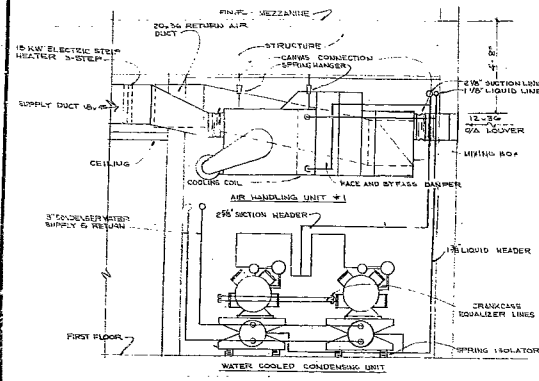


SECTION 'A-A'
SCALE: 1/2\"/>

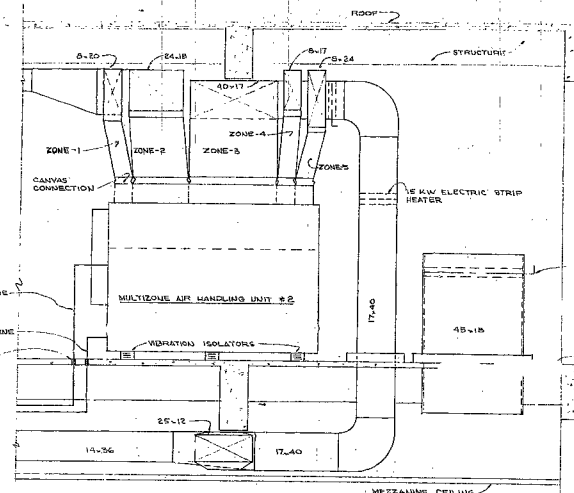


SECTION 'B-B'
SCALE: 1/2\"/>

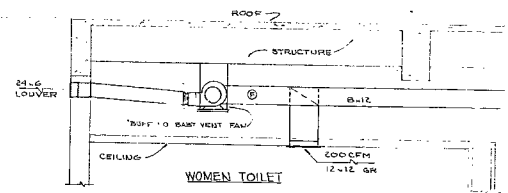

SECTION 'C-C'
SCALE: 1/2\"/>

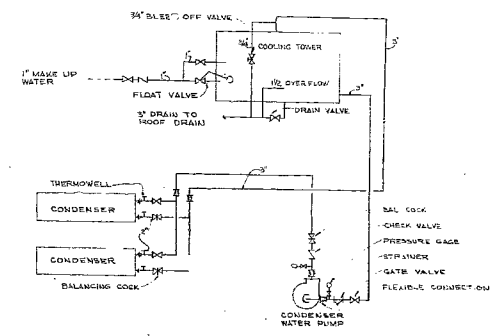

CONDENSER WATER PIPING DIAGRAM
NOT TO SCALE

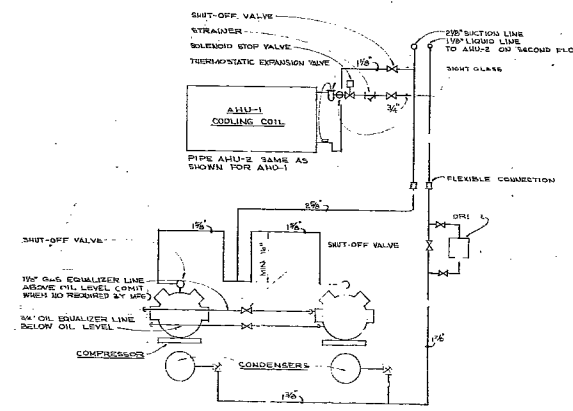

REFRIGERANT PIPING DIAGRAM
NOT TO SCALE

AIR HANDLING UNIT SCHEDULE																			
AIR HANDLING UNIT NO.	LOCATION	"CARRIER" MODEL	TYPE	DEHUMIDIFIED A.R. CFM	FUSED RY-PASS CFM	OUT-IDE CFM	TOTAL SUPPLY CFM	ROOM SENSIBLE HEAT BTU/HR	STAD-BTU/HR	INTERIOR AIR TEMP. °F DB WB DB WB	LEAVING AIR TEMP. °F DB WB DB WB	EXTERNAL STATIC PRESS. IN. OF H ₂ O	MAN. COIL FACE VEL. FPM	REFRIG. TON	FAN MOTOR HP	ELECTRICAL CHARACTERISTICS	REMARKS		
AHU-1	FIRST FLOOR	38AC-7	HORIZONTAL	3200	1000	400	2200	80,300	180,000	85.2 70.5 56.0 55.1	70.5 68.0 56.0 55.1	1/2	500	42	3	208/60/3	SINGLE ZONE WITH FAN AND REVERSE DAMPER		
AHU-2	SECOND FLOOR	38W-10	VERTICAL	10,300	1800	1500	11,800	222,600	500,000	85.2 85.0 58.0 56.7	70.5 69.0 56.0 56.7	3/8	550	42	7 1/2	208/60/3	MULTIZONE (SEE DRAWING 104-2-40-1)		
NOTE: *EXTRA REPAIRS. SEE P. 40-ADDITIONAL																			

NOTE: FAN DRIVERS SHALL BE ADJUSTED AS REQUIRED TO DELIVER THE SPECIFIED CFM AGAINST THE STATIC PRESSURE OF THE SYSTEM AS ACTUALLY INSTALLED.

(2) CONDENSING UNIT SCHEDULE									
COMPRESSOR "CARRIER" MODEL	CONDENSER "CARRIER" MODEL	SECTION TEMP. °F DB WB	CAPACITY TONS	WATER GPM	CONDENSER WATER PUMP GPM	FILLING FACTOR	MAX. PRESS. PSIG	POWER HP/1/2	ELECTRICAL CHARACTERISTIC
GL-40	EG-65	40	24.5	86	75	.001	15	22.8	208/60/3

COOLING TOWER DATA						
MODEL	WATER FLOW GPM	ENTERING WATER TEMP. °F	LEAVING WATER TEMP. °F	DESIGN WET-BULB °F	FAN MOTOR HP	ELECTRICAL CHARACTERISTIC
CT-50	150	86	86	79	2	208/60/3


CONDENSER WATER PUMP DATA						
ALLIS CHAMBERS SIZE	WATER FLOW GPM	TOTAL DYNAMIC HEAD FT	MIN. % EFF.	MOTOR RPM	MOD. # H.P.	ELECTRICAL CHARACTERISTIC
L-2XB	150	46	77	1760	3	208/60/3


FAN SCHEDULE									
FAN NO.	SERVICE	MANUFACTURER	MODEL	CFM	STATIC PRESS. IN. OF H ₂ O	FAN RPM	WATER PUMP	WATER PUMP	ELECTRICAL CHARACTERISTIC
EF-1	TOILET EXHAUST	"BUFFALO"	BARY VENT	200	1/4	1760	1/10	1/10	115/60/1
EF-2	TOILET EXHAUST	"BUFFALO"	BARY VENT	100	1/4	1760	1/10	1/10	115/60/1
EF-3	TOILET EXHAUST	"BUFFALO"	BARY VENT	400	1/4	1760	1/10	1/10	115/60/1
EF-4	TOILET EXHAUST	"BUFFALO"	BARY VENT	300	1/4	1760	1/10	1/10	115/60/1
EF-5	TOILET EXHAUST	"BUFFALO"	BARY VENT	1100	1/8	1160	1/6	1/6	115/60/1
EF-6	TOILET EXHAUST	"BUFFALO"	BARY VENT	800	1/8	1160	1/6	1/6	115/60/1
EF-7	TOILET EXHAUST	"BUFFALO"	BARY VENT	400	1/4	1760	1/10	1/10	115/60/1

CHARLES GILLER & ASSOCIATES
ARCHITECTS & ENGINEERS
4100 NO. MIAMI AVE.
MIAMI, FLA.


JEFFERSON NATIONAL BANK
MIAMI BEACH
SECTION, DIAGRAMS & SCHEDULES

70283

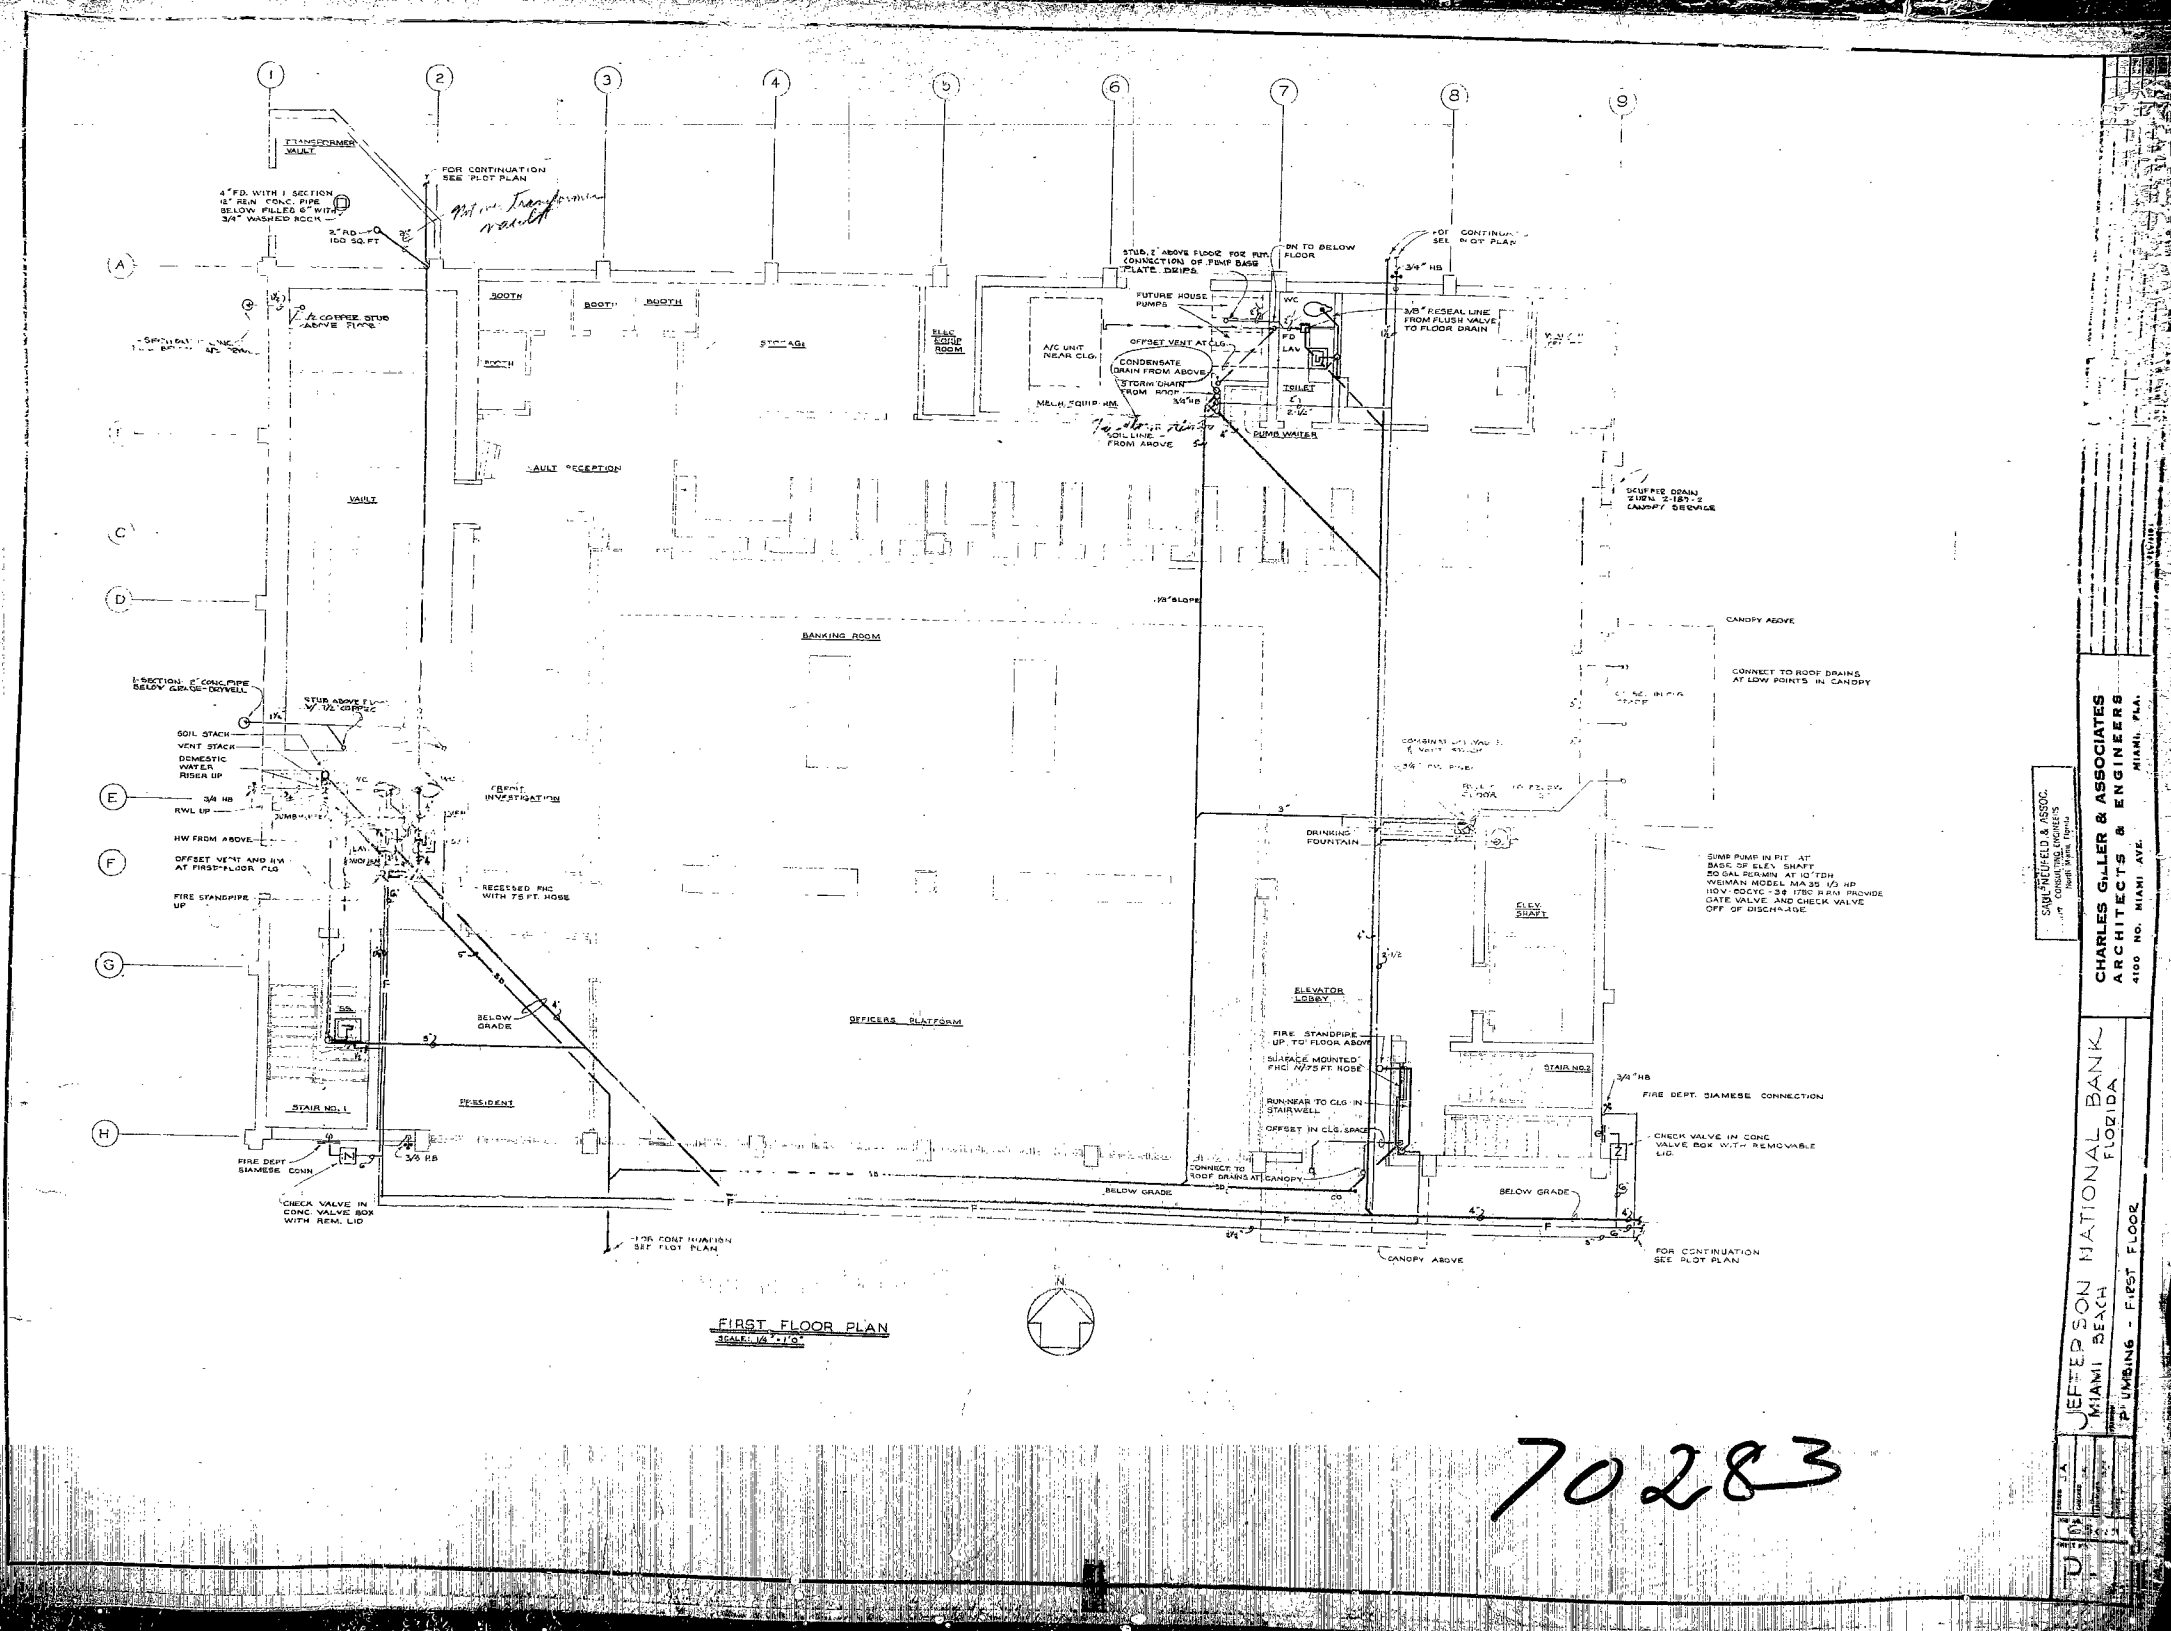

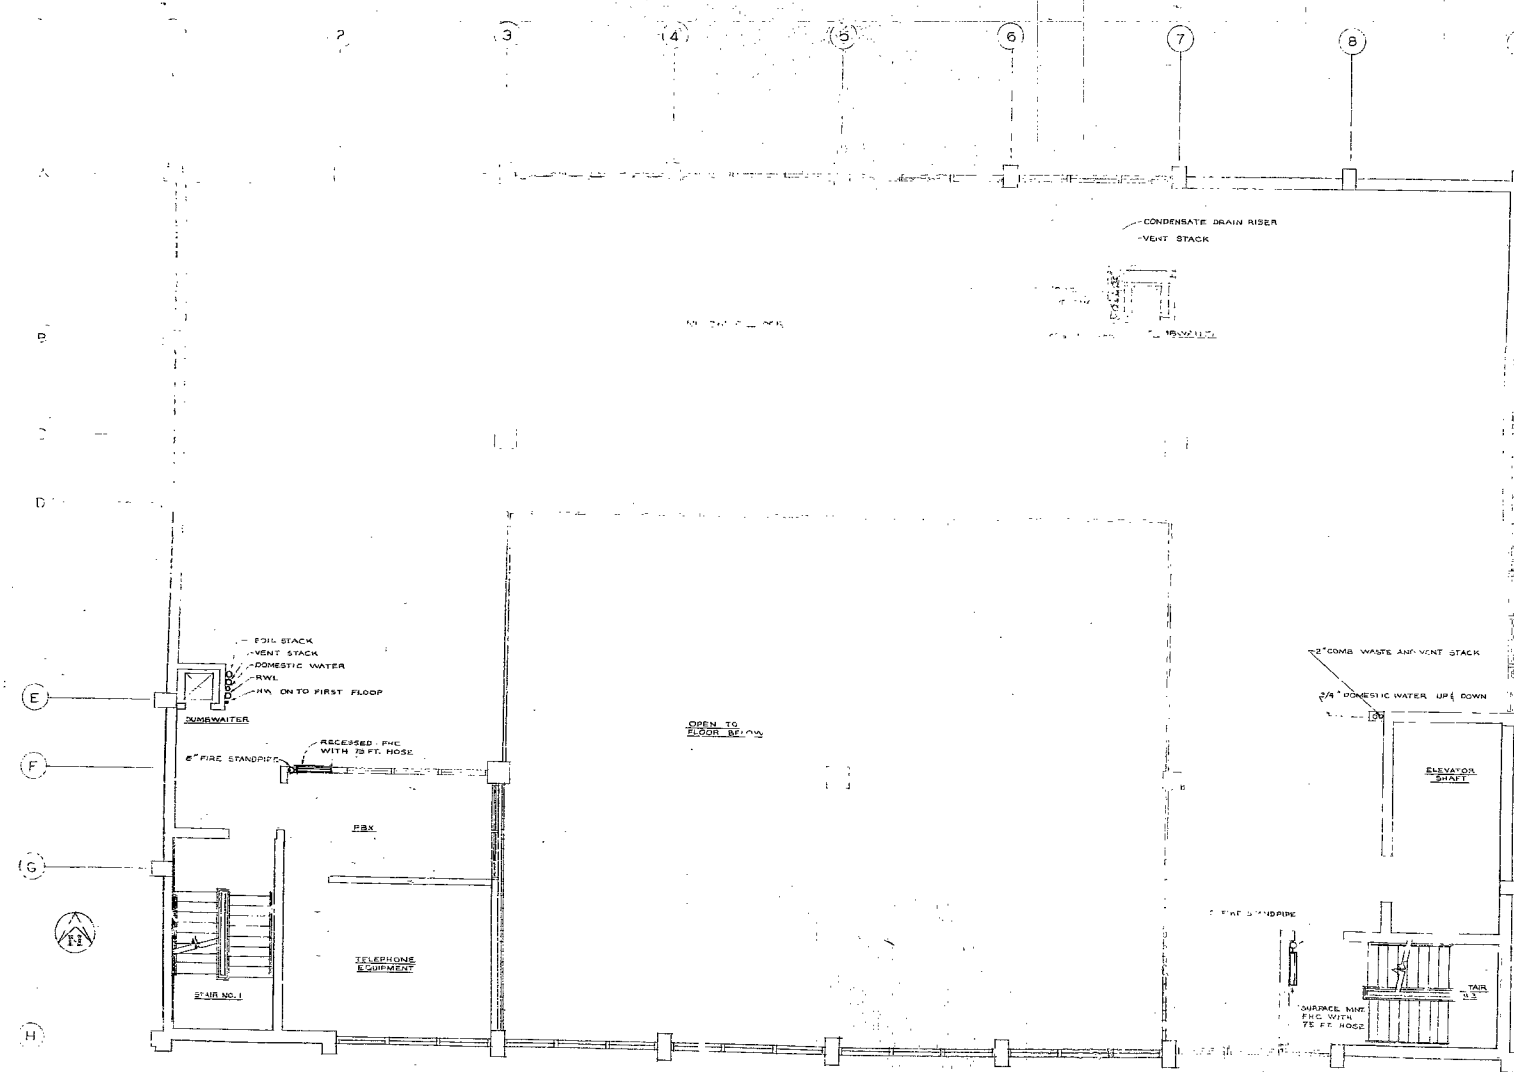

 MEZZANINE FLOOR PLAN
SCALE: 1/8" = 1'-0"




70283

JEFFERSON NATIONAL BANK
MAY 1934
P. 2

CHARLES GILLER & ASSOCIATES
ARCHITECTS & ENGINEERS
4006 NO. MIAMI AVE. MIAMI, FLA.

MEZZANINE PLAN

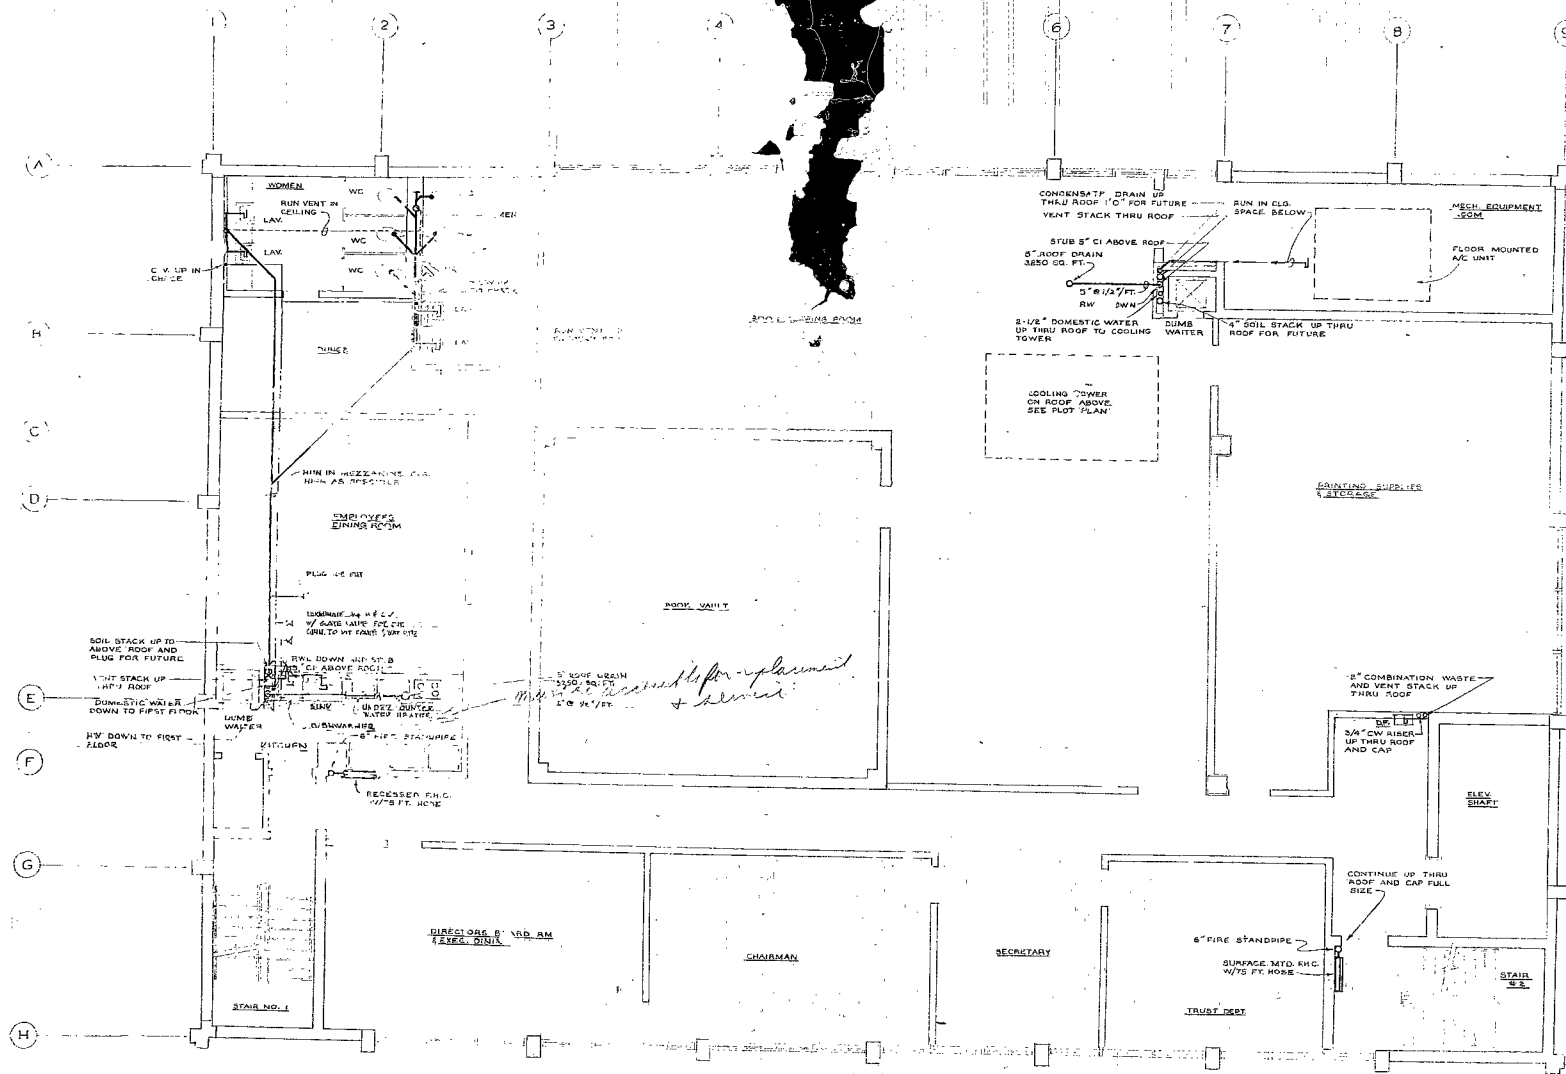


SECOND FLOOR PLAN
SCALE: 1/8" = 1'-0"

CHARLES GILLER & ASSOCIATES
ARCHITECTS & ENGINEERS
4100 N.W. MIAMI AVE.
MIAMI, FLA.

JEFFERSON NATIONAL BANK
MIAMI BEACH, FLORIDA
PLUMBERS - SECOND FLOOR


70283

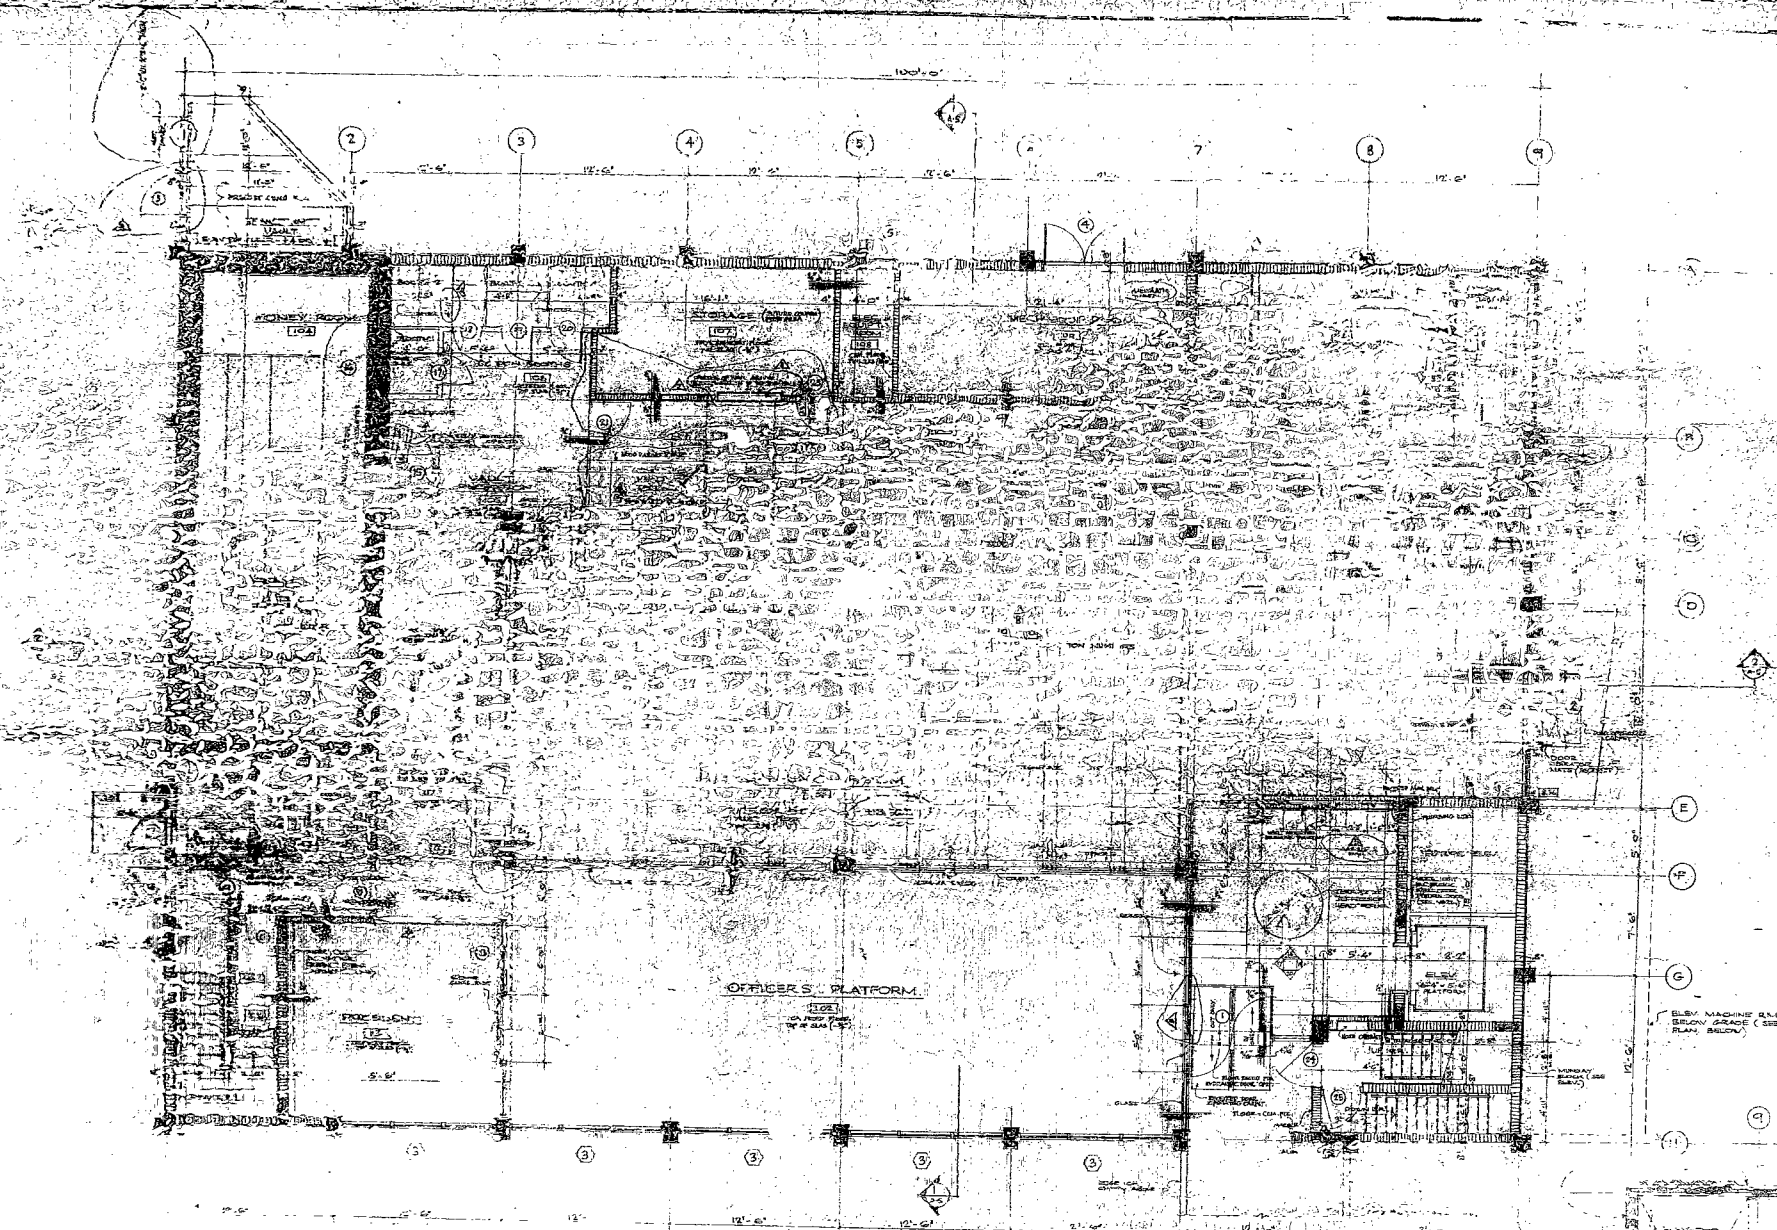

FIRST FLOOR PLAN


70233

NOTE: THIS PLAN IS FOR THE PURPOSE OF ILLUSTRATION ONLY AND IS NOT TO BE USED FOR CONSTRUCTION PURPOSES.

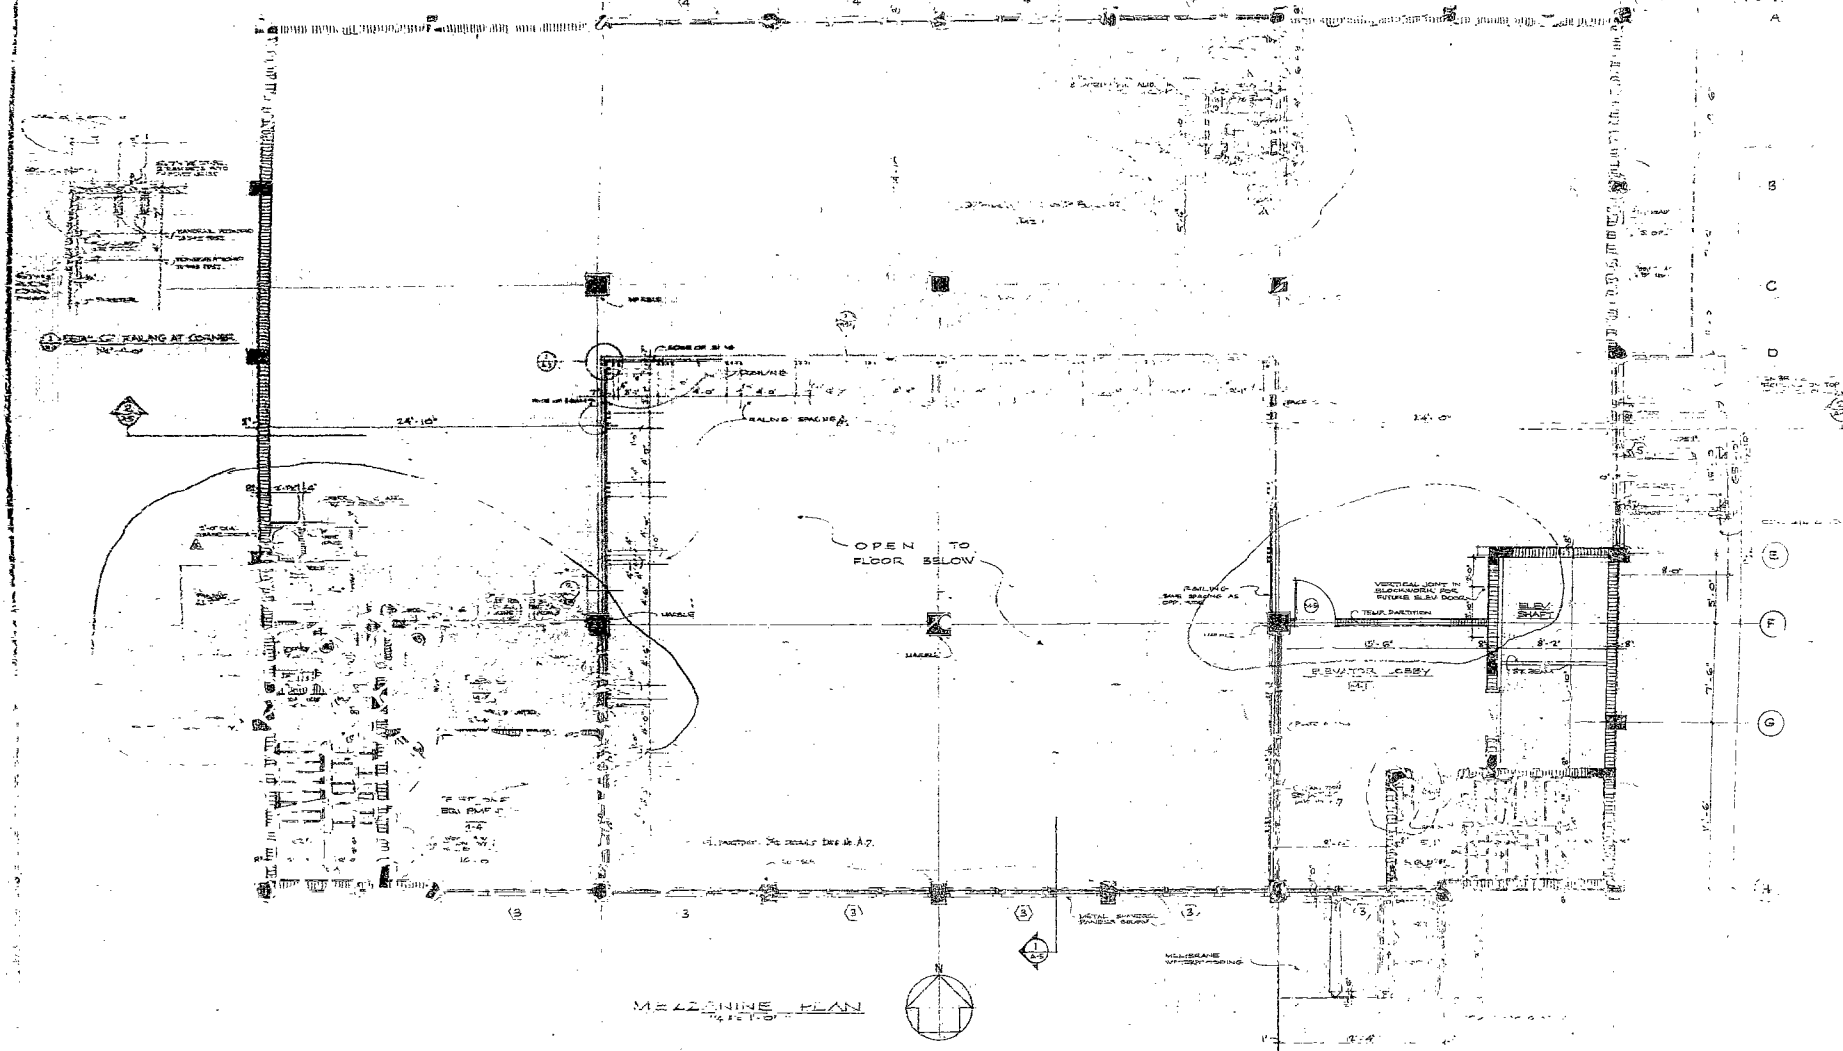

70283

CHARLES GILLER & ASSOCIATES
ARCHITECTS & ENGINEERS
3100 N.W. 11th Ave.
MIAMI, FLA.

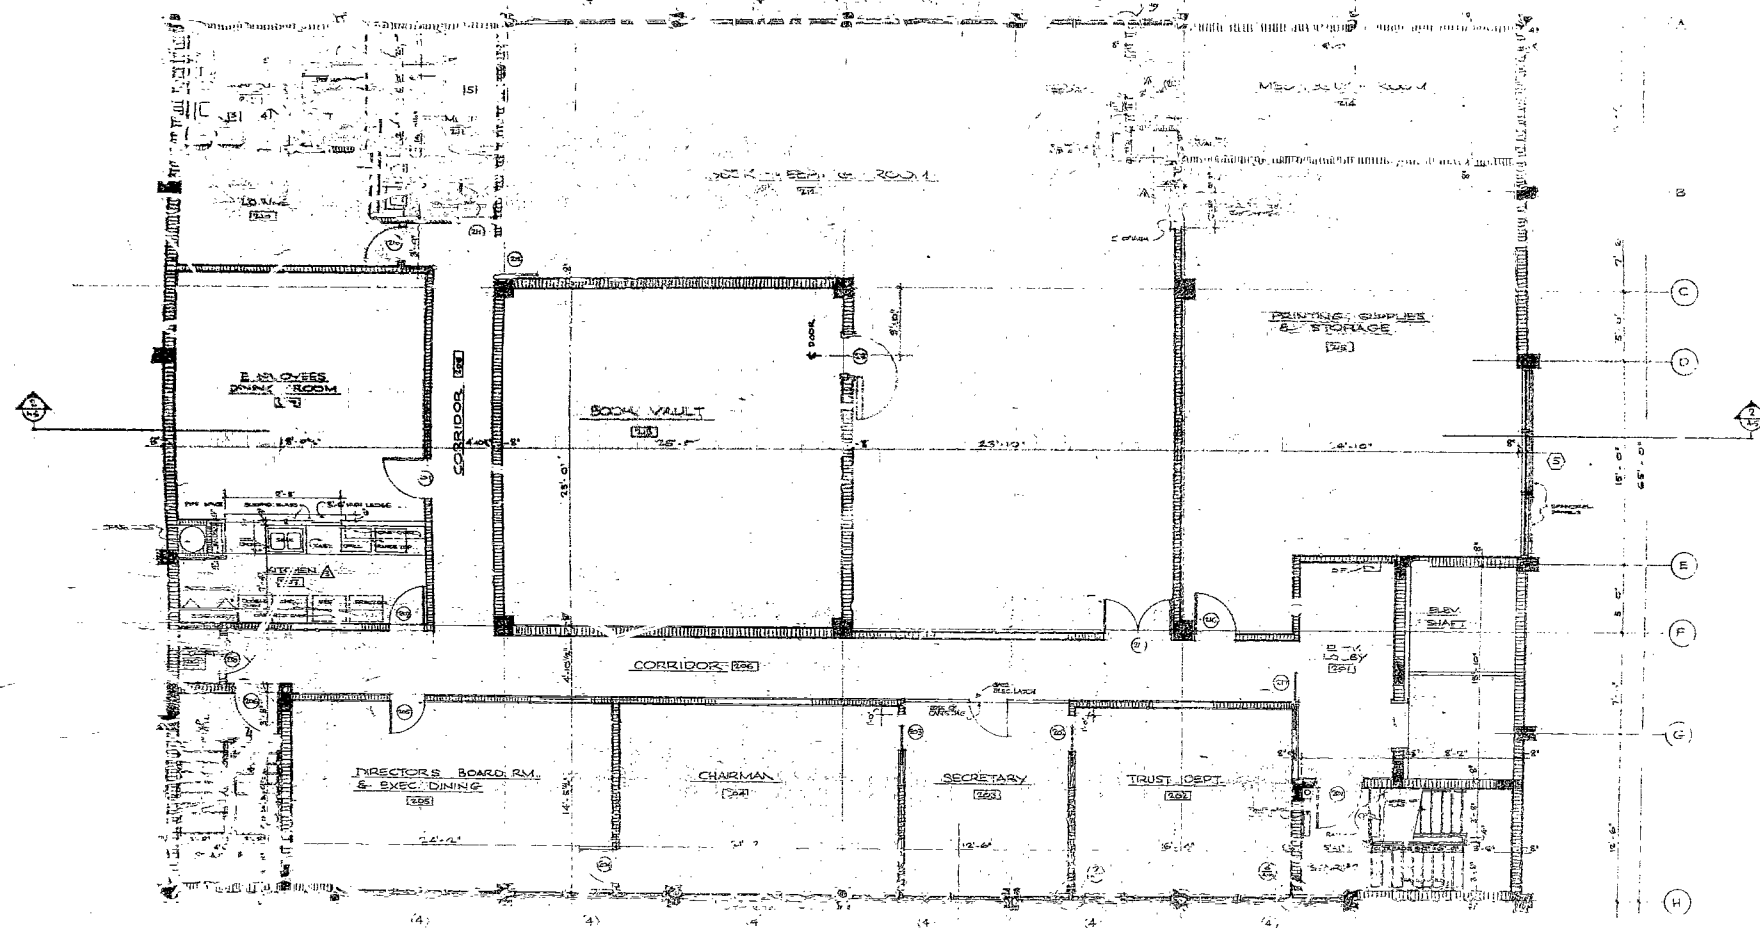

SECOND FLOOR PLAN

70203

PETERSON NATIONAL BANK
FLORIDA
CHARLES GILLER & ASSOCIATES
ARCHITECTS & ENGINEERS
4500 N.W. MIAMI AVE.
MIAMI, FLA.



NOTE: tapen 8-5 to 5" deep at base

[illegible]

FOUNDATION PLAN
SCALE 1/4" = 1'-0"

ROOF FRAMING PLAN
SCALE 1/4" = 1'-0"

SECTION S-4
SCALE 1/2" = 1'-0"

SECTION S-5
SCALE 1/2" = 1'-0"

SECTION S-6
SCALE 3/4" = 1'-0"

SECTION S-
SCALE 3/4" = 1' - 0"

AUTO TELLERS BOOTHS


CHARLES GILLER & ASSOCIATES
ARCHITECTS & ENGINEERS
3100 NO. MIAMI AVE.


LEFFERSON NATIONAL BANK
MIAMI BEACH
FLORIDA
WIT: TELLER'S BOOTHS - FLOOR & POSE SEALING

DATE	10-10-68
TIME	10:00
BY	DRG
FOR	DRG
APPROVED	
SIGNATURE	
REMARKS	


S-8

70283

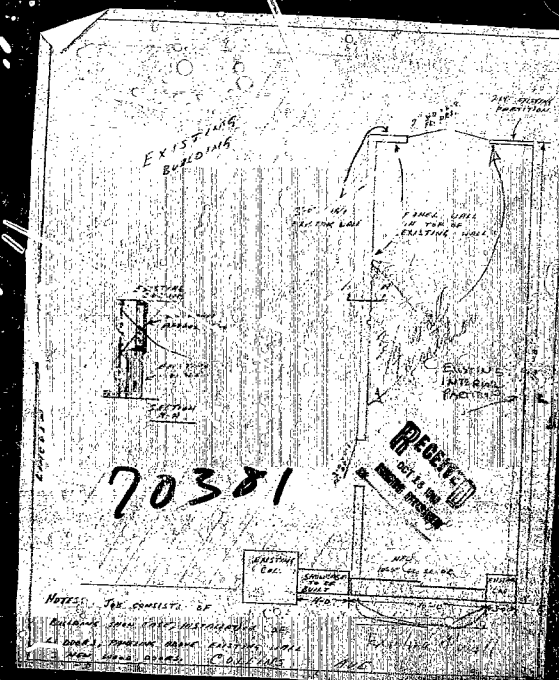


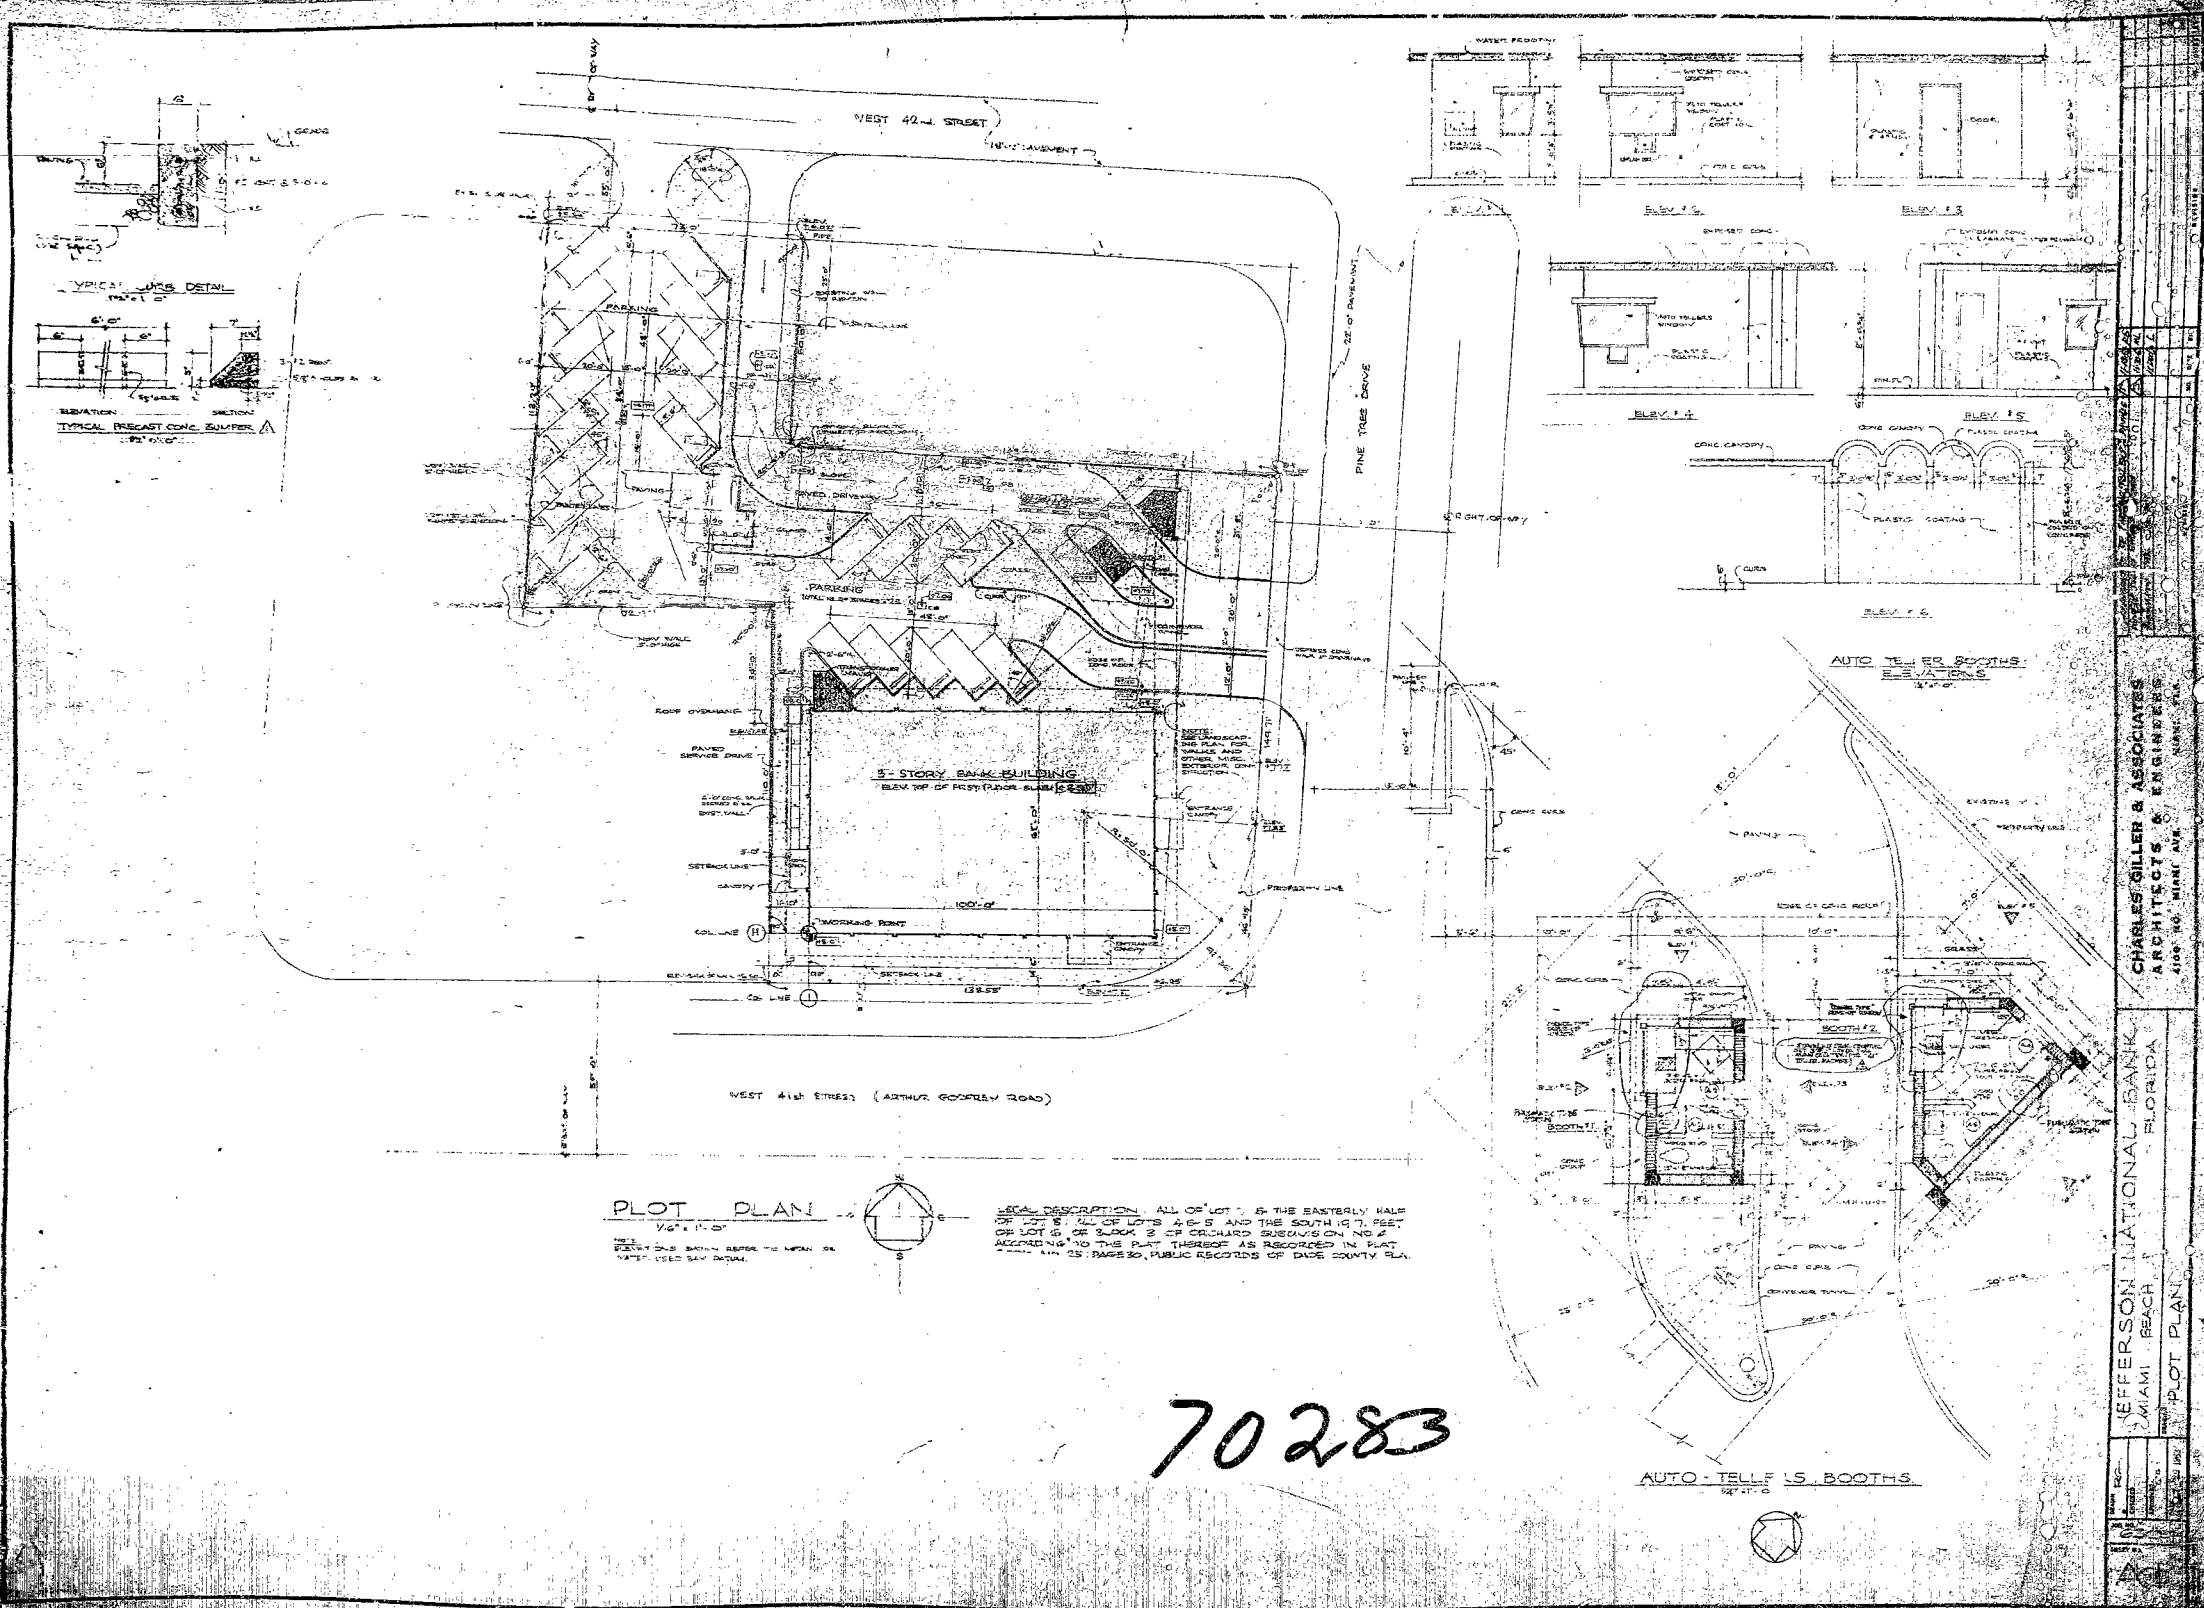

70283

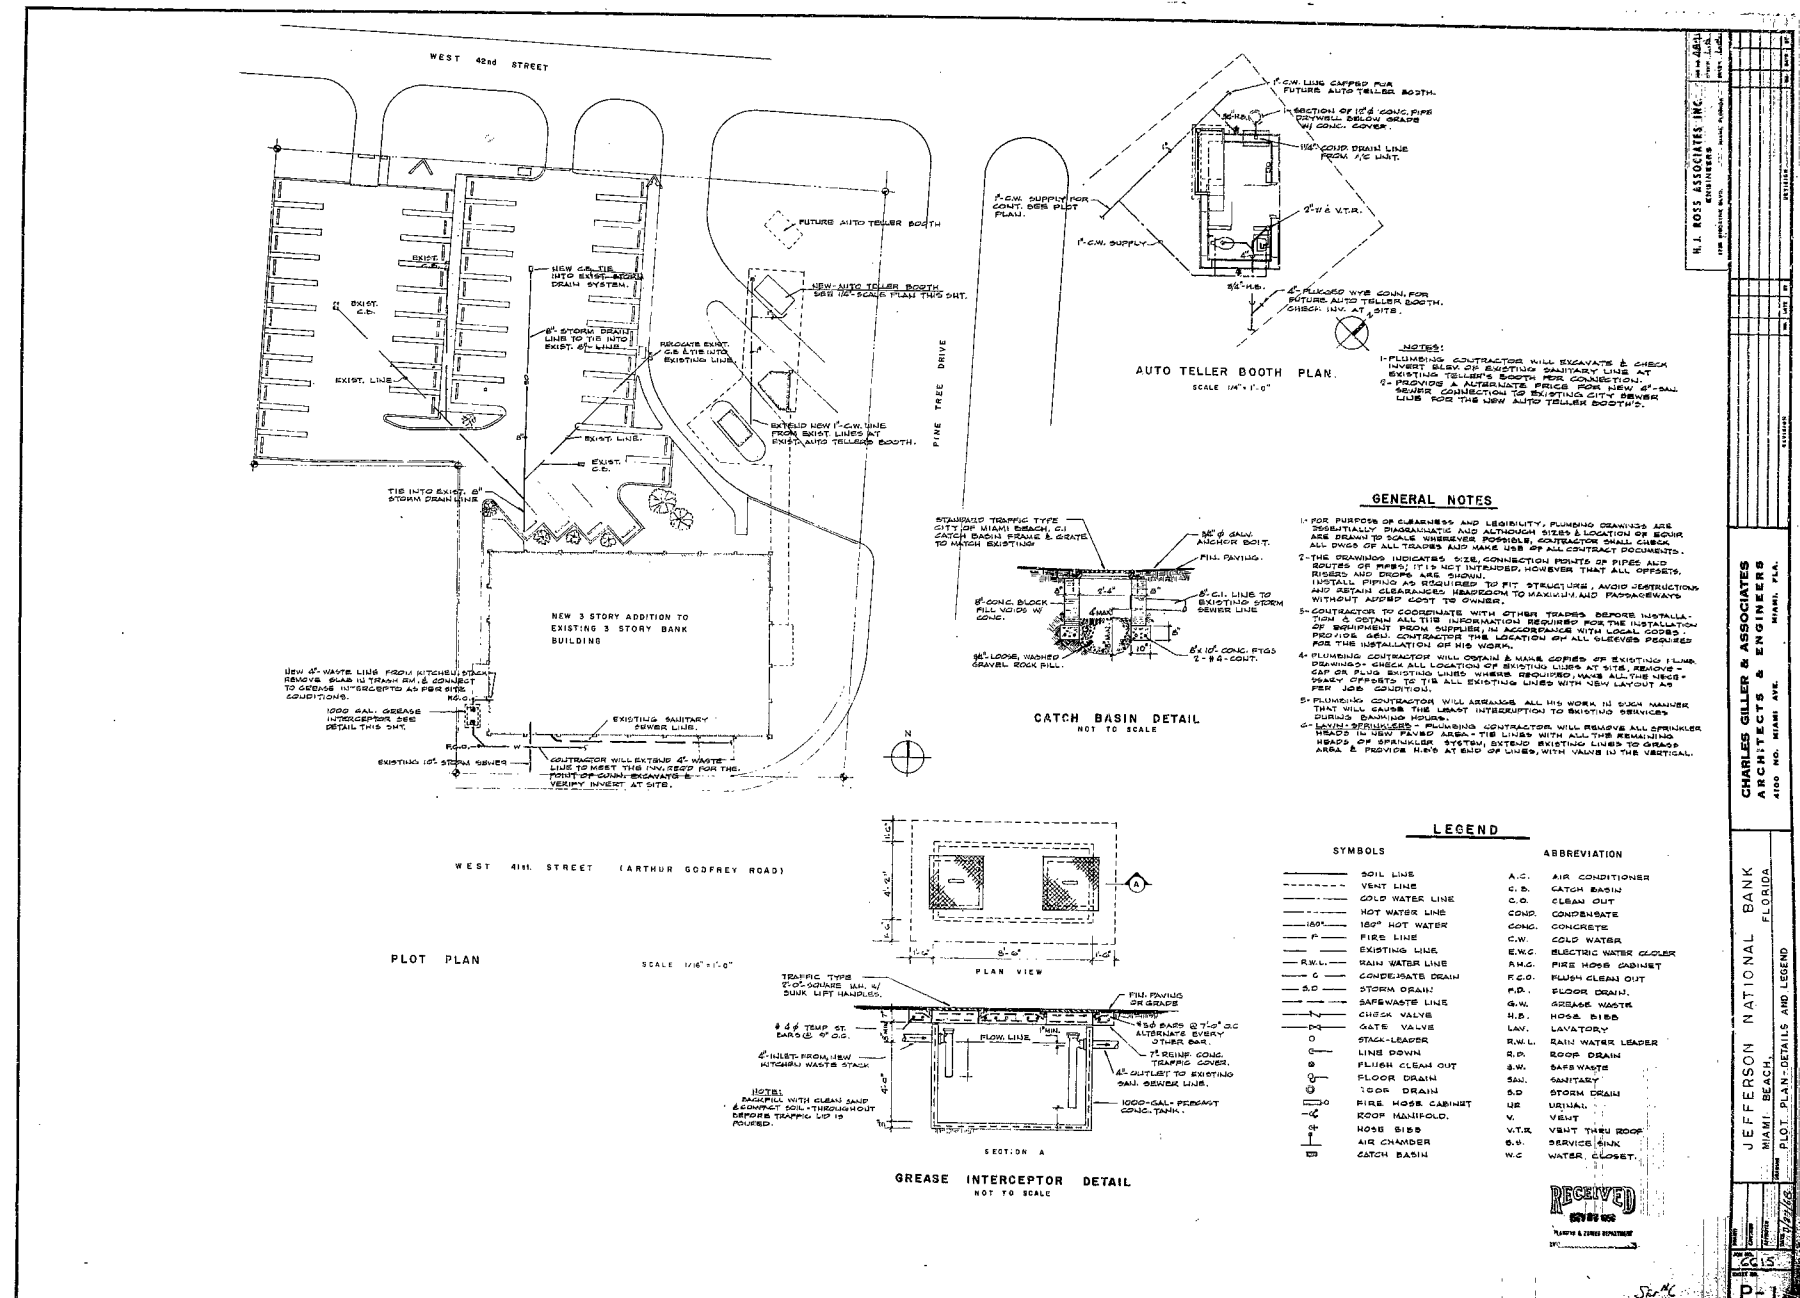


81451 P1-

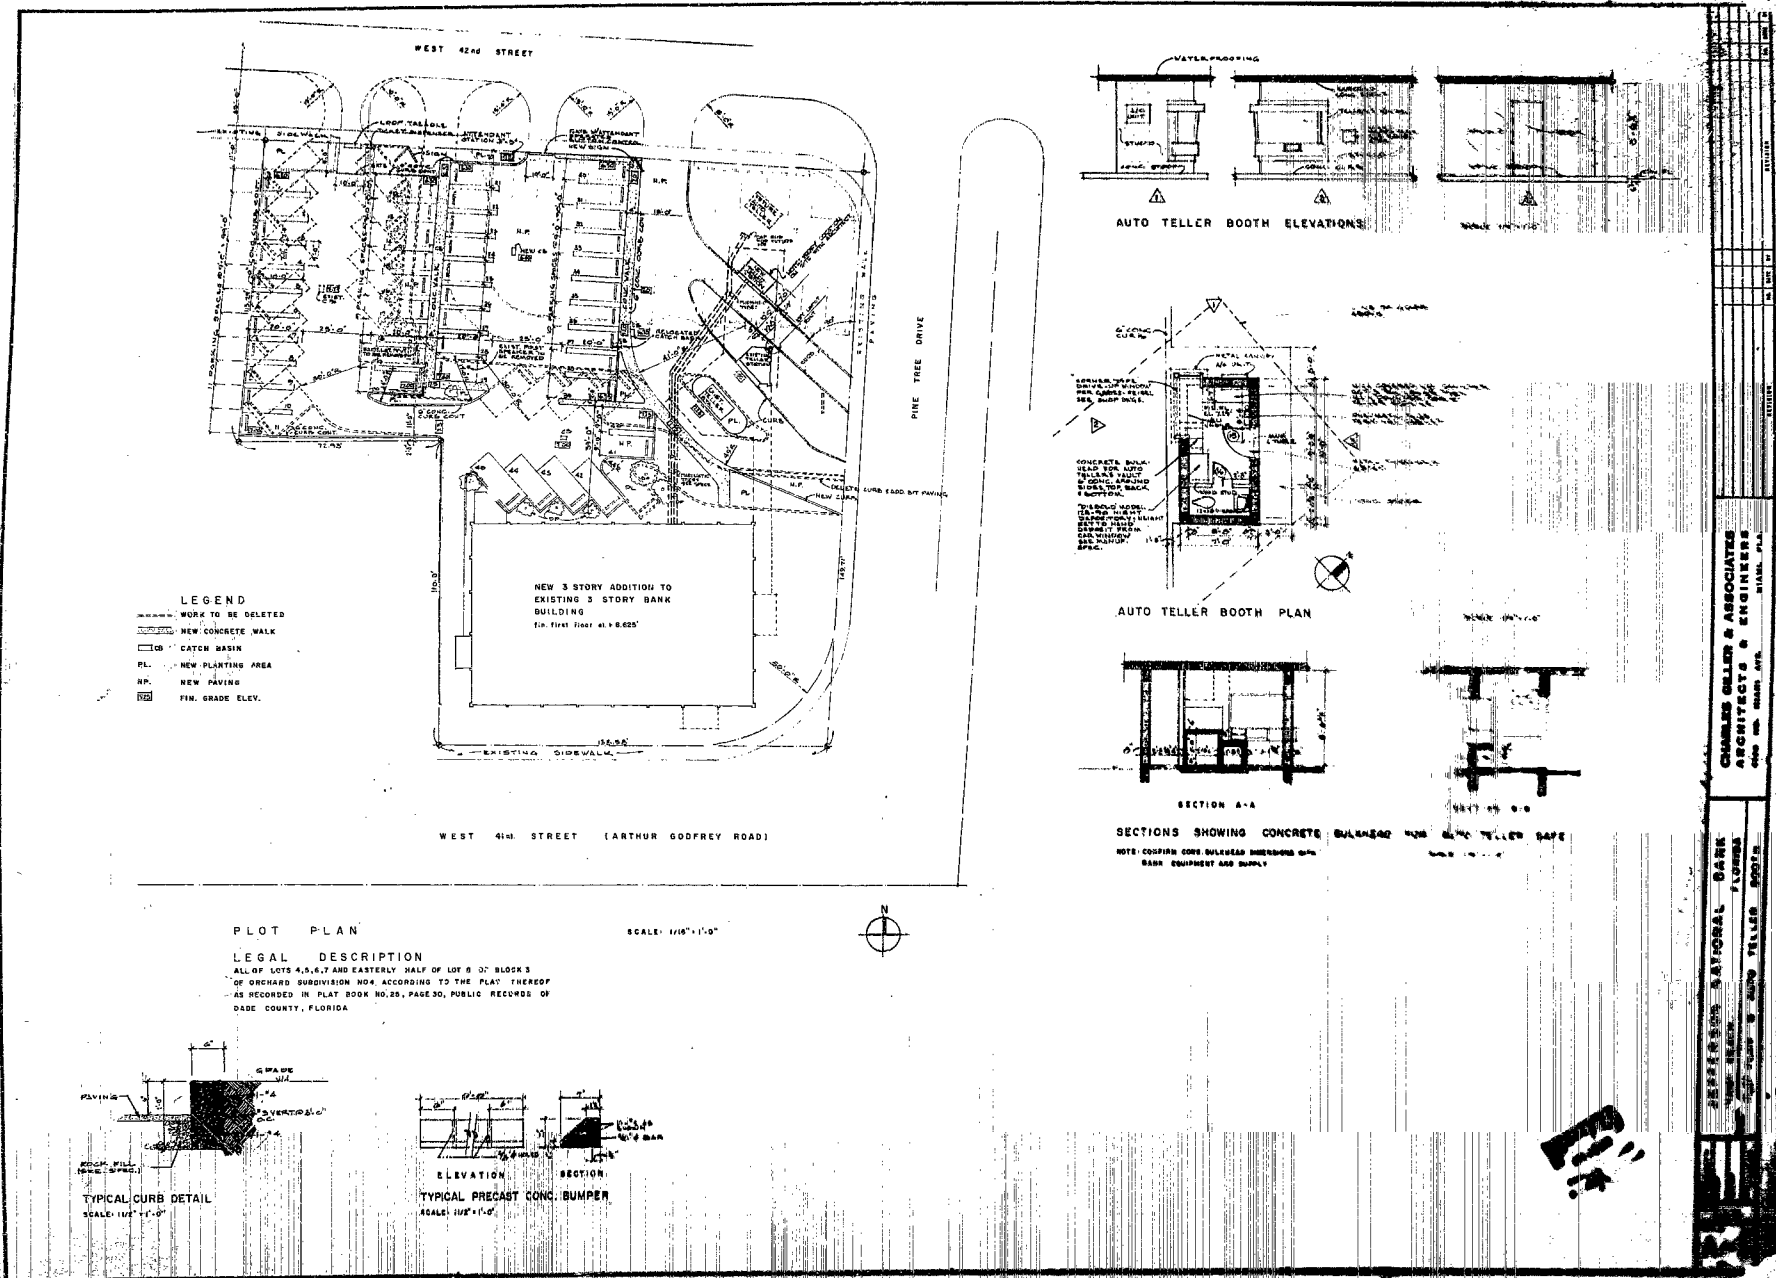

81728

A-1

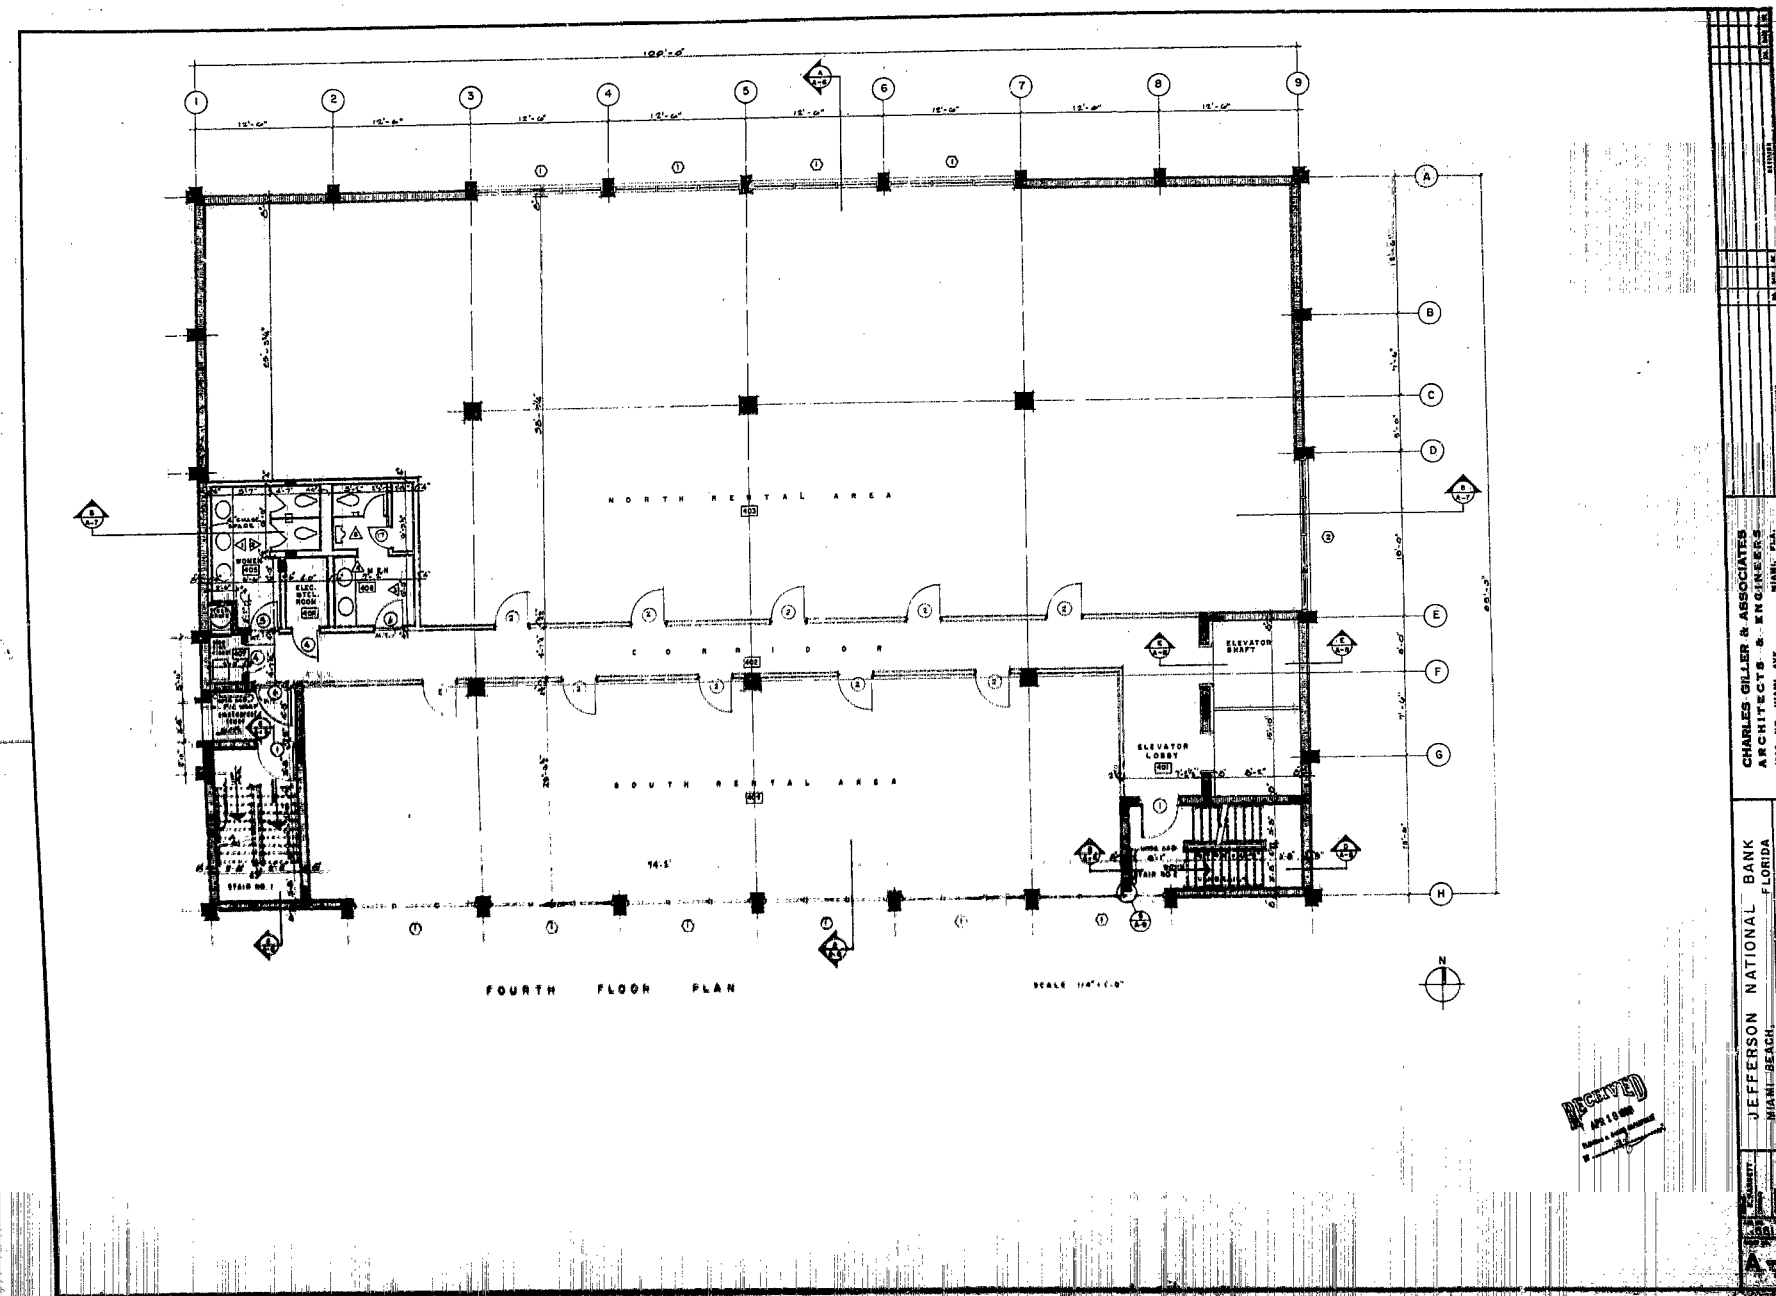


CHARLES GILLER & ASSOCIATES
ARCHITECTS & ENGINEERS
4150 NO. MIAMI AVE.
MIAMI, FLA.

JEFFERSON NATIONAL BANK
MIAMI-SEACH
FOURTH FLOOR PLAN


81728

A-2

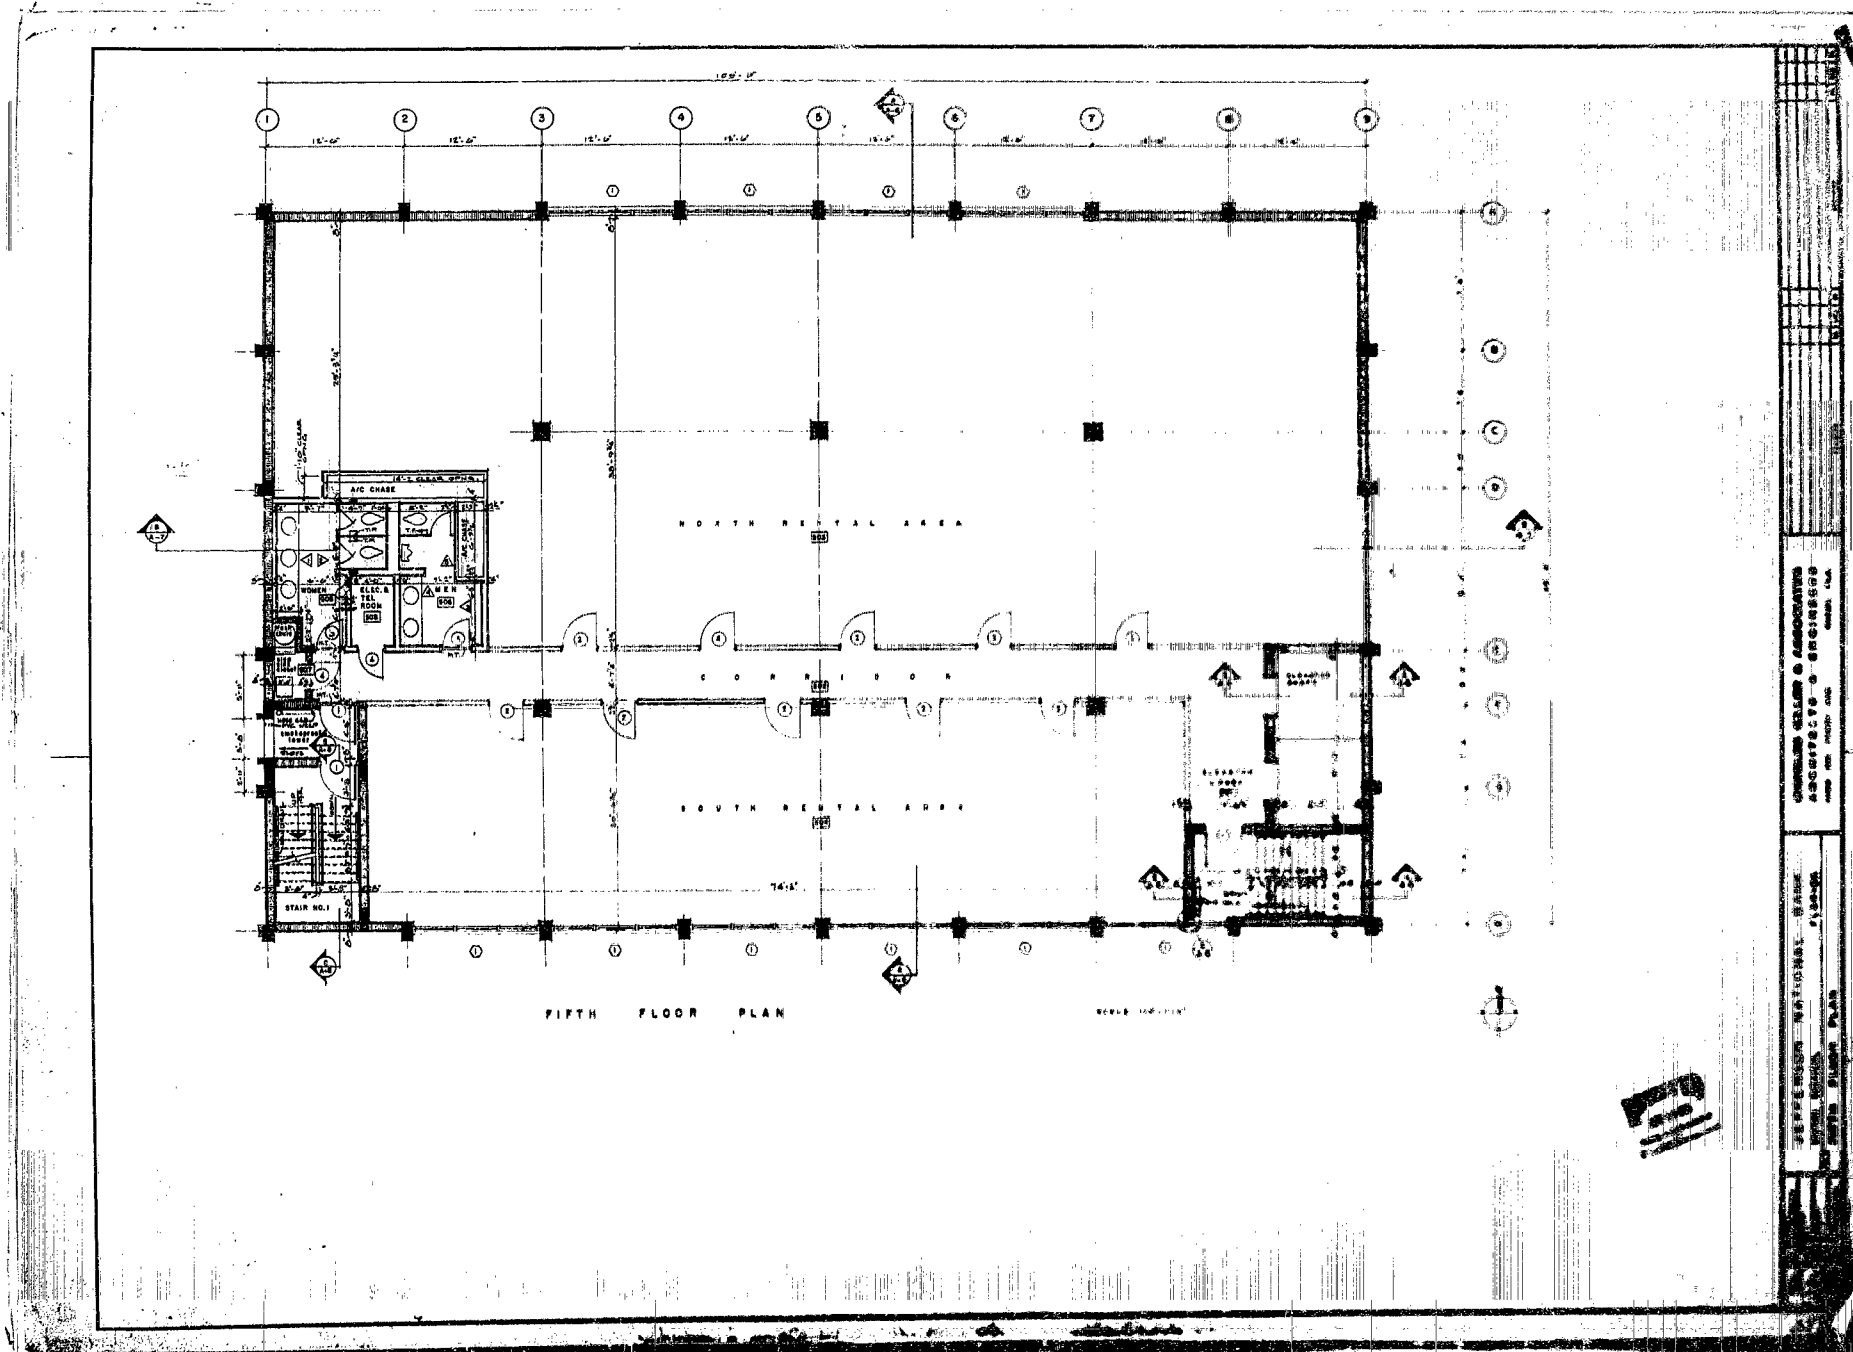


81728

A-3

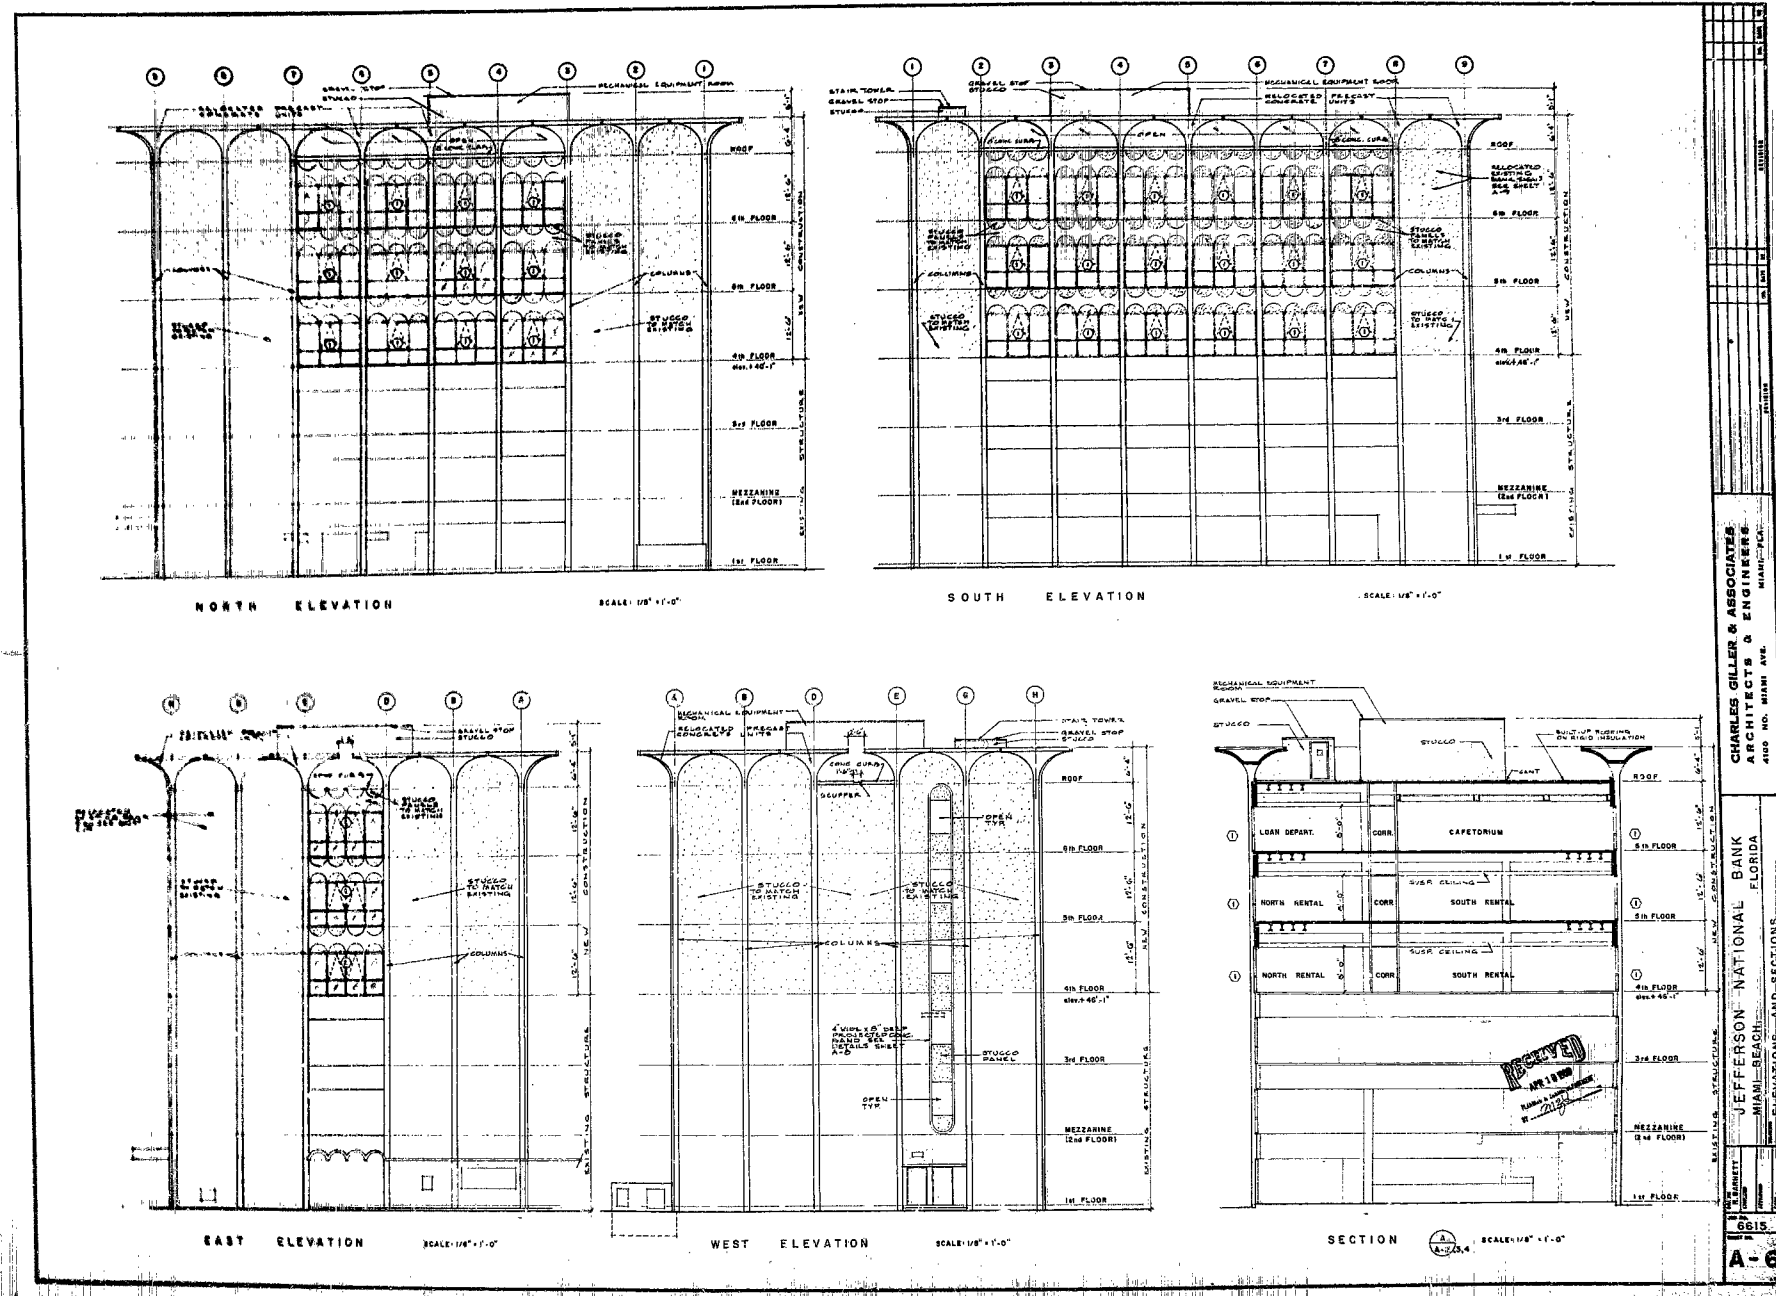


81728 A-6

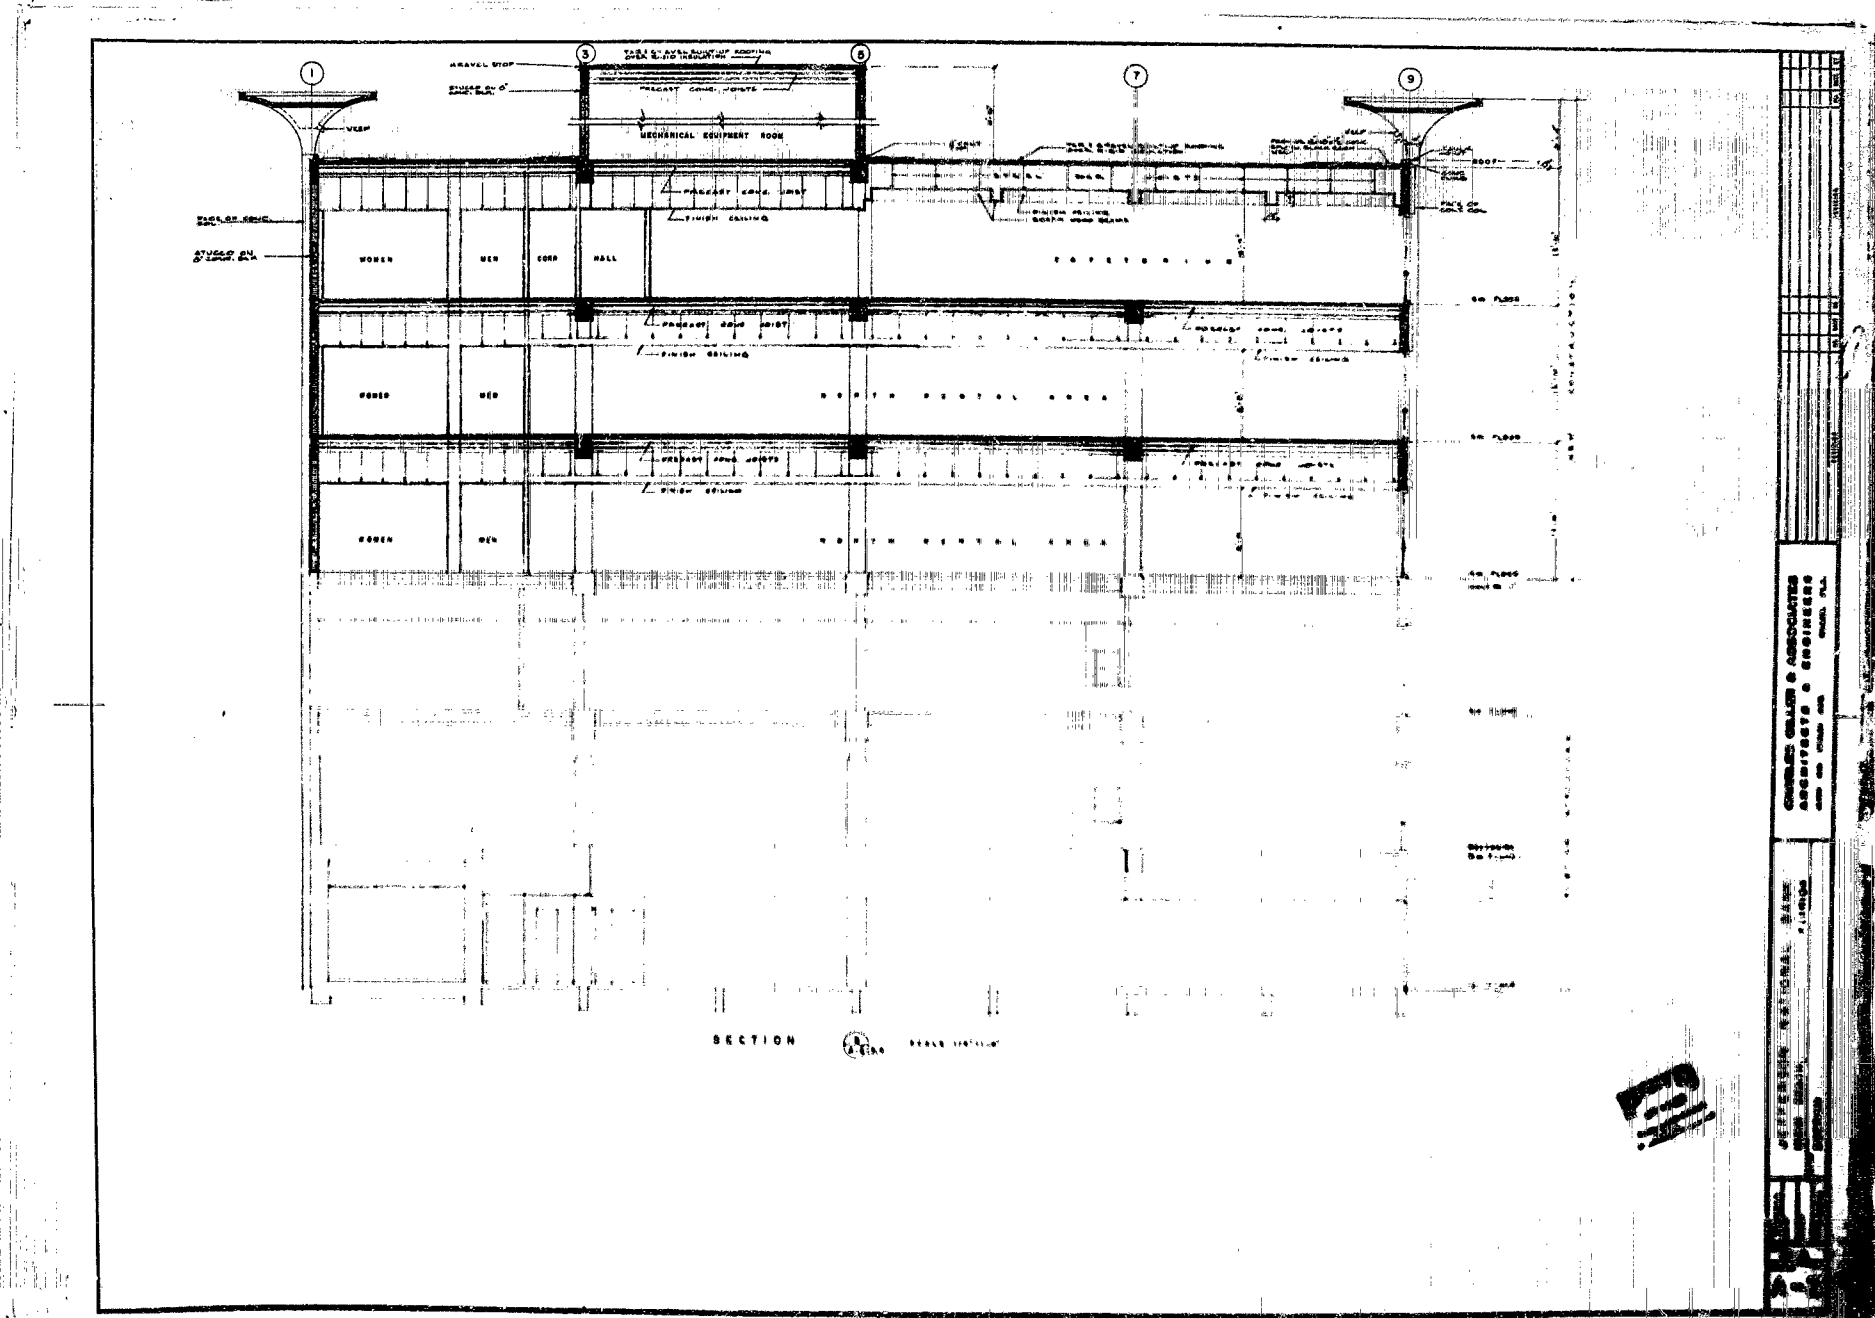


81728


A-7

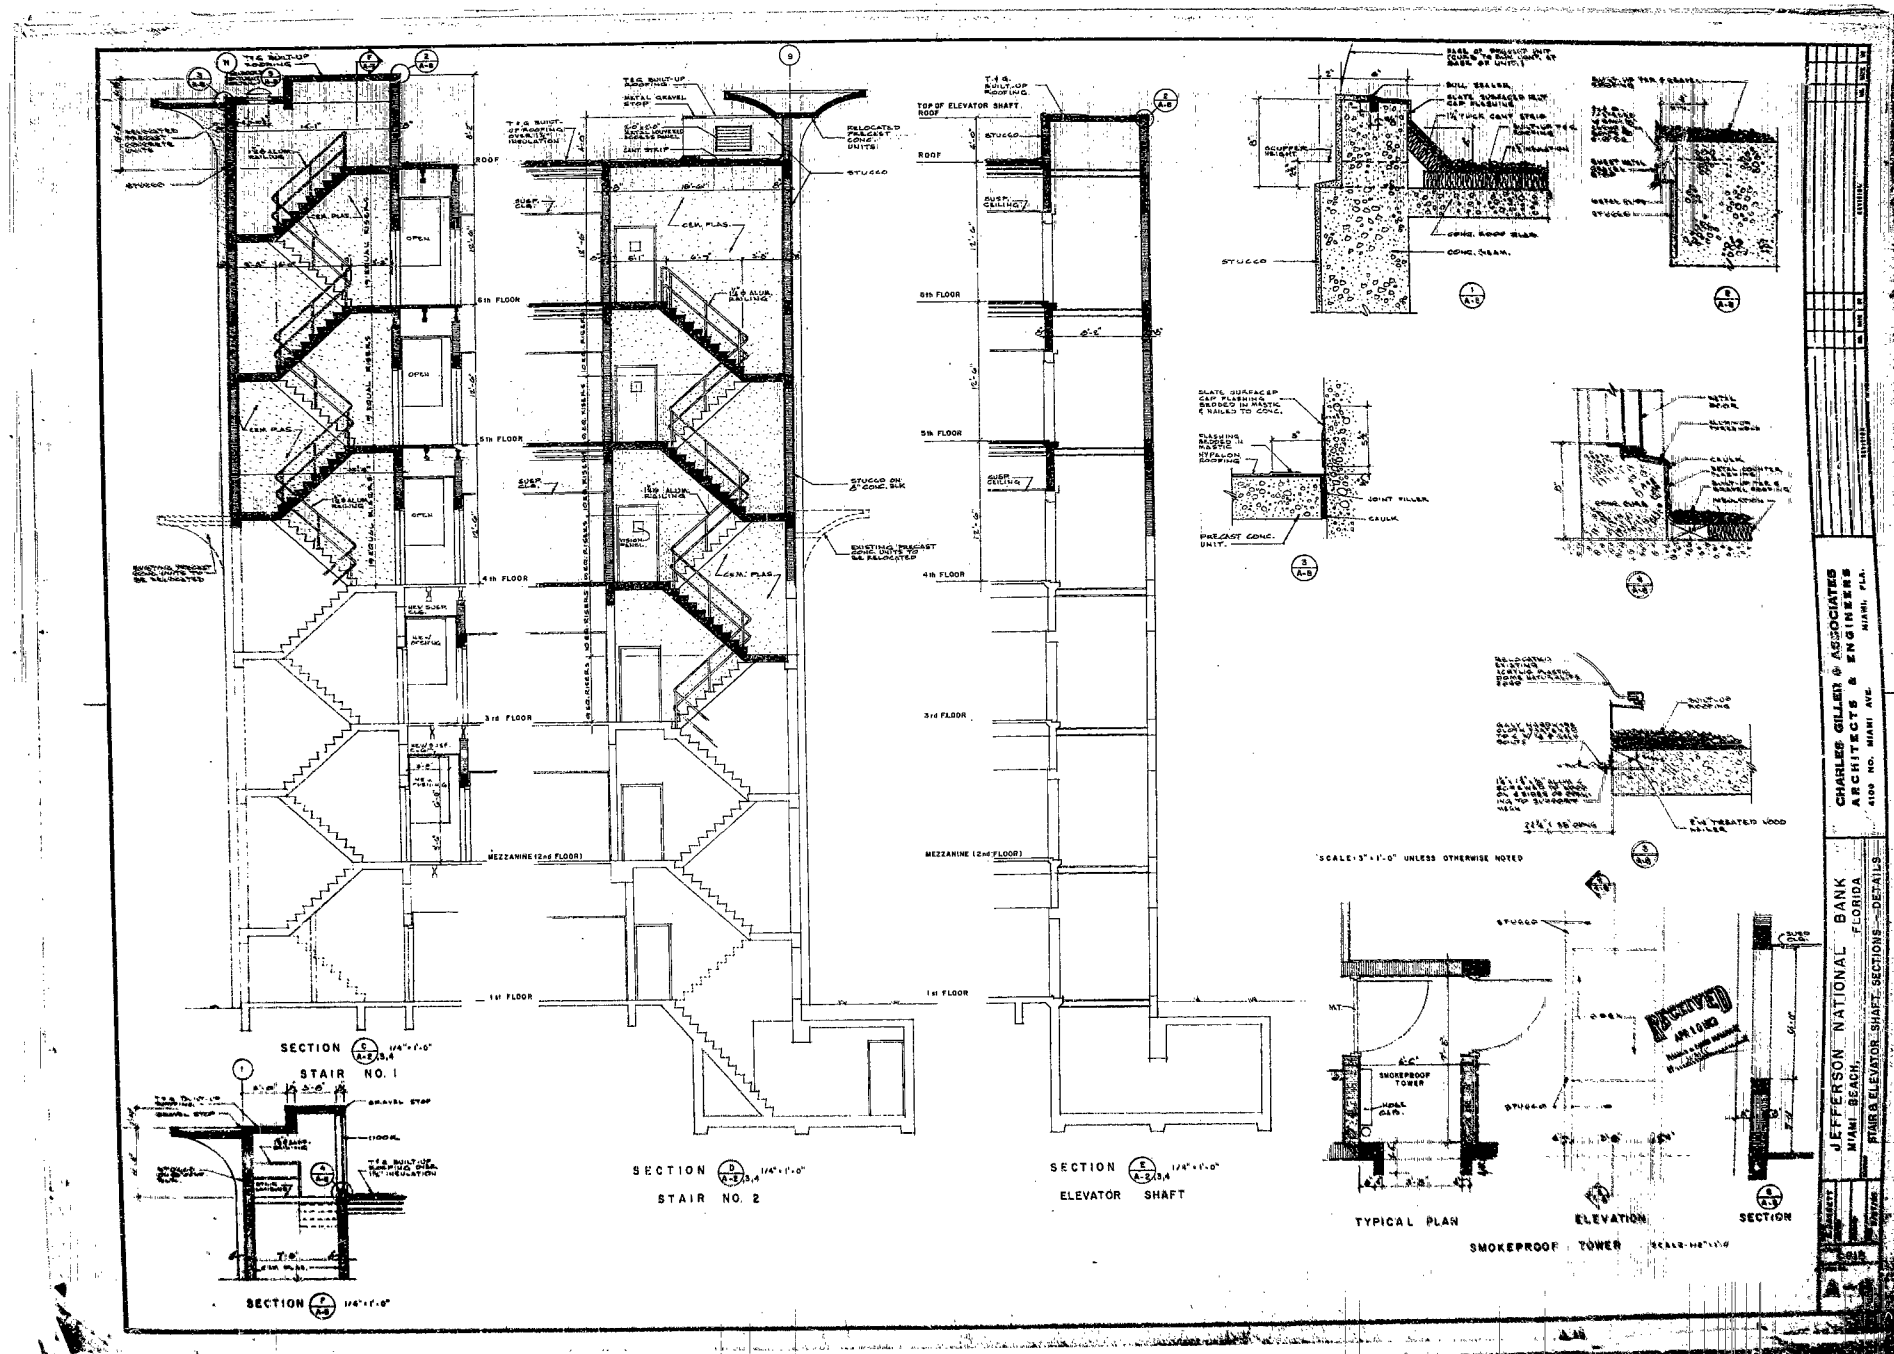

81728

 A-8




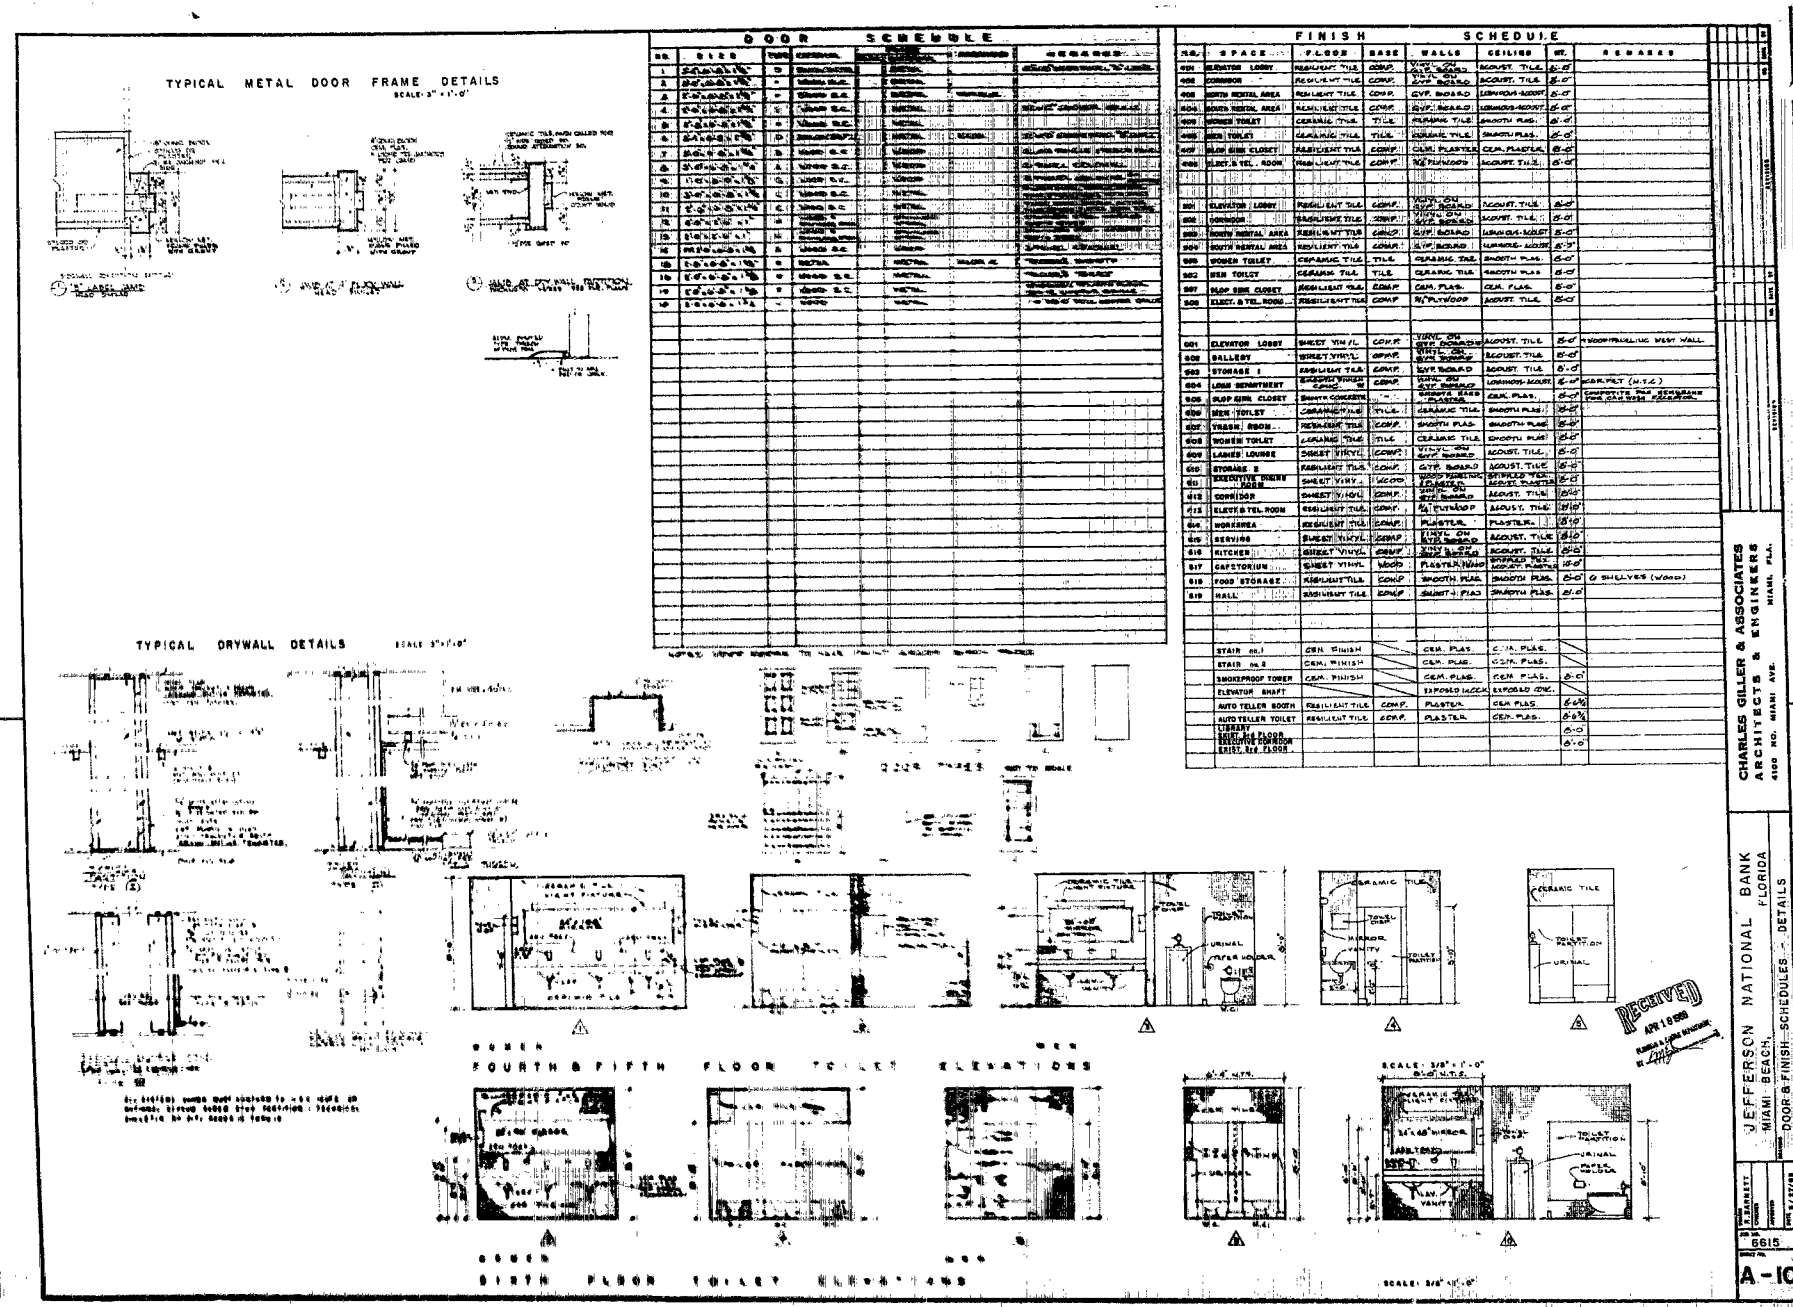


CHARLES GILLER & ASSOCIATES
ARCHITECTS & ENGINEERS
4150 NO. MIAMI AVE.
MIAMI, FLA.

JEFFERSON NATIONAL BANK
MIAMI BEACH
DOOR & FINISH SCHEDULES - DETAILS


5515
A-10

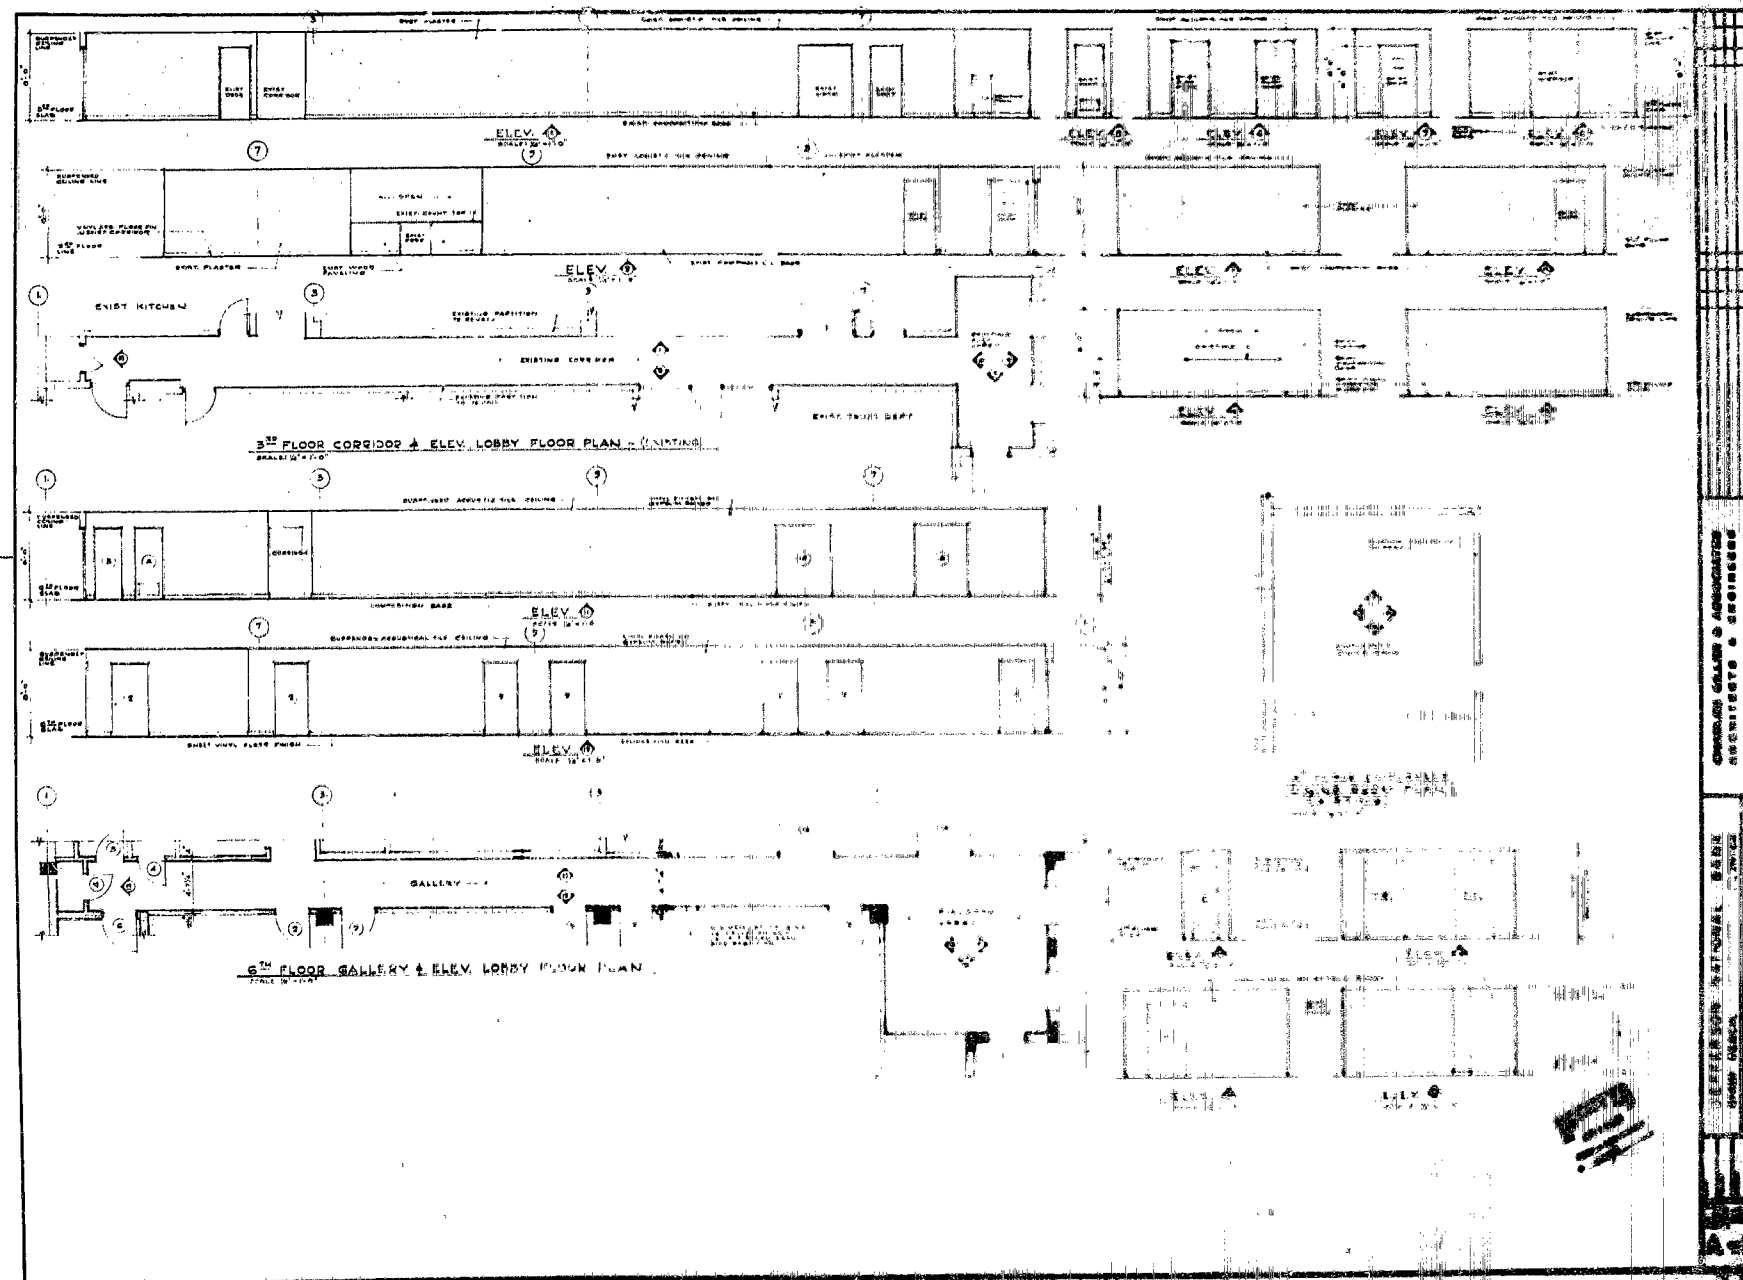

81728 A-11

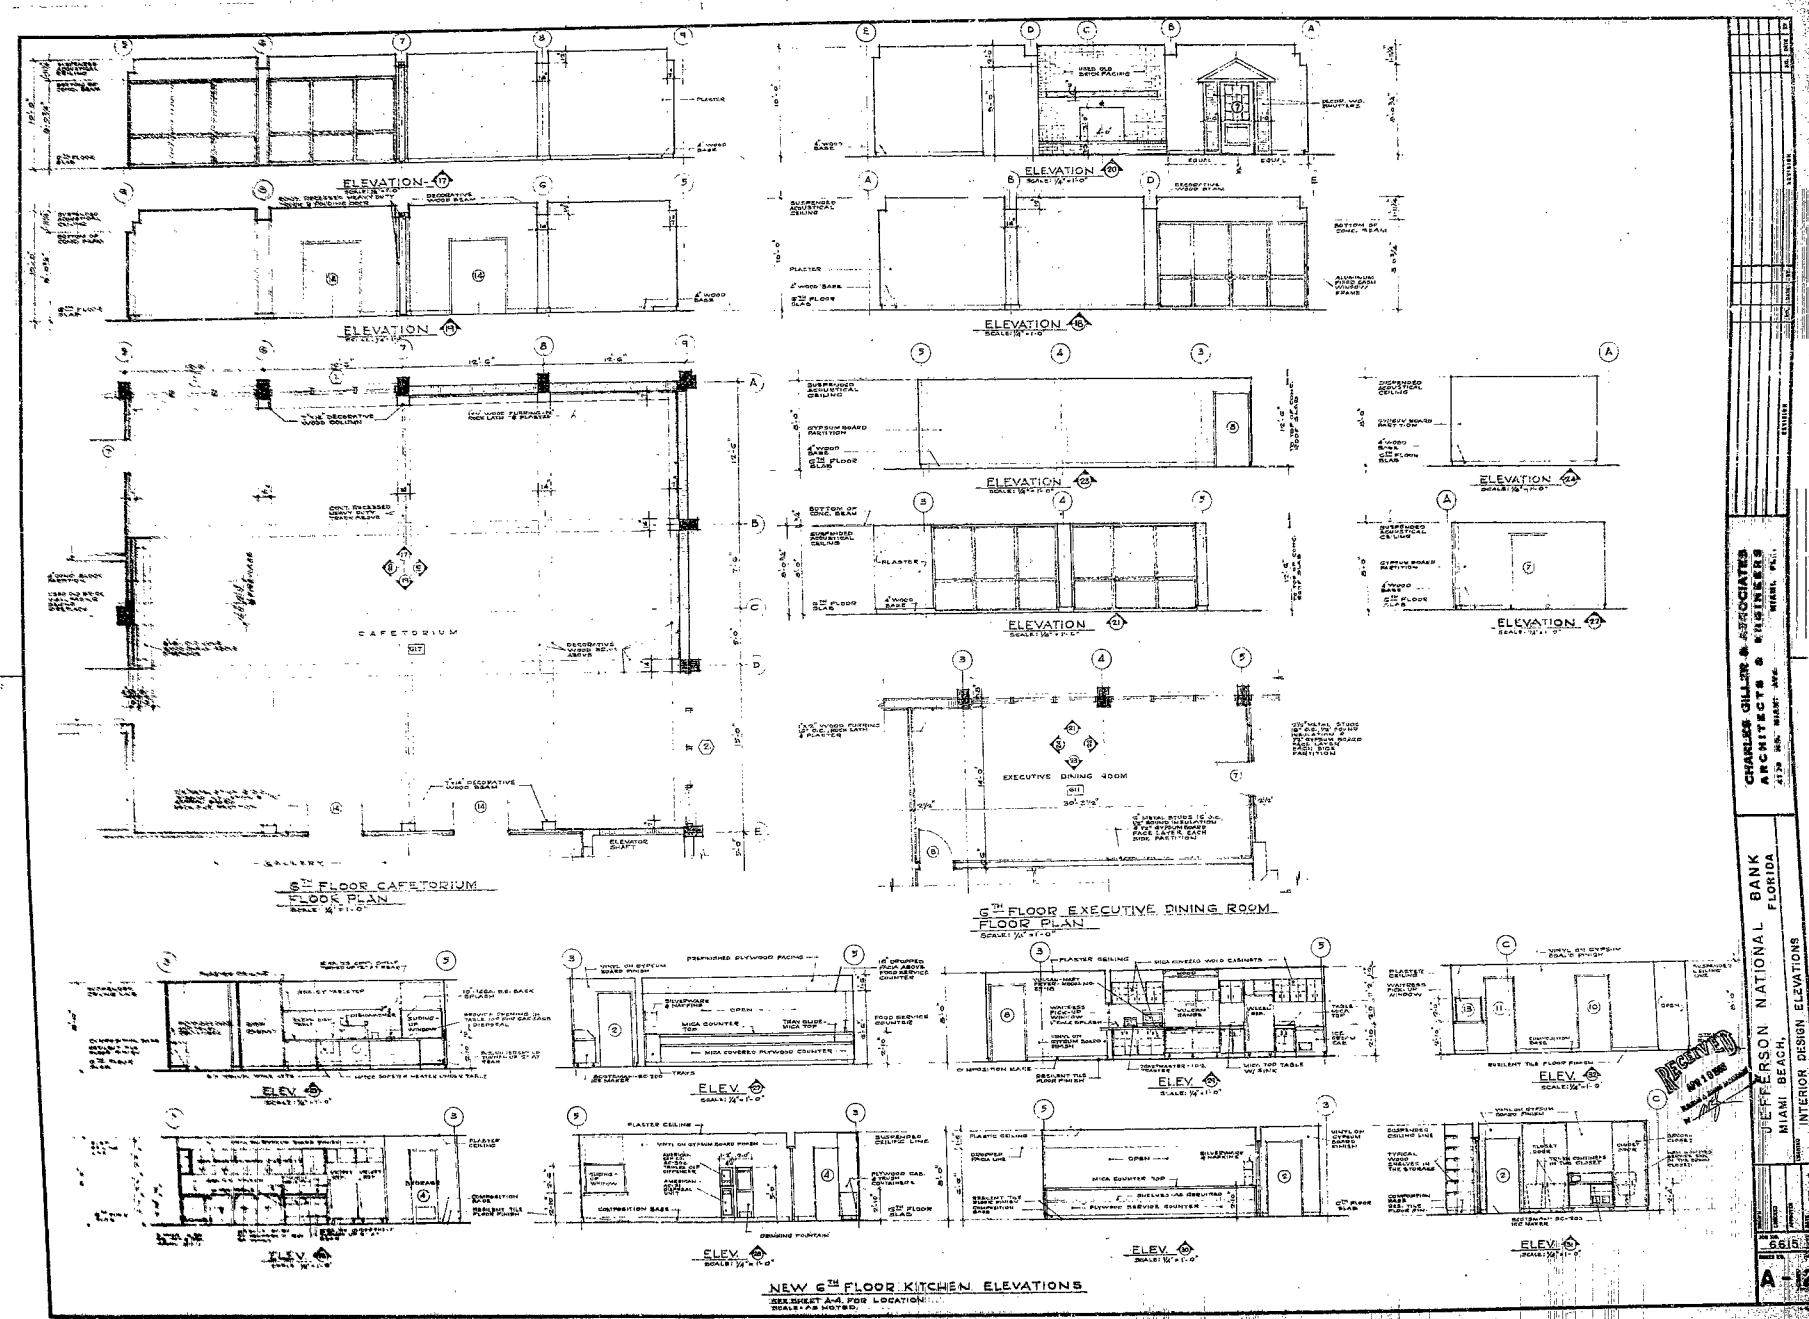


81728 A-12

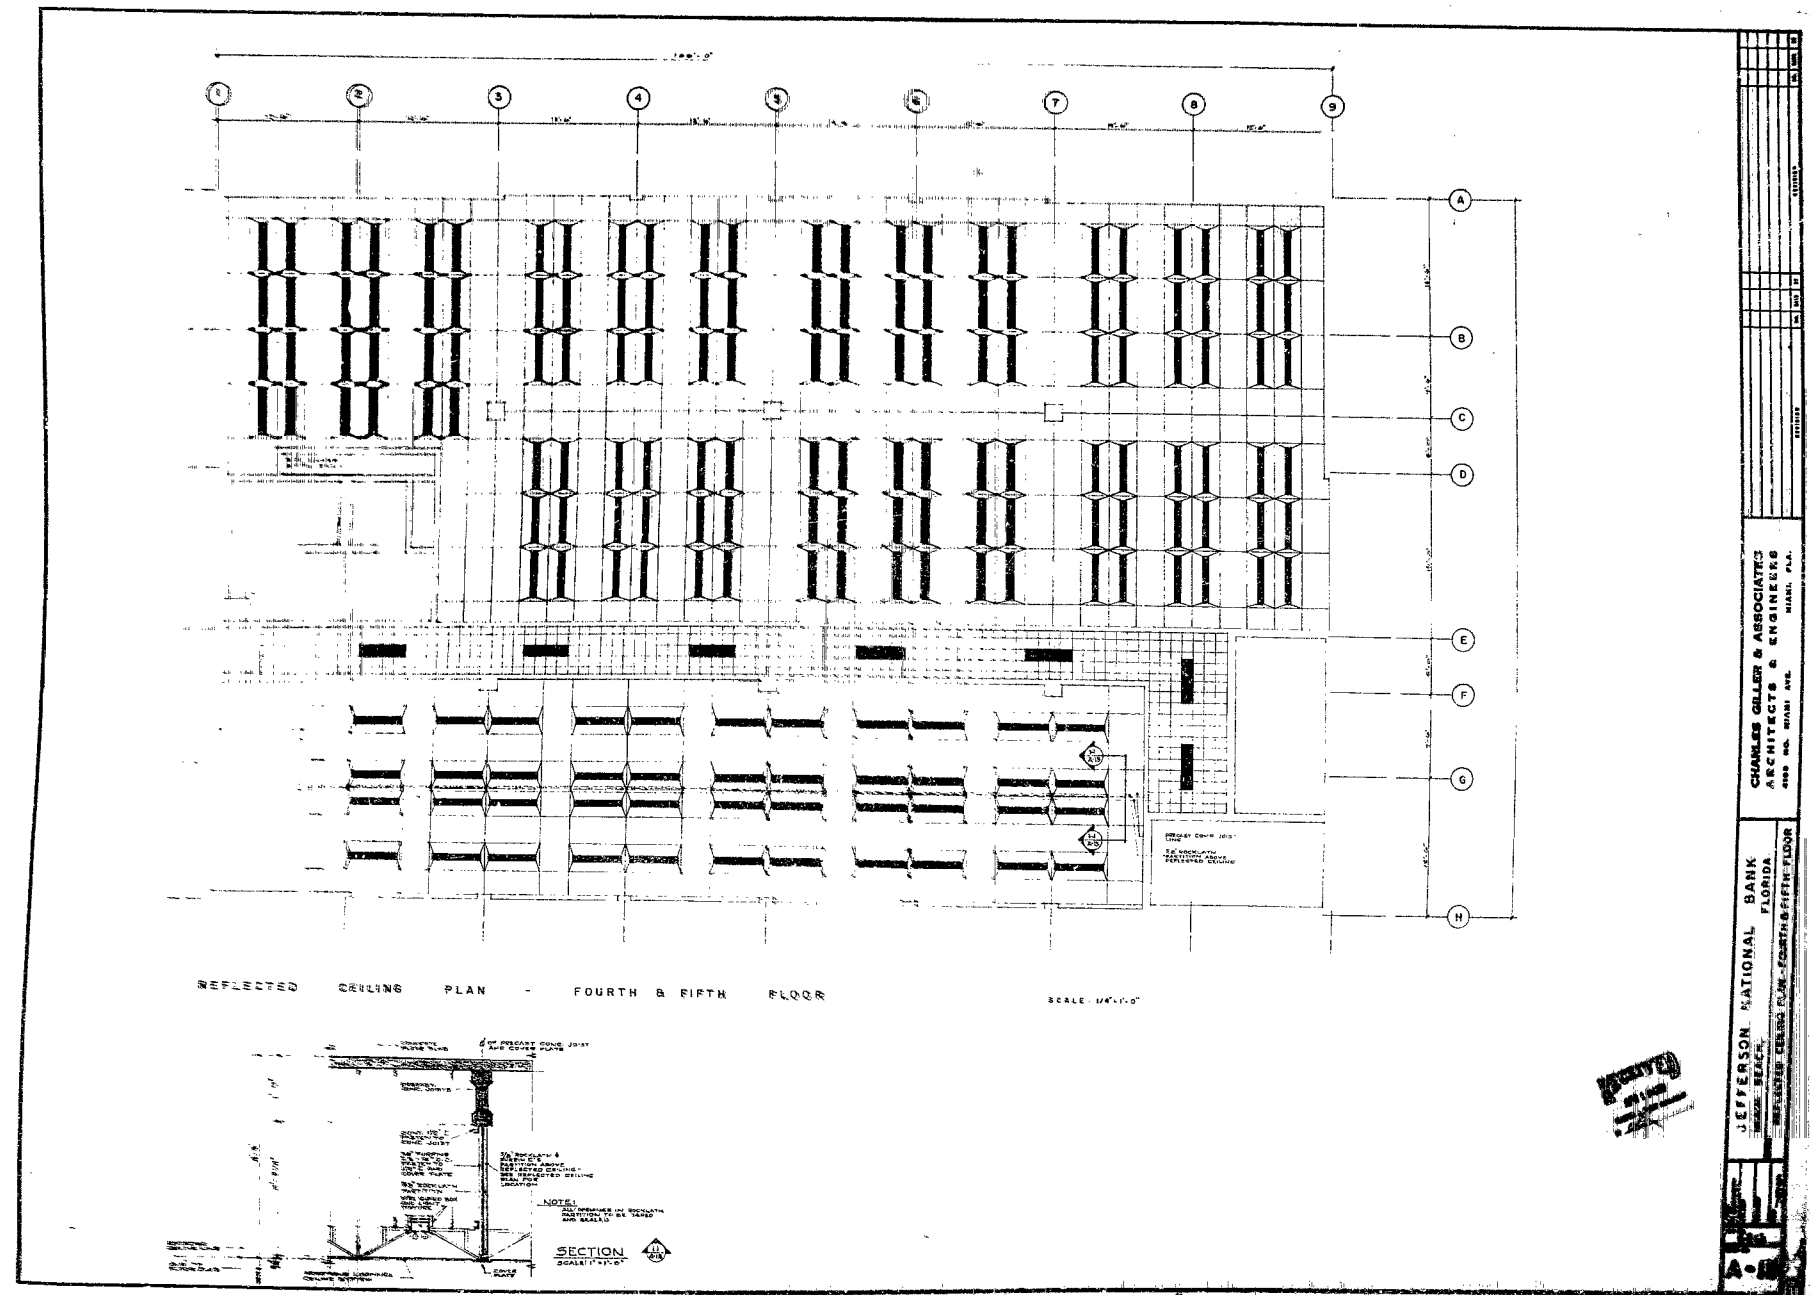


JEFFERSON NATIONAL BANK	CHARLES GILLEN & ASSOCIATES
MEMPHIS, TENNESSEE	ARCHITECTS & ENGINEERS
REFLECTED CEILING PLAN - FOURTH & FIFTH FLOOR	DATE: 10/1/54
	BY: C. GILLEN
	CHECKED: C. GILLEN
	APPROVED: C. GILLEN
	SCALE: 1/4" = 1'-0"
	PROJECT NO. 1000
	SHEET NO. 1000

81728 A-13

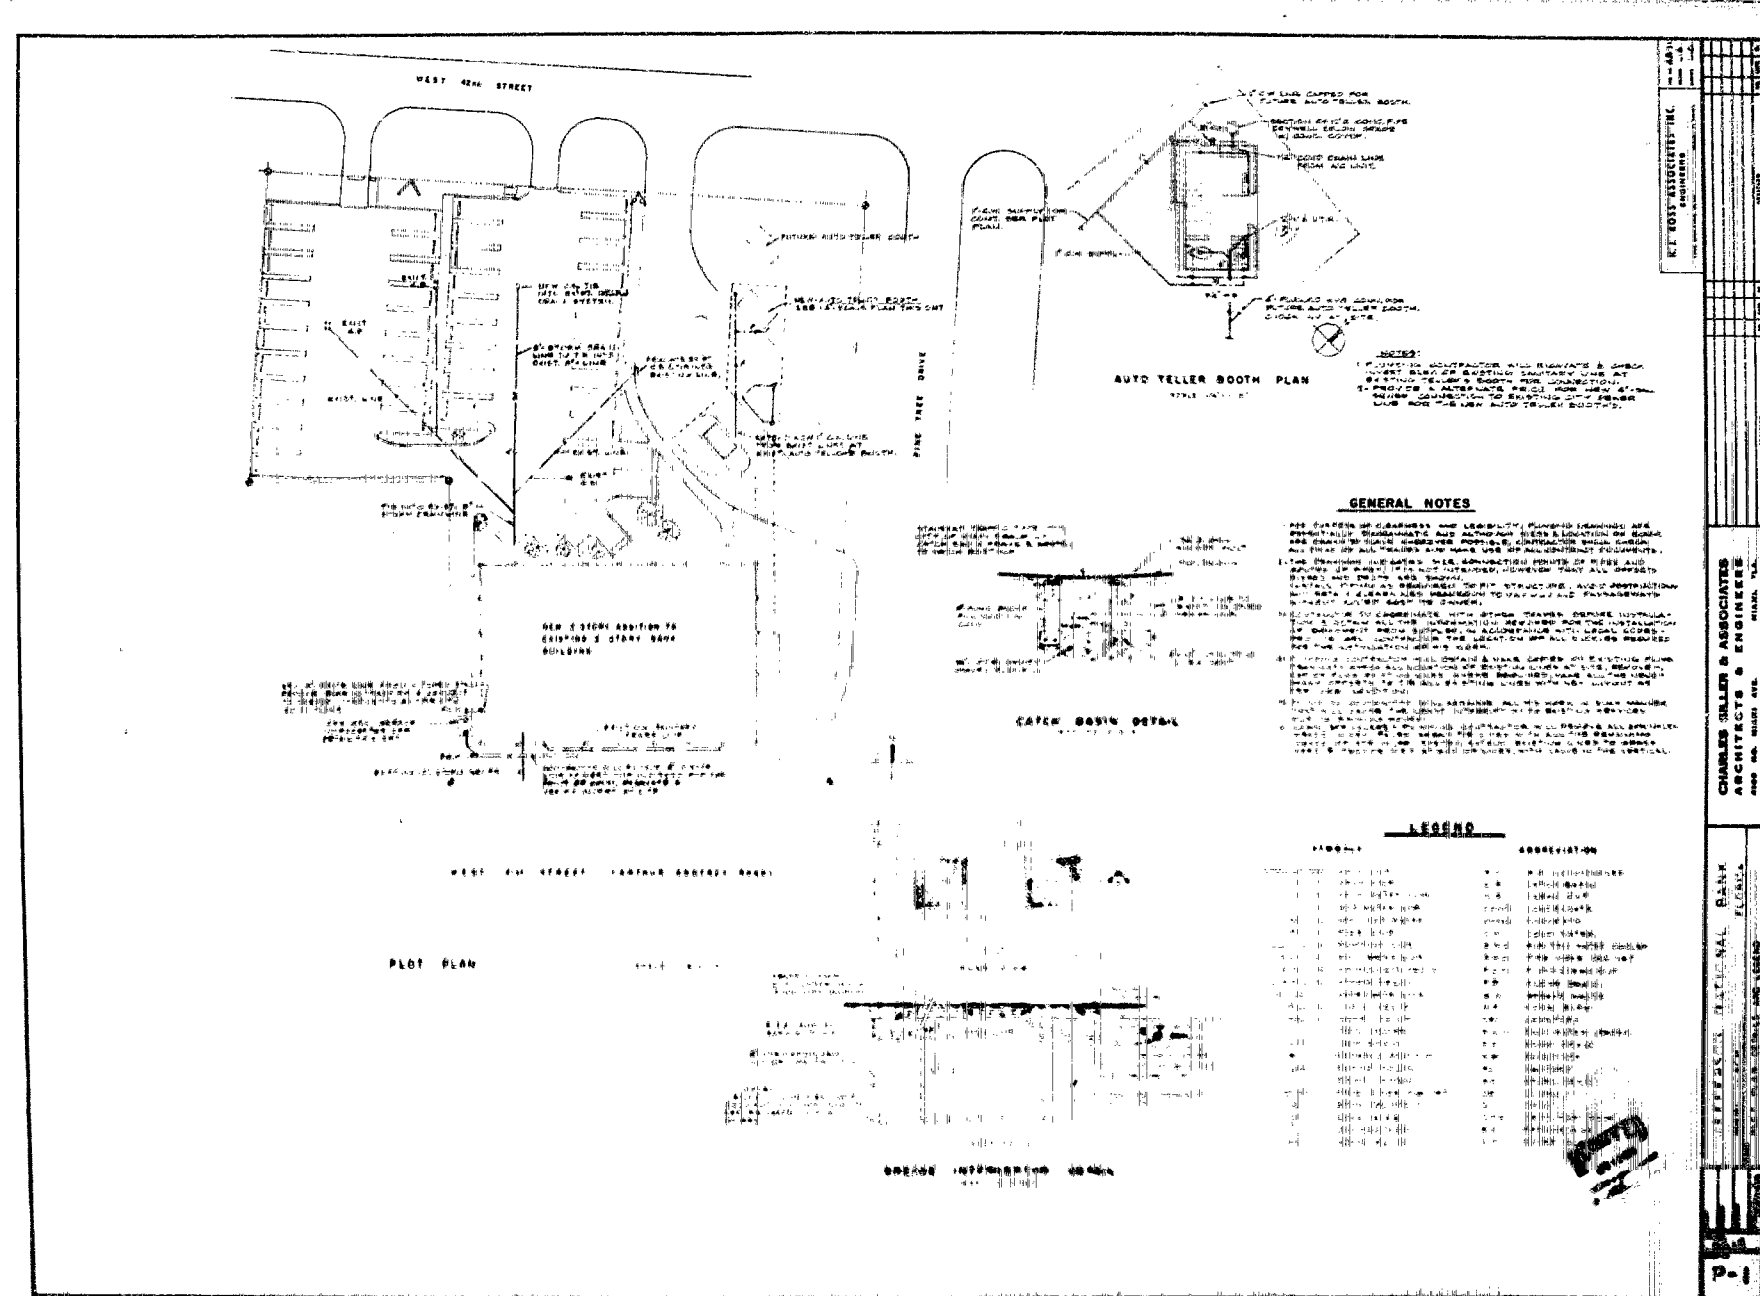




81728 P-1

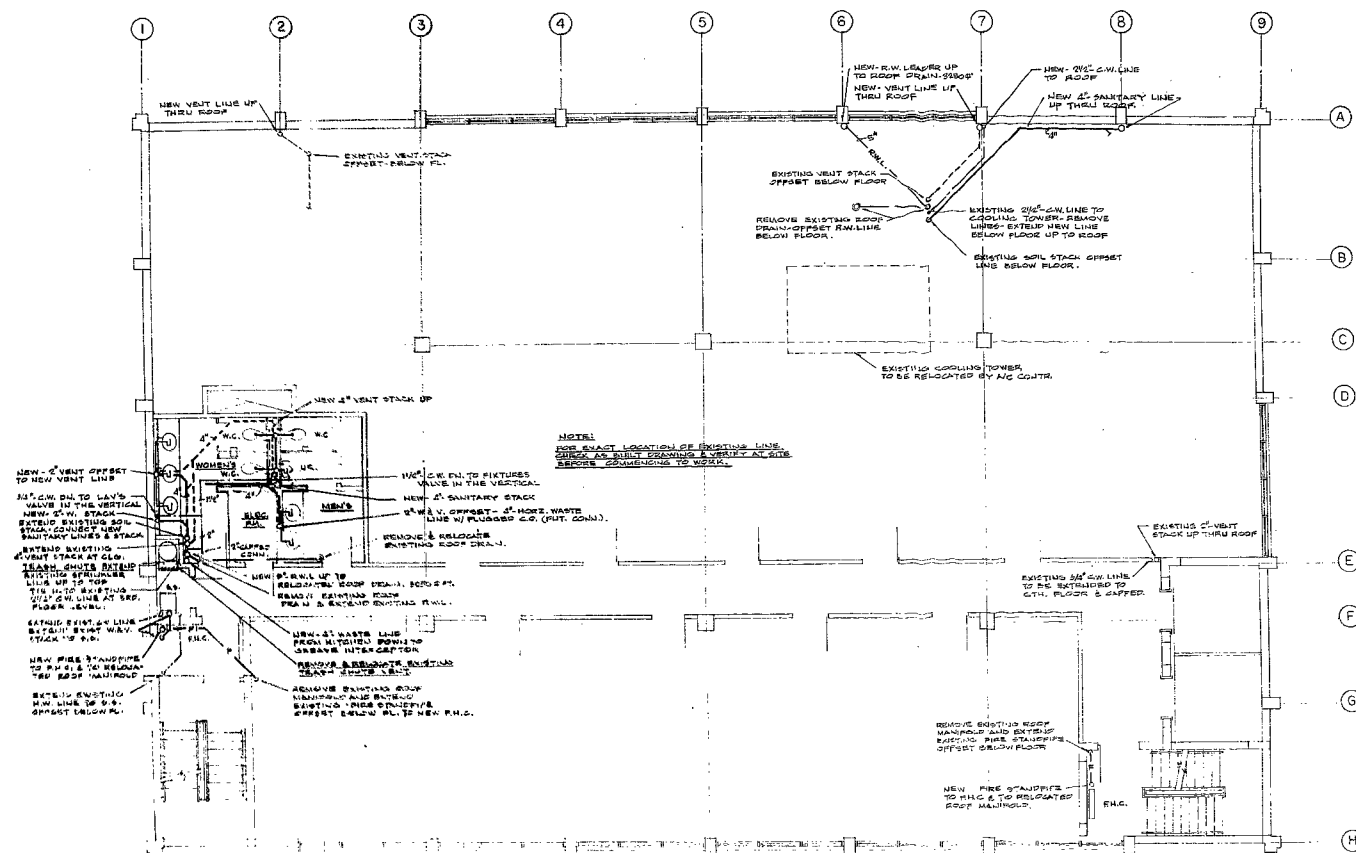

FOURTH FLOOR PLAN
SCALE 1/8" = 1'-0"

FIXTURES CONNECTION SCHEDULE				
ITEM	CON. TYP.	TRAP	F.L. CONN.	REMARKS
LABATORY	1/8"	-	1/8"	5
URINAL	3/8"	-	2"	4 FLUSH VALVE
WATER CLOSET	1"	-	4"	6 FLUSH VALVE
SERVICE SINK	1/2"	1/2"	2"	3 NEW FROM EXIST. W.H.
ELECTRIC WATER COOLER	1/2"	-	1/2"	1/2

N.Y. ROSS ASSOCIATES INC.
 ENGINEERS
 100 WALL STREET, NEW YORK 6, N.Y.
 100 WALL STREET, NEW YORK 6, N.Y.
 CHARLES GILLER & ASSOCIATES
 ARCHITECTS & ENGINEERS
 100 WALL STREET, NEW YORK 6, N.Y.
 JEFFERSON NATIONAL BANK
 FLORIDA
 4TH FLOOR PLAN AND SCHEDULES
 10/1/63
 P-2

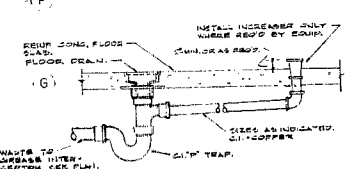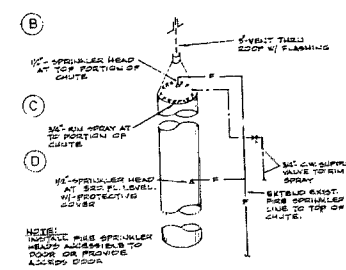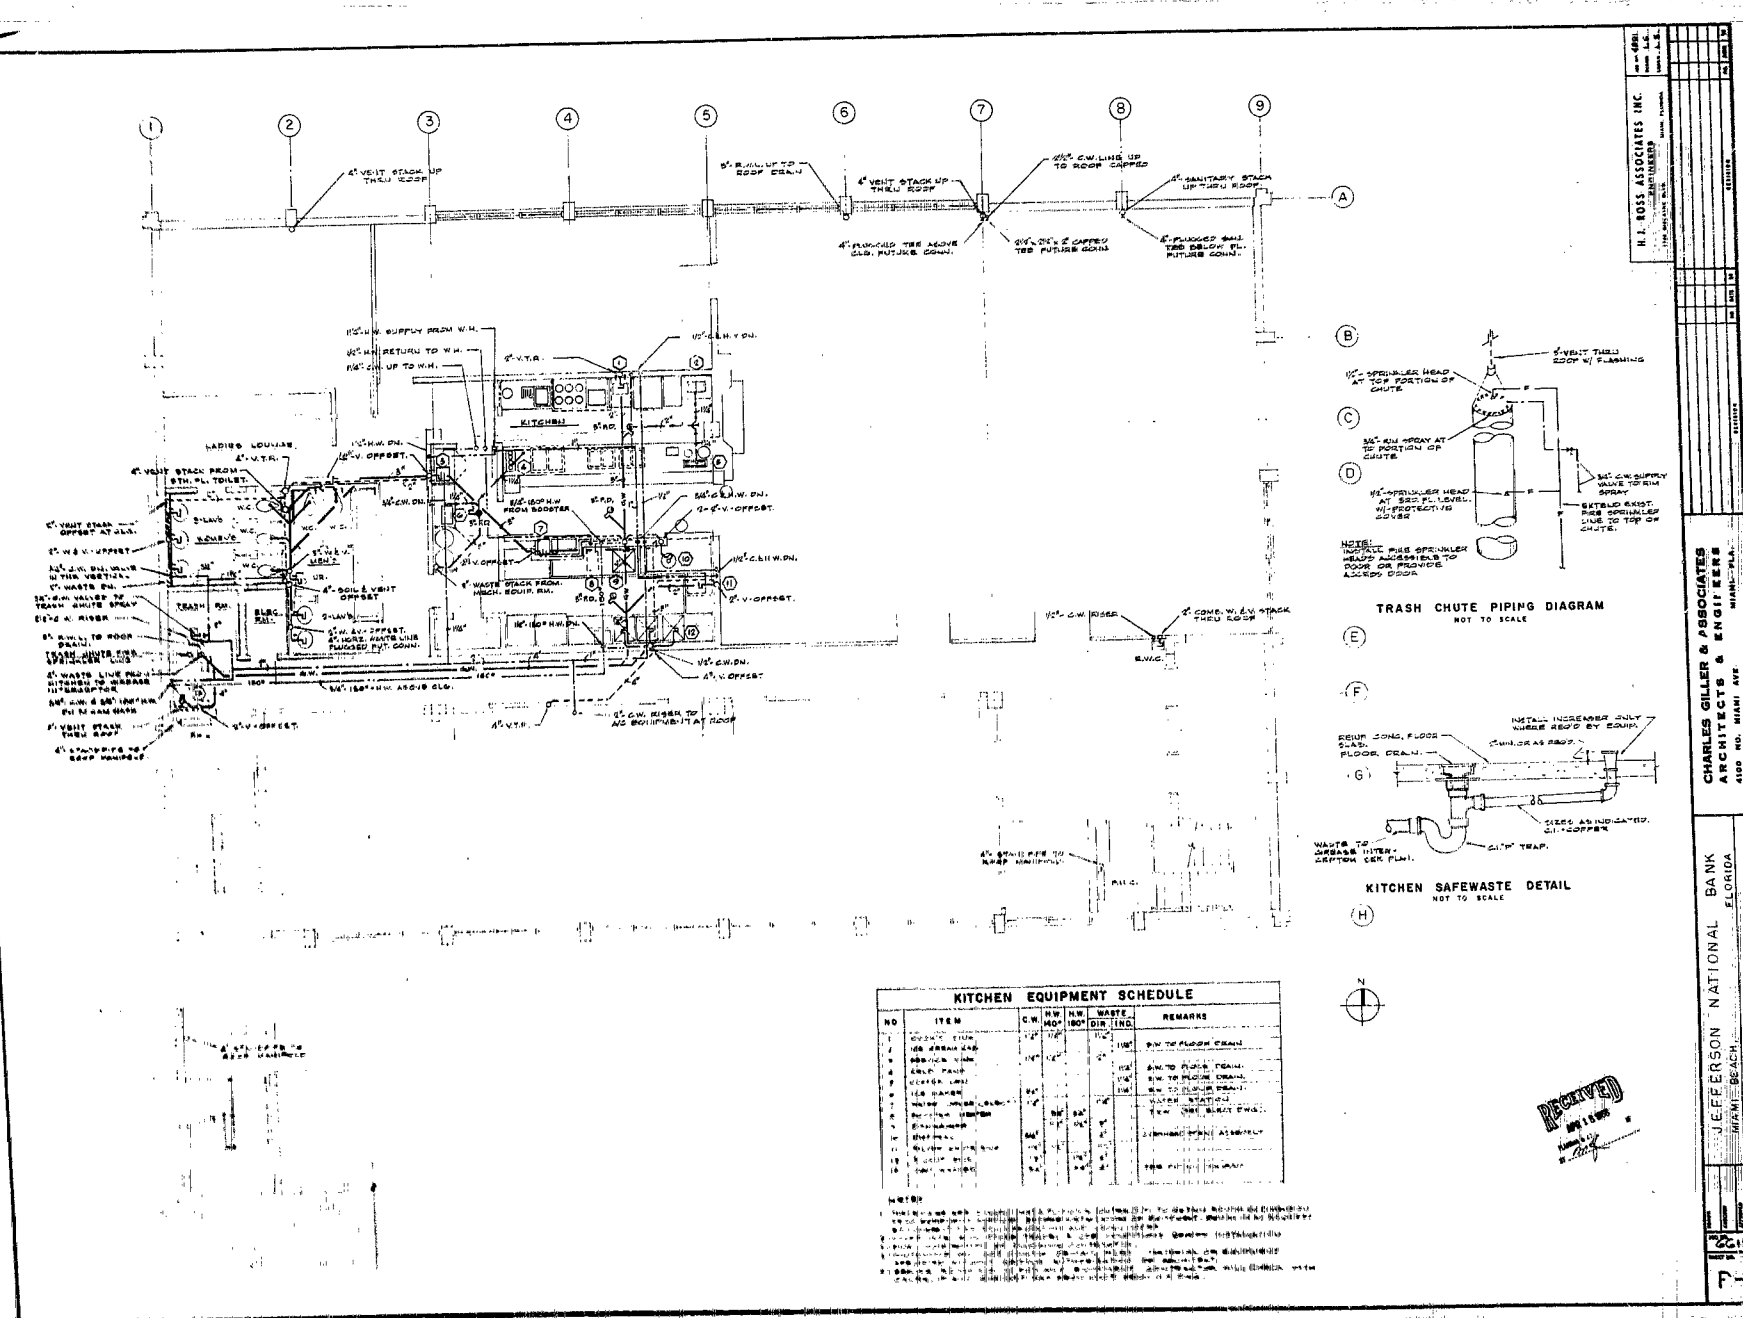

NO.	ITEM	QTY	UNIT	REMARKS
1	STOVE	1	EA	12" WIDE
2	SINK	1	EA	12" WIDE
3	REF	1	EA	12" WIDE
4	DISHWASHER	1	EA	12" WIDE
5	STOVE	1	EA	12" WIDE
6	SINK	1	EA	12" WIDE
7	REF	1	EA	12" WIDE
8	DISHWASHER	1	EA	12" WIDE
9	STOVE	1	EA	12" WIDE
10	SINK	1	EA	12" WIDE
11	REF	1	EA	12" WIDE
12	DISHWASHER	1	EA	12" WIDE

81728 P-4