


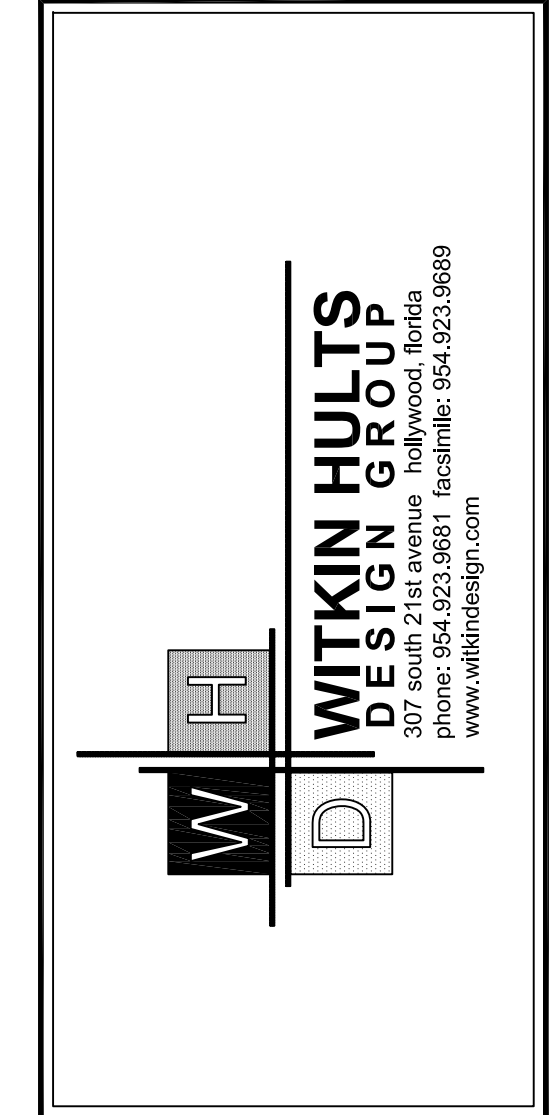


Project:

[illegible]

Seal:

Lic. # LA0000889
Member: A.S.L.A.

Drawing: LANDSCAPE PLAN
Date: 08/09/2017
Scale: See Left
Drawn by: CJH
Sheet No.:
L-1
Cad Id.: 2017-061

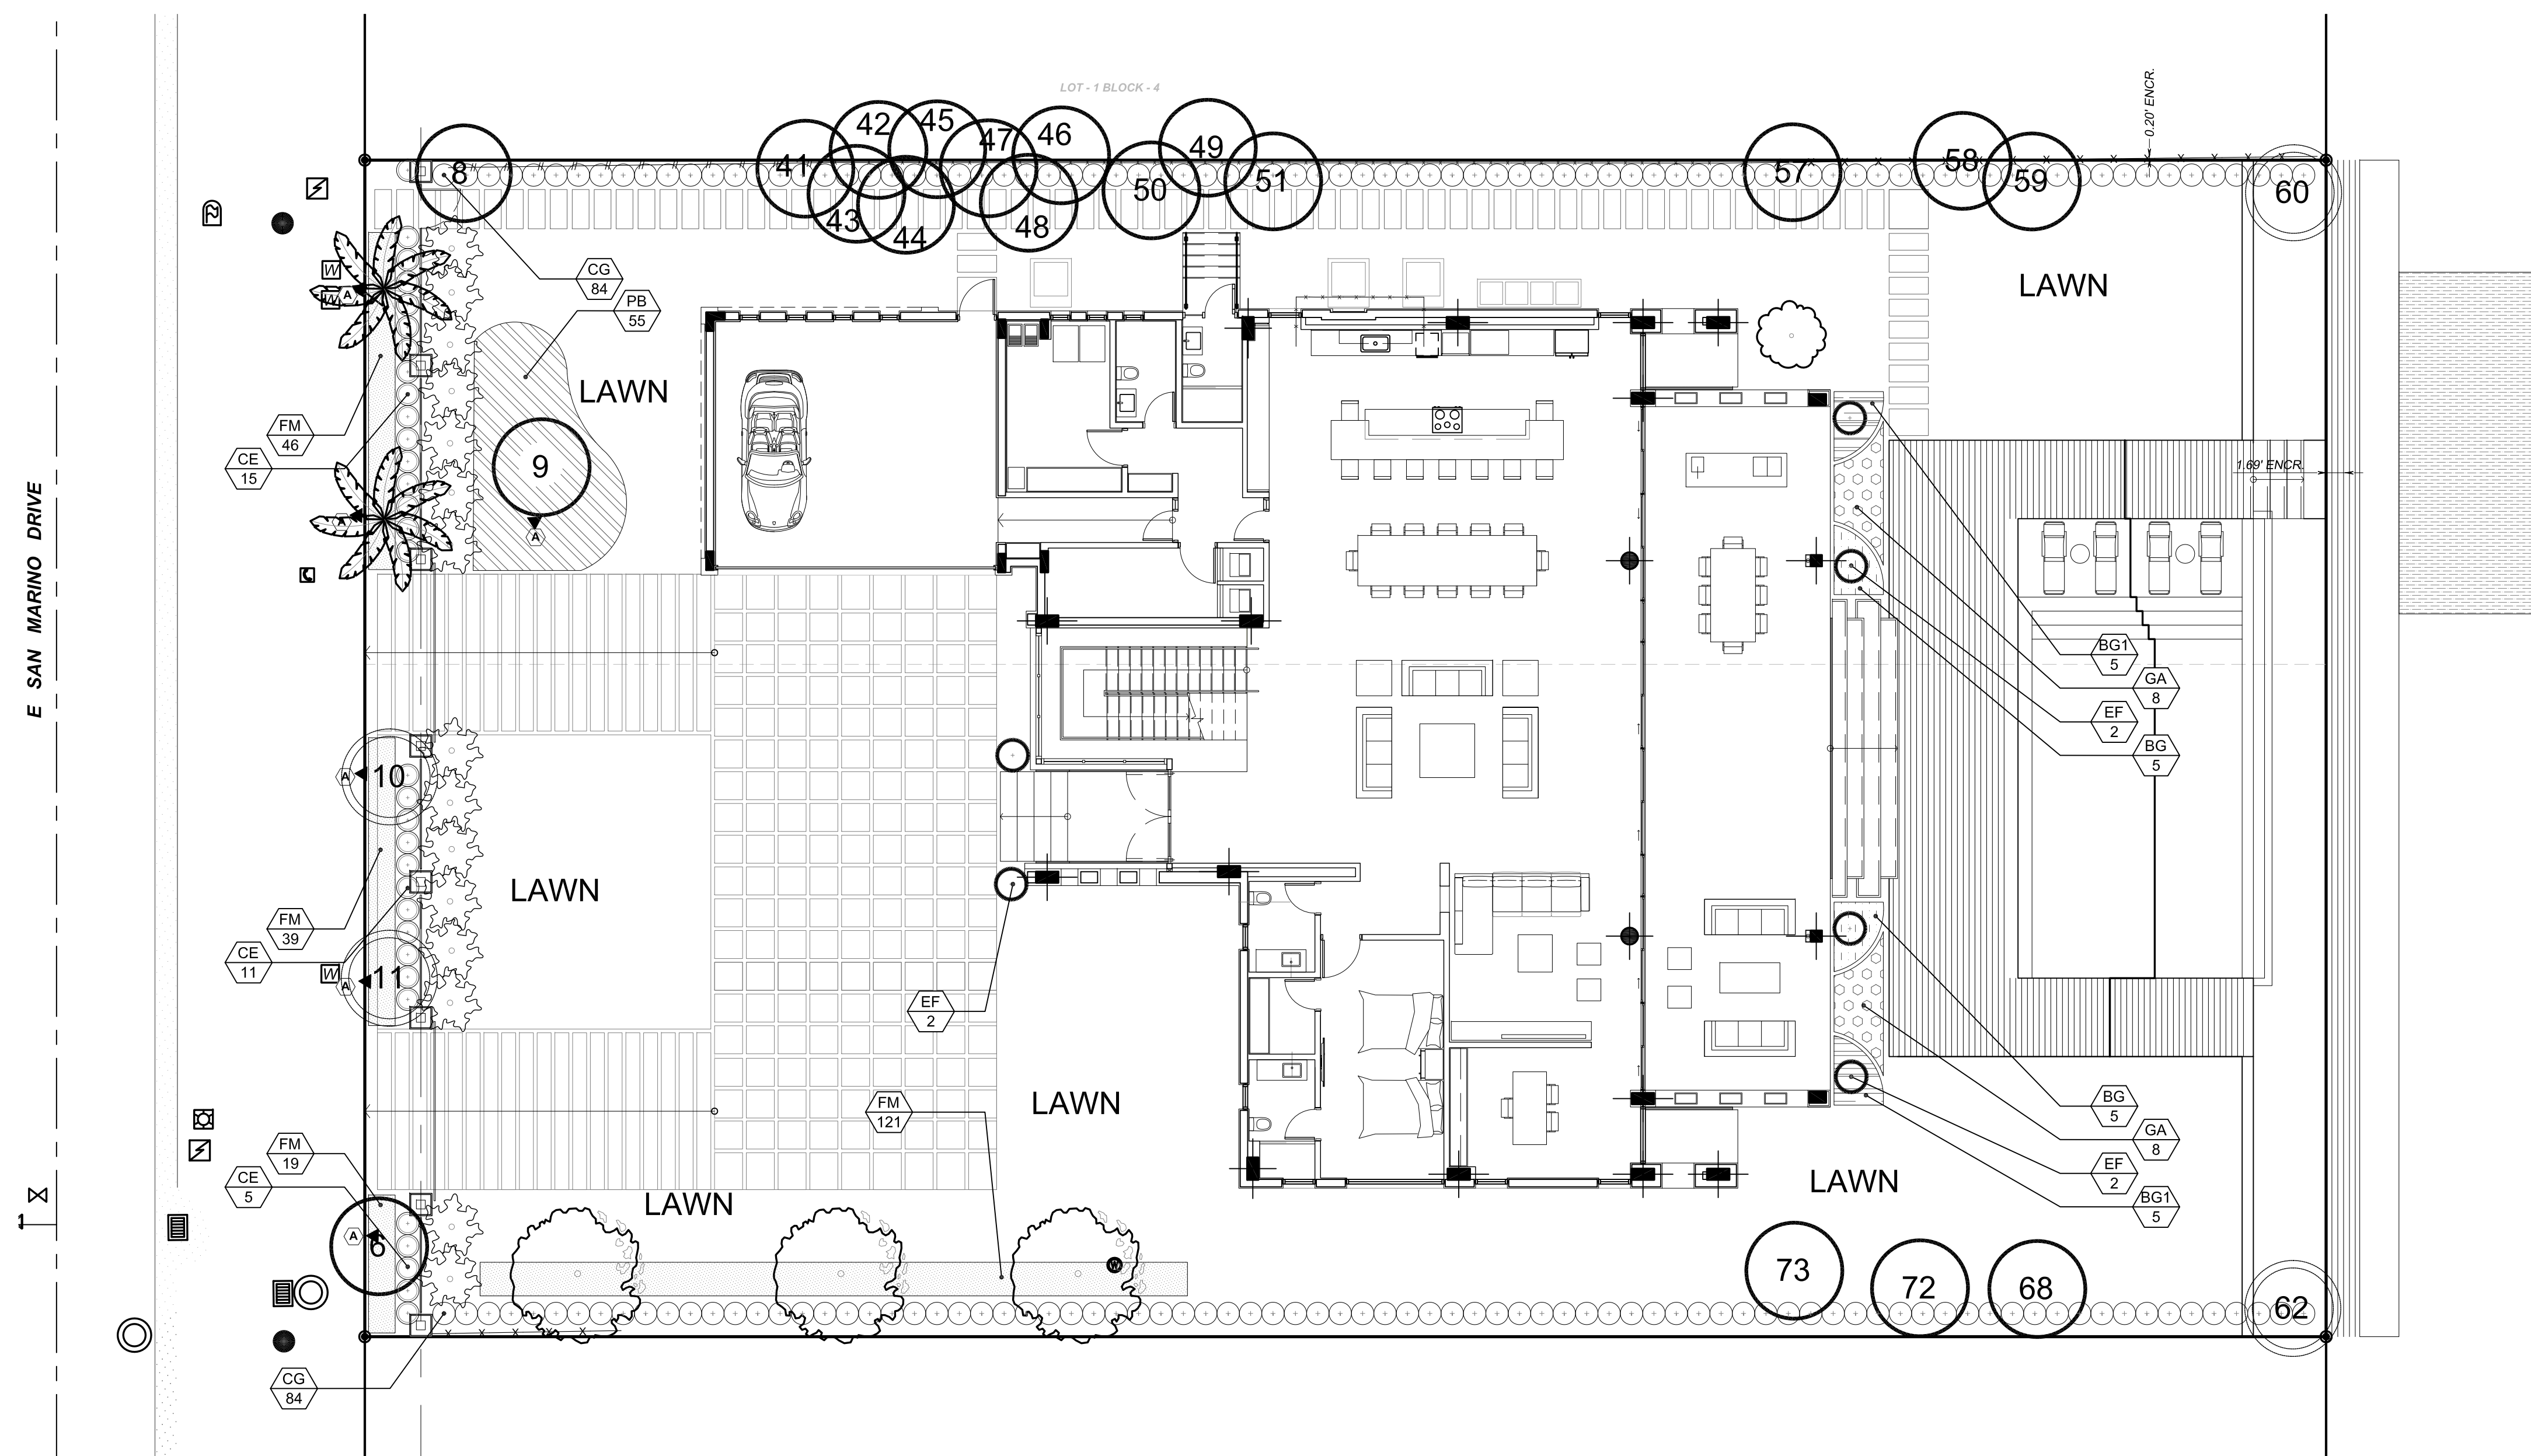

LANDSCAPE PLAN

Scale: 1"=10'-0"



LANDSCAPE LIGHTING FIXTURE SCHEDULE

TYPE	SYMBOL	DESCRIPTION	MANUFACTURER	CATALOG #	QTY	LAMP	MOUNTING	REMARKS	BALLAST/TRANSFORMER
* (A)	▼	Up Light	ARCLUCE	W-TT0033US-30 K	6	4W LED	GROUND STAKE	Uplight for Palms	120/227 VOLTAGE

*Contact Mads Schmidt with Infinity Architectural Lighting. 954.618.1028

LANDSCAPE LIST

TREES			
SYMBOL	QUAN.	PROPOSED MATERIAL	DESCRIPTION
	1	Citrus spp.	6'-8' HT
		FINAL SELECTION BY OWNER	25 GAL.
	3	Elaeocarpus decipiens	12'-14' HT., STANDARD
		JAPANESE BLUEBERRY	F.G.
	2	*Roystonea elata	20' O.A. HT. MIN. 4'C.T.
		ROYAL PALM	F.G.

SHRUBS AND GROUNDCOVERS

SYMBOL	QUAN.	PROPOSED MATERIAL	DESCRIPTION
BG	10	Bougainvillea 'New River' PURPLE BOUGAINVILLEA	24" HT. X 24" SPR. / 24" O.C. 3 GAL.
BG1	10	Bougainvillea 'Monrovia' ORANGE BOUGAINVILLEA	24" HT. X 24" SPR. / 24" O.C. 3 GAL.
CE	31	*Conocarpus erectus 'serotus' SILVER BUTTONWOOD	24" HT. X 24" SPR. / 24" O.C. 3 GAL.
CG	168	Clusia guttifera SMALL LEAF CLUSIA	24" HT. X 24" SPR. / 24" O.C. 3 GAL.
EF	6	*Eugenia foetida 'TOPIARY CONE' SPANISH STOPPER	7' O.A. HT. TOPIARY CONE 10 GAL., FULL TO BASE
FM	225	Ficus microcarpa 'Green Island' GREEN ISLAND FICUS	15" HT. X 15" SPR. / 15" O.C. 3 GAL.
GA	16	Gardenia augusta 'Miami Supreme' GARDENIA	24" HT. X 24" SPR. / 24" O.C. 3 GAL.
PB	55	Philodendron 'Burle Marx' BURLE MARX PHILODENDRON	24" HT. X 24" SPR. / 36" O.C. 3 GAL.
LAWN	As Required	Stenotaphrum secundatum 'Floratam' ST. AGUSTINE GRASS	SOLID EVEN SOD

* DENOTES NATIVE SPECIES

○ Tree to Remain, TYP.

 Tree to Relocate, TYP.