 
 
 
 
 
 
 
 
 
 
 

 

 

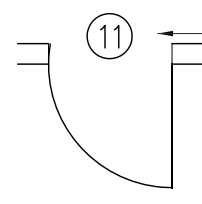
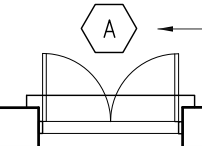
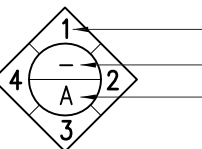

 

 
 
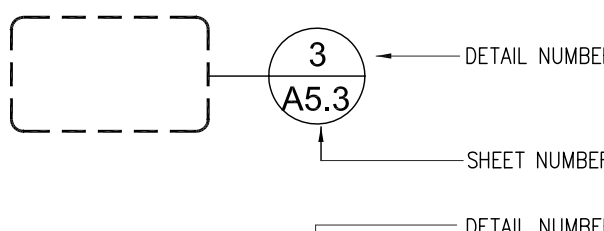
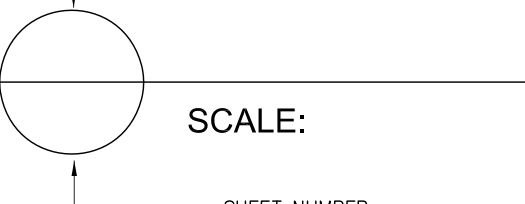
 

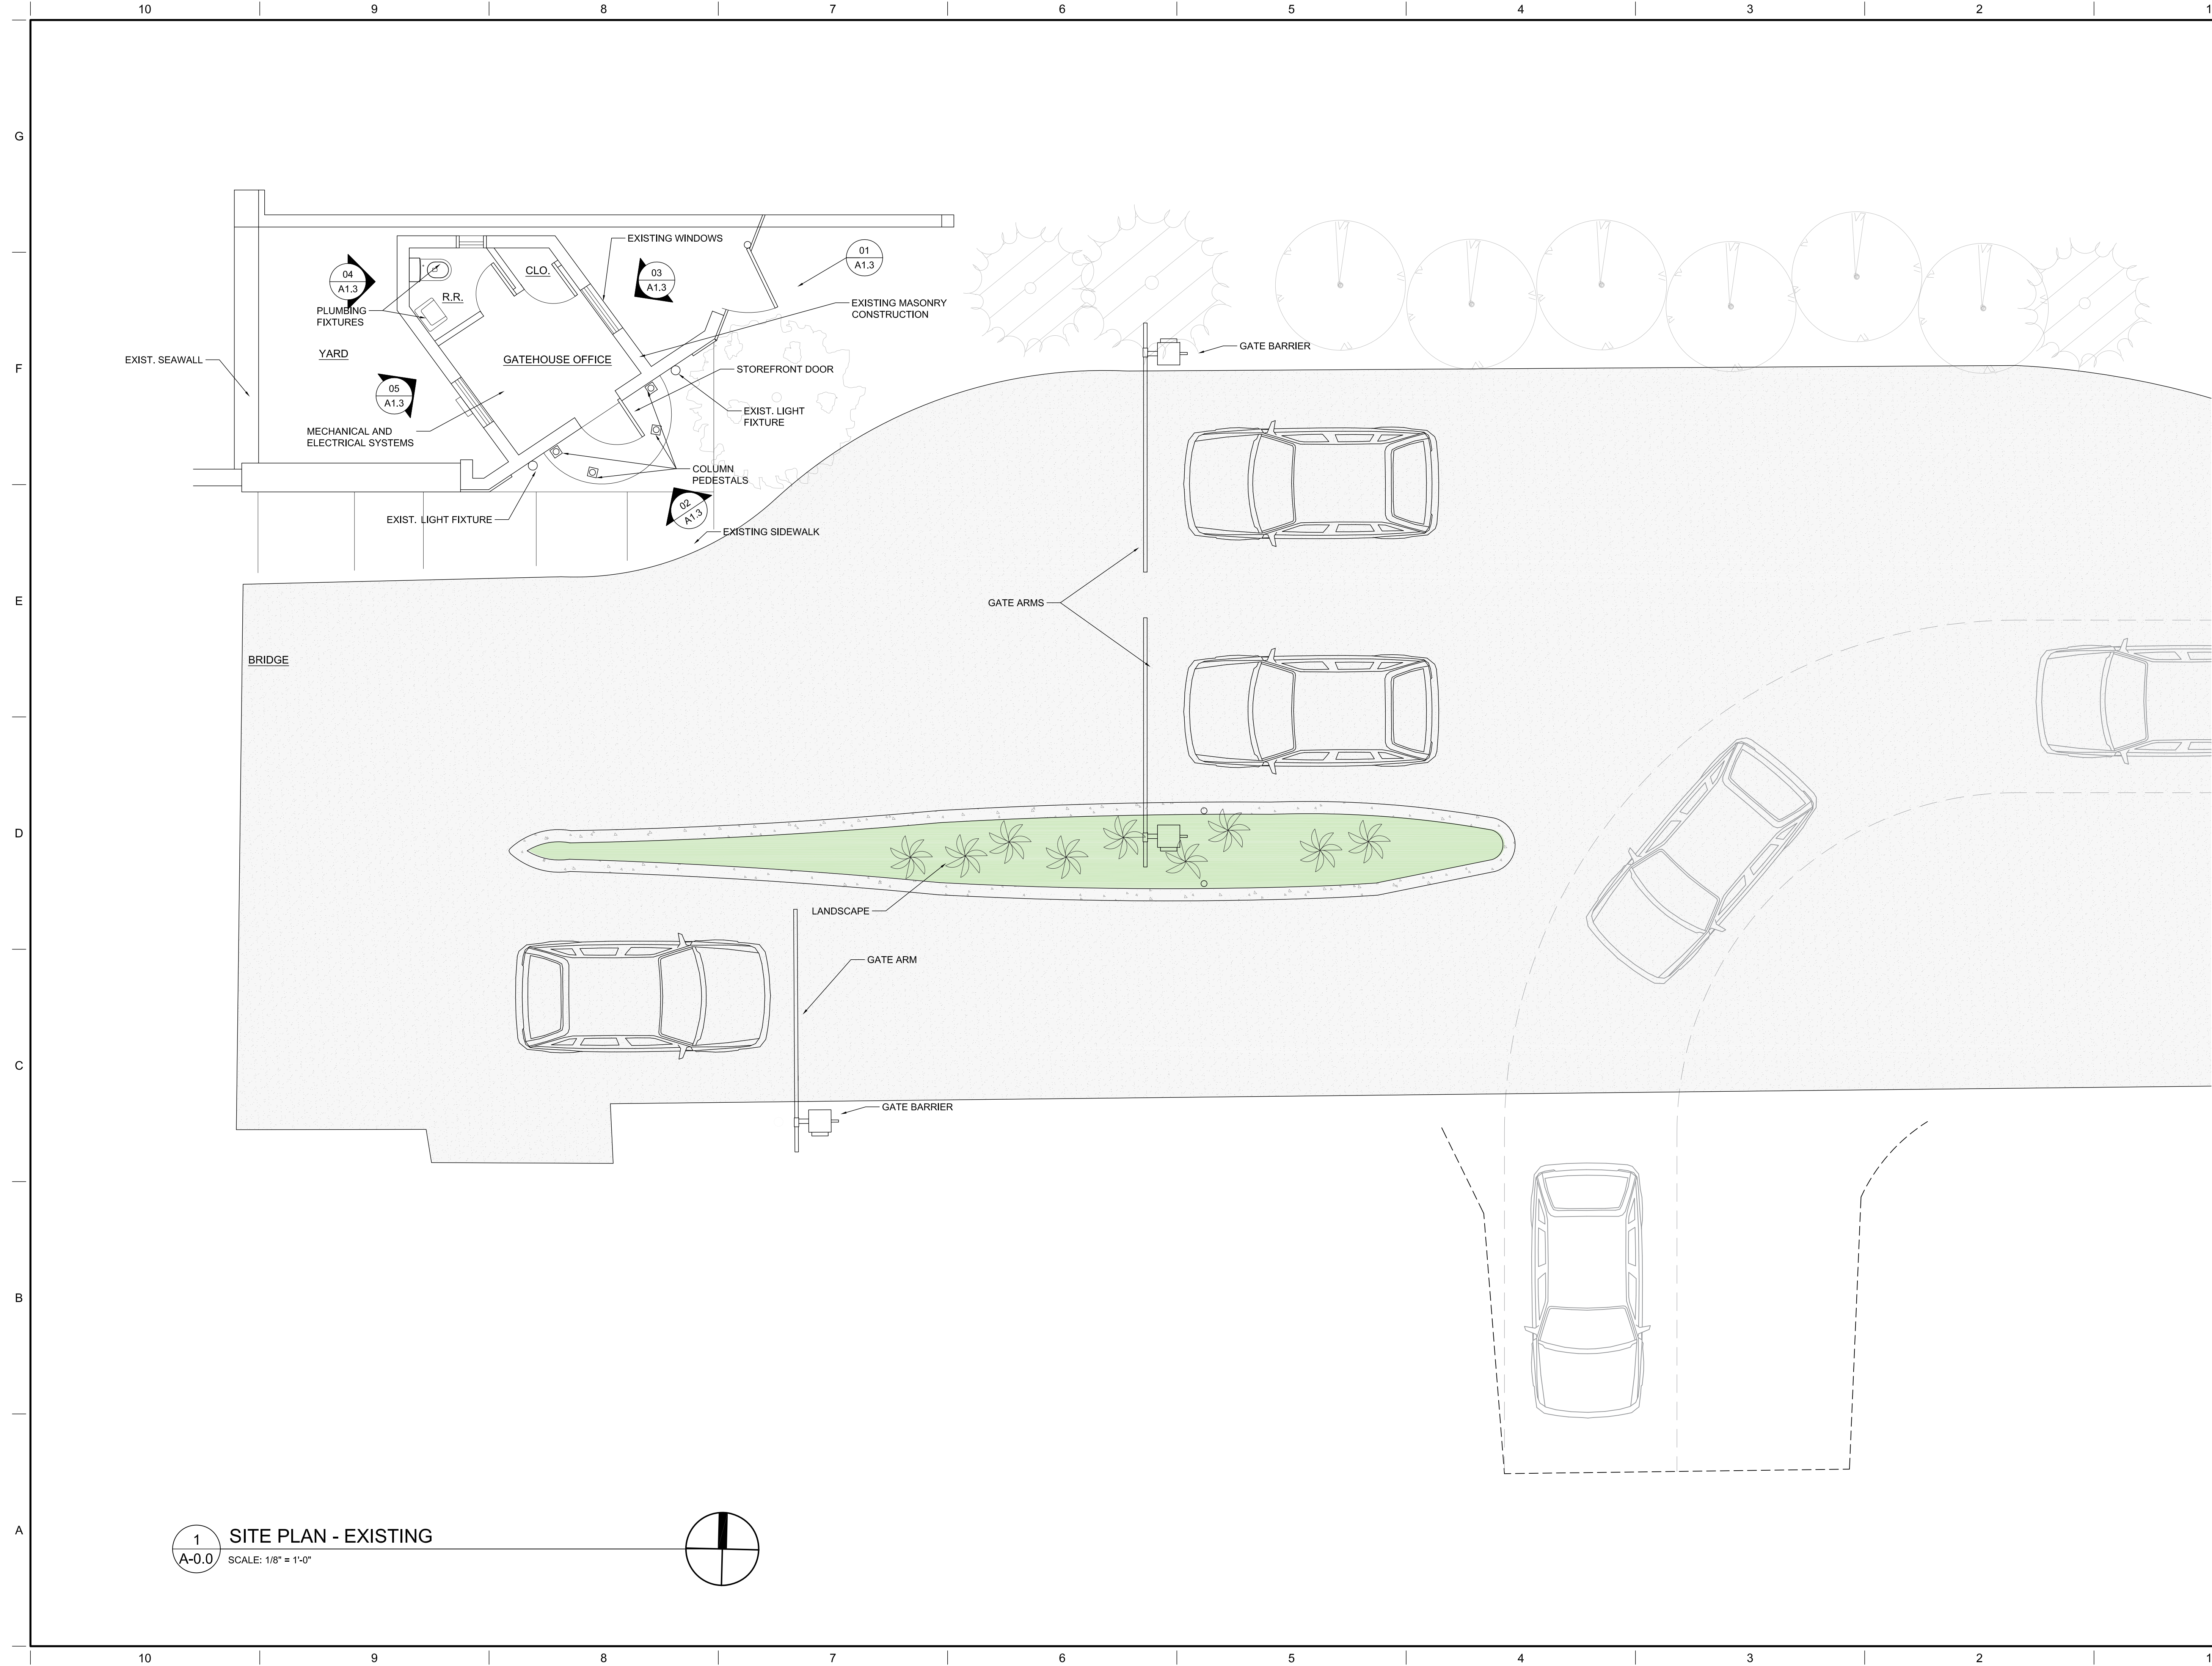


<div><div>MATERIAL SYMBOLS</div><div><div><div>INSULATION Blanket</div><div>INSULATION Light Weight</div><div>INSULATION Rigid</div><div>PORTLAND CEMENT MORTAR (Latex fortified)</div><div>PLYWOOD</div><div>SHEET METAL</div><div>STEEL Small Scale</div><div>STEEL Large Scale</div><div>TILE Ceramic / Marble</div><div>CONCRETE</div><div>CONCRETE MASONRY UNIT</div><div>GLASS</div><div>CEMENT BOARD</div><div>ACOUSTIC TILE</div><div>WOOD Finished</div><div>WOOD Blocking</div></div></div><div><div>DRAWING SYMBOLS</div><div><div>ROOM NAME</div><div>MECHANICAL</div><div>ROOM NAME</div></div><div><div>DOOR SYMBOL</div><div>DOOR NUMBER / TYPE</div></div><div><div>WINDOW SYMBOL</div><div>WINDOW NUMBER / TYPE</div></div><div><div>INTERIOR ELEVATIONS</div><div>ELEVATION NUMBERS DRAWING NUMBER SHEET NUMBER</div></div><div><div>FINISH TAG</div><div>FINISH NUMBER</div></div><div><div>PLUMBING FIXTURE &amp; ACCESSORIES TAG</div><div>PLUMBING FIXTURE / ACCESSORIES NUMBER</div></div><div><div>EQUIPMENT TAG</div><div>EQUIPMENT LETTER</div></div><div><div>LIGHT FIXTURE TAG</div><div>LIGHT FIXTURE LETTER</div></div><div><div>SECTION/DETAIL</div><div>DRAWING NUMBER SHEET NUMBER</div></div><div><div>DETAIL</div><div>DETAIL NUMBER SHEET NUMBER DETAIL NUMBER</div></div><div><div>DRAWING TITLE</div><div>SCALE: SHEET NUMBER KEYED FROM</div></div><div><div>ELEVATION ABOVE DATUM</div><div>ELEVATION ABOVE DATUM NOTE</div></div><div><div>DRAWING REVISION</div><div>REVISION NUMBER</div></div></div></div>	<div>BUILDING ANALYSIS</div> <div><div>AREA:</div><div><div>EXISTING GATEHOUSE</div><div>PROPOSED GATEHOUSE</div></div><div><div>= 114 SF</div><div>= 40 SF</div></div></div>	<div><div>SUNSET ISLAND 1 AND 2</div><div>PROPOSED GATE HOUSE</div><div>CMB DESIGN REVIEW APPLICATION</div><div>William Lane Architect, Inc.</div><div><div>1480 MARSEILLE DRIVE</div><div>MIAMI BEACH, FLORIDA 33141</div><div>T: 305 865 7830</div><div>F: 305 865 7832</div><div>LIC. #: AA0003666</div></div></div> <div>ZONING:</div> <div>USE CODE: GU</div>
		<div>DRAWING INDEX:</div> <div><div>Architecture</div><div>A-0.0 Existing Site Plan</div><div>A-1.0 Site Context and Proposed Plan</div><div>A-1.1 Site Photos</div><div>A-1.2 New Gate House Floor Plan</div><div>A-1.3 Existing Gate House</div><div>A-2.0 Proposed Elevations</div><div>A-2.1 3D Model</div><div>LP-1.0 Landscape</div><div>Survey</div><div>Site Survey</div><div>Historic Documentation of Existing Gatehouse</div></div>



SEAL OF PROJECT ARCHITECT:  
William Lane  
License # AR0014247

**WILLIAM LANE ARCHITECT, INC.**

1480 MARSEILLE DRIVE  
MIAMI BEACH, FLORIDA 33141  
LIC. #: AA0003666  
T: 305 865 7830  
F: 305 865 7832

## SUNSET ISLAND 1 AND 2

**GATE HOUSE**  
**NORTH BAY ROAD & 29TH STREET**  
**MIAMI, FL**

REVISIONS:

(C) COPYRIGHT 2016 ALL RIGHTS RESERVED. THESE DRAWINGS AND SPECIFICATIONS ARE INSTRUMENTS OF SERVICE AND SHALL REMAIN THE PROPERTY OF WILLIAM LANE ARCHITECT. THE ARCHITECT AGREES THAT THE PROJECT FOR WHICH THEY WERE PREPARED IS EXECUTED OR NOT, THEY ARE NOT TO BE USED IN ANY MANNER ON OTHER PROJECTS OR EXTENSIONS TO THIS PROJECTS WITHOUT AN AGREEMENT IN WRITING AND WITH THE APPROPRIATE COMPENSATION TO WILLIAM LANE ARCHITECT, INC. REPRODUCTIONS OF DRAWINGS AND SPECIFICATIONS WITHOUT THE WRITTEN CONSENT OF WILLIAM LANE ARCHITECT, INC. IS PROHIBITED. CONTRACTOR IS RESPONSIBLE FOR VERIFYING ALL SITE CONDITIONS PRIOR TO PROCEEDING AND MUST REPORT ANY DISCREPANCIES TO THE ARCHITECT PRIOR TO COMMENCEMENT OF WORK.

OWNER:  
City of Miami Beach

DATE:  
FEBRUARY 23, 2015

PHASE:

SHEET DESCRIPTION:

EXISTING  
CONDITION

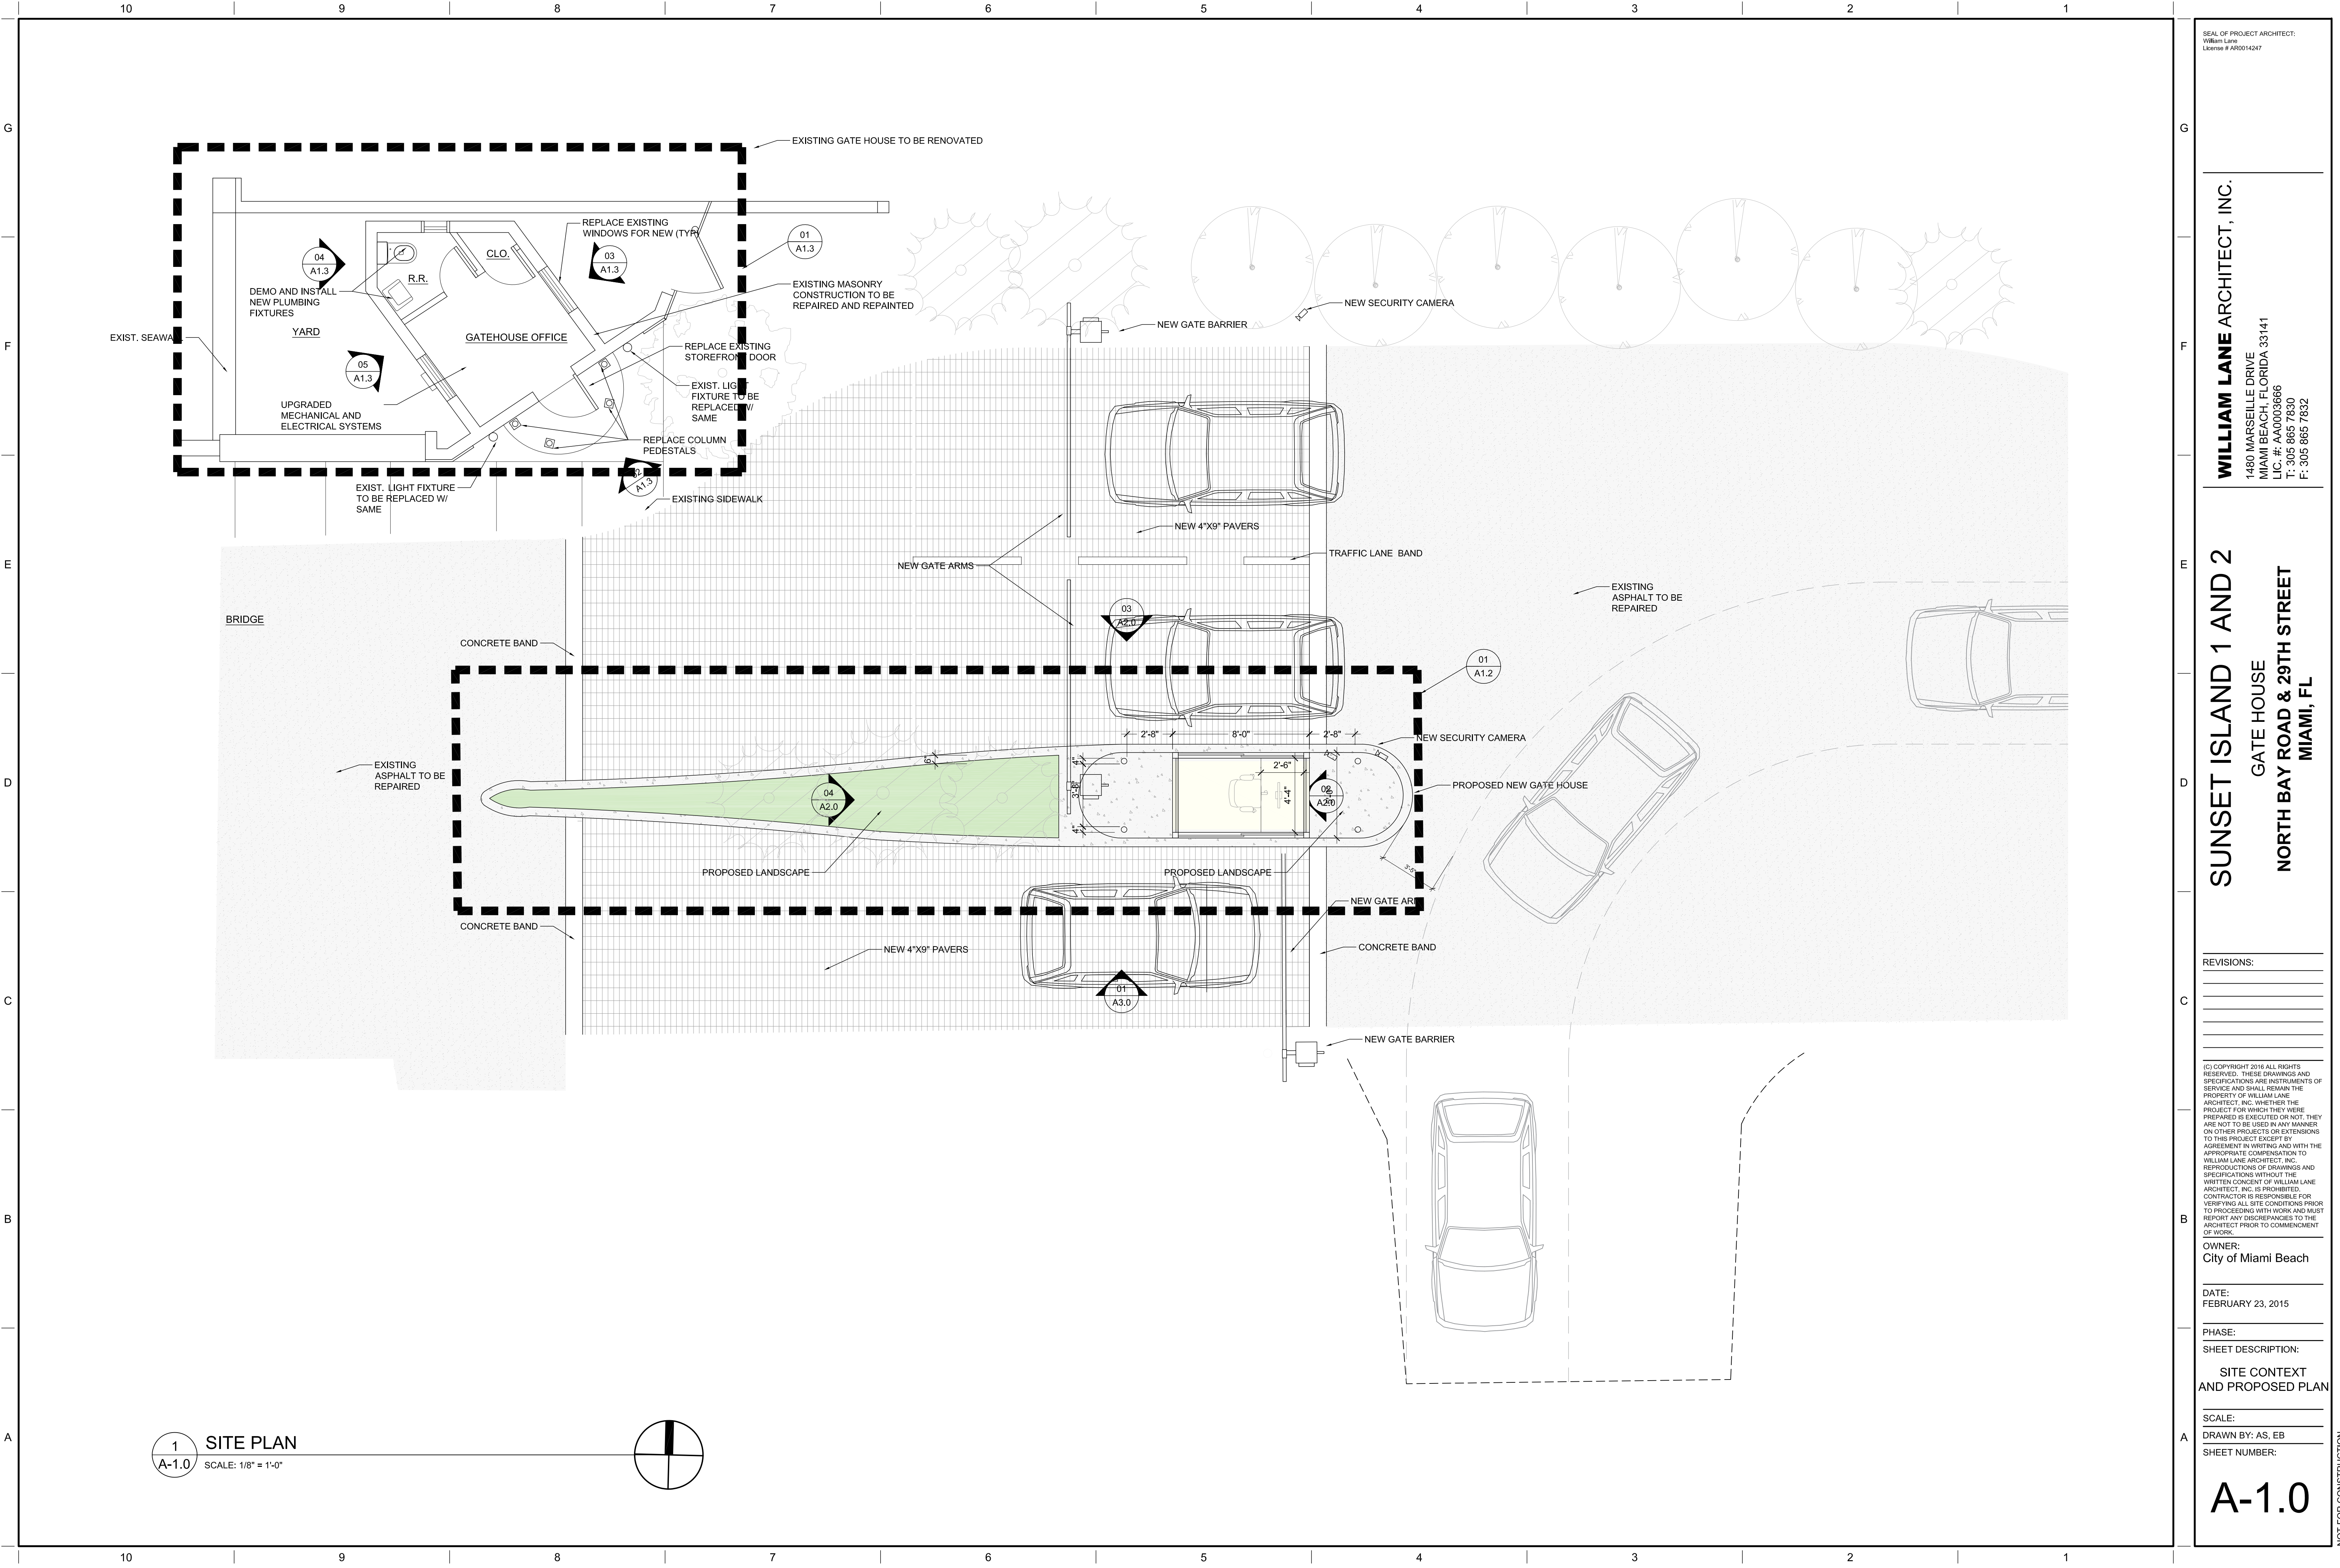
SCALE:

DRAWN BY: AS, EB

SHEET NUMBER:

A-0.0

NOT FOR CONSTRUCTION



SEAL OF PROJECT ARCHITECT:  
William Lane  
License # AR0014247

**WILLIAM LANE ARCHITECT, INC.**  
1480 MARSEILLE DRIVE  
MIAMI BEACH, FLORIDA 33141  
LIC. #: AA0003666  
T: 305 865 7830  
F: 305 865 7832

**SUNSET ISLAND 1 AND 2**  
**GATE HOUSE**  
**NORTH BAY ROAD & 29TH STREET**  
**MIAMI, FL**

REVISIONS:


(C) COPYRIGHT 2016 ALL RIGHTS RESERVED. THESE DRAWINGS AND SPECIFICATIONS ARE INSTRUMENTS OF SERVICE AND SHALL REMAIN THE PROPERTY OF WILLIAM LANE ARCHITECT, INC. WHETHER THE PROJECT FOR WHICH THEY WERE PREPARED IS EXECUTED OR NOT, THEY ARE NOT TO BE USED IN ANY MANNER ON OTHER PROJECTS OR EXTENSIONS TO THIS PROJECT EXCEPT BY AGREEMENT IN WRITING AND WITH THE APPROPRIATE COMPENSATION TO WILLIAM LANE ARCHITECT, INC. REPRODUCTIONS OF DRAWINGS AND SPECIFICATIONS WITHOUT THE WRITTEN CONSENT OF WILLIAM LANE ARCHITECT, INC. IS PROHIBITED. CONTRACTOR IS RESPONSIBLE FOR VERIFYING ALL SITE CONDITIONS PRIOR TO PROCEEDING WITH WORK AND MUST REPORT ANY DISCREPANCIES TO THE ARCHITECT PRIOR TO COMMENCEMENT OF WORK.

OWNER:  
City of Miami Beach

DATE:  
FEBRUARY 23, 2015

PHASE:  
SHEET DESCRIPTION:

SITE CONTEXT  
AND PROPOSED PLAN

SCALE:  
DRAWN BY: AS, EB

SHEET NUMBER:

**A-1.0**

NOT FOR CONSTRUCTION



SEAL OF PROJECT ARCHITECT:  
William Lane  
License # AR014247

**WILLIAM LANE ARCHITECT, INC.**  
1480 MARSELLE DRIVE  
MIAMI BEACH, FLORIDA 33141  
LIC. #: AA000666  
T: 305 865 7830  
F: 305 865 7832

**SUNSET ISLAND 1 AND 2**  
GATE HOUSE  
NORTH BAY ROAD & 29TH STREET  
MIAMI, FL

REVISIONS:

(C) COPYRIGHT 2016 ALL RIGHTS RESERVED. THESE DRAWINGS AND SPECIFICATIONS ARE INSTRUMENTS OF SERVICE AND SHALL REMAIN THE PROPERTY OF WILLIAM LANE ARCHITECT, INC. WHETHER THE PROJECT FOR WHICH THEY WERE PREPARED IS EXECUTED OR NOT. THEY ARE NOT TO BE USED IN ANY MANNER ON OTHER PROJECTS OR EXTENSIONS TO THIS PROJECT EXCEPT BY AGREEMENT IN WRITING AND WITH THE APPROPRIATE COMPENSATION TO WILLIAM LANE ARCHITECT, INC. REPRODUCTIONS OF DRAWINGS AND SPECIFICATIONS WITHOUT THE WRITTEN CONSENT OF WILLIAM LANE ARCHITECT, INC. IS PROHIBITED. CONTRACTOR IS RESPONSIBLE FOR VERIFYING ALL SITE CONDITIONS PRIOR TO PROCEEDING WITH WORK AND MUST REPORT ANY DISCREPANCIES TO THE ARCHITECT PRIOR TO COMMENCEMENT OF WORK.

OWNER:  
City of Miami Beach

DATE:  
FEBRUARY 23, 2015

PHASE:  
SHEET DESCRIPTION:  
SITE PHOTOS

SCALE:  
DRAWN BY: AS, EB  
SHEET NUMBER:

**A-1.1**

NOT FOR CONSTRUCTION