





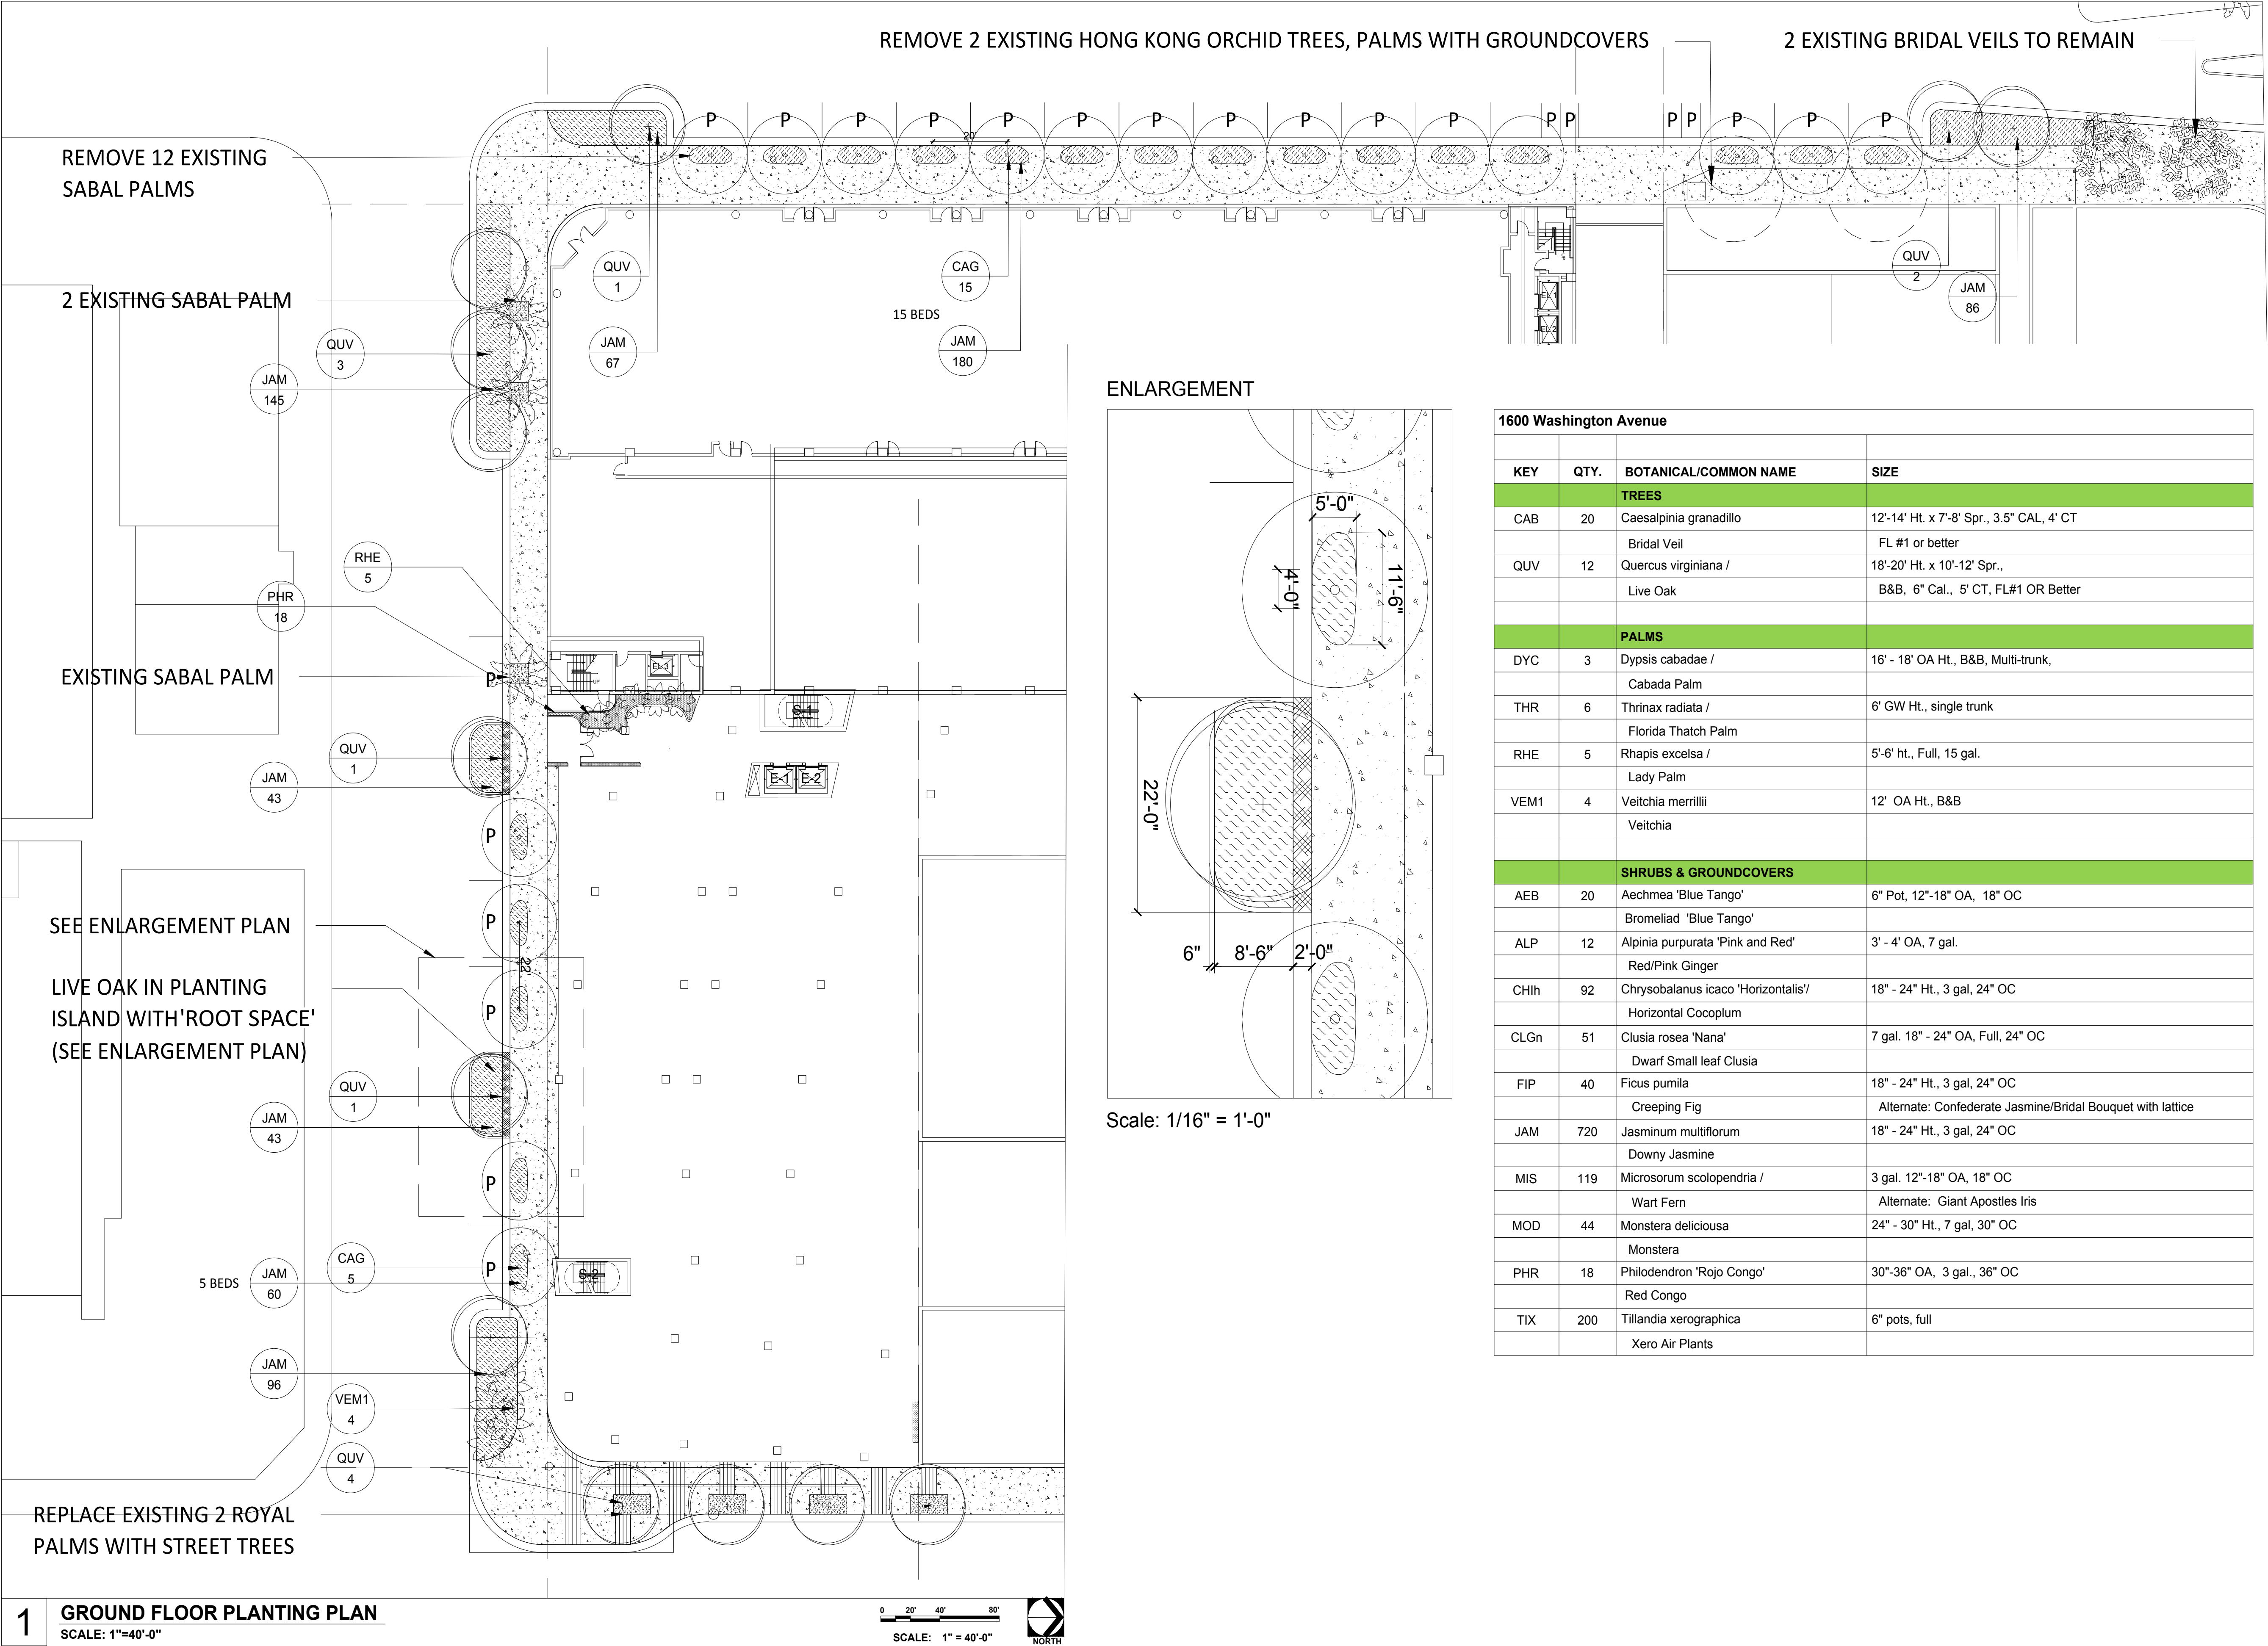

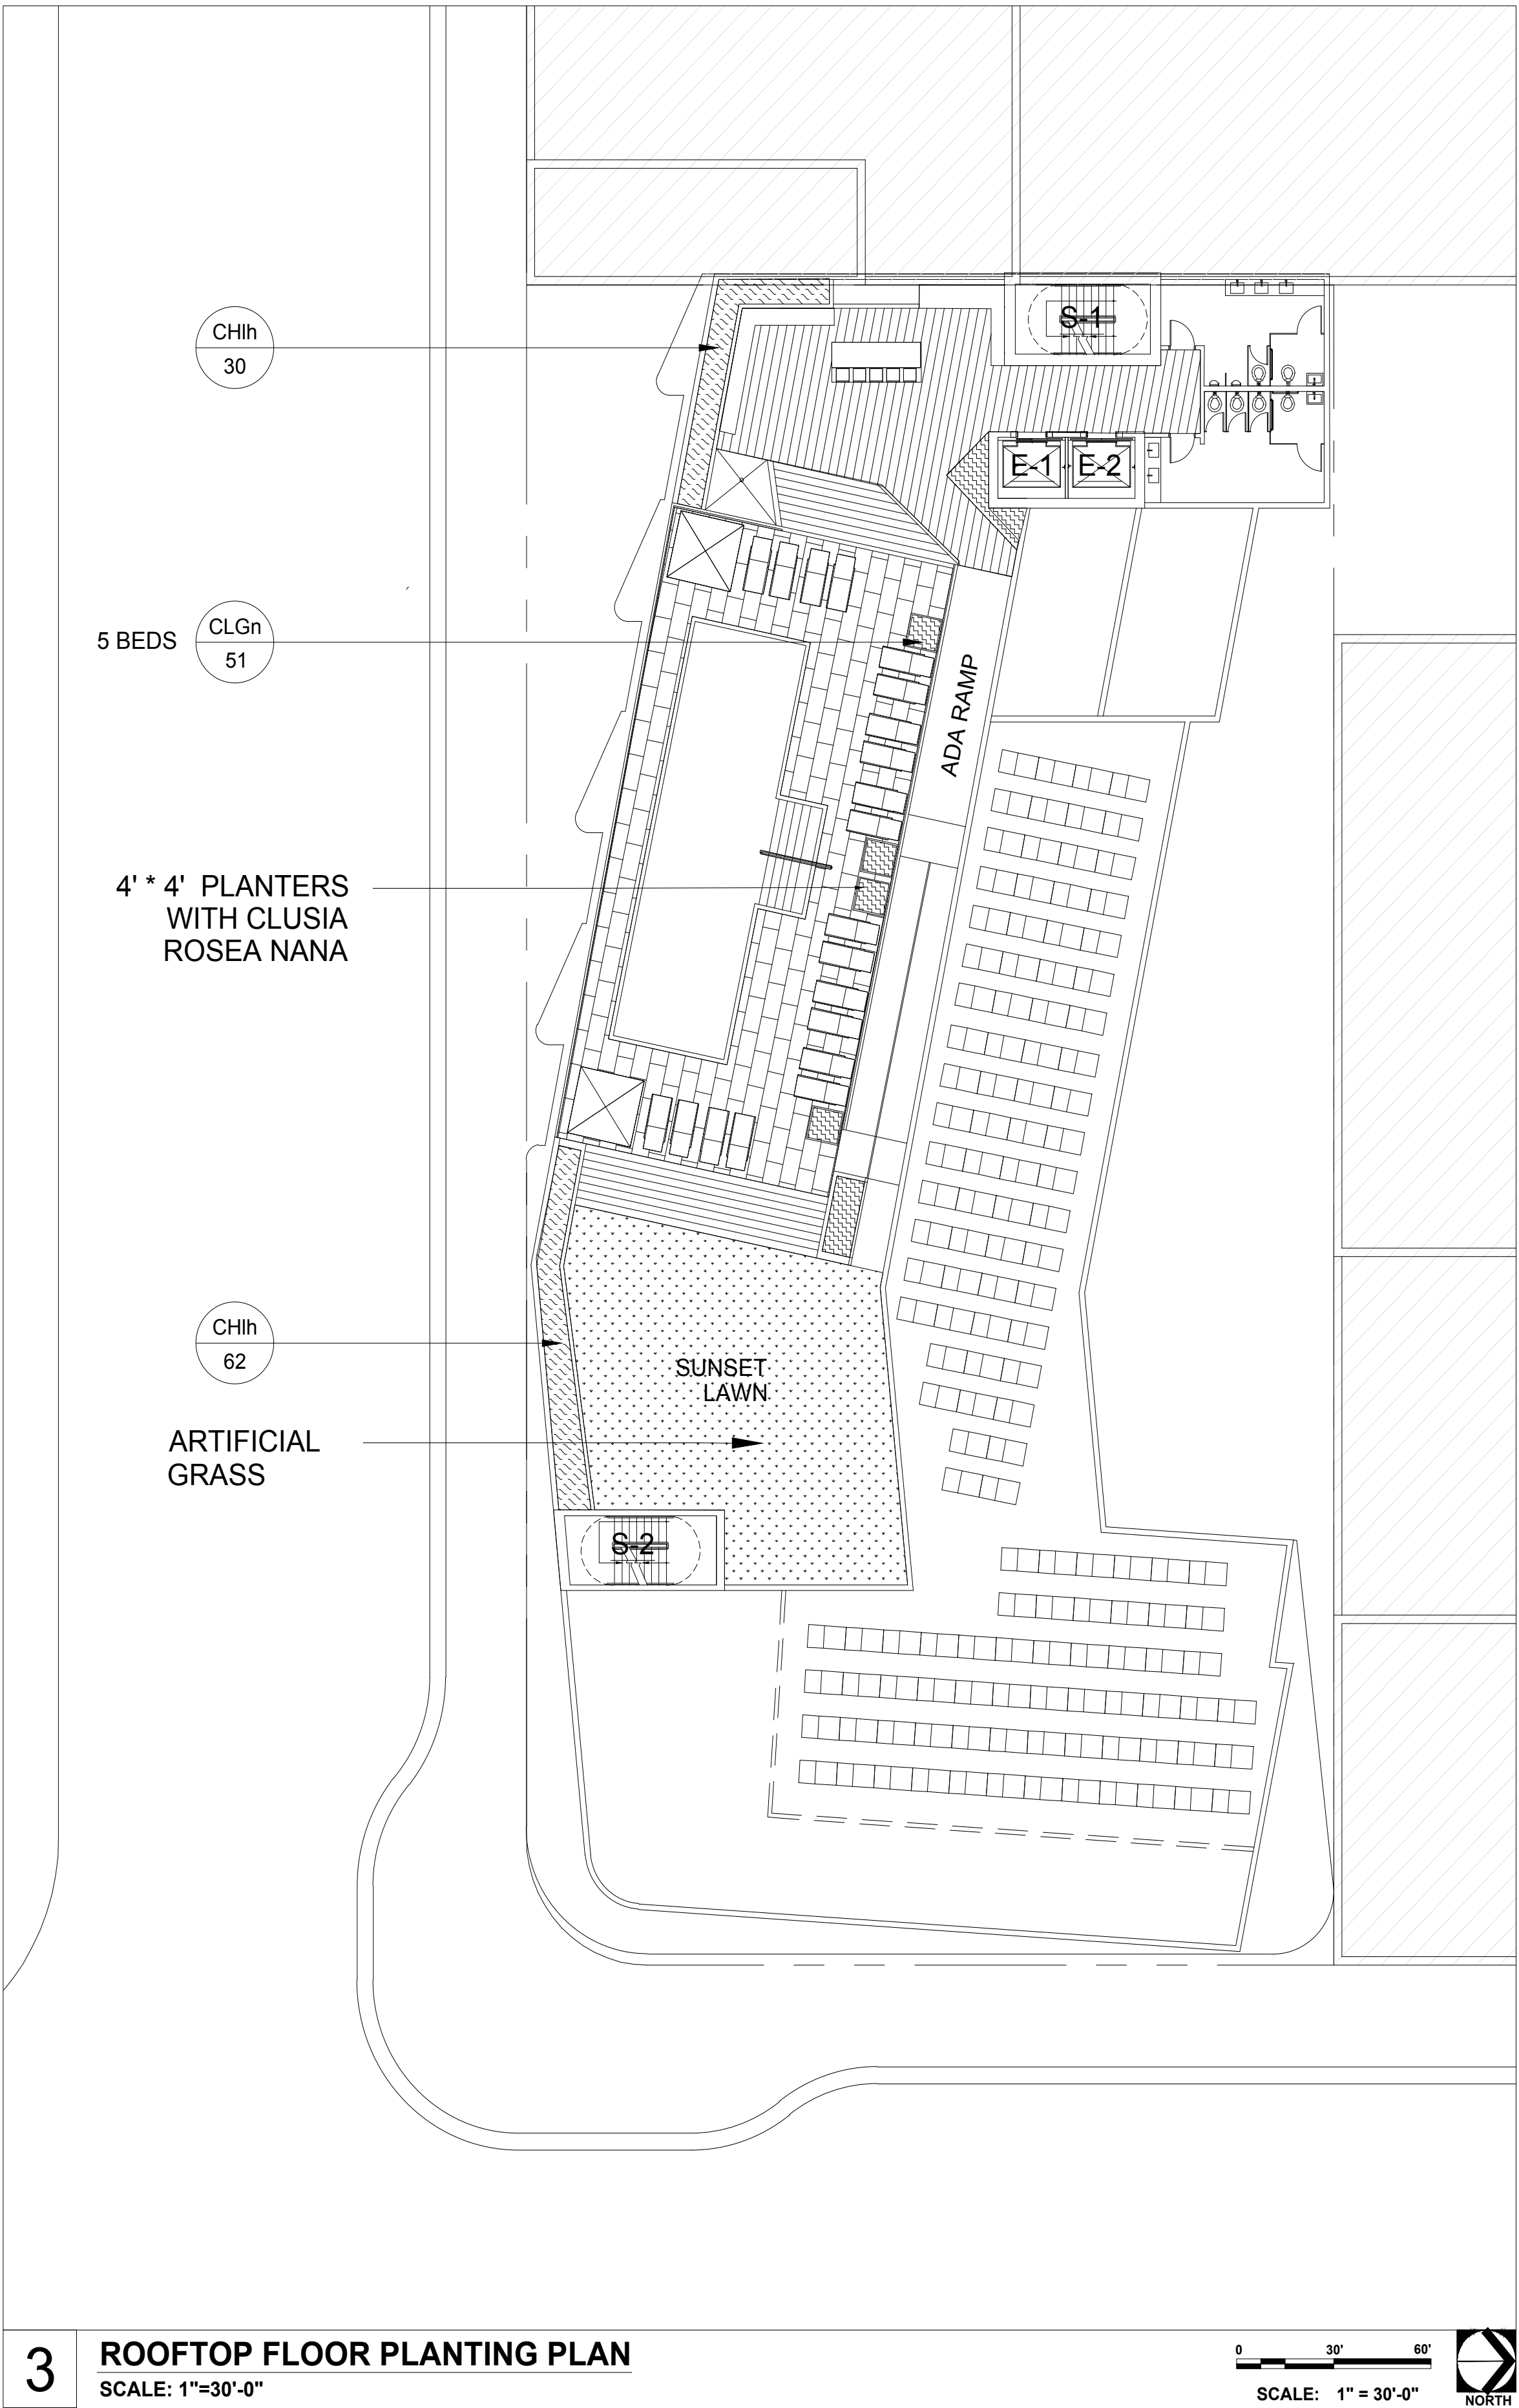

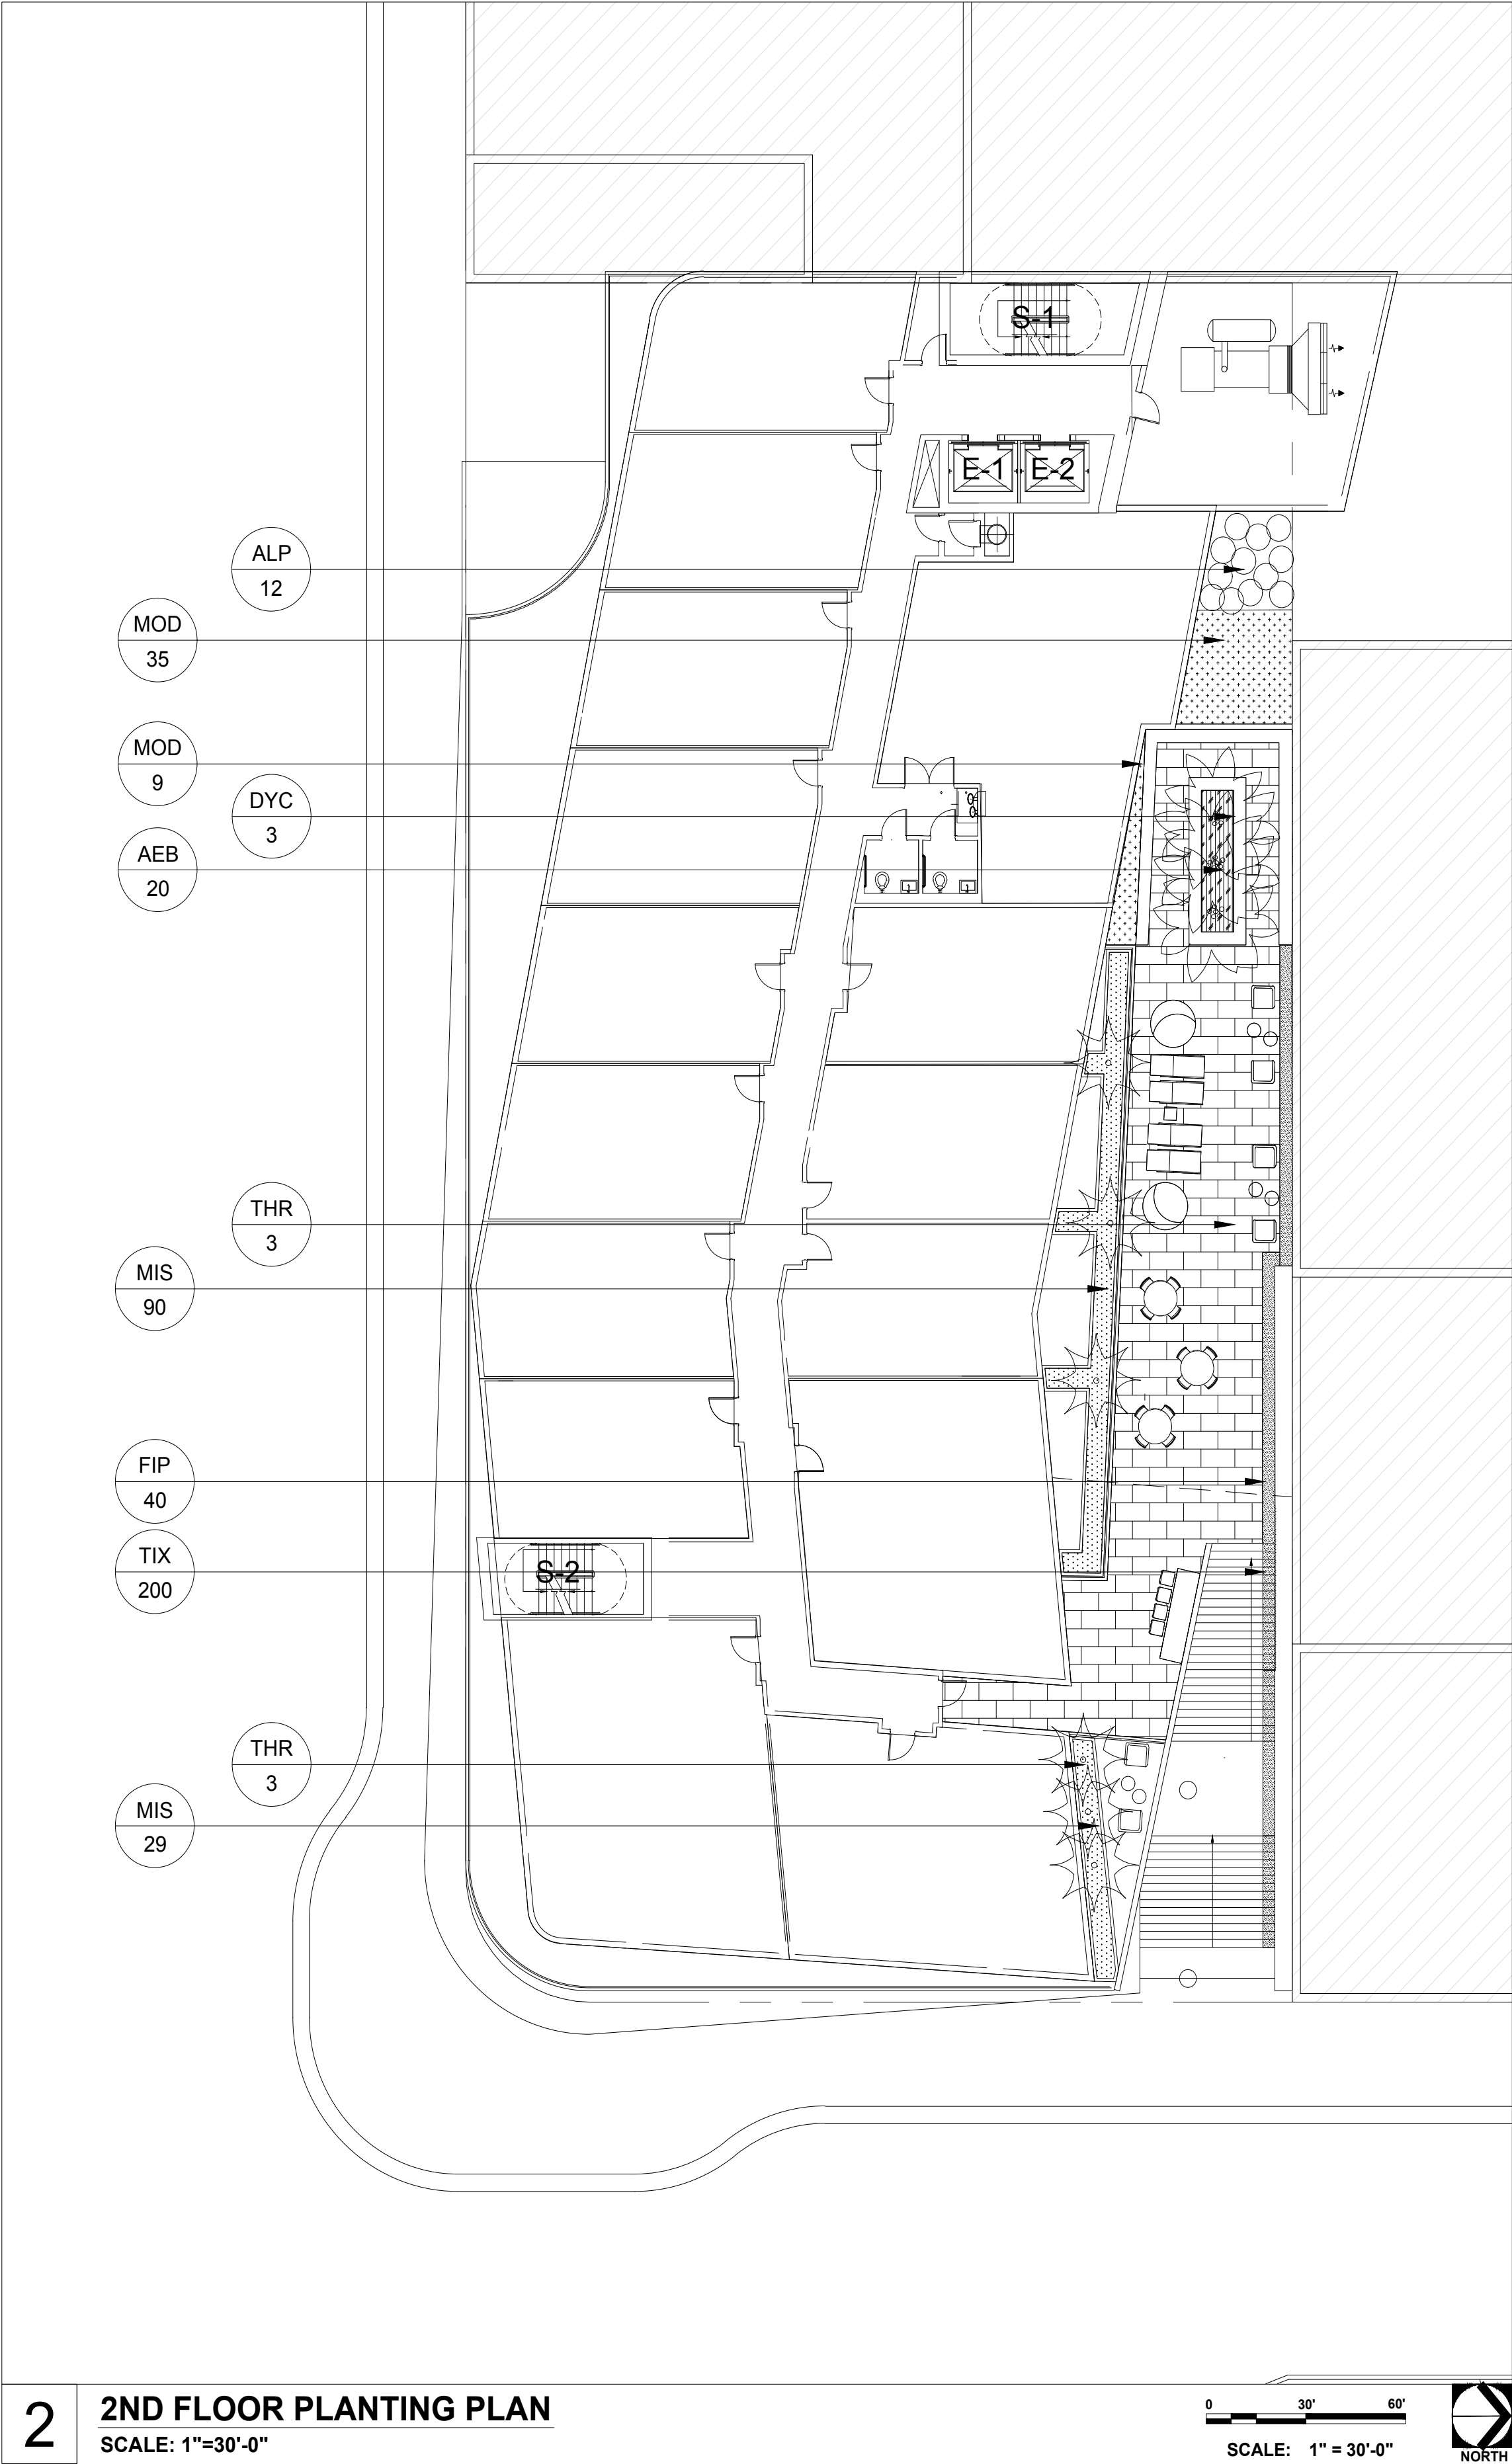

HARDSCAPE

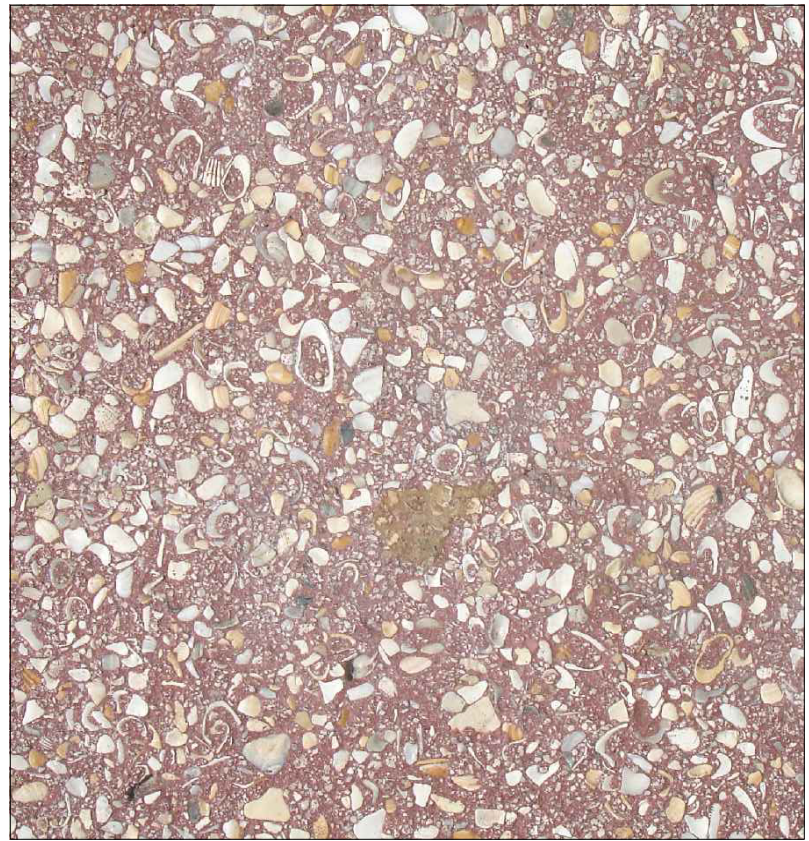

Concrete with Exposed Aggregate



Pervious Pavement

LIGHTING




Poulsen Satellite Light (Existing)



Miami Beach 'Red' with Existing Concrete Band Poulsen Satellite Streetlights

LEGEND


- 5' x 5' Pervious Pavement
- Miami Beach 'Red' Concrete with exposed shell aggregate'
- Flush Grate
- Concrete Bands
- Poulsen Light fixture, match existing
- 'RootSpace' Structural Soil Modules

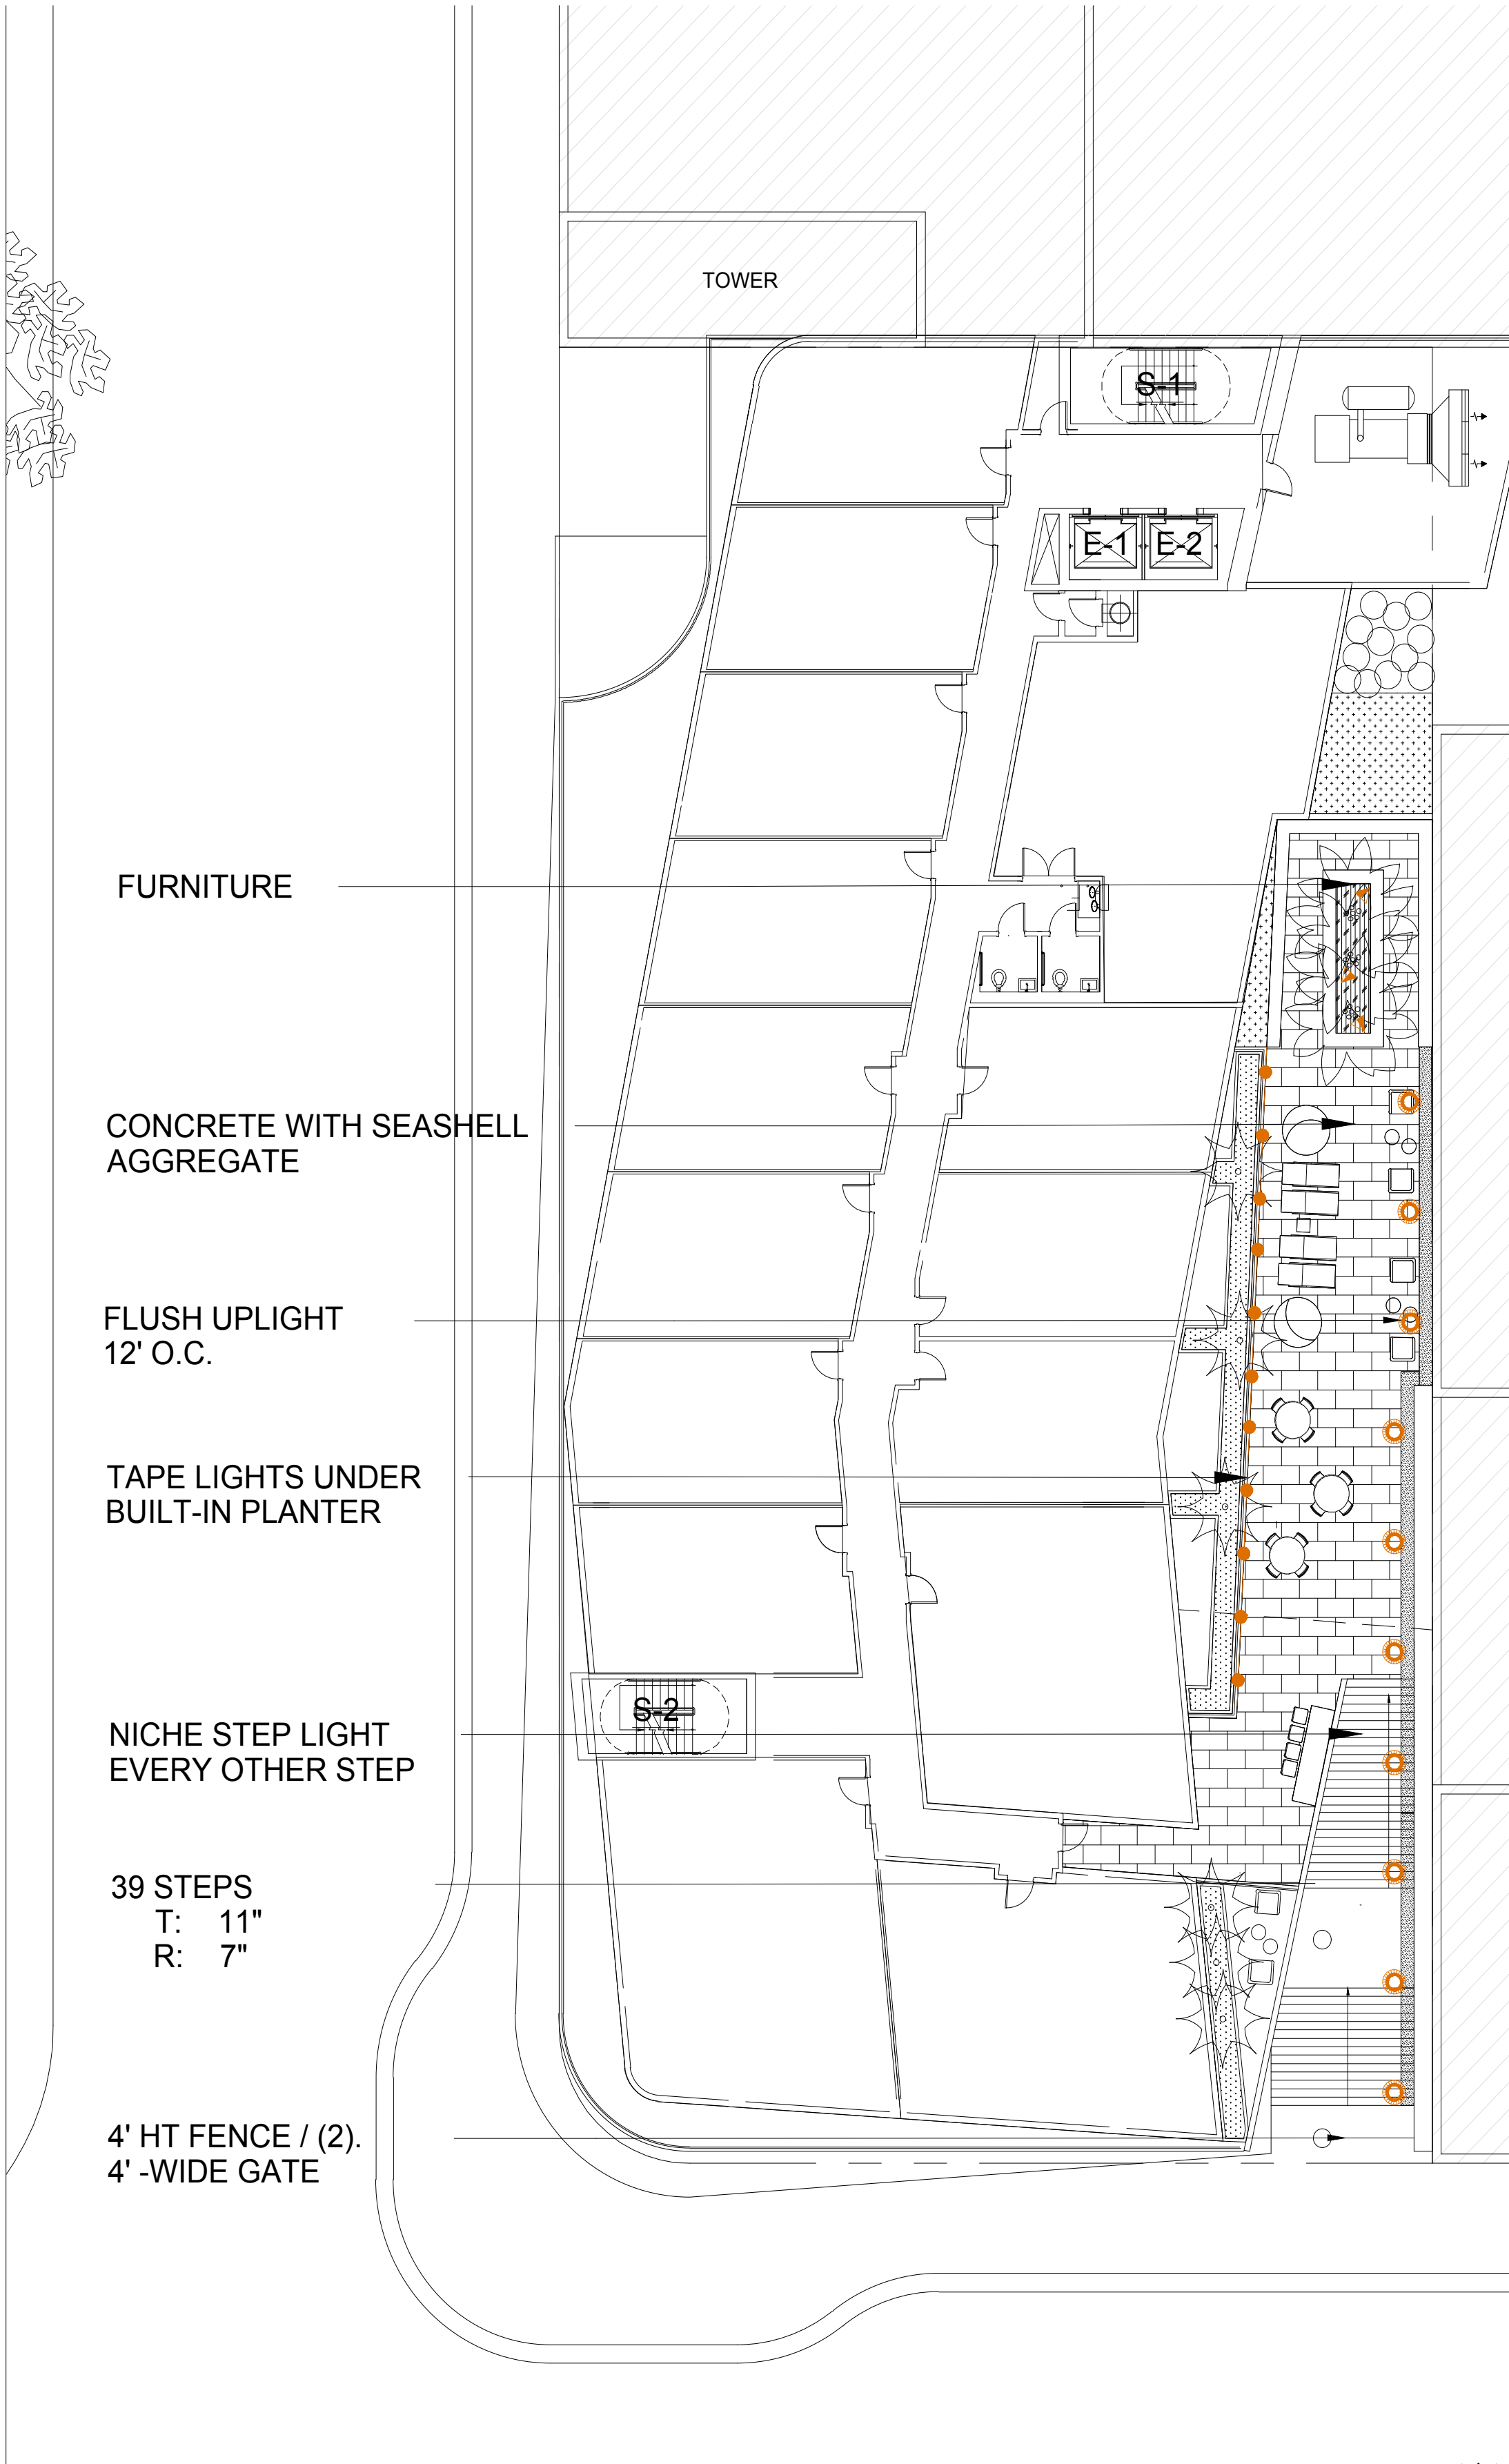

2 2ND FLOOR HARDSCAPE & LIGHTING PLAN
 SCALE: 1"=30'-0"

0 30' 60'
 SCALE: 1" = 30'-0"

NORTH

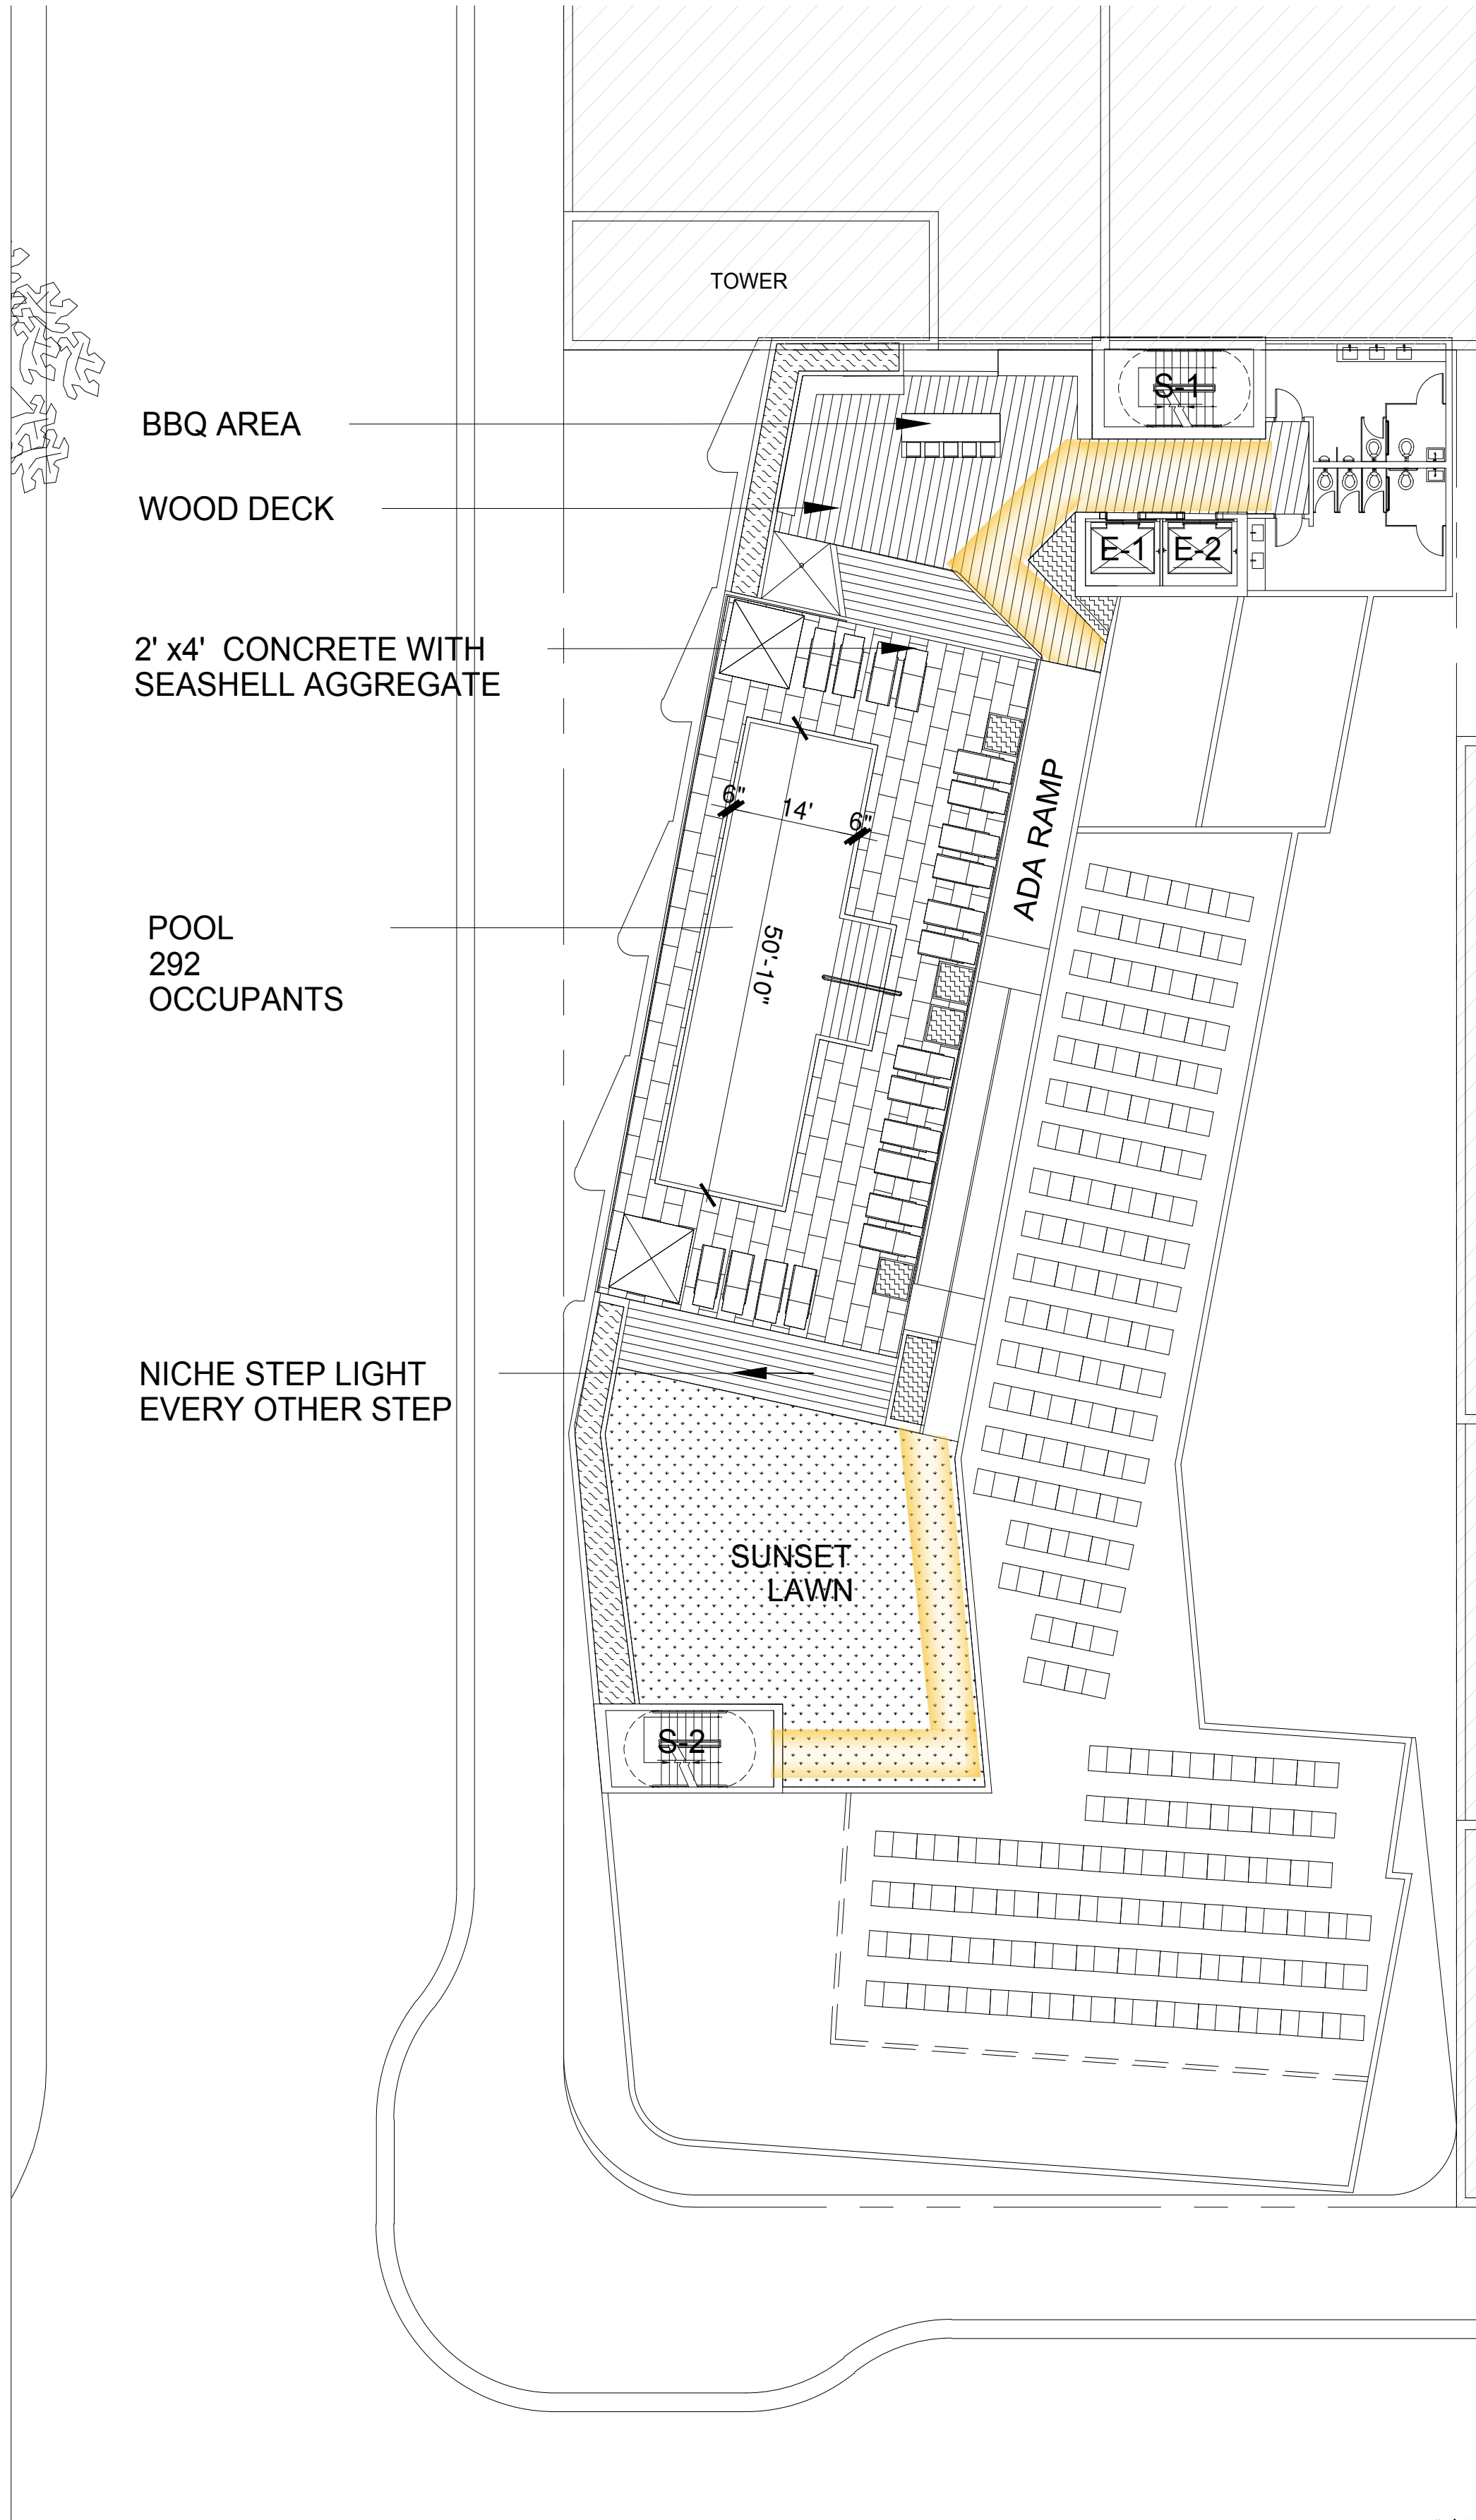

3 ROOFTOP FLOOR HARDSCAPE & LIGHTING PLAN
 SCALE: 1"=30'-0"

0 30' 60'
 SCALE: 1" = 30'-0"

NORTH

LIGHTING



Tape Light



Small Uplight



Flush Uplight

HARDSCAPE




Concrete with Seashell Aggregate




Wood Deck, Thermal modified or reclaimed


LEGEND

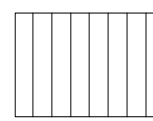


Wood Deck

 

 2' x 4' Porcelain Paver or Concrete with Seashell Aggregate



Lounge Chair

 

Movable Furniture



Flush Uplight



Small Uplight



Tape Light



Egress Lighting