


City of Miami Beach - Board Applications

9FLB003915F/MI90XSL78F

CAP Address: 659 West Ave, Miami Beach, Fl

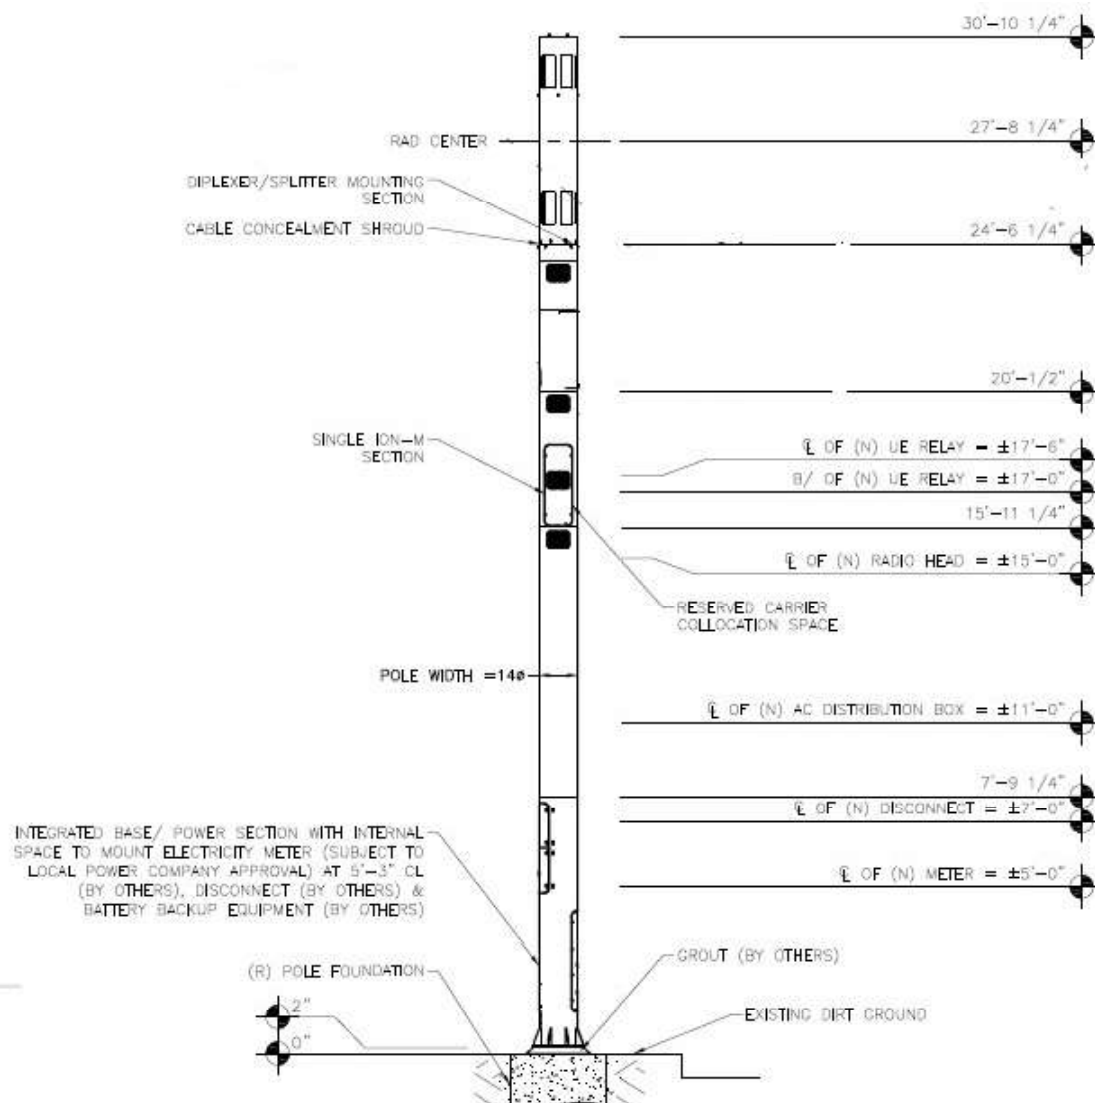



ITEM # 2—COPY OF SIGNED AND DATED CHECKLIST

MIAMI BEACH

Page 1 of 4

Planning Department, 1700 Convention Center Drive 2nd Floor
Miami Beach, Florida 33139, www.miamibeachfl.gov
305.673.7550

DRB

Property address: MOBILE

Board: 10-23-2017

Date: _____

BOARD APPLICATION CHECK LIST

A Pre-Application meeting must be scheduled via CAP to obtain a plan case number and for board staff review of all submittals.

Pre-Application meetings for applications that do not require a traffic study are scheduled on a first come-first served basis and must occur no later than five(5) business days prior to CAP First submittal.

Applications requiring a traffic study must meet with Planning, Transportation, and peer reviewer sixty (60) days* prior to First submittal deadline to determine the methodology for the traffic impact study. This meeting is considered the "Pre-Application meeting" and must be scheduled via CAP to obtain a plan case number for review and payment of fees. Thirty (30) days before First submittal, applicant must provide the traffic study via CAP (see Transportation Department's requirements check list). The Transportation Department/Peer Reviewer will submit first round of comments 15 days prior to First submittal. Applicant must address comments and submit revised traffic study/plans for CAP First submittal deadline.

Incomplete, or submittals found to be insufficient will not be placed on a Board agenda.

ITEM #	FIRST SUBMITTAL (VIA CAP) ** To be uploaded online (CAP) by the applicant before 5:00 pm by First submittal deadline. ALL PLANS MUST BE DIMENSIONED AND LEGIBLE. INCLUDE A GRAPHIC SCALE.	Required
1	Application Fee and Peer review fees shall be paid after Pre-Application meeting and before the First submittal. It is the applicant's responsibility to make this payment, if an invoice is not generated by the CAP system, the applicant should <u>contact staff prior to first submittal to be invoiced and make payment.</u>	X
2	Copy of signed and dated check list issued at Pre-Application meeting.	X
3	Completed Board Application, Affidavits & Disclosures of Interest (original signatures).	X
4	Signed and dated Letter of Intent. Letter must outline application details and identify hardships if Variances are requested. (see also Items # 42,43 and 44).	X
5	Mailing Labels: Upload property owner's list and copy of original certified letter from provider. See #52 for submittal of <u>Hard copy / originals of these items.</u>	X
6	Copies of all current or previously active Business Tax Receipts.	
7	School Concurrency Application for projects with a net increase in residential units (no SFH). Provide Planning Department - <u>Miami Dade - School Concurrency Application for Transmittal</u>	
8	Survey: Electronic version of original signed & sealed, dated no more than six months from date of application. Survey must provide: lot area, grade per Section 114-1 of the City Code. (If no sidewalk exists, provide the elevation of the <u>crown of the road</u>) and <u>spot elevations.</u>	X
9	Architectural Plans and Exhibits (must be 11"x 17")	X
a	Cover Sheet with bullet point scope of work, clearly labeled "First Submittal" and dated with First Submittal deadline date. Include copies of previous recorded board orders, if applicable.	X
b	Copy of the original survey included in plan package. See No. 8 above for survey requirements	X
c	All Applicable Zoning Information (Use Planning Department zoning data sheet format).	X
d	Context Location Plan, Min 8.5"x11" Color Aerial 1/2 mile radius, identifying project and showing name of streets. (no <u>Google images</u>)	X
e	Full legal description of the property if not included in survey (for lengthy legal descriptions, attach as a separate document - <u>label clearly</u>).	X
f	Existing FAR Shaded Diagrams (Single Family Districts: Unit Size and Lot Coverage Shaded Diagrams), if applicable	X
g	Proposed FAR Shaded Diagrams(Single Family Districts: Unit Size and Lot Coverage Shaded Diagrams), if applicable.	X
h	Site Plan (fully dimensioned with setbacks, existing and proposed, including adjacent right-of-way widths).	X

* 60 day lead time for projects including traffic studies is necessary to ensure completion of review and required corrections by Final submittal deadline. Applications cannot be scheduled without evaluated and corrected traffic studies.

Indicate N/A If Not Applicable

Initials: JS

MIAMI BEACH

Planning Department, 1700 Convention Center Drive 2nd Floor
Miami Beach, Florida 33139, www.miamibeachfl.gov
305.673.7550

Property address: _____

i	Current color photographs, dated, Min 4"x 6" of project site and existing structures (no Google images)	X
j	Current, color photographs, dated, Min 4"x6" of interior space (no Google images)	X
k	Current color photographs, dated, Min 4"x 6" of context, corner to corner, across the street and surrounding properties with a key directional plan (no Google images)	X
l	Existing Conditions Drawings (Floor Plans & Elevations with dimensions). Number of seats, furniture layout if applicable	X
m	Demolition Plans (Floor Plans & Elevations with dimensions)	X
n	Proposed Floor Plans and Roof Plan, including mechanical equipment plan and section marks. Plans shall indicate location of all property lines and setbacks.	X
o	Proposed Elevations, materials & finishes noted (showing grade, base flood elevation, heights in NGVD values and free board if applicable)	X
p	Proposed Section Drawings	X
q	Color Renderings (elevations and three dimensional perspective drawings).	
10	Landscape Plans and Exhibits (must be 11"x 17")	
a	Landscape Plan - street and onsite - identifying existing, proposed landscape material, lighting, irrigation, raised curbs, tree survey and tree disposition plan, as well as underground and overhead utilities when street trees are required.	
b	Hardscape Plan, i.e. paving materials, pattern, etc.	
11	Copy of original Building Permit Card, & Microfilm, If available.	
12	Copy of previously approved building permits. (provide building permit number).	
13	Existing and Proposed detailed topographic survey depicting existing spot grades (NAVD) as well as all underground/overhead utilities and easements/agreements with recording data. See Part 1 / Section 1 / A. Surveying & Mapping Standards and submittal Requirements of the Public Works Manual. http://www.miamibeachfl.gov/publicworks/engineering/engineeringmanual.aspx?id=12920	
14	Vacant/Unoccupied structures or sites shall provide recent photographic evidence that the site and structure are secured and maintained. The applicant shall obtain and post a No Trespassing Sign from the City's Police Dept.	
15	Historic Resources Report (This report shall include, but not be limited to, copy of the original Building Permit Card and subsequent modifications, Microfilm records, existing condition analysis, photographic and written description of the history and evolution of the original building on the site, all available historic data including original plans, historic photographs and permit history of the structure and any other related information on the property.	
16	Contextual Elevation Line Drawings, corner to corner, across the street and surrounding properties (dated).	
17	Line of Sight studies.	
18	Structural Analysis of existing building including methodology for shoring and bracing.	
19	Proposed exterior and interior lighting plan, including photometric calculations.	
20	Exploded Axonometric Diagram (showing second floor in relationship to first floor).	
21	Neighborhood Context Study. (Planning will provide guidance if necessary for application.)	
22	Required yards open space calculations and shaded diagrams.	
23	Required yards section drawings.	
24	Variance and/or Waiver Diagram	
25	Schematic signage program	
26	Detailed sign(s) with dimensions and elevation drawings showing exact location.	
27	Elevation drawings showing area of building façade for sign calculation (Building ID signs).	
28	Daytime and nighttime renderings for illuminated signs.	

Indicate N/A If Not Applicable

Initials: RS

MIAMI BEACH

Planning Department, 1700 Convention Center Drive 2nd Floor
Miami Beach, Florida 33139, www.miamibeachfl.gov
305.673.7550

Property address: _____

29	Floor Plan Indicating area where alcoholic beverages will be displayed.	
30	Survey showing width of the canal (Dimension shall be certified by a surveyor)	
31	Site Plan showing total projection of structures from seawall, location and dimension of all structures inclusive of dock, mooring piles, boat lift, etc.	
32	DERM recommendation/preliminary approval. Docks or any structures shall have approval stamp from DERM or other regulatory agency before submitting for a variance. A letter from DERM or other agency, explaining specific requirements for the project is recommended.	
33	Technical specifications of the boat lift and/ or boat, ship of vessel to be docked or moored.	
34	Survey shall include spot elevations in rear yard and elevation points on the dune adjacent to the property. Provide highest elevation point on the due within the property. Erosion control line and Bulkhead line shall be indicated if present.	
35	Scaled, signed, sealed and dated specific purpose survey (Alcohol License/Distance Separation) distance shown on survey with a straight line.	
36	Proposed Operational Plan: Include deliveries and trash pickup times, hours of operations, number of employees, security and restaurant menu (if applicable).	
37	Maneuvering plan for loading within the existing/proposed conditions, delivery and garbage trucks size (length and width).	
38	Traffic Study, Site plan(s) : Revised version addressing first round of comments from Transportation Department and peer review. (See Transportation Department check list for requirements.)	
39	Sound Study report (Hard copy) with 1 CD.	
40	Site Plan (Identify streets and alleys)	
a	Identify: setbacks _____ Height _____ Drive aisle widths _____ Streets and sidewalks widths _____	
b	# parking spaces & dimensions _____ Loading spaces locations & dimensions _____	
c	# of bicycle parking spaces _____	
d	Interior and loading area location & dimensions _____	
e	Street level trash room location and dimensions _____	
f	Delivery route _____ Sanitation operation _____ Valet drop-off & pick-up _____ Valet route in and out _____	
g	Valet route to and from _____ auto-turn analysis for delivery and sanitation vehicles _____	
h	Indicate any backflow preventer and FPL vault if applicable	
i	Indicate location of the area included in the application if applicable	
j	Preliminary on-street loading plan	
41	Floor Plan (dimensioned)	
a	Total floor area	
b	Identify # seats indoors _____ outdoors _____ seating in public right of way _____ Total _____	
c	Occupancy load indoors and outdoors per venue _____ Total when applicable _____	
42	The letter of Intent shall include and respond to all sea level rise and resiliency review criteria per section 133-50 of the City Code.	X
43	The Letter of Intent for Variances shall include and respond to all review guidelines in the code as follows:	
a	Section 118-53 (d) of the City Code for each Variance.	
44	The Letter of Intent for Planning Board shall include and respond to all review guidelines in the code as follows:	
a	For Conditional Use -Section 118-192 (a)(1)-(7)	
b	CU -Entertainment Establishments - Section 142-1362 (a)(1)-(9)	
c	CU - Mechanical Parking - Section 130-38 (3)(c)(i)(1)-(2) & (4)(a)-(k)	
d	CU - Structures over 50,000 SQ.FT. - Section 118-192 (b) (1)-(11)	
e	CU - Religious Institutions - Section 118-192 (c) (1)-(11)	

Indicate N/A If Not Applicable

Initials: PK

MIAMI BEACH

Planning Department, 1700 Convention Center Drive 2nd Floor
Miami Beach, Florida 33139, www.miamibeachfl.gov
305.673.7550

Property Address:

f	For Lot Splits - Section 118-321 (B) (1)-(6). Also see application instructions	
	<i>Notes: The applicant is responsible for checking above referenced sections of the Code. If not applicable write N/A</i>	


****ADDITIONAL INFORMATION AS MAY BE REQUIRED AT THE PRE-APPLICATION MEETING**


ITEM #	FINAL SUBMITTAL (via CAP)
	Revised and/or supplemented documents and drawings to address staff comments. Plans should be clearly labeled "Final Submittal" and dated with Final Submittal deadline date. Upload documents online (via CAP) before 5:00 pm on final submittal deadline. Staff will review and issue a notice to proceed to Paper Final submittal or to continue submittal to a future meeting if the application is found incomplete.
45	Traffic Study, Site plan(s): This is the final traffic study including any modifications required to address comments from the City's Transportation Department. City's required permit by FDOT should be obtained prior to Final submittal (via CAP).

ITEM #	PAPER FINAL SUBMITTAL:	Required
46	Original application with all signed and notarized applicable affidavits and disclosures.	X
47	Original of all applicable items.	X
48	One (1) signed and sealed 11"X17" bound, collated set of all the required documents.	X
49	14 collated copies of all required documents	X
50	One (1) CD/DVD with electronic copy of entire final application package (plans, application, Letter of Intent, traffic/sound study, etc.) see CD/DVD formatting attached, for instructions.	X
51	Traffic Study (Hard copy)	
52	Mailing Labels -2 sets of gummed labels and a CD including: Property owner's list and Original certified letter from provider.	X

ADDITIONAL INFORMATION AND ACKNOWLEDGEMENTS

- A. Other information/documentation required for First submittal will be identified during Pre-Application meeting but may be modified based on further analysis.
- B. It is the responsibility of the applicant to confirm that documents submitted via CAP, Paper Submittal sets (14 copies), and electronic version on CD are consistent with each other and legible.
- C. Plan revisions and supplemental documentation will not be accepted after the Final Submittal deadline
- D. All documents required for Board applications must be submitted in an electronic format (PDF) via CD in the manner prescribed herein. The CD is considered the "Formal Submission", and must include the electronic version of all hard copy documents associated with the application. A new Updated CD will be required if any modifications are made before or after hearing. Failure to comply with the aforementioned may result in a rehearing before the applicable board at the applicant's expense.
- E. Please note that the applicant will be required to submit revised plans pursuant to applicable Board Conditions no later than 60 days after Board Approval. (If applicable)

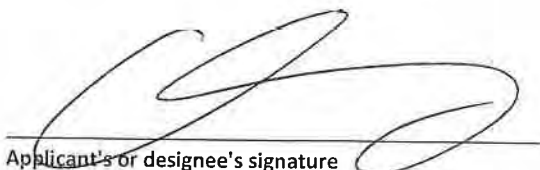
Applicant's or designee's signature

 
Date

Indicate N/A If Not Applicable

Initials: 



ITEM # 3—BOARD APPLICATION

MIAMI BEACH

PLANNING DEPARTMENT, 1700 CONVENTION CENTER DRIVE, 2ND FLOOR
MIAMI BEACH, FLORIDA 33139, WWW.MIAMIBEACHFL.GOV
305-673-7550

LAND USE BOARD HEARING APPLICATION

THE FOLLOWING APPLICATION IS SUBMITTED FOR REVIEW AND CONSIDERATION OF THE PROJECT DESCRIBED HEREIN BY THE LAND USE BOARD SELECTED BELOW. A SEPARATE APPLICATION MUST BE COMPLETED FOR EACH BOARD REVIEWING THE PROPOSED PROJECT.

- ☐ BOARD OF ADJUSTMENT
- ☐ VARIANCE FROM A PROVISION OF THE LAND DEVELOPMENT REGULATIONS
 - ☐ APPEAL OF AN ADMINISTRATIVE DECISION
- ☒ DESIGN REVIEW BOARD
- ☒ DESIGN REVIEW APPROVAL
 - ☐ VARIANCE RELATED TO PROJECT BEING CONSIDERED OR APPROVED BY DRB.
- ☐ HISTORIC PRESERVATION BOARD
- ☐ CERTIFICATE OF APPROPRIATENESS FOR DESIGN
 - ☐ CERTIFICATE OF APPROPRIATENESS TO DEMOLISH A STRUCTURE
 - ☐ HISTORIC DISTRICT / SITE DESIGNATION
 - ☐ VARIANCE RELATED TO PROJECT BEING CONSIDERED OR APPROVED BY HPB.
- ☐ PLANNING BOARD
- ☐ CONDITIONAL USE PERMIT
 - ☐ LOT SPLIT APPROVAL
 - ☐ AMENDMENT TO THE LAND DEVELOPMENT REGULATIONS OR ZONING MAP
 - ☐ AMENDMENT TO THE COMPREHENSIVE PLAN OR FUTURE LAND USE MAP
- ☐ FLOOD PLAIN MANAGEMENT BOARD
- ☐ FLOOD PLAIN WAIVER
- ☐ OTHER _____

SUBJECT PROPERTY ADDRESS: Proposed wireless small cell infrastructure on the public right of way.

Latitude: 25.776647 Longitude: -80.141927 X: 938543.50019 Y: 525432.94984

Nearest Intersection: WEST AVE & W 6TH ST

Approximate pole address: 651 West Ave, Miami Beach, FL

CAP address: 659 West Ave, Miami Beach, FL

LEGAL DESCRIPTION: PLEASE ATTACH LEGAL DESCRIPTION AS "EXHIBIT A"

FOLIO NUMBER (S) Public Right of Way

1. APPLICANT: ☐ OWNER OF THE SUBJECT PROPERTY ☐ TENANT ☐ ARCHITECT ☐ LANDSCAPE ARCHITECT
☐ ENGINEER ☐ CONTRACTOR ☒ OTHER (infrastructure owner)

NAME MOBILITIE, LLC
 ADDRESS 3475 Piedmont Rd NE, Suite 1000, Atlanta, GA, 30305
 BUSINESS PHONE (786) 910-4309 CELL PHONE (786) 910-4309
 E-MAIL ADDRESS Oraez@mobilitie.com

OWNER IF DIFFERENT THAN APPLICANT:

NAME Same as applicant
 ADDRESS _____
 BUSINESS PHONE _____ CELL PHONE _____
 E-MAIL ADDRESS _____

2. AUTHORIZED REPRESENTATIVE(S): N/A

☐ ATTORNEY:

NAME _____
 ADDRESS _____
 BUSINESS PHONE _____ CELL PHONE _____
 E-MAIL ADDRESS _____

☒ AGENT:

NAME Orlando Raez
 ADDRESS 3450 Lakeside Drive, Suite 301, Miramar, FL 33027
 BUSINESS PHONE (786) 910-4309 CELL PHONE (786) 910-4309
 E-MAIL ADDRESS oraez@mobilitie.com

☐ CONTACT:

NAME _____
 ADDRESS _____
 BUSINESS PHONE _____ CELL PHONE _____
 E-MAIL ADDRESS _____

3. PARTY RESPONSIBLE FOR PROJECT DESIGN:

☐ ARCHITECT ☐ LANDSCAPE ARCHITECT ☒ ENGINEER ☐ CONTRACTOR ☐ OTHER: _____

NAME Stephen Bray
 ADDRESS 1800 Route 34 Wall NJ 07719
 BUSINESS PHONE (732) 280-5623 CELL PHONE _____
 E-MAIL ADDRESS sbray@kmbcompanies.com

FILE NO. _____

4. SUMMARY OF APPLICATION – PROVIDE BRIEF SCOPE OF PROJECT:

MOBILITIE, LLC seeks to install one small-cell stealth pole at the specified location in order to improve the capacity and coverage of cellular devices within the vicinity.

- 4A. IS THERE AN EXISTING BUILDING(S) ON THE SITE ☐ YES ☒ NO
- 4B. DOES THE PROJECT INCLUDE INTERIOR OR EXTERIOR DEMOLITION ☐ YES ☒ NO
- 4C. PROVIDE THE TOTAL FLOOR AREA OF THE NEW BUILDING (IF APPLICABLE) n/a SQ. FT.
- 4D. PROVIDE THE TOTAL GROSS FLOOR AREA OF THE NEW BUILDING (INCLUDING REQUIRED PARKING AND ALL USEABLE FLOOR SPACE). _____ SQ. FT.

5. APPLICATION FEE (TO BE COMPLETED BY PLANNING STAFF) \$ _____

- A SEPARATE DISCLOSURE OF INTEREST FORM MUST BE SUBMITTED WITH THIS APPLICATION IF THE APPLICANT OR OWNER IS A CORPORATION, PARTNERSHIP, LIMITED PARTNERSHIP OR TRUSTEE.
- ALL APPLICABLE AFFIDAVITS MUST BE COMPLETED AND THE PROPERTY OWNER MUST COMPLETE AND SIGN THE "POWER OF ATTORNEY" PORTION OF THE AFFIDAVIT IF THEY WILL NOT BE PRESENT AT THE HEARING, OR IF OTHER PERSONS ARE SPEAKING ON THEIR BEHALF.
- TO REQUEST THIS MATERIAL IN ALTERNATE FORMAT, SIGN LANGUAGE INTERPRETER (FIVE-DAY NOTICE IS REQUIRED), INFORMATION ON ACCESS FOR PERSONS WITH DISABILITIES, AND ACCOMMODATION TO REVIEW ANY DOCUMENT OR PARTICIPATE IN ANY CITY-SPONSORED PROCEEDINGS, CALL 305.604.2489 AND SELECT (1) FOR ENGLISH OR (2) FOR SPANISH, THEN OPTION 6; TTY USERS MAY CALL VIA 711 (FLORIDA RELAY SERVICE).

PLEASE READ THE FOLLOWING AND ACKNOWLEDGE BELOW:

- APPLICATIONS FOR ANY BOARD HEARING(S) WILL NOT BE ACCEPTED WITHOUT PAYMENT OF THE REQUIRED FEE. ALL CHECKS ARE TO BE MADE PAYABLE TO THE "CITY OF MIAMI BEACH".
- PUBLIC RECORDS NOTICE – ALL DOCUMENTATION, SUBMITTED FOR THIS APPLICATION IS CONSIDERED A PUBLIC RECORD SUBJECT TO CHAPTER 119 OF THE FLORIDA STATUTES AND SHALL BE DISCLOSED UPON REQUEST.
- IN ACCORDANCE WITH THE REQUIREMENTS OF SECTION 2-482 OF THE CODE OF THE CITY OF MIAMI BEACH, ANY INDIVIDUAL OR GROUP THAT WILL BE COMPENSATED TO SPEAK OR REFRAIN FROM SPEAKING IN FAVOR OR AGAINST A PROJECT BEING PRESENTED BEFORE ANY OF THE CITY'S LAND USE BOARDS, SHALL FULLY DISCLOSE, PRIOR TO THE PUBLIC HEARING, THAT THEY HAVE BEEN, OR WILL BE COMPENSATED. SUCH PARTIES INCLUDE: ARCHITECTS, LANDSCAPE ARCHITECTS, ENGINEERS, CONTRACTORS, OR OTHER PERSONS RESPONSIBLE FOR PROJECT DESIGN, AS WELL AS AUTHORIZED REPRESENTATIVES ATTORNEYS OR AGENTS AND CONTACT PERSONS WHO ARE REPRESENTING OR APPEARING ON BEHALF OF A THIRD PARTY; SUCH INDIVIDUALS MUST REGISTER WITH THE CITY CLERK PRIOR TO THE HEARING.

FILE NO. _____

- IN ACCORDANCE WITH SEC.118-31. - DISCLOSURE REQUIREMENT. EACH PERSON OR ENTITY REQUESTING APPROVAL, RELIEF OR OTHER ACTION FROM THE PLANNING BOARD, DESIGN REVIEW BOARD, HISTORIC PRESERVATION BOARD (INCLUDING THE JOINT DESIGN REVIEW BOARD/HISTORIC PRESERVATION BOARD), OR THE BOARD OF ADJUSTMENT SHALL DISCLOSE, AT THE COMMENCEMENT (OR CONTINUANCE) OF THE PUBLIC HEARING(S), ANY CONSIDERATION PROVIDED OR COMMITTED, DIRECTLY OR ON ITS BEHALF, FOR AN AGREEMENT TO SUPPORT OR WITHHOLD OBJECTION TO THE REQUESTED APPROVAL, RELIEF OR ACTION, EXCLUDING FROM THIS REQUIREMENT CONSIDERATION FOR LEGAL OR DESIGN PROFESSIONAL SERVICES RENDERED OR TO BE RENDERED. THE DISCLOSURE SHALL: (i) BE IN WRITING, (ii) INDICATE TO WHOM THE CONSIDERATION HAS BEEN PROVIDED OR COMMITTED, (iii) GENERALLY DESCRIBE THE NATURE OF THE CONSIDERATION, AND (iv) BE READ INTO THE RECORD BY THE REQUESTING PERSON OR ENTITY PRIOR TO SUBMISSION TO THE SECRETARY/CLERK OF THE RESPECTIVE BOARD. UPON DETERMINATION BY THE APPLICABLE BOARD THAT THE FOREGOING DISCLOSURE REQUIREMENT WAS NOT TIMELY SATISFIED BY THE PERSON OR ENTITY REQUESTING APPROVAL, RELIEF OR OTHER ACTION AS PROVIDED ABOVE, THEN (i) THE APPLICATION OR ORDER, AS APPLICABLE, SHALL IMMEDIATELY BE DEEMED NULL AND VOID WITHOUT FURTHER FORCE OR EFFECT, AND (ii) NO APPLICATION FROM SAID PERSON OR ENTITY FOR THE SUBJECT PROPERTY SHALL BE REVIEWED OR CONSIDERED BY THE APPLICABLE BOARD(S) UNTIL EXPIRATION OF A PERIOD OF ONE YEAR AFTER THE NULLIFICATION OF THE APPLICATION OR ORDER. IT SHALL BE UNLAWFUL TO EMPLOY ANY DEVICE, SCHEME OR ARTIFICE TO CIRCUMVENT THE DISCLOSURE REQUIREMENTS OF THIS SECTION AND SUCH CIRCUMVENTION SHALL BE DEEMED A VIOLATION OF THE DISCLOSURE REQUIREMENTS OF THIS SECTION.
- WHEN THE APPLICABLE BOARD REACHES A DECISION A FINAL ORDER WILL BE ISSUED STATING THE BOARD'S DECISION AND ANY CONDITIONS IMPOSED THEREIN. THE FINAL ORDER WILL BE RECORDED WITH THE MIAMI-DADE CLERK OF COURTS. THE ORIGINAL BOARD ORDER SHALL REMAIN ON FILE WITH THE CITY OF MIAMI BEACH PLANNING DEPARTMENT. UNDER NO CIRCUMSTANCES WILL A BUILDING PERMIT BE ISSUED BY THE CITY OF MIAMI BEACH WITHOUT A COPY OF THE RECORDED FINAL ORDER BEING INCLUDED AND MADE A PART OF THE PLANS SUBMITTED FOR A BUILDING PERMIT.

THE AFOREMENTIONED IS ACKNOWLEDGED BY: ☐ OWNER OF THE SUBJECT PROPERTY

☒ AUTHORIZED REPRESENTATIVE

SIGNATURE: _____

PRINT NAME: _____

Orlando Raez

FILE NO. _____

NOT APPLICABLE

OWNER AFFIDAVIT FOR INDIVIDUAL OWNER

STATE OF _____

COUNTY OF _____

I, _____, being first duly sworn, depose and certify as follows: (1) I am the owner of the property that is the subject of this application. (2) This application and all information submitted in support of this application, including sketches, data, and other supplementary materials, are true and correct to the best of my knowledge and belief. (3) I acknowledge and agree that, before this application may be publicly noticed and heard by a land development board, the application must be complete and all information submitted in support thereof must be accurate. (4) I also hereby authorize the City of Miami Beach to enter my property for the sole purpose of posting a Notice of Public Hearing on my property, as required by law. (5) I am responsible for removing this notice after the date of the hearing.

SIGNATURE

Sworn to and subscribed before me this _____ day of _____, 20____. The foregoing instrument was acknowledged before me by _____, who has produced _____ as identification and/or is personally known to me and who did/did not take an oath.

NOTARY SEAL OR STAMP

NOTARY PUBLIC

My Commission Expires: _____

PRINT NAME

**ALTERNATE OWNER AFFIDAVIT FOR
CORPORATION, PARTNERSHIP, OR LIMITED LIABILITY COMPANY**
(Circle one)

STATE OF GeorgiaCOUNTY OF Fulton

I, Gadiel Rosario-Rivera, being duly sworn, depose and certify as follows: (1) I am the NRE Manager (print title) of MOBILITIE, LLC (print name of corporate entity). (2) I am authorized to file this application on behalf of such entity. (3) This application and all information submitted in support of this application, including sketches, data, and other supplementary materials, are true and correct to the best of my knowledge and belief. (4) The corporate entity named herein is the owner or tenant of the property that is the subject of this application. (5) I acknowledge and agree that, before this application may be publicly noticed and heard by a land development board, the application must be complete and all information submitted in support thereof must be accurate. (6) I also hereby authorize the City of Miami Beach to enter the subject property for the sole purpose of posting a Notice of Public Hearing on the property, as required by law. (7) I am responsible for removing this notice after the date of the hearing.

SIGNATURE

Sworn to and subscribed before me this 18th day of January, 2018. The foregoing instrument was acknowledged before me by Gadiel Rosario-Rivera, NRE Manager of MOBILITIE, LLC, on behalf of such entity, who has produced _____ as identification and/or is personally known to me and who did/did not take an oath.

NOTARY SEAL OR STAMP:

My Commission Expires: _____

_____
NOTARY PUBLIC_____
Gadiel Rosario-Rivera, NRE Manager_____
PRINT NAME

FILE NO. _____


POWER OF ATTORNEY AFFIDAVIT

STATE OF Georgia
COUNTY OF Fulton

I, Gadiel Rosario-Rivera, being duly sworn and deposed, certify as follows: (1) I am the owner or representative of the owner of the real property that is the subject of this application. (2) I hereby authorize Orlando Raez to be my representative before the _____ Board. (3) I also hereby authorize the City of Miami Beach to enter the subject property for the sole purpose of posting a Notice of Public Hearing on the property, as required by law. (4) I am responsible for removing this notice after the date of the hearing.

Gadiel Rosario-Rivera, NRE Manager

PRINT NAME (and Title, if applicable)

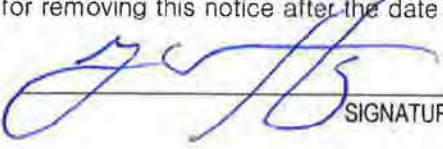
SIGNATURE

Sworn to and subscribed before me this 18th day of January, 2018. The foregoing instrument was acknowledged before me by Gadiel Rosario-Rivera, NRE Manager of MOBILITE, LLC who has produced as identification and/or is personally known to me and who did/did not take an oath.

NOTARY SEAL OR STAMP



My Commission Expires


NOTARY PUBLIC

Erin E. Scott

PRINT NAME

NOT APPLICABLE

CONTRACT FOR PURCHASE

If the applicant is not the owner of the property, but the applicant is a party to a contract to purchase the property, whether or not such contract is contingent on this application, the applicant shall list the names of the contract purchasers below, including any and all principal officers, stockholders, beneficiaries, or partners. If any of the contract purchasers are corporations, partnerships, limited liability companies, trusts, or other corporate entities, the applicant shall further disclose the identity of the individual(s) (natural persons) having the ultimate ownership interest in the entity. If any contingency clause or contract terms involve additional individuals, corporations, partnerships, limited liability companies, trusts, or other corporate entities, list all individuals and/or corporate entities.*

NAME

DATE OF CONTRACT

NAME, ADDRESS, AND OFFICE

% OF STOCK

In the event of any changes of ownership or changes in contracts for purchase, subsequent to the date that this application is filed, but prior to the date of a final public hearing, the applicant shall file a supplemental disclosure of interest.

FILE NO. _____

NOT APPLICABLE

CITY OF MIAMI BEACH
DEVELOPMENT REVIEW BOARD APPLICATION

DISCLOSURE OF INTEREST

1. CORPORATION, PARTNERSHIP, OR LIMITED LIABILITY COMPANY

If the property that is the subject of the application is owned or leased by a corporation, partnership, or limited liability company, list ALL of the owners, shareholders, partners, managers, and/or members, and the percentage of ownership held by each. If the owners consist of one or more corporations, partnerships, trusts, partnerships, or other corporate entities, the applicant shall further disclose the identity of the individual(s) (natural persons) having the ultimate ownership interest in the entity.*

NAME OF CORPORATE ENTITY

NAME AND ADDRESS

% OF OWNERSHIP

NAME OF CORPORATE ENTITY

NAME AND ADDRESS

% OF OWNERSHIP

IF THERE ARE ADDITIONAL CORPORATE OWNERS, LIST ALL SUCH OWNERS, INCLUDING CORPORATE NAMES AND THE NAME, ADDRESS, AND PERCENTAGE OF OWNERSHIP OF EACH ADDITIONAL OWNER, ON A SEPARATE PAGE.

NOTE: Notarized signature required on page 9

FILE NO. _____

NOT APPLICABLE

CITY OF MIAMI BEACH
DEVELOPMENT REVIEW BOARD APPLICATION
DISCLOSURE OF INTEREST

2. TRUSTEE

If the property that is the subject of this application is owned or leased by a trust, list any and all trustees and beneficiaries of the trust, and the percentage of interest held by each. If the owners consist of one or more corporations, partnerships, trusts, partnerships, or other corporate entities, the applicant shall further disclose the identity of the individual(s) (natural persons) having the ultimate ownership interest in the entity.*

TRUST NAME

NAME AND ADDRESS

% INTEREST

NOTE: Notarized signature required on page 9

FILE NO. _____

3. COMPENSATED LOBBYIST:

Pursuant to Section 2-482 of the Miami Beach City Code, all lobbyists shall, before engaging in any lobbying activities, register with the City Clerk. Please list below any and all persons or entities retained by the applicant to lobby City staff or any of the City's land development boards in support of this application.

	NAME	ADDRESS	PHONE #
a.	NONE		
b.			
c.			

Additional names can be placed on a separate page attached to this form.

*Disclosure shall not be required of any entity, the equity interests in which are regularly traded on an established securities market in the United States or other country, or of any entity, the ownership interests of which are held in a limited partnership or other entity, consisting of more than 5,000 separate interests, where no one person or entity holds more than a total of 5% of the ownership interests in the entity.


APPLICANT HEREBY ACKNOWLEDGES AND AGREES THAT (1) ANY APPROVAL GRANTED BY A LAND DEVELOPMENT BOARD OF THE CITY SHALL BE SUBJECT TO ANY AND ALL CONDITIONS IMPOSED BY SUCH BOARD AND BY ANY OTHER BOARD HAVING JURISDICTION, AND (2) APPLICANT'S PROJECT SHALL COMPLY WITH THE CODE OF THE CITY OF MIAMI BEACH AND ALL OTHER APPLICABLE CITY, STATE, AND FEDERAL LAWS.

APPLICANT AFFIDAVIT

STATE OF Georgia

COUNTY OF Fulton

I, Gadiel Rosario-Rivera, being first duly sworn, depose and certify as follows: (1) I am the applicant, or the representative of the applicant. (2) This application and all information submitted in support of this application, including disclosures, sketches, data, and other supplementary materials, are true and correct to the best of my knowledge and belief.

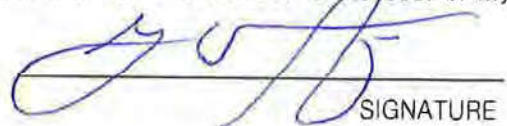
SIGNATURE

Sworn to and subscribed before me this 18th day of January, 2018. The foregoing instrument was acknowledged before me by, who has produced as identification and/or is personally known to me and who did/did not take an oath.

NOTARY SEAL OR STAMP



My Commission Expires:


NOTARY PUBLIC

Erin E. Scott

PRINT NAME

FILE NO. _____

ITEM # 4—LETTER OF INTENT

October 6th, 2017

City of Miami Beach
1700 Convention Center Drive
Miami Beach, FL 33139

RE: Board Applications for Small-Cell Stealth Poles on the public right-of-way

Dear Board Members and City Staff:

This letter intends to serve as Mobilitie, LLC's "Letter of Intent" in regards to our proposed small-cells infrastructure on the public rights-of-way within the City of Miami Beach, FL. Mobilitie is a wireless infrastructure company that develops intelligent infrastructure solutions to densify and optimize wireless carriers services and geographic reach. Mobilitie LLC possesses a Certificate to provide Alternative Access Vendor services from the Florida Public Service Commission. Mobilitie LLC is also registered with the City of Miami Beach, pursuant to City Code Section 104-4, as a communications services provider.

Mobilitie LLC works with all wireless carriers to enhance services throughout the country. Our design optimizes the performance of wireless networks by taking into consideration customer usage behaviors, terrain, obstructions, points-of-interest, and local guidance and ordinances. Mobilitie LLC's small-cell network within the City of Miami Beach will be utilized by Sprint, a wireless carrier, to fill in network deficiencies as a result of high demand for high-speed wireless service in the City.

During pre-application meetings with the City of Miami Beach Planning Department staff, it was expressed that the City of Miami Beach had spent two years developing an acceptable stealth design with a competitor. Although there are additional costs associated with the stealth design for our company, Mobilitie, LLC decided to work cooperatively with the City of Miami Beach and integrated the stealth design for our small-cell equipment installations. Our competitor has already pulled and replaced dozens of street light poles with stealth telecommunication light poles after getting permits from the City. Mobilitie LLC is effectively proposing to do the same. As required during our meetings with Planning Department staff, we have also reserved an area inside each pole should another wireless carrier which to utilize our poles for their equipment (reserved area is marked on plans).

REQUEST FOR APPROVAL

Mobilitie respectfully requests that the City review and approve the attached applications supplemented with the enclosed information. Mobilitie values the City's input on our proposal, and will work closely with the City to address any other concerns with our proposal, such as location, height, and pole color. Mobilitie looks forward to working with the City of Miami Beach and values its partnership in order to provide your constituents and visitors with high-speed connectivity. Thank you for your attention to this matter.

Respectfully submitted,



Orlando Raez | Permitting Manager

oraez@mobilitie.com

786 910 4309 mobile

www.mobilitie.com

March 1, 2018

Photo-Simulation

Subject: 651 West Ave, Miami Beach, FL 33141

Legal Description: Public right of way



3/1/2018

City of Miami Beach
1700 Convention Center Drive
Miami Beach, FL 33139

RE: Response regarding 500' distance comment between proposed pole location and existing or other proposed pole locations

Dear Board Members and City Staff:

This letter intends to serve as Mobilitie, LLC's "Response" in regards to staff's comment about a 500' distance requirement. The proposed pole location for candidate # MI90XSL78F is over 670 feet away from the nearest proposed stealth communications pole and about 750 feet away from the nearest existing communications pole. In addition, per Florida House Bill No. 687, an authority may not limit the placement of small wireless facilities by minimum separation distances.

Mobilitie respectfully requests that the Design Review Board find our response to the distance comment satisfied.

Respectfully submitted,



Orlando Raez | Permitting Manager
oraez@mobilitie.com
786 910 4309 mobile
www.mobilitie.com

ITEM # 5—MAILING LABELS

January 25th, 2018

City of Miami Beach
1700 Convention Center Drive
Miami Beach, FL 33139

RE: Property Owners list within 375 feet of:

Subject: 651 West Avenue, Miami Beach, FL 33141
Legal Description: Public Right of Way

This is to certify that the attached ownership list, map and mailing labels are a complete and accurate representation of the real estate property and property owners within 375 feet radius of the external boundaries of the subject property listed above. This reflects the most current records on the file in Miami-Dade County Property Appraisers' Office.

Total number of property owners without repetition: 861, including 24 international

Respectfully submitted,

A handwritten signature in black ink, appearing to read 'ORAEZ', is written over a solid black horizontal line.


Orlando Raez | Permitting Manager
oraez@mobilitie.com
786 910 4309 mobile
www.mobilitie.com

October 9th, 2017

City of Miami Beach
1700 Convention Center Drive
Miami Beach, FL 33139

Subject: 651 West Avenue, Miami Beach, FL 33141
Legal Description: Public Right of Way

375-Foot Radius Map

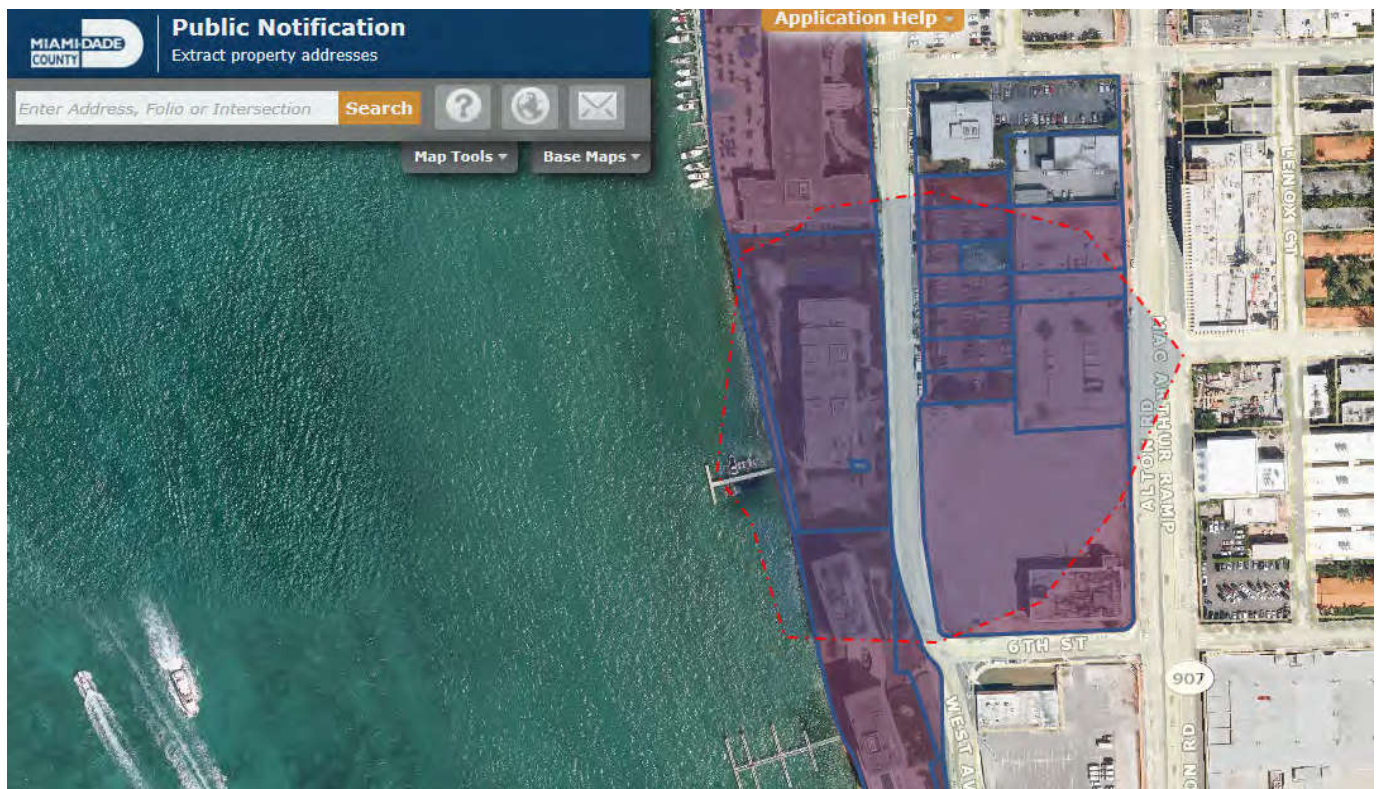

Source: Miami Dade County Property Appraiser, <http://gisweb.miamidade.gov/PublicNotification/>

Folio	Property Owner Name	Address	City	State	Zip Code	Country
02-4203-155-1860	MARCEL HACHEM	1227 SHERBROOKE ST W #44	MONTREAL QUEBEC H3G 1G1		-	CANADA
02-4203-155-1280	ANDEST INVESTMENT LLC	33 HARBOUR SQ UNIT 516	ONTARIO		-	CANADA
02-4203-155-2200	DAVID CAMPBELL	57 SPRINGWOOD CRESCENT	GRAVENHURST	ON	P1P1Y8	CANADA
02-4203-155-1450	SAMUEL H COHEN	425 WALMER RD # 10-A	YORK		M5P 2X9	CANADA
02-4203-155-2430	TODD D SLOAN JR & JUAN L ARAUJO	AMER EMBASSY USAID UNIT 3030	DPO	AA	34004	COLOMBIA
02-4204-014-0080	ERIC QVIST & JESPER QVIST &	UBBEROEDVEJ 33 2970	HOERSHOLM		-	DENMARK
02-4204-014-2400	DOMINIQUE GODIN & W CHRISTINE	101 BIS RUE ARISTIDE BRIAND	92300 LEVALLOIS PERRET FRANCE		-	FRANCE
02-4203-155-1830	STEFFEN KLUSCHKE	SCHLIEMANN STRASSE 30	BERLIN 10437		-	GERMANY
02-4203-155-2900	ELIZABETH SORG	BISCHOFSWEG 54	FRANKFURT		00598	GERMANY
02-4203-155-3240	ELIZABETH SORG	BISCHOFSWEG 54	FRANKFURT		-	GERMANY
02-4203-155-2630	ANTONIO URSINO	VIA VESTRICIO SPURINNA 101 D	ROMA 00175		-	ITALY
02-4203-291-1660	AURELIO TOMASI MORGANO JTRS	CORSO COSENZA 18	TORINO ITALY 10100		-	ITALY
02-4204-014-1510	AHMAD REZA AFSHAR	120 STIBBARD AVE	TORONTO ONTARIO M4P2C2		-	ITALY
02-4204-014-2440	MAURIZIO ZANINI & W	VIA A SAFFI 4/H 40131	BOLOGNA		-	ITALY
02-4204-014-1400	FRANCESCO FANTINI	VIA DELLO SPORT 20	PESCHIERA BORROMEO 20068		-	ITALY
02-4204-014-2790	PHILIPPE ARCHAMBAULT	LA TOUR ICHIGAYA SADOHARACHO 502	SHINJUKU-KU TOKYO		162-0842	JAPAN
02-4203-155-0570	SEAN CHRISTOPHER MAREK	PH10D-229 WELLINGTON CRESCENT	WINNIPEG MANITOBA R3M0E6		-	MANITOBA
02-4203-155-2820	ROBERT FISSEER	PR HENDRIKLAAN 3	BUSSUM 1404AR		-	NETHERLANDS
02-4203-155-0350	SPBR LLC	PAULUS POTTERSTRAAT 24	UTRECHT		-	NETHERLANDS
02-4203-155-2830	THOMAS GRUBE	PO BOX 22550	DOHA		-	QATAR
02-4203-155-1400	JAN ANDERS IVARSSON	SCHEELEGATAN 17	STOCKHOLM 112 28		-	SWEDEN
02-4204-014-0220	DENIS DOWEN JTRS	THORPE BULMER FARMHOUSE	HART ENGLAND T527 3AU		-	UNITED KINGDOM
02-4204-014-2700	SENAD PRUSAC	21 QUEENS GATE PL	LONDON ENGLAND SW7 5NY		-	UNITED KINGDOM
02-4204-014-1390	DAVID WOODWARD	11 PYRMONT RD CHISWICK	LONDON W43 NR		-	UNITED KINGDOM
02-4203-001-0031	VETERANS OF FOREIGN WARS	650 WEST AVE	MIAMI BEACH	FL	33139-5524	USA
02-4203-001-0035	FLORIDIAN OF MIA BCH CONDO ASSC	650 WEST AVE	MIAMI BEACH	FL	33139-5524	USA
02-4203-001-0100	SOUTH BEACH HEIGHTS I LLC	2200 BISCAYNE BLVD	MIAMI	FL	33137-5016	USA
02-4203-001-0161	KGM EQUITIES LLC	2200 BISCAYNE BLVD	MIAMI	FL	33137	USA
02-4203-001-0170	KGM EQUITIES LLC	2200 BISCAYNE BLVD	MIAMI	FL	33137	USA
02-4203-001-0180	KGM EQUITIES LLC	2200 BISCAYNE BLVD	MIAMI	FL	33137	USA
02-4203-001-0190	KGM EQUITIES LLC	2200 BISCAYNE BLVD	MIAMI	FL	33137	USA
02-4203-001-0200	KGM EQUITIES LLC	2200 BISCAYNE BLVD	MIAMI	FL	33137	USA
02-4203-001-0201	KGM EQUITIES LLC	2200 BISCAYNE BLVD	MIAMI	FL	33137	USA
02-4203-001-0210	KGM EQUITIES LLC	2200 BISCAYNE BLVD	MIAMI	FL	33137	USA
02-4203-001-0220	KGM EQUITIES LLC	2200 BISCAYNE BLVD	MIAMI	FL	33137	USA
02-4203-001-0250	SEVEN FORTY CENTRAL CORP	740 ALTON RD	MIAMI BEACH	FL	33139-5504	USA
02-4203-001-0260	MIAMI DADE COUNTY	111 NW 1 ST STE 2460	MIAMI	FL	33128-1929	USA
02-4203-001-0270	MIAMI DADE COUNTY	111 NW 1 ST STE 2460	MIAMI	FL	33128-1929	USA
02-4203-001-0280	SOUTH BEACH HEIGHTS I LLC	2200 BISCAYNE BLVD	MIAMI	FL	33137-5016	USA
02-4203-155-0010	DEUTSCHE BANK NATL TRUST CO TRS	5720 PREMIER PARK DR	WEST PALM BEACH	FL	33407	USA
02-4203-155-0020	IVAN TAMAR JACKSON	800 WEST AVE STE 301	MIAMI BEACH	FL	33139	USA
02-4203-155-0030	DAVID DEFORREST	1644 MCDUFF AVE SOUTH	JACKSONVILLE	FL	32205	USA
02-4203-155-0040	ISABEL M & LUISA FREITAS	800 WEST AVE #501	MIAMI BEACH	FL	33139-5536	USA
02-4203-155-0050	GAIL FIX	800 WEST AVE APT #601	MIAMI BEACH	FL	33139	USA
02-4203-155-0060	WAGNER LAPETINA	800 WEST AVE #701	MIAMI BEACH	FL	33139-5537	USA
02-4203-155-0070	BLANDINE ROUSSEL	800 WEST AVE #801	MIAMI BEACH	FL	33139-5599	USA
02-4203-155-0080	RICHARD BELLEW III	800 WEST AVE #901	MIAMI BEACH	FL	33139	USA
02-4203-155-0090	PATRICK DENNIS	800 WEST AVE PH01	MIAMI BEACH	FL	33139	USA
02-4203-155-0100	CATIA DOMBROWSKI	800 WEST AVE APT 202	MIAMI BEACH	FL	33139	USA
02-4203-155-0110	JENNIFER BLUM	800 WEST AVE #302	MIAMI BEACH	FL	33139-5535	USA
02-4203-155-0120	JOSE VALDOVINOS	58 RICH AVENUE W	GREENWICH	CT	06830	USA
02-4203-155-0130	SYBILLE FRITZ KASPAR	800 WEST AVE #502	MIAMI BEACH	FL	33139-5536	USA
02-4203-155-0140	MARIA VIRGINIA ALONSO	800 WEST AVE #602	MIAMI BEACH	FL	33139-5527	USA
02-4203-155-0150	DINA ANSALDI	1000 VENETIAN WAY #401	MIAMI BEACH	FL	33139	USA

02-4203-155-0160	JONATHAN GELBER &W JEANETTE	800 WEST AVE APT 802	MIAMI BEACH	FL	33139-5599	USA
02-4203-155-0170	SUSAN D WHITEBROOK	800 WEST AVE UNIT 902	MIAMI BEACH	FL	33139-5538	USA
02-4203-155-0180	YELENA HUEBNER	800 WEST AVE #PH02	MIAMI BEACH	FL	33139-5542	USA
02-4203-155-0190	BGM BAY WEST LLC	1330 COLLINS AVE STE 1	MIAMI BEACH	FL	33139	USA
02-4203-155-0200	MARK SHATLEY	800 WEST AVE UNIT 303	MIAMI	FL	33139-5535	USA
02-4203-155-0210	ALEJANDRO VERA	800 WEST AVE 403	MIAMI BEACH	FL	33139	USA
02-4203-155-0220	MARTIN R SHERMAN &W GRACE L	3484 CHASE AVE	MIAMI BEACH	FL	33140-3417	USA
02-4203-155-0230	FRANCK F MASHAYEKHI	800 WEST AVE #603	MIAMI BEACH	FL	33139-5527	USA
02-4203-155-0240	DEIDRE COLLINS	800 WEST AVE 703	MIAMI BEACH	FL	33139	USA
02-4203-155-0250	RENT RENTALS LLC	1200 BRICKELL BAY DR # 3515	MIAMI	FL	33131	USA
02-4203-155-0260	JESSICA NG JTRS	800 WEST AVENUE #903	MIAMI BEACH	FL	33139	USA
02-4203-155-0270	OSCAR BARCELO	800 WEST AVE #PH03	MIAMI BEACH	FL	33139-5542	USA
02-4203-155-0280	LOURDES HERNANDEZ	800 WEST AVE 204	MIAMI BEACH	FL	33139-5506	USA
02-4203-155-0290	SELMA RODRIGUEZ	800 WEST AVE #304	MIAMI BEACH	FL	33139-5535	USA
02-4203-155-0300	CORBATA LLC	12550 BISCAYNE BLVD 406	NORTH MIAMI	FL	33181	USA
02-4203-155-0310	AIDA L OLDRATTI	800 WEST AVE APT 504	MIAMI	FL	33139-5536	USA
02-4203-155-0320	MICHAEL KARAVOLOS	1995 NE 196 TER	MIAMI	FL	33179	USA
02-4203-155-0330	N NIMMAGADDA TRS	2081 SADDLE PATH	SEAFORD	NY	11783	USA
02-4203-155-0340	HENRY LOEB &W GRISEL H	800 WEST AVE UNIT 804	MIAMI BEACH	FL	33139-5599	USA
02-4203-155-0360	STELLA REAL ESTATE INC	150 SE 2 AVE # 1010	MIAMI	FL	33131	USA
02-4203-155-0370	ADOLFO TORRES	800 WEST AVE #205	MIAMI BEACH	FL	33139-5579	USA
02-4203-155-0380	VALARIE MARIE SHAEFE	800 WEST AVE #305	MIAMI BEACH	FL	33139-5535	USA
02-4203-155-0390	NICOLAS DI IORIO &	149-45 NORTHERN BLVD	FLUSHING	NY	11354	USA
02-4203-155-0400	PATRICIA D VICARI	5 ISLAND AVE #2B	MIAMI BEACH	FL	33139	USA
02-4203-155-0410	SAVERIO RICCOBONO LONGO	800 WEST AVE 605	MIAMI BEACH	FL	33139	USA
02-4203-155-0420	STEVEN SCHNEIDER	9809 ARBOR VIEW DR S	BOYNTON BEACH	FL	33437	USA
02-4203-155-0430	AMMY LLC	407 LINCOLN RD #2F	MIAMI BEACH	FL	33139	USA
02-4203-155-0440	SEAN KELLY	800 WEST AVE #905	MIAMI BEACH	FL	33139-5584	USA
02-4203-155-0450	HORACIO IRAUSQUIN	800 WEST AVE UNIT PH-5	MIAMI BEACH	FL	33139-5542	USA
02-4203-155-0460	CAROLINA MEDINA	800 WEST AVE UNIT 206	MIAMI BEACH	FL	33139	USA
02-4203-155-0470	HIGH TECHNOLOGY SERVICES INC	444 BRICKELL AVE STE 51-418	MIAMI	FL	33131-2466	USA
02-4203-155-0480	JOHN A COERSE	800 WEST AVE #406	MIAMI BEACH	FL	33139-5530	USA
02-4203-155-0490	AURORA ADAMSKI TRS	800 WEST AVE #506	MIAMI BEACH	FL	33139-5536	USA
02-4203-155-0500	OSCAR SANCHEZ	800 WEST AVE #606	MIAMI BEACH	FL	33139-5527	USA
02-4203-155-0510	JAMES KIERNAN	332 12 ST #3F	BROOKLYN	NY	11215	USA
02-4203-155-0520	STEVEN FRUMKIN	777 6TH AVE #32B	NEW YORK	NY	10001	USA
02-4203-155-0530	MSL ISLAND LLC	11402 NW 41 ST 202	DORAL	FL	33178	USA
02-4203-155-0540	JOSEPH ABBAMONT	800 WEST AVE #PH06	MIAMI BEACH	FL	33139	USA
02-4203-155-0550	EDUARDO TARTARINI	800 WEST AVE UNIT 208	MIAMI BEACH	FL	33139-5579	USA
02-4203-155-0560	ROBERTO ALVAREZ	800 WEST AVE UNIT 308	MIAMI BEACH	FL	33139-5535	USA
02-4203-155-0580	CATHERINE MACKEY	800 WEST AVE #508	MIAMI BEACH	FL	33139-5536	USA
02-4203-155-0590	DINA ANSALDI SCATIGNO	1000 VENETIAN WAY #401	MIAMI BEACH	FL	33139	USA
02-4203-155-0600	BROOKE TIMBERLAKE	800 WEST AVENUE #708	MIAMI BEACH	FL	33139	USA
02-4203-155-0610	ELYOT LLC	145 JEFFERSON AVE	MIAMI	FL	33139	USA
02-4203-155-0620	IVAN MARROQUIN	800 WEST AVE #908	MIAMI BEACH	FL	33139	USA
02-4203-155-0630	MARK SARACINO	800 WEST AVE UNIT PH-08	MIAMI BEACH	FL	33139-5542	USA
02-4203-155-0640	RONALD C SAUNDERS &W LORETTA W	8263 DEMING DR	ORLANDO	FL	32825	USA
02-4203-155-0650	ISABEL HANSEN & S H JEFFRIES TRS	212 PARK DR	COLUMBUS	OH	43209	USA
02-4203-155-0660	KRESHNIK DIBRANI	800 WEST AVE 409	MIAMI BEACH	FL	33139	USA
02-4203-155-0670	FRANCO MARANZANA	800 WEST AVE #509	MIAMI	FL	33139-5581	USA
02-4203-155-0680	OGNEN BLAZEVIC	800 WEST AVE #609	MIAMI BEACH	FL	33139	USA
02-4203-155-0690	ITZIAR DIEZ	800 WEST AVE #709	MIAMI BEACH	FL	33139	USA
02-4203-155-0700	JAMES E MAKI	800 WEST AVE 809	MIAMI BEACH	FL	33139	USA
02-4203-155-0710	FELIPE DE PAZ	231 PALM AVE	MIAMI	FL	33139	USA
02-4203-155-0730	VADIM ISKANDARYAN	60 W 23RD ST APT 914	NEW YORK	NY	10010-5296	USA
02-4203-155-0740	PATRICIA GREENE	800 WEST AVE #310	MIAMI BEACH	FL	33139-5535	USA
02-4203-155-0750	MARK TYE TRUST	PO BOX 8992	ASPEN	CO	81612	USA
02-4203-155-0760	DEBORAH WHOULEY	255 COLLINS AVE #5	MIAMI BEACH	FL	33139	USA
02-4203-155-0770	NIKOLAS KOZY	2230 OVERBROOK ST	MIAMI	FL	33133-3181	USA
02-4203-155-0780	GUS L MAYORGA	800 WEST AVE #710	MIAMI BEACH	FL	33139-5580	USA
02-4203-155-0790	EMILLIANO FABIAN	800 WEST AVE 810	MIAMI BEACH	FL	33139	USA
02-4203-155-0800	DANIEL ROSENBERG	800 WEST AVE #910	MIAMI BEACH	FL	33139-5584	USA
02-4203-155-0810	ERIN D MCCARTNEY	800 WEST AVE #PH10	MIAMI BEACH	FL	33139	USA
02-4203-155-0820	KARIN FIX TRS	800 WEST AVE #211	MIAMI BEACH	FL	33139	USA
02-4203-155-0830	MASSIMO CIRASINO	800 W AVE 311	MIAMI BEACH	FL	33139-5535	USA
02-4203-155-0840	FERNANDO RAUL SALVATO	184 PALM AVE	MIAMI BEACH	FL	33139-5180	USA
02-4203-155-0850	LUCIANO DI FELICE	800 WEST AVE 511	MIAMI BEACH	FL	33139	USA
02-4203-155-0870	JIM LOUKAS	800 WEST AVE #711	MIAMI BEACH	FL	33139	USA

02-4203-155-0880	PETER WOLK & W JANET	800 WEST AVE #811	MIAMI BEACH	FL	33139-5583	USA
02-4203-155-0890	JUANITA EVERETEZE	500 W 30TH ST APT 30J	NEW YORK	NY	10001-1382	USA
02-4203-155-0900	SPENCER BURKE	800 WEST AVE #PH9	MIAMI BEACH	FL	33139	USA
02-4203-155-0910	PHILLIP MONACO	291 CENTRAL PARK WEST #6E	NEW YORK CITY	NY	10024	USA
02-4203-155-0930	GARY STEVEN ZIMMERMAN	800 WEST AVE #412	MIAMI BEACH	FL	33139-5541	USA
02-4203-155-0940	CAVANAUGH CHARTERS INC	16885 DALLAS PARKWAY	ADDISON	TX	75001	USA
02-4203-155-0950	DOUGLAS G WERNICK	800 WEST AVE #612	MIAMI BEACH	FL	33139-5540	USA
02-4203-155-0960	BARBARA SINGER	800 WEST AVE UNIT 712	MIAMI BEACH	FL	33139-5580	USA
02-4203-155-0970	SYLVAIN BACON JTRS	800 WEST AVE #812	MIAMI BEACH	FL	33139	USA
02-4203-155-0980	CHRISTINE DAVIS	800 WEST AVE 912	MIAMI	FL	33139	USA
02-4203-155-0990	LOREN J GALLO	800 WEST AVE UNIT PH-12	MIAMI BEACH	FL	33139-5542	USA
02-4203-155-1000	ROSA MARIA CACHO	800 WEST AVE 414	MIAMI BEACH	FL	33139	USA
02-4203-155-1010	CHANDLER CRAIG & W SUZANNE C	800 WEST AVE #514	MIAMI BEACH	FL	33139-5581	USA
02-4203-155-1020	MARGHERITA CORP	1444 BISCAYNE BLVD #306	MIAMI	FL	33132	USA
02-4203-155-1030	ANDRZEJ REDUCHA & W OLGA	4450 SW 154 AVE	MIAMI	FL	33185-4548	USA
02-4203-155-1040	MARIO CASTELL	800 WEST AVE #814	MIAMI BEACH	FL	33139-5583	USA
02-4203-155-1050	WILLIAM SARILLE	800 WEST AVE #914	MIAMI BEACH	FL	33139-5584	USA
02-4203-155-1060	INGRID NEGRON	29 WASHINGTON ST 110	SAN JUAN	PR	00907	USA
02-4203-155-1070	MICHELA BELLUSO TR	1943 EAST MARSHALL AVE	PHOENIX	AZ	85016	USA
02-4203-155-1080	PORTFOLIO MANAGEMENT AND	536 14 ST 106	MIAMI BEACH	FL	33139	USA
02-4203-155-1090	CAVANAUGH CHARTERS INC	16885 DALLAS PARKWAY	ADDISON	TX	75001	USA
02-4203-155-1100	ANDREA BAZZANI	800 WEST AVE #715	MIAMI BEACH	FL	33139	USA
02-4203-155-1110	NOEMI L LOPEZ	4125 CASE STREET APT #2-G	ELMHURT	NY	11373	USA
02-4203-155-1120	BARBARA INES VILASECA	10350 WEST BAY HARBOR DR #6P	BAY HARBOR	FL	33154-1238	USA
02-4203-155-1130	DEBORA KATZ	800 WEST AVE #PH15	MIAMI BEACH	FL	33139	USA
02-4203-155-1140	MARCO FERRARI	650 WEST AVE APT 1509	MIAMI BEACH	FL	33139-6331	USA
02-4203-155-1150	PABLO LAFFORGUE &	800 WEST AVE #516	MIAMI BEACH	FL	33139-5581	USA
02-4203-155-1160	LOURDES HUMBLE	9999 COLLINS AVE 124 12 A	BAL HARBOUR	FL	33154	USA
02-4203-155-1170	JAMES ERNEST MAKI	360 FURMAN ST #444	BROOKLYN	NY	11201	USA
02-4203-155-1180	EDWARD L GEOPFERT TRS	1235 N KINGS RD #103	LOS ANGELES	CA	90069	USA
02-4203-155-1190	BETTY TIBBETTS	800 WEST AVE #916	MIAMI BEACH	FL	33139-5584	USA
02-4203-155-1200	EDWARD L GEOPFERT TRS	1235 N KINGS RD #103	WEST HOLLYWOOD	CA	90069	USA
02-4203-155-1210	417 SOUTHBAY INC	1390 BRICKELL AVE STE 200	MIAMI	FL	33131-3322	USA
02-4203-155-1220	MAGIC LEONE	800 WEST AVE 517	MIAMI BEACH	FL	33139	USA
02-4203-155-1230	ALEXANDER PLEYER	1623 LENOX AVE 8	MIAMI BEACH	FL	33139-2494	USA
02-4203-155-1240	HAROLD R RUBENSTEIN	8 EAST 74 ST APT 4A	NEW YORK	NY	10021	USA
02-4203-155-1250	ARIEL ROSE	800 WEST AVE 817	MIAMI BEACH	FL	33139	USA
02-4203-155-1260	ORIE ATTAS	20941 NE 21ST CT	NORTH MIAMI BEACH	FL	33179	USA
02-4203-155-1270	DEBORA KATZ	800 WEST AVE #PH 17	MIAMI	FL	33139-5582	USA
02-4203-155-1290	TITAN DEVELOPMENT PARTNERS LLC	4095 SW 67 AVE	MIAMI	FL	33155	USA
02-4203-155-1300	FIVE HORIZONS PROPERTY LLC	220 71 ST #213	MIAMI BEACH	FL	33141	USA
02-4203-155-1310	800 W AVE 718 LLC	5601 OAKMONT AVE	HOLLYWOOD	FL	33312	USA
02-4203-155-1320	SALVATORE DELLOMO	1603 HOLBROOK ST	OAKHURST	NJ	07755	USA
02-4203-155-1330	EDWARD L GEOPFERT TRS	1235 N KINGS RD #103	LOS ANGELES	CA	90069	USA
02-4203-155-1340	CHRISTINA CUERVO TRS	444 BRICKELL AVE #700	MIAMI	FL	33131	USA
02-4203-155-1350	LUC HARDY & W MARY	303 COGNEWAUGH RD	COS COB	CT	06807	USA
02-4203-155-1360	R MICHAEL FLORES	302 TOURAINE RD	GROSSE POINTE FARMS	MI	48236-3311	USA
02-4203-155-1370	RONALD G BELLOPEDE	800 WEST AVE #619	MIAMI BEACH	FL	33139-5540	USA
02-4203-155-1380	RONALD GERARD BELLOPEDE	800 WEST AVE # 619	MIAMI	FL	33139	USA
02-4203-155-1390	PETER GRIMES	800 WEST AVE 819	MIAMI BEACH	FL	33139	USA
02-4203-155-1410	JOLIE GLASSMAN	800 WEST AVE PH19	MIAMI BEACH	FL	33139	USA
02-4203-155-1420	FUTURA MIAMI INVEST LLC	1680 MICHIGAN AVE # 910	MIAMI BEACH	FL	33139	USA
02-4203-155-1430	J I U S EXPORT LLC	7400 SW 133 ST	MIAMI	FL	33156	USA
02-4203-155-1440	DALE COTTON	1330 WEST AVE	MIAMI BEACH	FL	33139	USA
02-4203-155-1460	MIGUEL R ARROYO	800 WEST AVE UNIT 820	MIAMI BEACH	FL	33139-5583	USA
02-4203-155-1470	EDWARD J DEMOTT JR	800 WEST AVE #920	MIAMI BEACH	FL	33139-5584	USA
02-4203-155-1480	ANDREW ROSS COHAN JTRS	PO BOX 402767	MIAMI BEACH	FL	33140	USA
02-4203-155-1490	ARTURO GARCIA EST OF	800 WEST AVE #421	MIAMI BEACH	FL	33139-5541	USA
02-4203-155-1500	LIZZ RIA KRITZER	245 E 54 ST #1713	NEW YORK	NY	10022	USA
02-4203-155-1510	ALEXIS PERIN & MAXIMO PERIN	164 HICKORY ST	WASHINGTON	NJ	07676	USA

02-4203-155-1520	IBERIAN TRADING CORP	304 RHODODENDRIN DR	CHAPEL HILL	NC	27517	USA
02-4203-155-1530	RAN GOLANI	800 WEST AVE #821	MIAMI BEACH	FL	33139-5583	USA
02-4203-155-1540	RICHARD T FLEISHER	PO BOX 2623	SAG HARBOR	NY	11963	USA
02-4203-155-1550	JOEL CUCCIO	367 LONG BOW DR	ENGLEWOOD	NJ	07631	USA
02-4203-155-1560	JOYCE A CARRINGTON	1274 5th Ave Apt 309	New York	NY	10029-3413	USA
02-4203-155-1570	LEONID L YANCHUK	4238 FRANCE AVE S	EDINA	MN	55416	USA
02-4203-155-1580	SHD S BAY CLU I LLC	141 NE 3 AVE 12 FLR	MIAMI	FL	33132	USA
02-4203-155-1590	OLIVIER REFALO	11250 SW 73RD CT	MIAMI	FL	33156-4625	USA
02-4203-155-1600	CHRISTIANA TRUST TRS	2900 W CYPRESS CREEK RD STE 6	FORT LAUDERDALE	FL	33309	USA
02-4203-155-1610	NICOLAS VASATURO	800 WEST AVE #922	MIAMI BEACH	FL	33139-5584	USA
02-4203-155-1620	DAEHONG KIM	800 WEST AVE PH22	MIAMI	FL	33139	USA
02-4203-155-1630	MILAGROS GUTIERREZ TRS	11130 GRIFFING BLVD	BISCAYNE PARK	FL	33161	USA
02-4203-155-1640	BELKIS CARPINTERO &H	800 WEST AVE #523	MIAMI BEACH	FL	33139-5581	USA
02-4203-155-1650	FRANK W DUNN	800 WEST AVE 623	MIAMI BEACH	FL	33139	USA
02-4203-155-1660	STEPHEN UPSON	800 WEST AVE #723	MIAMI BEACH	FL	33139-5580	USA
02-4203-155-1670	AMBROTHERS LLC	16375 NE 18 AVENUE #225	NORTH MIAMI BEACH	FL	33162	USA
02-4203-155-1680	ALEX FREYTAG	800 WEST AVE # 923	MIAMI BEACH	FL	33139	USA
02-4203-155-1690	CARSTEN WILLERT JTRS	800 WEST AVE #PH23	MIAMI BEACH	FL	33139	USA
02-4203-155-1700	NICOLAS PITSILOS &	13 BLACK WALNUT	PALOS PARK	IL	60464	USA
02-4203-155-1710	CHRISTOPHER J MCCAULEY	800 WEST AVE #524	MIAMI BEACH	FL	33139-5581	USA
02-4203-155-1720	SUPERCAMCAM LLC	800 WEST AVE APT 624	MIAMI BEACH	FL	33139	USA
02-4203-155-1730	WILLIAM GILCHRIST	800 WEST AVE #724	MIAMI BEACH	FL	33139	USA
02-4203-155-1740	CHRIS J SERLUCCO	800 WEST AVE # 824	MIAMI	FL	33139	USA
02-4203-155-1750	ABRS MARKETING & CONSULTING LLC	800 WEST AVE #335	MIAMI BEACH	FL	33139	USA
02-4203-155-1770	MICHELE TOWBIN	832 S SOUTHLAKE DR	HOLLYWOOD	FL	33019	USA
02-4203-155-1780	MANUEL PUNS	800 WEST AVE #525	MIAMI BEACH	FL	33139-5581	USA
02-4203-155-1790	WILLIAM BONDY	800 WEST AVE #625	MIAMI BEACH	FL	33139-5540	USA
02-4203-155-1800	AILEEN UPSON	800 WEST AVE #725	MIAMI BEACH	FL	33139	USA
02-4203-155-1810	TOM F BLANCHESTER	1348 WASHINGTON AVE # 248	MIAMI BEACH	FL	33139	USA
02-4203-155-1820	LISA DANIELSON	8307 HATHAWAY DRIVE APT A	AUSTIN	TX	78757	USA
02-4203-155-1840	GENEVIEVE NEGLIA	800 WEST AVE 426	MIAMI BEACH	FL	33139	USA
02-4203-155-1850	JORGE E GUZZETTI TRS	9 NE 19 CT #207C	FORT LAUDERDALE	FL	33305	USA
02-4203-155-1870	ORLANDO J RODRIGUEZ EST OF	800 WEST AVE UNIT 726	MIAMI BEACH	FL	33139-5580	USA
02-4203-155-1880	EVELYN MENIN	800 WEST AVE 826	MIAMI	FL	33139	USA
02-4203-155-1890	JOSE SANCHEZ	800 WEST AVE UNIT 926	MIAMI BEACH	FL	33139-5584	USA
02-4203-155-1900	DAVID L JARRETT	GRAND CENTRAL STATION	NEW YORK	NY	10163-1486	USA
02-4203-155-1910	JOSE ALFONSO PENA	9 ISLAND AVE APT 1111	MIAMI BEACH	FL	33139-1328	USA
02-4203-155-1920	RYAN JACOBS	800 WEST AVE 527	MIAMI BEACH	FL	33139	USA
02-4203-155-1930	CONNIE IOANNIDIS	800 WEST AVE UNIT 627	MIAMI BEACH	FL	33139-5506	USA
02-4203-155-1940	BYLUDO LLC	540 WEST AVE # 1913	MIAMI BEACH	FL	33139	USA
02-4203-155-1950	ROBERT FLEMING LE	800 WEST AVENUE #827	MIAMI BEACH	FL	33139	USA
02-4203-155-1960	RAOUL PECK	800 WEST AVE #927	MIAMI BEACH	FL	33139-5573	USA
02-4203-155-1970	DADDY GIFT LLC	800 WEST AVE PH27	MIAMI BEACH	FL	33139	USA
02-4203-155-1980	RICHARD W TWOHIG &W LINDA J	800 WEST AVE #428	MIAMI BEACH	FL	33139-5541	USA
02-4203-155-1990	MARIA DEL CARMEN SANCHEZ	800 WEST AVE # 528	MIAMI	FL	33139-5581	USA
02-4203-155-2000	DARA RAUZIN	800 WEST AVE 628	MIAMI BEACH	FL	33139-5540	USA
02-4203-155-2010	SUZANNE MICHICO SWAN JTRS	5545 N PEACHTREE RD	DUNWOODY	GA	30338	USA
02-4203-155-2020	CHARLES POUNCY	800 WEST AVE #828	MIAMI BEACH	FL	33139-5538	USA
02-4203-155-2030	JANET A BETCHKAL TRS	6335 CHRISTOPHER CREEK RD WEST	JACKSONVILLE	FL	32217	USA
02-4203-155-2040	DIANA MABEL SANCHEZ	800 WEST AVE PH28	MIAMI BEACH	FL	33139	USA
02-4203-155-2050	STEPHEN R HALSEY	800 WEST AVE #429	MIAMI BEACH	FL	33139	USA
02-4203-155-2060	LUIS PAVONI	3380 PEACHTREE RD NE UNIT 1607	ATLANTA	GA	30326-1655	USA
02-4203-155-2070	SCOTT CARDONE	1413 SUNSET HARBOUR DR 412	MIAMI	FL	33139-	USA
02-4203-155-2080	LOUIS F PETROLE	800 WEST AVE UNIT 729	MIAMI BEACH	FL	33139-5599	USA
02-4203-155-2090	JOSEPH P LUCAS &W JOSEPHINE	364 CONCORD DRIVE	MAYWOOD	NJ	07607	USA
02-4203-155-2100	DAVID B COMMON	108 E 82 ST #8C	NEW YORK	NY	10028	USA
02-4203-155-2110	CORRADO COLINI	465 OCEAN DR 1015	MIAMI BEACH	FL	33139	USA
02-4203-155-2120	1515 WEST LLC	800 WEST AVENUE #430	MIAMI BEACH	FL	33139	USA
02-4203-155-2130	GREG F PANAGIOTATOS	800 WEST AVE APT 530	MIAMI BEACH	FL	33139	USA
02-4203-155-2140	LECY MARIA CROSARA MILANO	800 WEST AVE #630	MIAMI BEACH	FL	33139-5537	USA
02-4203-155-2150	MICHELA BELLUSO	1943 EAST MARSHALL AVE04	PHOENIX	AZ	85016	USA
02-4203-155-2160	SERGE MASSAT	9 ISLAND AVE #401	MIAMI BEACH	FL	33139	USA
02-4203-155-2170	CATHERIN E SEELE	800 WEST AVE #930	MIAMI BEACH	FL	33139-5573	USA
02-4203-155-2180	ANNA MICHELLE GEOR	5401 COLLINS AVE UNIT 314	MIAMI BEACH	FL	33139	USA

02-4203-155-2190	STELLA REAL ESTATE INC	150 SE 2 AVE ST 1010	MIAMI	FL	33131	USA
02-4203-155-2210	DOWNTOWN DREAM VIEWS LLC	326 71 ST	MIAMI BEACH	FL	33141	USA
02-4203-155-2220	ANDY GAERTNER	800 WEST AVE # 731	MIAMI BEACH	FL	33139	USA
02-4203-155-2230	JOSEP VIADER I BERGES	1049 SOUTHFIELD RD	SHREVEPORT	LA	71106	USA
02-4203-155-2240	ARI BARKAN	2101 MARKET ST #3603	PHILADELPHIA	PA	19103	USA
02-4203-155-2250	JAMES D LONEY	800 WEST AVE #PH 31	MIAMI BEACH	FL	33139-5539	USA
02-4203-155-2260	STEPHEN J DEGENNARO	13700 SW 78 CT	MIAMI	FL	33158	USA
02-4203-155-2270	JEROME SOLOVAY &W JOAN	800 CYPREE GROVE DR UNIT 307	POMPANO BEACH	FL	33069	USA
02-4203-155-2280	MARIA KRON TRS	60 WASHINGTON AVE	SPRINGFIELD	NJ	07081	USA
02-4203-155-2290	BEATRIZ S GIL	800 WEST AVE #732	MIAMI BEACH	FL	33139-5599	USA
02-4203-155-2300	GREGORY ALLEN DURKAN	800 WEST AVE #832	MIAMI	FL	33139	USA
02-4203-155-2310	GUSTAVO PRADILLA	800 WEST AVE # 932	MIAMI BEACH	FL	33139	USA
02-4203-155-2320	BGM BAY WEST LLC	1330 COLLINS AVE 1	MIAMI BEACH	FL	33139	USA
02-4203-155-2330	JAMES M WILLIAMS	800 WEST AVE 433	MIAMI BEACH	FL	33139	USA
02-4203-155-2340	HAYDEE BELVEDER	800 WEST AVE #533	MIAMI BEACH	FL	33139-5527	USA
02-4203-155-2350	LIONEL T HAYWARD	800 WEST AVE #633	MIAMI BEACH	FL	33139	USA
02-4203-155-2360	DAVID CHOWANEC & MICHAEL OLIVE	2383 BEAR DEN RD	FREDERICK	MD	21701-9328	USA
02-4203-155-2370	DENNIS WARD	800 WEST AVE UNIT 833	MIAMI BEACH	FL	33139-5538	USA
02-4203-155-2380	KEVIN SAEED	540 NW 166th Ave	Pembroke Pines	FL	33028-1404	USA
02-4203-155-2390	ENID RODRIGUEZ	800 WEST AVE PH33	MIAMI	FL	33139	USA
02-4203-155-2400	THOMAS PAUL INMAN	6 WAVERLY PLACE	STAMFORD	CT	06902	USA
02-4203-155-2410	JERMAINE HERON	800 WEST AVE #334	MIAMI BEACH	FL	33139	USA
02-4203-155-2420	SERDAR AYBERK	825 W END AVE #7D	NEW YORK	NY	10025	USA
02-4203-155-2440	DANIEL RAMIREZ	2502 FAIRFIELD BEND DR	SAN ANTONIO	TX	78231	USA
02-4203-155-2450	WILLIAM VALDES-ZUAZO	3660 NW 41 ST	MIAMI	FL	33142	USA
02-4203-155-2460	JACK MOSKOWITZ &W FAYE	3306 HIGHLAND PL NW	WASHINGTON	DC	20008-3233	USA
02-4203-155-2470	MICHELE PETTERNELLA	800 WEST AVE 934	MIAMI BEACH	FL	33139	USA
02-4203-155-2480	LORI L RAND LE	800 WEST AVE #PH34	MIAMI BEACH	FL	33139	USA
02-4203-155-2490	KALYAN INUGANTI	800 WEST AVE APT 235	MIAMI BEACH	FL	33139-5535	USA
02-4203-155-2500	ANA B SANTOS BIRCH	800 WEST AVE #335	MIAMI BEACH	FL	33139	USA
02-4203-155-2510	LUISA FREITAS & ISABEL FREITAS	800 WEST AVE UNIT 435	MIAMI BEACH	FL	33139-5536	USA
02-4203-155-2520	RIITTA LIISA HELMINEN	800 WEST AVE UNIT 535	MIAMI BEACH	FL	33139-5527	USA
02-4203-155-2530	INDERA RAMPERSAUD	2642 FLAMINGO LN	FORT LAUDERDALE	FL	33312	USA
02-4203-155-2540	RODNEY HUTCHESON	800 WEST AVE # 735	MIAMI BEACH	FL	33139	USA
02-4203-155-2550	FABRICIO A AYALA &W CLAUDIA V	13936 BALD CYPRESS CIR	FT MYERS	FL	33907-1840	USA
02-4203-155-2560	MIHAELA A PASCU	800 WEST AVE #935	MIAMI BEACH	FL	33139	USA
02-4203-155-2570	MICHAEL J CHIANESE	800 WEST AVE UNIT PH35	MIAMI BEACH	FL	33139-5542	USA
02-4203-155-2580	BEVERLY L WOLINE	800 WEST AVE 236	MIAMI BEACH	FL	33139	USA
02-4203-155-2590	TANYA VILLANUEVA	800 WEST AVE #336	MIAMI BEACH	FL	33139-5530	USA
02-4203-155-2600	VICTORIA H VALENCIA &H	7811 SAINT CHARLES AVE	NEW ORLEANS	LA	70118	USA
02-4203-155-2610	DIANA DLUZ	800 WEST AVE #536	MIAMI BEACH	FL	33139-5527	USA
02-4203-155-2620	EDGAR GONZALEZ	800 WEST AVE # 636	MIAMI BEACH	FL	33139	USA
02-4203-155-2640	DONALD W NEUFELD	800 W AVE 836	MIAMI BEACH	FL	33139	USA
02-4203-155-2650	ANTONIO QUEVEDO JR LE	740 6 S E	NAPLES	FL	34117	USA
02-4203-155-2660	USBERKO LLC	1580 BAY RD 951	MIAMI	FL	33139	USA
02-4203-155-2670	JORGE D DOCTOROVICH &W LILIANA B	1585 E 11 AVE	HALEAH	FL	33010-3308	USA
02-4203-155-2680	ELA DOPAZO	515 WEST 59 ST APT-33A	NEW YORK	NY	10019-0000	USA
02-4203-155-2690	OSCAR SANCHEZ	800 WEST AVE #606	MIAMI BEACH	FL	33139-5527	USA
02-4203-155-2700	TDG HOUSING LLC	444 BRICKELL AVE #700	MIAMI	FL	33131	USA
02-4203-155-2710	JOSE ANTONIO BORBON	800 WEST AVE UNIT 637	MIAMI BEACH	FL	33139	USA
02-4203-155-2720	AVA RADO HARTE LE	800 WEST AVE #737	MIAMI BEACH	FL	33139	USA
02-4203-155-2730	CATHERIN E SEELE	800 WEST AVE #930	MIAMI BEACH	FL	33139-5573	USA
02-4203-155-2740	MICHELA BELLUSO (TR)	1943 EAST MARSHALL AVE	PHOENIX	AZ	85016	USA
02-4203-155-2750	VITO G ZULLO	800 WEST AVE # PH 37	MIAMI BEACH	FL	33139	USA
02-4203-155-2760	MICHELE PARKER	5100 SW 90 AVE #202	COPPER CITY	FL	33328	USA
02-4203-155-2770	SARAH & CATHY ZUCKERMAN (JTRS)	800 WEST AVE #338	MIAMI BEACH	FL	33139-5530	USA
02-4203-155-2790	JOSE E OTERO	800 WEST AVE UNIT 538	MIAMI BEACH	FL	33139-5527	USA
02-4203-155-2800	JOSE E & CHAMA OTERO	800 WEST AVE #538	MIAMI BEACH	FL	33139-5527	USA
02-4203-155-2810	EUGENIA A BENFIELD &	800 WEST AVE 738	MIAMI	FL	33139	USA
02-4203-155-2840	ERIC G CHRISTIANSEN	800 WEST AVE PH38	MIAMI BEACH	FL	33139	USA
02-4203-155-2850	UV CITE II LLC	1125 NE 125 ST STE 101	NORTH MIAMI	FL	33161	USA
02-4203-155-2860	DARIO PICARDI	90 ALTON RD # 1607	MIAMI BEACH	FL	33139	USA
02-4203-155-2870	AMADO MEDEROS &W TERESA	800 WEST AVE #440	MIAMI BEACH	FL	33139-5536	USA
02-4203-155-2880	ANDREW LOUKAS	800 WEST AVE 845	MIAMI BEACH	FL	33139	USA
02-4203-155-2890	ANDREW LOUKAS	800 WEST AVE 845	MIAMI BEACH	FL	33139	USA
02-4203-155-2910	JEAN C HEICHMAN	800 WEST AVE APT 840	MIAMI BEACH	FL	33139	USA
02-4203-155-2920	STEPHEN J GALLOWAY	800 WEST AVE #940	MIAMI BCH	FL	33139-5573	USA
02-4203-155-2930	CYNTHIA SHOWSTARK	800 WEST AVE PH40	MIAMI BEACH	FL	33139	USA
02-4203-155-2940	CHRISTINE FLOREZ JTRS	800 WEST AVE #241	MIAMI BEACH	FL	33139	USA

02-4203-155-2950	1250 WEST LLC	1330 COLLINS AVE UNIT #1	MIAMI BEACH	FL	33139	USA
02-4203-155-2960	SALVATORE DOMANTI	800 WEST AVE 441	MIAMI BEACH	FL	33139	USA
02-4203-155-2970	JORGE E GUZZETTI TRS	9 NE 19 CT 207C	FORT LAUDERDALE	FL	33305	USA
02-4203-155-2980	MICHAEL MOOSHER	1000 WEST AVE #427	MIAMI BEACH	FL	33139-4718	USA
02-4203-155-2990	MICHAEL J DORE	800 WEST AVE UNIT 741	MIAMI BEACH	FL	33139-5599	USA
02-4203-155-3000	FELIPE CUNHA	800 WEST AVE 841	MIAMI BEACH	FL	33139	USA
02-4203-155-3010	JO ANN CLARK	800 WEST AVE #941	MIAMI BEACH	FL	33139-5573	USA
02-4203-155-3020	CHRISTOPHER E KILEY	800 WEST AVE UNIT PH-41	MIAMI BEACH	FL	33139	USA
02-4203-155-3030	SOUTH BEACH WEST LLC	1330 COLLINS AVE #1	MIAMI BEACH	FL	33139	USA
02-4203-155-3040	BENJAMIN LOPEZ	442 W 162 ST #1	NEW YORK	NY	10032	USA
02-4203-155-3050	SVYA KARAIM	PO BOX 398058	MIAMI BEACH	FL	33239-8058	USA
02-4203-155-3060	KATHLEEN VACCARO TCHALABY	800 WEST AVE 542	MIAMI BEACH	FL	33139	USA
02-4203-155-3070	LAURA KAPLAN	800 WEST AVE #642	MIAMI BEACH	FL	33139-5537	USA
02-4203-155-3080	SUSANA ANDRES-CARRILLO	800 WEST AVE UNIT 742	MIAMI BEACH	FL	33139-5599	USA
02-4203-155-3090	JASON POWE	800 WEST AVE 842	MIAMI BEACH	FL	33139	USA
02-4203-155-3100	LAZARO SUAREZ	800 WEST AVE # 942	MIAMI BEACH	FL	33139	USA
02-4203-155-3110	CHANDLER H PELLOCK	800 WEST AVE # PH42	MIAMI BEACH	FL	33139	USA
02-4203-155-3120	SVEN SCHULZ	800 WEST AVE #243	MIAMI BEACH	FL	33139	USA
02-4203-155-3130	JOEN L HILFER	800 WEST AVE #343	MIAMI BEACH	FL	33139-5530	USA
02-4203-155-3140	HANK REARDEN LLC	1111 CRANDON BLVD #A1105	KEY BISCAYNE	FL	33149	USA
02-4203-155-3150	SUSAN ZETSCHA	525 EAST 14 ST #8B	NEWYORK	NY	10009	USA
02-4203-155-3160	WILLIAM FRASER	800 WEST AVE UNIT 643	MIAMI BEACH	FL	33139	USA
02-4203-155-3170	ELIZABETH LARDI ECHEVERRIA	800 W AVE #743	MIAMI BEACH	FL	33139	USA
02-4203-155-3180	BEATRICA SAGAR (TR)	800 WEST AVE #843	MIAMI BEACH	FL	33139-5538	USA
02-4203-155-3190	DIANNE THORNE	800 WEST AVE #943	MIAMI BEACH	FL	33139-5573	USA
02-4203-155-3200	MARCELO JOSE CATURLA	800 WEST AVE UNIT PH43	MIAMI BEACH	FL	33139-5542	USA
02-4203-155-3210	WILLIAM GARDNER	800 WEST AVE #244	MIAMI BEACH	FL	33139	USA
02-4203-155-3220	STELLANO LLC	800 WEST AVE 344	MIAMI BEACH	FL	33139	USA
02-4203-155-3230	ALLEN HARRIS FLASTERSTEIN	PO BOX 565901	MIAMI	FL	33256	USA
02-4203-155-3250	RAN Z GOLANI	800 WEST AVE #644	MIAMI BEACH	FL	33139-5537	USA
02-4203-155-3260	ARIEL GENE HUGUET	800 WEST AVE 744	MIAMI BEACH	FL	33139	USA
02-4203-155-3270	157 SOUTH LLC	1001 BRICKELL BAY DR #2650	MIAMI	FL	33131	USA
02-4203-155-3280	ROBERT S DIESEL	800 WEST AVE #944	MIAMI BEACH	FL	33139-5573	USA
02-4203-155-3290	OMAR J RODRIGUEZ & W ANA M	800 WEST AVE #PH44	MIAMI BEACH	FL	33139-5542	USA
02-4203-155-3300	SPIAGGIA INC	800 WEST AVE 746	MIAMI BEACH	FL	33139	USA
02-4203-155-3310	SUSAN SCHEIN	800 WEST AVE #345	MIAMI BEACH	FL	33139-5530	USA
02-4203-155-3320	ADOLPHUS L SPAIN TRS	800 WEST AVE APT 445	MIAMI BEACH	FL	33139	USA
02-4203-155-3330	HENDRIKA ELISABETH BREED	800 WEST AVE #545	MIAMI BEACH	FL	33139-5527	USA
02-4203-155-3340	DIANNE THORNE	800 WEST AVE #645	MIAMI BEACH	FL	33139-5537	USA
02-4203-155-3350	WEST AVE ASSOCIATES LLC	421 MERIDIAN AVE #1	MIAMI BEACH	FL	33139	USA
02-4203-155-3360	ANDREW LOUKAS	800 WEST AVE 845	MIAMI BEACH	FL	33139	USA
02-4203-155-3370	GEORGE F ZAKHARIA TRS	907 N LINDEN CT	WICHITA	KS	67206	USA
02-4203-155-3380	PIERRE LARROQUE & MARIO FAURET	800 WEST AVE PH-45	MIAMI BEACH	FL	33139-5539	USA
02-4203-155-3390	DENNIS MOUYIOS &	800 WEST AVE #246	MIAMI BEACH	FL	33139	USA
02-4203-155-3400	MICHELE L TAUBMAN	800 WEST AVE #346	MIAMI BEACH	FL	33139	USA
02-4203-155-3410	JAMES L WEINGARTEN	800 WEST AVE #446	MIAMI BEACH	FL	33139-5536	USA
02-4203-155-3420	LUCIANO DIFELICE	800 WEST AVE #546	MIAMI BEACH	FL	33139	USA
02-4203-155-3430	H QUINN PEITZ JR TRS	800 WEST AVE APT 646	MIAMI BEACH	FL	33139	USA
02-4203-155-3440	ELIZABETH CORYLLOS LARDI	800 WEST AVE UNIT 746	MIAMI BEACH	FL	33139-5599	USA
02-4203-155-3450	JEAN B DEL RIO	800 WEST AVE #846	MIAMI BEACH	FL	33139-5538	USA
02-4203-155-3460	ALEXANDER WENDELL & W PATRICIA	800 WEST AVE #946	MIAMI BEACH	FL	33139-5573	USA
02-4203-155-3470	SOLEMARE O4 LLC	1550 MADRUGA AVE #120	CORAL GABLES	FL	33146-3016	USA
02-4203-155-3480	SOUTH BAY CLUB CONDO ASSN INC	800 WEST AVE	MIAMI BEACH	FL	33139-5542	USA
02-4203-291-0010	BENTLEY BAY 501 LLC	520 WEST AVE UNIT 501	MIAMI BEACH	FL	33139	USA
02-4203-291-0020	JENNIFER SNOOK	7363 MILTON CT	NEW ALBANY	OH	43054	USA
02-4203-291-0030	GAIL GOLDMAN TRS	520 WEST AVE #701	MIAMI BEACH	FL	33139	USA
02-4203-291-0040	JEAN JACQUES JESSIER & W	CCS 82843 PO BOX 025323	MIAMI	FL	33102	USA
02-4203-291-0050	MICHAEL GOLDBERG	520 WEST AVE 901	MIAMI BEACH	FL	33139	USA
02-4203-291-0060	CRAIG COLODNY	2844 MARQUESAS CT	WINDERMERE	FL	34786	USA
02-4203-291-0070	ARMAND MEYARA	900 OCEAN DR #G	MIAMI BEACH	FL	33139	USA
02-4203-291-0080	PS ENTERPRISES	20801 BISCAYNE BLVD 306	AVENTURA	FL	33180	USA
02-4203-291-0090	ELIAHO WEINGARTEN TRS	520 W AVE 1401	MIAMI BEACH	FL	33139	USA
02-4203-291-0100	JIBSR LLC	1201 ORANGE ST 600	WILMINGTON	DE	19801	USA
02-4203-291-0110	SIDNEY BARCLAIS	520 West Ave Apt 1601	Miami Beach	FL	33139-5188	USA

02-4203-291-0120	SEGNER BROTHERS LTD	201 S BISCAYNE BLVD STE 1500	MIAMI	FL	33131	USA
02-4203-291-0130	NEAL E PFEIFFER	520 WEST AVE #1801	MIAMI BEACH	FL	33139	USA
02-4203-291-0140	TONY TALEBI TRS	1521 ALTON RD #900	MIAMI BEACH	FL	33139	USA
02-4203-291-0150	BLUE SKY 702 LLC	407 LINCOLN ROAD #10R	MIAMI BEACH	FL	33139	USA
02-4203-291-0160	SETAI INV LTD	PO BOX 398570	MIAMI BEACH	FL	33329	USA
02-4203-291-0170	KESMAR LLC	520 WEST AVE #2201	MIAMI BEACH	FL	33139	USA
02-4203-291-0180	BENTLEY BAY 2301 LLC	10286 CLUBHOUSE TURN RD	LAKE WORTH	FL	33449	USA
02-4203-291-0190	U S BANK NATIONAL ASSOC TRS	8742 LUCENT BOULEVARD SUITE 300	HIGHLANDS RANCH	CO	80129	USA
02-4203-291-0200	JONATHON ADVISORS LIMITED	5 SPRING HILL RD	MANTUA	NJ	08051	USA
02-4203-291-0220	ALLGOOD PROPERTIES INVEST LLC	201 S BISCAYNE BLVD #1500	MIAMI	FL	33131	USA
02-4203-291-0230	ANDREW TUOYO HARRIMAN	520 WEST AVE #902	MIAMI BEACH	FL	33139-5168	USA
02-4203-291-0240	ARMAND MEYARA	520 WEST AVE #1002	MIAMI BEACH	FL	33139	USA
02-4203-291-0250	BENTLEY BAY 1102 INC	21209 NE 38 AVE	AVENTURA	FL	33180	USA
02-4203-291-0260	PLJ LLC	20801 BISCAYNE BLVD STE 306	AVENTURA	FL	33180	USA
02-4203-291-0270	JANET SILVERMAN	520 WEST AVE UNIT 1402	MIAMI BEACH	FL	33139	USA
02-4203-291-0280	EDESSA HOLDINGS LLC	1521 ALTON RD 900	MIAMI	FL	33139	USA
02-4203-291-0290	SAMUEL R PICCIOTTO	520 WEST AVE #1602	MIAMI BEACH	FL	33139	USA
02-4203-291-0300	JAIRO PEREZ	520 WEST AVE 1702	MIAMI BEACH	FL	33139	USA
02-4203-291-0310	PAULA TADROS TRS	9839 NE 13 AVE	MIAMI SHORES	FL	33138	USA
02-4203-291-0320	ANTONIO PREVITE	800 CLAUGHTON ISLAND DR 2501	MIAMI	FL	33131	USA
02-4203-291-0330	MARK W COOPER	520 WEST AVE APT#2002	MIAMI BEACH	FL	33139	USA
02-4203-291-0340	NYON PROPERTIES CORP	355 ALHAMBRA CIR STE 801	CORAL GABLES	FL	33134	USA
02-4203-291-0350	MATTHEW ANTHONY	PO BOX 398276	MIAMI BEACH	FL	33239-8276	USA
02-4203-291-0360	BENTLEY BAY 2301 LLC	10286 CLUBHOUSE TURN RD	LAKE WORTH	FL	33449	USA
02-4203-291-0370	COAST OCEAN PROPERTIES LLC	10286 CLUBHOUSE TURN RD	LAKE WORTH	FL	33449	USA
02-4203-291-0380	DAYNE POPA	402 PALM TR	DELRAY BEACH	FL	33483	USA
02-4203-291-0390	MIAMI SAAF LLC	1150 SW 22 ST	MIAMI	FL	33129	USA
02-4203-291-0400	KAYA HASANOGLU	2125 1 AVENUE APT 2105	SEATTLE	WA	98121	USA
02-4203-291-0410	DAVID JACOB LASMAN	520 WEST AVE #803	MIAMI BEACH	FL	33139	USA
02-4203-291-0420	AMAR CHAAL	520 WEST AVE 903	MIAMI	FL	33139	USA
02-4203-291-0430	BRYON G EHRHART TRS	2444 NORTH ORCHARD STREET	CHICAGO	IL	60614	USA
02-4203-291-0440	JOMEK LLC	2050 CENTER AVE #510	FORT LEE	NJ	07024	USA
02-4203-291-0450	STEVEN ROSENFELD &W NICOLE	9870 SW 2 ST	PLANTATION	FL	33324	USA
02-4203-291-0460	DOREEN MARINA LE	611 NE 58 ST	MIAMI	FL	33137	USA
02-4203-291-0470	HAYAT H BRANCHEAU	520 WEST AVE #1503	MIAMI BEACH	FL	33139	USA
02-4203-291-0480	BRANDON KRIEG	261 W 28 ST #4B	NEW YORK	NY	10001	USA
02-4203-291-0490	PETR PRUCHA	520 WEST AVE UNIT 1703	MIAMI BEACH	FL	33139	USA
02-4203-291-0500	PAOLO REALTY CORP	5 CROTON CT	MELVILLE	NY	11747	USA
02-4203-291-0510	BENTLEY BAY 1903 LLC	520 WEST AVE 1903	MIAMI BEACH	FL	33139	USA
02-4203-291-0520	RICHARD LIEBERMAN	236 E 47 ST 18F	NEW YORK	NY	10017	USA
02-4203-291-0530	ADEM ADEM	520 WEST AVE #2103	MIAMI BEACH	FL	33139	USA
02-4203-291-0540	BEST & BEAM MANAGEMENT INC	601 NE 36 ST #CU3	MIAMI	FL	33137	USA
02-4203-291-0550	HEINRICH LEOPOLD LEHNER	520 W AVE #2403	MIAMI BEACH	FL	33139	USA
02-4203-291-0560	JOHN M STAPLES TRS	2927 24TH RD NORTH	ARLINGTON	VA	22207	USA
02-4203-291-0570	ALBERT GARNER JR	520 WEST AVE #504	MIAMI BEACH	FL	33139	USA
02-4203-291-0580	CHEAP REAL ESTATE LLC TRS	111 W WASHINGTON ST 1020	CHICAGO	IL	60602	USA
02-4203-291-0590	PHILLIP & MARIE ANNE DRAOUI &	1100 ROADHOUSE LN	ALEXANDRIA	VA	22314	USA
02-4203-291-0600	DUNKAN INVESTMENTS LLC	2929 SW 3 AVE #210	MIAMI	FL	33129	USA
02-4203-291-0610	VIVIAN DEMARIA	2032 ALHAMBRA CT	CORAL GABLES	FL	33134	USA
02-4203-291-0620	MARION OTT	1111 KANE CONCOURSE #201	BAY HARBOR	FL	33154	USA
02-4203-291-0630	ROSE ANN MCGREGOR TRS	520 W AVE # 1104	MIAMI BEACH	FL	33139	USA
02-4203-291-0640	EYAL WACHS	744 21 AVE S	NAPLES	FL	34102	USA
02-4203-291-0650	HAMSA 5 LLC	520 WEST AVE UNIT 1404	MIAMI BEACH	FL	33139	USA
02-4203-291-0660	MICHAEL NETSKY	520 WEST AVE #1504	MIAMI BEACH	FL	33139	USA
02-4203-291-0670	FRANCISCO A MEDINA &W EVA C	2080 SW 59 AVE	FT LAUDERDALE	FL	33317	USA
02-4203-291-0680	HEATHER MONAHAN	520 WEST AVE #1704	MIAMI BEACH	FL	33139-6799	USA
02-4203-291-0690	JEAN MARIE TANNOUS JTRS	520 WEST AVE #1804	MIAMI BEACH	FL	33139	USA

02-4203-291-0700	NOAH ESTELLE LLC	4834 FISHER ISLAND DR	MIAMI	FL	33109	USA
02-4203-291-0710	STEFAN GAVELL	303 BERKELEY ST UNIT 6	BOSTON	MA	02116-1566	USA
02-4203-291-0720	FABIO VISCONTI	520 WEST AVE 2104	MIAMI BEACH	FL	33139	USA
02-4203-291-0730	CHRISTOPHER B DAVIS	520 WEST AVE #2204	MIAMI BEACH	FL	33139-5167	USA
02-4203-291-0740	ALBERT GARNER JR	520 WEST AVE #605	MIAMI BEACH	FL	33139	USA
02-4203-291-0750	GUSTAVO PANTOL	520 WEST AVE #705	MIAMI	FL	33139	USA
02-4203-291-0760	ARE TRAASDAHL	PO BOX 8020	GARDEN CITY	NY	11530	USA
02-4203-291-0770	ELISA GOSSELIN TRS	14 STAR ISLAND	MIAMI BEACH	FL	33139	USA
02-4203-291-0780	CASEY MCNAMARA	17 WEST 71 ST #6C	NEW YORK	NY	10023	USA
02-4203-291-0790	VOLANTINA LLC	520 WEST AVE #1105	MIAMI BCH	FL	33139-6799	USA
02-4203-291-0800	IA BENTLY BAY INVESTMENTS LLC	175 SW 7 ST # 1518	MIAMI	FL	33130	USA
02-4203-291-0810	LNB 001-13	1521 ALTON RD #812	MIAMI BEACH	FL	33139	USA
02-4203-291-0820	ESTHER ARNETTE	540 WEST AVE #211	MIAMI BEACH	FL	33139	USA
02-4203-291-0830	SUSSEX MANAGEMENT LTD	8024 FISHER ISLAND DR	MIAMI BEACH	FL	33109	USA
02-4203-291-0840	PHILLIP SAMMUT	1469 165 ST	WHITE STONE	NY	11357	USA
02-4203-291-0850	FRIZON LLC	540 WEST AVE 2412	MIAMI BEACH	FL	33139	USA
02-4203-291-0860	RICHARD SAPIENZA JR	27 THE KEEL	EAST ISLIP	NY	11730	USA
02-4203-291-0870	SOBE BO LLC	310 EAST 70 ST UNIT 5E	NEW YORK	NY	10021	USA
02-4203-291-0880	JOHN F MOORE	540 WEST AVE 811	MIAMI	FL	33139	USA
02-4203-291-0890	ALLAN KLEER	540 WEST AVE #911	MIAMI BEACH	FL	33139-6781	USA
02-4203-291-0900	RICHARD SAPIENZA JR	27 THE KEEL	EAST ISLIP	NJ	11730	USA
02-4203-291-0910	SPENCER D PEPE &W XAVIERA M	4496 TORREY PINES DR	CHINO HILLS	CA	91709	USA
02-4203-291-0920	RICARDO V DE OLIVEIRA	540 WEST AVE #1211	MIAMI BEACH	FL	33139	USA
02-4203-291-0930	PAUL RONALD PLANTE	540 WEST AVE #1411	MIAMI BEACH	FL	33133	USA
02-4203-291-0940	WEST AVENUE VENTURES INC	133 ARAGON AVE	CORAL GABLES	FL	33134	USA
02-4203-291-0950	JOHN D DIFFENDERFER	28 BEVERLY RD	SUMMIT	NJ	07901	USA
02-4203-291-0960	JOSIANE SEYMAN	540 WEST AVE # 1711	MIAMI BEACH	FL	33139	USA
02-4203-291-0970	ROBERT DOVER	540 WEST AVE 1811	MIAMI BEACH	FL	33139	USA
02-4203-291-0980	GOLDENROCK INVESTING LIMITED	540 WEST AVE 1911	MIAMI BEACH	FL	33139-6768	USA
02-4203-291-0990	PHI GROUP LLC	540 WEST AVE #2011	MIAMI BEACH	FL	33139	USA
02-4203-291-1000	MELIS ASSOC INC	540 WEST AVE UNIT 2111	MIAMI BEACH	FL	33139	USA
02-4203-291-1010	RG FAMILY INVESTMENTS LLC	10 MUSEUM WAP APT 608	CAMBRIDGE	MA	02141	USA
02-4203-291-1020	RICHARD D AMICO &W BRENDA	16 LAMB LN	CRESKILL	NJ	07626	USA
02-4203-291-1030	BBAY LLC	2900 MCKINNON ST #608	DALLAS	TX	75201	USA
02-4203-291-1040	THOMAS RICHARD FRANCO	540 WEST AVE 212	MIAMI	FL	33139	USA
02-4203-291-1050	PIERIC J VAUCHER DE LA CROIX	3561 CRYSTAL VIEW CT	MIAMI	FL	33133-4024	USA
02-4203-291-1060	PIERLUCA LOMBARDI	540 WEST AVENUE UNIT 412	MIAMI BEACH	FL	33139	USA
02-4203-291-1070	LITTLE CAT LLC	2020 NORTH BAYSHORE DR UNIT 2409	MIAMI	FL	33137	USA
02-4203-291-1080	IGNACIO RECONDO	PO BOX 190243	MIAMI BEACH	FL	33119	USA
02-4203-291-1090	VALERIO SANGUIGNI	540 WEST AVE 712	MIAMI BEACH	FL	33139	USA
02-4203-291-1100	HOPE TWO LLC	1390 BRICKELL AVE # 200	MIAMI	FL	33131	USA
02-4203-291-1110	LUIS ALIETI &W ESMERALDA	540 WEST AVE # 912	MIAMI	FL	33139	USA
02-4203-291-1120	ANDREA BARSANTI	540 WEST AVE #1012	MIAMI	FL	33139	USA
02-4203-291-1130	LEO BEACH LLC	540 WEST AVE UNIT 1112	MIAMI BEACH	FL	33139	USA
02-4203-291-1140	DAVID HODGE	540 WEST AVE #1212	MIAMI BEACH	FL	33139	USA
02-4203-291-1150	MARKUS KLOS	540 WEST AVE 1412	MIAMI BEACH	FL	33139-6768	USA
02-4203-291-1160	DIETER P GLEASON	PO BOX 025250	MIAMI	FL	33102	USA
02-4203-291-1170	BRYON G EHRHART TRS	2444 N ORCHARD ST	CHICAGO	IL	60614	USA
02-4203-291-1180	DWT PROPERTIES TWO LLC	400 ALTON RD UNIT #1804	MIAMI BEACH	FL	33139	USA
02-4203-291-1190	TODD CHANDLER	27 LEONARD ST #5`	NEW YORK	NY	10013	USA
02-4203-291-1200	BB RE HOLDINGS LLC	785 CRADON BLVD #201	KEY BISCAYNNE	FL	33149	USA
02-4203-291-1210	SIMON JESUS KASSIS HADID	540 WEST AVE 2012	MIAMI BEACH	FL	33139	USA
02-4203-291-1220	JAN A SMITH	540 WEST AVE 2112	MIAMI	FL	33139-6771	USA
02-4203-291-1230	J BRUNO HOLDINGS LLC	PO BOX 61 1154	MIAMI	FL	33261	USA
02-4203-291-1240	RAYMOND ADKINS & W	540 WEST AVE #2312	MIAMI BEACH	FL	33139	USA
02-4203-291-1250	PURASANGRE MIAMI LLC	1000 BRICKELL AVENUE 480	MIAMI	FL	33131	USA
02-4203-291-1260	SERGE LUBENSKY	52 92 ST 4A	BROOKLYN	NY	11209	USA
02-4203-291-1270	XOCHITL SERRANO	540 WEST AVE UNIT #313	MIAMI BEACH	FL	33139	USA
02-4203-291-1280	DAMASI LLC	650 WEST AVE # 2306	MIAMI BEACH	FL	33139	USA
02-4203-291-1290	MINIBAR BENTLEY LLC	1 SE 3 AVE 10 FL	MIAMI	FL	33131	USA
02-4203-291-1300	STEPHEN COHEN	1000 WEST AVE APT 1002	MIAMI BEACH	FL	33139-4724	USA

02-4203-291-1310	RUYA ALEPAPA LLC	1691 MICHIGAN AVE #320	MIAMI BEACH	FL	33139	USA
02-4203-291-1320	ARMAND MEYARA	520 West Ave Apt 1002	Miami Beach	FL	33139-5183	USA
02-4203-291-1330	MIAMI SUNSET REAL ESTATE	301 COSTANERA RD	CORAL GABLES	FL	33143	USA
02-4203-291-1340	LOFT1 LLC	1818 SW 1 AVE #1014	MIAMI	FL	33129	USA
02-4203-291-1350	SEDIF INVEST INC	100 N BISCAYNE BLVD #2904	MIAMI	FL	33132	USA
02-4203-291-1360	BRENT P MAHONEY	150 COUNTY ROAD #256	ABILENE	TX	79606	USA
02-4203-291-1370	100 DEGREES LLC	1401 N UNIVERSITY DR STE 301	CORAL GABLES	FL	33134	USA
02-4203-291-1380	AR BENTLEY INVESTMENT LLC	540 WEST AVE #1513	MIAMI BEACH	FL	33139	USA
02-4203-291-1390	SPERT INC	540 WEST AVE #1613	MIAMI	FL	33139-6768	USA
02-4203-291-1400	KAYA HASANOGLU	2125 1 AVE 2105	SEATTLE	WA	98121	USA
02-4203-291-1410	OCEAN DRIVE CLEVELANDER INC	1455 OCEAN DR #1502	MIAMI BEACH	FL	33139	USA
02-4203-291-1420	SOUTH REAL PROPERTIES LLC	488 MADISON AVE 17 FL	MANHATTAN	NY	10022	USA
02-4203-291-1430	A J ALCOVER II &	540 WEST AVE #2013	MIAMI BEACH	FL	33139-6771	USA
02-4203-291-1440	RICHARD LIEBERMAN	236 E 47 ST #18F	NEW YORK	NY	10017	USA
02-4203-291-1450	BENTLEY BAY 2213 LLC	1110 BRICKELL AVE 404	MIAMI	FL	33131	USA
02-4203-291-1460	CYRIL BATES TRS	540 WEST AVE UNIT 2313	MIAMI BEACH	FL	33139	USA
02-4203-291-1470	GINEVRA REAL ESTATE LLC	1410 20 ST 214	MIAMI BEACH	FL	33139	USA
02-4203-291-1480	CHRISTIAN HAUTIERE	540 WEST AVE # 314	MIAMI BEACH	FL	33139	USA
02-4203-291-1490	LEONEL CALDERON	540 WEST AVE 414	MIAMI BCH	FL	33139-6769	USA
02-4203-291-1500	LNB 002 13 LLC	1521 ALTON RD #812	MIAMI BEACH	FL	33139	USA
02-4203-291-1510	BENEDIKT LEX	540 WEST AVE 614	MIAMI BEACH	FL	33139	USA
02-4203-291-1520	AMFRAN ESTATES INC	415 GENDRON RD	PLAINFIELD	CT	06374	USA
02-4203-291-1530	KAMACO INVESTMENT LLC	785 CRANDON BLVD #201	KEY BISCAYNE	FL	33149	USA
02-4203-291-1540	KIMBERLY GERM CRAMER	300 NORTH END AVE #17E	NEW YORK	NY	10282	USA
02-4203-291-1550	BB 1014 LLC	220 FIFTH AVENUE STE #400	NEW YORK	NY	10001	USA
02-4203-291-1560	SVEGLIA LLC	540 WEST AVE #1114	MIAMI BEACH	FL	33139	USA
02-4203-291-1570	TIMOTHY P CARR	540 WEST AVE 1214	MIAMI BEACH	FL	33139-5162	USA
02-4203-291-1580	STA INTERNATIONAL LLC	540 WEST AVE #1414	MIAMI BEACH	FL	33139	USA
02-4203-291-1590	MARGERLY STEINBERG TRS	PO BOX 825	LENEX	MA	01240	USA
02-4203-291-1600	SANDRINE POLOSSON	540 WEST AVE #1614	MIAMI BEACH	FL	33139	USA
02-4203-291-1610	CHRISTINE BERARD FERRIER &H	540 WEST AVE #1714	MIAMI BCH	FL	33139-6771	USA
02-4203-291-1620	DAVID J DIROCCO &	14 VIRGINIA ST	BOSTON	MA	02125	USA
02-4203-291-1630	PAOLA FACCIOLI	3370 MARY ST	MIAMI	FL	33133	USA
02-4203-291-1640	AKSUT LLC	56 BERKELEY RD	SELMA	AL	36701	USA
02-4203-291-1650	BAY PROPERTY MB LLC	2386 PRAIRIE DUNES	CLERMONT	FL	34711	USA
02-4203-291-1670	SUNSET WEST AVE CORP	200 LIBERTY ST 27TH FLOOR	NEW YORK	NY	10281	USA
02-4203-291-1680	ALLAN BLANK	871 BUTTONWOOD DR	BOCA RATON	FL	33432-3003	USA
02-4204-006-0130	TIITF/DNR-DIV REC & PARKS	3900 COMMONWEALTH BLVD	TALLAHASSEE	FL	32399	USA
02-4204-006-0150	BENTLEY BAY RETAIL LLC	230 5TH STREET	MIAMI	FL	33139	USA
02-4204-014-0010	DAVID DEFORREST	1644 MCDUFF AVE S	JACKSONVILLE	FL	32205	USA
02-4204-014-0020	DAVID BOWER	4303 MEDALLION DR	SILVER SPRINGS	MD	20904	USA
02-4204-014-0030	LYNETTE LONG	650 W AVE #501	MIAMI BEACH	FL	33139	USA
02-4204-014-0040	AHMED K GORDAH	650 WEST AVE 601	MIAMI BEACH	FL	33139	USA
02-4204-014-0050	JOSHUA AINSLEY LAMPERT	650 WEST AVE #701	MIAMI BEACH	FL	33139	USA
02-4204-014-0060	FLORIDA POINT REAL EST INC	2920 SW 25 TERR	MIAMI	FL	33133-2112	USA
02-4204-014-0070	HENRIQUE S AUTRAN	650 WEST AVE 901	MIAMI BEACH	FL	33139	USA
02-4204-014-0090	DENIELLE DELUGA &H	650 WEST AVE #1101	MIAMI BEACH	FL	33139-5556	USA
02-4204-014-0100	MEHMET KAHVECI TRS	650 WEST AVE UNIT 1201	MIAMI BEACH	FL	33139	USA
02-4204-014-0110	ALLEN SILANEE	650 WEST AVE #1401	MIAMI BEACH	FL	33139	USA
02-4204-014-0120	DAVID SINE	935 4 ST	MIAMI BEACH	FL	33139-6825	USA
02-4204-014-0130	PIMLICO 1601 LLC	650 W AVE #1601	MIAMI BEACH	FL	33139	USA
02-4204-014-0140	K S R SOUTH BEACH FAMILY L P	18 EAST 48 ST 10 FLOOR	NEW YORK	NY	10017	USA
02-4204-014-0150	ANTHONY LEVEY &	25 ANDREA ROAD	HOLBROOK	NY	11741	USA
02-4204-014-0160	ANTHONY LAKAVAGE	1820 RANDOLPH ST NW	WASHINGTON	DC	20011-5340	USA
02-4204-014-0170	ADANTES LLC	2475 BRICKELL AVE 2305	MIAMI	FL	33129	USA
02-4204-014-0180	MIAMI UNIT 2101 INC	650 WEST AVE #2101	MIAMI BEACH	FL	33139	USA
02-4204-014-0190	BEATRICE I COX (CUSTODIAN FOR)	650 WEST AVE UNIT 2201	MIAMI BEACH	FL	33139	USA
02-4204-014-0200	BAY SHORE PROPERTIES LLC	1220 DA CLA MAR CT	CARBONDALE	IL	62901	USA
02-4204-014-0210	ALICIA G WARNER TRS &	310 ISLAND DR	KEY BISCAYNE	FL	33149-2414	USA
02-4204-014-0230	MARCELO DE PAZ	650 WEST AVE 2601	MIAMI BEACH	FL	33139	USA
02-4204-014-0240	JEFFREY STROUD JTRS	8193 SKELTON CIRCLE	FALLS CHURCH	VA	22042	USA
02-4204-014-0250	DANILO PRIMERANO	650 WEST AVE #2801	MIAMI BEACH	FL	33139-6371	USA

02-4204-014-0260	ELEVEN AND ONCE LLC	555 NE 34 ST 1107	MIAMI	FL	33137	USA
02-4204-014-0270	CONERO ENTERPRISE INC	150 SE 2 AVE STE 1010	MIAMI	FL	33131	USA
02-4204-014-0280	WEST AVE INVEST INC	650 WEST AVE #3101	MIAMI BEACH	FL	33139-6372	USA
02-4204-014-0290	RACHELGAB COMPANY LLC	650 WEST AVE # 302	MIAMI BEACH	FL	33139	USA
02-4204-014-0300	MICHAEL CLIPP	650 WEST AVE #402	MIAMI BEACH	FL	33139	USA
02-4204-014-0310	MARYAM AFSHAR	3523 EDMUNDS ST NW	WASHINGTON	DC	20007	USA
02-4204-014-0320	MICHAEL GUERRA	240 E 93 ST #11-B	NEW YORK	NY	10128	USA
02-4204-014-0330	VICTOR PINA	650 WEST AVE #702	MIAMI BEACH	FL	33139	USA
02-4204-014-0340	JORGE L GONZALEZ	650 WEST AVE #802	MIAMI BEACH	FL	33139-5545	USA
02-4204-014-0350	JOSELYN FAUCHER	650 WEST AVE UNIT 902	MIAMI BEACH	FL	33139	USA
02-4204-014-0360	IRVING SHECHTMAN	4401 COLLINS AVE 2-1412	MIAMI BEACH	FL	33140	USA
02-4204-014-0370	RONALD SANCETTA	650 WEST AVE #1102	MIAMI BEACH	FL	33139	USA
02-4204-014-0380	CARLOS ALBERTO DUQUE	650 WEST AVENUE UNIT 1202	MIAMI BEACH	FL	33139	USA
02-4204-014-0390	ARYEH NAKACHE	650 WEST AVE #1402	MIAMI BEACH	FL	33139	USA
02-4204-014-0400	NEDAN REAL ESTATE LLC	3370 MARY STREET	MIAMI	FL	33133	USA
02-4204-014-0410	MARCO FLAVIO SIMOES COELHO	650 WEST AVE #1602	MIAMI BECAH	FL	33139	USA
02-4204-014-0420	DENNIS CHRYSANTHOPOULOS	55 COOPER ST 5F	NEW YORK	NY	10034	USA
02-4204-014-0430	AMALIA LITOS	8004 NW 154 ST #331	HIALEAH	FL	33016	USA
02-4204-014-0440	W FREDERICK BURNSIDE	650 WEST AVE 1902	MIAMI	FL	33139	USA
02-4204-014-0450	JAY PAUL DERATANY	650 WEST AVE #2002	MIAMI BEACH	FL	33139-6367	USA
02-4204-014-0460	LINDA WEIKEL JTRS	650 WEST AVE #2102	MIAMI BEACH	FL	33139	USA
02-4204-014-0470	THEODOOR DAMEN	650 WEST AVE #2202	MIAMI	FL	33139	USA
02-4204-014-0480	ANDREW AKERMAN	650 WEST AVE #2302	MIAMI BEACH	FL	33139-6368	USA
02-4204-014-0490	ELIAS ARACTINGI	1090 KANE CONCOURSE STE 202	BAY HARBOR ISLANDS	FL	33154	USA
02-4204-014-0500	DAVID J STACK	4 ARNOLD TERRACE	BURLINGTON	MA	01803	USA
02-4204-014-0510	DBGS LLC	11900 BISCAYNE BLVD STE 508	MIAMI	FL	33131	USA
02-4204-014-0520	JOHN STANLEY LORD JR	650 WEST AVE #2702	MIAMI	FL	33139	USA
02-4204-014-0530	R MICHAEL DORSCH III	1330 W AVE #2408	MIAMI BEACH	FL	33139	USA
02-4204-014-0540	HUGO WARNANT &W MARIA R	650 WEST AVE #2902	MIAMI BEACH	FL	33139-6371	USA
02-4204-014-0550	ANTHONY HULL	170 CHAPIN RD	BERNARDSVILLE	NJ	07924	USA
02-4204-014-0560	ROBERT KATZ &W	7359 196TH ST	FRESH MEADOWS	NY	11366	USA
02-4204-014-0570	TIE LINES LLC	1441 BRICKELL AVE STE 1400	MIAMI	FL	33131	USA
02-4204-014-0580	JGP PROPERTIES MIAMI LLC	1150 SW 22 ST	MIAMI	FL	33129	USA
02-4204-014-0590	EDWARD W VUOLO	45 SEMINOLE DR	COMMACK	NY	11725	USA
02-4204-014-0600	OHAD JEHASSI	650 WEST AVE APT 3106	MIAMI BEACH	FL	33139-6372	USA
02-4204-014-0610	LUNA FAMILY HOLDINGS LLC	1521 ALTON RD	MIAMI BEACH	FL	33139	USA
02-4204-014-0620	FLORIDIAN 803 LLC	650 WEST AVE 803	MIAMI BEACH	FL	33139	USA
02-4204-014-0630	YONEL FELLOUS	650 WEST AVE #903	MIAMI BEACH	FL	33139	USA
02-4204-014-0640	RANDOLPH SEDA TRS	1900 PURDY AVE #2108	MIAMI BEACH	FL	33139-1458	USA
02-4204-014-0650	JOY PROPERTY LLC	407 LINCOLN RD #PH-NE	MIAMI BEACH	FL	33139	USA
02-4204-014-0660	TRAVEL CHARTER BUSINESS LTD	140 EAST 72 ST 9B	NEW YORK	NY	10021	USA
02-4204-014-0670	VOYAGE CORPORATE RLTY INC	74 ARDELL RD	BRONXVILLE	NY	10708	USA
02-4204-014-0680	ERIC MITCHELL	650 WEST AVE 1503	MIAMI BEACH	FL	33139	USA
02-4204-014-0690	ANTHONY LEVEY	25 ANDREA ROAD	HOLBROOK	NY	11741	USA
02-4204-014-0700	DANIEL SILBERMAN	650 WEST AVE 1703	MIAMI BEACH	FL	33139	USA
02-4204-014-0710	ANTHONY LEVEY	25 ANDREA RD	HOLBROOK	NY	11741	USA
02-4204-014-0720	SOPHIA TSANOS	650 WEST AVE #1903	MIAMI BEACH	FL	33139-6367	USA
02-4204-014-0730	MERSOLEIL LLC	90 ALTON RD UNIT 1906	MIAMI BEACH	FL	33139	USA
02-4204-014-0740	FRANCO RABITTI	650 WEST AVE #2103	MIAMI BEACH	FL	33139	USA
02-4204-014-0750	FEDERICA MAIO	650 WEST AVE UNIT 2203	MIAMI BEACH	FL	33139-5524	USA
02-4204-014-0760	MONOMIAMI LLC	90 ALTON ROAD #2506	MIAMI BEACH	FL	33139	USA
02-4204-014-0770	VICTOIRE MAILLEBIAU	11113 SW 148 PL	MIAMI BEACH	FL	33196	USA
02-4204-014-0780	KENNETH P SHRUM	650 WEST AVE 2503	MIAMI	FL	33139	USA
02-4204-014-0790	MARCEL BUEHLER	650 WEST AVE #2603	MIAMI BEACH	FL	33139	USA
02-4204-014-0800	SMVO CORP	650 WEST AVE # 2703	MIAMI	FL	33139	USA
02-4204-014-0810	ELIAS ARACTINGI	650 WEST AVE #2803	MIAMI BEACH	FL	33139	USA
02-4204-014-0820	GASIC FAMILY LP	3705 CHAMPION RIDGE IN	LONGVIEW	TX	75605	USA
02-4204-014-0830	MELWYN SALVADORE DSOUZA TRS	1516 PACAYA COVE	NAPLES	FL	34119	USA
02-4204-014-0840	FLORIDIAN INVEST LLC	927 LINCOLN RD # 200	MIAMI BEACH	FL	33139	USA
02-4204-014-0850	BEATRIZ BELLIO	650 WEST AVE #304	MIAMI	FL	33139	USA
02-4204-014-0860	NATALLIA KOSSMAN	650 WEST AVE #1001	MIAMI BEACH	FL	33139	USA
02-4204-014-0870	DANYA J PINCAVAGE	1800 PURDY AVE APT 1609	MIAMI BEACH	FL	33139	USA
02-4204-014-0880	WAI LING CHOW	650 WEST AVE #604	MIAMI BEACH	FL	33139-5545	USA
02-4204-014-0890	BRICKELL ON THE RIVER 508	848 BRICKELL AVE # 741	MIAMI	FL	33131	USA

02-4204-014-0900	PATUCHA CORP	650 WEST AVE #804	MIAMI BEACH	FL	33139-5545	USA
02-4204-014-0910	MARIELA STOCHETTI	155 OCEAN LANE DR 804	MIAMI BEACH	FL	33139-5524	USA
02-4204-014-0920	JOSE J VILLAR &W MILLI MEMBIELA	650 WEST AVE #1004	MIAMI BEACH	FL	33139-5556	USA
02-4204-014-0930	REINALDO KLEPACZ	650 WEST AVE UNIT 1104	MIAMI BEACH	FL	33139	USA
02-4204-014-0940	KRISTRUN WOHL	650 WEST AVE #1204	MIAMI BEACH	FL	33139-5598	USA
02-4204-014-0950	MEET ME IN MIAMI ABL LLC	95 RIVER ST #209	HOBOKEN	NJ	07030	USA
02-4204-014-0960	R SAUL MCCORMICK &W PAULA K	4 HORN POINT COURT	ANNAPOLIS	MD	21403	USA
02-4204-014-0970	LOVE AND PEACE F AND M INC	1410 20 ST 214	MIAMI GARDENS	FL	33139	USA
02-4204-014-0980	ALEXANDRA ABERGEL	650 WEST AVE UNIT 1704	MIAMI BEACH	FL	33139	USA
02-4204-014-0990	STEVE VINTON	650 W AVE # 1804	MIAMI BEACH	FL	33139	USA
02-4204-014-1000	ADAM KOTKIN	650 W AVE #1904	MIAMI BEACH	FL	33139	USA
02-4204-014-1010	DELRAYO LLC	72 MADISON AVD 6TH FLOOR	NEW YORK	NY	10016	USA
02-4204-014-1020	VIKRAM REAL ESTATE LLC	650 WEST AVE #2104	MIAMI BEACH	FL	33139	USA
02-4204-014-1030	JOSEPH HORSTMANN	55 MAIN ST	EAST HAMPTON	NY	11937	USA
02-4204-014-1040	DAVID KLEIN	650 WEST AVE 2304	MIAMI BEACH	FL	33139	USA
02-4204-014-1050	BERNARD ISTRIA JTRS	175 E 96 ST #7K	NEW YORK	NY	10128	USA
02-4204-014-1060	650 W 2405 LLC	12767 EQUESTRIAN TRAIL	DAVIE	FL	33330	USA
02-4204-014-1070	J & B REAL ESTATE HOLDINGS INC	752 MILFORD ROAD	EAST STROUDSBURG	PA	18301	USA
02-4204-014-1080	TED SNIDER	18081 BISVAYNE BLD #1701	AVENTURA	FL	33160	USA
02-4204-014-1090	CHICKEN 2310 LLC	5200 PINE TREE DR	MIAMI BEACH	FL	33140	USA
02-4204-014-1100	ELIZABETH SHIELDS	650 WEST AVE 2904	MIAMI BEACH	FL	33139	USA
02-4204-014-1110	HARVEY P KATZ	650 WEST AVE UNIT 3004	MIAMI BEACH	FL	33139	USA
02-4204-014-1120	ANTONIO ELLEK	650 WEST AVE #3104	MIAMI BEACH	FL	33139-6372	USA
02-4204-014-1130	BURCU TANDOGAN	650 WEST AVE 305	MIAMI BEACH	FL	33139	USA
02-4204-014-1140	SUPPER CLUB SOUTH BEACH LLC	2105 MERIDIAN AVE	MIAMI BEACH	FL	33139	USA
02-4204-014-1150	CARIOCA 79 LLC	14 E 33 ST 10S	NEW YORK	NY	10016	USA
02-4204-014-1160	HUBERTUS HANS FIEDLER	650 WEST AVE 605	MIAMI BEACH	FL	33139	USA
02-4204-014-1170	JOSE IGNACIO GARRI	650 WEST AVE #705	MIAMI BEACH	FL	33139-5545	USA
02-4204-014-1180	A TO Z REAL EST INVESTMENTS INC	650 WEST AVE #805	MIAMI BEACH	FL	33139-5545	USA
02-4204-014-1190	MARY J BREW	650 WEST AVE #905	MIAMI BEACH	FL	33139-5556	USA
02-4204-014-1200	SILVIA COMO	650 WEST AVE #1005	MIAMI BEACH	FL	33139-5556	USA
02-4204-014-1210	DAVID S E NOBLE	328 MOUNT MERINO RD	HUDSON	NY	12534	USA
02-4204-014-1220	TRAVEL CHARTER BUSINESS LTD	1111 LINCOLN RD STE 400	MIAMI BEACH	FL	33139	USA
02-4204-014-1230	BOULEDOGUE REALTY CORP	7777 NW 146 STREET	MIAMI LAKES	FL	33016	USA
02-4204-014-1240	ROBERTO MONTALBANO	650 WEST AVE 1505	MIAMI BEACH	FL	33139	USA
02-4204-014-1250	ZACHARY D ROOF	650 WEST AVE 1605	MIAMI BEACH	FL	33139	USA
02-4204-014-1260	DAVID E GELLER	650 WEST AVE #1705	MIAMI BEACH	FL	33139	USA
02-4204-014-1270	54D TEAM LLC	17707 NW MIAMI CT 101	MIAMI	FL	33169	USA
02-4204-014-1280	MICHELLE M RESSLER	650 WEST AVE #1905	MIAMI BEACH	FL	33139-6367	USA
02-4204-014-1290	FLORIDIAN INVEST LLC	927 LINCOLN RD STE 200	MIAMI BEACH	FL	33139	USA
02-4204-014-1300	MARTIN FELDMAN	101 W 79 ST #22C	NEW YORK	NY	10024	USA
02-4204-014-1310	RIGHT MOVE REAL ESTATE CO LLC	605 LINCOLN RD # 202	MIAMI BEACH	FL	33139	USA
02-4204-014-1320	PETER T BAZELI	425 CENTRAL PARK WEST #7-J	NEW YORK	NY	10025	USA
02-4204-014-1330	ASTRID COMTE DE SEDA TRS	1900 PURDY AVE #2108	MIAMI BEACH	FL	33139-1458	USA
02-4204-014-1340	MATTHEW SETH MCMILLAN	650 WEST AVE 2505	MIAMI BEACH	FL	33139	USA
02-4204-014-1350	GOLDEN OAK PROPERTIES LLC	650 WEST AVE UNIT 2605	MIAMI BEACH	FL	33139	USA
02-4204-014-1360	SONIA SEPE TRUSSARDI	650 WEST AVE #2705	MIAMI BEACH	FL	33139	USA
02-4204-014-1370	A ASHTON HOLDINGS LLC	650 WEST AVE #2805	MIAMI BEACH	FL	33139	USA
02-4204-014-1380	HARRI TENHU	650 WEST AVE # 2905	MIAMI BEACH	FL	33139	USA
02-4204-014-1410	FLORIDIAN 306 LLC	5201 BLUE LAGOON DR STE 100	MIAMI	FL	33126	USA
02-4204-014-1420	LIA JARDINI	650 WEST AVE 2907	MIAMI BEACH	FL	33139	USA
02-4204-014-1430	MARCIO DA ROCHA	650 WEST AVE #506	MIAMI BEACH	FL	33139	USA
02-4204-014-1440	ANA CAROLINA VELEZ	1155 BRICKELL BAY DR APT 2803	MIAMI	FL	33131-3241	USA
02-4204-014-1450	DORIS C JU & HELEN JU JTRS	650 WEST AVE #706	MIAMI BEACH	FL	33139-5545	USA
02-4204-014-1460	PAUL WIMBLETON &W	4 FOXMORE CT	MARLTON	NJ	08053	USA
02-4204-014-1470	SPIKE MANAGEMENT LLC	181 S FRANKLIN AVE # 4 FL	VALLEY STREAM	NY	11581	USA

02-4204-014-1480	JESSICA WANDA TROLLER	650 WEST AVE # 1006	MIAMI BEACH	FL	33139	USA
02-4204-014-1490	EUGENIO FERRANTE	650 WEST AVE #1106	MIAMI BEACH	FL	33139	USA
02-4204-014-1500	SALIH SAKA	650 WEST AVE #1206	MIAMI BEACH	FL	33139	USA
02-4204-014-1520	VADIM SKHLOVSKY &W NADYA	1538 GREEN ST	PHILADELPHIA	PA	19130	USA
02-4204-014-1530	INNA ROIZIN	301 E 79 ST #3F	NEW YORK	NY	10075	USA
02-4204-014-1540	ABITTAN 1706 LLC	650 W AVE #1706	MIAMI BEACH	FL	33139	USA
02-4204-014-1550	IUS INVESTMENTS LLC	7225 NW 1 CT	MIAMI	FL	33150	USA
02-4204-014-1560	SHIVSANKAR MISIR &W	5050 MABRY DR	NAPLES	FL	34112	USA
02-4204-014-1570	DANIELLE L DELUGA	650 WEST AVE #2006	MIAMI BEACH	FL	33139-6367	USA
02-4204-014-1580	STEFAN H LINGMERT	242 S 1 ST #4B	BROOKLYN	NY	11211	USA
02-4204-014-1590	WILLIAM THOMAS HOYT	650 WEST AVE 2206	MIAMI BEACH	FL	33139	USA
02-4204-014-1600	SILVANEI DO CARMO SILVEIRA BULL	68 SE 6 ST #3408	MIAMI	FL	33131	USA
02-4204-014-1610	EDWARD PELOSO	932 EAST MAIN ST 2ND FLOOR	BRIDGEPORT	CT	06608	USA
02-4204-014-1620	VIVASLAVA LLC	1680 MICHIGAN AVE 910	MIAMI BEACH	FL	33139	USA
02-4204-014-1630	ZY2606 LLC	650 WEST AVE #1706	MIAMI BEACH	FL	33139	USA
02-4204-014-1640	DOUGLAS WALLACE CAMPOS	650 W AVE #2706	MIAMI BEACH	FL	33139-6370	USA
02-4204-014-1650	FLORIDIAN 2806 LLC	601 NE 36 ST #2701	MIAMI	FL	33137	USA
02-4204-014-1660	IUS INVESTMENTS LLC	7225 NW 1 CT	MIAMI	FL	33150	USA
02-4204-014-1670	STEFANIA A NGELA BERTOGLIO	650 W AVE # 3006	MIAMI BEACH	FL	33139	USA
02-4204-014-1680	OHAD JEHASSI TRS	650 WEST AVE 3106	MIAMI BEACH	FL	33139	USA
02-4204-014-1690	KERRY MCHUGH TRS	650 WEST AVE #307	MIAMI BEACH	FL	33139	USA
02-4204-014-1700	MARIE E MORAN	650 WEST AVE #407	MIAMI BEACH	FL	33139-5528	USA
02-4204-014-1710	JULIO QUINTERO	650 WEST AVE UNIT 507	MIAMI BEACH	FL	33139-5528	USA
02-4204-014-1730	REFIK CEVIK	650 WEST AVE #707	MIAMI BEACH	FL	33139-5545	USA
02-4204-014-1740	TAPD FLORIDA CORPORATION	1110 BRICKELL AVE STE 310	MIAMI	FL	33131	USA
02-4204-014-1750	JOAQUIN ALVAREZ MENENDEZ	650 WEST AVE #907	MIAMI BEACH	FL	33139	USA
02-4204-014-1760	VINMAX 25 LLC	407 LINCOLN RD # 9D	MIAMI BEACH	FL	33139	USA
02-4204-014-1770	HORMUZ IRANI &W RHODA	1905 HAGGIN OAKS BLVD	BAKERFIELD	CA	93311	USA
02-4204-014-1780	CARLOS RAMON RAMIREZ	650 WEST AVE 1207	MIAMI	FL	33139	USA
02-4204-014-1790	MOACIR SCHNAPP	5895 GARDEN REACH COVE	MEMPHIS	TN	38120	USA
02-4204-014-1800	FRED SCHAKEL	650 WEST AVE # 1507	MIAMI BEACH	FL	33139	USA
02-4204-014-1810	MARILYN NICHOLS KANE	330 E 38 ST # 16N	NEW YORK	NY	10016	USA
02-4204-014-1820	WILLIAM A DARPINI	650 W AVE #1707	MIAMI BEACH	FL	33139	USA
02-4204-014-1830	650 WEST AVE 1807 LLC	650 WEST AVE #1807	MIAMI BEACH	FL	33139	USA
02-4204-014-1840	MOACIR SCHNAPP	5895 GARDEN REACH COVE	MEMPHIS	TN	38120	USA
02-4204-014-1850	GLORIA MARCELA REYES	650 WEST AVE #2007	MIAMI BEACH	FL	33139	USA
02-4204-014-1860	FLORIDIAN INVEST LLC	927 LICOLN RD #200	MIAMI BEACH	FL	33139	USA
02-4204-014-1870	PATRICK MCLAUGHLIN	650 WEST AVE #1711	MIAMI BEACH	FL	33139-6364	USA
02-4204-014-1880	HANDAN RIZVANOGLU	650 WEST AVE 2307	MIAMI BEACH	FL	33139	USA
02-4204-014-1890	JOHN T HILDERBRANDT	650 WEST AVE UNIT #2407	MIAMI BEACH	FL	33139	USA
02-4204-014-1900	MATTHEW S MCMILLAN &W	650 WEST AVE #2507	MIAMI BEACH	FL	33139-6369	USA
02-4204-014-1910	SEAN D LAVIN	650 WEST AVE UNIT #2607	MIAMI BEACH	FL	33139	USA
02-4204-014-1920	NORM SCHECTER TRS	650 WEST AVENUE #2707	MIAMI BEACH	FL	33139	USA
02-4204-014-1930	ANTHONY ARRIGHI	650 WEST AVE 2807	MIAMI BEACH	FL	33139	USA
02-4204-014-1940	LIA JARDINI	650 WEST AVE 2907	MIAMI BEACH	FL	33139	USA
02-4204-014-1950	FLORIDIAN 3007 INVEST LLC	650 WEST AVE 3007	MIAMI BEACH	FL	33139	USA
02-4204-014-1960	GGC ASSOC L C	6600 W BROAD ST	RICHMOND	VA	23226	USA
02-4204-014-1970	ELIZABETH SHIELDS	650 W AVE #308	MIAMI BEACH	FL	33139	USA
02-4204-014-1980	ROGER V JUDGE	22 SUMMIT DR PO BOX 190	FAIRHAVEN	MA	02719	USA
02-4204-014-1990	STARTEGIC GLOBAL INVEST GRP LLC	1680 MERIDIAN AVE 101	MIAMI BEACH	FL	33139	USA
02-4204-014-2000	SHBM LLC	333 NE 24TH ST STE 309	MIAMI	FL	33137-4861	USA
02-4204-014-2010	CRISTIAN KUTSCHERAUER &W	650 WEST AVE 808	MIAMI BEACH	FL	33139-5545	USA
02-4204-014-2020	ANGEL O FERNANDEZ	650 WEST AVE UNIT 908	MIAMI BEACH	FL	33139	USA
02-4204-014-2030	RENATA ROJEK DUCHANE	650 WEST AVE 1008	MIAMI BEACH	FL	33139	USA
02-4204-014-2040	LNB 003-13 LLC	1521 ALTON RD #812	MIAMI BEACH	FL	33139	USA
02-4204-014-2050	ANDREW MOSSBERG	650 WEST AVE UNIT 1208	MIAMI BEACH	FL	33139	USA
02-4204-014-2060	DAN MAZA	650 WEST AVE 1408	MIAMI BEACH	FL	33139-6331	USA
02-4204-014-2070	ISAIAH ORLEN	650 WEST AVE 1508	MIAMI BEACH	FL	33139	USA
02-4204-014-2080	SUSAN GARCIA	650 WEST AVE #1608	MIAMI BEACH	FL	33139-6331	USA
02-4204-014-2090	RINA J AKOLAWALA TRS	2449 THE STRAND	NORTHBROOK	IL	60062	USA
02-4204-014-2100	LARRY S PERLMAN	650 WEST AVE #1808	MIAMI BEACH	FL	33139	USA
02-4204-014-2110	DAREN CHRISTOPHER MARHULA	650 WEST AVE 1908	MIAMI BEACH	FL	33139	USA

02-4204-014-2120	TATIANA LITVIAKOVA	650 WEST AVE UNIT 2008	MIAMI BEACH	FL	33139	USA
02-4204-014-2130	PAULO T MOLEDO	650 WEST AVE #2108	MIAMI BEACH	FL	33139	USA
02-4204-014-2140	JAMES GIORDANO	650 WEST AVE #2208	MIAMI BEACH	FL	33139	USA
02-4204-014-2150	BRADLEY S LAKE TRS	2626 N LAKEVIEW AVE #2612	CHICAGO	IL	60614	USA
02-4204-014-2160	UV ASSETS LLC	1125 NE 125 ST #101	NORTH MIAMI	FL	33161	USA
02-4204-014-2170	MARTIN FELDMAN	650 WEST AVE #2508	MIAMI BEACH	FL	33139	USA
02-4204-014-2180	OLIVIER AMIEL	650 WEST AVE #2608	MIAMI BEACH	FL	33139	USA
02-4204-014-2190	PATRICIA HENNING	650 WEST AVE #2708	MIAMI	FL	33132	USA
02-4204-014-2200	JONATHAN PONSARD	4530 NE 6 AVE	OAKLAND PARK	FL	33334	USA
02-4204-014-2210	SUNSTONE GROUP LLC	650 WEST AVE APT 2703	MIAMI BEACH	FL	33139	USA
02-4204-014-2220	NELLY VAYNER & PETER TONG	650 WEST AVE #3008	MIAMI BEACH	FL	33139-6372	USA
02-4204-014-2230	MICHAEL FABBIANI TRS	1102 RUSH COURT	CELEBRATION	FL	34747	USA
02-4204-014-2240	IMMOBILIARE INVESTMENTS LLC	350 S OCEAN BLVD #2C	BOCA RATON	FL	33432	USA
02-4204-014-2250	BUNKER INVEST GRP INC	650 WEST AVE #809	MIAMI BEACH	FL	33139-5545	USA
02-4204-014-2260	BENJAMIN LERMAN	650 WEST AVE #909	MIAMI BEACH	FL	33139	USA
02-4204-014-2270	ERIC MATHIEU	650 WEST AVE #1009	MIAMI BEACH	FL	33139-5556	USA
02-4204-014-2280	MARY EVANS SELLA TRS	3038 O STREET NW	WASHINGTON	DC	20007	USA
02-4204-014-2290	PQR MIAMI LLC	1680 MICHIGAN AVE STE 910	MIAMI BEACH	FL	33139	USA
02-4204-014-2300	M HATEM ZAYED MOUSTAFA	650 WEST AVE #1409	MIAMI BEACH	FL	33139-6331	USA
02-4204-014-2310	MARCO FERRARI	650 WEST AVE 1509	MIAMI	FL	33139	USA
02-4204-014-2320	MERSOLEIL LLC	10796 PINES BLVD #204	HOLLYWOOD	FL	33026	USA
02-4204-014-2330	DAVID DE FORREST	1644 MCDUFF AVE S	JACKSONVILLE	FL	32205	USA
02-4204-014-2340	KIREN MITRUKA & H NADER FATEH	650 WEST AVE #1809	MIAMI BEACH	FL	33139-6364	USA
02-4204-014-2350	JEAN MARC MORANDINI	650 W AVE #1909	MIAMI BEACH	FL	33139	USA
02-4204-014-2360	4 BALLS WALK LLC	6843 MAIN STREET #302	MIAMI LAKES	FL	33014	USA
02-4204-014-2370	JAVIER A GRANADA	650 WEST AVE #2109	MIAMI BEACH	FL	33139	USA
02-4204-014-2380	CARLOS DE VRIES	177 OCEAN LANE DR APT 514	KEY BISCAYNE	FL	33149	USA
02-4204-014-2390	GD FLORIDA PROPERTY INC	8700 W FLAGLER ST STE 170	MIAMI	FL	33174	USA
02-4204-014-2410	MAGO LLC	650 W AVE #2509	MIAMI BEACH	FL	33139	USA
02-4204-014-2420	UMANG PURI TR	248 EAST 31 ST APT 3A	NEW YORK	NY	10016	USA
02-4204-014-2430	SONIA SEPE TRUSSARDI	650 WEST AVE #2709	MIAMI BEACH	FL	33139	USA
02-4204-014-2450	CARL R LAMANNA	407 CHANNEL DR	POINT PLEASANT BEACH	NJ	08742	USA
02-4204-014-2460	MATTHEW CHANG	650 WEST AVE 2004	MIAMI BEACH	FL	33139	USA
02-4204-014-2470	JEFFREY KASS	650 WEST AVE #3109	MIAMI BEACH	FL	33139-6372	USA
02-4204-014-2480	NATALIA KOSSMAN	650 WEST AVE #710	MIAMI BEACH	FL	33139	USA
02-4204-014-2490	CRISTIAN ROBERT ANTUNEZ ASAFF	650 WEST AVE 810	MIAMI BEACH	FL	33139	USA
02-4204-014-2500	PETER A KENT	5 ROBERT RD	STOW	MA	01775-3314	USA
02-4204-014-2510	HARRIS KUPPERMAN	330 Mangrove Thicket Blvd	Ponte Vedra	FL	32081-0740	USA
02-4204-014-2520	BRUCE ALTMAN	300 SOUTH POINTE DR # 1103	MIAMI BEACH	FL	33139	USA
02-4204-014-2530	REGINA KATIA FRANCA LIMA	650 W AVE 1210	MIAMI BEACH	FL	33139	USA
02-4204-014-2540	SOPHIE SOLANGE LEFEBVRE	650 WEST AVE #1410	MIAMI BEACH	FL	33139	USA
02-4204-014-2550	SCOTT SHAFER	924 W CASTLEWOOD TER	CHICAGO	IL	60640	USA
02-4204-014-2560	MITCHELL MACHTAY	25261 MARGOT CT	BEACHWOOD	OH	44122	USA
02-4204-014-2570	ANGEL VELAZQUEZ MARIN	650 WEST AVE #1710	MIAMI BEACH	FL	33139-6364	USA
02-4204-014-2580	BETTY GERLAND LE	650 WEST AVE #1810	MIAMI BEACH	FL	33139	USA
02-4204-014-2590	1910 TRUST LLC	50 WEST 87 STREET APT 1	NEW YORK	NY	10024	USA
02-4204-014-2600	CM1 INVESTMENTS INC	1521 ALTON RD #642	MIAMI BEACH	FL	33139	USA
02-4204-014-2610	AC INVESTMENT I LLC	300 ALTON RD #100	MIAMI BEACH	FL	33139	USA
02-4204-014-2620	MARTINE ABERGEL	650 WEST AVE #2210	MIAMI BEACH	FL	33139-6368	USA
02-4204-014-2630	CHICKEN 2310 LLC	5200 PINE TREE DR	MIAMI BEACH	FL	33140	USA
02-4204-014-2640	FLORIDIAN STATE LLC	3380 W 91 TERR	HIALEAH	FL	33018	USA
02-4204-014-2650	GONZALO F YANEZ LE	7635 SW 88 CT	MIAMI	FL	33173	USA
02-4204-014-2660	MICHELE CHIARAMONDIA	650 W AVE #2610	MIAMI BEACH	FL	33139	USA
02-4204-014-2670	GREEN ISLAND PROPERTIES INC	150 SE 2 AVE #1010	MIAMI	FL	33131	USA
02-4204-014-2680	RODRIGO ALDAY DELGADILLO	650 WEST AVE UNIT 2810	MIAMI BEACH	FL	33139	USA
02-4204-014-2690	DAWNETTE ANN MARIE LEWIS	650 WEST AVE 2910	MIAMI BEACH	FL	33139	USA
02-4204-014-2710	ITACORUBI LLC	650 WEST AVE 3110	MIAMI BEACH	FL	33139	USA
02-4204-014-2720	SIMON PAVITT	650 WEST AVE #711	MIAMI BEACH	FL	33139	USA
02-4204-014-2730	RUSS SOPER	96 GARFIELD PL	BROOKLYN	NY	11215	USA
02-4204-014-2740	JOHN TALIERCIO	650 WEST AVE #911	MIAMI BEACH	FL	33139	USA
02-4204-014-2750	MICHAEL W MOCOSKI	650 WEST AVE #1011	MIAMI BEACH	FL	33139	USA
02-4204-014-2760	LIA JARDINI	650 WEST AVE 2907	MIAMI BEACH	FL	33139	USA
02-4204-014-2770	JAMES TERRY	650 WEST AVE 1211	MIAMI BEACH	FL	33139	USA
02-4204-014-2780	STEVEN FETNER	12 VAN HOUTEN ST	UPPER NYACK	NY	10960	USA

02-4204-014-2800	SERGIO GUTIERREZ	2155 NW 23 AVE	MIAMI	FL	33142	USA
02-4204-014-2810	PATRICK MCLAUGHLIN	650 WEST AVE #1711	MIAMI BEACH	FL	33139-6364	USA
02-4204-014-2820	ANDREW MARTIN	650 WEST AVE #1811	MIAMI BEACH	FL	33139-6364	USA
02-4204-014-2830	STEVE WILLIAMS	650 WEST AVE 1911	MIAMI BEACH	FL	33139	USA
02-4204-014-2840	MVU FLORIDA PROPERTY LLC	500 FIFTH AVE #1610	NEW YORK	NY	10110	USA
02-4204-014-2850	CHRISTOS PHILIPPOU	650 WEST AVE 2111	MIAMI BEACH	FL	33139	USA
02-4204-014-2860	CALULU FLORIDIAN LLC	1313 PONCE DE LEON BLVD #301	CORAL GABLES	FL	33134	USA
02-4204-014-2870	CARLOS ERNESTO CAO	650 WEST AVE UNIT 2311	MIAMI BEACH	FL	33139	USA
02-4204-014-2880	BARBARA A BAIN	PO BOX 170851	HIALEAH	FL	33017-0851	USA
02-4204-014-2890	SOUTHBEMI INVESTMENTS LLC	400 CLATON RD	SCARSDALE	NY	10583	USA
02-4204-014-2900	ANTONY E MILSOM &W CAROL L	650 WEST AVE #2611	MIAMI BEACH	FL	33139-6370	USA
02-4204-014-2910	ERIKA BOEHM	650 WEST AVE #2711	MIAMI BEACH	FL	33139-6370	USA
02-4204-014-2920	CLEARVIEW PROSPECTS LLC	11900 BISCAYNE BLVD #508	MIAMI	FL	33181	USA
02-4204-014-2930	MOACIR SCHNAPP	5895 GARDEN REACH COVE	MENPHIS	TN	38120	USA
02-4204-014-2940	RICHARD LINDHOLM	376 S COCONUT PALM BLVD	TAVERNIER	FL	33070	USA
02-4204-014-2950	KENT W OVERHOLT	11110 STUART MILL RD	OAKTON	VA	22124	USA
02-4204-014-2960	CONRAD J MACON	650 W AVE #712	MIAMI BEACH	FL	33139	USA
02-4204-014-2970	UMANG K PURI	650 WEST AVE 2609	MIAMI BEACH	FL	33139-5524	USA
02-4204-014-2980	BRYAN M BLOOM	650 WEST AVE #912	MIAMI BEACH	FL	33139	USA
02-4204-014-2990	FRANCISCO J LEON	6311 RIVIERA DR	CORAL GABLES	FL	33146	USA
02-4204-014-3000	LONG SEA REAL ESTATE LLC	1680 MICHIGAN AVE #700	MIAMI BEACH	FL	33139	USA
02-4204-014-3010	SABRIANE BRANDAO TRS	650 WEST AVE UNIT 1212	MIAMI BEACH	FL	33139	USA
02-4204-014-3020	JODI BABBITZ	650 WEST AVE #1412	MIAMI BEACH	FL	33139-6331	USA
02-4204-014-3030	DARREL W BURKS	650 WEST AVE #1512	MIAMI BEACH	FL	33139-6331	USA
02-4204-014-3040	KEVIN F HARGADON	270 W 17TH ST APT 4L	NEW YORK	NY	10011-5355	USA
02-4204-014-3050	MARK HENKIN	650 WEST AVE 1712	MIAMI BEACH	FL	33139	USA
02-4204-014-3060	SOUTHBEMI INVESTMENTS LLC	400 CLATON RD	SCARDALE	NY	10583	USA
02-4204-014-3070	MICHAEL CHARRIER	PO BOX 286	SOUTHAMPTON	NY	11969	USA
02-4204-014-3080	NADINE DIEUVIL &H JOSEPH	1175 MANOR CT	WESTON	FL	33326	USA
02-4204-014-3090	MOACIR SCHNAPP	5895 GARDEN REACH COVE	MEMPHIS	TN	38120	USA
02-4204-014-3100	ALAN BIRNKRANT	8104 HAMPDEN LANE	BETHESDA	MD	20814	USA
02-4204-014-3110	JOEL CUCCIO	367 LONG BOW DR	FRANKLIN LAKES	NJ	07417-2124	USA
02-4204-014-3120	NADIA PRANDELLI	650 WEST AVE 2412	MIAMI BEACH	FL	33139	USA
02-4204-014-3130	SERGIO TINTORI	650 WEST AVE # 2512	MIAMI BEACH	FL	33139	USA
02-4204-014-3140	DENEKULA LLC	650 WEST AVE #2612	MIAMI BEACH	FL	33139	USA
02-4204-014-3150	TED SNIDER	650 WEST AVE #2712	MIAMI BEACH	FL	33139-6370	USA
02-4204-014-3160	IMMOBILIARE INVESTMENTS LLC	350 S OCEAN BLVD 2 C	BOCA RATON	FL	33432	USA
02-4204-014-3170	MOACIR SCHNAPP	5895 GARDEN REACH COVE	MEMPHIS	TN	38120	USA
02-4204-014-3180	DENEKULA LLC	650 WEST AVE 2612	MIAMI BEACH	FL	33139	USA
02-4204-014-3190	MARCUS LOVENFORST	1717 NORTH BAYSHORE DRIVE #1848	MIAMI	FL	33132	USA
02-4204-014-3200	FLORIDIAN PH01 LLC	1680 MICHIGAN AVE 910	MIAMI BEACH	FL	33139	USA
02-4204-014-3210	BRETT BENZA	650 WEST AVE #PH02	MIAMI BEACH	FL	33139-5524	USA
02-4204-014-3220	MARK MCGOVERN	650 WEST AVE PH3	MIAMI BCH	FL	33139-6372	USA
02-4204-014-3230	DALE R SMITH &W	448 LAFAYETTE AVE	EXCELSIOR	MN	55331	USA
02-4204-014-3240	MICHAEL E KAVOUKJIAN	650 WEST AVE #PH05	MIAMI BEACH	FL	33139-5524	USA
02-4204-014-3250	ALAN B WOLPERT	15 LAKEVILLE DR	EAST HILLS	NY	11576	USA
02-4204-014-3260	GGC ASSOC LC	6600 W BROAD ST	RICHMOND	VA	23226	USA
02-4204-014-3270	BRIAN M ERCOLE	650 WEST AVE PH 8	MIAMI BEACH	FL	33139-6373	USA
02-4204-014-3280	REBOND LLC	700 E DANIA BEACH STE 202	DANIA	FL	33004	USA
02-4204-014-3290	CHRISTOPHER MELTON	118 MONTROSE LN	WATERMILL	NY	11976	USA
02-4204-014-3300	GGC ASSOC LC	6600 W BROAD ST	RICHMOND	VA	23226	USA
02-4204-014-3310	CHRIS A COOPER	650 WEST AVE PH12	MIAMI	FL	33139	USA
02-4204-014-3320	CRL PARTICIPATION CORP	650 WEST AVE #PH-14	MIAMI BEACH	FL	33139	USA
02-4204-014-3330	GGC ASSOC LC	6600 W BROAD ST STE 100	RICHMOND	VA	23230	USA
02-4204-014-3340	TIMOTHY E MARTORELLA &W	650 WEST AVENUE UNIT PH-16	MIAMI BEACH	FL	33139-5524	USA
02-4204-014-3350	JEFFREY CRAIG RUBENSTEIN	650 WEST AVE #PH17	MIAMI BEACH	FL	33139-5524	USA

Item # 9—Architectural Plans and Exhibits

9a: Cover Sheet with bullet point scope of work, clearly labeled "First Submittal" and dated with First Submittal deadline date.

9d: Location Plan, Min 4"x6" Color Aerial 1/2 mile radius, showing name of streets and project site identified.

9h: Site Plan (fully dimensioned with setbacks, existing and proposed, including adjacent right-of-way widths).

9i: Current color photographs, dated, Min 4"x 6" of project site and existing structures (no Google images)


9n: Specifications of pole and equipment

9o: Proposed elevations , materials, and finishes noted

SITE ID-CANDIDATE LETTER/CASCADE ID-CANDIDATE LETTER:
9FLB003915F/MI90XSL78F

LATITUDE/LONGITUDE:
25.776647/-80.141927

 CROSS STREET:
WEST AVE & W 6TH ST
CITY, STATE, ZIP:
MIAMI BEACH, FL 33139



THE UTILITIES SHOWN HEREIN ARE FOR THE CONTRACTORS CONVENIENCE ONLY. THERE MAY BE OTHER UTILITIES NOT SHOWN ON THESE PLANS. THE ENGINEER/SURVEYOR ASSUMES NO RESPONSIBILITY FOR THE LOCATIONS SHOWN AND IT SHALL BE THE CONTRACTORS RESPONSIBILITY TO VERIFY ALL UTILITIES WITHIN THE LIMITS OF THE WORK. ALL DAMAGE MADE TO THE UTILITIES BY THE CONTRACTOR SHALL BE THE SOLE RESPONSIBILITY OF THE CONTRACTOR.

NOTE:
GENERAL CONTRACTOR IS REQUIRED TO CROSS CHECK COORDINATES, EXHIBIT PHOTO, AERIAL PHOTO AND SITE PLAN TO INSURE PROPER POLE LOCATION PRIOR TO BREAKING GROUND. CONCERNS OR QUESTIONS SHOULD BE IMMEDIATELY DIRECTED TO ASSIGNED MOBILITE CM.

GENERAL NOTES

THE FACILITY IS UNMANNED AND NOT FOR HUMAN HABITATION. A TECHNICIAN WILL VISIT THE SITE AS REQUIRED FOR ROUTINE MAINTENANCE. THE PROJECT WILL NOT RESULT IN ANY SIGNIFICANT DISTURBANCE OF EFFECT ON DRAINAGE, NO SANITARY SEWER SERVICE, POTABLE WATER OR TRASH DISPOSAL IS REQUIRED AND NO COMMERCIAL SIGNAGE IS (N).

SITE INFORMATION

SITE ID: 9FLB003915F
CASCADE ID: MI90XSL78F
LATITUDE: 25.776647
LONGITUDE: -80.141927
CROSS STREET: WEST AVE & W 6TH ST
CITY, STATE, ZIP: MIAMI BEACH, FL 33139
COUNTY: MIAMI-DADE COUNTY
JURISDICTION: MIAMI BEACH CITY
PROPERTY OWNER: PUBLIC RIGHT-OF-WAY
APPLICANT: MOBILITE, LLC
3475 PIEDMONT ROAD NE, SUITE 1000
ATLANTA, GEORGIA 30305
PHONE: (312) 638-5400

ENGINEER

KMB DESIGN GROUP, LLC
1800 ROUTE 34, SUITE 209
WALL, NJ 07719
FOR QUESTIONS EMAIL: DESIGTEAM@KMBDG.COM
TEL: (732) 280-5623 FAX: (732) 280-3980 www.KMBDG.com

DO NOT SCALE DRAWINGS


CONTRACTORS SHALL VERIFY ALL PLANS, (E) DIMENSIONS & FIELD CONDITIONS ON THE JOB SITE & SHALL IMMEDIATELY NOTIFY THE ARCHITECT/ENGINEER IN WRITING OF ANY DISCREPANCIES BEFORE PROCEEDING WITH THE WORK OR BE RESPONSIBLE FOR SAME.

LOCATION MAPS

VICINITY MAP



REGIONAL MAP

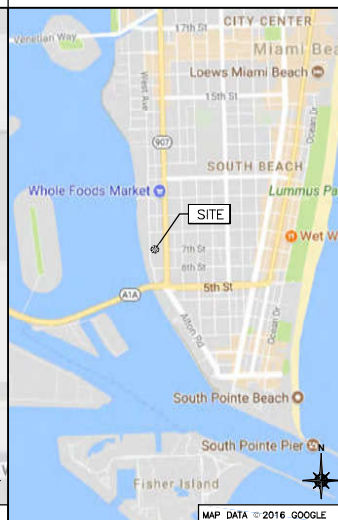

PROJECT DESCRIPTION

END USER PROPOSES TO REPLACE EXISTING STEEL POLE AND INSTALL EQUIPMENT ON A NEW STEEL POLE WITHIN AN EXISTING RIGHT-OF-WAY.
THE SCOPE WILL CONSIST OF THE FOLLOWING:
- REMOVE EXISTING STEEL LIGHT POLE
- INSTALL A NEW GALVANIZED STEEL STEALTH LIGHT POLE WITH PROPOSED BACKHAUL TRANSPORT EQUIPMENT

CODES

2017 FLORIDA BUILDING CODE, 6TH EDITION
NATIONAL ELECTRICAL SAFETY CODE
TIA/ISA-222-G-2 OR LATEST EDITION
LOCAL BUILDING/PLANNING CODE

DRAWING INDEX

SHEET NO:	SHEET TITLE
T-1	TITLE SHEET
SP-1	EXHIBIT PHOTO & SITE PLAN
SP-2	UTILITY SITE PLAN
SP-3	ENLARGED SITE PLAN
EV-1	ELEVATIONS
EV-2	ELEVATIONS
PL-1	PLUMBING & RISER DIAGRAM
EQ-1	EQUIPMENT DETAILS
EQ-2	EQUIPMENT DETAILS
E-1	ELECTRICAL DETAILS
G-1	GROUNDING DETAILS
S-1	FOUNDATION DETAILS
TC-1	VEHICULAR TRAFFIC CONTROL PLAN
TC-2	PEDESTRIAN TRAFFIC CONTROL PLAN
GN-1	GENERAL NOTES
GN-2	GENERAL NOTES
GN-3	GENERAL NOTES
ATTACHED	SITE SURVEY

mobilitie

FINAL SUBMITTAL
3-2-2018

FIRST SUBMITTAL
2-12-2018

PROJECT NO: 9FLB003915F
DRAWN BY: RC
CHECKED BY: SJB

REVISION
D 01-09-18
C 11-28-17
B 10-17-17
A 09-03-17 FOR CLIENT REVIEW

KMB DESIGN GROUP, LLC
Stephen A. Bray
PROFESSIONAL ENGINEER
LICENSE
No. 68902
STATE OF FLORIDA
PROFESSIONAL ENGINEER
FL LICENSE 19/18
IT IS A VIOLATION OF THE LAW FOR ANY PERSON, UNLESS THEY ARE ACTING UNDER THE DIRECTION OF A LICENSED PROFESSIONAL ENGINEER, TO ALTER THIS DOCUMENT

MI90XSL78F
MIAMI BEACH, FL 33139 '24'-6"
STEEL POLE

SHEET TITLE
TITLE SHEET

SHEET NUMBER
T-1


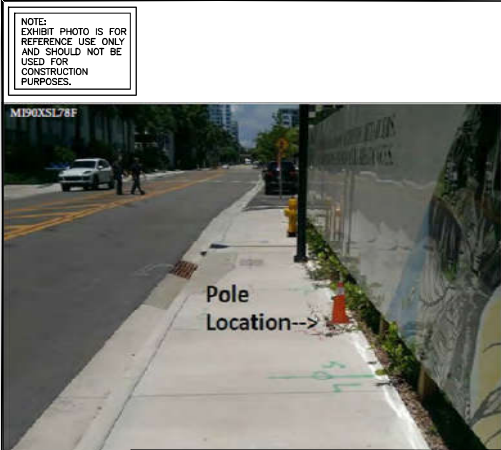


EXHIBIT PHOTO

SCALE: NOT TO SCALE


1

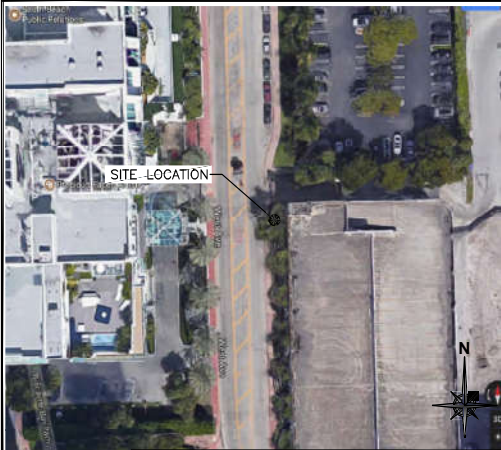

AERIAL SITE LOCATION

SCALE: NOT TO SCALE

2

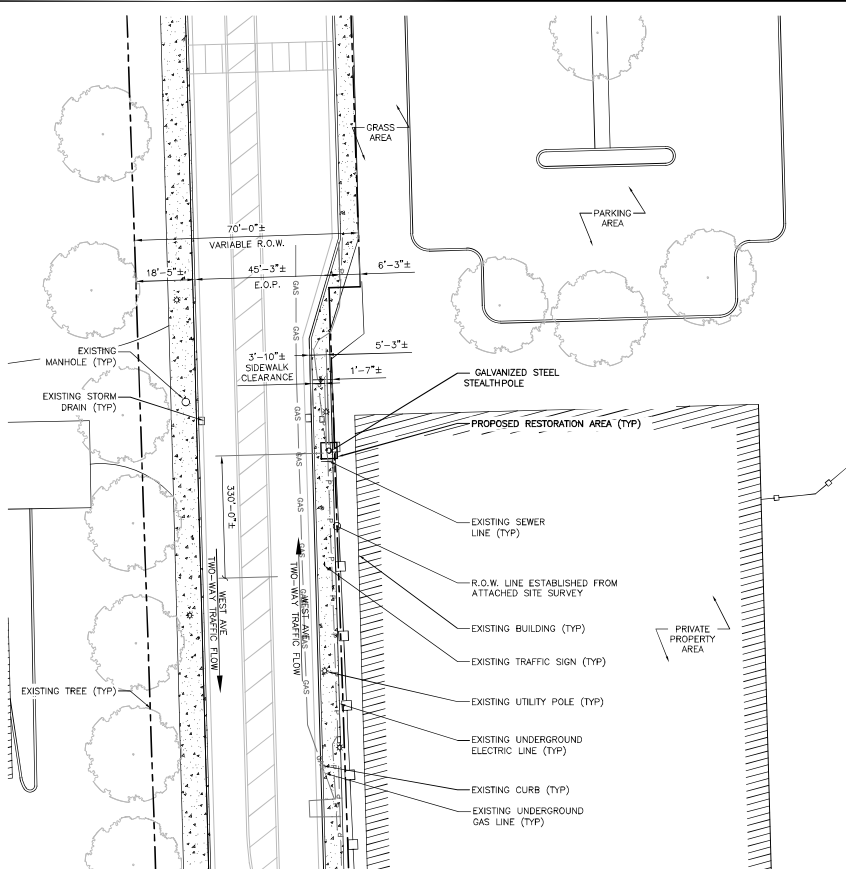

NOTE:
1. ALL DAMAGED AREAS SHALL BE RESTORED TO EQUAL OR BETTER CONDITION.
2. ALL ITEMS AND DIMENSIONS SHOULD BE VERIFIED IN THE FIELD.
3. GENERAL CONTRACTORS ARE REQUIRED TO CROSS CHECK COORDINATES, AERIAL PHOTO AND SITE PLAN TO ENSURE PROPER POLE LOCATION PRIOR TO BREAKING GROUND. CONCERNS OR QUESTIONS SHOULD BE IMMEDIATELY DIRECTED TO THE ASSIGNED MOBILITIE CM.



SITE PLAN

SCALE: 1" = 30'-0" (1" = 15'-0" ON 24"x36" SHEET)

3

mobilitie

PROJECT NO: 9FLB00315F
DRAWN BY: RC
CHECKED BY: SJB

REVISION	DATE	BY	FOR
D	01-09-18		REVISION
C	11-28-17		REVISION
B	10-17-17		REVISION
A	09-03-17		FOR CLIENT REVIEW

KMB DESIGN GROUP, LLC
Stephen A. Bray
PROFESSIONAL ENGINEER
FLORIDA
LICENSE
No. 68902
1/9/18
FL LICENSE 16062
IT IS A VIOLATION OF THE LAW FOR ANY PERSON, UNLESS THEY ARE ACTING UNDER THE DIRECTION OF A LICENSED PROFESSIONAL ENGINEER, TO ALTER THIS DOCUMENT

M190XSL78F
MIAMI BEACH, FL 33139 ' 24'-6"
STEEL POLE

SHEET TITLE
EXHIBIT PHOTO & SITE PLAN

SHEET NUMBER
SP-1

mobilitie

PROJECT NO: 9FLB00315F
DRAWN BY: RC
CHECKED BY: SUB

	REVISION
D	01-09-18
C	11-28-17
B	10-17-17
A	09-03-17 FOR CLIENT REVIEW

KMB DESIGN GROUP, LLC
Stephen A. Bray
PROFESSIONAL ENGINEER
LICENSE No. 68902
STATE OF FLORIDA
FL LICENSE 19/18
1/9/18
IT IS A VIOLATION OF THE LAW FOR ANY PERSON, UNLESS THEY ARE ACTING UNDER THE DIRECTION OF A LICENSED PROFESSIONAL ENGINEER, TO ALTER THIS DOCUMENT

M190XSL78F
MIAMI BEACH, FL 33139 '24'-6"
STEEL POLE


SHEET TITLE
ENLARGED SITE PLAN

SHEET NUMBER
SP-3

1

ENLARGED SITE PLAN


SCALE: 1" = 5'-0"

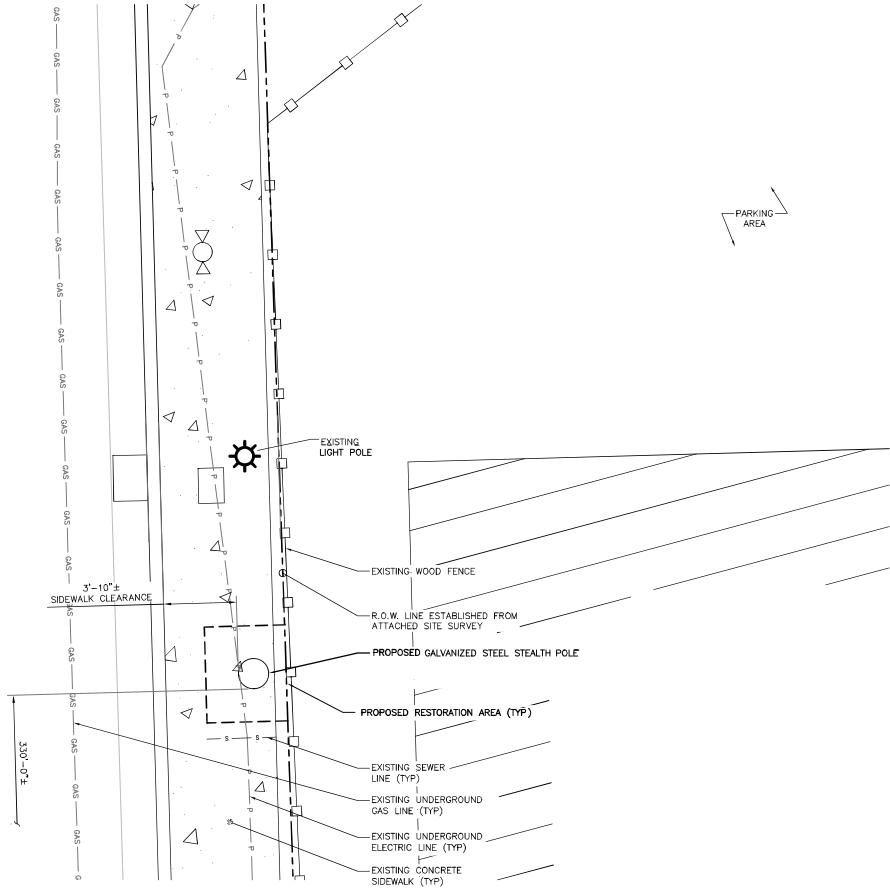

NOTE:
1. ALL DAMAGED AREAS SHALL BE RESTORED TO EQUAL OR BETTER CONDITION.
2. ALL ITEMS AND DIMENSIONS SHOULD BE VERIFIED IN THE FIELD.
3. GENERAL CONTRACTORS ARE REQUIRED TO CROSS CHECK COORDINATES, AERIAL PHOTO AND SITE PLAN TO ENSURE PROPER POLE LOCATION PRIOR TO BREAKING GROUND. CONCERNS OR QUESTIONS SHOULD BE IMMEDIATELY DIRECTED TO THE ASSIGNED MOBILITE CM.

mobilitie

NOTE:
POLE FINISH: GALVANIZED PER ASTM123
AND POWDER COATED (COLOR TBD.)

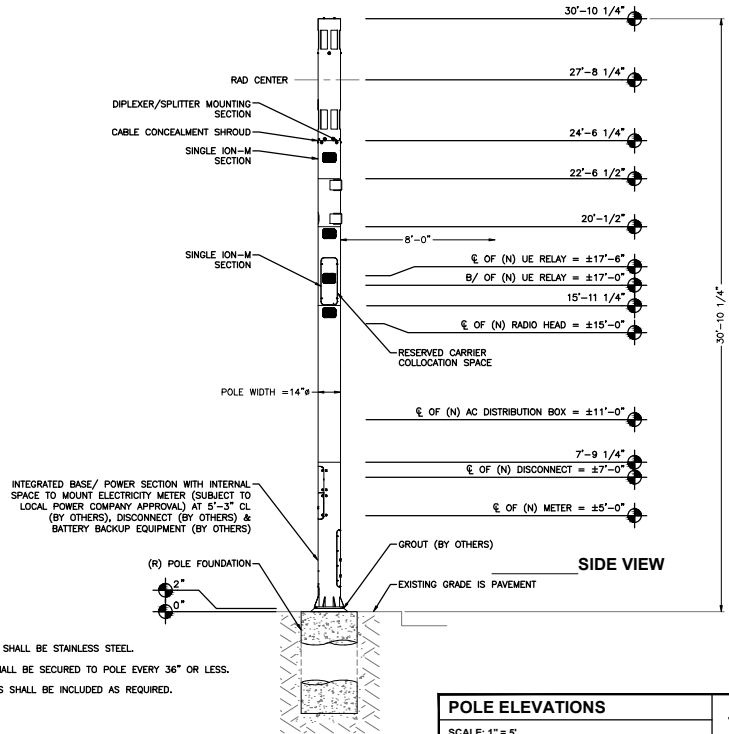

NOTE:
REFER TO STRUCTURAL ANALYSIS REPORT
M90XSL78F (SEPARATE DOCUMENT) FOR
ADDITIONAL STRUCTURAL INFORMATION.

PROJECT NO: SFLB00315P
DRAWN BY: RC
CHECKED BY: SUB

REVISION
D 01-09-18
C 11-28-17
B 10-11-17
A 09-01-17 FOR CLIENT REVIEW

KMB DESIGN GROUP, LLC
Stephen A. Bray
STEPHEN A. BRAY
LICENSE
No. 68902
STATE OF
FLORIDA
PROFESSIONAL ENGINEER
1/9/18
IT IS A VIOLATION OF THE LAW FOR ANY
PERSON, UNLESS THEY ARE ACTING UNDER THE
DIRECTION OF A LICENSED PROFESSIONAL
ENGINEER, TO ALTER THIS DOCUMENT

M90XSL78F
MIAMI BEACH, FL 33139 ' 24'-6"
STEEL POLE

SHEET TITLE
POLE ELEVATIONS

SHEET NUMBER
EV-1

NOTE:
ALL CABLING, EQUIPMENT AND
APPURTENANCES TO BE INSTALLED
INTERNAL TO STEALTH POLE

NOTE:
CABLING DIAGRAM IS FOR CLARITY OF
CABLE ROUTE AND TERMINATION ONLY.
CONTRACTOR SHALL INSTALL CABLES
WITH MINIMAL VISUAL IMPACT ON
REPLACEMENT GALVANIZED STEEL STEALTH
LIGHT POLE. SEE ELEVATION DRAWING
FOR EQUIPMENT AND ANTENNA
LOCATIONS.

CABLING NOTES:

- A) WOOD, CONCRETE AND EXISTING METALLIC POLES
I) FROM GRADE LINE TO 11'-0" ABOVE GRADE, ALL
CABLES/CONDUCTORS EXCEPT GROUNDING CONDUCTOR
MUST RUN IN RIGID GALVANIZED STEEL CONDUIT (RGS)
II) GROUNDING CONDUCTORS IN EXPOSED LOCATIONS
MUST BE INSTALLED IN PVC.
III) IN EARTH INSTALL PVC CONDUIT FOR BACKHAUL
AND ELECTRICAL SERVICE. TRANSITION TO RGS AT
GRADE LINE.
IV) ABOVE 11'-0" ALL CABLES (POWER, ETHERNET,
COAXIAL) MUST RUN IN PVC UTILITY POLE RISER.
(1) AT MAJOR EQUIPMENT, EXTEND UTILITY DUCT
IMMEDIATELY ADJACENT TO THE EQUIPMENT. INSTALL
CABLES IN THE UTILITY POLE RISER CREATING
CABLE DRIP LOOPS NOT LESS THAN THE CABLE
BENDING RADIUS.
(2) INSIDE THE UTILITY POLE RISER, UTILIZE 1/2"
COAX BLOCKS WITH LAG SCREWS TO SUPPORT
COAX, RADIO AND MW POWER, RF COAX, AND
ETHERNET CABLES TO WITHIN 12" OF THE
EQUIPMENT BEING SERVED AND ON INTERVALS NOT
TO EXCEED 6'.
V) FOR UNDERGROUND HFC/PUBLIC BACKHAUL, ROUTE
ETHERNET CABLE IN CONDUIT UP THE POLE AND
ENTER THE UTILITY POLE RISER. SEAL EXPOSED END
OF CONDUIT WITH A CABLE TERMINATION FITTING.
VI) BY APPROVAL IN SELECT CASES LIQUID-TIGHT
FLEXIBLE METALLIC CONDUIT (LFMC) MAY BE USED IN
LENGTHS NOT TO EXCEED 36" TO EXTEND THE
ELECTRICAL SERVICE CONDUIT TO THE AC
DISTRIBUTION BOX. EXAMPLE: UTILITY-REQUIRED
DISCONNECT ON POLE W/ AC DISTRIBUTION BOX ON
OPPOSITE SIDE OF POLE. NOT REQUIRED FOR COAX.
B) NEW METALLIC POLES
I) PROVIDE NEW POLES WITH SUITABLE HAND HOLES
SUCH THAT HAND HOLES EXIST AT ALL EQUIPMENT
LOCATIONS.
(1) WITH CLIENT APPROVAL IN SELECT CASES TO
FACILITATE IMPROVED APPEARANCE, 3/4" COAXIAL
CABLES MAY BE "SUPERFLEX" IN LIEU OF LDF-4.
II) WHERE POSSIBLE, INSTALL POLE BASE SUCH THAT THE
ELECTRICAL FEED AND BACKHAUL (IF UNDERGROUND)
CIRCUIT ENTER THE POLE THROUGH THE POLE BASE. IF A
DISCONNECTING MEANS SEPARATE FROM THE AC
DISTRIBUTION BOX IS REQUIRED BY JURISDICTION OR
UTILITY, WITH APPROVAL IN SELECT CASES LIQUID-TIGHT
FLEXIBLE METALLIC CONDUIT (LFMC) MAY BE USED IN
LENGTHS NOT TO EXCEED 36" TO EXTEND THE ELECTRICAL
SERVICE CONDUIT TO THE AC DISTRIBUTION BOX.

PLUMBING DIAGRAM

SCALE: NOT TO SCALE

1


BILL OF MATERIALS							
QTY.	DESCRIPTION	MANUFACTURER	MODEL NUMBER	AZIMUTH	CABLE	DIMENSIONS (h x w x d)	WEIGHT
1	ANTENNA	ALPHA WIRELESS	AW3477-S	TBD	12'-6"±	30.7" X 4.7" DIAMETER	7 LBS
1	UE RELAY	AIRSPAN	IR460-SPB-ST-1-P-Q	TBD	3'±	13" X 7" DIAMETER	8.8 LBS
1	GPS	TALLYSMAN	GPS-ANT-3	---	---	2" X 2.6" DIAMETER	0.3 LBS
1	RADIO	AIRSPAN	AH4000	---	---	20.3" X 10.3" X 8.3"	42 LBS
1	AC DISTRIBUTION PANEL	TRANSPECTOR	1101-1207-1012	---	1'±	12" X 12" X 4"	17 LBS
1	NEMA TYPE-3R DISCONNECT	SIEMENS	GF222NR (EXAMPLE)	---	1'±	15.45" X 8.7" X 5.95"	14 LBS
1	METER SOCKET	MILBANK	U4801-XL-519 (EXAMPLE)	---	---	19" X 13" X 4.84"	21 LBS

RFDS REVISION TYPE: NOT FINAL
RFDS REVISION NUMBER: N/A
RFDS REVISION TIMESTAMP: N/A

BILL OF MATERIALS

SCALE: NOT TO SCALE

2

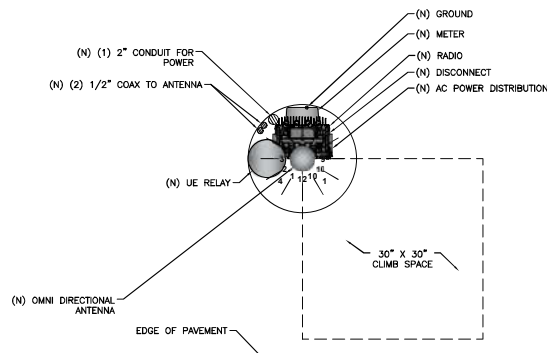

RISER ORIENTATION DIAGRAM

SCALE: NOT TO SCALE

3


mobilitie

PROJECT NO: SFLB00315F
DRAWN BY: RC
CHECKED BY: SUB

D 01-09-18 REVISION
C 11-28-17 REVISION
B 10-17-17 REVISION
A 09-03-17 FOR CLIENT REVIEW

KMB DESIGN GROUP, LLC

Stephen A. Bray

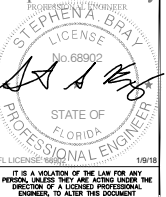

M190XSL78F
MIAMI BEACH, FL 33139 ' 24'-6"
STEEL POLE

SHEET TITLE
PLUMBING & RISER DIAGRAM

SHEET NUMBER
PL-1


MANUFACTURER: ALPHA WIRELESS MODEL: AW3477-S HEIGHT: 30.7 IN DIAMETER: 4.7 IN WEIGHT: 7 LBS MOUNT WEIGHT: 44 LBS	MANUFACTURER: AIRSPAN MODEL: IR460 HEIGHT: 13 IN DIAMETER: 7 IN WEIGHT: 8.8 LBS	NOT USED	MANUFACTURER: TRANSTECTOR MODEL: 1101-1207-1012 HEIGHT: 12 IN WIDTH: 12 IN DEPTH: 4 IN WEIGHT: 17 LBS	
MANUFACTURER: AIRSPAN MODEL: AH 4000 HAR40-CN-U20R1-806AP1 (B26) HAR40-EFCN-U41-806AP1 (B41) HEIGHT: 20.3 IN WIDTH: 10.3 IN DEPTH: 8.3 IN WEIGHT: 42 LBS	NOT USED	MANUFACTURER: SIEMENS MODEL: GF22NR TYPE: 3R DISCONNECT HEIGHT: 18.45 IN WIDTH: 5.7 IN DEPTH: 5.88 IN WEIGHT: 14 LBS	MANUFACTURER: SIEMENS MODEL: GF22NR TYPE: 3R DISCONNECT HEIGHT: 18.45 IN WIDTH: 5.7 IN DEPTH: 5.88 IN WEIGHT: 14 LBS	PROJECT NO: 9FLB00315F DRAWN BY: RC CHECKED BY: SJB D 01-09-18 REGION C 11-28-17 REGION B 10-17-17 REGION A 09-03-17 FOR CLIENT REVIEW KMB DESIGN GROUP, LLC Stephen A. Bray PROFESSIONAL ENGINEER LICENSE No. 68902 STATE OF FLORIDA PROFESSIONAL ENGINEER FL LICENSE 19/18
MANUFACTURER: AIRSPAN MODEL: TBD HEIGHT: 20.8 IN WIDTH: 9.25 IN DEPTH: 2.9 IN WEIGHT: 6.6 LBS	MANUFACTURER: FAITH MODEL: TBD HEIGHT: 29 IN WIDTH: 11.5 IN DEPTH: 11 IN WEIGHT: TBD	MANUFACTURER: TALLYSMAN MODEL: GPS-ANT-3 HEIGHT: 2 IN DIAMETER: 2.6 IN WEIGHT: 6.3 LBS	MANUFACTURER: MILBANK MODEL: U4891-XL-619 HEIGHT: 19 IN WIDTH: 13 IN DEPTH: 4.48 IN WEIGHT: 21 LBS	M190XSL78F MIAMI BEACH, FL 33139 * 24'-6" STEEL POLE SHEET TITLE EQUIPMENT DETAILS SHEET NUMBER EQ-1

mobilitie

PROJECT NO: 9FLB00315F
DRAWN BY: RC
CHECKED BY: SUB

	REVISION
D	01-09-18
C	11-28-17
B	10-17-17
A	09-03-17 FOR CLIENT REVIEW

KMB DESIGN GROUP, LLC
Stephen A. Bray

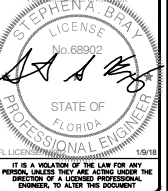

M190XSL78F
MIAMI BEACH, FL 33139 ' 24'-6"
STEEL POLE

SHEET TITLE
EQUIPMENT DETAILS

SHEET NUMBER
EQ-2

NOT USED


SCALE: NOT TO SCALE

1

NOT USED

SCALE: NOT TO SCALE

3

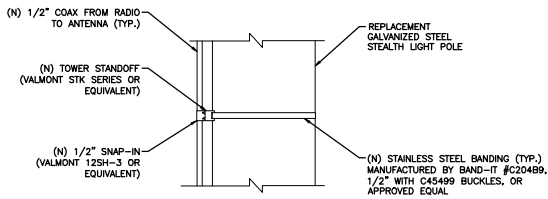


NOTE:
SPACE SNAP-INS PER
CABLE MANUFACTURER'S
SPECIFICATIONS

CABLE MOUNTING DETAIL


SCALE: NOT TO SCALE

2

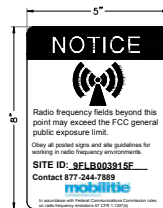

ANTENNA SIGNAGE:
ON METAL POLES - ADHESIVE VINYL OR PLACARD
STRAPPED WITH SS TIES
SIGN PLACEMENT:
AFFIX TO THE STRUCTURE 3'-4" BELOW THE COMMERCIAL
RF ANTENNA(S)
SIZE APPROX. 6" x 5"

ANTENNA SIGNAGE

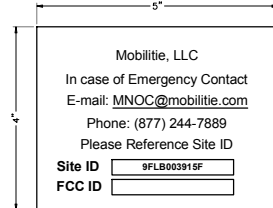


OWNER / OPERATOR NOTE:
SITE ID LABEL TO BE AFFIXED AT OR NEAR THE
POINT OF POWER CONNECTION WITH 12x6x241
LABELING TAPE OR EQUIVALENT BLACK ON WHITE
LABELING TAPE OF AT LEAST 18mm WIDTH WITH
EXTRA-STRENGTH ADHESIVE. USE ANY COMPATIBLE
P-TOUCH LABEL MAKER. TEXT SHOULD BE
PRINTED IN ALL CAPS WITH A MINIMUM HEIGHT
OF 1/2".

EMERGENCY CONTACT SIGN

POLE MOUNTED SIGNS

SCALE: NOT TO SCALE


4

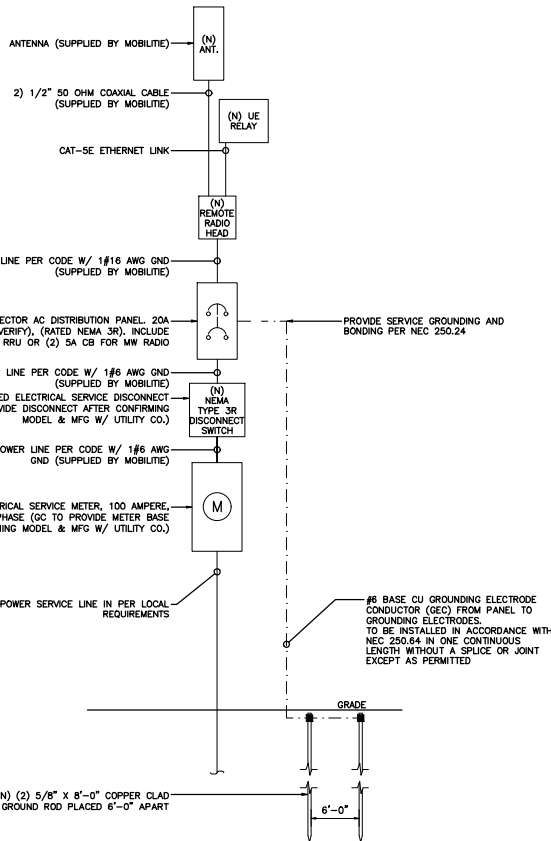

ONE-LINE DIAGRAM

SCALE: NOT TO SCALE

1

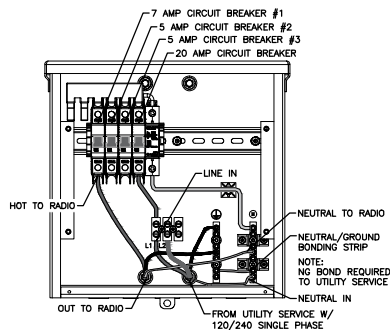

TRANSECTOR EXPORT AC DISTRIBUTION BOX

BREAKER SCHEDULE

SCALE: NOT TO SCALE

2

NOTES:

1. NOMINAL POWER IS CALCULATED AS 80% OF OEM DOCUMENTED MAXIMUM POWER.
2. CALCULATIONS FOR UE W/ NOKIA DO NOT NEED TO INCLUDE THE POWER FOR THE UE ANTENNA AS IT IS INCLUDED IN THE MAX POWER FIGURE. CALCULATIONS FOR UE W/ AIRSPAN MUST INCLUDE UE AS IT IS NOT INCLUDED
3. KVA IS CALCULATED FROM THE CONSUMPTION VALUE ASSUMING A PF=1. MAXIMUM POWER WAS USED FOR KVA. WHERE MAXIMUM WAS NOTED BY THE OEM THE QUOTED FIGURE WAS USED. WHERE AVERAGE/NOMINAL POWER WAS NOTED BY THE OEM MAXIMUM POWER WAS CALCULATED BY INCREASING AVERAGE/NOMINAL POWER BY A FACTOR OF 50%

Airspan Scenario 2 AH4000 High Power Radio and UE Backhaul

Unit	Sub Description	Max Power (W)	Max Current (A)	KVA	kWh/Yr
AirHarmony 4000	LTE Base Station	540	4.50	0.54	4730.4
Airspan IR460	UE Relay	N/A	N/A	N/A	N/A
Total		540	4.50	0.54	4730.4

LOAD CALCULATIONS

SCALE: NOT TO SCALE

3

mobilitie

PROJECT NO: SFLB00315P
DRAWN BY: RC
CHECKED BY: SUB

REVISION
D 01-08-18
C 11-28-17
B 10-11-17
A 09-03-17 FOR CLIENT REVIEW

KMB DESIGN GROUP, LLC
Stephen A. Bray

STEPHEN A. BRAY
LICENSE No. 68902
STATE OF FLORIDA
PROFESSIONAL ENGINEER
1/9/18


IT IS A VIOLATION OF THE LAW FOR ANY PERSON, UNLESS THEY ARE AGING UNDER THE DIRECTION OF A LICENSED PROFESSIONAL ENGINEER, TO ALTER THIS DOCUMENT

M190XSL78F
MIAMI BEACH, FL 33139 ' 24'-6"
STEEL POLE

SHEET TITLE
ELECTRICAL DETAILS

SHEET NUMBER
E-1


NOTE:
CONTRACTOR TO SURROUND COMPLETED
CONNECTION WITH HEAT-SHRINK TUBING TO
ENSURE WEATHER PROOF CONNECTION

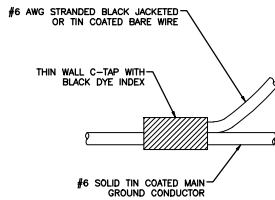

C-TAP DETAIL

SCALE: NOT TO SCALE

1

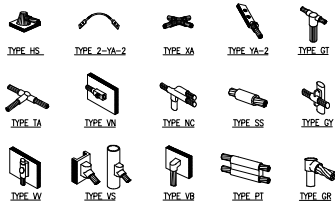


NOTE:

ERICO EXOTHERMIC "MOLD TYPES" SHOWN HERE ARE EXAMPLES.
CONSULT WITH PROJECT MANAGER FOR SPECIFIC MOLDS TO BE
USED FOR THIS PROJECT.

WELD CONNECTION DETAILS

SCALE: NOT TO SCALE

2

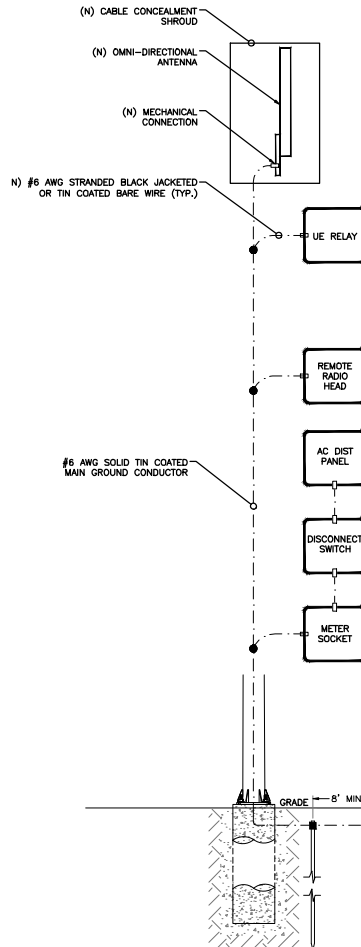

LEGEND
■ CADWELD CONNECTION
□ MECHANICAL CONNECTION
● COMPRESSION CONNECTION

NOTE:
GROUNDING RISER FOR DIAGRAMMATIC
PURPOSES ONLY. SEE ELEVATION DRAWING
FOR EQUIPMENT AND ANTENNA LOCATIONS.

NOTES:

1. ALL RGS TO BE GROUNDED AT BOTH ENDS USING GROUNDING BUSHINGS
2. GROUND WIRE TO BE RUN IN 1/2" SCHEDULE 40 PVC.

GROUNDING RISER DIAGRAM

SCALE: NOT TO SCALE

3


mobilitie

PROJECT NO: SFLB00315P
DRAWN BY: RC
CHECKED BY: SUB

REVISION
D 01-08-18
C 11-28-17
B 10-11-17
A 09-01-17 FOR CLIENT REVIEW

KMB DESIGN GROUP, LLC

Stephen A. Bray

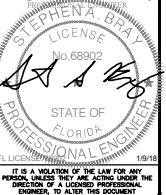

M190XSL78F
MIAMI BEACH, FL 33139 ' 24'-6"
STEEL POLE

SHEET TITLE
GROUNDING DETAILS

SHEET NUMBER
G-1

REINFORCED CONCRETE NOTES:

1. ALL CONCRETE WORK SHALL BE IN ACCORDANCE WITH THE ACI 301, ACI 318, ACI 336, ASTM A184, ASTM A185 AND THE DESIGN & CONSTRUCTION SPECIFICATION FOR CAST-IN-PLACE CONCRETE.

2. ALL SITECAST CONCRETE SHALL HAVE A MINIMUM COMPRESSIVE STRENGTH OF 3000 PSI WITHIN 28 DAYS. CONTINUOUS INSPECTION AND TESTING IS NOT REQUIRED. THE CONTRACTOR MAY SUBSTITUTE 5000 PSI FOR HIGH EARLY STRENGTH.

SLUMP - 4" MIN. / 6" MAX.
AIR ENTRAINMENT - 2% TO 3% BY VOLUME

CLASSES OF CONCRETE

CLASS	28 DAY STRENGTH (PSI)	MAX. WATER/CEMENT RATIO	PLACEMENT LOCATION	NORMAL WEIGHT
TYPE 1	3000	0.55	ALL LOCATIONS	

3. REINFORCING STEEL SHALL CONFORM TO ASTM A615, GRADE 60, DEFORMED UNLESS NOTED OTHERWISE. WELDED WIRE FABRIC SHALL CONFORM TO ASTM A185 WELDED STEEL FABRIC UNLESS OTHERWISE NOTED. SPLICES FOR REBAR SHALL BE CLASS 7D AND ALL HOOKS SHALL BE STANDARD, UNO. STAGGER SPLICES UNO. LAPS FOR WELDED WIRE FABRIC SHALL BE AT LEAST TWO FULL MESHES, UNO.

4. THE FOLLOWING MINIMUM CONCRETE COVER SHALL BE PROVIDED FOR REINFORCING STEEL UNLESS OTHERWISE NOTED ON DRAWINGS:

CONCRETE CAST AGAINST EARTH.....	3"
CONCRETE EXPOSED TO EARTH OR WEATHER	
#6 AND LARGER.....	2"
#5 AND SMALLER & W.W.F.....	1-1/2"

5. MAXIMUM COARSE AGGREGATE SIZE SHALL BE 3/4".

6. INSTALLATION OF CONCRETE ANCHORS SHALL BE IN ACCORDANCE WITH THE MANUFACTURER'S WRITTEN SPECIFICATIONS. THE ANCHOR BOLTS, DOWEL, OR RODS SHALL CONFORM TO THE ANCHOR MANUFACTURER'S SPECIFICATIONS FOR MATERIAL, STRENGTH, EMBEDMENT DEPTH, SPACING, AND EDGE DISTANCE OR AS DETAILED ON THE DRAWINGS. NO REBAR SHALL BE CUT WITHOUT PRIOR ENGINEERING APPROVAL WHEN DRILLING HOLES IN CONCRETE. EXPANSION BOLTS SHALL BE PROVIDED BY RAMSET/REDHEAD, HILTI OR APPROVED EQUAL. IF THE MANUFACTURER'S SPECIFICATIONS AND DETAILS ARE FOUND TO CONFLICT WITH THAT SHOWN HEREIN, THE ENGINEER SHALL BE NOTIFIED IMMEDIATELY.


7. MECHANICAL VIBRATION IS REQUIRED ON ALL SLABS TO REDUCE THE HONEYCOMB EFFECT UNLESS OTHERWISE DIRECTED BY THE CONSTRUCTION MANAGER.

8. THE CONTRACTOR SHALL VERIFY ALL ELECTRICAL CONDUIT SIZES AND PENETRATION LOCATION PRIOR TO POURING THE SLAB. REFER TO SHELTER MANUFACTURER'S SPECIFICATIONS FOR ADDITIONAL INFORMATION.

9. ALLOWABLE SOIL PRESSURE = 2500 PSF (ASSUMED).

NOTE:
SEE GN-3 FOUNDATION, EXCAVATION AND BACKFILL FOR ADDITIONAL NOTES.

NOTE:
REFER TO STRUCTURAL ANALYSIS REPORT (SEPARATE DOCUMENT) FOR ADDITIONAL STRUCTURAL INFORMATION.

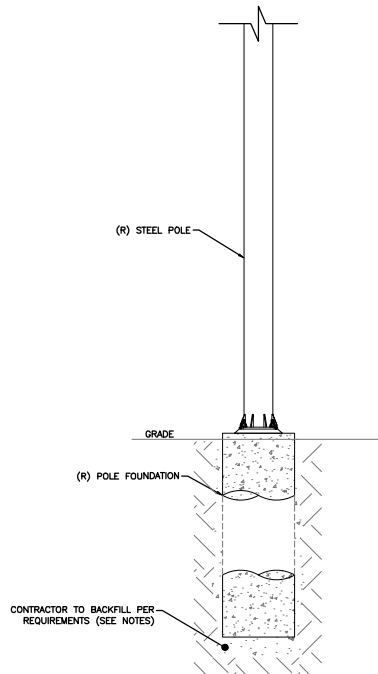

POLE FOUNDATION DETAILS

SCALE: NOT TO SCALE

1

mobilitie

PROJECT NO: SFLB000315P
DRAWN BY: RC
CHECKED BY: SUB

D 01-09-18 REVISION
C 11-28-17 REVISION
B 10-17-17 REVISION
A 09-03-17 FOR CLIENT REVIEW

KMB DESIGN GROUP, LLC

Stephen A. Bray



1/9/18
I, THE ENGINEER, CERTIFY THAT I AM A LICENSED PROFESSIONAL ENGINEER, TO ALTER THIS DOCUMENT

M190XSL78F
MIAMI BEACH, FL 33139 ' 24'-6"
STEEL POLE

SHEET TITLE
POLE FOUNDATION DETAILS

SHEET NUMBER
S-1

PLAN NOTES:

1. PLANS DEPICTED ARE GENERAL GUIDELINES FOR TEMPORARY VEHICULAR TRAFFIC CONTROL PLANS (TCP) TO INCLUDE PEDESTRIAN AND WORKER SAFETY. CONTRACTOR IS REQUIRED TO HAVE PREPARED A SITE-SPECIFIC TOP FOR REVIEW AND APPROVAL BY THE HIGHWAY AUTHORITY HAVING JURISDICTION. IF REQUIRED, THE FIRM PREPARING THE TOP SHALL BE AUTHORIZED OR CERTIFIED BY THE AUTHORITY HAVING JURISDICTION.
2. EXTEND CHANNELIZATION DEVICES INTO SHOULDER WHERE APPLICABLE.
3. DISTANCES AS INDICATED IN TABLE 1 SHOULD BE INCREASED FOR CONDITIONS THAT WOULD AFFECT STOPPING DISTANCE SUCH AS DOWNGRADES OR LIMITED SIGHT DISTANCES. DISTANCES CAN BE DECREASED FOR LOW-SPEED (RESIDENTIAL) AREAS WITH APPROVAL BY THE AUTHORITY HAVING JURISDICTION. NIGHT-TIME WORK IS PROHIBITED UNLESS IT IS REQUIRED AS A CONDITION OF APPROVAL BY THE HIGHWAY AND LOCAL AUTHORITY HAVING JURISDICTION.
4. SHOULDER TAPERS SHOULD BE 1/3 OF THE ON-STREET TAPER LENGTH.
5. MAINTAIN A MINIMUM LANE WIDTH OF 10'.
6. CONTRACTOR IS REQUIRED TO INPUT ALL LANE CLOSURES ON A STATE HIGHWAY IN THE LANE CLOSURE INFORMATION SYSTEM ([HTTPS://LCIS.DOT.STATE.FL.US](https://LCIS.DOT.STATE.FL.US)) 14 DAYS PRIOR TO THE CLOSURE.

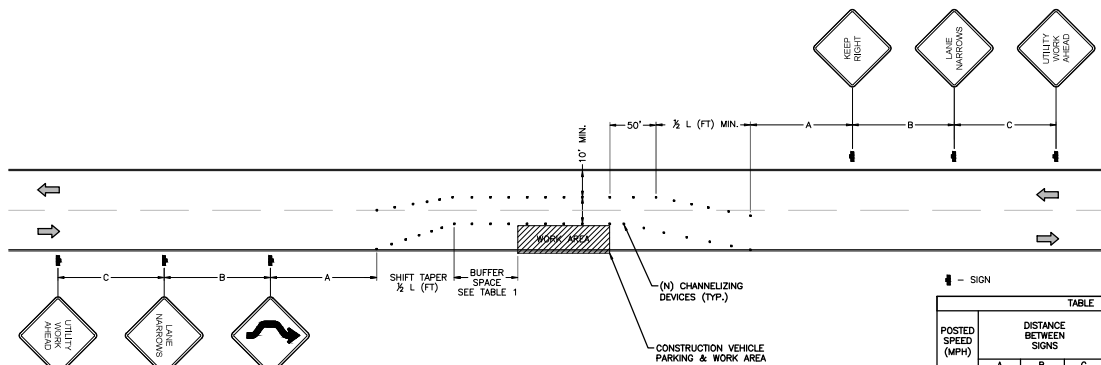


TABLE 1					
POSTED SPEED (MPH)	DISTANCE BETWEEN SIGNS			TAPER	BUFFER
	A	B	C		
15	100'	100'	100'	45'	100'
20	100'	100'	100'	80'	115'
25	100'	100'	100'	125'	155'
30	200'	200'	200'	180'	200'
35	200'	200'	200'	245'	250'
40	350'	350'	350'	320'	305'
45	350'	350'	350'	540'	360'
50	500'	500'	500'	600'	425'
55	500'	500'	500'	660'	495'
60	500'	500'	500'	720'	570'
65	500'	500'	500'	780'	645'

NOTES:
A) DISTANCES IN FEET UNLESS OTHERWISE NOTED.
B) CONTRACTOR TO VERIFY (C) SPEED LIMIT.
C) DISTANCES SHOWN ARE NOT VALID FOR LIMITED ACCESS
HIGHWAYS. CONSULT STATE DOT MANUAL FOR DISTANCES.
D) ADJUST DISTANCES TO COMPLY WITH REQUIREMENT OF
THE STATE OR LOCAL HIGHWAY AUTHORITY HAVING
JURISDICTION. SEE NOTE 1, SHEET TC-2.
E) TAPER LENGTHS SHOWN BASED ON 12' LANE WIDTH.
SEE NOTE 1B, SHEET TC-2.

VEHICULAR TRAFFIC CONTROL PLAN - LANE SHIFT

SCALE: NOT TO SCALE


1

mobilitie

PROJECT NO: SFLB00315P
DRAWN BY: RC
CHECKED BY: SJB

D 01-08-18 REVISION
C 11-28-17 REVISION
B 05-11-17 REVISION
A 09-03-17 FOR CLIENT REVIEW

KMB DESIGN GROUP, LLC
Stephen A. Bray

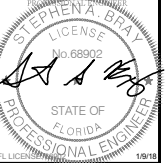

IT IS A VIOLATION OF THE LAW FOR ANY PERSON, UNLESS THEY ARE AGING UNDER THE DIRECTION OF A LICENSED PROFESSIONAL ENGINEER, TO ALTER THIS DOCUMENT


M190XSL78F
MIAMI BEACH, FL 33139 '24'-6"
STEEL POLE

SHEET TITLE
VEHICULAR TRAFFIC CONTROL PLAN

SHEET NUMBER
TC-1

1. ALL TEMPORARY TRAFFIC CONTROL SIGNAGE, LAYOUTS AND PROCEDURES SHALL COMPLY WITH LOCAL JURISDICTION'S RECOMMENDATIONS AND MANUAL OF UNIFORM TRAFFIC CONTROL DEVICES (MUTCD), LATEST EDITION, WHICHEVER IS MORE STRINGENT.
2. PRIOR TO ANY ROAD CONSTRUCTION, TRAFFIC CONTROL SIGNS AND DEVICES SHALL BE IN PLACE.
3. TRAFFIC CONTROL DEVICES FOR LANE CLOSURES INCLUDING SIGNS, CONES, BARRICADES, ETC. SHALL BE PLACED AS SHOWN ON PLANS. SIGNS SHALL NOT BE PLACED WITHOUT ACTUAL LANE CLOSURE AND SHALL BE IMMEDIATELY REMOVED UPON REMOVAL OF THE CLOSURES.
4. SELECTION, PLACEMENT, MAINTENANCE, AND PROTECTION OF TRAFFIC, PEDESTRIANS, AND WORKERS SHALL BE IN ACCORDANCE WITH THE MUTCD, AND TEMPORARY TRAFFIC CONTROL DEVICES, PART V, "TEMPORARY TRAFFIC CONTROL", AND LOCAL JURISDICTIONAL REQUIREMENTS UNLESS OTHERWISE NOTED IN THE PLANS AND SPECIFICATIONS. ALL SHALL BE APPROVED BY THE APPROPRIATE HIGHWAY AUTHORITY HAVING JURISDICTION.
5. ADVANCE WARNING SIGNS, DISTANCES, AND TAPER LENGTHS MAY BE EXTENDED TO ADJUST FOR REDUCED VISIBILITY DUE TO HORIZONTAL AND VERTICAL CURVES, TRUCK TRAILER LENGTHS, AND APPLICABLE CIRCULAR TRAFFIC SPEEDS IF IN EXCESS OF POSTED SPEED LIMITS.
6. TAPERS SHALL BE LOCATED TO MAXIMIZE THE VISIBILITY OF THEIR TOTAL LENGTH.
7. CONFLICTING OR NON-OPERATING SIGNAL INDICATIONS ON THE (E) TRAFFIC SIGNAL SYSTEMS SHALL BE BAGED OR COVERED.
8. ALL (E) ROAD SIGNS, PAVEMENT MARKINGS AND/OR FLOWABLE PAVEMENT REFLECTORS MUST COMPLY WITH THE (N) PLACABLE TRAFFIC CONTROL PLANS COVERING THE ROAD AND APPLICABLE LOCAL TRAFFIC CONTROL DEVICES SHALL BE RESTORED TO MATCH PRE-CONSTRUCTION CONDITIONS AFTER COMPLETION OF WORK.
9. CONTRACTOR SHALL CONTACT LOCAL AUTHORITY HAVING HIGHWAY JURISDICTION AND PROVIDE ADDITIONAL FLAGMEN OR POLICE SUPERVISION, IF REQUIRED.
10. ALL EXCAVATED AREAS WITHIN OR ADJACENT TO THE ROADWAY SHALL BE BACKFILLED AND PLACED ON A MINIMUM 6H:1 SLOPE PRIOR TO END OF EACH WORK DAY. EXCAVATED AREAS WITHIN THE CLEAR ZONE ARE TO BE EITHER BACKFILLED OR PLACED WITH CONCRETE CURBS AND BARRICADES. BARRICADES SET TEMPORARILY IN PLACE TO SHIELD WORKERS AND PEDESTRIAN TRAFFIC.
11. WHERE DICTATED BY LOCAL CONDITIONS, THE CONTRACTOR SHALL MAKE PROVISIONS FOR MAINTAINING PEDESTRIAN AND WORKER CROSSING LOCATIONS IN ACCORDANCE WITH APPLICABLE CODES AND OSHA REQUIREMENTS.
12. CONSTRUCTION ZONE SPEED LIMIT IF REDUCED FROM POSTED LIMITS SHALL BE IN ACCORDANCE WITH MUTCD AND WILL BE DETERMINED BY THE AUTHORITY HAVING JURISDICTION.
13. THERE SHALL BE NO WORKERS, EQUIPMENT, OR OTHER VEHICLES IN THE BUFFER SPACE OR THE ROLL AHEAD SPACE.
14. DRIVEWAYS AND/OR SIDE STREETS ENTERING THE ROADWAY AFTER THE FIRST ADVANCE WARNING SIGN SHALL BE PROVIDED WITH AT LEAST ONE W20-1 SIGN (ROAD WORK AHEAD) AS A MINIMUM.
15. CONES MAY BE SUBSTITUTED FOR DRUMS AND INSTALLED UPON THE APPROVAL OF THE AUTHORITY HAVING JURISDICTION PROVIDED THEY COMPLY WITH MUTCD.
16. THE SPACING BETWEEN CONES, TUBULAR MARKERS, VERTICAL PANELS, DRUMS, AND BARRICADES SHOULD NOT EXCEED A DISTANCE IN FEET EQUAL TO 1.0 TIMES THE SPEED LIMIT IN MPH WHEN USED FOR TAPER.
17. WHEN CHANGELANES ARE USED, THE TUBULAR MARKERS, VERTICAL PANELS, DRUMS, AND BARRICADES SHOULD BE EXTENDED A DISTANCE IN FEET OF 2.0 TIMES THE SPEED LIMIT IN MPH BEYOND THE DOWNSTREAM END OF THE TRANSITION AREA.
18. TAPER LENGTHS ARE CALCULATED AS FOLLOWS:
$$L = \frac{W \times S^2}{60 \times F}$$

WHERE W = OFFSET WIDTH (FT), S = TRAFFIC SPEED (MPH).

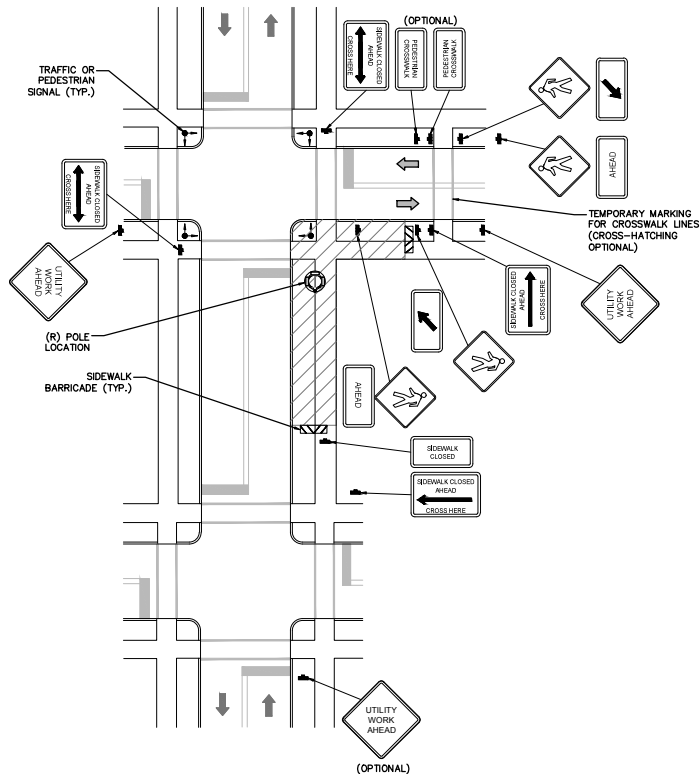

SCALE: NOT TO SCALE



GENERAL CONSTRUCTION NOTES:

1. ALL WORK SHALL CONFORM TO THE REQUIREMENTS OF THE LOCAL BUILDING CODE, THE LATEST ADOPTED EDITION AND ALL OTHER APPLICABLE CODES AND ORDINANCES.

2. CONTRACTOR SHALL CONSTRUCT SITE IN ACCORDANCE WITH THESE DRAWINGS AND LATEST MOBILITE CONSTRUCTION STANDARDS. THE SPECIFICATION IS THE RULING DOCUMENT AND ANY DISCREPANCIES BETWEEN THE SPECIFICATION AND THE CONSTRUCTION DRAWINGS SHALL BE BROUGHT TO THE ATTENTION OF THE ARCHITECT/ENGINEER OR MOBILITE CM PRIOR TO THE COMMENCEMENT OF WORK.

3. CONTRACTOR SHALL VISIT THE JOB SITE AND SHALL FAMILIARIZE THEMSELVES WITH ALL CONDITIONS AFFECTING THE (N) WORK AND SHALL MAKE PROVISIONS AS TO THE COST THEREOF. CONTRACTOR SHALL BE RESPONSIBLE FOR FAMILIARIZING THEMSELVES WITH ALL CONTRACT DOCUMENTS, FIELD CONDITIONS AND DIMENSIONS AND CONFIRMING THAT THE WORK MAY BE ACCOMPLISHED, AS SHOWN, PRIOR TO PROCEEDING WITH CONSTRUCTION. ANY DISCREPANCIES SHALL BE BROUGHT TO THE ATTENTION OF THE ARCHITECT/ENGINEER OR MOBILITE CM PRIOR TO THE COMMENCEMENT OF WORK. NO COMPENSATION WILL BE AWARDED BASED ON CLAIM OF LACK OF KNOWLEDGE OF FIELD CONDITIONS.

4. IT IS NOT THE INTENT OF THESE PLANS TO SHOW EVERY MINOR DETAIL OF CONSTRUCTION. CONTRACTOR IS REQUIRED TO FURNISH AND INSTALL ANY/ALL ITEMS FOR A COMPLETE AND FULLY FUNCTIONAL SYSTEM SUBJECT ONLY TO OWNER-SUPPLIED ITEMS. CONTRACTOR SHALL PROVIDE ANY/ALL REQUIREMENTS FOR THE EQUIPMENT TO BE PLACED IN PROPER WORKING ORDER.

5. PLANS ARE NOT TO BE SCALED. THESE PLANS ARE INTENDED TO BE A DIAGRAMMATIC OUTLINE ONLY UNLESS OTHERWISE NOTED. THE WORK SHALL INCLUDE FURNISHING MATERIALS, EQUIPMENT AND APPURTENANCES, AND LABOR NECESSARY TO EFFECT ALL INSTALLATIONS AS INDICATED ON THE DRAWINGS. OWNER PROVIDED AND CONTRACTOR INSTALLED MATERIALS WILL INCLUDE THE FOLLOWING, UNLESS NOTED OTHERWISE:

- A) TRANSMITTER
- B) UHF ANTENNA AND MOUNTING BRACKETS, GPS UNIT AND KU BACKHAUL
- C) UHF COAX AND HANGERS
- D) INTEGRATED LOAD CENTER

6. DIMENSIONS SHOWN ARE TO FINISH SURFACES UNLESS OTHERWISE NOTED. SPACING BETWEEN EQUIPMENT IS REQUIRED CLEARANCE. THEREFORE, IT IS CRITICAL TO FIELD VERIFY DIMENSIONS. SHOULD THERE BE ANY QUESTIONS REGARDING THE CONTRACT DOCUMENTS, (E) CONDITIONS AND/OR DESIGN INTENT, THE CONTRACTOR SHALL BE RESPONSIBLE FOR REPORTING ANY DISCREPANCIES TO THE ATTENTION OF THE MOBILITE CM, IN WRITING, PRIOR TO THE COMMENCEMENT OF WORK.

7. DETAILS PROVIDED ARE FOR THE PURPOSE OF SHOWING DESIGN INTENT. MODIFICATIONS MAY BE REQUIRED TO SUIT JOB DIMENSIONS OR SITE CONDITIONS, AND SUCH MODIFICATIONS SHALL BE INCLUDED AS PART OF THE WORK.

8. CONTRACTOR SHALL PAY FOR APPLICABLE PERMITS, FEES, INSPECTIONS AND TESTING. CONTRACTOR IS TO OBTAIN PERMITS AND APPROVED SUBMITTALS PRIOR TO ORDERING MATERIALS AND THE COMMENCEMENT OF WORK.

9. THE TERM "PROVIDE"-USED IN CONSTRUCTION DOCUMENTS AND SPECIFICATIONS, INDICATES THAT THE CONTRACTOR SHALL FURNISH AND INSTALL.

10. CONTRACTOR SHALL RECEIVE CLARIFICATION IN WRITING, AND SHALL RECEIVE IN WRITING AUTHORIZATION TO PROCEED BEFORE STARTING WORK ON ANY ITEMS NOT CLEARLY DEFINED OR IDENTIFIED BY THE CONTRACT DOCUMENTS.

11. CONTRACTOR SHALL SUPERVISE AND DIRECT THE WORK USING ACCEPTED INDUSTRY-STANDARD SKILLS AND ATTENTION. CONTRACTOR SHALL BE SOLELY RESPONSIBLE FOR CONSTRUCTION MEANS, METHODS, TECHNIQUES, SEQUENCES AND PROCEDURES AND FOR COORDINATING ALL PORTIONS OF THE WORK UNDER CONTRACT, UNLESS OTHERWISE NOTED.

12. CONTRACTOR SHALL BE RESPONSIBLE FOR THE SAFETY OF THE WORK AREA, ADJACENT AREAS AND BUILDING OCCUPANTS THAT ARE LIKELY TO BE AFFECTED BY THE WORK UNDER THIS CONTRACT. WORK SHALL CONFORM TO ALL OSHA REQUIREMENTS.

13. CONTRACTOR SHALL COORDINATE THEIR WORK WITH THE MOBILITE CM AND SCHEDULE THEIR ACTIVITIES AND WORKING HOURS IN ACCORDANCE WITH THE REQUIREMENTS.

14. CONTRACTOR SHALL BE RESPONSIBLE FOR COORDINATING THEIR WORK WITH THE WORK OF OTHERS AS IT MAY RELATE TO RADIO EQUIPMENT, ANTENNAS AND ANY OTHER PORTIONS OF THE WORK.

15. CONTRACTOR SHALL INSTALL ALL EQUIPMENT AND MATERIALS IN ACCORDANCE WITH MANUFACTURERS RECOMMENDATIONS UNLESS SPECIFICALLY OTHERWISE INDICATED OR WHERE LOCAL CODES OR REGULATIONS TAKE PRECEDENCE.

16. CONTRACTOR SHALL MAKE NECESSARY PROVISIONS TO PROTECT (E) SURFACES, EQUIPMENT, IMPROVEMENTS, PAVING ETC. AND IMMEDIATE REPAIR, TO NEW CONDITION, ANY DAMAGE THAT OCCURS DURING CONSTRUCTION AT THE SOLE COST OF THE CONTRACTOR.

17. IN DRILLING HOLES, OR CORING, INTO CONCRETE WHETHER FOR FASTENING OR ANCHORING PURPOSES, OR PENETRATIONS THROUGH THE FLOOR FOR CONDUIT RUNS, PIPE RUNS, ETC., MUST BE CLEARLY UNDERSTOOD THAT REINFORCING STEEL SHALL NOT BE DRILLED INTO, CUT OR DAMAGED UNDER ANY CIRCUMSTANCES (UNLESS NOTED OTHERWISE). LOCATIONS OF REINFORCING STEEL ARE NOT DEFINITELY KNOWN AND THEREFORE MUST BE LOCATED BY THE CONTRACTOR USING APPROPRIATE METHODS AND EQUIPMENT PRIOR TO ANY DRILLING OR CORING OPERATIONS IN (E) CONCRETE.

18. CONTRACTOR SHALL REPAIR, TO NEW CONDITION, ALL (E) WALL SURFACES DAMAGED DURING CONSTRUCTION SUCH THAT THEY MATCH AND BLEND IN WITH ADJACENT SURFACES.

19. CONTRACTOR SHALL SEAL PENETRATIONS THROUGH FIRE RATED ASSEMBLIES OR MATERIALS WITH ULL LISTED AND FIRE CODE APPROVED MATERIALS AND SYSTEMS THAT MEET OR EXCEED THE RATING OF THE ASSEMBLY IN WHICH THE NEW PENETRATION IS PLACED.

20. CONTRACTOR SHALL KEEP CONTRACT AREA CLEAN, HAZARD FREE, AND DISPOSE OF ALL DIRT, DEBRIS, AND RUBBISH. EQUIPMENT NOT SPECIFIED AS REMAINING ON THE PROPERTY OF THE OWNER SHALL BE REMOVED. LEAVE PREMISES IN CLEAN CONDITION AND FREE FROM PAINT SPOTS, DUST, OR SMUDGES OF ANY NATURE. CONTRACTOR SHALL BE RESPONSIBLE FOR MAINTAINING ALL ITEMS UNTIL COMPLETION OF CONSTRUCTION.

21. MINIMUM BEND RADIUS OF ANTENNA CABLES SHALL BE IN ACCORDANCE WITH CABLE MANUFACTURERS RECOMMENDATIONS.

22. CONTRACTOR SHALL MINIMIZE DISTURBANCE TO (E) SITE DURING CONSTRUCTION. EROSION CONTROL MEASURES, IF REQUIRED DURING CONSTRUCTION SHALL BE IN CONFORMANCE WITH JURISDICTIONAL OR STATE AND LOCAL GUIDELINES FOR EROSION AND SEDIMENT CONTROL AND COORDINATED WITH LOCAL REGULATORY AUTHORITIES. CONTRACTOR SHALL BE RESPONSIBLE FOR MAINTENANCE OF ANY EROSION CONTROL MEASURES, RECORD-KEEPING, MONITORING, AND REPORTING TO THE OWNER AND REGULATORY AUTHORITIES.

23. ALL CONSTRUCTION WORK IS TO ADHERE TO APPLICANT'S INTEGRATED CONSTRUCTION STANDARDS UNLESS STATE OR LOCAL CODE IS MORE STRINGENT.

24. THE INTENT OF THE PLANS AND SPECIFICATIONS IS TO PERFORM THE CONSTRUCTION IN ACCORDANCE PER STATE BUILDING STANDARDS CODE AND STATE CODE OF REGULATIONS. SHOULD ANY CONDITIONS DEVELOP NOT COVERED BY THE APPROVED PLANS AND SPECIFICATIONS WHEREIN THE FINISHED WORK WILL NOT COMPLY PER STATE CODE OF REGULATIONS, A SCOPE OF WORK DETAILING AND SPECIFYING THE REQUIRED WORK SHALL BE SUBMITTED TO AND APPROVED BY THE JURISDICTION BEFORE PROCEEDING WITH THE WORK. A CHANGE ORDER FOR THAT SCOPE SHALL BE SUBMITTED TO THE MOBILITE CM PRIOR TO PROCEEDING WITH THE WORK.

25. ADEQUATE AND REQUIRED LIABILITY INSURANCE SHALL BE PROVIDED BY THE CONTRACTOR FOR PROTECTION AGAINST PUBLIC LOSS AND ANY/ALL PROPERTY DAMAGE FOR THE DURATION OF WORK.

26. CONTRACTOR SHALL GUARANTEE ANY/ALL MATERIALS AND WORK FREE FROM DEFECTS FOR A PERIOD OF NOT LESS THAN ONE YEAR FROM DATE OF ACCEPTANCE. ANY CORRECTIVE WORK SHALL BE COMPLETED AT THE SOLE COST OF THE CONTRACTOR.

ELECTRICAL NOTES:

1. ELECTRICAL CONTRACTOR SHALL SUPPLY AND INSTALL ANY/ALL ELECTRICAL WORK INDICATED. ANY/ALL CONSTRUCTION SHALL BE IN ACCORDANCE W/DRAWINGS AND ANY/ALL APPLICABLE SPECIFICATIONS. IF ANY PROBLEMS ARE ENCOUNTERED BY COMPLYING WITH THESE REQUIREMENTS, CONTRACTOR SHALL NOTIFY MOBILITE CM AS SOON AS POSSIBLE, AFTER THE DISCOVERY OF THE PROBLEMS, AND SHALL NOT PROCEED WITH THAT PORTION OF WORK, UNTIL THE MOBILITE CM HAS DIRECTED THE CORRECTIVE ACTIONS TO BE TAKEN.

2. ELECTRICAL CONTRACTOR SHALL VISIT THE JOB SITE AND FAMILIARIZE THEMSELF WITH ANY/ALL CONDITIONS AFFECTING ELECTRICAL AND COMMUNICATION INSTALLATION AND MAKE PROVISIONS AS TO THE COST THEREOF. ALL (E) CONDITIONS OF ELECTRICAL EQUIP., ETC., THAT ARE PART OF THE FINAL SYSTEM, SHALL BE VERIFIED BY THE CONTRACTOR, PRIOR TO THE SUBMITTING OF THEIR BID. FAILURE TO COMPLY WITH THIS PARAGRAPH WILL IN NO WAY RELIEVE CONTRACTOR OF PERFORMING ALL WORK NECESSARY FOR A COMPLETE AND WORKING SYSTEM.

3. ALL WORK SHALL BE PERFORMED IN ACCORDANCE WITH THE LATEST EDITION OF THE NEC, ALL CODES AND ORDINANCES OF THE LOCAL JURISDICTION, AND POWER & TELEPHONE COMPANIES HAVING JURISDICTION AND SHALL INCLUDE BUT ARE NOT BE LIMITED TO:

- A) UL – UNDERWRITERS LABORATORIES
- B) NEC – NATIONAL ELECTRICAL CODE
- C) NEMA – NATIONAL ELECTRICAL MANUFACTURERS ASSOC.
- D) OSHA – OCCUPATIONAL SAFETY AND HEALTH ACT
- E) SBC – STANDARD BUILDING CODE
- F) NFPA – NATIONAL FIRE PROTECTION AGENCY
- G) ANSI – AMERICAN NATIONAL STANDARDS INSTITUTE
- H) IEEE – INSTITUTE OF ELECTRICAL AND ELECTRONICS ENGINEERS
- I) ASTM – AMERICAN SOCIETY FOR TESTING MATERIALS

4. REFER TO SITE PLANS AND ELEVATIONS FOR EXACT LOCATIONS OF ALL EQUIPMENT, AND CONFIRM WITH MOBILITE CM ANY SIZES AND LOCATIONS WHEN NEEDED.

5. (E) SERVICES: CONTRACTOR SHALL NOT INTERRUPT (E) SERVICES WITHOUT WRITTEN PERMISSION OF THE OWNER.

6. CONTRACTOR SHALL CONFIRM WITH LOCAL UTILITY COMPANY ANY/ALL REQUIREMENTS SUCH AS THE: LUG SIZE RESTRICTIONS, CONDUIT ENTRY, SIZE OF TRANSFORMERS, SCHEDULED DOWNTIME FOR THE OWNERS' CONFIRMATION, ETC... ANY/ALL CONFLICTS SHALL BE BROUGHT TO THE ATTENTION OF THE MOBILITE CM, PRIOR TO BEGINNING ANY WORK.

7. MINIMUM WIRE SIZE SHALL BE #12 AWG, NOT INCLUDING CONTROL WIRING, UNLESS NOTED OTHERWISE. ALL CONDUCTORS SHALL BE COPPER WITH THIN INSULATION, UNLESS OTHERWISE NOTED.

8. OUTLET BOXES SHALL BE PRESSED STEEL IN DRY LOCATIONS, CAST ALLOY WITH THREADED HUBS IN WET/DAMP LOCATIONS AND SPECIAL ENCLOSURES FOR OTHER CLASSIFIED AREAS.

9. IT IS NOT THE INTENT OF THESE PLANS TO SHOW EVERY MINOR DETAIL OF THE CONSTRUCTION. CONTRACTOR IS EXPECTED TO FURNISH AND INSTALL ALL ITEMS FOR A COMPLETE ELECTRICAL SYSTEM AND PROVIDE ALL REQUIREMENTS FOR THE EQUIPMENT TO BE PLACED IN PROPER WORKING ORDER.

10. ELECTRICAL SYSTEM SHALL BE AS COMPLETELY AND EFFECTIVELY GROUNDED, AS REQUIRED BY SPECIFICATIONS, SET FORTH BY APPLICANT.

11. ALL WORK SHALL BE PERFORMED BY A LICENSED ELECTRICAL CONTRACTOR IN A FIRST CLASS, WORKMANLIKE MANNER. THE COMPLETED SYSTEM SHALL BE FULLY FUNCTIONAL AND SHALL BE APPROVED BY THE MOBILITE CM AND LOCAL JURISDICTION. ANY DEFICIENCIES SHALL BE CORRECTED BY AN ELECTRICAL CONTRACTOR AT THE SOLE COST OF THE CONTRACTOR.

12. ALL WORK SHALL BE COORDINATED WITH OTHER TRADES TO AVOID INTERFERENCE WITH THE PROGRESS OF CONSTRUCTION.

mobilitie


PROJECT NO: SFLB000315P

DRAWN BY: RC

CHECKED BY: SUB

REVISION
D 01-08-18
C 11-28-17
B 05-17-17
A 09-03-17 FOR CLIENT REVIEW

KMB DESIGN GROUP, LLC
Stephen A. Bray

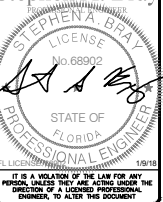

IT IS A VIOLATION OF THE LAW FOR ANY PERSON, UNLESS THEY ARE A LICENSED PROFESSIONAL ENGINEER, TO ALTER THIS DOCUMENT

M190XSL78F
MIAMI BEACH, FL 33139 ' 24'-6"
STEEL POLE

SHEET TITLE
GENERAL NOTES

SHEET NUMBER
GN-1

ELECTRICAL NOTES (CONT'D)

1. THE CORRECTION OF ANY DEFECTS SHALL BE COMPLETED BY THE CONTRACTOR WITHOUT ANY ADDITIONAL CHARGE AND SHALL INCLUDE THE REPLACEMENT OR THE REPAIR OF ANY OTHER PHASE OF THE INSTALLATION, WHICH MAY HAVE BEEN DAMAGED THEREIN.
2. CONTRACTOR SHALL PROVIDE AND INSTALL CONDUIT, CONDUCTORS, PULL WIRES, BOXES, COVER PLATES AND DEVICES FOR ALL OUTLETS AS INDICATED.
3. DITCHING AND BACK FILL - CONTRACTOR SHALL PROVIDE FOR ALL UNDERGROUND INSTALLED CONDUIT AND/OR CABLES INCLUDING EXCAVATION AND BACKFILLING AND COMPACTION. REFER TO NOTES AND REQUIREMENTS EXCAVATION, AND BACKFILLING.
4. MATERIALS, PRODUCTS AND EQUIPMENT, INCLUDING ALL COMPONENTS THEREOF, SHALL BE NEW AND SHALL APPEAR ON THE LIST OF U.L. APPROVED ITEMS AND SHALL MEET OR EXCEED THE REQUIREMENTS OF THE NEC, NEMA AND IECE.
5. CONTRACTOR SHALL SUBMIT SHOP DRAWINGS OR MANUFACTURER'S CATALOG INFORMATION OF ANY/ALL EQUIPMENT AND ALL OTHER ELECTRICAL ITEMS FOR APPROVAL BY THE MOBILITIE CM PRIOR TO INSTALLATION.
6. ANY CUTTING OR PATCHING DEEMED NECESSARY FOR ELECTRICAL WORK IS THE ELECTRICAL CONTRACTORS RESPONSIBILITY AND SHALL BE INCLUDED IN THE COST FOR WORK AND PERFORMED TO THE SATISFACTION OF THE MOBILITIE CM UPON FINAL ACCEPTANCE.
7. THE ELECTRICAL CONTRACTOR SHALL LABEL ALL PANELS WITH ONLY TYPEWRITTEN DIRECTORIES. ALL ELECTRICAL WIRING SHALL BE THE RESPONSIBILITY OF THE ELECTRICAL CONTRACTOR.
8. DISCONNECT SWITCHES SHALL BE UL-RATED, H.P. RATED HEAVY-DUTY, QUICK-MAKE AND QUICK-BREAK ENCLOSURES, AS REQUIRED BY EXPOSURE TYPE.
9. ALL CONNECTIONS SHALL BE MADE WITH A PROTECTIVE COATING OF AN ANTI-OXIDE COMPOUND KNOWN AS "NO-OXIDE A" BY DEARBORNE CHEMICAL CO. COAT ALL WIRE SURFACES BEFORE CONNECTING. EXPOSED COPPER SURFACES, INCLUDING GROUND BARS, SHALL BE TREATED - NO SUBSTITUTIONS.
10. RACEWAYS: CONDUIT SHALL BE SCHEDULE 80 PVC MEETING OR EXCEEDING NEMA TC2 - 1990. CONTRACTOR SHALL PLUG AND CAP EACH END OF SPARE AND EMPTY CONDUITS AND PROVIDE TWO SEPARATE PULL STRINGS - 200 LBS TEST POLYETHYLENE CORD. ALL CONDUIT BENDS SHALL BE A MINIMUM OF 2 FT. RADIUS. RGS CONDUITS WHEN SPECIFIED, SHALL MEET UL-8 FOR GALVANIZED STEEL. ALL FITTINGS SHALL BE SUITABLE FOR USE WITH THREADED RIGID CONDUIT. COAT ALL THREADS WITH "BRITE ZINC" OR "COLD GALV".
11. SUPPORT OF ALL ELECTRICAL WORK SHALL BE AS REQUIRED BY NEC.
12. CONDUCTORS: CONTRACTOR SHALL USE 98% CONDUCTIVITY COPPER WITH TYPE THIN INSULATION, UNLESS OTHERWISE NOTED. 600 VOLT, COLOR CODED. USE SOLID CONDUCTORS FOR WIRE UP TO AND INCLUDING NO. 8 AWG. USE STRANDED CONDUCTORS FOR WIRE ABOVE NO. 8 AWG.
13. CONNECTORS FOR POWER CONDUCTORS: CONTRACTOR SHALL USE PRESSURE TYPE INSULATED TWIST-ON CONNECTORS FOR NO. 10 AWG AND SMALLER. USE SOLDERLESS MECHANICAL TERMINAL LUGS FOR NO. 8 AWG AND LARGER.
14. SERVICE: AS SPECIFIED ON THE DRAWINGS. OWNER OR OWNER'S AGENT WILL APPLY FOR POWER. ALL PROVISIONS FOR TEMPORARY POWER WILL BE OBTAINED BY THE CONTRACTOR.
15. TELEPHONE OR FIBER SERVICE: CONTRACTOR SHALL PROVIDE EMPTY CONDUITS WITH PULL STRINGS AS INDICATED ON DRAWINGS.
16. ELECTRICAL AND TELCO/FIBER RACEWAYS TO BE BURIED A MINIMUM DEPTH OF 30", UNLESS OTHERWISE NOTED.
17. CONTRACTOR SHALL PLACE 6" WIDE DETECTABLE WARNING TAPE AT A DEPTH OF 6" BELOW GROUND AND DIRECTLY ABOVE ELECTRICAL AND TELCO SERVICE CONDUITS. CAUTIONS TAPE TO READ "CAUTION BURIED ELECTRIC" OR "BURIED TELCO".
18. ALL BOLTS SHALL BE 3-16 STAINLESS STEEL.

GROUNDING NOTES:

1. ALL HARDWARE SHALL BE 3-16 STAINLESS STEEL, INCLUDING LOCK WASHERS. COAT ALL SURFACES WITH AN ANTI-OXIDANT COMPOUND, AS SPECIFIED, BEFORE MATING. ALL HARDWARE SHALL BE STAINLESS STEEL 3/8 INCH DIAMETER OR SIZED TO MATCH COMPONENTS OR LOG SIZE.
2. FOR GROUND BOND TO STEEL ONLY: INSERT A CADMIUM FLAT WASHER BETWEEN LUG AND STEEL. COAT ALL SURFACES WITH AN ANTI-OXIDANT COMPOUND BEFORE MATING.
3. ALL STEEL CONDUIT SHALL BE BONDED AT BOTH ENDS WITH GROUNDING BUSHING.
4. ALL ELECTRICAL AND GROUNDING AT THE POLE SITE SHALL COMPLY WITH THE NATIONAL ELECTRICAL CODE (NEC), NATIONAL FIRE PROTECTION ASSOCIATION (NFPA) 780 (LATEST EDITION), AND MANUFACTURER.
5. ALL DETAILS ARE SHOWN IN GENERAL TERMS. ACTUAL GROUNDING INSTALLATION AND CONSTRUCTION MAY VARY DUE TO SITE SPECIFIC CONDITIONS.
6. GROUND ALL ANTENNA BASES, FRAMES, CABLE RUNS, AND OTHER METALLIC COMPONENTS USING #6 GROUND WIRES. FOLLOW ANTENNA AND BTS MANUFACTURER'S PRACTICES FOR GROUNDING REQUIREMENTS.
7. ALL GROUND CONNECTIONS SHALL BE #6 AWG, UNLESS OTHERWISE NOTED. USE SOLID COPPER, BLACK JACKETED WIRE ON NON WOOD POLES AND SOLID TINNED COPPER, BARE (NO JACKET) WIRES ON WOOD POLES. BLACK WIRES WILL USE A SINGLE STRIPE OF GREEN ELECTRICAL TAPE WITHING 12" OF THE CONNECTION POINTS TO IDENTIFY AS GROUNDING WIRE.
8. NOTIFY ARCHITECT/ENGINEER IF THERE ARE ANY DIFFICULTIES INSTALLING GROUNDING SYSTEM DUE TO SITE SOIL CONDITIONS.
9. ALL HORIZONTALLY RUN GROUNDING CONDUCTORS SHALL BE INSTALLED A MINIMUM OF 30" BELOW GRADE/ 6-BELOW FROST-LINE IN TRENCH, UNLESS OTHERWISE NOTED. BACK FILL SHALL BE COMPACTED AS REQUIRED BY ARCHITECT/ENGINEER.
10. ALL GROUND CONDUCTORS SHALL BE RUN AS STRAIGHT AND SHORT AS POSSIBLE, WITH A MINIMUM 12" BENDING RADIUS NOT LESS THAN 90 DEGREES.
11. ACCEPTABLE CONNECTIONS FOR GROUNDING SYSTEM SHALL BE:
 - A. BURNDY, HY-GRADE U.L. LISTED CONNECTORS FOR OUTDOOR USE OR AS APPROVED BY APPLICANT PROJECT MANAGER.
 - B. COLDWELD, EXOTHERMIC WELDS (WELDED CONNECTIONS).
 - C. ONE (1) OR (2) HOLES TINNED COPPER COMPRESSION (LONG BARREL) FITTINGS.
12. ALL CRIMPED CONNECTIONS SHALL HAVE EMBOSSED MANUFACTURER'S DEMARK VISIBLE AT THE CRIMP (RESULTING FROM USE OF PROPER CRIMPING DEVICES) AND WEATHER-PROOFED WITH HEAT SHRINK.
13. ALL CONNECTION HARDWARE SHALL BE TYPE 3-16 STAINLESS STEEL (NOT ATTRACTED TO MAGNETS).
14. ELECTRICAL SERVICE EQUIPMENT GROUNDING SHALL COMPLY WITH NEC, ARTICLE 250-82 AND SHALL BOND ALL (E) AND NEW GROUNDING ELECTRODES. NEW GROUNDING ELECTRODE SHALL INCLUDE BUT NOT LIMITED TO GROUND RODS.

TESTING AND EQUIPMENT TURN UP REQUIREMENTS:

1. RF CABLE, DATA CABLE, RADIO EQUIPMENT AND BACK HAUL EQUIPMENT TESTING WILL COMPLY WITH CURRENT INDUSTRY STANDARDS AND OR THOSE STANDARDS OF THE EQUIPMENT MANUFACTURER OR PROVIDED TO THE CONTRACTOR PRIOR TO TESTING.
2. CONTRACTOR WILL USE THE APPROPRIATE CALIBRATED TESTING EQUIPMENT IN THE TESTING OF RF CABLE, DATA CABLE, RADIO EQUIPMENT AND BACK HAUL EQUIPMENT THAT MEET INDUSTRY STANDARDS OF THE MANUFACTURER OR THOSE STANDARDS PROVIDED TO THE CONTRACTOR PRIOR TO TESTING.

3. CONTRACTOR TO VERIFY AND RECORD ALL TEST RESULTS AND PROVIDE THESE RESULTS WITHIN THE FINAL CLOSE OUT PACKAGE.
4. ALL PERSONNEL INVOLVED IN THE TESTING OF RF CABLE, DATA CABLE, RADIO EQUIPMENT AND BACK HAUL EQUIPMENT WILL BE REQUIRED TO HAVE BEEN TRAINED AND OR CERTIFIED IN THE PROPER TESTING OF RF CABLE, DATA CABLE, RADIO EQUIPMENT AND BACK HAUL EQUIPMENT.
5. ALL TEST RESULTS SHALL BE TIME STAMPED, RECORDED AND PRESENTED PRIOR TO ENERGIZING AND TURN UP OF ANY EQUIPMENT.
6. GPS EQUIPMENT (WHEN REQUIRED) IS NOT TO BE TESTED OR ATTACHED TO ANY CABLING DURING TESTING, DOING SO WILL DAMAGE THE GPS UNIT.
7. PRIOR TO TESTING IF THE CONTRACTOR HAS ANY QUESTIONS ABOUT THE TESTING PROCEDURES THEY ARE TO CALL AND OBTAIN ASSISTANCE FROM A QUALIFIED DESIGNATED TESTING REPRESENTATIVE.
8. EQUIPMENT IS NOT TO BE ENERGIZED UNTIL ALL TESTING HAS BEEN COMPLETED, APPROVED AND THE APPROPRIATE AUTHORITY HAS BEEN NOTIFIED AND GIVES APPROVAL TO ENERGIZE THE EQUIPMENT.

SITE WORK NOTES:

1. DO NOT EXCAVATE OR DISTURB BEYOND THE PROPERTY LINES OR LEASE LINES, UNLESS OTHERWISE NOTED.
2. SIZE, LOCATION AND TYPE OF ANY UNDERGROUND UTILITIES OR IMPROVEMENTS SHALL BE ACCURATELY NOTED AND PLACED ON AS-BUILT DRAWINGS BY GENERAL CONTRACTOR AND ISSUED TO ARCHITECT/ENGINEER AT COMPLETION OF PROJECT.
3. ALL (E) UTILITIES, FACILITIES, CONDITIONS AND THEIR DIMENSIONS SHOWN ON PLANS HAVE BEEN PLOTTED FROM AVAILABLE RECORDS. THE ENGINEER AND OWNER ASSUME NO RESPONSIBILITY WHATSOEVER AS TO THE SUFFICIENCY OR ACCURACY OF THE INFORMATION SHOWN ON THE PLANS OR THE MANNER OF THEIR REMOVAL OR ADJUSTMENT. CONTRACTOR SHALL BE RESPONSIBLE FOR DETERMINING EXACT LOCATION OF ALL (E) UTILITIES AND FACILITIES PRIOR TO START OF CONSTRUCTION. CONTRACTOR SHALL ALSO OBTAIN FROM EACH UTILITY COMPANY DETAILED INFORMATION RELATIVE TO WORKING SCHEDULES AND METHODS OF REMOVING OR ADJUSTING (E) UTILITIES.
4. CONTRACTOR SHALL VERIFY ALL (E) UTILITIES BOTH HORIZONTALLY AND VERTICALLY PRIOR TO START OF CONSTRUCTION. ANY DISCREPANCIES OR DOUBTS AS TO THE INTERPRETATION OF PLANS SHALL BE IMMEDIATELY REPORTED TO THE ARCHITECT/ENGINEER OR MOBILITIE CM FOR RESOLUTION AND INSTRUCTION, AND NO FURTHER WORK SHALL BE PERFORMED UNTIL THE DISCREPANCY IS CHECKED AND CORRECTED BY THE ARCHITECT/ENGINEER. FAILURE TO SECURE SUCH INSTRUCTION MEANS CONTRACTOR WILL HAVE WORKED AT THEIR OWN RISK AND EXPENSE. CONTRACTOR SHALL CALL LOCAL UTILITY LOCATE HOT LINE, SUCH AS 811, FOR UTILITY LOCATIONS A MINIMUM OF 48 HOURS PRIOR TO START OF CONSTRUCTION.
5. ALL NEW AND (E) UTILITY STRUCTURES ON SITE AND IN AREAS TO BE DISTURBED BY CONSTRUCTION SHALL BE ADJUSTED TO FINISH ELEVATIONS PRIOR TO FINAL INSPECTION OF WORK. ANY COST RELATED TO ADJUSTING (E) STRUCTURES SHALL BE BORNE SOLELY BY THE CONTRACTOR.
6. GRADING OF THE SITE WORK AREA IS TO BE SMOOTH AND CONTINUOUS IN SLOPE AND IS TO FEATHER INTO (E) GRADES AT THE GRADING LIMITS.
7. ALL TEMPORARY EXCAVATIONS FOR THE INSTALLATION OF FOUNDATIONS, UTILITIES, ETC., SHALL BE PROPERLY LAID BACK OR BRACED IN ACCORDANCE WITH CORRECT OCCUPATIONAL SAFETY AND HEALTH ADMINISTRATION (OSHA) REQUIREMENTS.

mobilitie

PROJECT NO: SFLB000315P
DRAWN BY: RC
CHECKED BY: SJB

D 01-08-18 REVISION
C 11-28-17 REVISION
B 10-17-17 REVISION
A 09-03-17 FOR CLIENT REVIEW



M190XSL78F
MIAMI BEACH, FL 33139 ' 24'-6"
STEEL POLE

SHEET TITLE
GENERAL NOTES

SHEET NUMBER
GN-2

SITE WORK NOTES CONT'D

8. STRUCTURAL FILLS SUPPORTING PAVEMENTS SHALL BE COMPACTED TO 95% OF MAXIMUM STANDARD PROCTOR DRY DENSITY, UNLESS OTHERWISE NOTED.

9. NEW GRADES NOT IN BUILDING AND DRIVEWAY IMPROVEMENT AREA TO BE ACHIEVED BY FILLING WITH APPROVED CLEAN FILL AND COMPACTED TO 95% OF STANDARD PROCTOR DENSITY.

10. ALL FILL SHALL BE PLACED IN UNIFORM LIFTS. THE LIFTS THICKNESS SHOULD NOT EXCEED THAT WHICH CAN BE PROPERLY COMPACTED THROUGHOUT ITS ENTIRE DEPTH WITH THE EQUIPMENT AVAILABLE.

11. ANY FILLS PLACED ON (E) SLOPES THAT ARE STEEPER THAN 10 HORIZONTAL TO 1 VERTICAL SHALL BE PROPERLY BENCHED INTO THE (E) SLOPE AS DIRECTED BY A GEOTECHNICAL ENGINEER.

12. CONTRACTOR SHALL CLEAN ENTIRE SITE AFTER CONSTRUCTION SUCH THAT NO DEBRIS, PAPER, TRASH, WEEDS, BRUSH, EXCESS FILL, OR ANY OTHER DEPOSITS WILL REMAIN. ALL MATERIALS COLLECTED DURING CLEANING OPERATIONS SHALL BE DISPOSED OF OFF-SITE BY THE GENERAL CONTRACTOR.

13. ALL TREES AND SHRUBS WHICH ARE NOT IN DIRECT CONFLICT WITH THE IMPROVEMENTS SHALL BE PROTECTED BY THE GENERAL CONTRACTOR.

14. ALL SITE WORK SHALL BE CAREFULLY COORDINATED BY GENERAL CONTRACTOR WITH LOCAL UTILITY COMPANY, TELEPHONE COMPANY, AND ANY OTHER UTILITY COMPANIES HAVING JURISDICTION OVER THIS LOCATION.

ENVIRONMENTAL NOTES:

1. ALL WORK PERFORMED SHALL BE DONE IN ACCORDANCE WITH ISSUED PERMITS. THE CONTRACTOR SHALL BE RESPONSIBLE FOR PAYMENT OF FINES AND PROPER CLEAN UP FOR AREAS IN VIOLATION.

2. CONTRACTOR SHALL BE RESPONSIBLE FOR CONSTRUCTION AND MAINTENANCE OF EROSION AND SEDIMENTATION CONTROLS DURING CONSTRUCTION FOR PROTECTION OF ADJACENT PROPERTIES, ROADWAYS AND WATERWAYS. ALL EROSION AND SEDIMENTATION CONTROLS SHALL BE MAINTAINED IN PLACE THROUGH FINAL JURISDICTIONAL INSPECTION & RELEASE OF SITE.

3. CONTRACTOR SHALL INSTALL/CONSTRUCT ALL NECESSARY SEDIMENT/SILT CONTROL FENCING AND PROTECTIVE MEASURES AS REQUIRED BY THE LOCAL JURISDICTION WITHIN THE LIMITS OF SITE DISTURBANCE PRIOR TO CONSTRUCTION.

4. NO SEDIMENT SHALL BE ALLOWED TO EXIT THE PROPERTY. THE CONTRACTOR IS RESPONSIBLE FOR TAKING ADEQUATE MEASURES FOR CONTROLLING EROSION. ADDITIONAL SEDIMENT CONTROL FENCING MAY BE REQUIRED IN ANY AREAS SUBJECT TO EROSION.

5. THE CONTRACTOR IS RESPONSIBLE FOR MAINTAINING POSITIVE DRAINAGE ON THE SITE AT ALL TIMES WITH SILT AND EROSION CONTROL MEASURES MAINTAINED ON THE DOWNSTREAM SIDE OF SITE DRAINAGE. ANY DAMAGE TO ADJACENT PROPERTY AS A RESULT OF EROSION WILL BE CORRECTED AT THE CONTRACTORS EXPENSE.

6. CONTRACTOR SHALL BE RESPONSIBLE FOR DAILY INSPECTIONS AND ANY REPAIRS OF ALL SEDIMENT CONTROL MEASURES INCLUDING SEDIMENT REMOVAL AS NECESSARY.

7. CLEARING OF VEGETATION AND TREE REMOVAL SHALL BE ONLY AS PERMITTED AND BE HELD TO A MINIMUM. ONLY TREES NECESSARY FOR CONSTRUCTION OF THE FACILITIES SHALL BE REMOVED.

8. SEEDING AND MULCHING AND/OR SODDING OF THE SITE WILL BE ACCOMPLISHED AS SOON AS POSSIBLE AFTER COMPLETION OF THE PROJECT FACILITIES AFFECTING LAND DISTURBANCE.

9. CONTRACTOR SHALL PROVIDE ALL EROSION AND SEDIMENTATION CONTROL MEASURES AS REQUIRED BY LOCAL AND STATE CODES AND ORDINANCES TO PROTECT EMBANKMENTS FROM SOIL LOSS AND TO PREVENT ACCUMULATION OF SOIL AND SILT IN STREAMS AND DRAINAGE PATHS LEAVING THE CONSTRUCTION AREA. THIS MAY INCLUDE, BUT IS NOT LIMITED TO SUCH MEASURES AS SILT FENCES, STRAW BALE SEDIMENT BARRIERS, AND CHECK DAMS.

10. RIP RAP OF SIZES INDICATED SHALL CONSIST OF CLEAN, HARD, SOUND, DURABLE, UNIFORM IN QUALITY STONE FREE OF ANY DETRIMENTAL QUANTITY OF SOFT, FRIABLE, THIN, ELONGATED OR LAMINATED PIECES, DISINTEGRATED MATERIAL, ORGANIC MATTER, OIL, ALKALI, OR OTHER DELETERIOUS SUBSTANCES.

11. GC TO PLACE FILTER MATERIAL AT ALL CATCH BASINS ADJACENT TO CONSTRUCTION SITE TO PREVENT SOLID WASTE CONTAMINATION FROM ENTERING SEWER SYSTEM

FOUNDATION, EXCAVATION AND BACKFILL NOTES:

1. ALL FINAL GRADED SLOPES SHALL BE A MAXIMUM OF 3 HORIZONTAL TO 1 VERTICAL, UNLESS OTHERWISE NOTED.

2. BACKFILL OF THE POLE SHALL BE PERFORMED BASED ON THE WATER TABLE. FLOWABLE FILL MIXTURES PURCHASED FROM CONCRETE PLANTS WILL BE USED INSTEAD OF FOAM IN WATER TABLE AREAS.

A: NORMAL SOIL ORDER OF PREFERENCE – FOAM, FLOWABLE FILL, CONCRETE, COMPACTED AGGREGATES

B: HIGH WATER TABLE SOILS ORDER OF PREFERENCES – FLOWABLE FILL, CONCRETE, COMPACTED AGGREGATES.

3. ALL EXCAVATIONS PREPARED FOR PLACEMENT OF CONCRETE SHALL BE OF UNDISTURBED SOILS, SUBSTANTIALLY HORIZONTAL AND FREE FROM ANY LOOSE, UNSUITABLE MATERIAL OR FROZEN SOILS, AND WITHOUT THE PRESENCE OF POUNDING WATER. DEWATERING FOR EXCESS GROUND WATER SHALL BE PROVIDED WHEN REQUIRED. COMPACTION OF SOILS UNDER CONCRETE PAD FOUNDATIONS SHALL NOT BE LESS THAN 90% OF THE MOOFTED PROCTOR MAXIMUM DRY DENSITY FOR THE SOIL IN ACCORDANCE WITH ASTM D1557.

4. CONCRETE FOUNDATIONS SHALL NOT BE PLACED ON ORGANIC OR UNSUITABLE MATERIAL. IF ADEQUATE BEARING CAPACITY IS NOT ACHIEVED AT THE DESIGNED EXCAVATION DEPTH, THE UNSATISFACTORY SOIL SHALL BE EXCAVATED TO ITS FULL DEPTH AND EITHER BE REPLACED WITH MECHANICALLY COMPACTED GRANULAR MATERIAL OR THE EXCAVATION SHALL BE FILLED WITH CONCRETE OF THE SAME TYPE SPECIFIED FOR THE FOUNDATION. CRUSHED LIME STONE #57 MAY BE USED TO STABILIZE THE BOTTOM OF THE EXCAVATION. ANY STONE SUB BASE MATERIAL, IF USED, SHALL NOT SUBSTITUTE FOR REQUIRED THICKNESS OF CONCRETE.

5. ALL EXCAVATIONS SHALL BE CLEAN OF UNSUITABLE MATERIAL SUCH AS VEGETATION, TRASH, DEBRIS, AND SO FORTH PRIOR TO BACK FILLING. BACK FILL SHALL CONSIST OF APPROVED MATERIALS SUCH AS EARTH, LOAM, SANDY CLAY, SAND AND GRAVEL, OR SOFT SHALE, FREE FROM CLODS OR LARGE STONES OVER 2 1/2" MAX DIMENSIONS. ALL BACK FILL SHALL BE PLACED IN COMPACTED LAYERS.

6. ALL FILL MATERIALS AND FOUNDATION BACK FILL SHALL BE PLACED IN MAXIMUM 6" THICK LIFTS BEFORE COMPACTION. EACH LIFT SHALL BE WETTED IF REQUIRED AND COMPACTED TO NOT LESS THAN 95% OF THE MODIFIED PROCTOR MAXIMUM DRY DENSITY FOR SOIL IN ACCORDANCE WITH ASTM D1557.

7. NEWLY PLACED CONCRETE FOUNDATIONS SHALL CURE A MINIMUM OF 72 HRS PRIOR TO BACK FILLING.

8. FINISHED GRADING SHALL BE SLOPED TO PROVIDE POSITIVE DRAINAGE AND PREVENT STANDING WATER. THE FINAL (FINISH) ELEVATION OF SLAB FOUNDATIONS SHALL SLOPE AWAY IN ALL DIRECTIONS FROM THE CENTER. FINISH GRADE OF CONCRETE PADS SHALL BE A MAXIMUM OF 4 INCHES ABOVE FINAL FINISH GRADE ELEVATIONS. PROVIDE SURFACE FILL GRAVEL TO ESTABLISH SPECIFIED ELEVATIONS WHERE REQUIRED.

9. NEWLY GRADED GRAVEL SURFACE AREAS TO RECEIVE GRAVEL SHALL BE COVERED WITH GEOTEXTILE FABRIC TYPE: TYPAR-3401 AS MANUFACTURED BY TYPAR GEOSYNTHETICS OR AN APPROVED EQUIVALENT. SHOWN ON PLANS. THE GEOTEXTILE FABRIC SHALL BE BLACK IN COLOR TO CONTROL THE RECURRENT OF VEGETATIVE GROWTH AND EXTEND TO WITHIN 1 FOOT OUTSIDE THE SITE FENCING OR ELECTRICAL GROUNDING SYSTEM PERIMETER WHICH EVER IS GREATER. ALL FABRIC SHALL BE COVERED WITH A MINIMUM OF 4" DEEP COMPACTED STONE OR GRAVEL AS SPECIFIED. I.E. FOOT TYPE NO. 57 FOR FENCED COMPOUND; FOOT TYPE NO. 67 FOR ACCESS DRIVE AREA, UNLESS OTHERWISE NOTED.

10. IN ALL AREAS TO RECEIVE FILL: REMOVE ALL VEGETATION, TOPSOIL, DEBRIS, WET AND UNSATISFACTORY SOIL MATERIALS, OBSTRUCTIONS, AND DELETERIOUS MATERIALS FROM GROUND SURFACE. PLOW STRIP OR BREAK UP SLOPED SURFACES STEEPER THAN 1 VERTICAL TO A HORIZONTAL SUCH THAT FILL MATERIAL WILL BIND WITH (E)/PREPARED SOIL SURFACE.

11. WHEN SUB GRADE OR PREPARED GROUND SURFACE HAS A DENSITY LESS THAN THAT REQUIRED FOR THE FILL MATERIAL, SCARIFY THE GROUND SURFACE TO DEPTH REQUIRED, PULVERIZE, MOISTURE-CONDITION AND/OR AERATE THE SOILS AND RECOMPACT TO THE REQUIRED DENSITY PRIOR TO PLACEMENT OF FILLS.

12. IN AREAS WHICH (E) GRAVEL SURFACING IS REMOVED OR DISTURBED DURING

CONSTRUCTION OPERATIONS, REPLACE GRAVEL SURFACING TO MATCH ADJACENT GRAVEL SURFACING AND RESTORED TO THE SAME THICKNESS AND COMPACTION AS SPECIFIED. ALL RESTORED GRAVEL SURFACING SHALL BE FREE FROM CORRUGATIONS AND WAVES.

13. (E) GRAVEL SURFACING MAY NOT BE REUSED.

14. GRAVEL SUB SURFACE SHALL BE PREPARED TO REQUIRED COMPACTION AND SUB GRADE ELEVATIONS BEFORE GRAVEL SURFACING IS PLACED AND/OR RESTORED. ANY LOOSE OR DISTURBED MATERIALS SHALL BE THOROUGHLY COMPACTED AND ANY DEPRESSIONS IN THE SUB GRADE SHALL BE FILLED AND COMPACTED WITH APPROVED SELECTED MATERIAL. GRAVEL SURFACING MATERIAL SHALL NOT BE USED FOR FILLING DEPRESSIONS IN THE SUB GRADE.

15. PROTECT (E) GRAVEL SURFACING AND SUB GRADE IN AREAS WHERE EQUIPMENT LOADS WILL OPERATE. USE PLANKING 'MATS' OR OTHER SUITABLE PROTECTION DESIGNED TO SPREAD EQUIPMENT LOADS AS MAY BE NECESSARY. REPAIR ANY DAMAGE TO (E) GRAVEL SURFACING OR SUB GRADE WHERE SUCH DAMAGE IS DUE TO THE CONTRACTORS OPERATIONS.

16. DAMAGE TO (E) STRUCTURES AND/OR UTILITIES RESULTING FROM CONTRACTORS NEGLIGENCE SHALL BE REPAIRED AND/ OR REPLACED TO THE OWNERS SATISFACTION AT NO ADDITIONAL COST TO THE CONTRACT.

17. ALL SUITABLE BORROW MATERIAL FOR BACK FILL OF THE SITE SHALL BE INCLUDED IN THE BID. EXCESS TOPSOIL AND UNSUITABLE MATERIAL SHALL BE DISPOSED OF OFF SITE AT LOCATIONS APPROVED BY GOVERNING AGENCIES AT NO ADDITIONAL COST TO THE CONTRACT.

mobilitie

PROJECT NO: SFLB000315P


DRAWN BY: RC

CHECKED BY: SUB

D	01-08-18	REVISION
C	11-28-17	REVISION
B	05-17-17	REVISION
A	09-03-17	FOR CLIENT REVIEW

KMB DESIGN GROUP, LLC

Stephen A. Bray

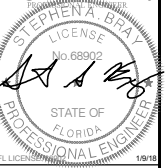

IT IS A VIOLATION OF THE LAW FOR ANY PERSON, UNLESS THEY ARE A LICENSED PROFESSIONAL ENGINEER, TO ALTER THIS DOCUMENT

M190XSL78F

MIAMI BEACH, FL 33139 ' 24'-6"

STEEL POLE

SHEET TITLE

GENERAL NOTES

SHEET NUMBER

GN-3

SPECIAL PURPOSE SURVEY

SECTION 4, TOWNSHIP 33 SOUTH, RANGE 42 EAST
MIAMI-DADE COUNTY, FLORIDA
FOR: KIMLEY-HORN




SUNSHINE STATE ONE CALL
TICKET: 244705529

FLOOD NOTE


ACCORDING TO MY INTERPRETATION OF COMMUNITY PANEL NUMBER 120651 0319 L OF THE FEDERAL EMERGENCY MANAGEMENT AGENCY (FEMA) NATIONAL FLOOD INSURANCE PROGRAM (NFIP) FLOOD INSURANCE RATE MAP (FIRM) FOR THE CITY OF MIAMI BEACH, MIAMI-DADE COUNTY, FLORIDA, DATED 9/11/2008, THE SUBJECT PROPERTY IS IN FLOOD ZONE "AE", IE, "SPECIAL FLOOD HAZARD AREAS SUBJECT TO INUNDATION BY THE 1% ANNUAL CHANCE FLOOD; BASE FLOOD ELEVATIONS DETERMINED".

NOTE: THE BASE FLOOD ELEVATION DEPICTED ON THE COMMUNITY PANEL, FOR THE LOCATION OF THE SUBJECT LIGHT POLE, IS 8' NGVD29, WHICH CORRESPONDS TO AN ELEVATION OF 6.6' NAVD88.

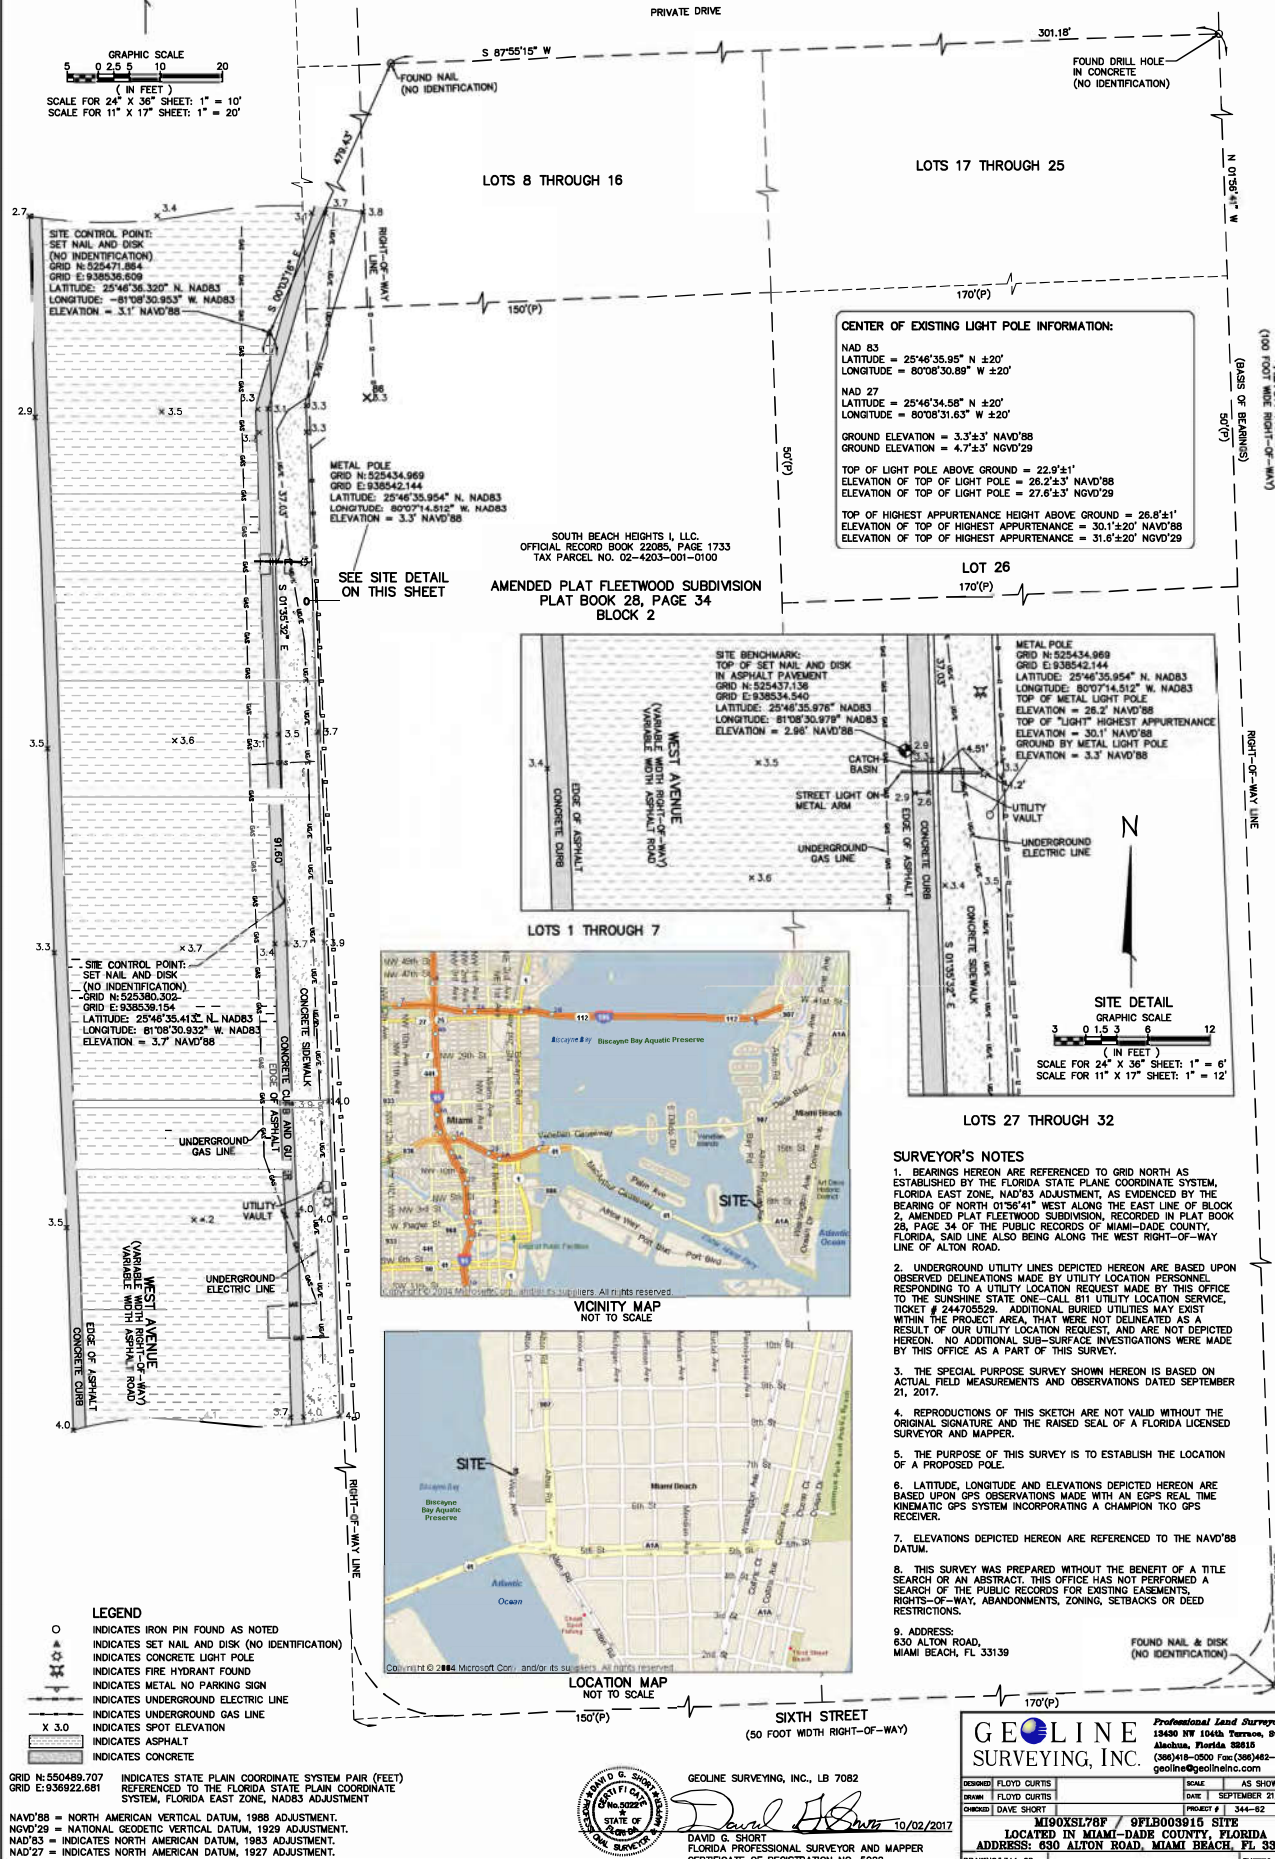

CENTER OF EXISTING LIGHT POLE INFORMATION:

 NAD 83
LATITUDE = 25°46'35.95" N ±20"
LONGITUDE = 80°08'30.89" W ±20"
NAD 27
LATITUDE = 25°46'34.58" N ±20"
LONGITUDE = 80°08'31.63" W ±20"
GROUND ELEVATION = 3.3'±3" NAVD88
GROUND ELEVATION = 4.7'±3" NGVD29
TOP OF LIGHT POLE ABOVE GROUND = 22.9'±1"
ELEVATION OF TOP OF LIGHT POLE = 26.2'±3" NAVD88
ELEVATION OF TOP OF LIGHT POLE = 27.8'±3" NGVD29
TOP OF HIGHEST APPURTENANCE HEIGHT ABOVE GROUND = 26.8'±1"
ELEVATION OF TOP OF HIGHEST APPURTENANCE = 30.1'±20" NAVD88
ELEVATION OF TOP OF HIGHEST APPURTENANCE = 31.8'±20" NGVD29



SURVEYOR'S NOTES


1. BEARINGS HEREON ARE REFERENCED TO GRID NORTH AS ESTABLISHED BY THE FLORIDA STATE PLANE COORDINATE SYSTEM, FLORIDA EAST ZONE, NAD83 ADJUSTMENT, AS EVIDENCED BY THE BEARING OF NORTH 01°56'41" WEST ALONG THE EAST LINE OF BLOCK 2, AMENDED PLAT FLEETWOOD SUBDIVISION, RECORDED IN PLAT BOOK 28, PAGE 34 OF THE PUBLIC RECORDS OF MIAMI-DADE COUNTY, FLORIDA, SAID LINE ALSO BEING ALONG THE WEST RIGHT-OF-WAY LINE OF ALTON ROAD.
2. UNDERGROUND UTILITY LINES DEPICTED HEREON ARE BASED UPON OBSERVED DELINEATIONS MADE BY UTILITY LOCATION PERSONNEL RESPONDING TO A UTILITY LOCATION REQUEST MADE BY THIS OFFICE TO THE SUNSHINE STATE ONE-CALL 811 UTILITY LOCATION SERVICE, TICKET # 244705529. ADDITIONAL BURIED UTILITIES MAY EXIST WITHIN THE PROJECT AREA, THAT WERE NOT DELINEATED AS A RESULT OF OUR UTILITY LOCATION REQUEST, AND ARE NOT DEPICTED HEREON. NO ADDITIONAL SUB-SURFACE INVESTIGATIONS WERE MADE BY THIS OFFICE AS A PART OF THIS SURVEY.
3. THE SPECIAL PURPOSE SURVEY SHOWN HEREON IS BASED ON ACTUAL FIELD MEASUREMENTS AND OBSERVATIONS DATED SEPTEMBER 21, 2017.
4. REPRODUCTIONS OF THIS SKETCH ARE NOT VALID WITHOUT THE ORIGINAL SIGNATURE AND THE RAISED SEAL OF A FLORIDA LICENSED SURVEYOR AND MAPPER.
5. THE PURPOSE OF THIS SURVEY IS TO ESTABLISH THE LOCATION OF A PROPOSED POLE.
6. LATITUDE, LONGITUDE AND ELEVATIONS DEPICTED HEREON ARE BASED UPON GPS OBSERVATIONS MADE WITH AN EPOCH REAL TIME KINEMATIC GPS SYSTEM INCORPORATING A CHAMPION T10 GPS RECEIVER.
7. ELEVATIONS DEPICTED HEREON ARE REFERENCED TO THE NAVD88 DATUM.
8. THIS SURVEY WAS PREPARED WITHOUT THE BENEFIT OF A TITLE SEARCH OR AN ABSTRACT. THIS OFFICE HAS NOT PERFORMED A SEARCH OF THE PUBLIC RECORDS FOR EXISTING EASEMENTS, RIGHTS-OF-WAY, ABANDONMENTS, ZONING, SETBACKS OR DEED RESTRICTIONS.
9. ADDRESS: 630 ALTON ROAD, MIAMI BEACH, FL 33139

- LEGEND**
- INDICATES IRON PIN FOUND AS NOTED
 - INDICATES SET NAIL AND DISK (NO IDENTIFICATION)
 - INDICATES CONCRETE LIGHT POLE
 - INDICATES FIRE HYDRANT FOUND
 - INDICATES METAL NO PARKING SIGN
 - INDICATES UNDERGROUND ELECTRIC LINE
 - INDICATES UNDERGROUND GAS LINE
 - INDICATES SPOT ELEVATION
 - INDICATES ASPHALT
 - INDICATES CONCRETE

GRID N:550489.707
GRID E:936922.691
INDICATES STATE PLANE COORDINATE SYSTEM PAIR (FEET)
REFERENCED TO THE FLORIDA STATE PLANE COORDINATE SYSTEM, FLORIDA EAST ZONE, NAD83 ADJUSTMENT
NAVD88 = NORTH AMERICAN VERTICAL DATUM, 1988 ADJUSTMENT.
NGVD29 = NATIONAL GEODETIC VERTICAL DATUM, 1929 ADJUSTMENT.
NAD83 = INDICATES NORTH AMERICAN DATUM, 1983 ADJUSTMENT.
NAD27 = INDICATES NORTH AMERICAN DATUM, 1927 ADJUSTMENT.

LOCATION MAP

NOT TO SCALE

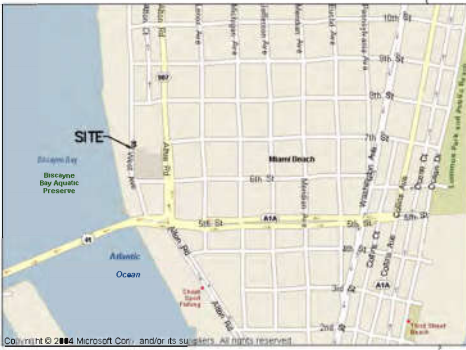

MOBILITY MAP

NOT TO SCALE





GEOLINE SURVEYING, INC., LB 7082
DAVID O. SHORT
FLORIDA PROFESSIONAL SURVEYOR AND MAPPER
CERTIFICATE OF REGISTRATION NO. 5022

Professional Land Surveyor		SCALE	
15430 NW 104th Terrace, Suite A Alachua, Florida 32310 (904)418-0500 Fax (904)412-0998 geoline@geolineinc.com		AS SHOWN	
DESIGNED: FLOYD CURTIS	DATE: SEPTEMBER 21, 2017	PROJECT #	344-82
DRAWN: DAVID SHORT			
LOCATED IN MIAMI-DADE COUNTY, FLORIDA ADDRESS: 630 ALTON ROAD, MIAMI BEACH, FL 33139			
DRAWING# 344-82		SHEET# 1 OF 1	



VIEWS OF
PROPOSED
LOCATION

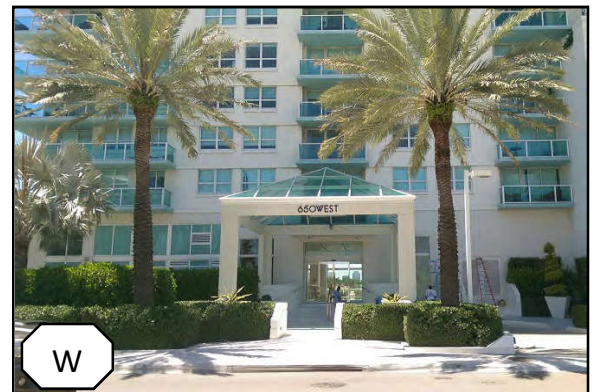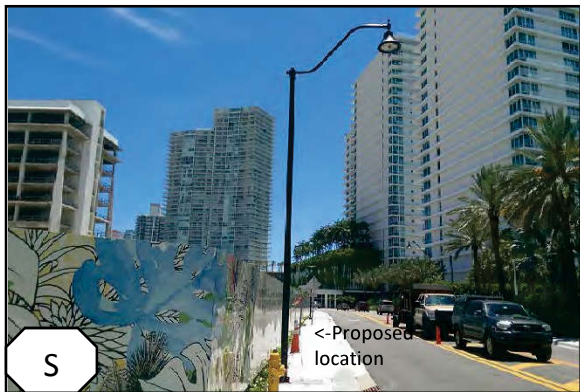

Approximate Address: 651 West Ave

Candidate: MI90XSL78F