

COMPONENTS OF CONTRACT PLANS SET

ROADWAY PLANS
SIGNING AND PAVEMENT MARKING PLANS
SIGNALIZATION PLANS
LIGHTING PLANS
LANDSCAPE PLANS
STRUCTURES PLANS (WEST AVENUE BRIDGE OVER COLLINS CANAL)
STRUCTURES PLANS (LINCOLN COURT PEDESTRIAN BRIDGE)

A DETAILED INDEX APPEARS ON THE
KEY SHEET OF EACH COMPONENT

INDEX OF ROADWAY PLANS

SHEET NO.	SHEET DESCRIPTION
1	KEY SHEET
2 - 6	TYPICAL SECTION
7	SUMMARY OF DRAINAGE STRUCTURES
8	PROJECT LAYOUT SHEET
9	WEST AVENUE PLAN & PROFILE
10 - 12	DADE BOULEVARD PLAN & PROFILE
13	WEST AVENUE SPECIAL PROFILES
14 - 16	DADE BOULEVARD SPECIAL PROFILES
17A- 17F	DRIVEWAY AND ACCESS RAMP DETAIL
18 - 20	INTERSECTION DETAIL
21 - 35	CROSS SECTIONS
36 - 48	TEMPORARY TRAFFIC CONTROL PLAN

GOVERNING STANDARDS AND SPECIFICATIONS:

Florida Department of Transportation, 2016 Design Standards and revised Index Drawings as appended herein, and 2016 Standard Specifications for Road and Bridge Construction, as amended by Contract Documents.

For Design Standards click on the "Design Standards" link at the following web site:
<http://www.dot.state.fl.us/rddesign/>

For the Standard Specifications for Road and Bridge Construction click on the "Specifications" link at the following web site:
<http://www.dot.state.fl.us/specificationoffice/>

REVISIONS



- 1 SIGNALIZATION SHEET T-5
- 1 STRUCTURES SHEETS BI-3, BI-10, BI-14 & BI-20
- 2 LIGHTING SHEETS L-2, L-3, L-4, L-5, L-8, L-9, L-15, L-16, L-17 & L-18
- 3 SIGNALIZATION SHEET T-5
- 4 ROADWAY SHEET NO. 9
SIGNING AND PAVEMENT MARKING SHEET S-3
SIGNALIZATION SHEET T-5
- 5 ROADWAY SHEET 17A
ADDED NEW ROADWAY SHEET 17G

CITY OF MIAMI BEACH

CONTRACT PLANS

WEST AVENUE OVER COLLINS CANAL

MIAMI DADE COUNTY

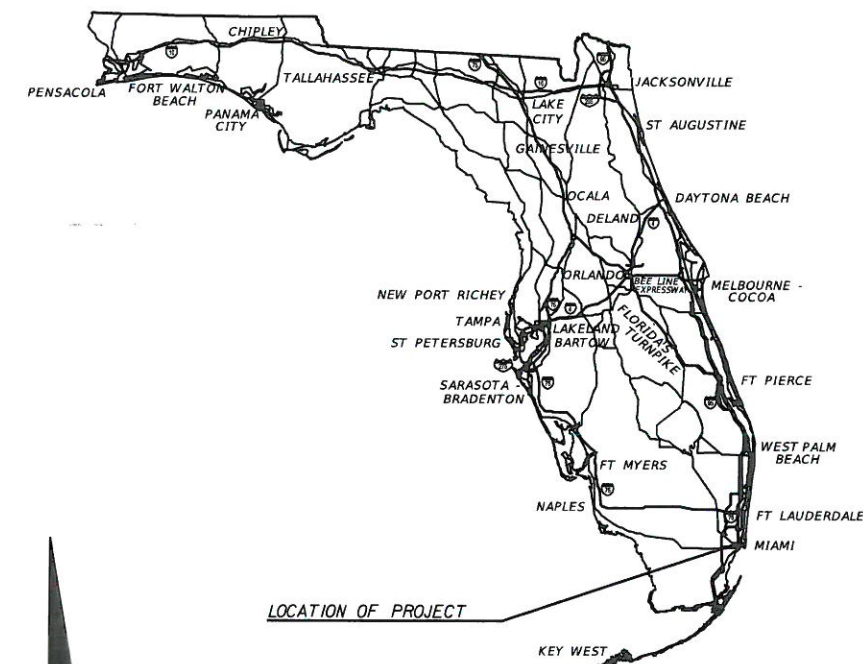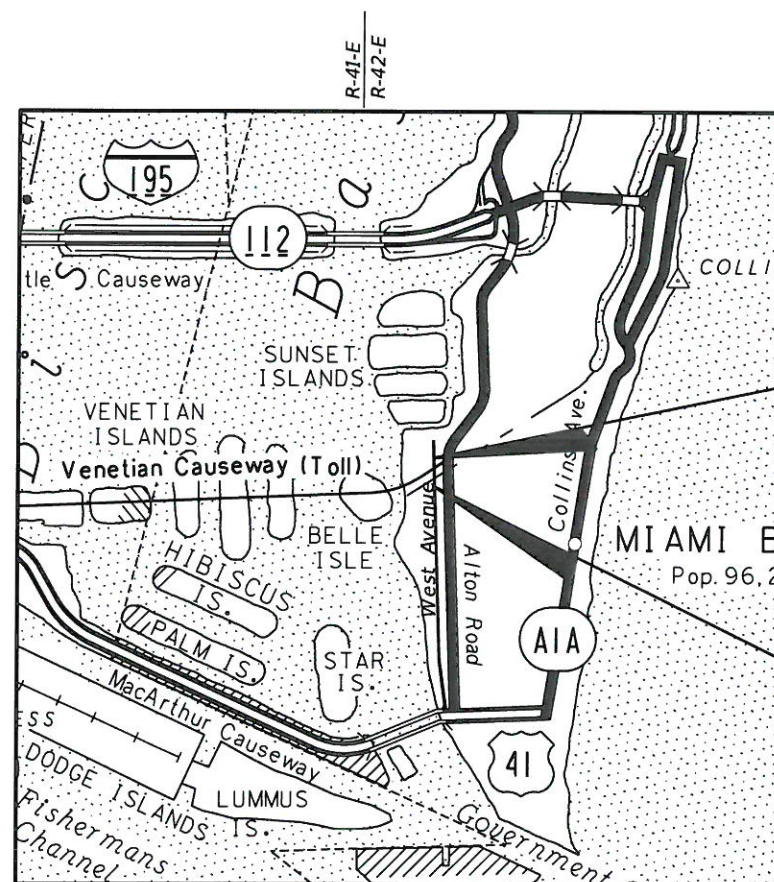


ROADWAY SHOP DRAWINGS TO BE SUBMITTED TO:


S. MARK KLINE, P.E.
KEITH AND SCHNARS, P.A.
6500 NORTH ANDREWS AVENUE
FORT LAUDERDALE, FL 33309-2132

PLANS PREPARED BY:


KEITH and SCHNARS, P.A.
ENGINEERS, PLANNERS, SURVEYORS
6500 NORTH ANDREWS AVENUE
FORT LAUDERDALE, FLORIDA 33309-2132

NOTE: THE SCALE OF THESE PLANS MAY
HAVE CHANGED DUE TO REPRODUCTION.

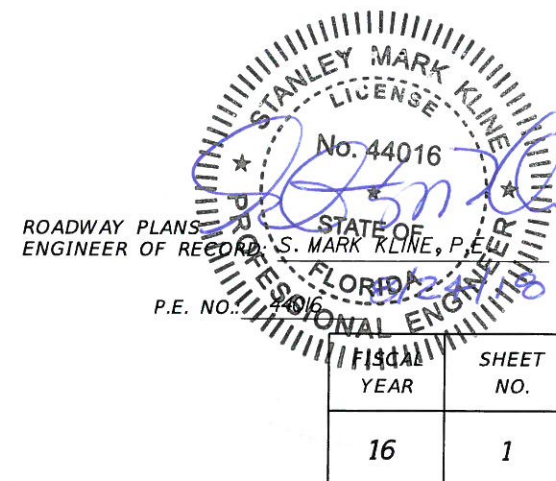

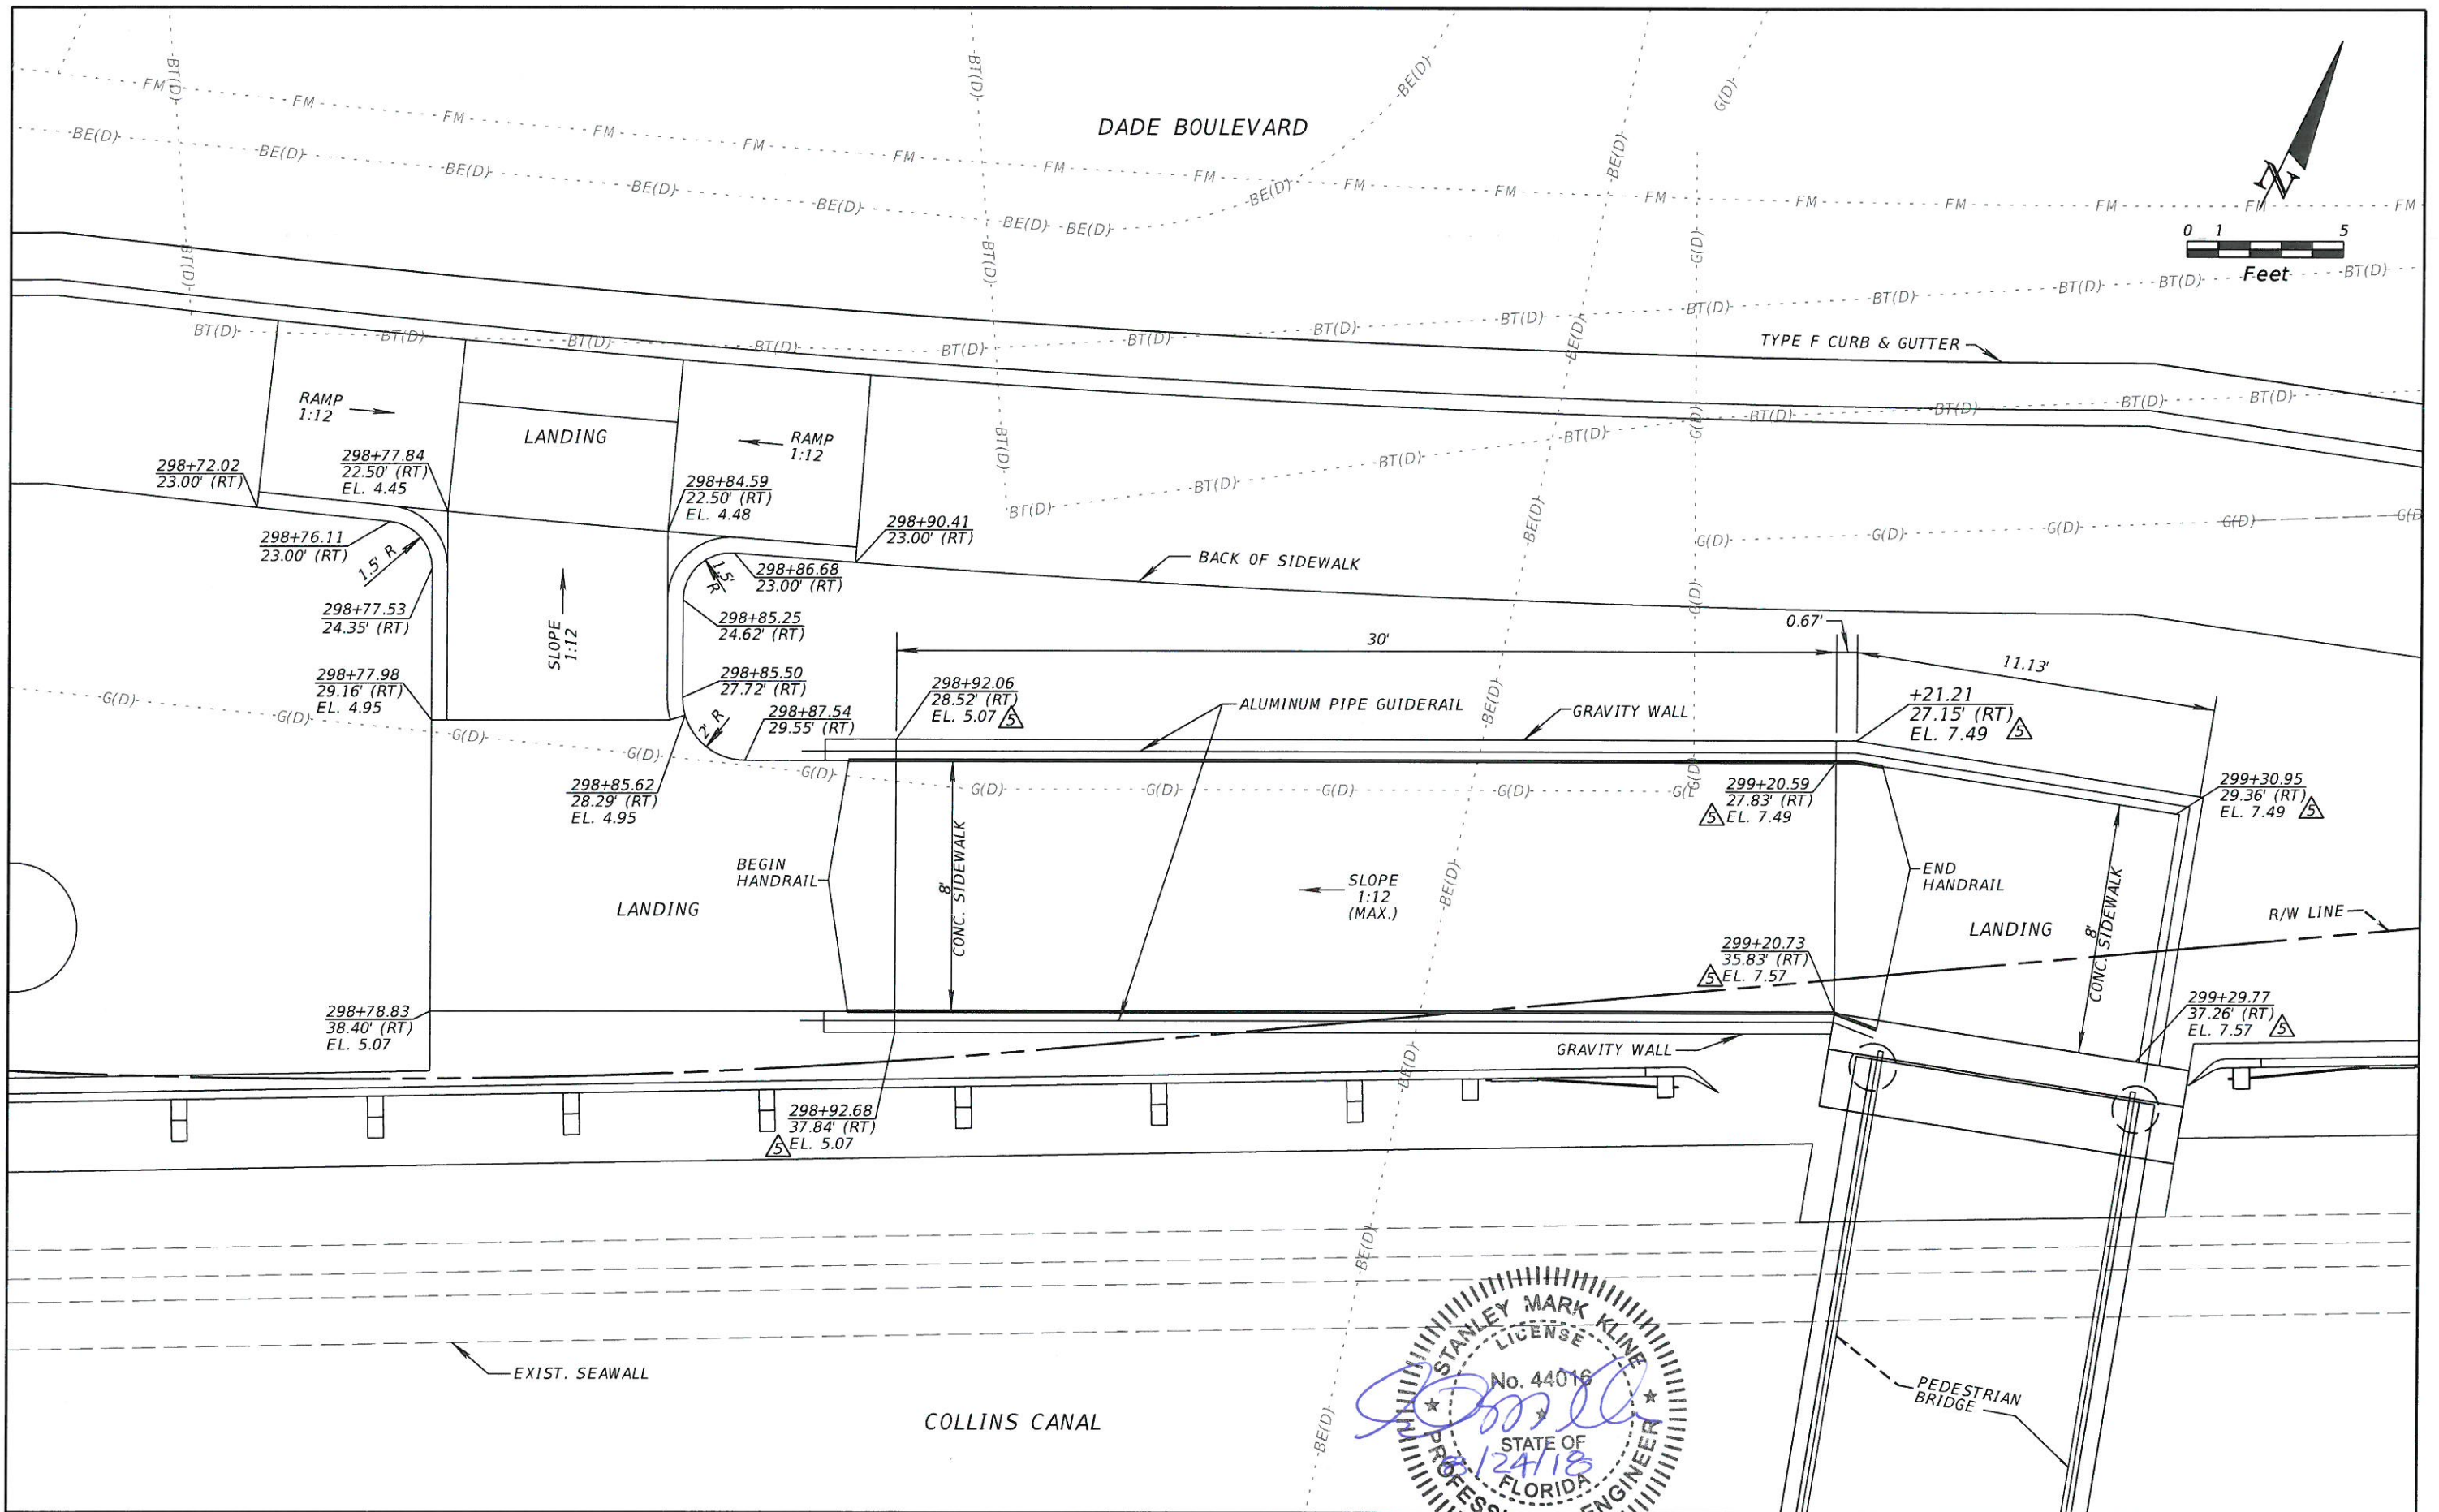

REVISIONS				ENGINEER OF RECORD: S. MARK KLINE P.E. #44016 KEITH and SCHNARS, P.A. ENGINEERS, PLANNERS, SURVEYORS 6500 NORTH ANDREWS AVENUE FORT LAUDERDALE, FLORIDA 33309-2132 (954)776-1616 CERTIFICATE OF AUTHORIZATION NO. 1337	CITY OF MIAMI BEACH ROAD NO. COUNTY FINANCIAL PROJECT ID MIAMI-DADE		DRIVEWAY AND ACCESS RAMP DETAIL	SHEET NO. 17A
DATE	DESCRIPTION	DATE	DESCRIPTION					
6-29-18	REVISED ELEVATION							

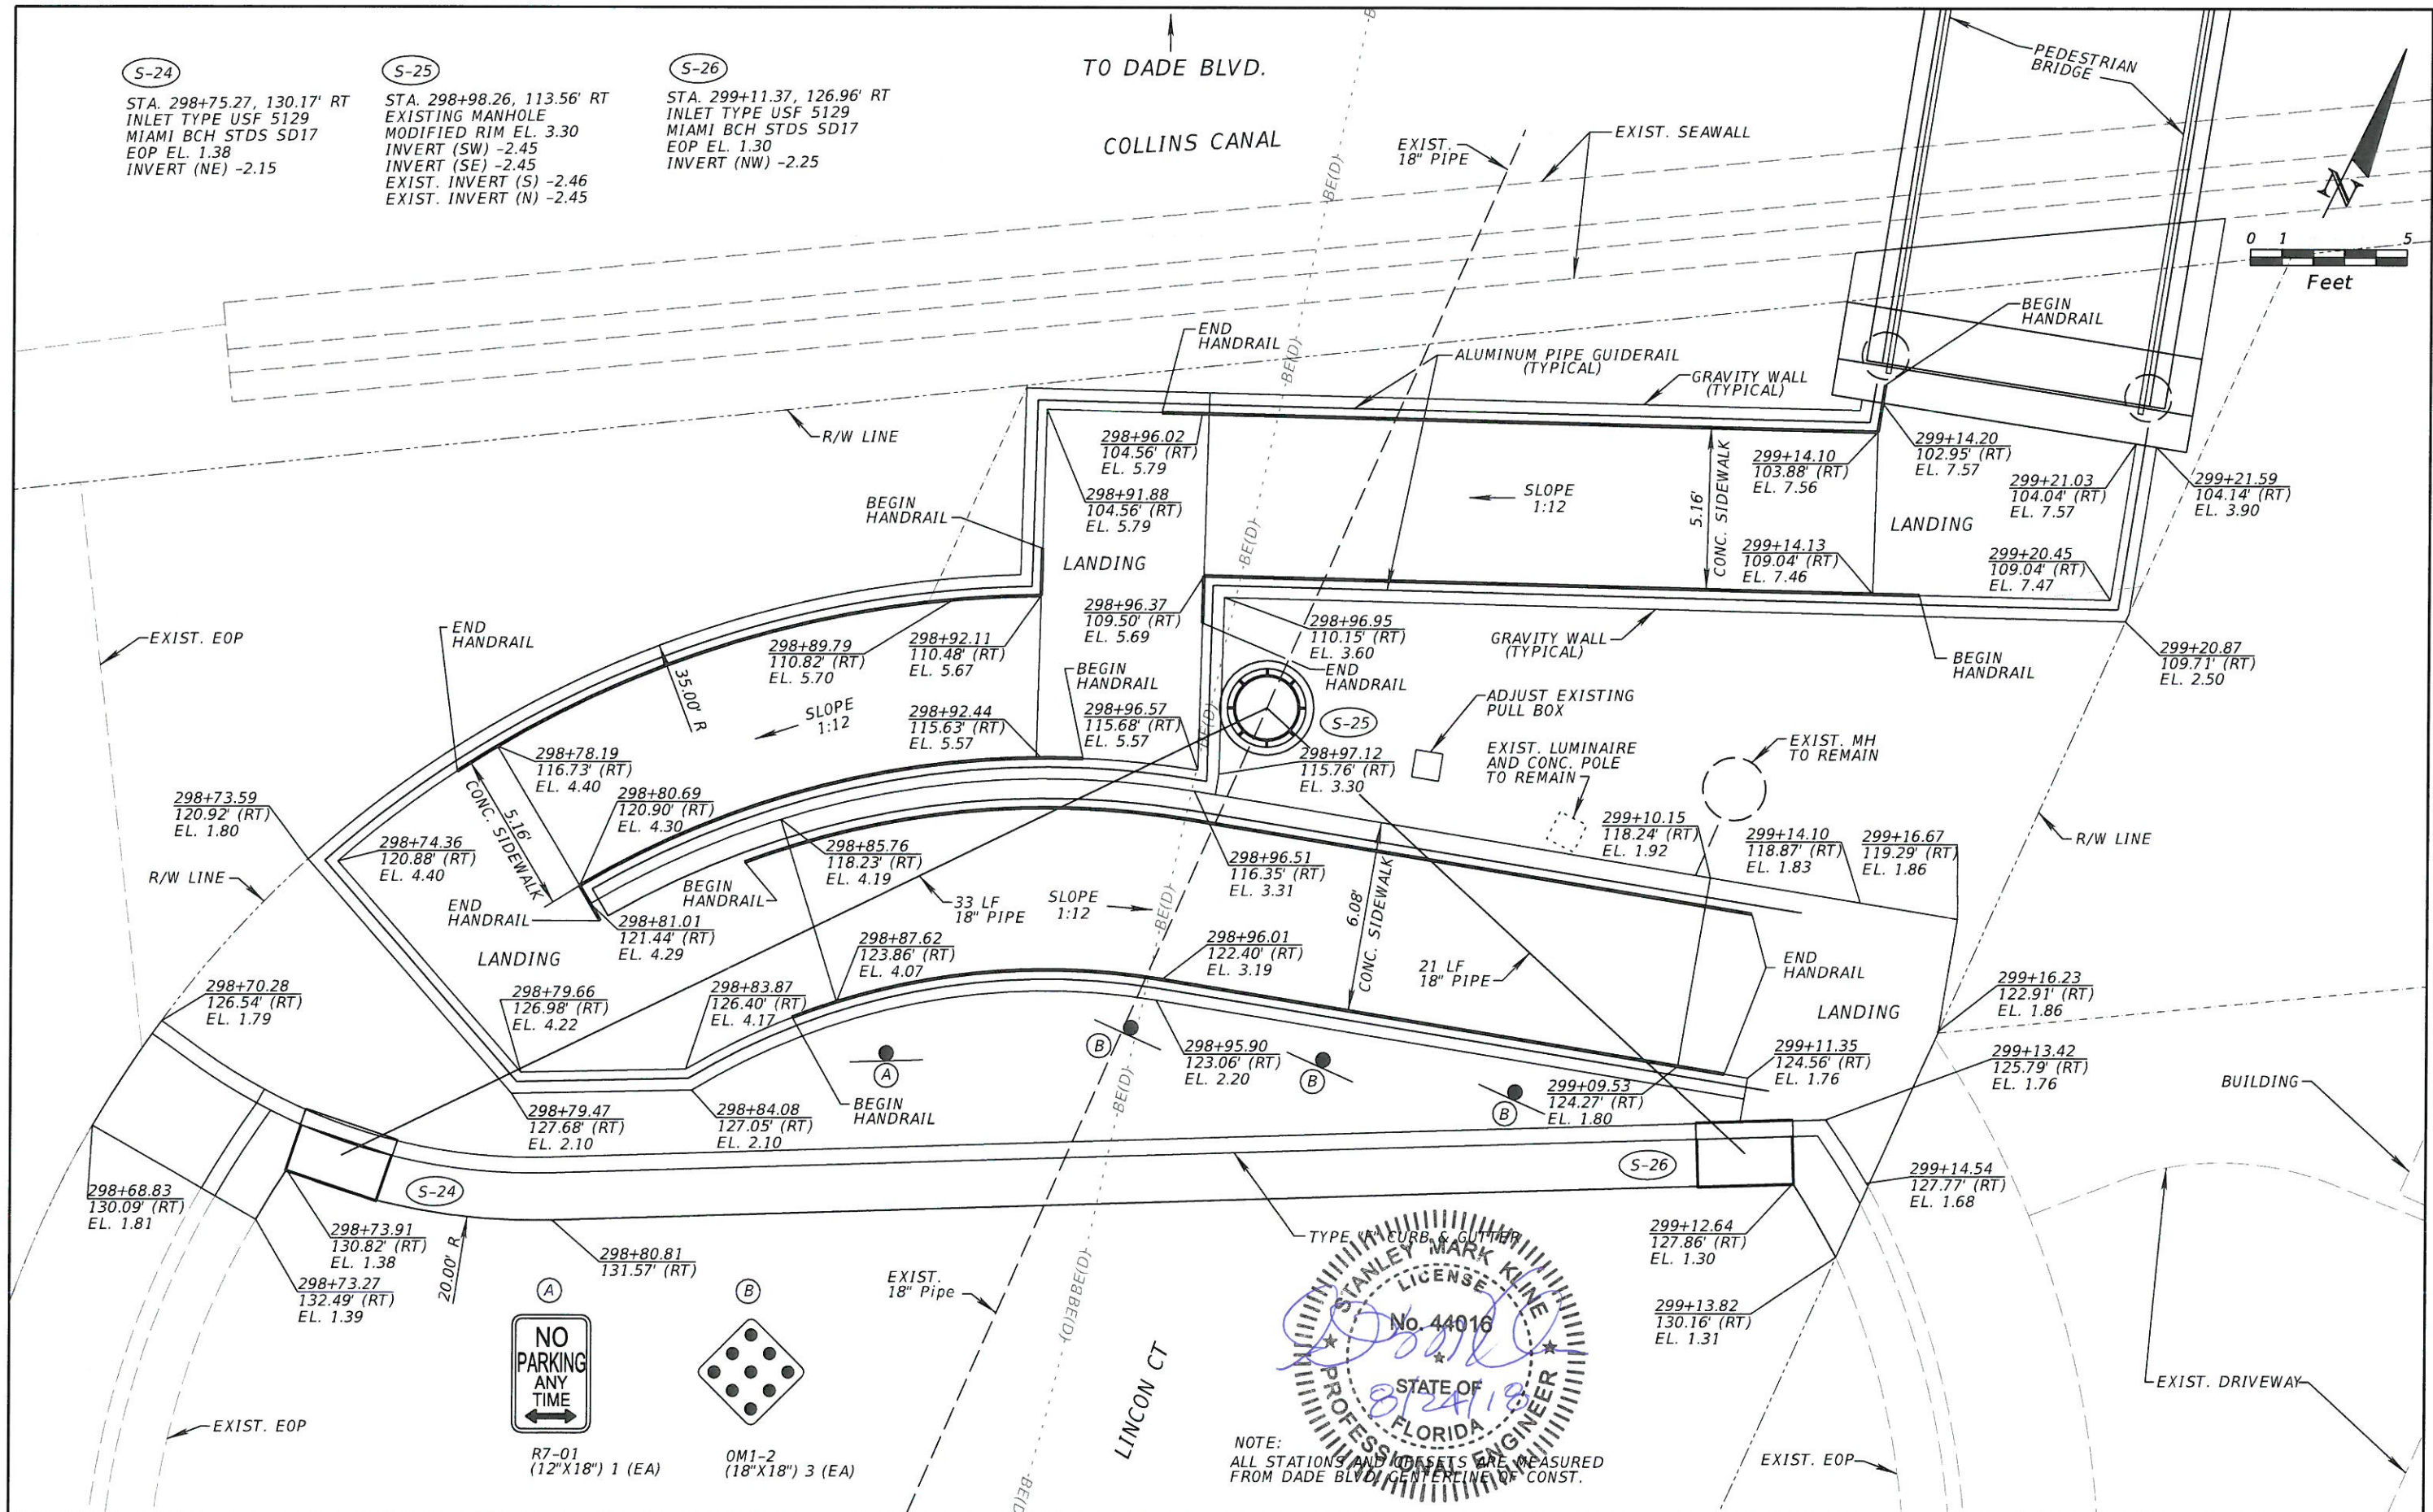

REVISIONS				ENGINEER OF RECORD: S. MARK KLINE P.E. #44016 KEITH and SCHNARS, P.A. ENGINEERS, PLANNERS, SURVEYORS 6500 NORTH ANDREWS AVENUE FORT LAUDERDALE, FLORIDA 33309-2132 (954)776-1616 CERTIFICATE OF AUTHORIZATION NO. 1337	CITY OF MIAMI BEACH			DRIVEWAY AND ACCESS RAMP DETAIL	SHEET NO.
DATE	DESCRIPTION	DATE	DESCRIPTION		ROAD NO.	COUNTY	FINANCIAL PROJECT ID		17G
6-29-18	△ NEW ACCESS RAMP DETAIL SHEET					MIAMI-DADE			

DRIVEWAY
AND ACCESS RAMP DETAIL

NOTE:
ALL STATIONS AND OFFSETS ARE MEASURED
FROM DADE BLVD CENTERLINE OF CONST.

INDEX OF STRUCTURE PLANS


SHEET NO.	SHEET DESCRIPTION
B2-1	KEY SHEET
B2-2	GENERAL NOTES
B2-3	PLAN AND ELEVATION
B2-4	FOUNDATION LAYOUT
B2-5	AUGER CAST PILE DATA
B2-6	END BENT DETAILS (1 OF 2)
B2-7	END BENT DETAILS (2 OF 2)
B2-8	PEDESTRIAN BRIDGE DATA

CITY OF MIAMI BEACH

CONTRACT PLANS

LINCOLN COURT PEDESTRIAN BRIDGE

STRUCTURE PLANS

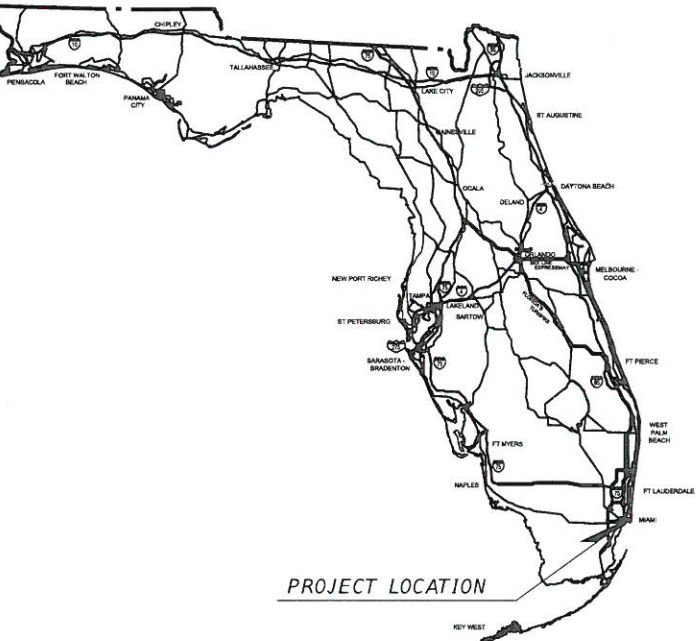

STRUCTURE SHOP DRAWINGS
TO BE SUBMITTED TO:

KEITH & SCHNARS, P.A.
6500 NORTH ANDREWS AVENUE
FORT LAUDERDALE, FL 33309-2332

PLANS PREPARED BY:
KEITH and SCHNARS, P.A.
ENGINEERS, PLANNERS, SURVEYORS
6500 NORTH ANDREWS AVENUE
FORT LAUDERDALE, FLORIDA 33309-2132
(954)776-1616
CERTIFICATE OF AUTHORIZATION NO. 1337

NOTE: THE SCALE OF THESE PLANS MAY
HAVE CHANGED DUE TO REPRODUCTION.

GOVERNING STANDARDS AND SPECIFICATIONS:
Florida Department of Transportation, 2016 Design Standards and
revised Index Drawings as appended herein, and 2016 Standard
Specifications for Road and Bridge Construction, as amended by
Contract Documents.

For Design Standards click on the "Design Standards" link at the
following web site:
<http://www.dot.state.fl.us/rddesign/DesignStandards>

For the Standard Specifications for Road and Bridge Construction
click on the "Specifications" link at the following web site:
<http://www.dot.state.fl.us/specificationsoffice/StandardSpecifications>


REVISIONS
1 LINCOLN COURT PEDESTRIAN BRIDGE, SHEET B2-3

KEY SHEET REVISIONS	
DATE	DESCRIPTION


ROBERTO M. RUBIO-ROACH
LICENSE
No. 48982
STATE OF FLORIDA
PROFESSIONAL ENGINEER
08/24/2018
STRUCTURE PLANS
ENGINEER OF RECORD: ROBERTO M. RUBIO, P.E.
P.E. NO. 48982

SHEET
NO.


B2-1

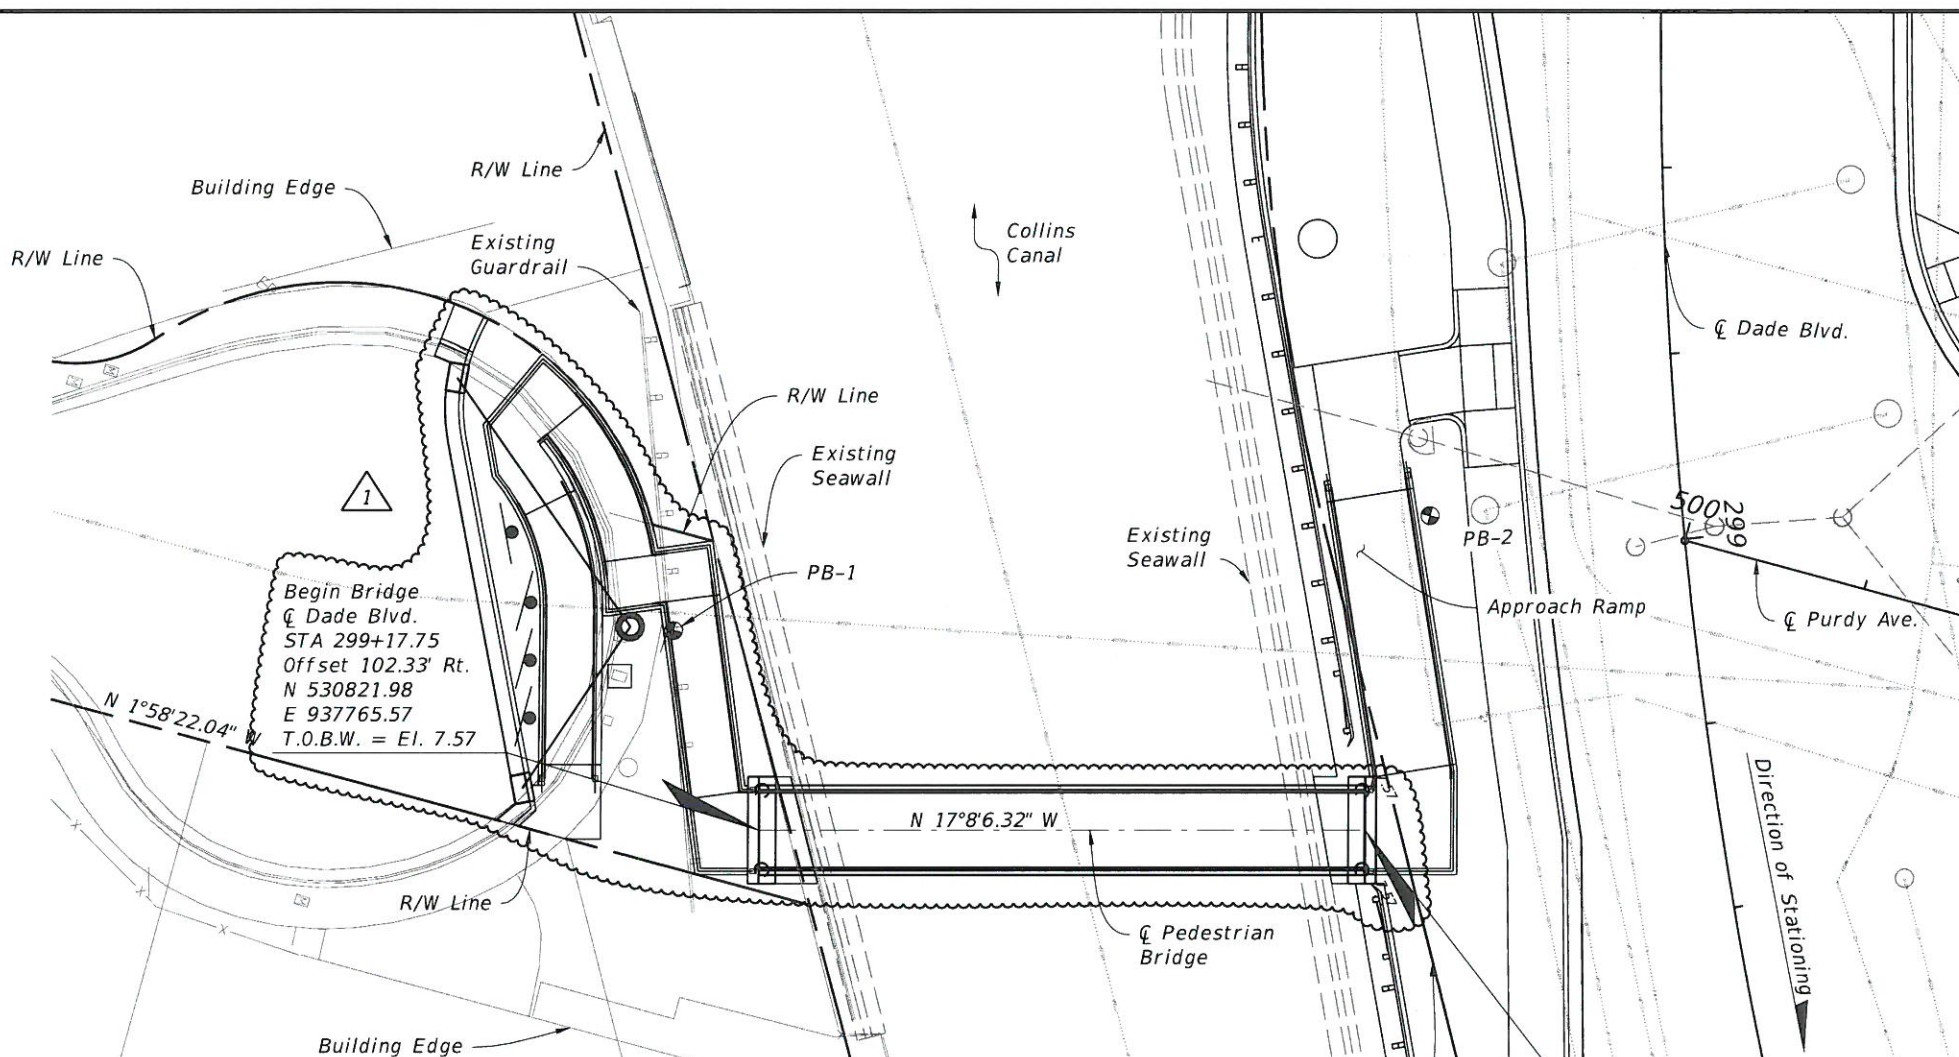

CURVE DATA DADEAMD61
 PI STA. = 298+53.41
 Δ = 27° 07' 11" (LT)
 D = 10° 29' 37"
 T = 131.69
 L = 258.44
 R = 546.00
 PC STA. = 297+21.72
 PT STA. = 299+80.16

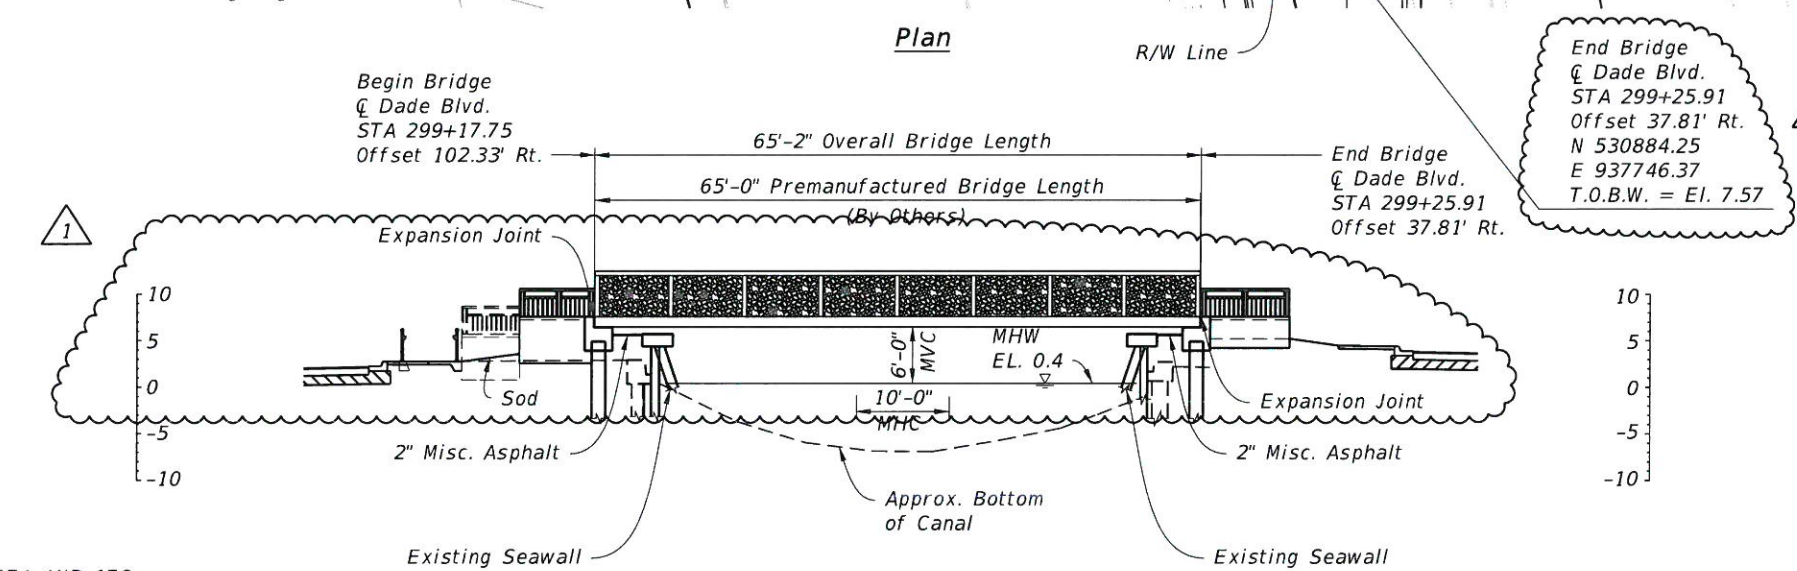

Legend:
 ⦿ Borings

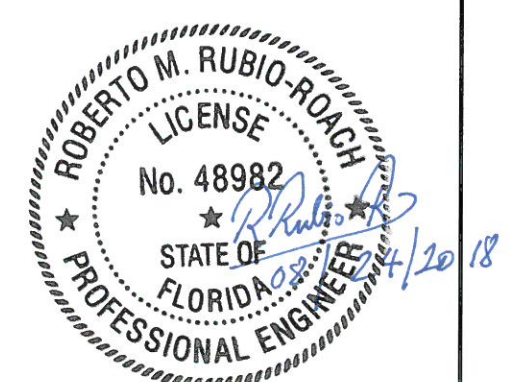

Note:
 Sheet to be used in combination with Sheets 17A AND 17G.

Bridge No. XXXXXX

REVISIONS						ENGINEER OF RECORD: ROBERTO RUBIO, P.E. #48982 KEITH and SCHNARS, P.A. ENGINEERS, PLANNERS, SURVEYORS 6500 NORTH ANDREWS AVENUE FORT LAUDERDALE, FLORIDA 33309-2132 (954)776-1616 CERTIFICATE OF AUTHORIZATION NO. 1337	DRAWN BY: CSL CHECKED BY: RMR DESIGNED BY: NA CHECKED BY: RMR	CITY OF MIAMI BEACH 1755 MERIDIAN AVENUE MIAMI BEACH, FLORIDA 33139	SHEET TITLE: PLAN AND ELEVATION		REF. DWG. NO.
DATE	BY	DESCRIPTION	DATE	BY	DESCRIPTION				PROJECT NAME: LINCOLN COURT PEDESTRIAN BRIDGE	SHEET NO. B2-3	
8/23/18	RR	1 END BENT ELEVATIONS, LINCOLN COURT PED. RAMP, BRIDGE RAILING.									