


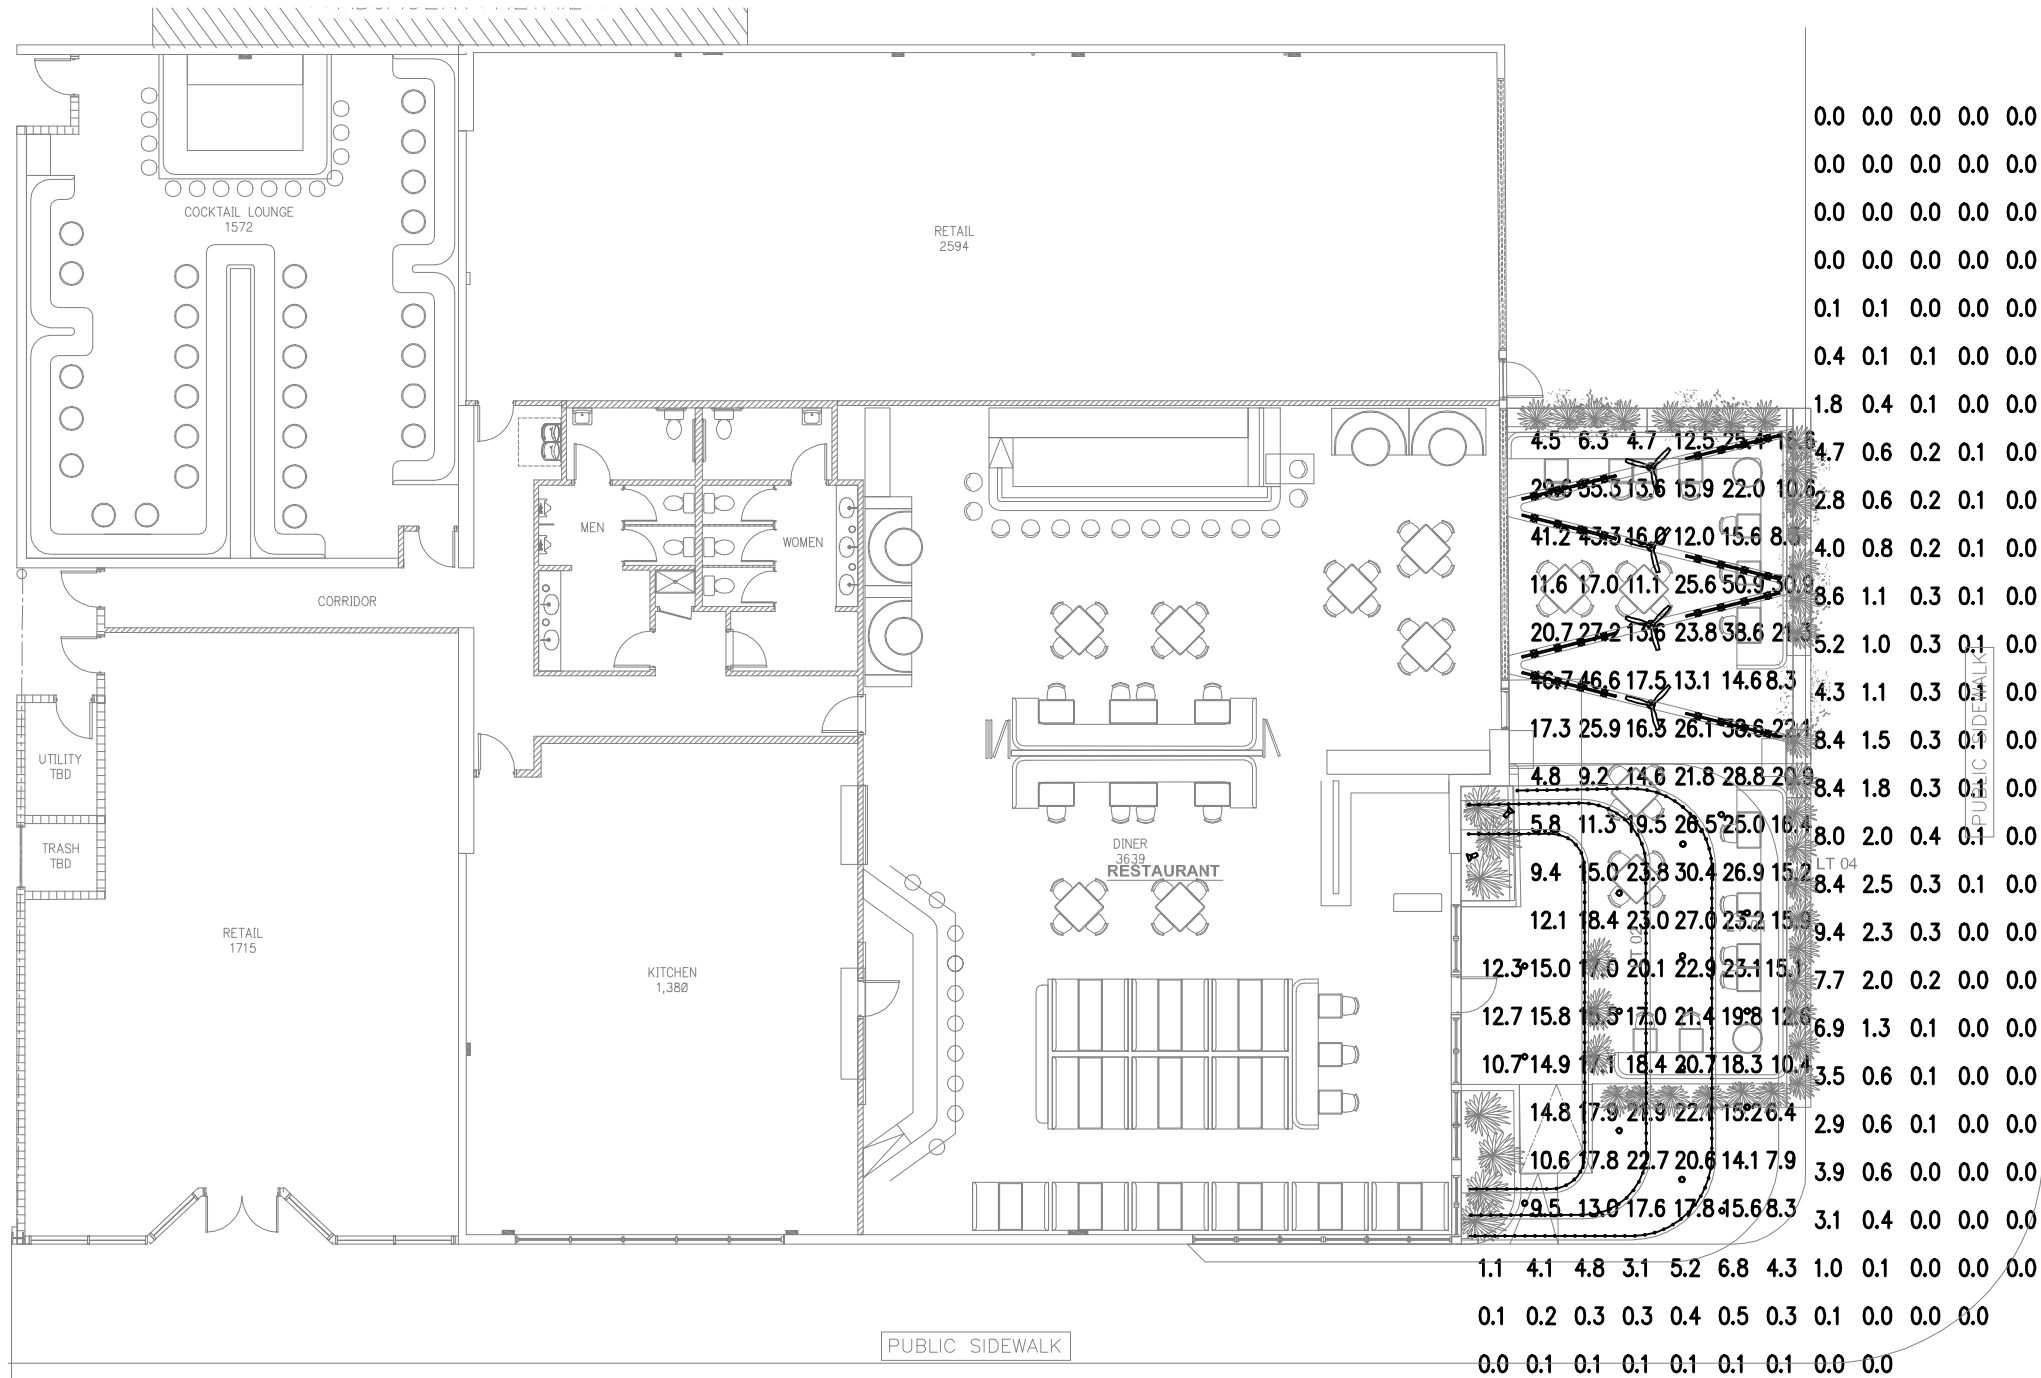

ELECTRICAL PLAN

SCALE: 1/16" = 1'-0"

NR

architect

NORBERTO ROSENSTEIN ARCHITECT , INC.

ARCHITECTURE - INTERIOR DESIGN - PLANNING

126 S. FEDERAL HIGHWAY SUITE # 202
DANIA BEACH, FLORIDA 33004
PH: (954) 922-6551
FAX: (954) 922-7388
EMAIL: info@rosensteinarchitect.com
WEB: www.rosensteinarchitect.com

STATE REG. NO. AR2016614
NATL. REG. NO. 69178

COPYRIGHT ©2016
NORBERTO ROSENSTEIN ARCHITECT, INC.
ALL RIGHTS RESERVED. THIS DOCUMENT OR PARTS THEREOF, MAY NOT BE REPRODUCED IN ANY FORM WITHOUT PERMISSION.

DESIGNED DS
DRAWN DS
CHECKED TEH

I HEREBY CERTIFY THAT THESE PLANS WHERE PREPARED BY ME OR UNDER MY SUPERVISION, AND TO THE BEST OF MY KNOWLEDGE, COMPLY WITH ALL APPLICABLE CODES.

THOMAS E. HENZ, PE, INC.
CONSULTING ENGINEER
240 Commercial Blvd 2A
Lauderdale By The Sea, FL 33308
T 954.523.4933
F 954.523.5062
www.henz.com

REVISIONS	
COMM.	DATE
2016-14	2-12-2016

1575 ALTON RD.
MIAMI BEACH
FLORIDA, 33139

ELECTRICAL
PLAN

E-1



**NORBERTO ROSENSTEIN
ARCHITECT, INC.
ARCHITECTURE - INTERIOR DESIGN - PLANNING**

126 S. FEDERAL HIGHWAY
SUITE # 202
DANA BEACH, FLORIDA 33004
P: (954) 922-6651
FAX: (954) 922-7388
EMAIL: info@osenshiner.com
WEB: www.osenshiner.com

STATE REG. NO. AR00166
NATL. REG. NO. 69178

COPYRIGHT © 2016
NORBERTO ROSENSTEIN ARCHITECT, INC.
ALL RIGHTS RESERVED. THIS DOCUMENT
OR PARTS THEREOF, MAY NOT BE REPRODUCED
IN ANY FORM WITHOUT PERMISSION.

DESIGNED
N.R.
DRAWN
J.G.
CHECKED
N.R.

I HEREBY CERTIFY THAT THESE PLANS WHERE PREPARED BY ME OR UNDER MY SUPERVISION, AND TO THE BEST OF MY KNOWLEDGE, COMPLY WITH ALL APPLICABLE CODES.


[illegible]

COMM. 2016-14	DATE 6-15-2016
------------------	-------------------

1575 ALTON RD.
MIAMI BEACH
FLORIDA, 33139

EXTERIOR ELEVATIONS


A-4.0 of 5

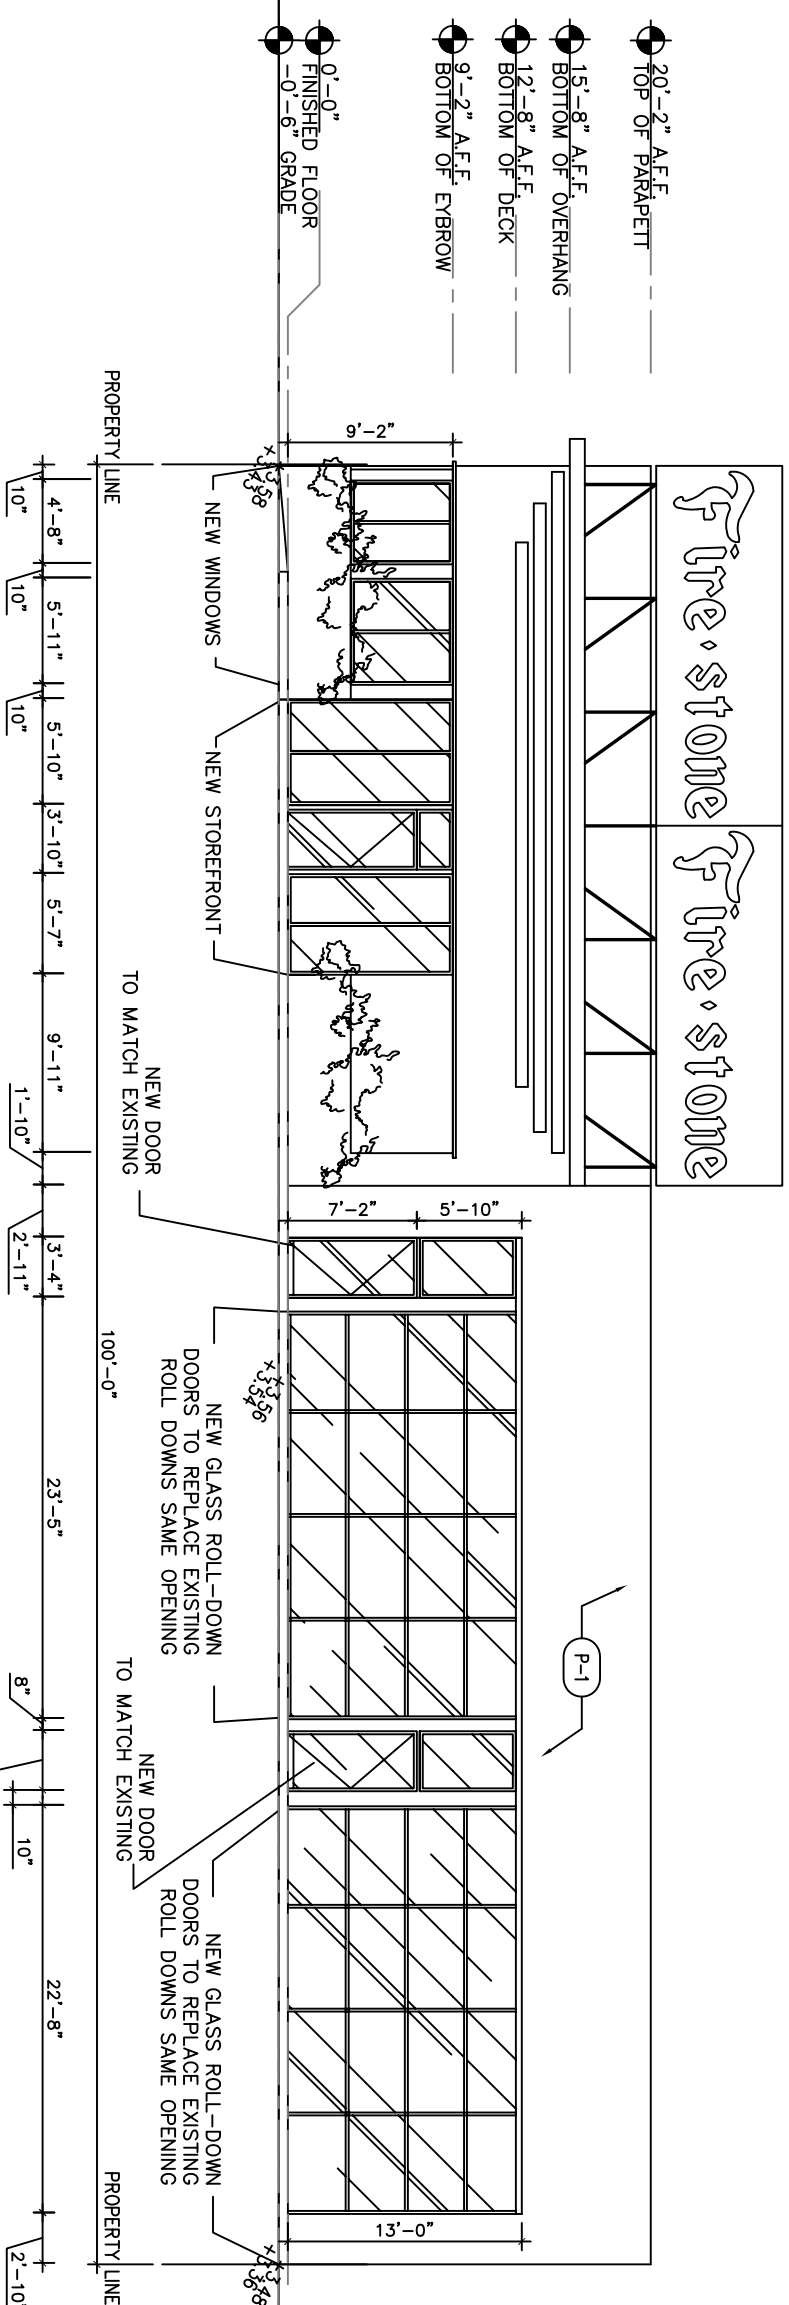

01 EAST ELEVATION
SCALE: 3/32"=1'-0"

FINISHES SCHEDULE						
GC		OWNER		MATERIAL		
FURNISH	INSTALL	FURNISH	INSTALL	TAG	DESCRIPTION AND SPECIFICATIONS	REMARKS
Q	Q			P-1	PAINT COLOR NAME: TBD	
Q	Q			P-2	PAINT COLOR NAME: TBD	
NOTE:						
FLOOR						
Q	Q			RL-1	EXTERIOR PATIO FLOOR MANUFACTURER: COLOR NAME: TBD PRODUCT:	
				RL-2	EXISTING FLOOR MANUFACTURER: COLOR NAME: TBD PRODUCT:	

NOTE: FLOOR MUST COMPLY WITH FFPC 101.716.4. THE WALKING SURFACE OF EACH ELEMENT IN THE MEANS OF EGRESS SHALL BE UNIFORMLY SLIP RESISTANT ALONG THE NATURAL PATH OF TRAVEL.

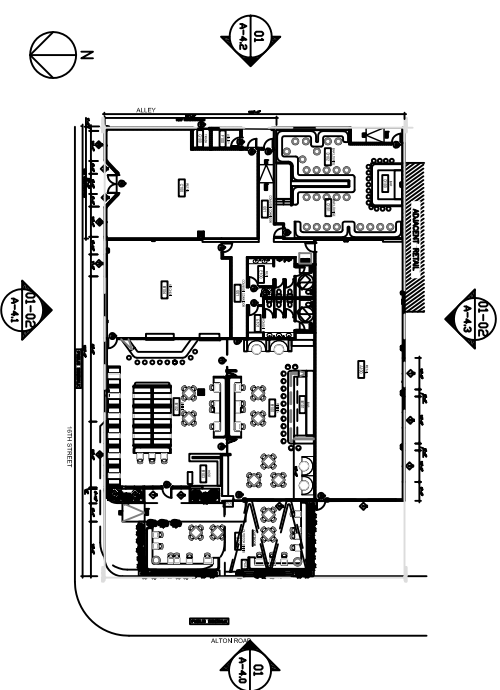

02 KEY PLAN
SCALE: 1/8"=1'-0"

03	LEGEND
----	--------

04 FINISHES SCHEDULE



[illegible]

COMM.	DATE
<u>2016-14</u>	<u>6-15-2016</u>

1575 ALTON RD.
MIAMI BEACH
FLORIDA, 33139

MIAMI BEACH
FLORIDA, 33139

EXTERIOR ELEVATIONS

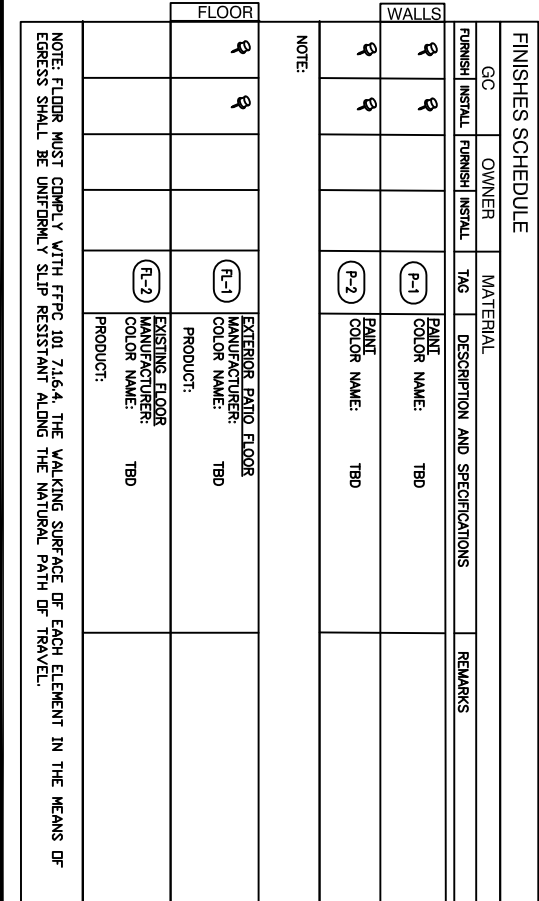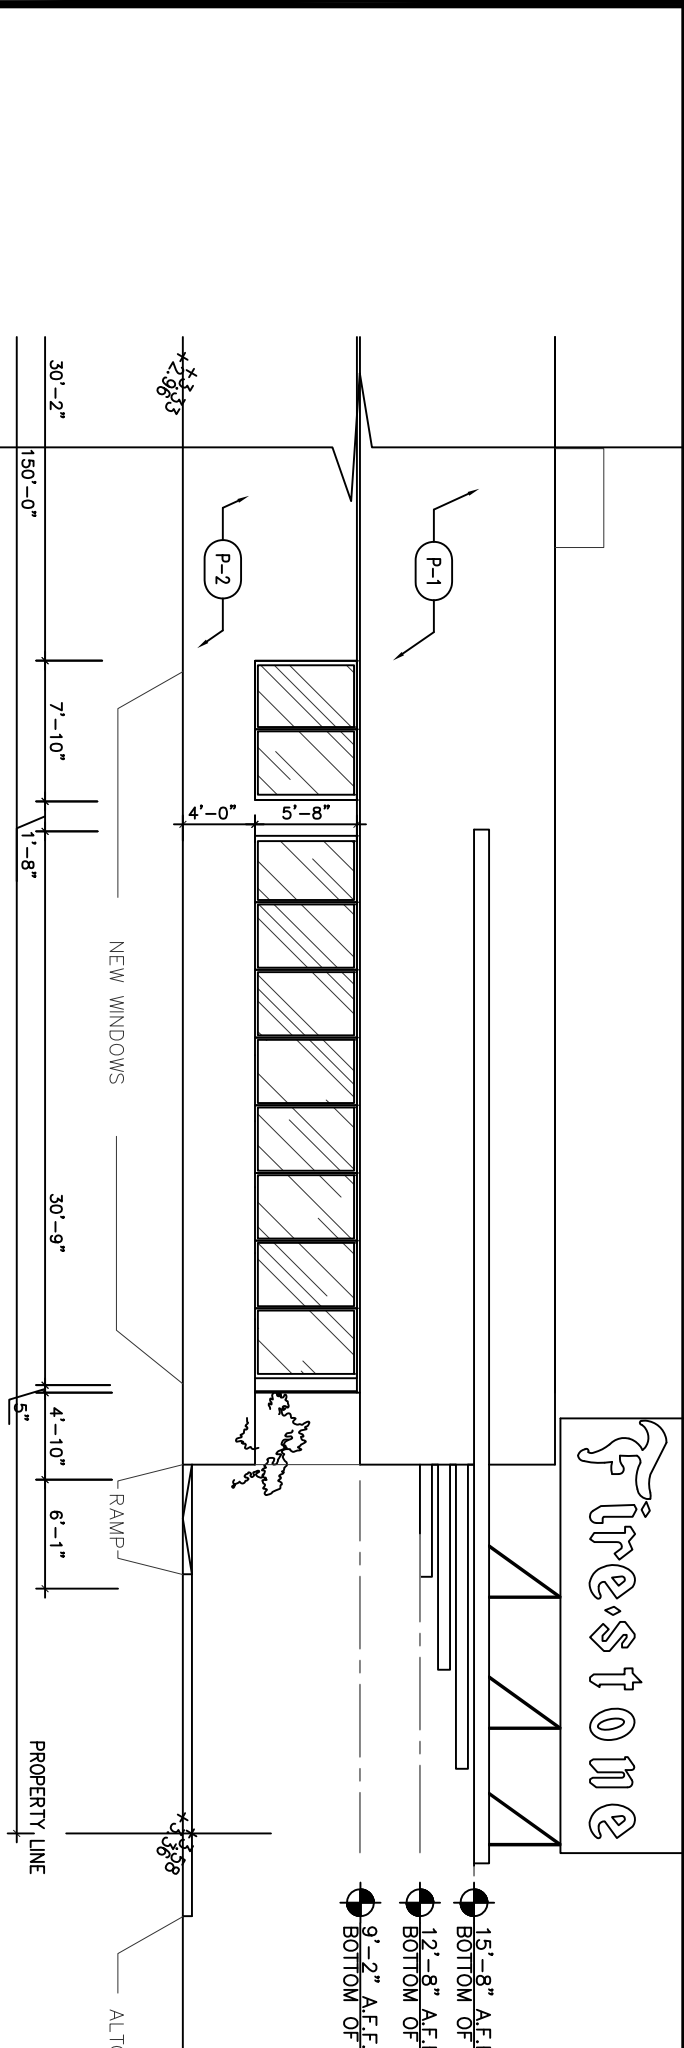A-4.1  5

ARCHITECTURE - INTERIOR DESIGN - PLANNING

WEB: www.rosendinarchitect.com

OR PARIS THEREOF, MAY NOT BE REPRODUCED
IN ANY FORM WITHOUT PERMISSION.

N.R.


OF INFORMATION, COMPLI WITH ALL
APPLICABLE CODES.

REVIEWS

<u>2016-14</u>	<u>6-15-2016</u>
----------------	------------------

FLORIDA, 33139

ELEVATIONS

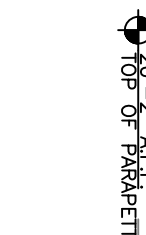

20'-2" A.F.F.
TOP OF PARAPET

A schematic diagram of a pressure transmitter labeled 'P-1'. It is represented by a circle with the text 'P-1' inside. Two lines extend from the circle: one line goes up and to the right, ending in an arrowhead, representing a signal line; the other line goes down and to the right, representing a power or supply line.

NR
architect

NORBERTO ROSENSTEIN
ARCHITECT, INC.
ARCHITECTURE - INTERIOR DESIGN - PLANNING

**NORBERTO ROSENSTEIN
ARCHITECT, INC.**

ARCHITECTURE - INTERIOR DESIGN - PLANNING

126 S. FEDERAL HIGHWAY
SUITE # 202
DANA BEACH, FLORIDA 33004
PH: (954) 922-6651
FAX: (954) 922-7388
EMAIL:for@oeststhar.chbed.com
WEB: www.oeststhar.chbed.com

STATE REG. NO. AR0016674
NATL. REG. NO. 69178

COPYRIGHT © 2016
NORBERTO ROSENSTEN ARCHITECT, INC.
ALL RIGHTS RESERVED. THIS DOCUMENT
OR PARTS THEREOF, MAY NOT BE REPRODUCED
IN ANY FORM, WITHOUT PERMISSION.

DESIGNED
N.R.
DRAWN
J.G.
CHECKED
N.R.


I HEREBY CERTIFY THAT THESE PLANS WHERE PREPARED BY ME OR UNDER MY SUPERVISION, AND TO THE BEST OF MY KNOWLEDGE, COMPLY WITH ALL APPLICABLE CODES.

[illegible]


COML.	DATE
<u>2016-14</u>	<u>6-15-2016</u>

1575 ALTON RD.
MIAMI BEACH
FLORIDA, 33139

EXTERIOR ELEVATIONS

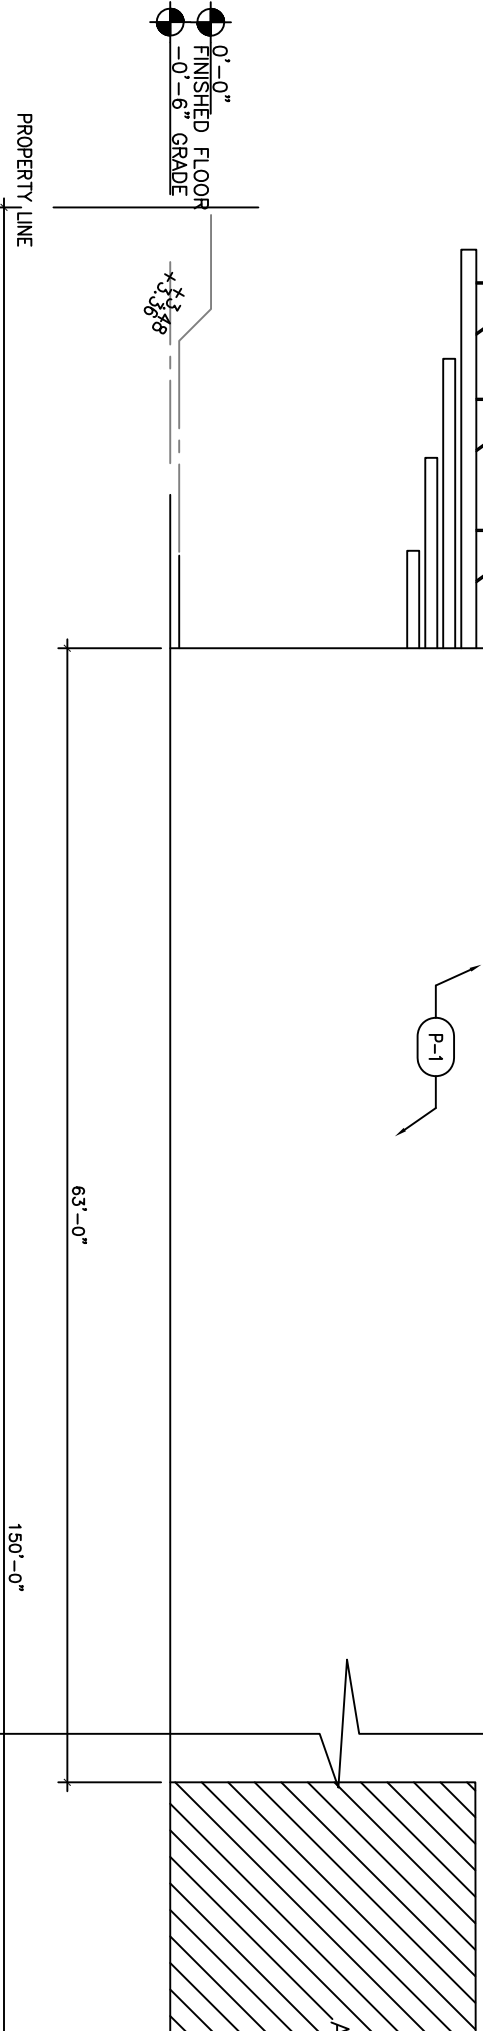A-4.3  5

01	NORTH ELEVATION - WEST SCALE: 3/32"=1'-0"
----	--

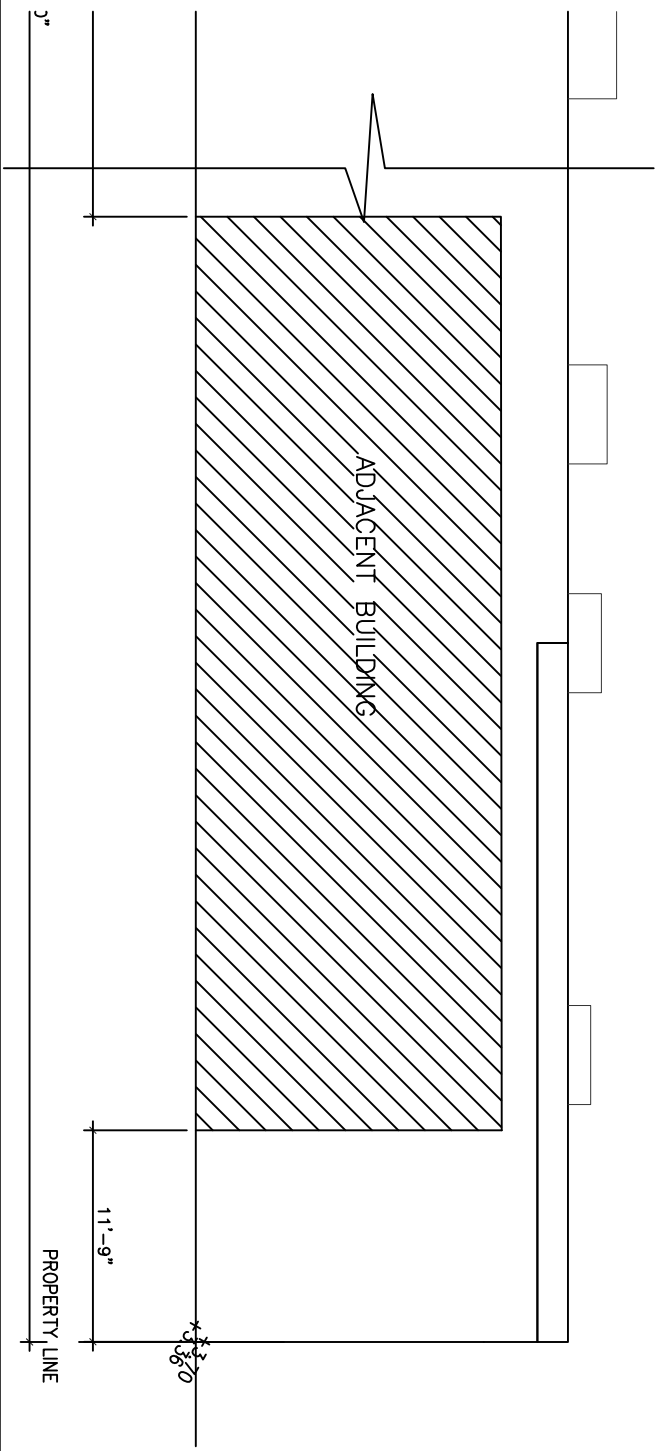

02	NORTH ELEVATION EAST SCALE: 3/32"=1'-0"
----	--

FINISHES SCHEDULE						
GC	OWNER	MATERIAL	DESCRIPTION AND SPECIFICATIONS			REMARKS
FURNISH	INSTALL	FURNISH	INSTALL	TAG		
				(P-1)	PAINT COLOR NAME:	TBD
				(P-2)	PAINT COLOR NAME:	TBD
NOTE:						
FLOOR						
				(FL-1)	EXISTING PATIO FLOOR MANUFACTURER: COLOR NAME:	TBD
				(FL-2)	EXISTING FLOOR MANUFACTURER: COLOR NAME:	TBD
					PRODUCT:	

NOTE: FLOOR MUST COMPLY WITH FFPC 101.7.16.4. THE WALKING SURFACE OF EACH ELEMENT IN THE MEANS OF EGRESS SHALL BE UNIFORMLY SLIP RESISTANT ALONG THE NATURAL PATH OF TRAVEL.

03 KEY PLAN
SCALE: 1/64"=1'-0"

04	ELEVATION KEY
----	---------------

05 FINISHES SCHEDULE



CONCEPTUAL LANDSCAPING