

4981 SW 74 CT
Miami, FL 33155
786.615.2943 O
786.615.2945 F
cbravo@urvanx.com
AA26002656
IB26001472

THE DESIGNS AND DRAWINGS PRESENT HEREIN ARE THE
SOLE PROPERTY OF URVANX, INC. AND MAY NOT BE COPIED
OR DUPLICATED WITHOUT SPECIFIC WRITTEN PERMISSION OF
URVANX, INC.

IN MY PROFESSIONAL JUDGEMENT AND TO THE BEST OF
MY KNOWLEDGE AND BELIEF, THE PLANS AND
SPECIFICATIONS CONTAINED HEREIN COMPLY WITH ALL
APPLICABLE BUILDING CODES.

815 West Di Lido Drive
Miami Beach, FL 33139

REVISIONS



[illegible]

SHEET TITLE

PROJECT NUMBER
1733

SHEET

A-102.1

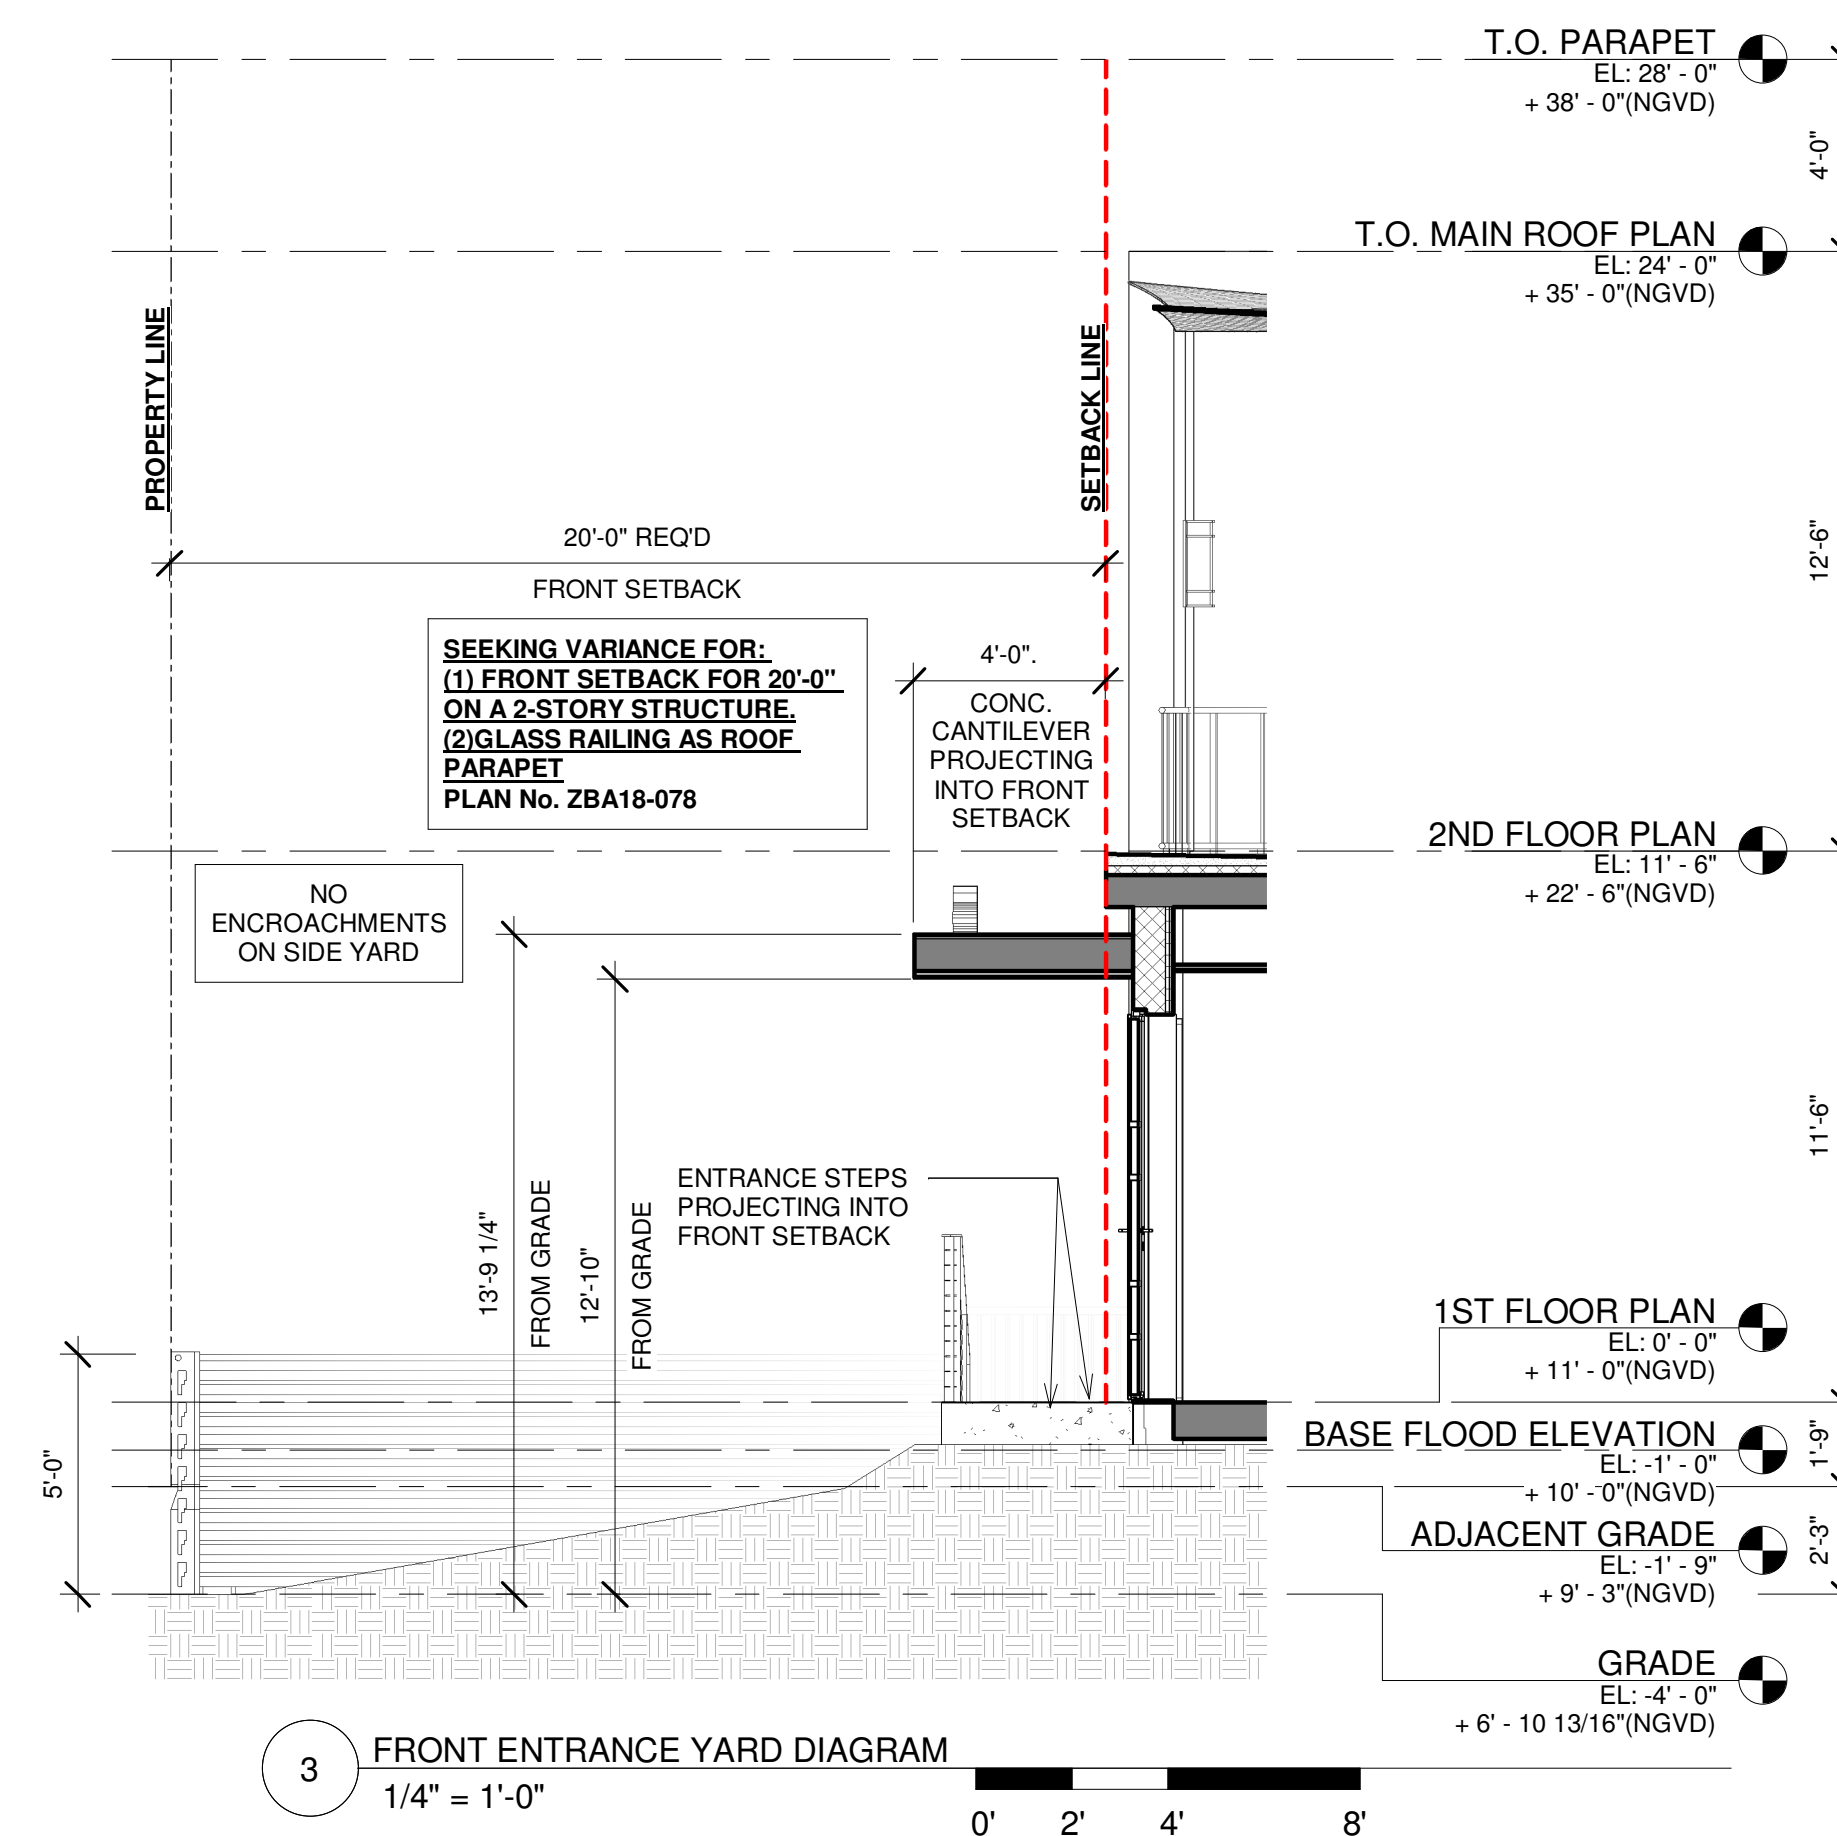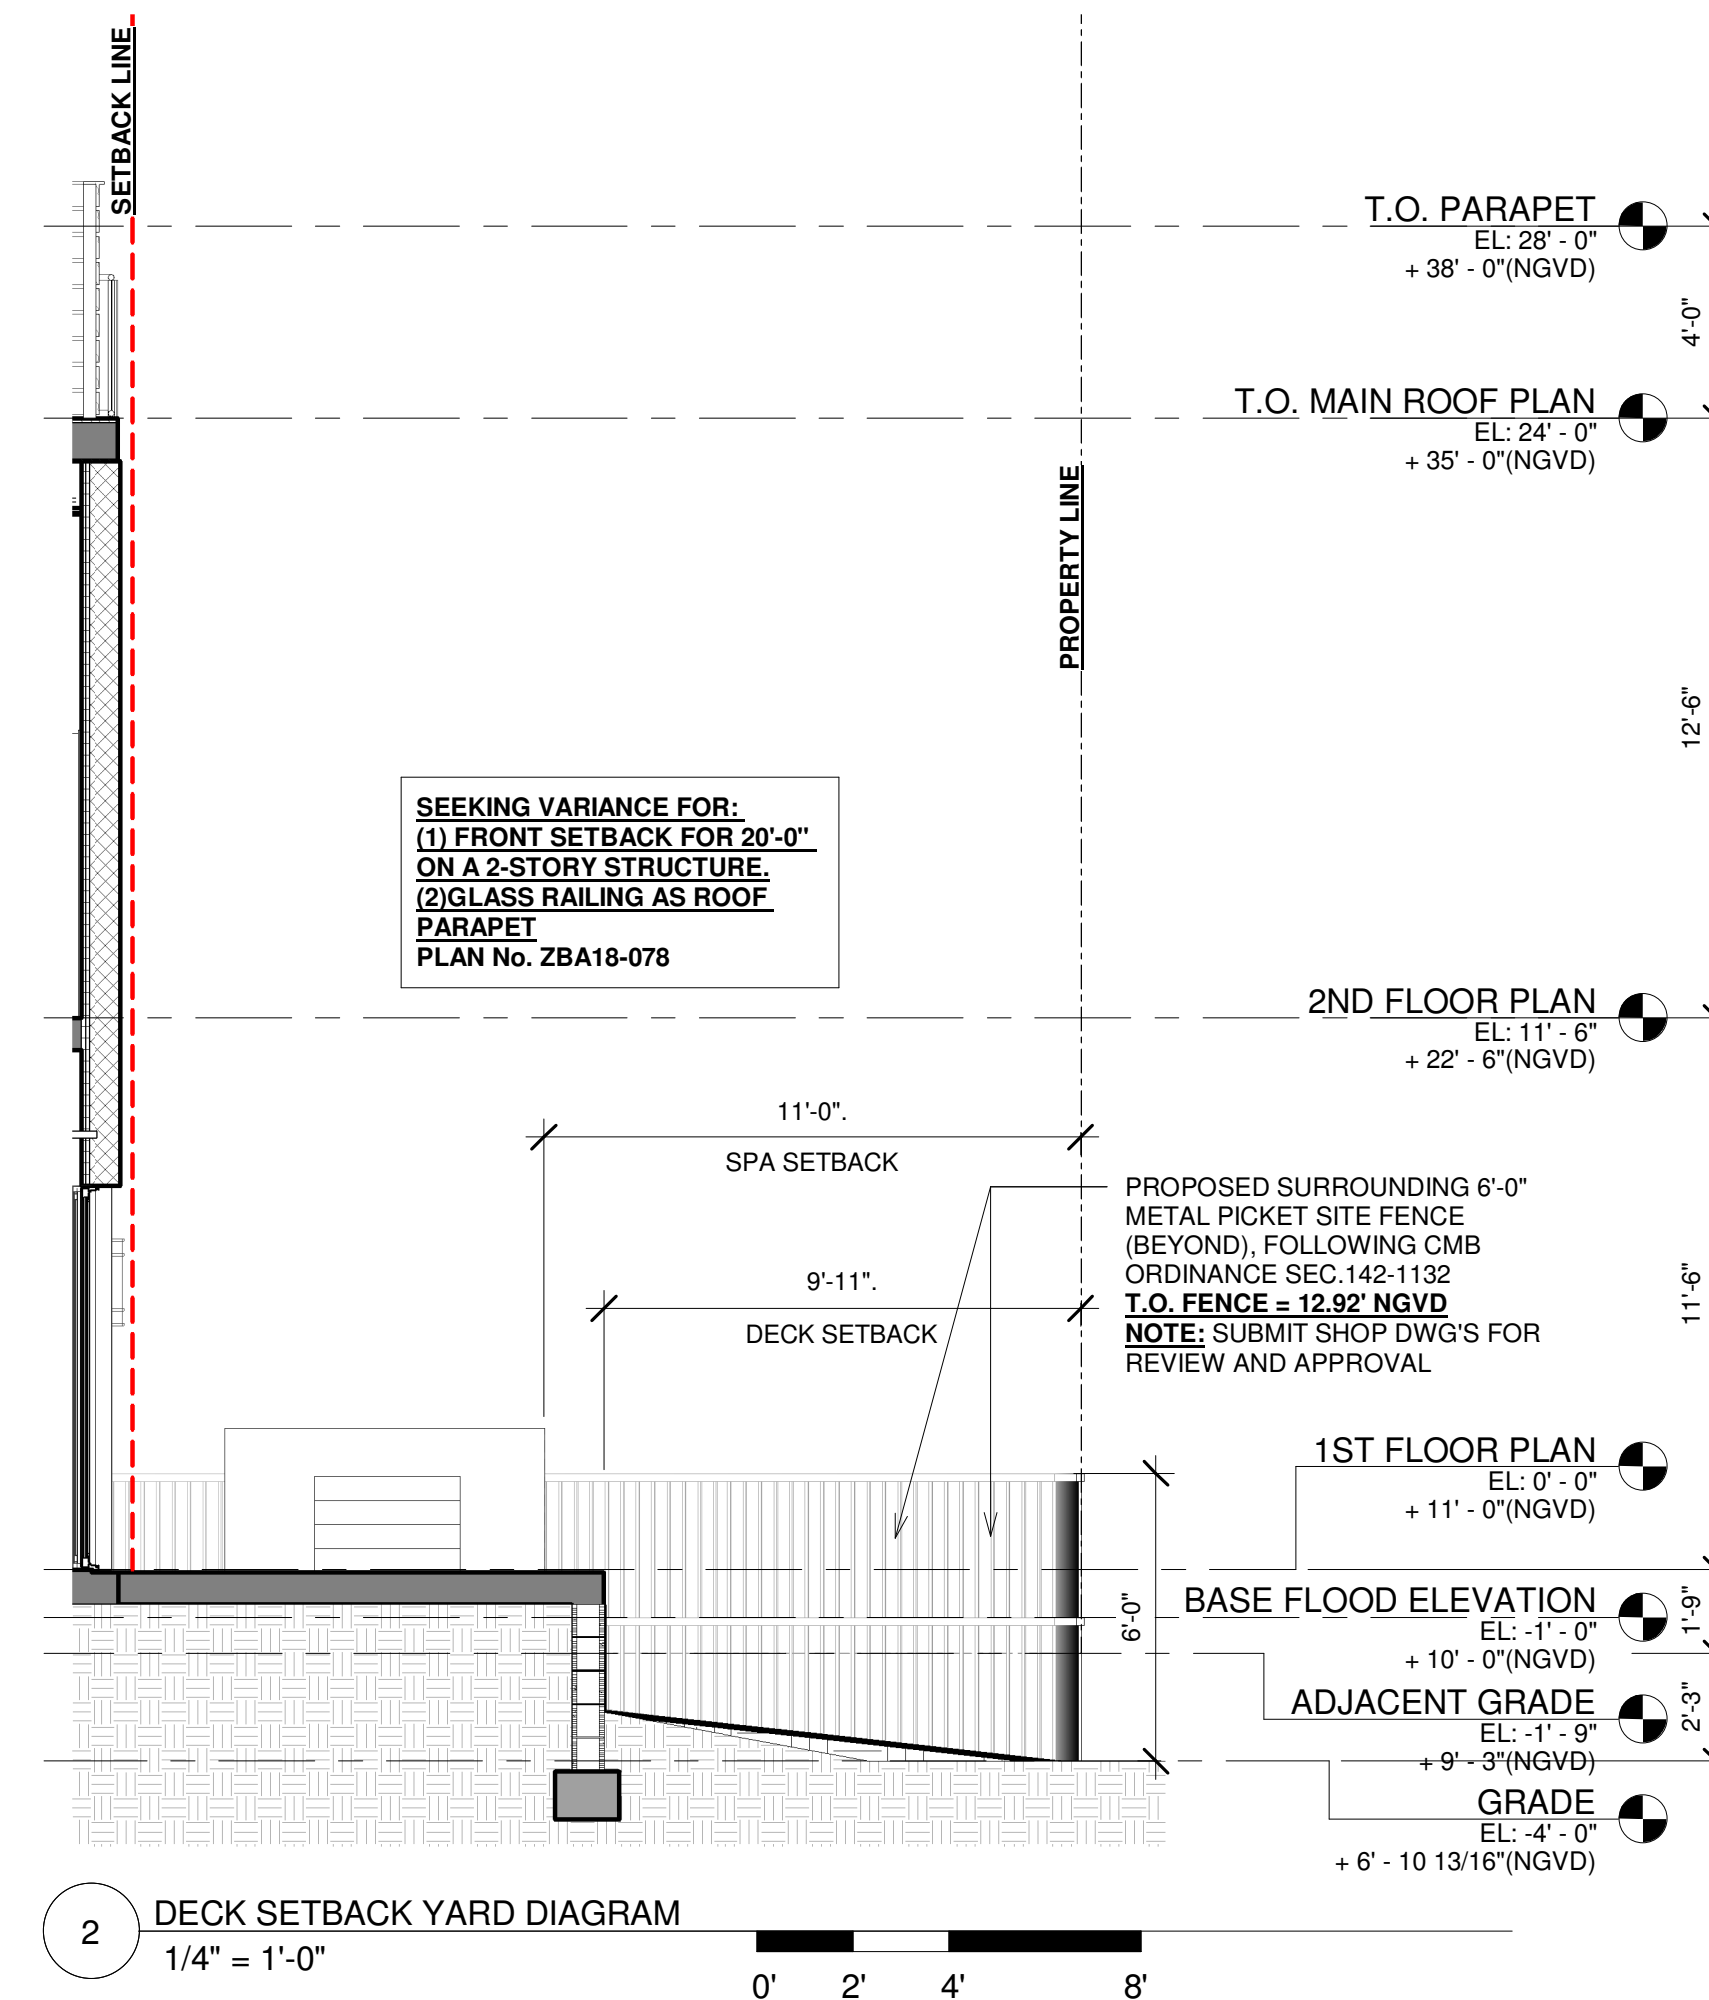

ELECTRICAL SYSTEMS, EQUIPMENT AND COMPONENTS; HEATING, VENTILATION, AIR CONDITIONING; PLUMBING APPLIANCES AND PLUMBING FIXTURES; DUCT SYSTEMS; AND OTHER SERVICE EQUIPMENT (POOL EQUIPMENT, WATER HEATERS, GENERATORS, ETC.) SHALL BE LOCATED AT OR ABOVE:

DESIGN FLOOD ELEVATION, D.F.E. (+10.00' NGVD)