
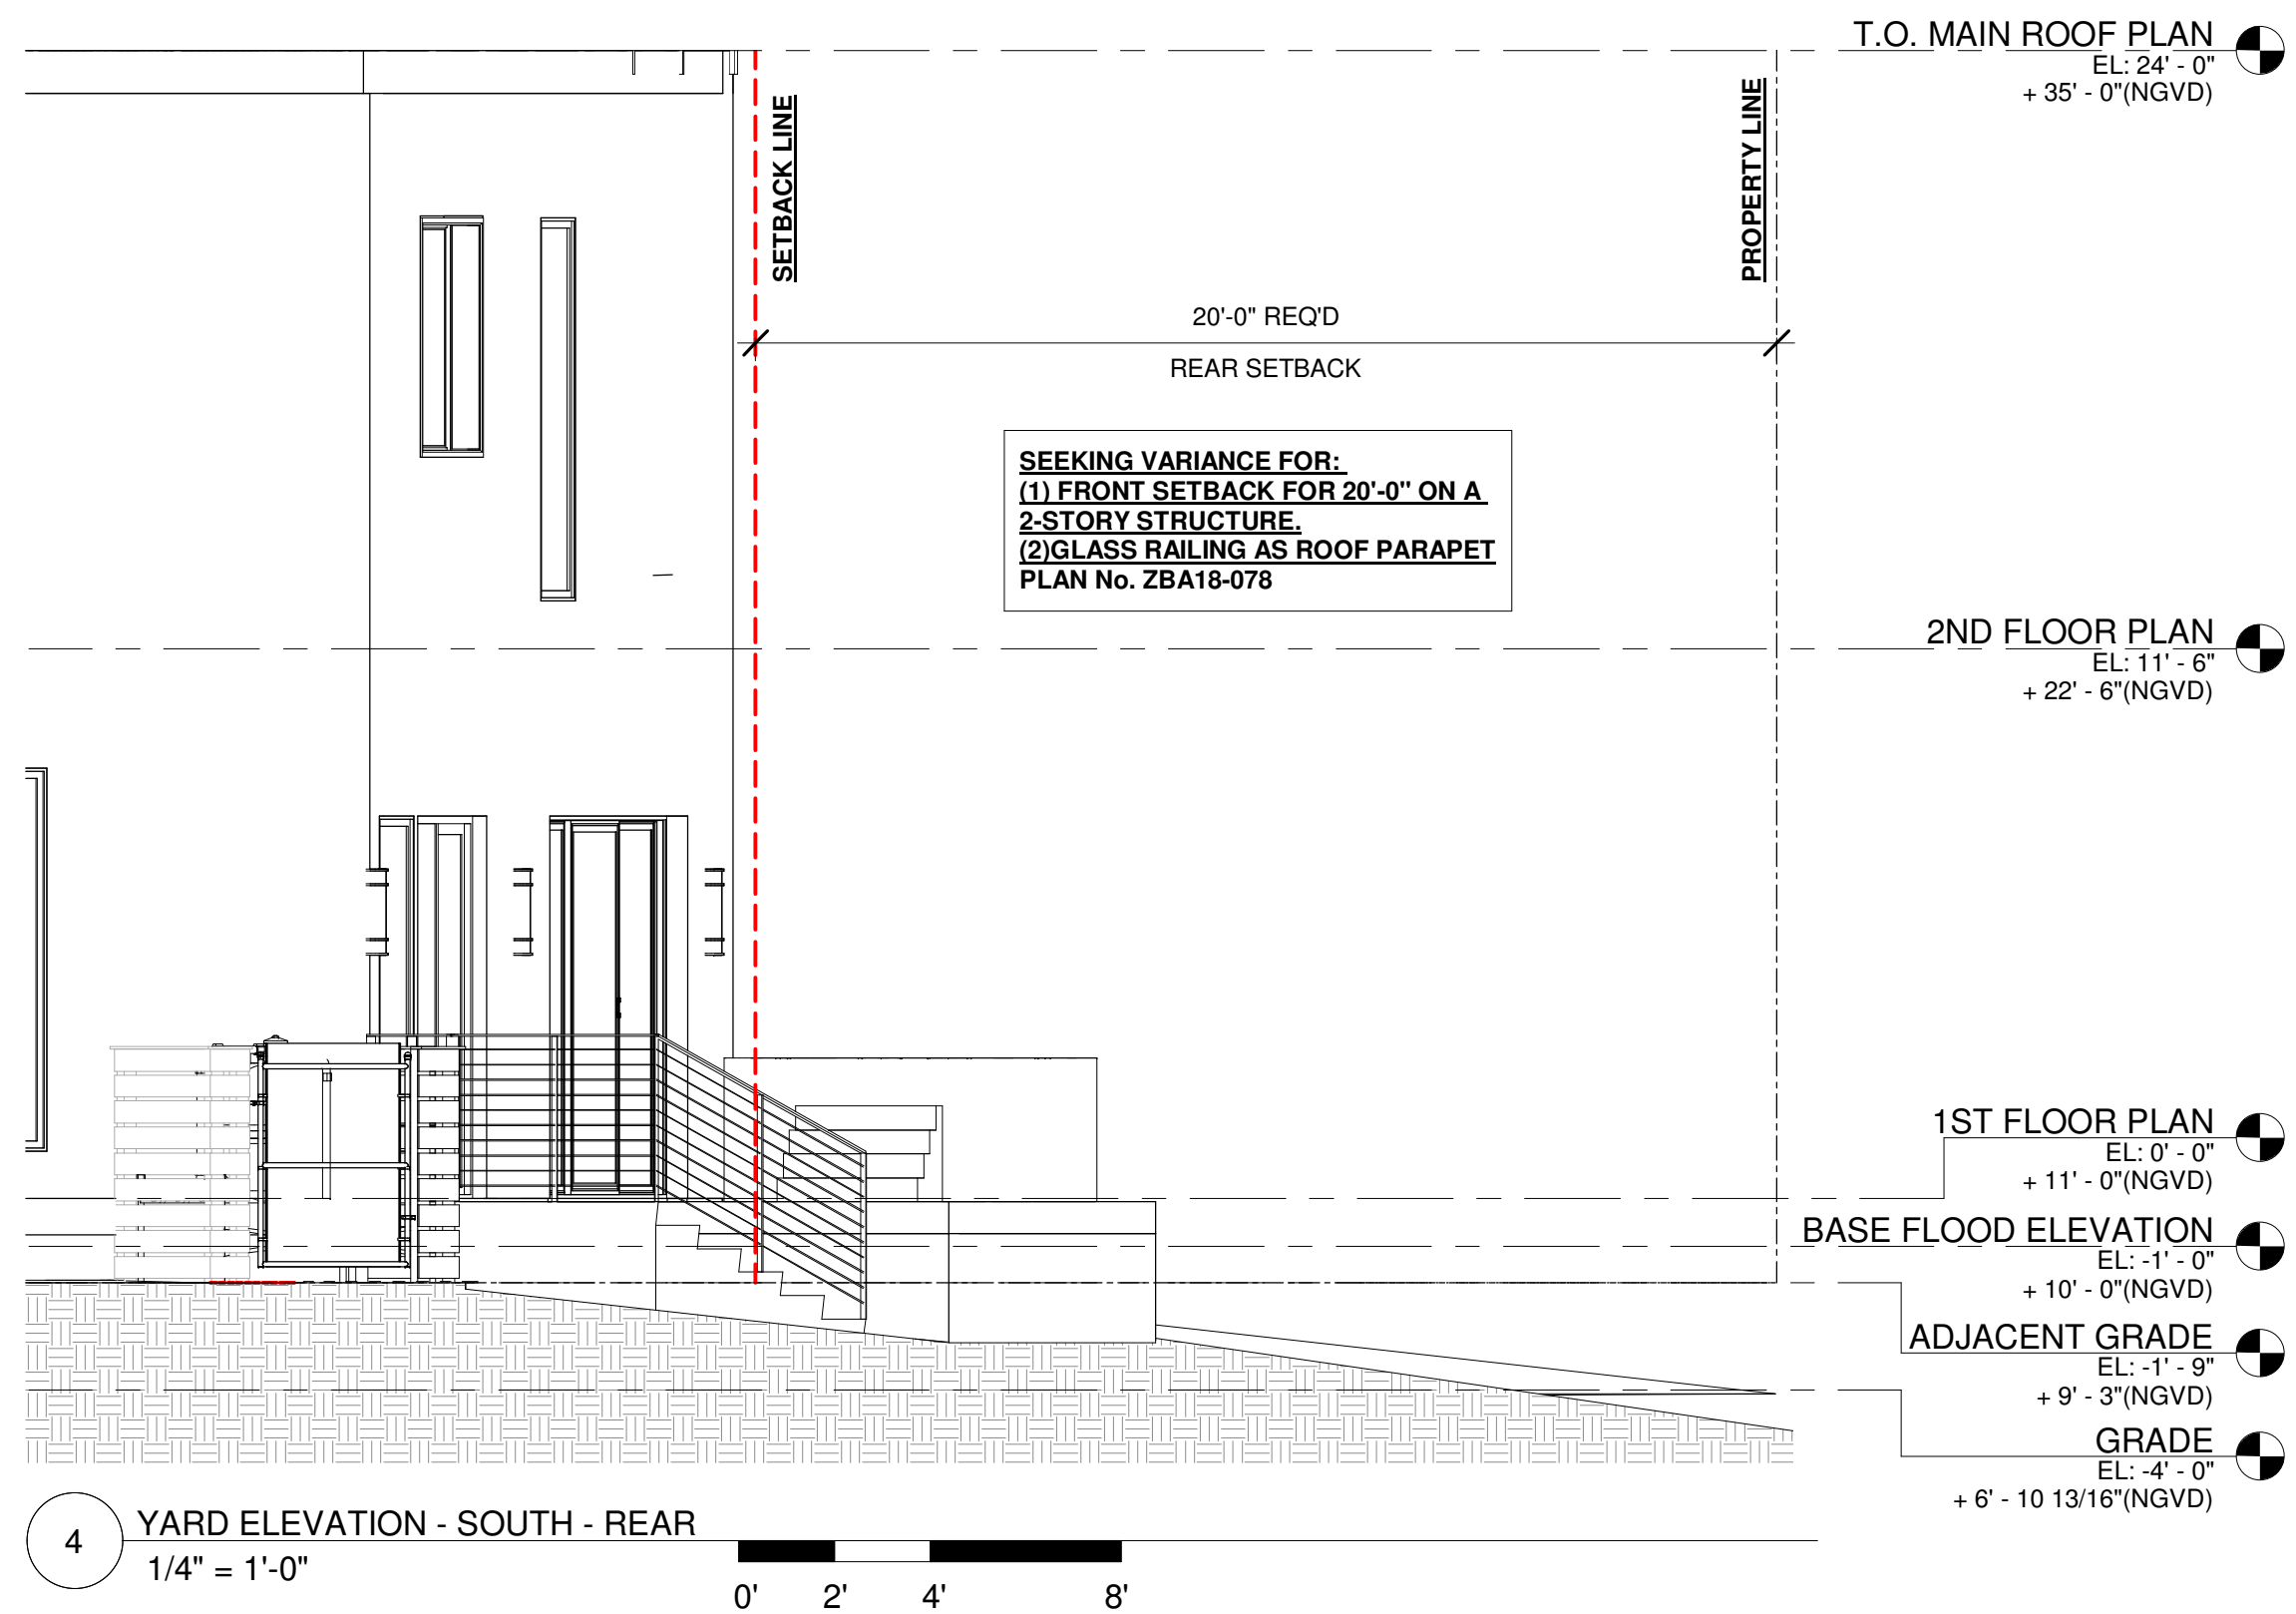
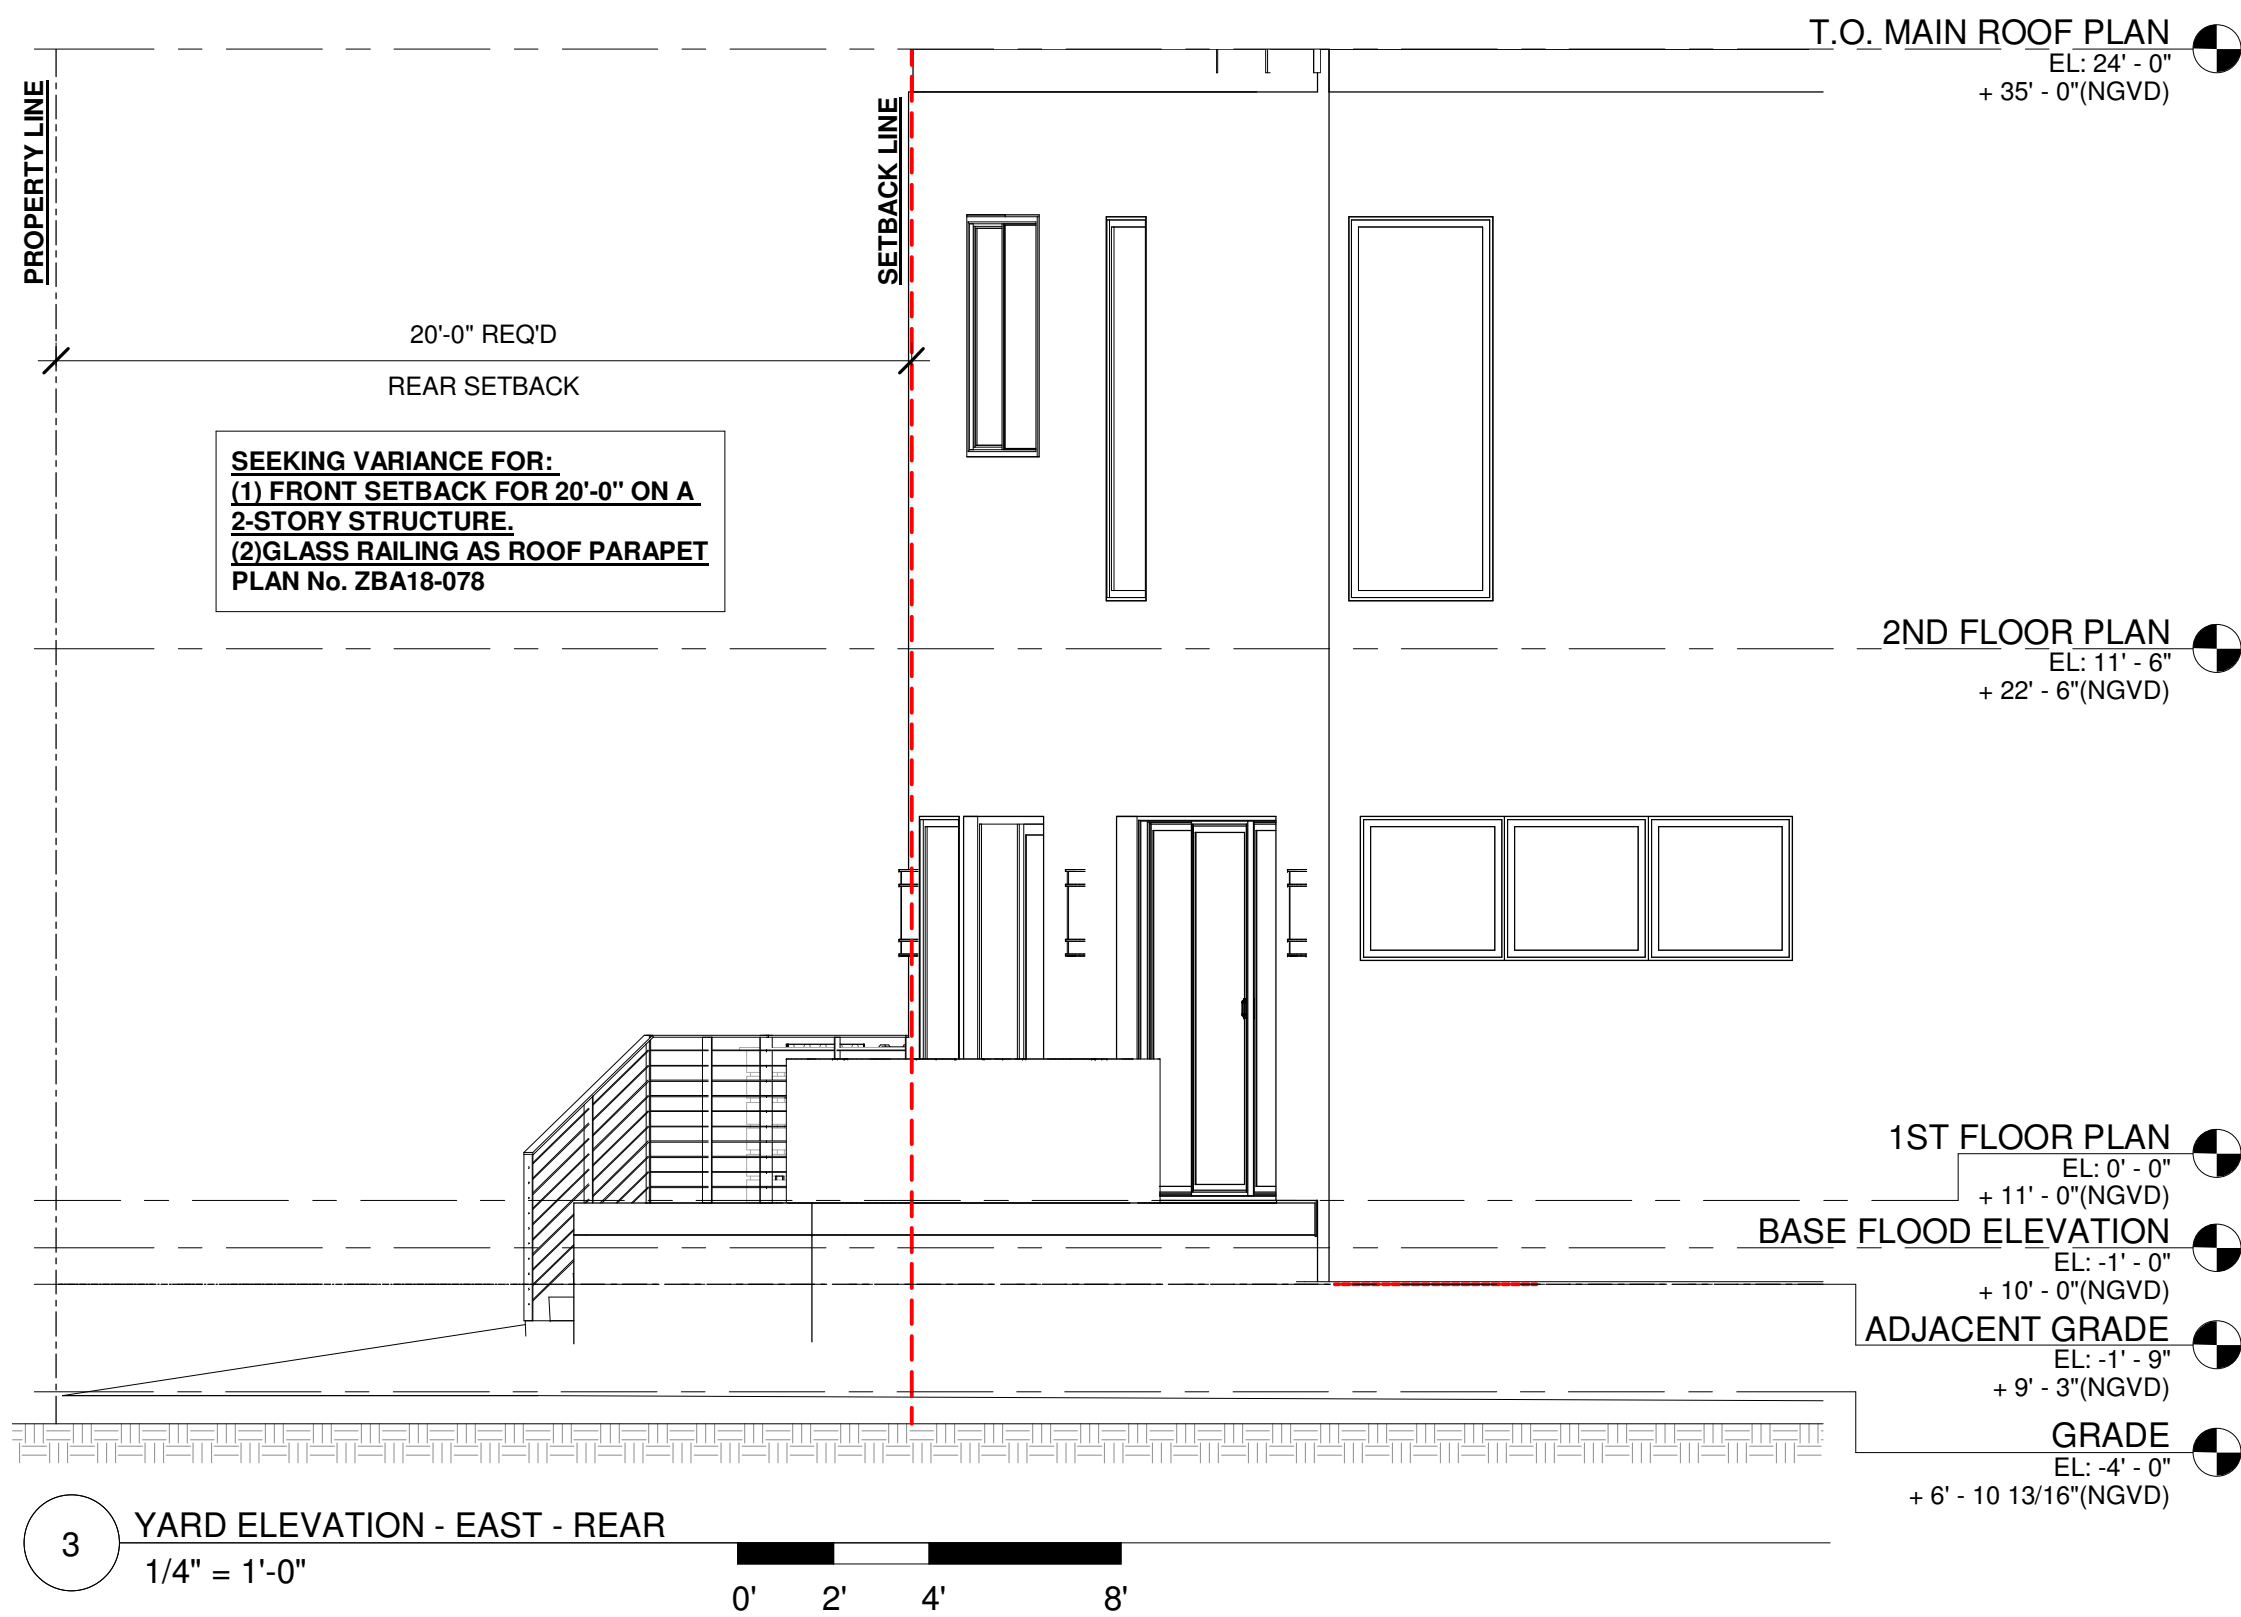
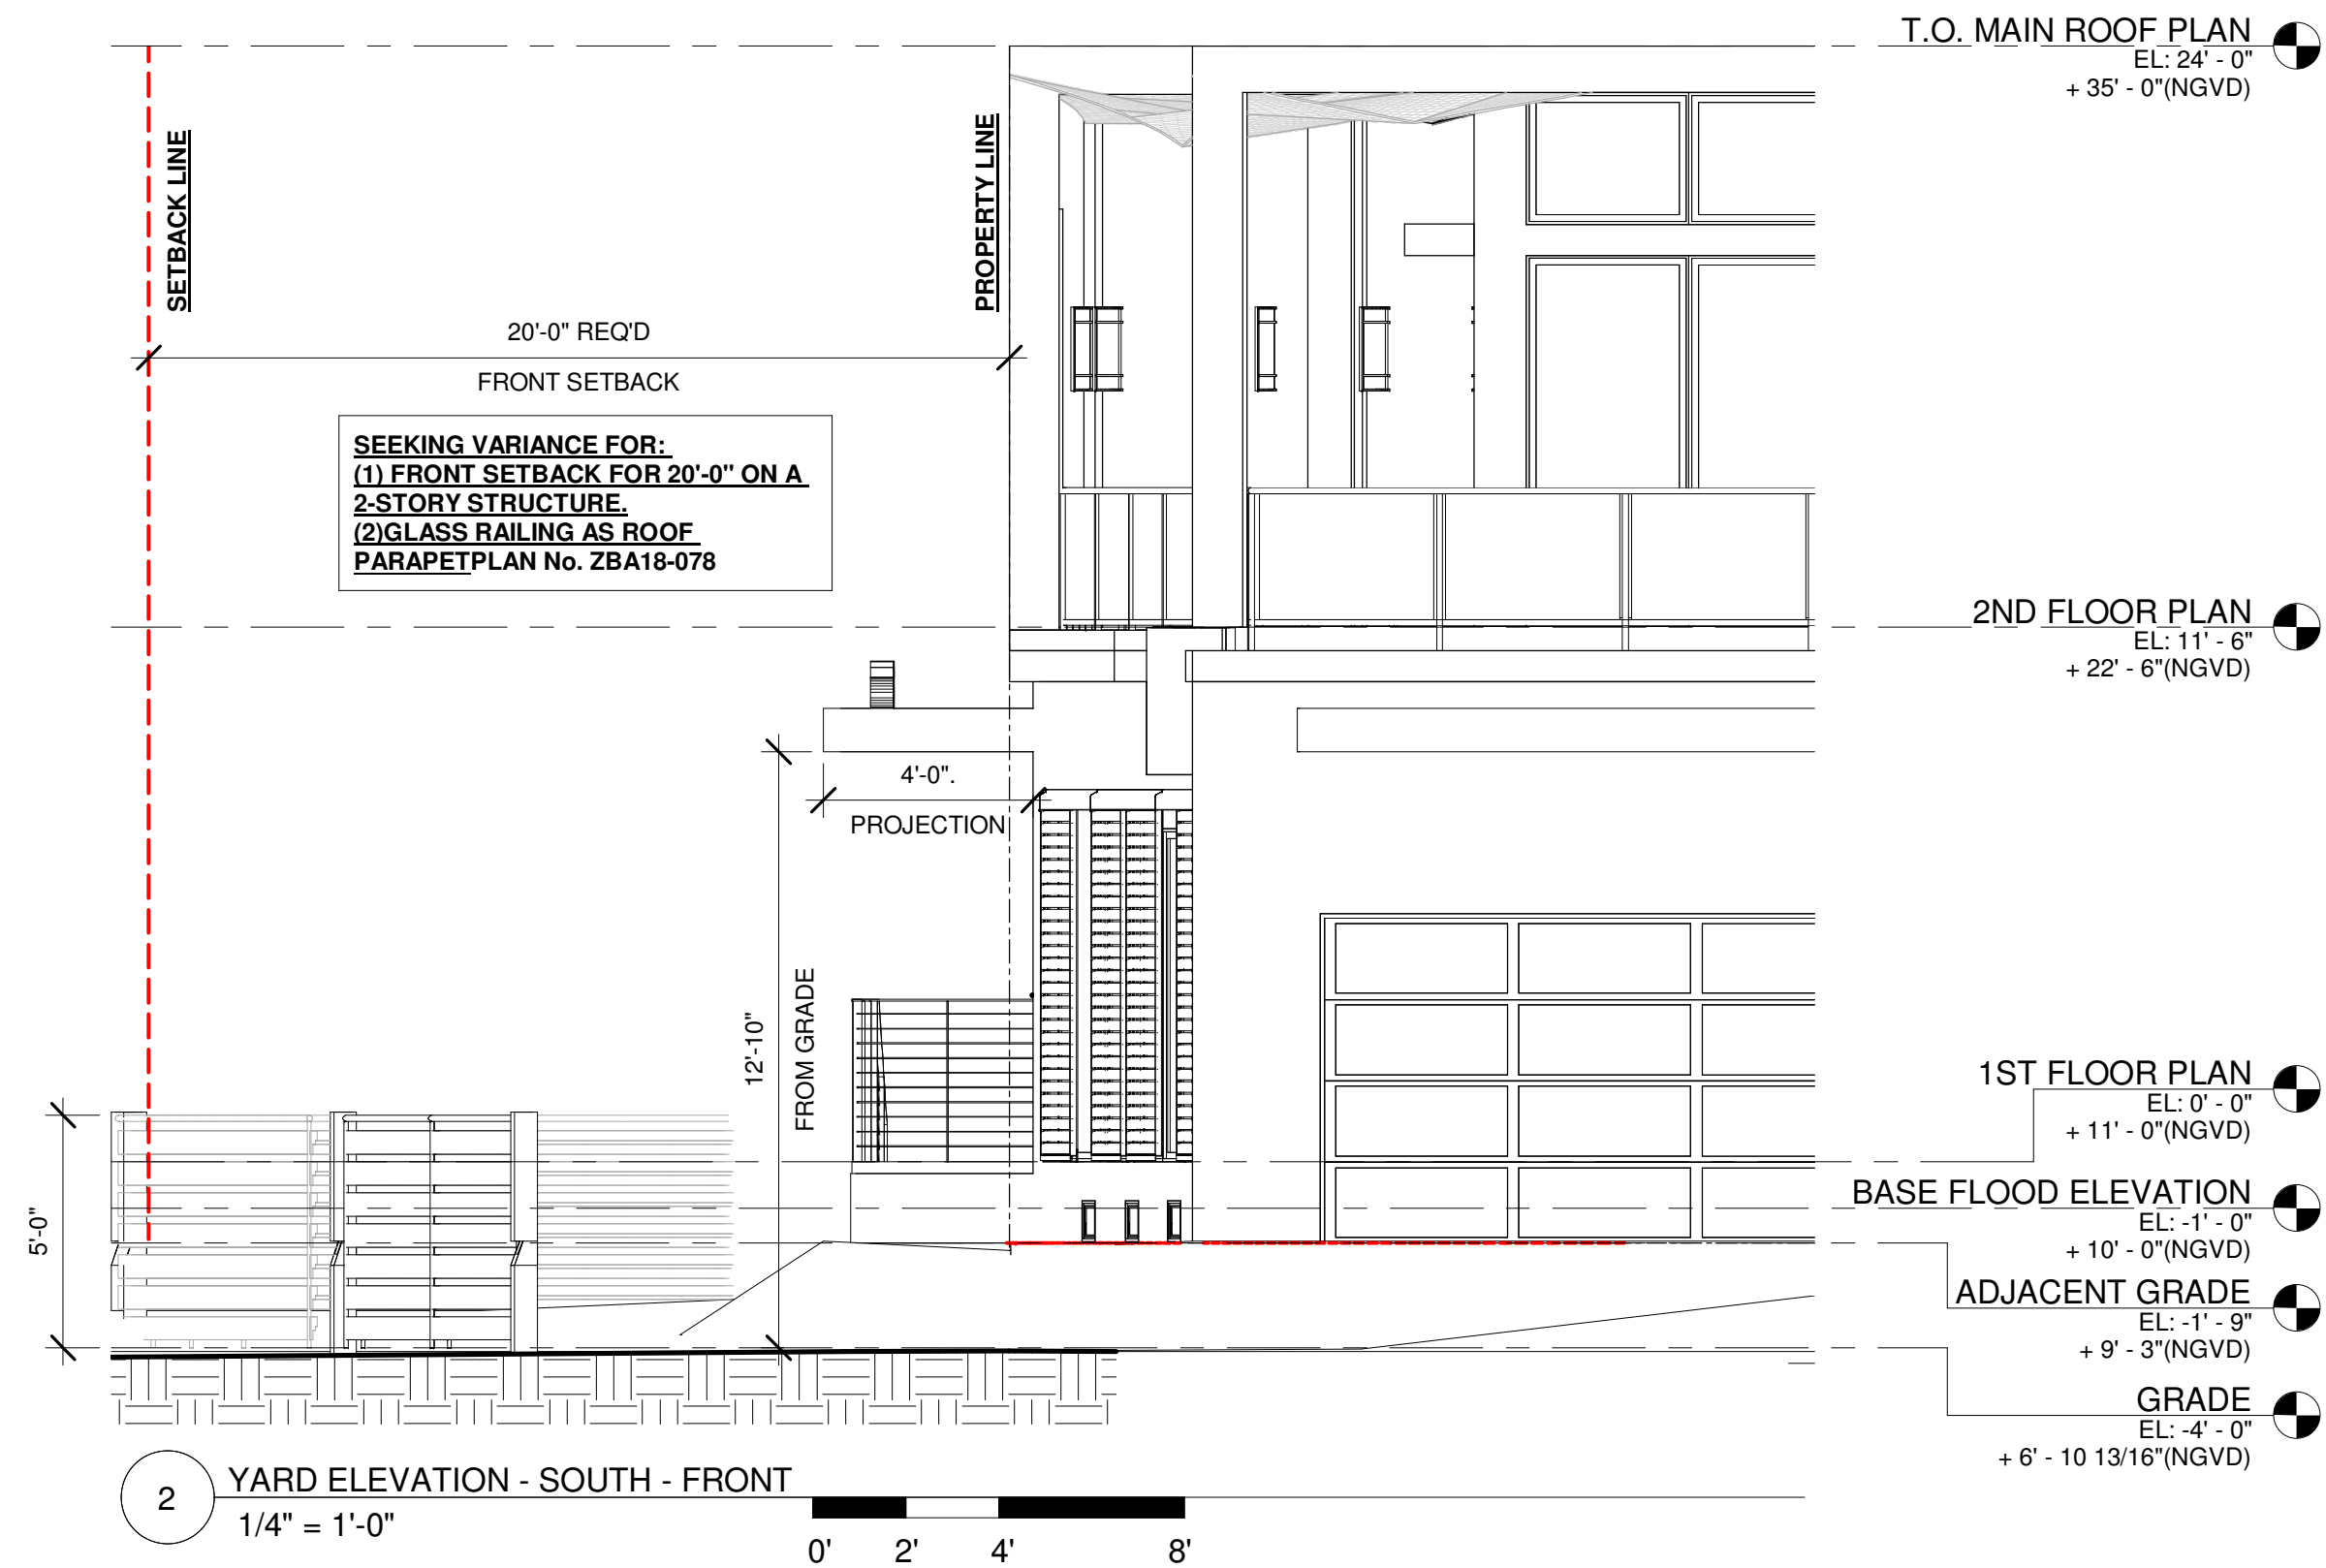


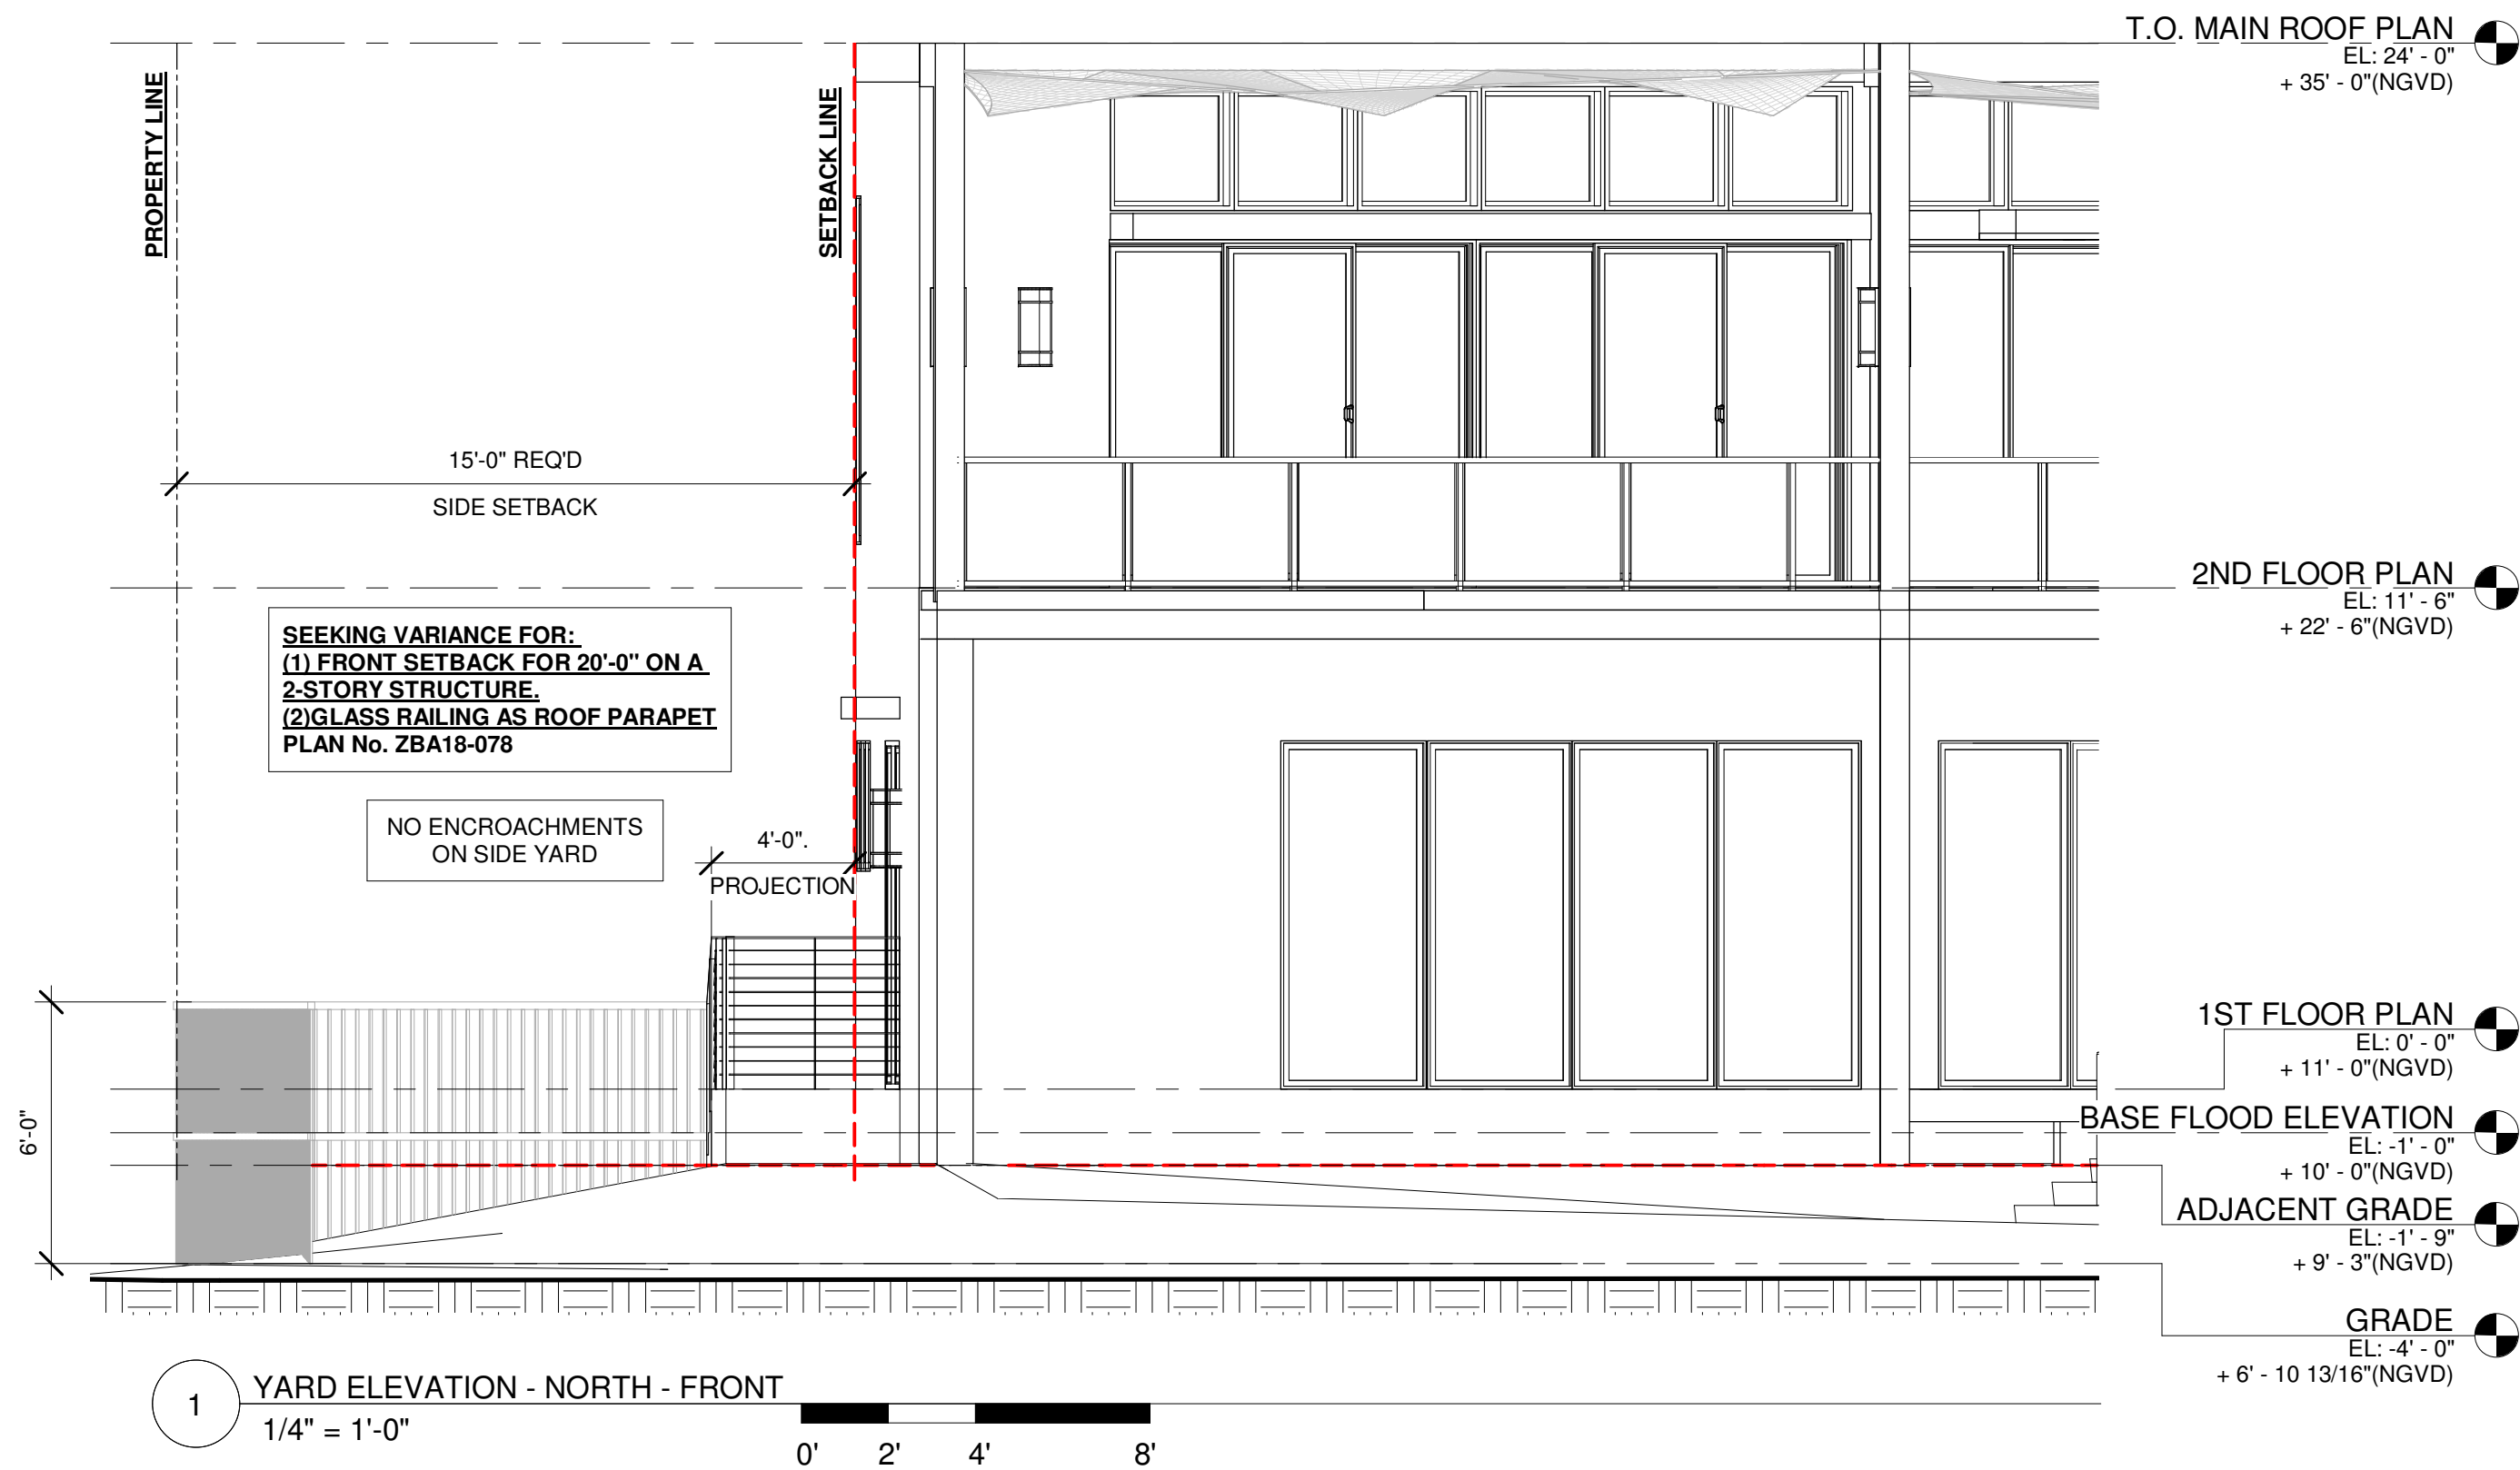


ELECTRICAL SYSTEMS, EQUIPMENT AND COMPONENTS; HEATING, VENTILATION, AIR CONDITIONING; PLUMBING APPLIANCES AND PLUMBING FIXTURES; DUCT SYSTEMS; AND OTHER SERVICE EQUIPMENT (POOL EQUIPMENT, WATER HEATERS, GENERATORS, ETC.) SHALL BE LOCATED AT OR ABOVE:
DESIGN FLOOD ELEVATION, D.F.E. (+10.00' NGVD)

4981 SW 74 CT
Miami, FL 33155
786.615.2943 O
786.615.2945 F
cbravo@urvanx.com
AA26002656
IB26001472

URVANX

Carlos J. Bravo, R.A. AR17584
Oscar Herrera, R.A. AR97980

THE DESIGNS AND DRAWINGS PRESENT HEREIN ARE THE SOLE PROPERTY OF URVANX, INC. AND MAY NOT BE COPIED OR DUPLICATED WITHOUT SPECIFIC WRITTEN PERMISSION OF URVANX, INC.

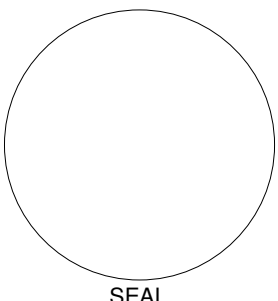

IN MY PROFESSIONAL JUDGEMENT AND TO THE BEST OF MY KNOWLEDGE AND BELIEF, THE PLANS AND SPECIFICATIONS CONTAINED HEREIN COMPLY WITH ALL APPLICABLE BUILDING CODES.

Di Lido Residence

815 West Di Lido Drive
Miami Beach, FL 33139

SIMON NICHOLLS
815 West Di Lido Drive
Miami Beach, FL 33139

PERMIT SET

REVISIONS

No.	Description	Date
A	BLDG.DEPT.COMMENTS	03.05.2018
C	BLDG.DEPT.COMMENTS	07.03.2018

YARD DIAGRAMS

SHEET TITLE

DATE 10.04.2017
DRAWN BY A.V.
REVIEWED BY C.J.B.

PROJECT NUMBER
1733

SHEET

A-102