



NOT FOR CONSTRUCTION

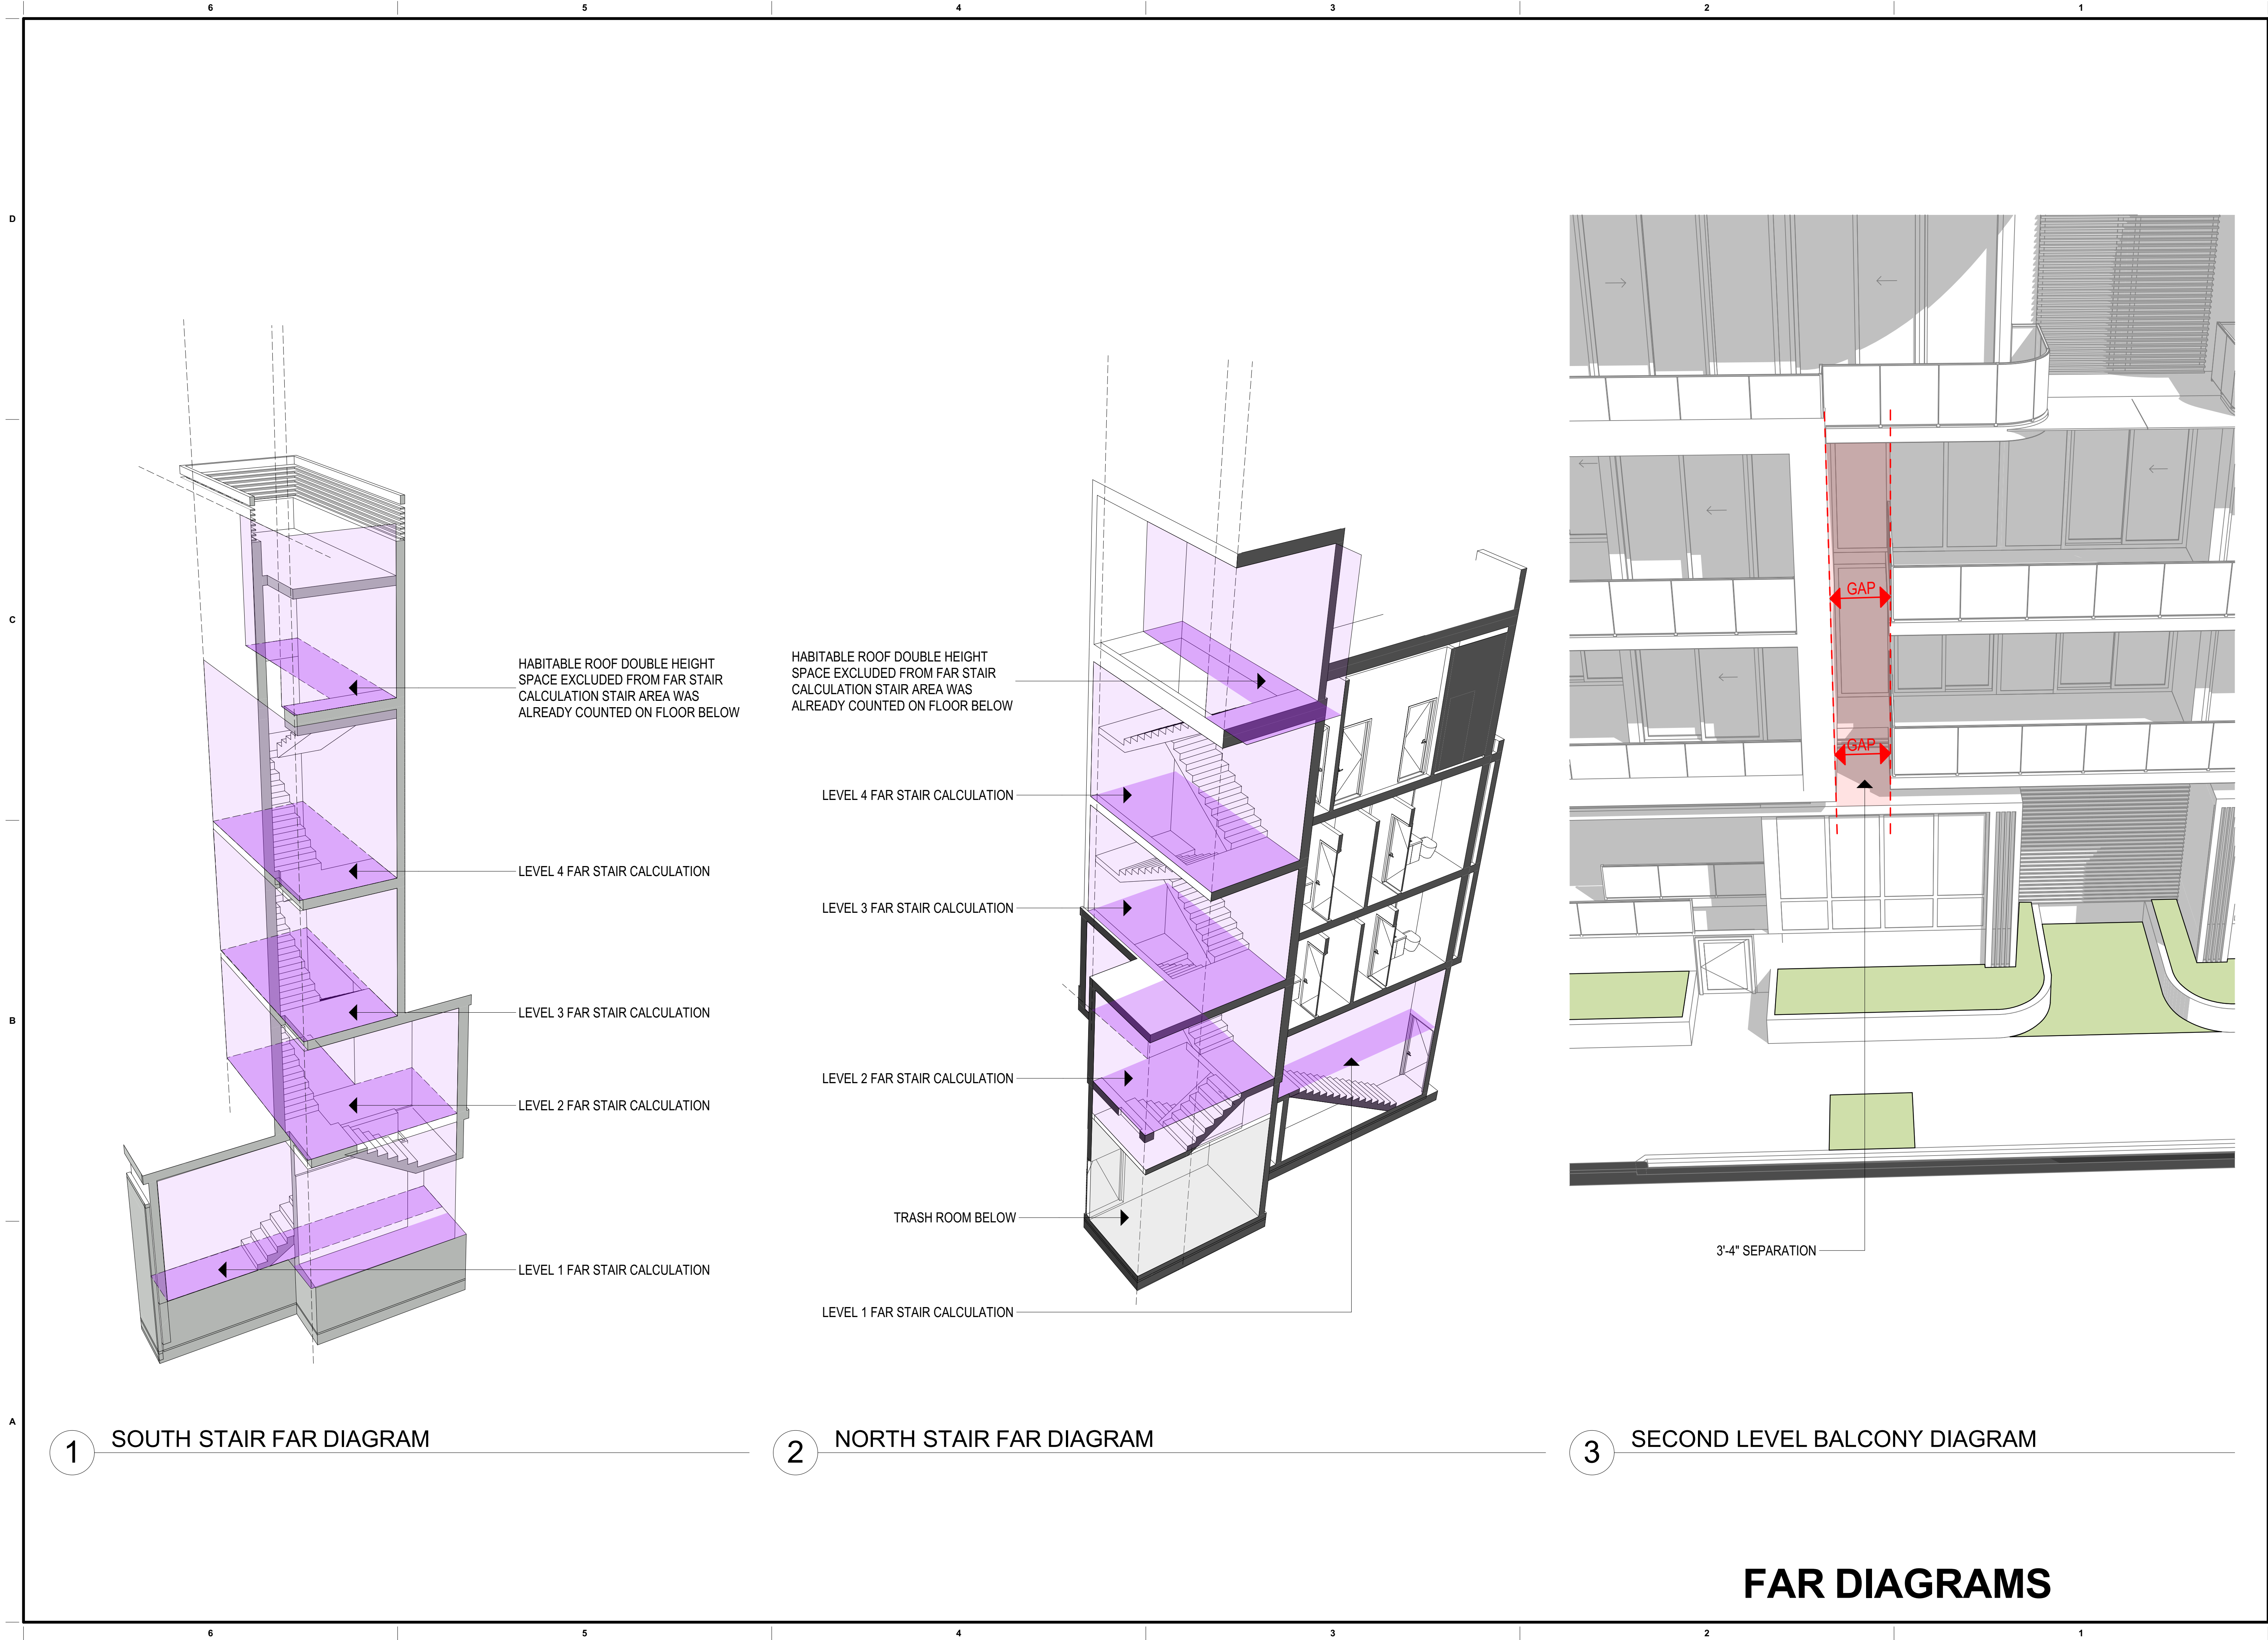

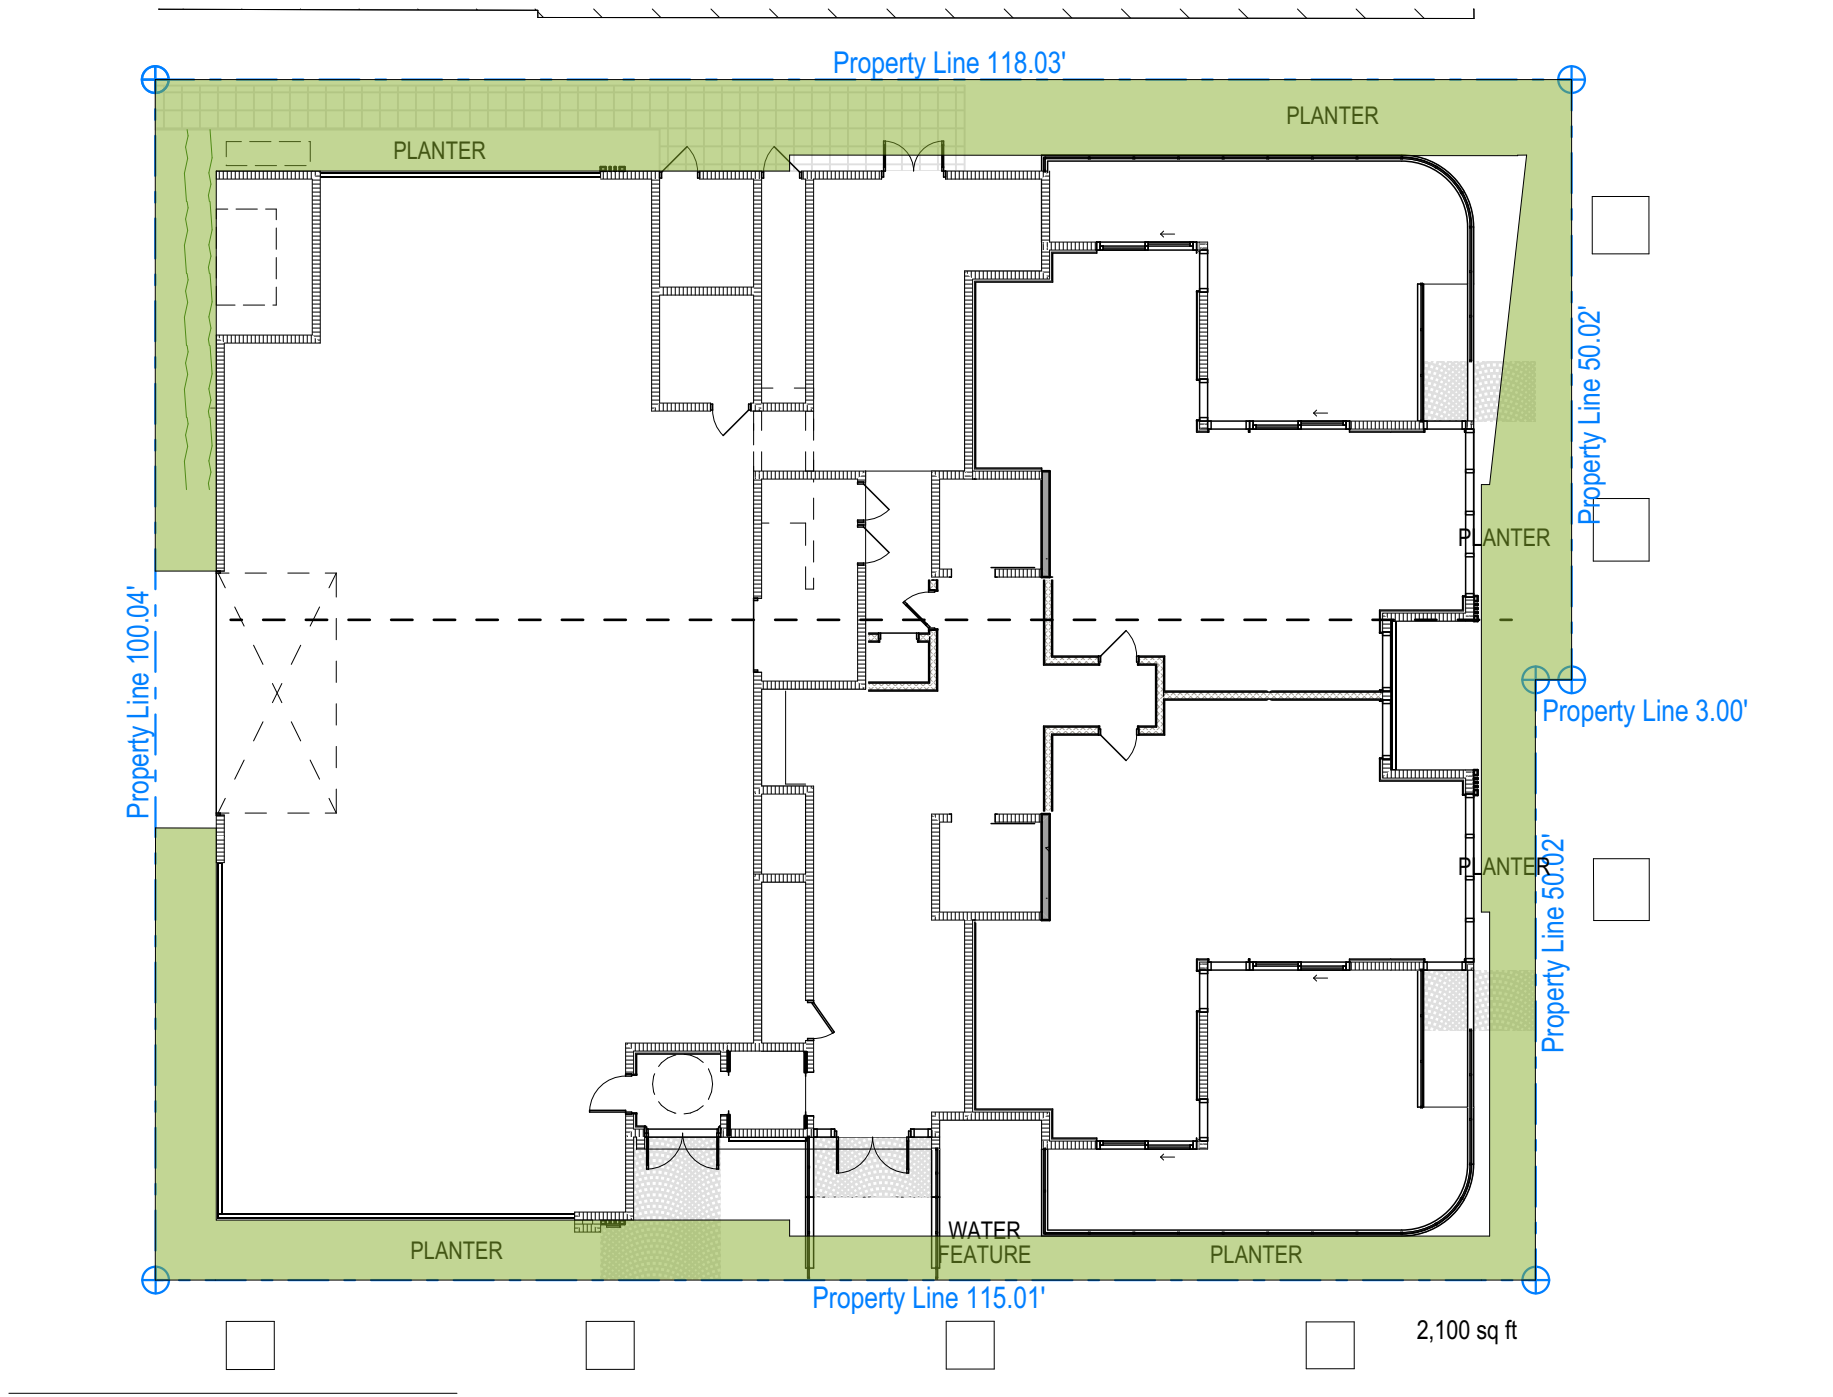

1 OPEN SPACE_LEVEL 1 **2,100 SF**
SCALE: 1/16" = 1'-0"
0 8' 16' 32'

*If printend in 11"x17" (half-size). The scale of this drawing will be 1/32" = 1'-0"

OPEN SPACE REQUIRED R-PS3


LOT AREA: 11,657 SF

OPEN SPACE REQUIRED [0.7] : 8,159.9 SF

OPEN SPACE PROVIDED ON-SITE: 4,600 SF
OPEN SPACE PROVIDE THROUGH PAYMENT OF IN-LIEU-OF FEE
INTO THE SOUTH POINT STREETScape FUND 3,560 SF


LIVING LANDSCAPE MATERIAL

LEVEL 2 LANDSCAPE REQUIRED [0.25] : 625 SF
LEVEL 2 LANDSCAPE PROVIDED: 635 SF

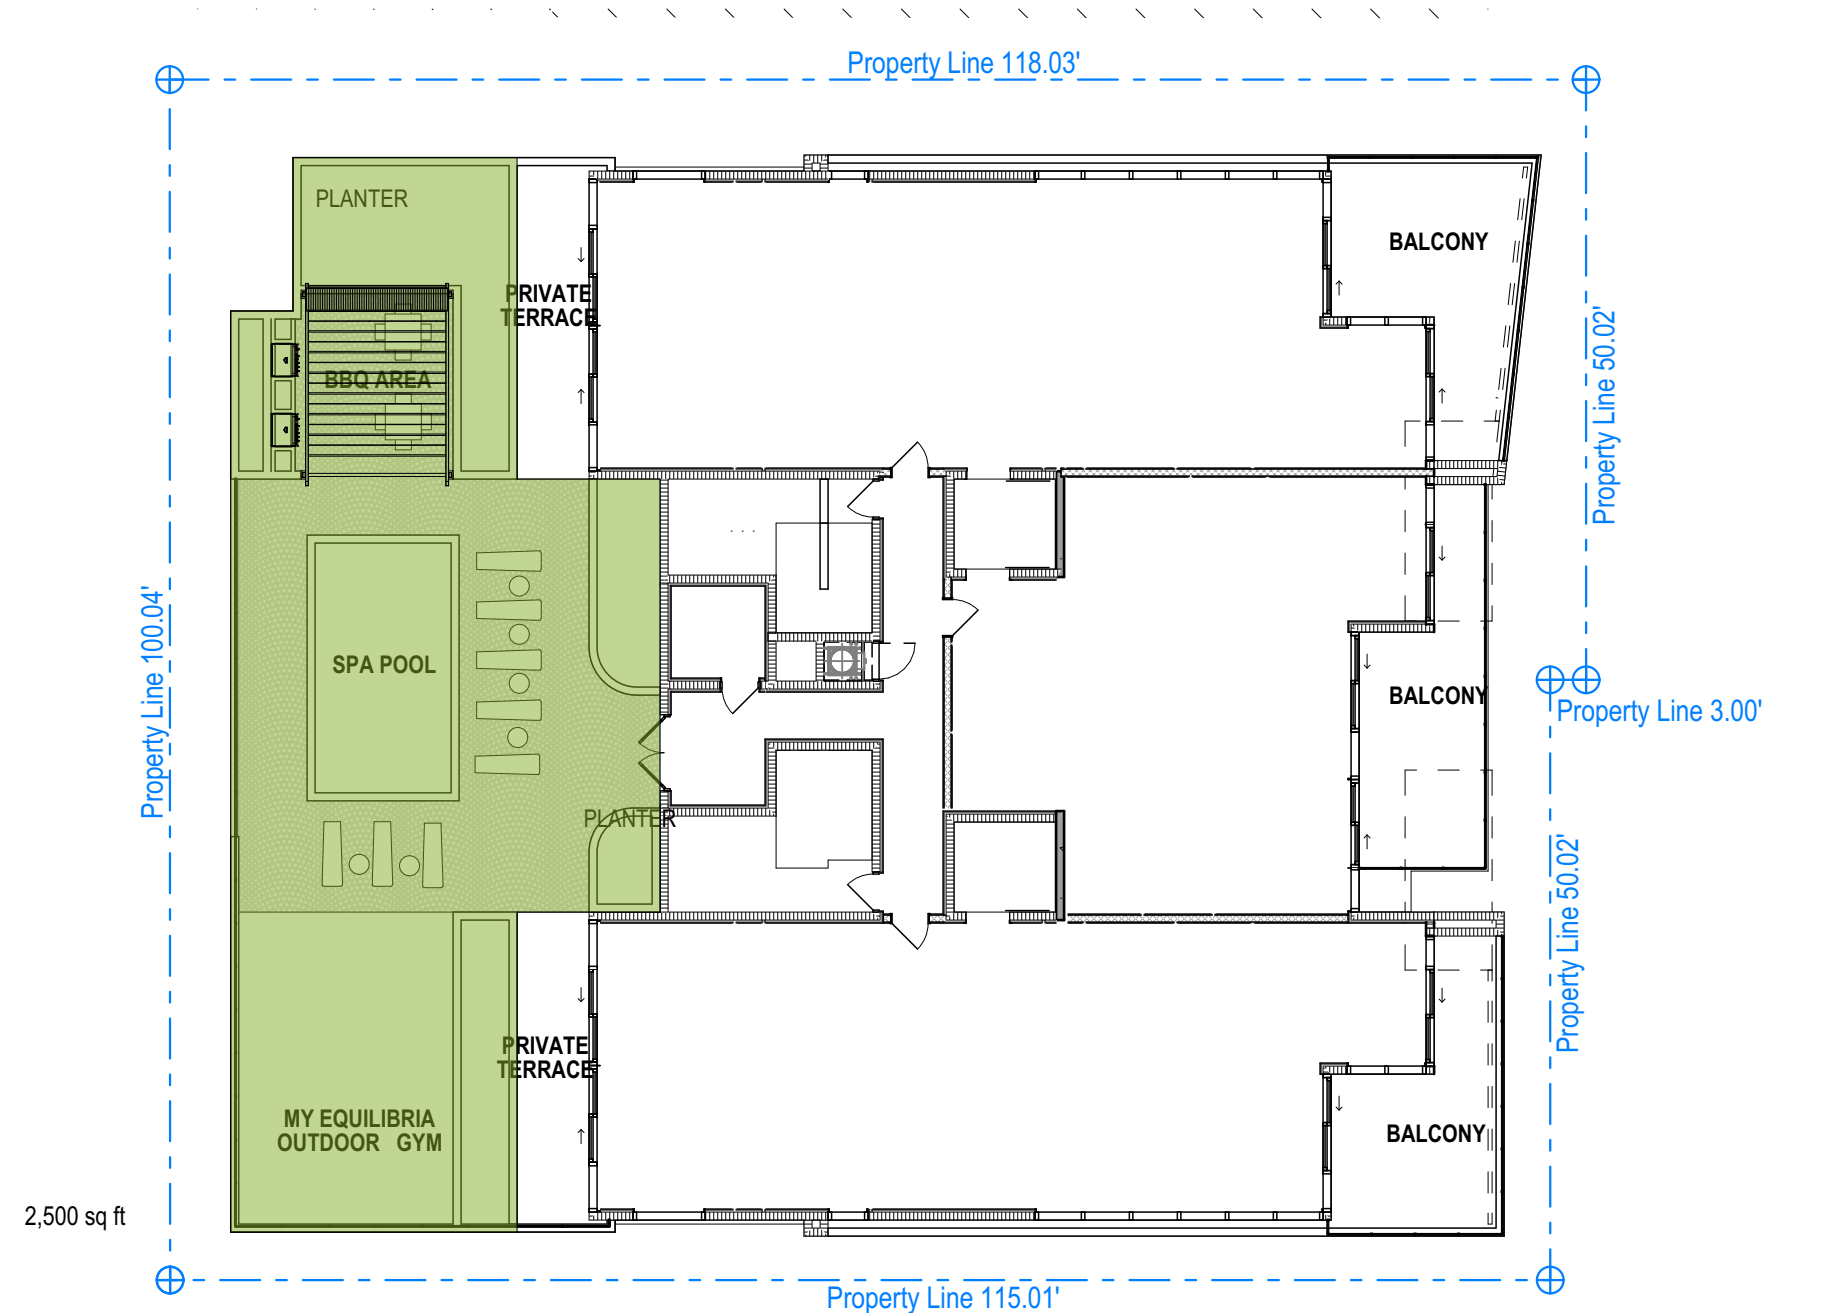

2 OPEN SPACE_LEVEL 2 **2,500 SF**
SCALE: 1/16" = 1'-0"
0 8' 16' 32'

*If printend in 11"x17" (half-size). The scale of this drawing will be 1/32" = 1'-0"

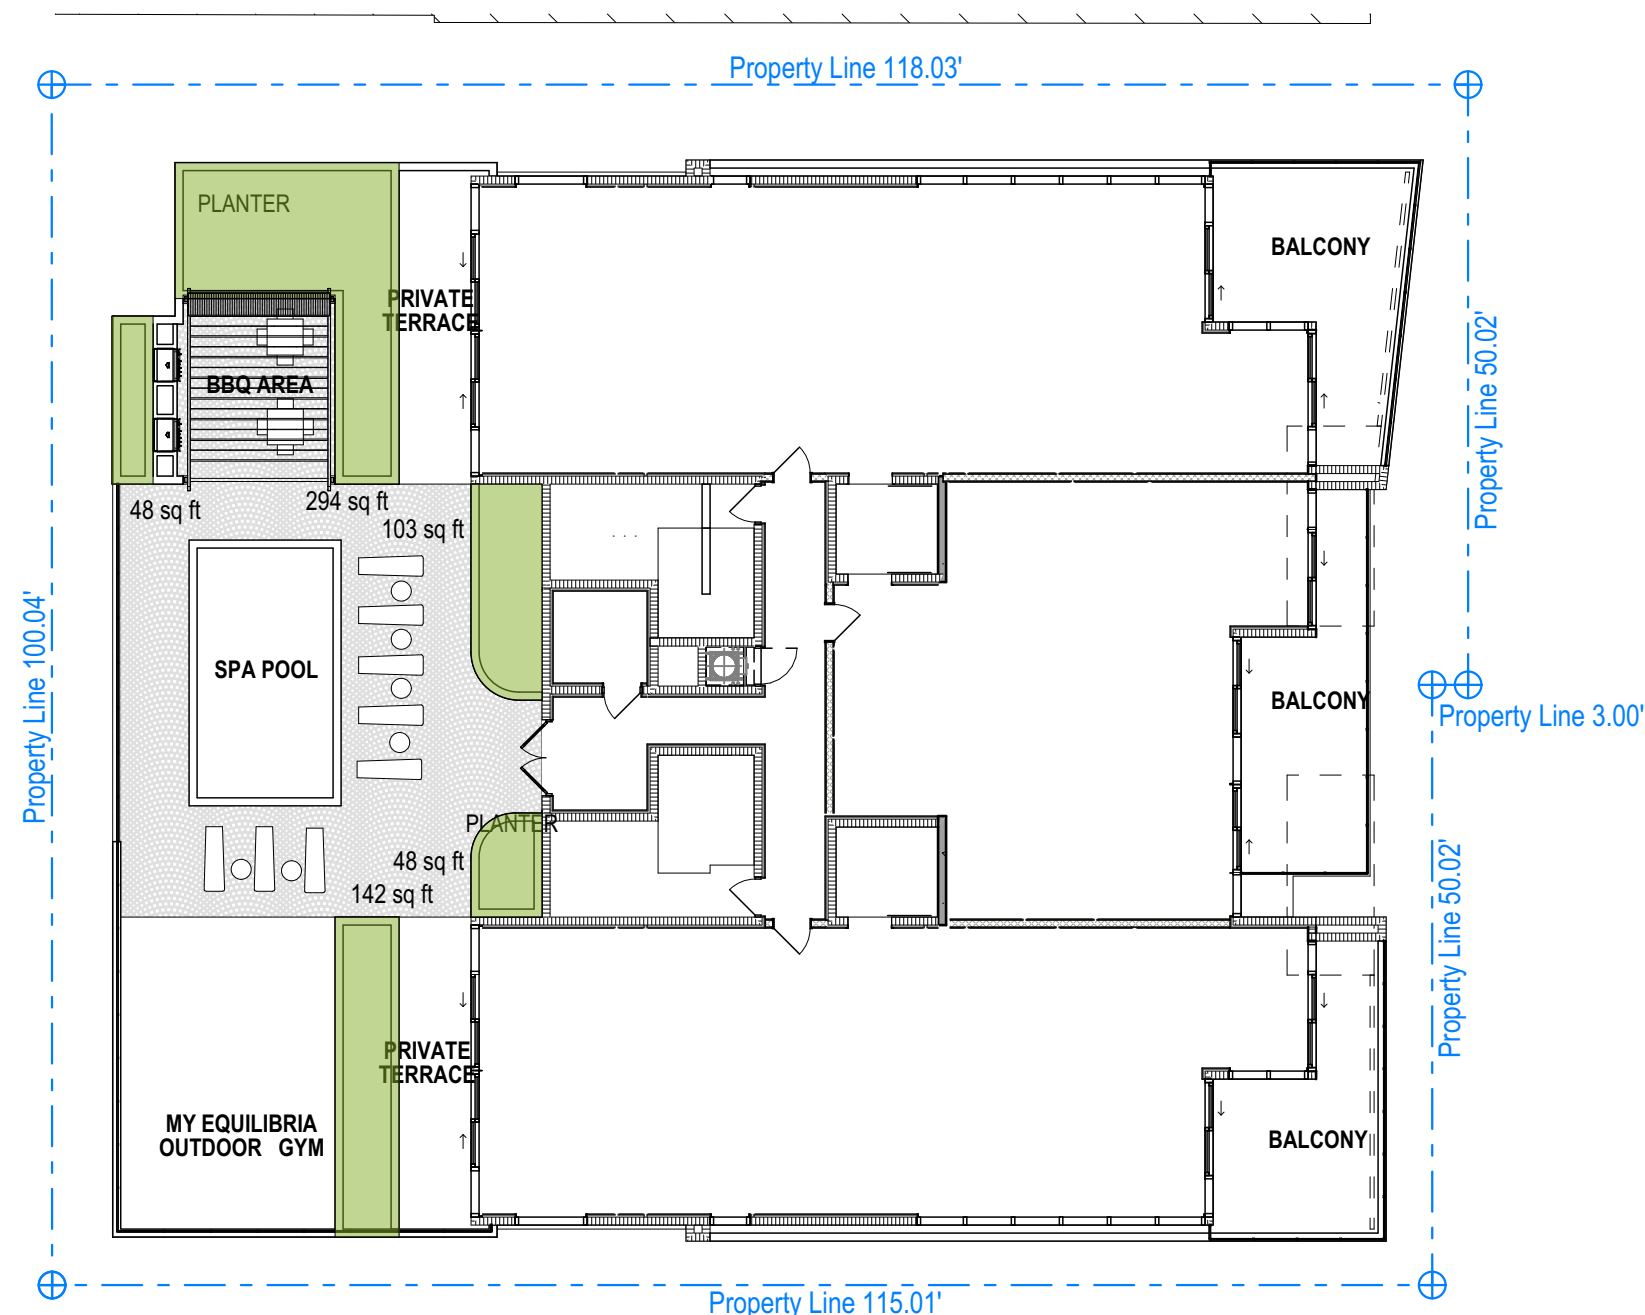

3 LANDSCAPE AREA_LEVEL 2 **635 SF**
SCALE: 1/16" = 1'-0"
0 8' 16' 32'

*If printend in 11"x17" (half-size). The scale of this drawing will be 1/32" = 1'-0"

OPEN SPACE CALCULATIONS

312 OCEAN PARK

304-312 Ocean Drive, Miami Beach, FL 33139, USA

Revisions

Owner Information

MULTIPLAN

312

OCEAN PARK
SOUTH BEACH

Consultant

Luis O. Revuelta

AR-0007972

PLANNING & ZONING FINAL SUBMITTAL

Date

12/10/2018

Scale

AS SHOWN

Project No.


1816

Sheet Name


GROSS AREA

Sheet No.


A-015

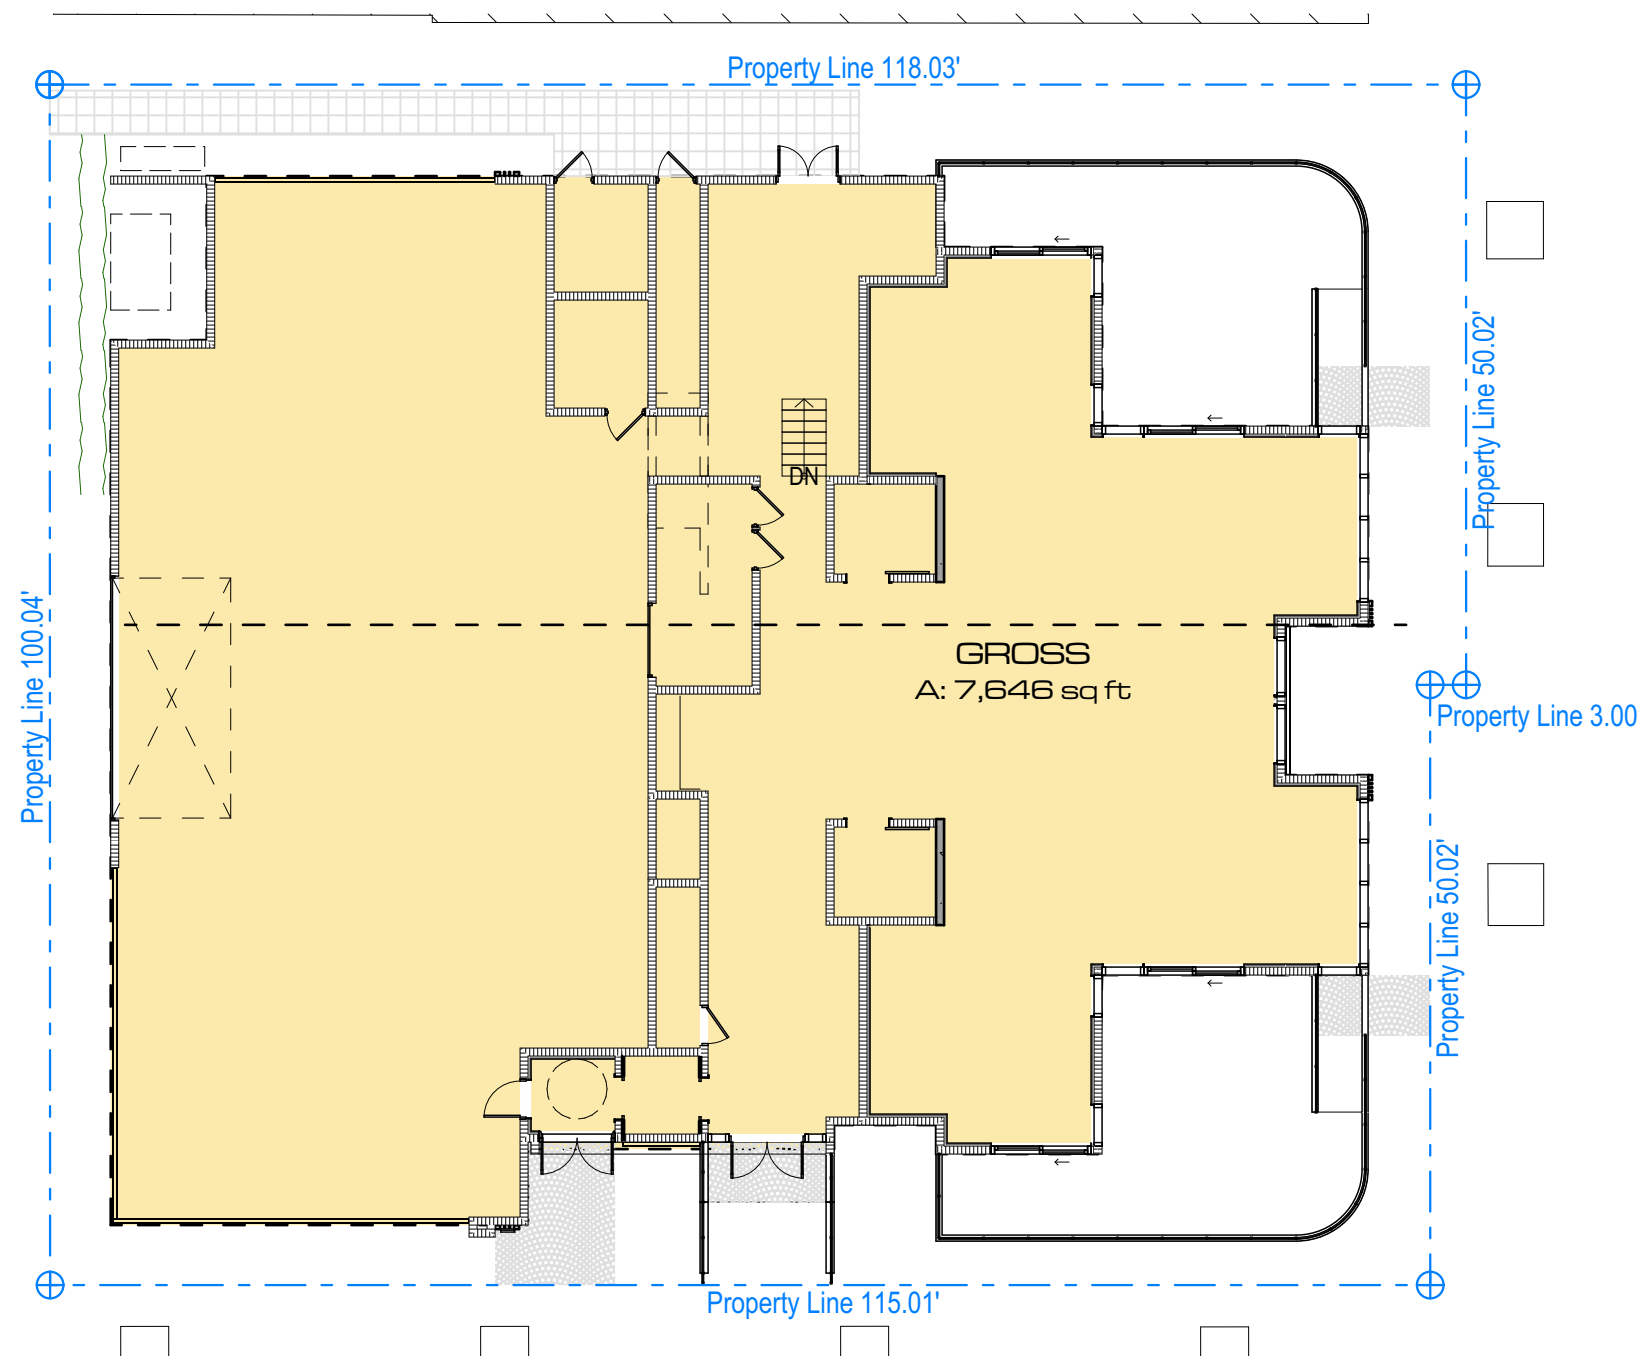


1 GROSS LEVEL 1
SCALE: 1/16" = 1'-0"

 


*If printend in 11"x17" (half-size). The scale of this drawing will be 1/32" = 1'-0"

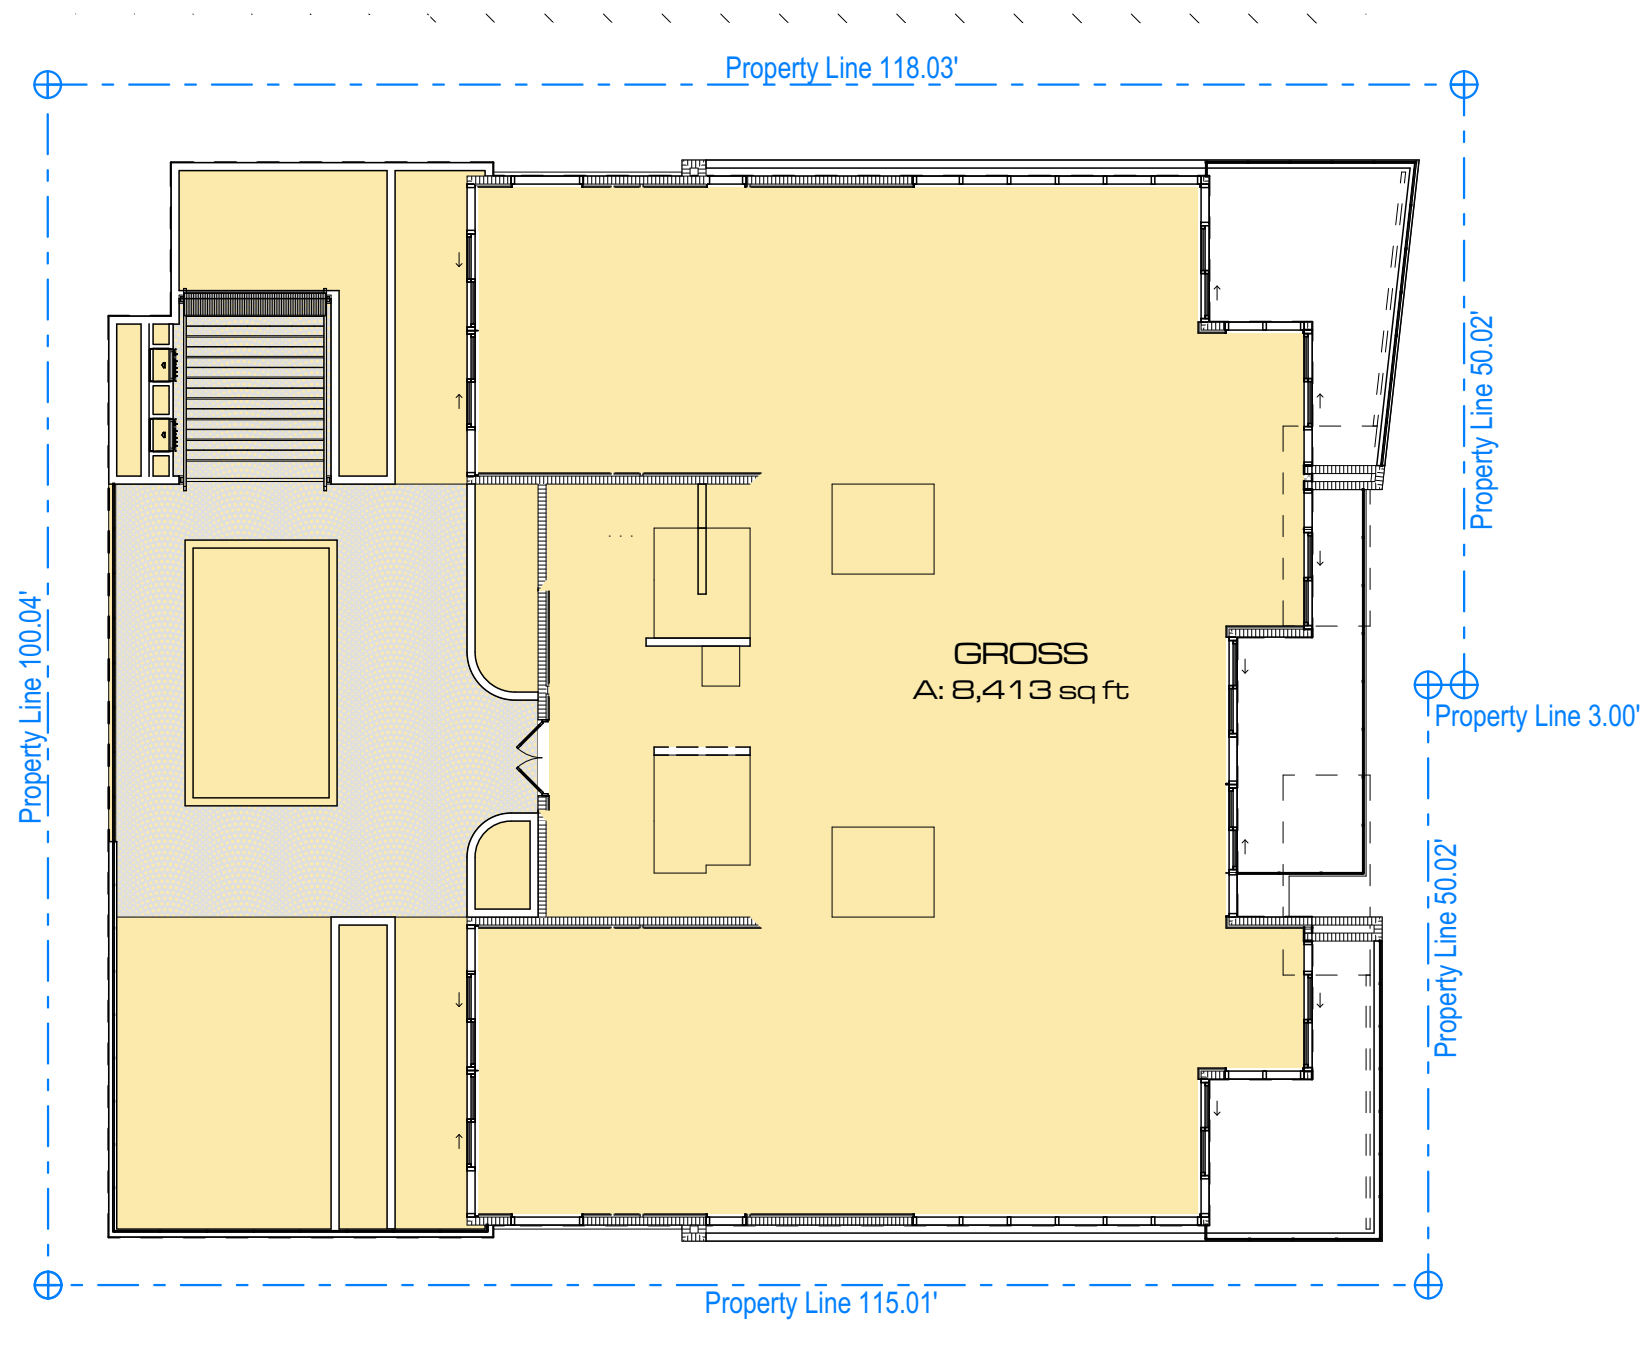


2 GROSS LEVEL 2
SCALE: 1/16" = 1'-0"

 


*If printend in 11"x17" (half-size). The scale of this drawing will be 1/32" = 1'-0"

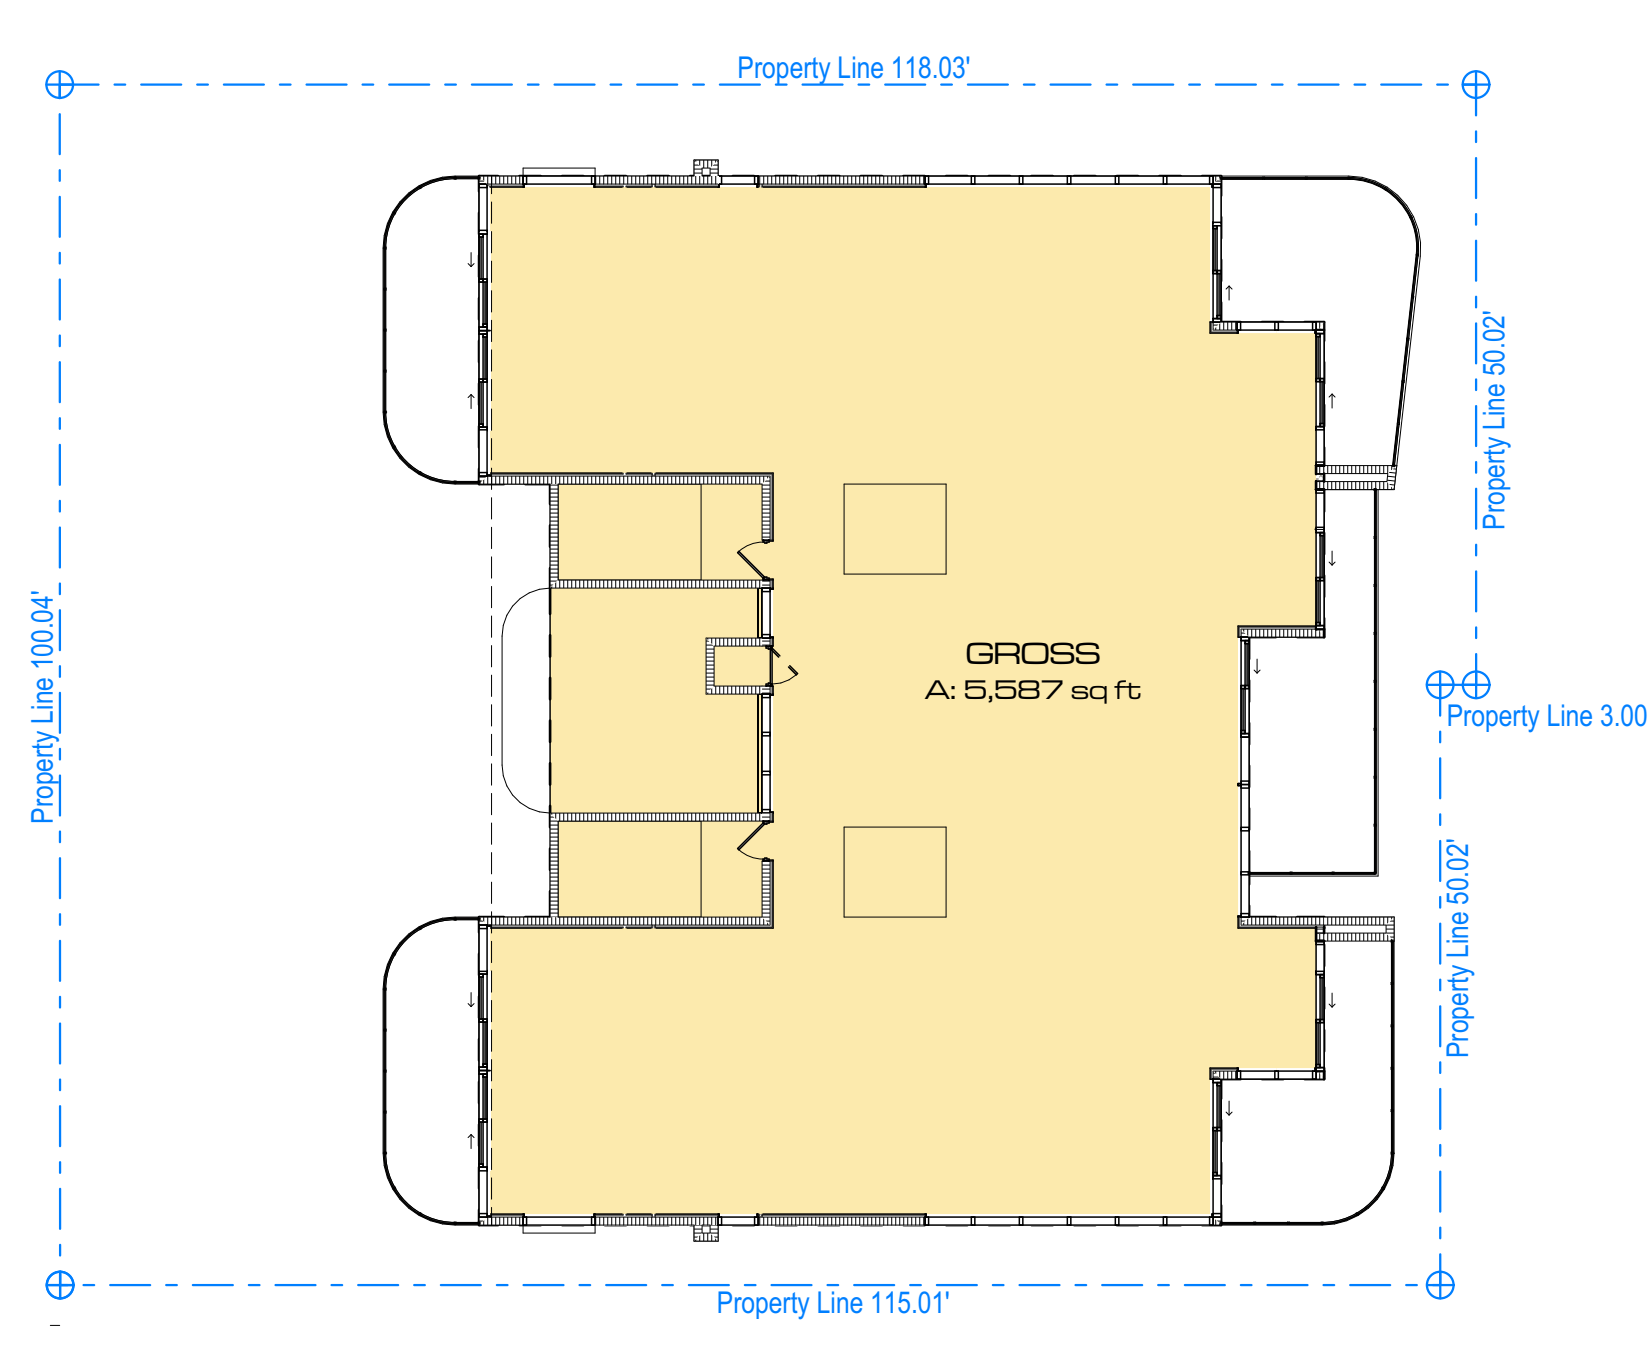


3 GROSS LEVEL 3
SCALE: 1/16" = 1'-0"

 


*If printend in 11"x17" (half-size). The scale of this drawing will be 1/32" = 1'-0"

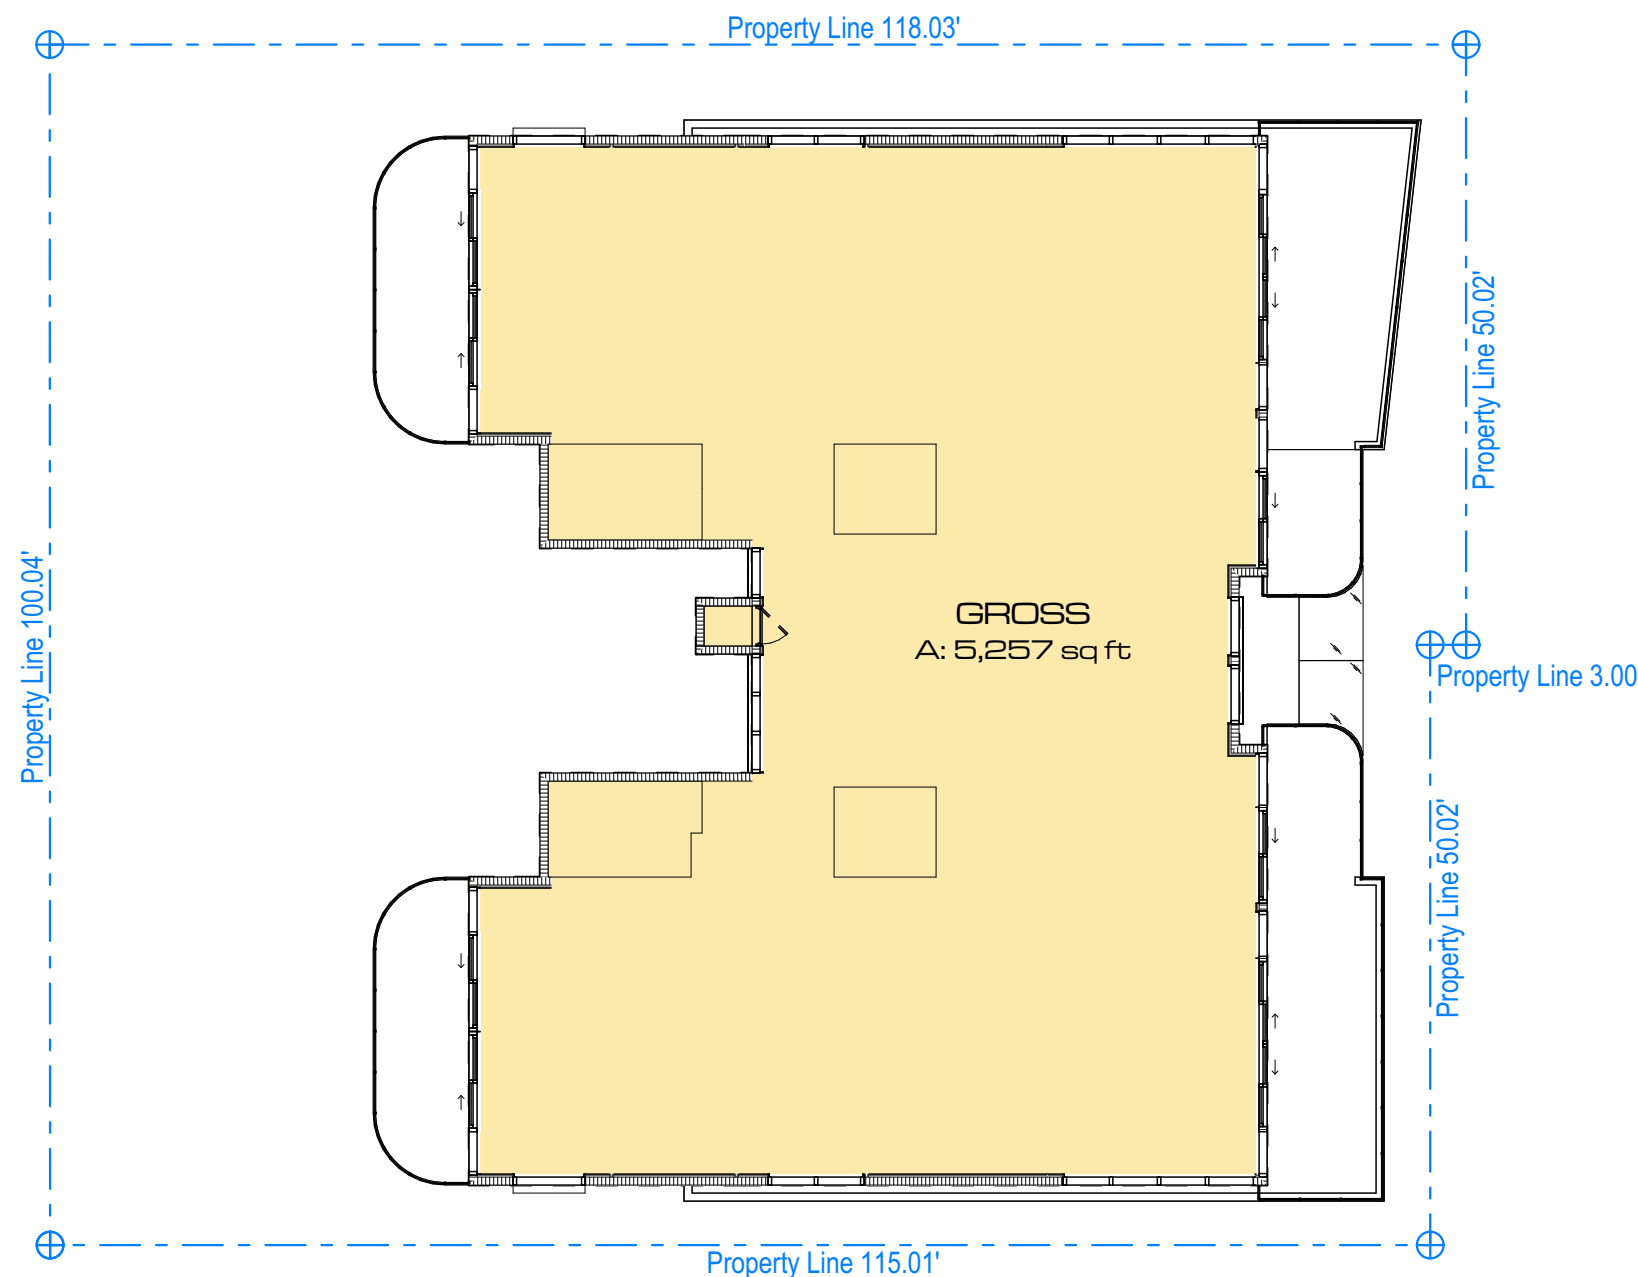


4 GROSS LEVEL 4
SCALE: 1/16" = 1'-0"

 

*If printend in 11"x17" (half-size). The scale of this drawing will be 1/32" = 1'-0"

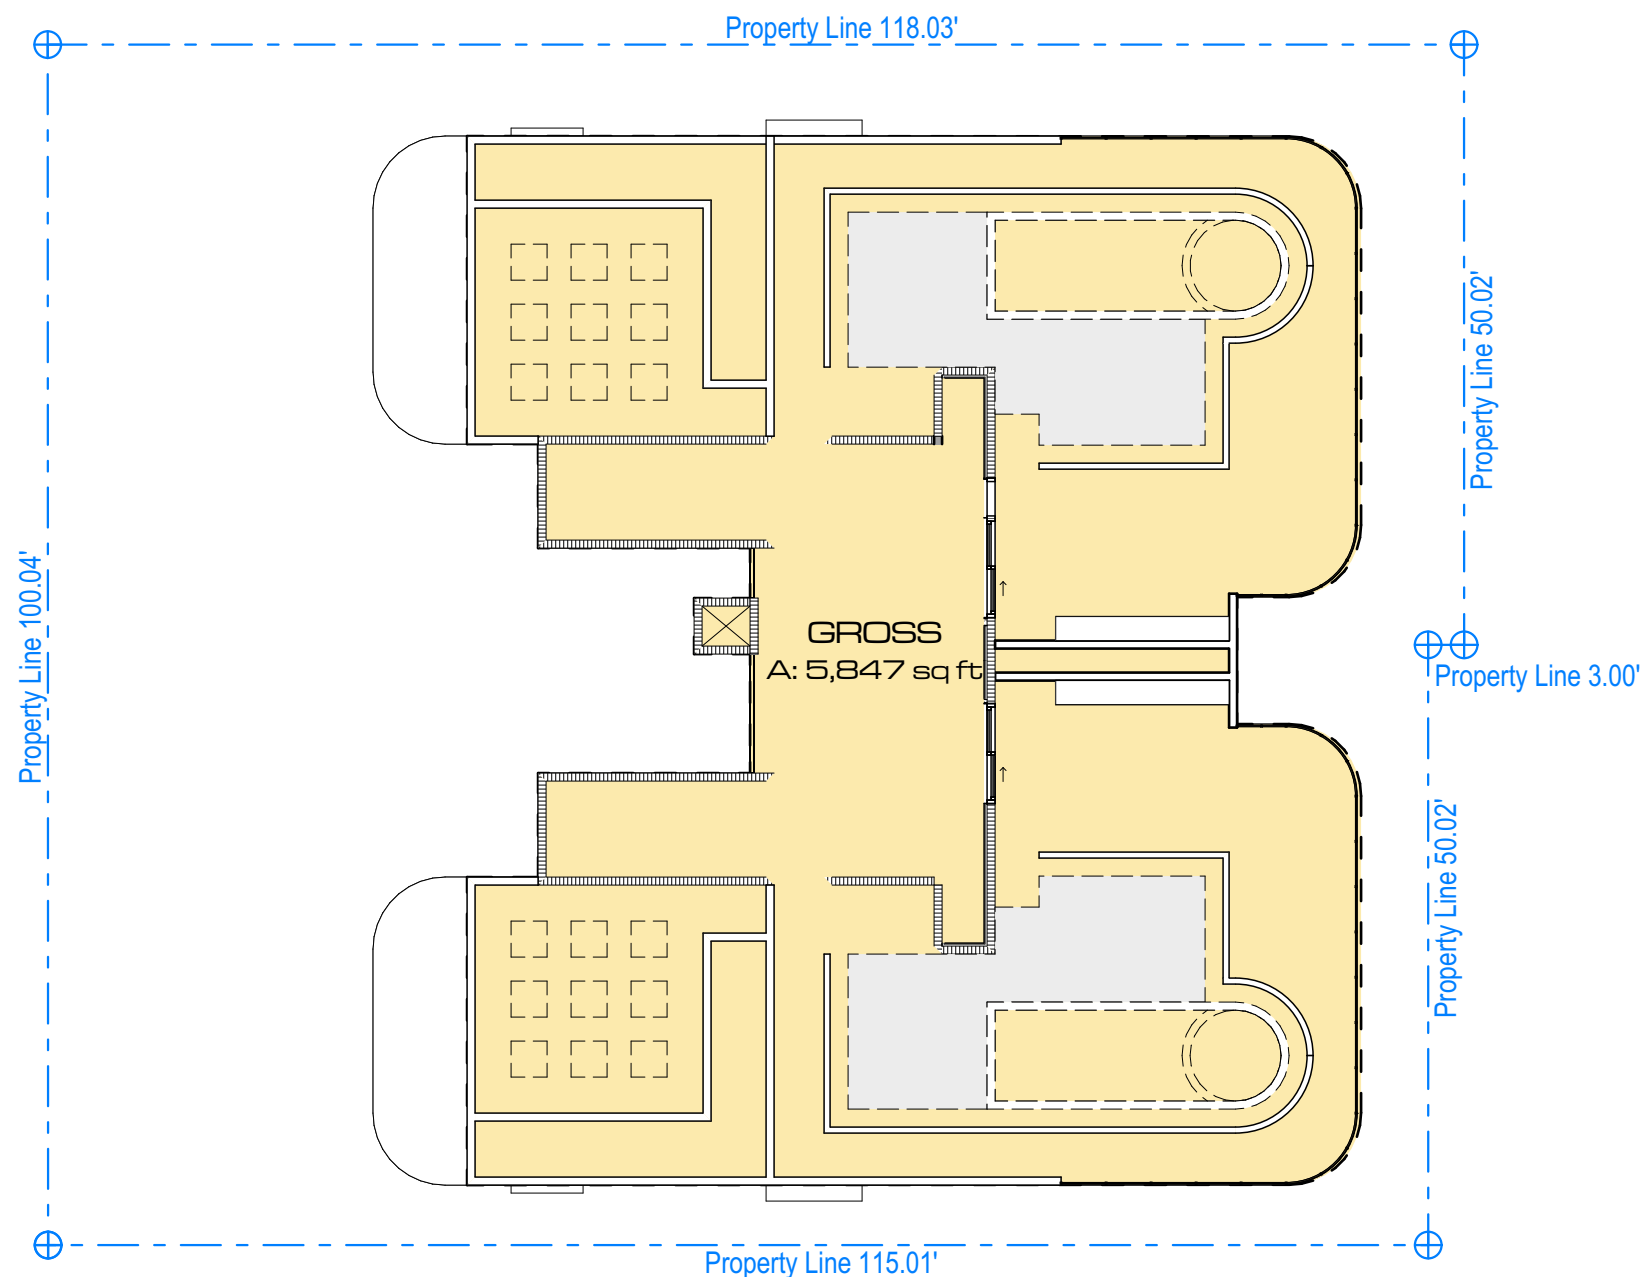

 5 GROSS TOP OF HABITABLE ROOF
SCALE: 1/16" = 1'-0"



*If printend in 11"x17" (half-size). The scale of this drawing will be 1/32" = 1'-0"

GROSS		
Floor (Story)	Name	Measured Area
LEVEL 1		
	GROSS	7,646
		7,646 sq ft
LEVEL 2		
	GROSS	8,413
		8,413 sq ft
LEVEL 3		
	GROSS	5,587
		5,587 sq ft
LEVEL 4		
	GROSS	5,257
		5,257 sq ft
TOP OF HABITABLE ROOF		
	GROSS	5,847
		5,847 sq ft
TOTAL		
		32,750 sq ft

GROSS AREA CALCULATIONS

nsultant

Sheet No. 22

N




NOT FOR CONSTRUCTION

These Design And Drawings Are The Copyrighted Property Of Revuelta Architecture International, P.A. and May Not Be Reproduced, Copied, or Transmitted in Any Form or by Any Means, Electronic or Mechanical, Without Prior Written Consent of the Architect. The Contractor Must Check And Verify All Dimensions Of The Job And Be Responsible For Any Discrepancies To The Architects Before Commencing Work. Drawings Not to be Scaled. The BIM Server, RAA - BIM Server, 2711616_304 OCEAN DRIVE MODEL 1 - 19 April saved by - 088 - 12/7/2018

OCEAN CT ALLEY

OCEAN DRIVE

3RD STREET

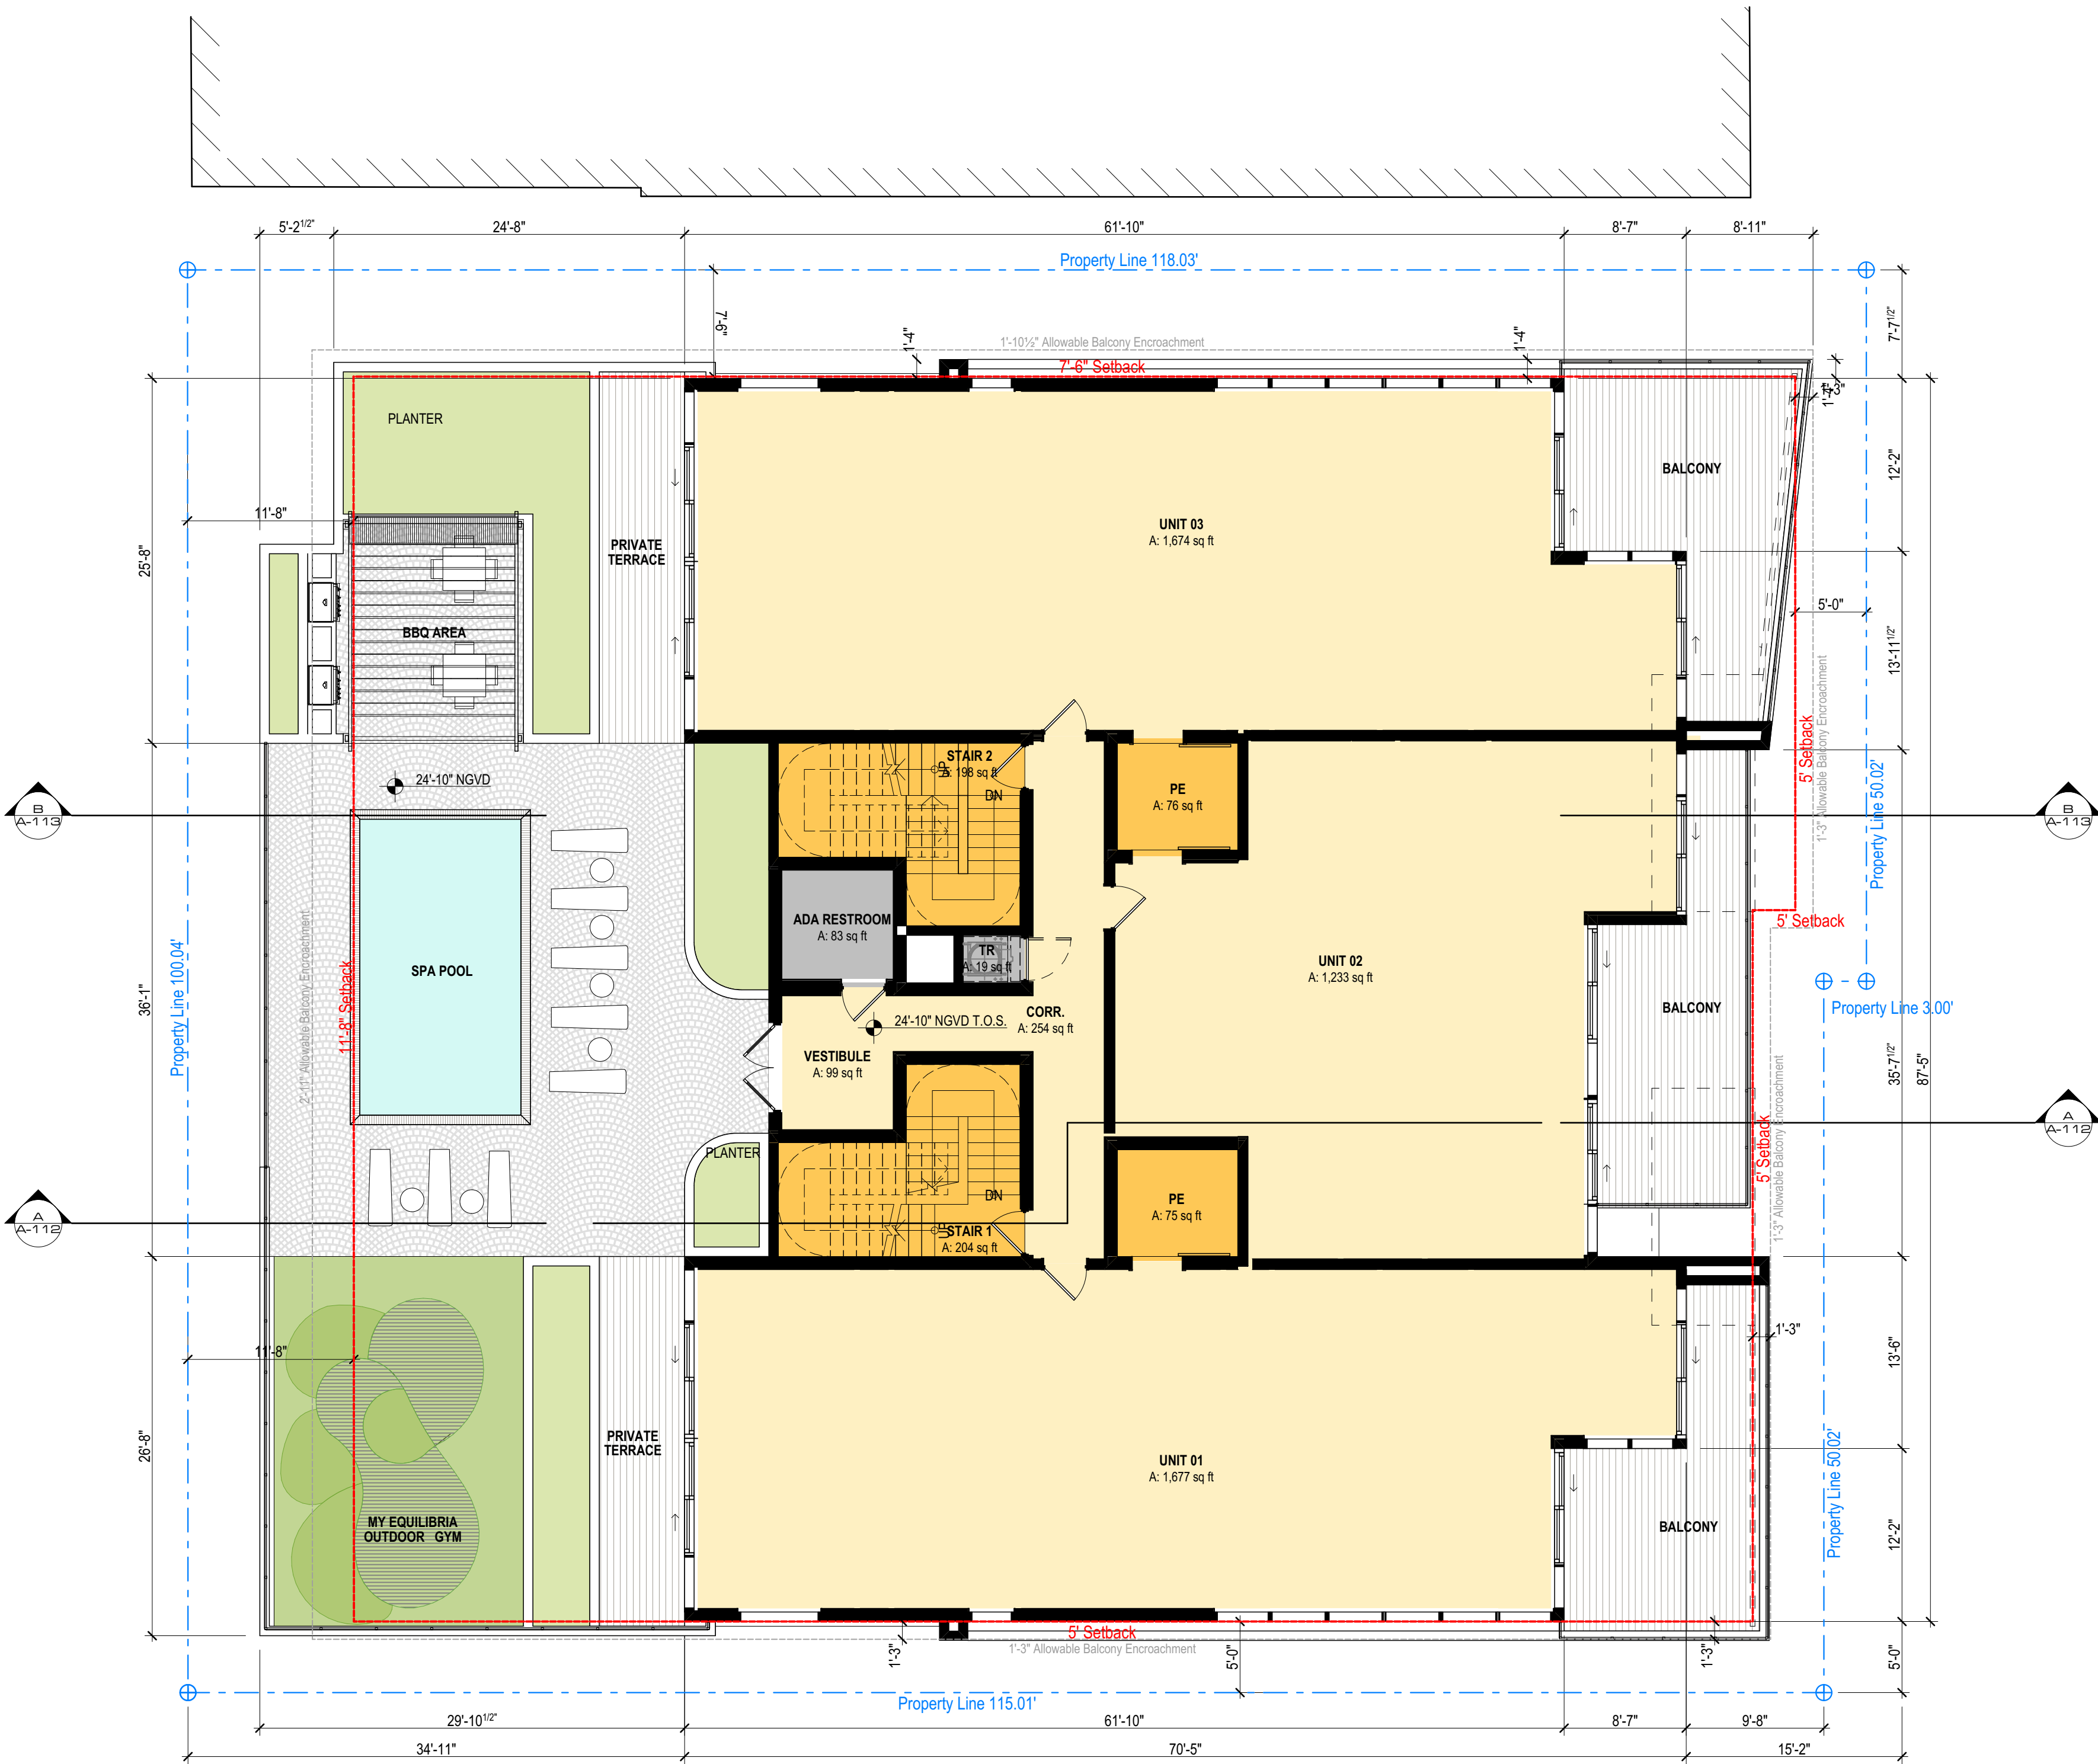

1

LEVEL 2 FLOOR PLAN

SCALE: 1/8" = 1'-0"



*If printend in 11"x17" (half-size). The scale of this drawing will be 1/16" = 1'-0"

N

revuelta
architecture
international

Miami
Santiago, Chile

revuelta-architecture.com

2950 SW 27TH AVE
SUITE 110
MIAMI, FL 33133
T: 305.590.5000
F: 305.590.5040

Project

312 OCEAN PARK

304-312 Ocean Drive, Miami Beach, FL 33139, USA

Revisions

Owner Information

MULTIPLAN

312
OCEAN PARK
SOUTH BEACH

Consultant

Luis O. Revuelta

AR-0007972

PLANNING & ZONING
FINAL SUBMITTAL

Date

12/10/2018

Scale

AS SHOWN

Project No.

1816

Sheet Name

LEVEL 2 FLOOR PLAN

Sheet No.

A-103

3304-312 Ocean Drive, Miami Beach, FL, 33139, USA

Owner Information

312
OCEAN PARK
SOUTH BEACH

Consultant

AR-0007972

FLOOR PLAN

A 104

A-104



N

SCALE: 1/8" = 1'-0"


*If printed in 11"x17" (half-size). The scale of this drawing will be 1/16" = 1'-0"

304-312 Ocean Drive, Miami Beach, FL, 33139, USA

312
OCEAN PARK
SOUTH BEACH

Consultant

Sheet No.

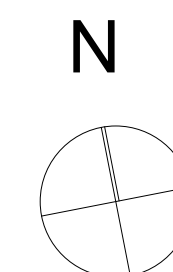

304-312 Ocean Drive, Miami Beach, FL, 33139, USA


312
OCEAN PARK
SOUTH BEACH

Consultant

HABITABLE ROOF PLAN

A-106

These Design And Drawings Are The Copyrighted Property Of Revue Architecture International P.A. and May Not Be Reproduced Except with Specific Written Consent of the Architect. The Contractor Must Check And Verify All Dimensions Of The Job And Be Responsible For Same, Reporting Any Discrepancies To The Architects Before Commencing work. Drawings Not to be Scaled. File: BIM Server: RAI - BIM Server 211816; 304 OCEAN Drive/1816 304 OCEAN Drive MODEL 1 - By: Last saved by - Date: 12/27/2018

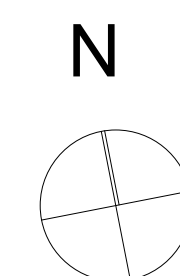

1 HABITABLE ROOF PLAN

SCALE: 1/8" = 1'-0"

0 4' 8' 16'

*If printend in 11"x17" (half-size). The scale of this drawing will be 1/16" = 1'-0"

These Design And Drawings Are The Copyrighted Property Of Revuelta Architecture International. P.A. and May Not Be Reproduced Except with Specific Written Consent of the Architect.
The Contractor Must Check And Verify All Dimensions Of The Job And Be Responsible For Same. Reporting Any Discrepancies To The Architects Before Commencing work. Drawings Not to be Scaled.
The BIM Server: RAI - BIM Server 2/1/18 - 304 OCEAN DRIVE MODEL 1 - 19/18/18 - 12/2/18

NOT FOR CONSTRUCTION

OCEAN CT ALLEY

OCEAN DRIVE

3RD STREET

1

MECHANICAL ROOF PLAN

SCALE: 1/8" = 1'-0"

*If printend in 11"x17" (half-size). The scale of this drawing will be 1/16" = 1'-0"

0 4' 8' 16'

N

revuelta
architecture
international

Miami
Santiago, Chile

revuelta-architecture.com

2950 SW 27TH AVE
SUITE 1110
MIAMI, FL 33133
T: 305.590.5000
F: 305.590.5040

Project

312 OCEAN PARK

304-312 Ocean Drive, Miami Beach, FL 33139, USA

Revisions

Owner Information

MULTIPLAN

312
OCEAN PARK
SOUTH BEACH

Consultant

Luis O. Revuelta

AR-0007972

PLANNING & ZONING
FINAL SUBMITTAL

Date

12/10/2018

Scale

AS SHOWN

Project No.

1816

Sheet Name

ROOF PLAN

Sheet No.

A-107