


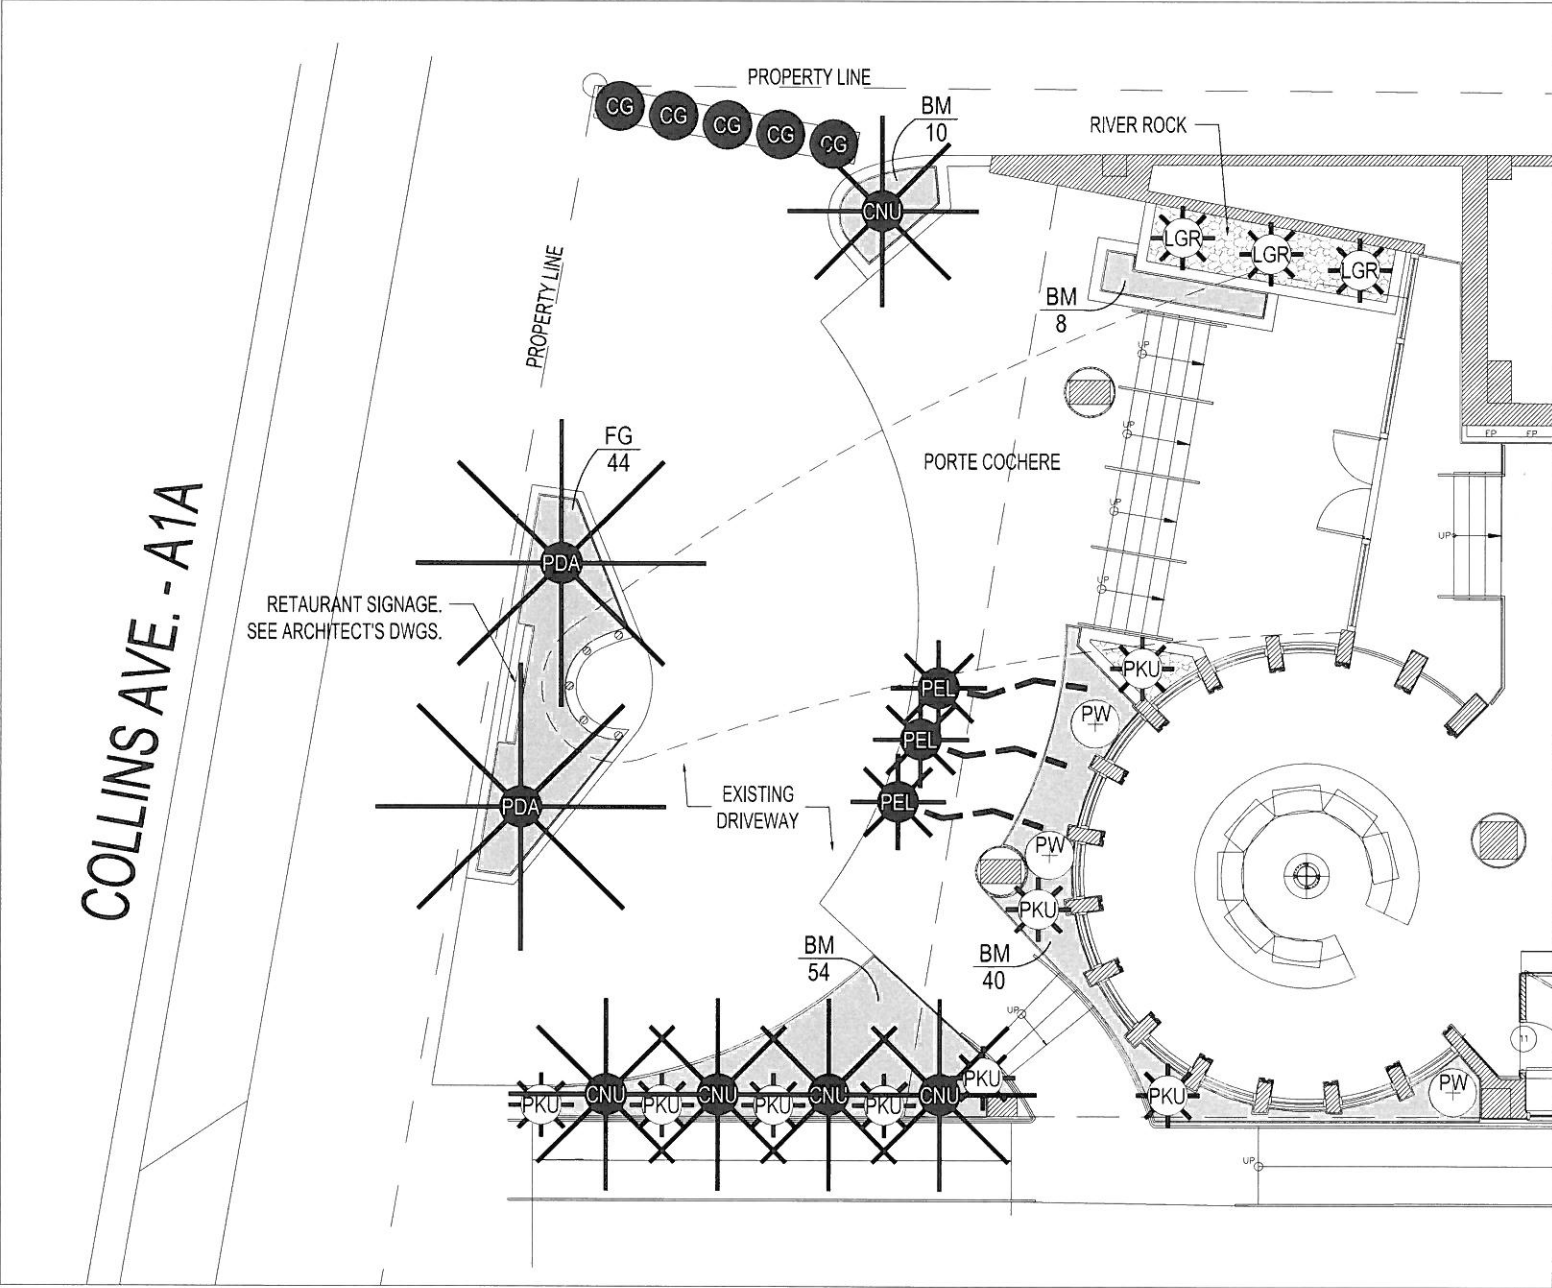

PLANT LIST

Symb.	Quant.	Botanical Name	Common Name	Description
Palms				
CNU	5	<i>Cocos nucifera</i>	Coconut Palm	Existing to remain. 25'+ OA.
LGR	4	<i>Licuala grandis</i>	Ruffled Fan Palm	7 G. 3' HT.
PDA	2	<i>Phoenix dactylifera</i>	Date Palm	Existing to remain. 40'+ OA.
PEL	4	<i>Ptychosperma elegans</i>	Solitaire Palm	Existing to remain.
PKU	7	<i>Pinanga kuhlii</i>	Ivory Cane Palm	25 G. 8'-10' HT.
Shrubs				
CG	1	<i>Clusia guttifera</i> hedge	Small Leaf Clusia Hedge	Existing to remain.
Accents				
PW	3	<i>Philodendron wilsonii</i>	Same	3 G. Full.
Groundcovers				
BM	112	<i>Philodendron 'Burle Marx'</i>	Same	G. Full. 18" OC.
FG	44	<i>Ficus 'Green Island'</i>	Same	G. Full. 18" OC.

1 LANDSCAPE PLAN
SCALE: 3/16" = 1'-0"

COLLABORATIVE
INDEPENDENT, INC
Landscape Designer

2347 SW 5TH ST.
MIAMI, FL 33135
T: 305.450.1115

MARSH KRIPLEN
Landscape Architect

1251 SW 20TH ST.
MIAMI, FL 33145
T: 305.322.2898

HOSPITALITY ARCHITECTURE
&
INTERIOR DESIGN



1111 KANE CONCOURSE, SUITE 301
MIAMI BEACH, FL 33134

TEL 305 866 1014
FAX 305 866 3317

tom@nightclub-design.com
www.nightclub-design.com
LICENSE # AA-000284

TATEL RESTAURANT
1669 COLLINS AVE
MIAMI BEACH, FL 33139

PROJECT No. :

DRAWN BY: A.R.


DATE: 6/9/2016

FINAL SUBMITTAL

REVISIONS:

△	
△	
△	
△	

MARSH C. KRIPLEN.

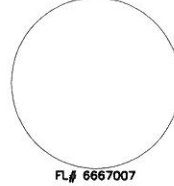


**LANDSCAPE
PLAN**

-
-

L-1

DRAWING No. 1 OF 1

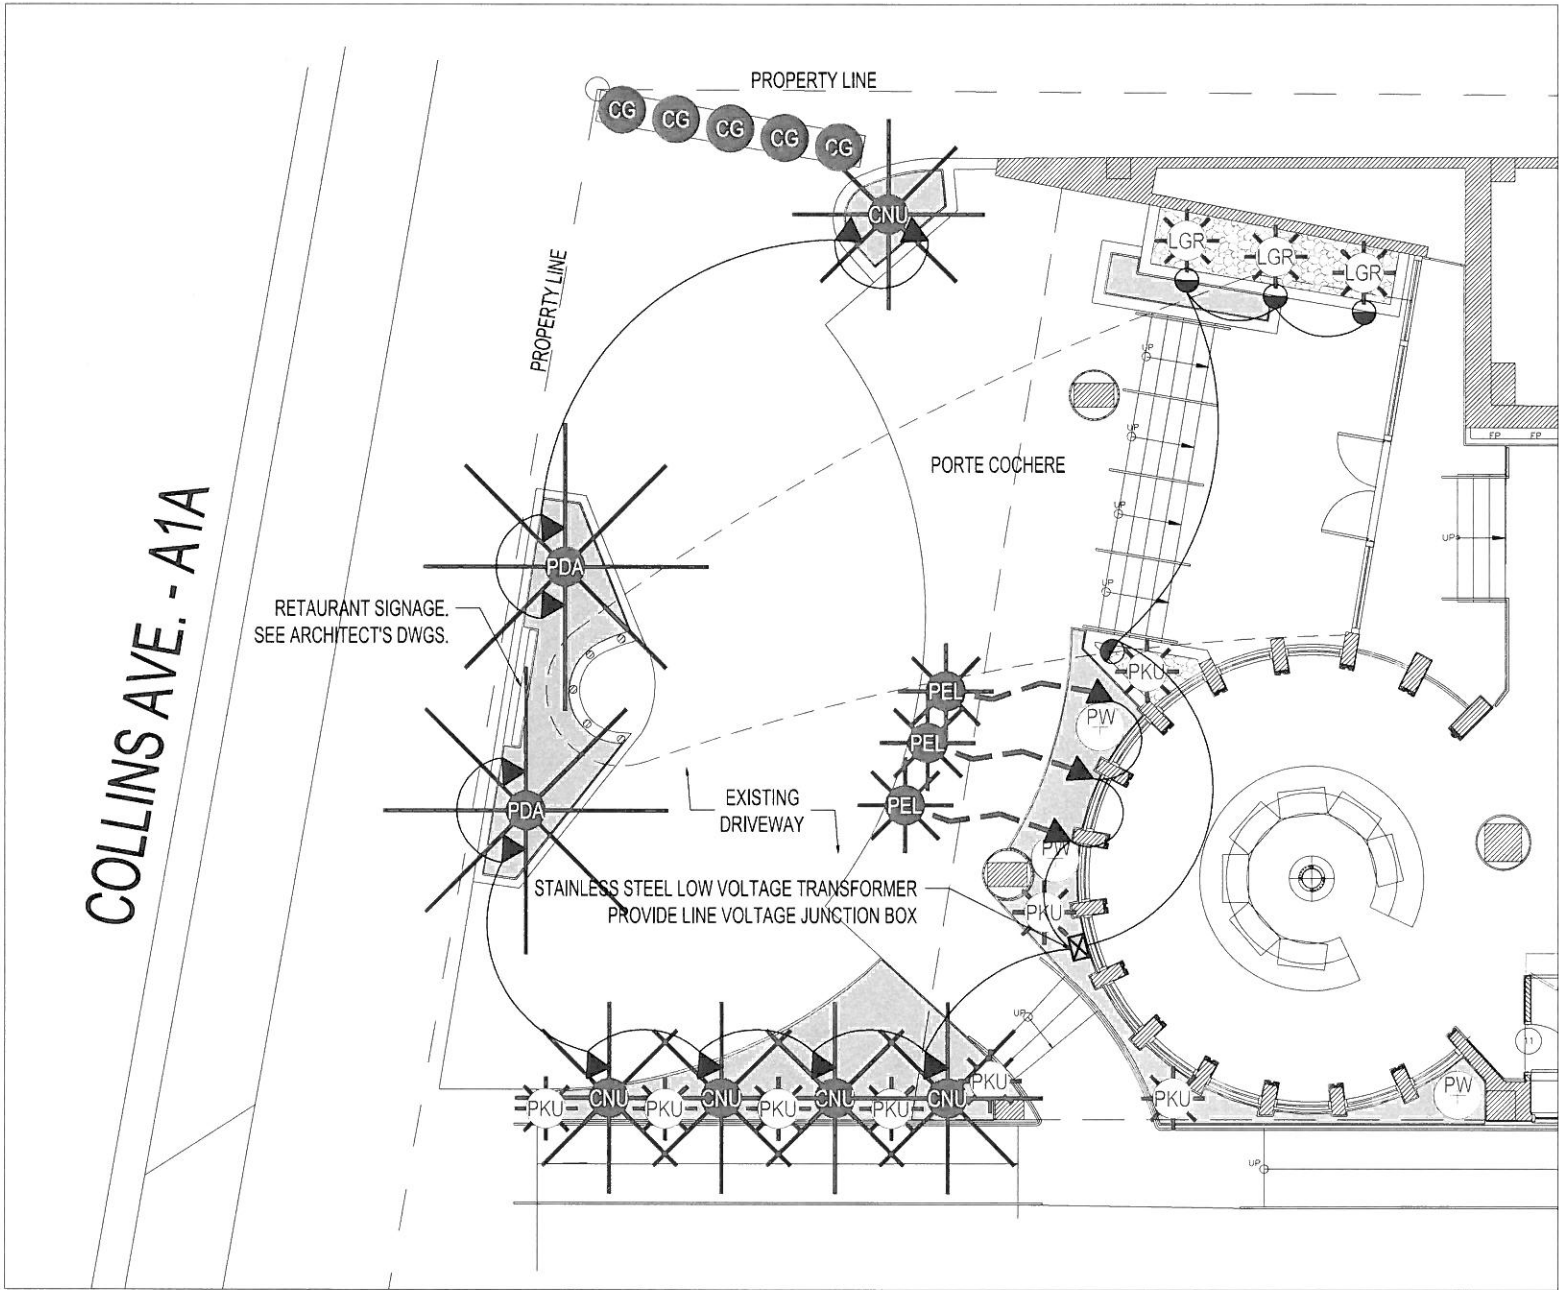

LANDSCAPE LIGHTING LEGEND

SYMBOL	TYPE	FIXTURE TYPE, MANUFACTURE & CATALOG #	FIXTURE QTY.	BULB TYPE, WATT. & LOAD	MOUNTING TYPE & HEIGHT	LOCATION OF FIXTURE	STRUCTURE LEVEL
▲	L1	LED LANDSCAPE UPLIGHT WITH GLARE SHIELD	13 FIXTURES	WARM WHITE LED , 4.9 & 7.4 WATT	POST MOUNTED. INSTALL UNDER PALMS- AIM UP	PLANTING BEDS	GROUND
		MANUFACTURE : YARD SENTRY MODEL V3 SOLID BRASS					
●	L2	LED LANDSCAPE WELL LIGHT WITH GLARE SHIELD	4 FIXTURES	WARM WHITE LED , 1.3 WATT	IN-GROUND	PLANTERS	GROUND
		MANUFACTURE : YARD SENTRY MODEL S2 SOLID BRASS					


1 LANDSCAPE LIGHTING PLAN
SCALE: 3/16" = 1'-0"



HOSPITALITY ARCHITECTURE
&
INTERIOR DESIGN
TL
TELESCO
ASSOCIATES
1111 KANE CONCOURSE, SUITE 301
MIAMI BEACH, FL 33134
TEL 305.866.1014
FAX 305.866.3317
tom@nightclub-design.com
www.nightclub-design.com
LICENSE # AA-000284

TATEL RESTAURANT
1669 COLLINS AVE
MIAMI BEACH, FL 33139

PROJECT No. :
DRAWN BY: A.R.
DATE: 6/9/2016
FINAL SUBMITTAL
REVISIONS:
▲
▲
▲
▲
MARSH C. KRIPLEN.

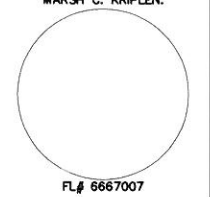

**LANDSCAPE
LIGHTING
PLAN**

COLLABORATIVE INDEPENDENT, INC Landscape Designer 2347 SW 5TH ST. MIAMI, FL 33135 T: 305.450.1115	MARSH KRIPLEN Landscape Architect 1251 SW 20TH ST. MIAMI, FL 33145 T: 305.322.2898
--	--

L-2
DRAWING No. 2 OF 1