

Z:\159352 - Carillon Hotel and Spa\Drawings\08_Interior\Production\Sheets\05-1-000-Finish-LEGEND.dwg, 2/27/2016 6:03:32 PM

FINISH LEGEND

CARPET / CARPET PAD

FURNISHED BY OWNER, INSTALLED BY GC	

GLASS

FURNISHED AND INSTALLED BY GC	
GL-101	CLEAR GLASS / 3/4" THICK / LAMINATED / (RESTAURANT & PDR)
GL-102	CLEAR GLASS / 3/8" THICK / TYPE 2 SAFETY / (MEETING ROOMS, RESTAURANT & PDR)
GL-103	BRONZE SATIN GLASS MIRROR/ 3/4" THICK / SAFETY BACKED / (BAR)

METAL

FURNISHED AND INSTALLED BY GC	
MTL-101	METAL / OIL RUBBED ANTIQUE BRONZE / US10B / (LOBBY)
MTL-102	METAL / DARK BRONZE / US20 / (LOBBY)
MTL-103	METAL / MARINE GRADE/ BRUSHED STAINLESS STEEL / (VARIOUS)
MTL-104	METAL / BLACKENED STEEL / (CAFE)
MTL-105	METAL / HAMMERED AND PEENED DARK BRONZE / US20 / (LOBBY)

PAINT

FURNISHED AND INSTALLED BY GC	
PT-101	CEILING PAINT / INTERIOR LATEX / FLAT/ BENJAMIN MOORE/ OC-17 WHITE DOVE/ (GENERAL)
PT-102	CEILING PAINT / BLACK/ INTERIOR DRYFALL / FLAT (RESTAURANT)
PT-103	CEILING PAINT / EXTERIOR LATEX / FLAT/ BENJAMIN MOORE/ OC-68 DISTANT GRAY/(BAR CABANAS & BATHROOMS)
PT-104	OPEN
PT-105	PAINT / INTERIOR LATEX / FLAT (CAFE)
PT-106	PAINT / INTERIOR LATEX / FLAT (CAFE)
PT-107	PAINT / INTERIOR LATEX / EGGSHELL/ BENJAMIN MOORE/ OC-30 GRAY MIST/ (LOBBY)

SPECIALTY FINISH

FURNISHED AND INSTALLED BY GC	
SP-101	FABRIC WRAPPED PANELS / FABRITRAK / FIRE RATED MINERAL BOARD BACKING/ FABRIC TBD/ (LIVING ROOM)
SP-102	CUSTOM SLATTED CEILING SYSTEM / CEILING PLUS / (RESTAURANT & PDR)
SP-103	WINDOW FILM / 3-M / BLACK-OUT / (RESTAURANT & PDR)
SP-104	FILM / 3-M DI-NOC / METAL / (ELEVATORS)
SP-105	VENEtian PLASTER /STUDIO E- SAKSHA TEXTURE / SKO #71508/(LOBBY)

STONE

FURNISHED AND INSTALLED BY GC	
ST-101	EXISTING TERRAZZO TO REMAIN / REPAIR AND POLISH AS REQUIRED
ST-102	STONE TILE / STILE ITALIANO- TRAVERTINE NAVONA/ LARGE FORMAT / POLISHED/ 24 X 48" / MUD SET / (LIVING ROOM)
ST-103	STONE TILE / STILE ITALIANO- TRAVERTINE NAVONA/ LARGE FORMAT / POLISHED/ 24 X 48" / MUD SET / (RESTAURANT)
ST-104	STONE SLAB / 3/4" THICK / HONED / CUT TO SIZES AS SHOWN ON DRAWINGS / KEYSTONE TO MATCH EXISTING SOUTH WALL AT LOBBY (LOBBY COLUMNS)
ST-105	STONE SLAB / DESIGN DIRECT SOURCE/ EASTERN STONE- ZEBRA/ 3/4" THICK / POLISHED / FABRICATED AS SHOWN ON DRAWINGS / (LIVING ROOM & BAR TOP)
ST-106	STONE SLAB /DESIGN & DIRECT SOURCE/ EASTERN STONE- CALCATA WHITE MARBLE/ 3/4" THICK / POLISHED / FABRICATED AS SHOWN ON DRAWINGS / (RESTAURANT, BAR, & BAR FRONT AT TAMBORNE BAR)
ST-107	STONE SLAB / STILE ITALIANO- TRAVERTINE NAVONA/ 3/4" THICK / HONED / CUT TO SIZES AS SHOWN ON DRAWINGS / (RESTAURANT COLUMNS)
ST-108	STONE SLAB / 3/4" THICK / POLISHED / FABRICATED AS SHOWN ON DRAWINGS / (BAR CABANAS & BATHROOMS)
ST-109	STONE SLAB / OPUSTONE/ BROWN EGO- BLACK/ 3/4" THICK / POLISHED / FABRICATED AS SHOWN ON DRAWINGS / (CABANA BAR LARGE BOOK MATCHED SLABS)

TILE

FURNISHED AND INSTALLED BY GC	
CT-101	PORCELAIN TILE /SUPERGRES PRIVE,COLOR:ECRU/SIZE:12"W X 48"L/GROUT:JAMO- BEACH DUNES 1/8" JOINT / (BAR CABANAS & BATHROOMS)
CT-102	CERAMIC TILE /TROPICAL TILE-NEW YORKER/ COLOR: CARAMEL/ 7.5CM X 30CM/ GROUT:JAMO- BEACH DUNES 1/8" JOINT/ (BAR CABANAS & BATHROOMS)
CT-103	QUARRY TILE / / / / (CAFE)
CT-104	PORCELAIN TILE / / / / (SHOWERS)
CT-105	CERAMIC TILE/DALTILE-ARTIGIANC/AR-96 VENICE STATUE STD/3"W X 6"L/ SKU# AR9636SAM1P/GROUT:JAMO- BEACH DUNES 1/8" JOINT/ (RESTAURANT EXPO KITCHEN WALLS)

WALL COVERING

FURNISHED BY OWNER, INSTALLED BY GC	
WC-101	WALL COVERING / / / / (BAR)
WC-102	WALL COVERING / WEITZNER- COCOON/# W1022-03/ COLOR: CLOUD/ (LIVING ROOM)

WOOD

FURNISHED AND INSTALLED BY GC	
WD-101	WOOD VENEERS AND SOLID STOCK / TO MATCH HAKWOOD- TRANQUILITY/ EUROPEAN OAK/ FABRICATION AS SHOWN IN DRAWINGS / (LOBBY, LIVING ROOM, BAR & RESTAURANT)
WD-102	EXISTING WOOD TO BE REFRESHED / FABRICATION AS SHOWN IN DRAWINGS / (LOBBY)
WD-103	WOOD VENEERS AND SOLID STOCK / FABRICATION AS SHOWN IN DRAWINGS / (BAR CABANAS & BATHROOMS)
WD-104	WOOD VENER PANELS / SCORED / FABRICATION AS SHOWN IN DRAWINGS / (LOBBY)
WD-105	WOOD VENER AND SOLID STOCK / FABRICATION AS SHOWN IN DRAWINGS / (CAFE)
WD-106	WOOD VENER AND SOLID STOCK / IPE/ FABRICATION AS SHOWN IN DRAWINGS / (TRELIS BAR EXTERIOR)

WOOD FLOORING

FURNISHED AND INSTALLED BY GC	
WFL-101	WOOD PLANK FLOORING / LV WOOD/ HAKWOOD- TRANQUILITY/ EUROPEAN OAK/ 3/4"THICK X 7"W / TONGUE AND GROOVE / HERRINGBONE PATTERN AS SHOWN ON DRAWINGS (BAR)
WFL-102	WOOD PLANK FLOORING / LV WOOD/ HAKWOOD- TRANQUILITY/ EUROPEAN OAK/ 3/4"THICK X 7"W /TONGUE AND GROOVE / PATTERN AS SHOWN ON DRAWINGS (RESTAURANT & PDR)
WFL-103	WOOD FLOORING / TONGUE AND GROOVE / PATTERN AS SHOWN ON DRAWINGS (CAFE)

PLUMBING / HARDWARE / LIGHTING SCHEDULE

PLUMBING FIXTURES


FURNISHED AND INSTALLED BY GC	
PF-101	TOILET / / /
PF-102	SINK / / /
PF-103	FAUCET / / /
PF-104	SINK / / /
PF-105	FAUCET / / /

LIGHT FIXTURES - HARD WIRED, DECORATIVE

FURNISHED BY OWNER, INSTALLED BY GC	
LT-01	LARGE SCALE PENDANT / / / (LOBBY)
LT-02	WALL SCONCE / / / (BAR)
LT-03	PENDANT / / / (BAR)
LT-04	PENDANT / / / (RESTAURANT)
LT-05	PENDANT / / / (RESTAURANT)
LT-06	PENDANT / / / (PDR)
LT-07	PENDANT / / / (RESTAURANT)
LT-08	PENDANT / / / (CABANA BAR)
LT-09	PENDANT / / / (CAFE)
LT-10	PENDANT / / / (CAFE)
LT-11	WALL SCONCE / / / (CABANA BATHROOMS)
LT-12	WALL SCONCE / / / (CABANA BATHROOMS)
LT-13	WALL SCONCE / / / (LOBBY COLUMNS)

HARDWARE

FURNISHED AND INSTALLED BY GC	
HW-01	ENTRY DOOR HANDLE / / / (LOBBY)
HW-02	MILLWORK HANDLE / / / (LIVING ROOM)
HW-03	MILLWORK HANDLE / / / (BAR)
HW-04	MILLWORK HANDLE / / / (RESTAURANT & PDR)
HW-05	MILLWORK HANDLE / / / (CABANAS & BATHROOMS)
HW-06	LATCH SETS / LEVER HANDLE / / (CABANAS & BATHROOMS)
HW-07	MILLWORK HANDLE / / / (CAFE)
HW-08	INTERIOR ADA COMPLIANT LATCH SETS / / / (LOBBY)

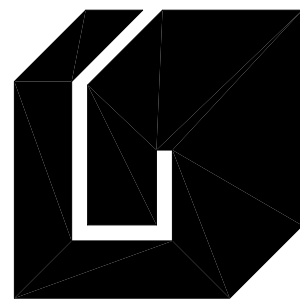

Giller & Giller, Inc.

17000 Biscayne Boulevard
975 Arthur Godfrey Road
Miami Beach, Florida 33140
Giller97800.COM
Reg. #AA C001364

ARCHITECTS INTERIOR DESIGNERS CONSTRUCTION MANAGERS

Wimberly
INTERIORS

miami FL 786 801 1737

CARILLON HOTEL
ALTERATIONS
Z CAPITAL FLORIDA RESORT LLC
6801 COLLINS AVENUE
MIAMI BEACH, FL

Issued by: AR000896
Reviewed by: AR001811
Issued by: Giller
Reviewed by: Giller

DATE REVISION DESCRIPTION


comment © 2016, Giller & Giller, Inc. ALL RIGHTS RESERVED

SHEET TITLE:
FINISH LEGEND

SHEET #
1-000
OF TOTAL
ARCH COMM #
15122

DATE: 2/18/16
CHECKED BY: APPROVED BY:

Z:\1595932 - Carillon Hotel and Spa\Drawings\08_Interior\Production\Sheets\CS-1102_RCP.dwg, 2/17/2016 6:04:47 PM

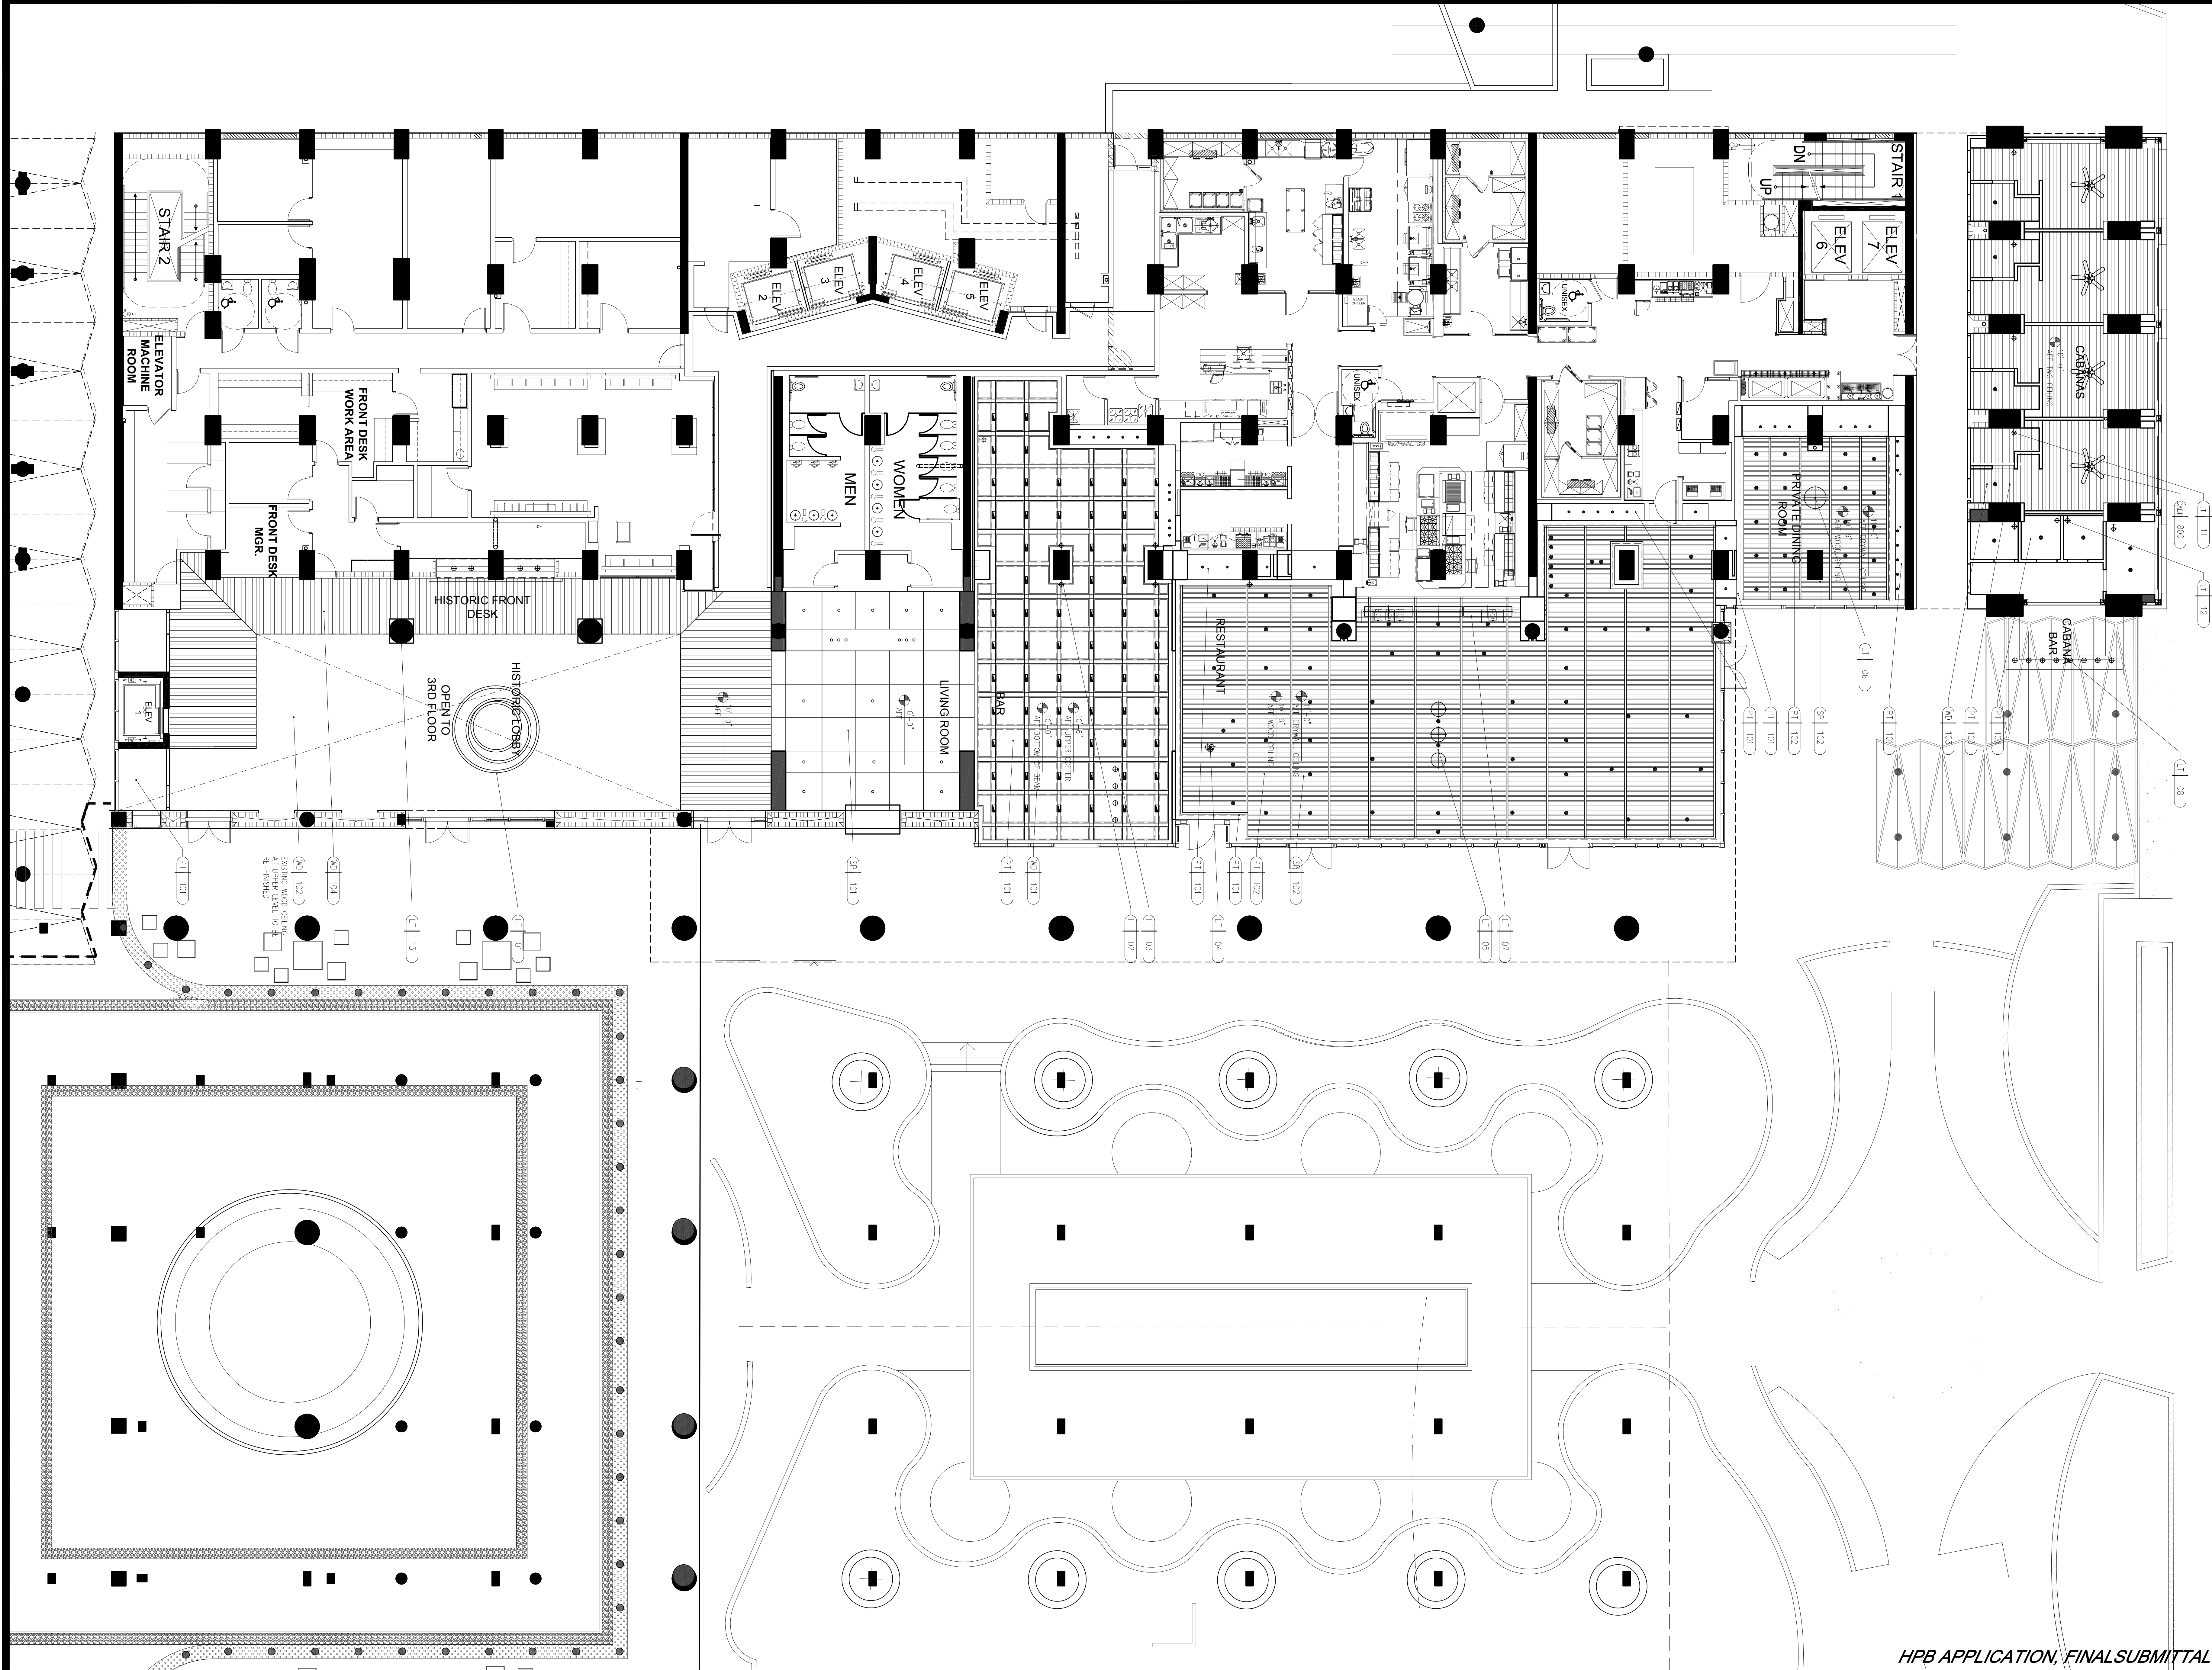

HPB APPLICATION, FINAL SUBMITTAL

SHEET #
1-102
REFLECTED CEILING PLAN

DATE: 2/18/16
CHECKED BY: [Signature]
APPROVED BY: [Signature]


REVISION	DATE	DESCRIPTION

IN O. GILLER
SHEA G. BERNARD
ARCHITECTS


CARILLON HOTEL
ALTERATIONS
Z CAPITAL FLORIDA RESORT LLC
6801 COLLINS AVENUE
MIAMI BEACH, FL

Wimberly
INTERIORS

Giller & Giller, Inc.
775 Arthur Godfrey Road
Miami Beach, Florida 33140
Tel: (305) 538-5921
Fax: (305) 538-5921
giller78@aol.com
Reg. #44, C001364
ARCHITECTS INTERIOR DESIGNERS CONSTRUCTION MANAGERS

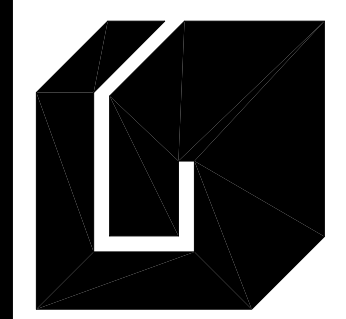

Z:\159352 - Carillon Hotel and Spa\Drawings\08_Interior\Production\Sheets\05-1103-FINISH PLAN.dwg, 2/17/2016 6:00:56 PM

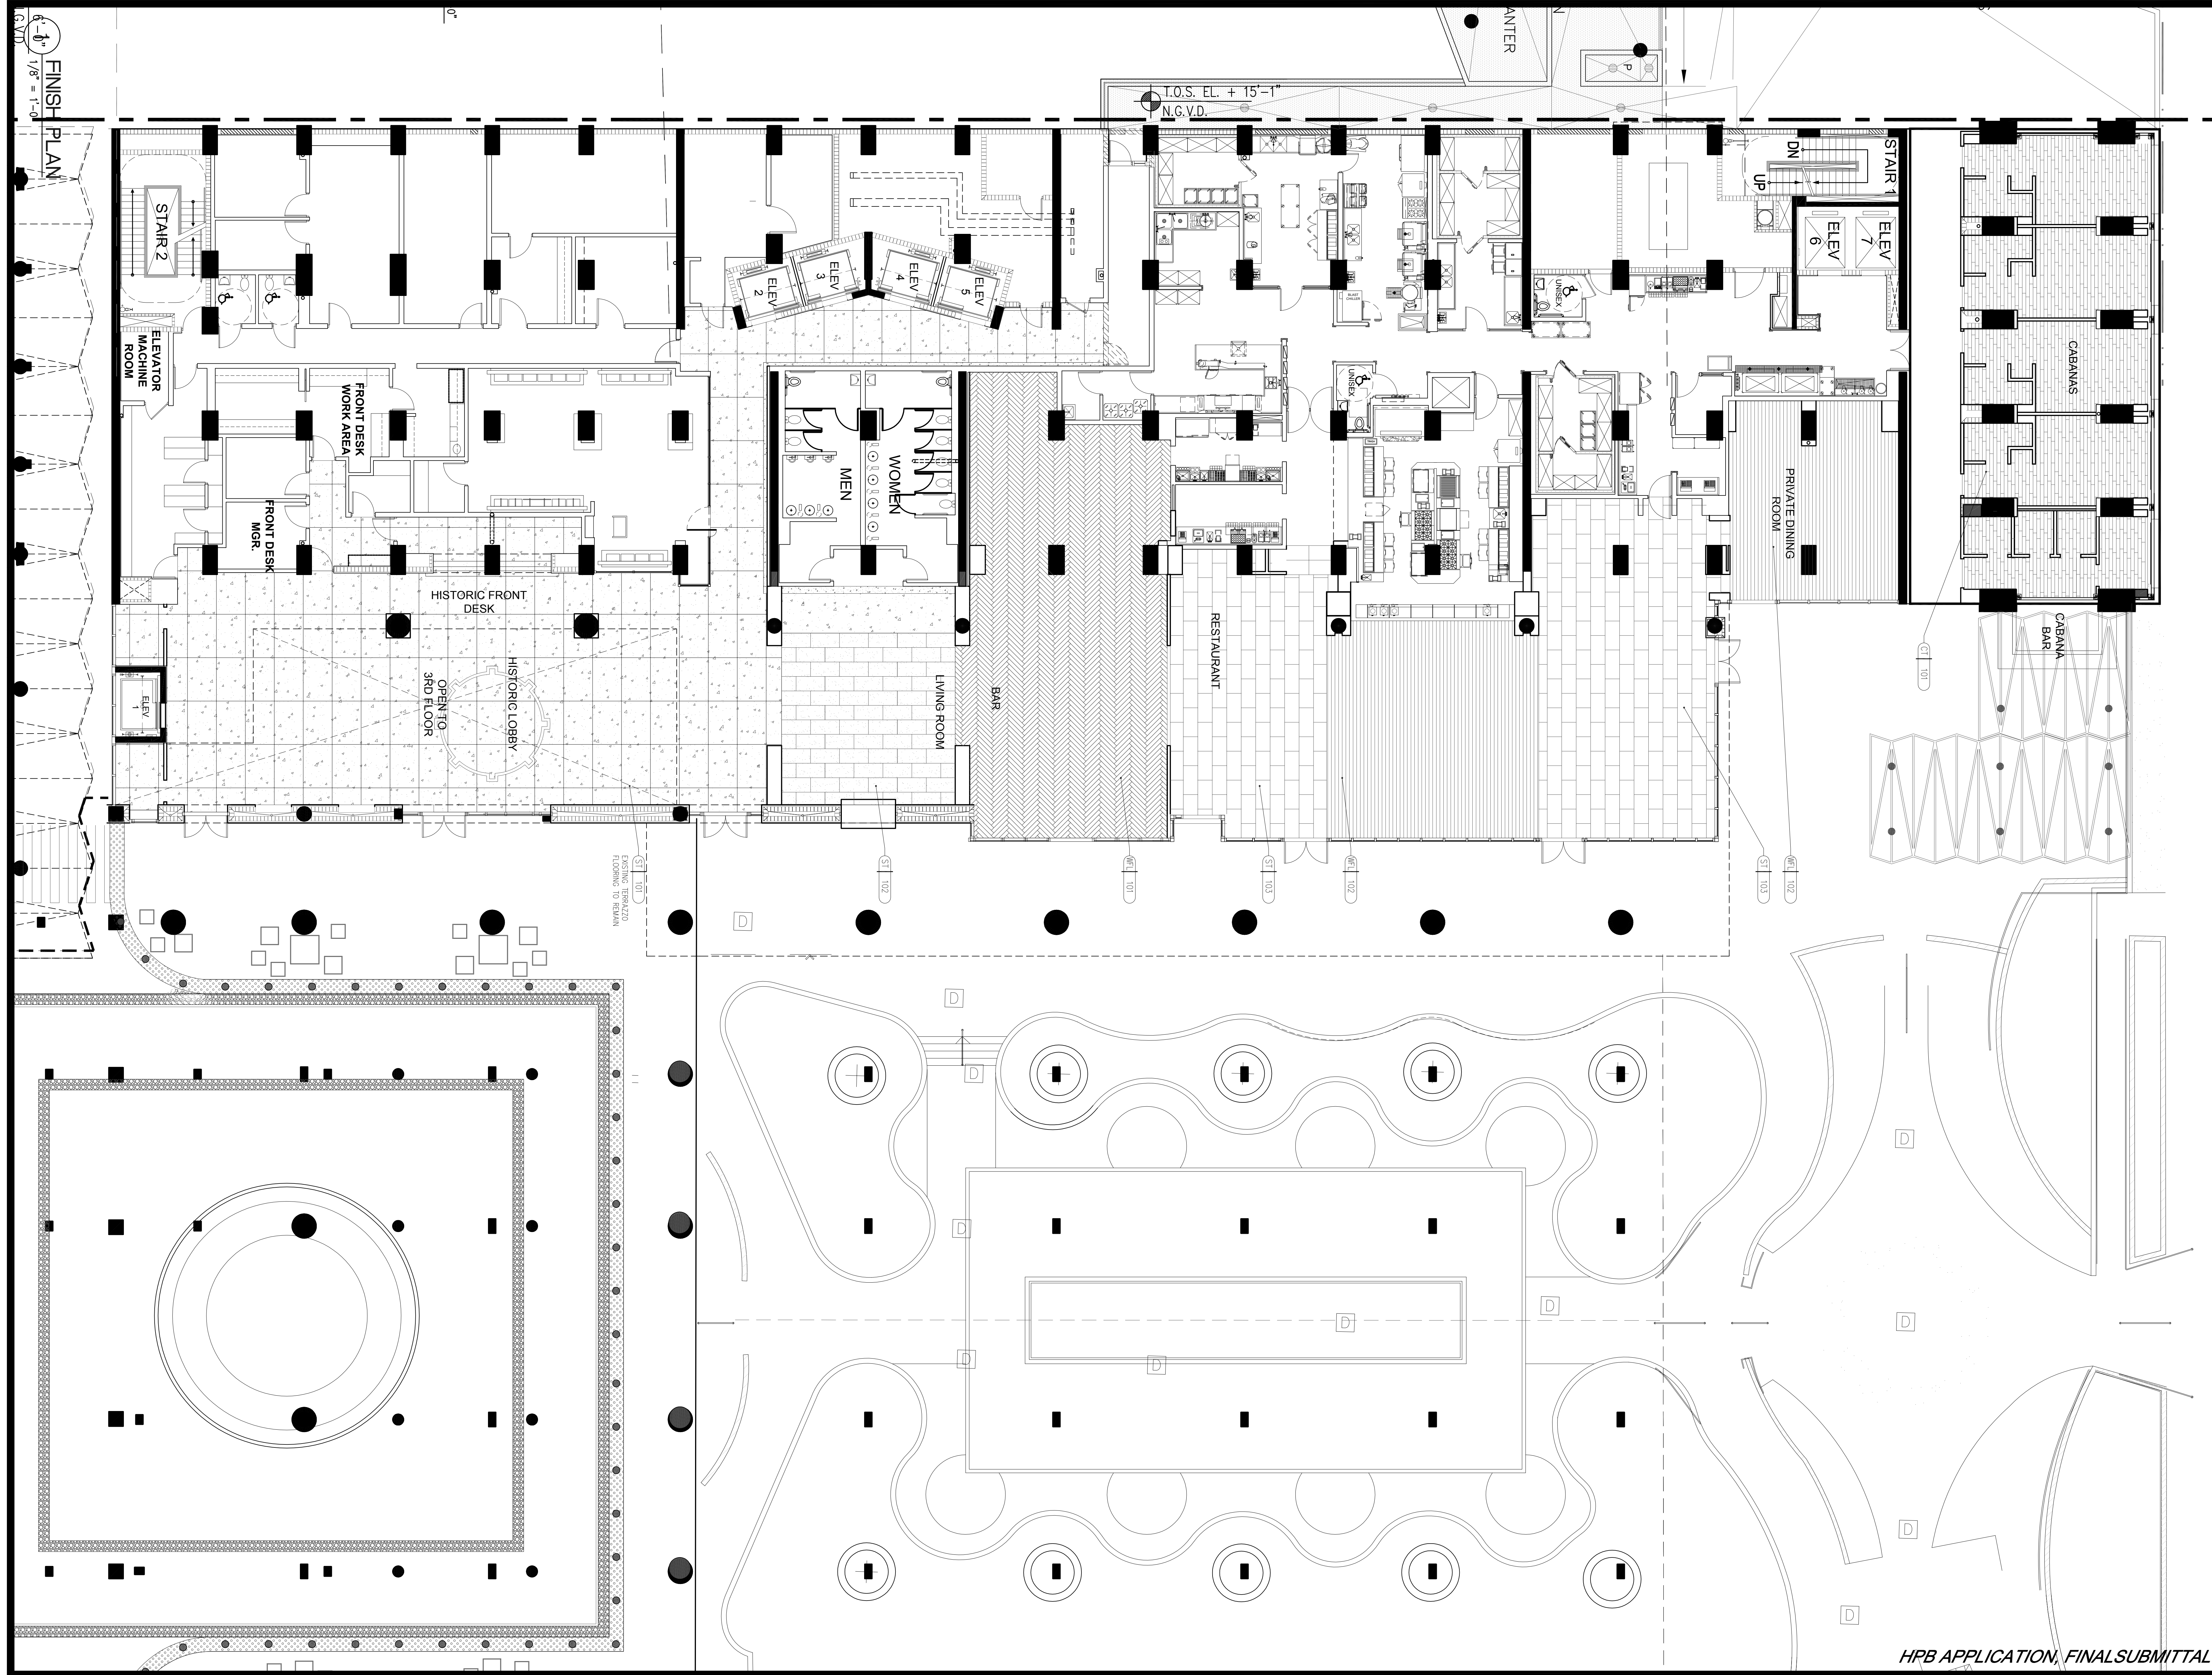

1-103

OF TOTAL

ARCH COMM #

15122

SHEET TITLE:

FINISH PLAN

DATE:

2/18/16

CHECKED BY:

—

APPROVED BY:

—

DATE

REVISION DESCRIPTION

Copyright © 2016, Giller & Giller, Inc. ALL RIGHTS RESERVED

IN D. Giller

APPROVED

AR01811

BY SHELL G. BELLARD

CARILLON HOTEL

ALTERATIONS

Z CAPITAL FLORIDA RESORT LLC

6801 COLLINS AVENUE

MIAMI BEACH, FL

Wimberly

INTERIORS

miami | FL 1 786 801 1737

Giller & Giller, Inc.

1737 Arthur Godfrey Road

Miami Beach, Florida 33140

Reg. #44, CDD-1364


Giller978003.COM

FAX (305) 538-5921

ARCHITECTS INTERIOR DESIGNERS CONSTRUCTION MANAGERS




HPB APPLICATION, FINAL SUBMITTAL

Z:\159592 - Carillon Hotel and Spa\Drawings\08_Interiors\Production\Sheets\CS-1-104_FURNITURE PLAN.dwg, 2/17/2016 6:02:06 PM

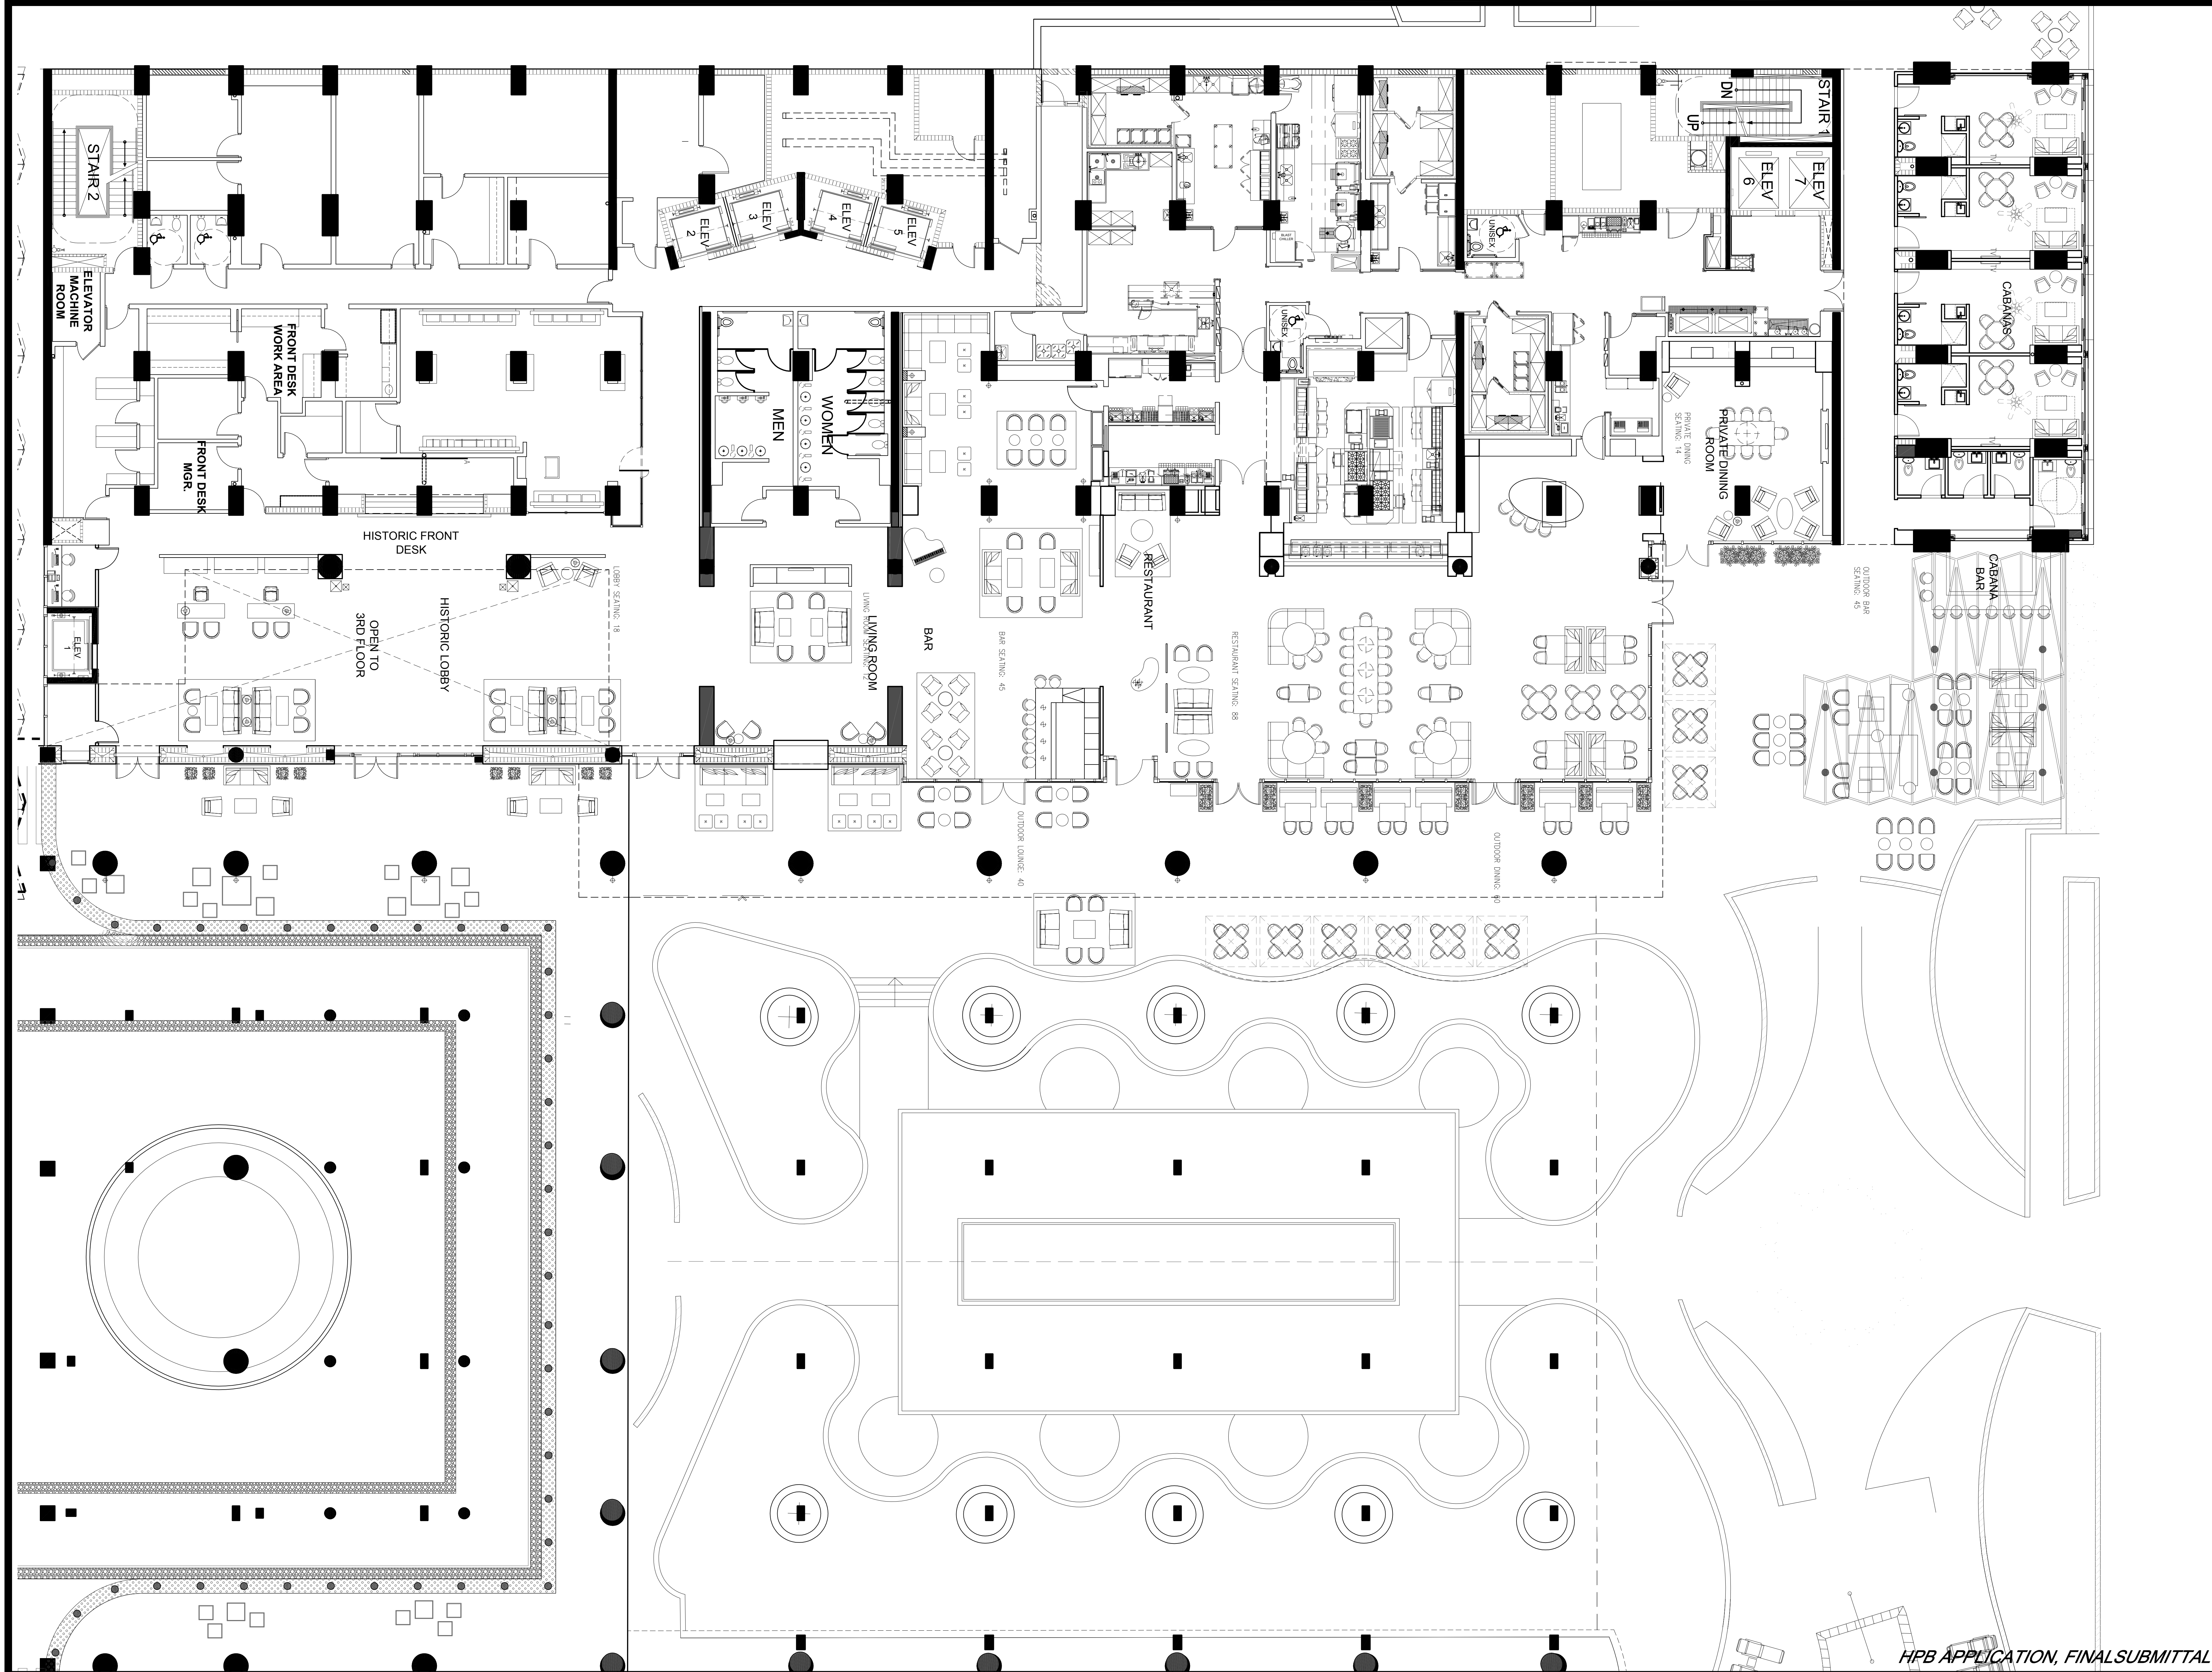

SHEET # I-104		SHEET TITLE: FURNITURE PLAN		DATE: 2/18/16		CHECKED BY: —		APPROVED BY: —	
OF TOTAL 15122		ARCH COORD #		DATE: 2/18/16		CHECKED BY: —		APPROVED BY: —	
comment		© 2016, Giller & Giller, Inc. ALL RIGHTS RESERVED		DESIGNED BY: —		DRAWN BY: —		PROJECT NO: —	
Z CAPITAL FLORIDA RESORT LLC		6801 COLLINS AVENUE		MIAMI BEACH, FL		miami FL 1786 801.1737		Wimberly INTERIORS	
CARILLON HOTEL ALTERATIONS		Z CAPITAL FLORIDA RESORT LLC		MIAMI BEACH, FL		miami FL 1786 801.1737		Wimberly INTERIORS	
Giller & Giller, Inc.		7075 Arthur Godfrey Road		Miami Beach, Florida 33140		Tel: (305) 538-5921		Fax: (305) 538-5921	
ARCHITECTS		INTERIOR DESIGNERS		CONSTRUCTION MANAGERS		Giller & Giller, Inc.		Reg. #44, C001364	

Z:\159352 - Carillon Hotel and Spa\Drawings\08_Interior\Production\Sheets\05-1-601 ELEVATIONS.dwg, 2/17/2016 6:02:38 PM

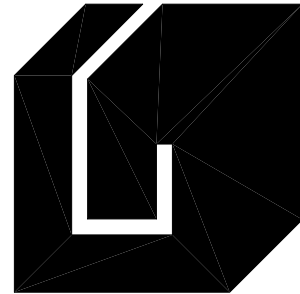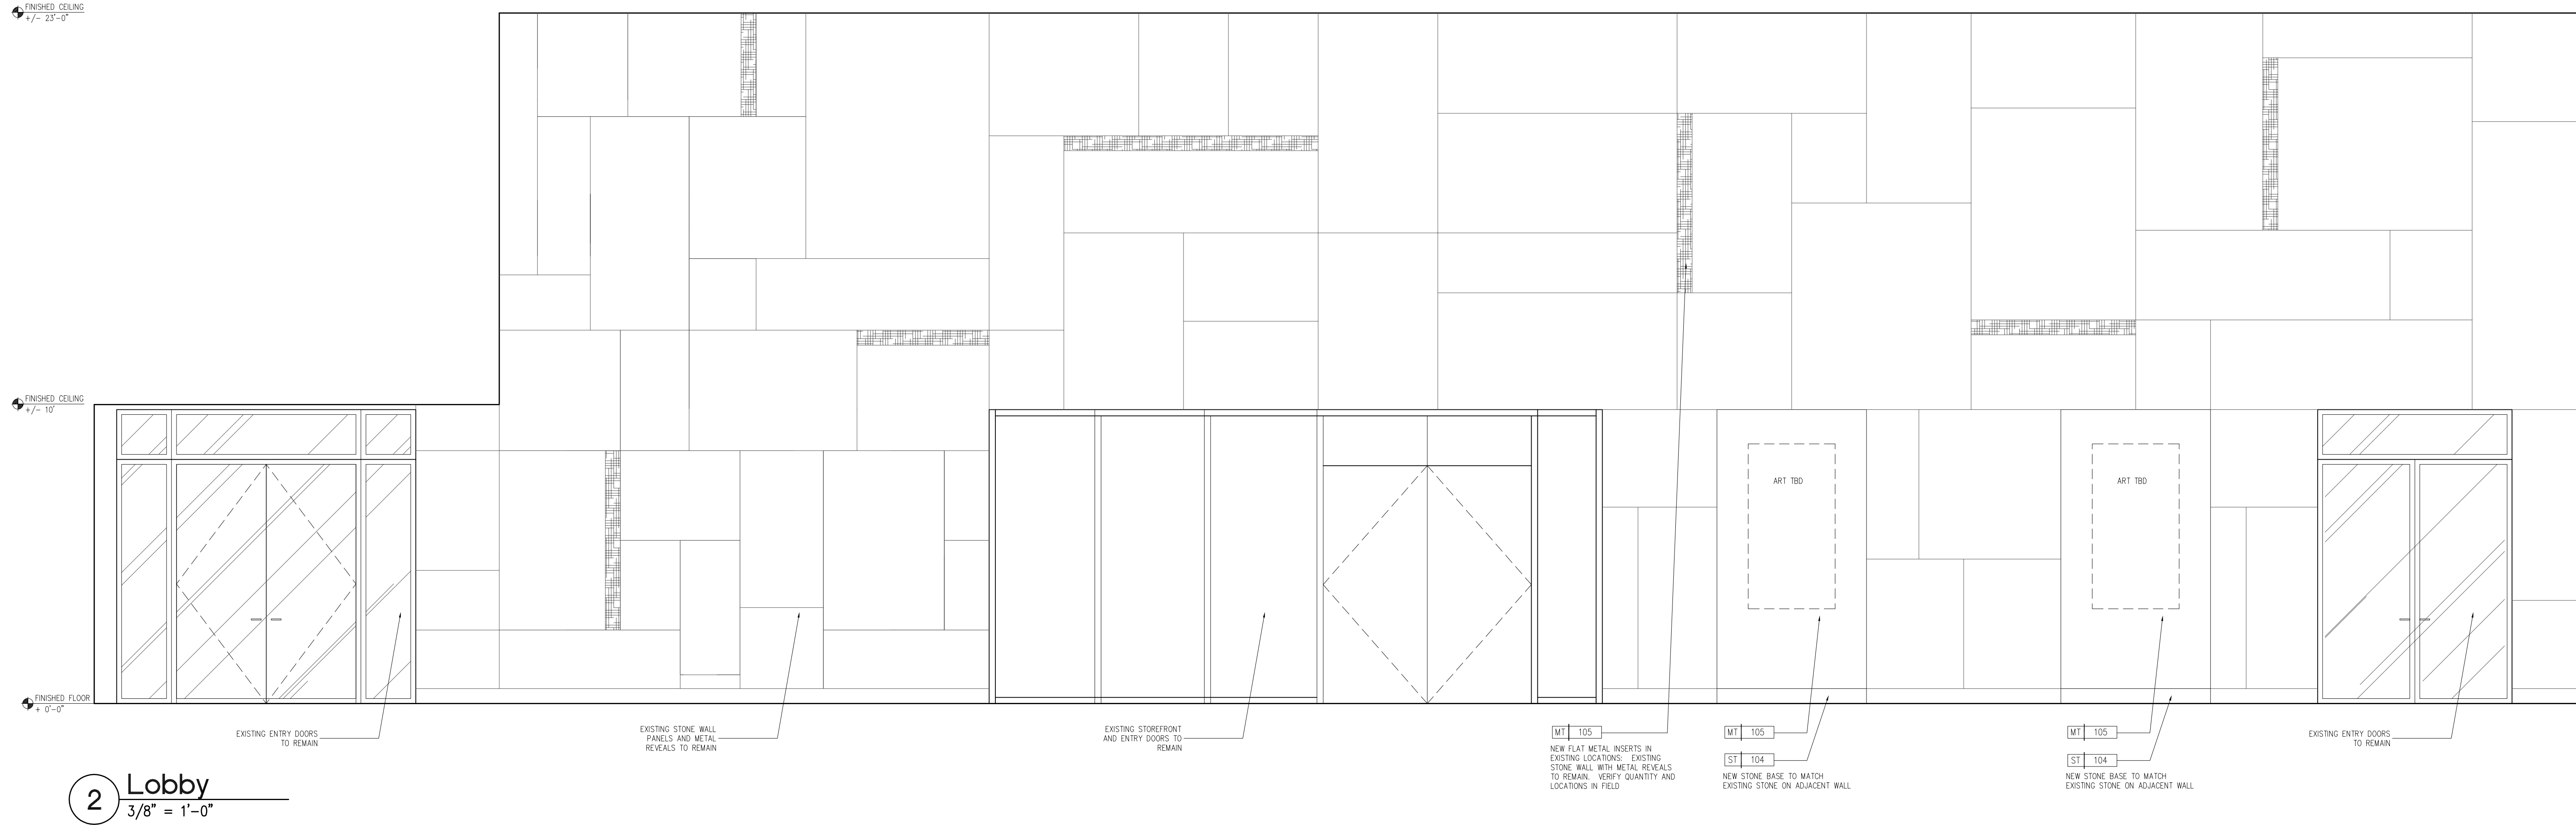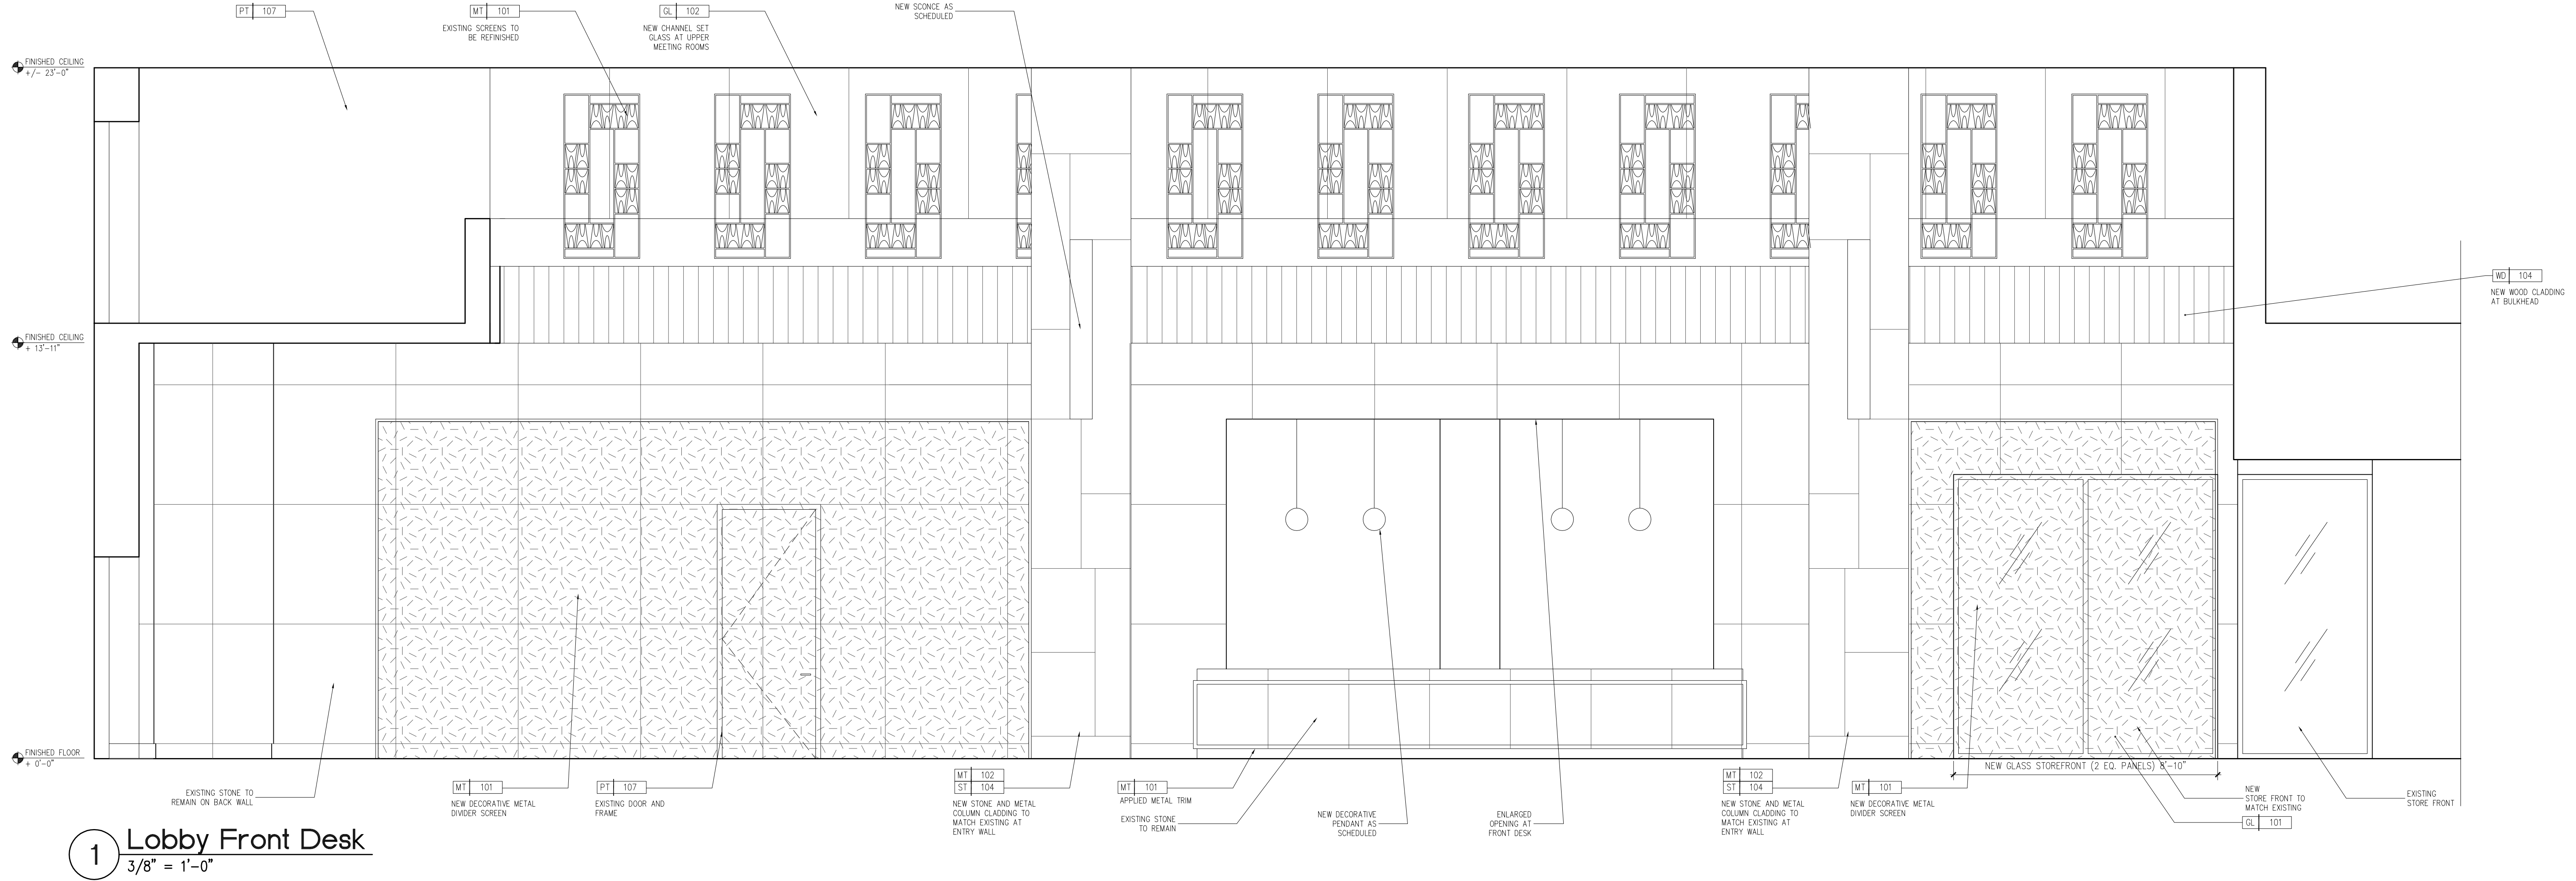

Giller & Giller, Inc.

7000 Biscayne Blvd.
Miami Beach, Florida 33140
975 Arthur Godfrey Road
Giller & Giller, Inc.
Reg. #AA 0001364

ARCHITECTS INTERIOR DESIGNERS CONSTRUCTION MANAGERS

Wimberly
INTERIORS

miami | FL 1786 801.1737

CARILLON HOTEL
ALTERATIONS

Z CAPITAL FLORIDA RESORT LLC

6801 COLLINS AVENUE MIAMI BEACH, FL

DATE REVISION DESCRIPTION

SHEET TITLE:
ELEVATIONS


SHEET #
1-601
OF TOTAL
ARCH COMM #
15122

DATE: 2/18/16
CHECKED BY: APPROVED BY:


Copyright © 2016, Giller & Giller, Inc. ALL RIGHTS RESERVED

by G. Giller
Sheila G. Bennett
ARCHITECT
ARCHITECT


HPB APPLICATION, FINAL SUBMITTAL

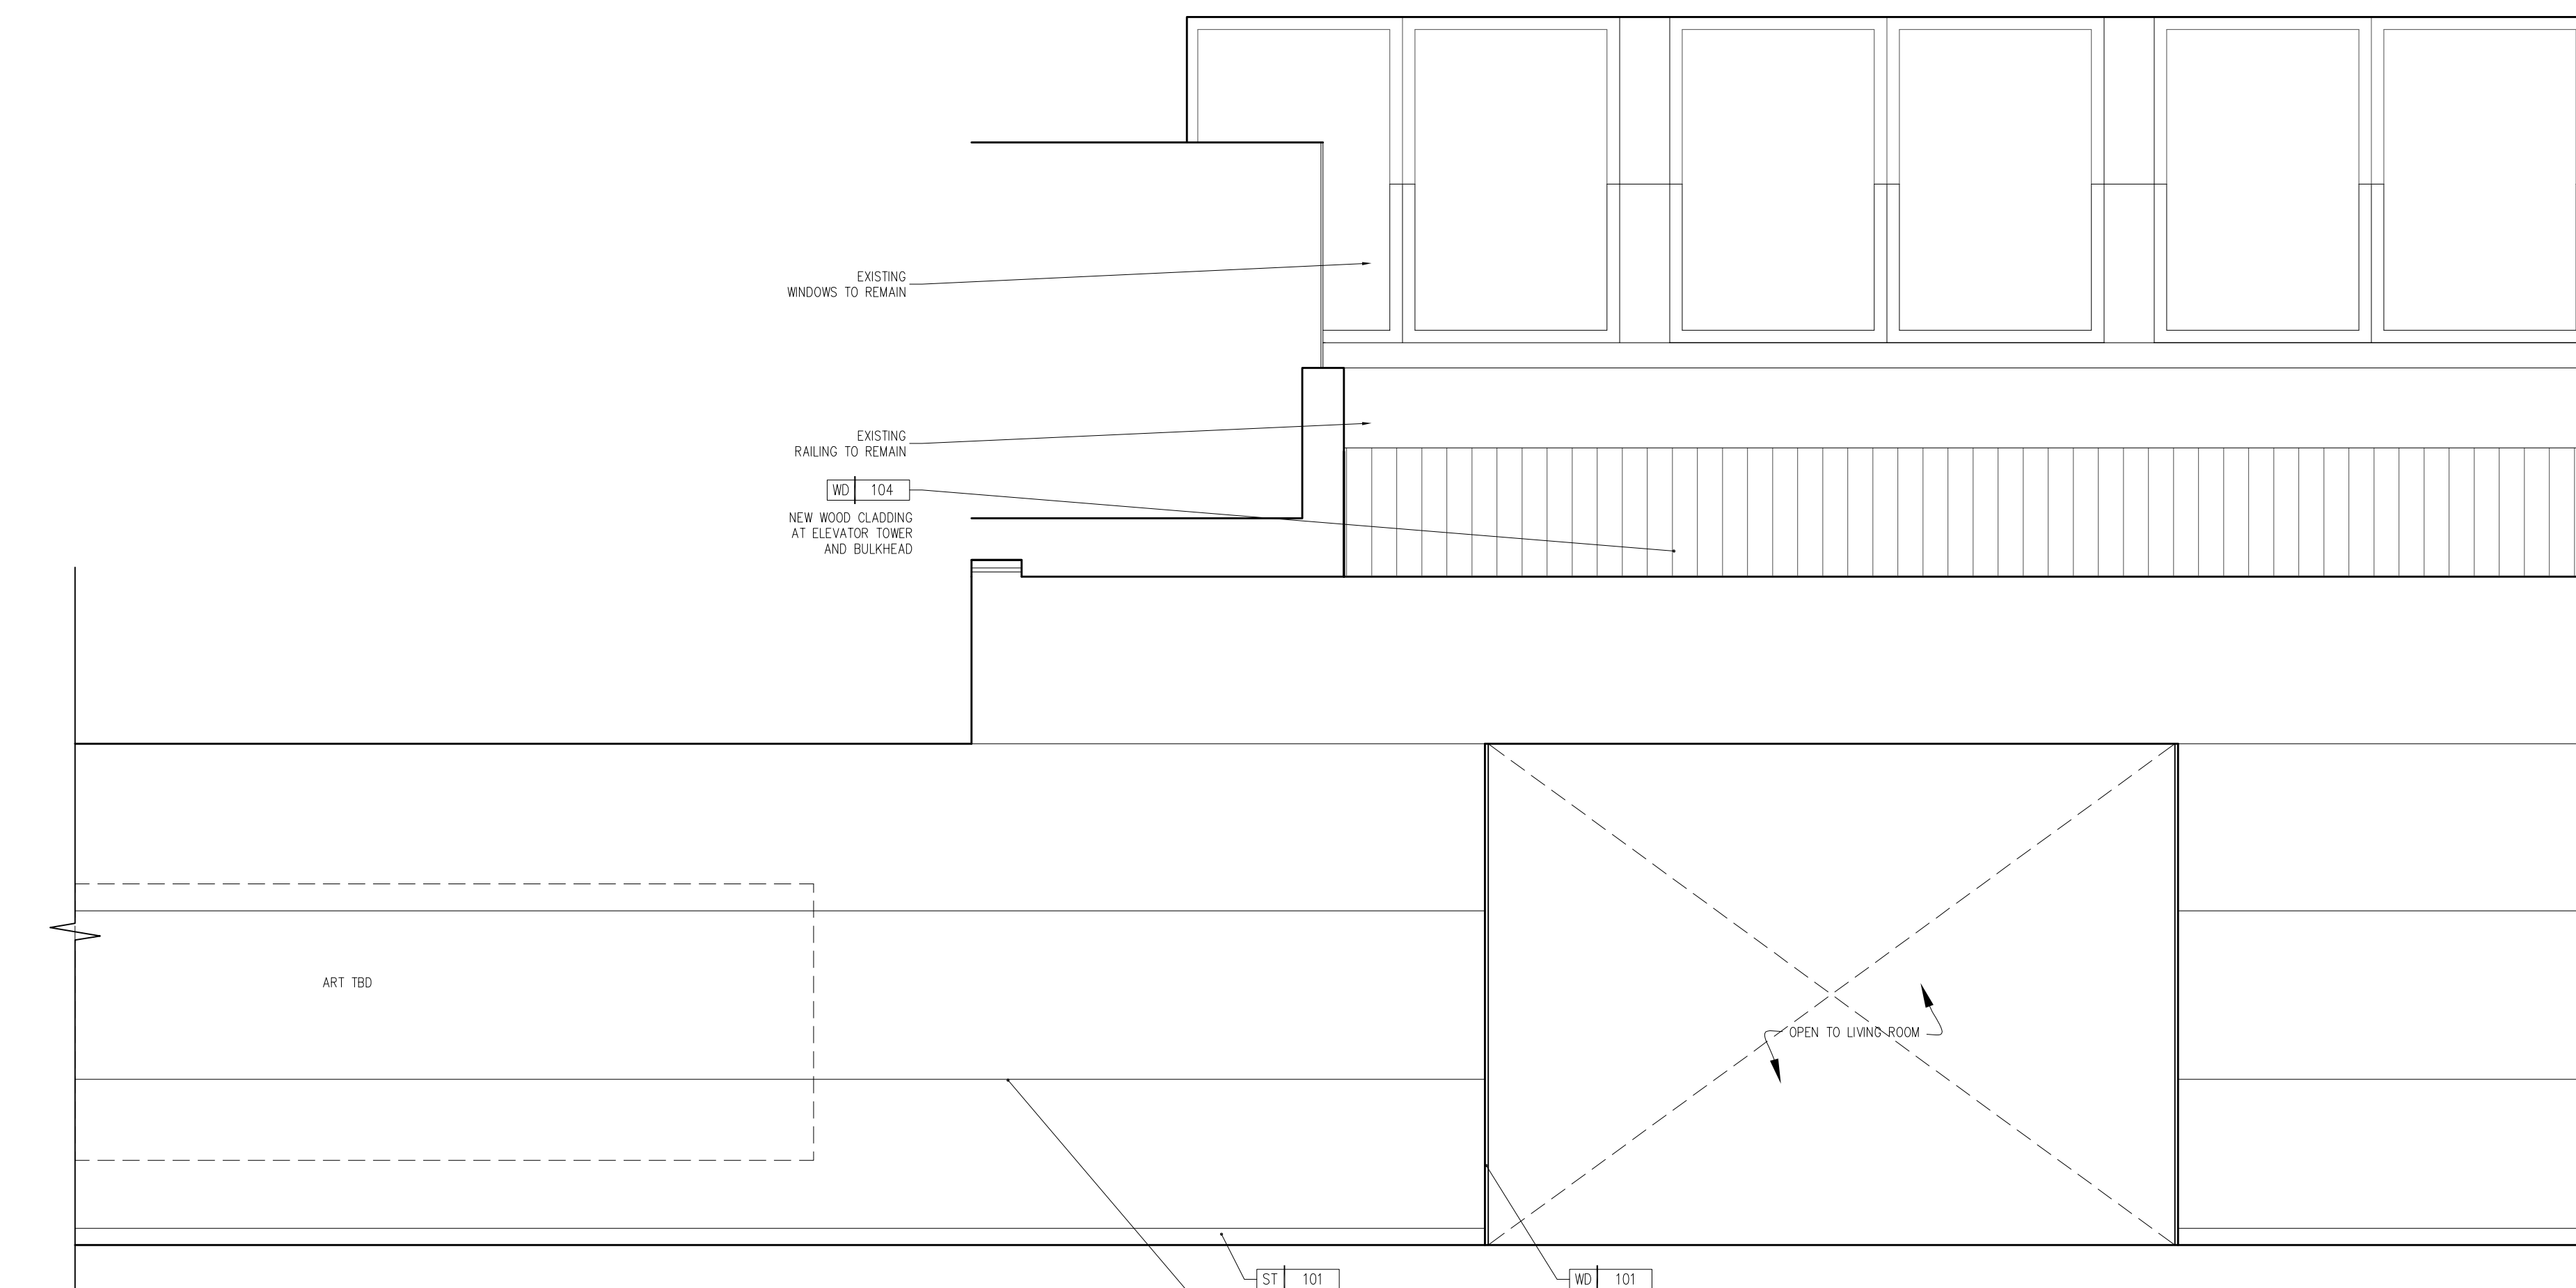


2 Lobby Elevator Corridor
3/8" = 1'-0"

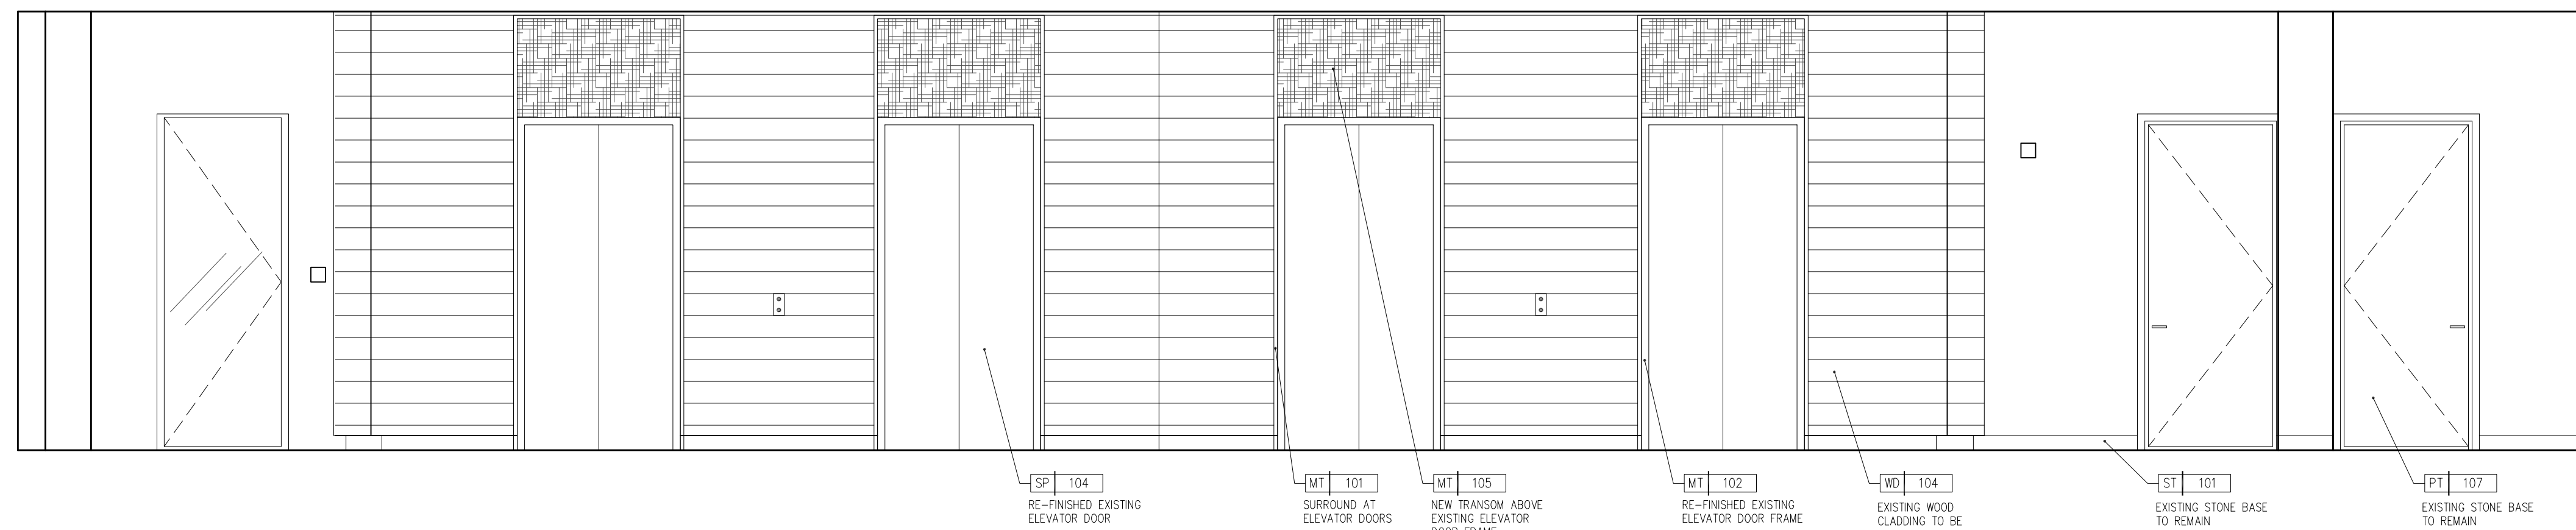


4 Lobby Elevator Corridor
3/8" = 1'-0"

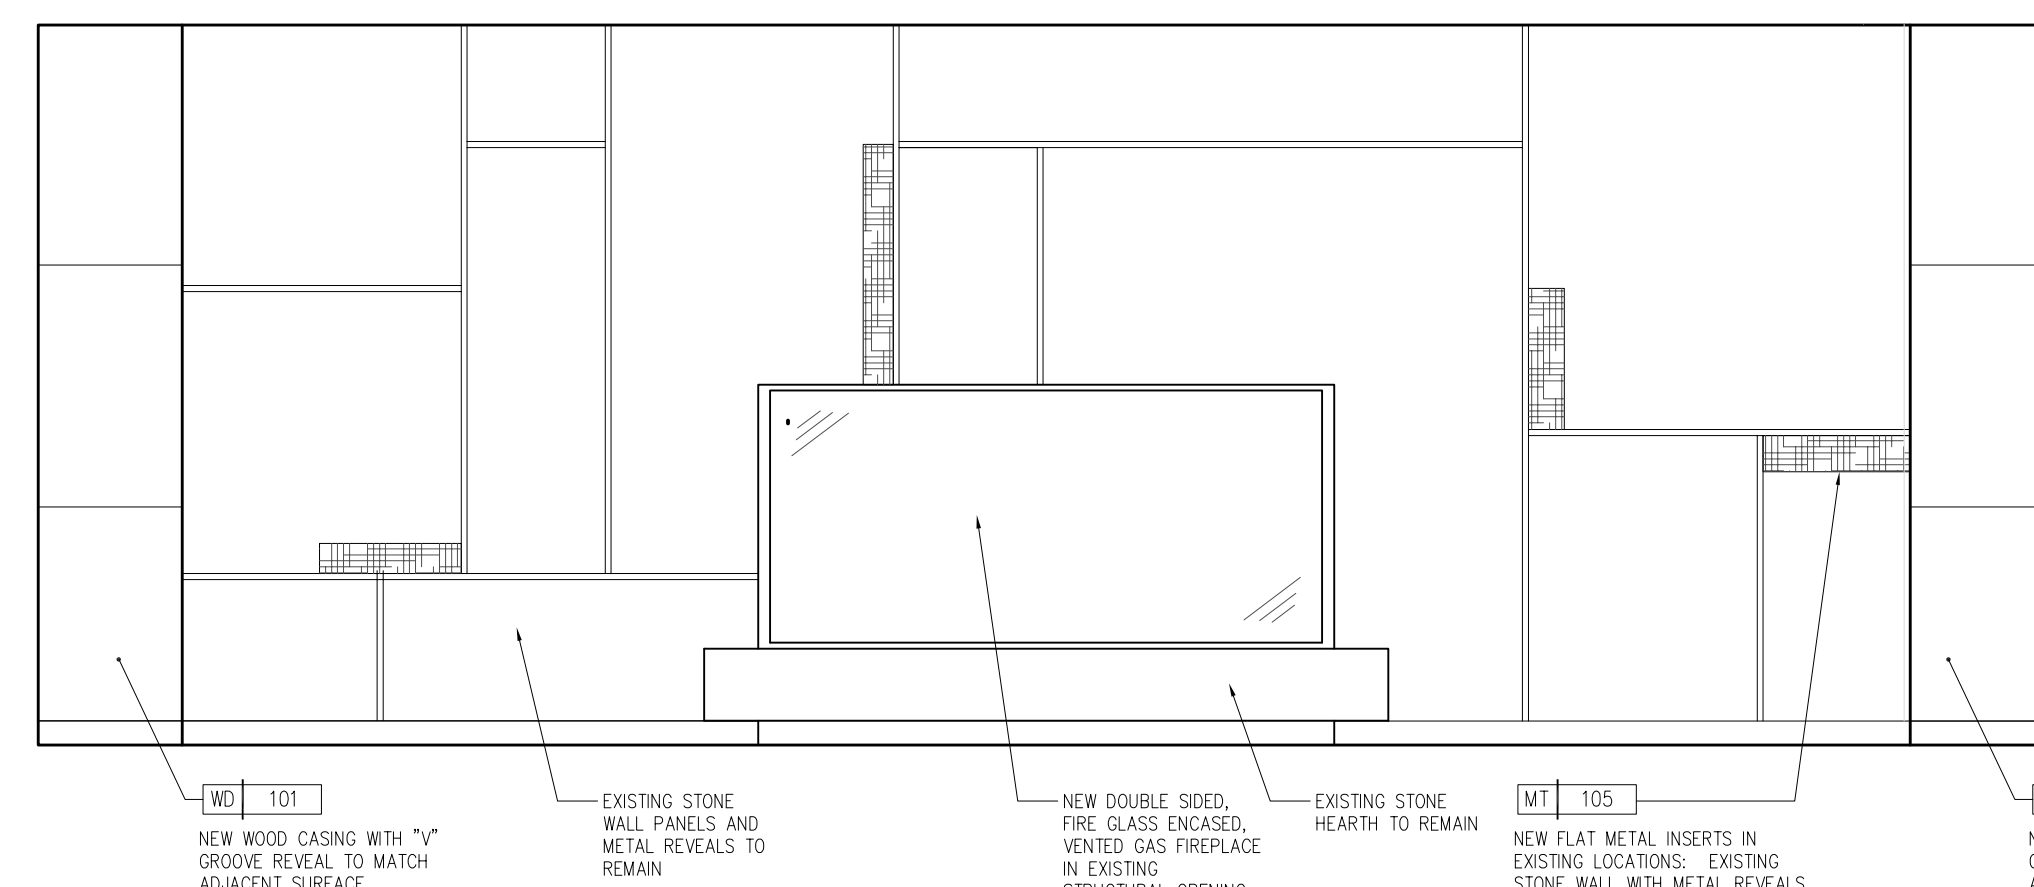




7 Media/ Library Elevation
3/8" = 1'-0"



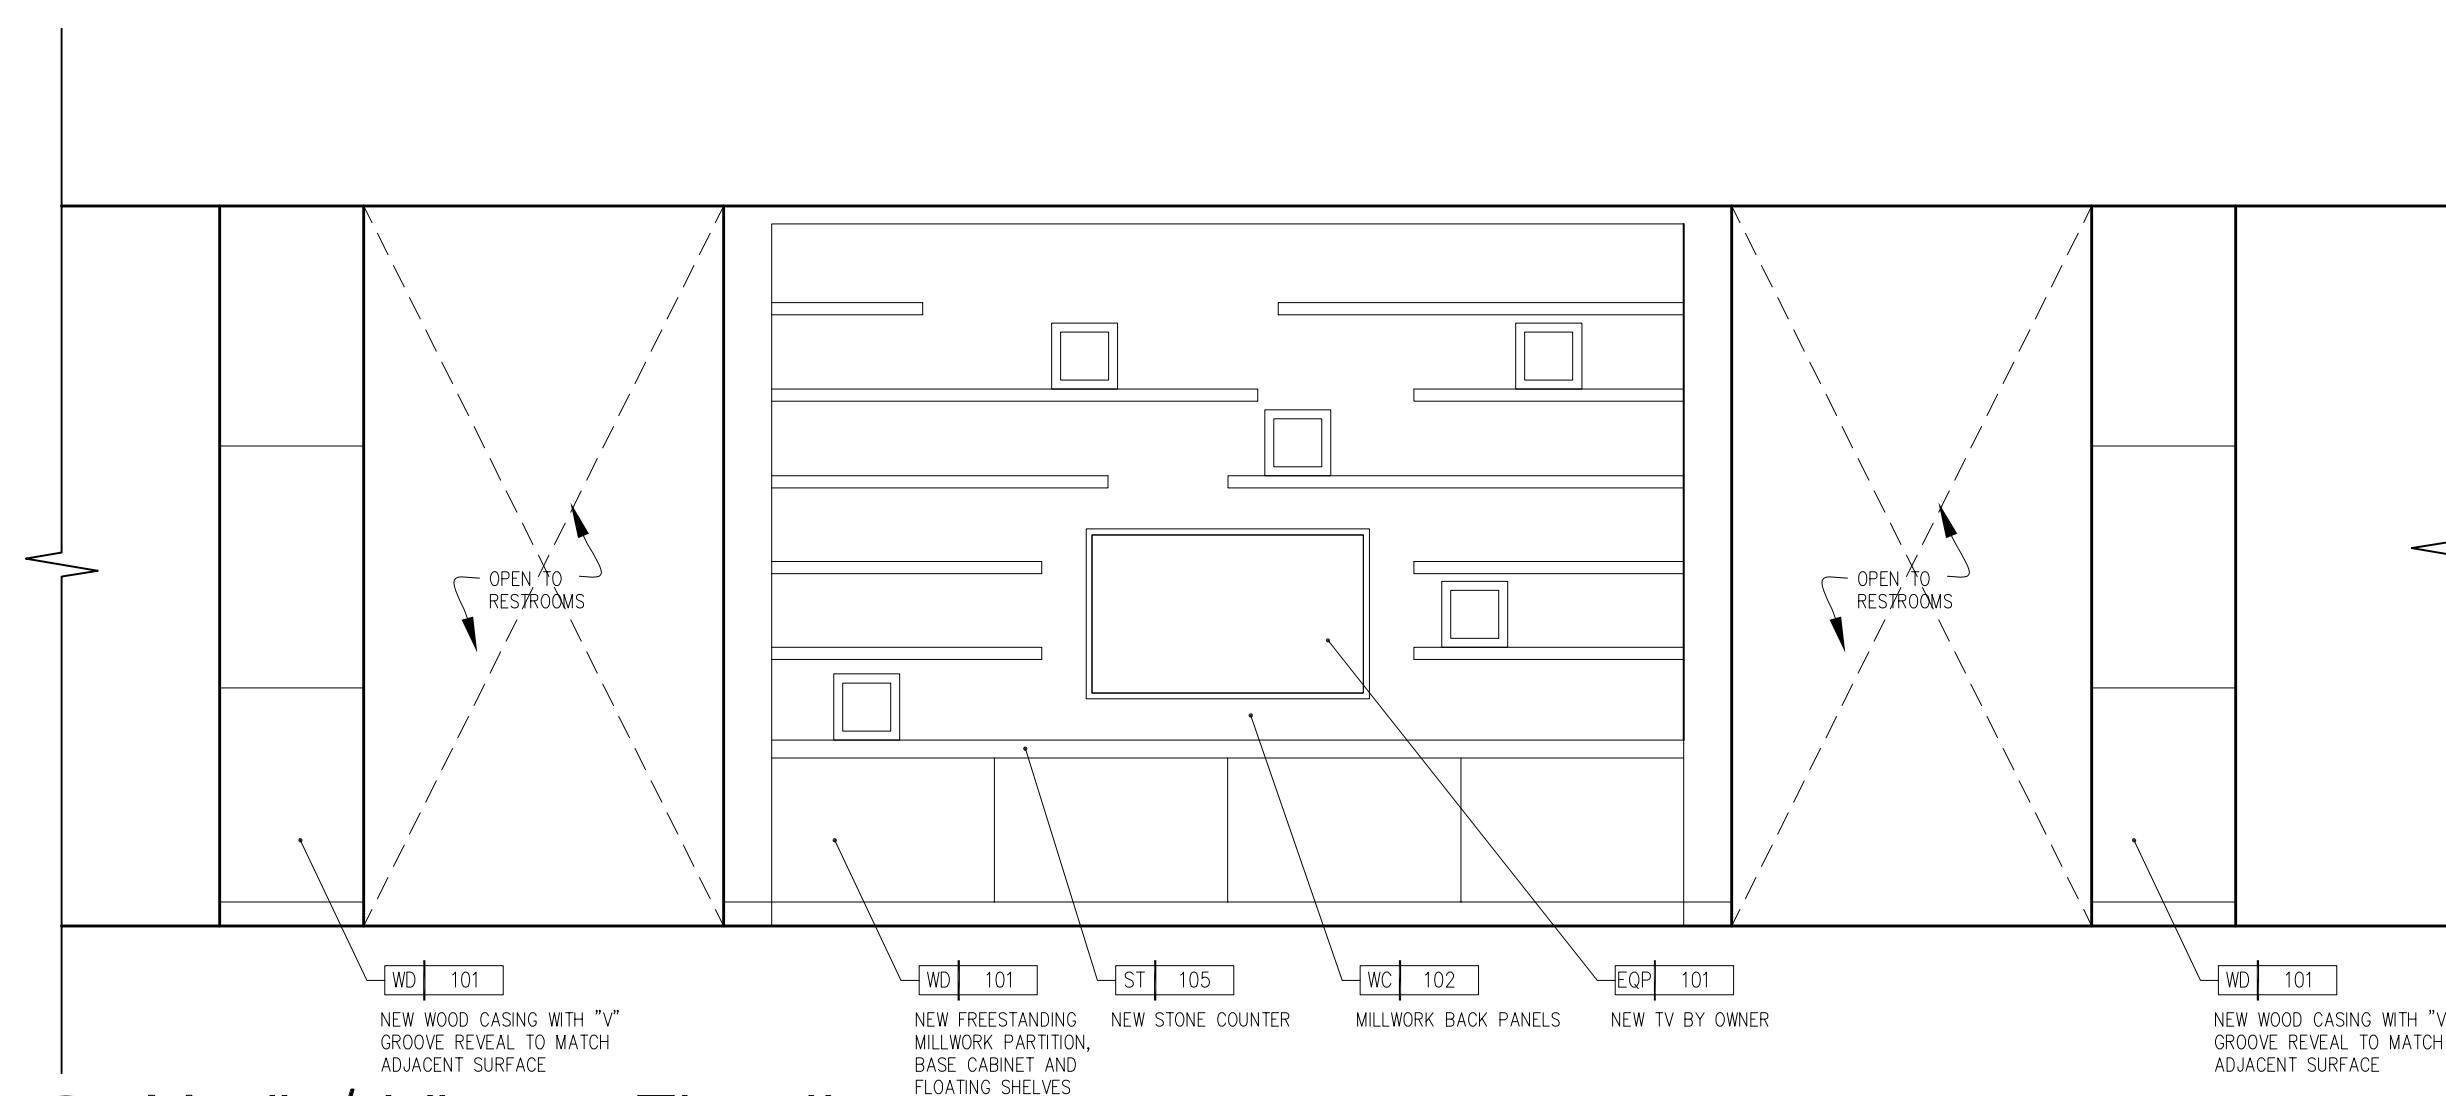




5 Media/ Library Elevation
3/8" = 1'-0"

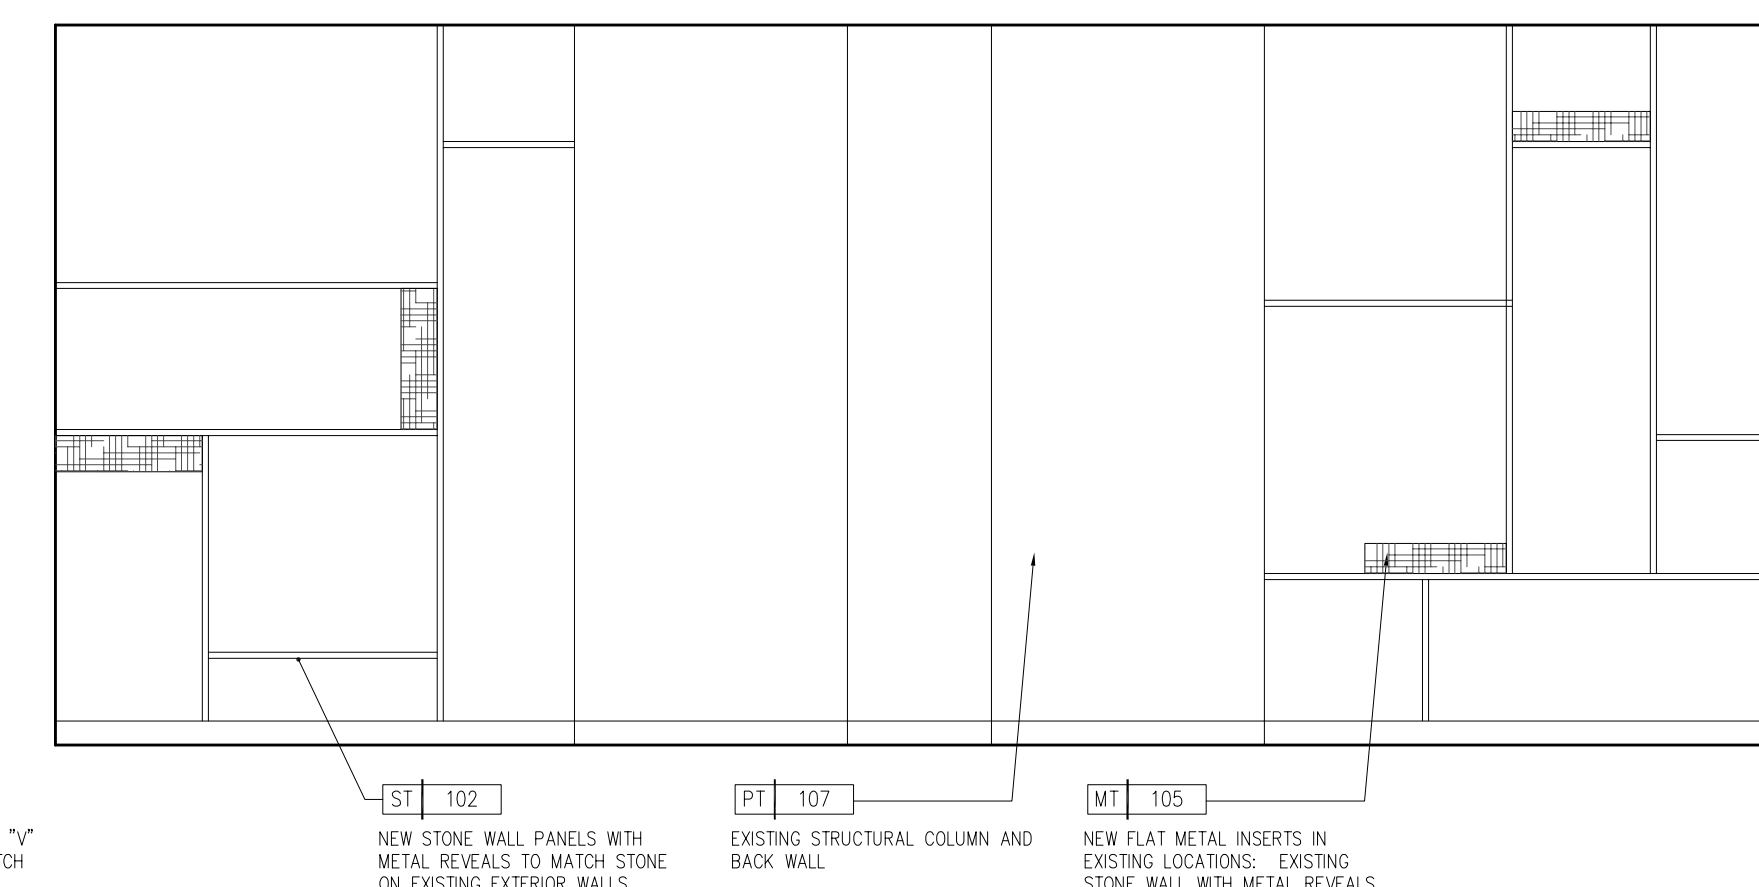

8 Media/ Library Elevation
3/8" = 1'-0"

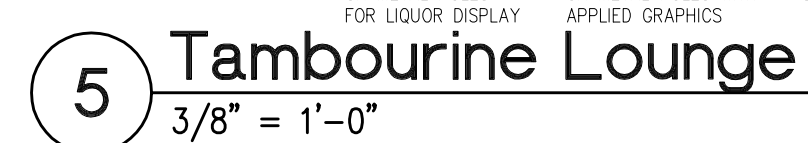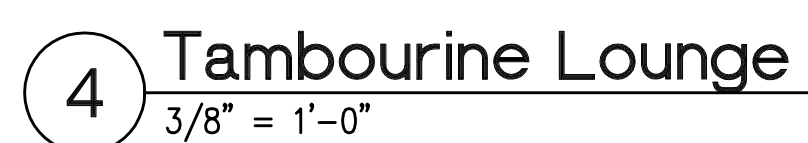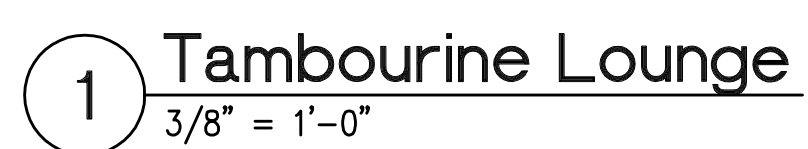

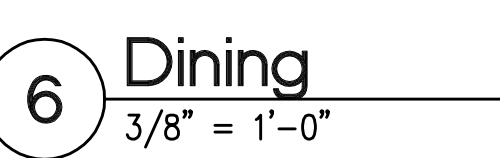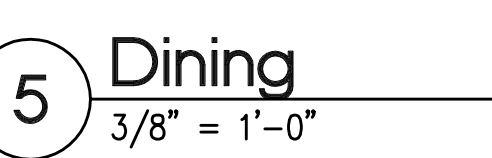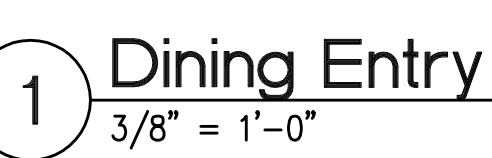

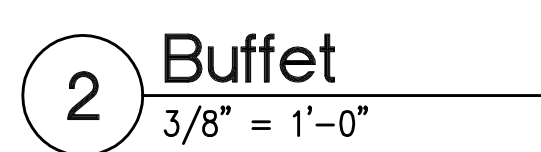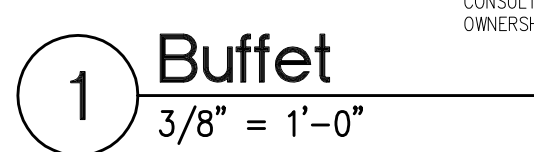

SHEET #	SHEET TITLE:	CHECKED BY:	APPROVED BY:
1-605	ELEVATIONS	DATE: 2/18/16	
OF TOTAL		DATE: 5/12/17	
		JARCH, COMIN #	


Wimberly
INTERIORS

miami | FL | 786 801 1737


CARILLON HOTEL
ALTERATIONS
Z CAPITAL FLORIDA RESORT LLC
6801 COLLINS AVENUE
MIAMI BEACH, FL

Giller & Giller, Inc.
The Giller Building
975 Arthur Godfrey Road
Miami Beach, Florida 33140
(305) 538-0224 FAX (305) 538-5921
Architects INTERIOR DESIGNERS
REG. #AA C001364 CONSTRUCTION MANAGERS


Z:\159352 - Carillon Hotel and Spa\Drawings\8_Interior\Production\Sheets\CS-1-606 ELEVATIONS.dwg, 2/17/2016 6:03:22 PM

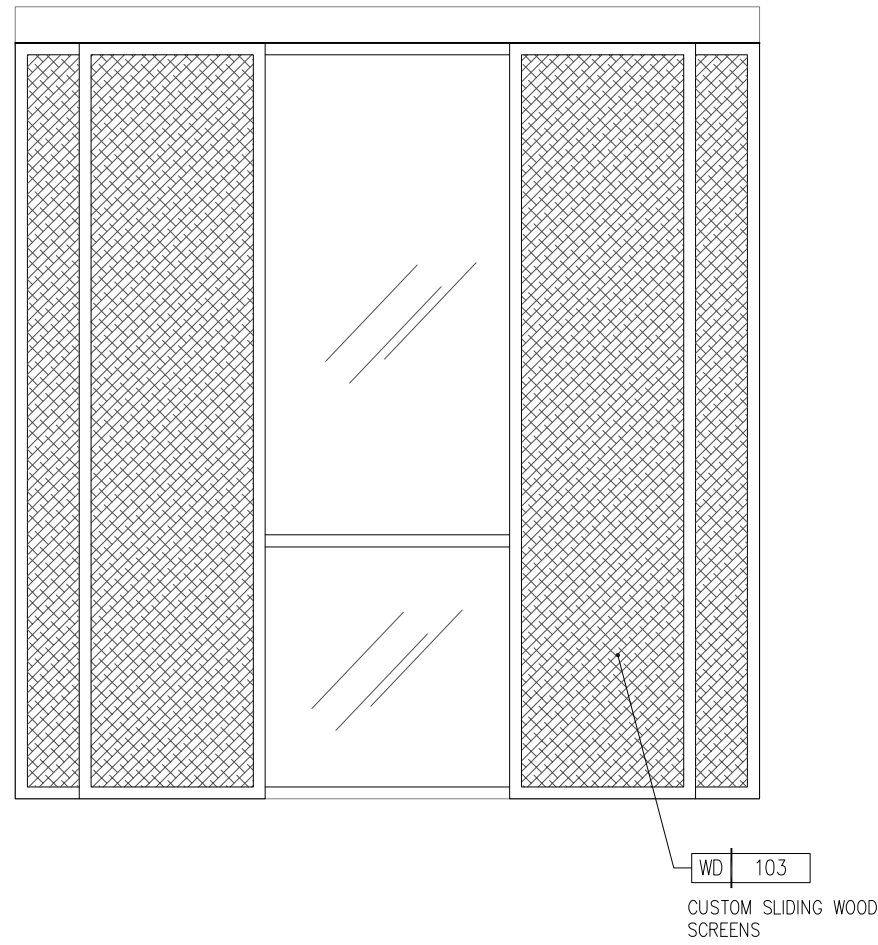


1 Private Cabanas
3/8" = 1'-0"

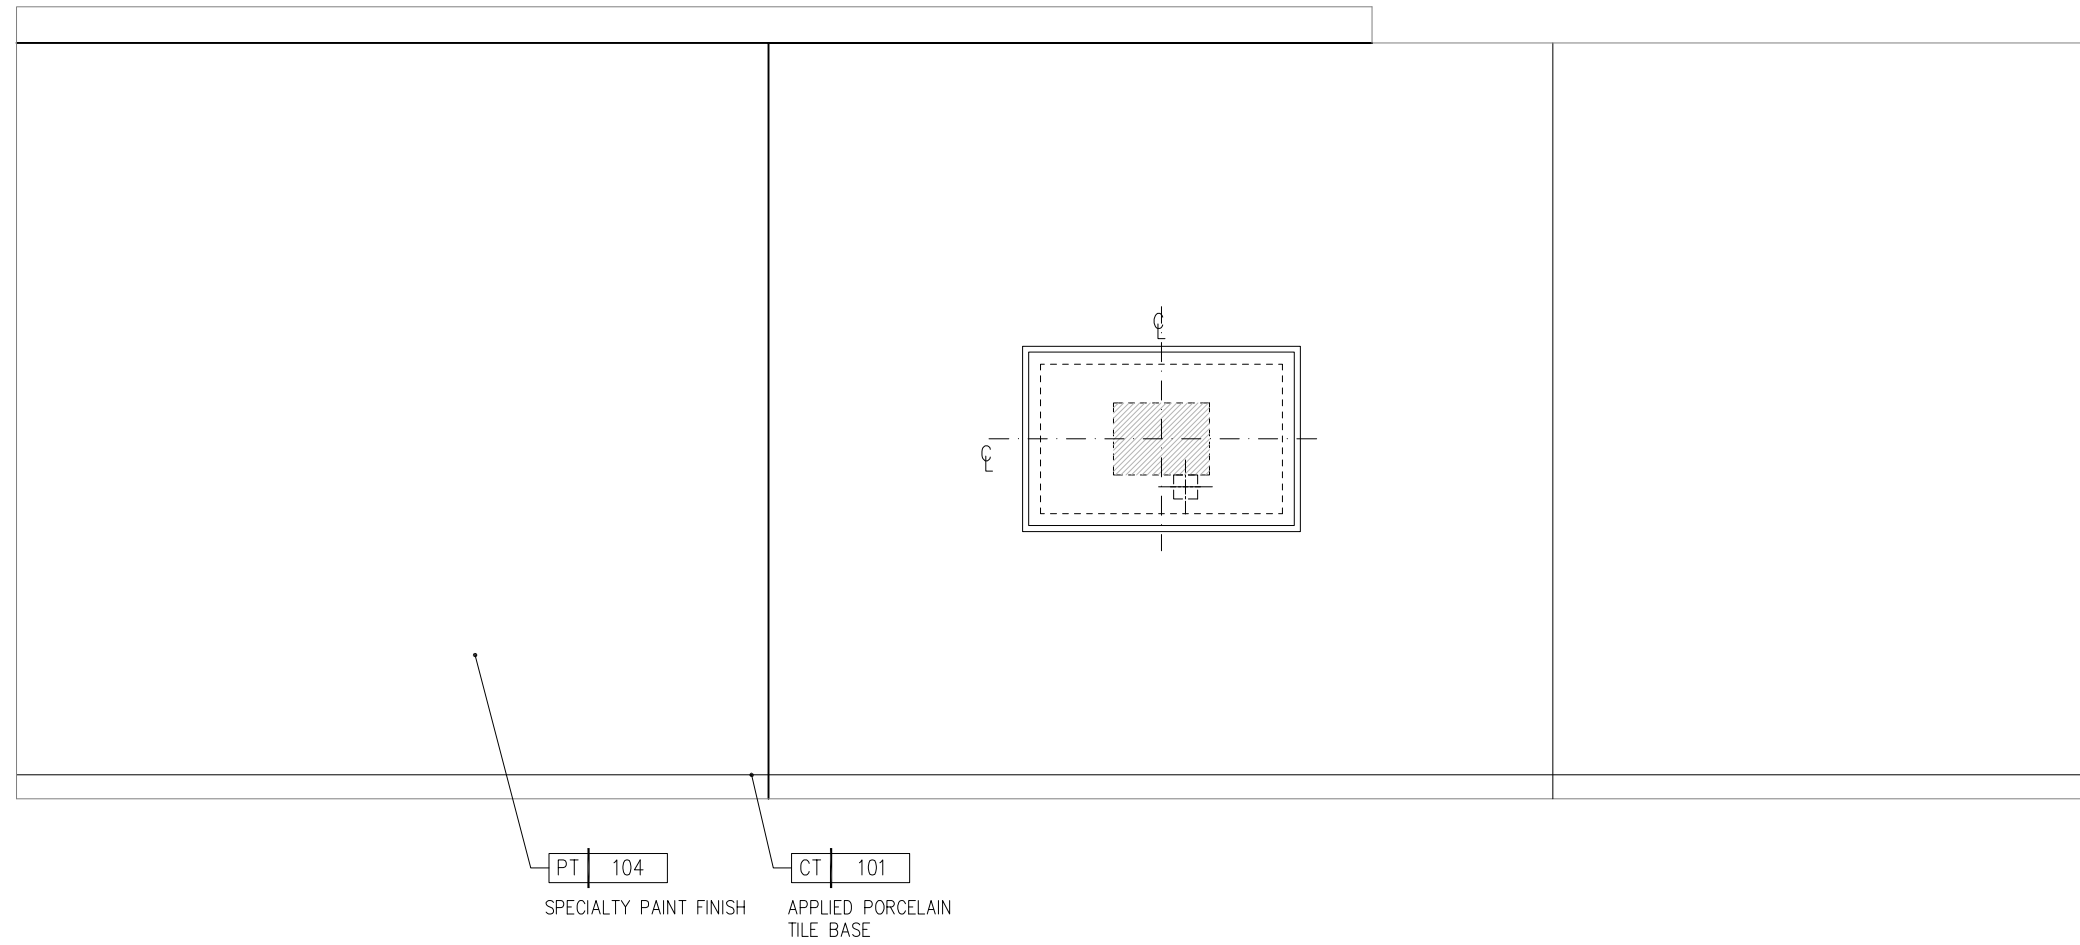


2 Private Cabanas
3/8" = 1'-0"

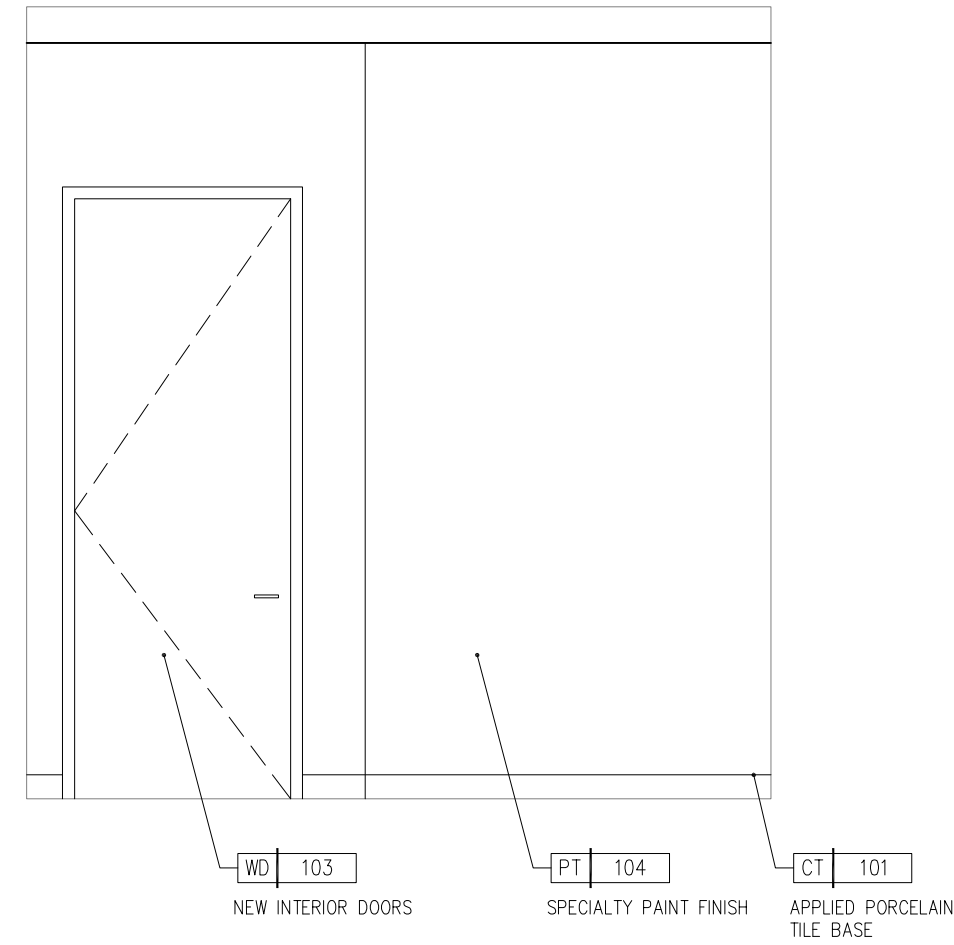


3 Private Cabanas
3/8" = 1'-0"

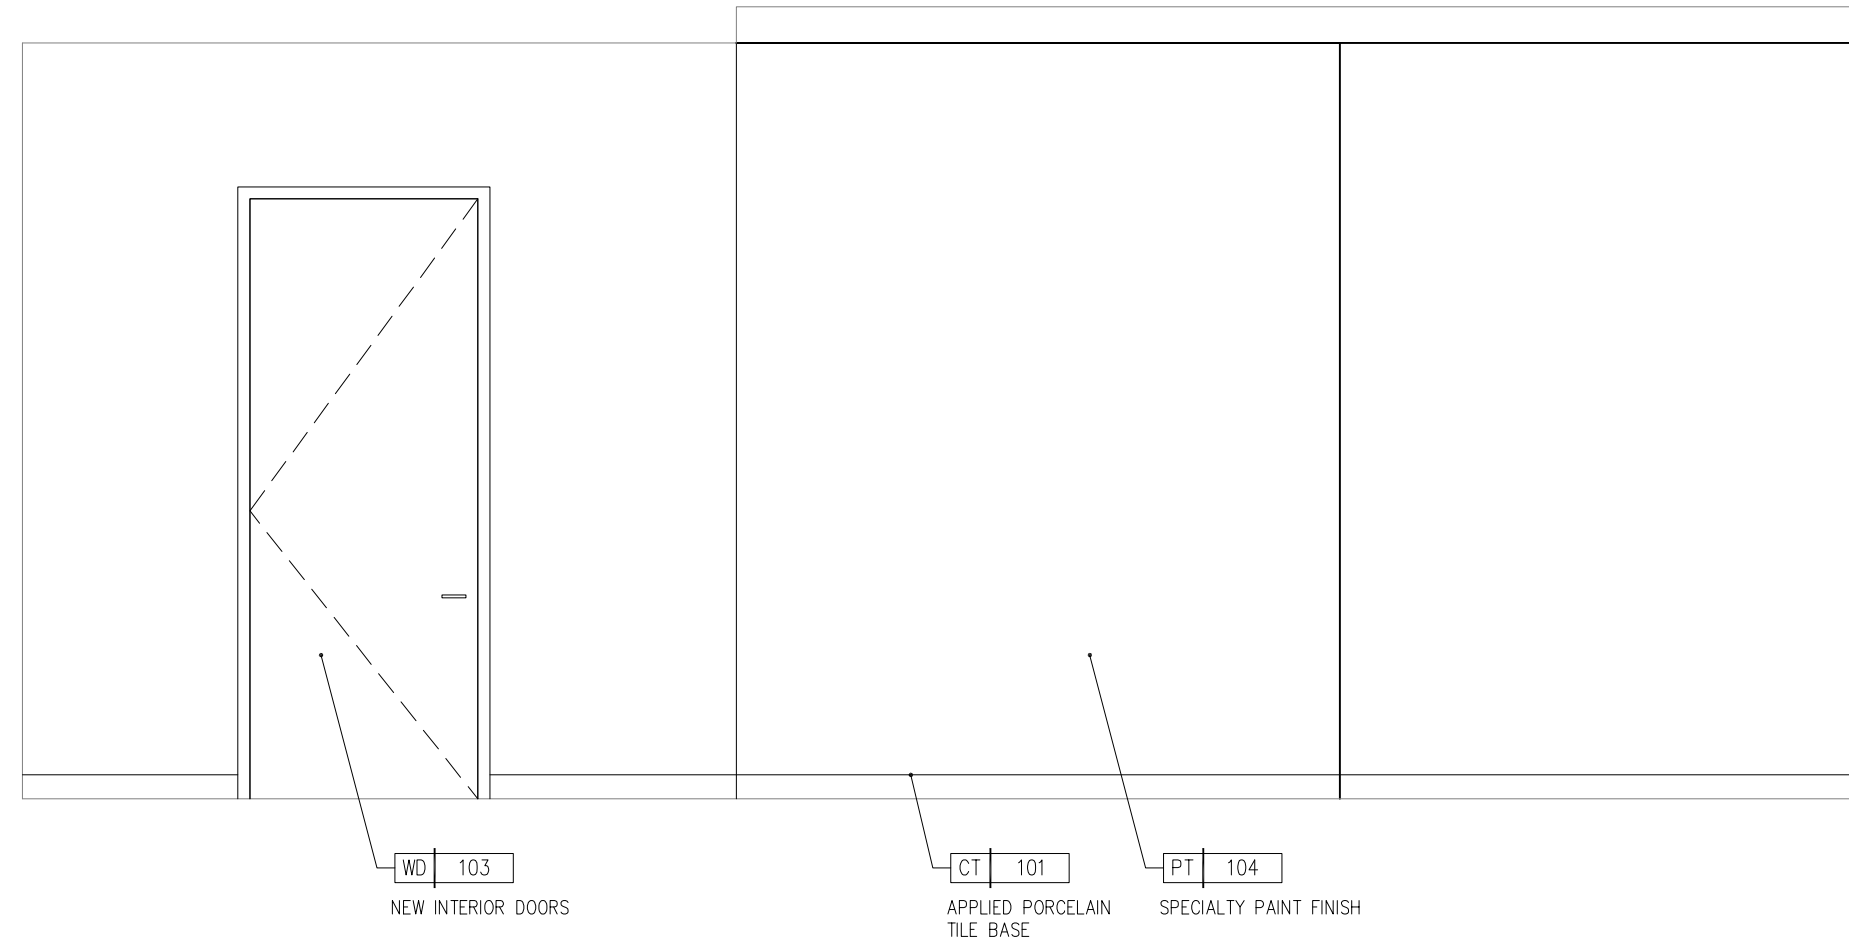


4 Private Cabanas
3/8" = 1'-0"

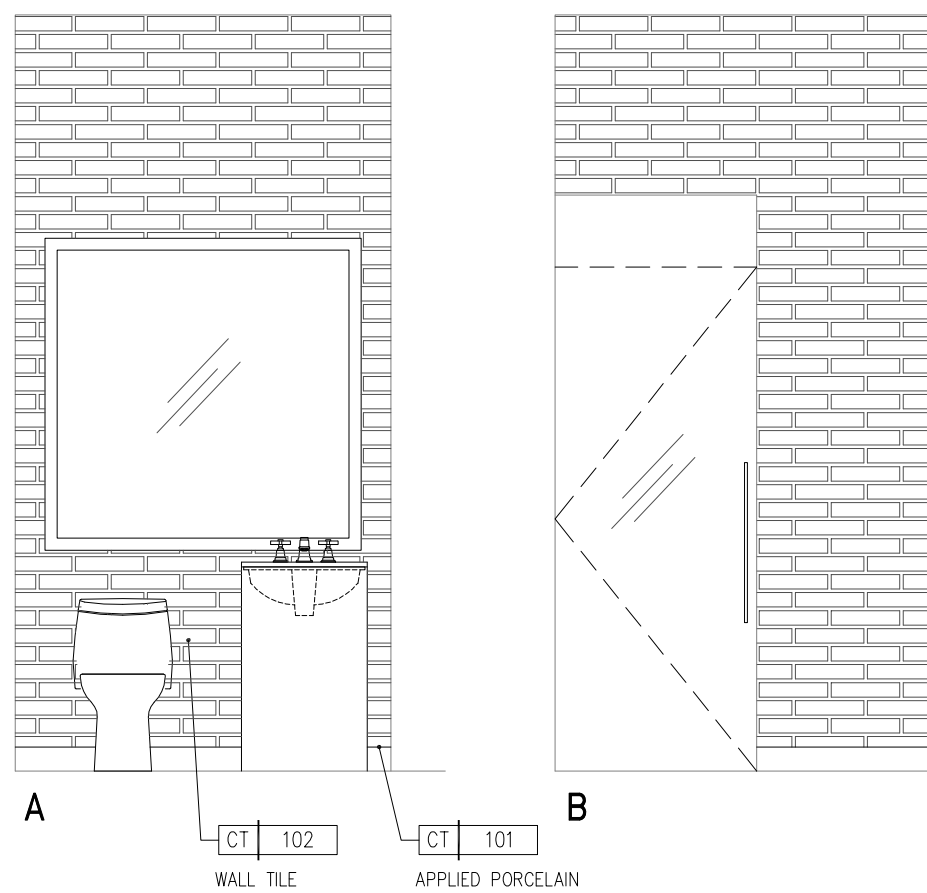


5 Private Cabanas
3/8" = 1'-0"

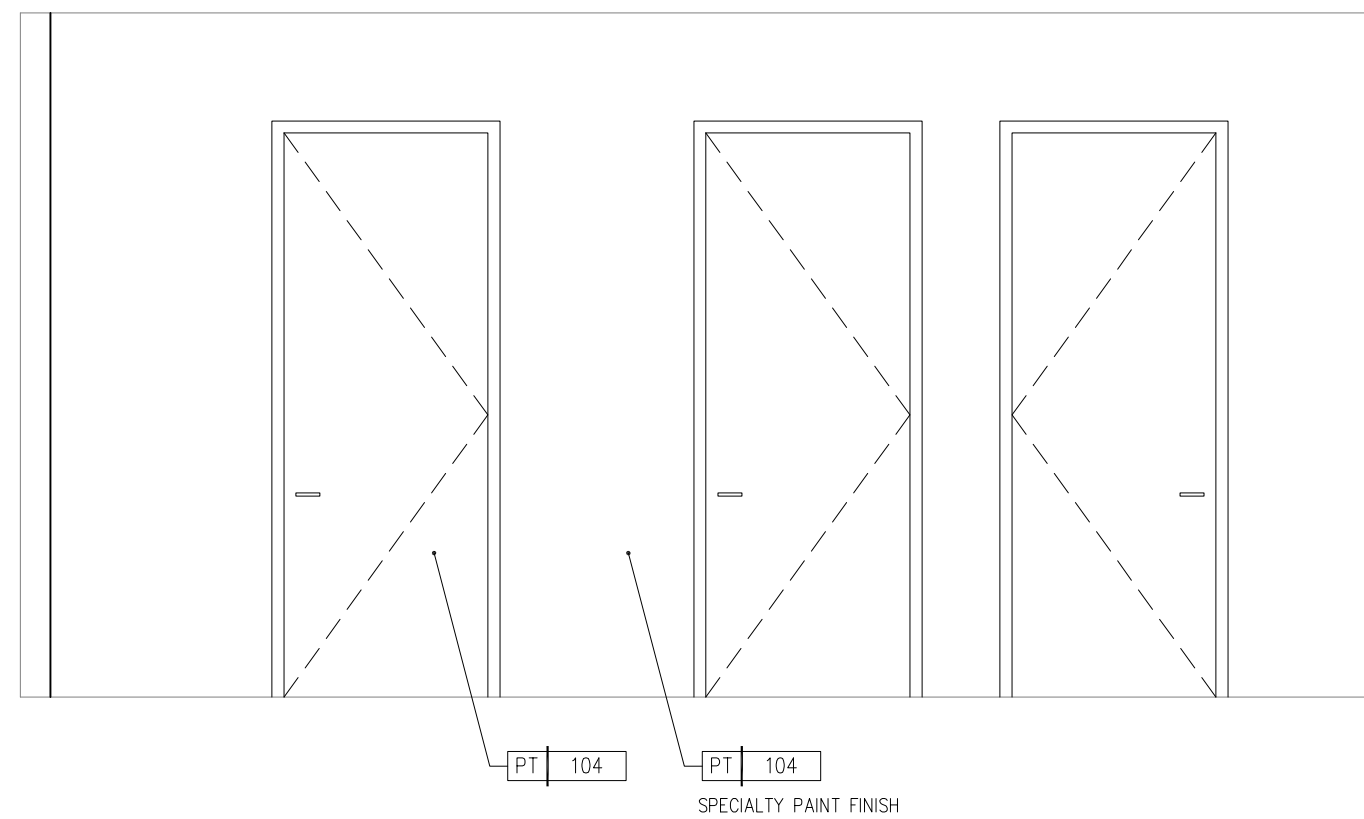


6 Cabana Bathrooms
3/8" = 1'-0"

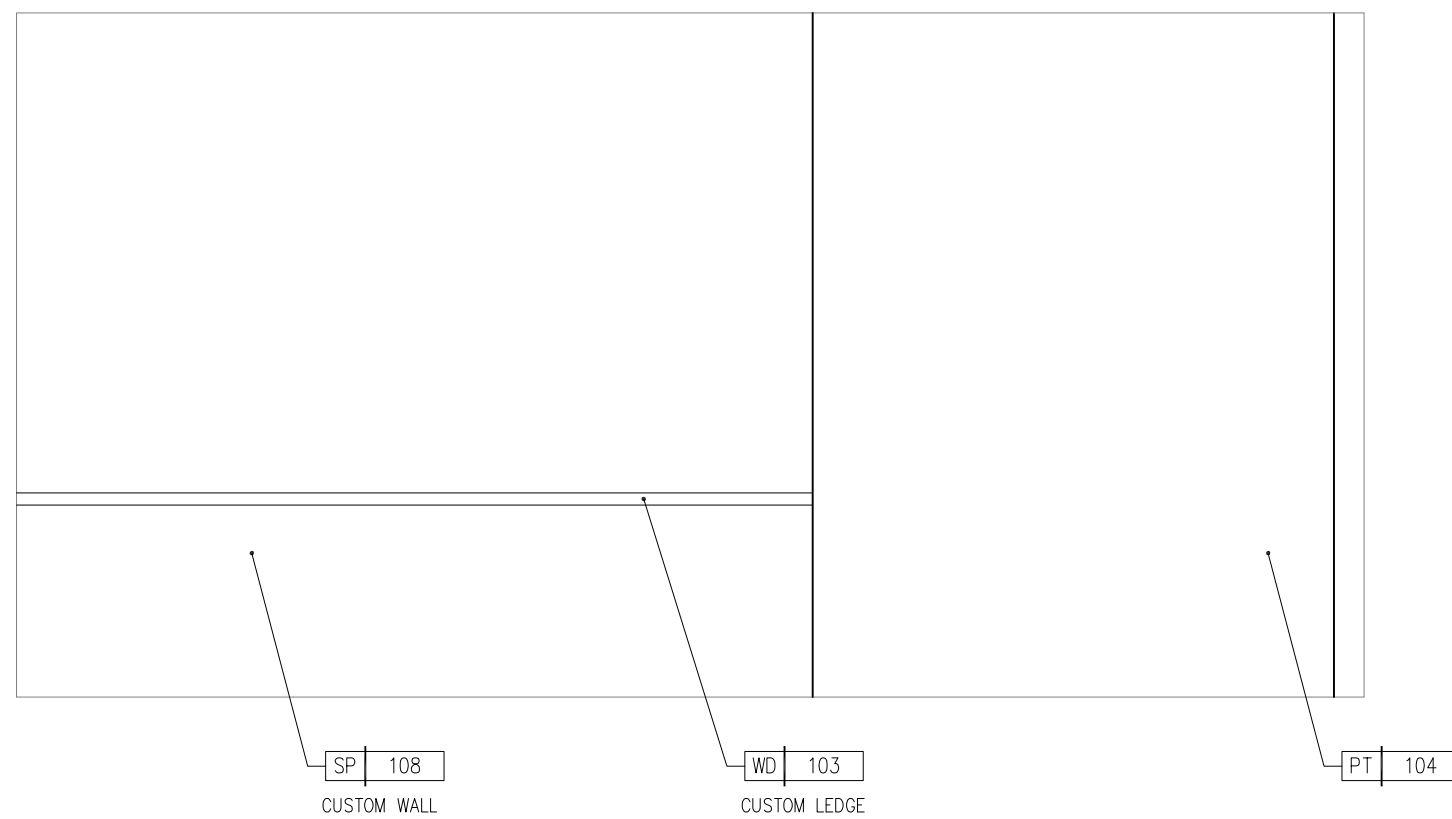







7 Cabana Bathrooms
3/8" = 1'-0"

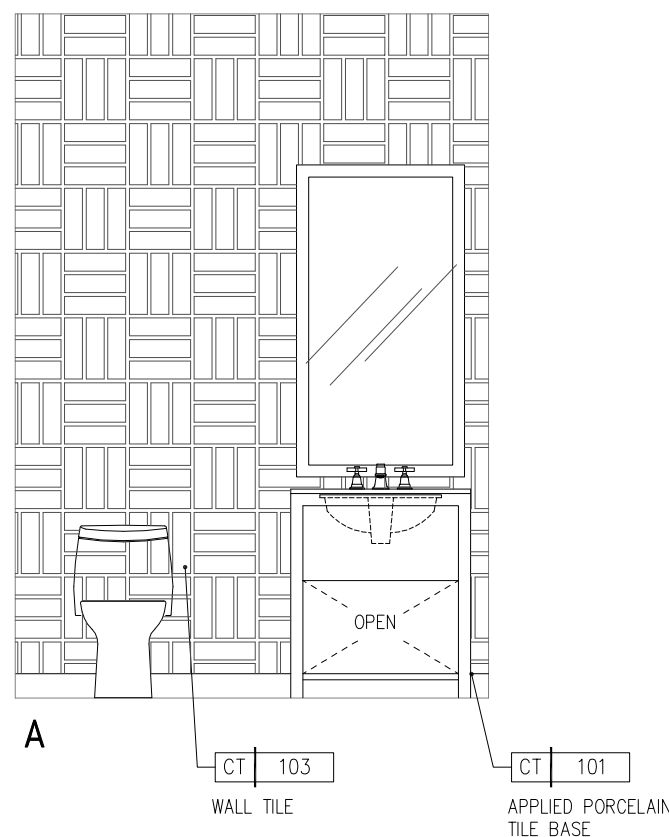

8 Cabana Bathrooms
3/8" = 1'-0"

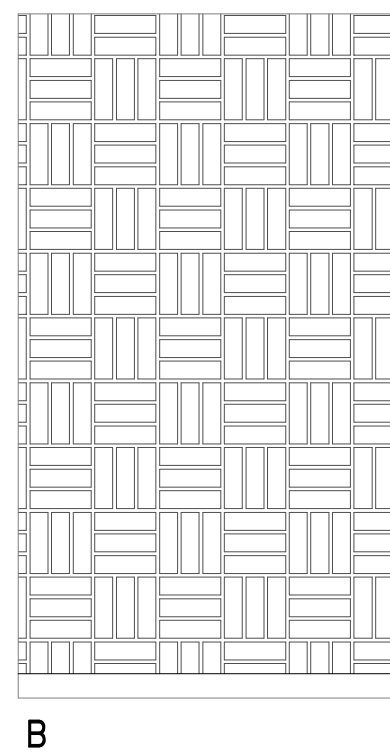

9 Elevator Cab
3/8" = 1'-0"

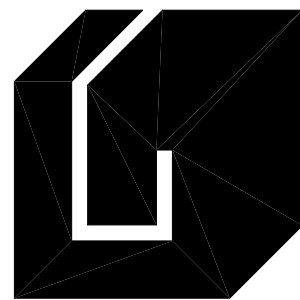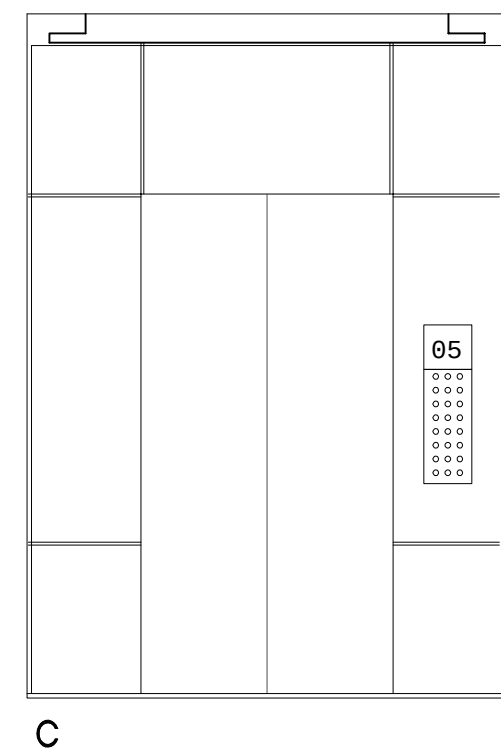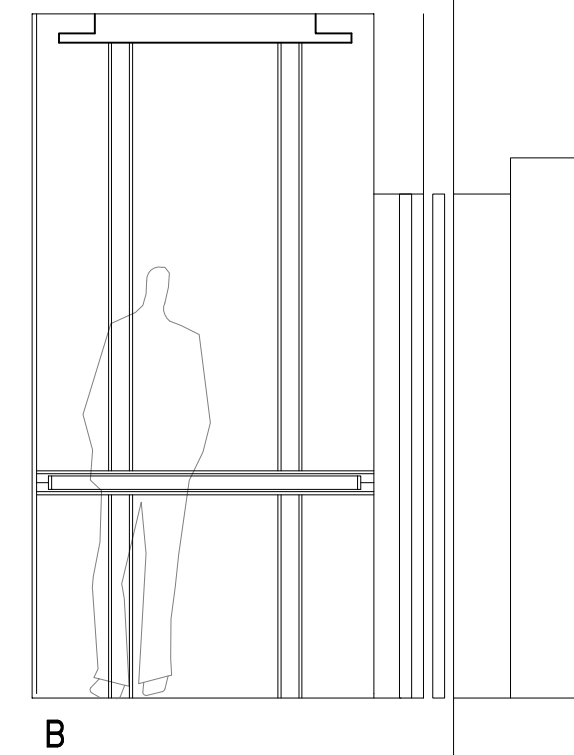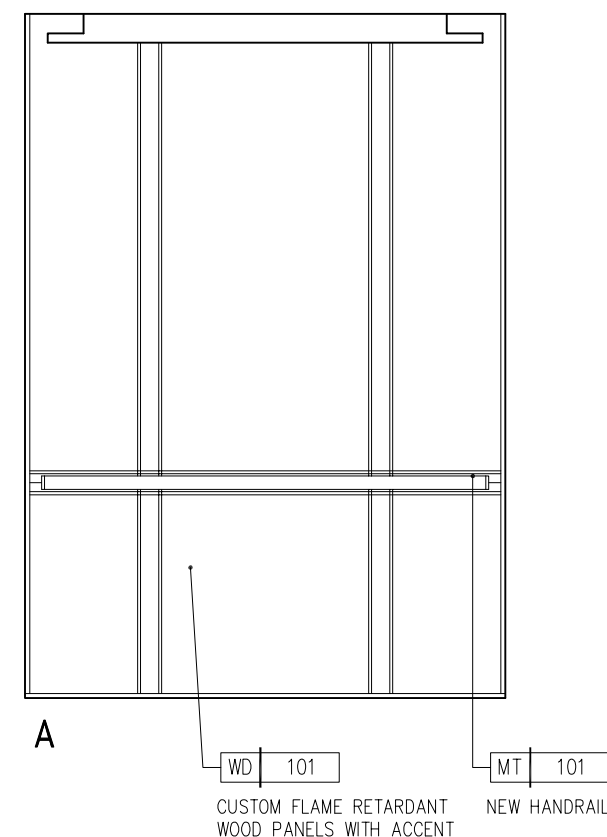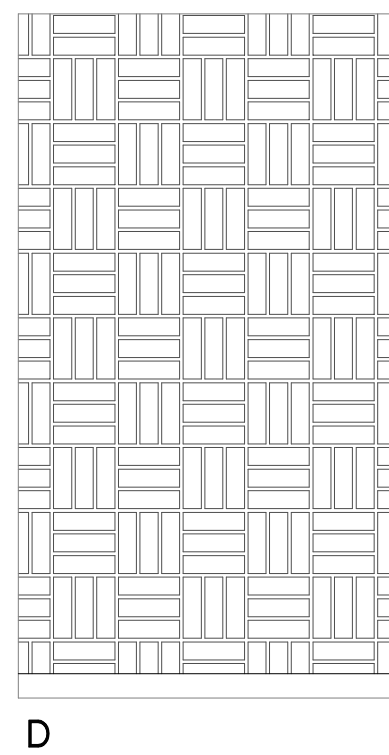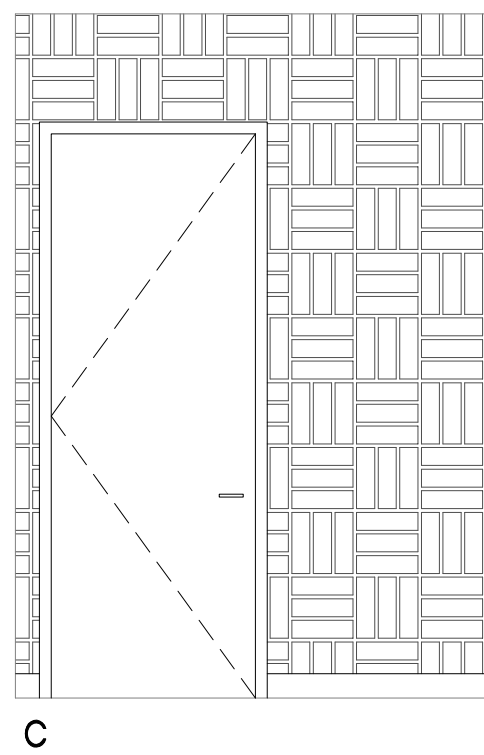

Giller & Giller, Inc.

775 Arthur Godfrey Road
Miami Beach, Florida 33140
Giller978903.COM
Reg. #AA C001364

ARCHITECTS INTERIOR DESIGNERS CONSTRUCTION MANAGERS

Wimberly
INTERIORS

miami | FL 786 801 1737

CARILLON HOTEL
ALTERATIONS
Z CAPITAL FLORIDA RESORT LLC
6801 COLLINS AVENUE
MIAMI BEACH, FL

Prep: J. D. Giller
Drawn: S. G. Bennett
AR000890
AR001811

DATE	REVISION DESCRIPTION

Copyright © 2016, Giller & Giller, Inc. All Rights Reserved


SHEET TITLE:
ELEVATIONS

DATE: 2/18/16
CHECKED BY:
APPROVED BY:
DATE: 2/18/16



SHEET #
1-606
OF TOTAL
ARCH COMM #
15122

HPB APPLICATION, FINALSUBMITTAL

Z:\15932 - Carillon Hotel and Spa Drawings\8_ Interiors\Production\Sheets\CS-1-607 ELEVATIONS.dwg, 2/17/2016 6:03:33 PM

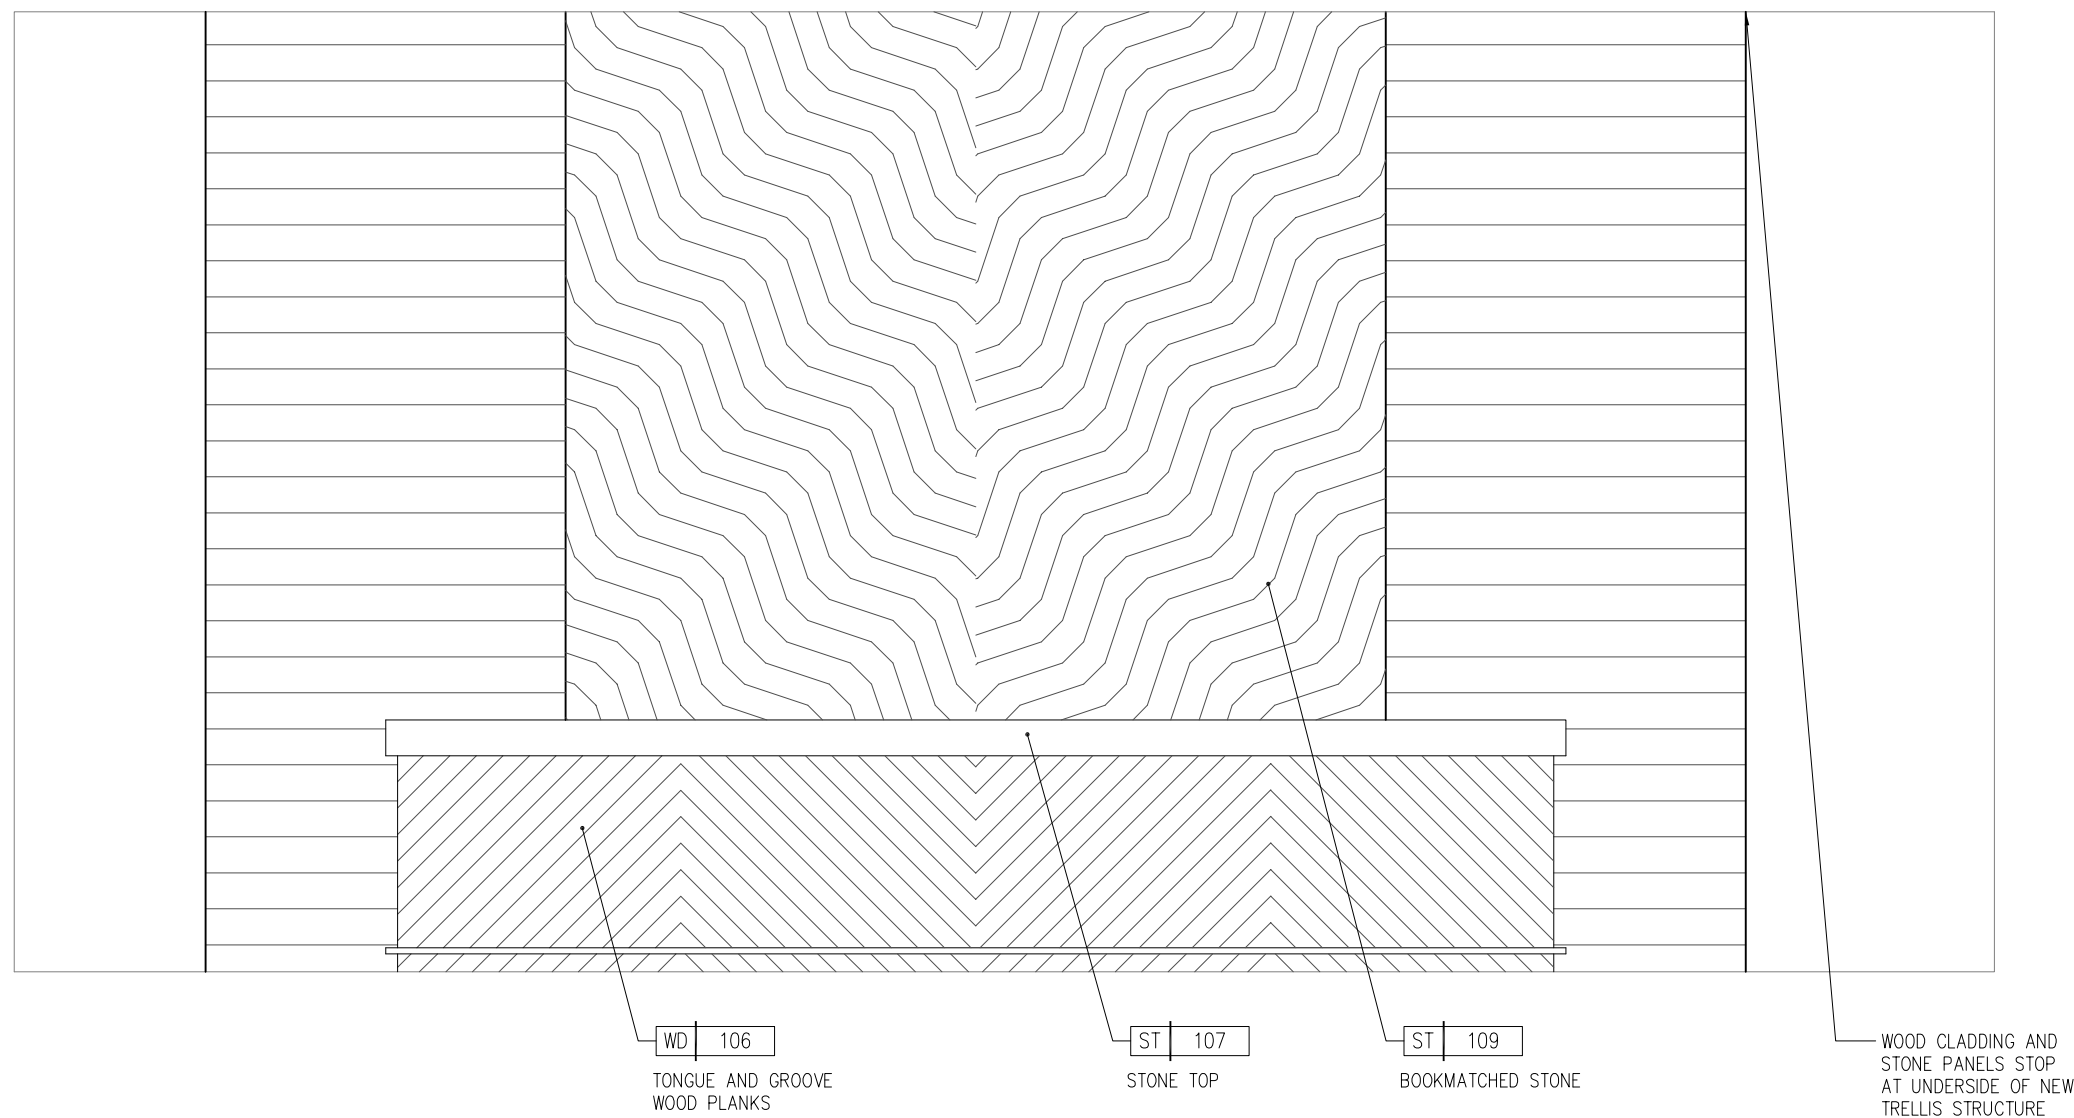

10 Bar
3/8" = 1'-0"

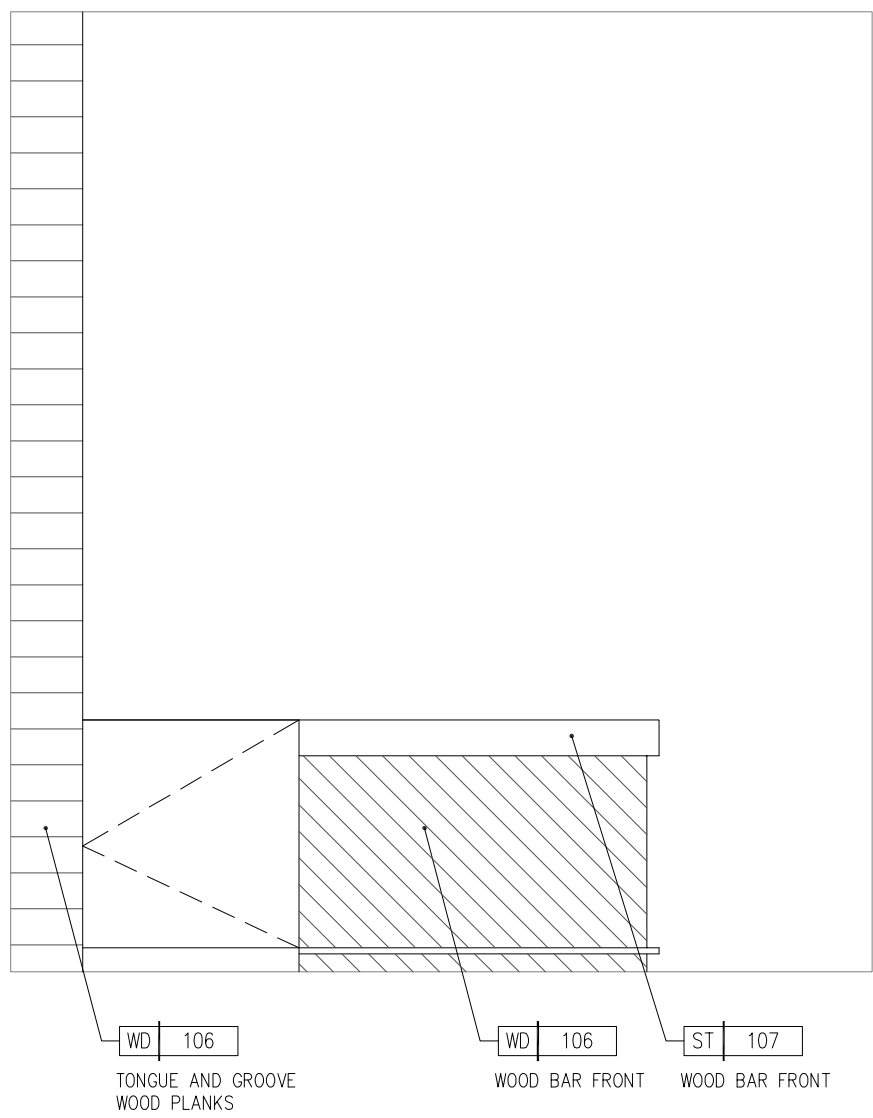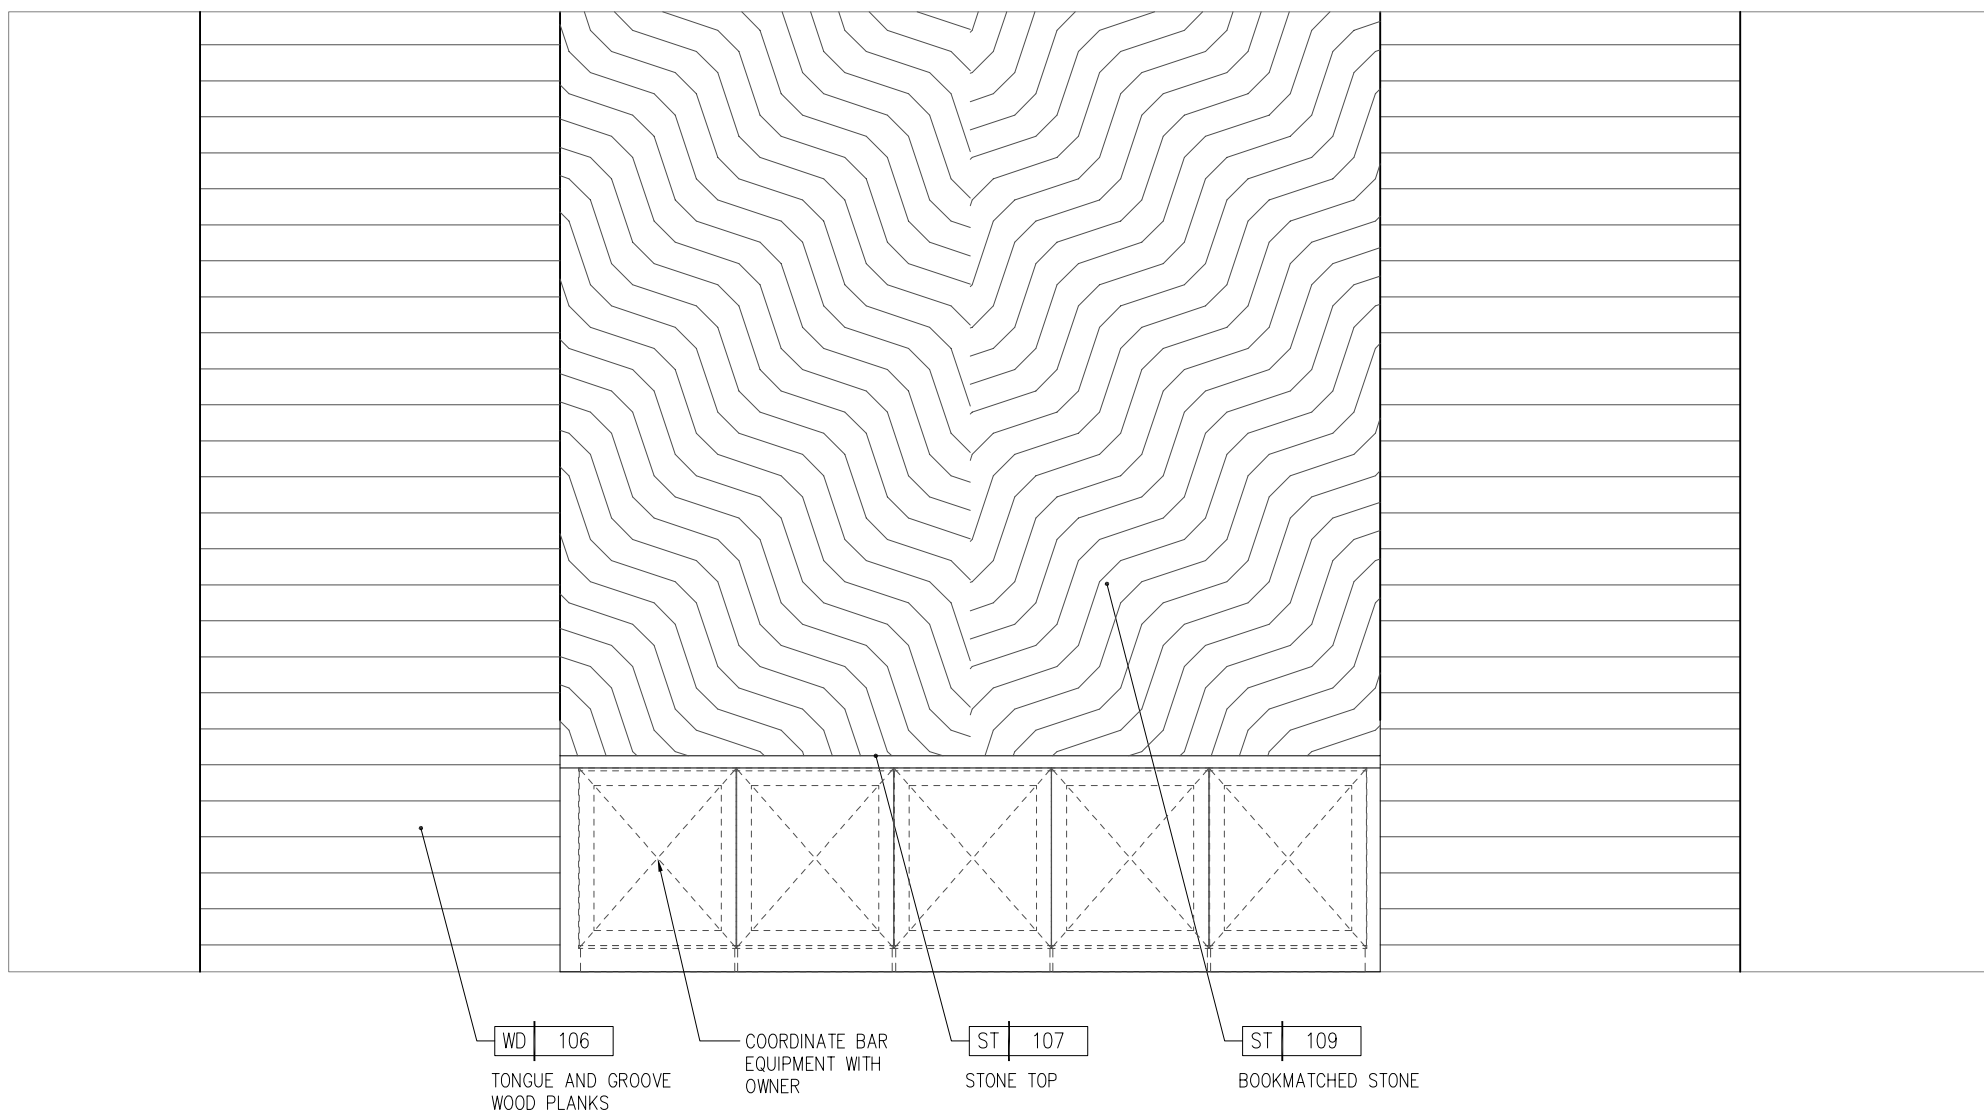

SHEET #
1-607
OF TOTAL
ARCH COMM #
15122

SHEET TITLE:
ELEVATIONS
DATE:
2/18/16
CHECKED BY:
— — —
APPROVED BY:
— — —

DATE	REVISION DESCRIPTION

Copyright © 2016, Giller & Giller, Inc. All rights reserved.

by G. Giller
Sheila G. Bennett
ARCHITECT
AR000590
AR001811

CARILLON HOTEL
ALTERATIONS
Z CAPITAL FLORIDA RESORT LLC
6801 COLLINS AVENUE
MIAMI BEACH, FL

Wimberly
INTERIORS,
miami | FL 786 801 1737

Giller & Giller, Inc.
786 801 1737
786 801 1738
Miami Beach, Florida 33140
975 Arthur Godfrey Road
Giller & Giller, Inc.
Reg. #AA C001364
FAX (305) 538-5921
Giller@786g.com

ARCHITECTS INTERIOR DESIGNERS CONSTRUCTION MANAGERS

