


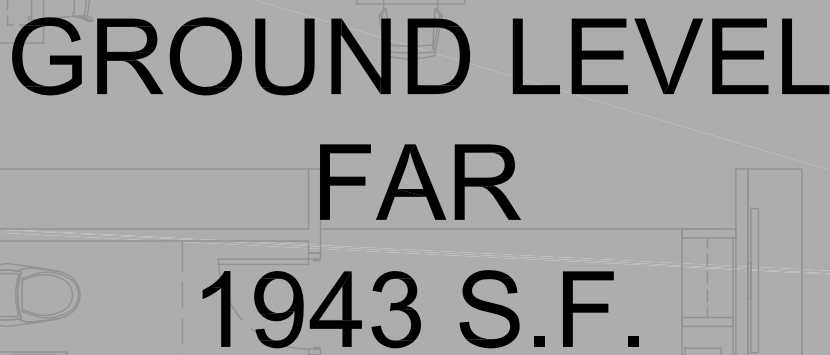


2 PROPOSED SECOND FLOOR PLAN (FAR)
SCALE: 3/16"=1'-0"

**SECOND LEVEL
FAR
1857 S.F.**

SECOND LEVEL
FAR
1857 S.F.

SHEET

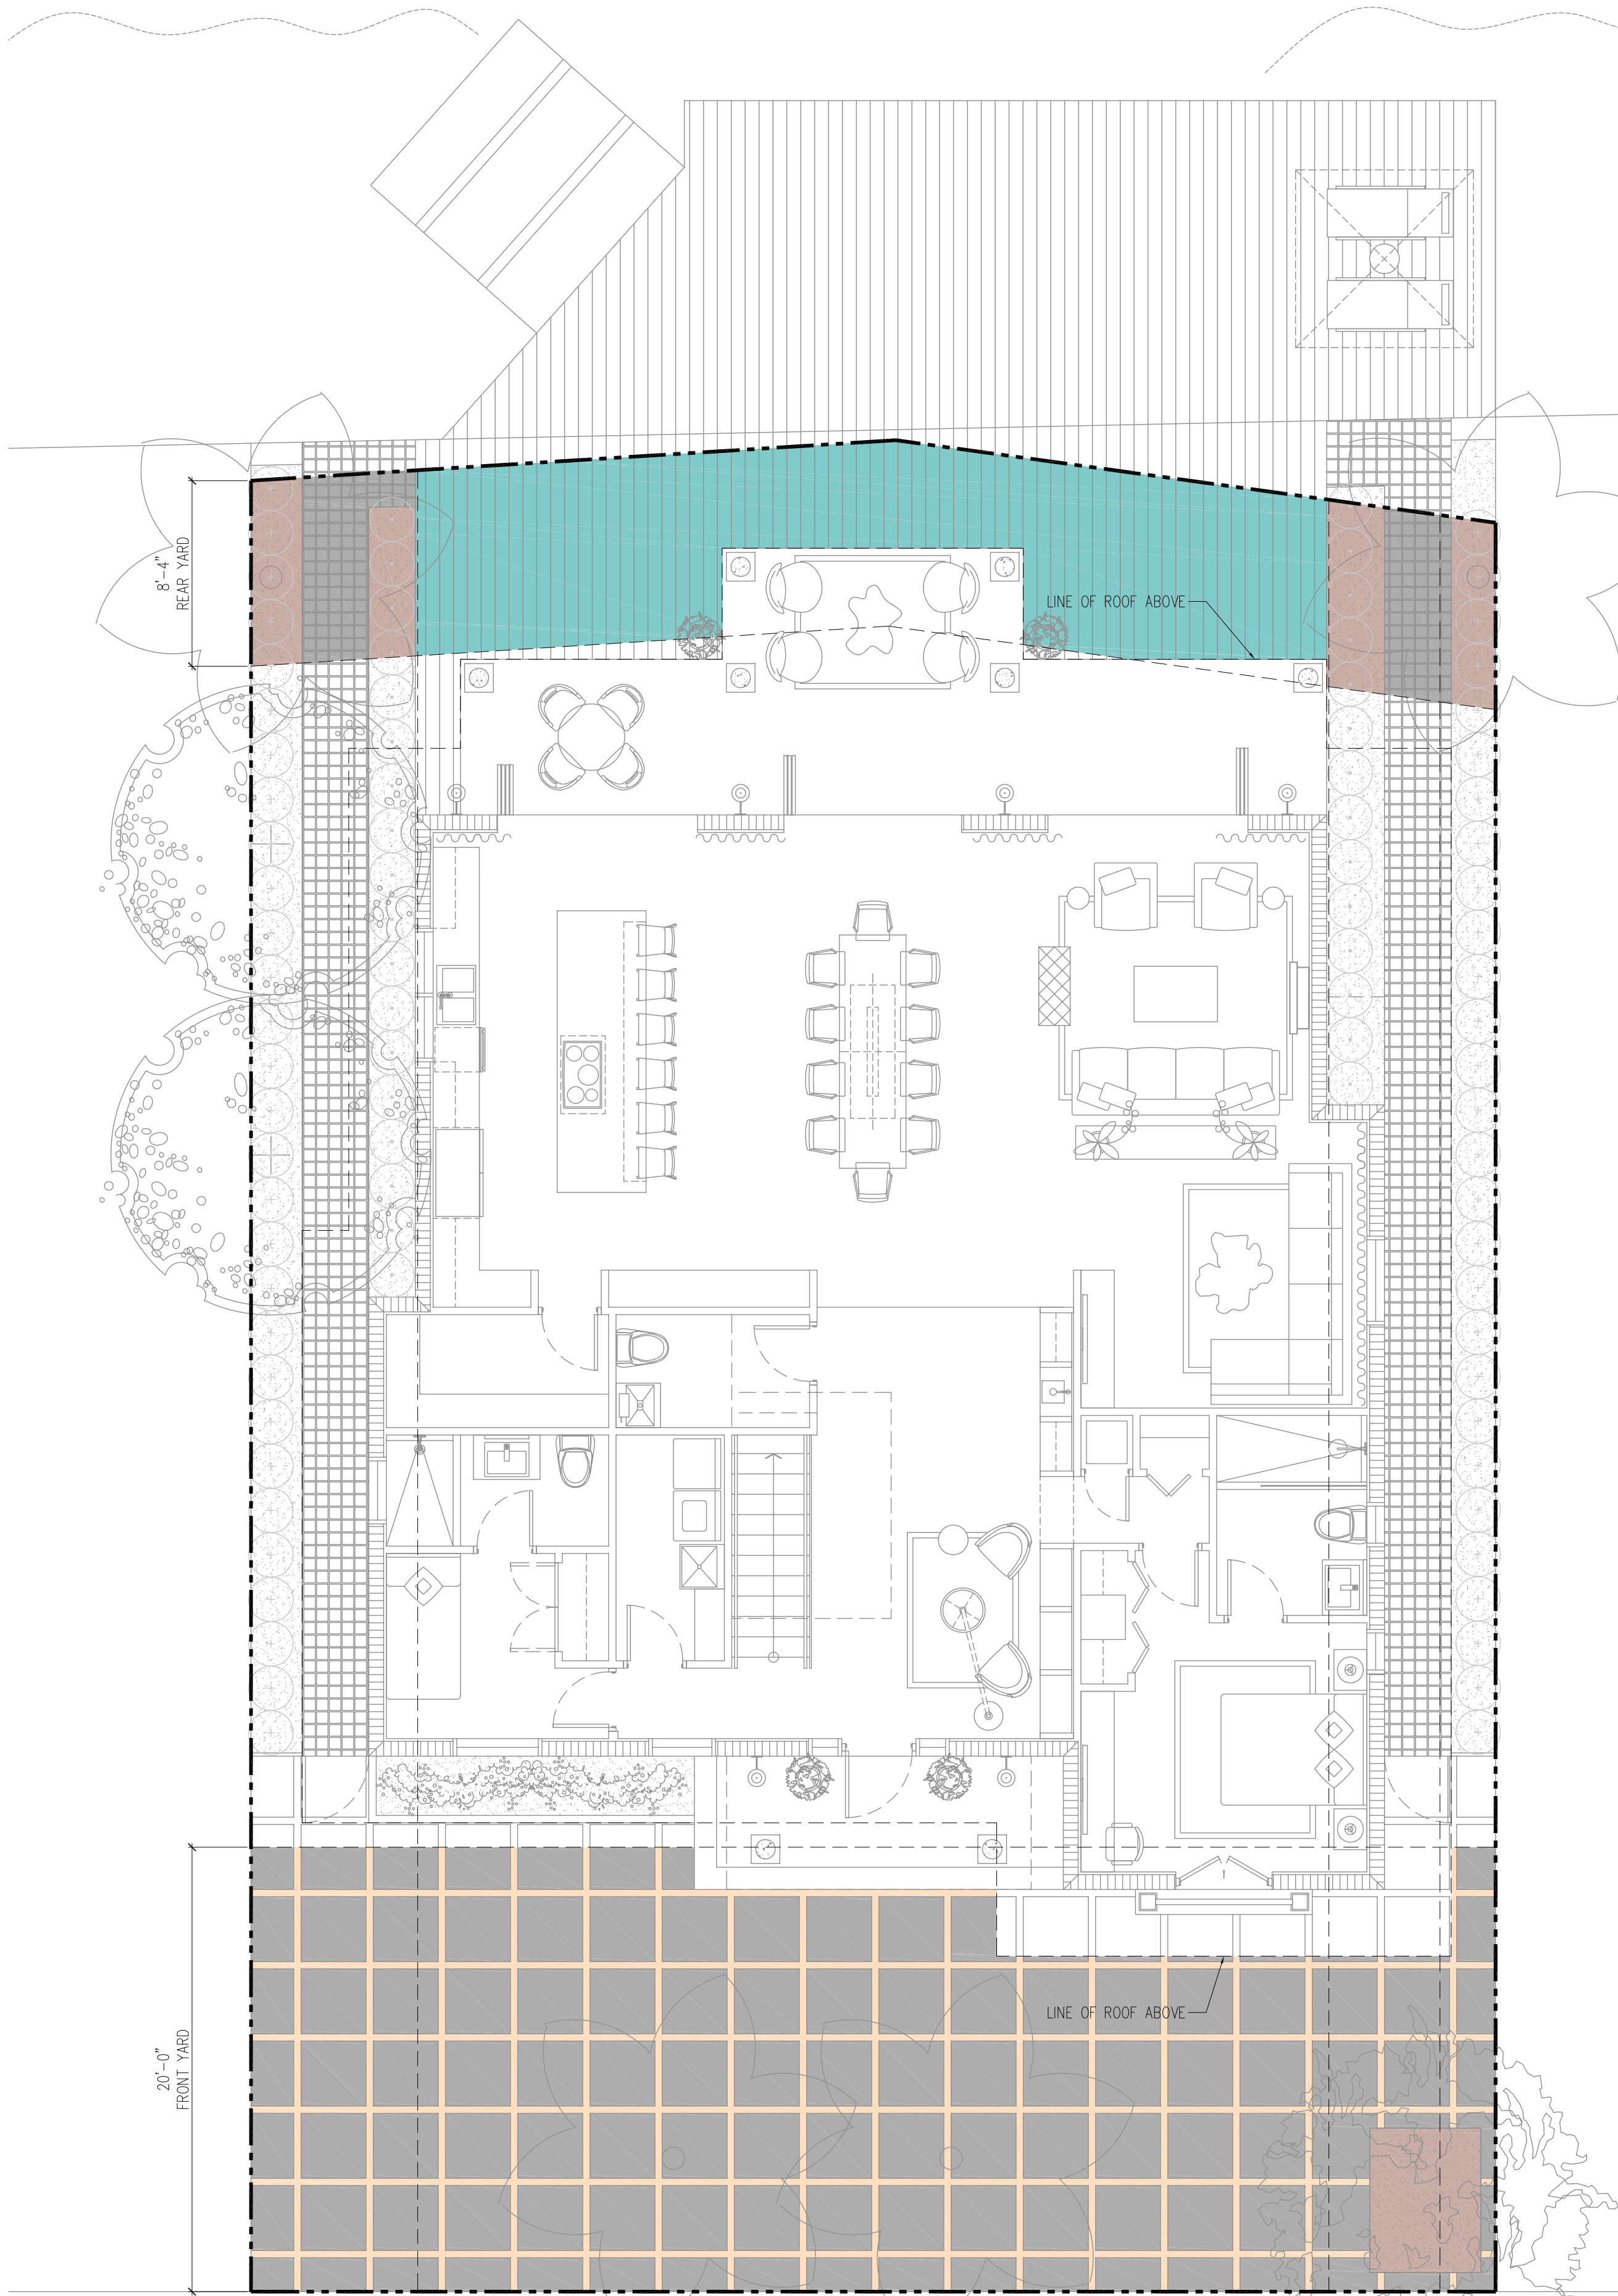

1 PROPOSED FIRST FLOOR PLAN (OPEN SPACE)
SCALE: 3/16"=1'-0"

OPEN SPACE REAR YARD	
COLOR	DESCRIPTION
	PERVIOUS SURFACE: SOIL - 72 S.F.
	IMPERVIOUS SURFACE: CONCRET PAVER - 64 S.F.
	IMPERVIOUS SURFACE: WOOD DECK - 286 S.F.
TOTAL REAR YARD OPEN AREA = 412 S.F. ALLOWED IMPERVIOUS SURFACE (30%) = 124 S.F. TOTAL IMPERVIOUS SURFACE = 340 S.F. REQUESTED VARIANCE REAR AREA = 216 S.F.	

OPEN SPACE FRONT YARD	
COLOR	DESCRIPTION
	PERVIOUS SURFACE: GRASS - 183 S.F.
	PERVIOUS SURFACE: SOIL - 33 S.F.
	IMPERVIOUS SURFACE: CONCRETE PAVER - 778 S.F.
TOTAL REAR YARD OPEN AREA = 994 S.F. ALLOWED IMPERVIOUS SURFACE (30%) = 298 S.F. TOTAL IMPERVIOUS SURFACE = 778 S.F. REQUESTED VARIANCE REAR AREA = 480 S.F.	

DO NOT SCALE DRAWING	
THIS DRAWING IS THE PROPERTY OF TAI ARCHITECTURE AND SHALL NOT BE REPRODUCED, COPIED, LENT OR DISPOSED OF DIRECTLY OR INDIRECTLY FOR ANY PURPOSES OTHER THAN THAT FOR WHICH IT IS SPECIFICALLY FURNISHED AND MUST BE RETURNED TO TAI ARCHITECTURE ON COMPLETION OF WORK IF REQUESTED.	
FINAL DRB SUBMITTAL	02.09.17
PRELIMINARY DRB SUBMITTAL	01.24.17
REVISIONS/SUBMISSIONS	DATE

SEAL

PROJECT NAME / ADDRESS:
PRIVATE RESIDENCE
8 FARREY LANE
MIAMI BEACH, FL 33139

DRAWING TITLE:
**OPEN SPACE
FLOOR PLAN**

PROJECT #:
16-M-04

FOR DRB

T-1.3

SHEET

ARCHITECT:
TAI ARCHITECTURE, INC.
278 NW 57th Street, Miami, FL 33127
p: 305.576.7556 f: 305.576.5772
e: michael@tdmiami.com license aa26001343



ARCHITECT:

TAI ARCHITECTURE, INC.
278 NW 37th Street, Miami, FL 33127
p: 305.576.7556 | f: 305.576.5772
e: michael@tfidmiami.com license aa260013

DO NOT SCALE DRAWING
THIS DRAWING IS THE PROPERTY OF TAI
ARCHITECTURE AND SHALL NOT BE REPRODUCED,
COPIED, LENT OR DISPOSED OF DIRECTLY OR
INDIRECTLY, NOR USED FOR ANY PURPOSE OTHER
THAN THAT FOR WHICH IT IS SPECIFICALLY
FURNISHED AND MUST BE RETURNED TO TAI
ARCHITECTURE ON COMPLETION OF WORK IF
REQUESTED.

[illegible]

SEAL

PROJECT NAME / ADDRESS:
PRIVATE RESIDENCE
8 FARREY LANE
MIAMI BEACH, FL 33139

DRAWING TITLE:


SITE PHOTOGRAPHS

PROJECT #:
16-M-04

B
B
D
B
C
L

T-1.4

HEE

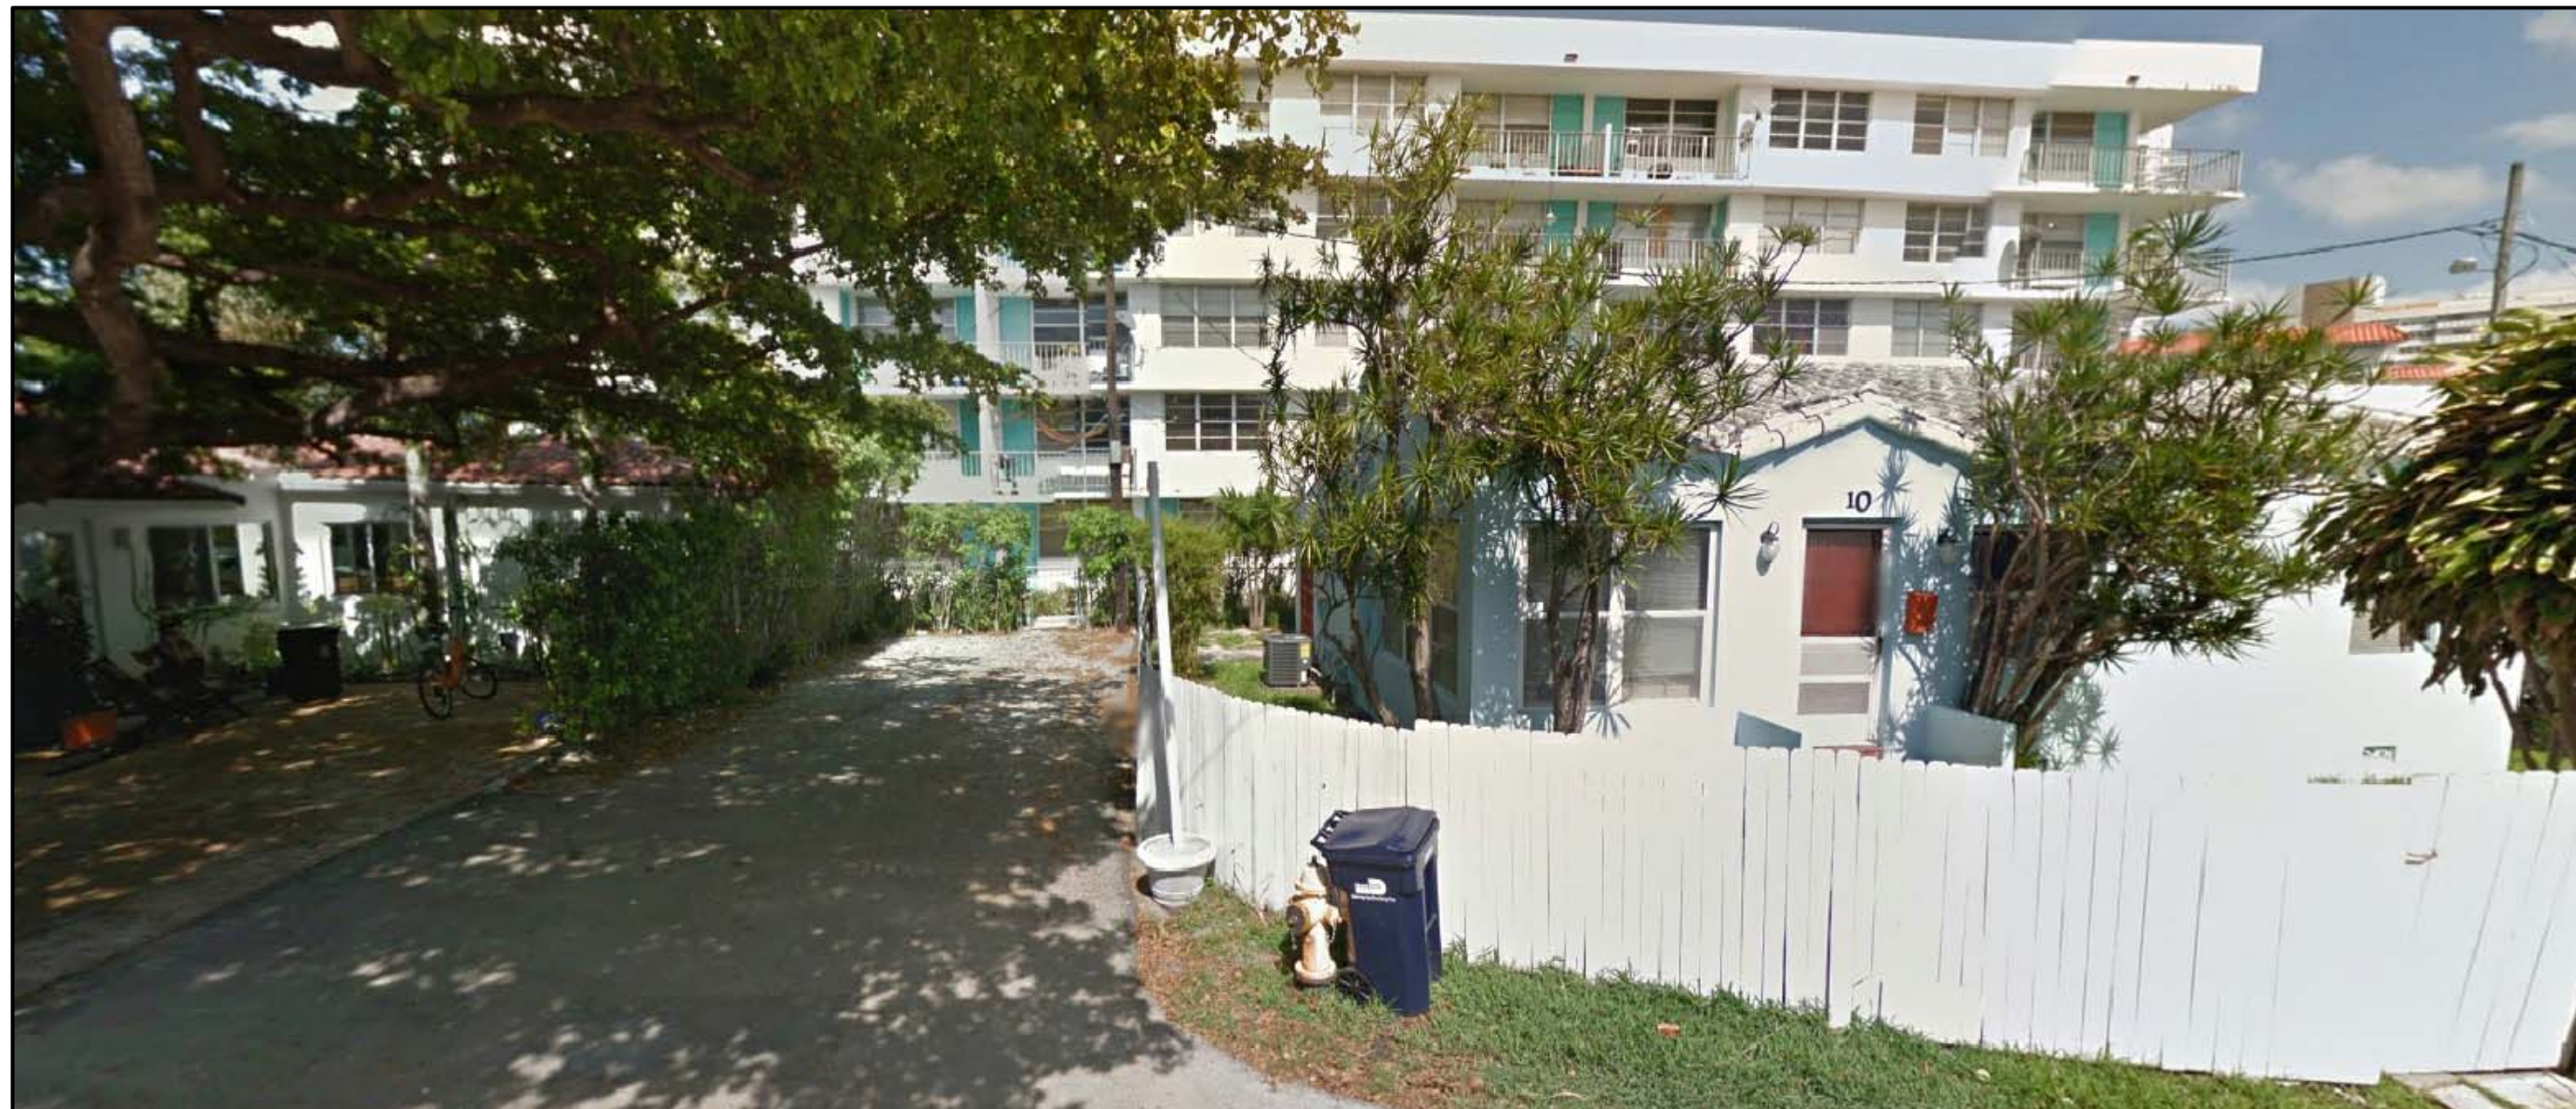

二
 〇
 一
 三
 三
 〇
 三
 三

TAI ARCHITECTURE, INC.
278 NW 37th Street, Miami, FL 33127
p: 305.576.7556 f: 305.576.5772
e: michael@tdmiami.com license aa260013

DO NOT SCALE DRAWING
THIS DRAWING IS THE PROPERTY OF TAI
ARCHITECTURE AND SHALL NOT BE REPRODUCED,
COPIED, LENT OR DISPOSED OF DIRECTLY OR
INDIRECTLY, NOR USED FOR ANY PURPOSE OTHER
THAN THAT FOR WHICH IT IS SPECIFICALLY
FURNISHED AND MUST BE RETURNED TO TAI
ARCHITECTURE ON COMPLETION OF WORK, IF
REQUESTED.

[illegible]

SEAL

PROJECT NAME / ADDRESS
PRIVATE RESIDENCE
8 FARREY LANE
MIAMI BEACH, FL 33139



j
j
E
E
5
,
E
E
E
E
j

SITE PHOTOGRAPHS

16-M-04	FOR DRB
----------------	----------------

T-1.5

SHEET

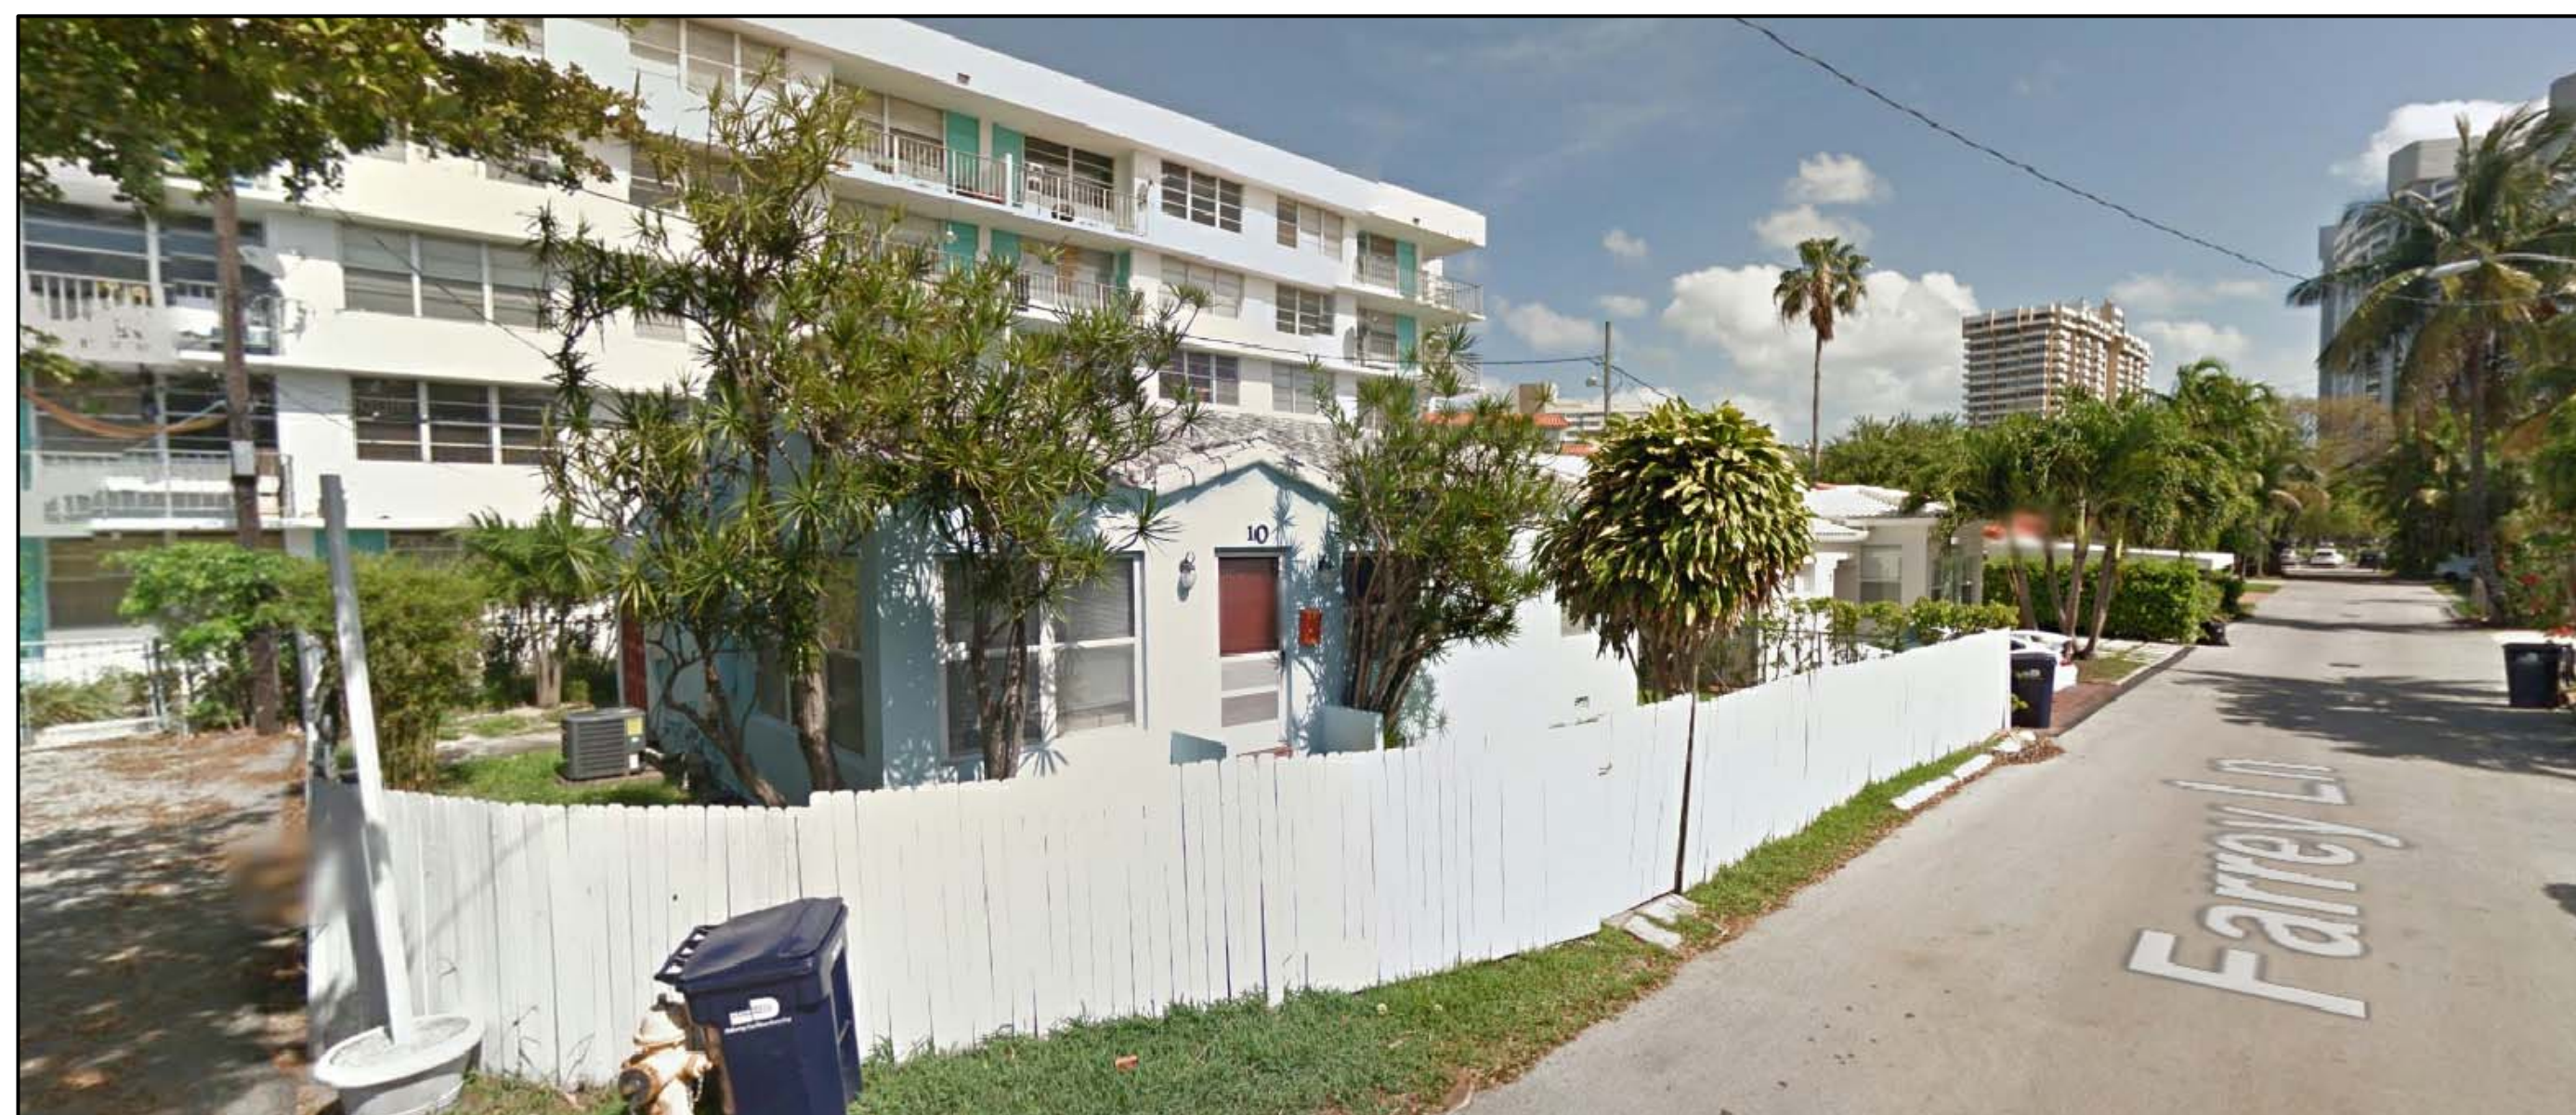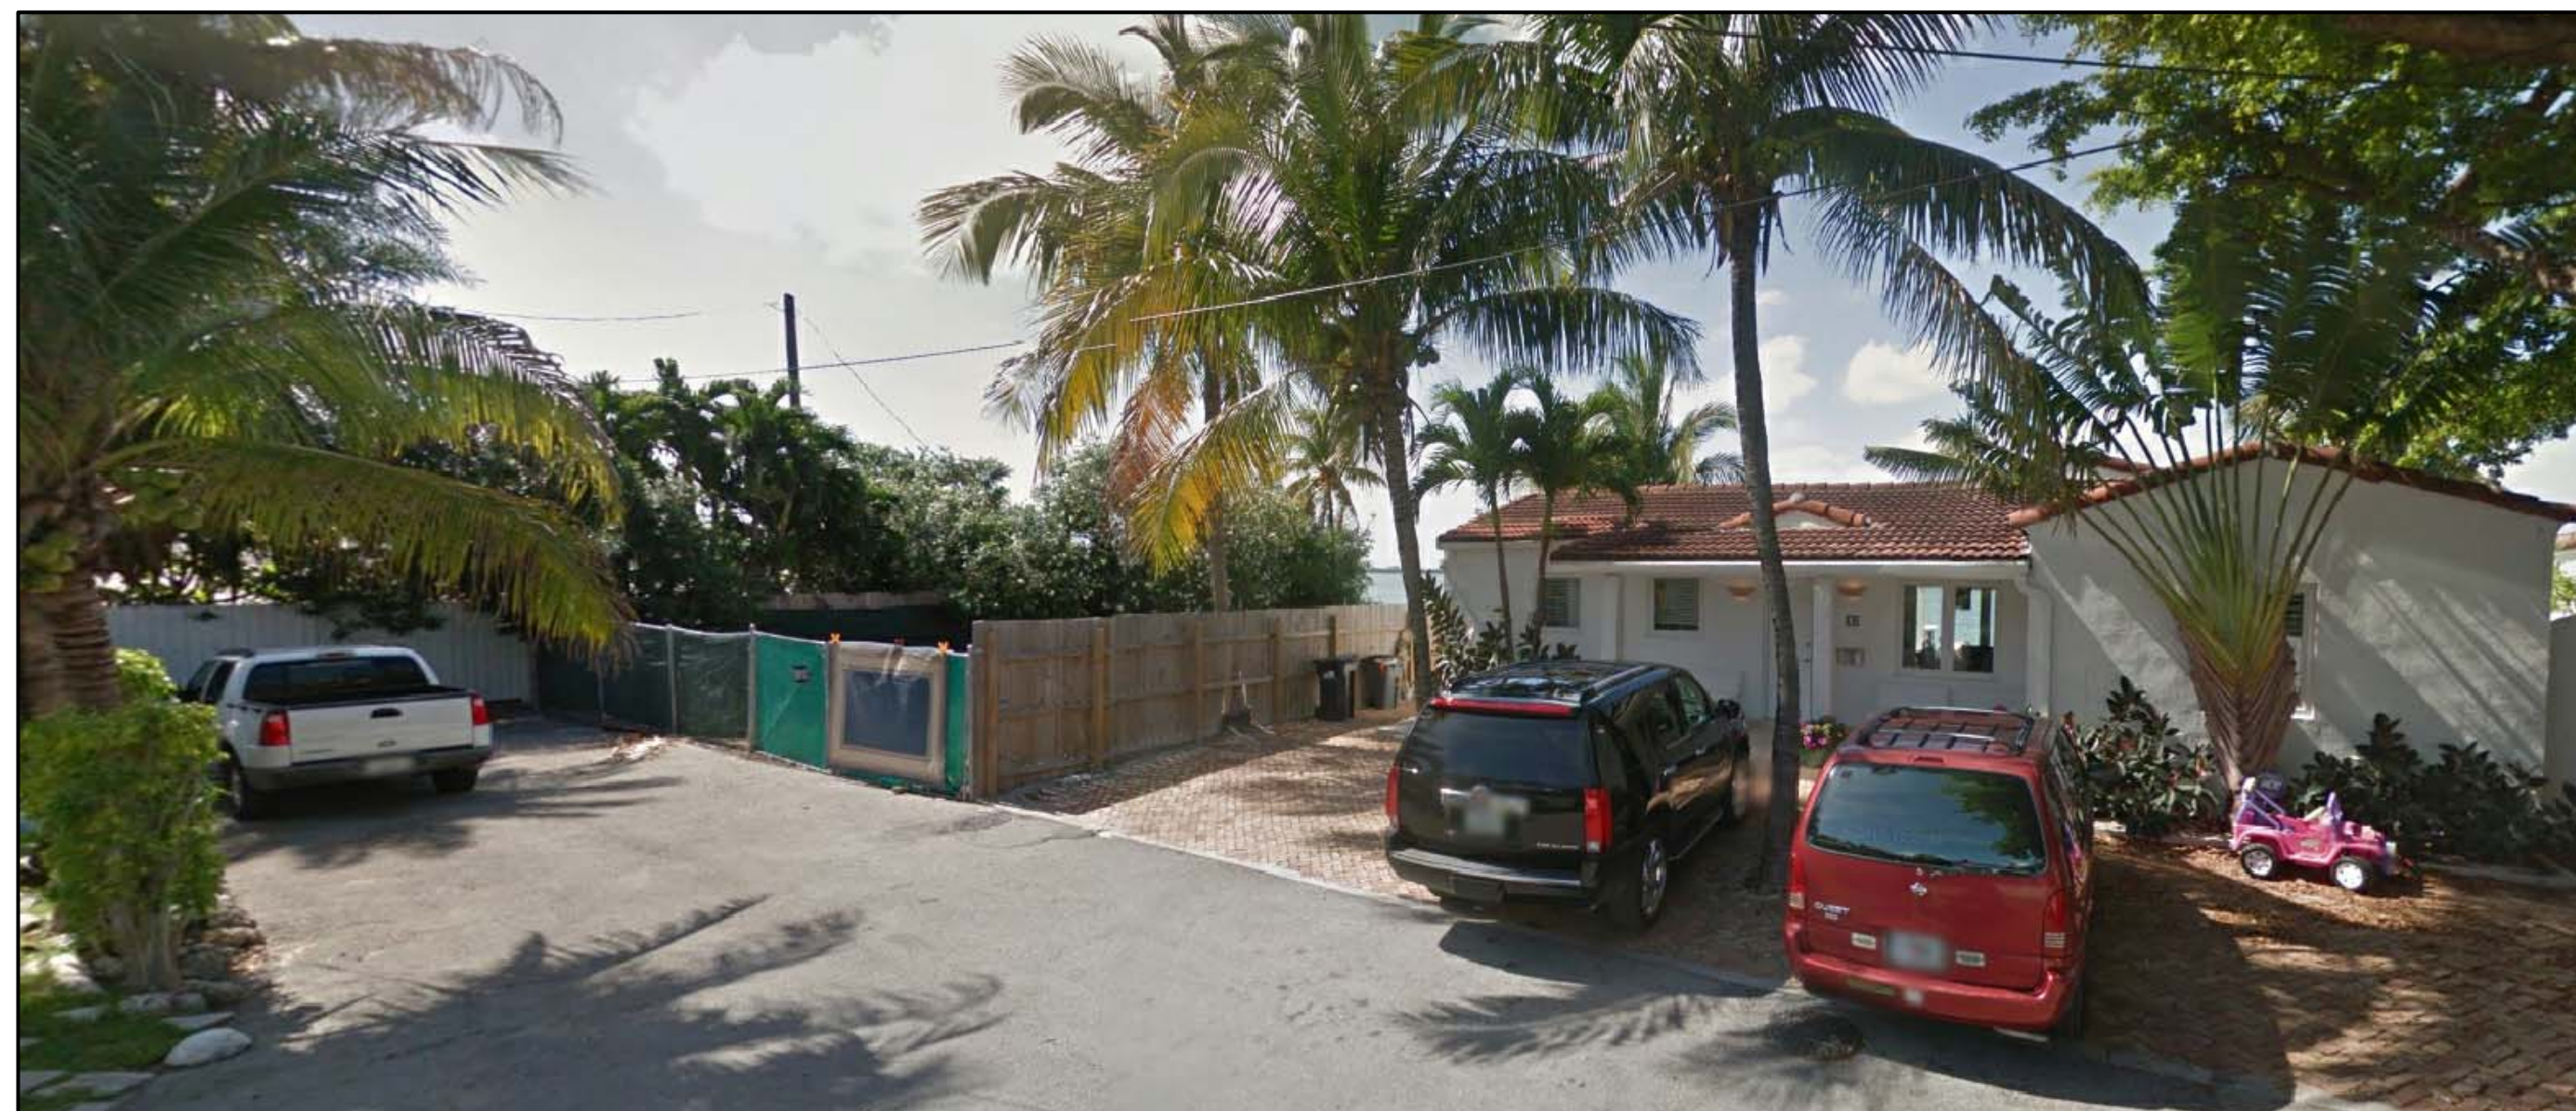

ARCHITECT:

TAI
TAI ARCHITECTURE, INC.
 278 NW 37th Street, Miami, FL 33127
 p: 305.576.7556 f: 305.576.5772

DO NOT SCALE DRAWING
THIS DRAWING IS THE PROPERTY OF TAI
ARCHITECTURE AND SHALL NOT BE REPRODUCED,
COPIED, LENT OR DISPOSED OF DIRECTLY OR
INDIRECTLY, NOR USED FOR ANY PURPOSE OTHER
THAN THAT FOR WHICH IT IS SPECIFICALLY
FURNISHED AND MUST BE RETURNED TO TAI
ARCHITECTURE ON COMPLETION OF WORK. IF

C	FINAL DRB SUBMITTAL	02.09.17		
	PRELIMINARY DRB SUBMITTAL	01.24.17		

SEAL

PROJECT NAME / ADDRESS:
PRIVATE RESIDENCE
8 FARREY LANE
MIAMI BEACH, FL 33139

DRAWING TITLE:


SITE PHOTOGRAPHS

PROJECT #: 16-M-04


FOR DBB

T-1.6


SHEET

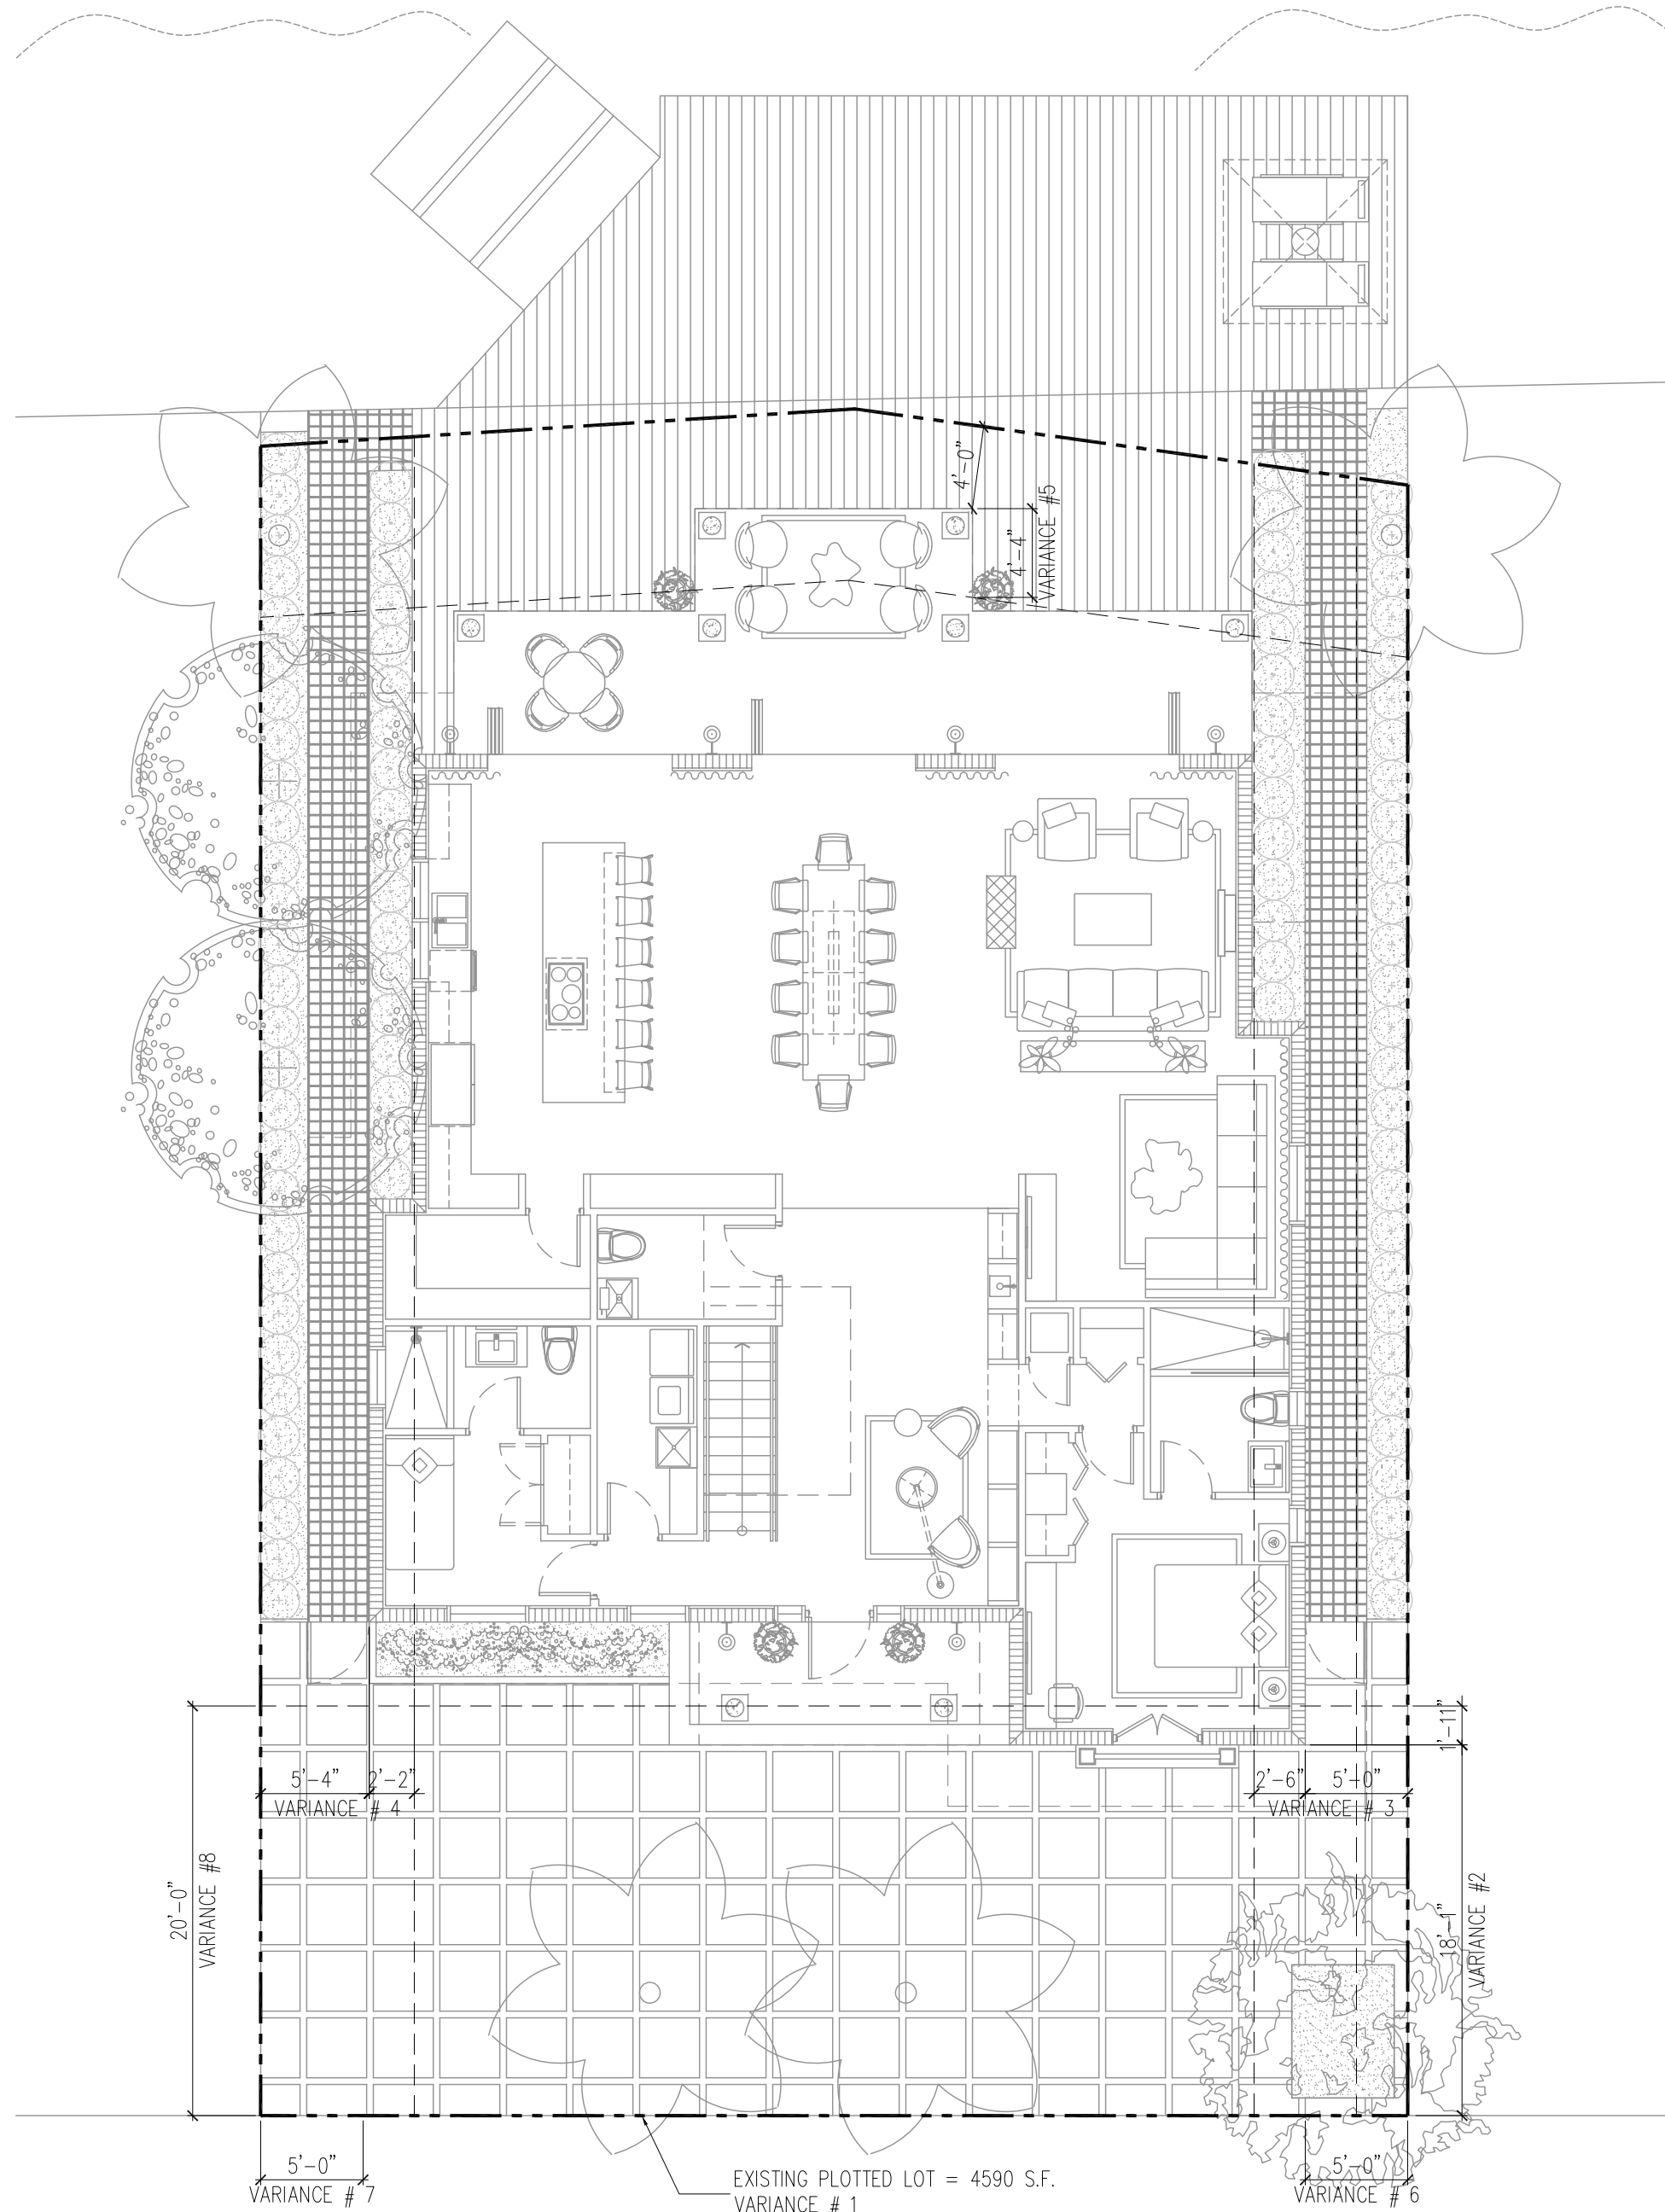

1 PROPOSED FIRST FLOOR PLAN (VARIANCES)
SCALE: 3/16"=1'-0"

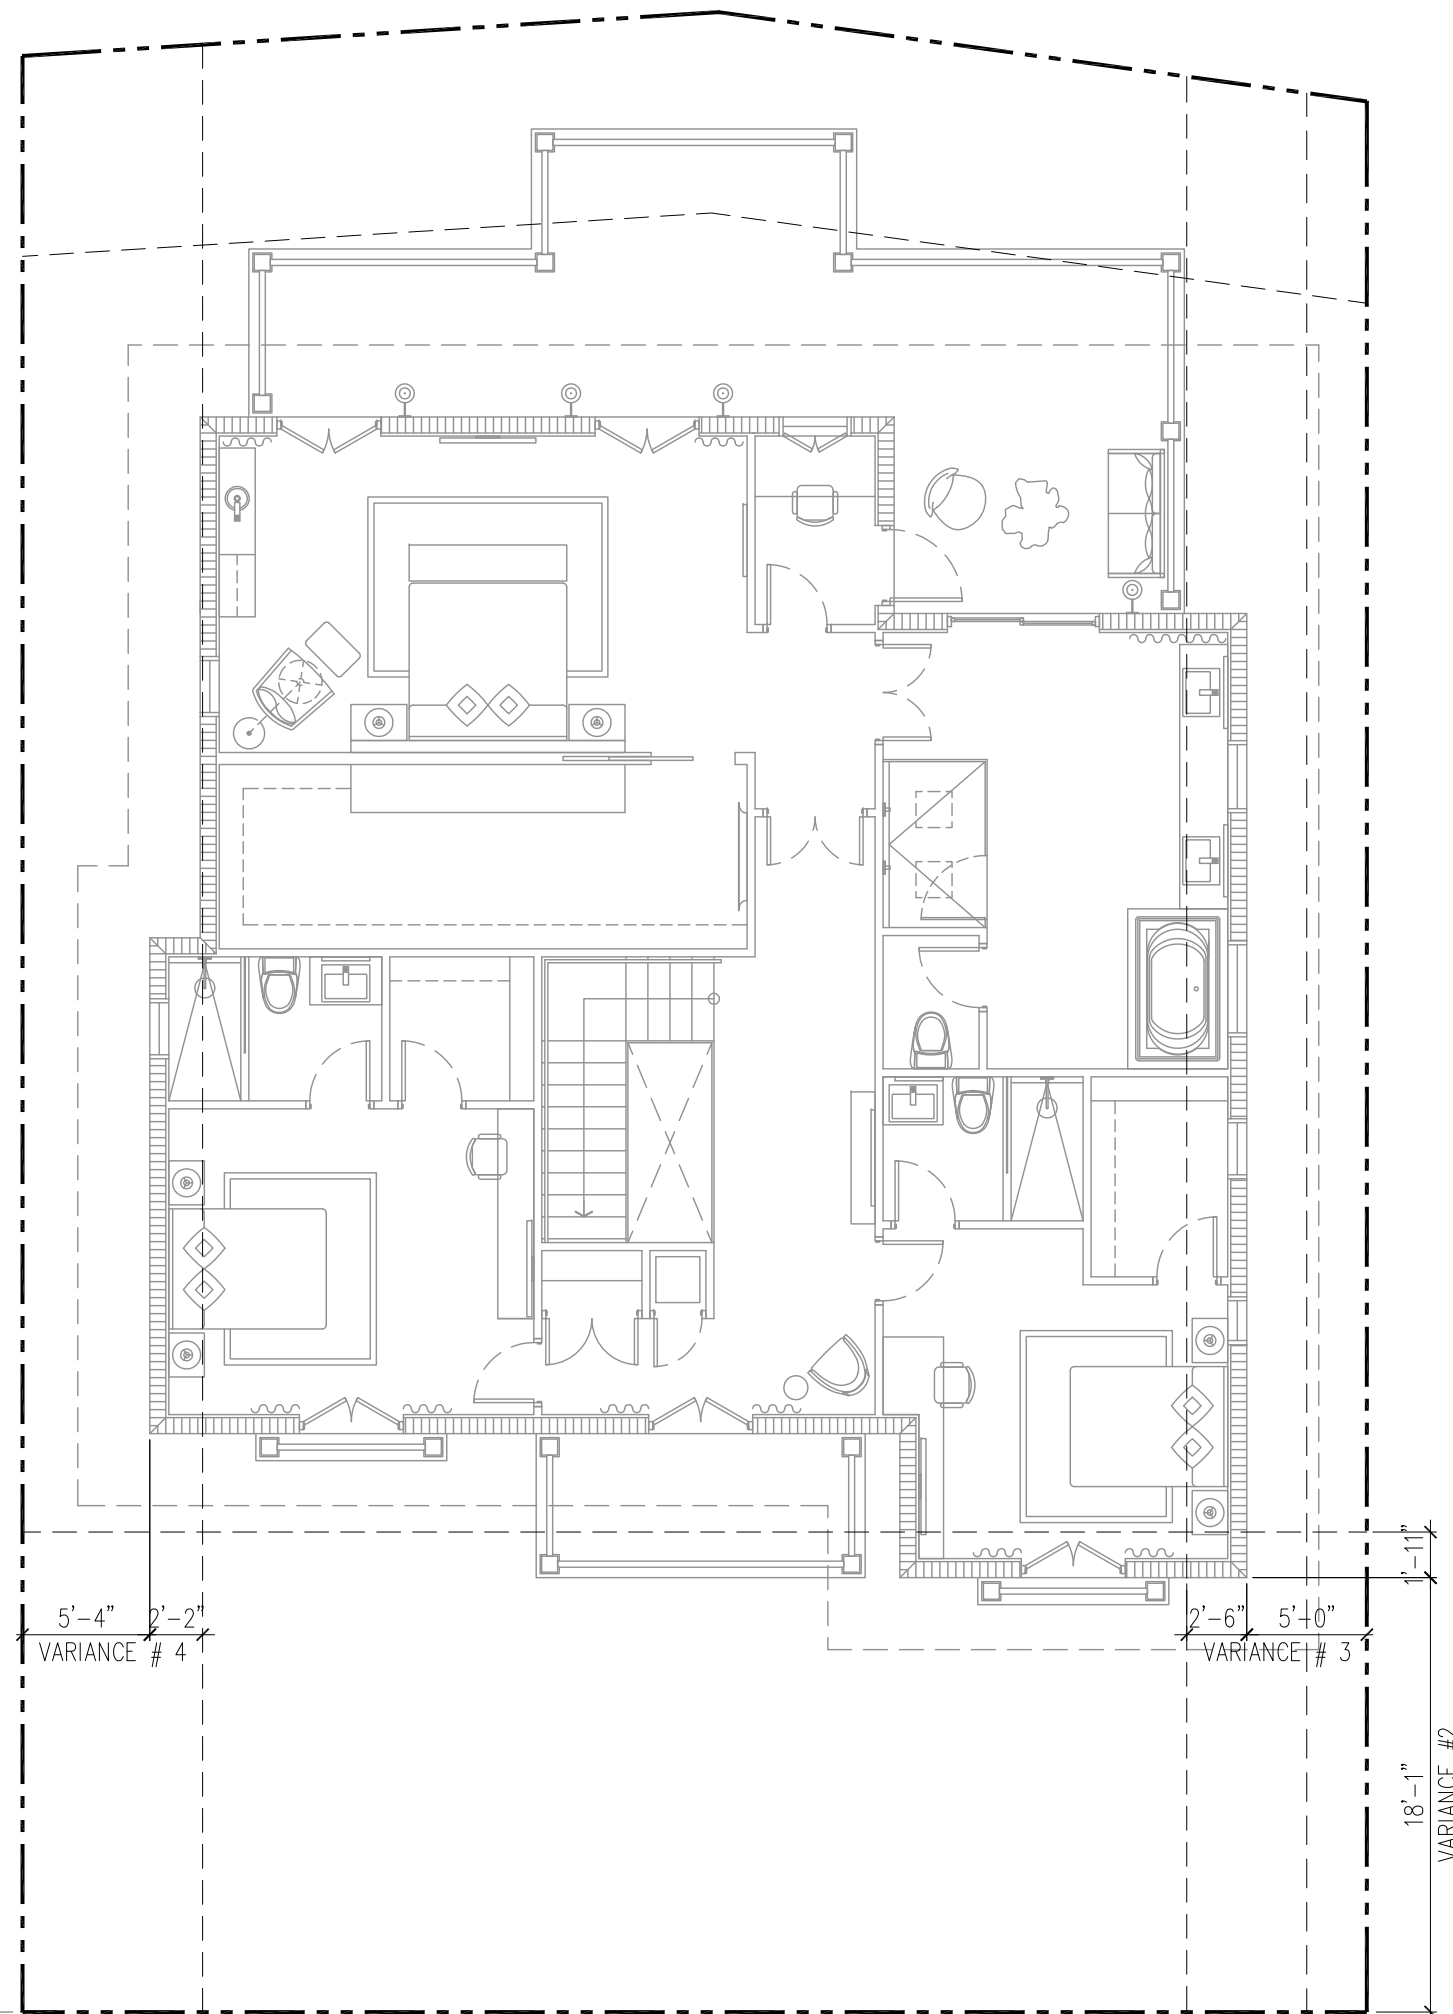

2 PROPOSED SECOND FLOOR PLAN (VARIANCES)
SCALE: 3/16"=1'-0"

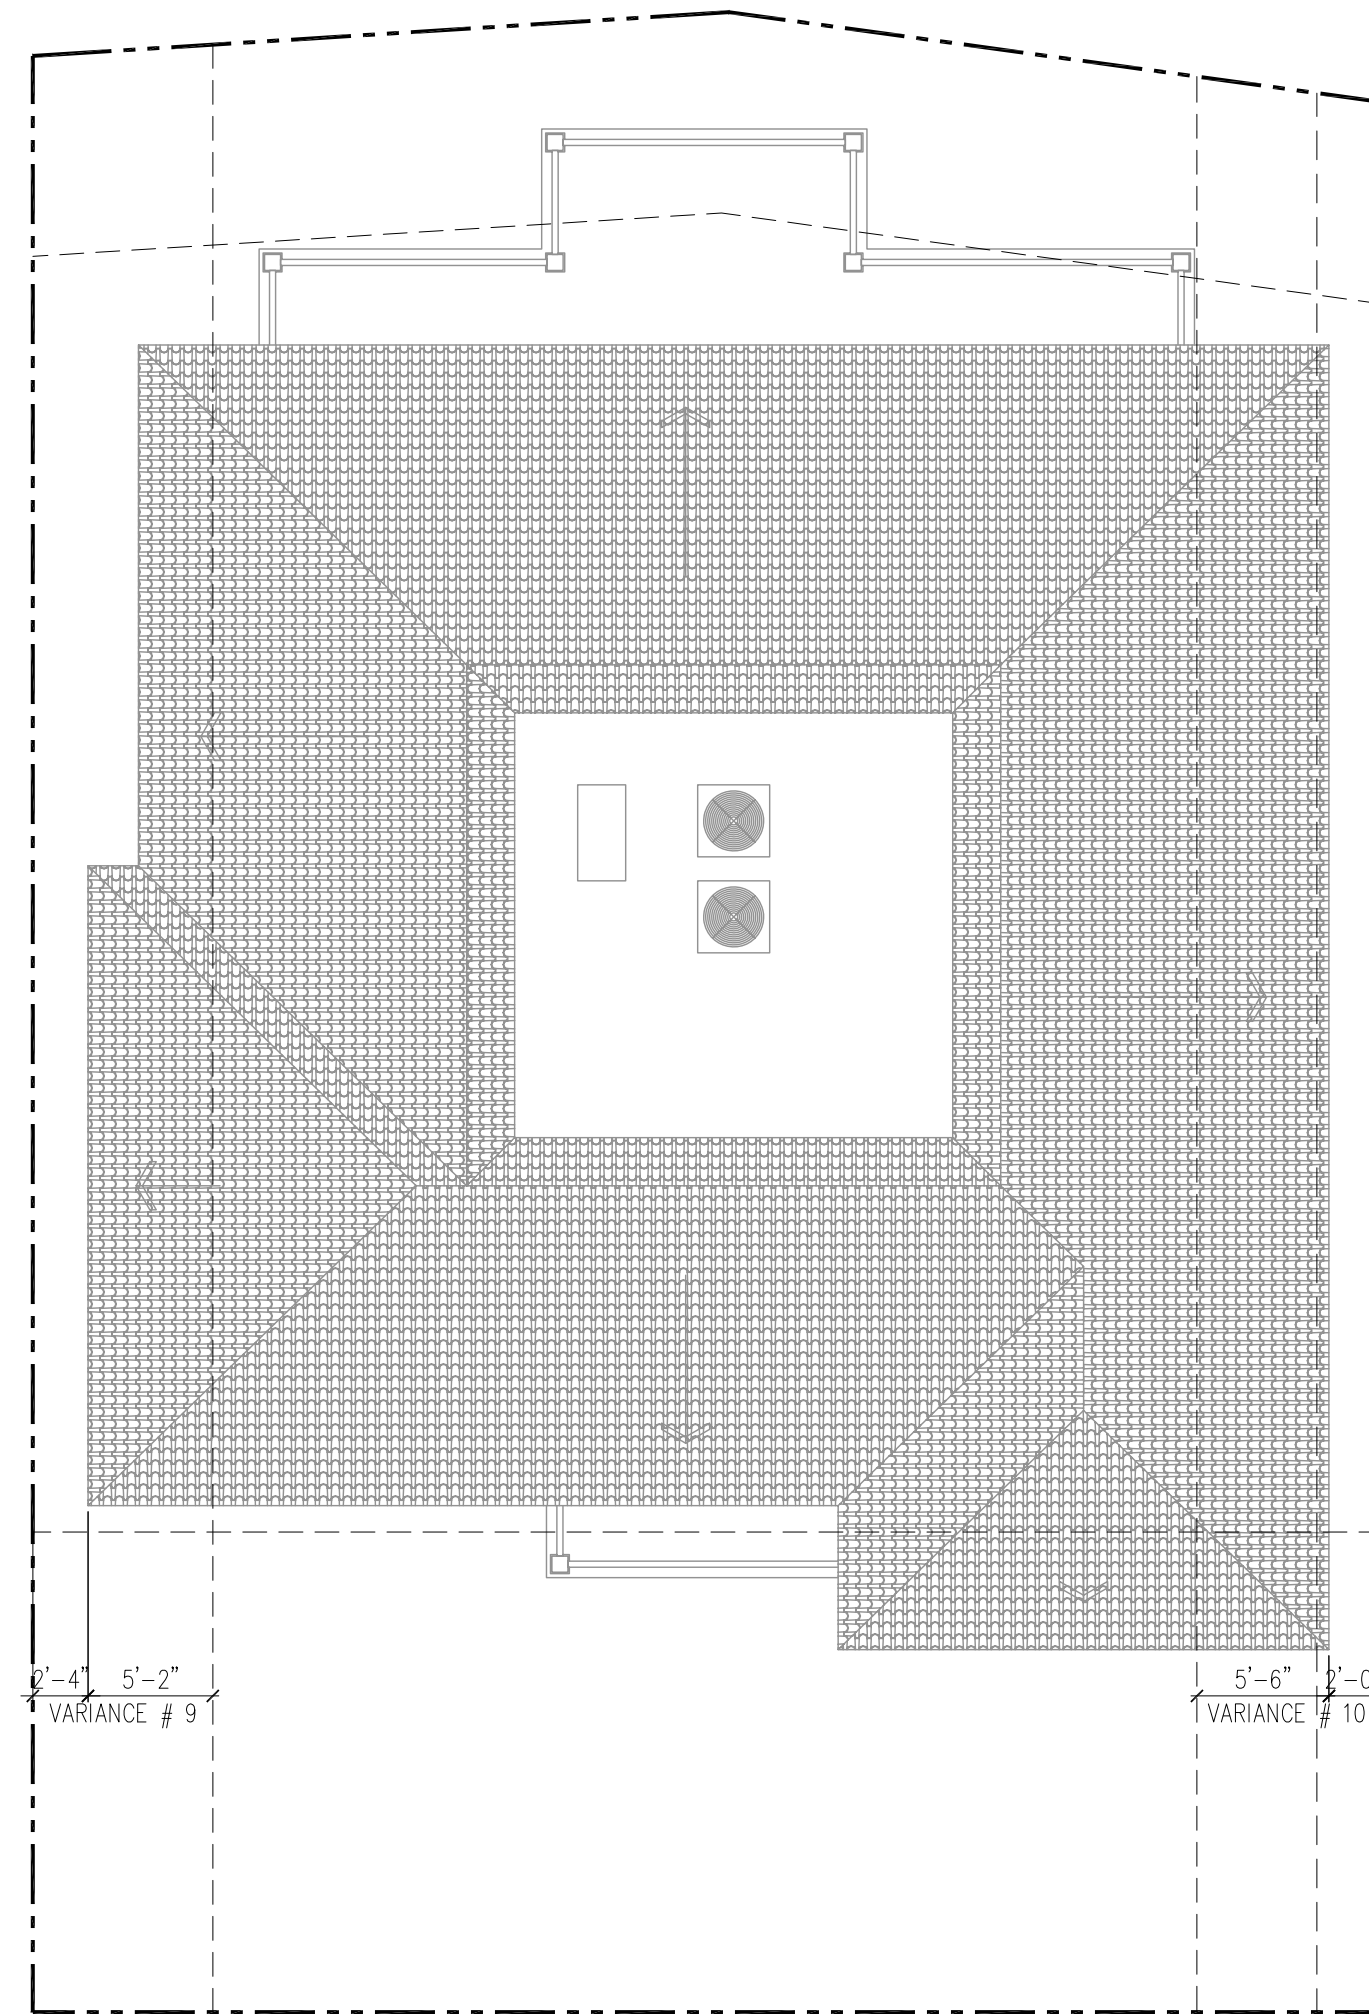

3 PROPOSED ROOF PLAN (VARIANCES)
SCALE: 3/16"=1'-0"

SEE SHEET T-1.1 FOR LIST OF VARIANCES

DRAWING TITLE:

**VARIANCES
FLOOR PLANS**

PROJECT #:
16-M-04

FOR DRB

PROJECT NAME / ADDRESS:

PRIVATE RESIDENCE
8 FARREY LANE
MIAMI BEACH, FL 33139

SEAL

DO NOT SCALE DRAWING

THIS DRAWING IS THE PROPERTY OF TAI
ARCHITECTURE AND SHALL NOT BE REPRODUCED,
COPIED, LENT OR DISPOSED OF DIRECTLY OR
INDIRECTLY FOR ANY PURPOSES OTHER
THAN THAT FOR WHICH IT IS SPECIFICALLY
FURNISHED AND MUST BE RETURNED TO TAI
ARCHITECTURE ON COMPLETION OF WORK IF
REQUESTED.


NO.

FINAL DRB SUBMITTAL
PRELIMINARY DRB SUBMITTAL

02.09.17
01.24.17

DATE

ARCHITECT:

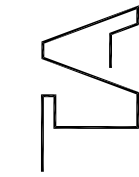

TAI ARCHITECTURE, INC.
279 NW 57th Street, Miami, FL 33127
p: 305.576.7556 f: 305.576.5772
e: michael@tdmiami.com license aa26001343

T-1.8

SHEET



1 PROPOSED SOUTH (FRONT) FACADE RENDERING

PROJECT NAME / ADDRESS:
PRIVATE RESIDENCE
8 FARREY LANE
MIAMI BEACH, FL 33139

**PROPOSED
RENDERING**

FOR DRB

16-M-04

R-1.0

SHEET

1
 2
 3
 525

DO NOT SCALE DRAWING
THIS DRAWING IS THE PROPERTY OF TAI
ARCHITECTURE AND SHALL NOT BE REPRODUCED,
COPIED, LENT OR DISPOSED OF DIRECTLY OR
INDIRECTLY, NOR USED FOR ANY PURPOSE OTHER
THAN THAT FOR WHICH IT IS SPECIFICALLY
FURNISHED AND MUST BE RETURNED TO TAI
ARCHITECTURE ON COMPLETION OF WORK, IF
REQUESTED.

		FINAL DRB SUBMITTAL	02.09.17
		PRELIMINARY DRB SUBMITTAL	01.24.17
no.		REVISIONS/SUBMISSIONS	date

REAL

TAI ARCHITECTURE, INC.
278 NW 37th Street, Miami, FL 33127
p: 305.576.7556 f: 305.576.5772
e: michael@tdmiami.com license aa26001343

COPYRIGHT © 2016
ARE HEREBY SPECIFICALLY RESERVED.

COPYRIGHT BY TAI ARCHITECTURE AND DESIGN, INC. AND FFD PRODUCT INC. THIS DRAWING SET IS GIVEN IN CONFIDENCE. NO USE OR DISSEMINATION MAY BE MADE WITHOUT PRIOR WRITTEN CONSENT OF TAI ARCHITECTURE OR FFD PRODUCT. ALL COMMON LAW RIGHTS OF COPYRIGHT AND OTHER WISE ARE HEREBY SPECIFICALLY RESERVED.



1 PROPOSED NORTH (REAR) FACADE RENDERING

ARCHITECT:

DO NOT SCALE DRAWING
THIS DRAWING IS THE PROPERTY OF TAI
ARCHITECTURE AND SHALL NOT BE REPRODUCED,
COPIED, LENT OR DISPOSED OF DIRECTLY OR
INDIRECTLY, NOR USED FOR ANY PURPOSE OTHER
THAN THAT FOR WHICH IT IS SPECIFICALLY
FURNISHED AND MUST BE RETURNED TO TAI
ARCHITECTURE ON COMPLETION OF WORK, IF
REQUESTED.

[illegible]

SEAL

PROJECT NAME / ADDRESS:
PRIVATE RESIDENCE
8 FARREY LANE
MIAMI BEACH, FL 33139

**PROPOSED
RENDERING**

DRAWING TITLE: **PRI**

PROJECT #: **16-M-04**

R-1.1

SHEET

COPYRIGHT © 2016

COPYRIGHT BY TAI ARCHITECTURE AND DESIGN, INC. AND FFD PRODUCT INC. THIS DRAWING SET IS GIVEN IN CONFIDENCE. NO USE OR DISSEMINATION MAY BE MADE WITHOUT PRIOR WRITTEN CONSENT OF TAI ARCHITECTURE OR FFD PRODUCT. ALL COMMON LAW RIGHTS OF COPYRIGHT AND OTHER WISE ARE HEREBY SPECIFICALLY RESERVED.



1

PROPOSED SOUTH (REAR) FACADE RENDERING W/ SITE CONTEXT

DRAWING TITLE:

**PROPOSED
RENDERING**

PROJECT #:
16-M-0

FOR BB

PRIVATE RESIDENCE
8 FARREY LANE
MIAMI BEACH, FL 33139

SEAL

ARCHITECT:

TAI
TAI ARCHITECTURE, INC.
 278 NW 37th Street, Miami, FL 33127
 p: 305.576.7556 f: 305.576.5772

DO NOT SCALE DRAWING
THIS DRAWING IS THE PROPERTY OF TAI
ARCHITECTURE AND SHALL NOT BE REPRODUCED,
COPIED, LENT OR DISPOSED OF DIRECTLY OR
INDIRECTLY, NOR USED FOR ANY PURPOSE OTHER
THAN THAT FOR WHICH IT IS SPECIFICALLY
FURNISHED AND MUST BE RETURNED TO TAI
ARCHITECTURE ON COMPLETION OF WORK, IF
REQUESTED.

[illegible]


COPYRIGHT © 2016

COPYRIGHT BY TAI ARCHITECTURE AND DESIGN, INC. AND FFD PRODUCT INC. THIS DRAWING SET IS GIVEN IN CONFIDENCE. NO USE OR DISSEMINATION MAY BE MADE WITHOUT PRIOR WRITTEN CONSENT OF TAI ARCHITECTURE OR FFD PRODUCT. ALL COMMON LAW RIGHTS OF COPYRIGHT AND OTHER WISE ARE HEREBY SPECIFICALLY RESERVED.


- DIMENSIONS SHOWN ARE NOMINAL
ACTUAL DIMENSIONS MAY VARY

	EXISTING GYPSUM BOARD WALL TO REMAIN
	EXISTING CONCRETE WALL / COLUMN TO REMAIN
	EXISTING CMU WALL TO REMAIN
	EXISTING WALL TO BE DEMOLISHED

1. EXISTING DOOR TO BE REMOVED
2. EXISTING WINDOW TO BE REMOVED
3. EXISTING BATHROOM MILLWORK TO BE DEMOLISHED. PLUMBING FIXTURE TO BE REMOVED & STORED
4. EXISTING KITCHEN MILLWORK TO BE DEMOLISHED. APPLIANCES & FIXTURES TO BE STORED
5. EXISTING APPLIANCES TO BE REMOVED & STORED
6. EXISTING SHOWER TO BE DEMOLISHED
7. EXTERIOR STORAGE TO BE DEMOLISHED
8. EXISTING GENERATOR TO BE REMOVED AND STORED
9. EXISTING A/C CONDENSING UNIT TO BE REMOVED AND STORED
10. EXISTING WATER HEATER TO BE REMOVED AND STORED
11. EXISTING WOOD DOCK TO REMAIN
12. EXISTING GATE TO BE DEMOLISHED
13. EXISTING SUPPORT COLUMN TO BE DEMOLISHED
14. EXISTING TILES / PAVERS TO BE REMOVED
15. EXISTING COCONUT PALM TO REMAIN
16. EXISTING BLACK OLIVE TREE TO REMAIN
17. EXISTING BOAT LIFT TO REMAIN

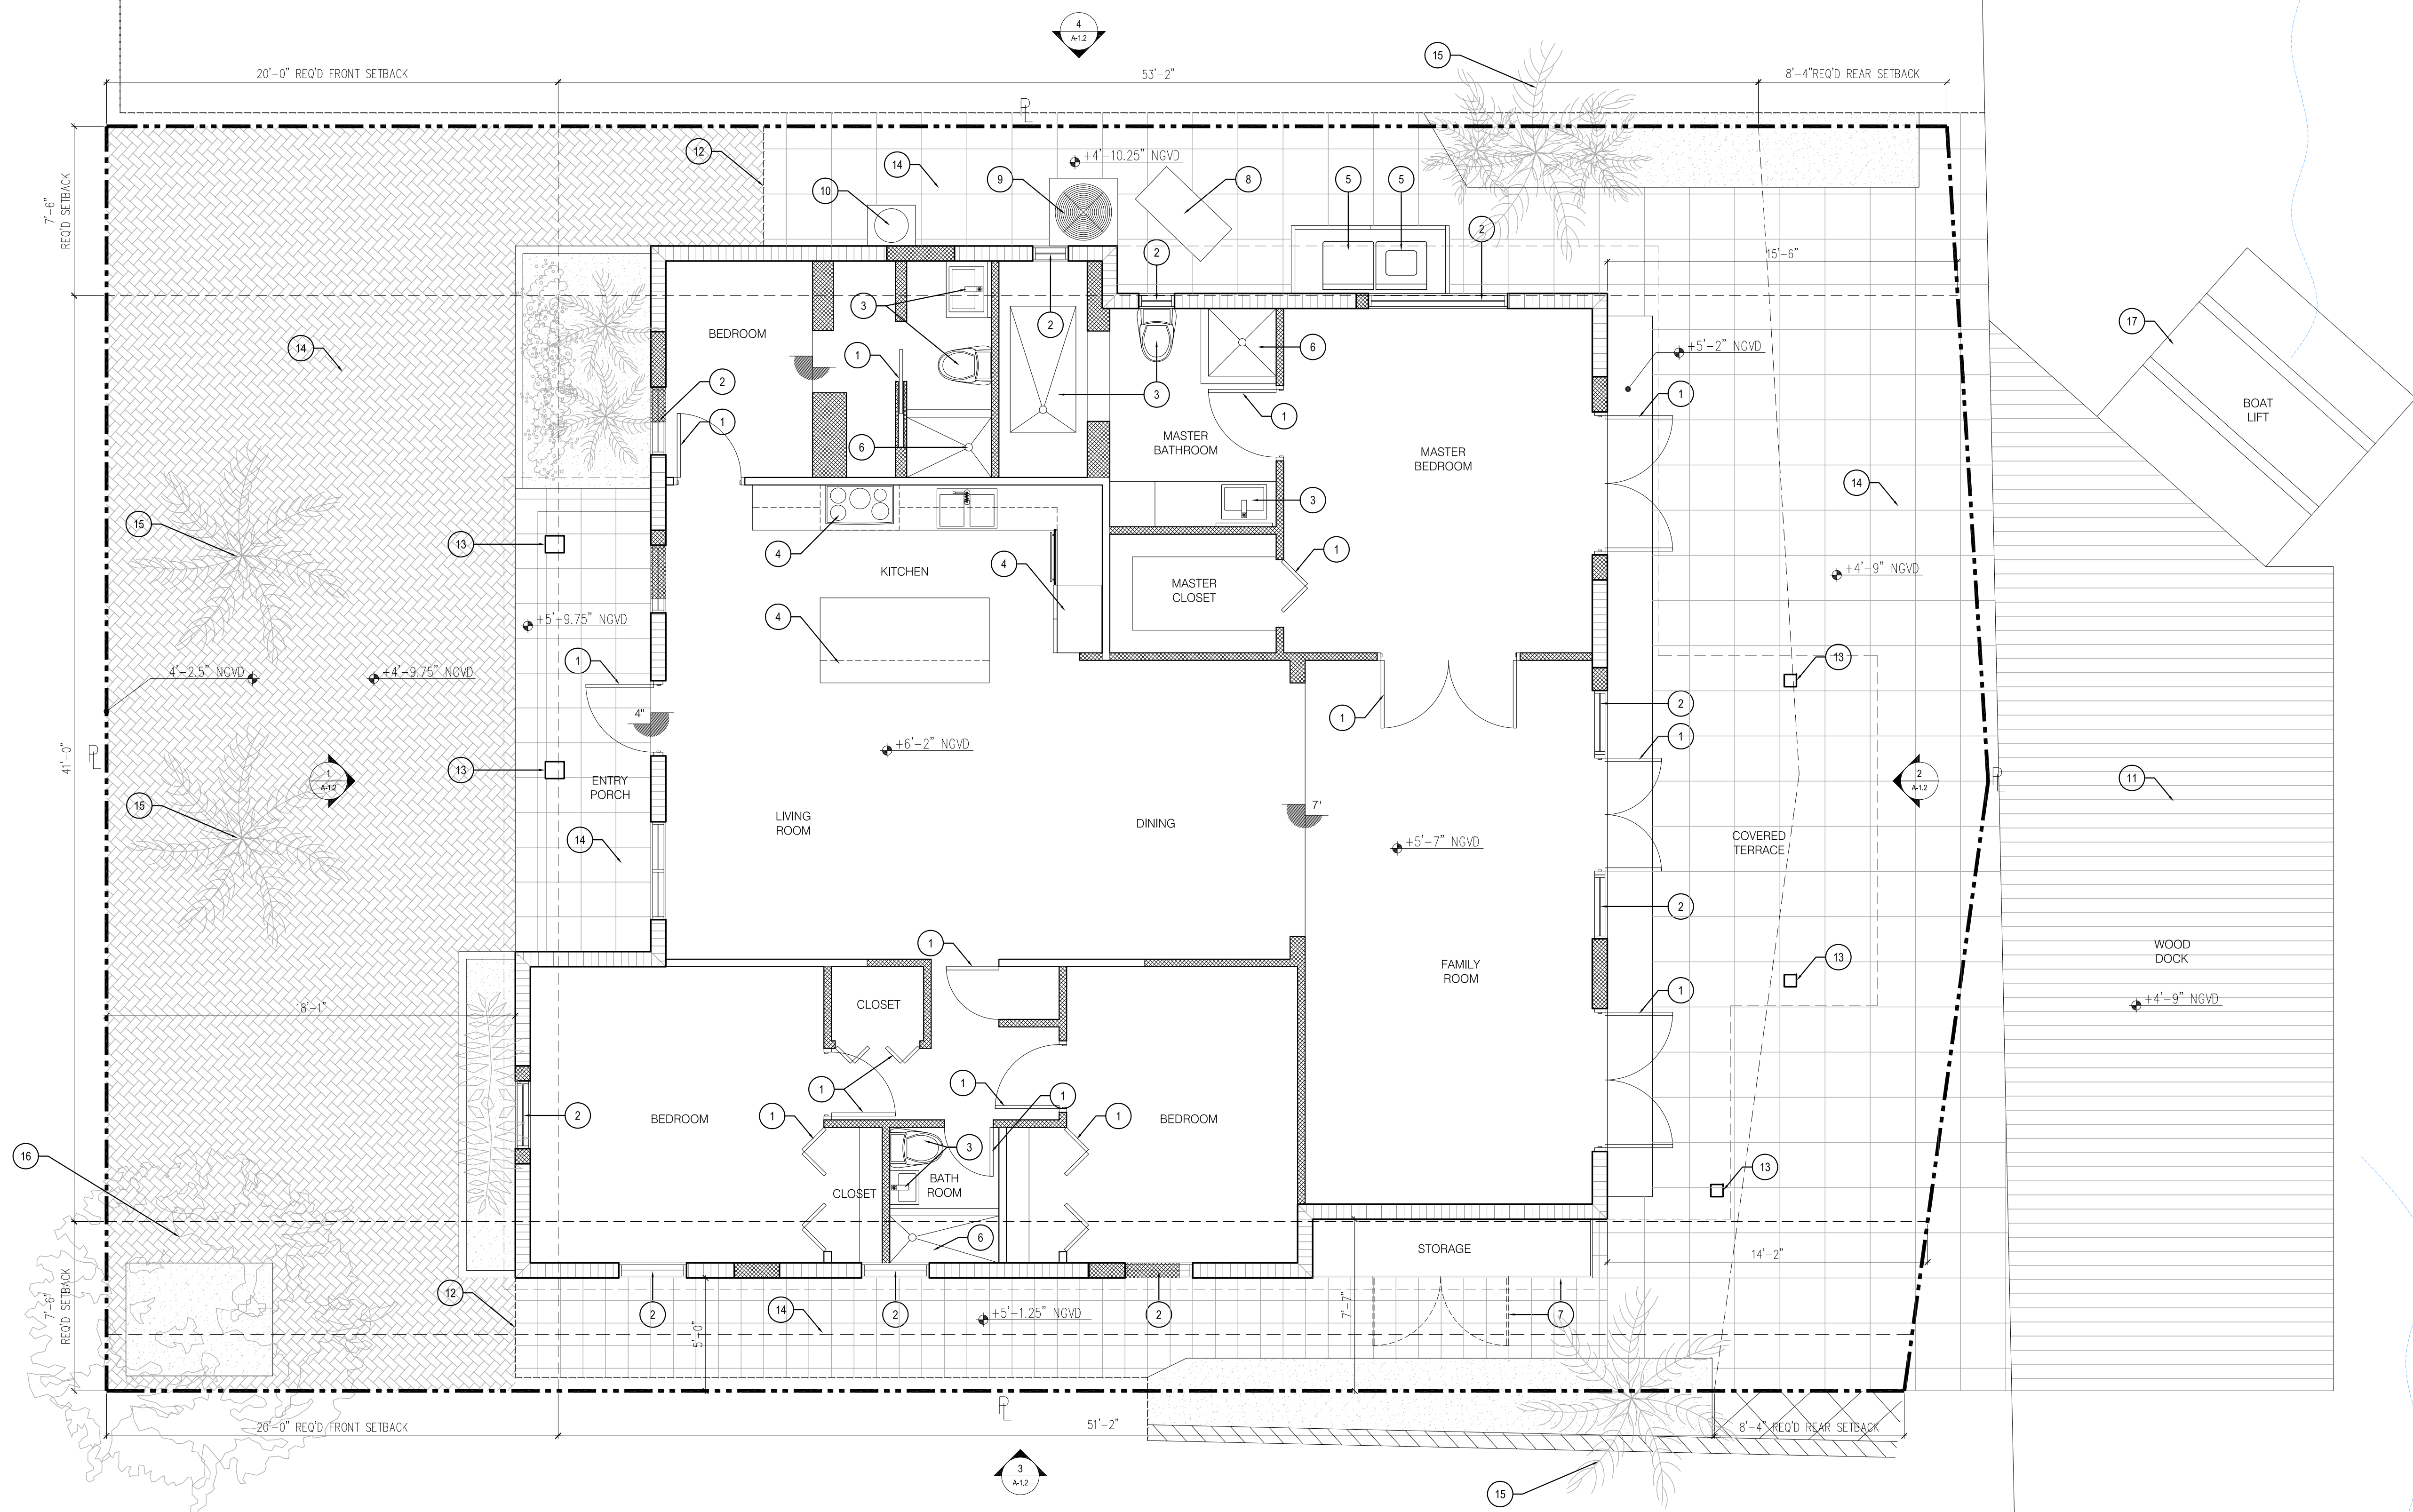

1 EXISTING FLOOR PLAN
SCALE: 1/4"=1'-0"

 

ARCHITECT:

DO NOT SCALE DRAWING
THIS DRAWING IS THE PROPERTY OF TAI
ARCHITECTURE AND SHALL NOT BE REPRODUCED,
COPIED, LENT OR DISPOSED OF DIRECTLY OR
INDIRECTLY, NOR USED FOR ANY PURPOSE OTHER
THAN THAT FOR WHICH IT IS SPECIFICALLY
FURNISHED AND MUST BE RETURNED TO TAI
ARCHITECTURE ON COMPLETION OF WORK, IF
REQUESTED.

[illegible]

SEAL

PROJECT NAME / ADDRESS:
PRIVATE RESIDENCE
8 FARREY LANE
MIAMI BEACH, FL 33139

DRAWING TITLE:

WING TITLE:
**EXISTING & DEMOLITION
FLOOR PLAN**

PROJECT #:
16-M-04

FOR DB

A-1.0

SHEET

COPYRIGHT © 2016

COPYRIGHT BY TAI ARCHITECTURE AND DESIGN, INC. AND FFD PRODUCT INC. THIS DRAWING SET IS GIVEN IN CONFIDENCE. NO USE OR DISSEMINATION MAY BE MADE WITHOUT PRIOR WRITTEN CONSENT OF TAI ARCHITECTURE OR FFD PRODUCT. ALL COMMON LAW RIGHTS OF COPYRIGHT AND OTHERWISE ARE HEREBY SPECIFICALLY RESERVED.

GENERAL NOTES:


- DIMENSIONS SHOWN ARE NOMINAL. ACTUAL DIMENSIONS MAY VARY

EXISTING WALL LEGEND

- EXISTING GYPSUM BOARD WALL TO REMAIN
- EXISTING CONCRETE WALL / COLUMN TO REMAIN
- EXISTING CMU WALL TO REMAIN
- EXISTING WALL TO BE DEMOLISHED

EXISTING / DEMOLITION NOTES:

- EXISTING DOOR TO BE REMOVED
- EXISTING WINDOW TO BE REMOVED
- EXISTING BATHROOM MILLWORK TO BE DEMOLISHED. PLUMBING FIXTURE TO BE REMOVED & STORED
- EXISTING KITCHEN MILLWORK TO BE DEMOLISHED. APPLIANCES & FIXTURES TO BE STORED
- EXISTING APPLIANCES TO BE REMOVED & STORED
- EXISTING SHOWER TO BE DEMOLISHED
- EXTERIOR STORAGE TO BE DEMOLISHED
- EXISTING GENERATOR TO BE REMOVED AND STORED
- EXISTING A/C CONDENSING UNIT TO BE REMOVED AND STORED
- EXISTING WATER HEATER TO BE REMOVED AND STORED
- EXISTING WOOD DOCK TO REMAIN
- EXISTING GATE TO BE DEMOLISHED
- EXISTING SUPPORT COLUMN TO BE DEMOLISHED
- EXISTING TILES / PAVERS TO BE REMOVED
- EXISTING COCONUT PALM TO REMAIN
- EXISTING BLACK OLIVE TREE TO REMAIN
- EXISTING BOAT LIFT TO REMAIN

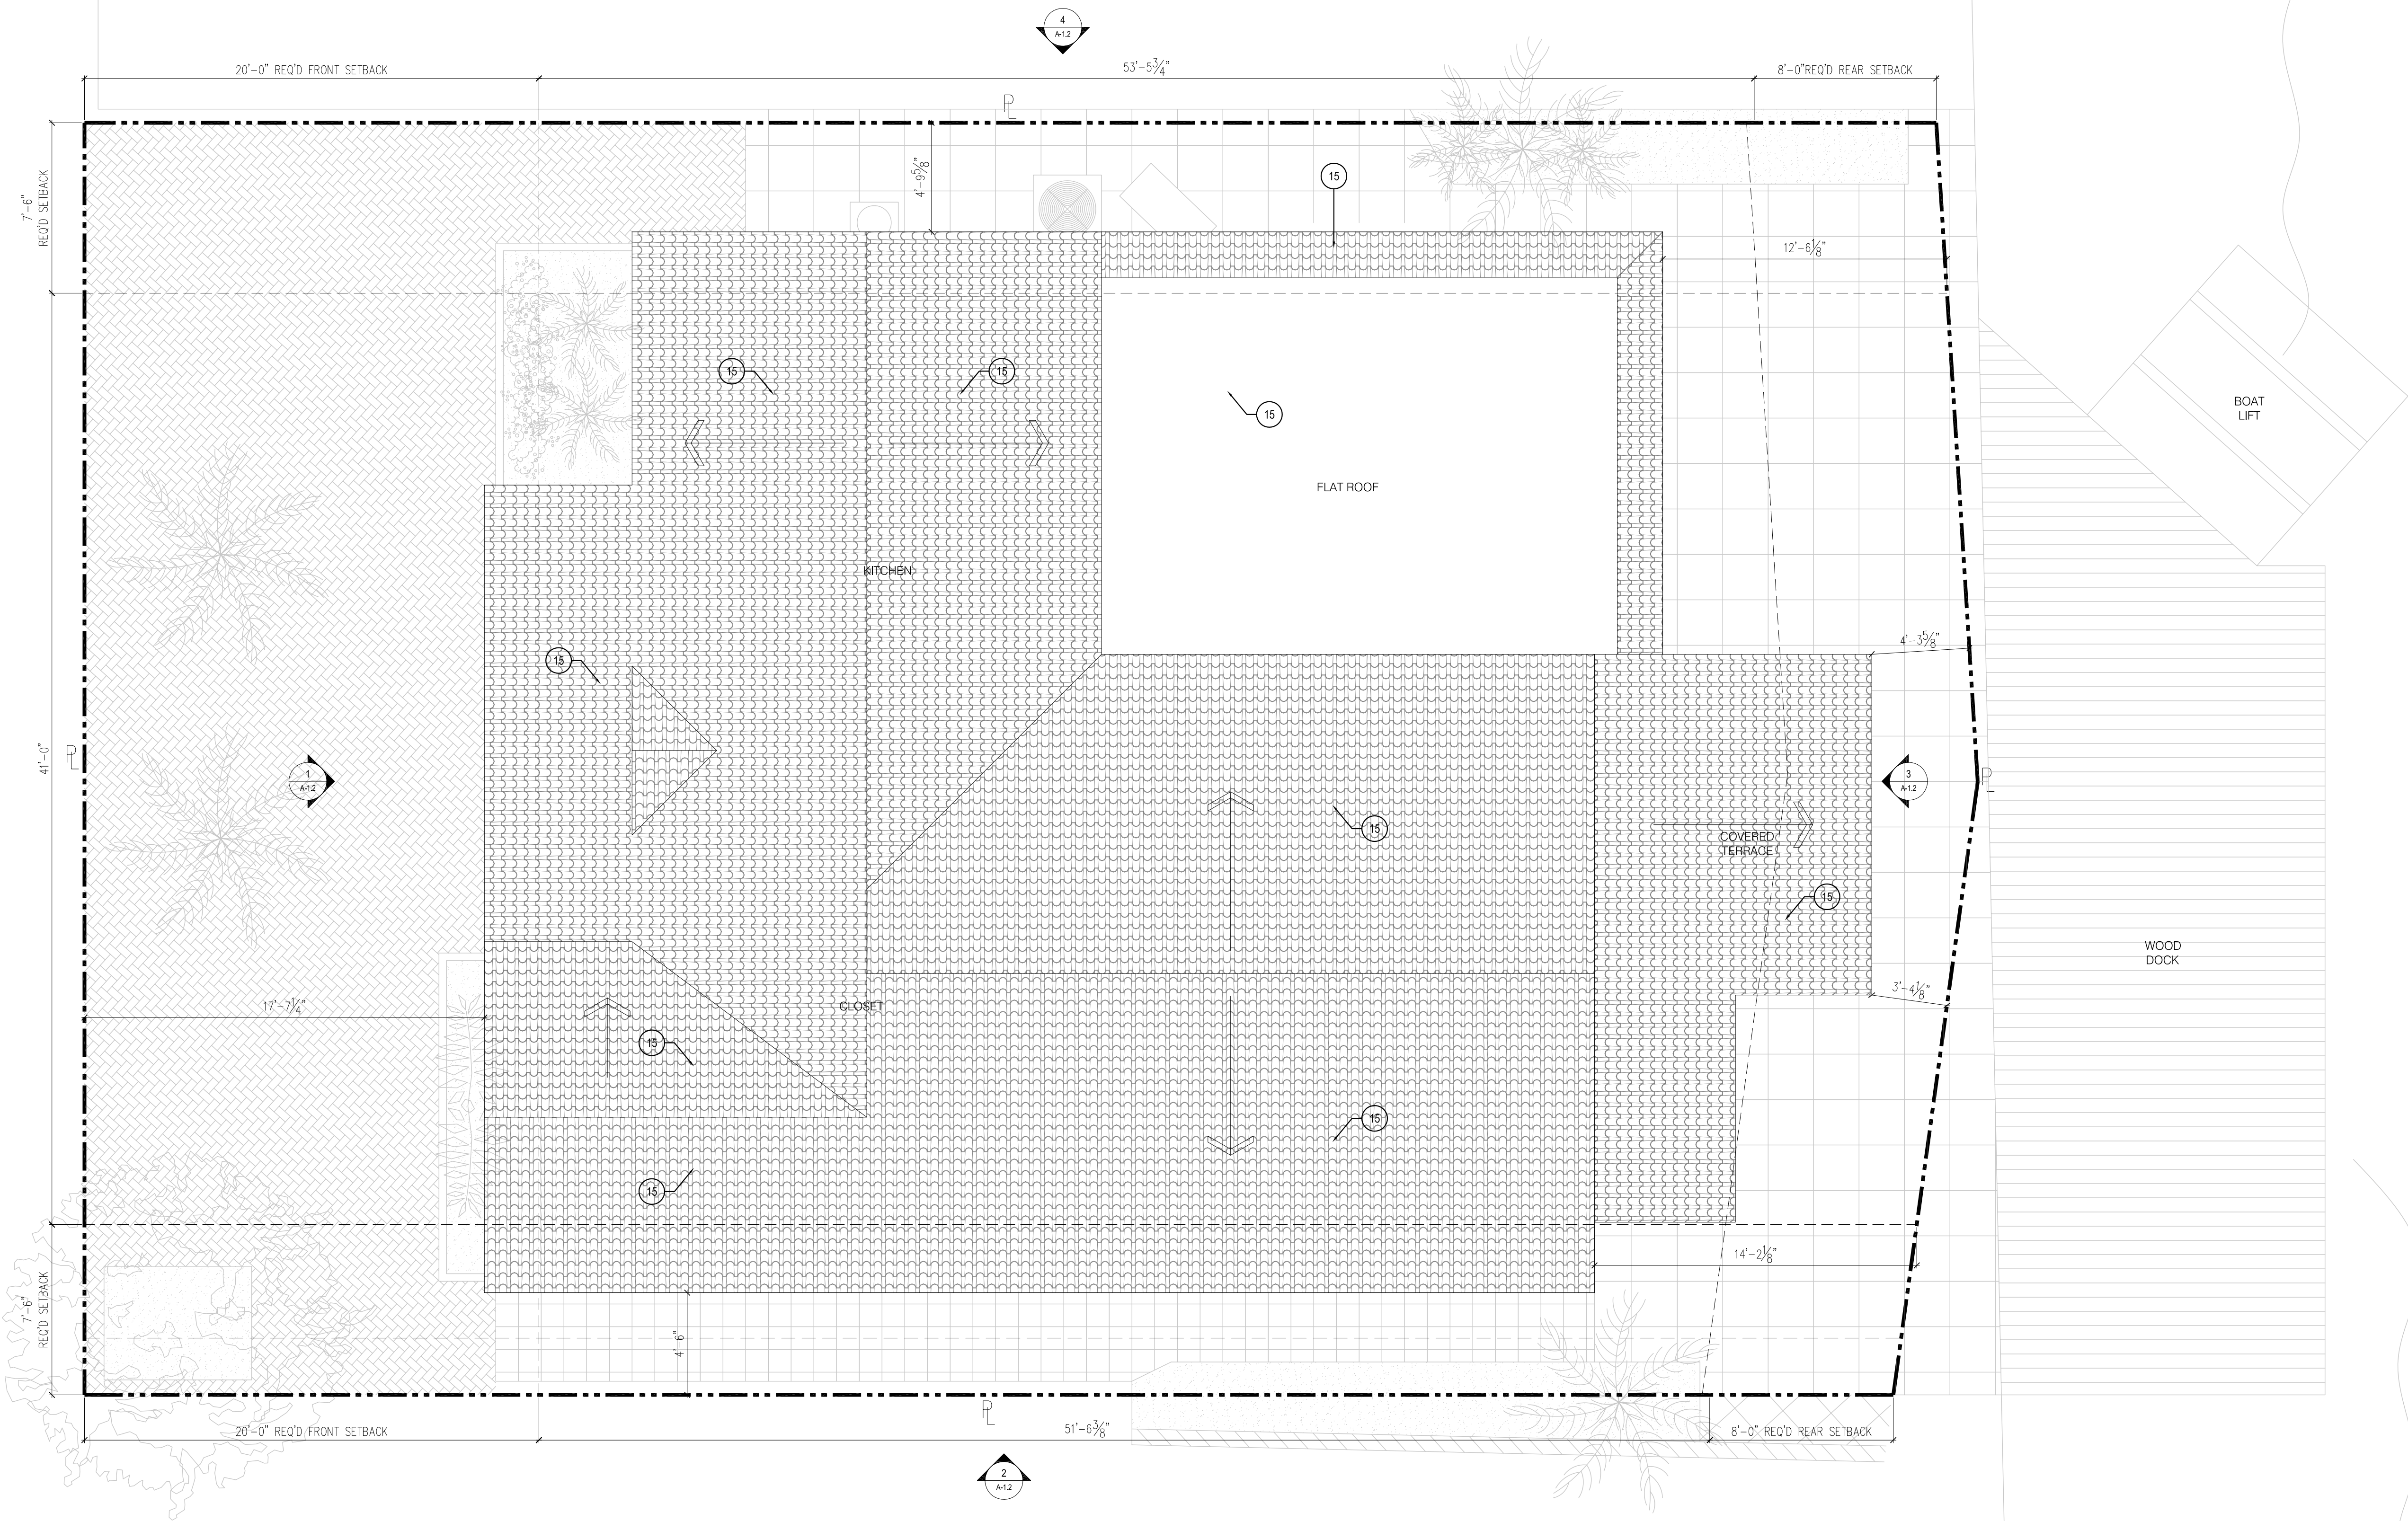

1 EXISTING & DEMOLITION ROOF PLAN
SCALE: 1/4"=1'-0"

ARCHITECT:

TAI ARCHITECTURE, INC.
278 NW 57th Street, Miami, FL 33127
p: 305.576.7556 f: 305.576.5772
e: michael@tdmiami.com license aa26001343

DO NOT SCALE DRAWING
THIS DRAWING IS THE PROPERTY OF TAI ARCHITECTURE AND SHALL NOT BE REPRODUCED, COPIED, LENT OR DISPOSED OF DIRECTLY OR INDIRECTLY WITHOUT THE WRITTEN CONSENT OF TAI ARCHITECTURE. ANY REUSE OR MISUSE OF THIS DRAWING WITHOUT THE WRITTEN CONSENT OF TAI ARCHITECTURE SHALL BE AT THE USER'S RISK AND WITHOUT LIABILITY TO TAI ARCHITECTURE. THIS DRAWING IS NOT TO BE USED FOR ANY OTHER PURPOSES WITHOUT THE WRITTEN CONSENT OF TAI ARCHITECTURE. THIS DRAWING IS NOT TO BE USED FOR ANY OTHER PURPOSES WITHOUT THE WRITTEN CONSENT OF TAI ARCHITECTURE. THIS DRAWING IS NOT TO BE USED FOR ANY OTHER PURPOSES WITHOUT THE WRITTEN CONSENT OF TAI ARCHITECTURE.

NO.	REVISIONS/SUBMISSIONS	DATE
01	PRELIMINARY	02.09.17
02	DRB SUBMITTAL	01.24.17
03	DRB SUBMITTAL	01.24.17
04	DRB SUBMITTAL	01.24.17

SEAL

PROJECT NAME / ADDRESS:
PRIVATE RESIDENCE
8 FARREY LANE
MIAMI BEACH, FL 33139

DRAWING TITLE:
EXISTING & DEMOLITION
ROOF PLAN

FOR DRB


PROJECT #:
16-M-04

A-1.1


SHEET

COPYRIGHT © 2016

COPYRIGHT BY TAI ARCHITECTURE AND DESIGN, INC. AND FFD PRODUCT INC. THIS DRAWING SET IS GIVEN IN CONFIDENCE. NO USE OR DISSEMINATION MAY BE MADE WITHOUT PRIOR WRITTEN CONSENT OF TAI ARCHITECTURE OR FFD PRODUCT. ALL COMMON LAW RIGHTS OF COPYRIGHT AND OTHER WISE ARE HEREBY SPECIFICALLY RESERVED.

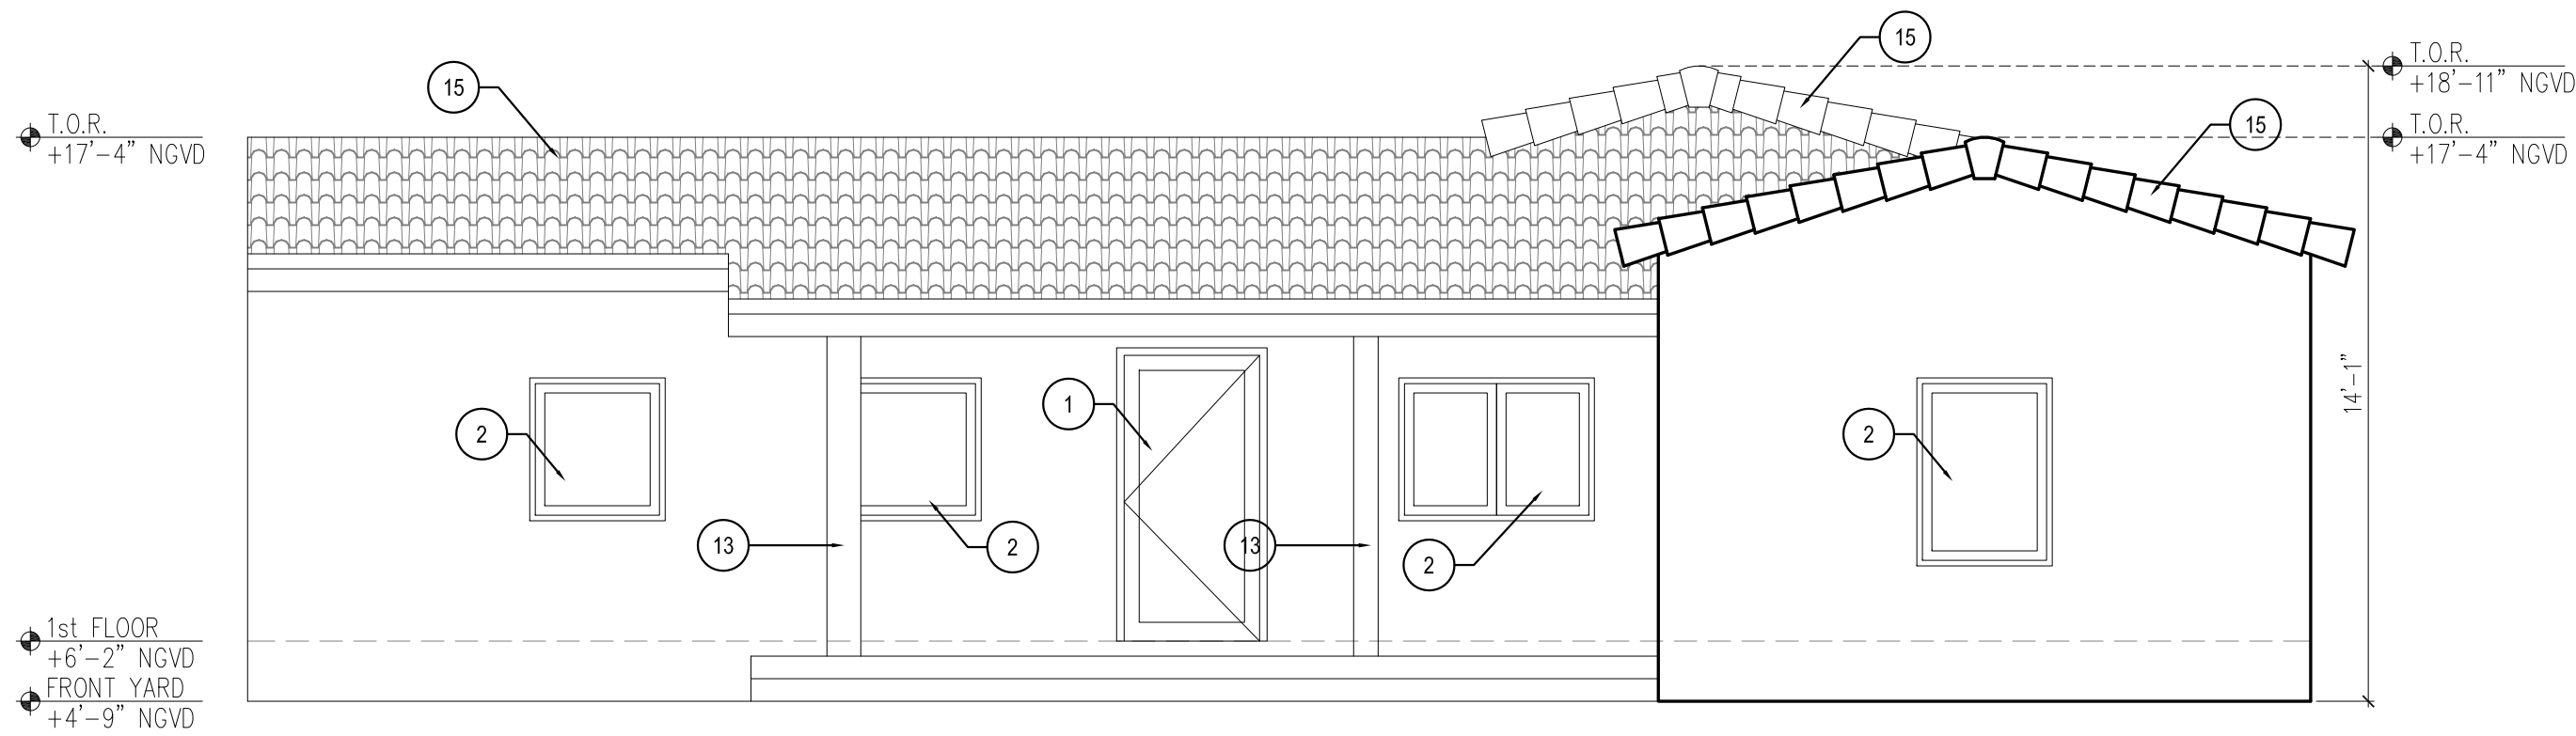


1 FRONT ELEVATION
SCALE: 1/4"=1'-0"

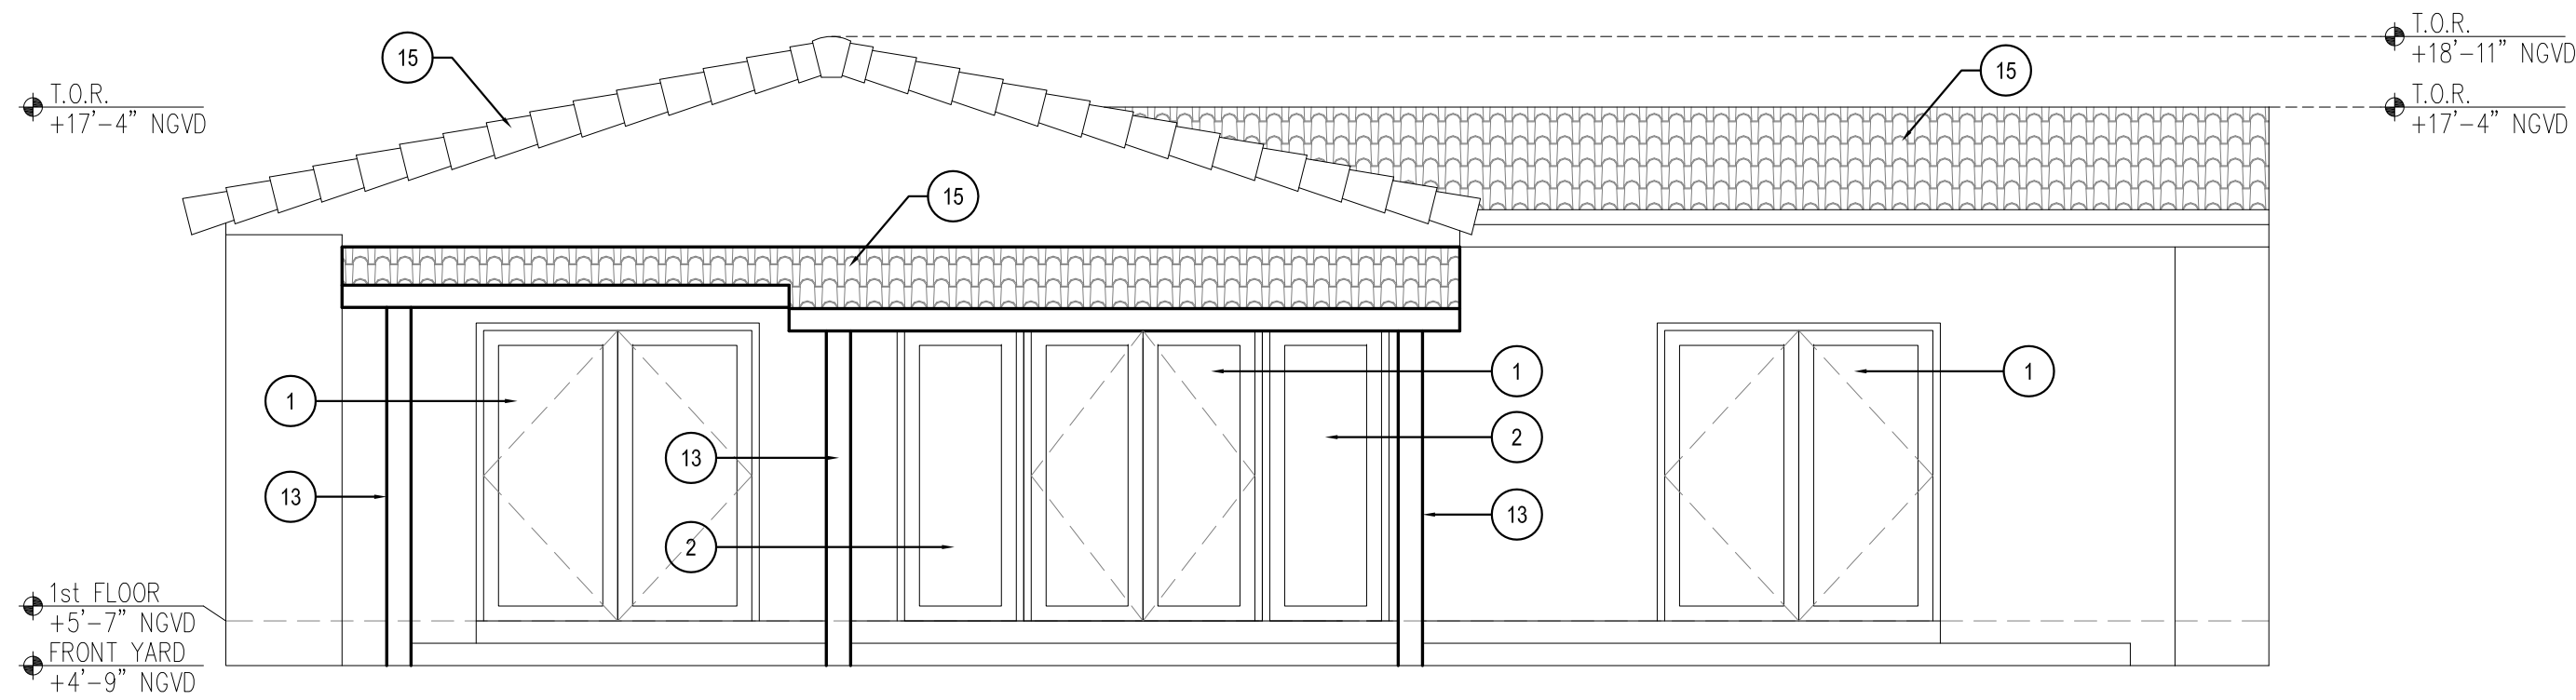


2 REAR ELEVATION
SCALE: 1/4"=1'-0"

EXISTING / DEMOLITION NOTES:

- EXISTING DOOR TO BE REMOVED
- EXISTING WINDOW TO BE REMOVED
- EXISTING BATHROOM MILLWORK TO BE DEMOLISHED. PLUMBING FIXTURE TO BE REMOVED & STORED
- EXISTING KITCHEN MILLWORK TO BE DEMOLISHED. APPLIANCES & FIXTURES TO BE STORED
- EXISTING APPLIANCES TO BE REMOVED & STORED
- EXISTING SHOWER TO BE DEMOLISHED
- EXTERIOR STORAGE TO BE DEMOLISHED
- EXISTING GENERATOR TO BE REMOVED AND STORED
- EXISTING A/C CONDENSING UNIT TO BE REMOVED AND STORED
- EXISTING WATER HEATER TO BE REMOVED AND STORED
- EXISTING WOOD DOCK TO REMAIN
- EXISTING GATE TO BE DEMOLISHED
- EXISTING SUPPORT COLUMN TO BE DEMOLISHED
- EXISTING TILES / PAVERS TO BE REMOVED
- EXISTING COCONUT PALM TO REMAIN
- EXISTING BLACK OLIVE TREE TO REMAIN
- EXISTING BOAT LIFT TO REMAIN

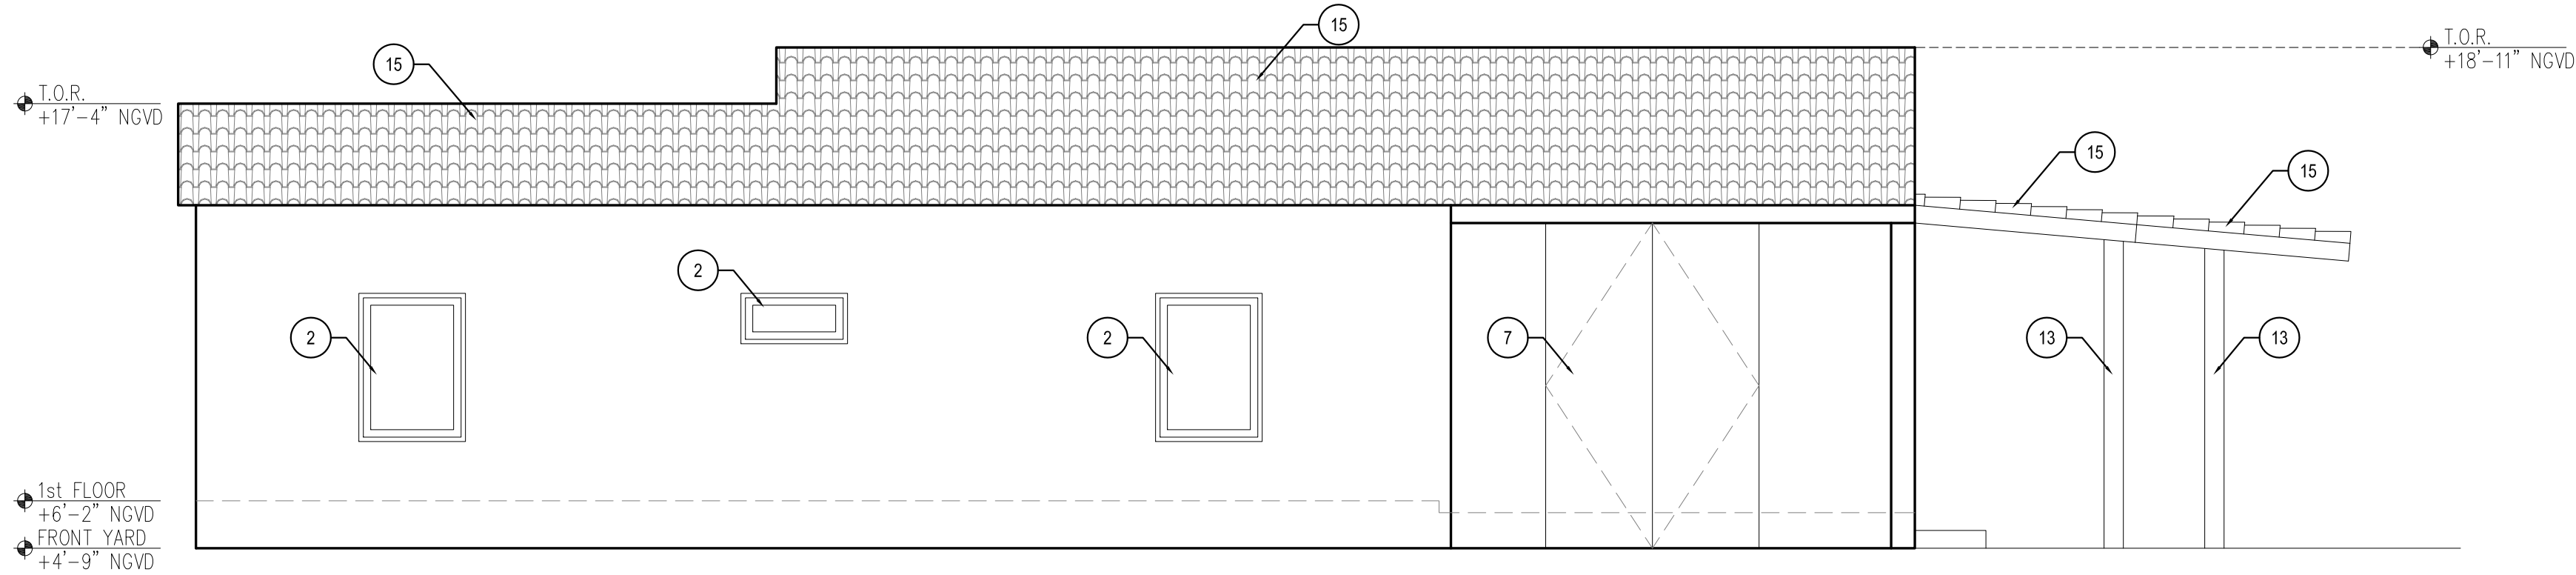

3 SIDE ELEVATION
SCALE: 1/4"=1'-0"

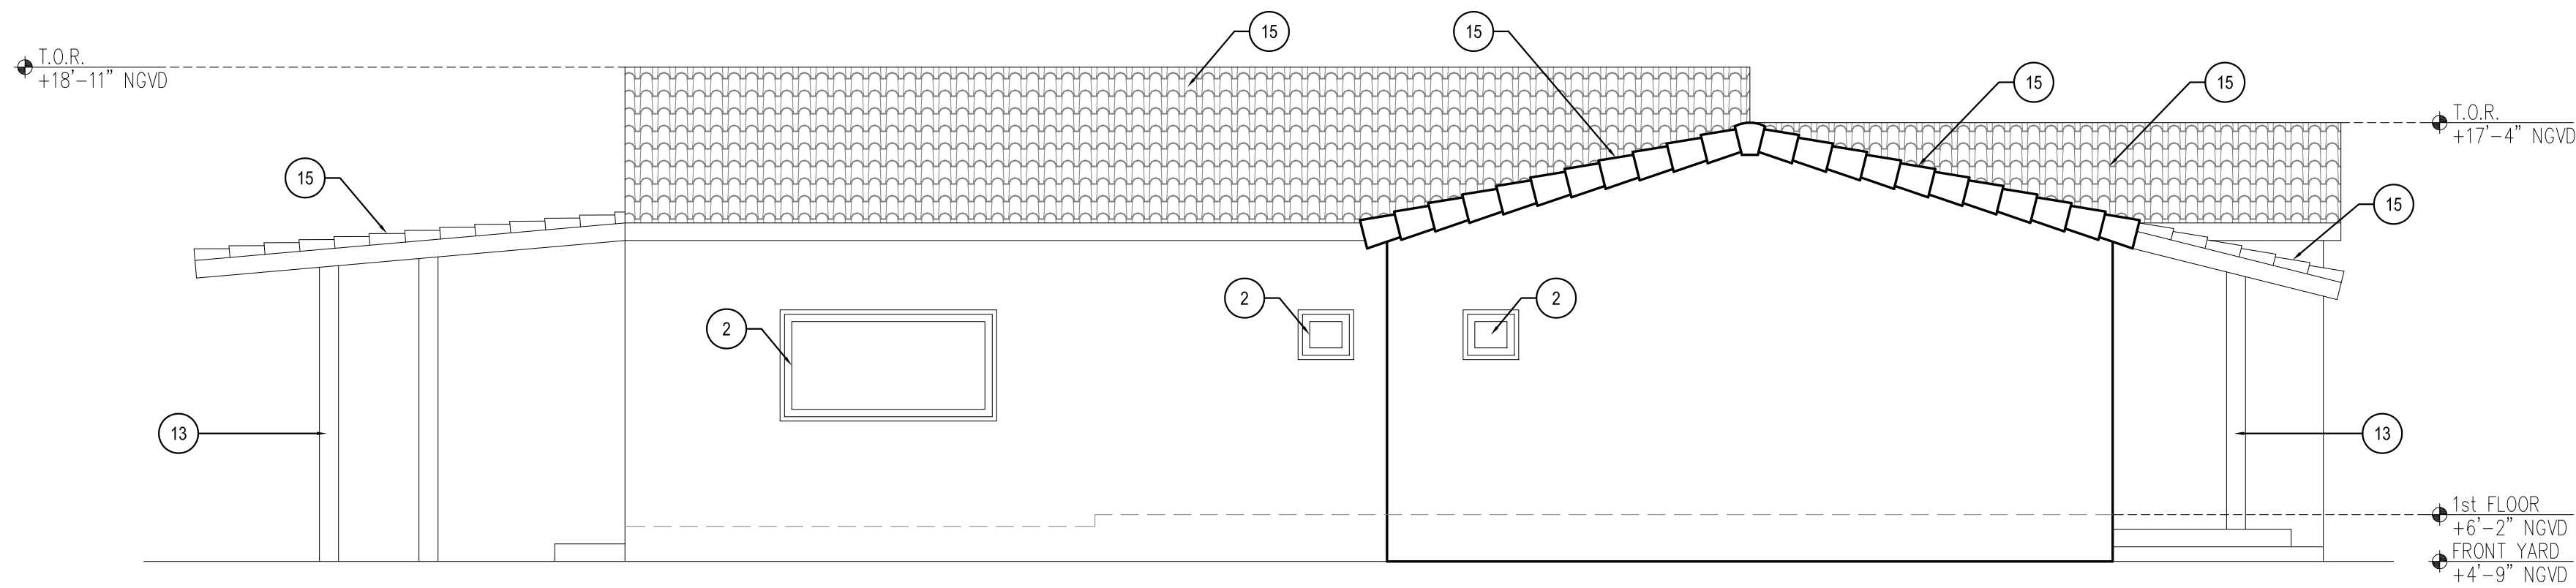

4 SIDE ELEVATION
SCALE: 1/4"=1'-0"

ARCHITECT:

TAI ARCHITECTURE, INC.
278 NW 57th Street, Miami, FL 33127
p: 305.576.7556 f: 305.576.5772
e: michael@tdmiami.com license aa26001343

DO NOT SCALE DRAWING
THIS DRAWING IS THE PROPERTY OF TAI ARCHITECTURE AND SHALL NOT BE REPRODUCED, COPIED, LENT OR DISPOSED OF DIRECTLY OR INDIRECTLY FOR ANY PURPOSES OTHER THAN THAT FOR WHICH IT IS SPECIFICALLY FURNISHED AND MUST BE RETURNED TO TAI ARCHITECTURE ON COMPLETION OF WORK IF REQUESTED.

NO.	REVISIONS/SUBMISSIONS	DATE
01	PRELIMINARY	02.09.17
02	DRB SUBMITTAL	01.24.17
03	DRB SUBMITTAL	01.24.17

SEAL

PROJECT NAME / ADDRESS:
PRIVATE RESIDENCE
8 FARREY LANE
MIAMI BEACH, FL 33139

DRAWING TITLE:
**EXISTING & DEMOLITION
ELEVATIONS**

FOR DRB

PROJECT #:
16-M-04

A-1.2

SHEET

COPYRIGHT © 2016

COPYRIGHT BY TAI ARCHITECTURE AND DESIGN, INC. AND FFD PRODUCT INC. THIS DRAWING SET IS GIVEN IN CONFIDENCE. NO USE OR DISSEMINATION MAY BE MADE WITHOUT PRIOR WRITTEN CONSENT OF TAI ARCHITECTURE OR FFD PRODUCT. ALL COMMON LAW RIGHTS OF COPYRIGHT AND OTHER WISE ARE HEREBY SPECIFICALLY RESERVED.


PROPOSED WALL LEGEND	
	GYPSUM BOARD WALL
	CONCRETE WALL / COLUMN
	CMU WALL

GENERAL NOTES:


- DIMENSIONS SHOWN ARE NOMINAL. ACTUAL DIMENSIONS MAY VARY

PROPOSED CONDITION NOTES:

- NEW PERMEABLE PAVER DRIVEWAY
- NEW METAL SIDEGATE
- EXISTING WOOD DOCK
- NEW COVERED TERRACE
- NEW PRECAST COLUMN W/ LIMESTONE FINISH
- NEW PRECAST GUARDRAIL POST W/ LIMESTONE FINISH
- NEW CUSTOM ALUMINUM GUARDRAIL W/ POWDER COAT PAINT FINISH
- NEW CUSTOM GLASS DOOR W/ FORGED IRON DETAIL
- NEW IMPACT RESISTANT COLLAPSIBLE DOOR SYSTEM (NANA WALL)

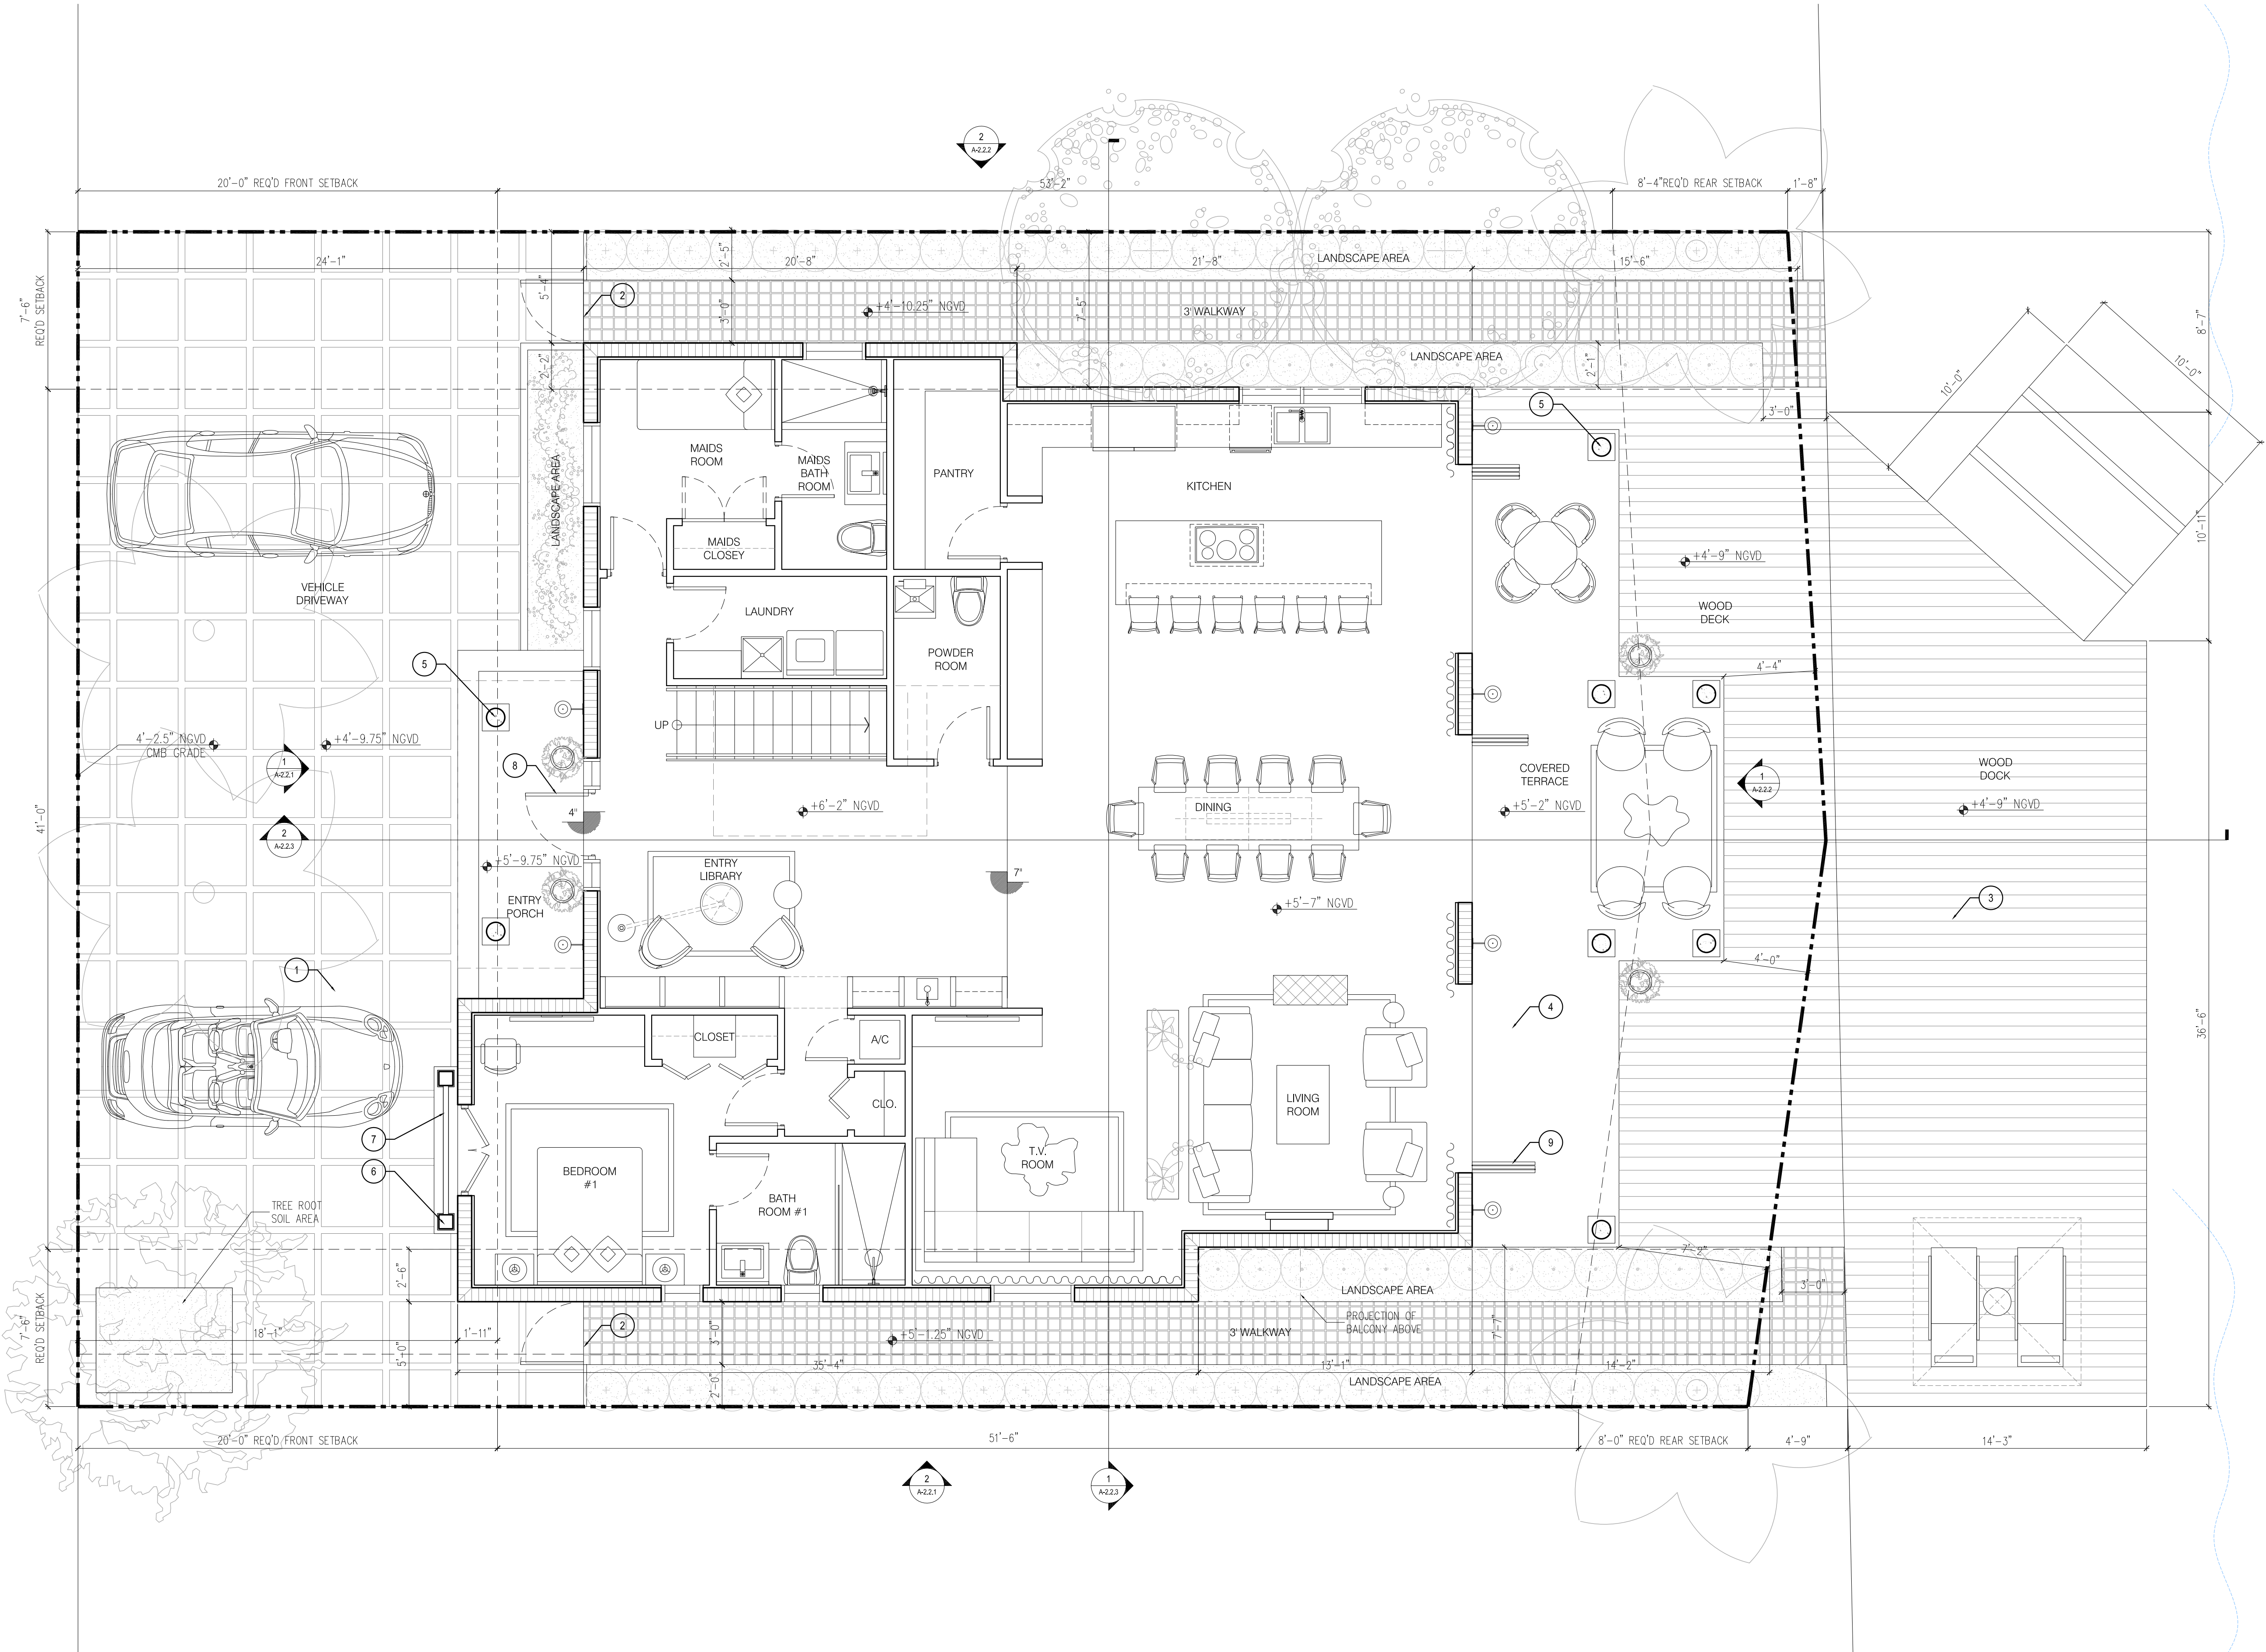

 1 PROPOSED GROUND FLOOR PLAN
SCALE: 1/4"=1'-0"



ARCHITECT:

DO NOT SCALE DRAWING
THIS DRAWING IS THE PROPERTY OF TAI
ARCHITECTURE AND SHALL NOT BE REPRODUCED,
COPIED, LENT OR DISPOSED OF DIRECTLY OR
INDIRECTLY WITHOUT THE WRITTEN CONSENT OF
TAI ARCHITECTURE. ANY REPRODUCTION OF THIS
DRAWING WITHOUT THE WRITTEN CONSENT OF
TAI ARCHITECTURE SHALL BE AT THE USER'S
RISK AND WITHOUT LIABILITY TO TAI
ARCHITECTURE. THIS DRAWING IS SPECIFICALLY
FURNISHED AND MUST BE RETURNED TO TAI
ARCHITECTURE ON COMPLETION OF WORK IF
REQUESTED.

NO.	REVISIONS/SUBMISSIONS	DATE
1	FINAL DRB SUBMITTAL	02.09.17
2	PRELIMINARY DRB SUBMITTAL	01.24.17

SEAL

PROJECT NAME / ADDRESS:
PRIVATE RESIDENCE
8 FARREY LANE
MIAMI BEACH, FL 33139

DRAWING TITLE:
PROPOSED GROUND
FLOOR PLAN

FOR DRB

PROJECT #:
16-M-04

A-2.0

SHEET

COPYRIGHT © 2016

COPYRIGHT BY TAI ARCHITECTURE AND DESIGN, INC. AND FFD PRODUCT INC. THIS DRAWING SET IS GIVEN IN CONFIDENCE. NO USE OR DISSEMINATION MAY BE MADE WITHOUT PRIOR WRITTEN CONSENT OF TAI ARCHITECTURE OR FFD PRODUCT. ALL COMMON LAW RIGHTS OF COPYRIGHT AND OTHER WISE ARE HEREBY SPECIFICALLY RESERVED.


PROPOSED WALL LEGEND	
	GYPSUM BOARD WALL
	CONCRETE WALL / COLUMN
	CMU WALL

GENERAL NOTES:


- DIMENSIONS SHOWN ARE NOMINAL. ACTUAL DIMENSIONS MAY VARY

PROPOSED CONDITION NOTES:

- NEW PERMEABLE PAVER DRIVEWAY
- NEW METAL SIDEGATE
- EXISTING WOOD DOCK
- NEW COVERED TERRACE
- NEW PRECAST COLUMN W/ LIMESTONE FINISH
- NEW PRECAST GUARDRAIL POST W/ LIMESTONE FINISH
- NEW CUSTOM ALUMINUM GUARDRAIL W/ POWDER COAT PAINT FINISH
- NEW CUSTOM GLASS DOOR W/ FORGED IRON DETAIL
- NEW IMPACT RESISTANT COLLAPSIBLE DOOR SYSTEM (NANA WALL)

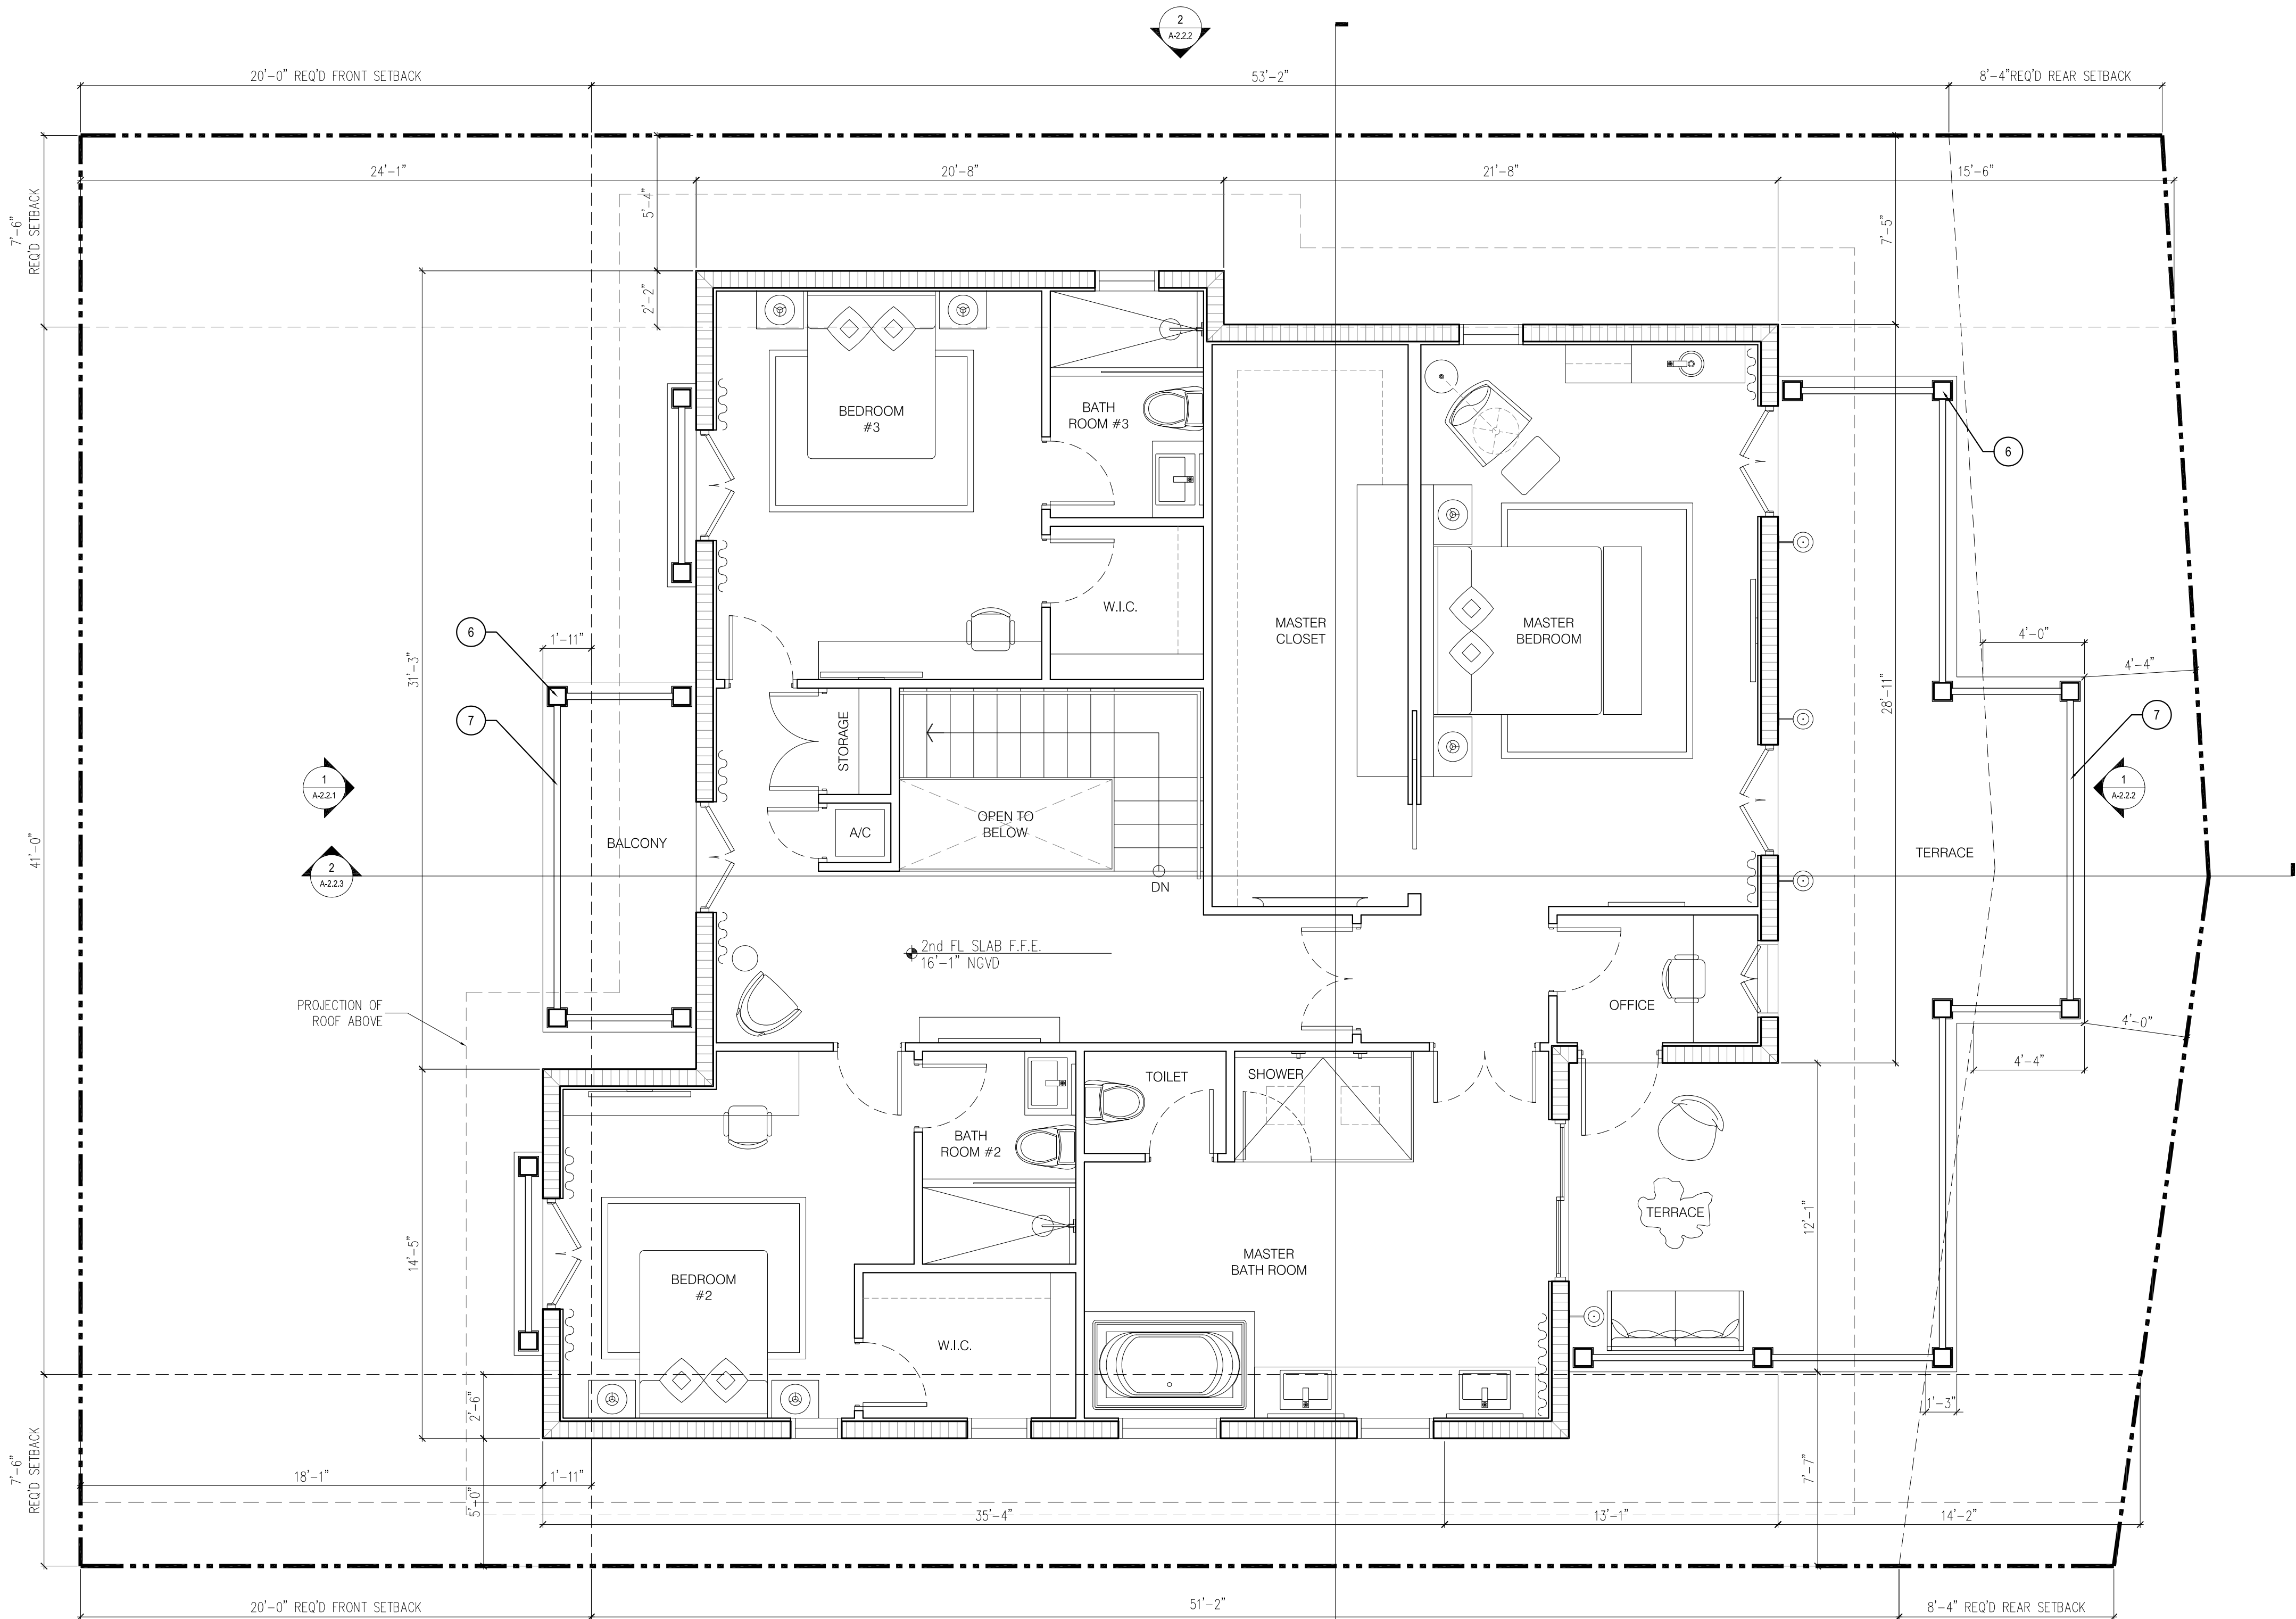

 1 PROPOSED SECOND FLOOR PLAN
SCALE: 1/4"=1'-0"



ARCHITECT:

TAI ARCHITECTURE, INC.
278 NW 57th Street, Miami, FL 33127
p: 305.576.7556 f: 305.576.5772
e: michael@tdmiami.com license aa26001343

DO NOT SCALE DRAWING
THIS DRAWING IS THE PROPERTY OF TAI ARCHITECTURE AND SHALL NOT BE REPRODUCED, COPIED, LENT OR DISPOSED OF DIRECTLY OR INDIRECTLY FOR ANY PURPOSES OTHER THAN THAT FOR WHICH IT IS SPECIFICALLY FURNISHED AND MUST BE RETURNED TO TAI ARCHITECTURE ON COMPLETION OF WORK IF REQUESTED.

REVISIONS/SUBMISSIONS		DATE
NO.	DESCRIPTION	
1	FINAL DRB SUBMITTAL	02.09.17
2	PRELIMINARY DRB SUBMITTAL	01.24.17

SEAL

PROJECT NAME / ADDRESS:
PRIVATE RESIDENCE
8 FARREY LANE
MIAMI BEACH, FL 33139

DRAWING TITLE:
PROPOSED SECOND FLOOR PLAN

PROJECT #:
16-M-04
FOR DRB

A-2.1
SHEET


PROPOSED WALL LEGEND	
	GYPSUM BOARD WALL
	CONCRETE WALL / COLUMN
	CMU WALL

GENERAL NOTES:

- DIMENSIONS SHOWN ARE NOMINAL. ACTUAL DIMENSIONS MAY VARY

PROPOSED CONDITION NOTES:

- NEW PERMEABLE PAVER DRIVEWAY
- NEW METAL SIDEGATE
- EXISTING WOOD DOCK
- NEW COVERED TERRACE
- NEW PRECAST COLUMN W/ LIMESTONE FINISH
- NEW PRECAST GUARDRAIL POST W/ LIMESTONE FINISH
- NEW CUSTOM ALUMINUM GUARDRAIL W/ POWDER COAT PAINT FINISH
- NEW CUSTOM GLASS DOOR W/ FORGED IRON DETAIL
- NEW IMPACT RESISTANT COLLAPSIBLE DOOR SYSTEM (NANA WALL)

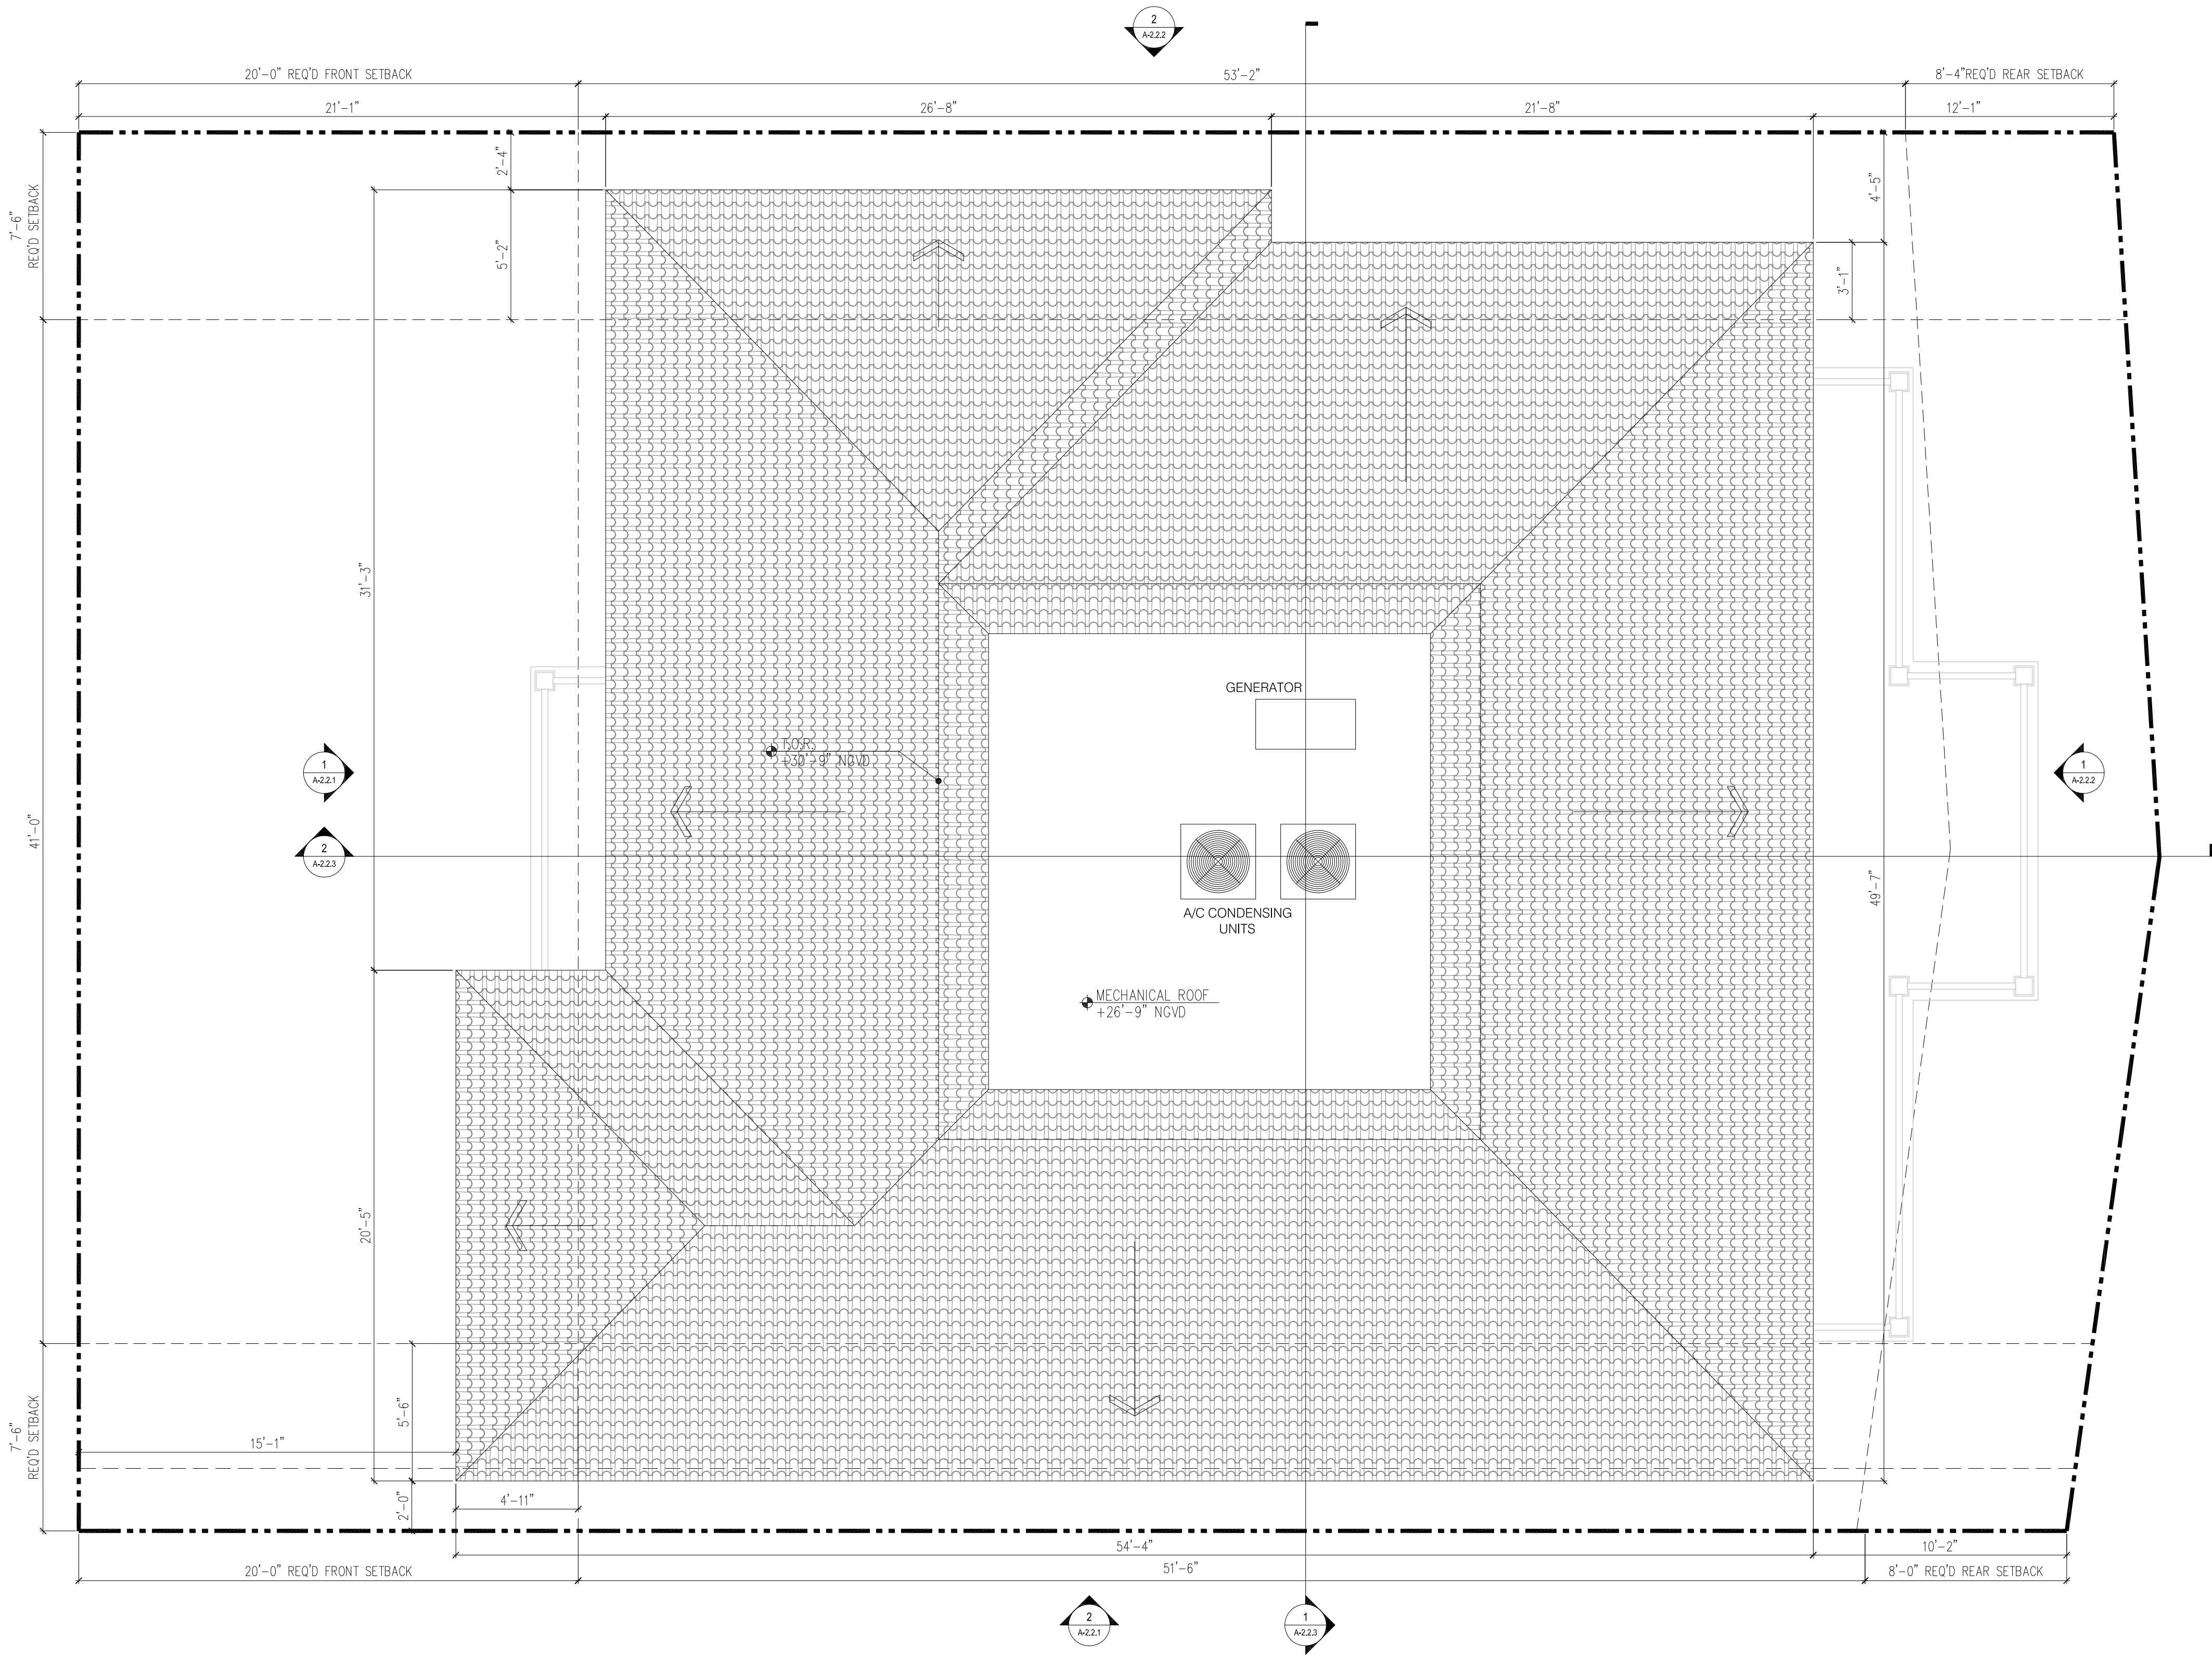

1 PROPOSED ROOF PLAN
SCALE: 1/4"=1'-0"



ARCHITECT:

TAI ARCHITECTURE, INC.
278 NW 57th Street, Miami, FL 33127
p: 305.576.7556 f: 305.576.5772
e: michael@tdmiami.com license aa26001343

DO NOT SCALE DRAWING

THIS DRAWING IS THE PROPERTY OF TAI ARCHITECTURE AND SHALL NOT BE REPRODUCED, COPIED, LENT OR DISPOSED OF DIRECTLY OR INDIRECTLY FOR ANY PURPOSES OTHER THAN THAT FOR WHICH IT IS SPECIFICALLY FURNISHED AND MUST BE RETURNED TO TAI ARCHITECTURE ON COMPLETION OF WORK IF REQUESTED.

NO.	REVISIONS/SUBMISSIONS	DATE
1	FINAL DRB SUBMITTAL	02.09.17
2	PRELIMINARY DRB SUBMITTAL	01.24.17

SEAL

PROJECT NAME / ADDRESS:
PRIVATE RESIDENCE
8 FARREY LANE
MIAMI BEACH, FL 33139

DRAWING TITLE:

PROPOSED ROOF
PLAN

PROJECT #:

16-M-04

FOR DRB

A-2.2

SHEET

COPYRIGHT © 2016


COPYRIGHT BY TAI ARCHITECTURE AND DESIGN, INC. AND FFD PRODUCT INC. THIS DRAWING SET IS GIVEN IN CONFIDENCE. NO USE OR DISSEMINATION MAY BE MADE WITHOUT PRIOR WRITTEN CONSENT OF TAI ARCHITECTURE OR FFD PRODUCT. ALL COMMON LAW RIGHTS OF COPYRIGHT AND OTHER WISE ARE HEREBY SPECIFICALLY RESERVED.

GENERAL NOTES:


- DIMENSIONS SHOWN ARE NOMINAL. ACTUAL DIMENSIONS MAY VARY
- INSIDE FINISH FLOOR ELEVATION: +0'-0" = 6.10' NAVD (7.66' NGVD) G.C. TO FIELD VERIFY

PROPOSED CONDITION NOTES:

- NEW CLAY ROOF TILE
- NEW PAINTED WOOD CORBELS
- NEW TRAVERTINE CORNER TILE
- PAINTED STUCCO FINISH
- NEW PRECAST WINDOW SILL W/ TRAVERTINE FINISH
- NEW PRECAST GUARDRAIL POST W/ TRAVERTINE FINISH
- NEW CUSTOM ALUMINUM GUARDRAIL W/ POWDER COAT PAINT FINISH
- NEW PRECAST COLUMN W/ TRAVERTINE FINISH
- PRECAST KEYSTONE W/ TRAVERTINE FINISH
- TRAVERTINE FINISH DOOR SILL
- TRAVERTINE FINISH EDGE TRIM
- NEW CUSTOM GLASS DOOR W/ FORGED IRON DETAIL

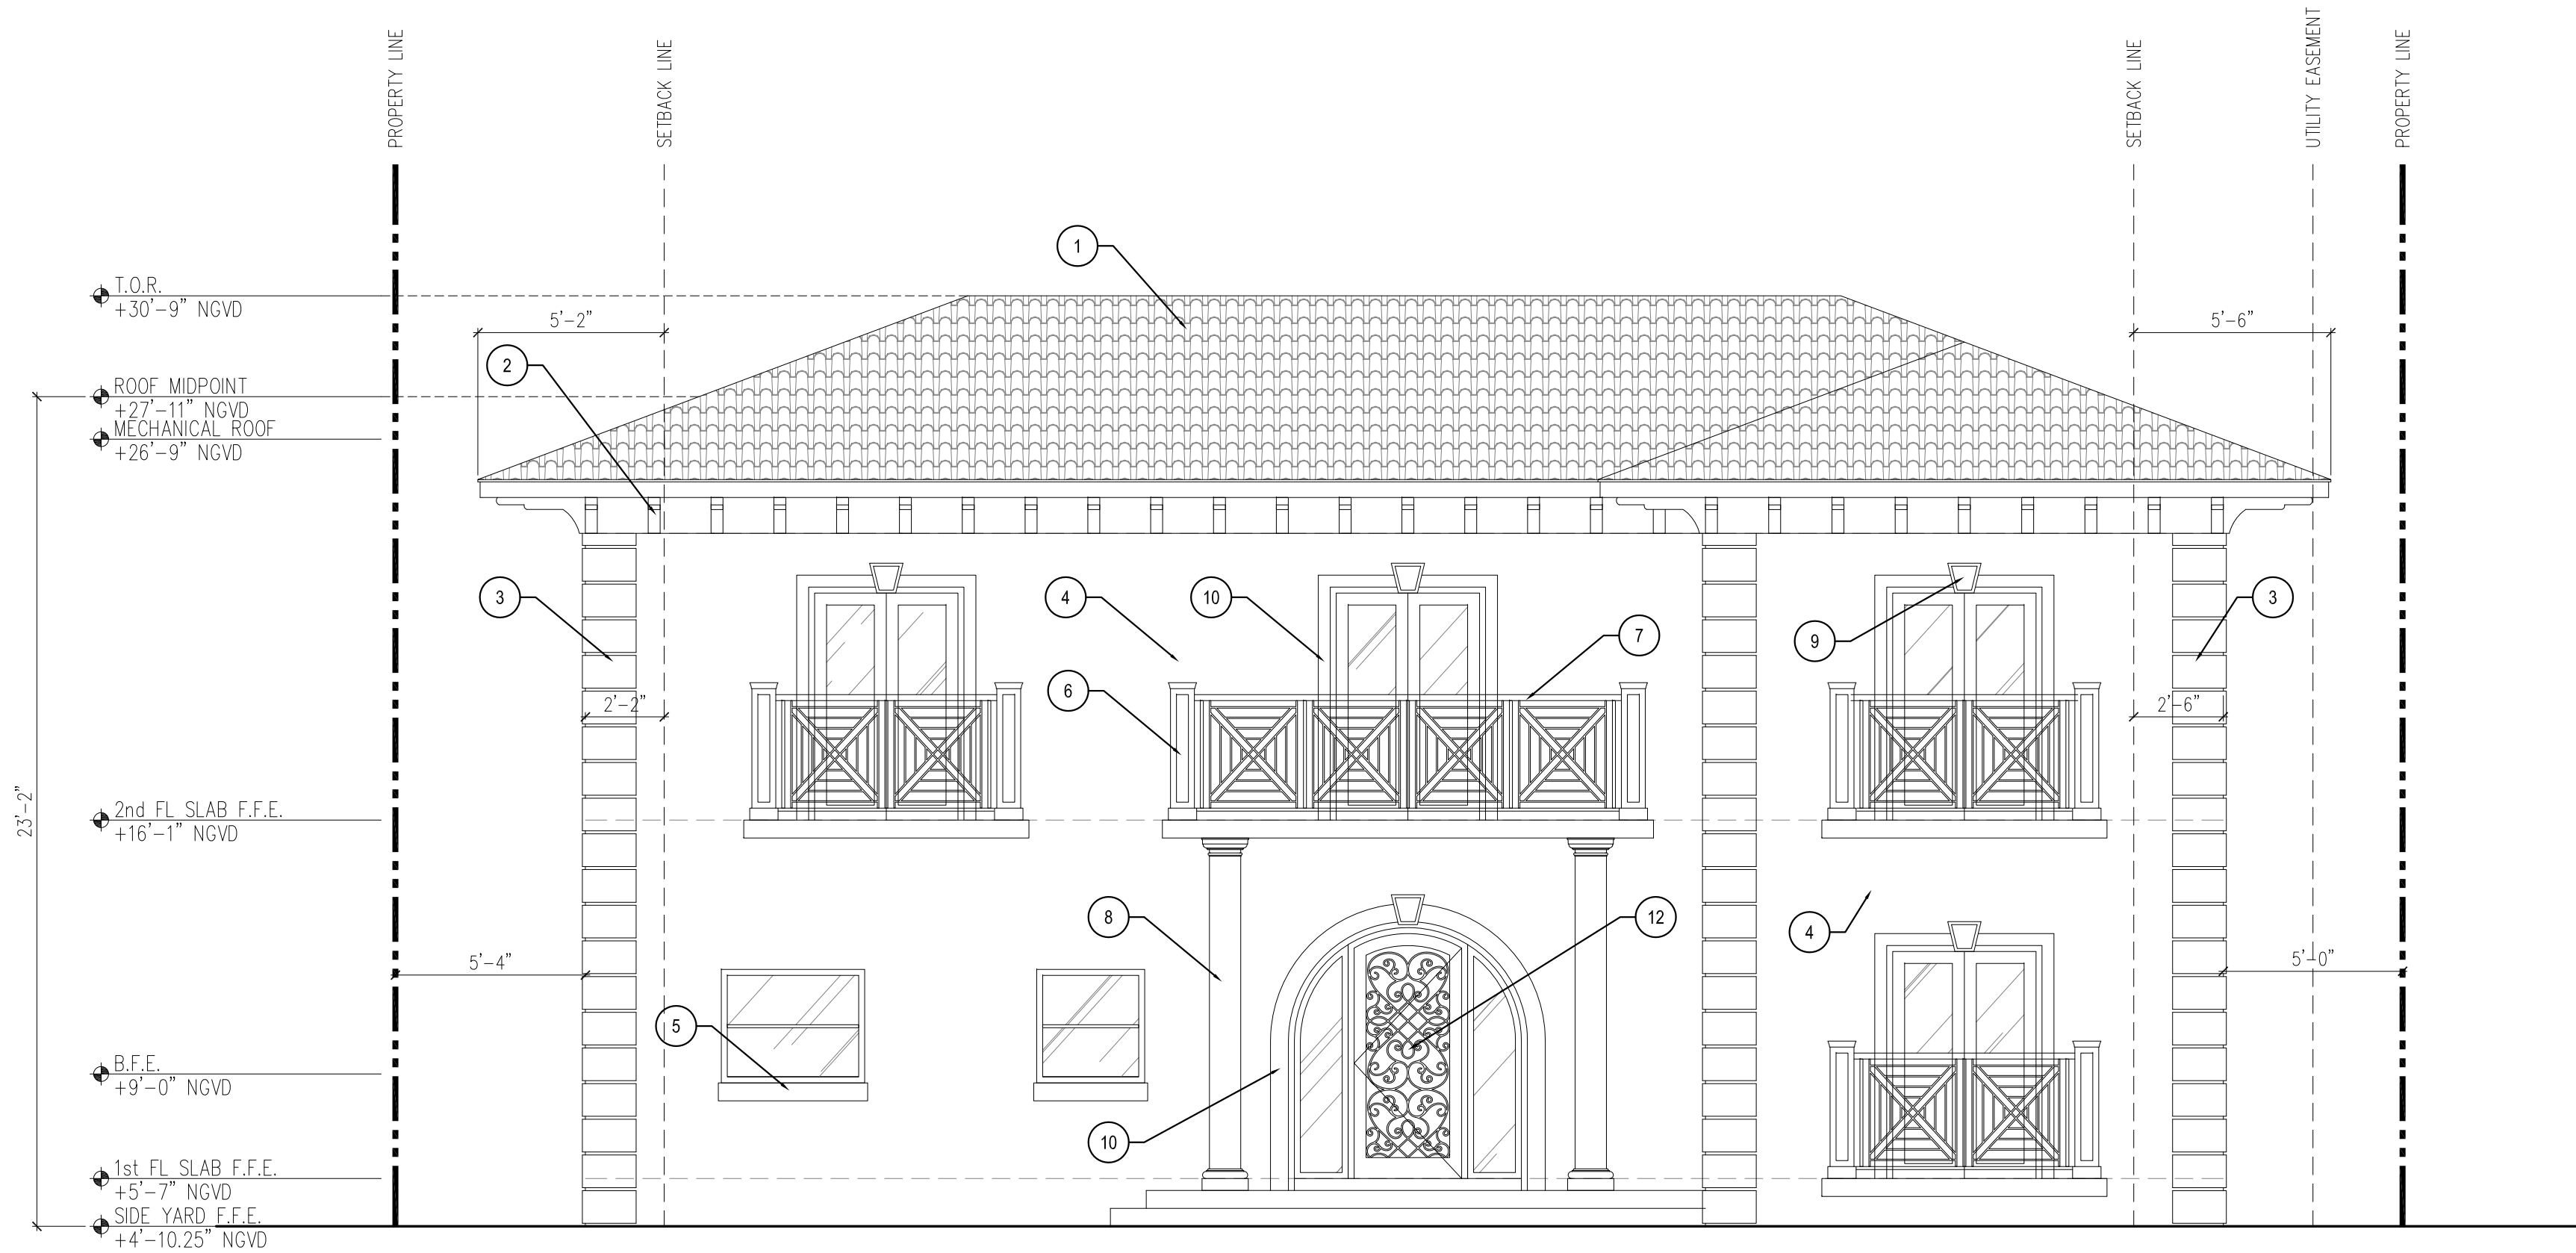

1 SOUTH ELEVATION
SCALE: 1/4"=1'-0"

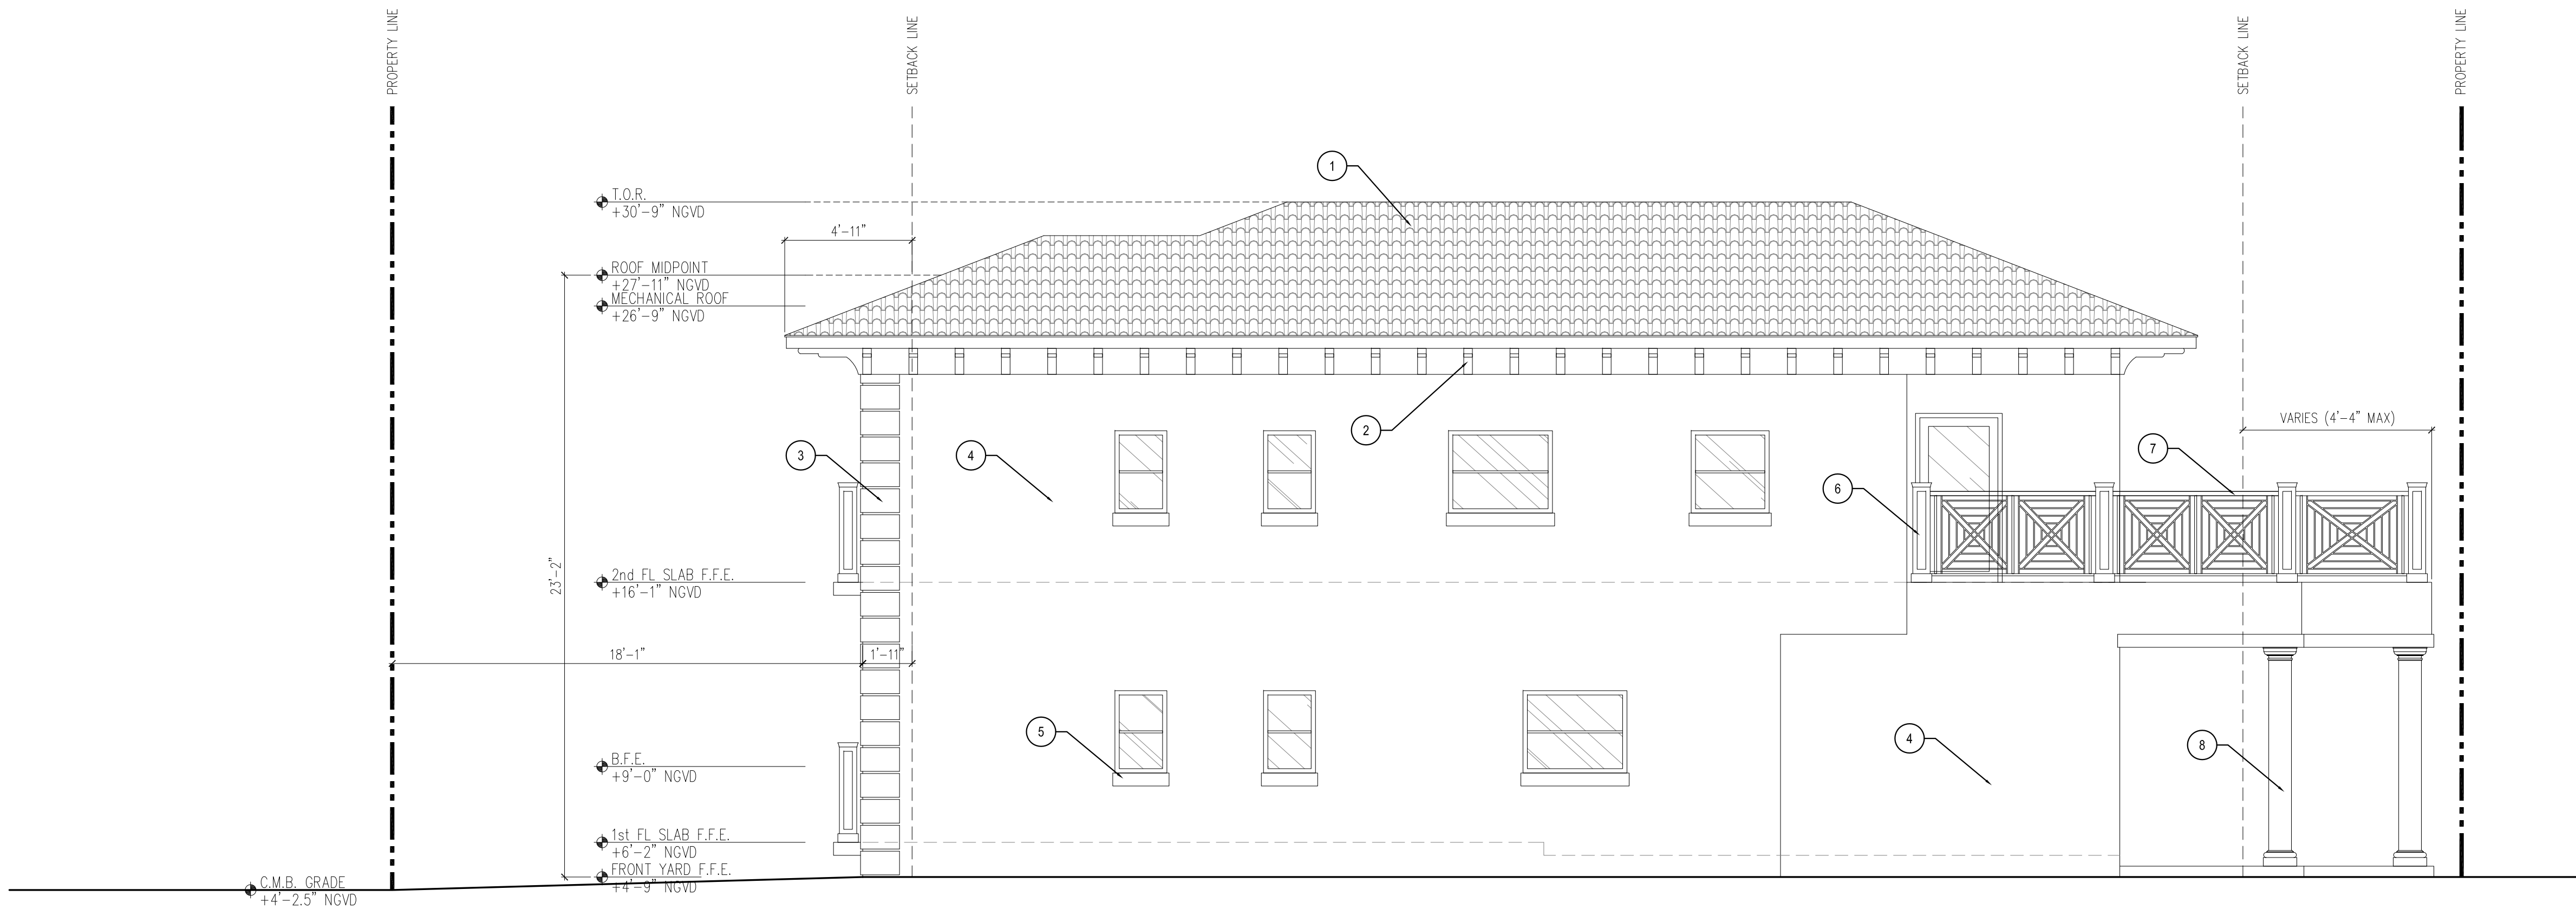

2 EAST ELEVATION
SCALE: 1/4"=1'-0"

ARCHITECT:

TAI ARCHITECTURE, INC.
278 NW 57th Street, Miami, FL 33127
p: 305.576.7556 f: 305.576.5772
e: michael@tdmiami.com license aa26001343

DO NOT SCALE DRAWING
THIS DRAWING IS THE PROPERTY OF TAI ARCHITECTURE AND SHALL NOT BE REPRODUCED, COPIED, LENT OR DISPOSED OF DIRECTLY OR INDIRECTLY FOR ANY PURPOSES OTHER THAN THAT FOR WHICH IT IS SPECIFICALLY FURNISHED AND MUST BE RETURNED TO TAI ARCHITECTURE ON COMPLETION OF WORK IF REQUESTED.

NO.	REVISIONS/SUBMISSIONS	DATE
01	PRELIMINARY	02.09.17
02	DRB SUBMITTAL	01.24.17
03	DRB SUBMITTAL	01.24.17

SEAL

PROJECT NAME / ADDRESS:
PRIVATE RESIDENCE
8 FARREY LANE
MIAMI BEACH, FL 33139

DRAWING TITLE:

PROPOSED ELEVATIONS

PROJECT #:

16-M-04

FOR DRB

A-2.3.1


SHEET

GENERAL NOTES:


- DIMENSIONS SHOWN ARE NOMINAL. ACTUAL DIMENSIONS MAY VARY
- INSIDE FINISH FLOOR ELEVATION: +0'-0" = 6.10' NAVD (7.66' NGVD) G.C. TO FIELD VERIFY

PROPOSED CONDITION NOTES:

- NEW CLAY ROOF TILE
- NEW PAINTED WOOD CORBELS
- NEW TRAVERTINE CORNER TILE
- PAINTED STUCCO FINISH
- NEW PRECAST WINDOW SILL W/ TRAVERTINE FINISH
- NEW PRECAST GUARDRAIL POST W/ TRAVERTINE FINISH
- NEW CUSTOM ALUMINUM GUARDRAIL W/ POWDER COAT PAINT FINISH
- NEW PRECAST COLUMN W/ TRAVERTINE FINISH
- PRECAST KEYSTONE W/ TRAVERTINE FINISH
- TRAVERTINE FINISH DOOR SILL
- TRAVERTINE FINISH EDGE TRIM
- NEW CUSTOM GLASS DOOR W/ FORGED IRON DETAIL

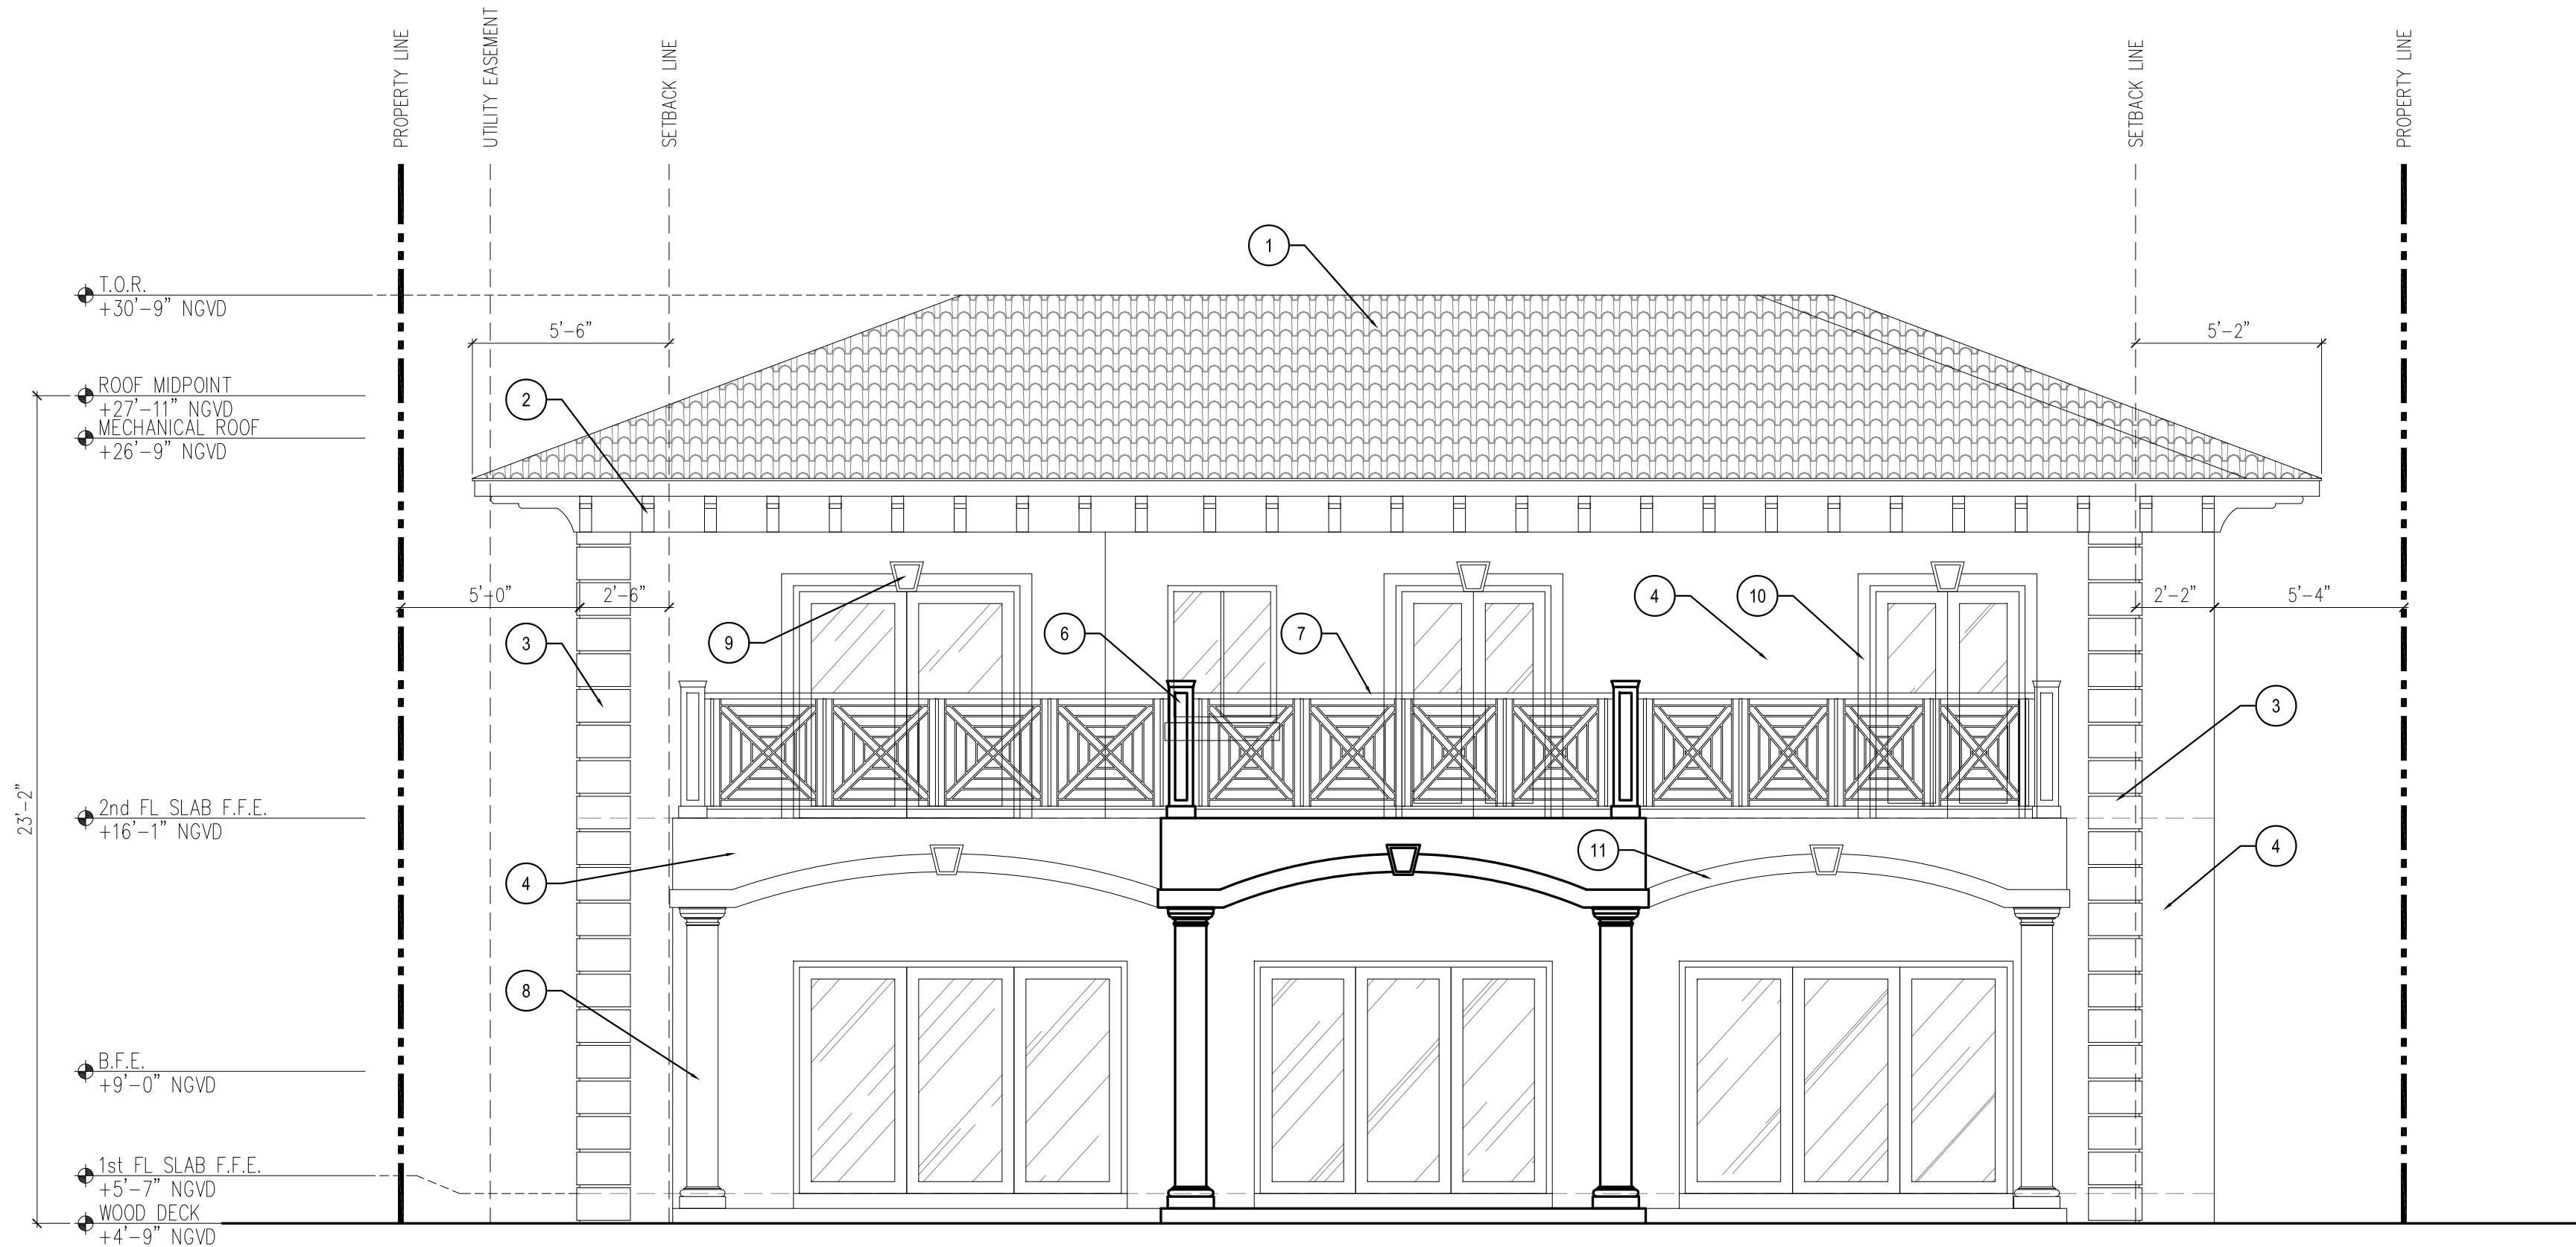

1 NORTH ELEVATION
SCALE: 1/4"=1'-0"

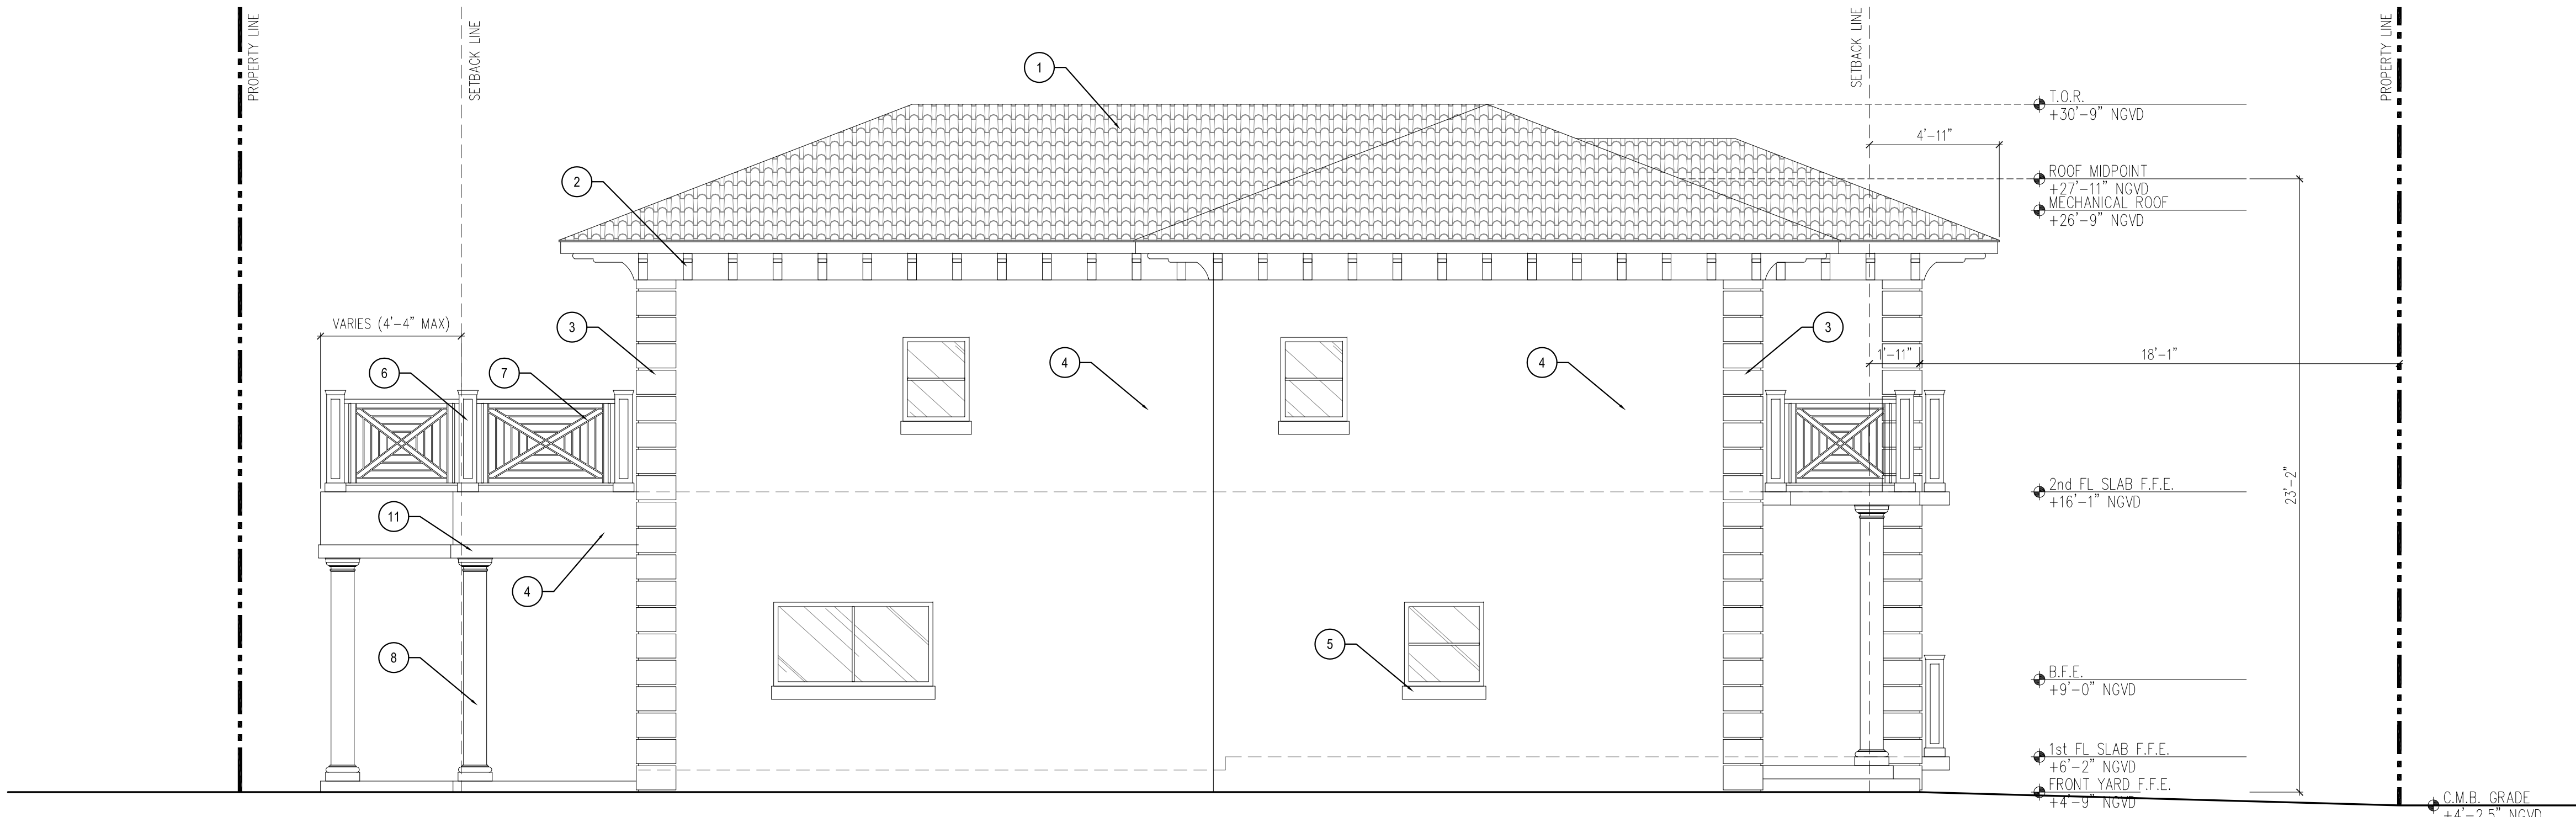

2 WEST ELEVATION
SCALE: 1/4"=1'-0"

ARCHITECT:

TAI ARCHITECTURE, INC.
278 NW 57th Street, Miami, FL 33127
p: 305.576.7556 f: 305.576.5772
e: michael@tdmiami.com license aa26001343

DO NOT SCALE DRAWING
THIS DRAWING IS THE PROPERTY OF TAI ARCHITECTURE AND SHALL NOT BE REPRODUCED, COPIED, LENT OR DISPOSED OF DIRECTLY OR INDIRECTLY FOR ANY PURPOSES OTHER THAN THAT FOR WHICH IT IS SPECIFICALLY FURNISHED AND MUST BE RETURNED TO TAI ARCHITECTURE ON COMPLETION OF WORK IF REQUESTED.

NO.	REVISIONS/SUBMISSIONS	DATE
	FINAL DRB SUBMITTAL	02.09.17
	PRELIMINARY DRB SUBMITTAL	01.24.17

SEAL

PROJECT NAME / ADDRESS:
PRIVATE RESIDENCE
8 FARREY LANE
MIAMI BEACH, FL 33139

DRAWING TITLE:

PROPOSED ELEVATIONS

PROJECT #:

16-M-04

FOR DRB

A-2.3.2


SHEET

COPYRIGHT © 2016


COPYRIGHT BY TAI ARCHITECTURE AND DESIGN, INC. AND FFD PRODUCT INC. THIS DRAWING SET IS GIVEN IN CONFIDENCE. NO USE OR DISSEMINATION MAY BE MADE WITHOUT PRIOR WRITTEN CONSENT OF TAI ARCHITECTURE OR FFD PRODUCT. ALL COMMON LAW RIGHTS OF COPYRIGHT AND OTHER WISE ARE HEREBY SPECIFICALLY RESERVED.

- DIMENSIONS SHOWN ARE NOMINAL.
ACTUAL DIMENSIONS MAY VARY
- INSIDE FINISH FLOOR ELEVATION:
+0'-0" = 6.10' NAVD (7.66' NGVD)
G.C. TO FIELD VERIFY

1. NEW CLAY ROOF TILE
2. NEW PAINTED WOOD CORBELS
3. NEW TRAVERTINE CORNER TILE
4. PAINTED STUCCO FINISH
5. NEW PRECAST WINDOW SILL W/
TRAVERTINE FINISH
6. NEW PRECAST GUARDRAIL POST W/
TRAVERTINE FINISH
7. NEW CUSTOM ALUMINUM GUARDRAIL W/
POWDER COAT PAINT FINISH
8. NEW PRECAST COLUMN W/ TRAVERTINE
FINISH
9. PRECAST KEYSTONE W/ TRAVERTINE
FINISH
10. TRAVERTINE FINISH DOOR SILL
11. TRAVERTINE FINISH EDGE TRIM
12. NEW CUSTOM GLASS DOOR W/ FORGED
IRON DETAIL

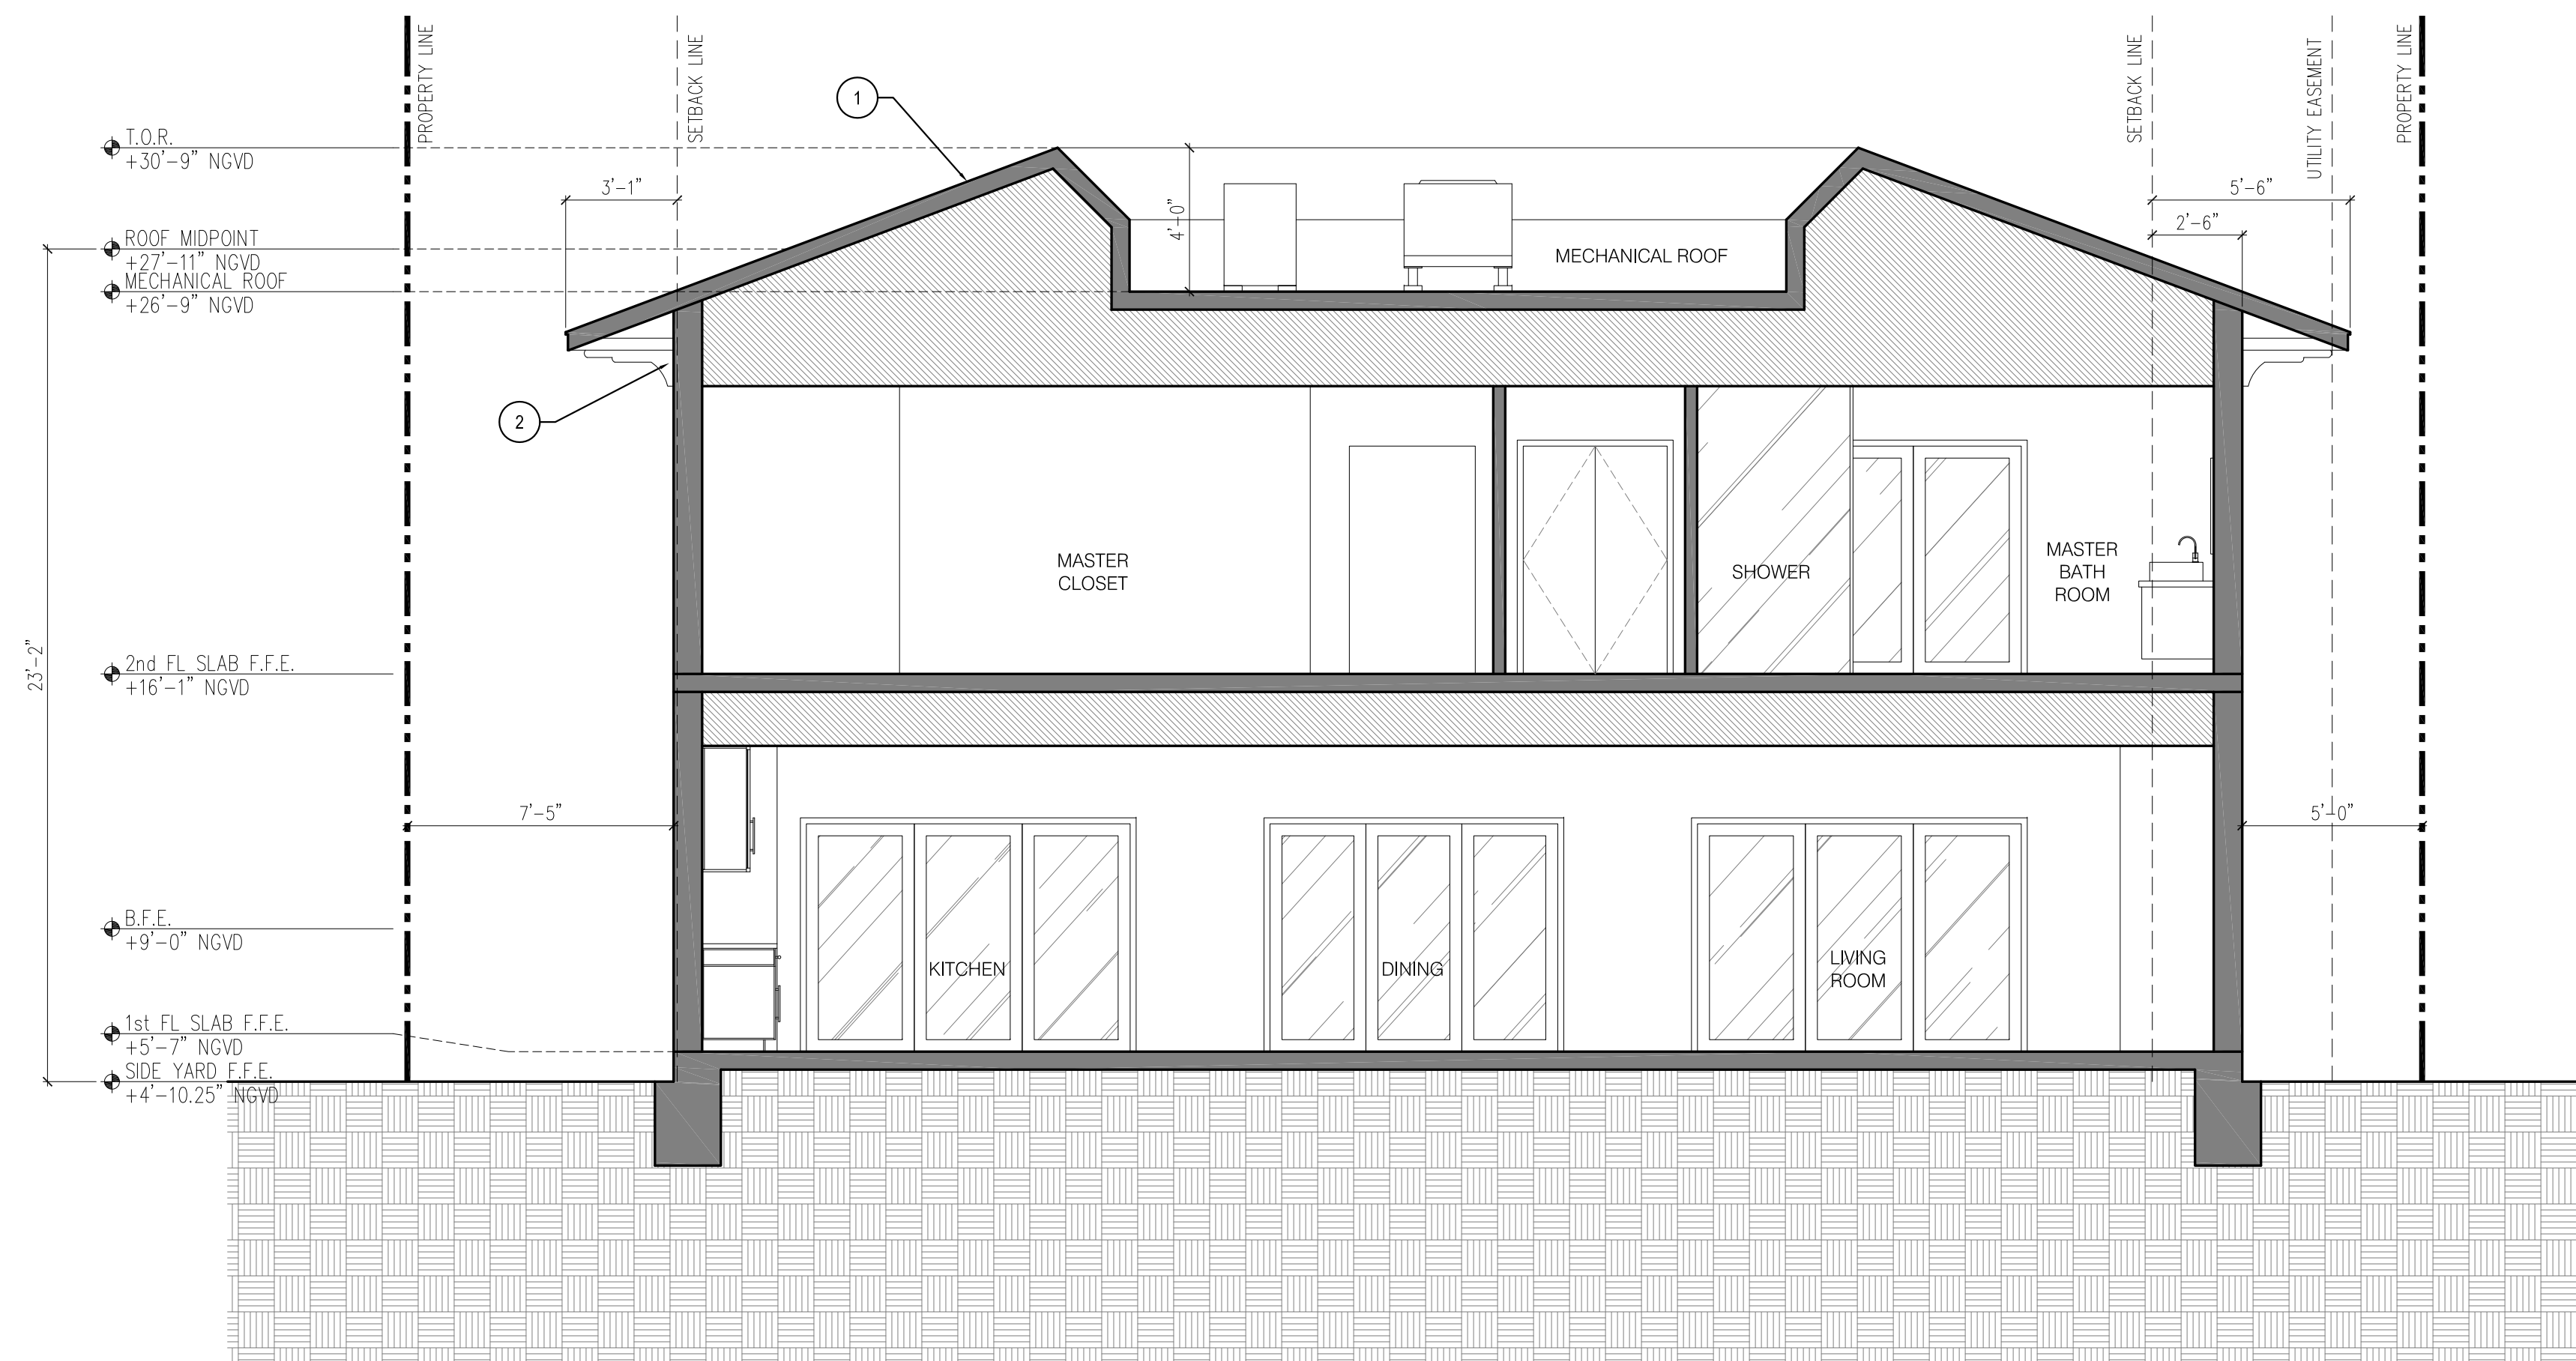

1 CROSS SECTION
SCALE: 1/4"=1'-0"

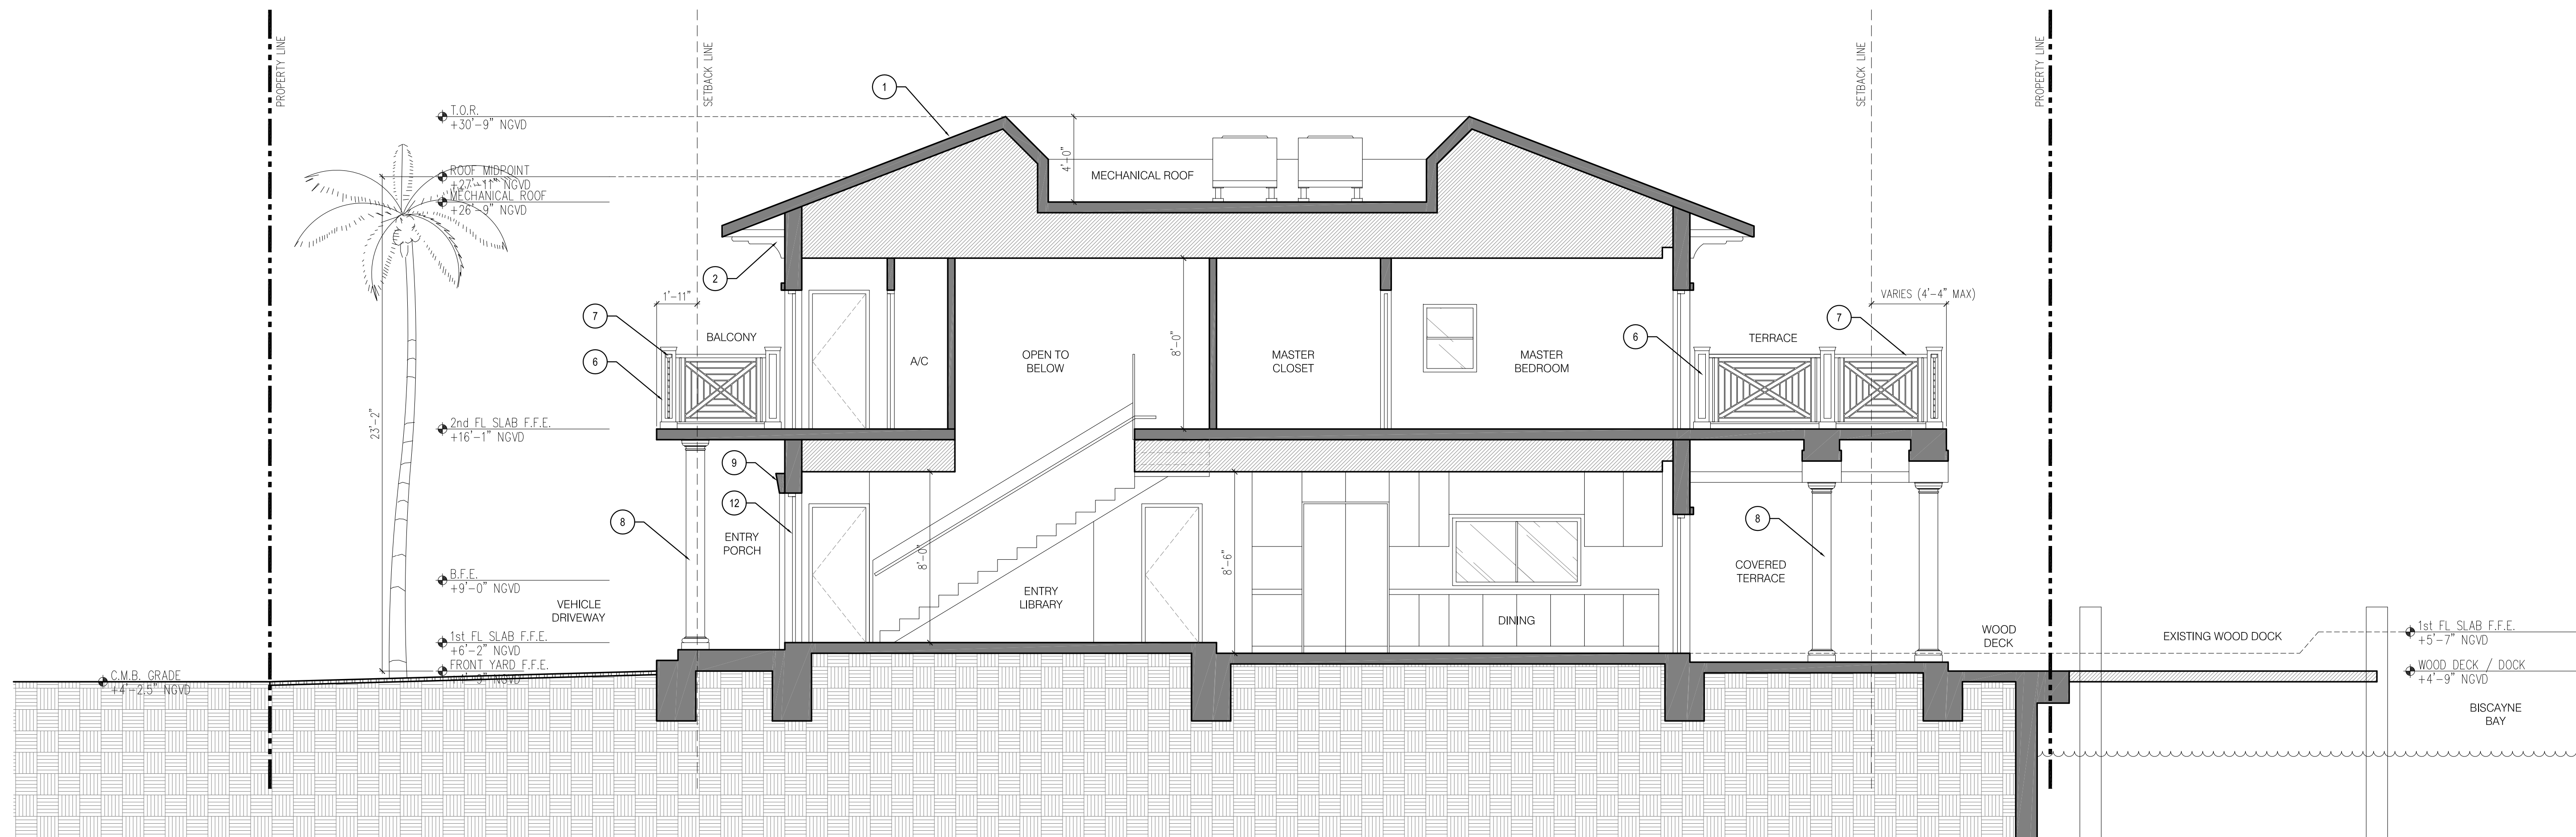

2 LONGITUDINAL SECTION
SCALE: 1/4"=1'-0"

ARCHITECT:

TAI ARCHITECTURE, INC.
278 NW 37th Street, Miami, FL 33127
p: 305.576.7556 f: 305.576.5772

DO NOT SCALE DRAWING
THIS DRAWING IS THE PROPERTY OF TAI
ARCHITECTURE AND SHALL NOT BE REPRODUCED,
COPIED, LENT OR DISPOSED OF DIRECTLY OR
INDIRECTLY, NOR USED FOR ANY PURPOSE OTHER
THAN THAT FOR WHICH IT IS SPECIFICALLY
FURNISHED AND MUST BE RETURNED TO TAI
ARCHITECTURE ON COMPLETION OF WORK. IF

[illegible]

SEAL

PROJECT NAME / ADDRESS:
PRIVATE RESIDENCE
8 FARREY LANE
MIAMI BEACH, FL 33139

DRAWING TITLE:

PROPOSED SECTIONS

FOR DBB

PROJECT #: 16-M-04

A-2.3.3

SHEET

COPYRIGHT © 2016

COPYRIGHT BY TAI ARCHITECTURE AND DESIGN, INC. AND FFD PRODUCT INC. THIS DRAWING SET IS GIVEN IN CONFIDENCE. NO USE OR DISSEMINATION MAY BE MADE WITHOUT PRIOR WRITTEN CONSENT OF TAI ARCHITECTURE OR FFD PRODUCT. ALL COMMON LAW RIGHTS OF COPYRIGHT AND OTHER WISE ARE HEREBY SPECIFICALLY RESERVED.

Diego Vanderbiest
6200 SW 80 ST
MIAMI, FLORIDA 33143
(305) 528-4001

CONSULTANT



JILL B. COHEN
RLA #0001600

DRAWN
DY



DATE
2/6/17

SCALE
1/4" = 1' - 0"

SHEET

$$\text{TD} = 1$$

OF - SHEETS

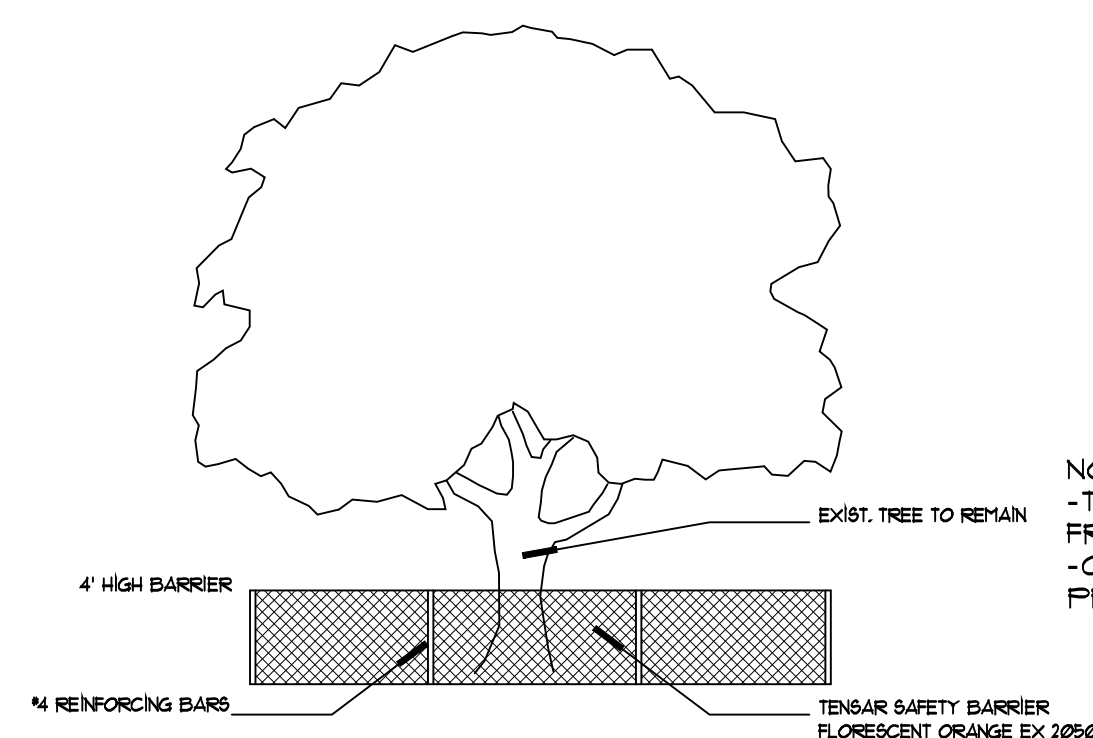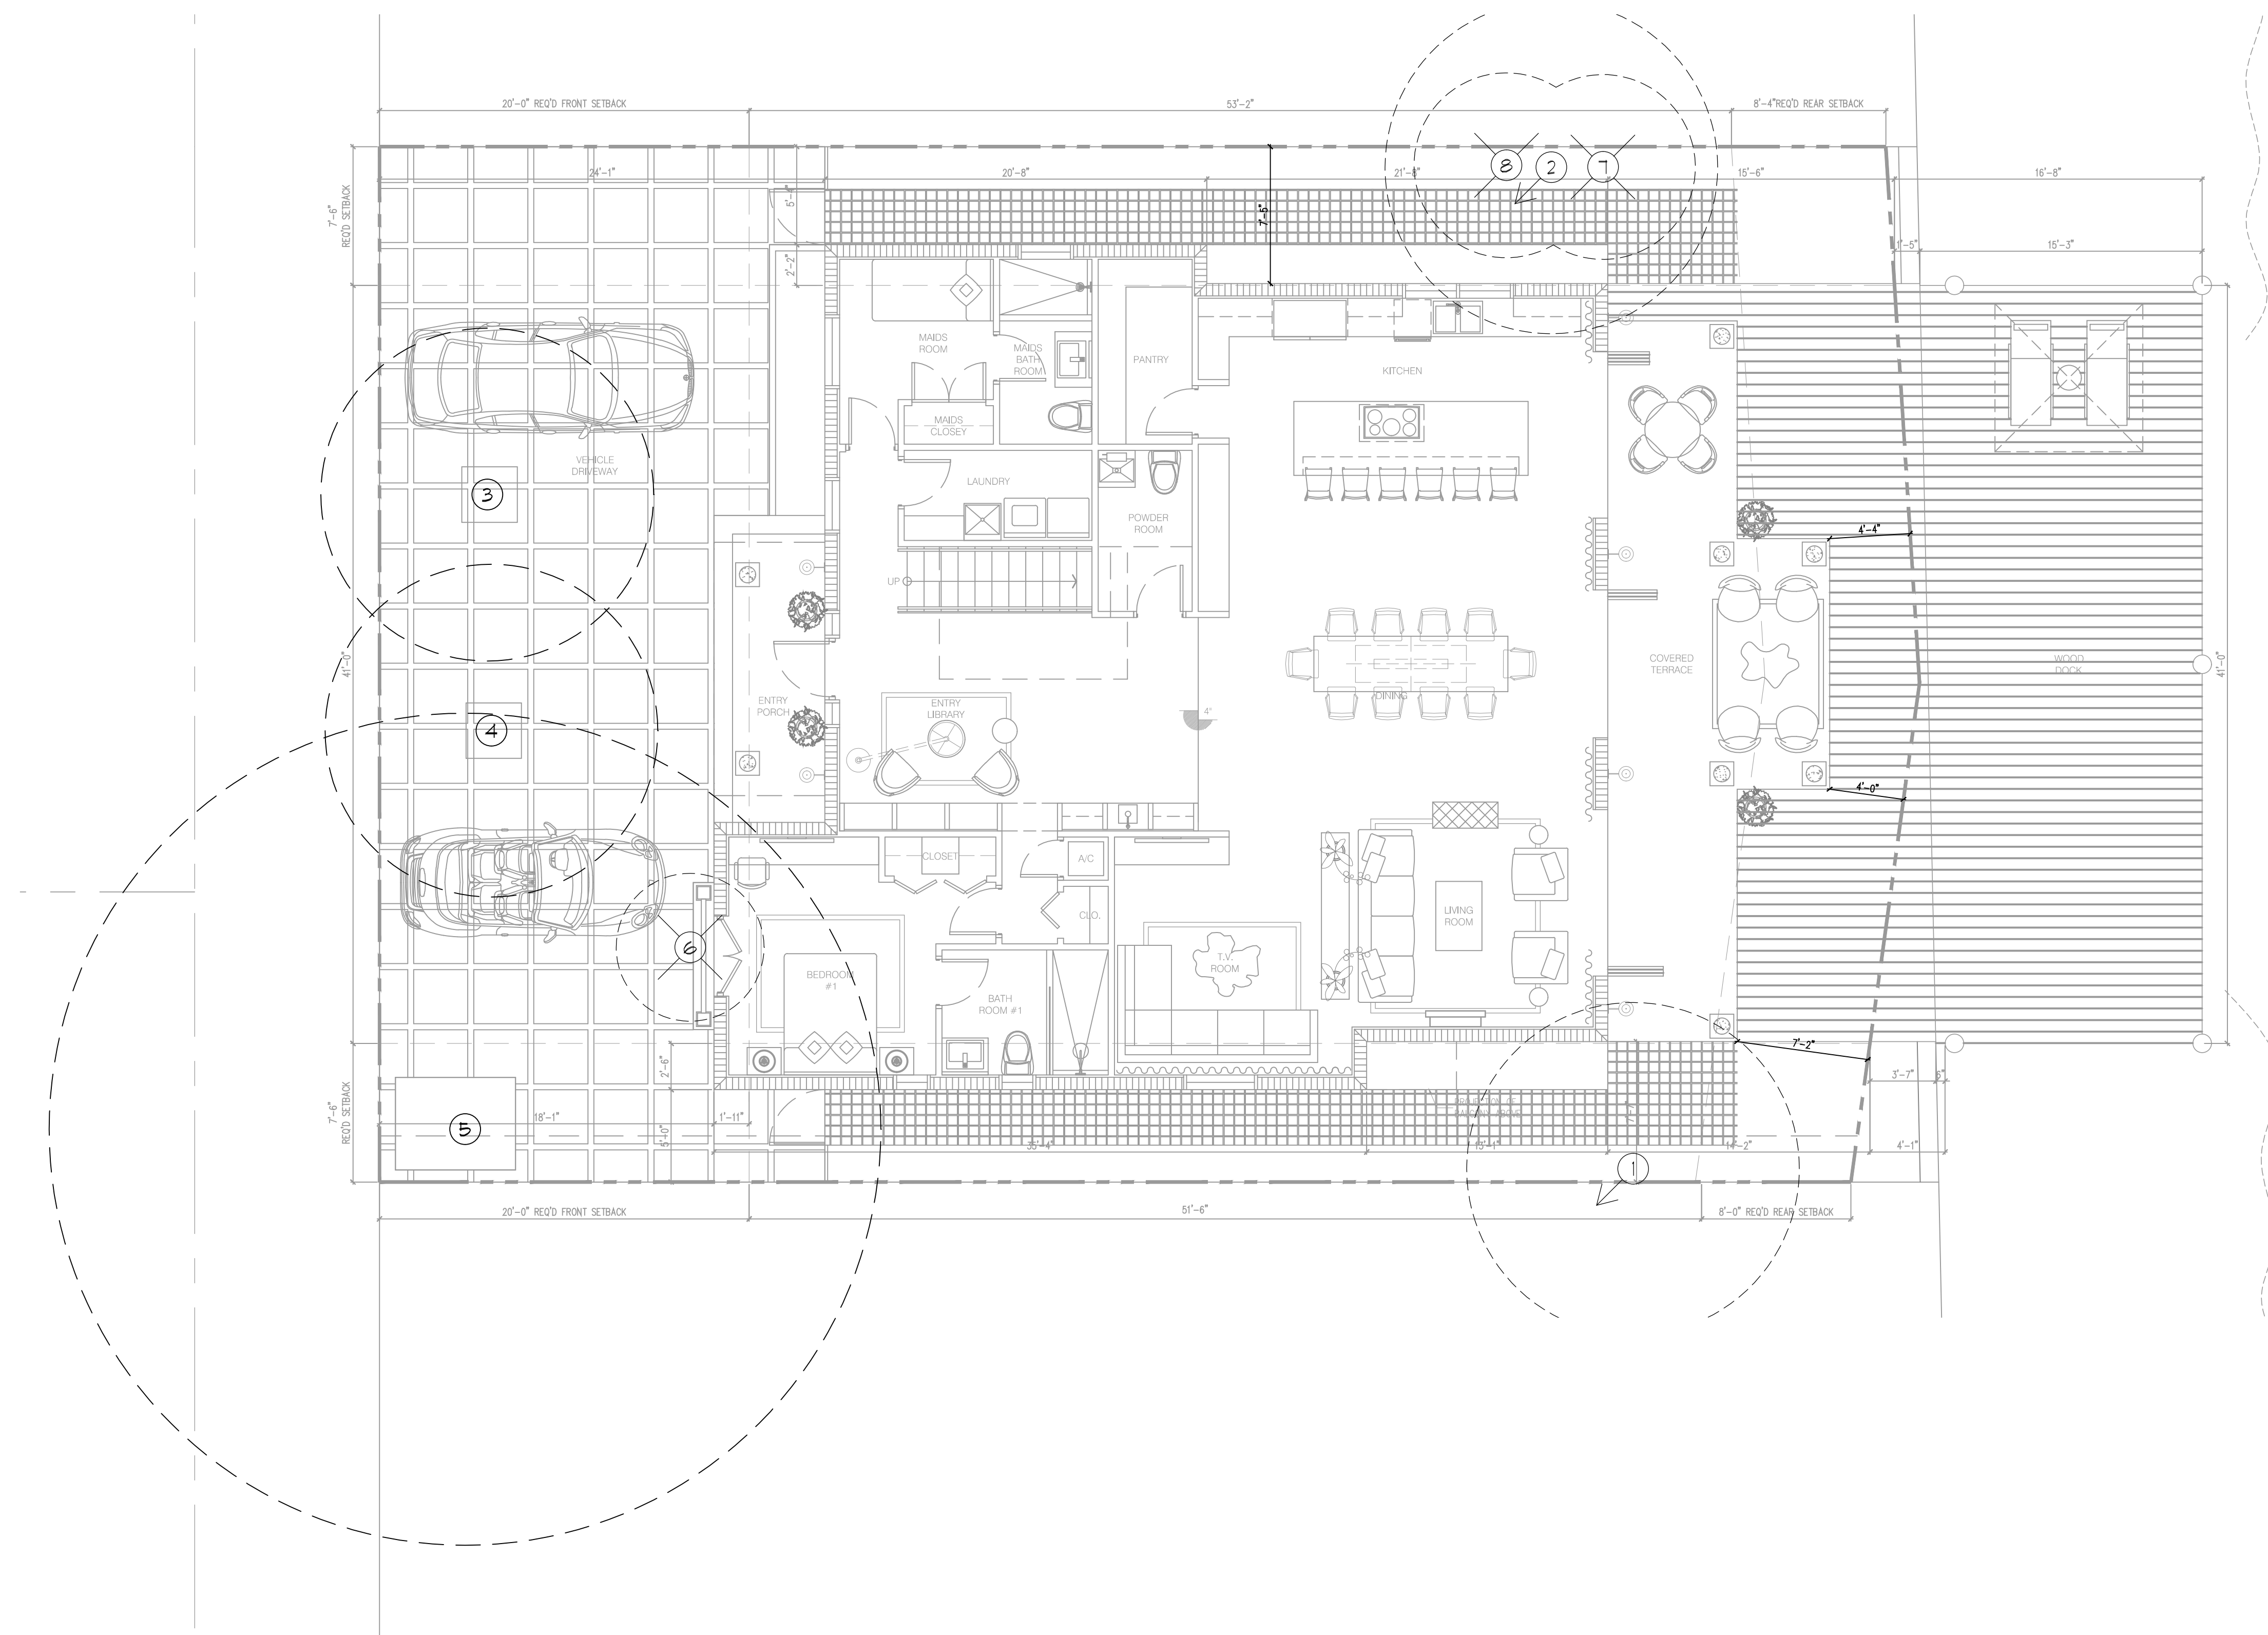

TREE BARRIER DETAIL

N.T.S.

NOTE:


- REFER TO ARCHITECTURAL PLANS FOR PROPOSED UTILITIES. SHOULD LANDSCAPE INTERFERE WITH PROPOSED UTILITIES CONTACT THE LANDSCAPE ARCHITECT TO FIELD ADJUST PROPOSED LANDSCAPE.
- SHOULD PROPOSED UTILITIES INTERFERE WITH EXISTING ROOTS, CONTACT THE LANDSCAPE ARCHITECT. UTILITIES NEED TO BE READJUSTED IN ORDER TO AVOID ANY EXISTING ROOTS.
- THE LANDSCAPE CONTRACTOR SHALL GUARANTEE ALL NEW TREES AND PALMS FOR A PERIOD OF 1-YEAR FROM THE DATE OF INITIAL ACCEPTANCE.
- ALL GUYING AND STAKING SHALL BE REMOVED FROM ALL TREES AND PALMS WITHIN TWELVE MONTHS AFTER PLANTING. EXCEPTIONS REQUIRE WRITTEN AUTHORIZATION FROM THE CITY URBAN FORESTER.
- A FINAL ONSITE INSPECTION SHALL BE REQUIRED WITH URBAN FORESTRY STAFF PRIOR TO ANY ONSITE ACCEPTANCE OF ROW PLANT MATERIAL IN ORDER TO VERIFY PROPER PLANTING DEPTH, SPACING AND QUALITY OF MATERIAL. FAILURE TO CONDUCT THE INSPECTION COULD RESULT IN REJECTION OF THE PLANT MATERIAL.

Tree Disposition						
No	Botanical Name	Common Name	DBH (in)	Height (ft)	Spread (ft)	Disposition
1	Cocos nucidera	Coconut Palm	10	28	16	Relocate
2	Cocos nucidera	Coconut Palm	10	27	16	Relocate
3	Cocos nucidera	Coconut Palm	10	27	16	Remain
4	Cocos nucidera	Coconut Palm	10	30	16	Remain
5	Bucidas buceras	Black Olive	36	35	50	Remain
6	Ravenala madagascariensis	Traveler's Palm	11	12	10	Remove
7	Adonia merillii	Christmas Palm	17	17	10	Remove
8	Adonia merillii	Christmas Palm	17	17	10	Remove



PLANT NOTES

1. ALL PLANT MATERIAL TO BE FLORIDA NO. 1 OR BETTER FLORIDA DEPARTMENT OF AGRICULTURE GRADES AND STANDARDS: PARTS I AND II, 2ND EDITION: FEBRUARY 1998, RESPECTIVELY.
2. ALL PLANTING BEDS TO BE TOPPED WITH 3" MULCH EXCLUDING TOP OF ROOT BALL (SEE PALM/ TREE PLANTING DETAIL).
3. ALL TREES TO BE STAKED IN A GOOD WORKMANLIKE MANNER, NO NAIL STAKING IN TRUNKS PERMITTED.
4. LANDSCAPE PLAN SHALL BE INSTALLED IN COMPLIANCE WITH ALL LOCAL CODES.
5. ALL SOD SHALL BE ST. AUGUSTINE 'FLORATAM' SOLID SOD, (UNLESS OTHERWISE NOTED) AND LAID WITH ALTERNATING AND ABUTTING JOINTS.
6. ALL PLANTING BEDS TO BE WEED AND GRASS FREE.
7. LANDSCAPE CONTRACTOR SHALL REVIEW ALL DRAWINGS AND PREPARE ONE'S OWN QUANTITY COUNTS (PRIOR TO BID COST AND COMPARE TO ARCHITECT'S PLANT LIST). LANDSCAPE CONTRACTOR IS RESPONSIBLE FOR ATTAINING ACCURATE COUNT OF PLANT MATERIALS SPECIFIED. IN THE EVENT OF DISCREPANCIES, LANDSCAPE CONTRACTORS SHALL BRING TO THE ATTENTION OF LANDSCAPE ARCHITECT. PLAN SHALL TAKE PRECEDENCE OVER PLANT LIST.
8. LANDSCAPE CONTRACTOR SHALL LOCATE AND VERIFY ALL UNDERGROUND UTILITIES PRIOR TO DIGGING.
9. NO CHANGES SHALL BE MADE WITHOUT THE PRIOR CONSENT OF THE LANDSCAPE ARCHITECT.
10. ALL PLANTED AREAS TO RECEIVE 100% COVERAGE BY AN AUTOMATIC IRRIGATION SYSTEM, WITH A MINIMUM OF 50% OVERLAP. RAIN SENSOR TO BE PROVIDED.

- NOTE:
- REFER TO ARCHITECTURAL PLANS FOR PROPOSED UTILITIES. SHOULD LANDSCAPE INTERFERE WITH PROPOSED UTILITIES CONTACT THE LANDSCAPE ARCHITECT TO FIELD ADJUST PROPOSED LANDSCAPE.
 - SHOULD PROPOSED UTILITIES INTERFERE WITH EXISTING ROOTS, CONTACT THE LANDSCAPE ARCHITECT. UTILITIES NEED TO BE READJUSTED IN ORDER TO AVOID ANY EXISTING ROOTS.
 - THE LANDSCAPE CONTRACTOR SHALL GUARANTEE ALL NEW TREES AND PALMS FOR A PERIOD OF 1-YEAR FROM THE DATE OF INITIAL ACCEPTANCE.
 - ALL GUYING AND STAKING SHALL BE REMOVED FROM ALL TREES AND PALMS WITHIN TWELVE MONTHS AFTER PLANTING. EXCEPTIONS REQUIRE WRITTEN AUTHORIZATION FROM THE CITY URBAN FORESTER.
 - A FINAL ON-SITE INSPECTION SHALL BE REQUIRED WITH URBAN FORESTRY STAFF PRIOR TO ANY OFFICIAL ACCEPTANCE OF ROW PLANT MATERIAL IN ORDER TO VERIFY PROPER PLANTING DEPTH, SPACING AND QUALITY OF MATERIAL. FAILURE TO CONDUCT THE INSPECTION COULD RESULT IN REJECTION OF THE PLANT MATERIAL.

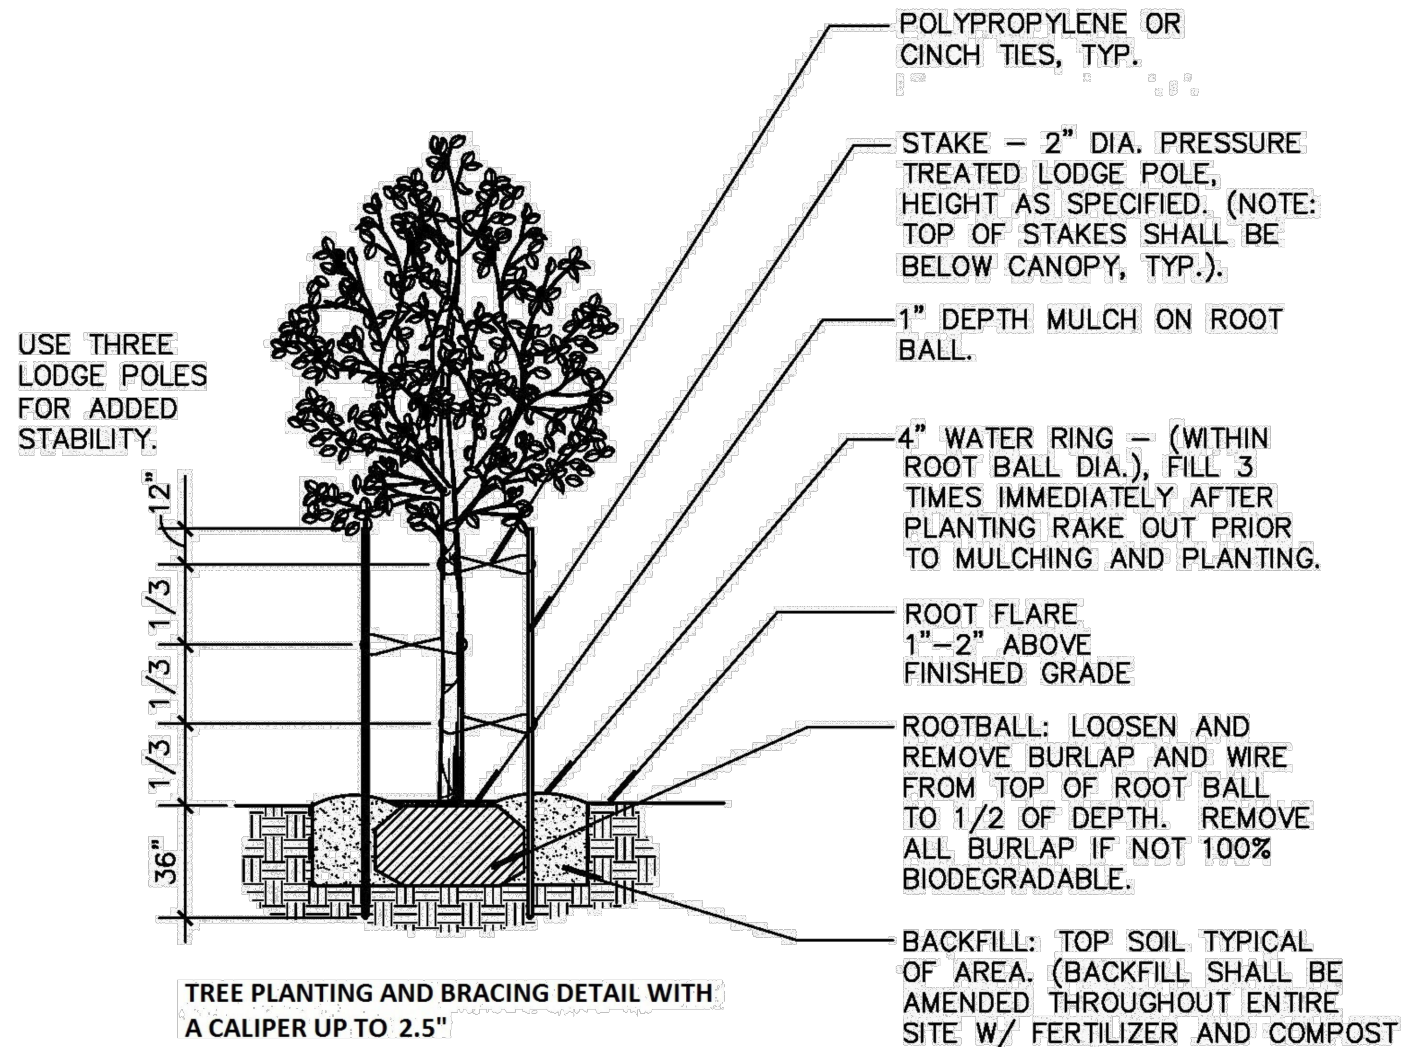


- NOTES
1. MULCH SHALL BE AMERIGROW RECYCLED PREMIUM PINEBARK BROWN OR CITY APPROVED EQUIVALENT.
 2. DO NOT APPLY MULCH WITHIN 6" OF THE TREE TRUNK

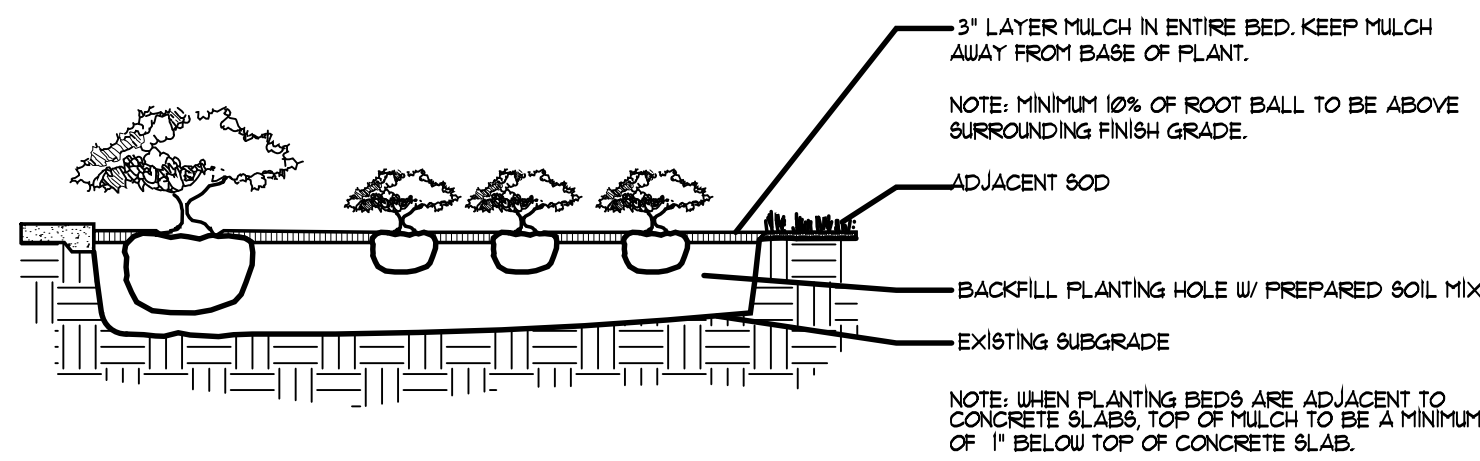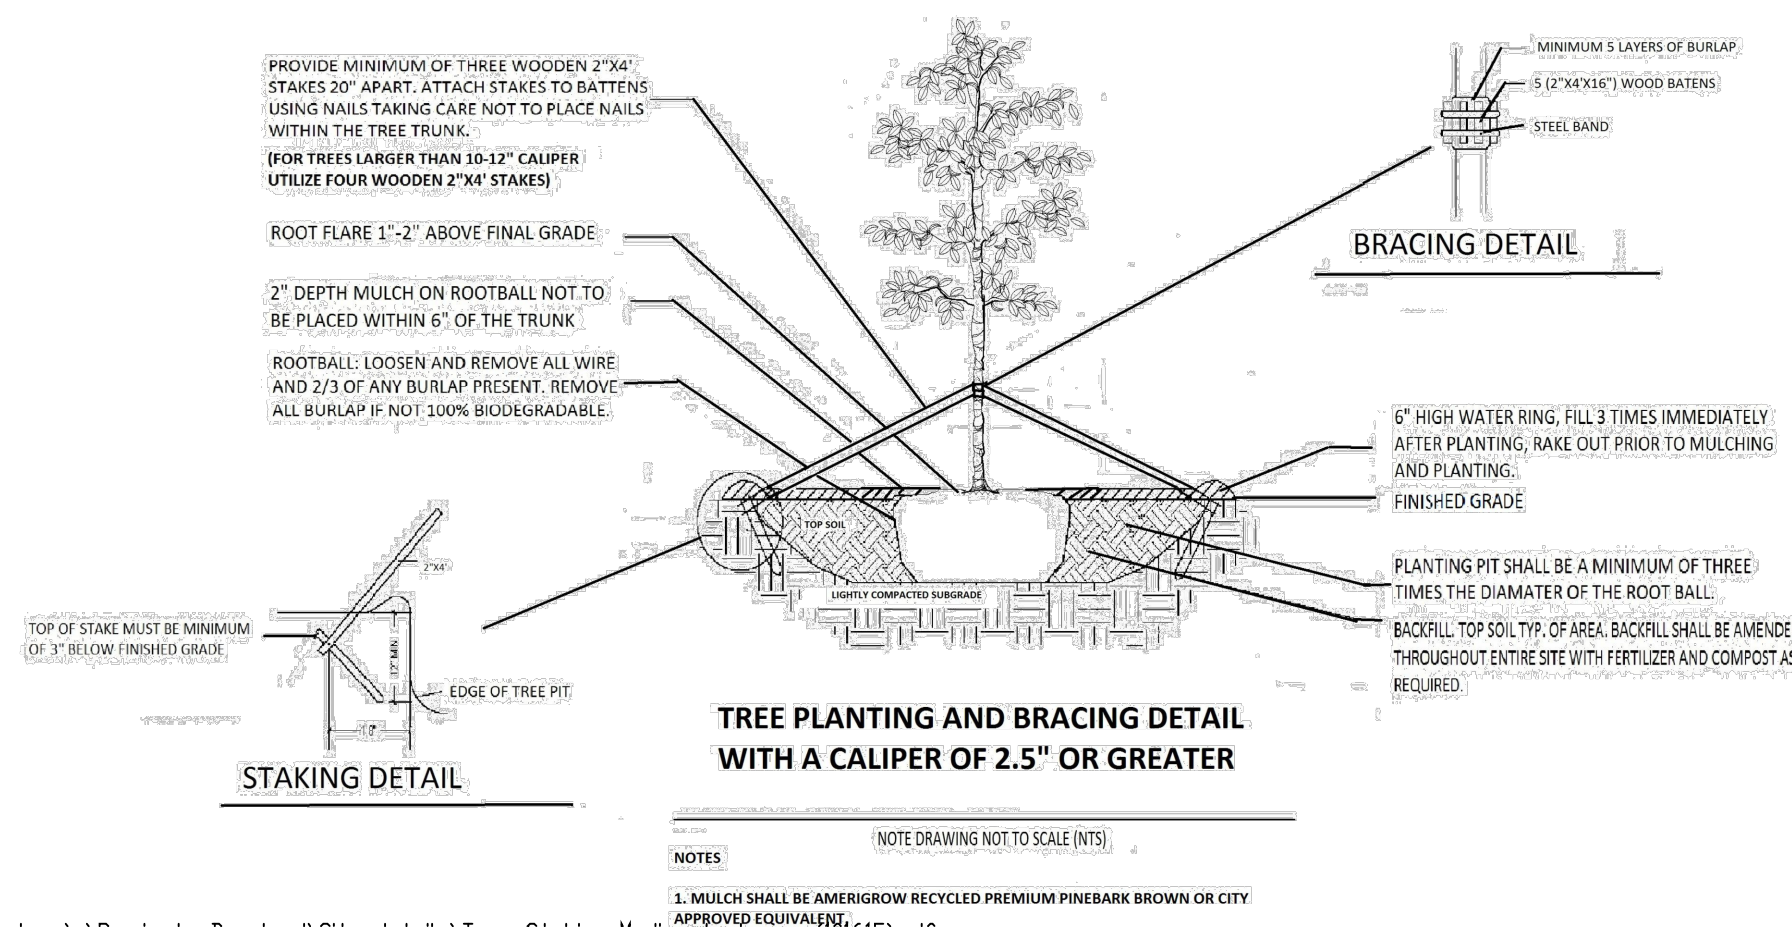

SHRUB/GROUND COVER DETAIL

N.T.S.

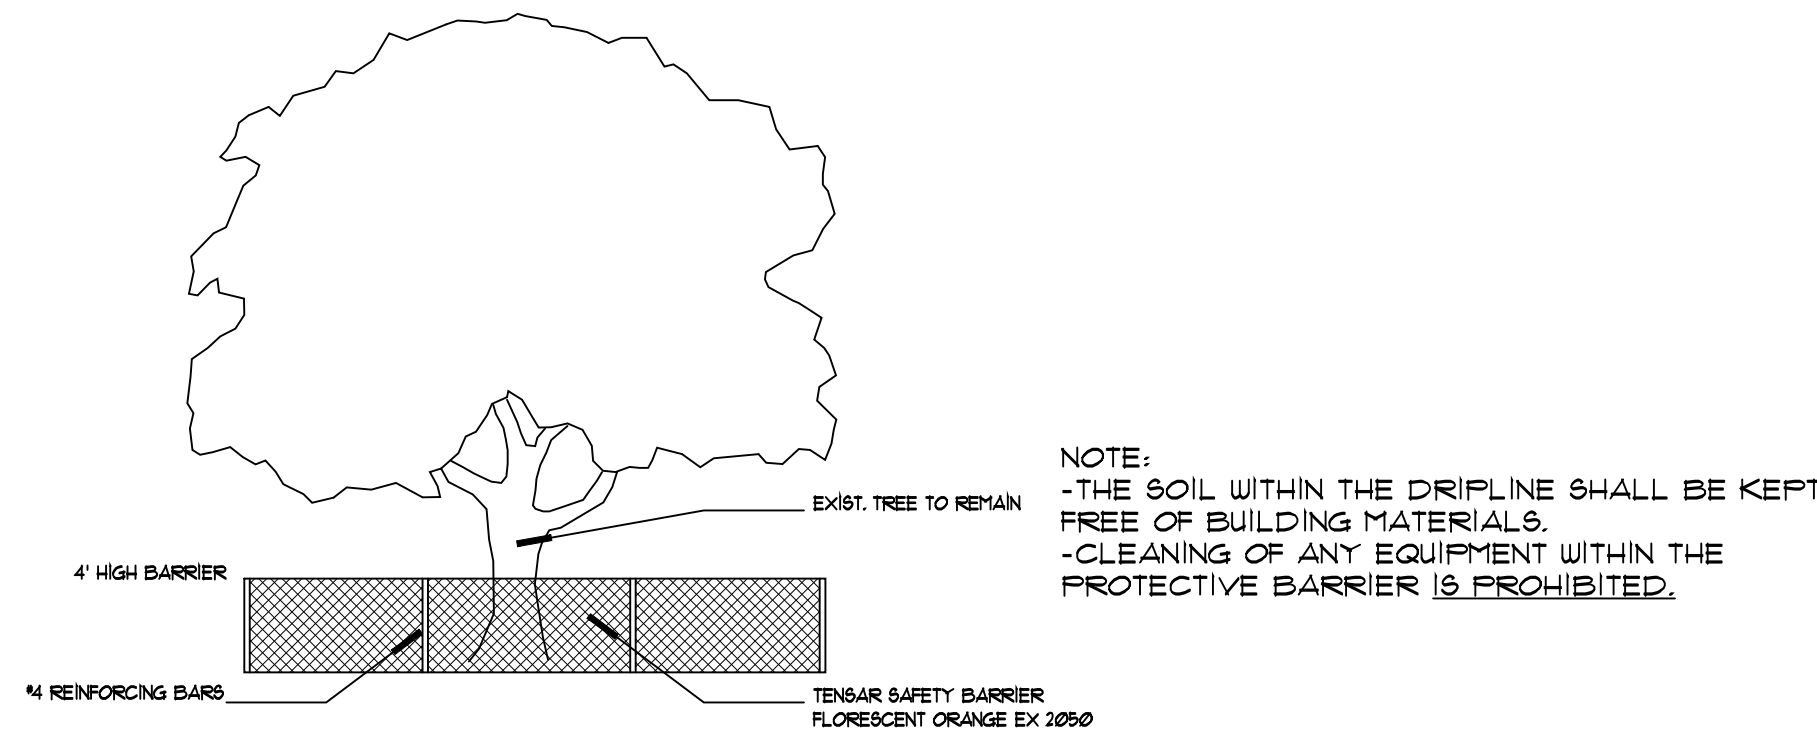

TREE BARRIER DETAIL

N.T.S.