


PERMIT #

89802981

ADDRESS

1601 N. Biscayne Ave
Miami Beach

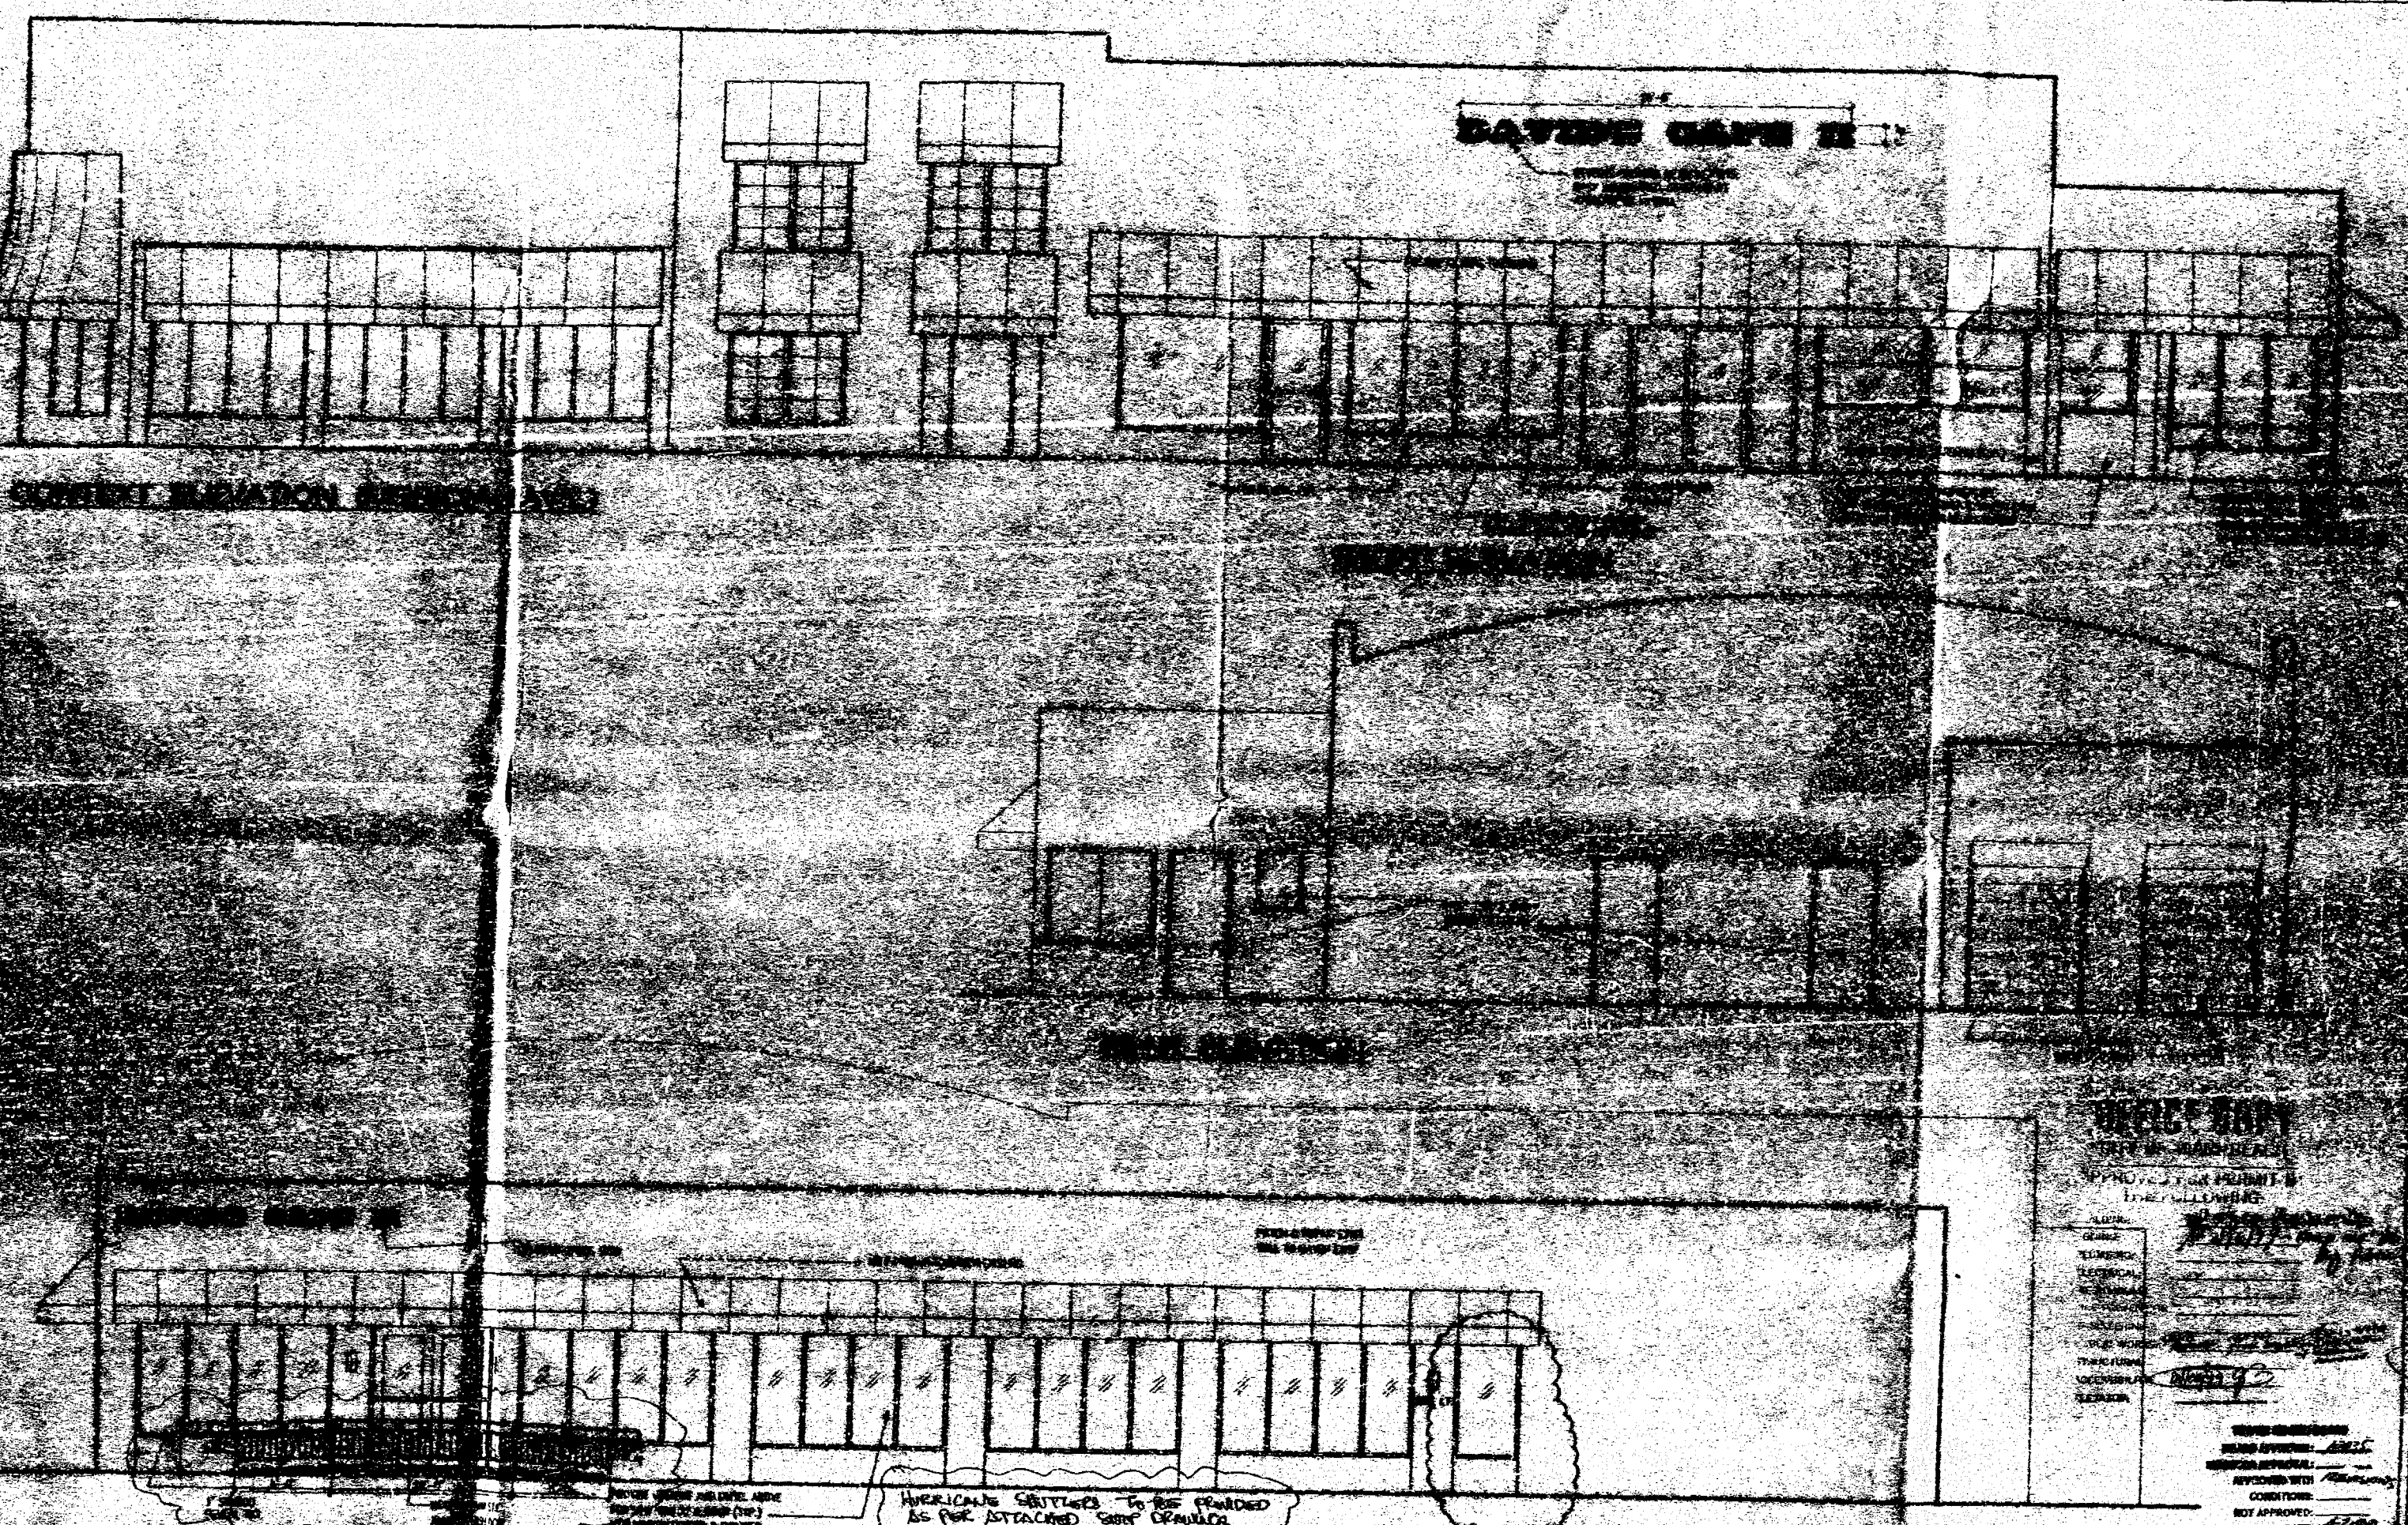

DAVIDE CAMP II

FRONT ELEVATION

RIGHT ELEVATION

FRONT ELEVATION


RIGHT ELEVATION

HURRICANE SHUTTERS TO BE PROVIDED AS PER ATTACHED SHOP DRAWINGS AND CALCULATIONS.



PROPOSED EXTERIOR ELEVATIONS

OFFICE COPY
 STATE OF FLORIDA
 DEPARTMENT OF COMMUNITY DEVELOPMENT
 DIVISION OF BUILDING PERMITS
 APPROVED FOR PERMIT BY
 DATE: 1/27/93
 BY: [Signature]
 PROJECT NO.: 93-0000000000
 PROJECT NAME: [Blank]
 PROJECT ADDRESS: [Blank]
 PROJECT CITY: [Blank]
 PROJECT COUNTY: [Blank]
 PROJECT ZIP: [Blank]
 PROJECT PHONE: [Blank]
 PROJECT FAX: [Blank]
 PROJECT E-MAIL: [Blank]
 PROJECT WEBSITE: [Blank]
 PROJECT DESCRIPTION: [Blank]
 PROJECT DRAWING NO.: [Blank]
 PROJECT DRAWING DATE: [Blank]
 PROJECT DRAWING BY: [Blank]
 PROJECT DRAWING CHECKED BY: [Blank]
 PROJECT DRAWING APPROVED BY: [Blank]
 PROJECT DRAWING APPROVED DATE: [Blank]
 PROJECT DRAWING APPROVED BY: [Blank]


A-3

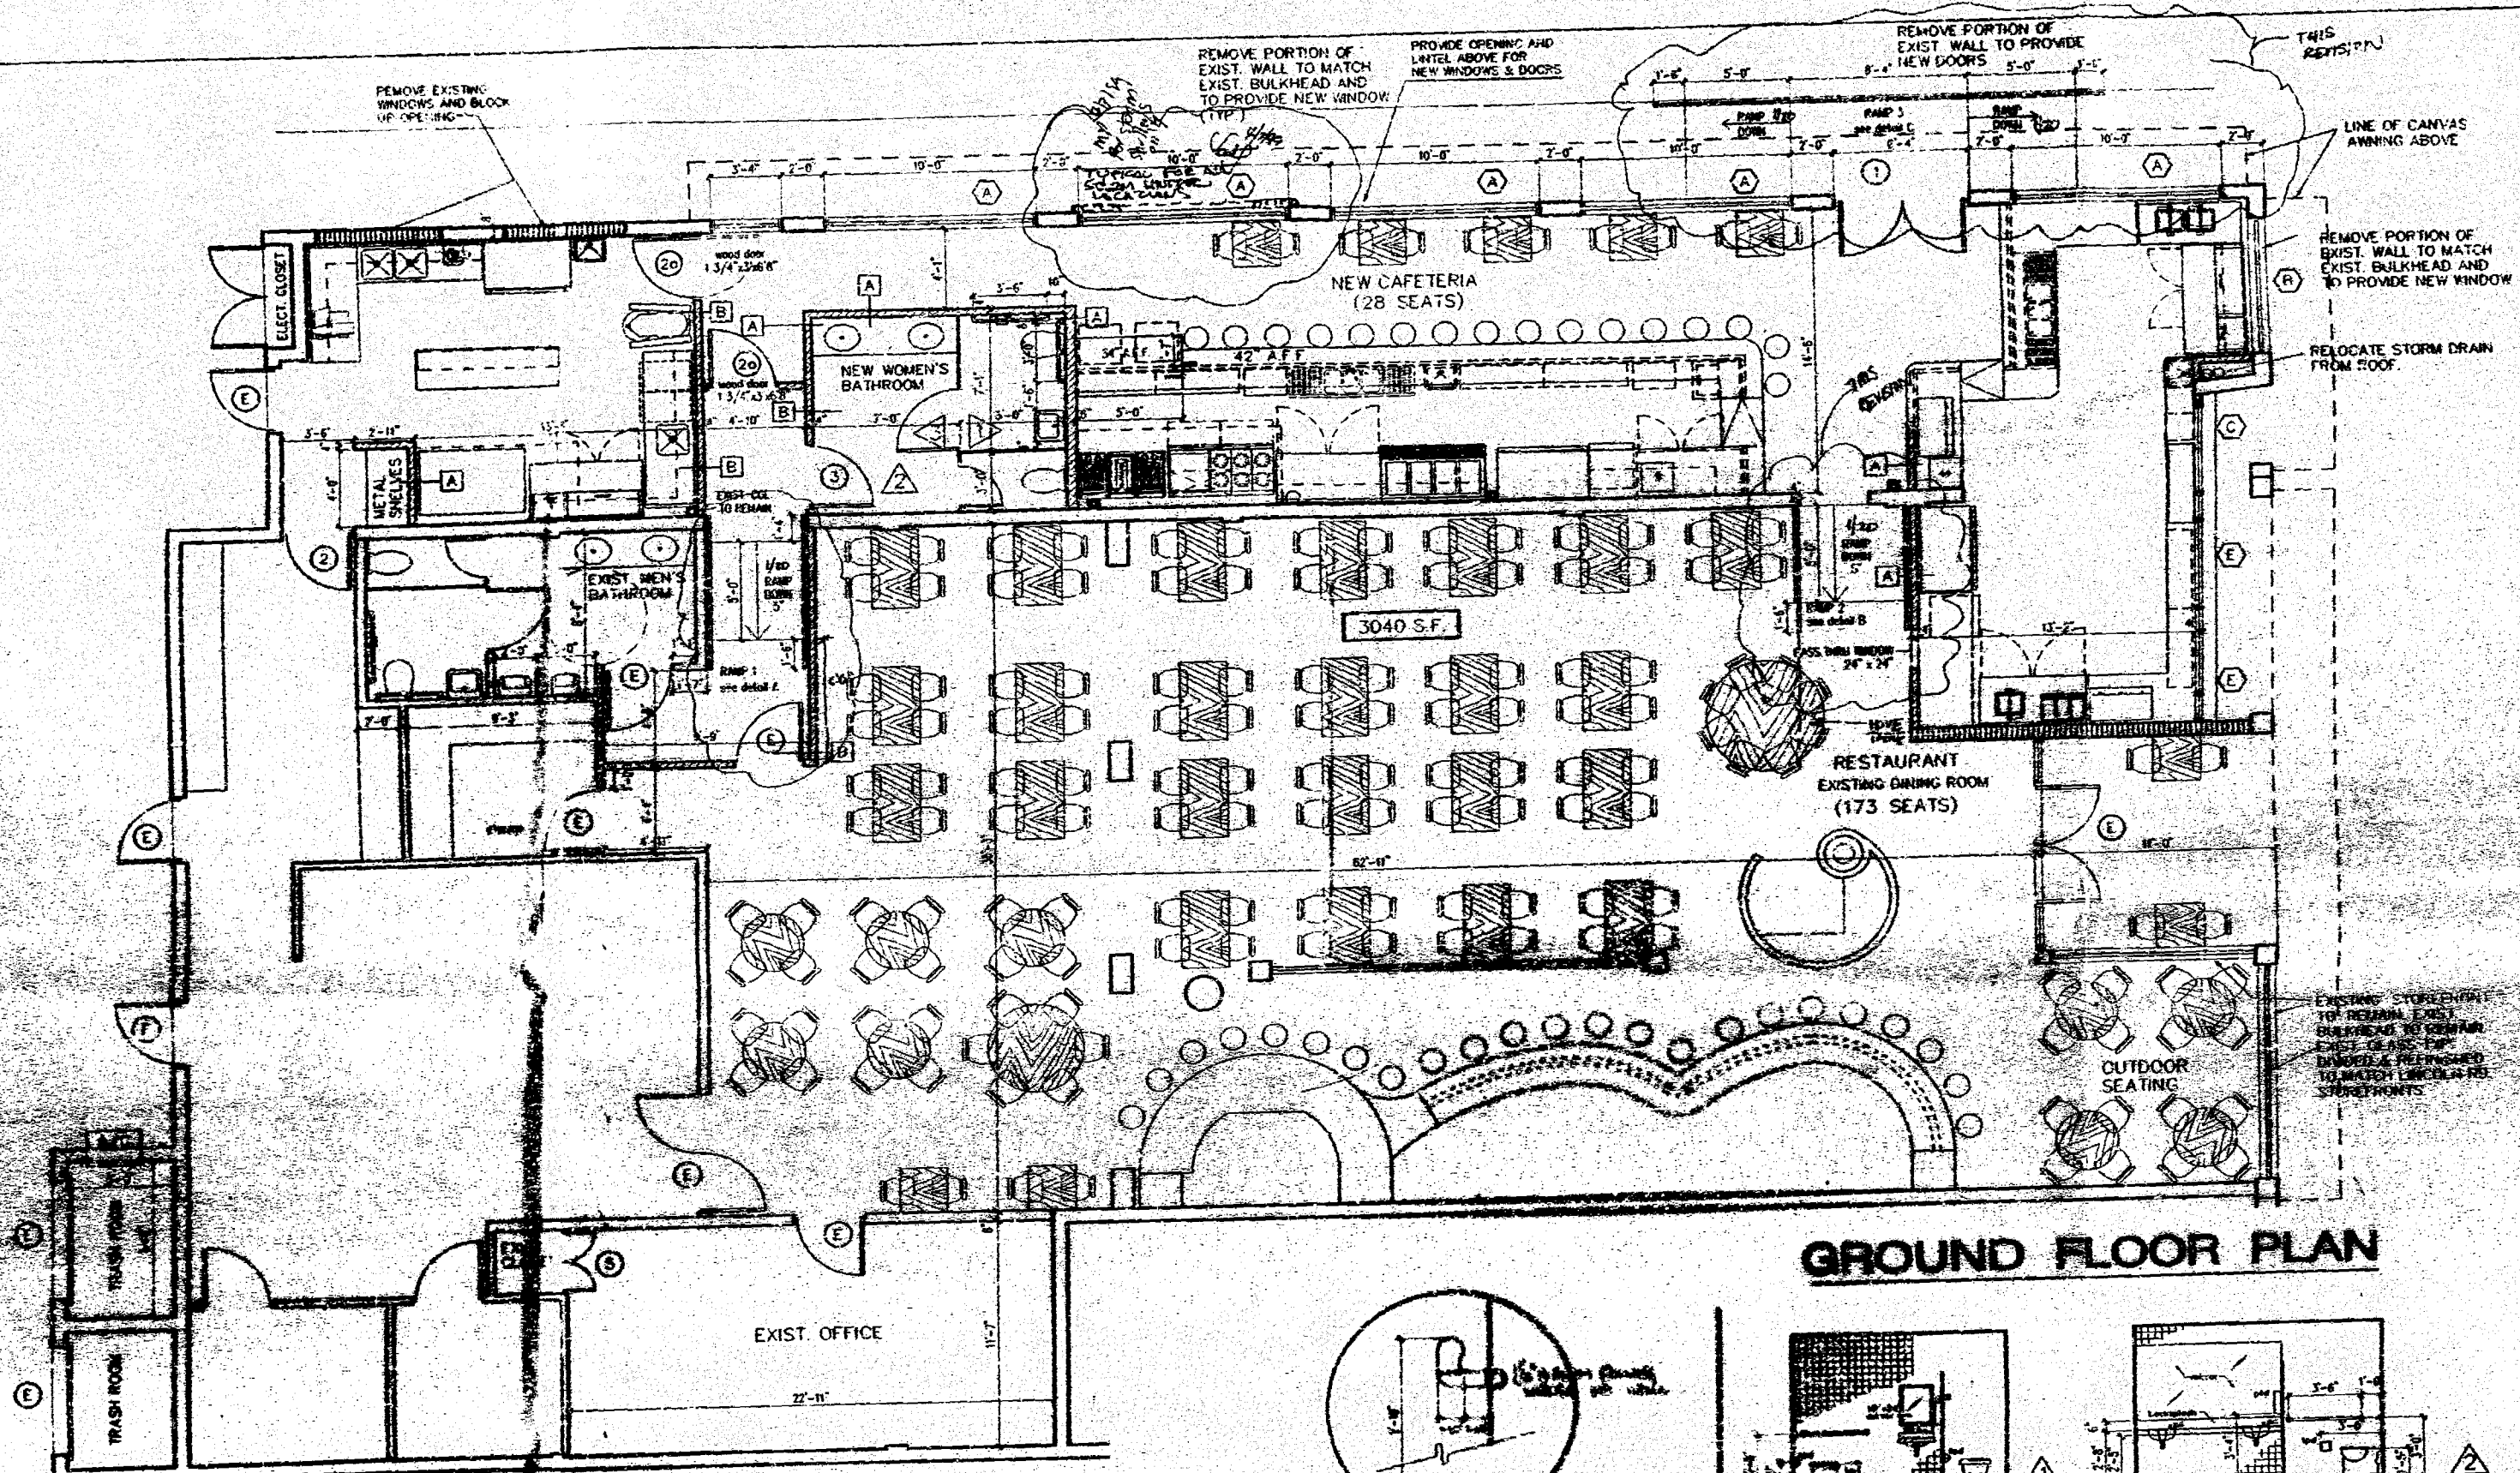

GROUND FLOOR PLAN

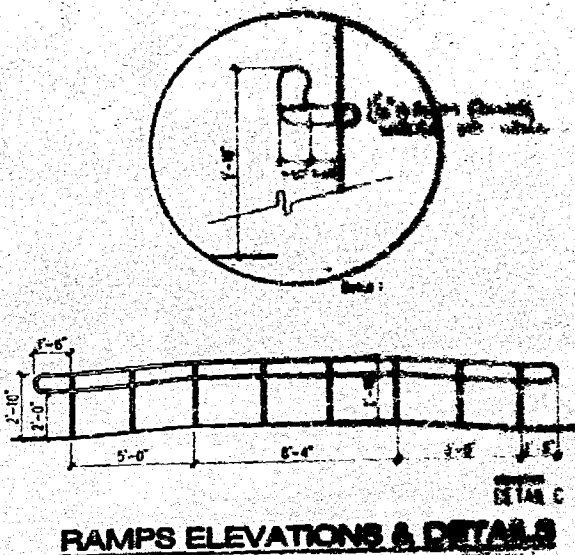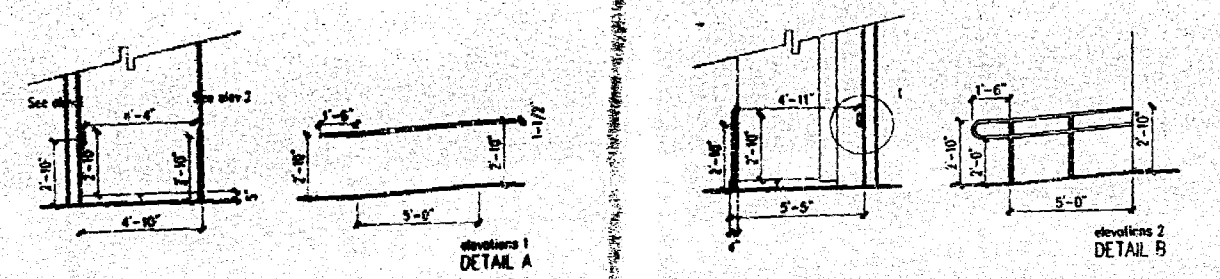


RAMPS ELEVATIONS & DETAILS

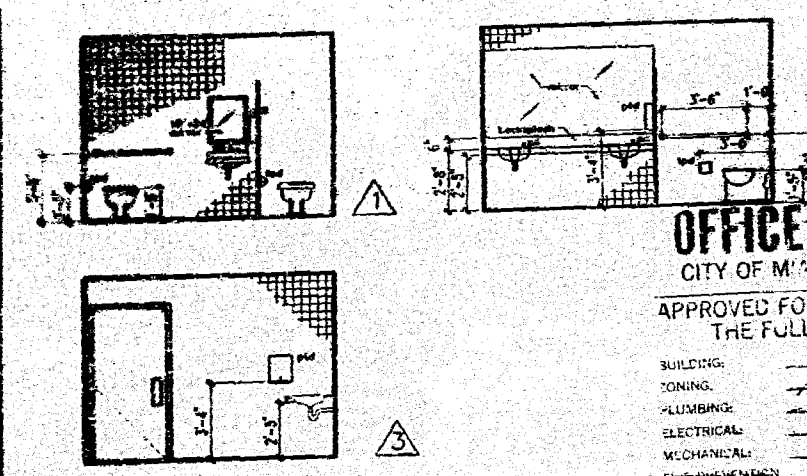

WOMEN RESTROOM INTERIOR ELEVATIONS

OFFICE COPY
CITY OF MIAMI BEACH
APPROVED FOR PERMIT BY
THE FOLLOWING:

BUILDING: W. J. J. J.
PLUMBING: W. J. J. J.
ELECTRICAL: W. J. J. J.
MECHANICAL: W. J. J. J.

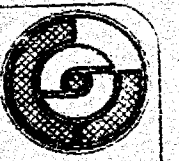

GAMBACH-SKLAR
ARCHITECTS, INC.


DAVID S. II
HURRICANE HURRICANE HURRICANE

1/4"=1'-0"

B.G.V.
98-794

A-2

GAMBACH SKLAR INC.

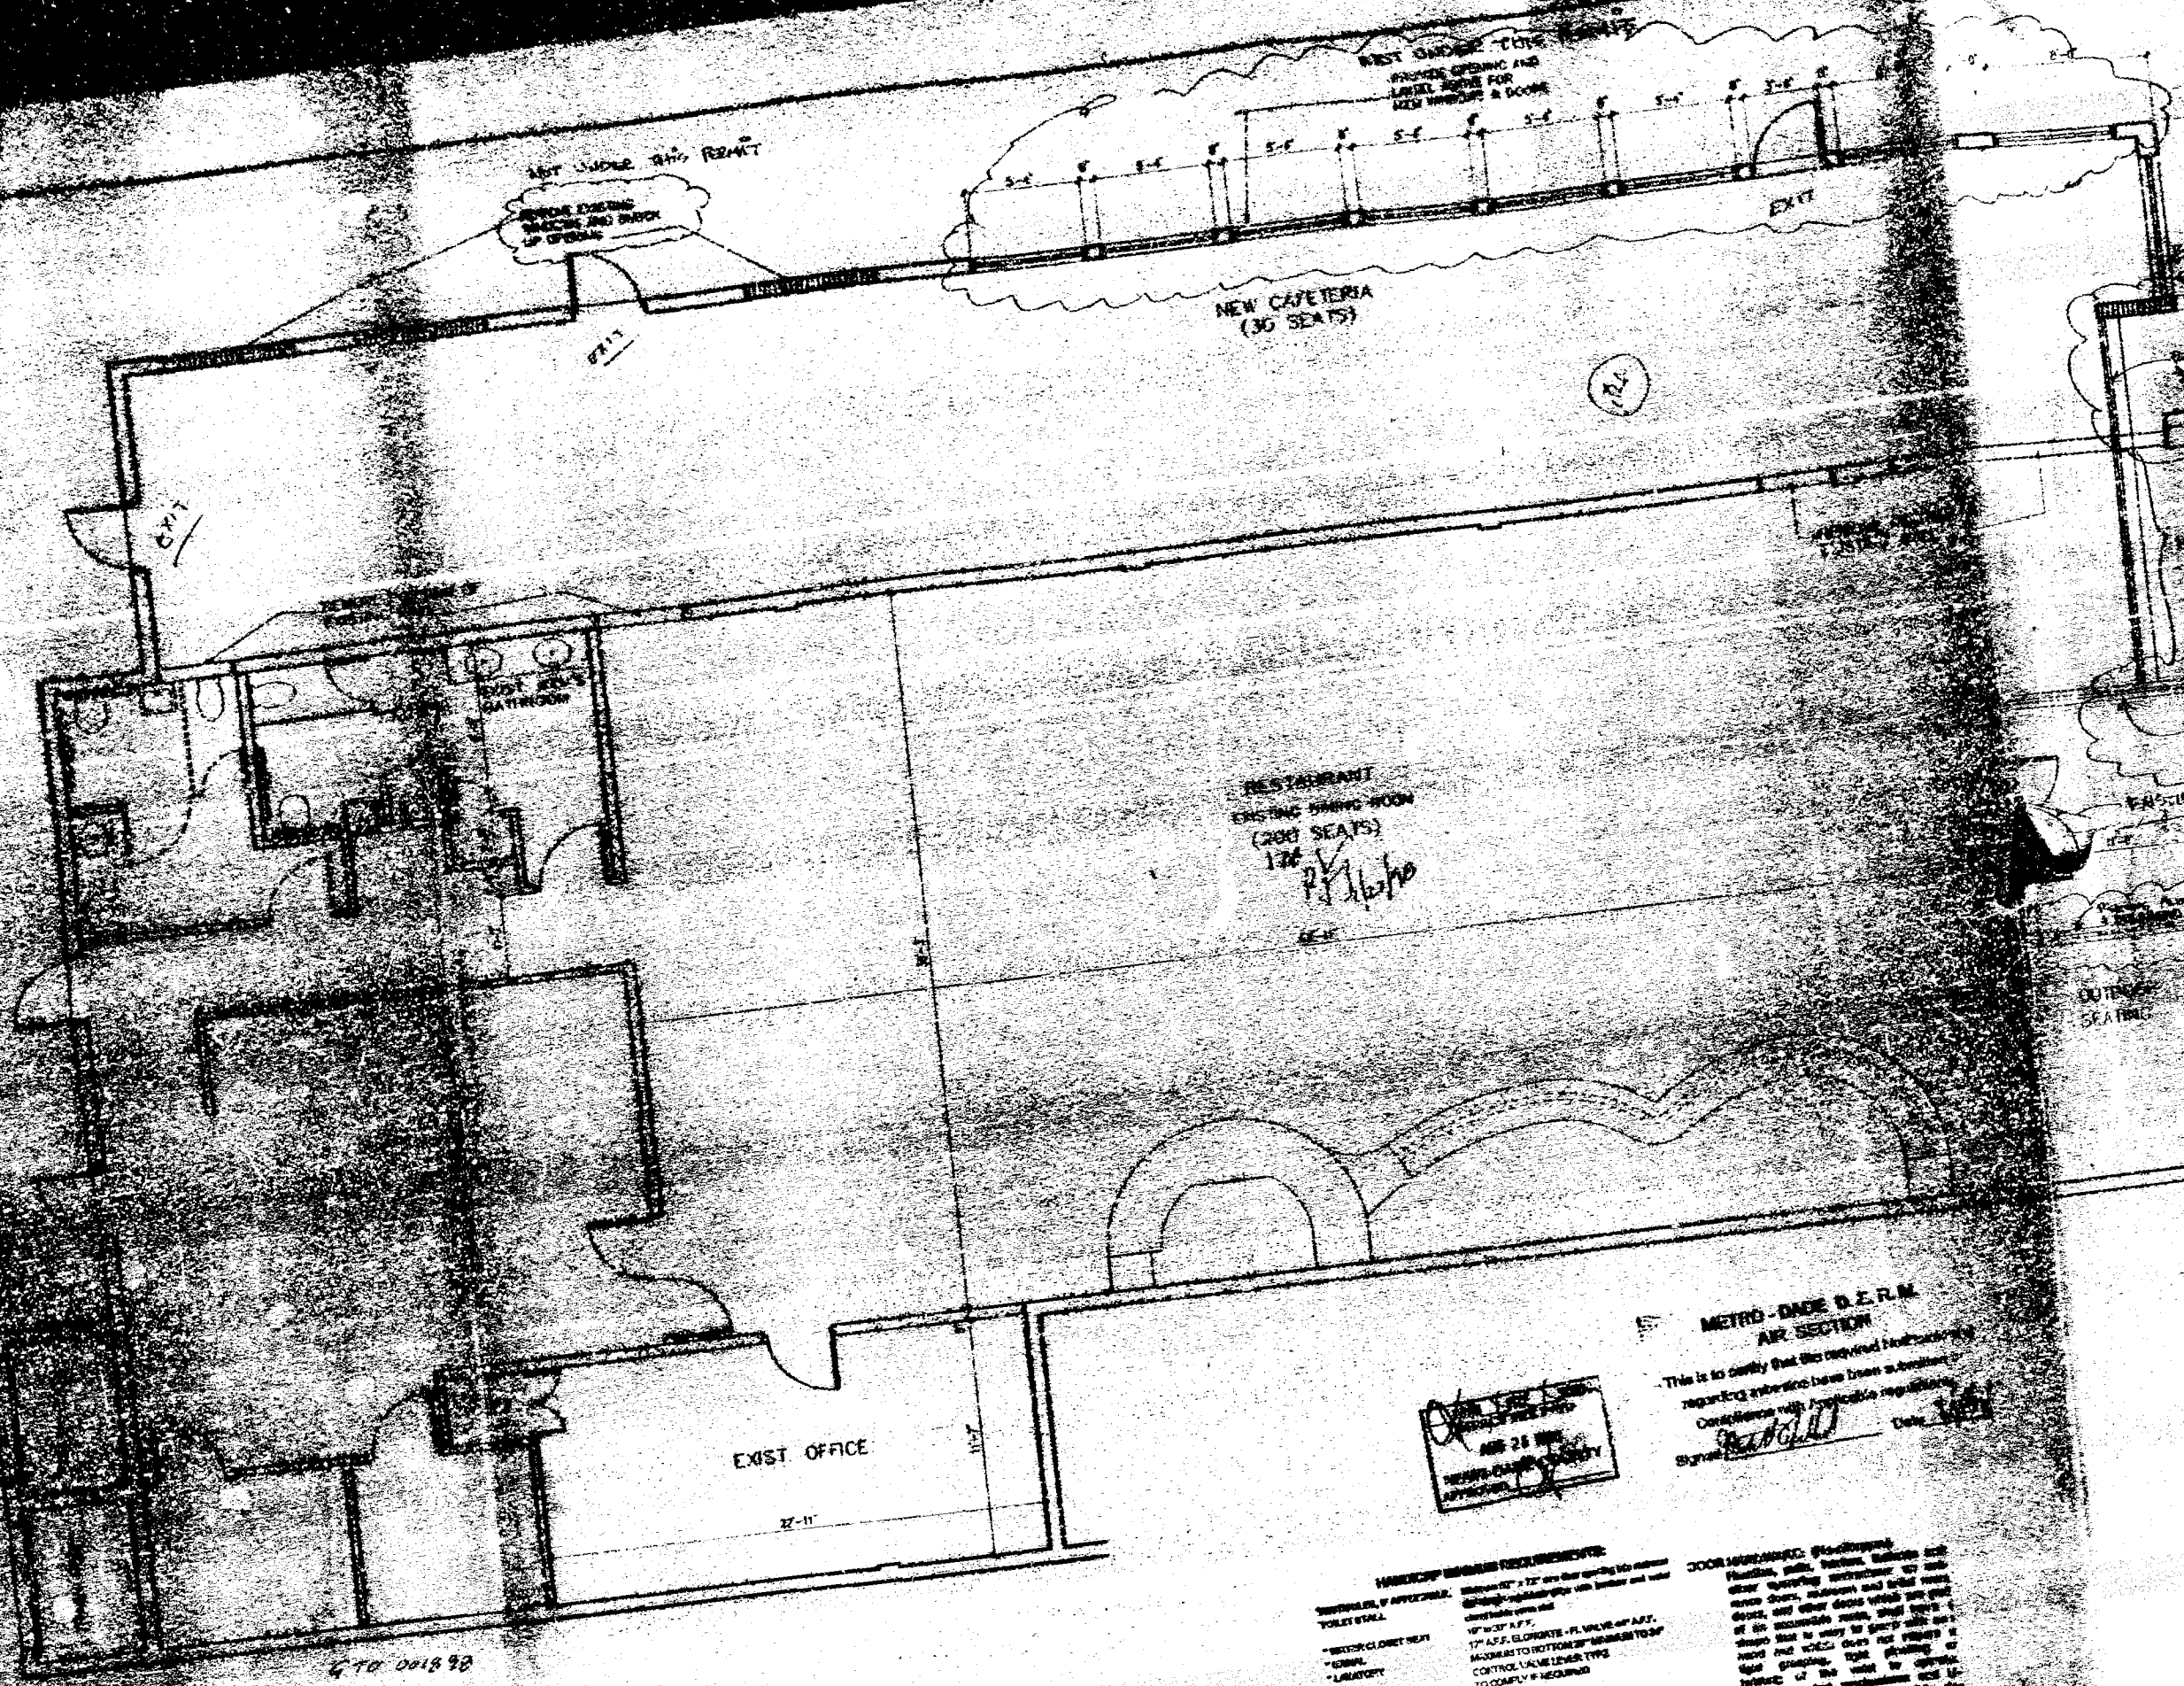

OFFICE COPY
CITY OF INDIAN BEACH

APPROVED FOR PERMIT BY
THE FOLLOWING:


ARCHITECT: *[Signature]*
ENGINEER: *[Signature]*
PLUMBING: *[Signature]*
ELECTRICAL: *[Signature]*
MECHANICAL: *[Signature]*
FIRE PREVENTION: *[Signature]*
ENGINEERING: *[Signature]*
PUBLIC WORKS: *[Signature]*
STRUCTURAL: *[Signature]*
ACCESSIBILITY: *[Signature]*
CLEANLINESS: *[Signature]*

DEMOLITION PLAN

1/4" = 1'-0"
B.C.V.
98-794
A-1

MINIMUM REQUIREMENTS:
SINKS, IF APPLICABLE: 18" x 24" x 12" are the minimum size for sinks and must be made of stainless steel.
CUPBOARD: 18" x 24" x 12" are the minimum size for cupboards and must be made of stainless steel.
COUNTER: 18" x 24" x 12" are the minimum size for counters and must be made of stainless steel.
SINKS: 18" x 24" x 12" are the minimum size for sinks and must be made of stainless steel.
CUPBOARD: 18" x 24" x 12" are the minimum size for cupboards and must be made of stainless steel.
COUNTER: 18" x 24" x 12" are the minimum size for counters and must be made of stainless steel.


FOOD SERVICE PERMIT
1-99-58

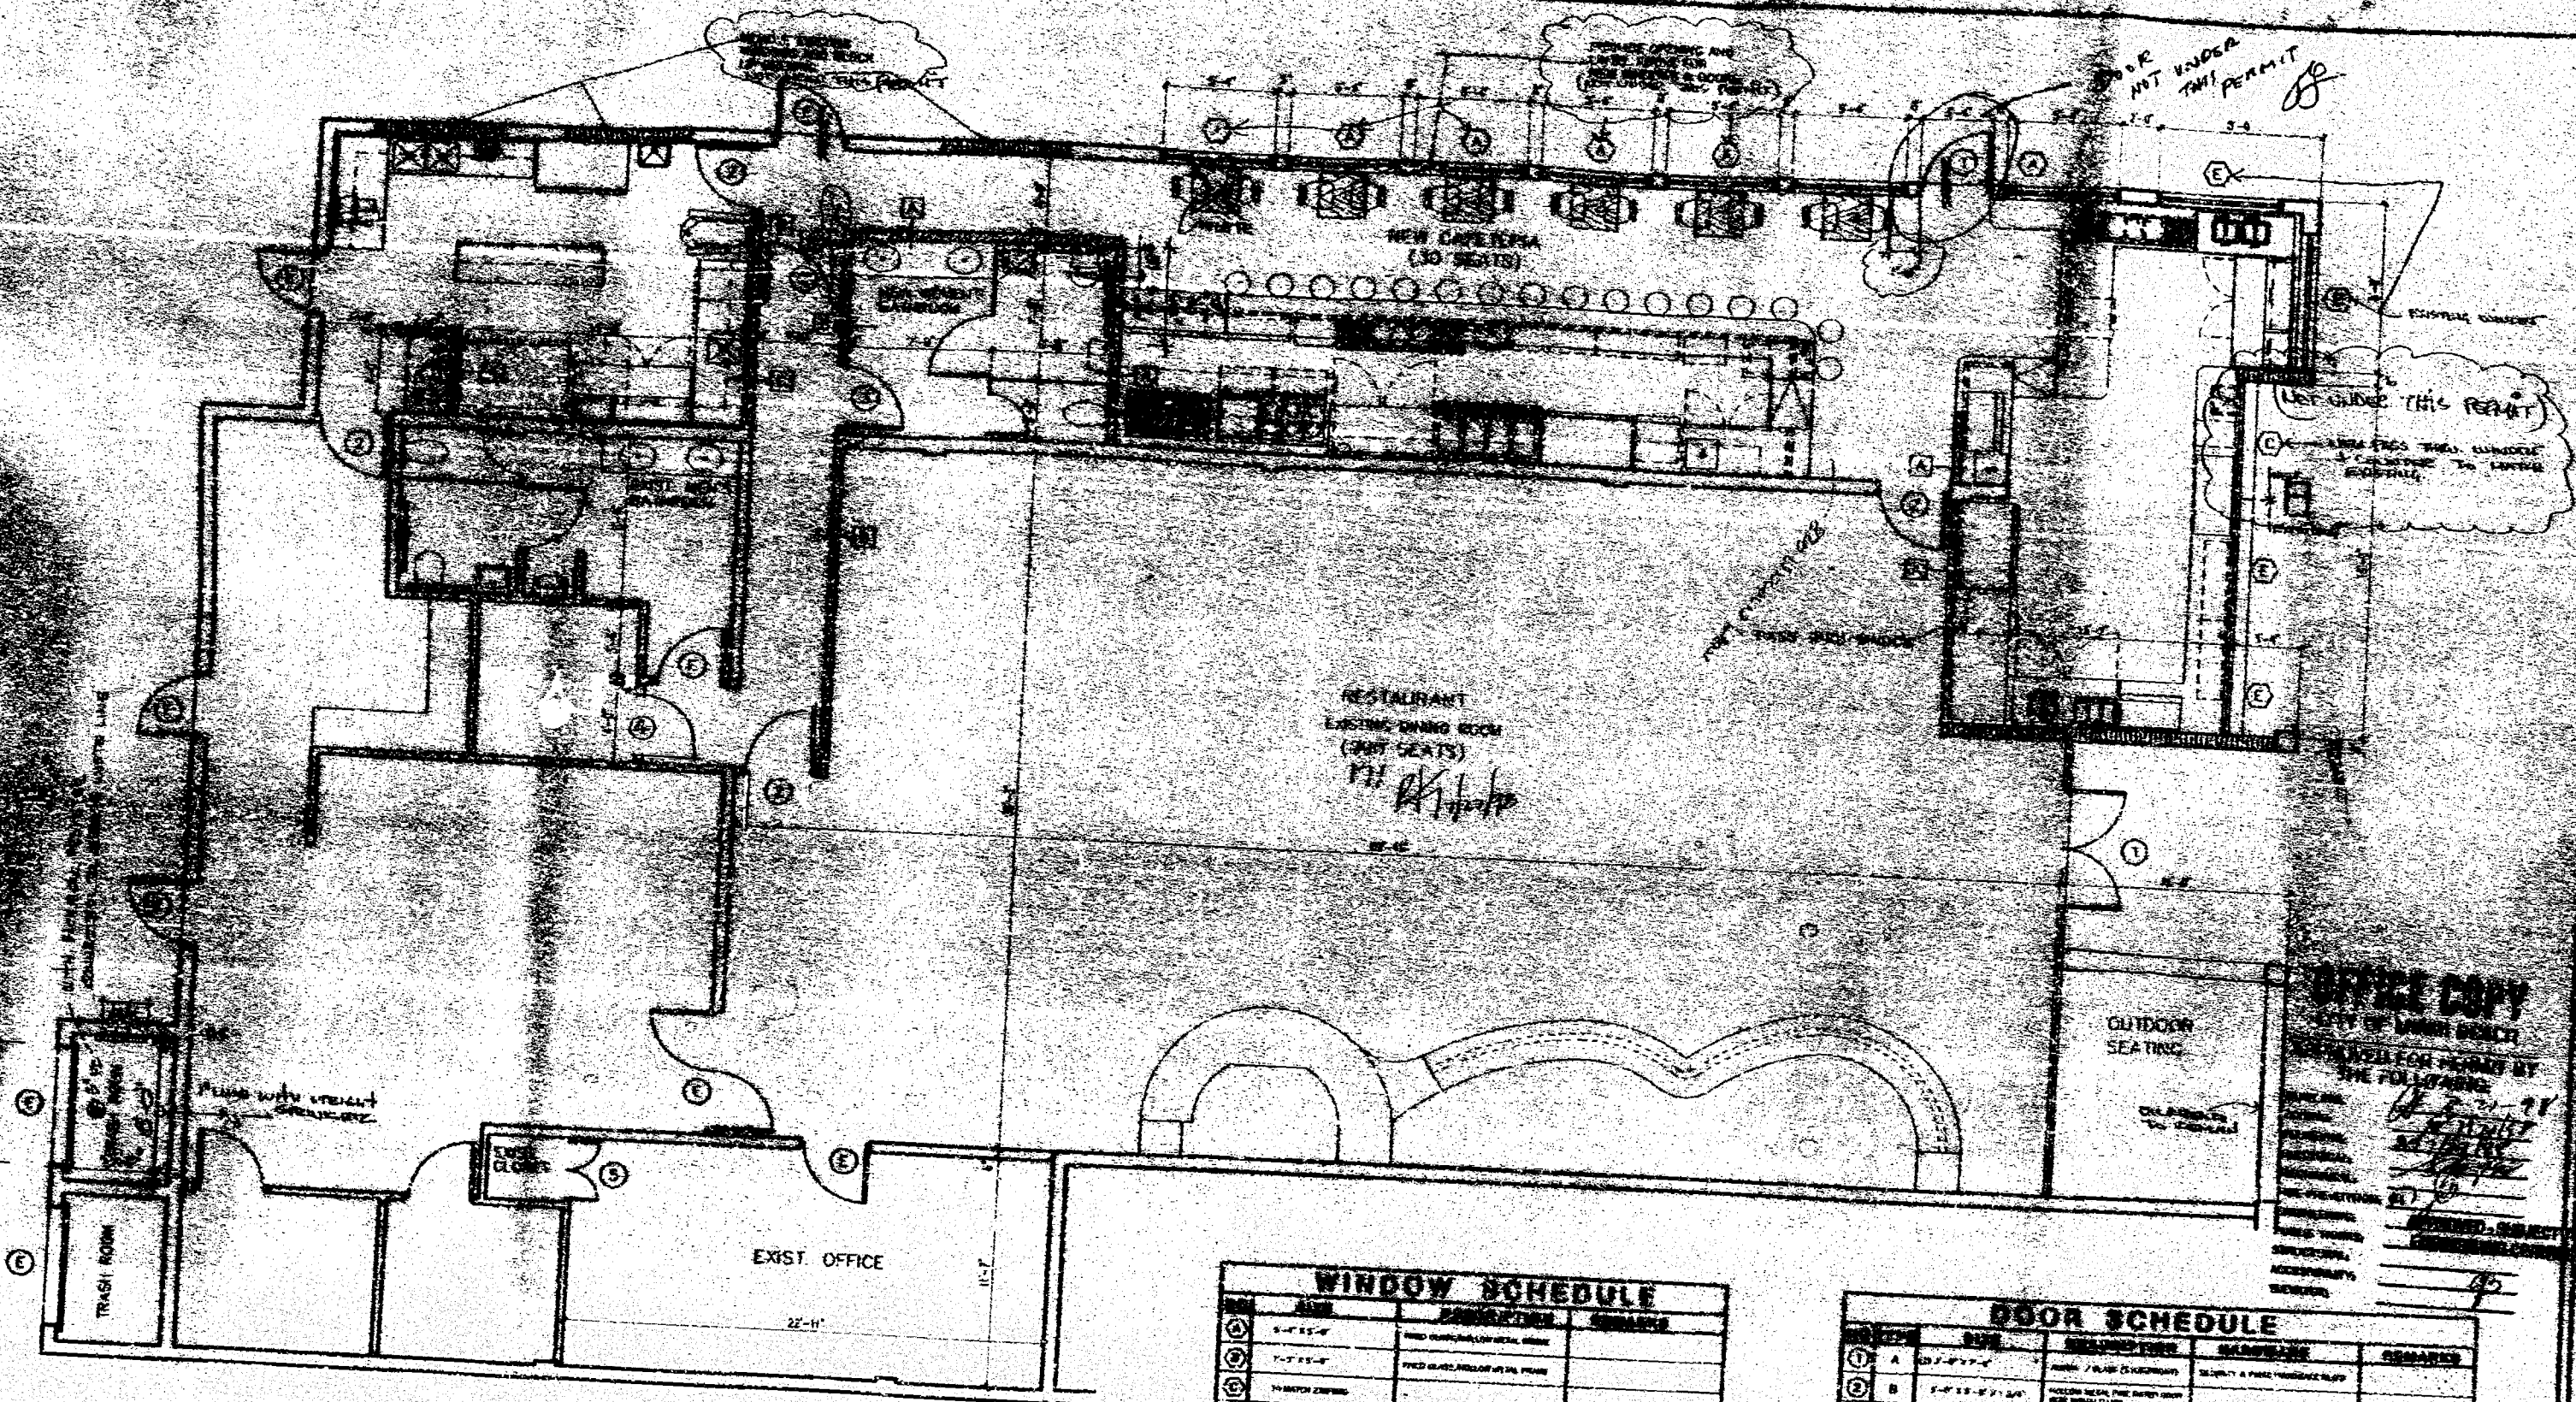

GROUND FLOOR PLAN


WINDOW SCHEDULE			
NO.	SIZE	CONSTRUCTION	REMARKS
1	6'-0" x 8'-0"	WOOD FRAME, DOUBLE GLASS	
2	4'-0" x 8'-0"	WOOD FRAME, DOUBLE GLASS	
3	4'-0" x 8'-0"	WOOD FRAME, DOUBLE GLASS	
4	4'-0" x 8'-0"	WOOD FRAME, DOUBLE GLASS	
5	4'-0" x 8'-0"	WOOD FRAME, DOUBLE GLASS	
6	4'-0" x 8'-0"	WOOD FRAME, DOUBLE GLASS	
7	4'-0" x 8'-0"	WOOD FRAME, DOUBLE GLASS	
8	4'-0" x 8'-0"	WOOD FRAME, DOUBLE GLASS	
9	4'-0" x 8'-0"	WOOD FRAME, DOUBLE GLASS	
10	4'-0" x 8'-0"	WOOD FRAME, DOUBLE GLASS	

WINDOW TYPES

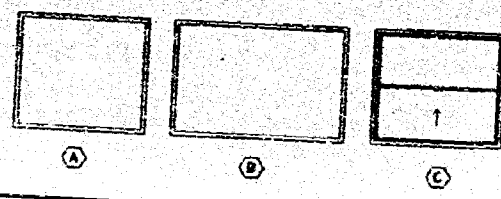

DOOR SCHEDULE			
NO.	TYPE	CONSTRUCTION	REMARKS
1	A	WOOD FRAME, DOUBLE GLASS	
2	B	WOOD FRAME, DOUBLE GLASS	
3	C	WOOD FRAME, DOUBLE GLASS	
4	C	WOOD FRAME, DOUBLE GLASS	
5	C	WOOD FRAME, DOUBLE GLASS	
6	C	WOOD FRAME, DOUBLE GLASS	
7	C	WOOD FRAME, DOUBLE GLASS	
8	C	WOOD FRAME, DOUBLE GLASS	
9	C	WOOD FRAME, DOUBLE GLASS	
10	C	WOOD FRAME, DOUBLE GLASS	

DOOR TYPES

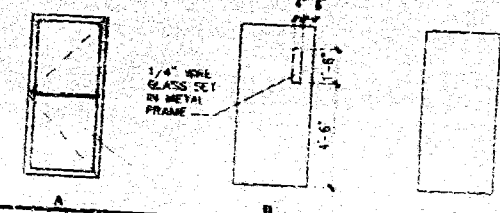

OFFICE COPY
 CITY OF MIAMI BEACH
 DEPARTMENT OF PERMITS
 1200 BAYVIEW BLVD.
 MIAMI BEACH, FL 33139
 (305) 361-2200
 FAX (305) 361-2201
 WWW.MIAMIBEACHFL.GOV

GAMBACH-SKLAR ARCHITECTS, INC.

1000 BAYVIEW BLVD.
 MIAMI BEACH, FL 33139
 (305) 361-2200
 FAX (305) 361-2201
 WWW.GAMBACH-SKLAR.COM

1/4" = 1'-0"
 B.G.V.
 98-794
 A-2



GAMBACH-SKLAR
ARCHITECTS, INC.

DAVID'S II
1200 S. BEACH BLVD.
SUITE 100
MIAMI BEACH, FL 33139
(305) 673-1234

APPROVED FOR PERMIT BY THE FOLLOWING:

BUILDING	
ZONING	
PLUMBING	
ELECTRICAL	
MECHANICAL	
FIRE PREVENTION	
ENGINEERING	
PUBLIC WORKS	
STRUCTURAL	
ACCESSIBILITY	
ELEVATOR	

1/4" = 1'-0"
B.G.V.
A-3

DAVID'S CAFE II
1200 S. BEACH BLVD.

CATWALK

REAR ELEVATION

DAVID'S CAFE II
1200 S. BEACH BLVD.

NEW CANVAS TO MATCH EXISTING


PATCH & REPAIR EXIST. WALL TO MATCH EXIST.

RIGHT ELEVATION


OFFICE COPY
CITY OF MIAMI BEACH
APPROVED FOR PERMIT BY THE FOLLOWING:

BUILDING
ZONING
PLUMBING
ELECTRICAL
MECHANICAL
FIRE PREVENTION
ENGINEERING
PUBLIC WORKS
STRUCTURAL
ACCESSIBILITY
ELEVATOR

EXTERIOR ELEVATIONS

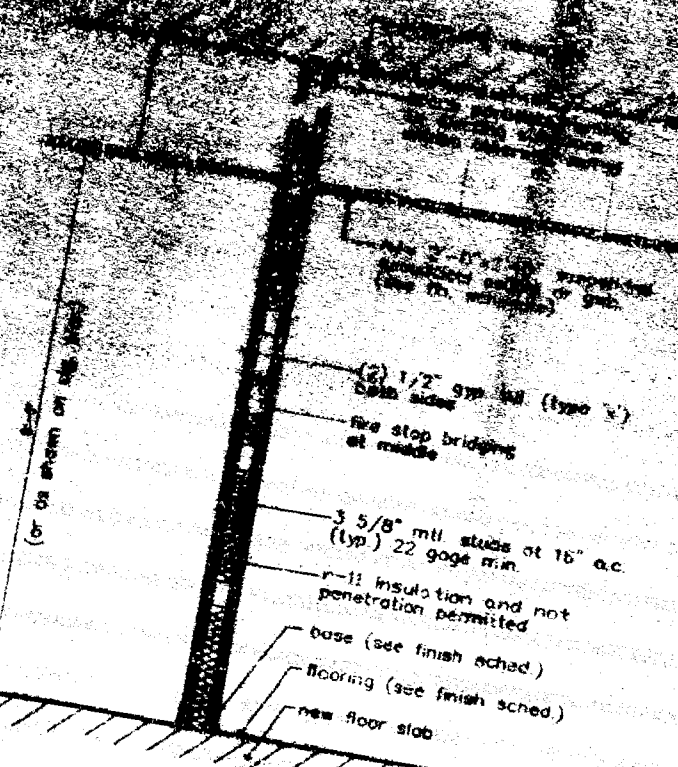


TYP 2 HR. PARTITION SECTION *
SCALE 3/4"=1'-0"

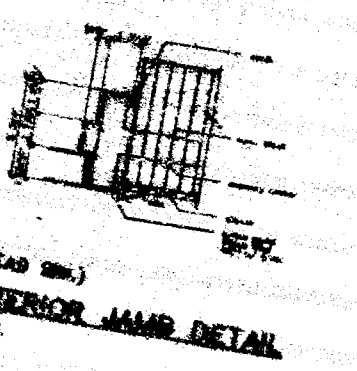

GENERAL NOTES

1. ALL WORK SHALL BE DONE IN ACCORDANCE WITH THE LATEST EDITIONS OF THE FOLLOWING SPECIFICATIONS:

- SECTION 05100 - METAL FABRICATED STRUCTURES
- SECTION 05200 - METAL STRUCTURES
- SECTION 05300 - METAL ROOFING
- SECTION 05400 - METAL Siding
- SECTION 05500 - METAL CLADDING
- SECTION 05600 - METAL PANELS
- SECTION 05700 - METAL SHEDS
- SECTION 05800 - METAL BRACKETS
- SECTION 05900 - METAL GUARDS
- SECTION 06000 - METAL RAILS
- SECTION 06100 - METAL STAIRS
- SECTION 06200 - METAL LADDERS
- SECTION 06300 - METAL PLATFORMS
- SECTION 06400 - METAL WALKWAYS
- SECTION 06500 - METAL GRATING
- SECTION 06600 - METAL FENCING
- SECTION 06700 - METAL SIGNAGE
- SECTION 06800 - METAL LIGHT FIXTURES
- SECTION 06900 - METAL VENTILATORS
- SECTION 07000 - METAL DUCTS
- SECTION 07100 - METAL PIPES
- SECTION 07200 - METAL VALVES
- SECTION 07300 - METAL FITTINGS
- SECTION 07400 - METAL FLANGES
- SECTION 07500 - METAL BOLTS
- SECTION 07600 - METAL NUTS
- SECTION 07700 - METAL WASHERS
- SECTION 07800 - METAL RIVETS
- SECTION 07900 - METAL SPLICERS
- SECTION 08000 - METAL BRACKETS
- SECTION 08100 - METAL CLIPS
- SECTION 08200 - METAL SCREWS
- SECTION 08300 - METAL NAILS
- SECTION 08400 - METAL PINS
- SECTION 08500 - METAL WIRE
- SECTION 08600 - METAL CABLE
- SECTION 08700 - METAL ROPES
- SECTION 08800 - METAL CHAINS
- SECTION 08900 - METAL BELTS
- SECTION 09000 - METAL CABLES
- SECTION 09100 - METAL ROPES
- SECTION 09200 - METAL CHAINS
- SECTION 09300 - METAL BELTS
- SECTION 09400 - METAL CABLES
- SECTION 09500 - METAL ROPES
- SECTION 09600 - METAL CHAINS
- SECTION 09700 - METAL BELTS
- SECTION 09800 - METAL CABLES
- SECTION 09900 - METAL ROPES
- SECTION 10000 - METAL CHAINS

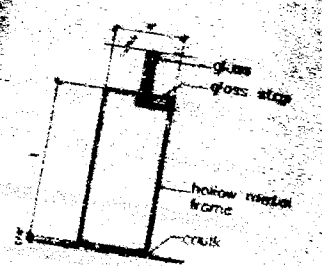

1. SILL DETAIL



2. JAMB DETAIL

STOREFRONT DETAILS
N.T.S.


OFFICE COPY
CITY OF MIAMI BEACH

APPROVED FOR PERMIT BY THE FOLLOWING:

7-21-99

APPROVED - SUBJECT TO ENCL. 1, 2, 3, 99, 100

AS SHOWN

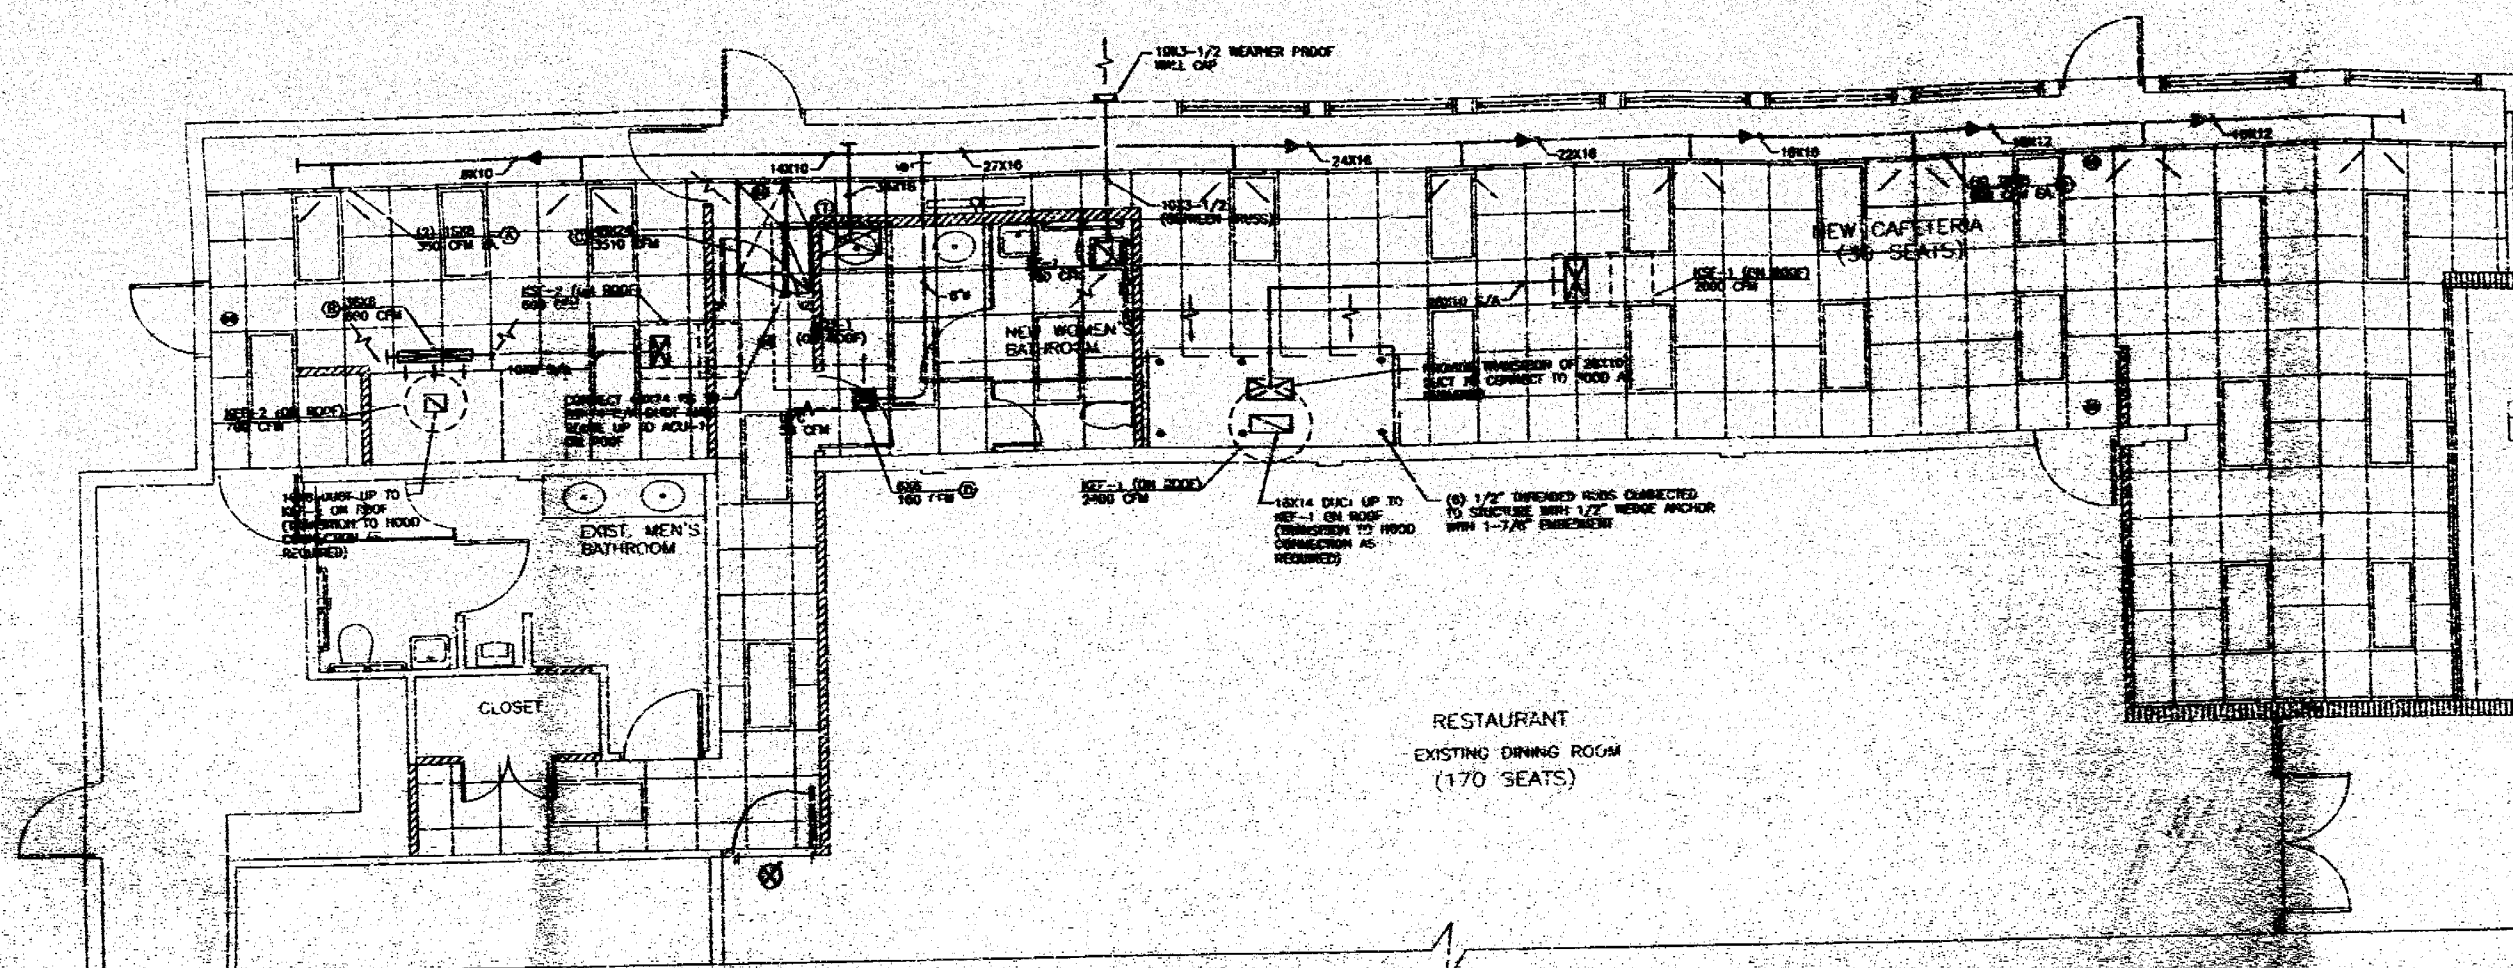

MECHANICAL PLAN

OUTSIDE AIR CALCULATION

AS PER ASHME 92-89

PERSONNEL AREA
2 PEOPLE @ 15 CFM / PERSON = 30 CFM

CATERING SEATING AREA
4 PEOPLE @ 15 CFM / PERSON = 60 CFM

CATERING SEATING AREA
32 PEOPLE @ 20 CFM / PERSON = 640 CFM

BAR/BEVERAGE COUNTER AREA
4 PEOPLE @ 15 CFM / PERSON = 60 CFM

TOTAL OUTSIDE AIR REQUIRED: 790 CFM

KITCHEN HOOD AIR BALANCE

EXHAUST AIR: KEF-1 + KEF-2 = -3,100 CFM
MAKE UP AIR: KSF-1 + KSF-2 = +2,600 CFM

TOTAL NEGATIVE CFM IS ADEQUATE
TO PREVENT NEGATIVE PRESSURE
FROM EXCEEDING 0.02 INCHES OF
WATER COLUMN.

AIR CONDITIONING EQUIPMENT SCHEDULE

[illegible]

- ① PROVIDE FACTORY FURNISHED ROOF CURBS DESIGNED FOR VERTICAL DISCHARGE.
- ② CONTRACTOR SHALL INSTALL UNIT PER MANUFACTURER'S RECOMMENDATIONS.

FAN SCHEDULE

[illegible]

A) ROOF CURB, B) SAFETY SWICH, C) INDOOR CURTAIN, D) GAS SCREEN
E) EXHAUSTION PROOF MOTOR, F) BACKDRAFT DAMPER

OFFICE COPY
CITY OF MIAMI BEACH

**APPROVED FOR PERMIT BY
THE FOLLOWING:**

BUILDING: _____
 ZONING: _____
 PLUMBING: _____
 ELECTRICAL: _____
 MECHANICAL: _____
 FIRE PREVENTION: 5) _____
 ENGINEERING: _____
 PUBLIC WORKS: _____
 SURVEYING: _____
 ACCESSIBILITY: _____
 ELEVATOR: _____

RICARDO A. MARTIN, P.E.
MECHANICAL ENGINEER
FLA. REG. #15380

95

ANALYST - VILAS
ASSOCIATES, INC.
MEMBERSHIP INFORMATION



**GAMBACH-SKLAR
ARCHITECTS, INC.**
100 W. 42ND ST. - NEW YORK, N.Y. 10018
TEL: 212-692-1000 FAX: 212-692-1001

DAVID'S II

504 MERIDIAN AVENUE, HT

Abstract

COLONIA




06/29/98

$$1/4'' = 1' - 0''$$


— D.B.

92-794

M-1

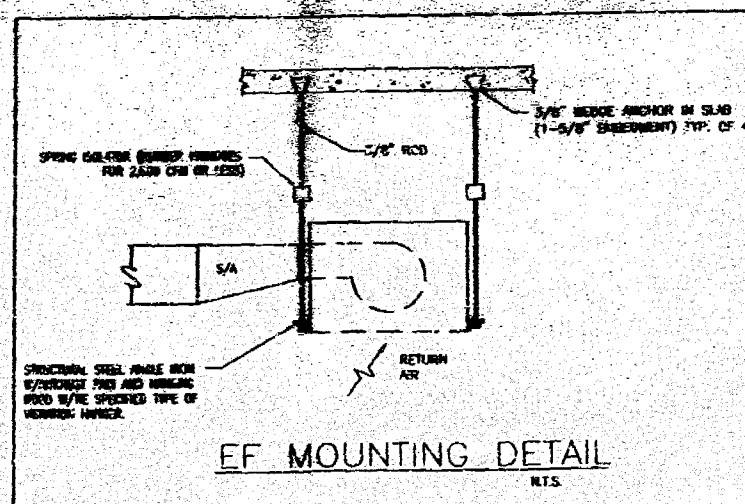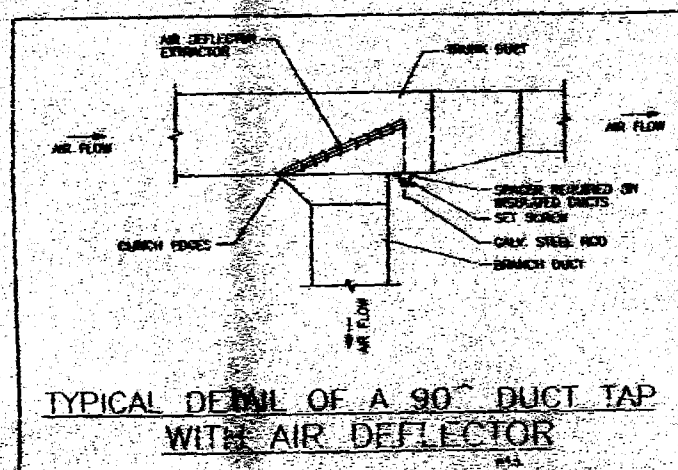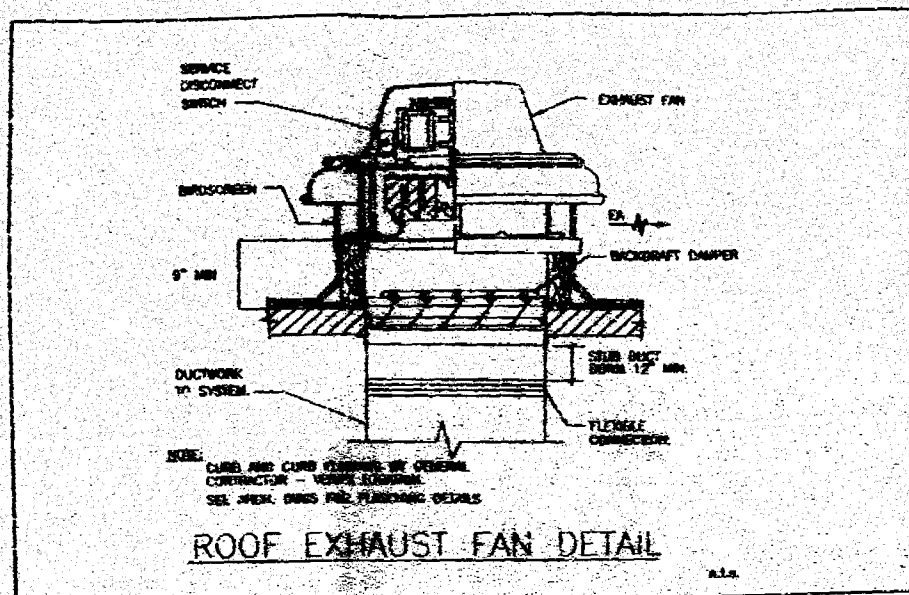

HVAC SYMBOLS			
GENERAL			
①	TERMINATOR		DIRECTION OF AIR FLOW
Q/M	CLIMB FEET PER MINUTE		EXISTING DUCT
EF	EXHAUST FAN		NEW DUCT
6	ROUND		TWO-OFF DUCT WITH VOLUME BOOSTER
W/V	WHIRLWIND AIR VOLUME		DUCT TRANSITION
T/D	TRANSFER DUCT		EXISTING RESTRICTED FLEXIBLE DUCT
Q/S	HELOCAPTE		NEW INSULATED FLEXIBLE DUCT
(E)	EXHAUST		DUCT WITH TURNING VANES
Q/S	NEW		TWO-OFF DUCT WITH AIR SCOOPERS
(A)	ALUMINUM		
S/A	SUPPLY AIR		
R/A	RETURN AIR		
L/A	EXHAUST AIR		
O/A	OUTSIDE AIR		
FD	FIRE DAMPER		
LD	LOWAIR DAMPER		
LD	LOWAIR RETURN		
②	CONNECT TO EXHAUST		
LT	LEAF DAMPER DIFFUSER		
RC	RETURN ORIFICE		
U/C	SAFER CUT DOOR		
		AIR DISTRIBUTION	
		Ⓐ	DOUBLE INSULATION SUPPLY, MINERAL WOOLNET, 3/4" SPACING, ALL ALUMINUM MANUFACTURER - WMS MODEL 272S
		Ⓑ	SUPPLY AIR DIFFUSER LEAFER TYPE ALL ALUMINUM MFR. TITUS MODEL 209MA
		Ⓒ	RETURN AIR ORIFICE ALL ALUMINUM MFR. TITUS MODEL 3PL

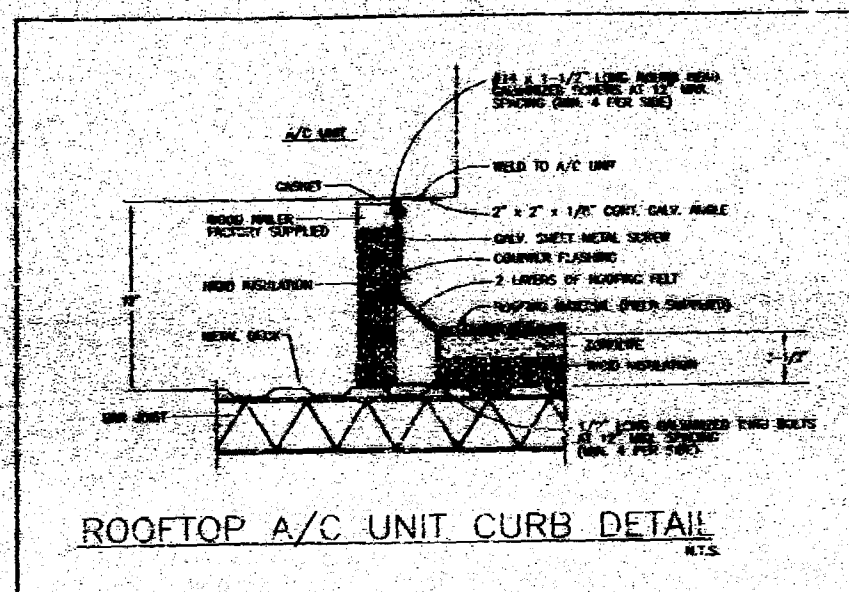

- [illegible]

- ## HOOD SYSTEM GENERAL NOTES
1. HOOD SHALL BE CONSTRUCTED AND ASSEMBLED WITH PLATE LIFT IN OPENED POSITION.
 2. HOOD SHALL BE CONSTRUCTED TO ALLOW FOR ITS OPERATION CONTINUOUSLY AND SUPPLY FAN TO EXHAUST.
 3. HOOD SHALL BE CONSTRUCTED TO BE SECURE, WHICHEVER THE EXHAUSTING SYSTEM IS ACTIVATED.
 4. HOOD LIFTING MECHANISM SHALL BE LISTED AS IN "YOUR SPECIFY" TAG.
 5. HOOD SHALL BE CONSTRUCTED TO BE A SINGLE HOODING AREA AND SHALL BE PROVIDED WITH SUFFICIENTLY LARGE FOR OPERATION OF ANY ONE SECTION.
 6. ALL EXHAUST HOODS SHALL BE LISTED AS IN "YOUR SPECIFY" TAG.
 7. ALL EXHAUST HOOD SHALL BE 18 GA. STAINLESS STEEL OR 18 GAUGE GALVANIZED STEEL.
 8. HOOD SHALL BE CONSTRUCTED WITH 18 GA. STAINLESS STEEL AND SHALL BE 18" THICKNESS AND 12" DEPTH IN 18"

OFFICE COPY
CITY OF MIAMI BEACH

APPROVED FOR PERMIT BY:
THE FOLLOWING:

BUILDING: _____
 ZONING: _____
 PLUMBING: _____
 ELECTRICAL: _____
 MECHANICAL: _____
 FINE FIXTURES: _____
 ENGINEERING: _____
 PUBLIC WORKS: _____
 STRUCTURAL: _____
 ACCESSIBILITY: _____
 ELEVATOR: _____

RICARDO A. MARTIN, P.E.
MECHANICAL ENGINEER
FLA. REG. #16390

MARTIN - TILATO ASSOCIATES, INC.
CONSULTING ENGINEERS

date: 06/29/98

$$\text{size } 1/4" = 1' - 0"$$

174-121-0
174-121-0


	D.B.
--	------

98-794

GAMBACH-SKLAR
ARCHITECTS, INC.
AN OFFICE - ROBERT J. GAMBACH - 400 SOUTH - 6601 PALM BLVD. #400
10001 KANE CIRCLE, DAYTON, OHIO 45424 (513) 233-2555

FLORIDA

DAVID'S III
1324 MERIDIAN AVENUE
SEASIDE, MD 21138

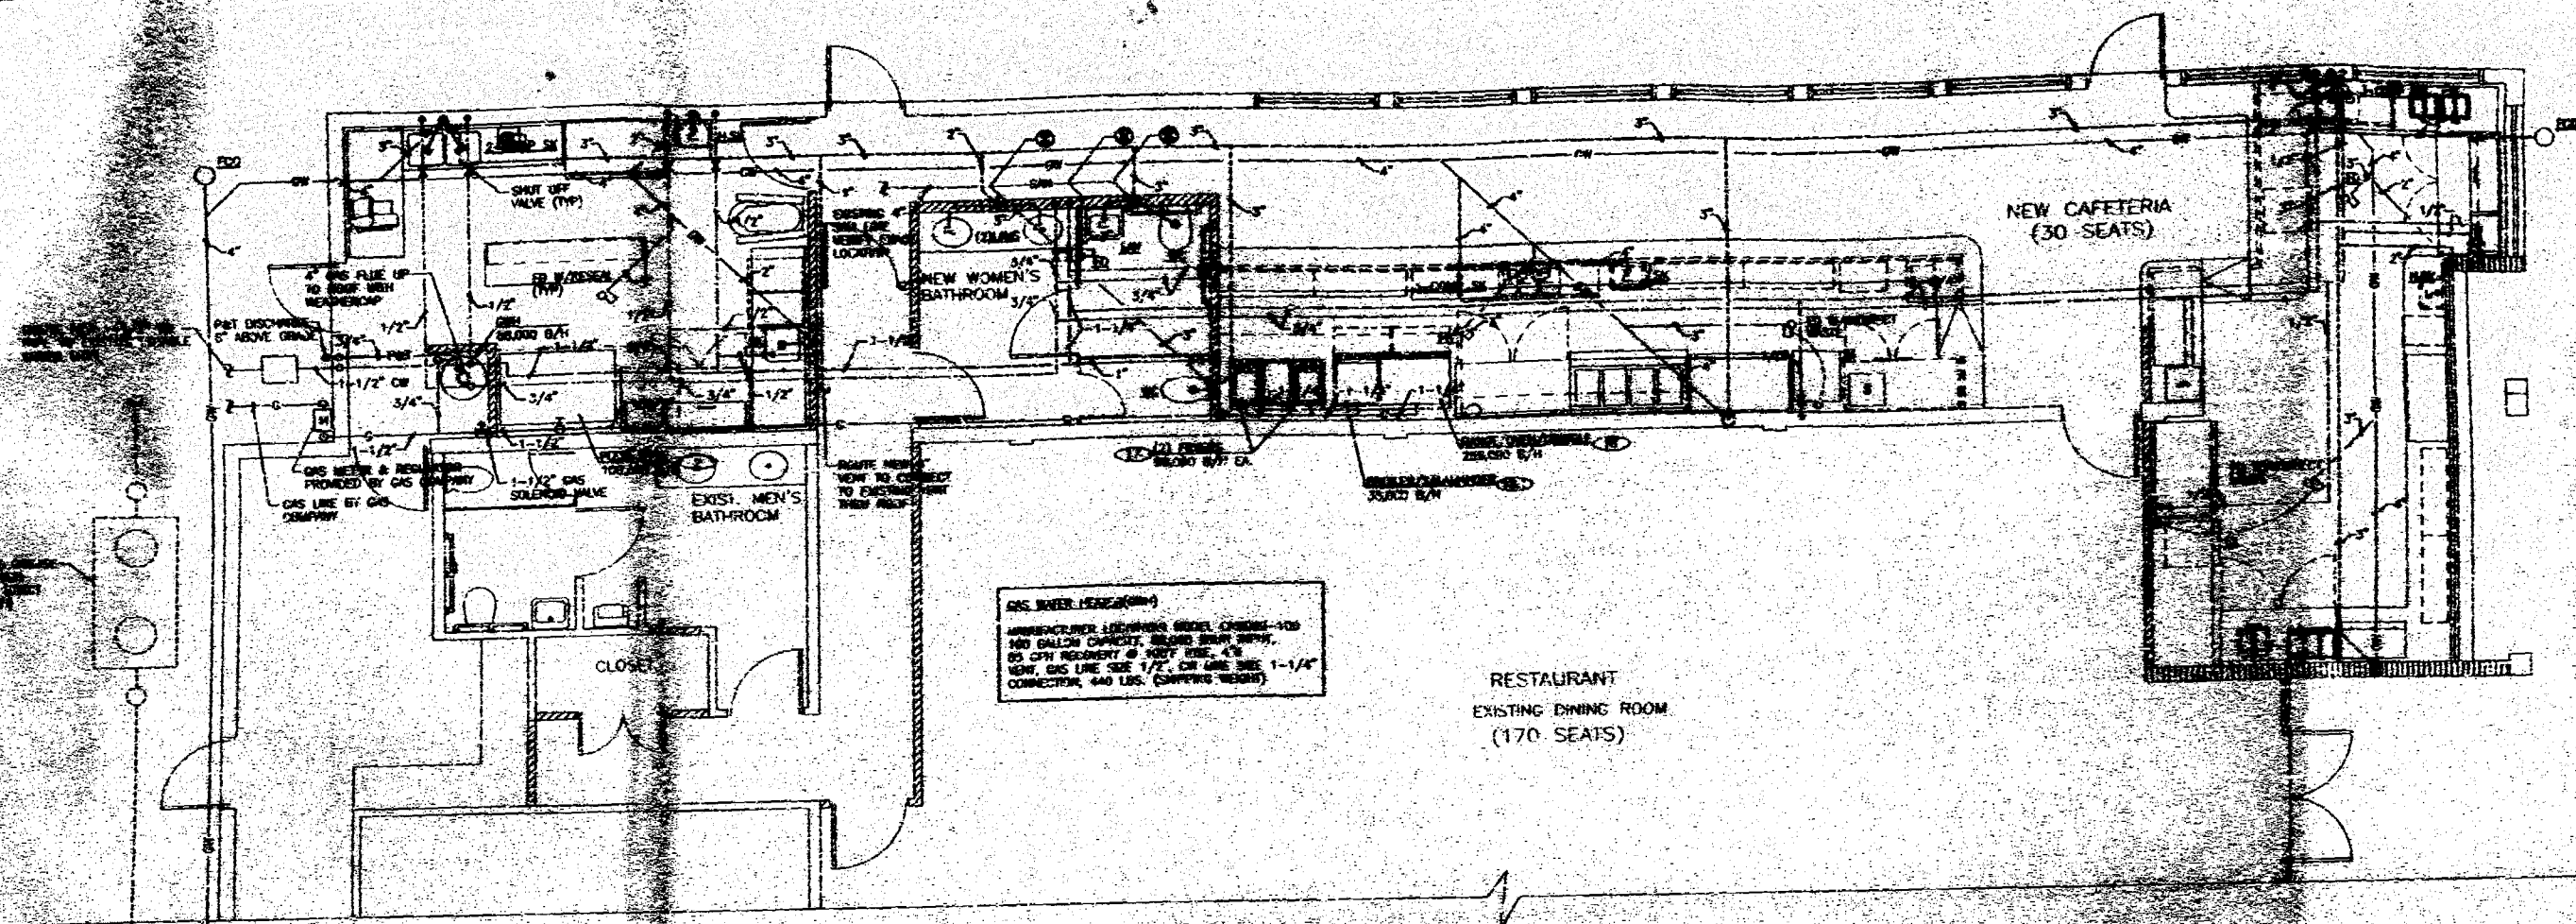

PLUMBING PLAN
SCALE 1/4" = 1'-0"

PLUMBING SYMBOL LEGEND

SYMBOL	DESCRIPTION
—S—	BUILDING SANITARY SEWER LINE
—V—	VENT LINE
—F—	FIRE LINE
—G—	GAS LINE
—H—	CLEAN OUT
—H—	WALL CLEAN OUT
—F—	FLOOR CLEAN OUT
—CTG—	CLEAN OUT TO GRADE
—CD—	CONDENSATE DRAIN
—C—	COLD WATER LINE (C.W.)
—H—	HOT WATER LINE (H.W.)
—GW—	DREAGE WASTE LINE
—D—	GATE VALVE
—U—	UNION
—H—	HOSE BIB W/ VACUUM BREAKER (VB) & CONTROL VALVE (VM)
—S—	SPRINKLER HEAD
—P—	PRESSURE-TEMPERATURE RELIEF VALVE
—FD—	FLOOR DRAIN W/TRAP SEAL PRIME VALVE
—RD—	ROOF DRAIN
—AD—	AREA DRAIN
—VTR—	VENT THRU ROOF
—RWL—	RAIL WATER LEADER
—CONT—	CONTINUATION
—TYP—	TYPICAL
—AFF—	ABOVE FINISHED FLOOR

GENERAL PLUMBING NOTES

- ALL WORK TO BE IN ACCORDANCE WITH THE LOCAL PLUMBING & BUILDING CODES.
- SEALING OF JOINTS SHALL BE DONE BY THE CONTRACTOR IN ACCORDANCE WITH THE LOCAL PLUMBING & BUILDING CODES.
- ALL WORKS UNDERGROUND TO BE DONE IN PRECAST CONCRETE WORKS, EXCEPT FOR SINKS.
- PLUMBING CONTRACTOR TO FURNISH ALL REQUIRED FLASHINGS FOR TYPES TO ROOFING CONTRACTOR.
- MATERIALS SHALL BE ALL NEW AND AS FOLLOWS:
 - DRAINAGE PIPING: 1/2" MIN. DIA. STD. 301 OR 304 STAINLESS STEEL, 1/2" DIA. 304 STAINLESS STEEL.
 - WATER PIPING: TYPE K COPPER, 1/2" DIA. 304 STAINLESS STEEL (ABOVE GROUND).
 - A/C CONDENSATE DRAIN: 1/2" DIA. 304 STAINLESS STEEL (ABOVE GROUND).
 - PLUMBING FIXTURES: TO BE SELECTED BY OWNER.
 - FLOOR DRAIN: 1/2" DIA. 304 STAINLESS STEEL OR EQUAL.
 - WATER HEATERS: 1/2" DIA. 304 STAINLESS STEEL OR EQUAL.
 - VALVES: 1/2" DIA. 304 STAINLESS STEEL OR EQUAL.
 - HOSE BIBS: CHICAGO # 302 OR EQUAL.
- PROVIDE ALL EXCAVATION, BACKFILL AND COMPACTION REQUIRED BY ALL PLUMBING WORK, AND DEMOLITION OF EXISTING SLAB REQ'D.
- PERFORM THE FOLLOWING TESTS:
 - WATER PIPING SHALL BE SUBJECTED TO HYDROSTATIC PRESSURE TEST OR 100 PSIG FOR A PERIOD OF ONE HOUR TO DRAINAGE SYSTEM BUT NOT LESS THAN 1 HR.
 - DRAINAGE PIPING: BEFORE INSTALLATION OF ANY DRAIN, THE ENDS OF SYSTEM SHALL BE COVERED AND ALL LINES FILLED WITH WATER TO THE HIGHEST POINT AND ALLOWED TO STAND UNTIL INSPECTION IS MADE AND WATER LEVEL REMAINS CONSTANT.
 - CORRECT ALL DEFECTS DISCLOSED BY ABOVE TESTS.
- STERILIZE ALL WATER LINES WITH A Mixture of (2) POUNDS OF CHLORINATED LIME TO EACH 1000 GAL. OF WATER (SOPH OF AVAILABLE CHLORINE). RETAIN MIXTURE IN PIPES 24 HRS. AND FLUSH THOROUGHLY W/ POTABLE WATER BEFORE PLACING IN SERVICE.
- COMPLETE SERVICE, FIXTURES AND EQUIPMENT SHALL BE GIVEN AN IN-SERVICE TEST AFTER COMPLETION OF THE INSTALLATION.
- PLUMBING CONTRACTOR SHALL FURNISH A WRITTEN GUARANTEE THAT ALL PLUMBING WORK SHALL BE FREE FROM DEFECTS OR MATERIALS AND WORKMANSHIP FOR A PERIOD OF 1 YR. FROM DATE OF FINAL ACCEPTANCE, AND THAT HE WILL, AT HIS EXPENSE, REPAIR & REPLACE ALL WORK WHICH BECOMES DEFECTIVE DURING GUARANTEE PERIOD.

OFFICE COPY
CITY OF MIAMI BEACH
APPROVED FOR PERMIT BY
THE FOLLOWING:

BUILDING: _____
PLUMBING: *AS 2/2/98*
ELECTRICAL: _____
MECHANICAL: _____
FIRE PREVENTION: _____
ENGINEERING: _____
PUBLIC WORKS: _____
STRUCTURAL: _____
ACCESSIBILITY: _____
ELEVATION: _____



RICARDO A. MARTIN, P.E.
MECHANICAL ENGINEER
FLA. REG. #16390

STAMP: RICARDO A. MARTIN, P.E. MECHANICAL ENGINEER FLA. REG. #16390

GAMBACH SKLAR ARCHITECTS, INC.
1554 NE 10TH AVENUE
MIAMI BEACH, FL 33139
TEL: 305-673-1111
FAX: 305-673-1112

DAVID'S H

DATE: 06/29/98
SCALE: 1/4" = 1'-0"
SHEET: D.B.
PROJECT: 98-784
P-1

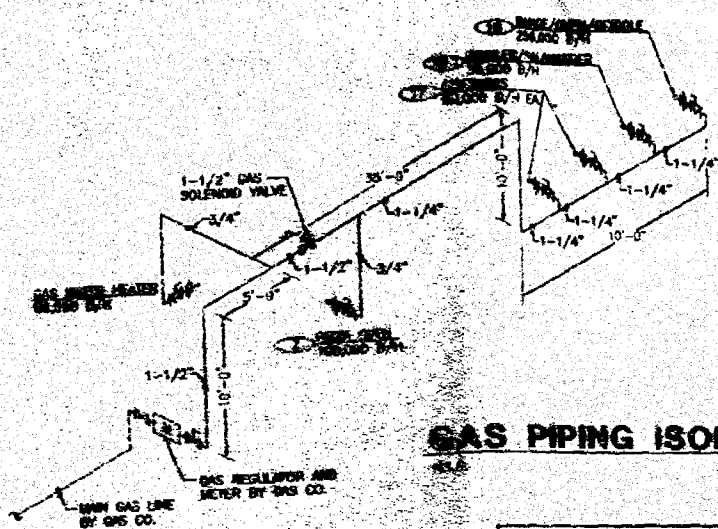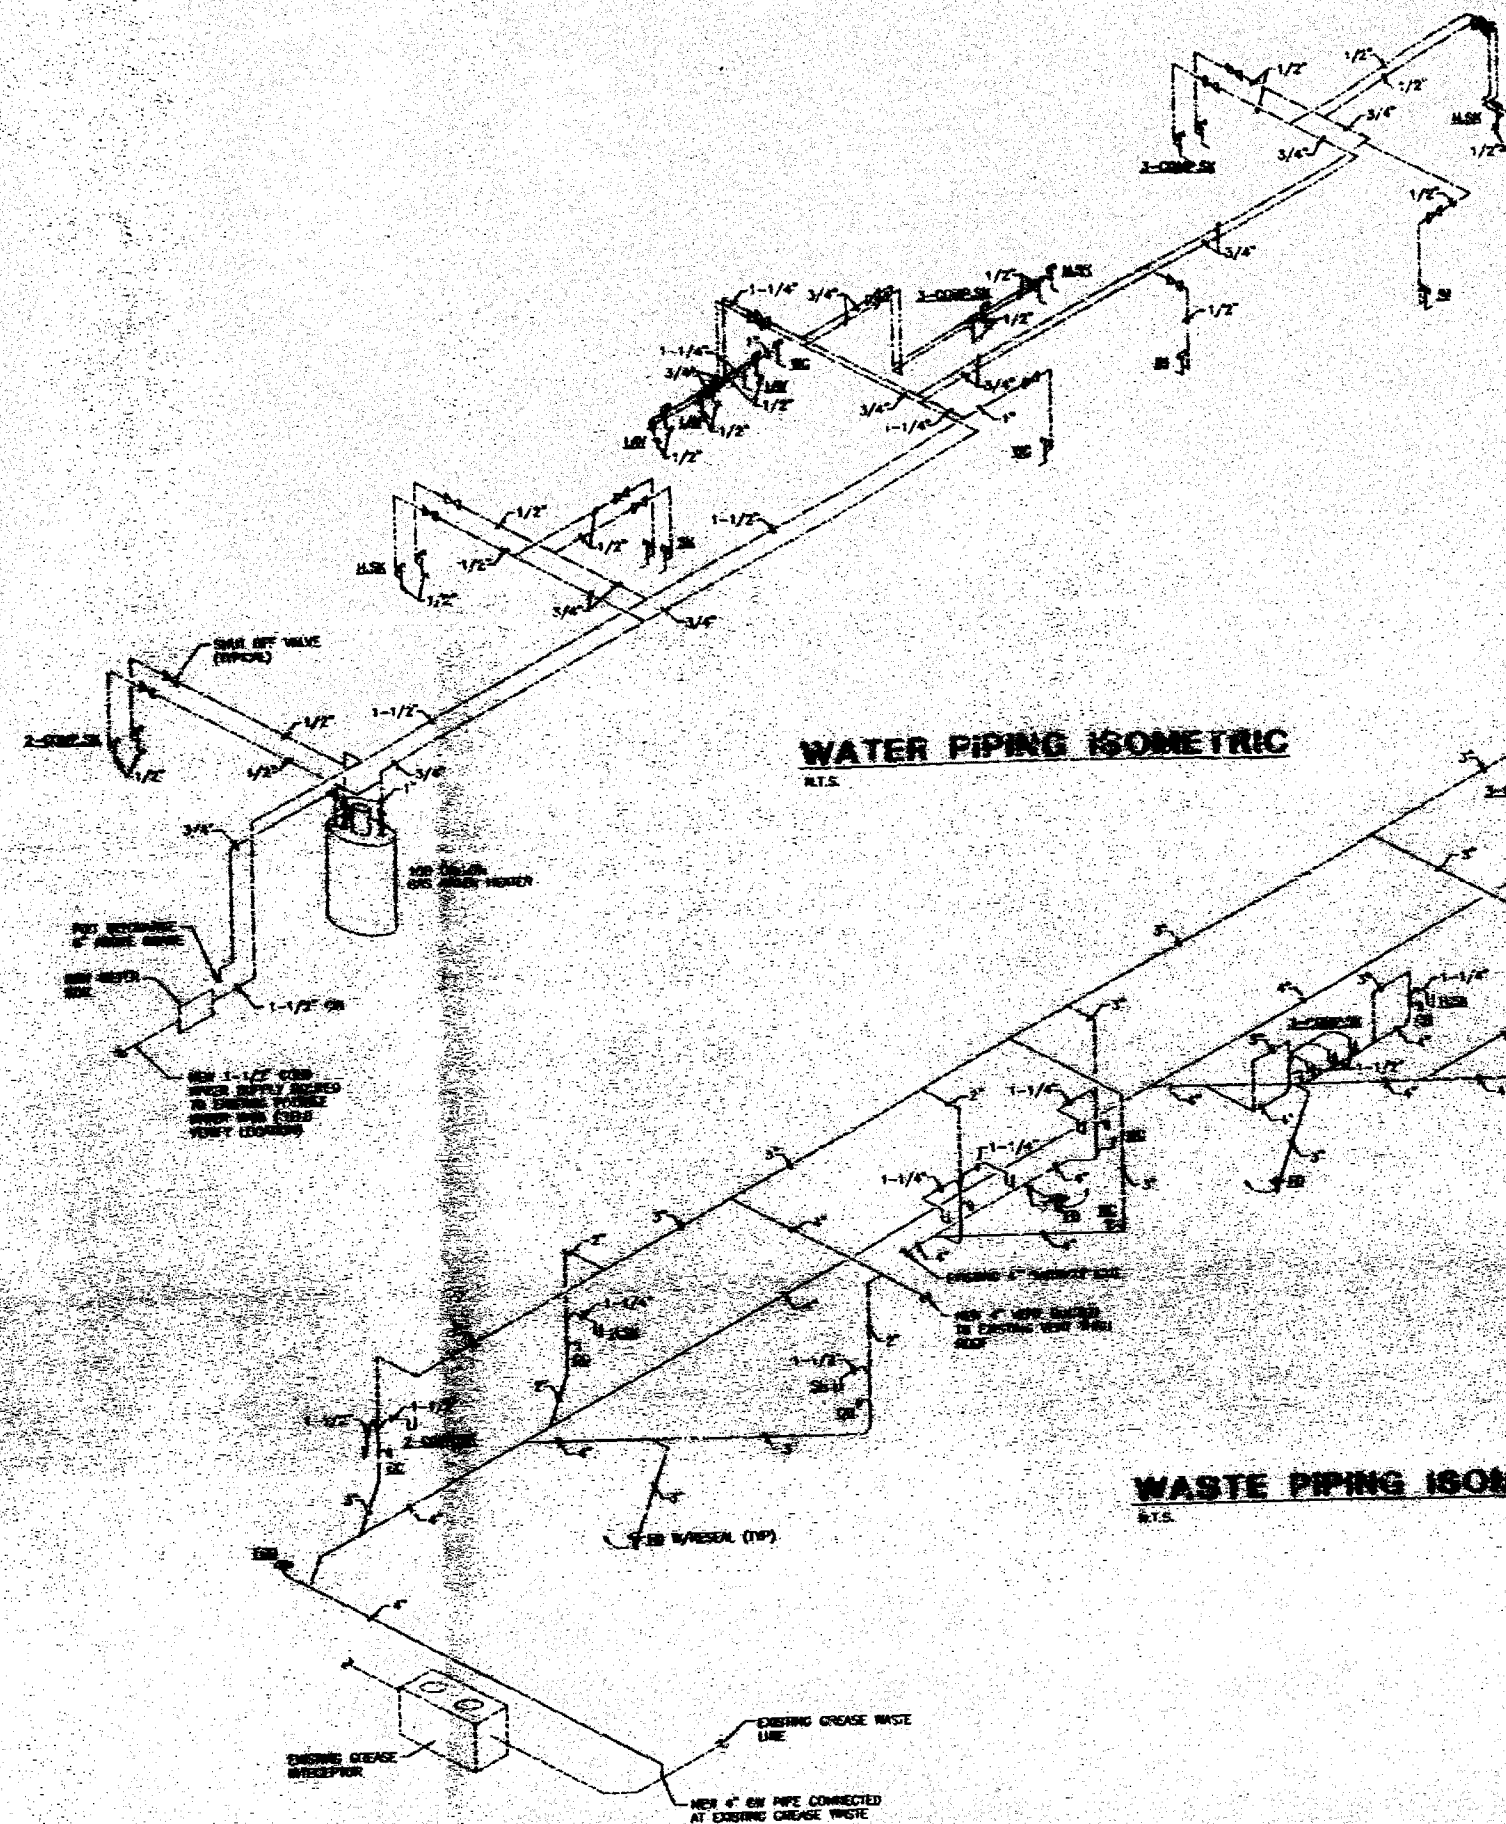

GAS PIPING ISOMETRIC

TOTAL GAS DEMAND		
② PIZZA OVEN	100,000 BTU X 1	= 100,000 BTU
① FRYERS	50,000 BTU X 2	= 100,000 BTU
③ GRILL/TOAST/ROAST	250,000 BTU X 1	= 250,000 BTU
④ GRILLER/SALAMANDER	35,000 BTU X 1	= 35,000 BTU
WATER HEATER	80,000 BTU X 1	= 80,000 BTU
TOTAL		= 665,000 BTU
		= 1.000 CFH
SPECIFIC GRABBY GAS		0.68
GAS PRESSURE		0.50
PRESSURE DROP		0.20
LONGEST RUN		70'-0"


WASTE PIPING ISOMETRIC

OFFICE COPY
CITY OF MIAMI BEACH

APPROVED FOR PERMIT BY
THE FOLLOWING:

BUILDING	
ZONING	
PLUMBING	
ELECTRICAL	
MECHANICAL	
FIRE PREVENTION	
ENGINEERING	
PUBLIC WORKS	
STRUCTURAL	
ACCESSIBILITY	
CLEANING	

 RICARDO A. MARTIN, P.E.
MECHANICAL ENGINEER
FLA. REG. #16390






DATE: 06/29/98
SCALE: 1/4"=1'-0"
BY: D.B.
NO: 98-784

P-2

GAMBACH-SKLAR
ARCHITECTS, INC.
401 COUNTRY AVENUE, SUITE 100, MIAMI BEACH, FL 33139
TEL: (305) 673-1111 FAX: (305) 673-1112

DAVID'S II
1000 WEST 10TH AVENUE
MIAMI BEACH, FL 33134

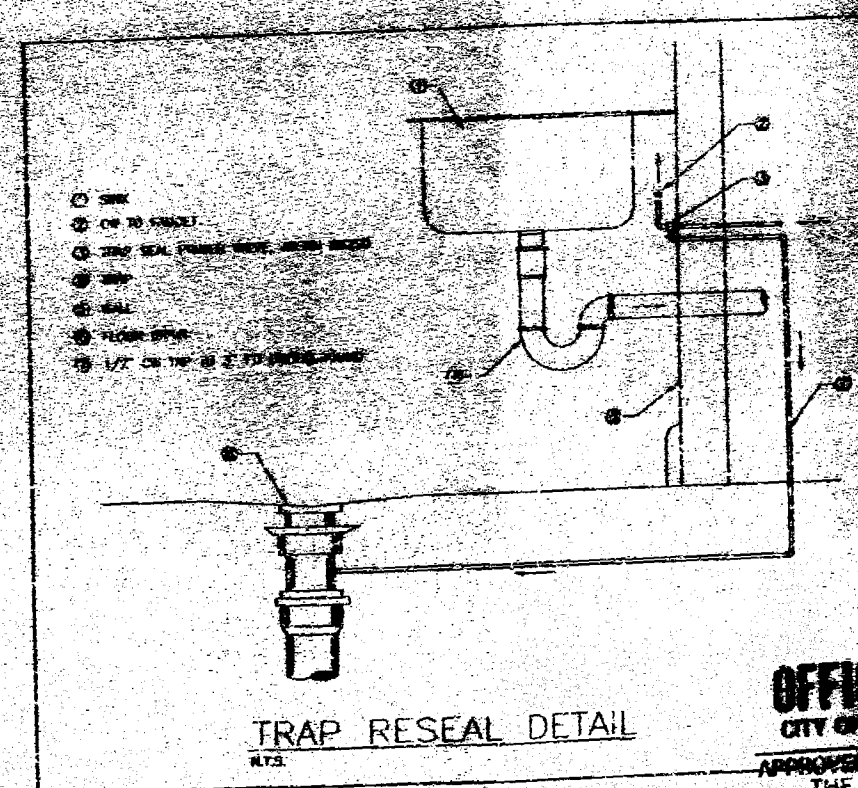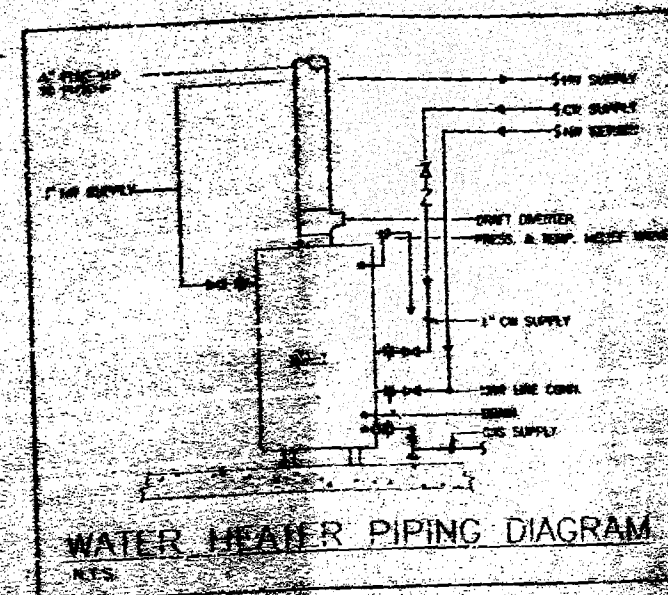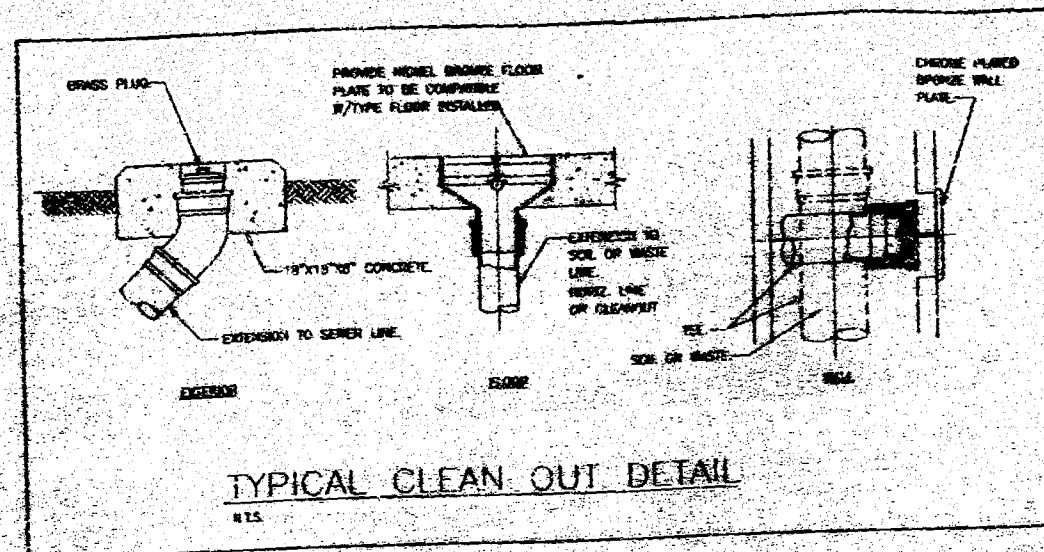


OFFICE COPY
CITY OF MIAMI BEACH

APPROVED FOR PERMIT BY
THE FOLLOWING:

BUILDING:	
ZONING:	
PLUMBING:	<i>[Signature]</i>
ELECTRICAL:	
MECHANICAL:	
FIRE PREVENTION:	<i>[Signature]</i>
ENGINEERING:	
PUBLIC WORKS:	
STRUCTURAL:	
ACCESSIBILITY:	
ELEVATOR:	

 RICARDO A. MARTIN, P.E.
MECHANICAL ENGINEER
F.L.A. REG. #16360



GAMBACH-SKLAR
ARCHITECTS, INC.
1000 BAYVIEW BLVD., SUITE 1000
MIAMI BEACH, FL 33139
TEL: 305-673-1111
FAX: 305-673-1112

DAVID'S H

DATE: 06/29/98

SCALE: 1/4"=1'-0"

PROJECT: D.B.

NO: 98-794

P-3



GAMBACH-SKLAR, INC.
ELECTRICAL ENGINEERS
1000 N. W. 10th Ave., Suite 400
Fort Lauderdale, FL 33304
(305) 555-1234

DAVID'S II

POWER PLAN


6/26/98

1/4" = 1'-0"




SVL

98-794

E-1

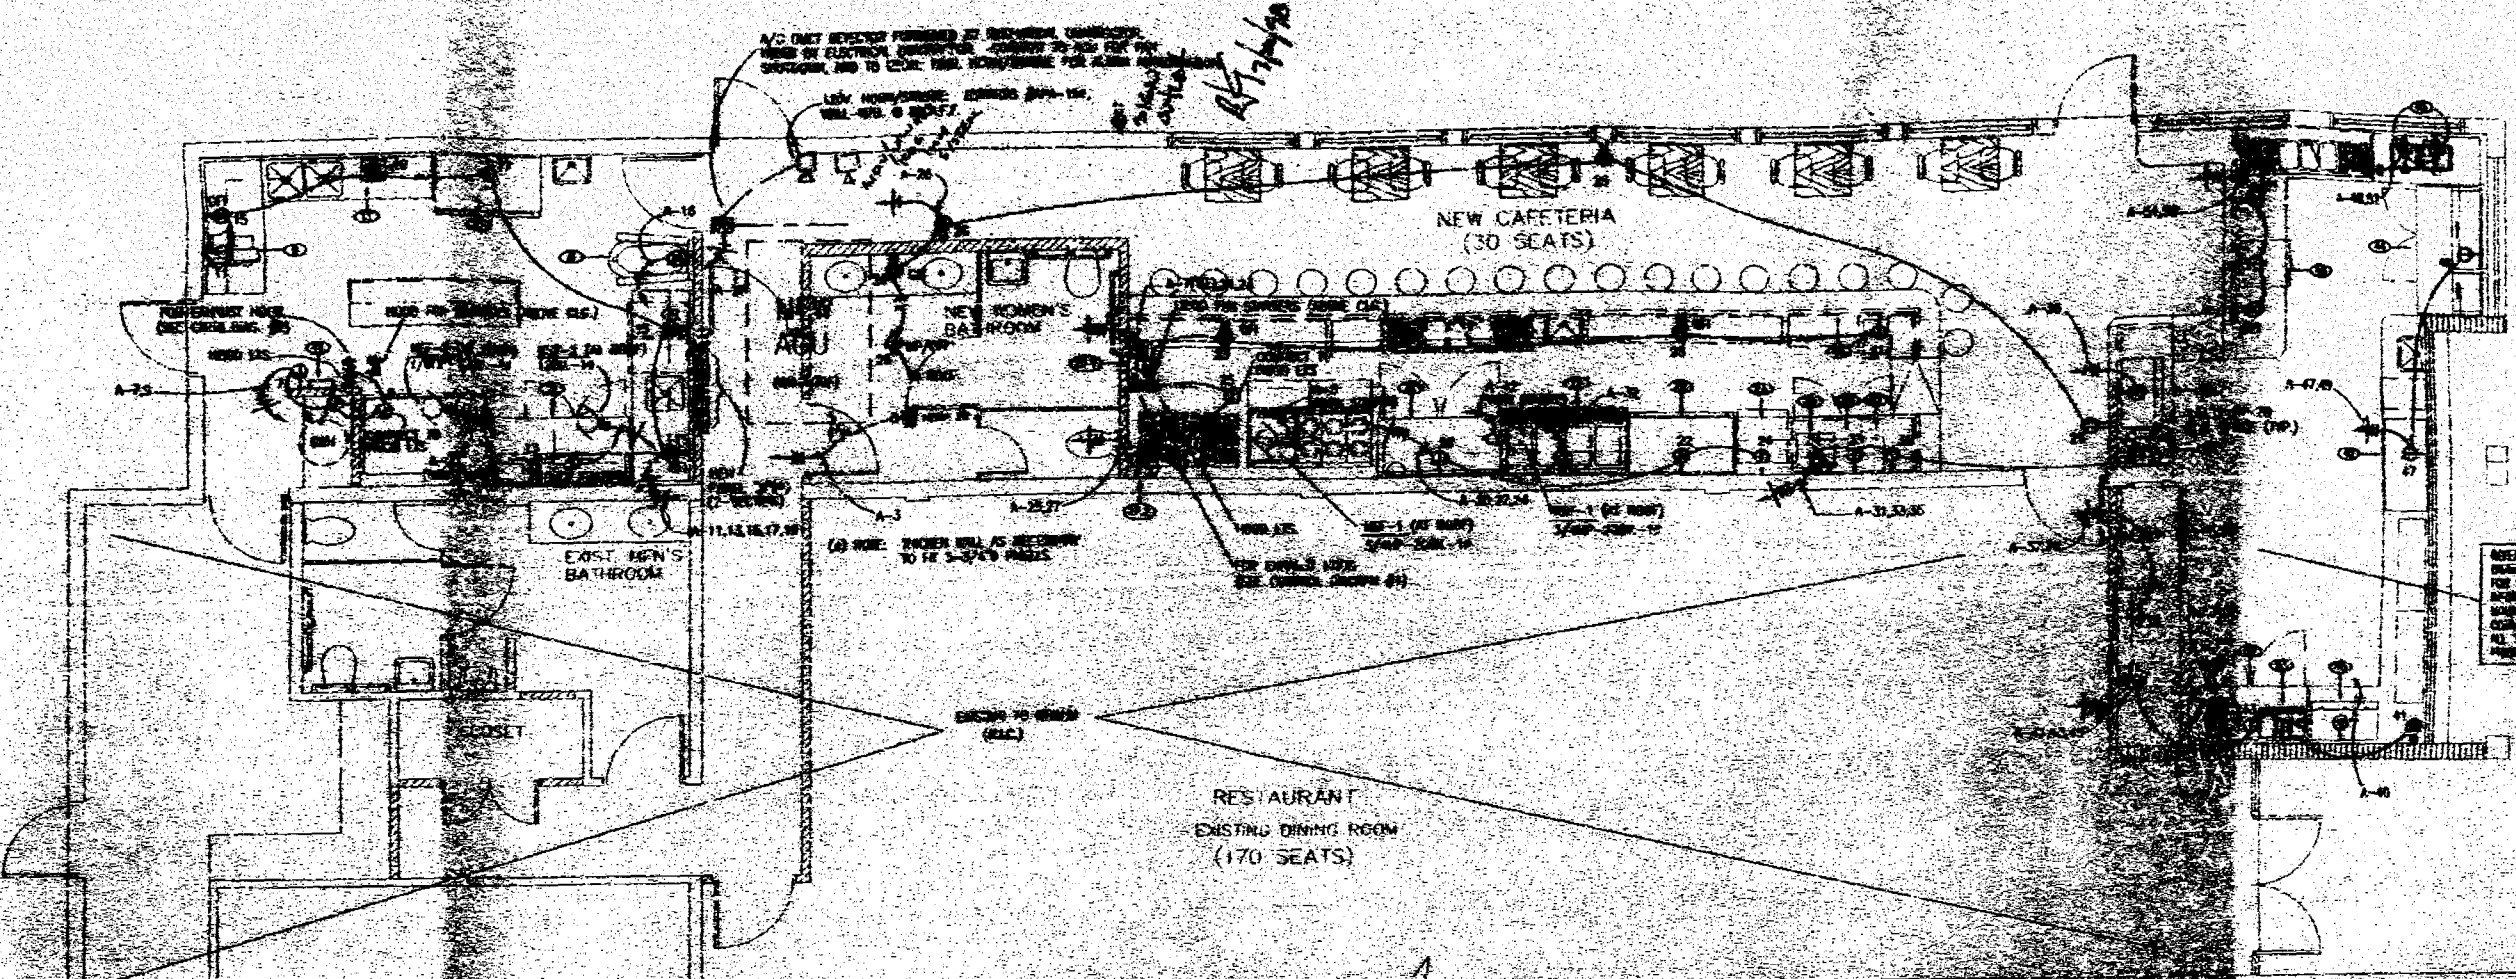

POWER PLAN
SCALE: 1/4" = 1'-0"

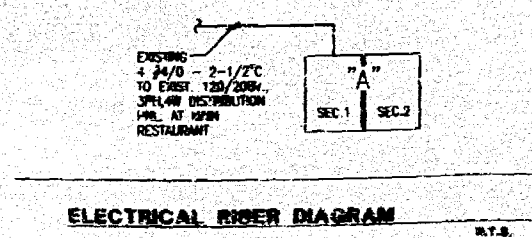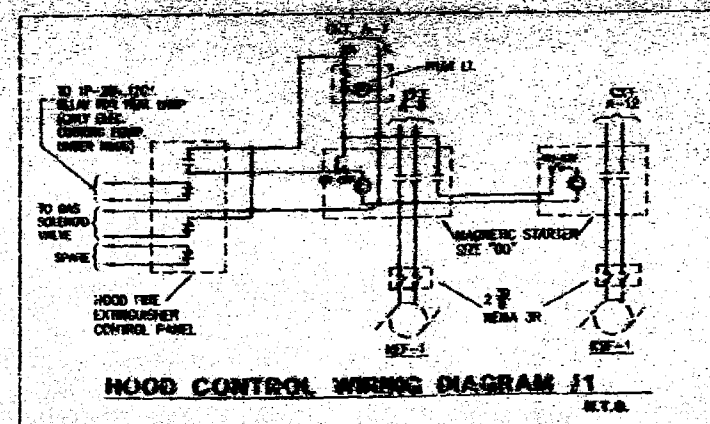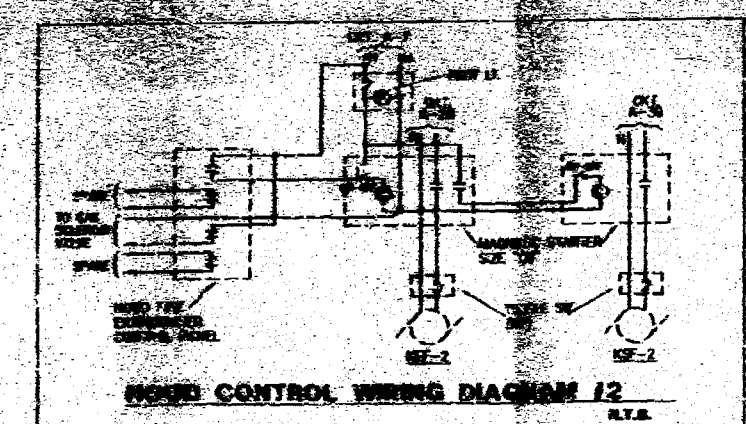


NO.	DESCRIPTION	AMPERES	VOLTS	WATTS	VA	PHASE	TYPE	LOCATION	NOTES
1	1000	1000	120	120000	120000	3	W	MAIN	
2	1000	1000	120	120000	120000	3	W	MAIN	
3	1000	1000	120	120000	120000	3	W	MAIN	
100	1000	1000	120	120000	120000	3	W	MAIN	

OFFICE COPY
CITY OF MIAMI BEACH
APPROVED FOR PERMIT BY
THE FOLLOWING:

ENRIQUE G. VILATO, P.E.
ELECTRICAL ENGINEER
FLA. REG. NO. 11584

MARTIN - VILATO
ASSOCIATES, INC.
CONSULTING ENGINEERS

6/26/98

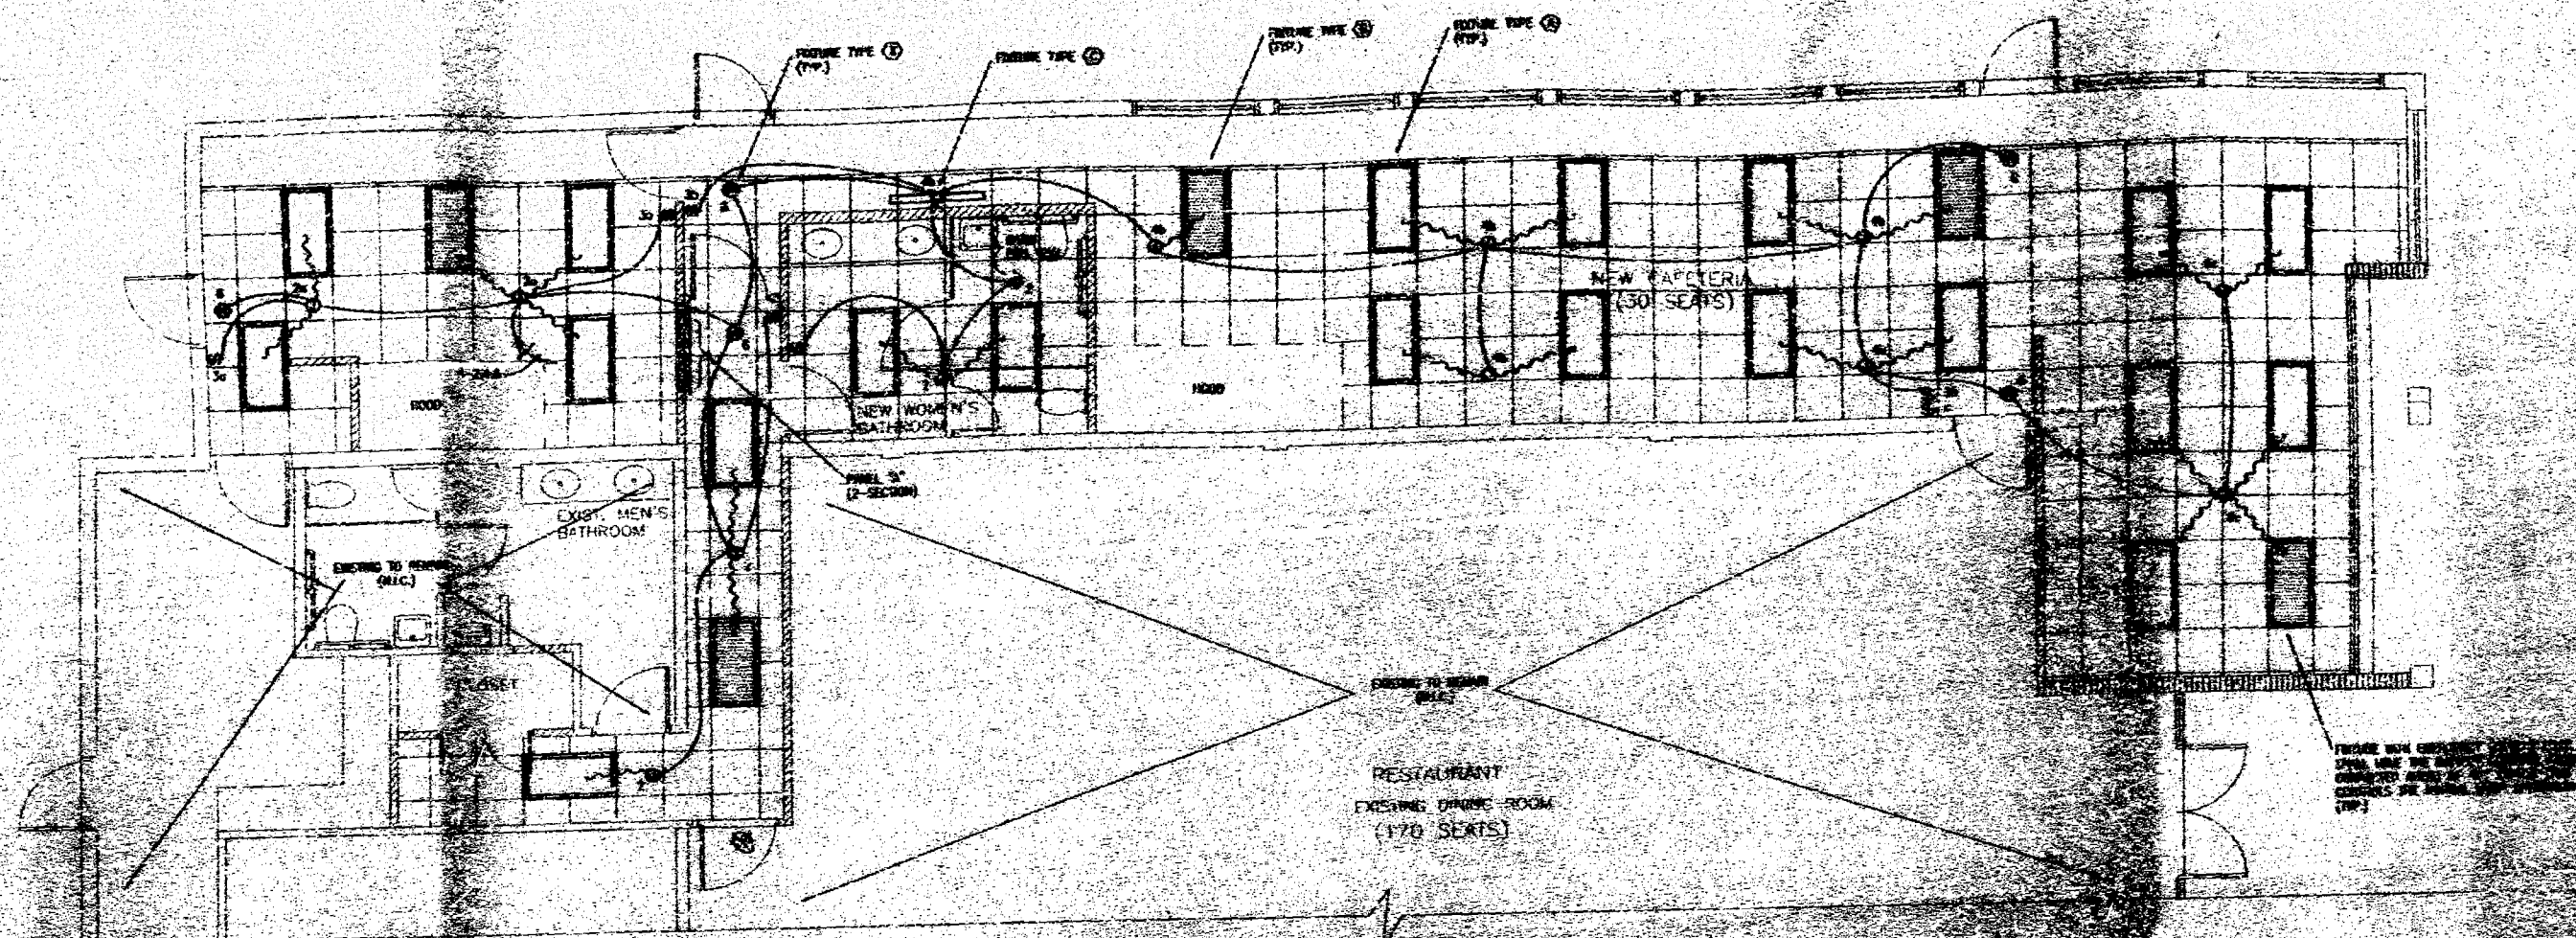

LIGHTING PLAN
PAGE 04 - 10

[illegible]

UNCLASSIFIED

[illegible]

100

[illegible]

OFFICE COPY
CITY OF SHERMAN BEACH

APPROVED FOR PERMIT BY
THE FOLLOWING:

BUILDING
ZONING
PLUMBING
ELECTRICAL
MECHANICAL
FIRE PREVENTION
ENGINEERING
PUBLIC WORKS
STRUCTURAL
ACCESSIBILITY
ELEVATOR

ENRIQUE G. VILATO, P.E.
ELECTRICAL ENGINEER
F.L. REG. NO. 11884

MASTEN - VELTOS
MASTEN, INC.
MANUFACTURING EQUIPMENT

2720 E. 2nd Ave. - Suite 400
Denver, CO 80202
Tel: 303.733.1111

GAMBACH SKLAR

THE

LIGHTING

0/28/20

$$1/4" = 1" - 2$$


6040

2000

1	2	3	100
---	---	---	---	---	---	---	---	---	----	----	-----

E 2

CONFIDENTIAL

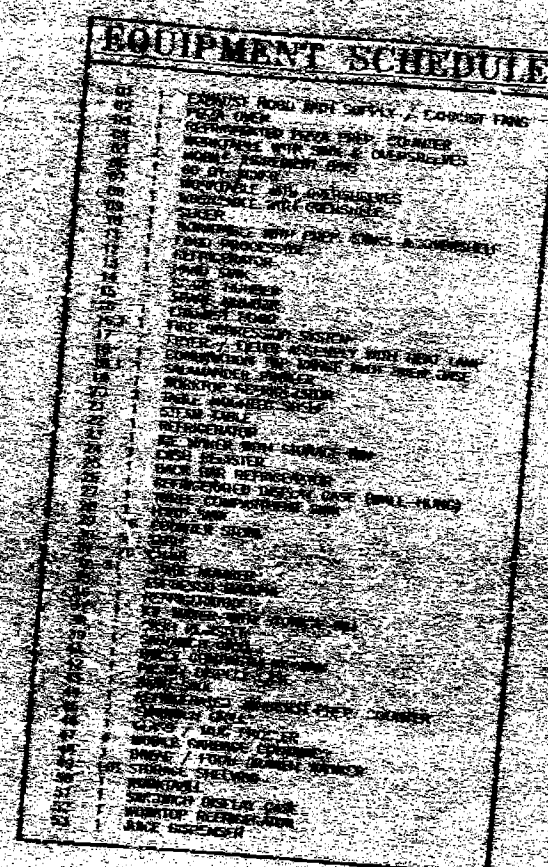

DAVID'S CAFE II - SOUTH BEACH, MIAMI, FL
MIAMI
FLORIDA


WATER GIP

APPROVED FOR PERIOD OF
THE FOLLOWING:

1. DATE
 2. TIME
 3. PLACE
 4. PERSONS
 5. REASON
 6. THE PERSON
 7. THE PLACE
 8. THE TIME
 9. THE PERSON
 10. THE PLACE
 11. THE TIME
 12. THE PERSON
 13. THE PLACE
 14. THE TIME
 15. THE PERSON
 16. THE PLACE
 17. THE TIME
 18. THE PERSON
 19. THE PLACE
 20. THE TIME
 21. THE PERSON
 22. THE PLACE
 23. THE TIME
 24. THE PERSON
 25. THE PLACE
 26. THE TIME
 27. THE PERSON
 28. THE PLACE
 29. THE TIME
 30. THE PERSON
 31. THE PLACE
 32. THE TIME
 33. THE PERSON
 34. THE PLACE
 35. THE TIME
 36. THE PERSON
 37. THE PLACE
 38. THE TIME
 39. THE PERSON
 40. THE PLACE
 41. THE TIME
 42. THE PERSON
 43. THE PLACE
 44. THE TIME
 45. THE PERSON
 46. THE PLACE
 47. THE TIME
 48. THE PERSON
 49. THE PLACE
 50. THE TIME
 51. THE PERSON
 52. THE PLACE
 53. THE TIME
 54. THE PERSON
 55. THE PLACE
 56. THE TIME
 57. THE PERSON
 58. THE PLACE
 59. THE TIME
 60. THE PERSON
 61. THE PLACE
 62. THE TIME
 63. THE PERSON
 64. THE PLACE
 65. THE TIME
 66. THE PERSON
 67. THE PLACE
 68. THE TIME
 69. THE PERSON
 70. THE PLACE
 71. THE TIME
 72. THE PERSON
 73. THE PLACE
 74. THE TIME
 75. THE PERSON
 76. THE PLACE
 77. THE TIME
 78. THE PERSON
 79. THE PLACE
 80. THE TIME
 81. THE PERSON
 82. THE PLACE
 83. THE TIME
 84. THE PERSON
 85. THE PLACE
 86. THE TIME
 87. THE PERSON
 88. THE PLACE
 89. THE TIME
 90. THE PERSON
 91. THE PLACE
 92. THE TIME
 93. THE PERSON
 94. THE PLACE
 95. THE TIME
 96. THE PERSON
 97. THE PLACE
 98. THE TIME
 99. THE PERSON
 100. THE PLACE
 101. THE TIME
 102. THE PERSON
 103. THE PLACE
 104. THE TIME
 105. THE PERSON
 106. THE PLACE
 107. THE TIME
 108. THE PERSON
 109. THE PLACE
 110. THE TIME
 111. THE PERSON
 112. THE PLACE
 113. THE TIME
 114. THE PERSON
 115. THE PLACE
 116. THE TIME
 117. THE PERSON
 118. THE PLACE
 119. THE TIME
 120. THE PERSON
 121. THE PLACE
 122. THE TIME
 123. THE PERSON
 124. THE PLACE
 125. THE TIME
 126. THE PERSON
 127. THE PLACE
 128. THE TIME
 129. THE PERSON
 130. THE PLACE
 131. THE TIME
 132. THE PERSON
 133. THE PLACE
 134. THE TIME
 135. THE PERSON
 136. THE PLACE
 137. THE TIME
 138. THE PERSON
 139. THE PLACE
 140. THE TIME
 141. THE PERSON
 142. THE PLACE
 143. THE TIME
 144. THE PERSON
 145. THE PLACE
 146. THE TIME
 147. THE PERSON
 148. THE PLACE
 149. THE TIME
 150. THE PERSON
 151. THE PLACE
 152. THE TIME
 153. THE PERSON
 154. THE PLACE
 155. THE TIME
 156. THE PERSON
 157. THE PLACE
 158. THE TIME
 159. THE PERSON
 160. THE PLACE
 161. THE TIME
 162. THE PERSON
 163. THE PLACE
 164. THE TIME
 165. THE PERSON
 166. THE PLACE
 167. THE TIME
 168. THE PERSON
 169. THE PLACE
 170. THE TIME
 171. THE PERSON
 172. THE PLACE
 173. THE TIME
 174. THE PERSON
 175. THE PLACE
 176. THE TIME
 177. THE PERSON
 178. THE PLACE
 179. THE TIME
 180. THE PERSON
 181. THE PLACE
 182. THE TIME
 183. THE PERSON
 184. THE PLACE
 185. THE TIME
 186. THE PERSON
 187. THE PLACE
 188. THE TIME
 189. THE PERSON
 190. THE PLACE
 191. THE TIME
 192. THE PERSON
 193. THE PLACE
 194. THE TIME
 195. THE PERSON
 196. THE PLACE
 197. THE TIME
 198. THE PERSON
 199. THE PLACE
 200. THE TIME
 201. THE PERSON
 202. THE PLACE
 203. THE TIME
 204. THE PERSON
 205. THE PLACE
 206. THE TIME
 207. THE PERSON
 208. THE PLACE
 209. THE TIME
 210. THE PERSON
 211. THE PLACE
 212. THE TIME
 213. THE PERSON
 214. THE PLACE
 215. THE TIME
 216. THE PERSON
 217. THE PLACE
 218. THE TIME
 219. THE PERSON
 220. THE PLACE
 221. THE TIME
 222. THE PERSON
 223. THE PLACE
 224. THE TIME
 225. THE PERSON
 226. THE PLACE
 227. THE TIME
 228. THE PERSON
 229. THE PLACE
 230. THE TIME
 231. THE PERSON
 232. THE PLACE
 233. THE TIME
 234. THE PERSON
 235. THE PLACE
 236. THE TIME
 237. THE PERSON
 238. THE PLACE
 239. THE TIME
 240. THE PERSON
 241. THE PLACE
 242. THE TIME
 243. THE PERSON
 244. THE PLACE
 245. THE TIME
 246. THE PERSON
 247. THE PLACE
 248

SCALE 1/4" = 1'-0"	TITLE
DATE 5/20/98	EQUIPMENT SCHEDULE
DESIGNED BY EG	FOR DAVID I. CAFFE
DATE MAY 19 1998	FROM THE DESIGN AND PLANNING DIVISION
	
	EDWARD DON & COMPANY
APPROVED BY C. K. LAR	SUBMITTED BY HERBERT D. GARCIA
THE ENGINEERING, ARCHITECTURAL AND ENVIRONMENTAL SERVICES AND CONSULTING COMPANY, INC. IS AN EQUAL OPPORTUNITY FIRM. MINORITY AND WOMEN OWNED AND OPERATED.	

 [illegible]



[illegible]

1	WALL, BRICK, EXTERIOR
2	WALL, CONCRETE, EXTERIOR
3	WALL, CONCRETE, INTERIOR
4	CEILING, BRICK
5	WALL, GYPSUM
6	FLOOR, BRICK, EXTERIOR
7	CEILING, GYPSUM
8	FLOOR, GYPSUM
9	WALL, CONCRETE
10	CEILING, GYPSUM
11	FLOOR, GYPSUM
12	WALL, CONCRETE
13	CEILING, CONCRETE
14	FLOOR, GYPSUM
15	WALL, CONCRETE
16	CEILING, CONCRETE
17	FLOOR, GYPSUM
18	WALL, CONCRETE
19	CEILING, CONCRETE
20	FLOOR, GYPSUM
21	WALL, CONCRETE
22	CEILING, CONCRETE
23	FLOOR, GYPSUM
24	WALL, CONCRETE
25	CEILING, CONCRETE
26	FLOOR, GYPSUM
27	WALL, CONCRETE
28	CEILING, CONCRETE
29	FLOOR, GYPSUM
30	WALL, CONCRETE
31	CEILING, CONCRETE
32	FLOOR, GYPSUM
33	WALL, CONCRETE
34	CEILING, CONCRETE
35	FLOOR, GYPSUM
36	WALL, CONCRETE
37	CEILING, CONCRETE
38	FLOOR, GYPSUM
39	WALL, CONCRETE
40	CEILING, CONCRETE
41	FLOOR, GYPSUM
42	WALL, CONCRETE
43	CEILING, CONCRETE
44	FLOOR, GYPSUM
45	WALL, CONCRETE
46	CEILING, CONCRETE
47	FLOOR, GYPSUM
48	WALL, CONCRETE
49	CEILING, CONCRETE
50	FLOOR, GYPSUM
51	WALL, CONCRETE
52	CEILING, CONCRETE
53	FLOOR, GYPSUM
54	WALL, CONCRETE
55	CEILING, CONCRETE
56	FLOOR, GYPSUM
57	WALL, CONCRETE
58	CEILING, CONCRETE
59	FLOOR, GYPSUM
60	WALL, CONCRETE
61	CEILING, CONCRETE
62	FLOOR, GYPSUM
63	WALL, CONCRETE
64	CEILING, CONCRETE
65	FLOOR, GYPSUM
66	WALL, CONCRETE
67	CEILING, CONCRETE
68	FLOOR, GYPSUM
69	WALL, CONCRETE
70	CEILING, CONCRETE
71	FLOOR, GYPSUM
72	WALL, CONCRETE
73	CEILING, CONCRETE
74	FLOOR, GYPSUM
75	WALL, CONCRETE
76	CEILING, CONCRETE
77	FLOOR, GYPSUM
78	WALL, CONCRETE
79	CEILING, CONCRETE
80	FLOOR, GYPSUM
81	WALL, CONCRETE
82	CEILING, CONCRETE
83	FLOOR, GYPSUM
84	WALL, CONCRETE
85	CEILING, CONCRETE
86	FLOOR, GYPSUM
87	WALL, CONCRETE
88	CEILING, CONCRETE
89	FLOOR, GYPSUM
90	WALL, CONCRETE
91	CEILING, CONCRETE
92	FLOOR, GYPSUM
93	WALL, CONCRETE
94	CEILING, CONCRETE
95	FLOOR, GYPSUM
96	WALL, CONCRETE
97	CEILING, CONCRETE
98	FLOOR, GYPSUM
99	WALL, CONCRETE
100	CEILING, CONCRETE
101	FLOOR, GYPSUM
102	WALL, CONCRETE
103	CEILING, CONCRETE
104	FLOOR, GYPSUM
105	WALL, CONCRETE
106	CEILING, CONCRETE
107	FLOOR, GYPSUM
108	WALL, CONCRETE
109	CEILING, CONCRETE
110	FLOOR, GYPSUM
111	WALL, CONCRETE
112	CEILING, CONCRETE
113	FLOOR, GYPSUM
114	WALL, CONCRETE
115	CEILING, CONCRETE
116	FLOOR, GYPSUM
117	WALL, CONCRETE
118	CEILING, CONCRETE
119	FLOOR, GYPSUM
120	WALL, CONCRETE
121	CEILING, CONCRETE
122	FLOOR, GYPSUM
123	WALL, CONCRETE
124	CEILING, CONCRETE
125	FLOOR, GYPSUM
126	WALL, CONCRETE
127	CEILING, CONCRETE
128	FLOOR, GYPSUM
129	WALL, CONCRETE
130	CEILING, CONCRETE
131	FLOOR, GYPSUM
132	WALL, CONCRETE
133	CEILING, CONCRETE
134	FLOOR, GYPSUM
135	WALL, CONCRETE
136	CEILING, CONCRETE
137	FLOOR, GYPSUM
138	WALL, CONCRETE
139	CEILING, CONCRETE
140	FLOOR, GYPSUM
141	WALL, CONCRETE
142	CEILING, CONCRETE
143	FLOOR, GYPSUM
144	WALL, CONCRETE
145	CEILING, CONCRETE
146	FLOOR, GYPSUM
147	WALL, CONCRETE
148	CEILING, CONCRETE
149	FLOOR, GYPSUM
150	

[illegible]


DAVID'S CAFE II - SOUTH BEACH, MIAMI, FL.

BUILDING
 ZONING
 PLANNING
 AIR QUALITY
 NOISE/ODOR
 FIRE PROTECTION
 HISTORIC
 PUBLIC WORKS
 STRUCTURES
 ACCESSIBILITY
 GLASSING

SCALE 1/4" = 1'-0"	TITLE ELECTRICAL REQUIREMENTS
NO. 10 DATE 7/1/57	PAGE
6 30 98	DAVID II CAFE
DESIGNED BY W.D.	FROM THE DESIGN AND PLANNING DIVISION
THE 1007 IN	DOH
AT	EDWARD DOW & COMPANY
APPROVED BY D. GARCIA	SUBMITTED BY W. DEPT D. GARCIA
	SHEET NO. 3 OF 3

THIS DRAWING, SPECIFICATIONS AND OTHER SUPPLEMENTARY MATERIALS ARE THE PROPERTY OF EDWARD DOW & COMPANY. NO PART OF THIS DRAWING OR ANY INFORMATION CONTAINED HEREIN IS TO BE REPRODUCED OR TRANSMITTED IN ANY FORM OR BY ANY MEANS, ELECTRONIC OR MECHANICAL, INCLUDING PHOTOCOPYING, RECORDING, OR BY ANY INFORMATION STORAGE AND RETRIEVAL SYSTEM, WITHOUT PERMISSION IN WRITING FROM EDWARD DOW & COMPANY.

This drawing is an instrument of service for the convenience of other contractors and relates only to the food service equipment. This drawing is an accurate one as can be determined at this job site. The General Contractor assumes no responsibility for its accuracy or completeness. Verify job site dimensions and check with the equipment contractor before purchasing it. It is not to be the governing contract of this job. As according to the 3" high exterior elevation specified, all dimensions are taken finished walls and floors. Appliances must be made for valves, chips, fittings or other contractor requirements. All plumbing and electrician work to be made by respective trades, including as indicated, valves, traps, fittings or other connections. Additional work (other) to be determined by architect. Size and location of doors must to be determined by architect.

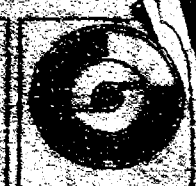


GAMBACH-SKLAR, INC.
MECHANICAL ENGINEERS
1000 N. W. 10th Ave., Suite 100
Fort Lauderdale, FL 33304
(305) 463-1111

PROJECT NO. 92-0170
DATE: 09/01/92
SHEET NO. 1 OF 1


OWNER: CITY OF MIAMI
DESIGNER: GAMBACH-SKLAR, INC.
DATE: 09/01/92

PROJECT: FIRE PROTECTION PLAN
SHEET: 1 OF 1
DATE: 09/01/92

FP-1

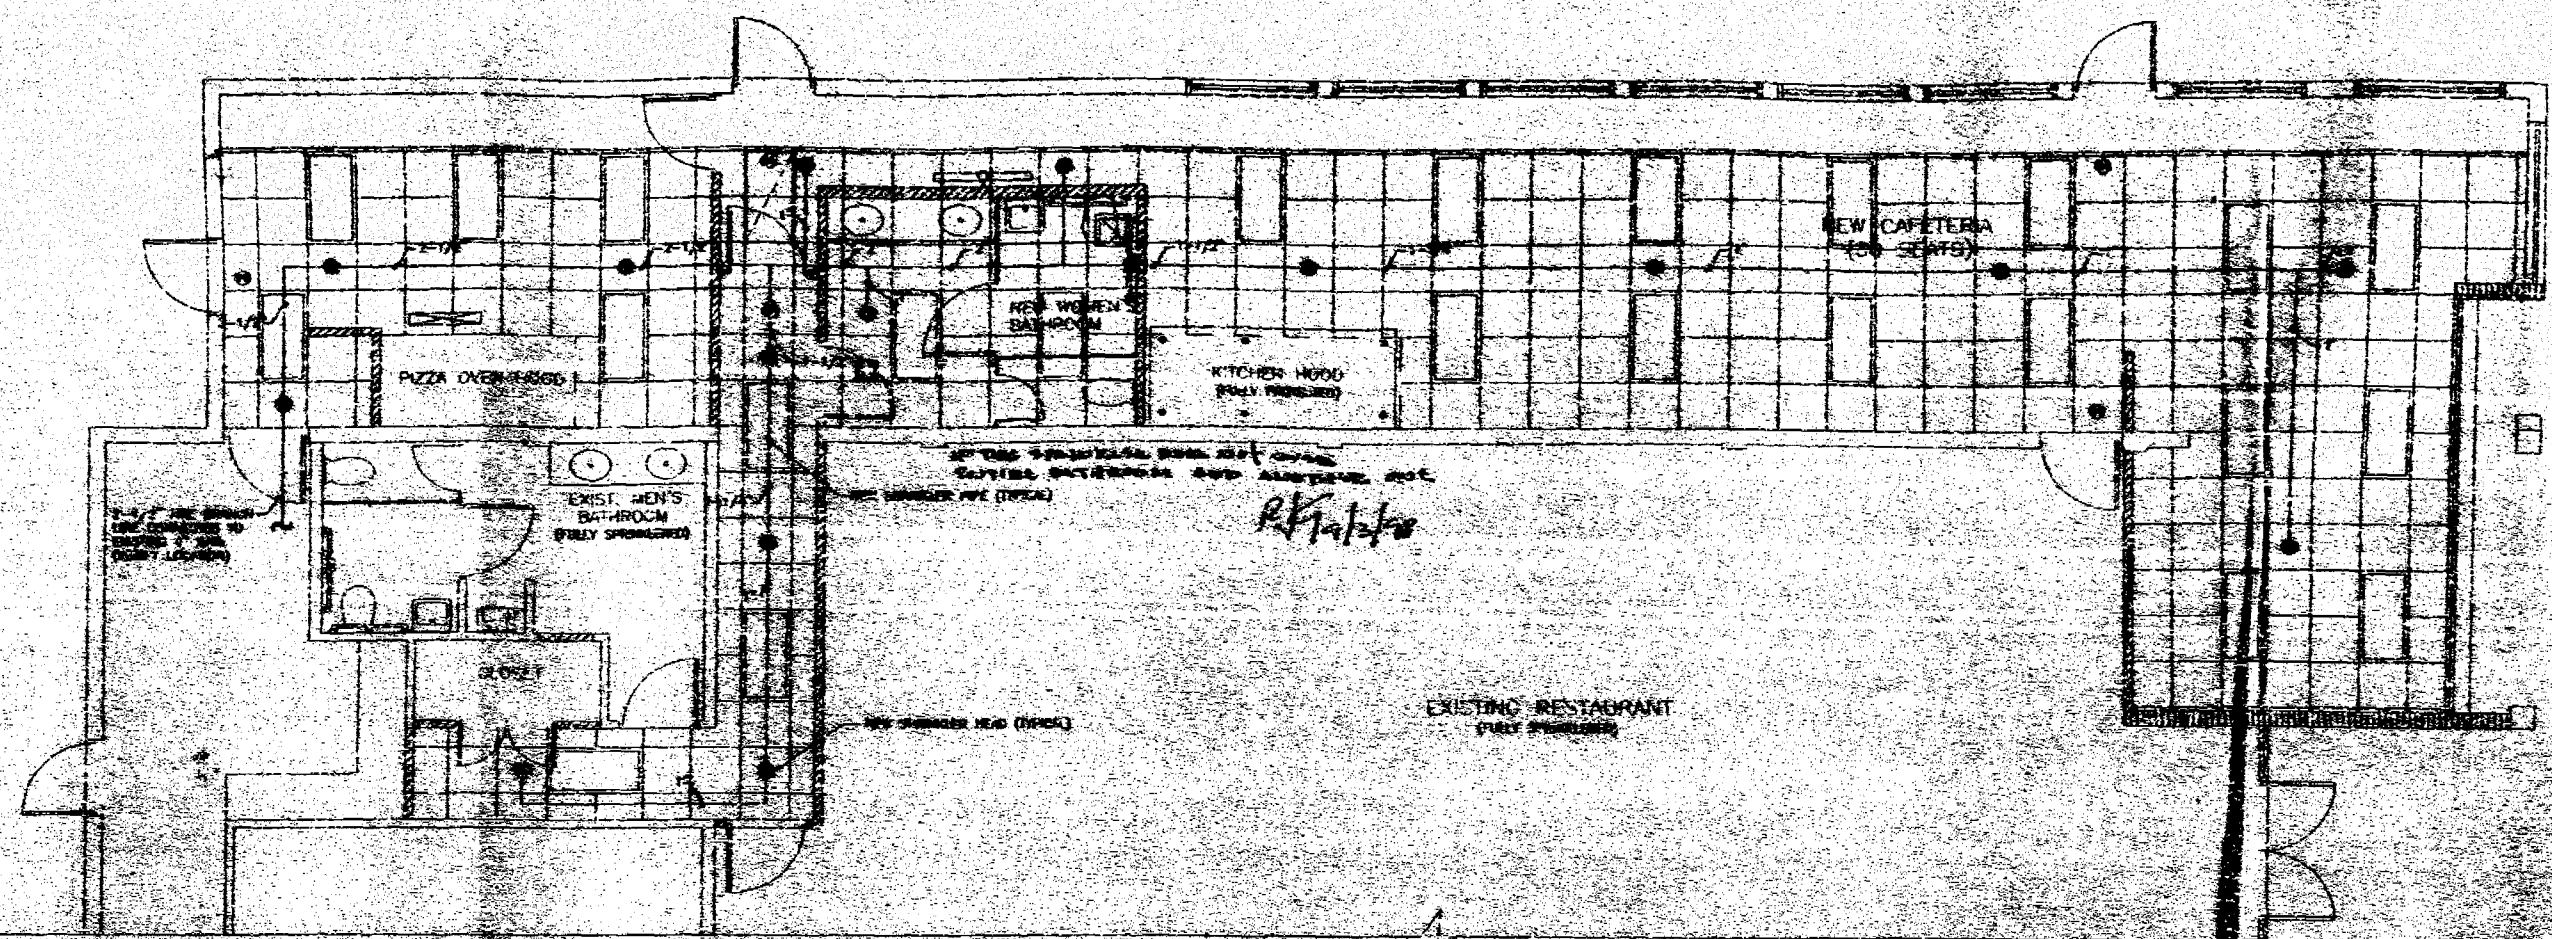

FIRE PROTECTION PLAN SCALE: 1/4" = 1'-0"

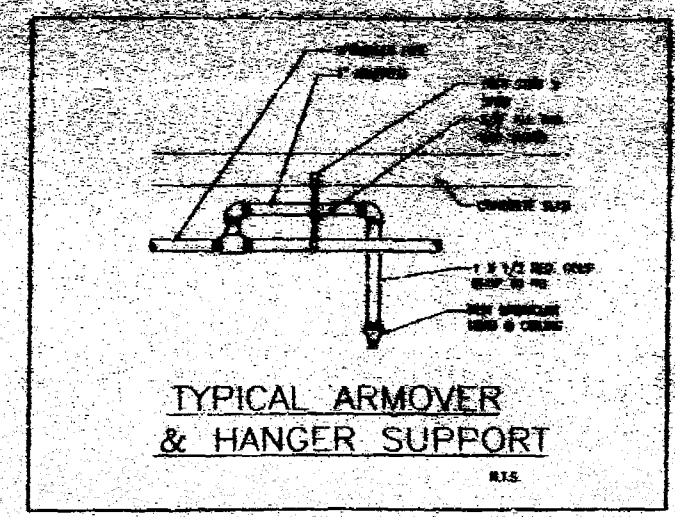


- ## FIRE PROTECTION GENERAL NOTES
1. ALL SPRINKLER SYSTEMS SHALL BE DESIGNED TO THE LATEST EDITION OF THE NFPA 13 CODE.
 2. ALL SPRINKLER SYSTEMS SHALL BE DESIGNED TO THE LATEST EDITION OF THE NFPA 13 CODE.
 3. SPRINKLER SYSTEMS SHALL BE DESIGNED TO THE LATEST EDITION OF THE NFPA 13 CODE.
 4. SPRINKLER SYSTEMS SHALL BE DESIGNED TO THE LATEST EDITION OF THE NFPA 13 CODE.

THIS DRAWING IS
FOR THE CITY OF MIAMI
ONLY. IT IS NOT TO BE
USED FOR ANY OTHER
PROJECT WITHOUT THE
WRITTEN PERMISSION OF
GAMBACH-SKLAR, INC.



OFFICE COPY
CITY OF MIAMI DESIG.
APPROVED FOR PERMIT BY
THE FOLLOWING:



ENGINEER	
ARCHITECT	
MECHANICAL	
ELECTRICAL	
PLUMBING	
HAZARDOUS WASTE	
ENVIRONMENTAL	
SOILS	
TRAFFIC	
UTILITY	
WATER	
WASTE	

 RICARDO A. MARTIN, P.E.
MECHANICAL ENGINEER
FLA. REG. #16390



9/2/92

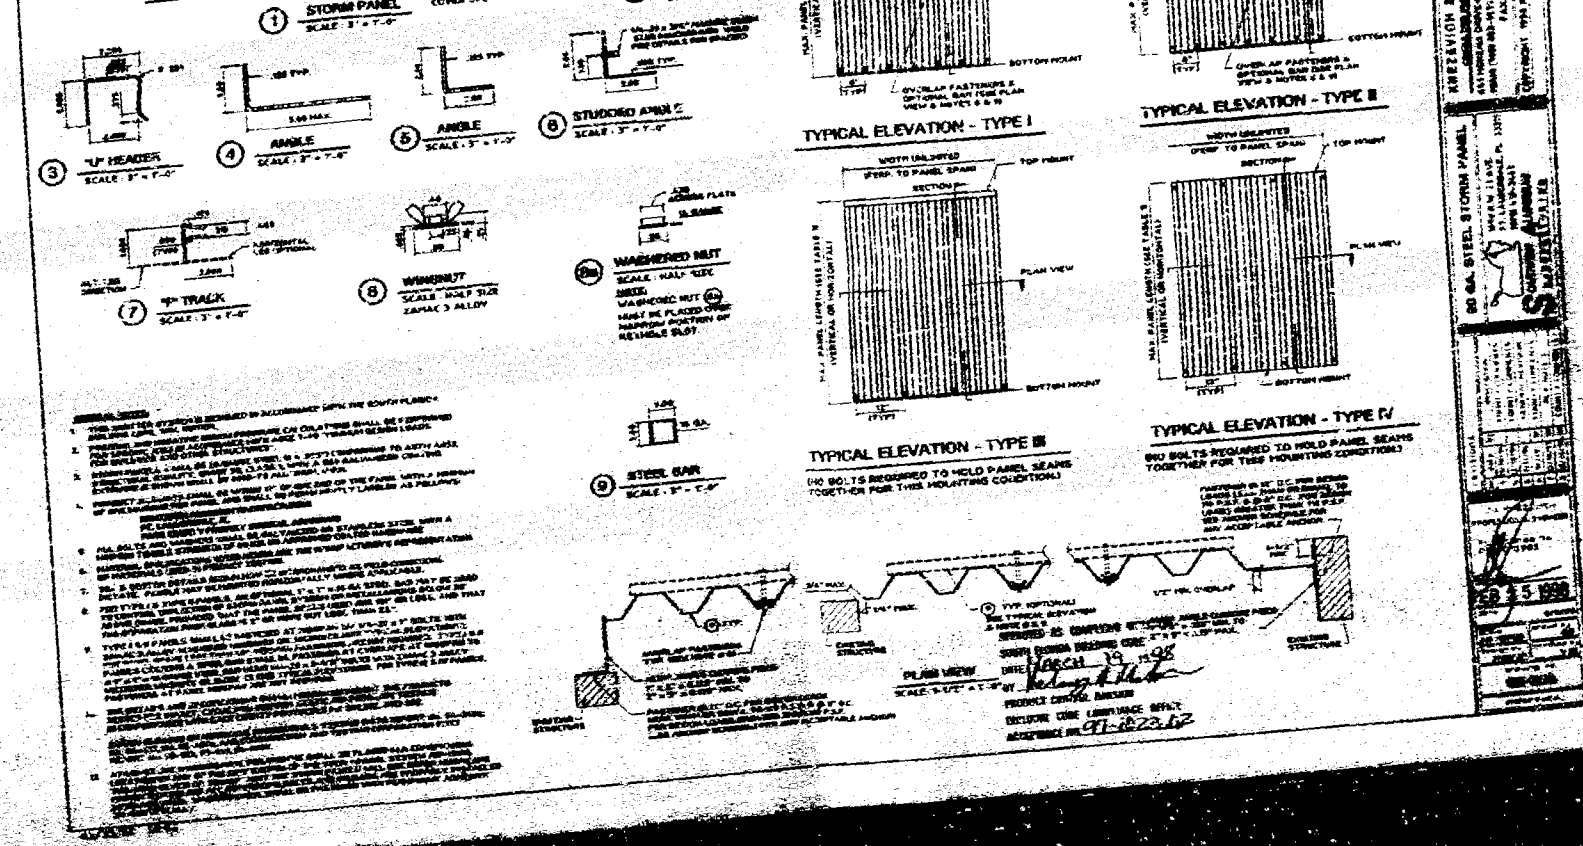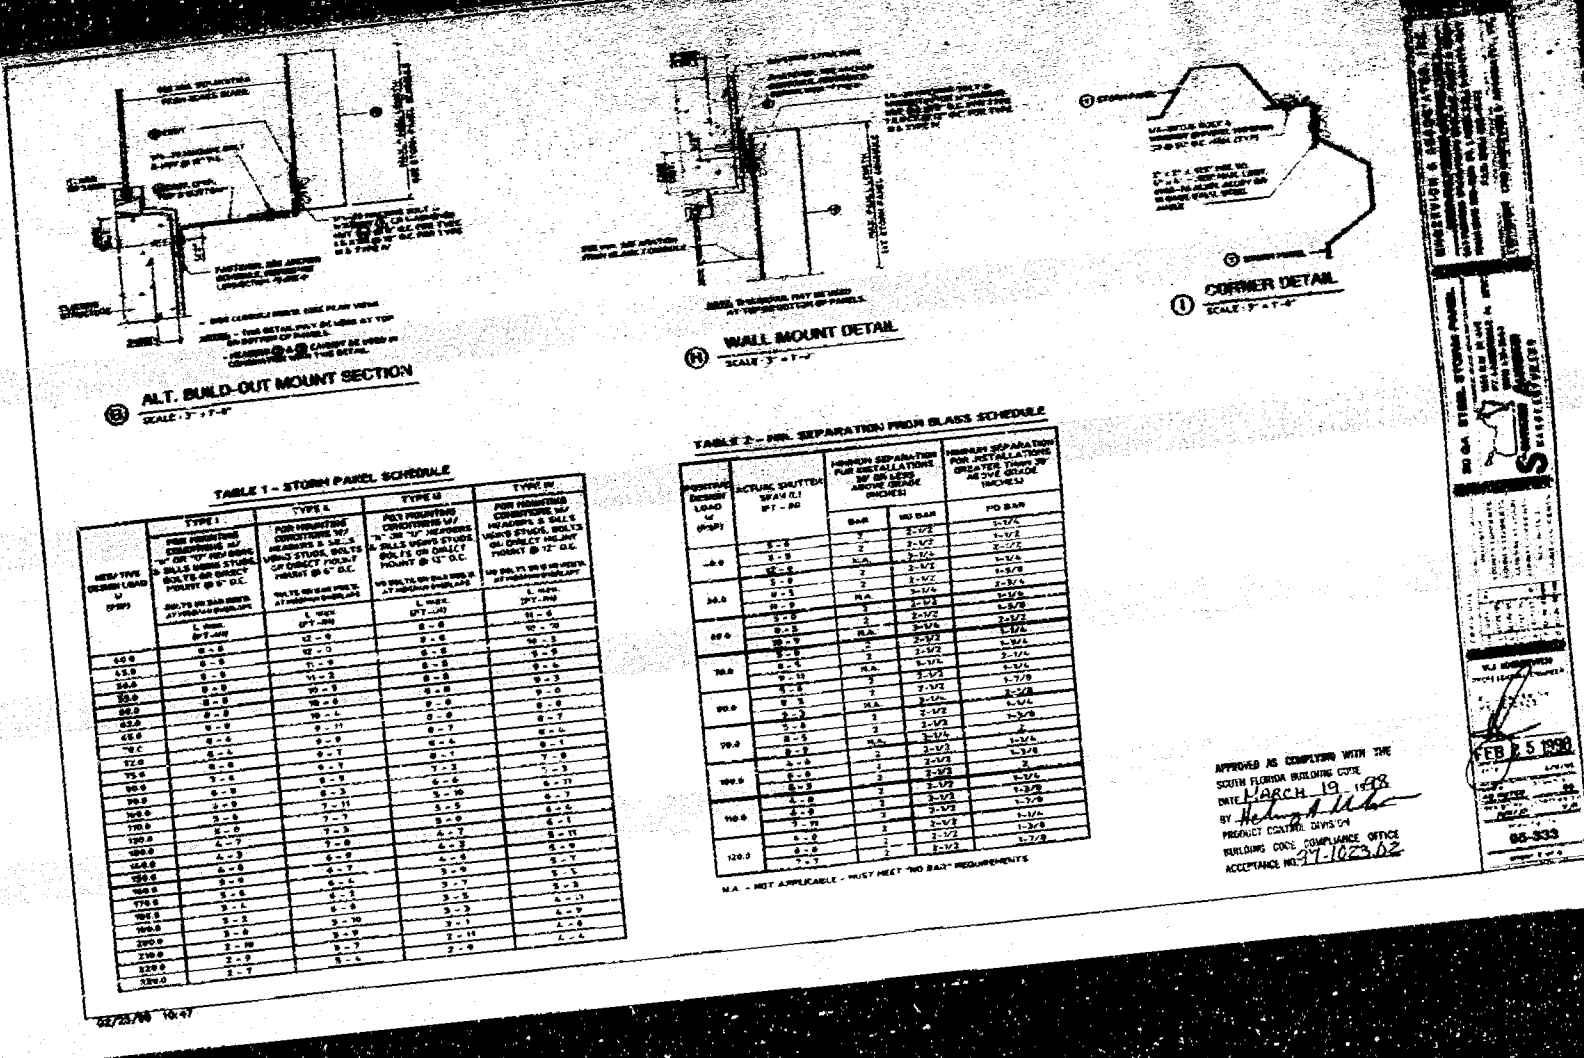[illegible]

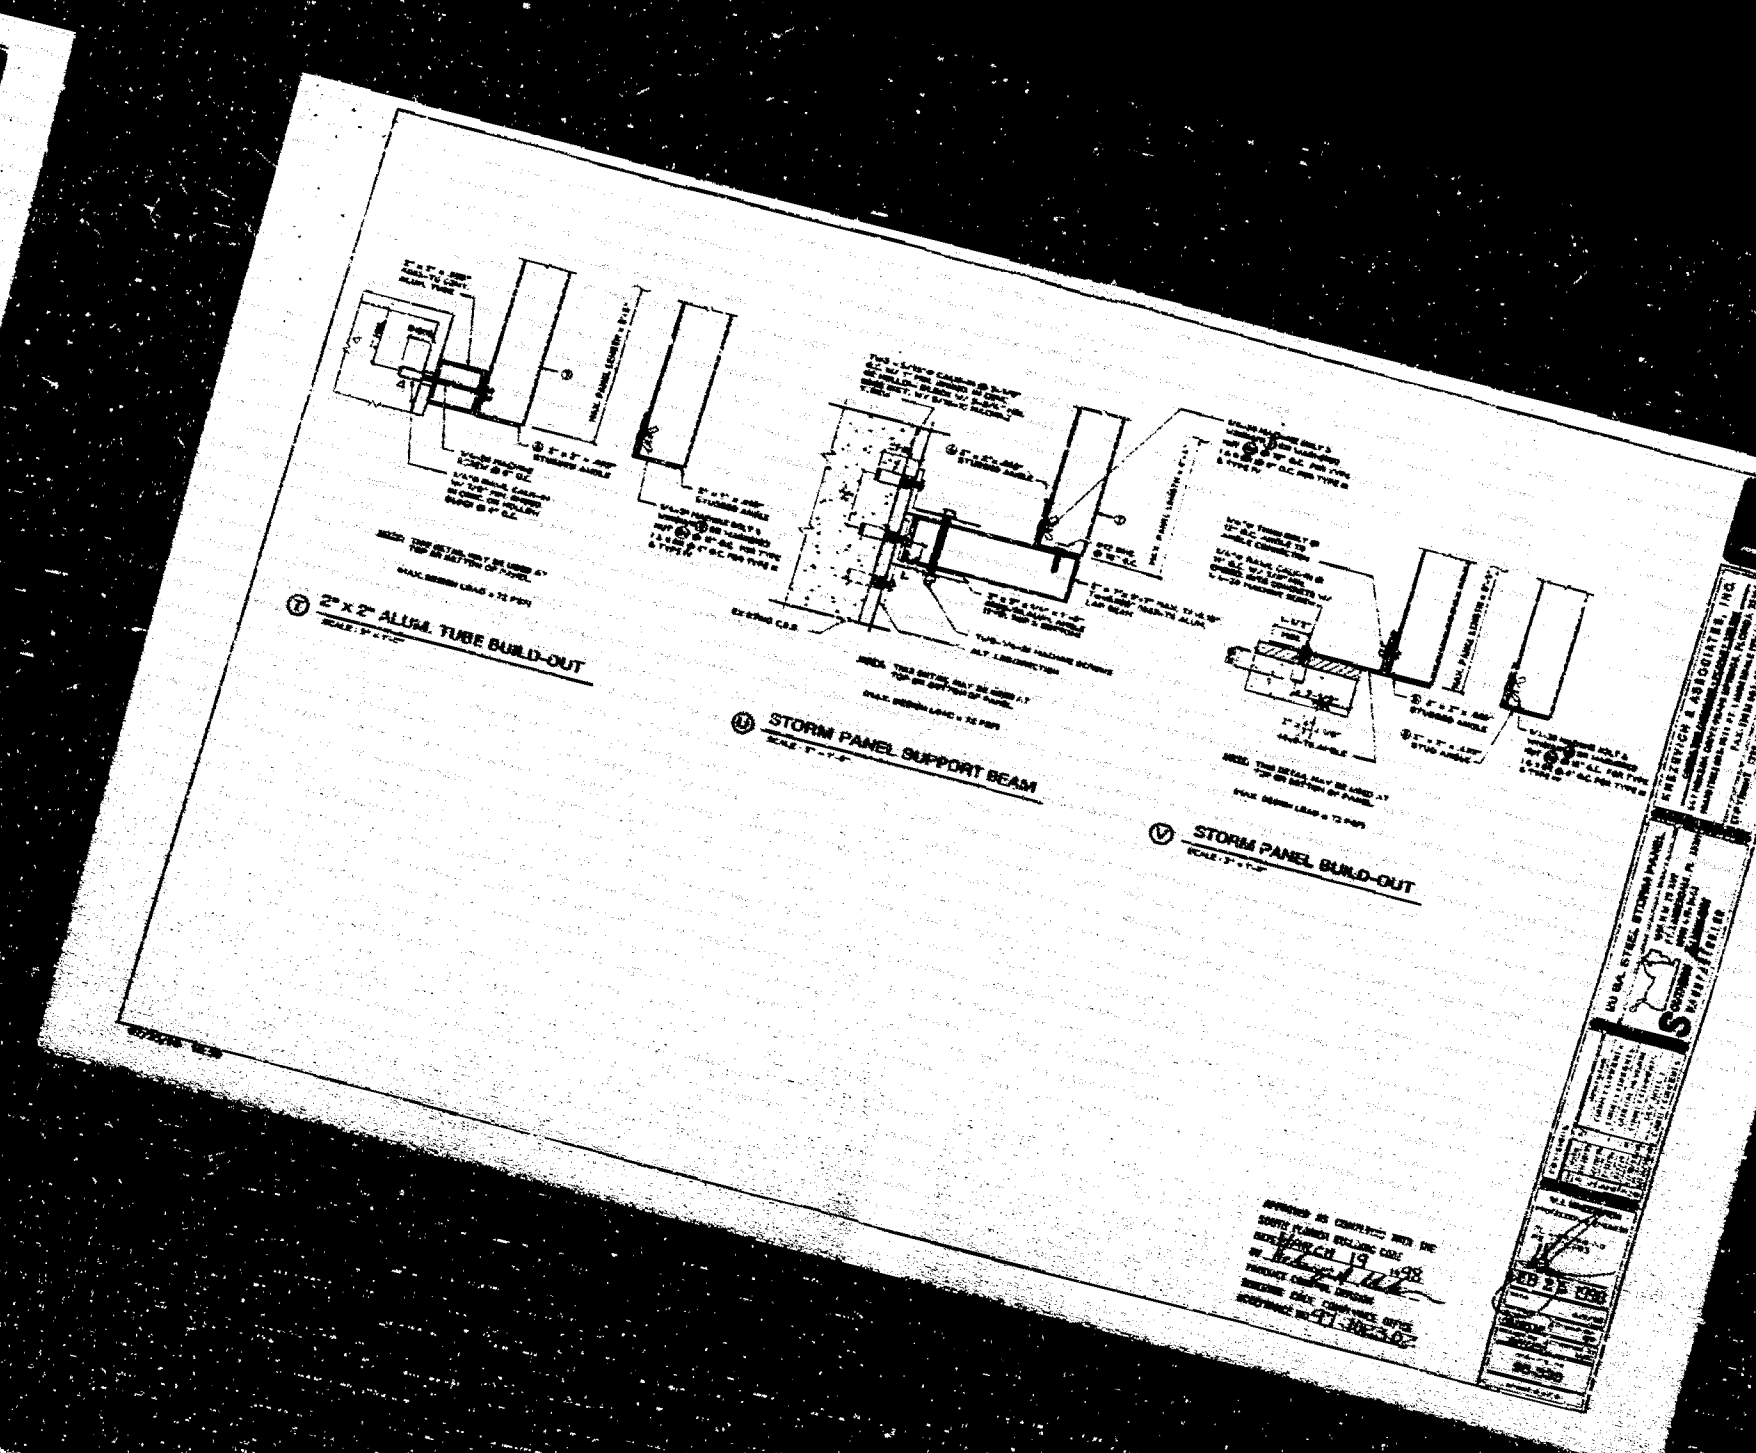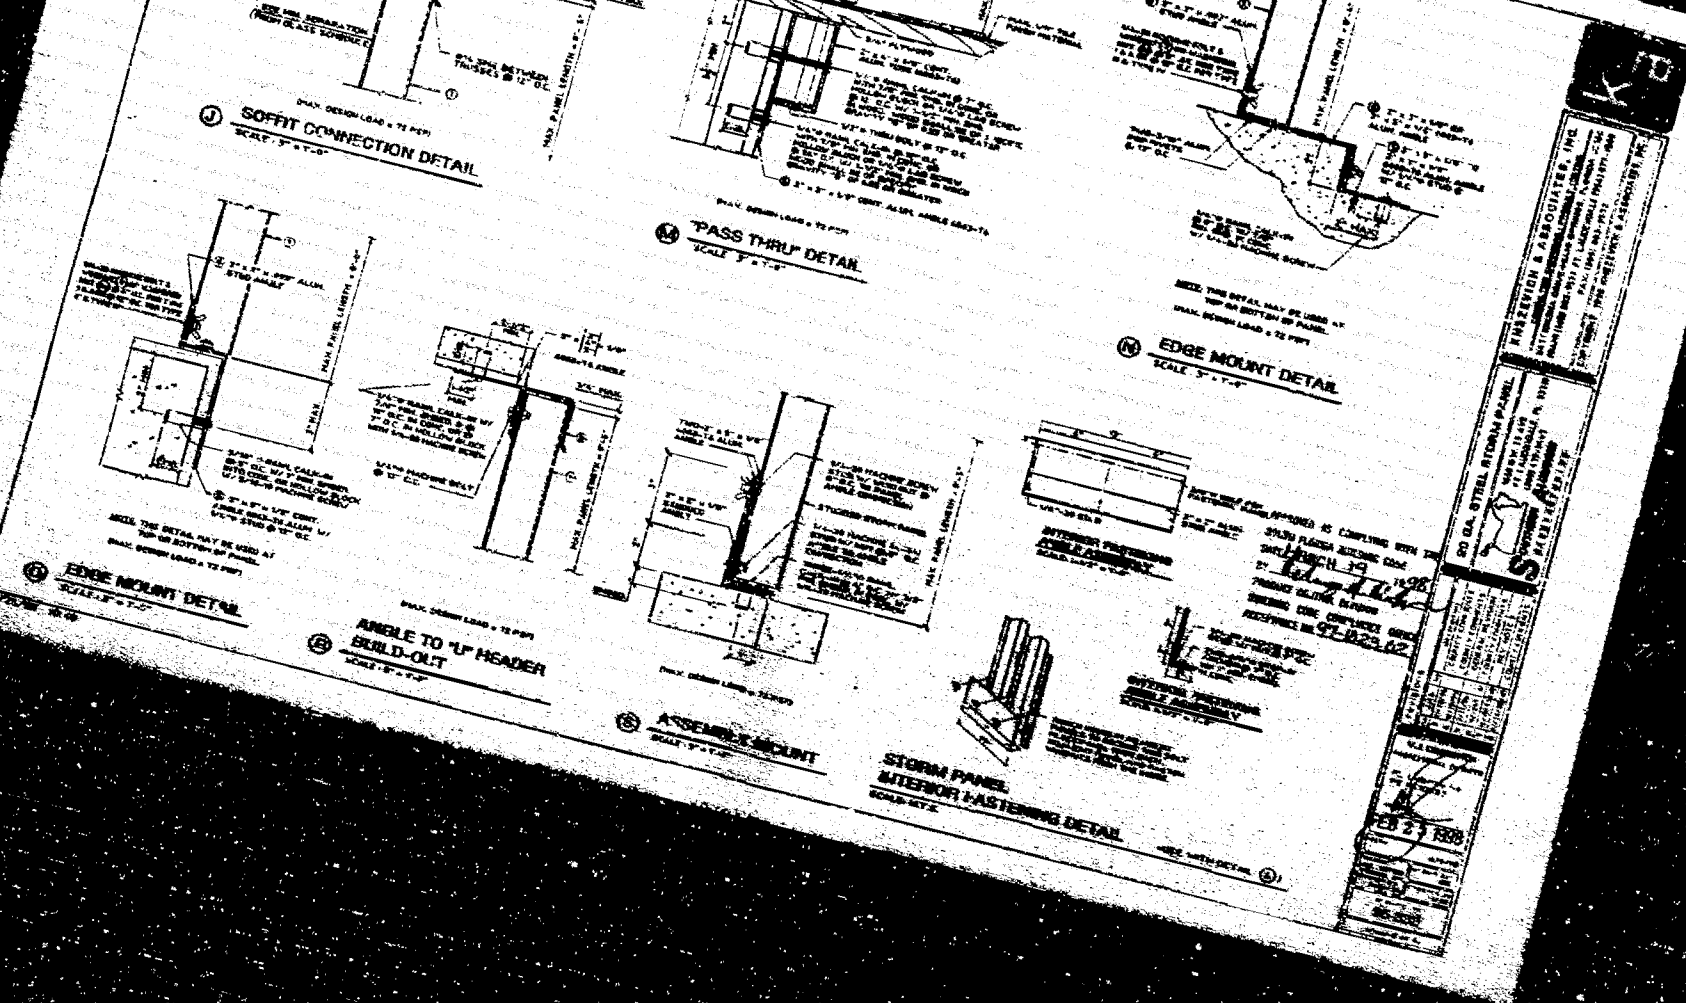

WIND LOAD TABLES FOR COMPONENTS & CLADDING
ASCE 7-88 & ASCE 7-93

BASIC WIND SPEED: 110 MPH
IMPORTANCE FACTOR: 1.05
TRIBUTARY AREA: 20 SQ. FT.

NOTES:
1. BLDGS. GREATER THAN 60 FT. IN HEIGHT, USE EXPOSURE C FOR NON-COASTAL AREAS, WHICHEVER IS SMALLER.
2. POSITIVE LOADS CAN BE GRADUATED FLOOR BY FLOOR USING ELEVATION ABOVE GRADE AT PARTICULAR FLOOR.
3. NEGATIVE LOADS MUST BE TAKEN AT MEAN ROOF HEIGHT AND APPLY TO ALL FLOORS. SEE ABOVE ILLUSTRATION FOR DETERMINATION OF ZONES.

FIG. 1-10 1995

AL-FAROOQ CORPORATION
ENGINEERS, PLANNERS & PRODUCT TESTING
1215 SW 87th AVENUE
MIAMI, FLORIDA 33174
(305) 264-8100

94-01

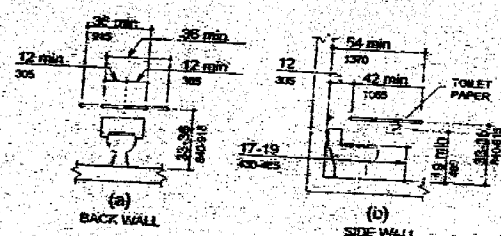


Fig 29
Grab Bars at Water Closets

** CONDITIONS OF PERMIT/APPROVAL ** DATE: 08/26/98
 Permit No.: B9902081 TYPE: BUILD PAGE: 2
 Location: 1650 MERIDIAN AV

R027 - F.E.M.A. BASE FLOOD ELEVATION NOT APPLICABLE BECAUSE:
 R028 - Remodel/addition is less than 50% of value of existing building.

R010 - ENCROACHMENTS/EASEMENTS:

R011 - Easement

R010 - GENERAL COMMENTS:

R011 - Public Services Department street permit required for work done on City Property.

R010 - Certificate of occupancy required.

R012 -

SIGNATURE: *[Signature]*

COMPANY: *[Signature]*

PHONE: *[Signature]*

DATE: 8/28/98

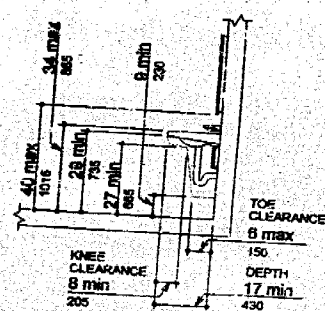


Fig 31
Lavatory Clearances

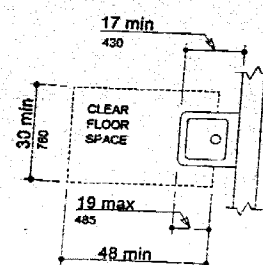


Fig 32
Clear Floor Space at Lavatories